

SOUND TRANSIT - LINK LIGHT RAIL

REFERENCE CONCEPT DRAWINGS

OPERATIONS AND MAINTENANCE FACILITY SOUTH (OMF SOUTH)

FEBRUARY 2024



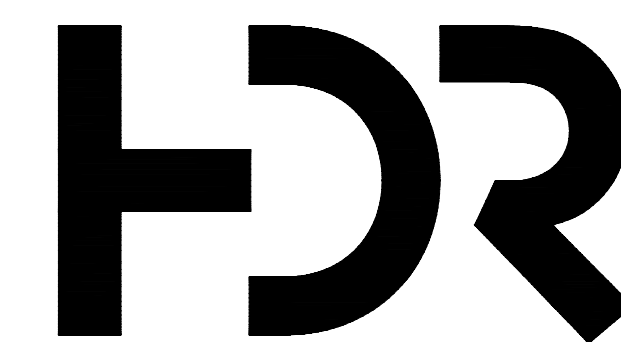
Disclaimer: Operations and Maintenance Facility South Information Only Conceptual Design Drawings

These documents are for information only, and do not specify any work or information required by any solicitation or prospective solicitation or contract. Sound Transit does not warrant or represent that any information contained in these documents is complete, accurate, without error or deficiencies, or sufficient to be used or referenced for any purpose, and as to this information, Sound Transit disclaims all such warranties or representations.

Except to the extent Sound Transit may specifically set forth in any future solicitation or contract, information contained in these documents must not be considered reference documents, reference designs, reference specification, solicitation documents or contract documents or relied upon or used as a justification for any type of protest, claim, change order or legal action against Sound Transit. The information in these documents is subject to change.

Environmental review for the OMF South project is currently underway. In May 2019, the Sound Transit Board identified three alternatives to study in an Environmental Impact Statement (EIS): the South 336th Street Alternative, the South 344th Street Alternative, and the Midway Landfill Alternative. Sound Transit issued a State Environmental Policy Act (SEPA) Draft Environmental Impact Statement in March 2021. After considering the Draft EIS analysis and comments received, the Sound Transit Board identified the South 336th Street Alternative as the Preferred Alternative. A preferred alternative is not a decision on the project to build; instead, it is a statement of preference based on currently available information. In September 2023 Sound Transit and the Federal Transit Administration (FTA) published a National Environmental Policy Act (NEPA) Draft EIS/SEPA Supplemental Draft EIS. Sound Transit and FTA anticipate publishing a NEPA/SEPA Final EIS in mid-2024 that will evaluate all three build alternatives and the no-build alternative. Following publication of the Final EIS, the Sound Transit Board is anticipated to select the project to be built and FTA is anticipated to issue their Record of Decision which will describe the project Sound Transit will build and required mitigation measures.

The information provided in this document is specific to the Preferred South 336th Street Alternative. This is not in any way a commitment to the Preferred Alternative or any of the other alternatives under evaluation in the NEPA process. After publication of the Final EIS, the Sound Transit Board may select to build any of the build alternatives or the no-build alternative.

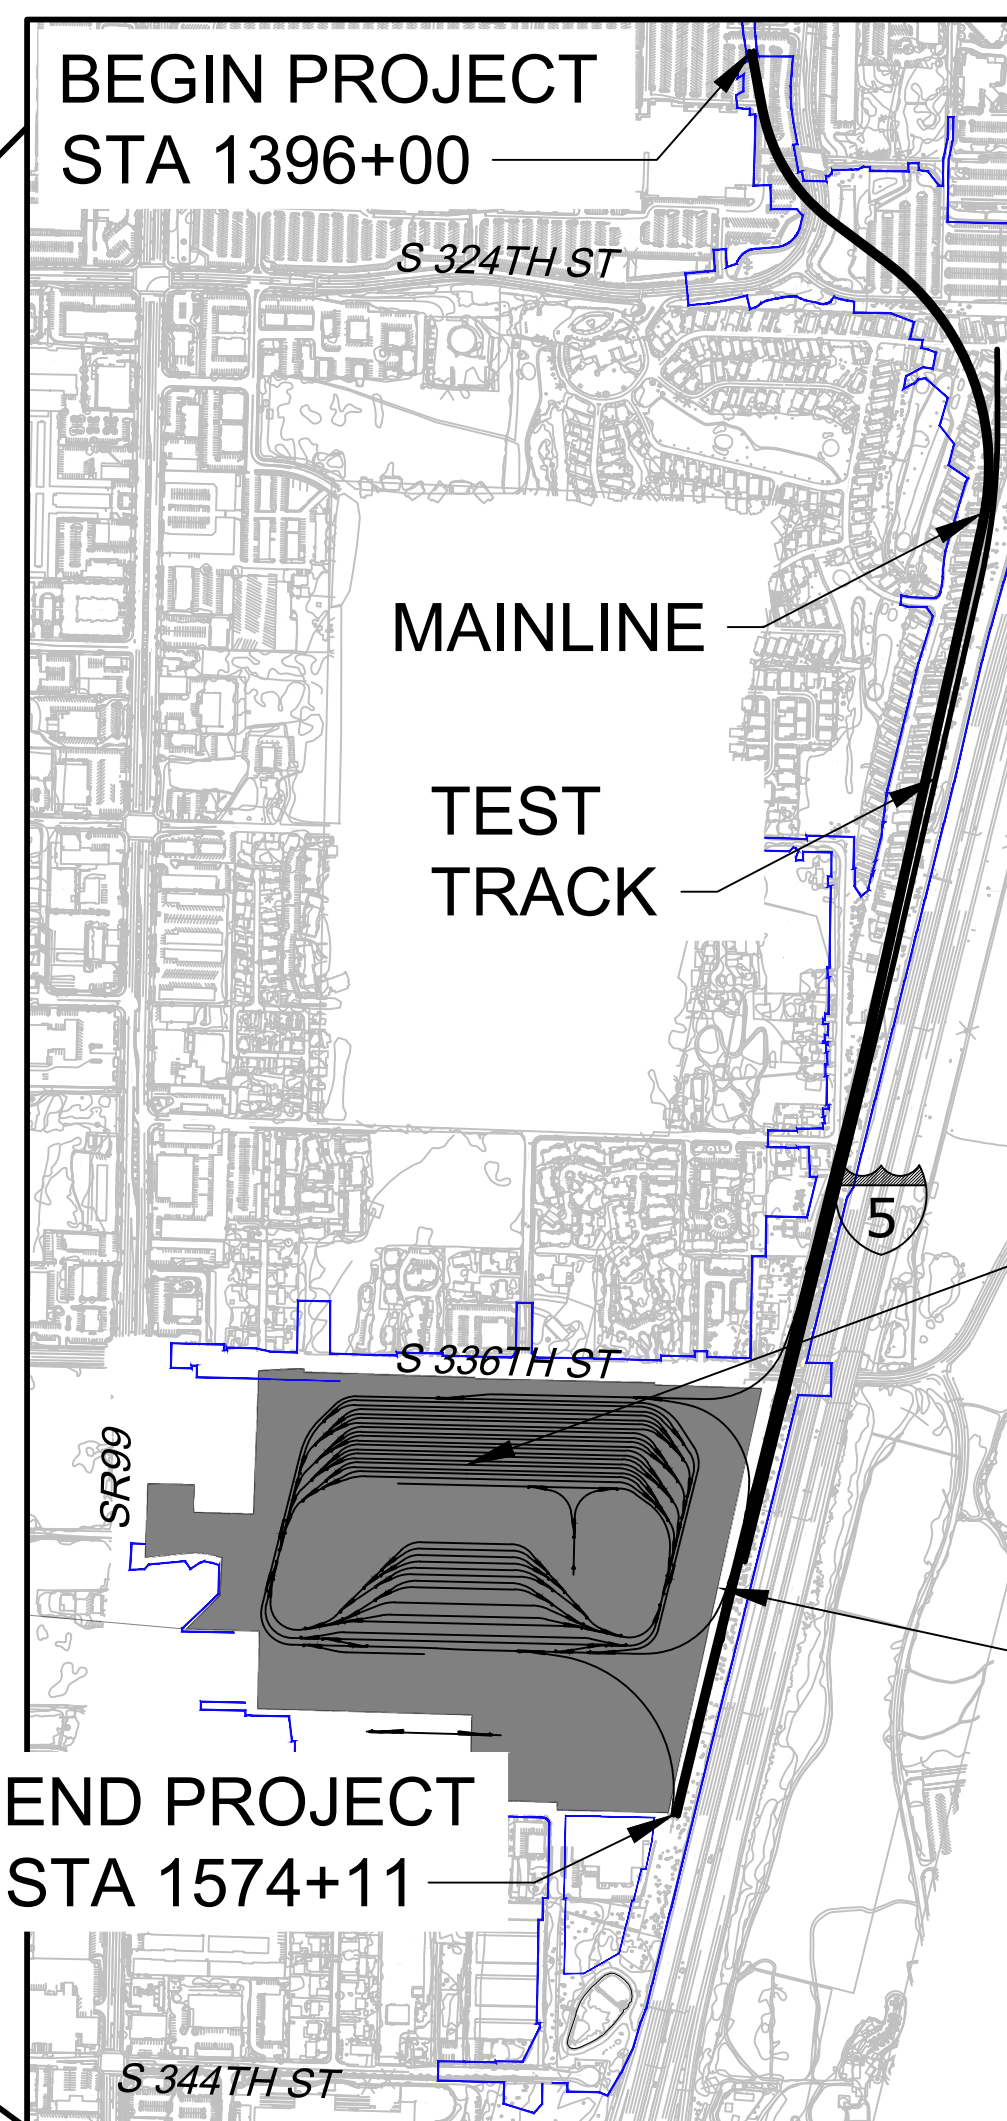
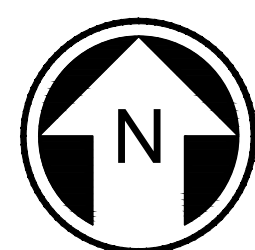


Parametrix

ENGINEERING . PLANNING . ENVIRONMENTAL SCIENCES



SOUND TRANSIT OPERATIONS AND MAINTENANCE FACILITY SOUTH



CIVIL ENGINEERING PRELIMINARY DESIGN CONSULTANT

Approved: _____ Date: _____

Project Manager



SOUNDTRANSIT

CENTRAL PUGET SOUND REGIONAL TRANSIT AUTHORITY

Approved: _____ Date: _____

Civil Engineering Manager

OPERATION AND
MAINTENANCE
FACILITY SOUTH

PROJECT LOCATION

Refer to the plan set COVER drawing
for disclaimers regarding this drawing.

PROJECT LOCATION MAP

NOT FOR
CONSTRUCTION

DRAWING No.:

STD-GZI102

Scale:
NOT TO SCALE

SHEET No.:

02/2024 | 9:45 AM | ASCHEPPE
C:\PWORKING\WEST01\02780545\OMFS-STD-GZ1103-111.DWG

INDEX OF DRAWINGS

SHEET NO.	DWG. NO.	PERSC/REF	TITLE
-----------	----------	-----------	-------

CIVIL CONTINUED

	S08-CXP114	REFERENCE	CIVIL DEMOLITION PLAN STA SB1565+00 TO STA SB1570+00
	S08-CXP115	REFERENCE	CIVIL DEMOLITION PLAN STA SB1570+00 TO STA SB1575+00
	S08-CXP116	REFERENCE	CIVIL DEMOLITION PLAN STA SB1575+00 TO END
	S08-CXP118	REFERENCE	CIVIL DEMOLITION PLAN
	S08-CXP121	REFERENCE	CIVIL DEMOLITION PLAN
	S08-CXP122	REFERENCE	CIVIL DEMOLITION PLAN
	S08-CXP123	REFERENCE	CIVIL DEMOLITION PLAN
	S08-CXP125	REFERENCE	CIVIL DEMOLITION PLAN
	S08-CXP126	REFERENCE	CIVIL DEMOLITION PLAN
	S08-CXP131	REFERENCE	CIVIL DEMOLITION PLAN
	S08-CXP132	REFERENCE	CIVIL DEMOLITION PLAN
	S08-CXP133	REFERENCE	CIVIL DEMOLITION PLAN
	S08-CXP134	REFERENCE	CIVIL DEMOLITION PLAN
	S08-CXP135	REFERENCE	CIVIL DEMOLITION PLAN
	S08-CRP100	REFERENCE	CIVIL ROADWAY PLAN
	S08-CRP101	REFERENCE	CIVIL ROADWAY PLAN STA SB1500+00 TO STA SB1505+00
	S08-CRP102	REFERENCE	CIVIL ROADWAY PLAN STA SB1505+00 TO STA SB1510+00
	S08-CRP103	REFERENCE	CIVIL ROADWAY PLAN STA SB1510+00 TO STA SB1515+00
	S08-CRP104	REFERENCE	CIVIL ROADWAY PLAN STA SB1515+00 TO STA SB1520+00
	S08-CRP105	REFERENCE	CIVIL ROADWAY PLAN STA SB1520+00 TO STA SB1525+00
	S08-CRP106	REFERENCE	CIVIL ROADWAY PLAN STA SB1525+00 TO STA SB1530+00
	S08-CRP107	REFERENCE	CIVIL ROADWAY PLAN STA SB1530+00 TO STA SB1535+00
	S08-CRP108	REFERENCE	CIVIL ROADWAY PLAN STA SB1535+00 TO STA SB1540+00
	S08-CRP109	REFERENCE	CIVIL ROADWAY PLAN STA SB1540+00 TO STA SB1545+00
	S08-CRP110	REFERENCE	CIVIL ROADWAY PLAN STA SB1545+00 TO STA SB1550+00
	S08-CRP118	REFERENCE	CIVIL ROADWAY PLAN
	S08-CRP121	REFERENCE	CIVIL ROADWAY PLAN
	S08-CRP122	REFERENCE	CIVIL ROADWAY PLAN
	S08-CRP125	REFERENCE	CIVIL ROADWAY PLAN
	S08-CRP126	REFERENCE	CIVIL ROADWAY PLAN
	S08-CRP131	REFERENCE	CIVIL ROADWAY PLAN
	S08-CRP132	REFERENCE	CIVIL ROADWAY PLAN
	S08-CRP133	REFERENCE	CIVIL ROADWAY PLAN
	S08-CRP134	REFERENCE	CIVIL ROADWAY PLAN
	S08-CRP135	REFERENCE	CIVIL ROADWAY PLAN
	S08-CRV101	REFERENCE	CIVIL ROADWAY PROFILE WINGED FOOT WAY / OAKLAND HILLS BLVD STA 11+25 TO STA 17+25
	S08-CRV102	REFERENCE	CIVIL ROADWAY PROFILE TEST TRACK ACCESS ROAD STA 9+50 TO STA 14+50
	S08-CRV103	REFERENCE	CIVIL ROADWAY PROFILE ACCESS ROAD STA 9+50 TO STA 15+50
	S08-CRV104	REFERENCE	CIVIL ROADWAY PROFILE ACCESS ROAD STA 15+50 TO STA 27+50
	S08-CRV105	REFERENCE	CIVIL ROADWAY PROFILE ACCESS ROAD STA 27+50 TO STA 35+00
	S08-CRV106	REFERENCE	CIVIL ROADWAY PROFILE 24TH AVE STA 10+50 TO STA 22+50
	S08-CRV107	REFERENCE	CIVIL ROADWAY PROFILE 24TH AVE STA 22+50 TO 24+00 / PVT. DRIVEWAY
	S08-CGP101	REFERENCE	CIVIL GRADING STA SB1500+00 TO STA SB1510+00
	S08-CGP102	REFERENCE	CIVIL GRADING STA SB1510+00 TO STA SB1520+00
	S08-CGP103	REFERENCE	CIVIL GRADING STA SB1520+00 TO STA SB1530+00
	S08-CGP104	REFERENCE	CIVIL GRADING STA SB1530+00 TO STA SB1540+00
	S08-CGP105	REFERENCE	CIVIL GRADING STA SB1540+00 TO STA SB1550+00
	S08-CGP106	REFERENCE	CIVIL GRADING STA SB1550+00 TO STA SB1560+00
	S08-CGP107	REFERENCE	CIVIL GRADING STA SB1560+00 TO STA SB1570+00
	S08-CGP108	REFERENCE	CIVIL GRADING STA SB1570+00 TO END
	S08-CDD101	REFERENCE	CIVIL OVERALL MAINLINE & OFFSITE DRAINAGE
	S08-CDD102	REFERENCE	CIVIL OVERALL MAINLINE & OFFSITE DRAINAGE
	S08-CDP101	REFERENCE	CIVIL DRAINAGE PLAN STA 1500+00 TO STA 1505+00
	S08-CDP102	REFERENCE	CIVIL DRAINAGE PLAN STA 1505+00 TO STA 1510+00
	S08-CDP103	REFERENCE	CIVIL DRAINAGE PLAN STA 1510+00 TO STA 1515+00
	S08-CDP104	REFERENCE	CIVIL DRAINAGE PLAN STA 1515+00 TO STA 1520+00
	S08-CDP105	REFERENCE	CIVIL DRAINAGE PLAN STA 1520+00 TO STA 1525+00
	S08-CDP106	REFERENCE	CIVIL DRAINAGE PLAN STA 1525+00 TO STA 1530+00
	S08-CDP107	REFERENCE	CIVIL DRAINAGE PLAN STA 1530+00 TO STA 1535+00
	S08-CDP108	REFERENCE	CIVIL DRAINAGE PLAN STA 1535+00 TO STA 1540+00
	S08-CDP109	REFERENCE	CIVIL DRAINAGE PLAN STA 1540+00 TO STA 1545+00
	S08-CDP110	REFERENCE	CIVIL DRAINAGE PLAN STA 1545+00 TO STA 1550+50
	S08-CDP118	REFERENCE	CIVIL DRAINAGE PLAN
	S08-CDP122	REFERENCE	CIVIL DRAINAGE PLAN

UTILITY

	S08-UZN100	REFERENCE	UTILITY GENERAL UTILITY NOTES, ABBREVIATIONS, AND LEGEND
	S08-UCP101	REFERENCE	UTILITY COMPOSITE UTILITY PLANS STA SB1500+00 TO STA SB1505+00
	S08-UCP102	REFERENCE	UTILITY COMPOSITE UTILITY PLANS STA SB1505+00 TO STA SB1510+00
	S08-UCP103	REFERENCE	UTILITY COMPOSITE UTILITY PLANS STA SB1510+00 TO STA SB1515+00
	S08-UCP104	REFERENCE	UTILITY COMPOSITE UTILITY PLANS STA SB1515+00 TO STA SB1520+00
	S08-UCP105	REFERENCE	UTILITY COMPOSITE UTILITY PLANS STA SB1520+00 TO STA SB1525+00
	S08-UCP106	REFERENCE	UTILITY COMPOSITE UTILITY PLANS STA SB1525+00 TO STA SB1530+00
	S08-UCP107	REFERENCE	UTILITY COMPOSITE UTILITY PLANS STA SB1530+00 TO STA SB1535+00

Refer to the plan set COVER drawing
for disclaimers regarding this drawing.

SHEET NO.	DWG. NO.	PERSC/REF	TITLE
-----------	----------	-----------	-------

UTILITY CONTINUED

	S08-UCP108	REFERENCE	UTILITY COMPOSITE UTILITY PLANS STA SB1535+00 TO STA SB1540+00
	S08-UCP109	REFERENCE	UTILITY COMPOSITE UTILITY PLANS STA SB1540+00 TO STA SB1545+00
	S08-UCP110	REFERENCE	UTILITY COMPOSITE UTILITY PLANS STA SB1545+00 TO STA SB1550+00
	S08-UCP111	REFERENCE	UTILITY COMPOSITE UTILITY PLANS STA SB1550+00 TO STA SB1555+00
	S08-UCP118	REFERENCE	UTILITY COMPOSITE UTILITY PLANS
	S08-UCP120	REFERENCE	UTILITY COMPOSITE UTILITY PLANS
	S08-UCP121	REFERENCE	UTILITY COMPOSITE UTILITY PLANS
	S08-UCP124	REFERENCE	UTILITY COMPOSITE UTILITY PLANS
	S08-UCP126	REFERENCE	UTILITY COMPOSITE UTILITY PLANS

TRAFFIC

	S08-TCP101	REFERENCE	TRAFFIC TRAFFIC CONTROL PLAN ROAD CLOSURE FOR S 336TH ST
	S08-TCP102	REFERENCE	TRAFFIC TRAFFIC CONTROL PLAN ROAD CLOSURE FOR S 341ST ST/21ST AVE
	S08-TCP103	REFERENCE	TRAFFIC TRAFFIC CONTROL PLAN ROAD CLOSURE FOR 23RD AVE/PARK AND RIDE ACCESS

STRUCTURAL

	STD-SZN001	REFERENCE	STRUCTURAL GUIDEWAY, RETAINING WALL, AND BRIDGE GENERAL NOTES
	S08-SEP101	REFERENCE	STRUCTURAL MAINLINE STRUCTURES PLAN AND PROFILE STA 1500+00 TO STA 1510+50
	S08-SEP102	REFERENCE	STRUCTURAL MAINLINE STRUCTURES PLAN AND PROFILE STA 1509+50 TO STA 1517+00
	S08-SEP103	REFERENCE	STRUCTURAL MAINLINE STRUCTURES PLAN AND PROFILE STA 1515+00 TO STA 1526+00
	S08-SEP104	REFERENCE	STRUCTURAL MAINLINE STRUCTURES PLAN AND PROFILE STA 1525+50 TO STA 1537+00
	S08-SEP105	REFERENCE	STRUCTURAL MAINLINE STRUCTURES PLAN AND PROFILE STA 1536+50 TO STA 1547+50
	S08-SEP106	REFERENCE	STRUCTURAL MAINLINE STRUCTURES PLAN AND PROFILE STA 1546+50 TO STA 1556+50
	S08-SEP107	REFERENCE	STRUCTURAL MAINLINE STRUCTURES PLAN AND PROFILE STA 1555+50 TO STA 1567+00
	S08-SEP108	REFERENCE	STRUCTURAL MAINLINE STRUCTURES PLAN AND PROFILE STA 1566+00 TO STA 1575+00
	S08-SEP110	REFERENCE	STRUCTURAL TEST TRACK STRUCTURES PLAN AND PROFILE STA 69+50 TO STA 75+00
	S08-SEP111	REFERENCE	STRUCTURAL TEST TRACK STRUCTURES PLAN AND PROFILE STA 75+00 TO STA 85+00
	STD-SFS001	REFERENCE	STRUCTURAL AERIAL GUIDEWAY - SUBSTRUCTURE FOUNDATION SCHEDULE
	STD-SVD001	REFERENCE	STRUCTURAL AERIAL GUIDEWAY - SUBSTRUCTURE DRILLED SHAFT DETAILS
	STD-SVD003	REFERENCE	STRUCTURAL AERIAL GUIDEWAY - SUBSTRUCTURE DRILLED SHAFT - COLUMN SILO DETAILS
	STD-SSS001	REFERENCE	STRUCTURAL AERIAL GUIDEWAY - SUBSTRUCTURE SUBSTRUCTURE SCHEDULE
	STD-SHX001	REFERENCE	STRUCTURAL AERIAL GUIDEWAY - SUBSTRUCTURE COLUMN SECTIONS
	STD-SBD002	REFERENCE	STRUCTURAL AERIAL GUIDEWAY - SUBSTRUCTURE TYPICAL SINGLE COLUMN BENT AT DOUBLE TRACK
	STD-SBD003	REFERENCE	STRUCTURAL AERIAL GUIDEWAY - SUBSTRUCTURE INTEGRAL SINGLE COLUMN BENT AT DOUBLE TRACK
	STD-SBD004	REFERENCE	STRUCTURAL AERIAL GUIDEWAY - SUBSTRUCTURE INTEGRAL TWO-COLUMN BENT
	STD-SBD005	REFERENCE	STRUCTURAL AERIAL GUIDEWAY - SUBSTRUCTURE UNDERSLUNG TWO-COLUMN BENT
	STD-SBD006	REFERENCE	STRUCTURAL AERIAL GUIDEWAY - SUBSTRUCTURE UNDERSLUNG THREE-COLUMN BENT WITH LEAD TRACK
	STD-SBD007	REFERENCE	STRUCTURAL AERIAL GUIDEWAY - SUBSTRUCTURE INTEGRAL THREE-COLUMN BENT WITH LEAD TRACK
	STD-SBD008	REFERENCE	STRUCTURAL AERIAL GUIDEWAY - SUBSTRUCTURE DOUBLE-TRACK ABUTMENT ON SPREAD FOOTING ON MSE
	STD-SBD010	REFERENCE	STRUCTURAL AERIAL GUIDEWAY - SUBSTRUCTURE THREE-TRACK ABUTMENT ON SPREAD FOOTING
	STD-SBD011	REFERENCE	STRUCTURAL AERIAL GUIDEWAY - SUBSTRUCTURE TYPICAL OFFSET BENT AT DOUBLE TRACK
	STD-SBD012	REFERENCE	STRUCTURAL AERIAL GUIDEWAY - SUBSTRUCTURE INTEGRAL HAMMERHEAD BENT AT 3-TRACK
	STD-SED011	REFERENCE	STRUCTURAL AERIAL GUIDEWAY - SUBSTRUCTURE TRANSITION SLAB DETAILS
	STD-SSS002	REFERENCE	STRUCTURAL AERIAL GUIDEWAY - SUPERSTRUCTURE SUPERSTRUCTURE SCHEDULE
	STD-SGX001	REFERENCE	STRUCTURAL AERIAL GUIDEWAY - SUPERSTRUCTURE TYPICAL DOUBLE TRACK SECTION
	STD-SGX002	REFERENCE	STRUCTURAL AERIAL GUIDEWAY - SUPERSTRUCTURE DOUBLE TRACK SECTION WITH OVERBUILD
	STD-SGX003	REFERENCE	STRUCTURAL AERIAL GUIDEWAY - SUPERSTRUCTURE THREE TRACK SECTION AT TEST TRACK
	STD-SGX004	REFERENCE	STRUCTURAL AERIAL GUIDEWAY - SUPERSTRUCTURE THREE TRACK SECTION AT LEAD TRACK
	STD-SGX005	REFERENCE	STRUCTURAL AERIAL GUIDEWAY - SUPERSTRUCTURE FOUR TRACK SECTION AT LEAD TRACK
	STD-SGX007	REFERENCE	STRUCTURAL AERIAL GUIDEWAY - SUPERSTRUCTURE DOUBLE TRACK SECTION WITH EXTERIOR WALKWAYS
	STD-SGS002	REFERENCE	STRUCTURAL AERIAL GUIDEWAY - SUPERSTRUCTURE TYPICAL FRAMING PLAN ON CURVES - MAINLINE
	STD-SSS004	REFERENCE	STRUCTURAL AERIAL GUIDEWAY - SUPERSTRUCTURE TYP CONSTRUCTION SEQUENCE - P/S GIRDER
	STD-SGX006	REFERENCE	STRUCTURAL AERIAL GUIDEWAY - SUPERSTRUCTURE DIAPHRAGM DETAILS
	STD-SED018	REFERENCE	STRUCTURAL AERIAL GUIDEWAY - SUPERSTRUCTURE DETAIL AT EXISTING BENT
	STD-SED019	REFERENCE	STRUCTURAL AERIAL GUIDEWAY - SUPERSTRUCTURE DETAIL AT TERMINUS BENT
	STD-SED005	REFERENCE	STRUCTURAL AERIAL GUIDEWAY - SUPERSTRUCTURE EXPANSION JOINT DETAILS
	STD-SDD001	REFERENCE	STRUCTURAL AERIAL GUIDEWAY - SUPERSTRUCTURE DRAINAGE DETAILS
	STD-SED020	REFERENCE	STRUCTURAL AERIAL GUIDEWAY - SUPERSTRUCTURE BEARING DETAILS
	STD-SWX001	REFERENCE	STRUCTURAL GUIDEWAY RETAINING WALL CUT WALL AT TEST TRACK
	STD-SWX002	REFERENCE	STRUCTURAL GUIDEWAY RETAINING WALL TYPICAL MSE WALL
	STD-SWX003	REFERENCE	STRUCTURAL GUIDEWAY RETAINING WALL MSE WALL BETWEEN NB TRACK AND TEST TRACK
	STD-SWX004	REFERENCE	STRUCTURAL GUIDEWAY RETAINING WALL TYPICAL CONCRETE CANTILEVER WALL
	STD-SWD001	REFERENCE	STRUCTURAL GUIDEWAY RETAINING WALL TYPICAL BALLAST WALLS
	STD-SWS001	REFERENCE	STRUCTURAL NOISE WALL GUIDEWAY ACOUSTIC BARRIER AND NOISE WALL SCH.
	STD-SWD007	REFERENCE	STRUCTURAL NOISE WALL ACOUSTIC BARRIER OVER MSE WALL DETAILS

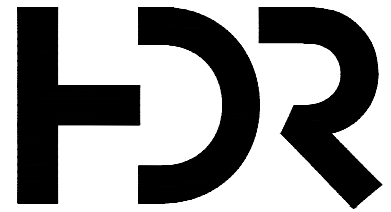
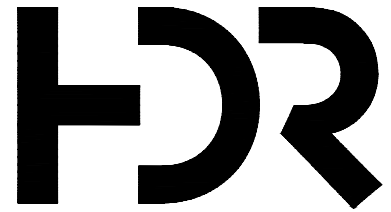
BUILDING STRUCTURES

	S08T-SGP101	REFERENCE	STRUCTURAL FIRST FLOOR
	S08T-SGP102	REFERENCE	STRUCTURAL ROOF PLAN
	S08T-SGX101	REFERENCE	STRUCTURAL TEST TRACK FACILITY SECTIONS
	S08T-SGS001	REFERENCE	STRUCTURAL 3D AXONOMETRIC VIEWS

ARCHITECTURE

	S08T-AZN011	REFERENCE	ARCHITECTURAL LIFE SAFETY LIFE SAFETY PLAN -LEVEL 1
	S08T-APP101	REFERENCE	ARCHITECTURAL FLOOR PLAN TEST TRACK FACILITY LEVEL 1

NOT FOR
CONSTRUCTION

REFERENCE CONCEPT DRAWINGS						AHJ:		PACKAGE #			DRAWING No.:		
						DESIGNED BY:					DRAWING No.: STD-GZ1104		
						C. FOX							
						DRAWN BY:							
						B. WILLIAMS							
						CHECKED BY:					FACILITY ID: STD		
						P. LOPEZ-HILFIKER							
						APPROVED BY:							
						P. LOPEZ-HILFIKER							
No.	DATE	DSN	CHK	APP	REVISION			SUBMITTED BY:	DATE:	REVIEWED BY:	DATE:	SHEET No.:	REV:
								PABLO LOPEZ-HILFIKER	2/27/2024		2/27/2024		0

02/20/24 | 9:45 AM | ASCHEPPE
C:\PWORKING\WEST01\2780545\OMFS-STD-GZ1103-111.DWG

INDEX OF DRAWINGS

SHEET NO.	DWG. NO.	PERSC/REF	TITLE	SHEET NO.	DWG. NO.	PERSC/REF	TITLE
ACHITECTURE CONTINUED				OPERATIONS AND MAINTENANCE FACILITY SOUTH DRAWINGS			
	S08T-AEE001	REFERENCE	ARCHITECTURAL ELEVATIONS TEST TRACK FACILITY ELEVATIONS	RIGHT OF WAY			
	S08T-ASX001	REFERENCE	ARCHITECTURAL SECTIONS TEST TRACK FACILITY SECTIONS		M08-RPP300	PREScriptive	RIGHT-OF-WAY OVERALL SITE & MAINLINE SOUTH OF S 336TH ST RIGHT-OF-WAY PLAN
	S08T-AMP001	REFERENCE	ARCHITECTURAL MASSING VIEWS TEST TRACK FACILITY VIEWS		M08-RPP101	PREScriptive	RIGHT-OF-WAY SITE RIGHT-OF-WAY PLAN
LANDSCAPE					M08-RPP102	PREScriptive	RIGHT-OF-WAY SITE RIGHT-OF-WAY PLAN
	S08-LPS001	REFERENCE	LANDSCAPE SCHEDULE		M08-RPP103	PREScriptive	RIGHT-OF-WAY SITE RIGHT-OF-WAY PLAN
	S08-LPP002	REFERENCE	LANDSCAPE PLAN STA 1500+00 TO STA 1510+00		M08-RPP104	PREScriptive	RIGHT-OF-WAY SITE RIGHT-OF-WAY PLAN
	S08-LPP003	REFERENCE	LANDSCAPE PLAN STA 1510+00 TO STA 1521+00		M08-RPP105	PREScriptive	RIGHT-OF-WAY SITE RIGHT-OF-WAY PLAN
	S08-LPP004	REFERENCE	LANDSCAPE PLAN STA 1521+00 TO STA 1532+00		M08-RPP106	PREScriptive	RIGHT-OF-WAY SITE RIGHT-OF-WAY PLAN
	S08-LPP005	REFERENCE	LANDSCAPE PLAN STA 1532+00 TO STA 1543+00		M08-RPP107	PREScriptive	RIGHT-OF-WAY SITE RIGHT-OF-WAY PLAN
	S08-LPP006	REFERENCE	LANDSCAPE PLAN STA 1543+00 TO STA 1555+00		M08-RPP108	PREScriptive	RIGHT-OF-WAY SITE RIGHT-OF-WAY PLAN
	S08-LPP007	REFERENCE	LANDSCAPE PLAN STA 1555+00 TO STA 1565+00		M08-RPP109	PREScriptive	RIGHT-OF-WAY SITE RIGHT-OF-WAY PLAN
	S08-LPP008	REFERENCE	LANDSCAPE PLAN STA 1565+00 TO STA 1577+00		M08-RPP110	PREScriptive	RIGHT-OF-WAY SITE RIGHT-OF-WAY PLAN
	S08-LPP009	REFERENCE	LANDSCAPE PLAN STA 1577+00 TO STA 1580+00		M08-RPP111	PREScriptive	RIGHT-OF-WAY SITE RIGHT-OF-WAY PLAN
MECHANICAL					M08-RPP112	PREScriptive	RIGHT-OF-WAY SITE RIGHT-OF-WAY PLAN
	S08T-MFP101	REFERENCE	MECHANICAL TTF FIRE PROTECTION FLOOR PLAN		M08-RPP113	PREScriptive	RIGHT-OF-WAY SITE RIGHT-OF-WAY PLAN
	S08T-MHP101	REFERENCE	MECHANICAL TTF HVAC FLOOR AND ROOF PLAN		M08-RPP114	PREScriptive	RIGHT-OF-WAY SITE RIGHT-OF-WAY PLAN
	S08T-MHS001	REFERENCE	MECHANICAL TTF HVAC BMS CONCEPT OF OPERATION		M08-RPP115	PREScriptive	RIGHT-OF-WAY SITE RIGHT-OF-WAY PLAN
	S08T-MHS002	REFERENCE	MECHANICAL TTF HVAC EQUIPMENT SCHEDULES		M08-RPP116	PREScriptive	RIGHT-OF-WAY SITE RIGHT-OF-WAY PLAN
	S08T-MPP001	REFERENCE	MECHANICAL TTF PLUMBING FOUNDATION PLAN		M08-RPP117	PREScriptive	RIGHT-OF-WAY SITE RIGHT-OF-WAY PLAN
	S08T-MPP101	REFERENCE	MECHANICAL TTF PLUMBING FLOOR PLAN		M08-RPP118	PREScriptive	RIGHT-OF-WAY SITE RIGHT-OF-WAY PLAN
	S08T-MPP201	REFERENCE	MECHANICAL TTF PLUMBING ROOF PLAN		M08-RPP119	PREScriptive	RIGHT-OF-WAY SITE RIGHT-OF-WAY PLAN
	S08T-MPS001	REFERENCE	MECHANICAL TTF PLUMBING EQUIPMENT SCHEDULES		M08-RPP120	PREScriptive	RIGHT-OF-WAY SITE RIGHT-OF-WAY PLAN
SYSTEMS					M08-RPP121	PREScriptive	RIGHT-OF-WAY SITE RIGHT-OF-WAY PLAN
	JZN001		TRACTION POWER SYSTEM SYSTEMS ABBREVIATIONS		M08-RPP122	PREScriptive	RIGHT-OF-WAY SITE RIGHT-OF-WAY PLAN
	STD-JTN001	PREScriptive	TRACTION POWER SYSTEM SYMBOLS AND LEGEND		M08-RPP123	PREScriptive	RIGHT-OF-WAY SITE RIGHT-OF-WAY PLAN
	STD-JTK001	REFERENCE	TRACTION POWER SYSTEM KEY PLAN		M08-RPP124	PREScriptive	RIGHT-OF-WAY SITE RIGHT-OF-WAY PLAN
	S08-JTS001	REFERENCE	TRACTION POWER SYSTEM MAINLINE SINGLE LINE DIAGRAM		M08-RPP125	PREScriptive	RIGHT-OF-WAY SITE RIGHT-OF-WAY PLAN
	S08-JTS002	PREScriptive	TRACTION POWER SYSTEM TPSS S08 METERING AND RELAYING SINGLE LINE DIAGRAM (SHEET 1 OF 2)		M08-RPP126	PREScriptive	RIGHT-OF-WAY SITE RIGHT-OF-WAY PLAN
	S08-JTS003	PREScriptive	TRACTION POWER SYSTEM TPSS S08 METERING AND RELAYING SINGLE LINE DIAGRAM (SHEET 2 OF 2)		M08-RPP127	PREScriptive	RIGHT-OF-WAY SITE RIGHT-OF-WAY PLAN
	S08-JTP101	REFERENCE	TRACTION POWER SYSTEM TPSS S08 SITE PLAN AND DETAILS		M08-RPP128	PREScriptive	RIGHT-OF-WAY SITE RIGHT-OF-WAY PLAN
	S08-JTP102	PREScriPITVE	TRACTION POWER SYSTEM TPSS GROUND GRID LAYOUT (TYPICAL)		M08-RPP129	PREScriptive	RIGHT-OF-WAY SITE RIGHT-OF-WAY PLAN
	S08-JTP103	REFERENCE	TRACTION POWER SYSTEM TPSS-S08 EQUIPMENT LAYOUT PLAN	TRACK WORK			
	S08-JTD001	REFERENCE	TRACTION POWER SYSTEM TPSS S08 PAD MOUNT DISCONNECT SWITCHES LAYOUT PLAN		M08-KAS001	REFERENCE	TRACKWORK ALIGNMENT DATA TABLES
	S08-JTS101	REFERENCE	TRACTION POWER SYSTEM TPSS #S08 CONDUIT AND CABLE SCHEDULE		M08-KAA200	REFERENCE	TRACKWORK OVERALL YARD TRACK PLAN
	S08-JTS102	REFERENCE	TRACTION POWER SYSTEM TYPICAL TPSS SCADA POINTS LIST		M08-KAA202	REFERENCE	TRACKWORK YARD TRACK PLAN
	STD-JTD001	PREScriptive	TRACTION POWER SYSTEM SUBSTATION GROUNDING DETAILS AND SIGNAGE		M08-KAA203	REFERENCE	TRACKWORK YARD TRACK PLAN
	STD-JTD002	REFERENCE	TRACTION POWER SYSTEM TRACTION POWER PULLBOX AND HANDHOLE DETAILS		M08-KAA204	REFERENCE	TRACKWORK YARD TRACK PLAN
	STD-JTD003	REFERENCE	TRACTION POWER SYSTEM TRACTION POWER DUCTBANK SECTIONS AND DETAILS		M08-KAA205	REFERENCE	TRACKWORK YARD TRACK PLAN
	S08-JOY020	REFERENCE	OVERHEAD CONTACT SYSTEMS GENERAL ARRANGEMENT SINGLE CROSSOVER		M08-KAA207	REFERENCE	TRACKWORK YARD TRACK PLAN
	S08-JOS060	REFERENCE	OVERHEAD CONTACT SYSTEMS SECTIONALIZATION PLAN MAINLINE		M08-KAA208	REFERENCE	TRACKWORK YARD TRACK PLAN
	S08-JOS070	REFERENCE	OVERHEAD CONTACT SYSTEMS MASTER OVERLAP CHART MAINLINE		M08-KAA209	REFERENCE	TRACKWORK YARD TRACK PLAN
	S08-JOP100	REFERENCE	OVERHEAD CONTACT SYSTEMS MAINLINE LAYOUT SB STA 1500+00 TO SB STA 1504+00		M08-KAA210	REFERENCE	TRACKWORK YARD TRACK PLAN
	S08-JOP101	REFERENCE	OVERHEAD CONTACT SYSTEMS MAINLINE LAYOUT SB STA 1504+00 TO SB STA 1514+00		M08-KAA212	REFERENCE	TRACKWORK YARD TRACK PLAN
	S08-JOP102	REFERENCE	OVERHEAD CONTACT SYSTEMS MAINLINE LAYOUT SB STA 1514+00 TO SB STA 1524+00		M08-KAA213	REFERENCE	TRACKWORK YARD TRACK PLAN
	S08-JOP103	REFERENCE	OVERHEAD CONTACT SYSTEMS MAINLINE LAYOUT SB STA 1524+00 TO SB STA 1533+00		M08-KAA214	REFERENCE	TRACKWORK YARD TRACK PLAN
	S08-JOP104	REFERENCE	OVERHEAD CONTACT SYSTEMS MAINLINE LAYOUT SB STA 1533+00 TO SB STA 1543+00		M08-KAA215	REFERENCE	TRACKWORK YARD TRACK PLAN
	S08-JOP105	REFERENCE	OVERHEAD CONTACT SYSTEMS MAINLINE LAYOUT SB STA 1543+00 TO SB STA 1552+00		M08-KAA217	REFERENCE	TRACKWORK YARD TRACK PLAN
	S08-JOP106	REFERENCE	OVERHEAD CONTACT SYSTEMS MAINLINE LAYOUT SB STA 1552+00 TO SB STA 1562+00		M08-KAA218	REFERENCE	TRACKWORK YARD TRACK PLAN
	S08-JOP107	REFERENCE	OVERHEAD CONTACT SYSTEMS MAINLINE LAYOUT SB STA 1562+00 TO SB STA 1571+00		M08-KAA219	REFERENCE	TRACKWORK YARD TRACK PLAN
	S08-JOP108	REFERENCE	OVERHEAD CONTACT SYSTEMS MAINLINE LAYOUT SB STA 1571+00 TO SB STA 1579+70		M08-KAA221	REFERENCE	TRACKWORK YARD TRACK PLAN
	S08-JOD108	REFERENCE	OVERHEAD CONTACT SYSTEMS ASSEMBLY SPRING TENSIONER - MAINLINE		M08-KAA222	REFERENCE	TRACKWORK YARD TRACK PLAN
	STD-JSN001	PREScriptive	SIGNAL SYSTEM SYMBOLS AND LEGEND		M08-KAP101	REFERENCE	TRACKWORK YARD TRACK L1 PLAN AND PROFILE L1 STA 10+00 TO 18+00
	S08-JSS001	REFERENCE	SIGNAL SYSTEM MAINLINE SINGLE LINE TRACK PLAN SHEET 1 OF 3		M08-KAP102	REFERENCE	TRACKWORK YARD TRACK L1 PLAN AND PROFILE L1 STA 18+00 TO 25+96.12
	S08-JSS002	REFERENCE	SIGNAL SYSTEM MAINLINE SINGLE LINE TRACK PLAN SHEET 2 OF 3		M08-KAP103	REFERENCE	TRACKWORK YARD TRACK L2 PLAN AND PROFILE L2 STA 20+00 TO 28+47.92
	S08-JSS003	REFERENCE	SIGNAL SYSTEM MAINLINE SINGLE LINE TRACK PLAN SHEET 3 OF 3		M08-KAP104	REFERENCE	TRACKWORK YARD TRACK L3 PLAN AND PROFILE L3 STA 30+00 TO 37+57.44
	S08-JSS101	REFERENCE	SIGNAL SYSTEM MAINLINE DOUBLE LINE TRACK SCHEMATIC SHEET 1 OF 3		M08-KAP105	REFERENCE	TRACKWORK YARD TRACK L4 PLAN AND PROFILE L4 STA 40+00 TO 44+00
	S08-JSS102	REFERENCE	SIGNAL SYSTEM MAINLINE DOUBLE LINE TRACK SCHEMATIC SHEET 2 OF 3		M08-KAP106	REFERENCE	TRACKWORK YARD TRACK L4 PLAN AND PROFILE L4 STA 44+00 TO 50+78.91
	S08-JSS103	REFERENCE	SIGNAL SYSTEM MAINLINE DOUBLE LINE TRACK SCHEMATIC SHEET 3 OF 3		M08-KYX001	REFERENCE	TRACKWORK TYPICAL SECTIONS
	STD-JCS001	REFERENCE	COMMUNICATIONS SYSTEM PROJECT LOCATION IDENTIFICATION M08		M08-KYX002	REFERENCE	TRACKWORK TYPICAL SECTIONS
	STD-JCK001	REFERENCE	COMMUNICATIONS SYSTEM KEY PLAN		M08-KYX003	REFERENCE	TRACKWORK TYPICAL SECTIONS
	S08-JCD001	REFERENCE	COMMUNICATIONS SYSTEM TYPICAL SIGNAL HOUSE EQUIPMENT LAYOUT		M08-KYX004	REFERENCE	TRACKWORK TYPICAL SECTIONS
	S08-JCD002	REFERENCE	COMMUNICATIONS SYSTEM SIGNAL BUNGALOW COMMUNICATIONS RACK ELEVATION AND FDP DETAIL	CIVIL			
	S08-JCD003	REFERENCE	COMMUNICATIONS SYSTEM TYPICAL TPSS EQUIPMENT LAYOUT		M08-CHP101	REFERENCE	CIVIL DELIVERY ROUTE
	S08-JCD004	REFERENCE	COMMUNICATIONS SYSTEM TPSS FIBER DISTRIBUTION CABINET ELEVATION AND FDP DETAIL		M08-CRY301	PREScriptive	CIVIL TYPICAL SECTIONS
					M08-CRY302	PREScriptive	CIVIL TYPICAL SECTIONS
					M08-CRY303	PREScriptive	CIVIL TYPICAL SECTIONS
					M08-CEP101	REFERENCE	CIVIL EXISTING CONDITIONS
					M08-CEP102	REFERENCE	CIVIL EXISTING CONDITIONS
					M08-CEP103	REFERENCE	CIVIL EXISTING CONDITIONS
					M08-CEP104	REFERENCE	CIVIL EXISTING CONDITIONS
					M08-CEP105	REFERENCE	CIVIL EXISTING CONDITIONS
					M08-CEP106	REFERENCE	CIVIL EXISTING CONDITIONS
					M08-CEP107	REFERENCE	CIVIL EXISTING CONDITIONS
					M08-CEP108	REFERENCE	CIVIL EXISTING CONDITIONS

Refer to the plan set COVER drawing
for disclaimers regarding this drawing.

for disclaimers regarding this drawing.										AHJ:				PACKAGE #								
REFERENCE CONCEPT DRAWINGS						DESIGNED BY:									SCALE:		SOUND TRANSIT PRELIMINARY ENGINEERING PLANS OPERATIONS & MAINTENANCE FACILITY SOUTH GENERAL INDEX OF DRAWINGS				DRAWING No.:	
						C. FOX									STD-GZI105							
						DRAWN BY:									FACILITY ID:							
						B. WILLIAMS									STD							
						CHECKED BY:									SHEET No.:							
						P. LOPEZ-HILFIKER						AE-0030-17				REV:						
						APPROVED BY:						DATE:						0				
						P. LOPEZ-HILFIKER						DATE:										

NOT FOR
CONSTRUCTION

02/20/24 | 9:45 AM | ASCHEPPE
C:\PWORKING\WEST01\2780545\OMFS-STD-GZ103-111.DWG

INDEX OF DRAWINGS

SHEET NO.	DWG. NO.	PERSC/REF	TITLE
CIVIL CONTINUED			
	M08-CEP109	REFERENCE	CIVIL EXISTING CONDITIONS
	M08-CEP110	REFERENCE	CIVIL EXISTING CONDITIONS
	M08-CEP111	REFERENCE	CIVIL EXISTING CONDITIONS
	M08-CEP112	REFERENCE	CIVIL EXISTING CONDITIONS
	M08-CEP113	REFERENCE	CIVIL EXISTING CONDITIONS
	M08-CEP114	REFERENCE	CIVIL EXISTING CONDITIONS
	M08-CEP115	REFERENCE	CIVIL EXISTING CONDITIONS
	M08-CEP116	REFERENCE	CIVIL EXISTING CONDITIONS
	M08-CEP117	REFERENCE	CIVIL EXISTING CONDITIONS
	M08-CEP118	REFERENCE	CIVIL EXISTING CONDITIONS
	M08-CEP119	REFERENCE	CIVIL EXISTING CONDITIONS
	M08-CEP120	REFERENCE	CIVIL EXISTING CONDITIONS
	M08-CEP121	REFERENCE	CIVIL EXISTING CONDITIONS
	M08-CEP122	REFERENCE	CIVIL EXISTING CONDITIONS
	M08-CEP123	REFERENCE	CIVIL EXISTING CONDITIONS
	M08-CEP124	REFERENCE	CIVIL EXISTING CONDITIONS
	M08-CEP125	REFERENCE	CIVIL EXISTING CONDITIONS
	M08-CEP126	REFERENCE	CIVIL EXISTING CONDITIONS
	M08-CEP127	REFERENCE	CIVIL EXISTING CONDITIONS
	M08-CEP128	REFERENCE	CIVIL EXISTING CONDITIONS
	M08-CEP129	REFERENCE	CIVIL EXISTING CONDITIONS
	M08-CEP130	REFERENCE	CIVIL EXISTING CONDITIONS
	M08-CEP131	REFERENCE	CIVIL EXISTING CONDITIONS
	M08-CEP132	REFERENCE	CIVIL EXISTING CONDITIONS
	M08-CUP101	REFERENCE	CIVIL EXISTING UTILITIES
	M08-CUP102	REFERENCE	CIVIL EXISTING UTILITIES
	M08-CUP103	REFERENCE	CIVIL EXISTING UTILITIES
	M08-CUP104	REFERENCE	CIVIL EXISTING UTILITIES
	M08-CUP105	REFERENCE	CIVIL EXISTING UTILITIES
	M08-CUP106	REFERENCE	CIVIL EXISTING UTILITIES
	M08-CUP107	REFERENCE	CIVIL EXISTING UTILITIES
	M08-CUP108	REFERENCE	CIVIL EXISTING UTILITIES
	M08-CUP109	REFERENCE	CIVIL EXISTING UTILITIES
	M08-CUP110	REFERENCE	CIVIL EXISTING UTILITIES
	M08-CUP111	REFERENCE	CIVIL EXISTING UTILITIES
	M08-CUP112	REFERENCE	CIVIL EXISTING UTILITIES
	M08-CUP113	REFERENCE	CIVIL EXISTING UTILITIES
	M08-CUP114	REFERENCE	CIVIL EXISTING UTILITIES
	M08-CUP115	REFERENCE	CIVIL EXISTING UTILITIES
	M08-CUP116	REFERENCE	CIVIL EXISTING UTILITIES
	M08-CUP117	REFERENCE	CIVIL EXISTING UTILITIES
	M08-CUP118	REFERENCE	CIVIL EXISTING UTILITIES
	M08-CUP119	REFERENCE	CIVIL EXISTING UTILITIES
	M08-CUP120	REFERENCE	CIVIL EXISTING UTILITIES
	M08-CUP121	REFERENCE	CIVIL EXISTING UTILITIES
	M08-CUP122	REFERENCE	CIVIL EXISTING UTILITIES
	M08-CUP123	REFERENCE	CIVIL EXISTING UTILITIES
	M08-CUP124	REFERENCE	CIVIL EXISTING UTILITIES
	M08-CUP125	REFERENCE	CIVIL EXISTING UTILITIES
	M08-CUP126	REFERENCE	CIVIL EXISTING UTILITIES
	M08-CUP127	REFERENCE	CIVIL EXISTING UTILITIES
	M08-CUP128	REFERENCE	CIVIL EXISTING UTILITIES
	M08-CUP129	REFERENCE	CIVIL EXISTING UTILITIES
	M08-CUP130	REFERENCE	CIVIL EXISTING UTILITIES
	M08-CXP100A	REFERENCE	CIVIL OVERALL DEMOLITION PLAN
	M08-CXP100B	REFERENCE	CIVIL OVERALL DEMOLITION PLAN
	M08-CXP101	REFERENCE	CIVIL DEMOLITION PLAN
	M08-CXP102	REFERENCE	CIVIL DEMOLITION PLAN
	M08-CXP103	REFERENCE	CIVIL DEMOLITION PLAN
	M08-CXP104	REFERENCE	CIVIL DEMOLITION PLAN
	M08-CXP105	REFERENCE	CIVIL DEMOLITION PLAN
	M08-CXP106	REFERENCE	CIVIL DEMOLITION PLAN
	M08-CXP107	REFERENCE	CIVIL DEMOLITION PLAN
	M08-CXP108	REFERENCE	CIVIL DEMOLITION PLAN
	M08-CXP109	REFERENCE	CIVIL DEMOLITION PLAN
	M08-CXP110	REFERENCE	CIVIL DEMOLITION PLAN
	M08-CXP111	REFERENCE	CIVIL DEMOLITION PLAN
	M08-CXP112	REFERENCE	CIVIL DEMOLITION PLAN
	M08-CXP113	REFERENCE	CIVIL DEMOLITION PLAN
	M08-CXP114	REFERENCE	CIVIL DEMOLITION PLAN
	M08-CXP115	REFERENCE	CIVIL DEMOLITION PLAN
	M08-CXP116	REFERENCE	CIVIL DEMOLITION PLAN
	M08-CXP117	REFERENCE	CIVIL DEMOLITION PLAN
	M08-CXP118	REFERENCE	CIVIL DEMOLITION PLAN

Refer to the plan set COVER drawing
for disclaimers regarding this drawing.

SHEET NO.	DWG. NO.	PERSC/REF	TITLE
CIVIL CONTINUED			
	M08-CXP119	REFERENCE	CIVIL DEMOLITION PLAN
	M08-CXP120	REFERENCE	CIVIL DEMOLITION PLAN
	M08-CXP121	REFERENCE	CIVIL DEMOLITION PLAN
	M08-CXP122	REFERENCE	CIVIL DEMOLITION PLAN
	M08-CXP123	REFERENCE	CIVIL DEMOLITION PLAN
	M08-CXP124	REFERENCE	CIVIL DEMOLITION PLAN
	M08-CXP125	REFERENCE	CIVIL DEMOLITION PLAN
	M08-CXP126	REFERENCE	CIVIL DEMOLITION PLAN
	M08-CXP127	REFERENCE	CIVIL DEMOLITION PLAN
	M08-CXP128	REFERENCE	CIVIL DEMOLITION PLAN
	M08-CXP129	REFERENCE	CIVIL DEMOLITION PLAN
	M08-CXP130	REFERENCE	CIVIL DEMOLITION PLAN
	M08-CRP300A	REFERENCE	CIVIL OVERALL ROADWAY PLAN
	M08-CRP300B	REFERENCE	CIVIL OVERALL ROADWAY PLAN
	M08-CRP301	REFERENCE	CIVIL ROADWAY PLAN
	M08-CRP302	REFERENCE	CIVIL ROADWAY PLAN
	M08-CRP303	REFERENCE	CIVIL ROADWAY PLAN
	M08-CRP304	REFERENCE	CIVIL ROADWAY PLAN
	M08-CRP305	REFERENCE	CIVIL ROADWAY PLAN
	M08-CRP307	REFERENCE	CIVIL ROADWAY PLAN
	M08-CRP308	REFERENCE	CIVIL ROADWAY PLAN
	M08-CRP309	REFERENCE	CIVIL ROADWAY PLAN
	M08-CRP310	REFERENCE	CIVIL ROADWAY PLAN
	M08-CRP311	REFERENCE	CIVIL ROADWAY PLAN
	M08-CRP312	REFERENCE	CIVIL ROADWAY PLAN
	M08-CRP313	REFERENCE	CIVIL ROADWAY PLAN
	M08-CRP314	REFERENCE	CIVIL ROADWAY PLAN
	M08-CRP315	REFERENCE	CIVIL ROADWAY PLAN
	M08-CRP316	REFERENCE	CIVIL ROADWAY PLAN
	M08-CRP317	REFERENCE	CIVIL ROADWAY PLAN
	M08-CRP318	REFERENCE	CIVIL ROADWAY PLAN
	M08-CRP319	REFERENCE	CIVIL ROADWAY PLAN
	M08-CRP321	REFERENCE	CIVIL ROADWAY PLAN
	M08-CRP322	REFERENCE	CIVIL ROADWAY PLAN
	M08-CRP323	REFERENCE	CIVIL ROADWAY PLAN
	M08-CRP325	REFERENCE	CIVIL ROADWAY PLAN
	M08-CRP326	REFERENCE	CIVIL ROADWAY PLAN
	M08-CRP327	REFERENCE	CIVIL ROADWAY PLAN
	M08-CRP328	REFERENCE	CIVIL ROADWAY PLAN
	M08-CRP330	REFERENCE	CIVIL ROADWAY PLAN
	M08-CRP331	REFERENCE	CIVIL ROADWAY PLAN
	M08-CRP332	REFERENCE	CIVIL ROADWAY PLAN
	M08-CRV101	REFERENCE	CIVIL ROADWAY PROFILE S 336TH ST STA 12+00 TO STA 18+00
	M08-CRV102	REFERENCE	CIVIL ROADWAY PROFILE S 336TH ST STA 18+00 TO STA 24+00
	M08-CRV103	REFERENCE	CIVIL ROADWAY PROFILE S 336TH ST STA 24+00 TO STA 27+00
	M08-CRV104	REFERENCE	CIVIL ROADWAY PROFILE S 336TH ST STA 27+00 TO STA 35+50
	M08-CRV105	REFERENCE	CIVIL ROADWAY PROFILE 18TH PL S EXTENSION STA 9+50 TO STA 15+50
	M08-CRV106	REFERENCE	CIVIL ROADWAY PROFILE 18TH PL S EXTENSION STA 15+50 TO STA 21+50
	M08-CRV107	REFERENCE	CIVIL ROADWAY PROFILE 18TH PL S EXTENSION STA 21+50 TO STA 25+50
	M08-CRV108	REFERENCE	CIVIL ROADWAY PROFILE S 341ST PL STA 10+00 TO STA 16+00
	M08-CRV109	REFERENCE	CIVIL ROADWAY PROFILE S 341ST PL STA 16+00 TO STA 20+00
	M08-CRV110	REFERENCE	CIVIL ROADWAY PROFILE GUARD GATE ENTRANCE STA 9+50 TO STA 15+50
	M08-CRV111	REFERENCE	CIVIL ROADWAY PROFILE GUARD GATE ENTRANCE STA 15+50 TO STA 21+50
	M08-CRV112	REFERENCE	CIVIL ROADWAY PROFILE GUARD GATE ENT. STA 21+50 TO STA 27+50
	M08-CRV113	REFERENCE	CIVIL ROADWAY PROFILE MOW ENTRANCE/ 21ST AVE S EXT. STA 10+00 TO STA 16+00
	M08-CRV114	REFERENCE	CIVIL ROADWAY PROFILE 21ST AVE S EXT. STA 16+00 TO STA 18+50/ S 344TH ST
	M08-CGP100A	REFERENCE	CIVIL GRADING PLAN
	M08-CGP100B	REFERENCE	CIVIL GRADING PLAN
	M08-CGP101	REFERENCE	CIVIL GRADING PLAN
	M08-CGP102	REFERENCE	CIVIL GRADING PLAN
	M08-CGP103	REFERENCE	CIVIL GRADING PLAN
	M08-CGP104	REFERENCE	CIVIL GRADING PLAN
	M08-CGP105	REFERENCE	CIVIL GRADING PLAN
	M08-CGP106	REFERENCE	CIVIL GRADING PLAN
	M08-CGP107	REFERENCE	CIVIL GRADING PLAN
	M08-CGP108	REFERENCE	CIVIL GRADING PLAN
	M08-CGP109	REFERENCE	CIVIL GRADING PLAN
	M08-CGP110	REFERENCE	CIVIL GRADING PLAN
	M08-CGP111	REFERENCE	CIVIL GRADING PLAN
	M08-CGP112	REFERENCE	CIVIL GRADING PLAN
	M08-CGP113	REFERENCE	CIVIL GRADING PLAN
	M08-CGP114	REFERENCE	CIVIL GRADING PLAN
	M08-CGP115	REFERENCE	CIVIL GRADING PLAN
	M08-CGP116	REFERENCE	CIVIL GRADING PLAN

NOT FOR
CONSTRUCTION

for disclaimers regarding this drawing.										AHJ:										PACKAGE #																																							
REFERENCE CONCEPT DRAWINGS										DESIGNED BY: C. FOX										  SUBMITTED BY: PABLO LOPEZ-HILFIKER DATE: 2/27/2024 REVIEWED BY: DATE:										 SCALE: NTS FILENAME: OMFS-STD-GZI103-111 CONTRACT No.: AE-0030-17 DATE: 2/27/2024										SOUND TRANSIT PRELIMINARY ENGINEERING PLANS OPERATIONS & MAINTENANCE FACILITY SOUTH GENERAL INDEX OF DRAWINGS										DRAWING No.: STD-GZI106									
										DRAWN BY: B. WILLIAMS																																								FACILITY ID: STD									
										CHECKED BY: P. LOPEZ-HILFIKER																																								SHEET No.: REV:									
										APPROVED BY: P. LOPEZ-HILFIKER																																								1									
										No. DATE DSN CHK APP REVISION																																																	

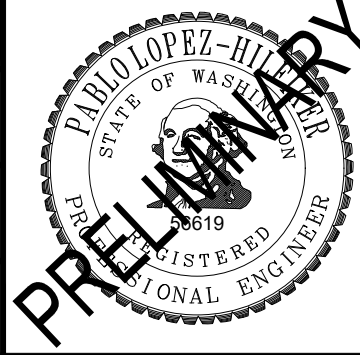
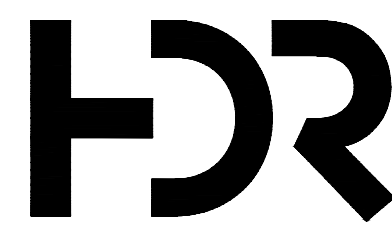
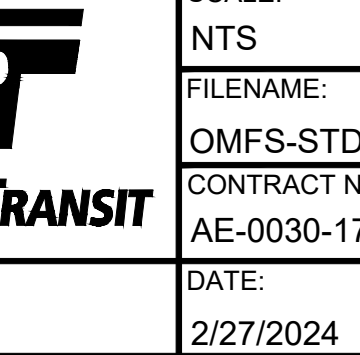
02/20/24 | 9:45 AM | ASCHEPPE
C:\PWORKING\WEST01\02780545\OMFS-STD-GZI103-111.DWG

INDEX OF DRAWINGS

SHEET NO.	DWG. NO.	PERSC/REF	TITLE	SHEET NO.	DWG. NO.	PERSC/REF	TITLE
CIVIL CONTINUED				UTILITY CONTINUED			
	M08-CGP117	REFERENCE	CIVIL GRADING PLAN		M08-UCP101	REFERENCE	UTILITY COMPOSITE SITE UTILITY PLANS
	M08-CGP118	REFERENCE	CIVIL GRADING PLAN		M08-UCP102	REFERENCE	UTILITY COMPOSITE SITE UTILITY PLANS
	M08-CGP119	REFERENCE	CIVIL GRADING PLAN		M08-UCP103	REFERENCE	UTILITY COMPOSITE SITE UTILITY PLANS
	M08-CGP120	REFERENCE	CIVIL GRADING PLAN		M08-UCP104	REFERENCE	UTILITY COMPOSITE SITE UTILITY PLANS
	M08-CGP121	REFERENCE	CIVIL GRADING PLAN		M08-UCP105	REFERENCE	UTILITY COMPOSITE SITE UTILITY PLANS
	M08-CGP122	REFERENCE	CIVIL GRADING PLAN		M08-UCP106	REFERENCE	UTILITY COMPOSITE SITE UTILITY PLANS
	M08-CGP123	REFERENCE	CIVIL GRADING PLAN		M08-UCP107	REFERENCE	UTILITY COMPOSITE SITE UTILITY PLANS
	M08-CGP124	REFERENCE	CIVIL GRADING PLAN		M08-UCP108	REFERENCE	UTILITY COMPOSITE SITE UTILITY PLANS
	M08-CGP125	REFERENCE	CIVIL GRADING PLAN		M08-UCP109	REFERENCE	UTILITY COMPOSITE SITE UTILITY PLANS
	M08-CGP126	REFERENCE	CIVIL GRADING PLAN		M08-UCP110	REFERENCE	UTILITY COMPOSITE SITE UTILITY PLANS
	M08-CGP127	REFERENCE	CIVIL GRADING PLAN		M08-UCP111	REFERENCE	UTILITY COMPOSITE SITE UTILITY PLANS
	M08-CGP128	REFERENCE	CIVIL GRADING PLAN		M08-UCP112	REFERENCE	UTILITY COMPOSITE SITE UTILITY PLANS
	M08-CGX101	REFERENCE	CIVIL GRADING SECTIONS		M08-UCP113	REFERENCE	UTILITY COMPOSITE SITE UTILITY PLANS
	M08-CGX102	REFERENCE	CIVIL GRADING SECTIONS		M08-UCP114	REFERENCE	UTILITY COMPOSITE SITE UTILITY PLANS
	M08-CGX103	REFERENCE	CIVIL GRADING SECTIONS		M08-UCP115	REFERENCE	UTILITY COMPOSITE SITE UTILITY PLANS
	M08-CGX104	REFERENCE	CIVIL GRADING SECTIONS		M08-UCP116	REFERENCE	UTILITY COMPOSITE SITE UTILITY PLANS
	M08-CGX105	REFERENCE	CIVIL GRADING SECTIONS		M08-UCP117	REFERENCE	UTILITY COMPOSITE SITE UTILITY PLANS
	M08-CGX106	REFERENCE	CIVIL GRADING SECTIONS		M08-UCP118	REFERENCE	UTILITY COMPOSITE SITE UTILITY PLANS
	M08-CDP100	REFERENCE	CIVIL OVERALL SITE DRAINAGE PLAN		M08-UCP119	REFERENCE	UTILITY COMPOSITE SITE UTILITY PLANS
	M08-CDP101	REFERENCE	CIVIL DRAINAGE PLAN		M08-UCP120	REFERENCE	UTILITY COMPOSITE SITE UTILITY PLANS
	M08-CDP102	REFERENCE	CIVIL DRAINAGE PLAN		M08-UCP121	REFERENCE	UTILITY COMPOSITE SITE UTILITY PLANS
	M08-CDP103	REFERENCE	CIVIL DRAINAGE PLAN		M08-UCP122	REFERENCE	UTILITY COMPOSITE SITE UTILITY PLANS
	M08-CDP104	REFERENCE	CIVIL DRAINAGE PLAN		M08-UCP123	REFERENCE	UTILITY COMPOSITE SITE UTILITY PLANS
	M08-CDP105	REFERENCE	CIVIL DRAINAGE PLAN		M08-UCP124	REFERENCE	UTILITY COMPOSITE SITE UTILITY PLANS
	M08-CDP106	REFERENCE	CIVIL DRAINAGE PLAN		M08-UCP125	REFERENCE	UTILITY COMPOSITE SITE UTILITY PLANS
	M08-CDP107	REFERENCE	CIVIL DRAINAGE PLAN		M08-UCP126	REFERENCE	UTILITY COMPOSITE SITE UTILITY PLANS
	M08-CDP108	REFERENCE	CIVIL DRAINAGE PLAN		M08-UCP127	REFERENCE	UTILITY COMPOSITE SITE UTILITY PLANS
	M08-CDP109	REFERENCE	CIVIL DRAINAGE PLAN		M08-UCP128	REFERENCE	UTILITY COMPOSITE SITE UTILITY PLANS
	M08-CDP110	REFERENCE	CIVIL DRAINAGE PLAN		M08-UCP129	REFERENCE	UTILITY COMPOSITE SITE UTILITY PLANS
	M08-CDP111	REFERENCE	CIVIL DRAINAGE PLAN		M08-UCP130	REFERENCE	UTILITY COMPOSITE SITE UTILITY PLANS
	M08-CDP112	REFERENCE	CIVIL DRAINAGE PLAN		M08-UCP131	REFERENCE	UTILITY COMPOSITE SITE UTILITY PLANS
	M08-CDP113	REFERENCE	CIVIL DRAINAGE PLAN		M08-UCP132	REFERENCE	UTILITY COMPOSITE SITE UTILITY PLANS
	M08-CDP114	REFERENCE	CIVIL DRAINAGE PLAN		M08-UCP133	REFERENCE	UTILITY COMPOSITE SITE UTILITY PLANS
	M08-CDP115	REFERENCE	CIVIL DRAINAGE PLAN				
	M08-CDP116	REFERENCE	CIVIL DRAINAGE PLAN				
	M08-CDP117	REFERENCE	CIVIL DRAINAGE PLAN				
	M08-CDP118	REFERENCE	CIVIL DRAINAGE PLAN				
	M08-CDP119	REFERENCE	CIVIL DRAINAGE PLAN				
	M08-CDP120	REFERENCE	CIVIL DRAINAGE PLAN				
	M08-CDP121	REFERENCE	CIVIL DRAINAGE PLAN				
	M08-CDP122	REFERENCE	CIVIL DRAINAGE PLAN				
	M08-CDP123	REFERENCE	CIVIL DRAINAGE PLAN				
	M08-CDP124	REFERENCE	CIVIL DRAINAGE PLAN				
	M08-CDP125	REFERENCE	CIVIL DRAINAGE PLAN				
	M08-CDP126	REFERENCE	CIVIL DRAINAGE PLAN				
	M08-CDP127	REFERENCE	CIVIL DRAINAGE PLAN				
	M08-CDP128	REFERENCE	CIVIL DRAINAGE PLAN				
	M08-CDP130	REFERENCE	CIVIL DRAINAGE PLAN				
	M08-CDP131	REFERENCE	CIVIL DRAINAGE PLAN				
	M08-CDP132	REFERENCE	CIVIL DRAINAGE PLAN				
	M08-CDP133	REFERENCE	CIVIL DRAINAGE PLAN				
	M08-CDP134	REFERENCE	CIVIL DRAINAGE DETAILS				
	M08-CDX001	REFERENCE	CIVIL DRAINAGE SECTIONS AND DETAILS SWM FACILITY SECTIONS				
	M08-CDX002	REFERENCE	CIVIL DRAINAGE SECTIONS AND DETAILS SWM FACILITY DETAILS				
	M08-CDX003	REFERENCE	CIVIL DRAINAGE SECTIONS AND DETAILS SWM FACILITY DESIGN SUMMARY TABLE				
STREAM							
	M08-SRP100	REFERENCE	STREAM STREAM KEY PLAN				
	M08-SRP101	REFERENCE	STREAM EAST FORK HYLEBOS CREEK TRIB 0016A PLAN AND PROFILE STA 100+00 TO 105+00				
	M08-SRP102	REFERENCE	STREAM EAST FORK HYLEBOS CREEK TRIB 0016A PLAN AND PROFILE STA 105+00 TO 110+00				
	M08-SRP103	REFERENCE	STREAM EAST FORK HYLEBOS CREEK TRIB 0016A PLAN AND PROFILE STA 110+00 TO 115+00				
	M08-SRP104	REFERENCE	STREAM EAST FORK HYLEBOS CREEK TRIB 0016A PLAN AND PROFILE STA 115+00 TO 120+00				
	M08-SRP105	REFERENCE	STREAM EAST FORK HYLEBOS CREEK TRIB 0016A PLAN AND PROFILE STA 120+00 TO 125+00				
	M08-SRP106	REFERENCE	STREAM EAST FORK HYLEBOS CREEK TRIB 0016A PLAN AND PROFILE STA 125+00 TO 130+00				
	M08-SRP107	REFERENCE	STREAM EAST FORK HYLEBOS CREEK TRIB 0016A PLAN AND PROFILE STA 130+00 TO 135+00				
	M08-SRP108	REFERENCE	STREAM EAST FORK HYLEBOS CREEK TRIB 0016A PLAN AND PROFILE STA 135+00 TO 140+00				
	M08-SRP109	REFERENCE	STREAM WEST FORK HYLEBOS CREEK TRIB 0014C PLAN AND PROFILE STA 150+00 TO 154+00				
	M08-SRX101	REFERENCE	STREAM EAST FORK HYLEBOS CREEK TRIB 0016A TYPICAL SECTIONS				
	M08-SRX102	REFERENCE	STREAM EAST FORK HYLEBOS CREEK TRIB 0016A TYPICAL SECTIONS				
	M08-SRX103	REFERENCE	STREAM EAST FORK HYLEBOS CREEK TRIB 0016A TYPICAL SECTIONS				
	M08-SRX104	REFERENCE	STREAM WEST FORK HYLEBOS CREEK TRIB 0014C TYPICAL SECTIONS				
UTILITY							
	M08-UZN100	REFERENCE	UTILITY GENERAL UTILITY NOTES				
	M08-UCP600	REFERENCE	UTILITY OVERALL UTILITY PLAN				

Refer to the plan set COVER drawing
for disclaimers regarding this drawing.

AHJ:

REFERENCE CONCEPT DRAWINGS						DESIGNED BY:				LINE IS 1" AT FULL SCALE 				SCALE:		SOUND TRANSIT PRELIMINARY ENGINEERING PLANS OPERATIONS & MAINTENANCE FACILITY SOUTH GENERAL INDEX OF DRAWINGS				DRAWING No.:	
						NTS								STD-GZI107							
						FILENAME:								FACILITY ID:							
						OMFS-STD-GZI103-111								STD							
						CONTRACT No.:								SHEET No.:							
AE-0030-17		REV:																			
DATE:		2/27/2024														2					
SUBMITTED BY:		DATE:		REVIEWED BY:		DATE:															
PABLO LOPEZ-HILFIKER		2/27/2024				2/27/2024															
P. LOPEZ-HILFIKER																					
No.	DATE	DSN	CHK	APP	REVISION																

NOT FOR
CONSTRUCTION

02/2024 | 9:45 AM | ASCHEPPE
C:\PWORKING\WEST01\D2780545\OMFS-STD-GZ1103-111.DWG

INDEX OF DRAWINGS

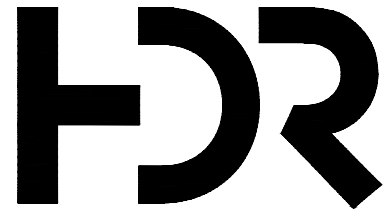
SHEET NO.	DWG. NO.	PERSC/REF	TITLE	SHEET NO.	DWG. NO.	PERSC/REF	TITLE
STRUCTURAL CONTINUED				STRUCTURAL CONTINUED			
	M08-SWP404	REFERENCE	STRUCTURAL SITE WALL E PLAN AND PROFILE STA E 15+00 TO STA E 20+00		M10-SGP103	REFERENCE	STRUCTURAL FLOOR PLANS - ROOF
	M08-SWP405	REFERENCE	STRUCTURAL SITE WALL E PLAN AND PROFILE STA E 20+00 TO STA E 25+00		M10-SGX101	REFERENCE	STRUCTURAL BUILDING SECTIONS
	M08-SWP406	REFERENCE	STRUCTURAL SITE WALL E PLAN AND PROFILE STA E 25+00 TO STA E 30+00		M10-SGS101	REFERENCE	STRUCTURAL 3D AXONOMETRIC VIEWS
	M08-SWP501	REFERENCE	STRUCTURAL ROADWAY WALL 21W PLAN AND PROFILE STA 21W 0+00 TO STA 21W 4+00	ARCHITECTURAL			
	M08-SWP502	REFERENCE	STRUCTURAL ROADWAY WALL 21W PLAN AND PROFILE STA 21W 4+00 TO STA 21W 6+50		GEN-AZN001	REFERENCE	ARCHITECTURAL CODE ANALYSIS BUILDING CODE
	M08-SWP503	REFERENCE	STRUCTURAL ROADWAY WALL 21E PLAN AND PROFILE STA 21E 0+00 TO STA 21E 3+50		GEN-AZN002	REFERENCE	ARCHITECTURAL LIFE SAFETY SECURITY BOOTH LIFE SAFETY PLAN
	M08-SDP101	REFERENCE	STRUCTURAL HYDRAULIC STRUCTURE 1 PLAN AND ELEVATION		GEN-AZN003	REFERENCE	ARCHITECTURAL SITE PLAN ARCH SITE PLAN
	M08-SDP102	REFERENCE	STRUCTURAL HYDRAULIC STRUCTURE 2 PLAN AND ELEVATION		M08-AZN003	REFERENCE	ARCHITECTURAL LIFE SAFETY OCCUPANCY CLASSIFICATION SCHEDULES
	M08-SDP103	REFERENCE	STRUCTURAL HYDRAULIC STRUCTURE 3 PLAN AND ELEVATION		M08-AZN004	REFERENCE	ARCHITECTURAL LIFE SAFETY OMF LIFE SAFETY PLAN -LEVEL 1
	M08-SWD001	REFERENCE	STRUCTURAL SITE RETAINING WALL TYPICAL MSE WALL SECTIONS		M08-AZN005	REFERENCE	ARCHITECTURAL LIFE SAFETY OMF LIFE SAFETY PLAN -LEVEL 2
	M08-SWD002	REFERENCE	STRUCTURAL ROADWAY RETAINING WALL TYPICAL CIP CANTILEVER WALL		M08-APP001	REFERENCE	ARCHITECTURAL FLOOR PLAN OMF OVERALL LOWER WORK PLATFORM PLAN
	M08-SWD003	REFERENCE	STRUCTURAL SITE RETAINING WALL TYPICAL CANTILEVER SOLDIER PILE WALL		M08-APP101	REFERENCE	ARCHITECTURAL FLOOR PLAN OMF OVERALL PLAN -LEVEL 1
	M08-SWD004	REFERENCE	STRUCTURAL SITE RETAINING WALL MSE WALL SECTION AT WALLS N AND L2		M08-APP102	REFERENCE	ARCHITECTURAL FLOOR PLAN OMF ENLARGED PLANS -LEVEL 1-A
	M08-SWD005	REFERENCE	STRUCTURAL SITE RETAINING WALL CUT WALL SECTION AT WALL N		M08-APP103	REFERENCE	ARCHITECTURAL FLOOR PLAN OMF ENLARGED PLANS -LEVEL 1-B
	M08-SWD006	REFERENCE	STRUCTURAL SITE RETAINING WALL MSE WALL SECTION AT WALLS B3 AND B4		M08-APP104	REFERENCE	ARCHITECTURAL FLOOR PLAN OMF ENLARGED PLANS -LEVEL 1-C
	M08-SWD007	REFERENCE	STRUCTURAL ROADWAY RETAINING WALL WALL 336SW SECTION AT S. 336TH ST		M08-APP105	REFERENCE	ARCHITECTURAL FLOOR PLAN OMF ENLARGED PLANS -LEVEL 1-D
	M08-SWD008	REFERENCE	STRUCTURAL ROADWAY RETAINING WALL TIERED WALL SECTION AT 18TH PL S		M08-APP106	REFERENCE	ARCHITECTURAL FLOOR PLAN OMF ENLARGED PLANS -LEVEL 1-E
	M08-SWD010	REFERENCE	STRUCTURAL ROADWAY RETAINING WALLS WALL SECTION AT WALLS 21W AND 21E		M08-APP106A	REFERENCE	ARCHITECTURAL FLOOR PLAN OMF ENLARGED PLANS -LEVEL 1-F
	M08-SDX101	REFERENCE	STRUCTURAL HYDRAULIC STRUCTURE 1 SECTION		M08-APP107	REFERENCE	ARCHITECTURAL FLOOR PLAN OMF ENLARGED PLANS -LEVEL 1-G
	M08-SDX102	REFERENCE	STRUCTURAL HYDRAULIC STRUCTURE 2 SECTION		M08-APP108	REFERENCE	ARCHITECTURAL FLOOR PLAN OMF ENLARGED PLANS -LEVEL 1-H
	M08-SDX103	REFERENCE	STRUCTURAL HYDRAULIC STRUCTURE 3 SECTION		M08-APP109	REFERENCE	ARCHITECTURAL FLOOR PLAN OMF ENLARGED PLANS -LEVEL 1-I
	M08-SDX104	REFERENCE	STRUCTURAL HYDRAULIC STRUCTURE 3 SECTION		M08-APP110	REFERENCE	ARCHITECTURAL FLOOR PLAN OMF ENLARGED PLANS -LEVEL 1-J
	M08-SDX105	REFERENCE	STRUCTURAL HYDRAULIC STRUCTURE WINGWALLS TYPICAL CIP CANTILEVER WALL		M08-APP111	REFERENCE	ARCHITECTURAL FLOOR PLAN OMF ENLARGED PLANS -LEVEL 1-K
	OMFS-GZS101	REFERENCE	STRUCTURAL GENERAL STRUCTURAL NOTES		M08-APP112	REFERENCE	ARCHITECTURAL FLOOR PLAN OMF ENLARGED PLANS -LEVEL 1-L
	OMFS-GZS102	REFERENCE	STRUCTURAL SPECIAL INSPECTION REQUIREMENTS		M08-APP113	REFERENCE	ARCHITECTURAL FLOOR PLAN OMF ENLARGED PLANS -LEVEL 1-M
	OMFS-GZS103	REFERENCE	STRUCTURAL TYPICAL REINFORCING DETAILS		M08-APP114	REFERENCE	ARCHITECTURAL FLOOR PLAN OMF ENLARGED PLANS -LEVEL 1-N
	OMFS-GZS104	REFERENCE	STRUCTURAL TYPICAL SLAB AND JOINT DETAILS		M08-APP115	REFERENCE	ARCHITECTURAL FLOOR PLAN OMF ENLARGED PLANS -LEVEL 1-O, P
	OMFS-GZS105	REFERENCE	STRUCTURAL TYPICAL REINFORCING SPLICE DETAILS		M08-APP201	REFERENCE	ARCHITECTURAL FLOOR PLAN OMF OVERALL PLAN -LEVEL 2
	OMFS-GZS106	REFERENCE	STRUCTURAL TYPICAL CONCRETE PAD DETAILS		M08-APP202	REFERENCE	ARCHITECTURAL FLOOR PLAN OMF ENLARGED PLANS -LEVEL 2-A
	OMFS-GZS107	REFERENCE	STRUCTURAL TYPICAL STEEL AND ANCHOR DETIALS		M08-APP203	REFERENCE	ARCHITECTURAL FLOOR PLAN OMF ENLARGED PLANS -LEVEL 2-B
	OMFS-GZS108	REFERENCE	STRUCTURAL TYPICAL STEEL JOIST DETAILS		M08-APP204	REFERENCE	ARCHITECTURAL FLOOR PLAN OMF ENLARGED PLANS -LEVEL 2C
	OMFS-GZS109	REFERENCE	STRUCTURAL TYPICAL METAL DECK AND STAIR DETAILS		M08-APP205	REFERENCE	ARCHITECTURAL FLOOR PLAN OMF ENLARGED PLANS -LEVEL 2-H
	M08-SFP001	REFERENCE	STRUCTURAL OVERALL LOWER WORK PLATFORM PLAN		M08-APP206	REFERENCE	ARCHITECTURAL FLOOR PLAN OMF ENLARGED PLANS -LEVEL 2-I
	M08-SFP101	REFERENCE	STRUCTURAL OMF OVERALL PLAN - LEVEL 1		M08-APP206A	REFERENCE	ARCHITECTURAL FLOOR PLAN OMF ENLARGED PLANS LEVEL-2J
	M08-SFP102	REFERENCE	STRUCTURAL OMF ENLARGED PLANS - LEVEL 1		M08-APP207	REFERENCE	ARCHITECTURAL FLOOR PLAN OMF ENLARGED PLANS -LEVEL 2F -G
	M08-SFP103	REFERENCE	STRUCTURAL OMF ENLARGED PLANS - LEVEL 1		M08-ARP101	REFERENCE	ARCHITECTURAL ROOF PLAN OMF OVERALL ROOF PLAN
	M08-SFP104	REFERENCE	STRUCTURAL OMF ENLARGED PLANS - LEVEL 1		M08-AEE001	REFERENCE	ARCHITECTURAL ELEVATIONS OMF ELEVATIONS
	M08-SFP105	REFERENCE	STRUCTURAL OMF ENLARGED PLANS - LEVEL 1		M08-ASX001	REFERENCE	ARCHITECTURAL SECTIONS OMF SECTIONS
	M08-SFP106	REFERENCE	STRUCTURAL OMF ENLARGED PLANS - LEVEL 1		M08-ASX002	REFERENCE	ARCHITECTURAL SECTIONS OMF SECTIONS
	M08-SFP107	REFERENCE	STRUCTURAL OMF ENLARGED PLANS - LEVEL 1		M08-ASX003	REFERENCE	ARCHITECTURAL SECTIONS OMF SECTIONS
	M08-SFP108	REFERENCE	STRUCTURAL OMF ENLARGED PLANS - LEVEL 1		M08-ASX004	REFERENCE	ARCHITECTURAL SECTIONS OMF SECTIONS
	M08-SFP109	REFERENCE	STRUCTURAL OMF ENLARGED PLANS - LEVEL 1		M08-ASX005	REFERENCE	ARCHITECTURAL SECTIONS OMF SECTIONS
	M08-SFP110	REFERENCE	STRUCTURAL OMF ENLARGED PLANS - LEVEL 1		M08-AMP001	REFERENCE	ARCHITECTURAL MASSING VIEWS OMF MASSING VIEWS
	M08-SFP111	REFERENCE	STRUCTURAL OMF ENLARGED PLANS - LEVEL 1		M08W-AZN006	REFERENCE	ARCHITECTURAL LIFE SAFETY PLANS LRV WASH
	M08-SFP112	REFERENCE	STRUCTURAL OMF ENLARGED PLANS - LEVEL 1		M08W-APP001	REFERENCE	ARCHITECTURAL FLOOR PLAN LRV WASH -LOWER LEVEL
	M08-SFP113	REFERENCE	STRUCTURAL OMF ENLARGED PLANS - LEVEL 1		M08W-APP101	REFERENCE	ARCHITECTURAL FLOOR PLAN LRV WASH -LEVEL 1
	M08-SFP114	REFERENCE	STRUCTURAL OMF ENLARGED PLANS - LEVEL 1		M08W-APP201	REFERENCE	ARCHITECTURAL FLOOR PLAN LRV WASH -PLATFORM PLAN
	M08-SFP115	REFERENCE	STRUCTURAL OMF ENLARGED PLANS - LEVEL 1		M08W-AEE001	REFERENCE	ARCHITECTURAL ELEVATIONS LRV WASH ELEVATIONS
	M08-SFP116	REFERENCE	STRUCTURAL OMF ENLARGED PLANS - LEVEL 1		M08W-ASX001	REFERENCE	ARCHITECTURAL SECTIONS LRV WASH -SECTIONS
	M08-SFX101	REFERENCE	STRUCTURAL BUILDING SECTION		M08W-AMP001	REFERENCE	ARCHITECTURAL MASSING VIEWS LRV WASH MASSING VIEWS
	M08-SGP201	REFERENCE	STRUCTURAL OMF OVERALL PLAN - LEVEL 2		M09-AZN007	REFERENCE	ARCHITECTURAL LIFE SAFETY MOW BUILDING OCCUPANCY CLASSIFICATION SCHEDULE
	M08-SGP202	REFERENCE	STRUCTURAL LEVEL 2 - ENLARGED FLOOR PLAN 01		M09-AZN008	REFERENCE	ARCHITECTURAL LIFE SAFETY MOW BUILDING LIFE SAFETY PLAN -LEVEL 1
	M08-SGP203	REFERENCE	STRUCTURAL LEVEL 2 - ENLARGED FLOOR PLAN 01		M09-APP101	REFERENCE	ARCHITECTURAL FLOOR PLAN MOW BUILDING -LEVEL 1
	M08-SGP204	REFERENCE	STRUCTURAL LEVEL 2 - ENLARGED FLOOR PLAN 01		M09-ARP101	REFERENCE	ARCHITECTURAL ROOF PLAN MOW BUILDING -ROOF PLAN
	M08-SGP205	REFERENCE	STRUCTURAL LEVEL 2 - ENLARGED FLOOR PLAN 02		M09-AEE001	REFERENCE	ARCHITECTURAL ELEVATIONS MOW BUILDING ELEVATIONS
	M08-SGP206	REFERENCE	STRUCTURAL LEVEL 2 - ENLARGED FLOOR PLAN 02		M09-ASX001	REFERENCE	ARCHITECTURAL SECTIONS MOW BUILDING SECTIONS
	M08-SGP207	REFERENCE	STRUCTURAL LEVEL 2 - ENLARGED FLOOR PLAN 03		M09-AMP001	REFERENCE	ARCHITECTURAL MASSING VIEWS MOW BUILDING MASSING VIEWS
	M08-SGP301	REFERENCE	STRUCTURAL OMF OVERALL PLAN - ROOF FRAMING		M09W-AZN009	REFERENCE	ARCHITECTURAL LIFE SAFETY NRV LIFE SAFETY PLAN
	M08-SGP302	REFERENCE	STRUCTURAL ROOF - ENLARGED FLOOR PLAN 01		M09W-APP101	REFERENCE	ARCHITECTURAL FLOOR PLAN NRV WASH LEVEL 1
	M08-SGP303	REFERENCE	STRUCTURAL ROOF - ENLARGED FLOOR PLAN 02		M09W-AEE001	REFERENCE	ARCHITECTURAL ELEVATIONS NRV WASH ELEVATIONS
	M08-SGP304	REFERENCE	STRUCTURAL ROOF - ENLARGED FLOOR PLAN 03		M09W-ASX001	REFERENCE	ARCHITECTURAL SECTIONS NRV WASH SECTIONS
	M08-SGS001	REFERENCE	STRUCTURAL 3D AXONOMETRIC VIEWS		M09W-AMP001	REFERENCE	ARCHITECTURAL MASSING VIEWS NRV WASH VIEWS
	M08W-SGP101	REFERENCE	STRUCTURAL LRV WASH - WHEEL TRUING PIT		M10-AZN010	REFERENCE	ARCHITECTURAL LIFE SAFETY LINK SYSTEM WIDE STORAGE LIFE SAFETY PLAN
	M08W-SGP102	REFERENCE	STRUCTURAL LRV WASH - FIRST FINISH FLOOR		M10-APP101	REFERENCE	ARCHITECTURAL FLOOR PLAN LINK SYSTEM WIDE STORAGE LEVEL 1
	M08W-SGP103	REFERENCE	STRUCTURAL LRV WASH - MEZZANINE LEVEL		M10-APP201	REFERENCE	ARCHITECTURAL FLOOR PLAN LINK SYSTEM WIDE STORAGE MEZZANINE
	M08W-SGP104	REFERENCE	STRUCTURAL LRV WASH - ROOF LEVEL		M10-ARP101	REFERENCE	ARCHITECTURAL ROOF PLAN LINK SYSTEM WIDE STORAGE ROOF PLAN
	M08W-SGX101	REFERENCE	STRUCTURAL BUILDING SECTIONS		M10-AEE001	REFERENCE	ARCHITECTURAL ELEVATIONS LINK SYSTEM WIDE STORAGE ELEVATIONS
	M08W-SGS101	REFERENCE	STRUCTURAL LRV WASH - 3D AXONOMETRIC		M10-ASX001	REFERENCE	ARCHITECTURAL SECTIONS LINK SYSTEM WIDE STORAGE SECTIONS
	M09-SGP101	REFERENCE	STRUCTURAL FLOOR PLANS - LEVEL 1		M10-AMP001	REFERENCE	ARCHITECTURAL MASSING VIEWS LINK SYSTEM WIDE STORAGE MASSING VIEWS
	M09-SGP102	REFERENCE	STRUCTURAL FOOR PLANS - ROOF				
	M09-SGX101	REFERENCE	STRUCTURAL BUILDING SECTIONS				
	M09-SGS001	REFERENCE	STRUCTURAL 3D AXONOMETRIC				
	M10-SGP101	REFERENCE	STRUCTURAL FLOOR PLANS - LEVEL 1				
	M10-SGP102	REFERENCE	STRUCTURAL FLOOR PLANS - MEZZANINE				

Refer to the plan set COVER drawing
for disclaimers regarding this drawing.

AHJ:

REFERENCE CONCEPT DRAWINGS

DESIGNED BY:	C. FOX
DRAWN BY:	B. WILLIAMS
CHECKED BY:	P. LOPEZ-HILFIKER
APPROVED BY:	P. LOPEZ-HILFIKER



SUBMITTED BY:	DATE:	REVIEWED BY:	DATE:
PABLO LOPEZ-HILFIKER	2/27/2024		

LANDSCAPE

M08-LPS001	REFERENCE	LANDSCAPE SCHEDULE
M08-LPP101	REFERENCE	LANDSCAPE PLAN
M08-LPP102	REFERENCE	LANDSCAPE PLAN

NOT FOR
CONSTRUCTION

PACKAGE #

SCALE:	NTS
FILENAME:	OMFS-STD-GZ1103-111
CONTRACT No.:	AE-0030-17
DATE:	2/27/2024

SOUND TRANSIT
PRELIMINARY ENGINEERING PLANS
OPERATIONS & MAINTENANCE FACILITY SOUTH

GENERAL
INDEX OF DRAWINGS

DRAWING No.:	STD-GZ1108
FACILITY ID:	STD
SHEET No.:	REV:
	3

02/2024 | 9:45 AM | ASCHEPPE
C:\PWORKING\WEST01\2780545\OMFS-STD-GZ1103-111.DWG

INDEX OF DRAWINGS

SHEET NO.	DWG. NO.	PERSC/REF	TITLE	SHEET NO.	DWG. NO.	PERSC/REF	TITLE
LANDSCAPE CONTINUED				MECHANICAL CONTINUED			
	M08-LPP103	REFERENCE	LANDSCAPE PLAN		M08-MHS010	REFERENCE	MECHANICAL OMF HVAC SCHEDULES
	M08-LPP104	REFERENCE	LANDSCAPE PLAN		M08-MPP001	REFERENCE	MECHANICAL OMF PLUMBING FOUNDATION PLAN - OVERALL
	M08-LPP105	REFERENCE	LANDSCAPE PLAN		M08-MPP101	REFERENCE	MECHANICAL OMF PLUMBING OVERALL LEVEL 1 PLAN
	M08-LPP106	REFERENCE	LANDSCAPE PLAN		M08-MPP102	REFERENCE	MECHANICAL OMF PLUMBING LEVEL 1 FLOOR PLAN AREA A
	M08-LPP107	REFERENCE	LANDSCAPE PLAN		M08-MPP103	REFERENCE	MECHANICAL OMF PLUMBING LEVEL 1 FLOOR PLAN AREA B
	M08-LPP108	REFERENCE	LANDSCAPE PLAN		M08-MPP104	REFERENCE	MECHANICAL OMF PLUMBING LEVEL 1 PARTIAL PLANS
	M08-LPP109	REFERENCE	LANDSCAPE PLAN		M08-MPP201	REFERENCE	MECHANICAL OMF PLUMBING OVERALL LEVEL 2 PLAN
	M08-LPP110	REFERENCE	LANDSCAPE PLAN		M08-MPP202	REFERENCE	MECHANICAL OMF PLUMBING LEVEL 2 FLOOR PLAN AREA A
	M08-LPP111	REFERENCE	LANDSCAPE PLAN		M08-MPP203	REFERENCE	MECHANICAL OMF PLUMBING LEVEL 2 FLOOR PLAN AREA B
	M08-LPP112	REFERENCE	LANDSCAPE PLAN		M08-MPP204	REFERENCE	MECHANICAL OMF PLUMBING LEVEL 2 PARTIAL PLANS
	M08-LPP113	REFERENCE	LANDSCAPE PLAN		M08-MPP301	REFERENCE	MECHANICAL OMF PLUMBING ROOF PLAN - OVERALL
	M08-LPP114	REFERENCE	LANDSCAPE PLAN		M08-MPS001	REFERENCE	MECHANICAL PLUMBING PIPING DIAGRAMS
	M08-LPP115	REFERENCE	LANDSCAPE PLAN		M08-MPS002	REFERENCE	MECHANICAL PLUMBING DETAILS
	M08-LPP116	REFERENCE	LANDSCAPE PLAN		M08-MPS003	REFERENCE	MECHANICAL PLUMBING EQUIPMENT SCHEDULES
	M08-LPP117	REFERENCE	LANDSCAPE PLAN		M08W-MFP101	REFERENCE	MECHANICAL LRV WASH FIRE PROTECTION FLOOR PLAN
	M08-LPP118	REFERENCE	LANDSCAPE PLAN		M08W-MHP101	REFERENCE	MECHANICAL LRV WASH HVAC FLOOR PLAN
	M08-LPP119	REFERENCE	LANDSCAPE PLAN		M08W-MHP201	REFERENCE	MECHANICAL LRV WASH HVAC ROOF PLAN
	M08-LPP121	REFERENCE	LANDSCAPE PLAN		M08W-MHS001	REFERENCE	MECHANICAL LRV WASH HVAC BMS CONCEPT OF OPERATIONS
	M08-LPP122	REFERENCE	LANDSCAPE PLAN		M08W-MHS002	REFERENCE	MECHANICAL LRV WASH HVAC BMS CONTROL SCHEMATICS
	M08-LPP123	REFERENCE	LANDSCAPE PLAN		M08W-MHS003	REFERENCE	MECHANICAL LRV WASH HVAC EQUIPMENT SCHEDULES
	M08-LPP125	REFERENCE	LANDSCAPE PLAN		M08W-MPP001	REFERENCE	MECHANICAL LRV WASH PLUMBING FOUNDATION PLAN
	M08-LPP126	REFERENCE	LANDSCAPE PLAN		M08W-MPP101	REFERENCE	MECHANICAL LRV WASH PLUMBING FLOOR PLAN
	M08-LPP127	REFERENCE	LANDSCAPE PLAN		M08W-MPP201	REFERENCE	MECHANICAL LRV WASH PLUMBING ROOF PLAN
	M08-LPP128	REFERENCE	LANDSCAPE PLAN		M08W-MPS001	REFERENCE	MECHANICAL LRV WASH PLUMBING WASH WATER DIAGRAM
MECHANICAL					M08W-MPS002	REFERENCE	MECHANICAL LRV WASH PLUMBING DETAILS
	M08-MZN001	REFERENCE	MECHANICAL LEGENDS AND ABBREVIATIONS GENERAL		M08W-MPS003	REFERENCE	MECHANICAL LRV WASH PLUMBING EQUIPMENT SCHEDULES
	M08-MZP101	REFERENCE	MECHANICAL MECHANICAL LEVEL 1 FLOOR PLAN - OVERALL		M09-MFP101	REFERENCE	MECHANICAL MOW FIRE PROTECTION FLOOR PLAN
	M08-MFP101	REFERENCE	MECHANICAL FIRE PROTECTION LEVEL 1 FLOOR PLAN - AREA A		M09-MHP101	REFERENCE	MECHANICAL MOW HVAC IN-FLOOR HEATING ZONE PLAN
	M08-MFP102	REFERENCE	MECHANICAL FIRE PROTECTION LEVEL 1 FLOOR PLAN - AREA B		M09-MHP102	REFERENCE	MECHANICAL MOW HVAC DOAS ZONE PLAN
	M08-MFP103	REFERENCE	MECHANICAL FIRE PROTECTION LEVEL 1 FLOOR PLAN - AREA C		M09-MHP103	REFERENCE	MECHANICAL MOW HVAC FLOOR PLAN
	M08-MFP104	REFERENCE	MECHANICAL FIRE PROTECTION LEVEL 1 FLOOR PLAN - AREA D		M09-MHP104	REFERENCE	MECHANICAL MOW MECHANICAL ROOM PLAN
	M08-MFP105	REFERENCE	MECHANICAL FIRE PROTECTION LEVEL 1 FLOOR PLAN - AREA E		M09-MHP201	REFERENCE	MECHANICAL MOW HVAC ROOF PLAN
	M08-MFP106	REFERENCE	MECHANICAL FIRE PROTECTION LEVEL 1 FLOOR PLAN - AREA F & G		M09-MHS001	REFERENCE	MECHANICAL MOW HVAC COOLING AND HEATING PLANT SCHEMATIC
	M08-MFP201	REFERENCE	MECHANICAL FIRE PROTECTION LEVEL 2 FLOOR PLAN - AREA A		M09-MHS002	REFERENCE	MECHANICAL MOW HVAC BMS CONCEPT OF OPERATIONS
	M08-MFP202	REFERENCE	MECHANICAL FIRE PROTECTION LEVEL 2 FLOOR PLAN - AREA B		M09-MHS003	REFERENCE	MECHANICAL MOW HVAC BMS CONTROL SCHEMATICS
	M08-MFP203	REFERENCE	MECHANICAL FIRE PROTECTION LEVEL 2 FLOOR PLAN - AREA C		M09-MHS004	REFERENCE	MECHANICAL MOW HVAC EQUIPMENT SCHEDULES
	M08-MFP204	REFERENCE	MECHANICAL FIRE PROTECTION LEVEL 2 FLOOR PLAN - AREA D		M09-MPP001	REFERENCE	MECHANICAL MOW PLUMBING FOUNDATION PLAN
	M08-MFP205	REFERENCE	MECHANICAL FIRE PROTECTION LEVEL 2 FLOOR PLAN - AREA E		M09-MPP101	REFERENCE	MECHANICAL MOW PLUMBING FLOOR PLAN
	M08-MFP206	REFERENCE	MECHANICAL FIRE PROTECTION LEVEL 2 FLOOR PLAN - AREA F & G		M09-MPP102	REFERENCE	MECHANICAL MOW PLUMBING PARTIAL PLANS
	M08-MHP001	REFERENCE	MECHANICAL HVAC LOWER LEVEL IN-FLOOR HEATING ZONES		M09-MPP201	REFERENCE	MECHANICAL MOW PLUMBING ROOF PLAN
	M08-MHP002	REFERENCE	MECHANICAL HVAC LOWER LEVEL FLOOR PLAN - AREA C		M09-MPS001	REFERENCE	MECHANICAL MOW PLUMBING PIPING DIAGRAMS
	M08-MHP003	REFERENCE	MECHANICAL HVAC LOWER LEVEL FLOOR PLAN - AREA D		M09-MPS002	REFERENCE	MECHANICAL MOW PLUMBING DETAILS
	M08-MHP004	REFERENCE	MECHANICAL HVAC LOWER LEVEL FLOOR PLAN - AREA E		M09-MPS003	REFERENCE	MECHANICAL MOW PLUMBING EQUIPMENT SCHEDULES
	M08-MHP101	REFERENCE	MECHANICAL HVAC LEVEL 1 IN-FLOOR HEATING ZONES		M09W-MFP101	REFERENCE	MECHANICAL NRV FIRE PROTECTION FLOOR PLAN
	M08-MHP102	REFERENCE	MECHANICAL HVAC LEVEL 1 DOAS ZONES		M09W-MHP101	REFERENCE	MECHANICAL NRV HVAC FLOOR PLAN
	M08-MHP103	REFERENCE	MECHANICAL HVAC LEVEL 1 FLOOR PLAN - AREA A		M09W-MHP201	REFERENCE	MECHANICAL NRV HVAC ROOF PLAN
	M08-MHP104	REFERENCE	MECHANICAL HVAC LEVEL 1 FLOOR PLAN - AREA B		M09W-MHS001	REFERENCE	MECHANICAL NRV HVAC BMS CONCEPT OF OPERATIONS AND BMS CONTROL SCHEMATICS
	M08-MHP105	REFERENCE	MECHANICAL HVAC LEVEL 1 FLOOR PLAN - AREA C		M09W-MHS002	REFERENCE	MECHANICAL NRV HVAC EQUIPMENT SCHEDULES
	M08-MHP106	REFERENCE	MECHANICAL HVAC LEVEL 1 FLOOR PLAN - AREA D		M09W-MPP001	REFERENCE	MECHANICAL NRV PLUMBING FOUNDATION PLAN
	M08-MHP107	REFERENCE	MECHANICAL HVAC LEVEL 1 FLOOR PLAN - AREA E		M09W-MPP101	REFERENCE	MECHANICAL NRV PLUMBING FLOOR PLAN
	M08-MHP108	REFERENCE	MECHANICAL HVAC LEVEL 1 FLOOR PLAN - AREA F & G		M09W-MPP201	REFERENCE	MECHANICAL NRV PLUMBING ROOF PLAN
	M08-MHP201	REFERENCE	MECHANICAL HVAC LEVEL 2 DOAS ZONES		M09W-MPS001	REFERENCE	MECHANICAL NRV PLUMBING DETAILS
	M08-MHP202	REFERENCE	MECHANICAL HVAC LEVEL 2 FLOOR PLAN - AREA A		M09W-MPS002	REFERENCE	MECHANICAL NRV PLUMBING EQUIPMENT SCHEDULES
	M08-MHP203	REFERENCE	MECHANICAL HVAC LEVEL 2 FLOOR PLAN - AREA B		M10-MFP101	REFERENCE	MECHANICAL LSWS FIRE PROTECTION FLOOR PLAN
	M08-MHP204	REFERENCE	MECHANICAL HVAC LEVEL 2 FLOOR PLAN - AREA C		M10-MFP201	REFERENCE	MECHANICAL LSWS FIRE PROTECTION MEZZANINE PLAN
	M08-MHP205	REFERENCE	MECHANICAL HVAC LEVEL 2 FLOOR PLAN - AREA D		M10-MHP101	REFERENCE	MECHANICAL LSWS HVAC IN-FLOOR HEATING ZONE PLAN
	M08-MHP206	REFERENCE	MECHANICAL HVAC LEVEL 2 FLOOR PLAN - AREA E		M10-MHP102	REFERENCE	MECHANICAL LSWS HVAC DOAS ZONE PLAN
	M08-MHP207	REFERENCE	MECHANICAL HVAC LEVEL 2 FLOOR PLAN - AREA F & G		M10-MHP103	REFERENCE	MECHANICAL LSWS HVAC FLOOR PLAN
	M08-MHP208	REFERENCE	MECHANICAL HVAC LEVEL 2 MECHANICAL ROOM PLAN - AREA B		M10-MHP201	REFERENCE	MECHANICAL LSWS HVAC MEZZANINE PLAN
	M08-MHP301	REFERENCE	MECHANICAL HVAC ROOF PLAN - AREA A		M10-MHP202	REFERENCE	MECHANICAL LSWS HVAC MECHANICAL ROOM PLAN
	M08-MHP302	REFERENCE	MECHANICAL HVAC ROOF PLAN - AREA B		M10-MHP301	REFERENCE	MECHANICAL LSWS HVAC ROOF PLAN
	M08-MHP303	REFERENCE	MECHANICAL HVAC ROOF PLAN - AREA C		M10-MHS001	REFERENCE	MECHANICAL LSWS HVAC COOLING AND HEATING PLANT SCHEMATIC
	M08-MHP304	REFERENCE	MECHANICAL HVAC ROOF PLAN - AREA D		M10-MHS002	REFERENCE	MECHANICAL LSWS HVAC BMS CONCEPT OF OPERATIONS
	M08-MHP305	REFERENCE	MECHANICAL HVAC ROOF PLAN - AREA E		M10-MHS003	REFERENCE	MECHANICAL HVAC BMS CONTROL SCHEMATICS
	M08-MHP306	REFERENCE	MECHANICAL HVAC ROOF PLAN - AREA F & G		M10-MHS004	REFERENCE	MECHANICAL LSWS HVAC EQUIPMENT SCHEDULES
	M08-MHS001	REFERENCE	MECHANICAL HVAC COOLING AND HEATING PLANT SCHEMATIC		M10-MPP001	REFERENCE	MECHANICAL LSWS PLUMBING FOUNDATION PLAN
	M08-MHS002	REFERENCE	MECHANICAL HVAC BMS CONTROL SCHEMATICS		M10-MPP101	REFERENCE	MECHANICAL LSWS PLUMBING FLOOR PLAN
	M08-MHS003	REFERENCE	MECHANICAL HVAC BMS CONTROL SCHEMATICS		M10-MPP102	REFERENCE	MECHANICAL LSWS PLUMBING PARTIAL FLOOR PLANS
	M08-MHS004	REFERENCE	MECHANICAL HVAC BMS CONTROL SCHEMATICS		M10-MPP201	REFERENCE	MECHANICAL LSWS PLUMBING MEZZANINE PLAN
	M08-MHS005	REFERENCE	MECHANICAL HVAC BMS CONTROL SCHEMATIC		M10-MPP301	REFERENCE	MECHANICAL LSWS PLUMBING ROOF PLAN
	M08-MHS006	REFERENCE	MECHANICAL HVAC BMS CONCEPT OF OPERATIONS		M10-MPS001	REFERENCE	MECHANICAL LSWS PLUMBING PIPING DIAGRAMS
	M08-MHS007	REFERENCE	MECHANICAL OMF HVAC DETAILS		M10-MPS002	REFERENCE	MECHANICAL LSWS PLUMBING EQUIPMENT SCHEDULES
	M08-MHS008	REFERENCE	MECHANICAL OMF HVAC DETAILS	ELECTRICAL			
	M08-MHS009	REFERENCE	MECHANICAL OMFHVAC DETAILS				
Refer to the plan set COVER drawing for disclaimers regarding this drawing.					M08-ESN001	REFERENCE	ELECTRICAL ELECTRICAL LEGEND

NOT FOR
CONSTRUCTION

Refer to the plan set COVER drawing for disclaimers regarding this drawing.										AHJ:										PACKAGE #																																	
REFERENCE CONCEPT DRAWINGS <table><tr><td></td><td></td><td></td><td></td><td></td><td></td></tr><tr><td></td><td></td><td></td><td></td><td></td><td></td></tr><tr><td></td><td></td><td></td><td></td><td></td><td></td></tr><tr><td></td><td></td><td></td><td></td><td></td><td></td></tr><tr><td>No.</td><td>DATE</td><td>DSN</td><td>CHK</td><td>APP</td><td>REVISION</td></tr></table>																																		No.	DATE	DSN	CHK	APP	REVISION	DESIGNED BY: C. FOX		PAULO LOPEZ-HILFIKER STATE OF WASHINGTON 2019 REGISTERED PROFESSIONAL ENGINEER PRELIMINARY HSR SUBMITTED BY: PABLO LOPEZ-HILFIKER LINE IS 1" AT FULL SCALE ST SOUNDTRANSIT DATE: 2/27/2024 REVIEWED BY: DATE:										DRAWING No.: STD-GZI109	
No.	DATE	DSN	CHK	APP	REVISION																																																
DRAWN BY: B. WILLIAMS		FACILITY ID: STD																																																			
CHECKED BY:		SHEET No.: 4																																																			
P. LOPEZ-HILFIKER		REV:																																																			
APPROVED BY: P. LOPEZ-HILFIKER																																																					

02/29/24 | 9:45 AM | ASCHEPPE
C:\PWORKING\WEST01\02780545\OMFS-STD-GZI103-111.DWG

INDEX OF DRAWINGS							
SHEET NO.	DWG. NO.	PERSC/REF	TITLE	SHEET NO.	DWG. NO.	PERSC/REF	TITLE
INDUSTRIAL CONTINUED							
	M09W-QZP001	REFERENCE	EQUIPMENT NRV WASH EQUIPMENT SCHEDULE				
	M09W-QPP102	REFERENCE	EQUIPMENT NRV WASH LEVEL 1 LAYOUT PLAN				
	M10-QZP001	REFERENCE	EQUIPMENT LSWS EQUIPMENT SCHEDULE				
	M10-QPP101	REFERENCE	EQUIPMENT LSWS OVERALL LEVEL 1 LAYOUT PLAN				
	M10-QPP102	REFERENCE	EQUIPMENT LSWS LEVEL 1A LAYOUT PLAN				
	M10-QPP103	REFERENCE	EQUIPMENT LSWS LEVEL 1C LAYOUT PLAN				
	M10-QPP201	REFERENCE	EQUIPMENT LSWS OVERALL LEVEL 2 LAYOUT PLAN				
	M10-QPP202	REFERENCE	EQUIPMENT LSWS LEVEL 2A LAYOUT PLAN				
	M10-QPP203	REFERENCE	EQUIPMENT LSWSL LEVEL 2B LAYOUT PLAN				
	M10-QPP204	REFERENCE	EQUIPMENT LSWSL LEVEL 2D LAYOUT PLAN				
	M10-QPP205	REFERENCE	EQUIPMENT LSWSL BRIDGE CRANE COVERAGE				

NOT FOR
CONSTRUCTION

Refer to the plan set COVER drawing
for disclaimers regarding this drawing.

for disclaimers regarding this drawing.						AHJ:				PACKAGE #							
REFERENCE CONCEPT DRAWINGS						DESIGNED BY: C. FOX				LINE IS 1" AT FULL SCALE		SCALE: NTS		SOUND TRANSIT PRELIMINARY ENGINEERING PLANS OPERATIONS & MAINTENANCE FACILITY SOUTH GENERAL INDEX OF DRAWINGS		DRAWING No.: STD-GZI111	
						DRAWN BY: B. WILLIAMS						FILENAME: OMFS-STD-GZI103-111				FACILITY ID: STD	
						CHECKED BY: P. LOPEZ-HILFIKER						CONTRACT No.: AE-0030-17				SHEET No.: REV:	
						APPROVED BY:						DATE:				6	
						P. LOPEZ-HILFIKER						2/27/2024					
No.	DATE	DSN	CHK	APP	REVISION	SUBMITTED BY: PABLO LOPEZ-HILFIKER		DATE: 2/27/2024		REVIEWED BY:		DATE: 2/27/2024					