



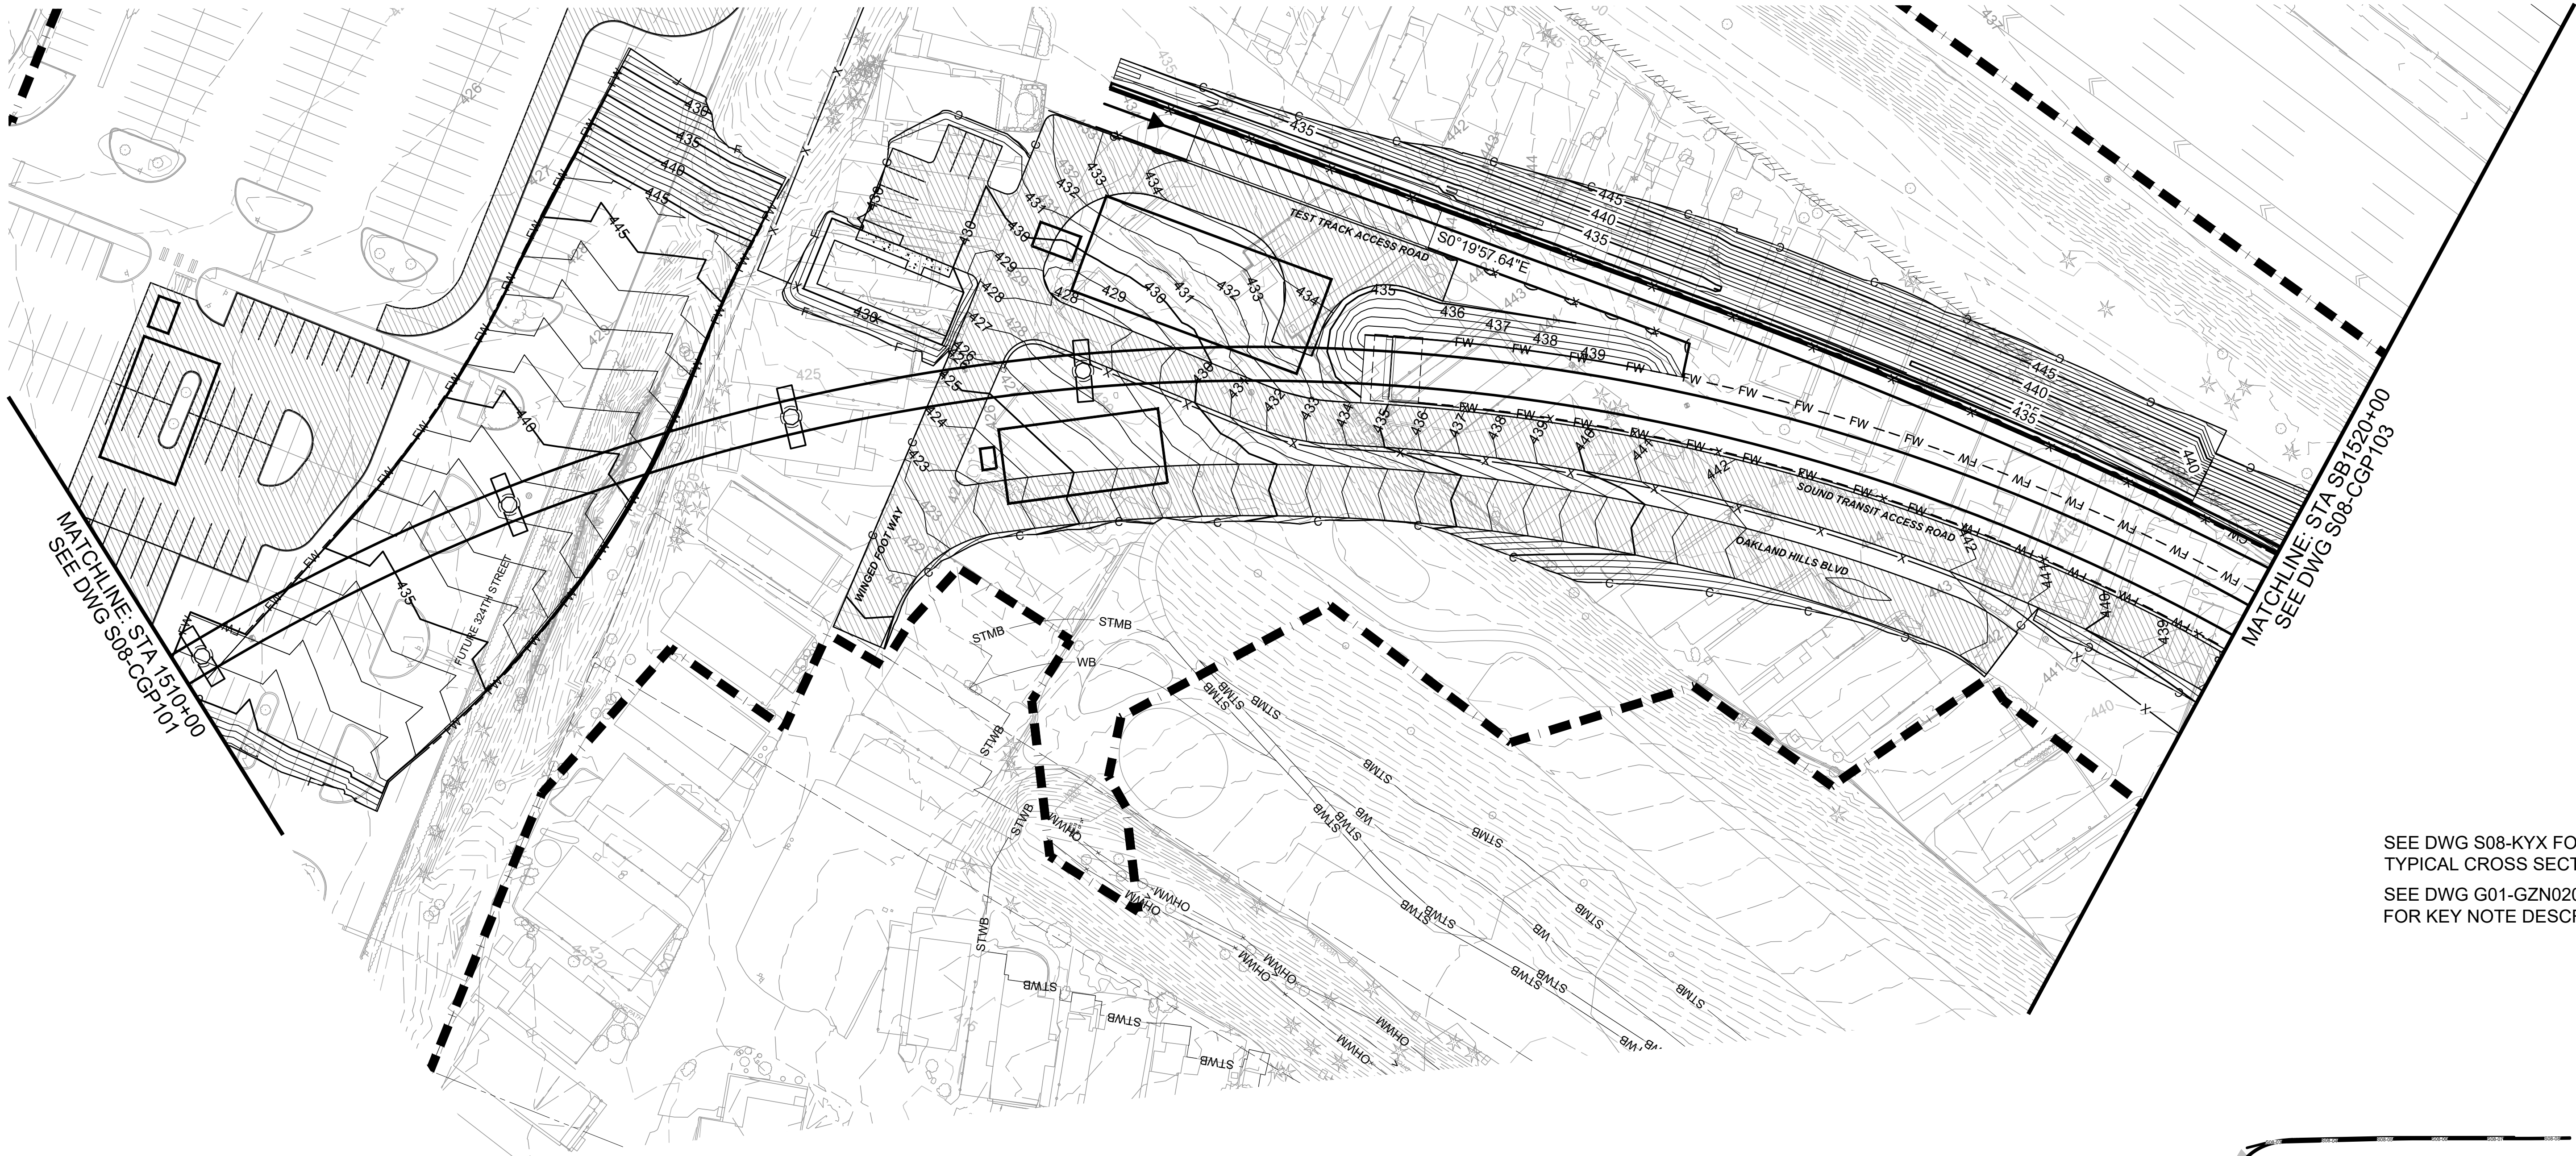

SEE DWG S08-KYX FOR
TYPICAL CROSS SECTIONS
SEE DWG G01-GZN020
FOR KEY NOTE DESCRIPTIONS

LEGEND:

- MAJOR / MINOR CONTOUR (PROPOSED)
- MAJOR / MINOR CONTOUR (EXISTING)
- TEMPORARY CONSTRUCTION IMPACT AREA

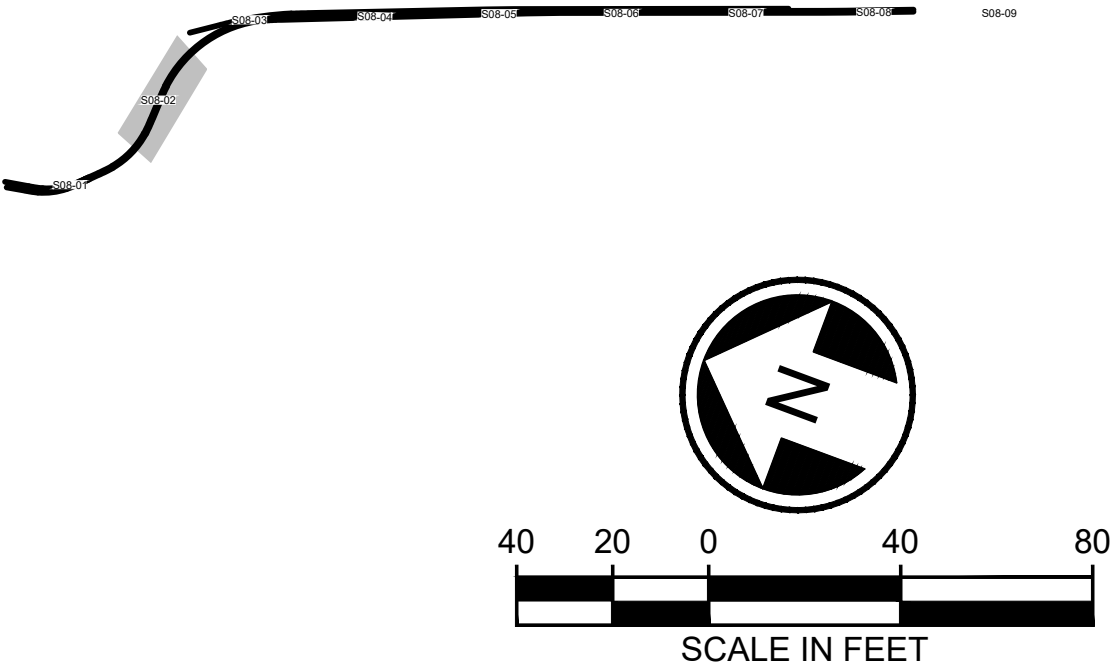

NOT FOR
CONSTRUCTION


Refer to the plan set COVER drawing
for disclaimers regarding this drawing.

for disclaimers regarding this drawing.

REFERENCE CONCEPT DRAWINGS						AHJ:		PACKAGE #				DRAWING No.:																									
<table><tr><td>No.</td><td>DATE</td><td>DSN</td><td>CHK</td><td>APP</td><td>REVISION</td></tr><tr><td> </td><td> </td><td> </td><td> </td><td> </td><td> </td></tr><tr><td> </td><td> </td><td> </td><td> </td><td> </td><td> </td></tr><tr><td> </td><td> </td><td> </td><td> </td><td> </td><td> </td></tr></table>						No.	DATE	DSN	CHK	APP	REVISION																			DESIGNED BY: K. McDONALD			LINE IS 1" AT FULL SCALE		SCALE: 1"=40'	SOUND TRANSIT PRELIMINARY ENGINEERING PLANS OPERATIONS & MAINTENANCE FACILITY SOUTH CIVIL GRADING STA SB1510+00 TO STA SB1520+00	S08-CGP102
						No.	DATE	DSN	CHK	APP	REVISION																										
DRAWN BY: J. LUM	FILENAME: OMFS-S08-CGP101-108	FACILITY ID: S08																																			
CHECKED BY: P. LOPEZ-HILFIKER	CONTRACT No.: AE-0030-17	SHEET No.: REV:																																			
APPROVED BY: P. LOPEZ-HILFIKER	DATE: 2/27/2024	DATE: 2/27/2024	0																																		

02/23/24 | 4:56 PM | KIMCDONALD
C:\P\WORKING\WEST01\D2780550\OMFS-S08-CGP101-108.DWG


MATCHLINE: STA 1530+00
SEE DWG S08-CGP103

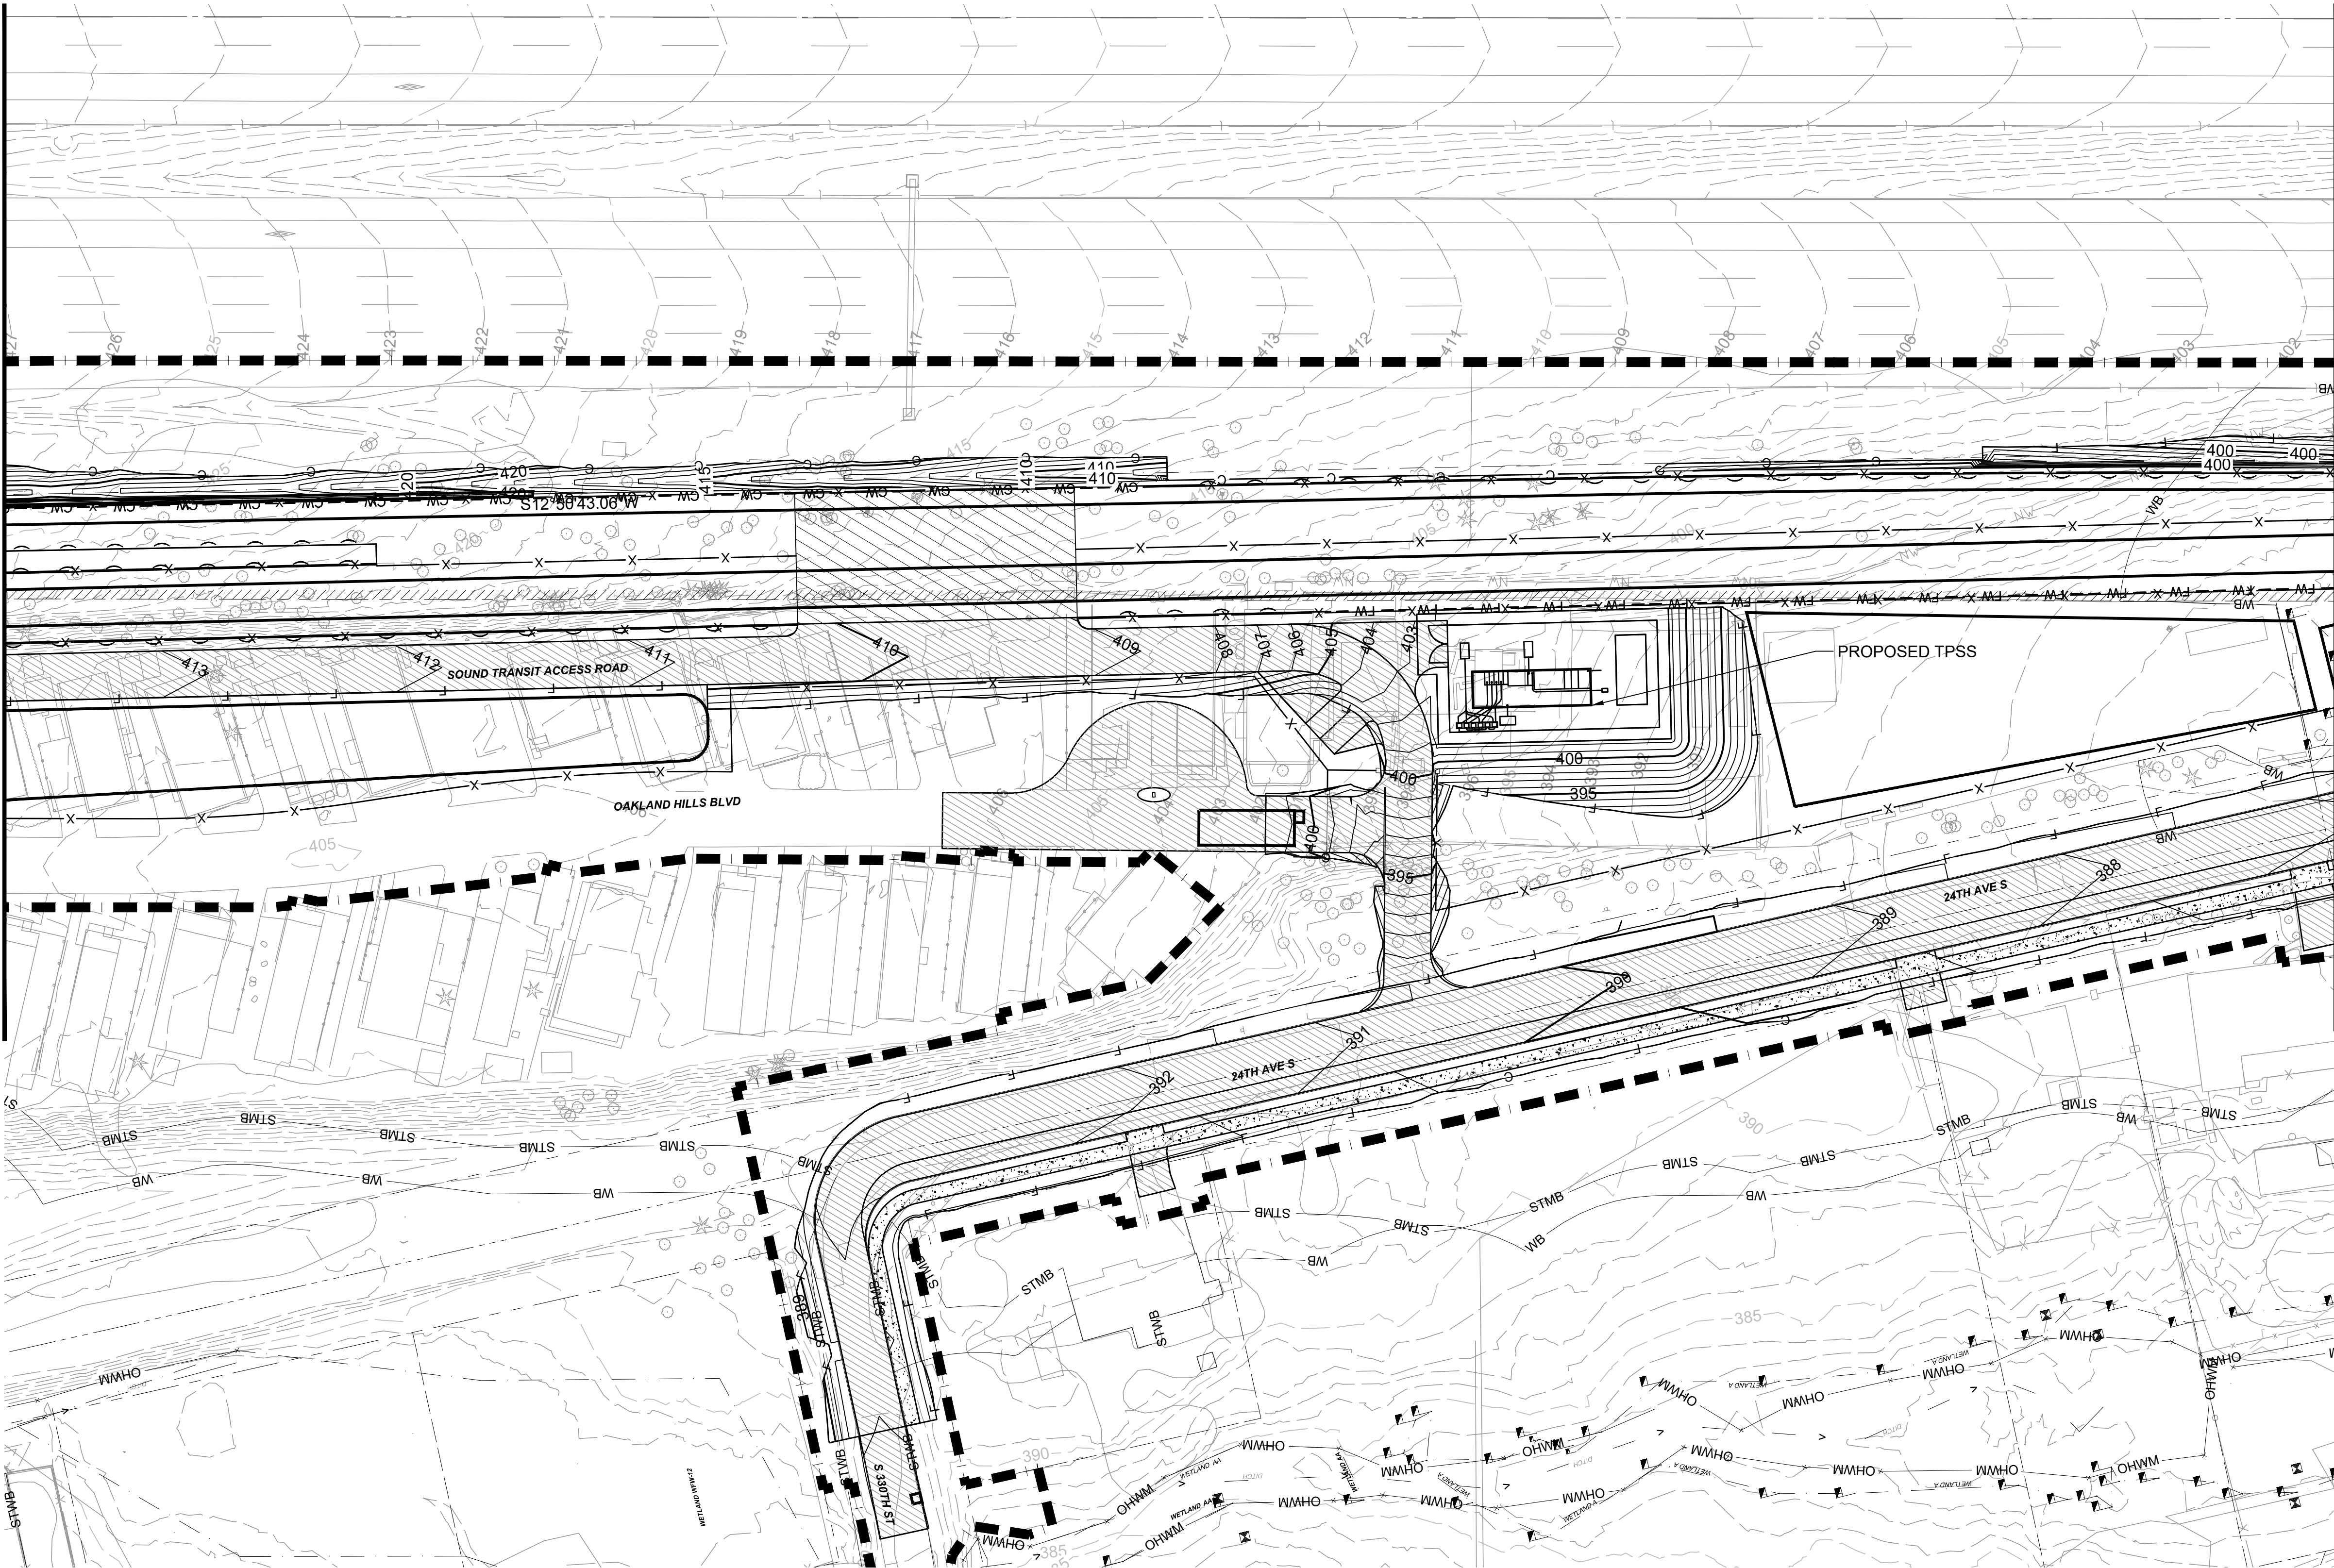

- LEGEND:**
- MAJOR / MINOR CONTOUR (PROPOSED)
 - MAJOR / MINOR CONTOUR (EXISTING)
 - TEMPORARY CONSTRUCTION IMPACT AREA

MATCHLINE: STA 1540+00
SEE DWG S08-CGP105

SEE DWG S08-KYX FOR
TYPICAL CROSS SECTIONS
SEE DWG G01-GZN020
FOR KEY NOTE DESCRIPTIONS

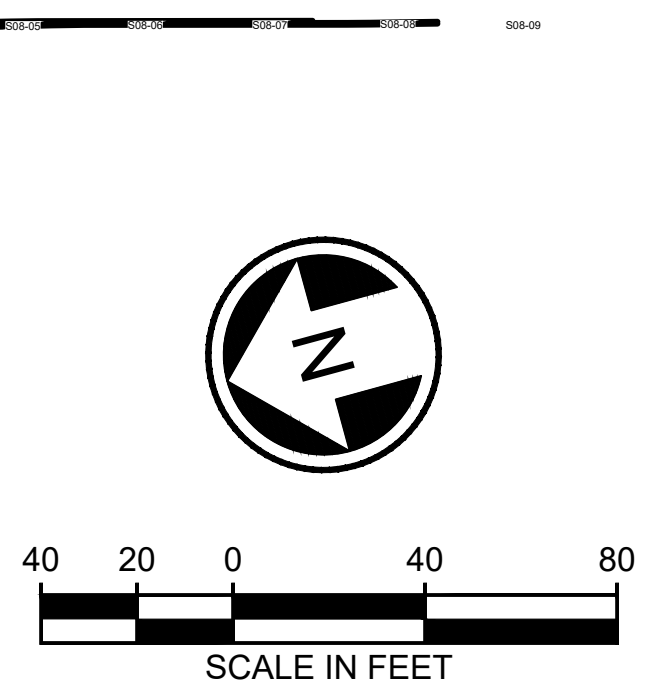


**NOT FOR
CONSTRUCTION**

Refer to the plan set COVER drawing
for disclaimers regarding this drawing.

REFERENCE CONCEPT DRAWINGS

No.	DATE	DSN	CHK	APP	REVISION

DESIGNED BY:
K. McDONALD
DRAWN BY:
J. LUM
CHECKED BY:
P. LOPEZ-HILFIKER
APPROVED BY:
P. LOPEZ-HILFIKER

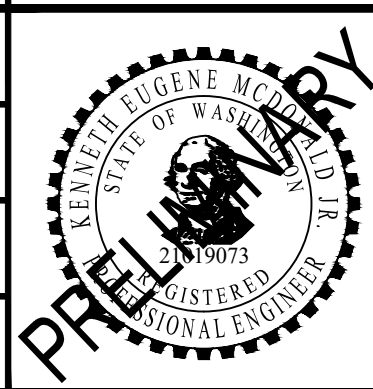

HR
SUBMITTED BY:
PABLO LOPEZ-HILFIKER
DATE:
2/27/2024
REVIEWED BY:

DATE:
2/27/2024

REVIEWED BY:

LINE IS 1" AT
FULL SCALE
SOUNDTRANSIT
DATE:
2/27/2024

PACKAGE


SCALE:
1"=40'
FILENAME:
OMFS-S08-CGP101-108
CONTRACT No.:
AE-0030-17
DATE:
2/27/2024

**SOUND TRANSIT
PRELIMINARY ENGINEERING PLANS
OPERATIONS & MAINTENANCE FACILITY SOUTH**

CIVIL
GRADING
STA SB1530+00 TO STA SB1540+00

DRAWING No.:
S08-CGP104
FACILITY ID:
S08
SHEET No.:
REV:
0


02/23/24 | 4:59 PM | KIMCDONALD
C:\P\WORKING\WEST01\D2780550\OMFS-S08-CGP101-108.DWG

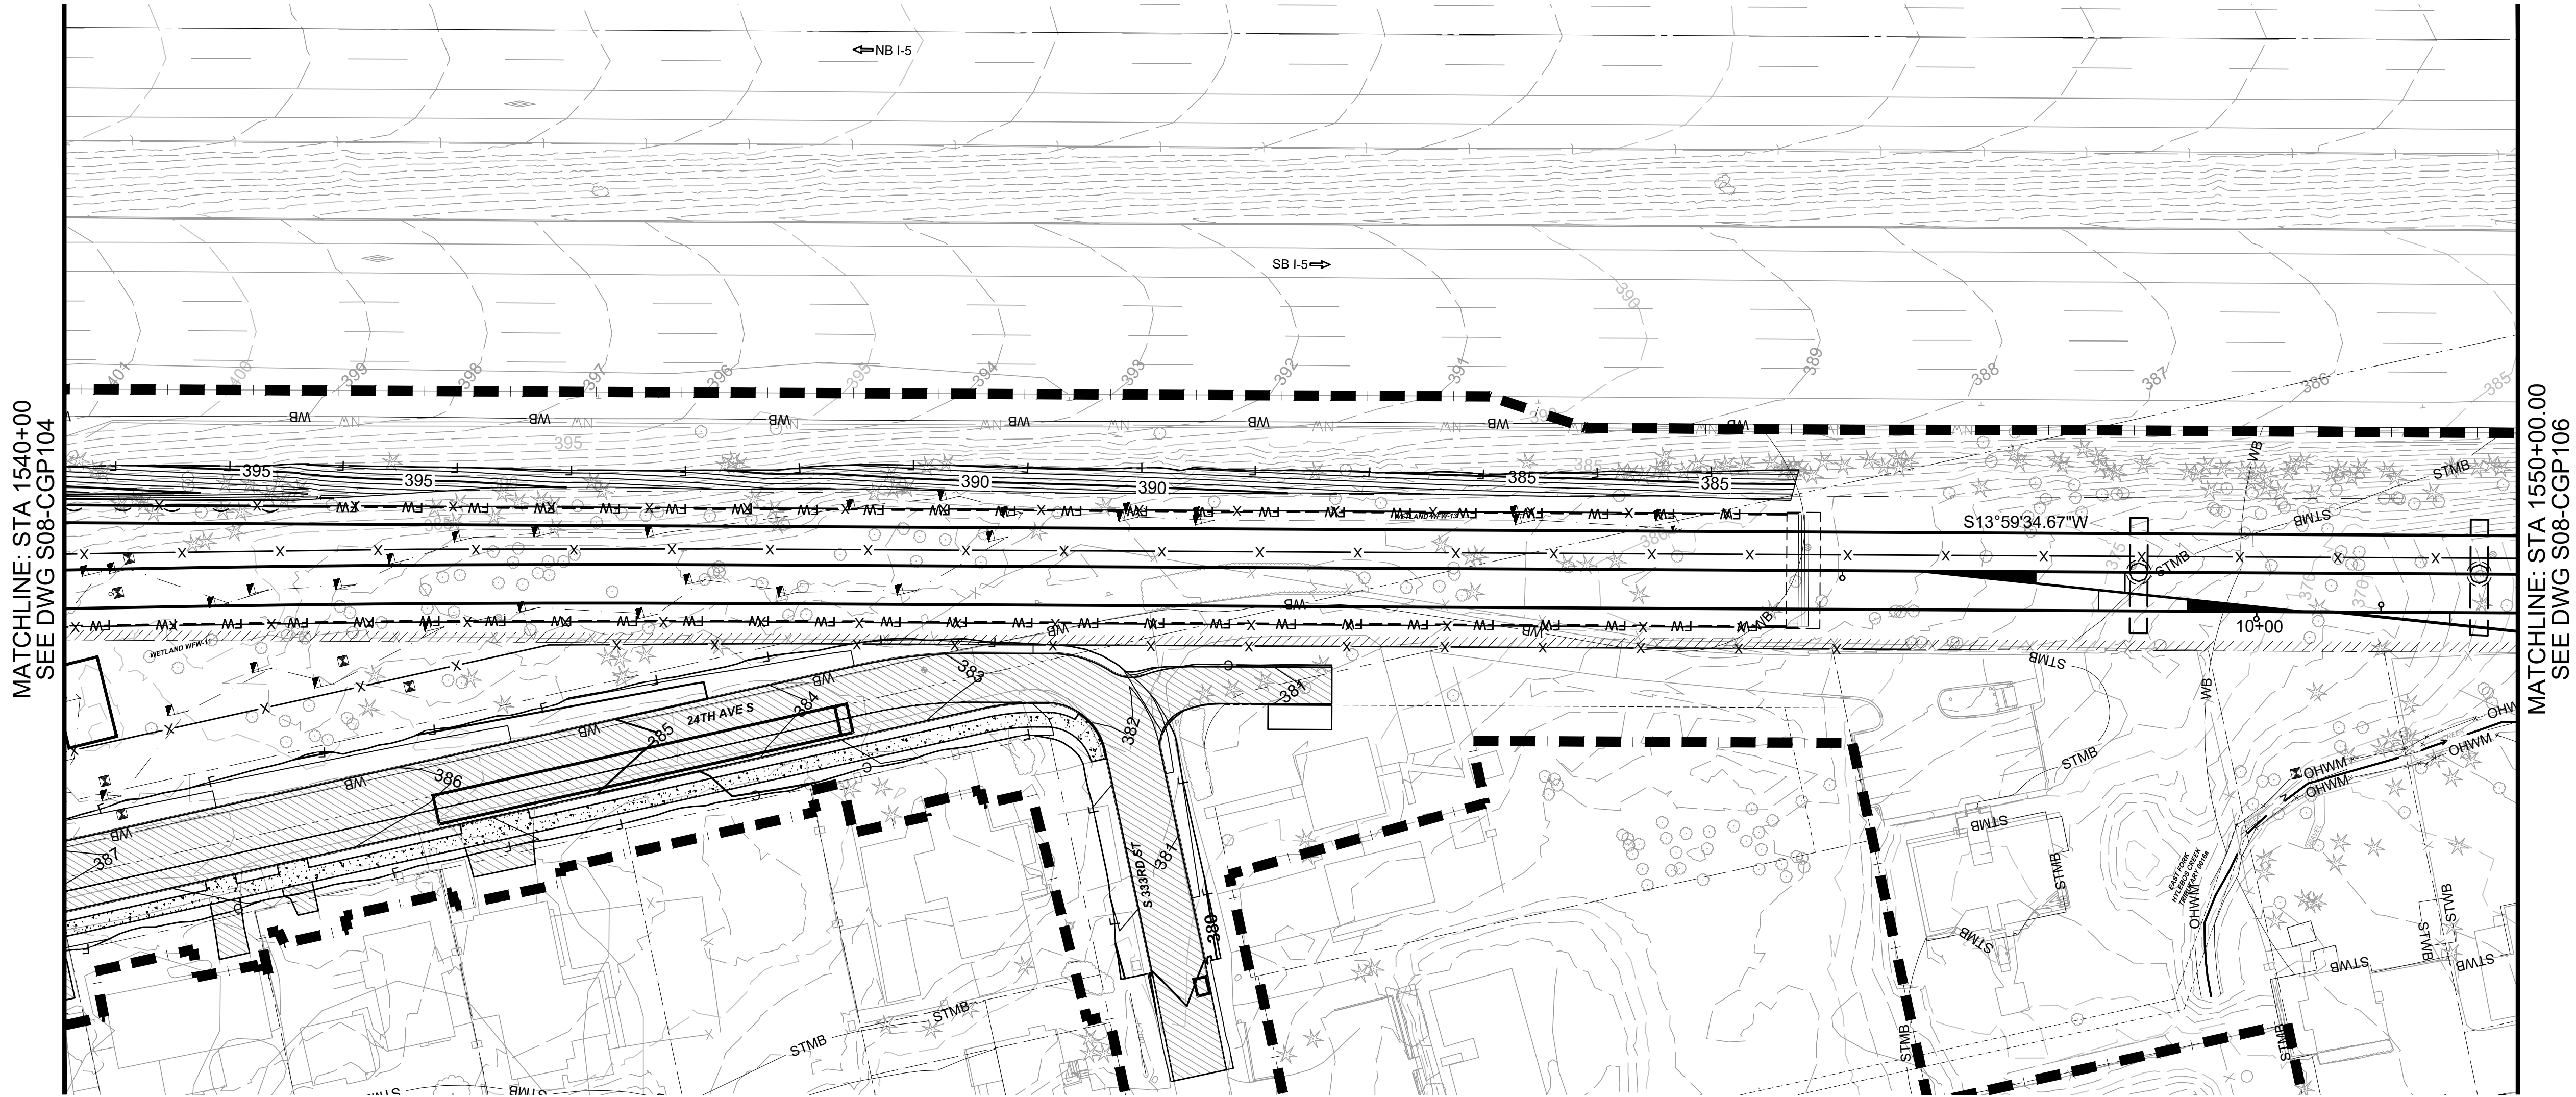

LEGEND:

- MAJOR / MINOR CONTOUR (PROPOSED)
- MAJOR / MINOR CONTOUR (EXISTING)
- TEMPORARY CONSTRUCTION IMPACT AREA

SEE DWG S08-KYX FOR
TYPICAL CROSS SECTIONS
SEE DWG G01-GZN020
FOR KEY NOTE DESCRIPTIONS

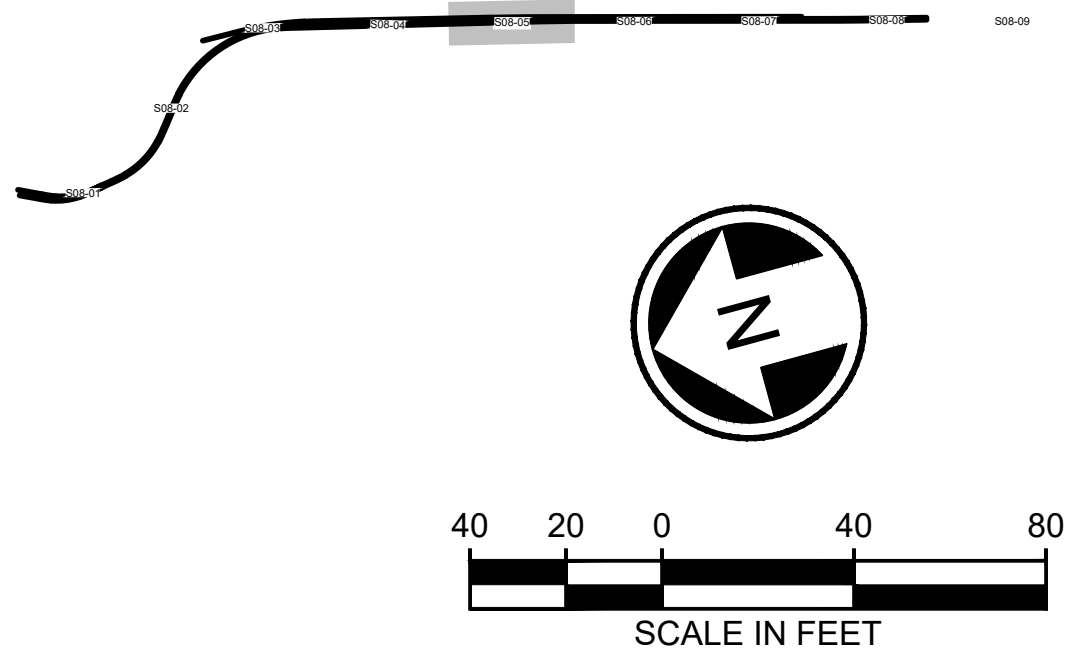



NOT FOR
CONSTRUCTION

Refer to the plan set COVER drawing
for disclaimers regarding this drawing.

REFERENCE CONCEPT DRAWINGS

No.	DATE	DSN	CHK	APP	REVISION

DESIGNED BY:
K. McDONALD
DRAWN BY:
J. LUM
CHECKED BY:
P. LOPEZ-HILFIKER
APPROVED BY:
P. LOPEZ-HILFIKER

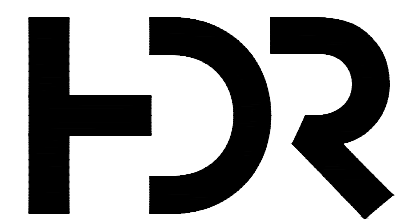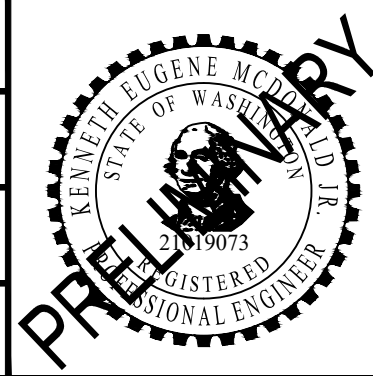

SUBMITTED BY:
PABLO LOPEZ-HILFIKER

DATE:
2/27/2024

REVIEWED BY:



DATE:
2/27/2024


PACKAGE #

SCALE:
1"=40'
FILENAME:
OMFS-S08-CGP101-108
CONTRACT No.:
AE-0030-17
DATE:
2/27/2024

SOUND TRANSIT
PRELIMINARY ENGINEERING PLANS
OPERATIONS & MAINTENANCE FACILITY SOUTH

CIVIL
GRADING
STA SB1540+00 TO STA SB1550+00


DRAWING No.:
S08-CGP105
FACILITY ID:
S08
SHEET No.: REV:
0

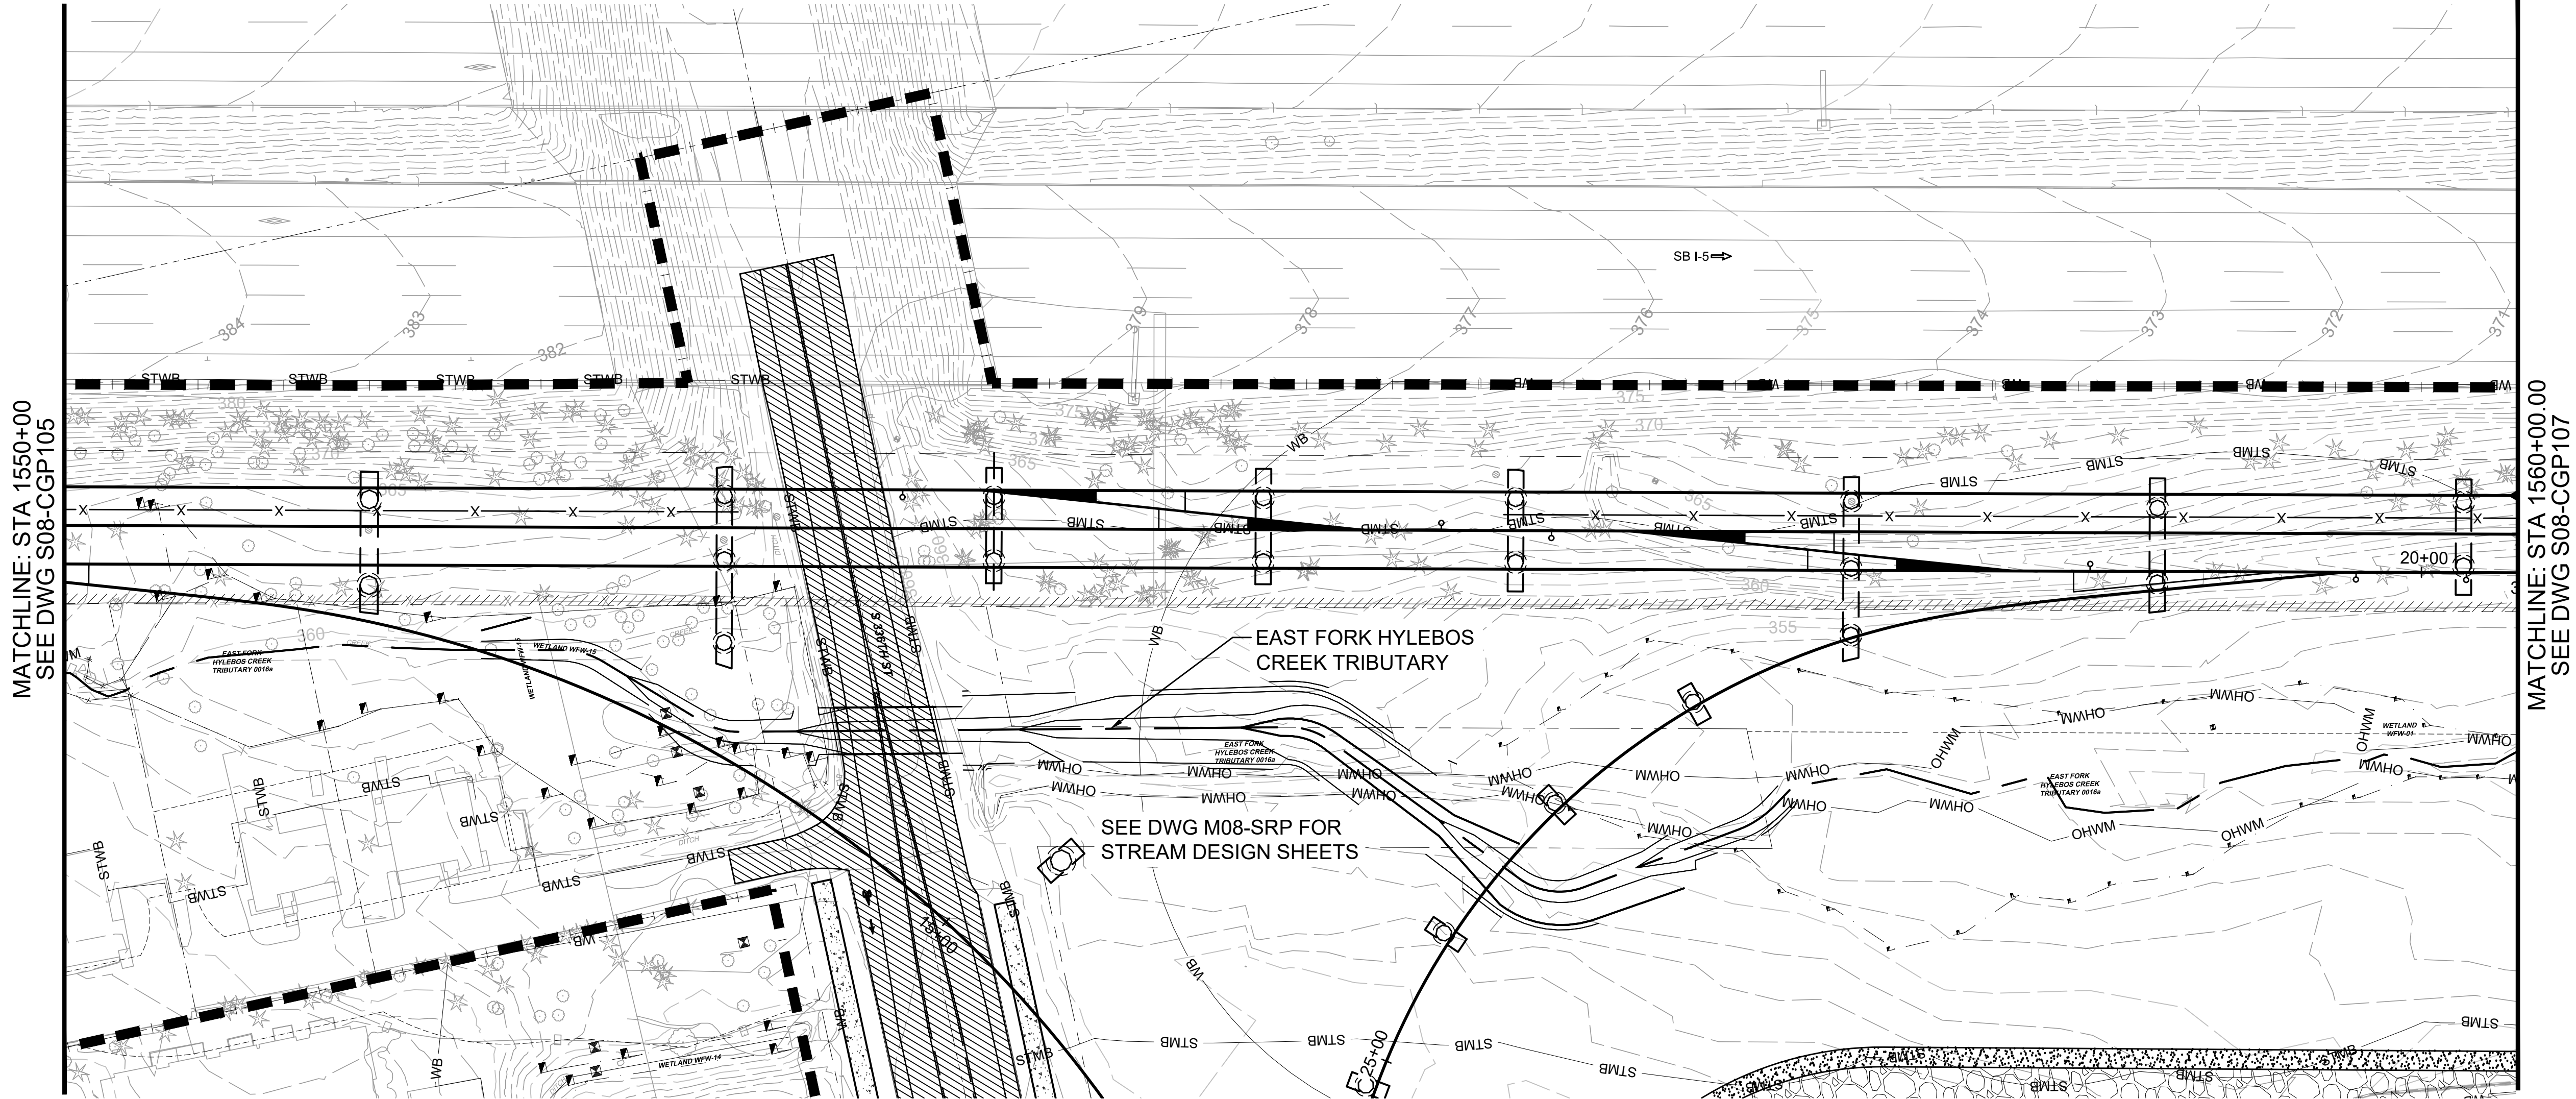

LEGEND:



- MAJOR / MINOR CONTOUR (PROPOSED)
- MAJOR / MINOR CONTOUR (EXISTING)
- TEMPORARY CONSTRUCTION IMPACT AREA

SEE DWG S08-KYX FOR
TYPICAL CROSS SECTIONS
SEE DWG G01-GZN020
FOR KEY NOTE DESCRIPTIONS

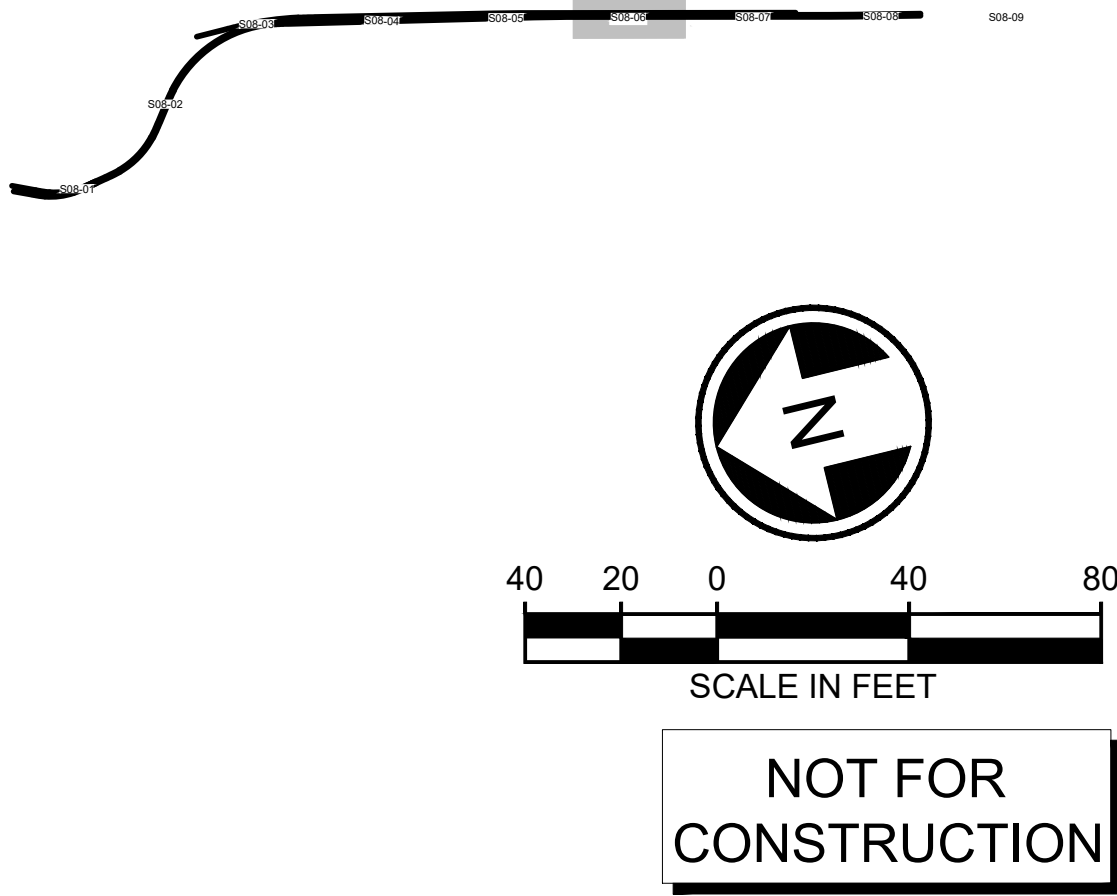


Refer to the plan set COVER drawing
for disclaimers regarding this drawing.

for disclaimers regarding this drawing.

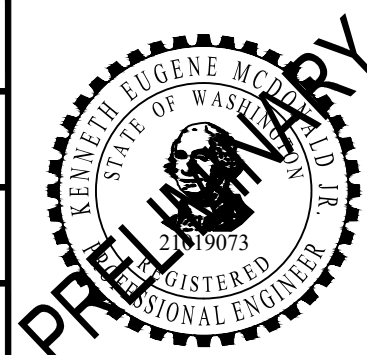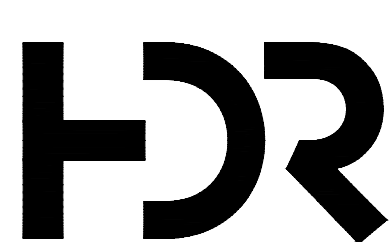REFERENCE CONCEPT DRAWINGS						AHJ:		PACKAGE #																																							
<table><tr><td></td><td></td><td></td><td></td><td></td><td></td></tr><tr><td></td><td></td><td></td><td></td><td></td><td></td></tr><tr><td></td><td></td><td></td><td></td><td></td><td></td></tr><tr><td></td><td></td><td></td><td></td><td></td><td></td></tr><tr><td>No.</td><td>DATE</td><td>DSN</td><td>CHK</td><td>APP</td><td>REVISION</td></tr></table>																														No.	DATE	DSN	CHK	APP	REVISION	DESIGNED BY: K. MCDONALD					LINE IS 1" AT FULL SCALE 	SCALE: 1"=40'		SOUND TRANSIT PRELIMINARY ENGINEERING PLANS OPERATIONS & MAINTENANCE FACILITY SOUTH CIVIL GRADING STA SB1550+00 TO STA SB1560+00		DRAWING No.: S08-CGP106	
No.	DATE	DSN	CHK	APP	REVISION																																										
DRAWN BY: J. LUM		FILENAME: OMFS-S08-CGP101-108		FACILITY ID: S08																																											
CHECKED BY: P. LOPEZ-HILFIKER		CONTRACT No.: AE-0030-17		SHEET No.: 0																																											
APPROVED BY: P. LOPEZ-HILFIKER		DATE: 2/27/2024		REV: 0																																											
		REVIEWED BY:		DATE: 2/27/2024																																											

02/23/24 | 5:04 PM | KMC DONALD
C:\P\WORKING\WEST01\D2780550\OMFS-S08-CGP101-108.DWG

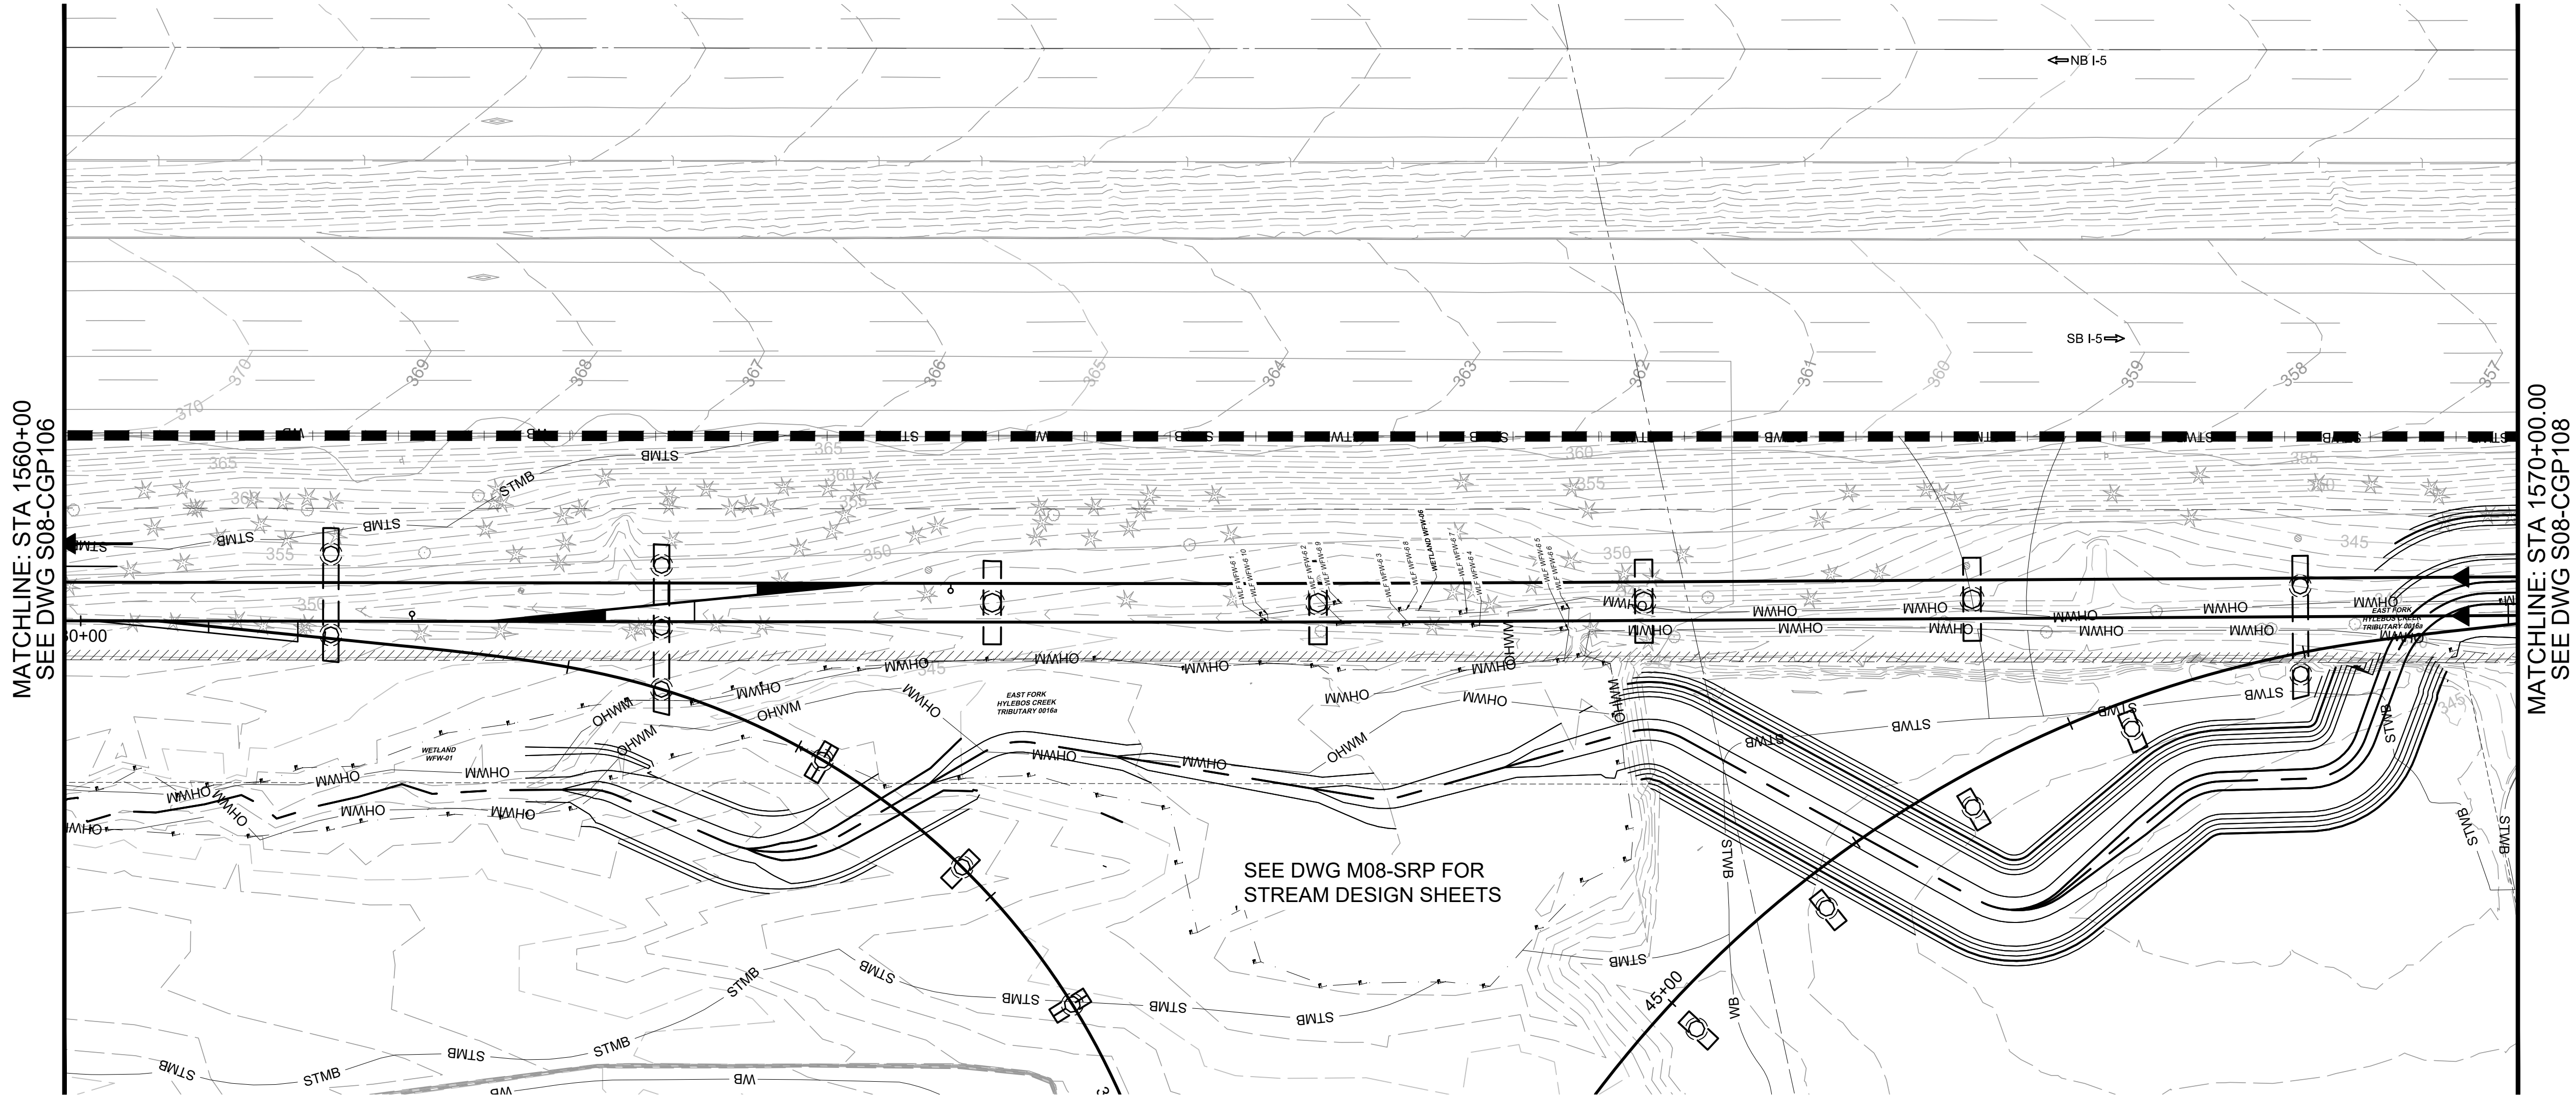


SEE DWG M08-SRP FOR
STREAM DESIGN SHEETS

SEE M08-CGP DRAWINGS

SEE DWG S08-KYX FOR
TYPICAL CROSS SECTIONS
SEE DWG G01-GZN020
FOR KEY NOTE DESCRIPTIONS

LEGEND:

- MAJOR / MINOR CONTOUR (PROPOSED)
- MAJOR / MINOR CONTOUR (EXISTING)
- TEMPORARY CONSTRUCTION IMPACT AREA

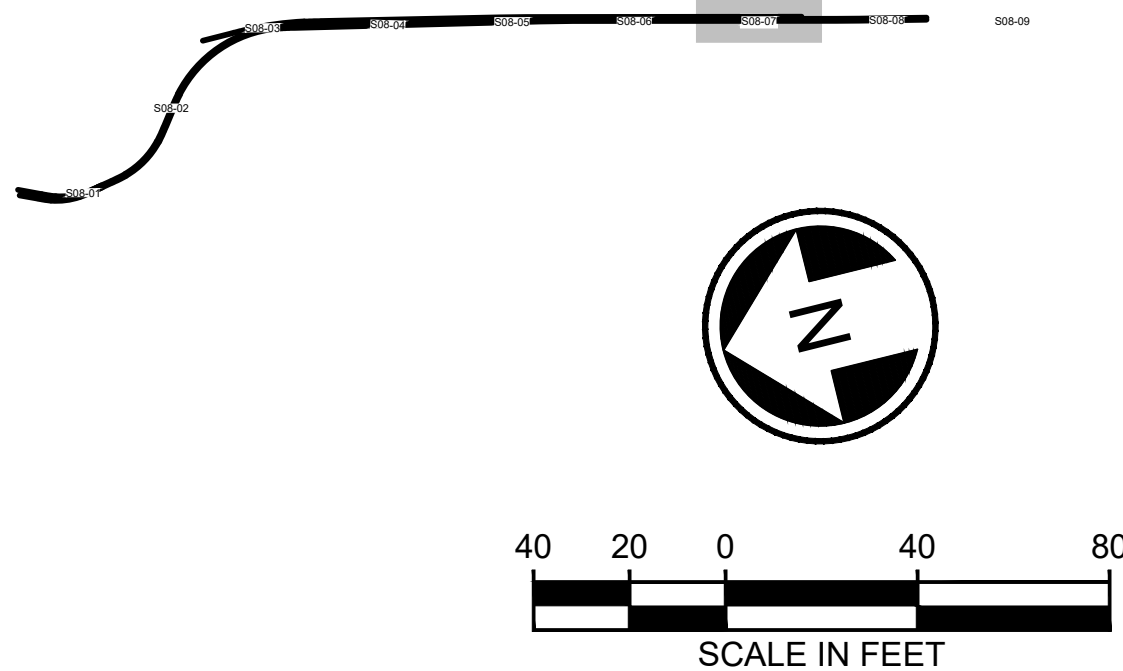


NOT FOR
CONSTRUCTION

Refer to the plan set COVER drawing
for disclaimers regarding this drawing.

REFERENCE CONCEPT DRAWINGS					
No.	DATE	DSN	CHK	APP	REVISION

DESIGNED BY:	K. McDONALD
DRAWN BY:	J. LUM
CHECKED BY:	P. LOPEZ-HILFIKER
APPROVED BY:	P. LOPEZ-HILFIKER

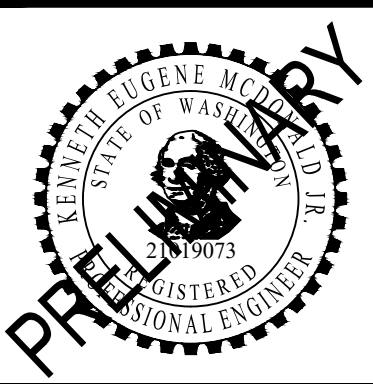

SUBMITTED BY:
PABLO LOPEZ-HILFIKER

DATE:
2/27/2024

REVIEWED BY:

DATE:
2/27/2024

LINE IS 1" AT
FULL SCALE

PACKAGE #
SCALE: 1"=40'
FILENAME: OMFS-S08-CGP101-108
CONTRACT No.: AE-0030-17
DATE: 2/27/2024


SOUND TRANSIT
PRELIMINARY ENGINEERING PLANS
OPERATIONS & MAINTENANCE FACILITY SOUTH

CIVIL
GRADING
STA SB1560+00 TO STA SB1570+00



DRAWING No.:	S08-CGP107
FACILITY ID:	S08
SHEET No.:	REV:
	0

02/23/24 | 5:06 PM | KIMCDONALD
C:\P\WORKING\WEST01\D2780550\OMFS-S08-CGP101-108.DWG

MATCHLINE: STA SB1570+00
SEE DWG S08-CGP107

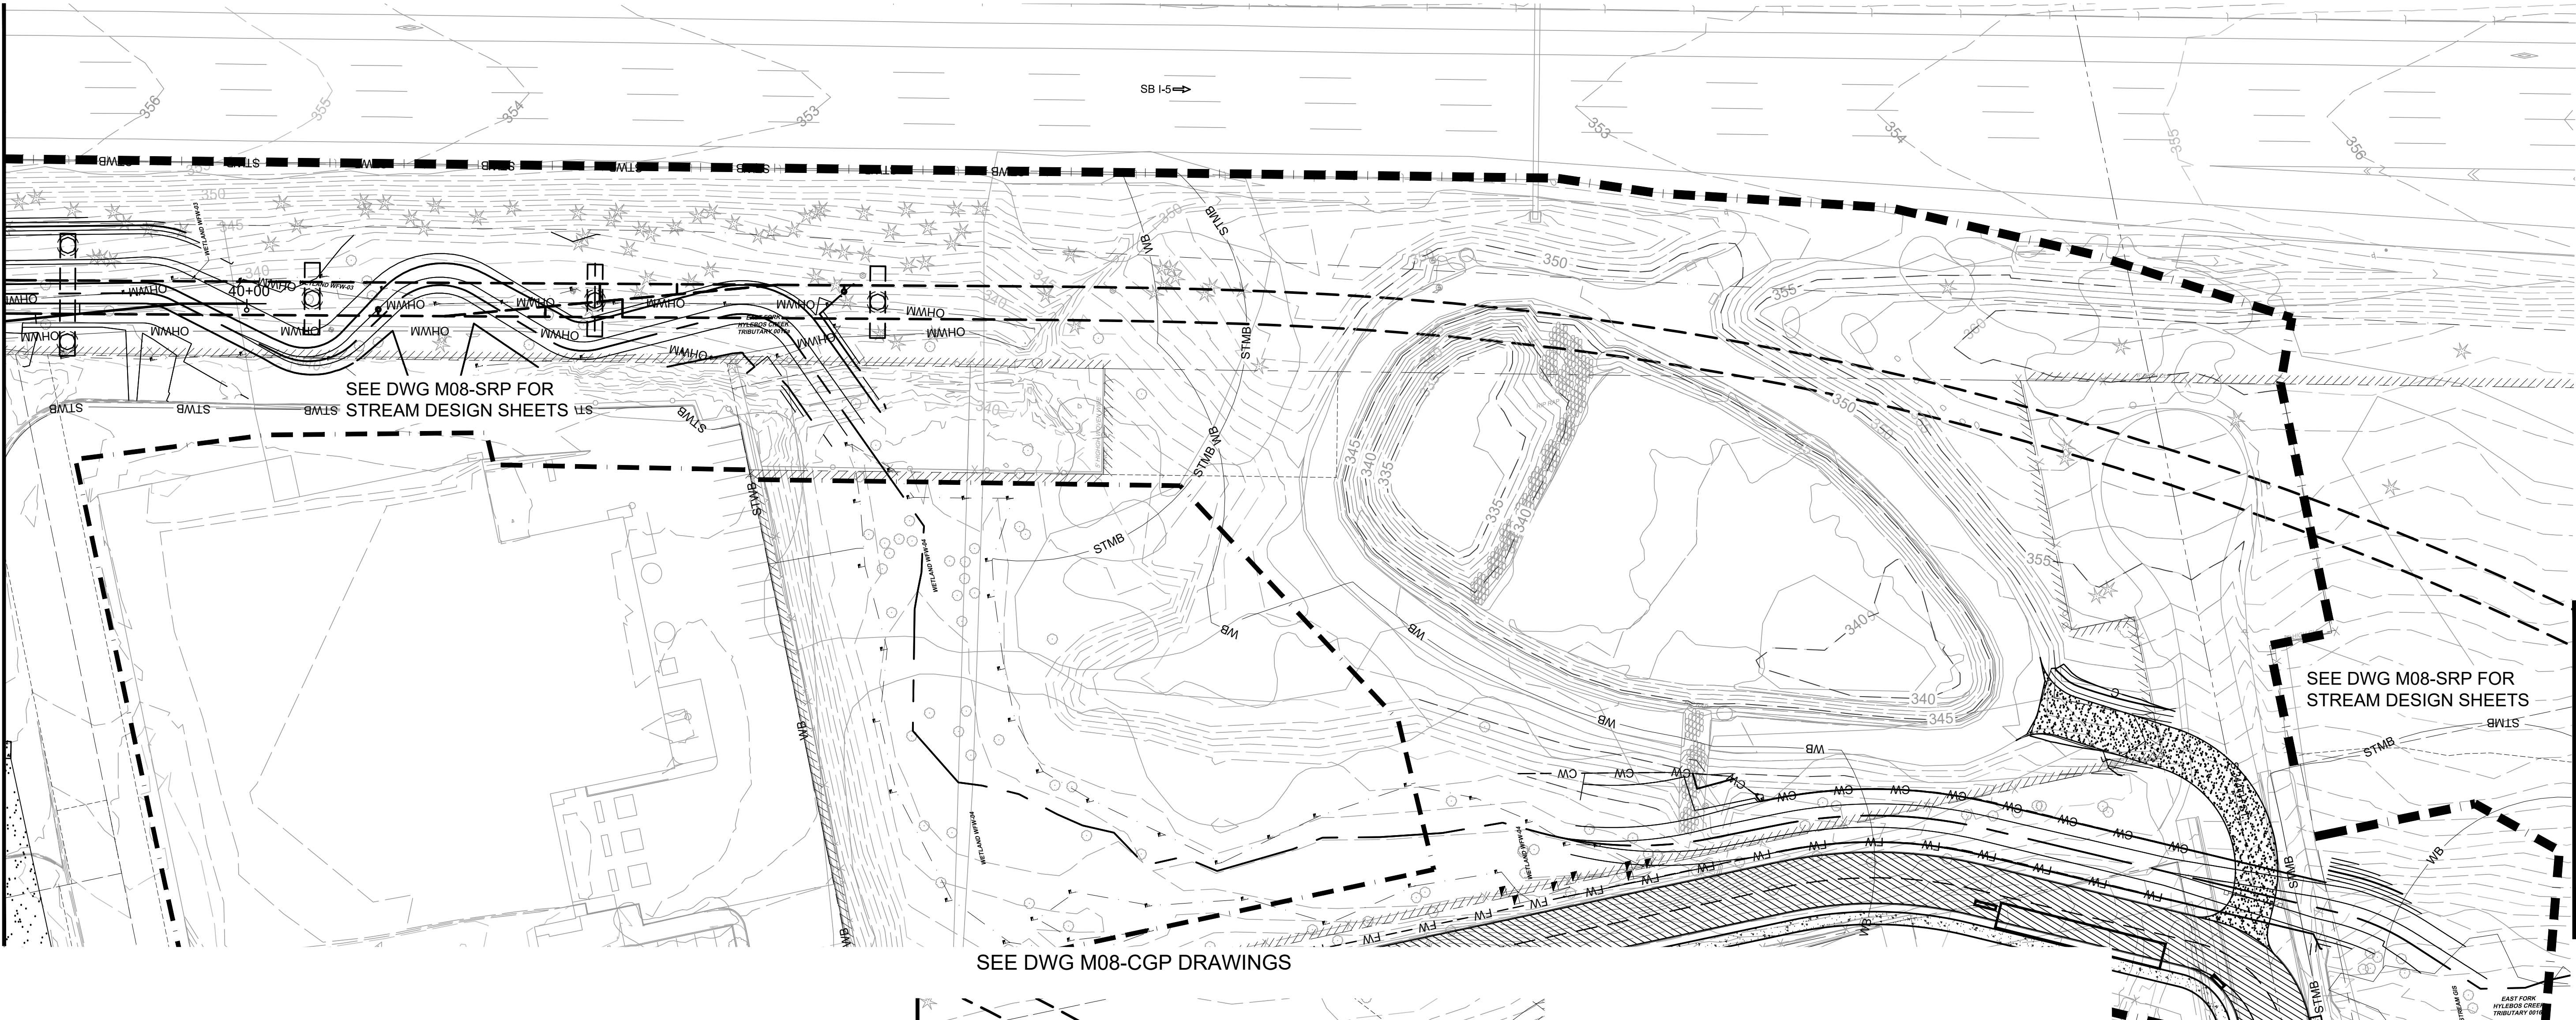

- LEGEND:**
- MAJOR / MINOR CONTOUR (PROPOSED)
 - MAJOR / MINOR CONTOUR (EXISTING)
 - TEMPORARY CONSTRUCTION IMPACT AREA

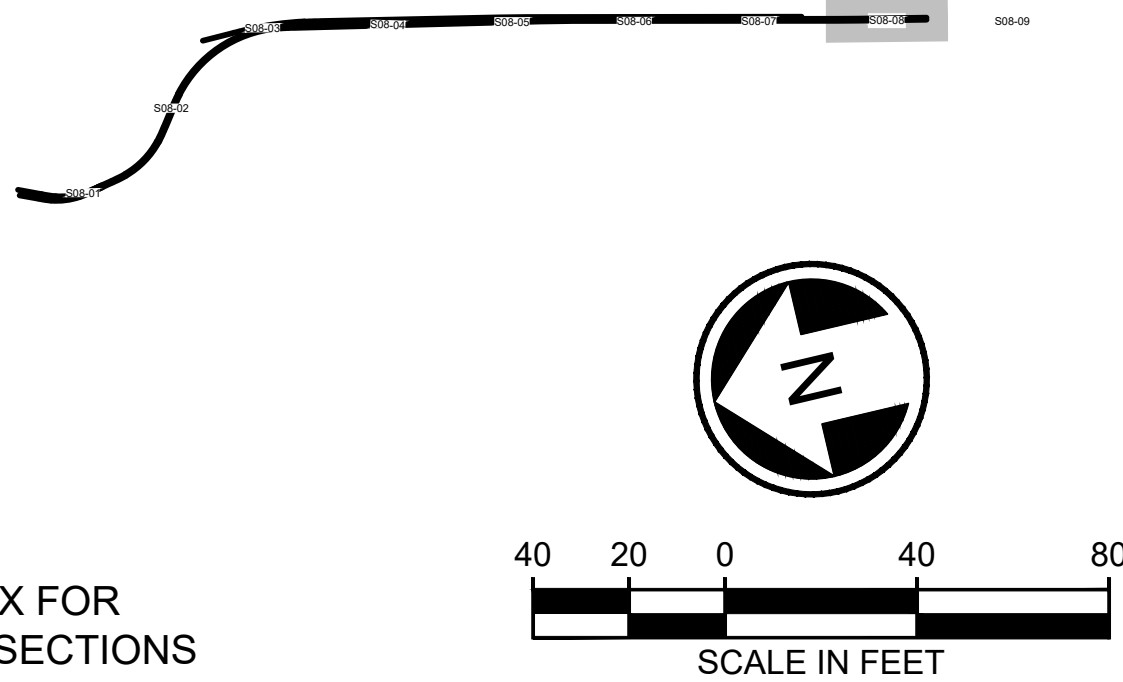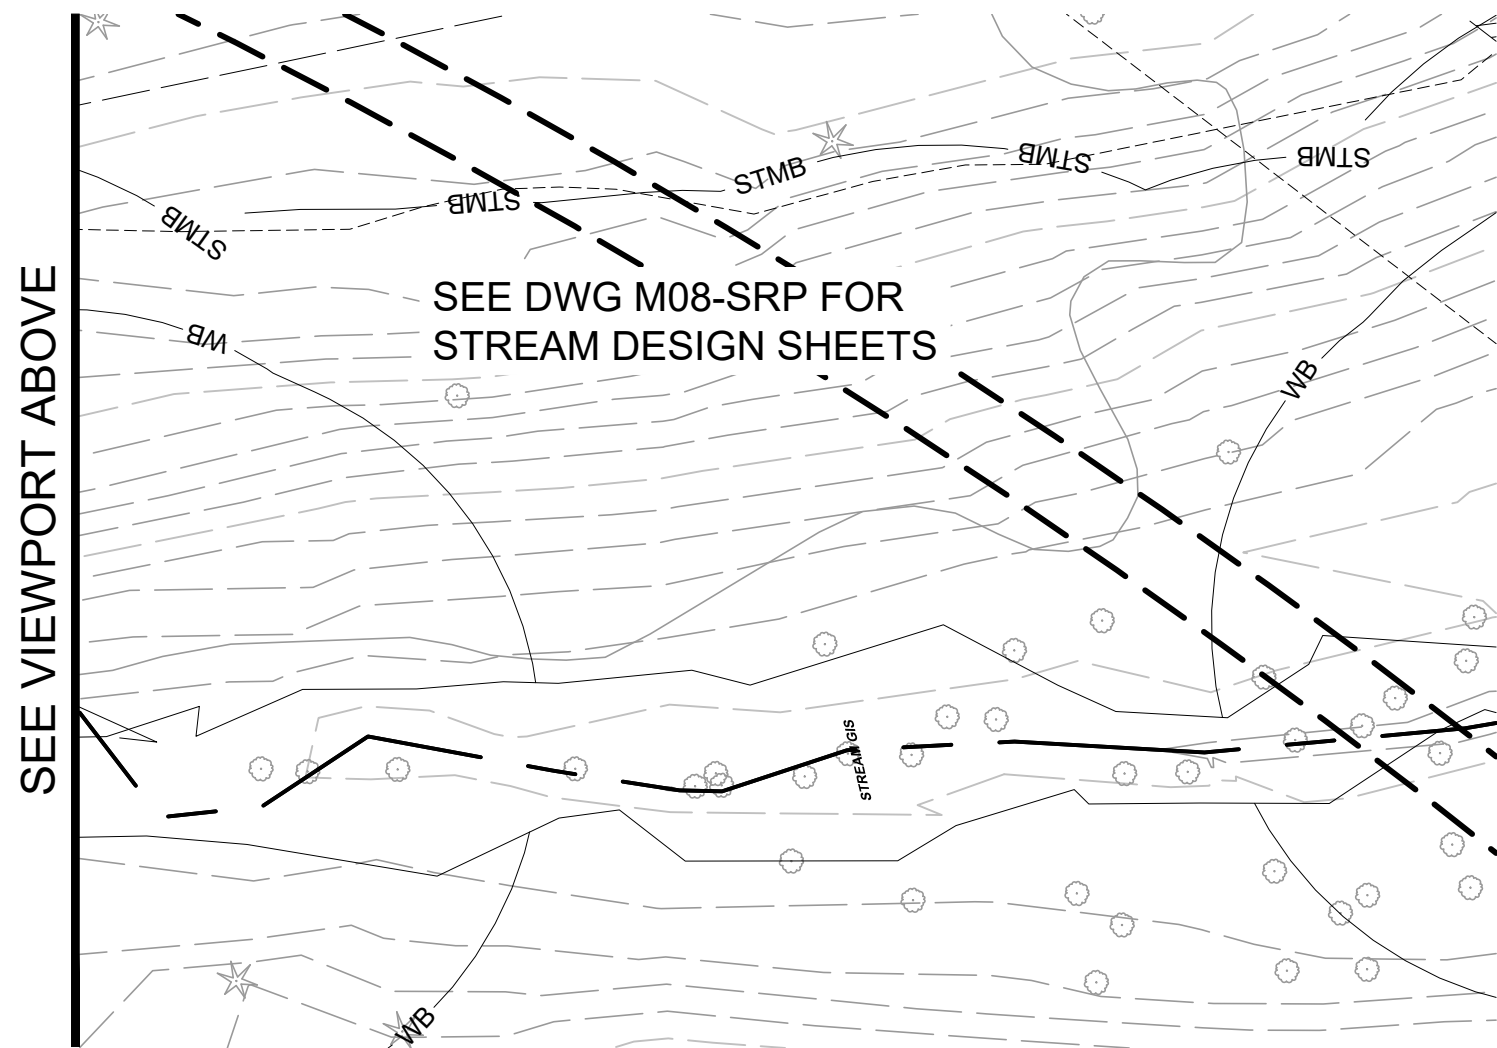


SEE DWG S08-KYX FOR
TYPICAL CROSS SECTIONS
SEE DWG G01-GZN020
FOR KEY NOTE DESCRIPTIONS

NOT FOR
CONSTRUCTION

REFERENCE CONCEPT DRAWINGS

No.	DATE	DSN	CHK	APP	REVISION

DESIGNED BY:
K. McDONALD
DRAWN BY:
J. LUM
CHECKED BY:
P. LOPEZ-HILFIKER
APPROVED BY:
P. LOPEZ-HILFIKER

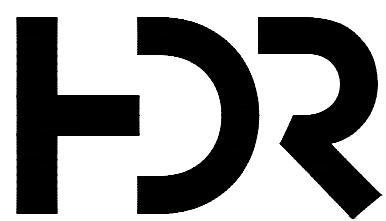

SUBMITTED BY:
PABLO LOPEZ-HILFIKER

DATE:
2/27/2024

REVIEWED BY:



DATE:
2/27/2024

PACKAGE

SCALE:
1"=40'
FILENAME:
OMFS-S08-CGP101-108
CONTRACT No.:
AE-0030-17
DATE:
2/27/2024

SOUND TRANSIT
PRELIMINARY ENGINEERING PLANS
OPERATIONS & MAINTENANCE FACILITY SOUTH

CIVIL
GRADING
STA SB1570+00 TO END


DRAWING No.:
S08-CGP108
FACILITY ID:
S08
SHEET No.:
REV:
0

02/2024 | 11:00 AM | WILLIBRE
C:\PWORKING\WEST01\12780562\OMFS-S08-CDD101-102.DWG

Refer to the plan set COVER drawing
for disclaimers regarding this drawing.

REFERENCE CONCEPT DRAWINGS					
No.	DATE	DSN	CHK	APP	REVISION

DESIGNED BY:	L. GRABOWSKI
DRAWN BY:	B. WILLIAMS
CHECKED BY:	J. WRIGHT
APPROVED BY:	J.COOP

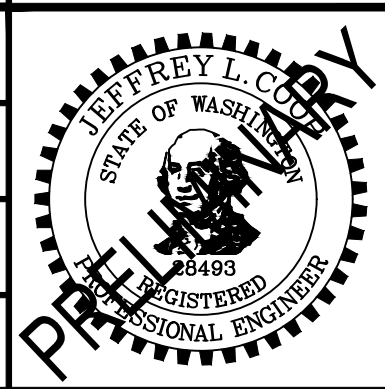


SUBMITTED BY:
PABLO LOPEZ-HILFIKER

DATE:
2/27/2024

REVIEWED BY:

LINE IS 1" AT
FULL SCALE

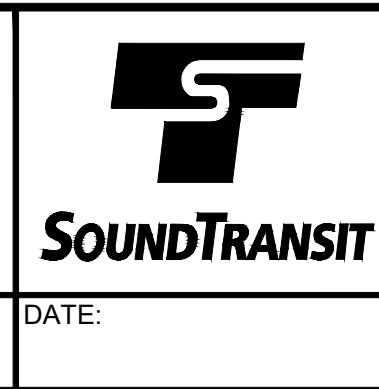


DATE:


PACKAGE #

SCALE: 1"=200'
FILENAME: OMFS-S08-CDD101-102
CONTRACT No.: AE-0030-17
DATE:

SOUND TRANSIT PRELIMINARY ENGINEERING PLANS OPERATIONS & MAINTENANCE FACILITY SOUTH CIVIL OVERALL MAINLINE & OFFSITE DRAINAGE	DRAWING No.: S08-CDD101
FACILITY ID: S08	
SHEET No.: REV: 0	

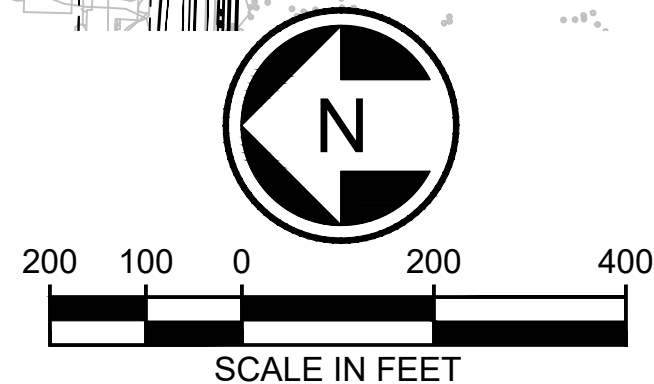

NOT FOR
CONSTRUCTION

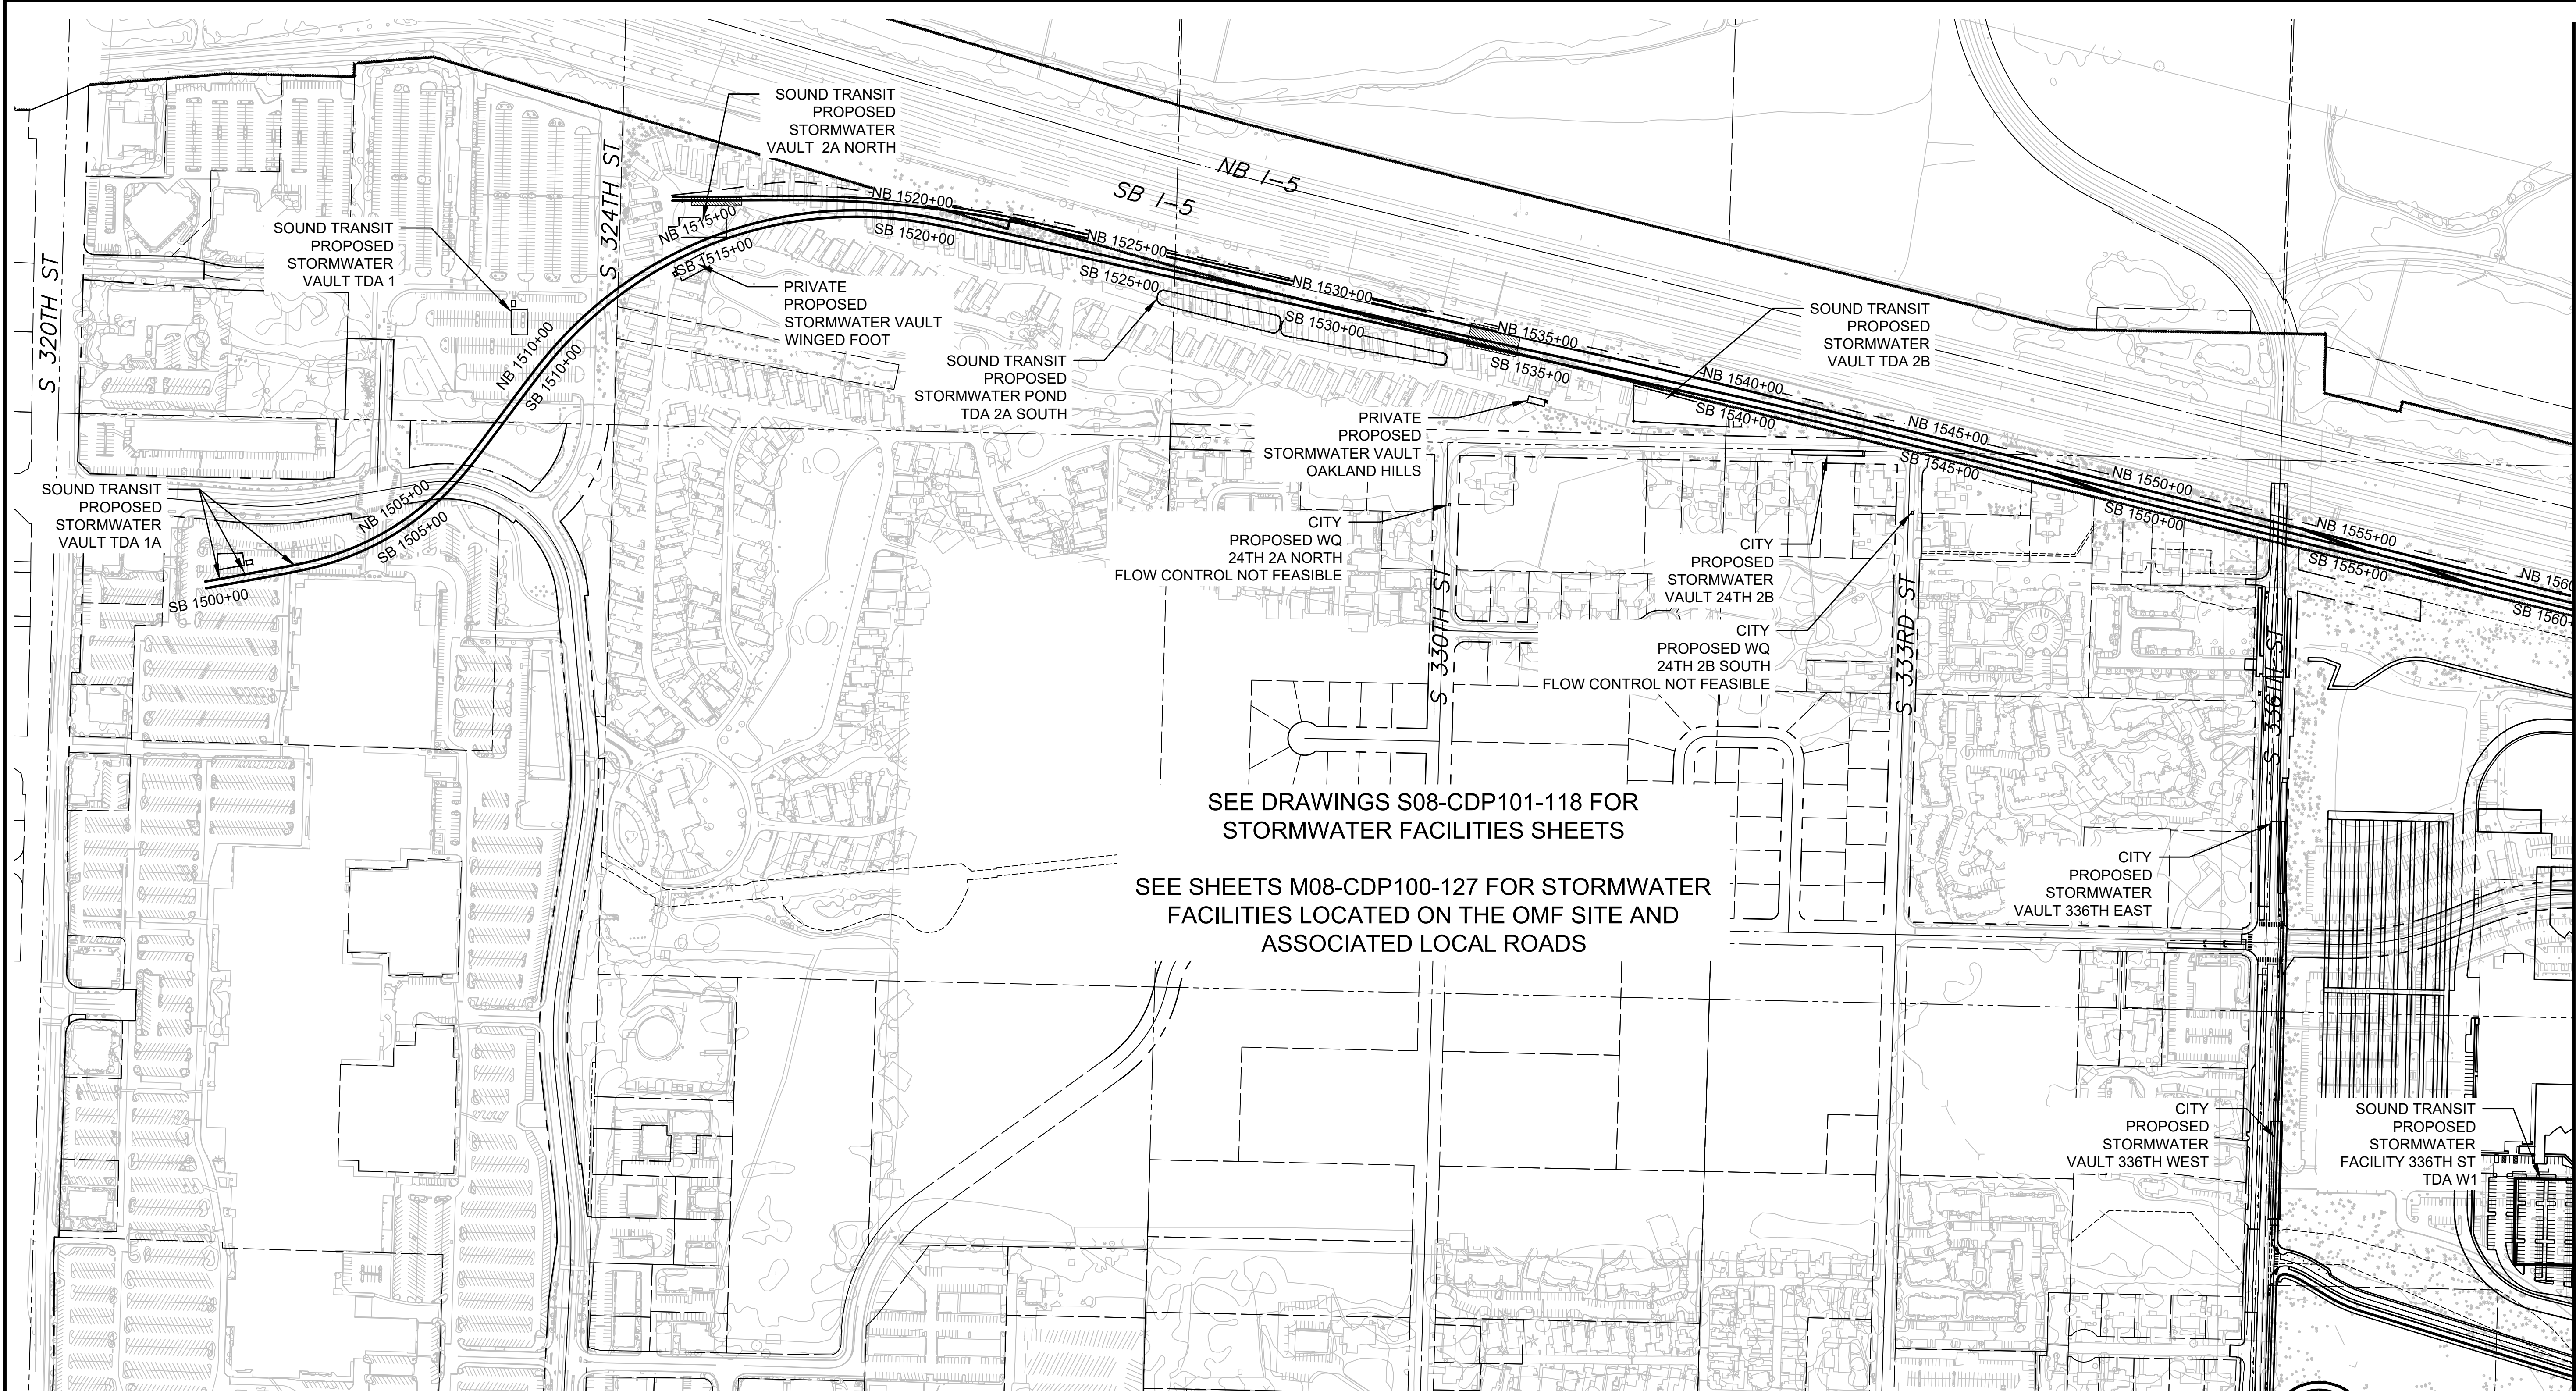


SEE DRAWINGS S08-CDP101-118 FOR
STORMWATER FACILITIES SHEETS

SEE SHEETS M08-CDP100-127 FOR STORMWATER
FACILITIES LOCATED ON THE OMF SITE AND
ASSOCIATED LOCAL ROADS

MATCHLINE: STA NB1560+00
SEE DWG S08-CDD102


02/2024 | 11:00 AM | WILLIBRE
C:\PWORKING\WEST01\2780562\OMFS-S08-CDD101-102.DWG

MATCHLINE: STA NB1560+00
SEE DWG S08-CDD101

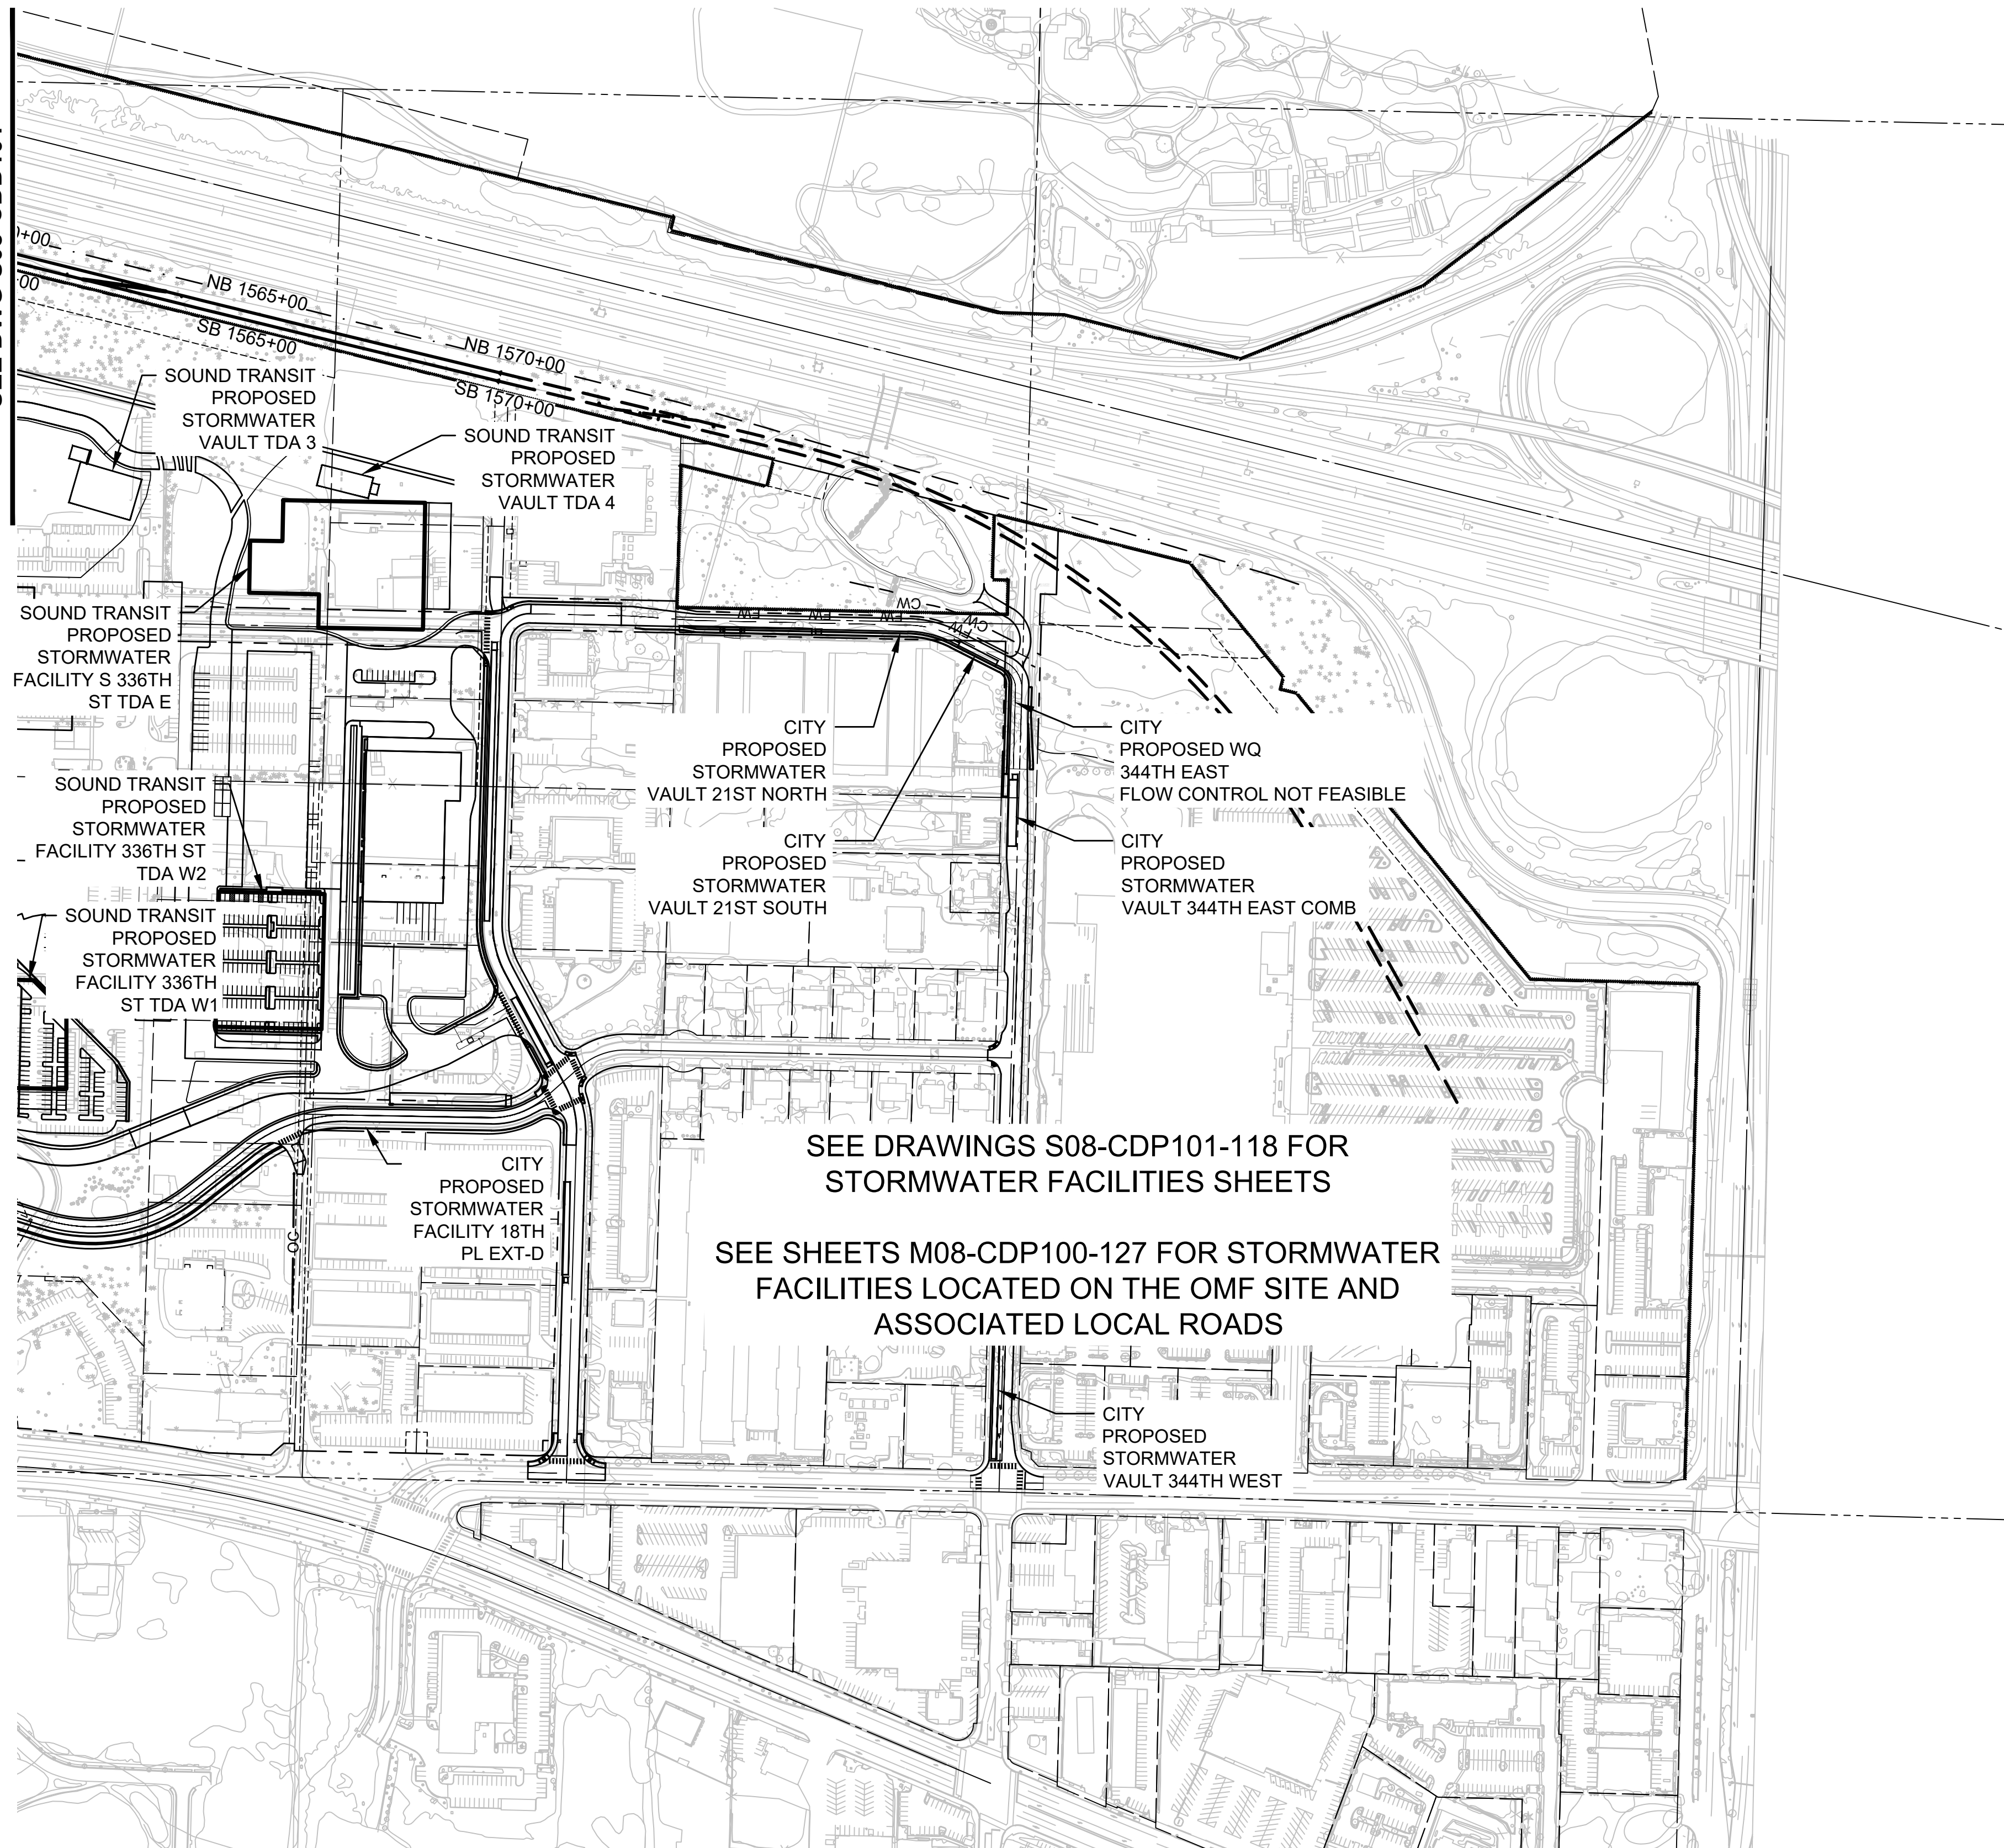

SEE DRAWINGS S08-CDP101-118 FOR
STORMWATER FACILITIES SHEETS

SEE SHEETS M08-CDP100-127 FOR STORMWATER
FACILITIES LOCATED ON THE OMF SITE AND
ASSOCIATED LOCAL ROADS

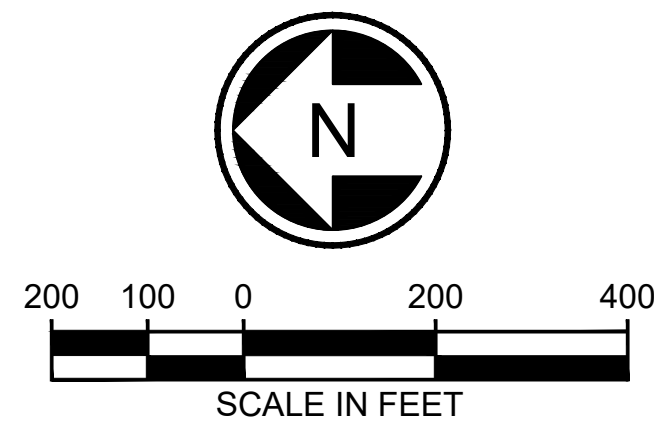

NOT FOR
CONSTRUCTION

Refer to the plan set COVER drawing
for disclaimers regarding this drawing.


REFERENCE CONCEPT DRAWINGS						DESIGNED BY: L. GRABOWSKI				LINE IS 1" AT FULL SCALE		PACKAGE #		DRAWING No.: S08-CDD102			
						DRAWN BY: B. WILLIAMS						SCALE: 1"=200'		SOUND TRANSIT PRELIMINARY ENGINEERING PLANS OPERATIONS & MAINTENANCE FACILITY SOUTH CIVIL OVERALL MAINLINE & OFFSITE DRAINAGE		FACILITY ID: S08	
						CHECKED BY: J. WRIGHT						FILENAME: OMFS-S08-CDD101-102				SHEET No.: REV:	
						APPROVED BY: J.COOP						CONTRACT No.: AE-0030-17				0	
No.	DATE	DSN	CHK	APP	REVISION	SUBMITTED BY: PABLO LOPEZ-HILFIKER		DATE: 2/27/2024		REVIEWED BY:		DATE:					

02/21/24 | 4:14 PM | WILLIBRE
C:\PWORKING\WEST01\02780562\OMFS-S08-CDP101-118.DWG

Refer to the plan set COVER drawing
for disclaimers regarding this drawing.

REFERENCE CONCEPT DRAWINGS					
No.	DATE	DSN	CHK	APP	REVISION

DESIGNED BY:	L. GRABOWSKI
DRAWN BY:	B. WILLIAMS
CHECKED BY:	J. WRIGHT
APPROVED BY:	J.COOP

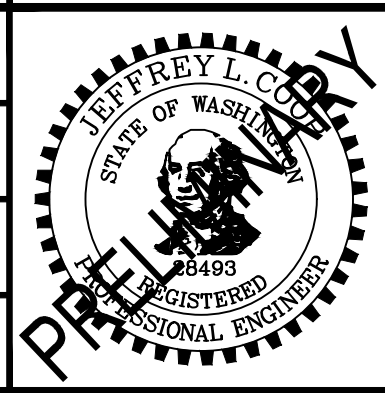

SUBMITTED BY:
PABLO LOPEZ-HILFIKER

DATE:
2/27/2024

REVIEWED BY:




DATE:

PACKAGE #
SCALE: 1"=20'
FILENAME: OMFS-S08-CDP101-118
CONTRACT No.: AE-0030-17
DATE: 2/27/2024


SOUND TRANSIT PRELIMINARY ENGINEERING PLANS OPERATIONS & MAINTENANCE FACILITY SOUTH CIVIL DRAINAGE PLAN STA 1500+00 TO STA 1505+00

DRAWING No.: S08-CDP101
FACILITY ID: S08
SHEET No.: REV: 0

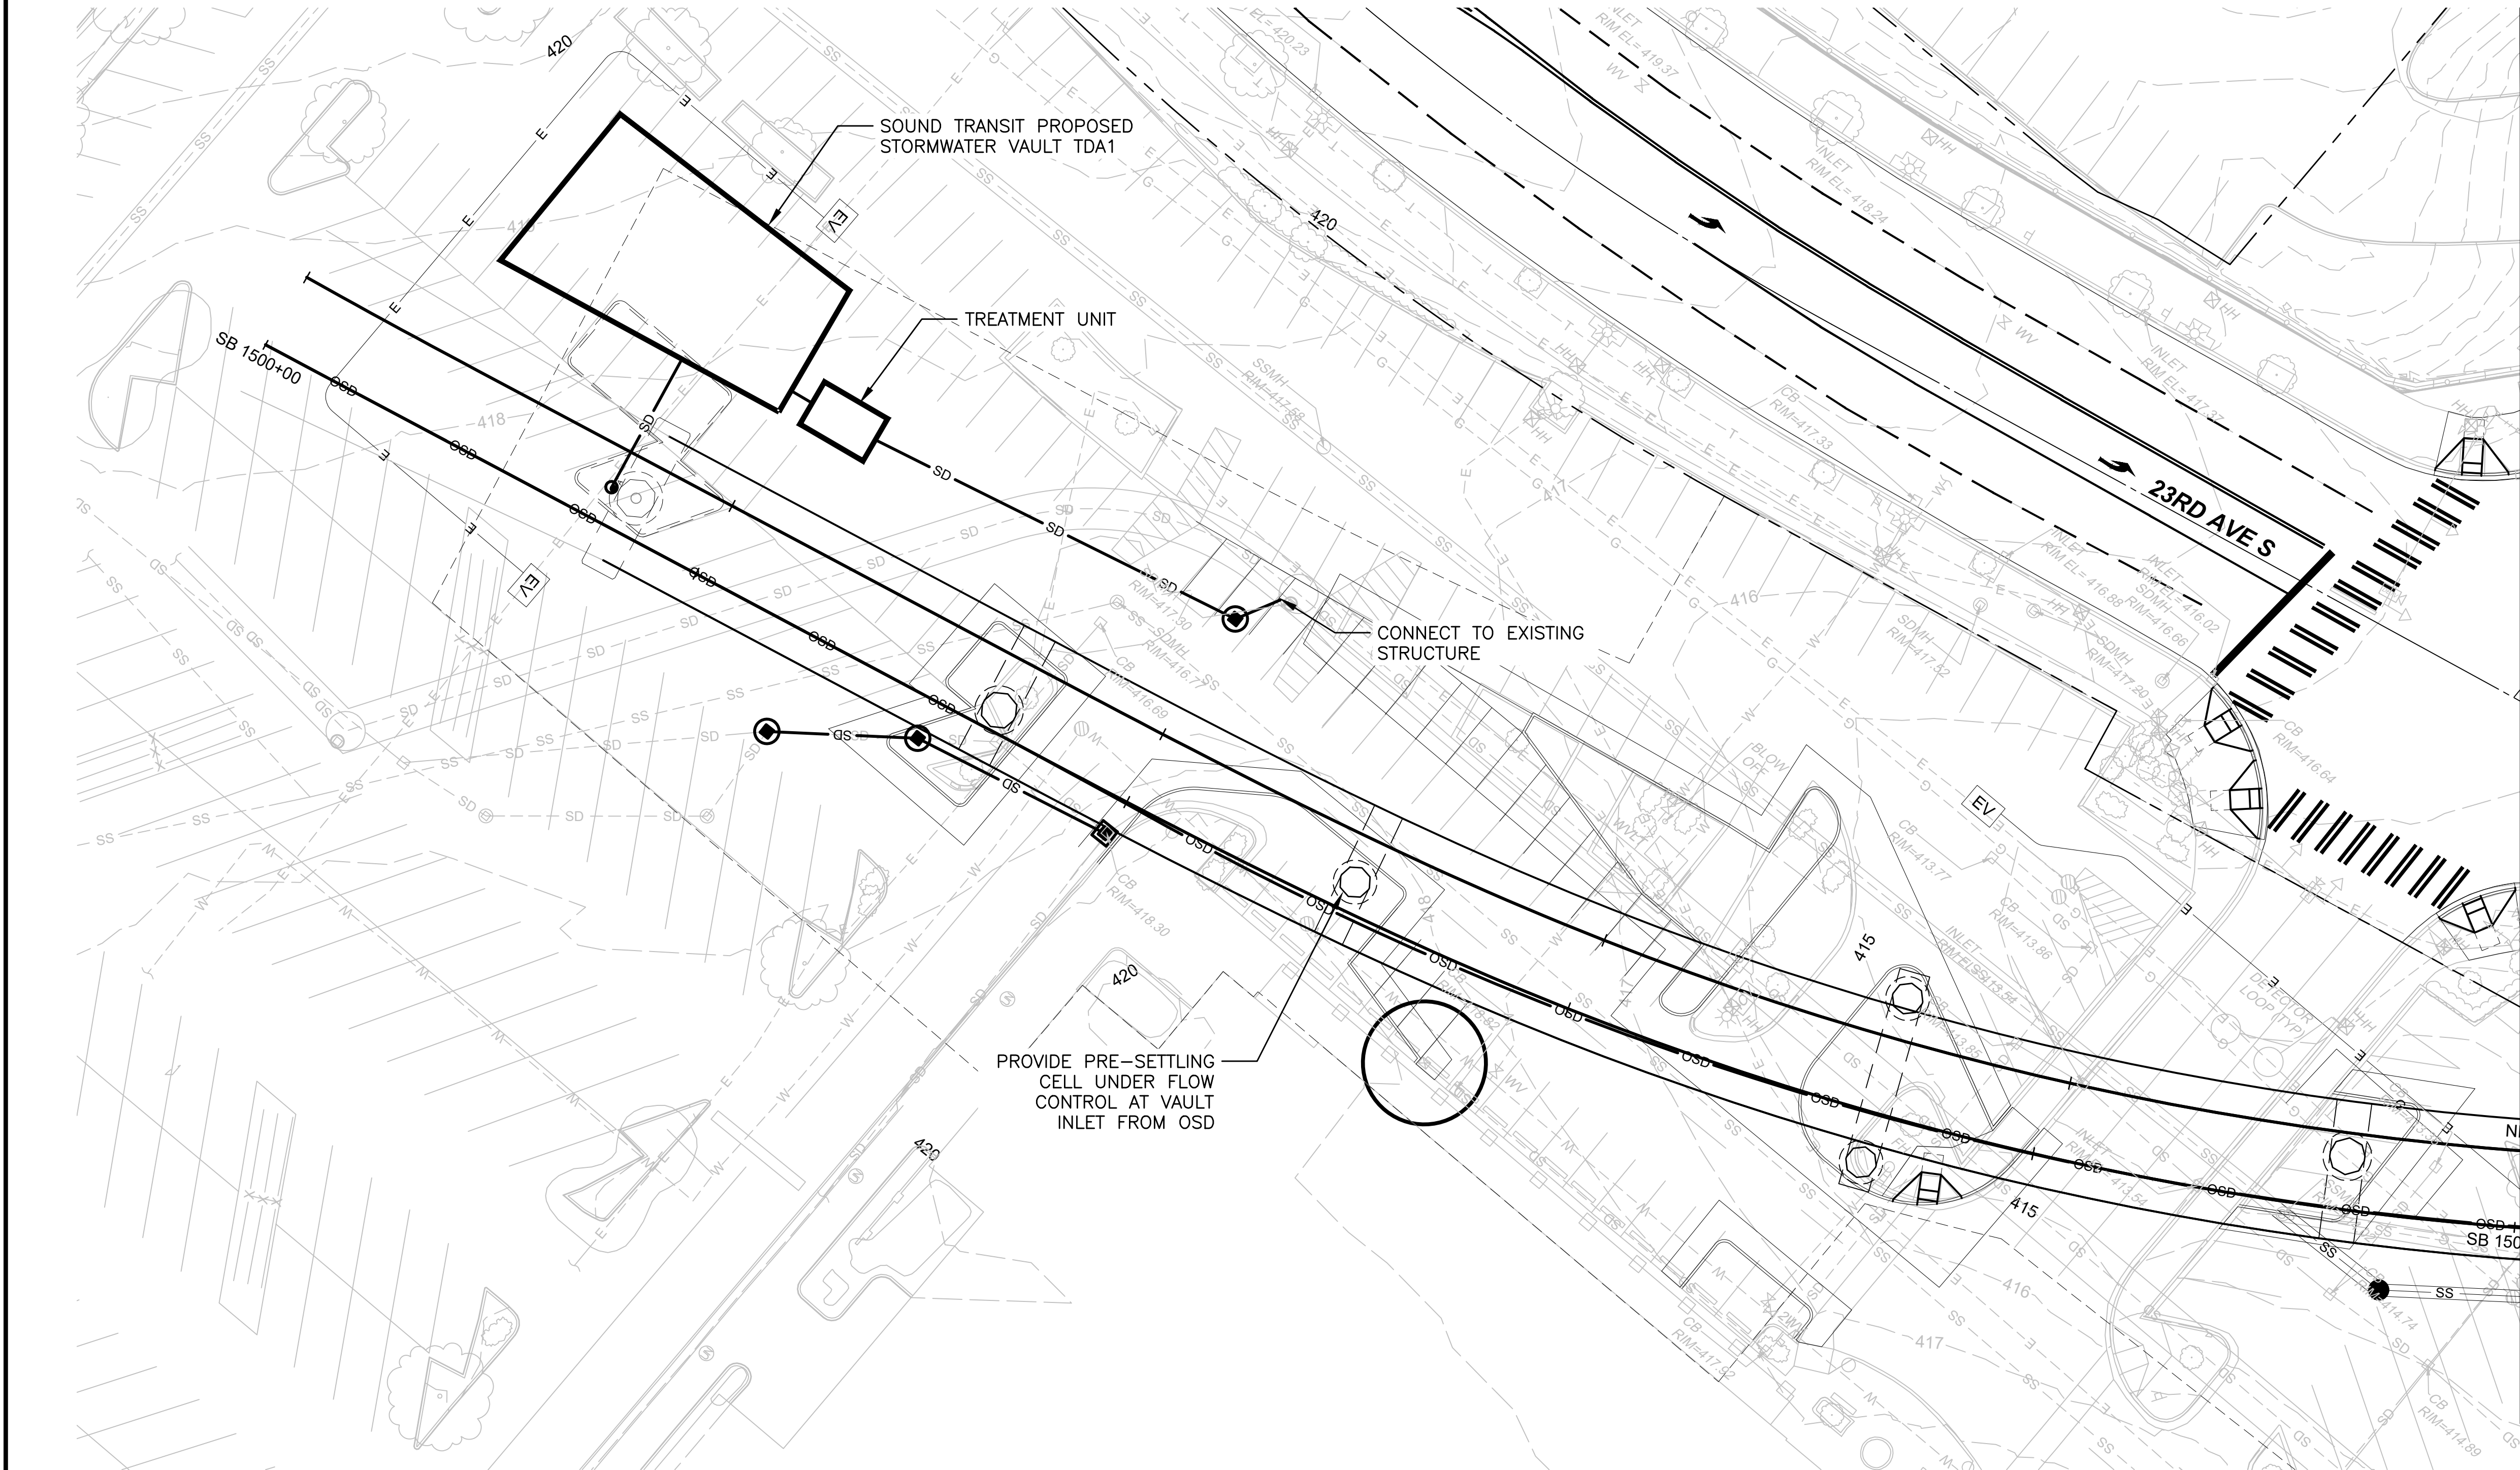

MATCHLINE: STA SB1505+00
SEE DWG S08-CDP102

- NOTES:**
- REMOVE EXISTING STORM DRAINS AND DRAINAGE STRUCTURES AT CONFLICTS WITH PROPOSED STORM DRAIN, PROPOSED DRAINAGE STRUCTURES, OR PROPOSED STORMWATER FACILITIES. RELOCATE STORM DRAINS OR REPLACE EXISTING DRAINAGE STRUCTURES AS REQUIRED.
 - ALL PROPOSED UNDERGROUND STORM DRAIN 12-INCH DIAMETER UNLESS NOTED OTHERWISE.

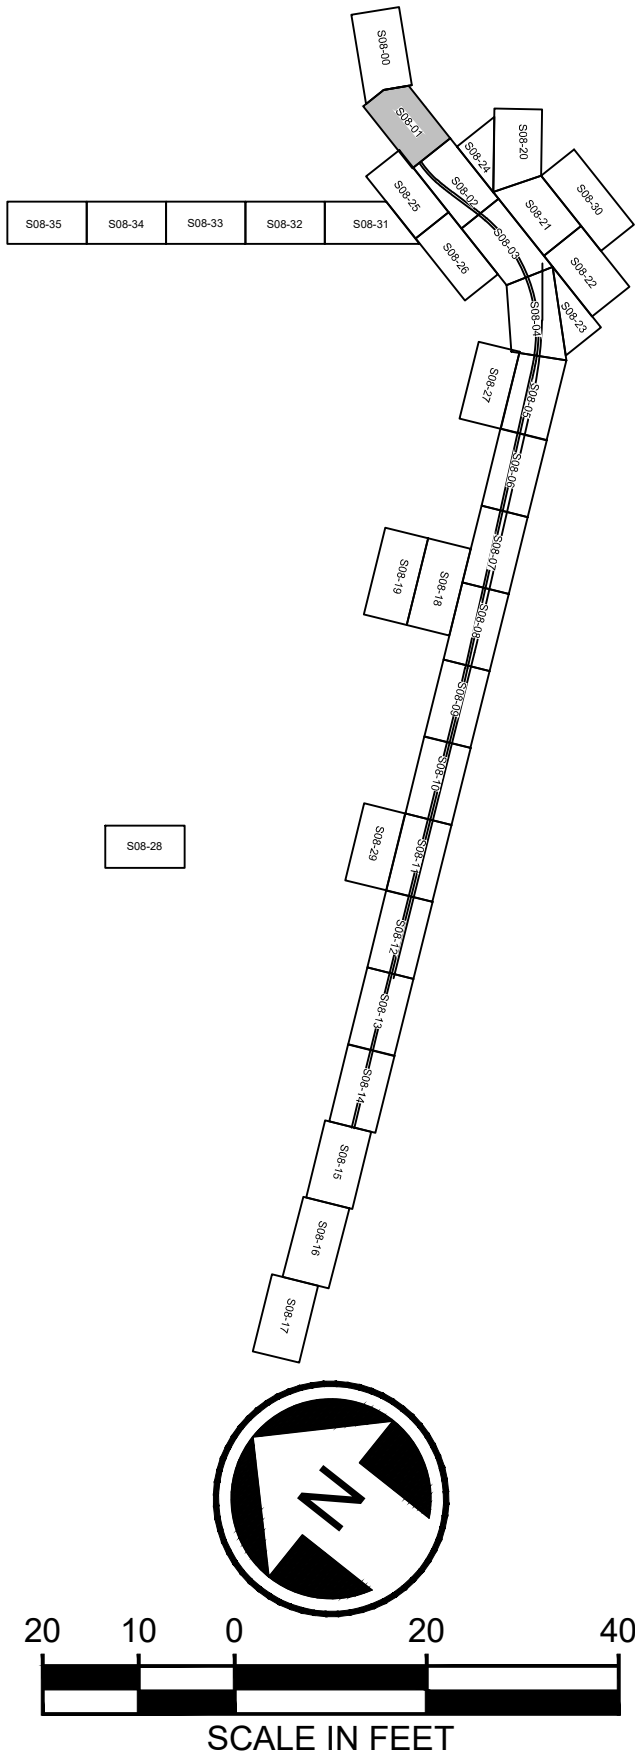


NOT FOR
CONSTRUCTION

02/21/24 | 4:16 PM | WILLIBRE
C:\PWORKING\WEST01\2780562\OMFS-S08-CDP101-118.DWG


Refer to the plan set COVER drawing
for disclaimers regarding this drawing.

REFERENCE CONCEPT DRAWINGS						AHJ:		PACKAGE #																													
<table><tr><td>No.</td><td>DATE</td><td>DSN</td><td>CHK</td><td>APP</td><td>REVISION</td></tr><tr><td> </td><td> </td><td> </td><td> </td><td> </td><td> </td></tr><tr><td> </td><td> </td><td> </td><td> </td><td> </td><td> </td></tr><tr><td> </td><td> </td><td> </td><td> </td><td> </td><td> </td></tr></table>						No.	DATE	DSN	CHK	APP	REVISION																			DESIGNED BY: L. GRABOWSKI		SCALE: 1"=20'		SOUND TRANSIT PRELIMINARY ENGINEERING PLANS OPERATIONS & MAINTENANCE FACILITY SOUTH CIVIL DRAINAGE PLAN STA 1505+00 TO STA 1510+00		DRAWING No.: S08-CDP102	
						No.	DATE	DSN	CHK	APP	REVISION																										
DRAWN BY: B. WILLIAMS		FILENAME: OMFS-S08-CDP101-118		FACILITY ID: S08																																	
CHECKED BY: J. WRIGHT		CONTRACT No.: AE-0030-17		SHEET No.: REV:																																	
APPROVED BY: J.COOP		DATE: 2/27/2024		DATE: 2/27/2024		0																															

MATCHLINE: STA SB1505+00
SEE DWG S08-CDP101

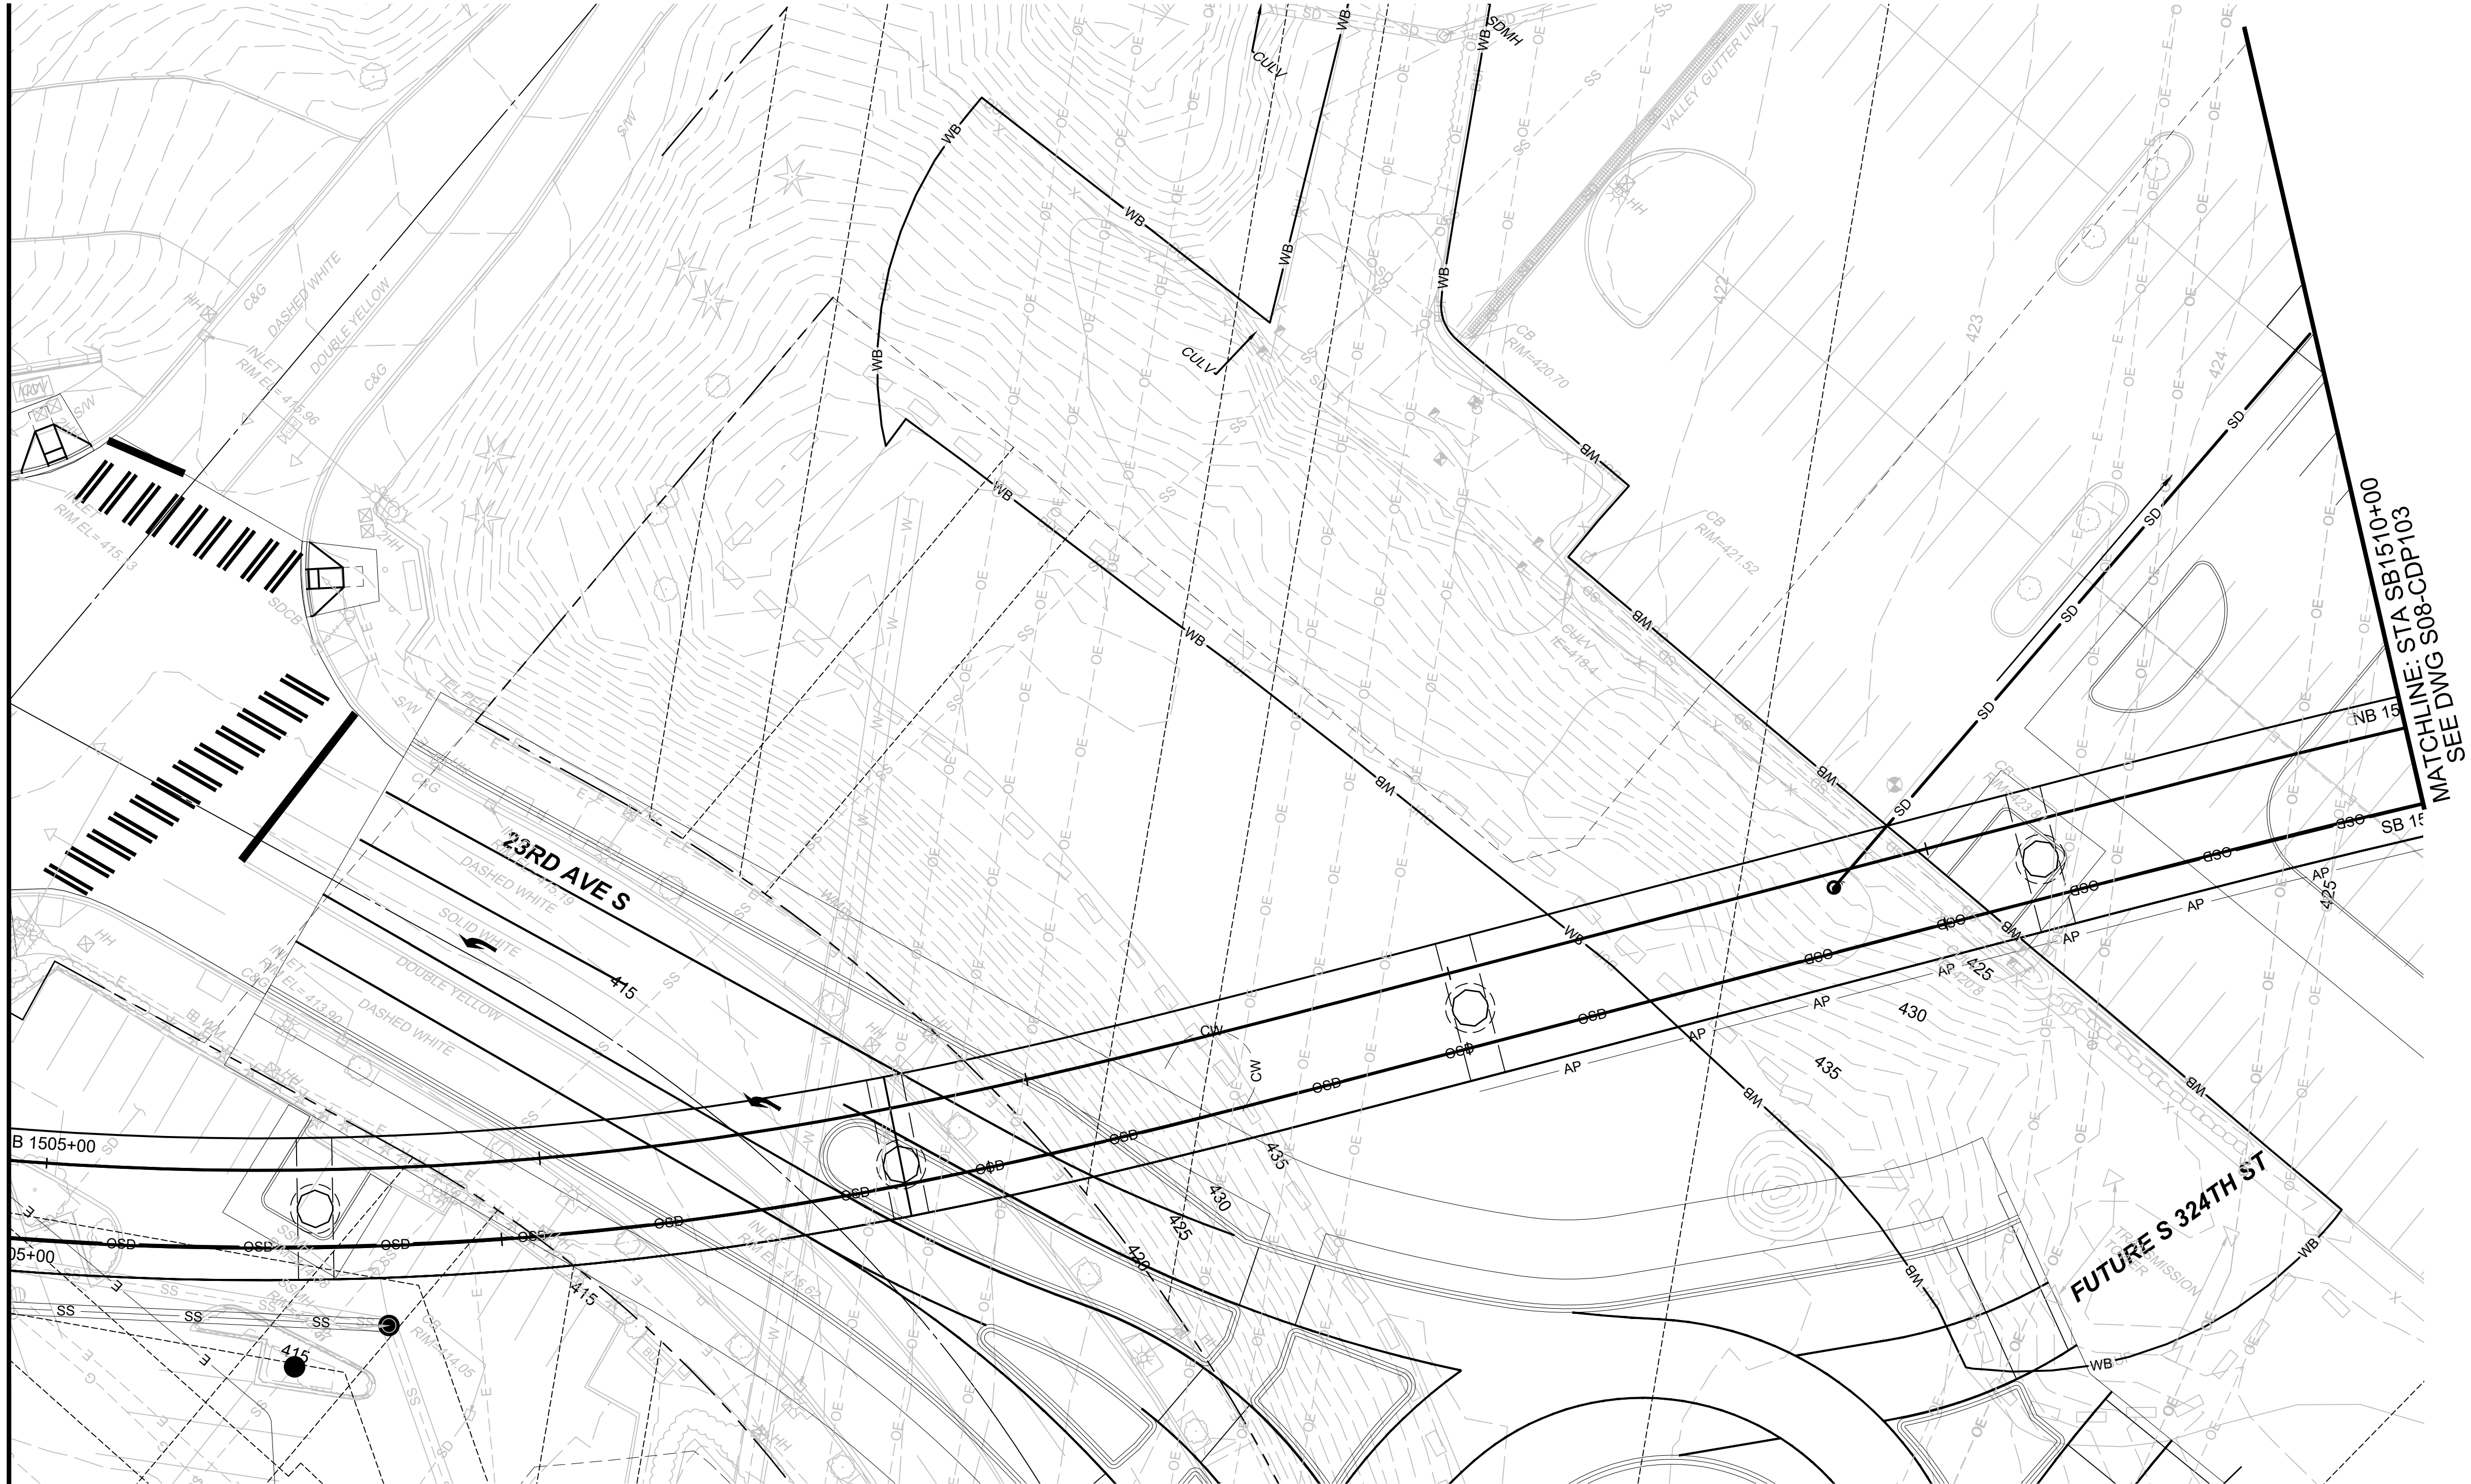

- NOTES:**
- REMOVE EXISTING STORM DRAINS AND DRAINAGE STRUCTURES AT CONFLICTS WITH PROPOSED STORM DRAIN, PROPOSED DRAINAGE STRUCTURES, OR PROPOSED STORMWATER FACILITIES. RELOCATE STORM DRAINS OR REPLACE EXISTING DRAINAGE STRUCTURES AS REQUIRED.
 - ALL PROPOSED UNDERGROUND STORM DRAIN 12-INCH DIAMETER UNLESS NOTED OTHERWISE.

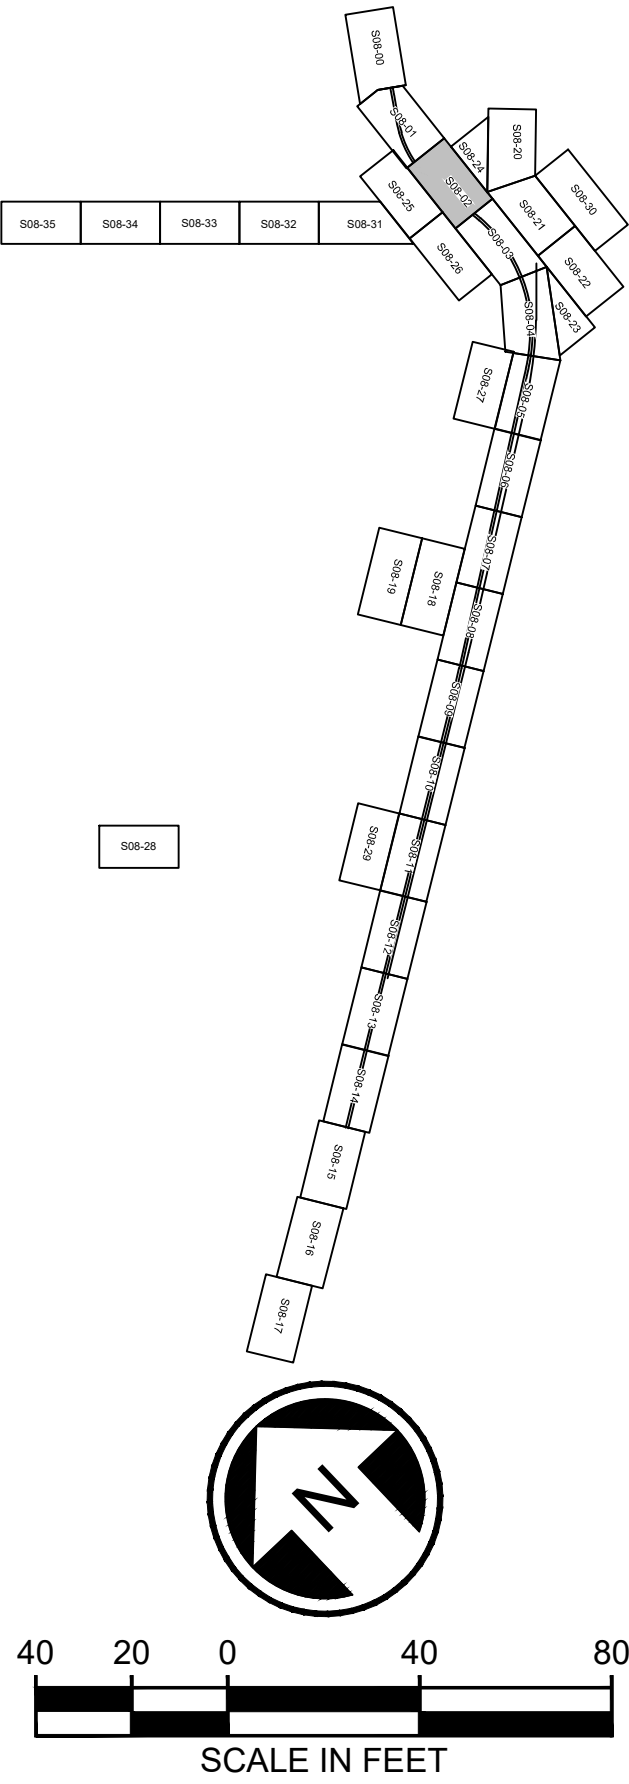


NOT FOR
CONSTRUCTION


02/21/24 | 4:18 PM | WILLIBRE
C:\PWORKING\WEST01\2780562\OMFS-S08-CDP101-118.DWG

Refer to the plan set COVER drawing
for disclaimers regarding this drawing.

REFERENCE CONCEPT DRAWINGS						AHJ:		PACKAGE #																											
<table><tr><td>No.</td><td>DATE</td><td>DSN</td><td>CHK</td><td>APP</td><td>REVISION</td></tr><tr><td> </td><td> </td><td> </td><td> </td><td> </td><td> </td></tr><tr><td> </td><td> </td><td> </td><td> </td><td> </td><td> </td></tr><tr><td> </td><td> </td><td> </td><td> </td><td> </td><td> </td></tr></table>						No.	DATE	DSN	CHK	APP	REVISION																			DESIGNED BY: L. GRABOWSKI		SCALE: 1"=20'		DRAWING No.: S08-CDP103	
						No.	DATE	DSN	CHK	APP	REVISION																								
DRAWN BY: B. WILLIAMS		FILENAME: OMFS-S08-CDP101-118																																	
CHECKED BY: J. WRIGHT		CONTRACT No.: AE-0030-17																																	
APPROVED BY: J.COOP		DATE: 2/27/2024																																	
SUBMITTED BY: PABLO LOPEZ-HILFIKER						DATE: 2/27/2024		REVIEWED BY:		DATE:		SOUND TRANSIT PRELIMINARY ENGINEERING PLANS OPERATIONS & MAINTENANCE FACILITY SOUTH CIVIL DRAINAGE PLAN STA 1510+00 TO STA 1515+00		FACILITY ID: S08																					
DATE: 2/27/2024						DATE: 2/27/2024		DATE:		DATE:		SHEET No.: 0		REV:																					

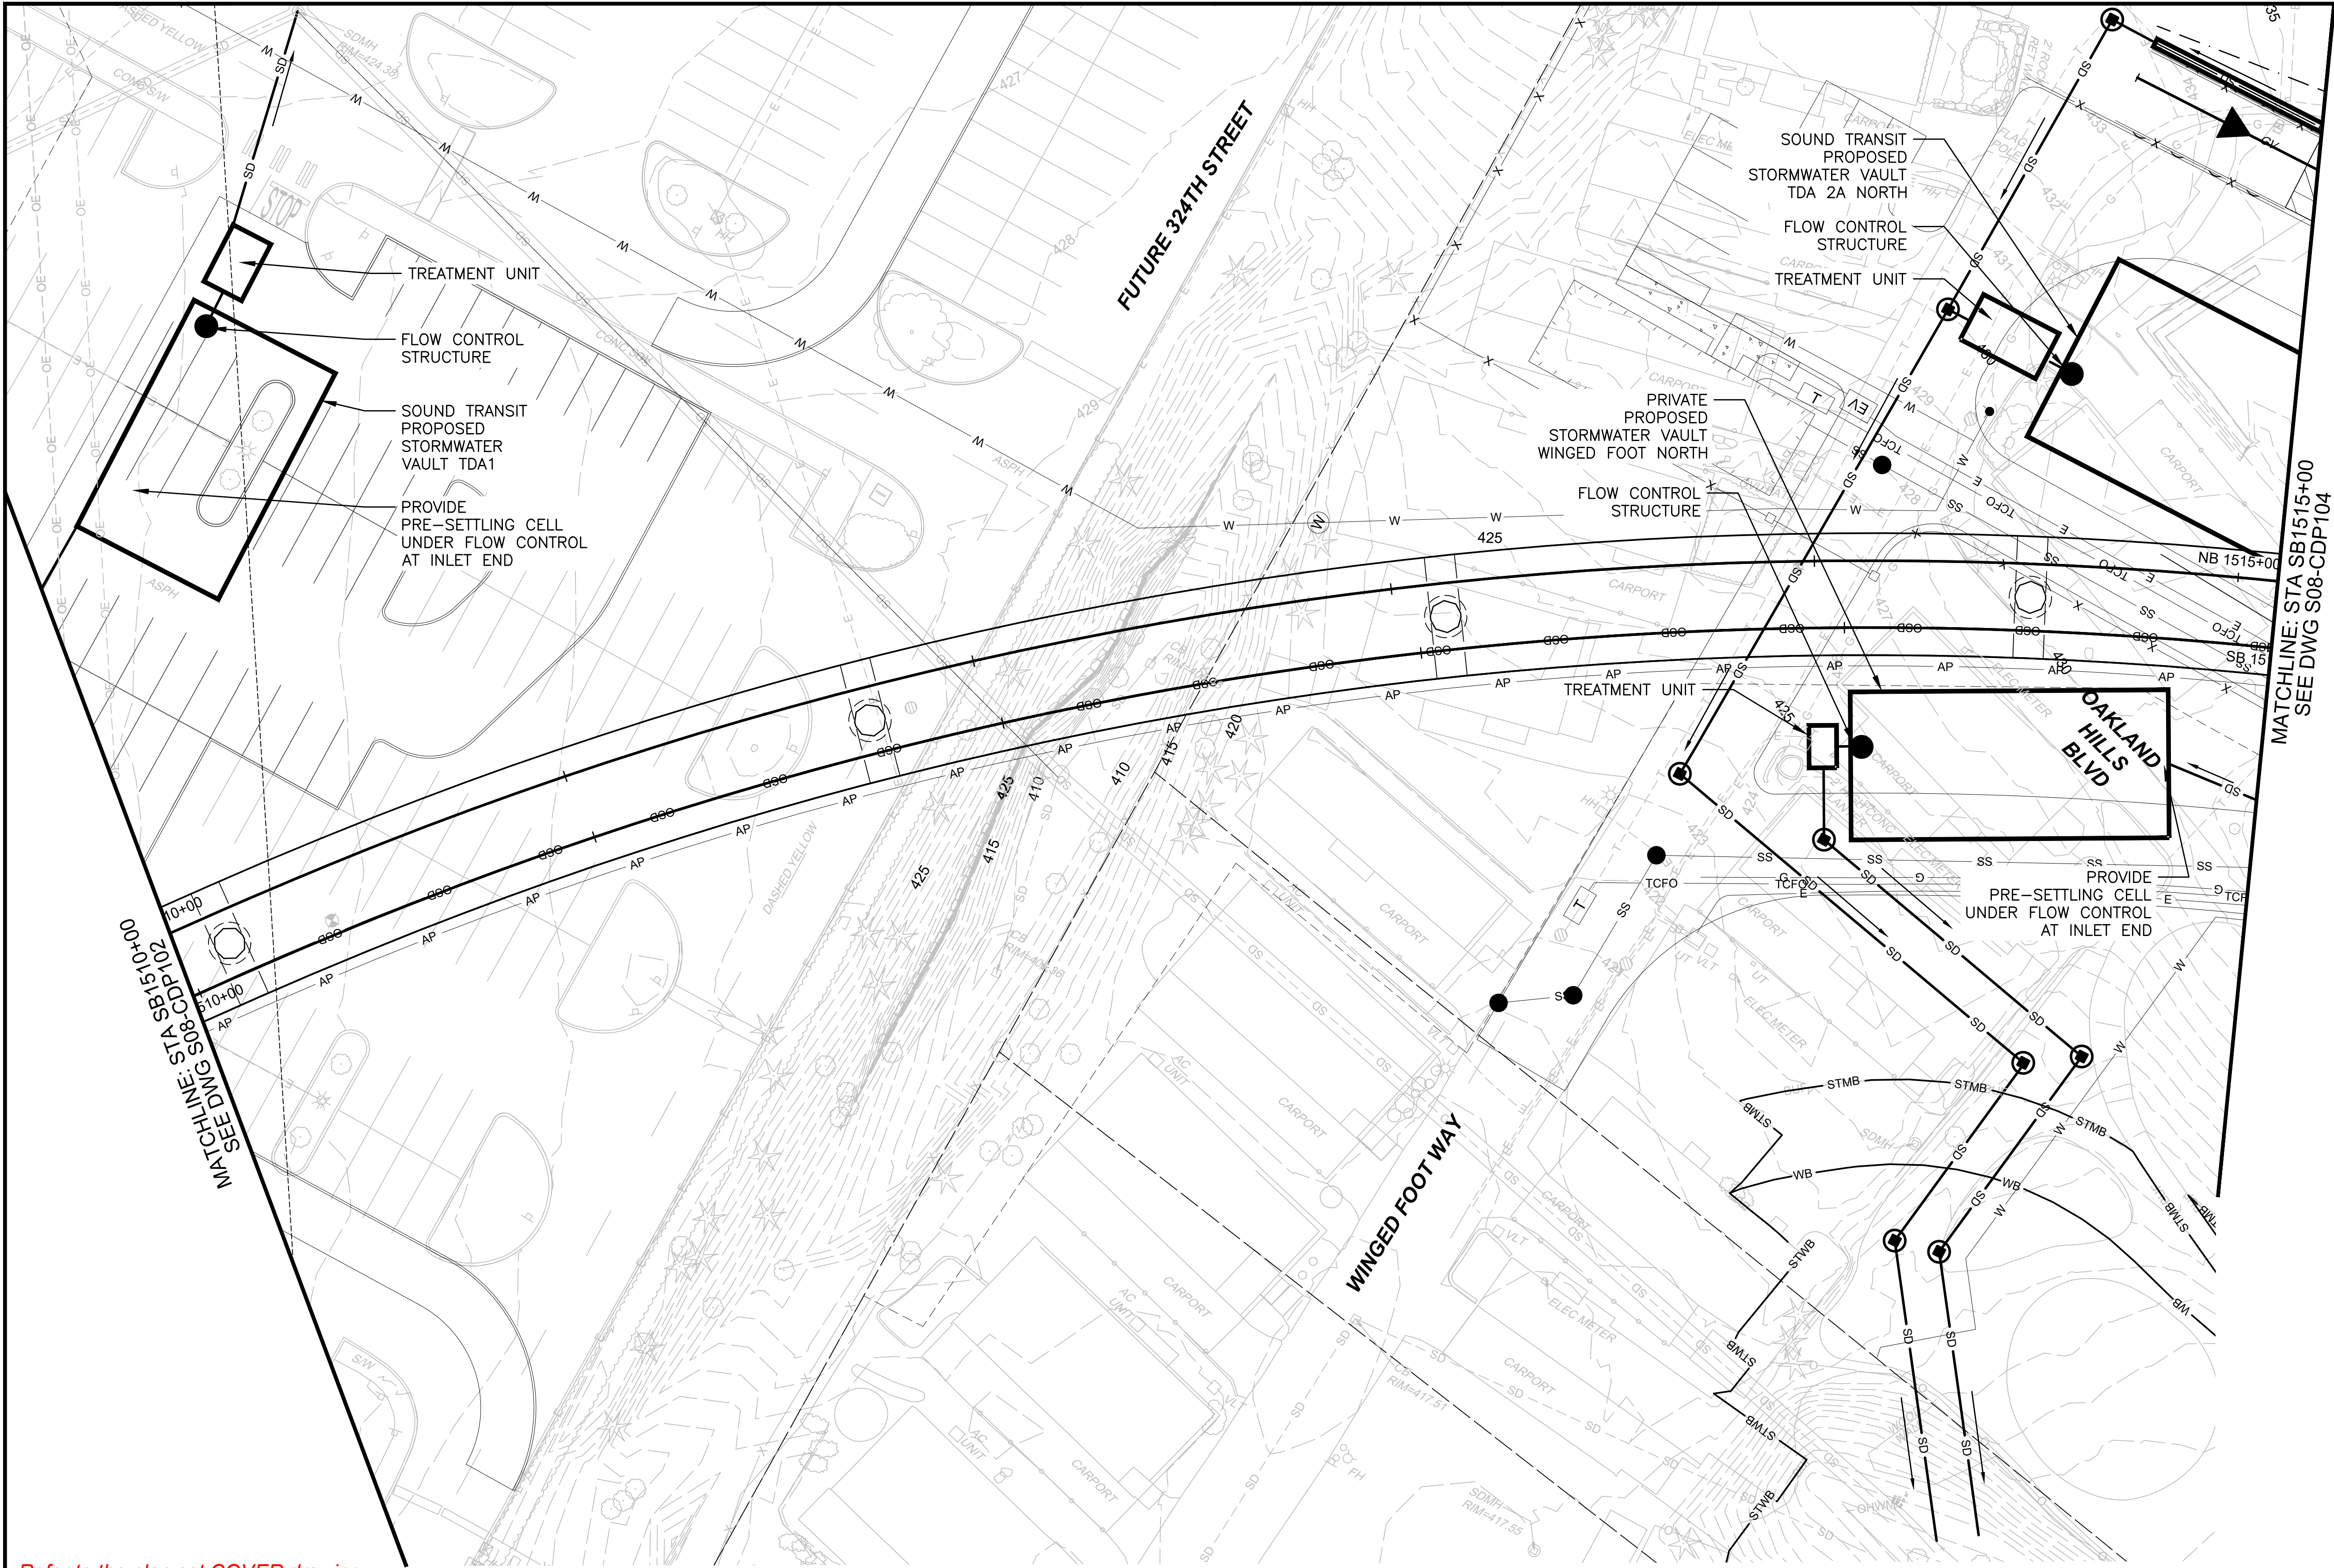

- NOTES:**
1. REMOVE EXISTING STORM DRAINS AND DRAINAGE STRUCTURES AT CONFLICTS WITH PROPOSED STORM DRAIN, PROPOSED DRAINAGE STRUCTURES, OR PROPOSED STORMWATER FACILITIES. RELOCATE STORM DRAINS OR REPLACE EXISTING DRAINAGE STRUCTURES AS REQUIRED.
 2. ALL PROPOSED UNDERGROUND STORM DRAIN 12-INCH DIAMETER UNLESS NOTED OTHERWISE.

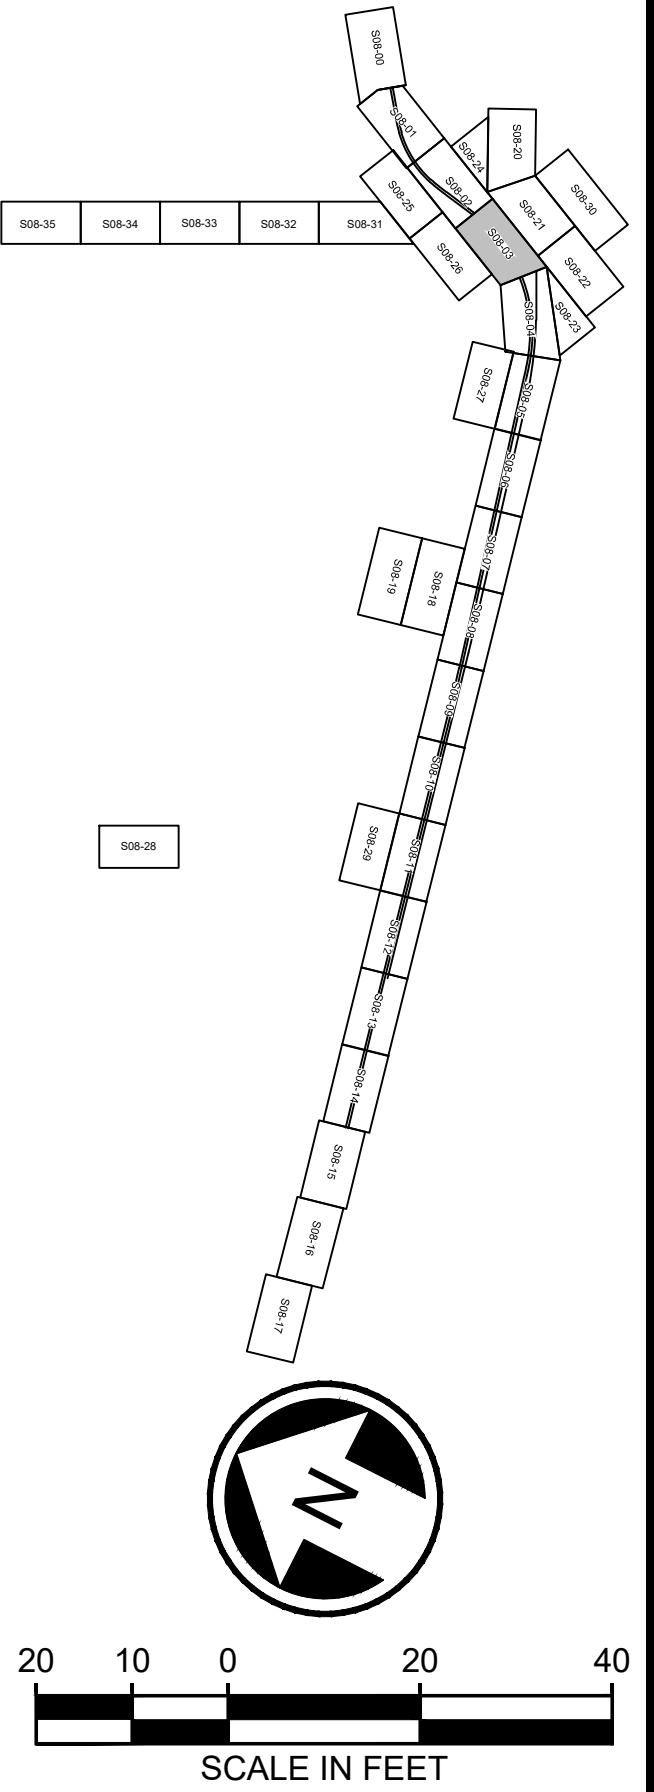

NOT FOR
CONSTRUCTION

MATCHLINE:
SEE DWG S08-CDP123

NOTES:

1. REMOVE EXISTING STORM DRAINS AND DRAINAGE STRUCTURES AT CONFLICTS WITH PROPOSED STORM DRAIN, PROPOSED DRAINAGE STRUCTURES, OR PROPOSED STORMWATER FACILITIES. RELOCATE STORM DRAINS OR REPLACE EXISTING DRAINAGE STRUCTURES AS REQUIRED.
2. ALL PROPOSED UNDERGROUND STORM DRAIN 12-INCH DIAMETER UNLESS NOTED OTHERWISE.


MATCHLINE: STA SB1515+00
SEE DWG S08-CDP103

MATCHLINE: STA SB1520+00
SEE DWG S08-CDP105

SOUND TRANSIT
PROPOSED
STORMWATER VAULT
TDA 2A NORTH

PROVIDE PRE-SETTLING
CELL UNDER FLOW
CONTROL AT INLET END

OAKLAND HILLS BLVD

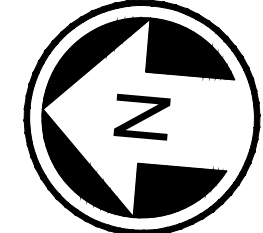



NOT FOR
CONSTRUCTION

Refer to the plan set COVER drawing
for disclaimers regarding this drawing.

REFERENCE CONCEPT DRAWINGS

No.	DATE	DSN	CHK	APP	REVISION

DESIGNED BY:
L. GRABOWSKI
DRAWN BY:
B. WILLIAMS
CHECKED BY:
J. WRIGHT
APPROVED BY:
J.COOP

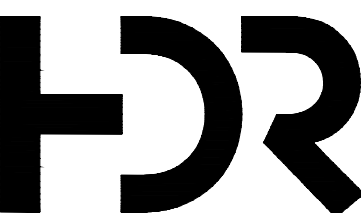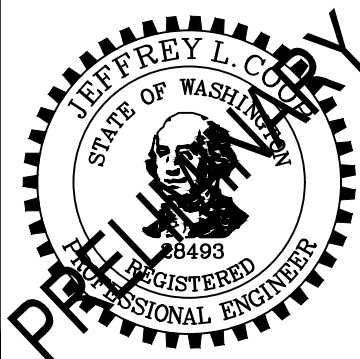

SUBMITTED BY:
PABLO LOPEZ-HILFIKER

DATE:
2/27/2024

REVIEWED BY:

LINE IS 1" AT
FULL SCALE



DATE:

PACKAGE #

SCALE:
1"=20'
FILENAME:
OMFS-S08-CDP101-118
CONTRACT No.:
AE-0030-17
DATE:
2/27/2024

SOUND TRANSIT
PRELIMINARY ENGINEERING PLANS
OPERATIONS & MAINTENANCE FACILITY SOUTH

CIVIL
DRAINAGE PLAN
STA 1515+00 TO STA 1520+00


DRAWING No.:
S08-CDP104
FACILITY ID:
S08
SHEET No.:
REV:
0

02/21/24 | 4:22 PM | WILLIBRE
C:\PWORKING\WEST01\2780562\OMFS-S08-CDP101-118.DWG


Refer to the plan set COVER drawing
for disclaimers regarding this drawing.

REFERENCE CONCEPT DRAWINGS					
No.	DATE	DSN	CHK	APP	REVISION

DESIGNED BY: L. GRABOWSKI
DRAWN BY: B. WILLIAMS
CHECKED BY: J. WRIGHT
APPROVED BY: J.COOP

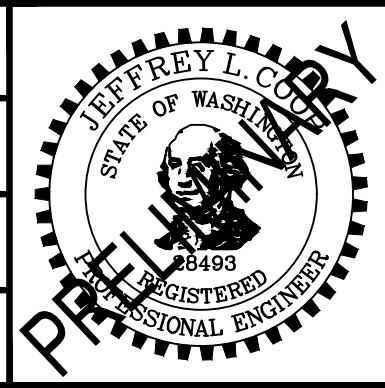


SUBMITTED BY: PABLO LOPEZ-HILFIKER	DATE: 2/27/2024	REVIEWED BY:
---------------------------------------	--------------------	--------------

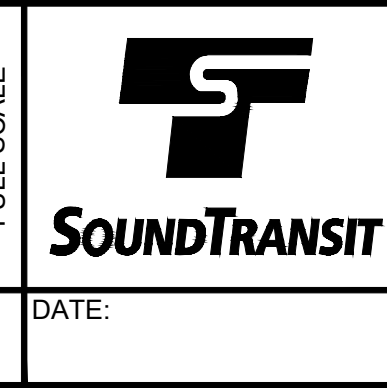

SCALE: 1"=20'
FILENAME: OMFS-S08-CDP101-118
CONTRACT No.: AE-0030-17
DATE: 2/27/2024

SOUND TRANSIT PRELIMINARY ENGINEERING PLANS OPERATIONS & MAINTENANCE FACILITY SOUTH
CIVIL DRAINAGE PLAN STA 1520+00 TO STA 1525+00

DRAWING No.: S08-CDP105
FACILITY ID: S08
SHEET No.: 0

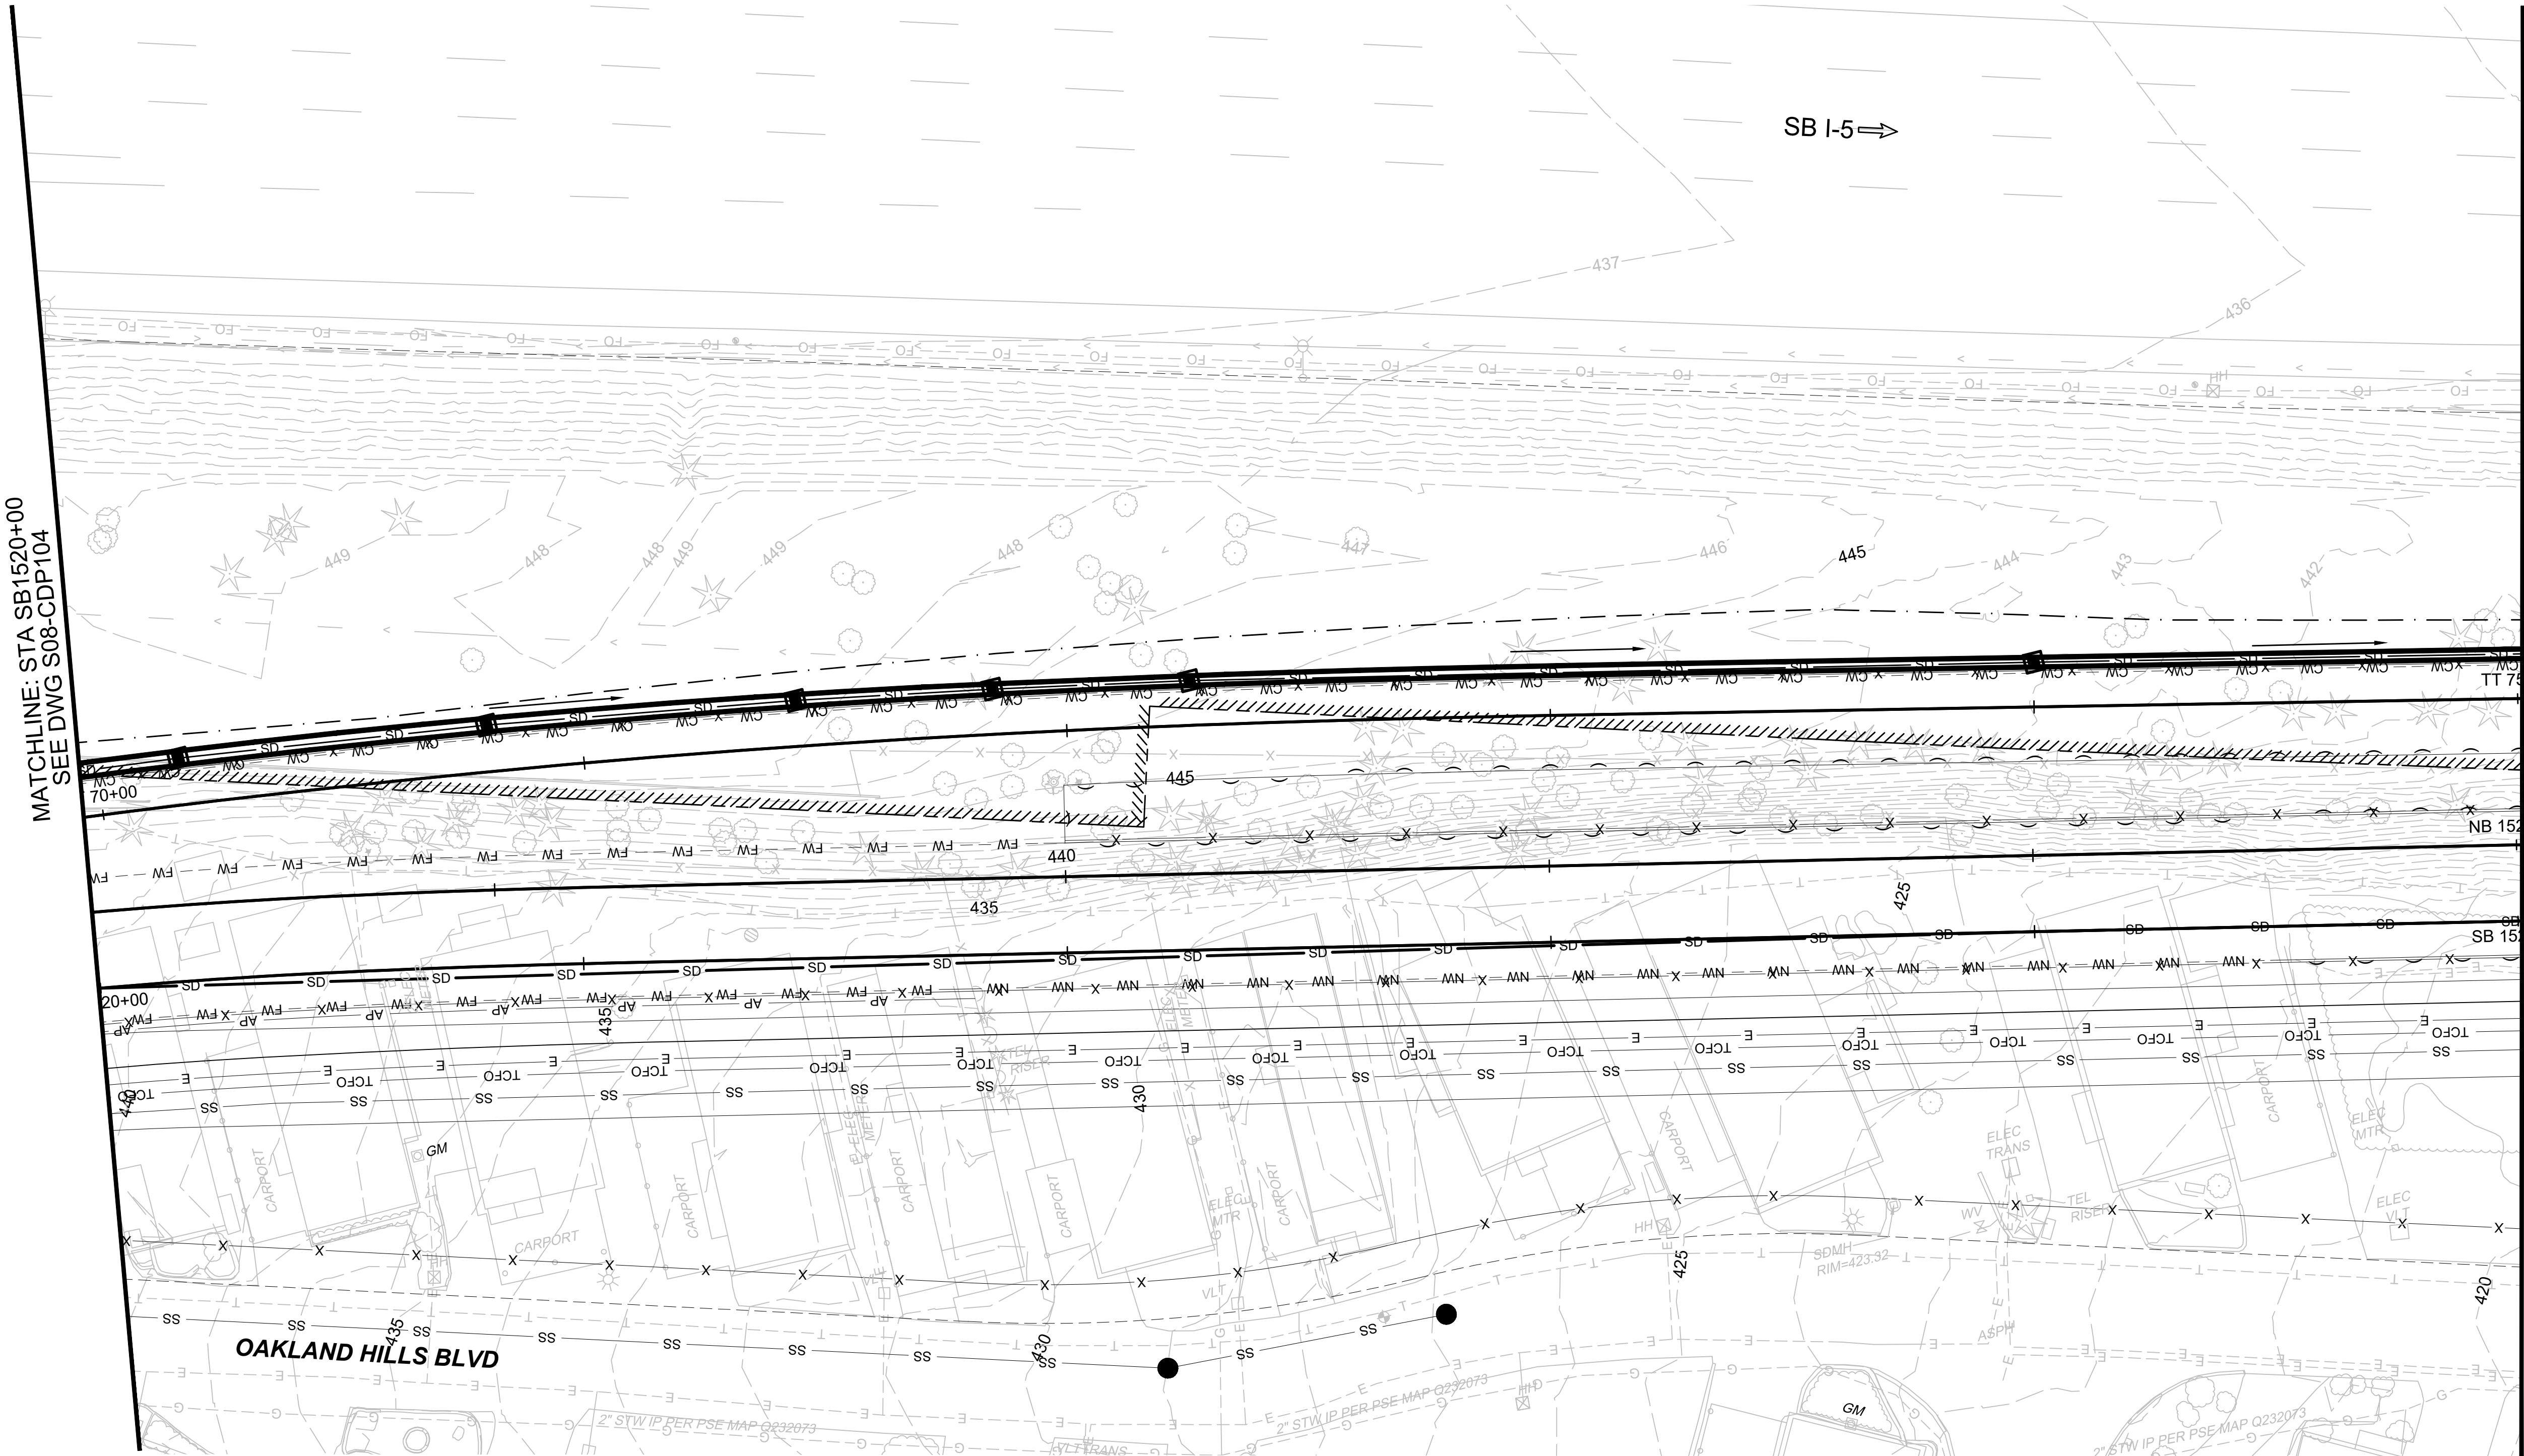


NOTES:

1. REMOVE EXISTING STORM DRAINS AND DRAINAGE STRUCTURES AT CONFLICTS WITH PROPOSED STORM DRAIN, PROPOSED DRAINAGE STRUCTURES, OR PROPOSED STORMWATER FACILITIES. RELOCATE STORM DRAINS OR REPLACE EXISTING DRAINAGE STRUCTURES AS REQUIRED.
2. ALL PROPOSED UNDERGROUND STORM DRAIN 12-INCH DIAMETER UNLESS NOTED OTHERWISE.

SCALE IN FEET

NOT FOR CONSTRUCTION

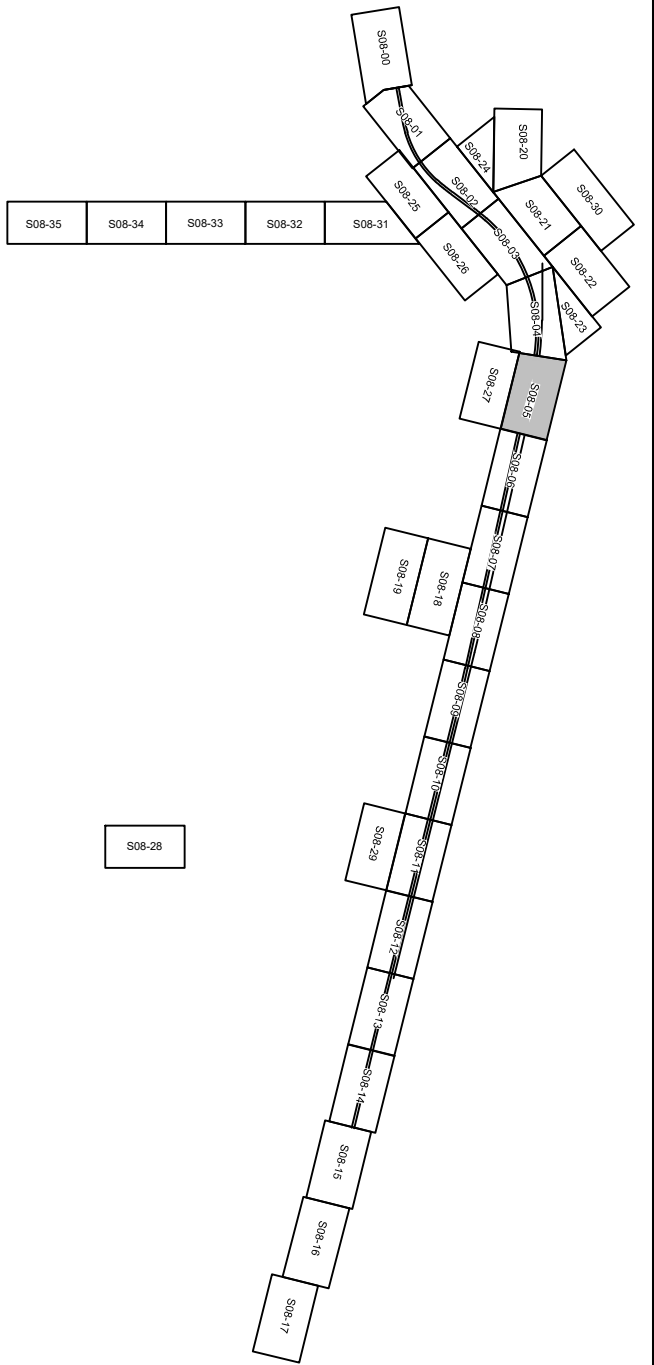


02/21/24 | 4:23 PM | WILLIBRE
C:\PWORKING\WEST01\2780562\OMFS-S08-CDP101-118.DWG

Refer to the plan set COVER drawing
for disclaimers regarding this drawing.

REFERENCE CONCEPT DRAWINGS					
No.	DATE	DSN	CHK	APP	REVISION

DESIGNED BY: L. GRABOWSKI
DRAWN BY: B. WILLIAMS
CHECKED BY: J. WRIGHT
APPROVED BY: J.COOP

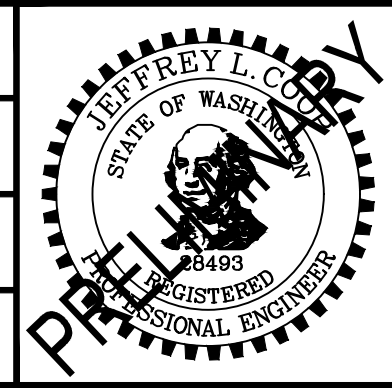

SUBMITTED BY:
PABLO LOPEZ-HILFIKER

DATE:
2/27/2024

REVIEWED BY:

DATE:

PACKAGE #

SCALE:
1"=20'

FILENAME:
OMFS-S08-CDP101-118


CONTRACT No.:
AE-0030-17

DATE:
2/27/2024

SOUND TRANSIT
PRELIMINARY ENGINEERING PLANS
OPERATIONS & MAINTENANCE FACILITY SOUTH

CIVIL
DRAINAGE PLAN
STA 1525+00 TO STA 1530+00

DRAWING No.: S08-CDP106
FACILITY ID: S08
SHEET No.: 0
REV:

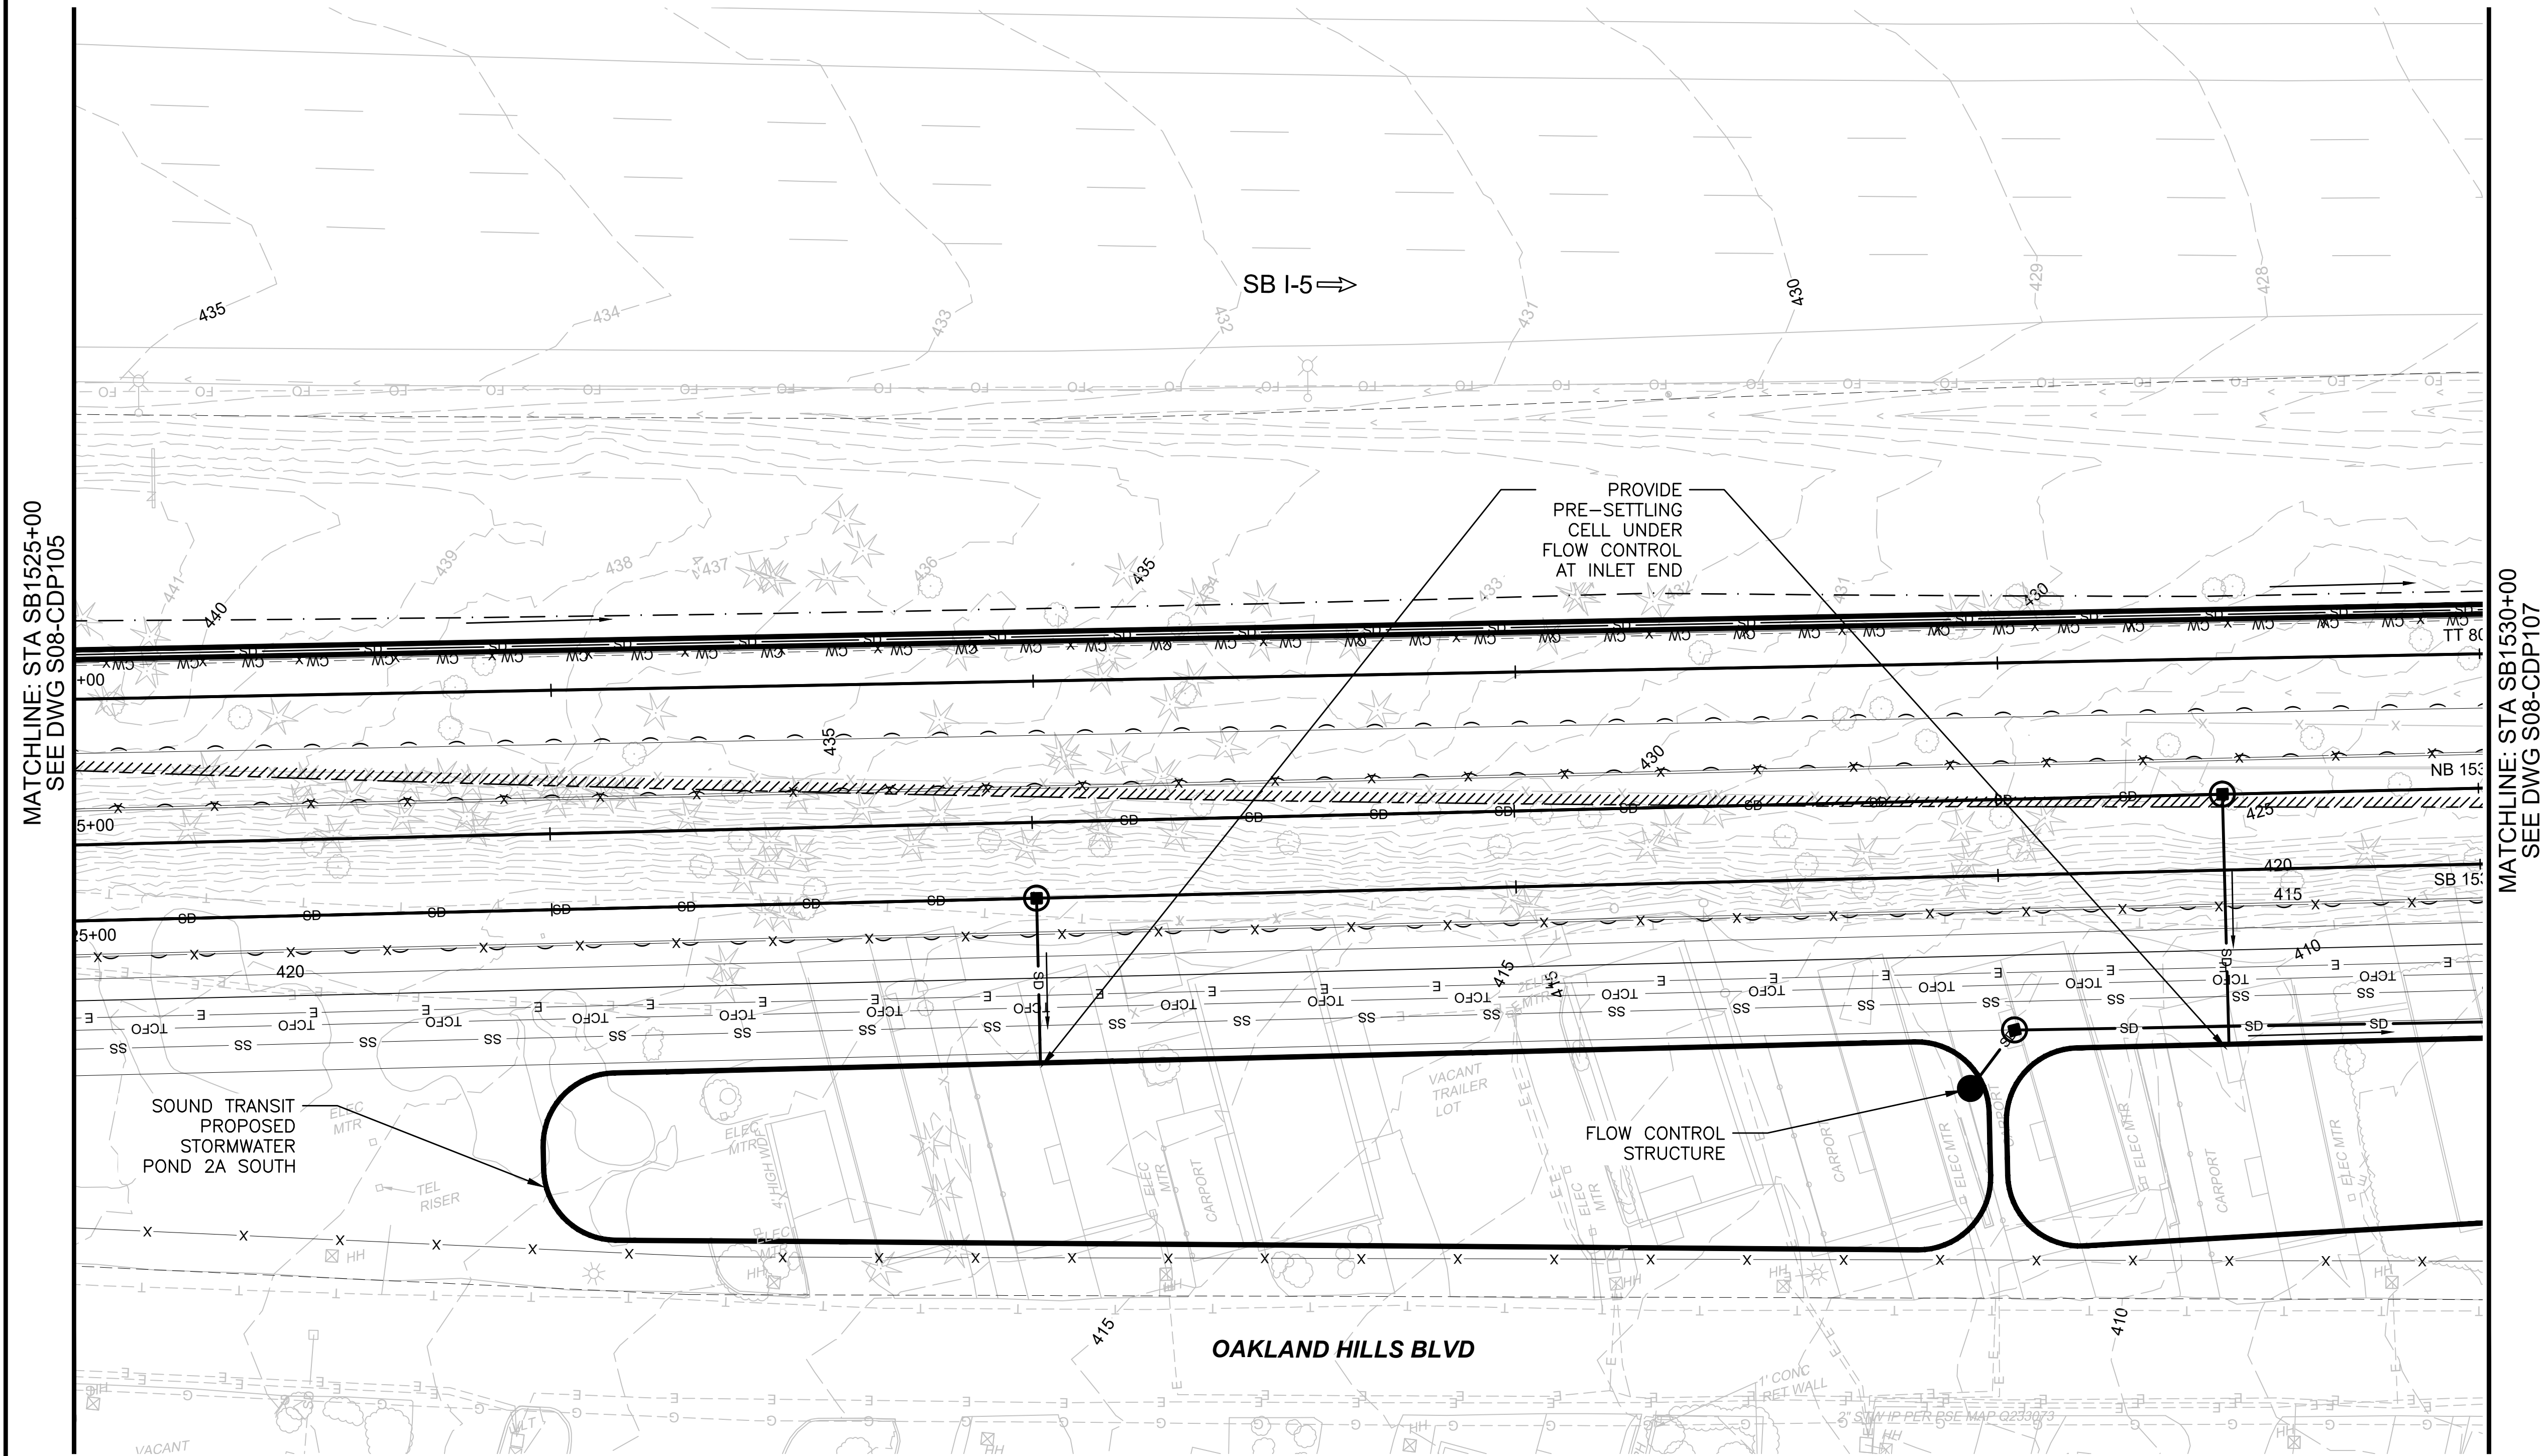


- NOTES:**
- REMOVE EXISTING STORM DRAINS AND DRAINAGE STRUCTURES AT CONFLICTS WITH PROPOSED STORM DRAIN, PROPOSED DRAINAGE STRUCTURES, OR PROPOSED STORMWATER FACILITIES. RELOCATE STORM DRAINS OR REPLACE EXISTING DRAINAGE STRUCTURES AS REQUIRED.
 - ALL PROPOSED UNDERGROUND STORM DRAIN 12-INCH DIAMETER UNLESS NOTED OTHERWISE.

SCALE IN FEET

NOT FOR
CONSTRUCTION

1. REMOVE EXISTING STORM DRAINS AND DRAINAGE STRUCTURES AT CONFLICTS WITH PROPOSED STORM DRAIN, PROPOSED DRAINAGE STRUCTURES, OR PROPOSED STORMWATER FACILITIES. RELOCATE STORM DRAINS OR REPLACE EXISTING DRAINAGE STRUCTURES AS REQUIRED.

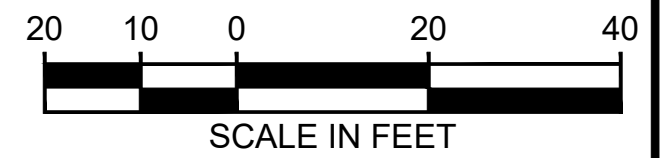[illegible]

1111

SCALE:


0

02/21/24 | 4:27 PM | WILLIBRE
C:\PWORKING\WEST01\2780562\OMFS-S08-CDP101-118.DWG

Refer to the plan set COVER drawing
for disclaimers regarding this drawing.

REFERENCE CONCEPT DRAWINGS					
No.	DATE	DSN	CHK	APP	REVISION

DESIGNED BY:	L. GRABOWSKI
DRAWN BY:	B. WILLIAMS
CHECKED BY:	J. WRIGHT
APPROVED BY:	J.COOP

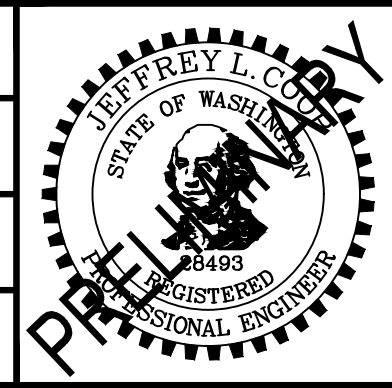

SUBMITTED BY:
PABLO LOPEZ-HILFIKER

DATE:
2/27/2024

REVIEWED BY:




DATE:

PACKAGE #	
SCALE:	1"=20'
FILENAME:	OMFS-S08-CDP101-118
CONTRACT No.:	AE-0030-17
DATE:	2/27/2024

SOUND TRANSIT PRELIMINARY ENGINEERING PLANS OPERATIONS & MAINTENANCE FACILITY SOUTH	
CIVIL DRAINAGE PLAN STA 1535+00 TO STA 1540+00	


DRAWING No.:	S08-CDP108
FACILITY ID:	S08
SHEET No.:	REV:
	0

MATCHLINE: STA SB1535+00
SEE DWG S08-CDP107

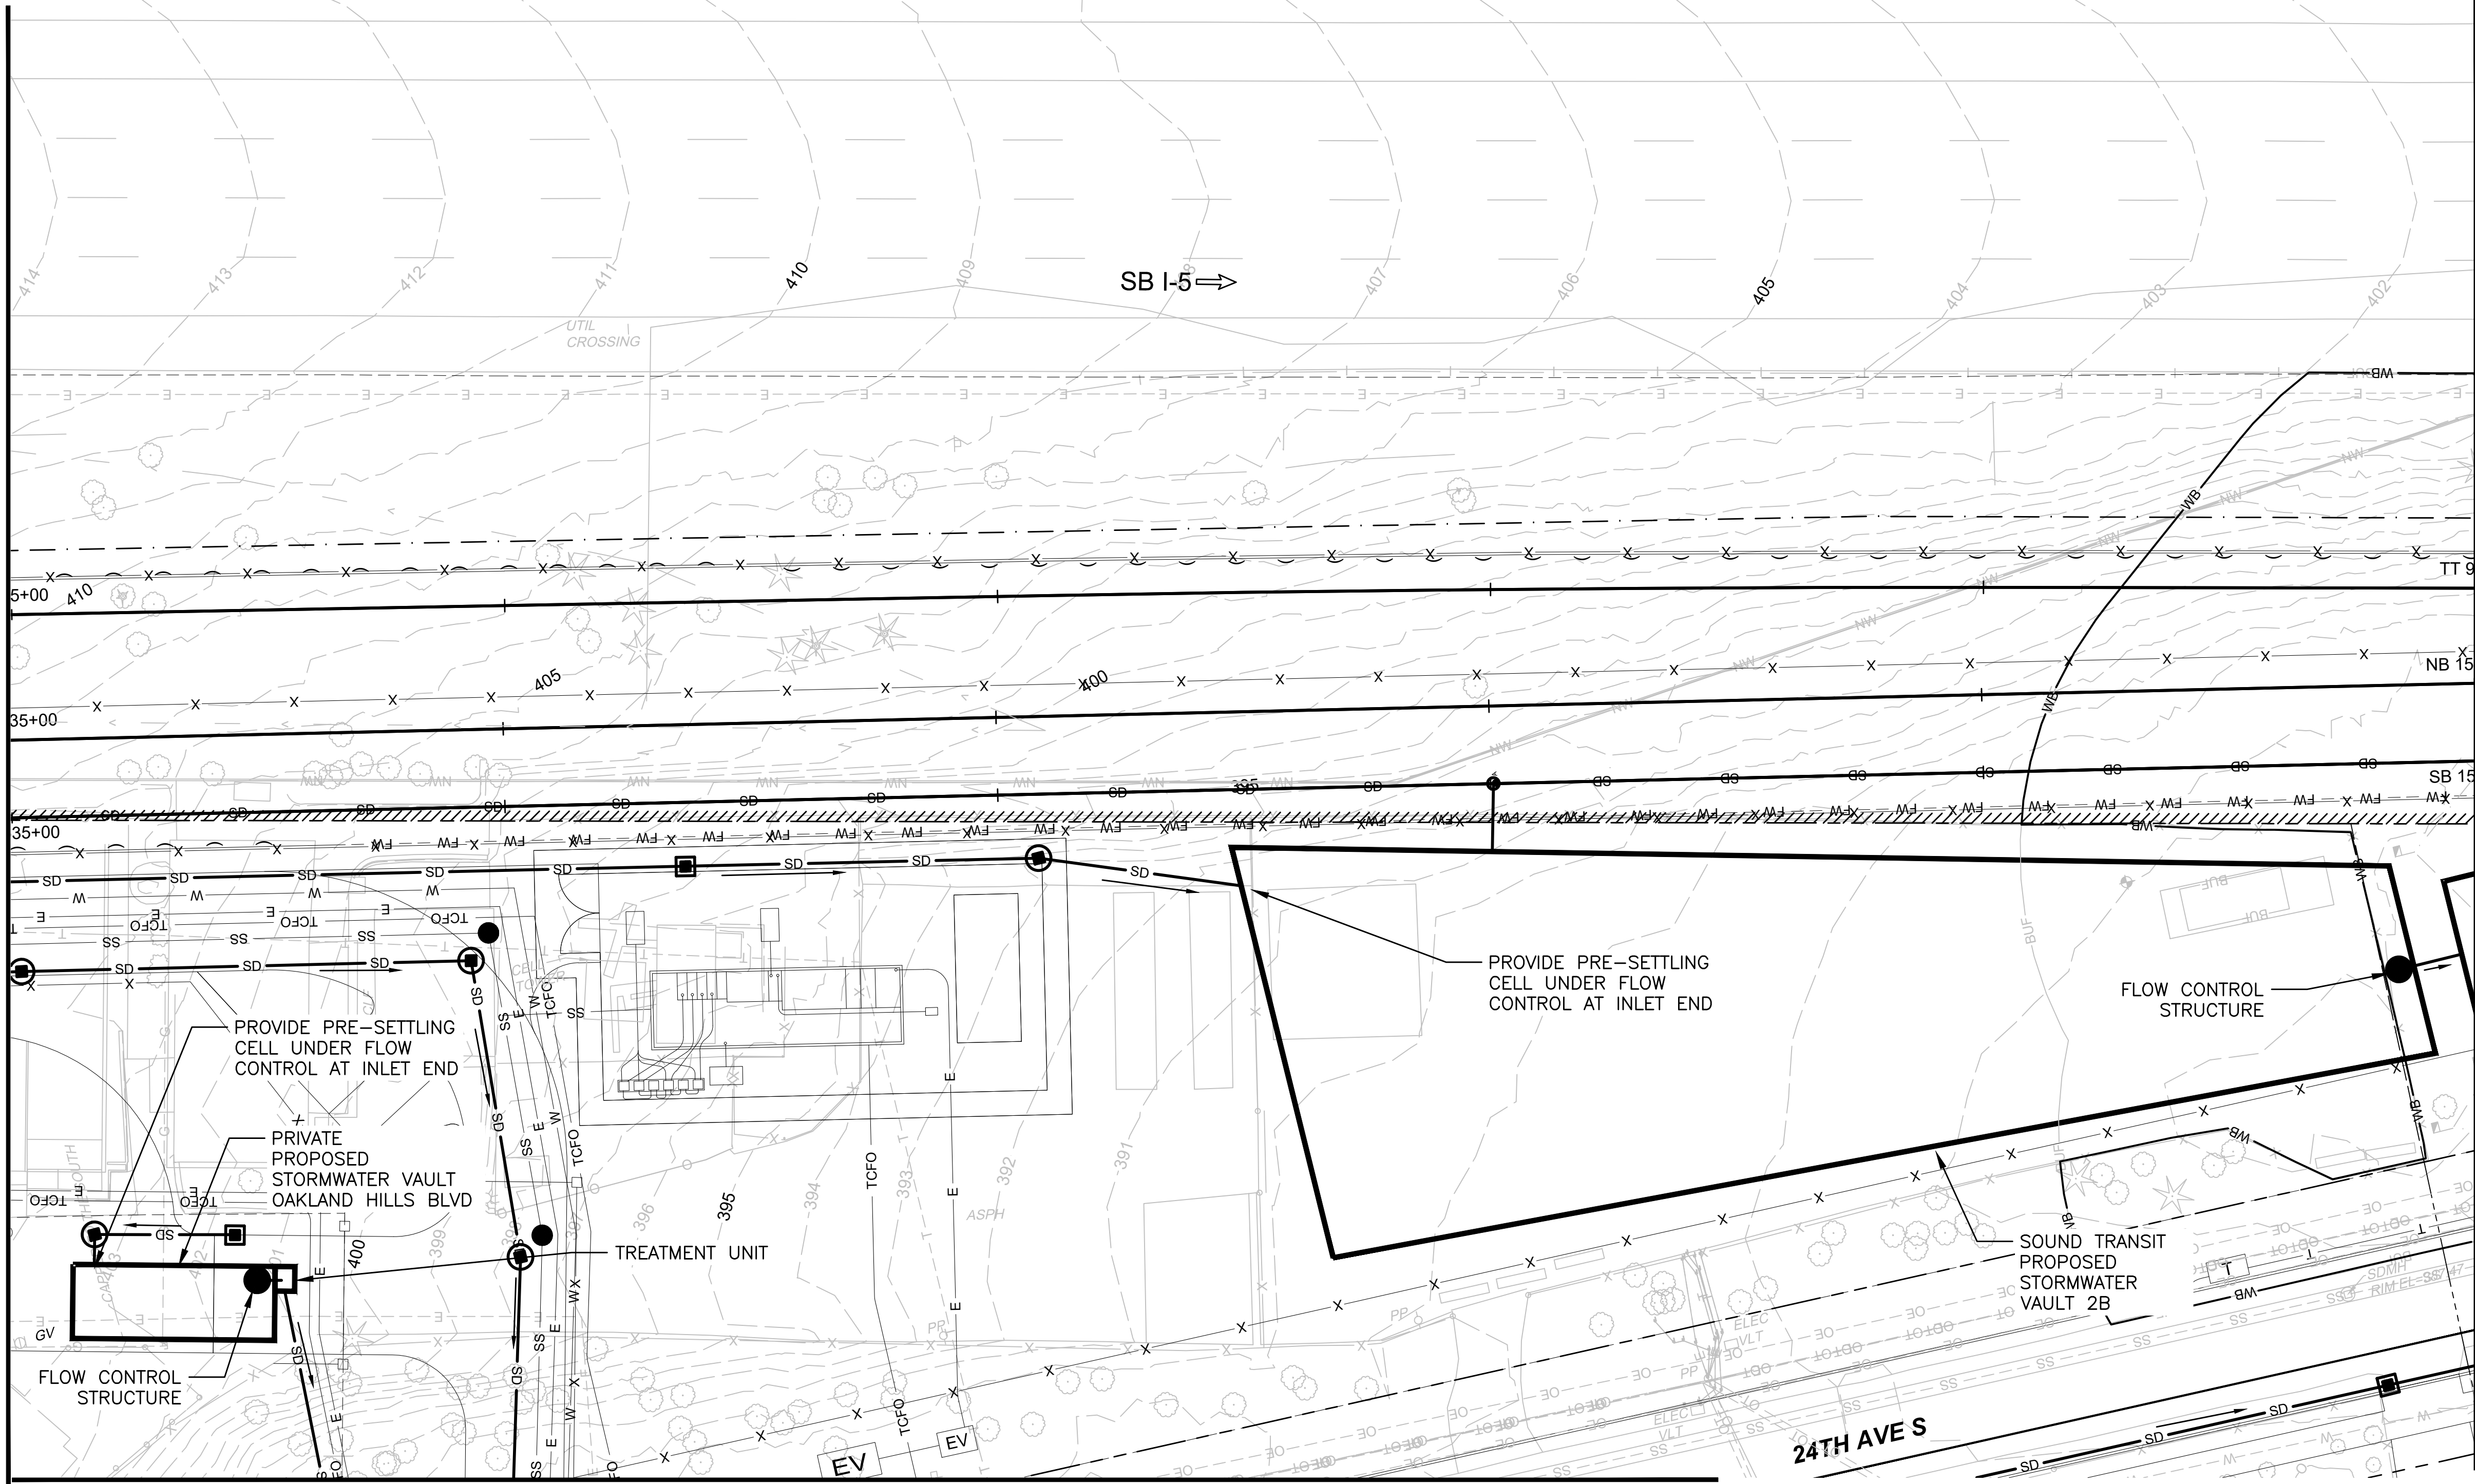

MATCHLINE: STA SB1540+00
SEE DWG S08-CDP109

- NOTES:**
1. REMOVE EXISTING STORM DRAINS AND DRAINAGE STRUCTURES AT CONFLICTS WITH PROPOSED STORM DRAIN, PROPOSED DRAINAGE STRUCTURES, OR PROPOSED STORMWATER FACILITIES. RELOCATE STORM DRAINS OR REPLACE EXISTING DRAINAGE STRUCTURES AS REQUIRED.
 2. ALL PROPOSED UNDERGROUND STORM DRAIN 12-INCH DIAMETER UNLESS NOTED OTHERWISE.

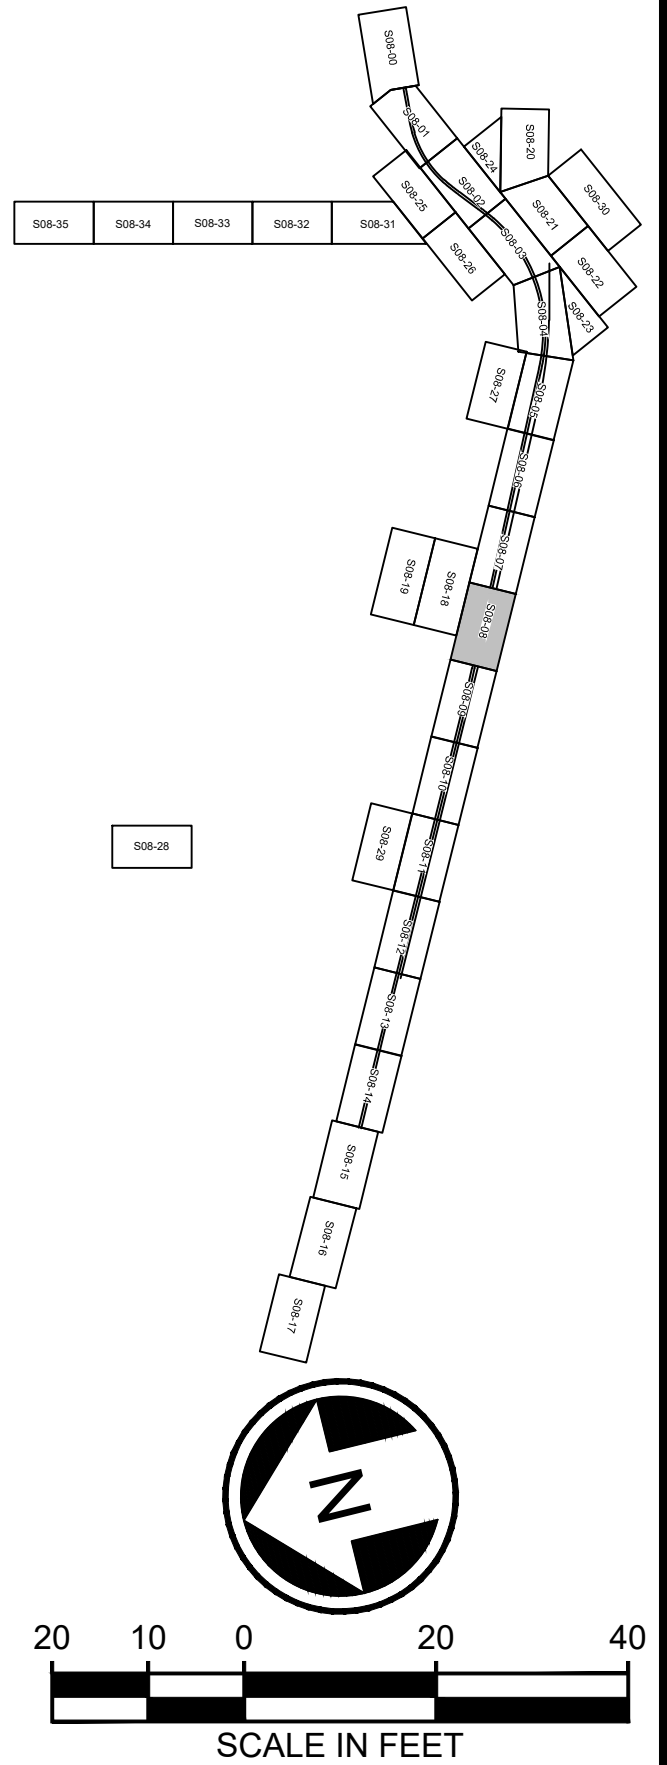


NOT FOR
CONSTRUCTION

02/21/24 | 4:29 PM | WILLIBRE
C:\P\WORKING\WEST01\2780562\OMFS-S08-CDP101-118.DWG

Refer to the plan set COVER drawing
for disclaimers regarding this drawing.

REFERENCE CONCEPT DRAWINGS					
No.	DATE	DSN	CHK	APP	REVISION

DESIGNED BY:	L. GRABOWSKI
DRAWN BY:	B. WILLIAMS
CHECKED BY:	J. WRIGHT
APPROVED BY:	J.COOP

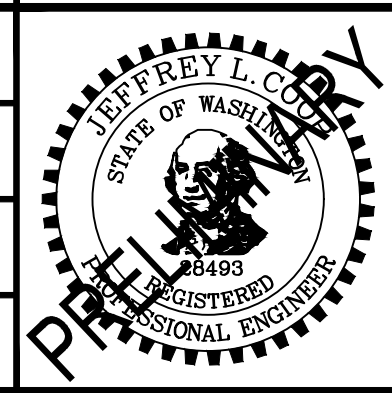

SUBMITTED BY:
PABLO LOPEZ-HILFIKER

DATE:
2/27/2024

REVIEWED BY:




DATE:

PACKAGE #
SCALE: 1"=20'
FILENAME: OMFS-S08-CDP101-118
CONTRACT No.: AE-0030-17
DATE: 2/27/2024

SOUND TRANSIT PRELIMINARY ENGINEERING PLANS OPERATIONS & MAINTENANCE FACILITY SOUTH
CIVIL DRAINAGE PLAN STA 1540+00 TO STA 1545+00


DRAWING No.: S08-CDP109
FACILITY ID: S08
SHEET No.: REV: 0

MATCHLINE: STA SB1540+00
SEE DWG S08-CDP108

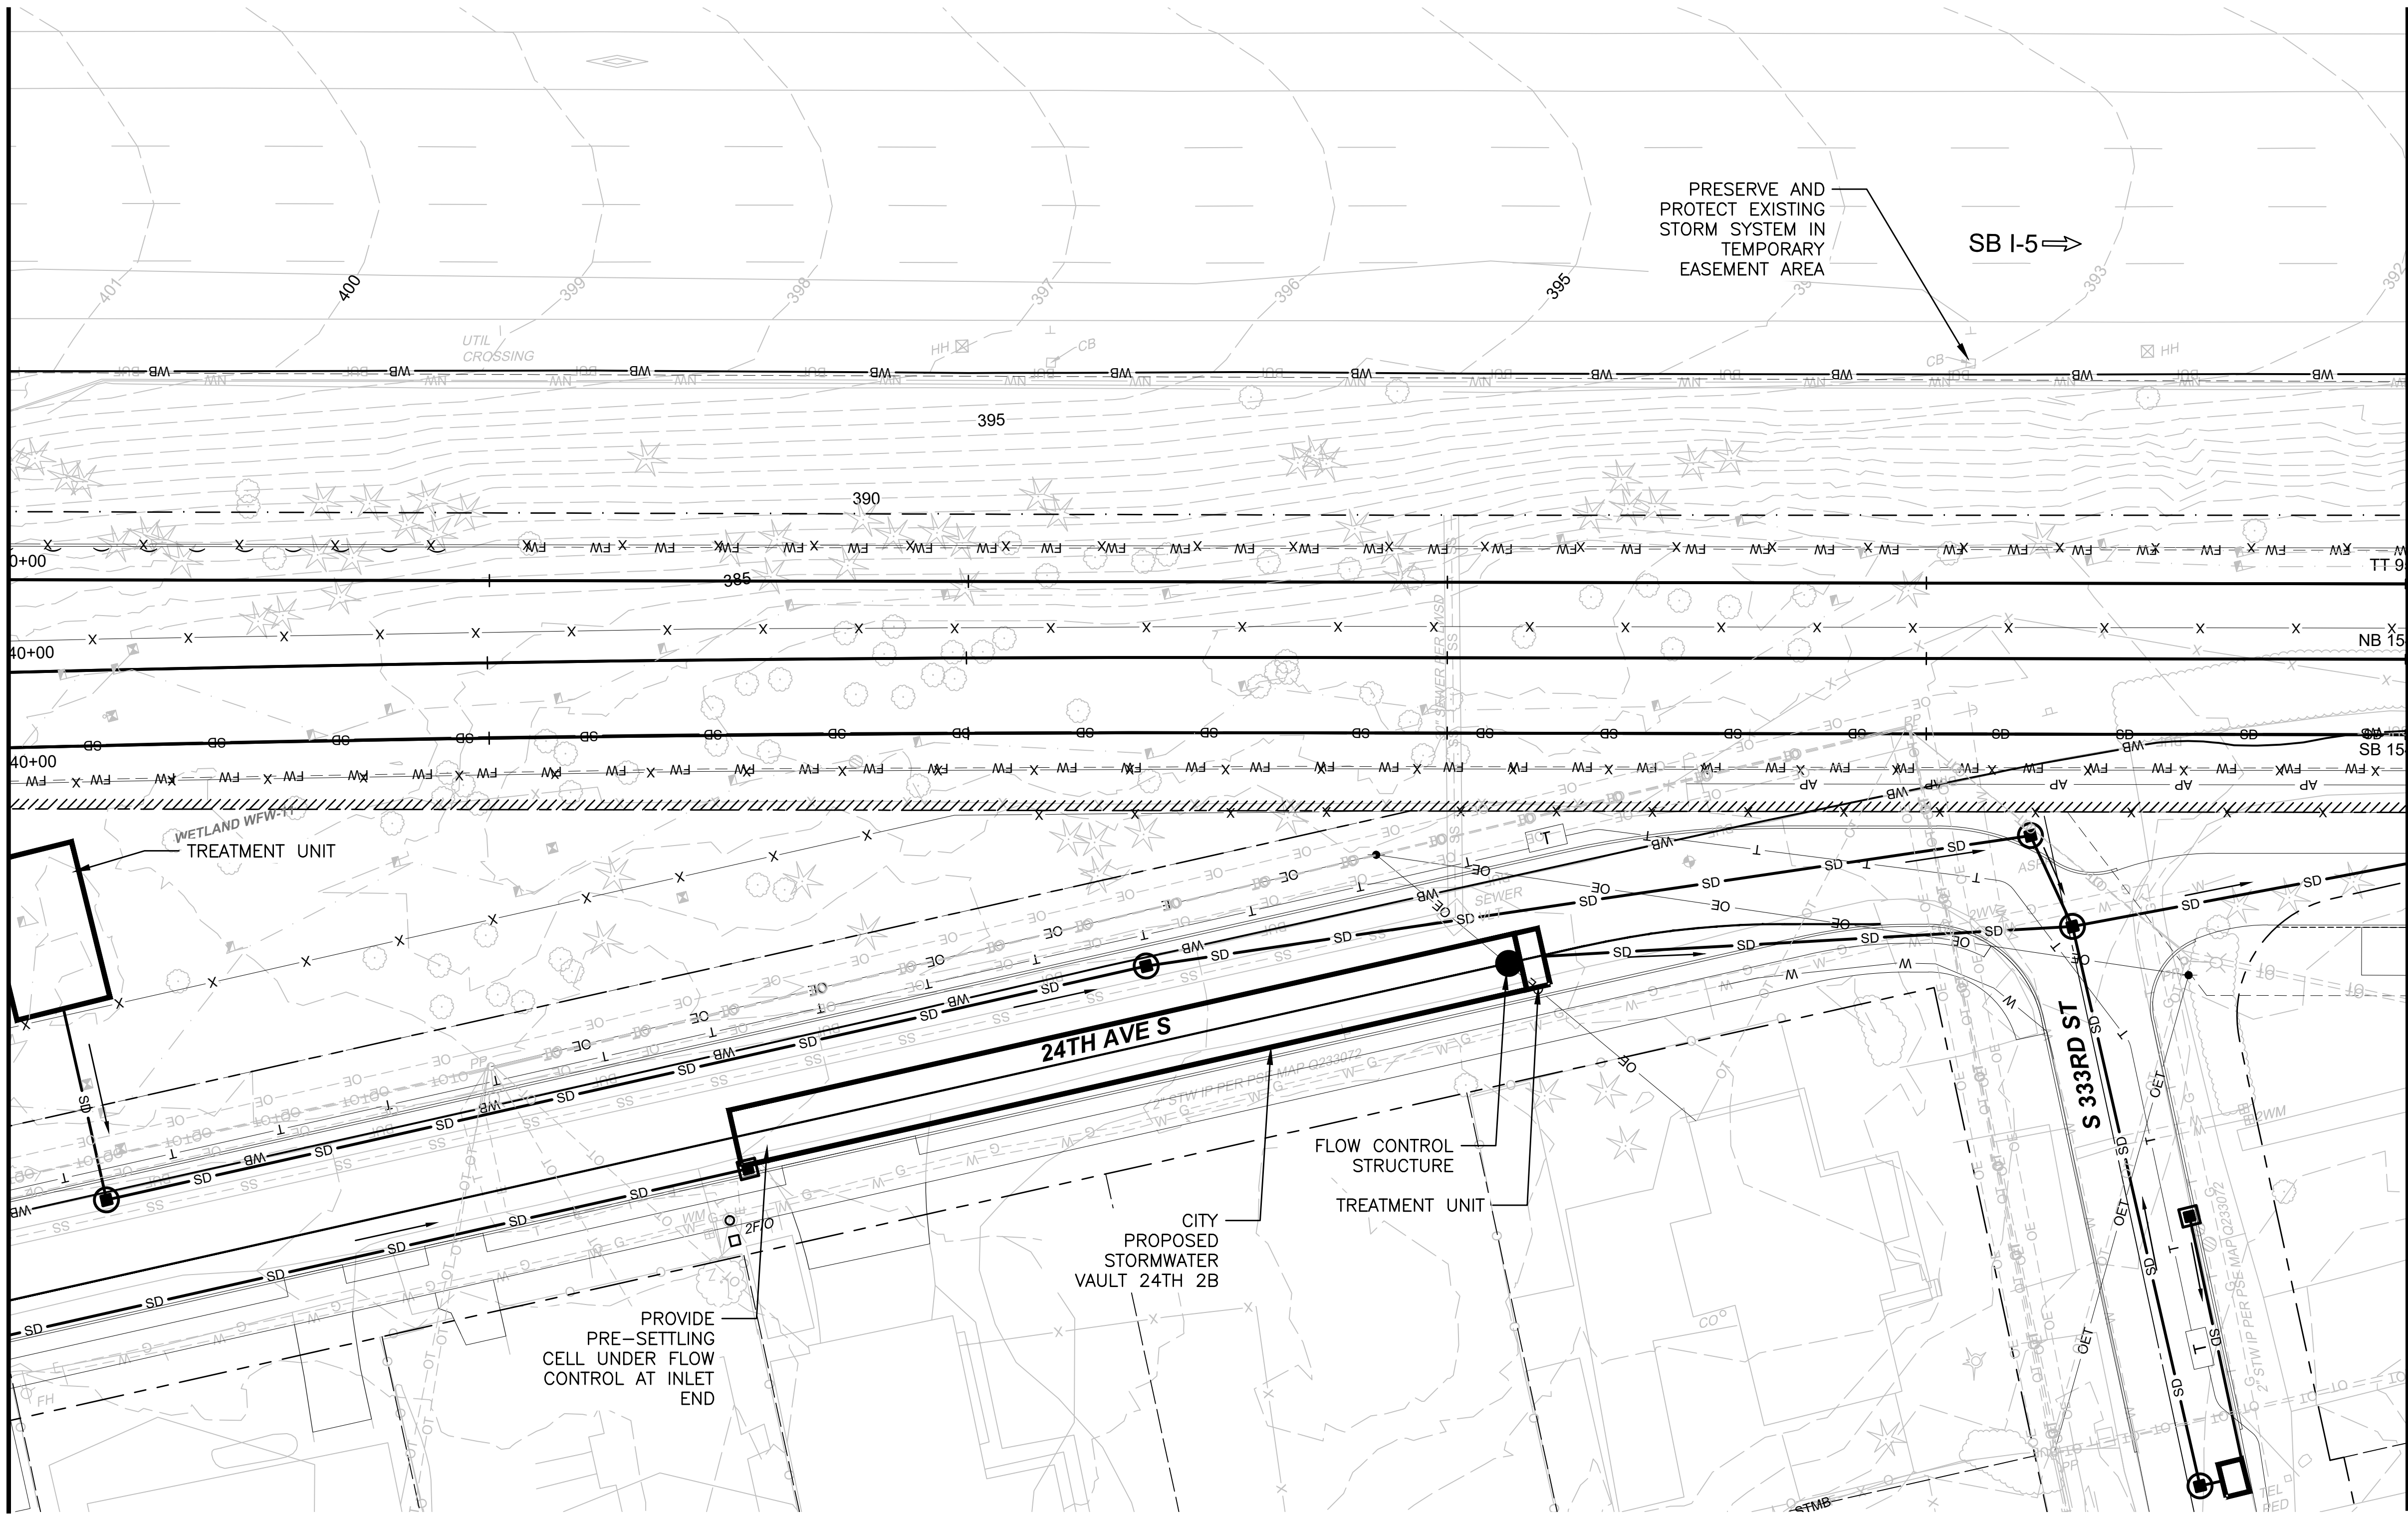

MATCHLINE: STA SB1545+00
SEE DWG S08-CDP110


- NOTES:**
1. REMOVE EXISTING STORM DRAINS AND DRAINAGE STRUCTURES AT CONFLICTS WITH PROPOSED STORM DRAIN, PROPOSED DRAINAGE STRUCTURES, OR PROPOSED STORMWATER FACILITIES. RELOCATE STORM DRAINS OR REPLACE EXISTING DRAINAGE STRUCTURES AS REQUIRED.
 2. ALL PROPOSED UNDERGROUND STORM DRAIN 12-INCH DIAMETER UNLESS NOTED OTHERWISE.

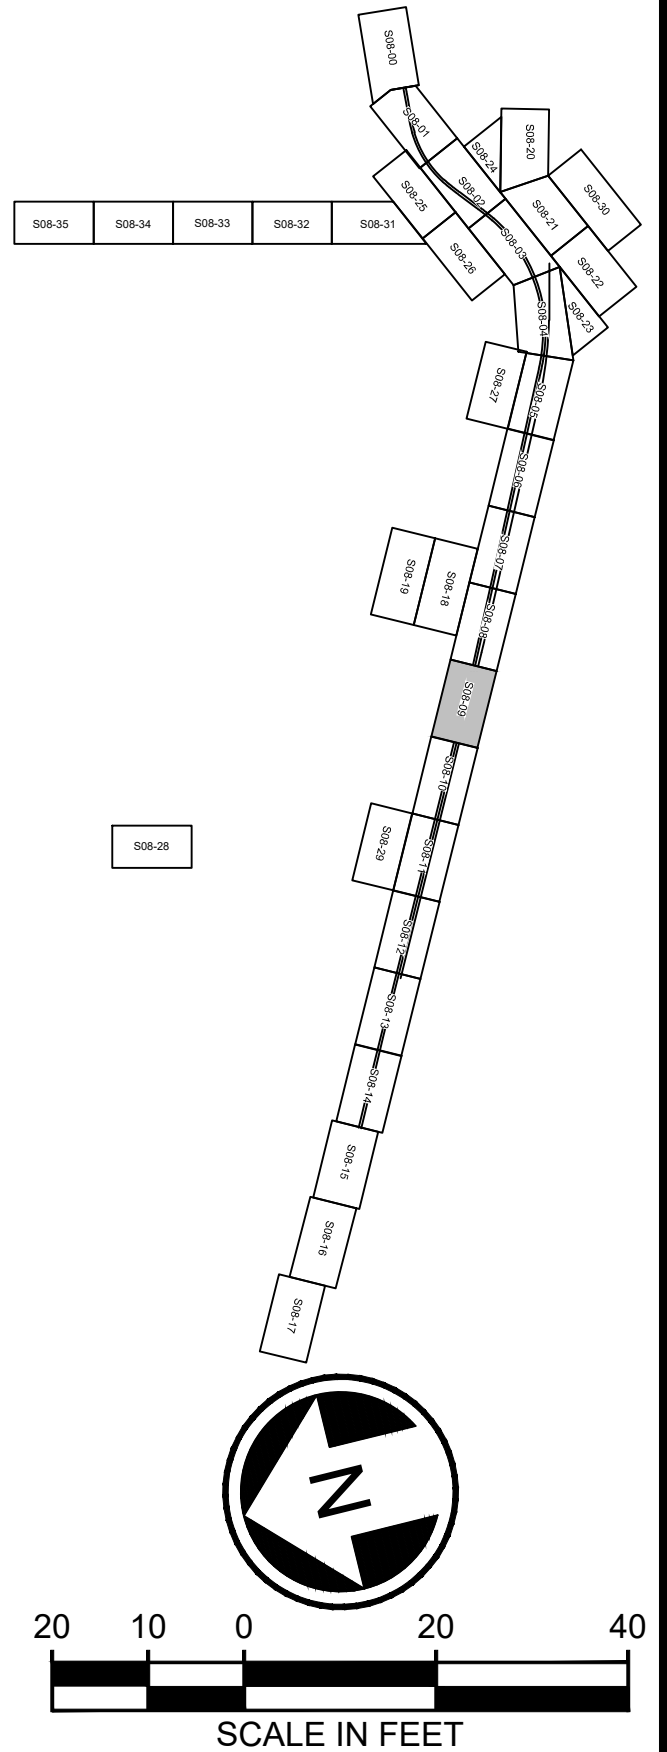


NOT FOR
CONSTRUCTION

02/23/24 | 9:17 AM | WILLIBRE
C:\PWORKING\WEST01\D278052\OMFS-S08-CDP101-122.DWG

MATCHLINE: STA SB1545+00
SEE DWG S08-CDP109

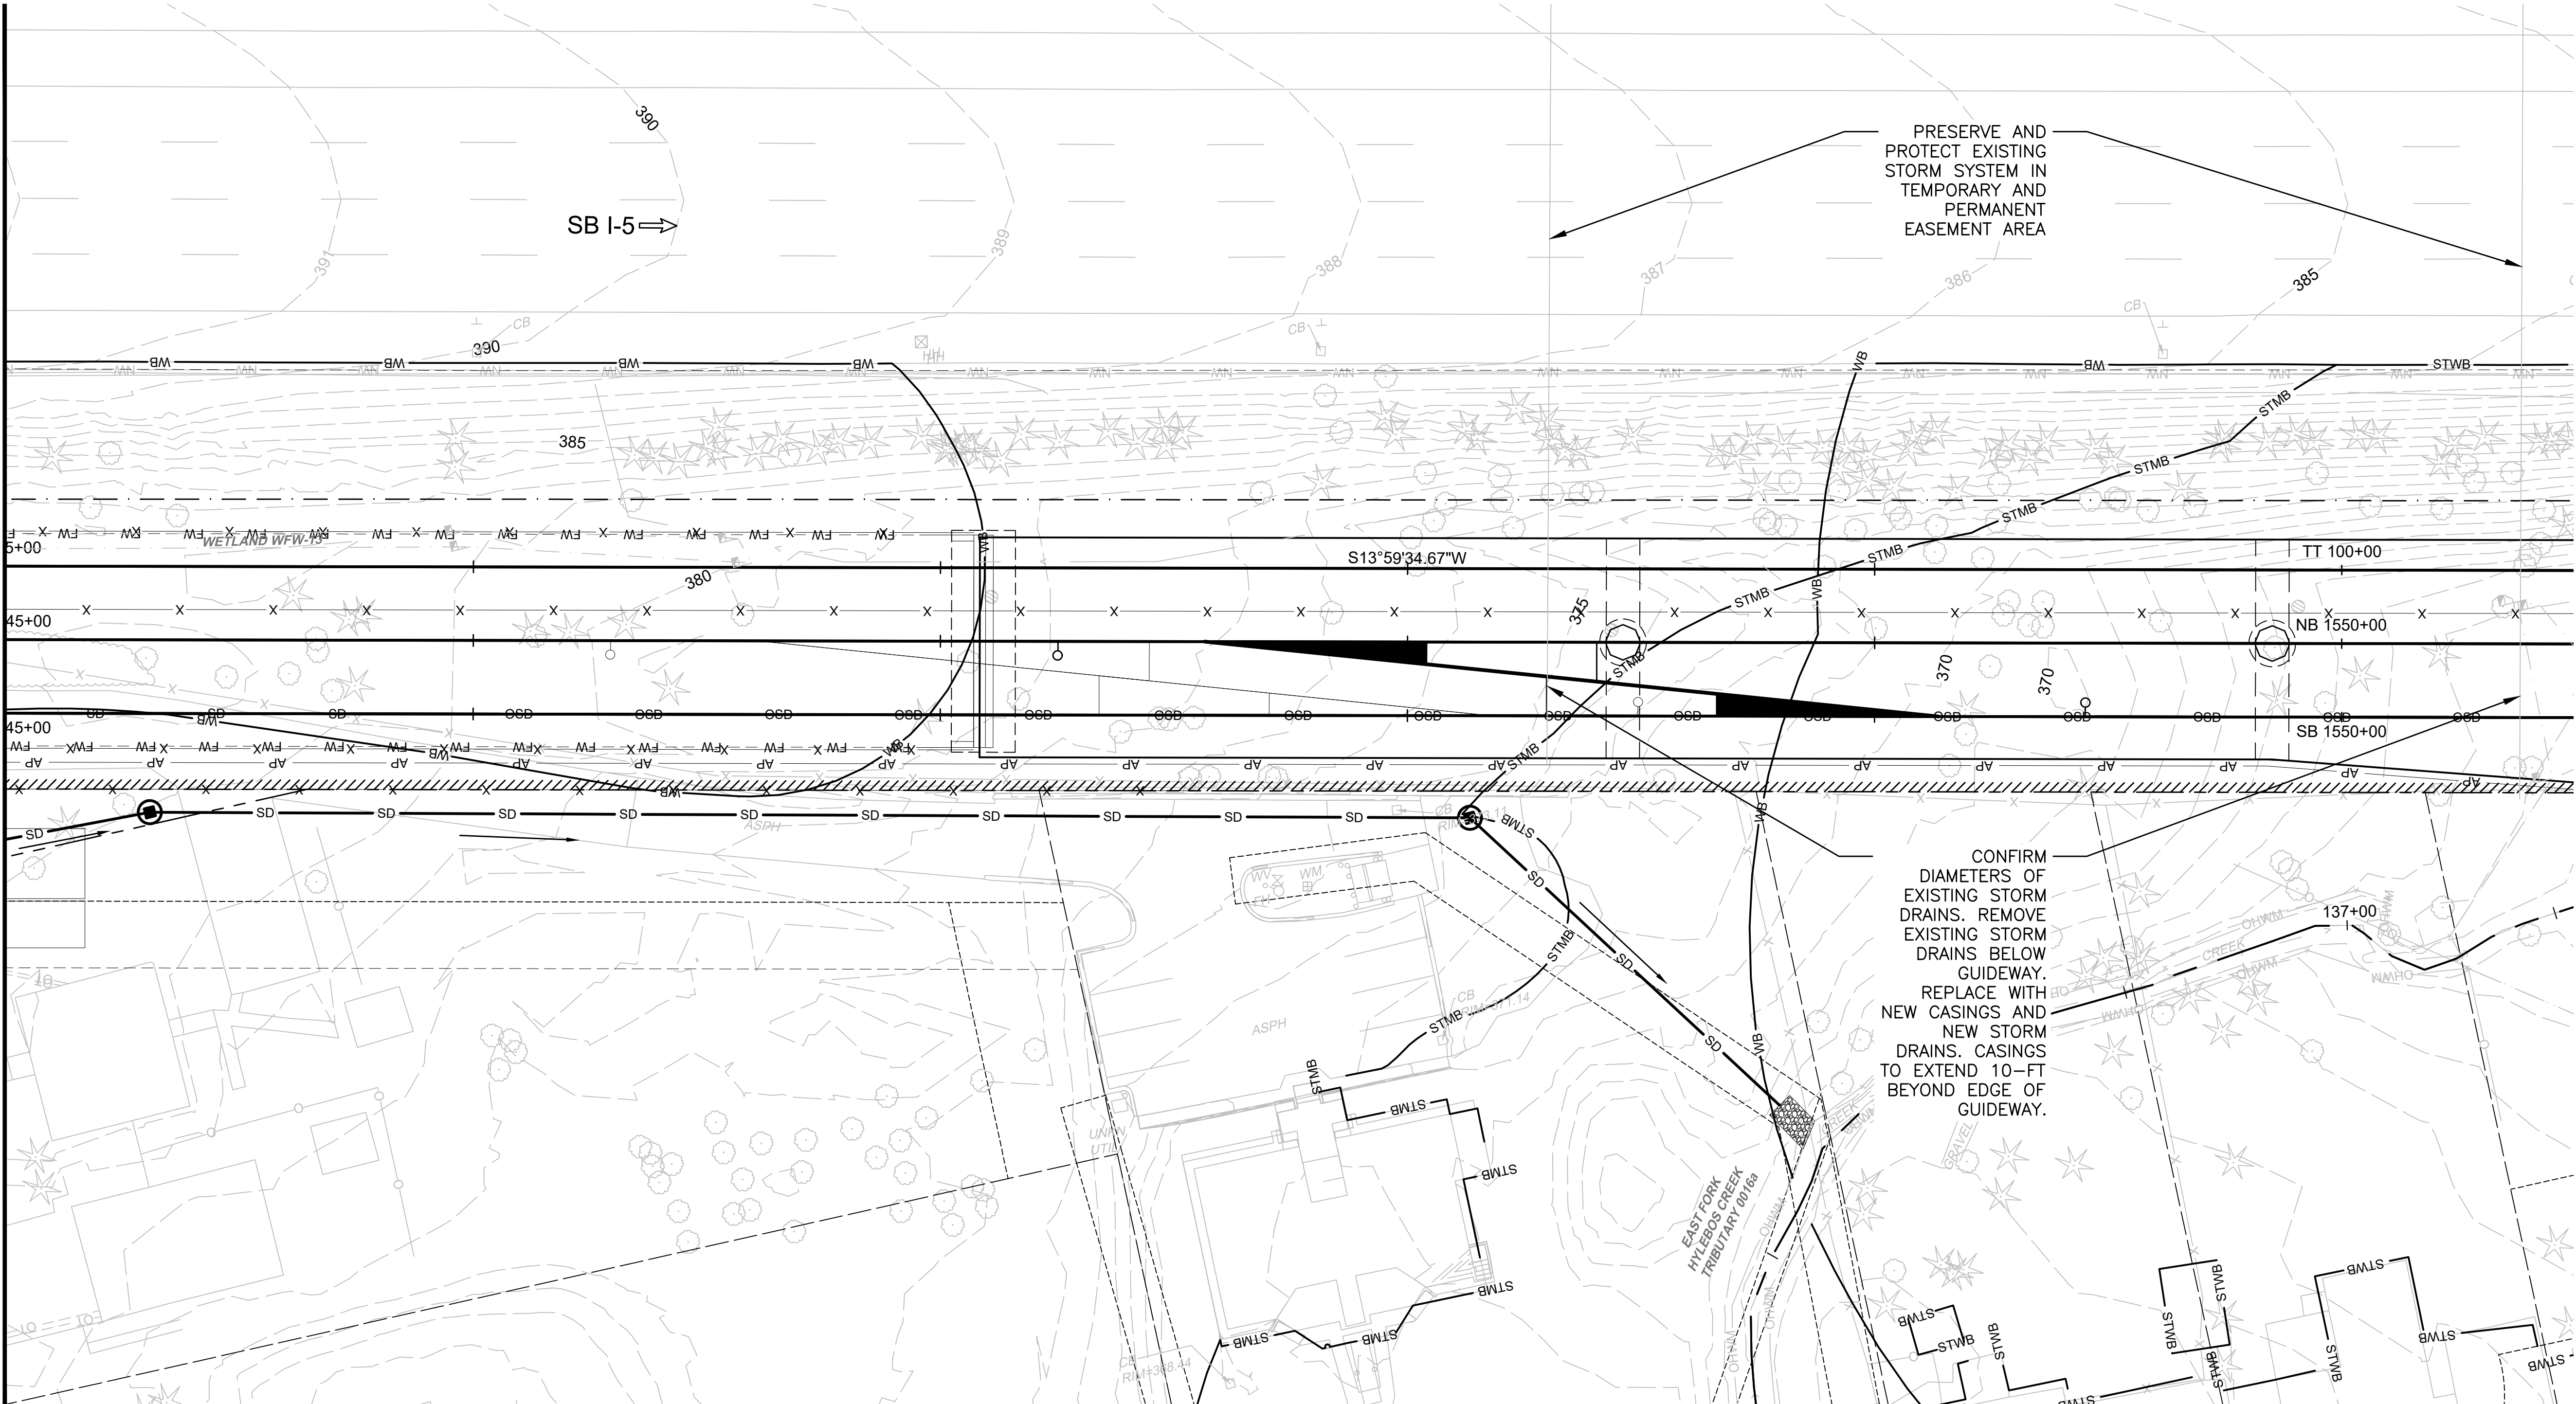


- NOTES:**
1. REMOVE EXISTING STORM DRAINS AND DRAINAGE STRUCTURES AT CONFLICTS WITH PROPOSED STORM DRAIN, PROPOSED DRAINAGE STRUCTURES, OR PROPOSED STORMWATER FACILITIES. RELOCATE STORM DRAINS OR REPLACE EXISTING DRAINAGE STRUCTURES AS REQUIRED.
 2. ALL PROPOSED UNDERGROUND STORM DRAIN 12-INCH DIAMETER UNLESS NOTED OTHERWISE.

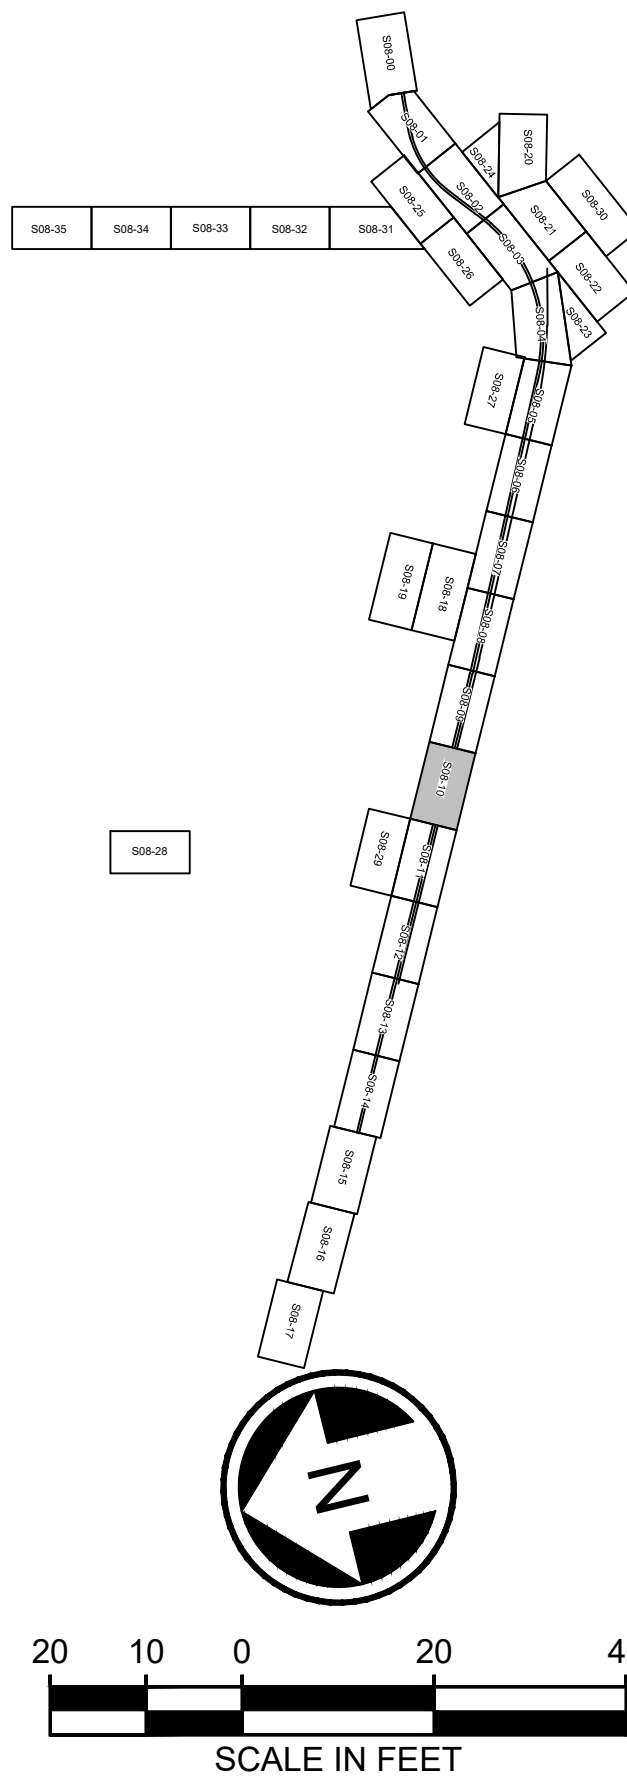

Refer to the plan set COVER drawing
for disclaimers regarding this drawing.

REFERENCE CONCEPT DRAWINGS					
No.	DATE	DSN	CHK	APP	REVISION

DESIGNED BY:
L. GRABOWSKI
DRAWN BY:
B. WILLIAMS
CHECKED BY:
J. WRIGHT
APPROVED BY:
J.COOP

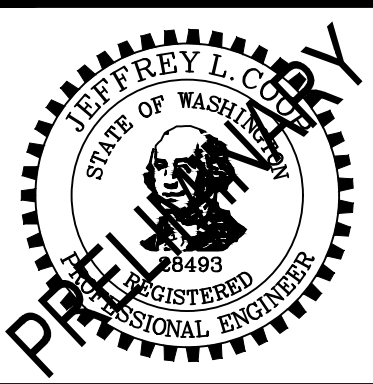

HR
SUBMITTED BY:
PABLO LOPEZ-HILFIKER

DATE:
2/27/2024

REVIEWED BY:

LINE IS 1" AT FULL SCALE
SOUNDTRANSIT
DATE:

PACKAGE #
SCALE:
1"=20'
FILENAME:
OMFS-S08-CDP101-122
CONTRACT No.:
AE-0030-17
DATE:
2/27/2024

SOUND TRANSIT
PRELIMINARY ENGINEERING PLANS
OPERATIONS & MAINTENANCE FACILITY SOUTH
CIVIL
DRAINAGE PLAN
STA 1545+00 TO STA 1550+50

DRAWING No.:
S08-CDP110
FACILITY ID:
S08
SHEET No.:
REV:
0



NOT FOR
CONSTRUCTION

MATCHLINE:
SEE DWG S08-CDP107

MATCHLINE:
SEE DWG S08-CDP108

NOTES:

1. REMOVE EXISTING STORM DRAINS AND DRAINAGE STRUCTURES AT CONFLICTS WITH PROPOSED STORM DRAIN, PROPOSED DRAINAGE STRUCTURES, OR PROPOSED STORMWATER FACILITIES. RELOCATE STORM DRAINS OR REPLACE EXISTING DRAINAGE STRUCTURES AS REQUIRED.
2. ALL PROPOSED UNDERGROUND STORM DRAIN 12-INCH DIAMETER UNLESS NOTED OTHERWISE.

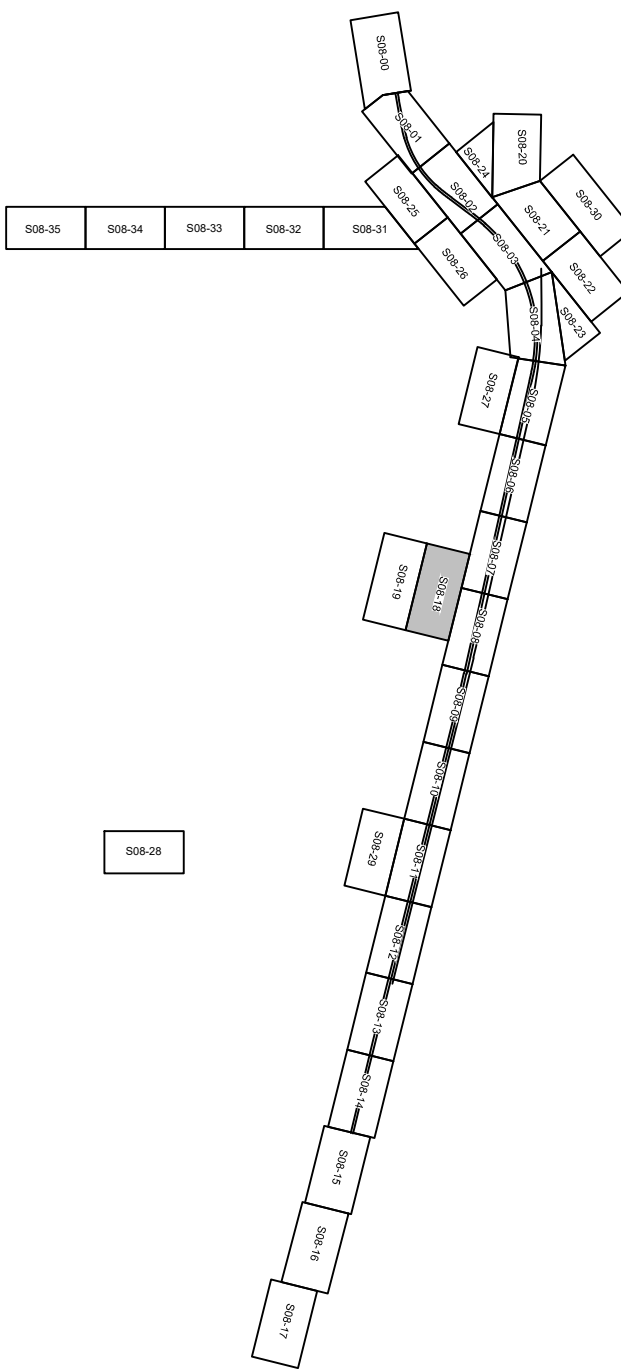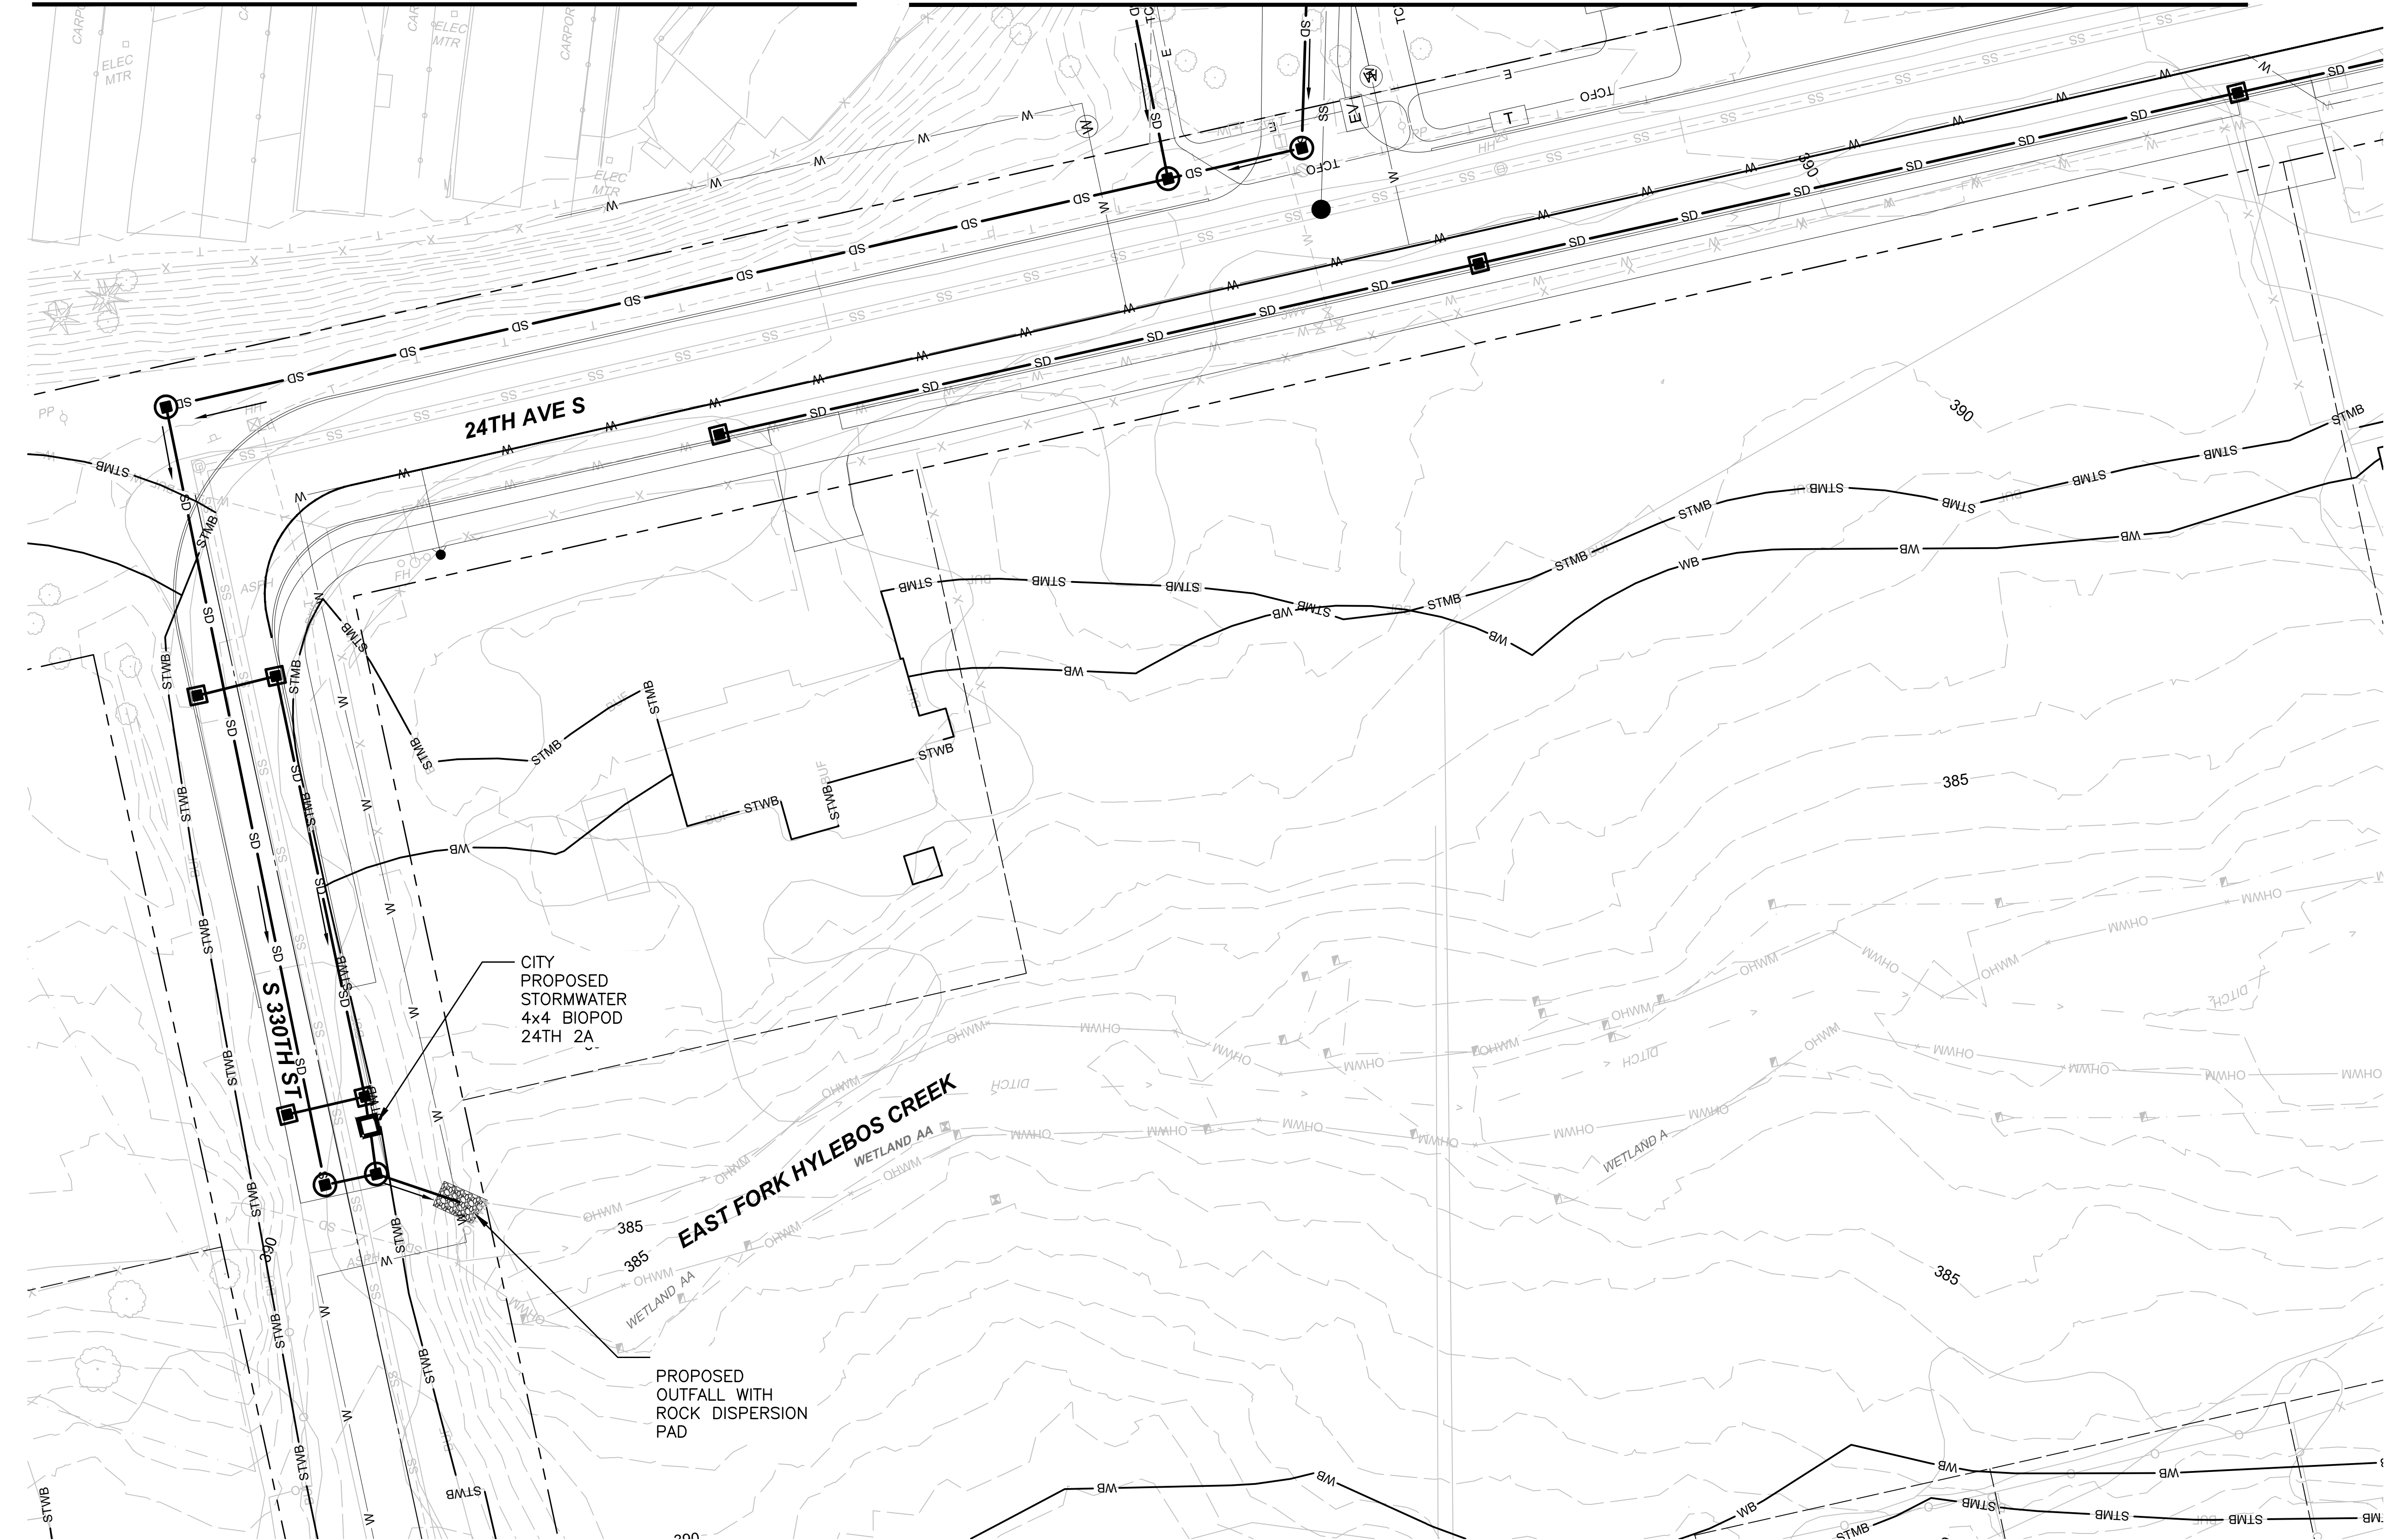


NOT FOR
CONSTRUCTION

Refer to the plan set COVER drawing
for disclaimers regarding this drawing.

REFERENCE CONCEPT DRAWINGS

No.	DATE	DSN	CHK	APP	REVISION

DESIGNED BY:
L. GRABOWSKI
DRAWN BY:
B. WILLIAMS
CHECKED BY:
J. WRIGHT
APPROVED BY:
J.COOP

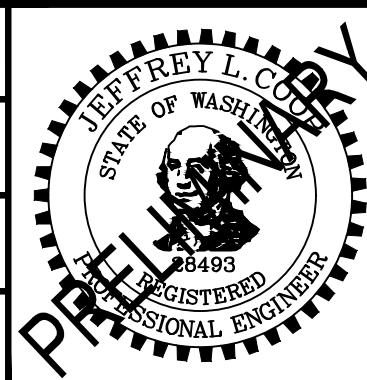

SUBMITTED BY:
PABLO LOPEZ-HILFIKER

DATE:
2/27/2024

REVIEWED BY:



DATE:


PACKAGE #

SCALE:
1"=20'
FILENAME:
OMFS-S08-CDP101-122
CONTRACT No.:
AE-0030-17
DATE:
2/27/2024

SOUND TRANSIT
PRELIMINARY ENGINEERING PLANS
OPERATIONS & MAINTENANCE FACILITY SOUTH
CIVIL
DRAINAGE PLAN

DRAWING No.:
S08-CDP118
FACILITY ID:
S08
SHEET No.:
REV:
0

1. REMOVE EXISTING STORM DRAINS AND DRAINAGE STRUCTURES AT CONFLICTS WITH PROPOSED STORM DRAIN, PROPOSED DRAINAGE STRUCTURES, OR PROPOSED STORMWATER FACILITIES. RELOCATE STORM DRAINS OR REPLACE EXISTING DRAINAGE STRUCTURES AS REQUIRED.
2. ALL PROPOSED UNDERGROUND STORM DRAIN 12-INCH DIAMETER UNLESS NOTED OTHERWISE.

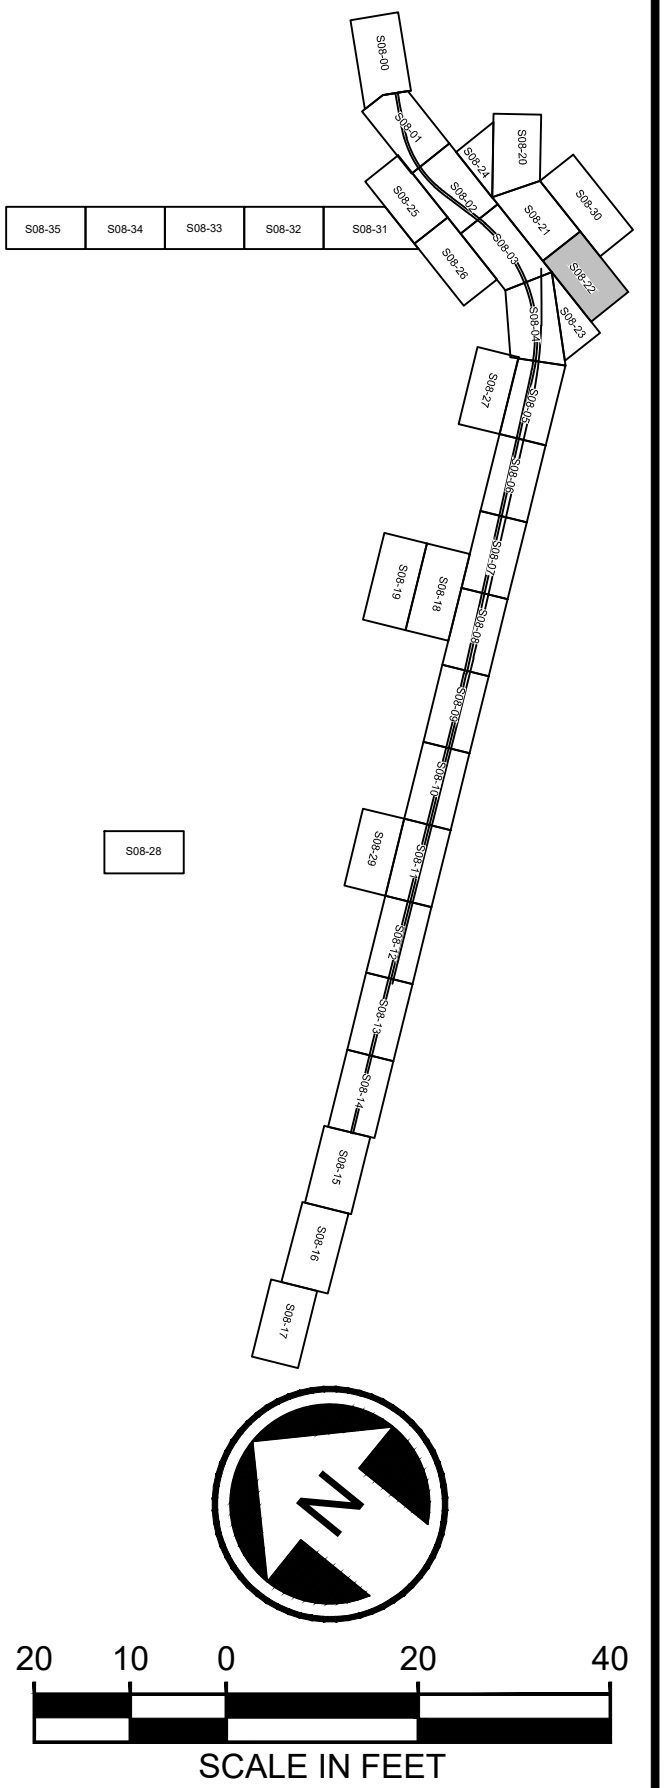

NOT FOR
CONSTRUCTION

AHJ:					PACKAGE #				
					SCALE: 1"=20'	SOUND TRANSIT PRELIMINARY ENGINEERING PLANS OPERATIONS & MAINTENANCE FACILITY SOUTH CIVIL DRAINAGE PLAN			DRAWING No.: S08-CDP122
					FILENAME: OMFS-S08-CDP101-122				FACILITY ID: S08
					CONTRACT No.: AE-0030-17				SHEET No.: REV:
					DATE: 2/27/2024				0
SUBMITTED BY: PABLO LOPEZ-HILFIKER		DATE: 2/27/2024	REVIEWED BY:	DATE:					