

02/20/24 | 3:51 PM | JSANNON
C:\PWORKING\WEST01\0278055\OMFS-S08-UCP101-124.DWG

ELECTRICAL UTILITY KEY NOTES

- 1XX
- 100 PROTECT EXISTING UNDERGROUND ELECTRICAL
- 101 PROTECT EXISTING UTILITY POLE
- 103 PROTECT EXISTING OVERHEAD ELECTRICAL
- 132 OVERHEAD DISTRIBUTION POWER
- 133 RAISE OVERHEAD DISTRIBUTION POWER
- 140 UNDERGROUND ELECTRIC
- 144 DISTRIBUTION POWER LINES
- 150 ELECTRICAL/UTILITY POLE
- 170 OVERHEAD POWER SERVICE
- 190 TPSS POWER SUPPLY

TELECOMMUNICATION UTILITY KEY NOTES

- 2XX
- 200 PROTECT EXISTING UNDERGROUND TELECOMMUNICATIONS
- 203 PROTECT EXISTING OVERHEAD TELECOMMUNICATIONS
- 242 RAISE OVERHEAD TELECOMMUNICATIONS
- 250 UNDERGROUND TELECOMMUNICATIONS
- 290 OVERHEAD TELECOMMUNICATIONS SERVICE

GAS UTILITY KEY NOTES

- 3XX
- 300 PROTECT EXISTING NATURAL GAS PIPE LINE
- 340 RELOCATED GAS LINE

WATER UTILITY KEY NOTES

- 4XX
- 400 PROTECT EXISTING WATER MAIN
- 401 PROTECT EXISTING HYDRANT
- 440 RELOCATED WATER DISTRIBUTION MAIN
- 442 WATER DOMESTIC SERVICE
- 443 WATER FIRE SERVICE
- 444 FIRE HYDRANT ASSEMBLY

SANITARY SEWER UTILITY KEY NOTES

- 5XX
- 500 PROTECT EXISTING SANITARY SEWER MAIN
- 501 PROTECT EXISTING SANITARY SEWER STRUCTURE
- 540 RELOCATED SANITARY SEWER MAIN
- 542 INSTALL SANITARY SIDE SEWER SERVICE
- 560 INSTALL SANITARY SEWER STRUCTURE

STORM DRAINAGE UTILITY KEY NOTES

- 6XX
- 600 PROTECT EXISTING STORM DRAIN, CONFIRM PROTECTION WITH DESIGN ON CDP SHEETS
- 699 NEW STORM DRAIN, SEE CDP SHEETS THIS SET FOR STORM DRAIN INFRASTRUCTURE DETAILS

NOT FOR
CONSTRUCTION

Refer to the plan set COVER drawing
for disclaimers regarding this drawing.

for disclaimers regarding this drawing.										AHJ: CITY OF FEDERAL WAY, LAKEHAVEN WATER AND SEWER DISTRICT										PACKAGE #																																							
REFERENCE CONCEPT DRAWINGS										DESIGNED BY: J. SANNON										PRELIMINARY LINE IS 1" AT FULL SCALE SOUNDTRANSIT										SCALE: NTS										SOUND TRANSIT PRELIMINARY ENGINEERING PLANS OPERATIONS & MAINTENANCE FACILITY SOUTH										DRAWING No.: S08-UZN100									
										DRAWN BY: E. HERRMANN																				FILENAME: OMFS-S08-UCP101-124																				FACILITY ID: S08									
										CHECKED BY: M. STARLING																				CONTRACT No.: AE-0030-17																				SHEET No.: REV:									
										APPROVED BY: P. LOPEZ-HILFIKER																				DATE: 2/27/2024																				0									
										No. DATE DSN CHK APP REVISION																				SUBMITTED BY: PABLO LOPEZ-HILFIKER										DATE: 2/27/2024										REVIEWED BY:									


02/21/24 | 8:45 AM | EHERRMANN
C:\PWORKING\WEST01\278055\OMFS-S08-UCP101-124.DWG

Refer to the plan set COVER drawing
for disclaimers regarding this drawing.



REFERENCE CONCEPT DRAWINGS						
No.	DATE	DSN	CHK	APP	REVISION	

DESIGNED BY:	J. SANNON
DRAWN BY:	E. HERRMANN
CHECKED BY:	M. STARLING
APPROVED BY:	P. LOPEZ-HILFIKER

AHJ: CITY OF FEDERAL WAY, LAKEHAVEN WATER AND SEWER DISTRICT					PACKAGE #					
PRELIMINARY				LINE IS 1" AT FULL SCALE 	SCALE: 1"=20'	SOUND TRANSIT PRELIMINARY ENGINEERING PLANS OPERATIONS & MAINTENANCE FACILITY SOUTH UTILITY COMPOSITE UTILITY PLANS STA SB1500+00 TO STA SB1505+00			DRAWING No.: S08-UCP101	
					FILENAME: OMFS-S08-UCP101-124				FACILITY ID: S08	
					CONTRACT No.: AE-0030-17				SHEET No.: REV:	
					DATE: 2/27/2024				0	
	SUBMITTED BY: PABLO LOPEZ-HILFIKER		DATE: 2/27/2024	REVIEWED BY:		DATE: 2/27/2024				

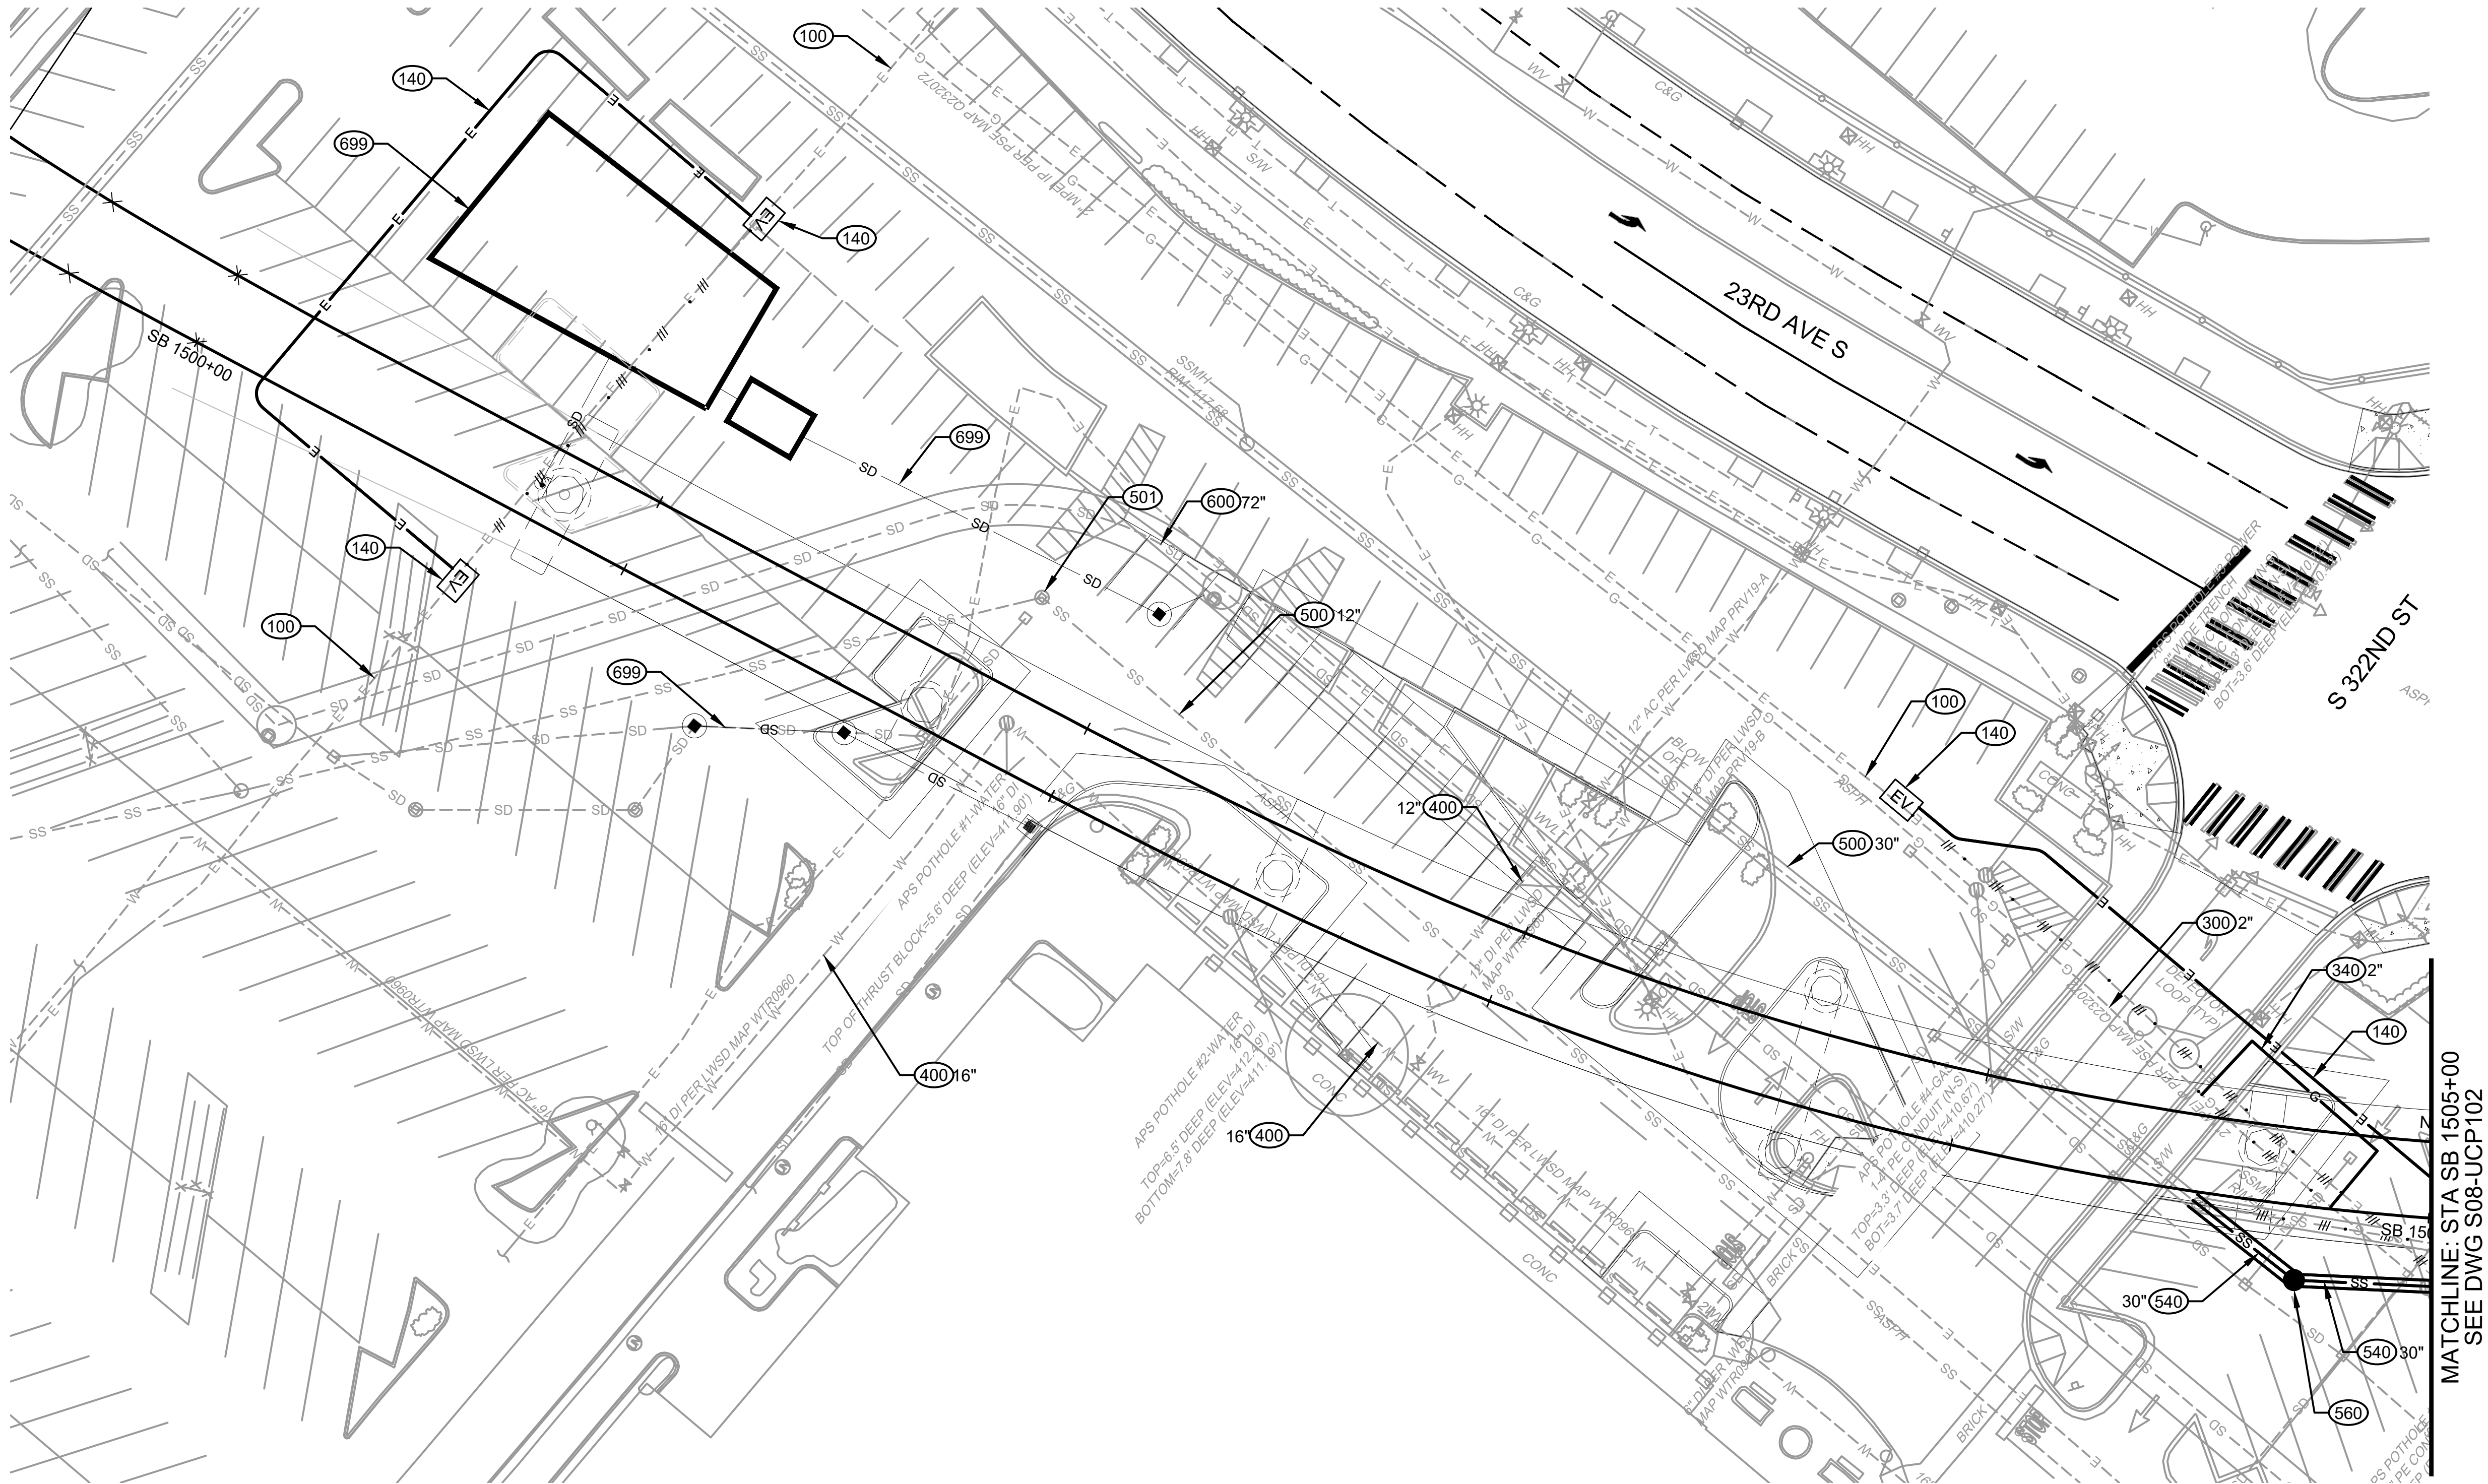

KEY NOTES:
SEE SHEET S08-UZN100 THIS SET FOR UTILITY
INSTALLATION DESCRIPTIONS AND DETAILS.

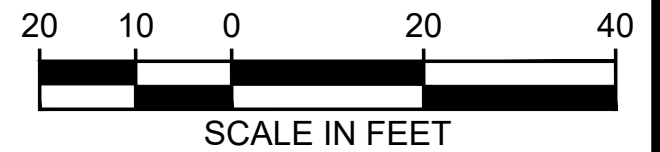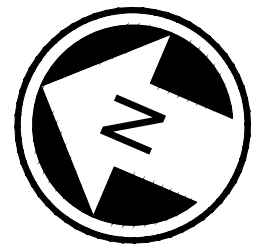

NOT FOR
CONSTRUCTION

02/20/24 | 3:52 PM | JSANNON
C:\PWORKING\WEST01\0278055\OMFS-S08-UCP101-124.DWG


MATCHLINE: STA SB 1505+00
SEE DWG S08-UCSP101

Refer to the plan set COVER drawing
for disclaimers regarding this drawing.

REFERENCE CONCEPT DRAWINGS						
No.	DATE	DSN	CHK	APP	REVISION	

DESIGNED BY:	J. SANNON
DRAWN BY:	E. HERRMANN
CHECKED BY:	M. STARLING
APPROVED BY:	P. LOPEZ-HILFIKER

PRELIMINARY

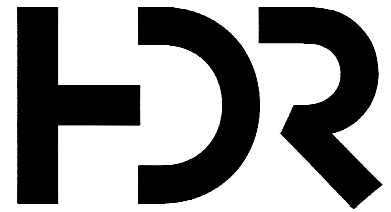

SUBMITTED BY:

PABLO LOPEZ-HILFIKER

DATE:

2/27/2024

REVIEWED BY:

LINE IS 1" AT
FULL SCALE




SOUNDTRANSIT

PACKAGE #
SCALE: 1"=20'
FILENAME: OMFS-S08-UCP101-124
CONTRACT No.: AE-0030-17
DATE: 2/27/2024

SOUND TRANSIT
PRELIMINARY ENGINEERING PLANS
OPERATIONS & MAINTENANCE FACILITY SOUTH


UTILITY
COMPOSITE UTILITY PLANS
STA SB1505+00 TO STA SB1510+00

DRAWING No.:	S08-UCP102
FACILITY ID:	S08
SHEET No.:	REV:
	0

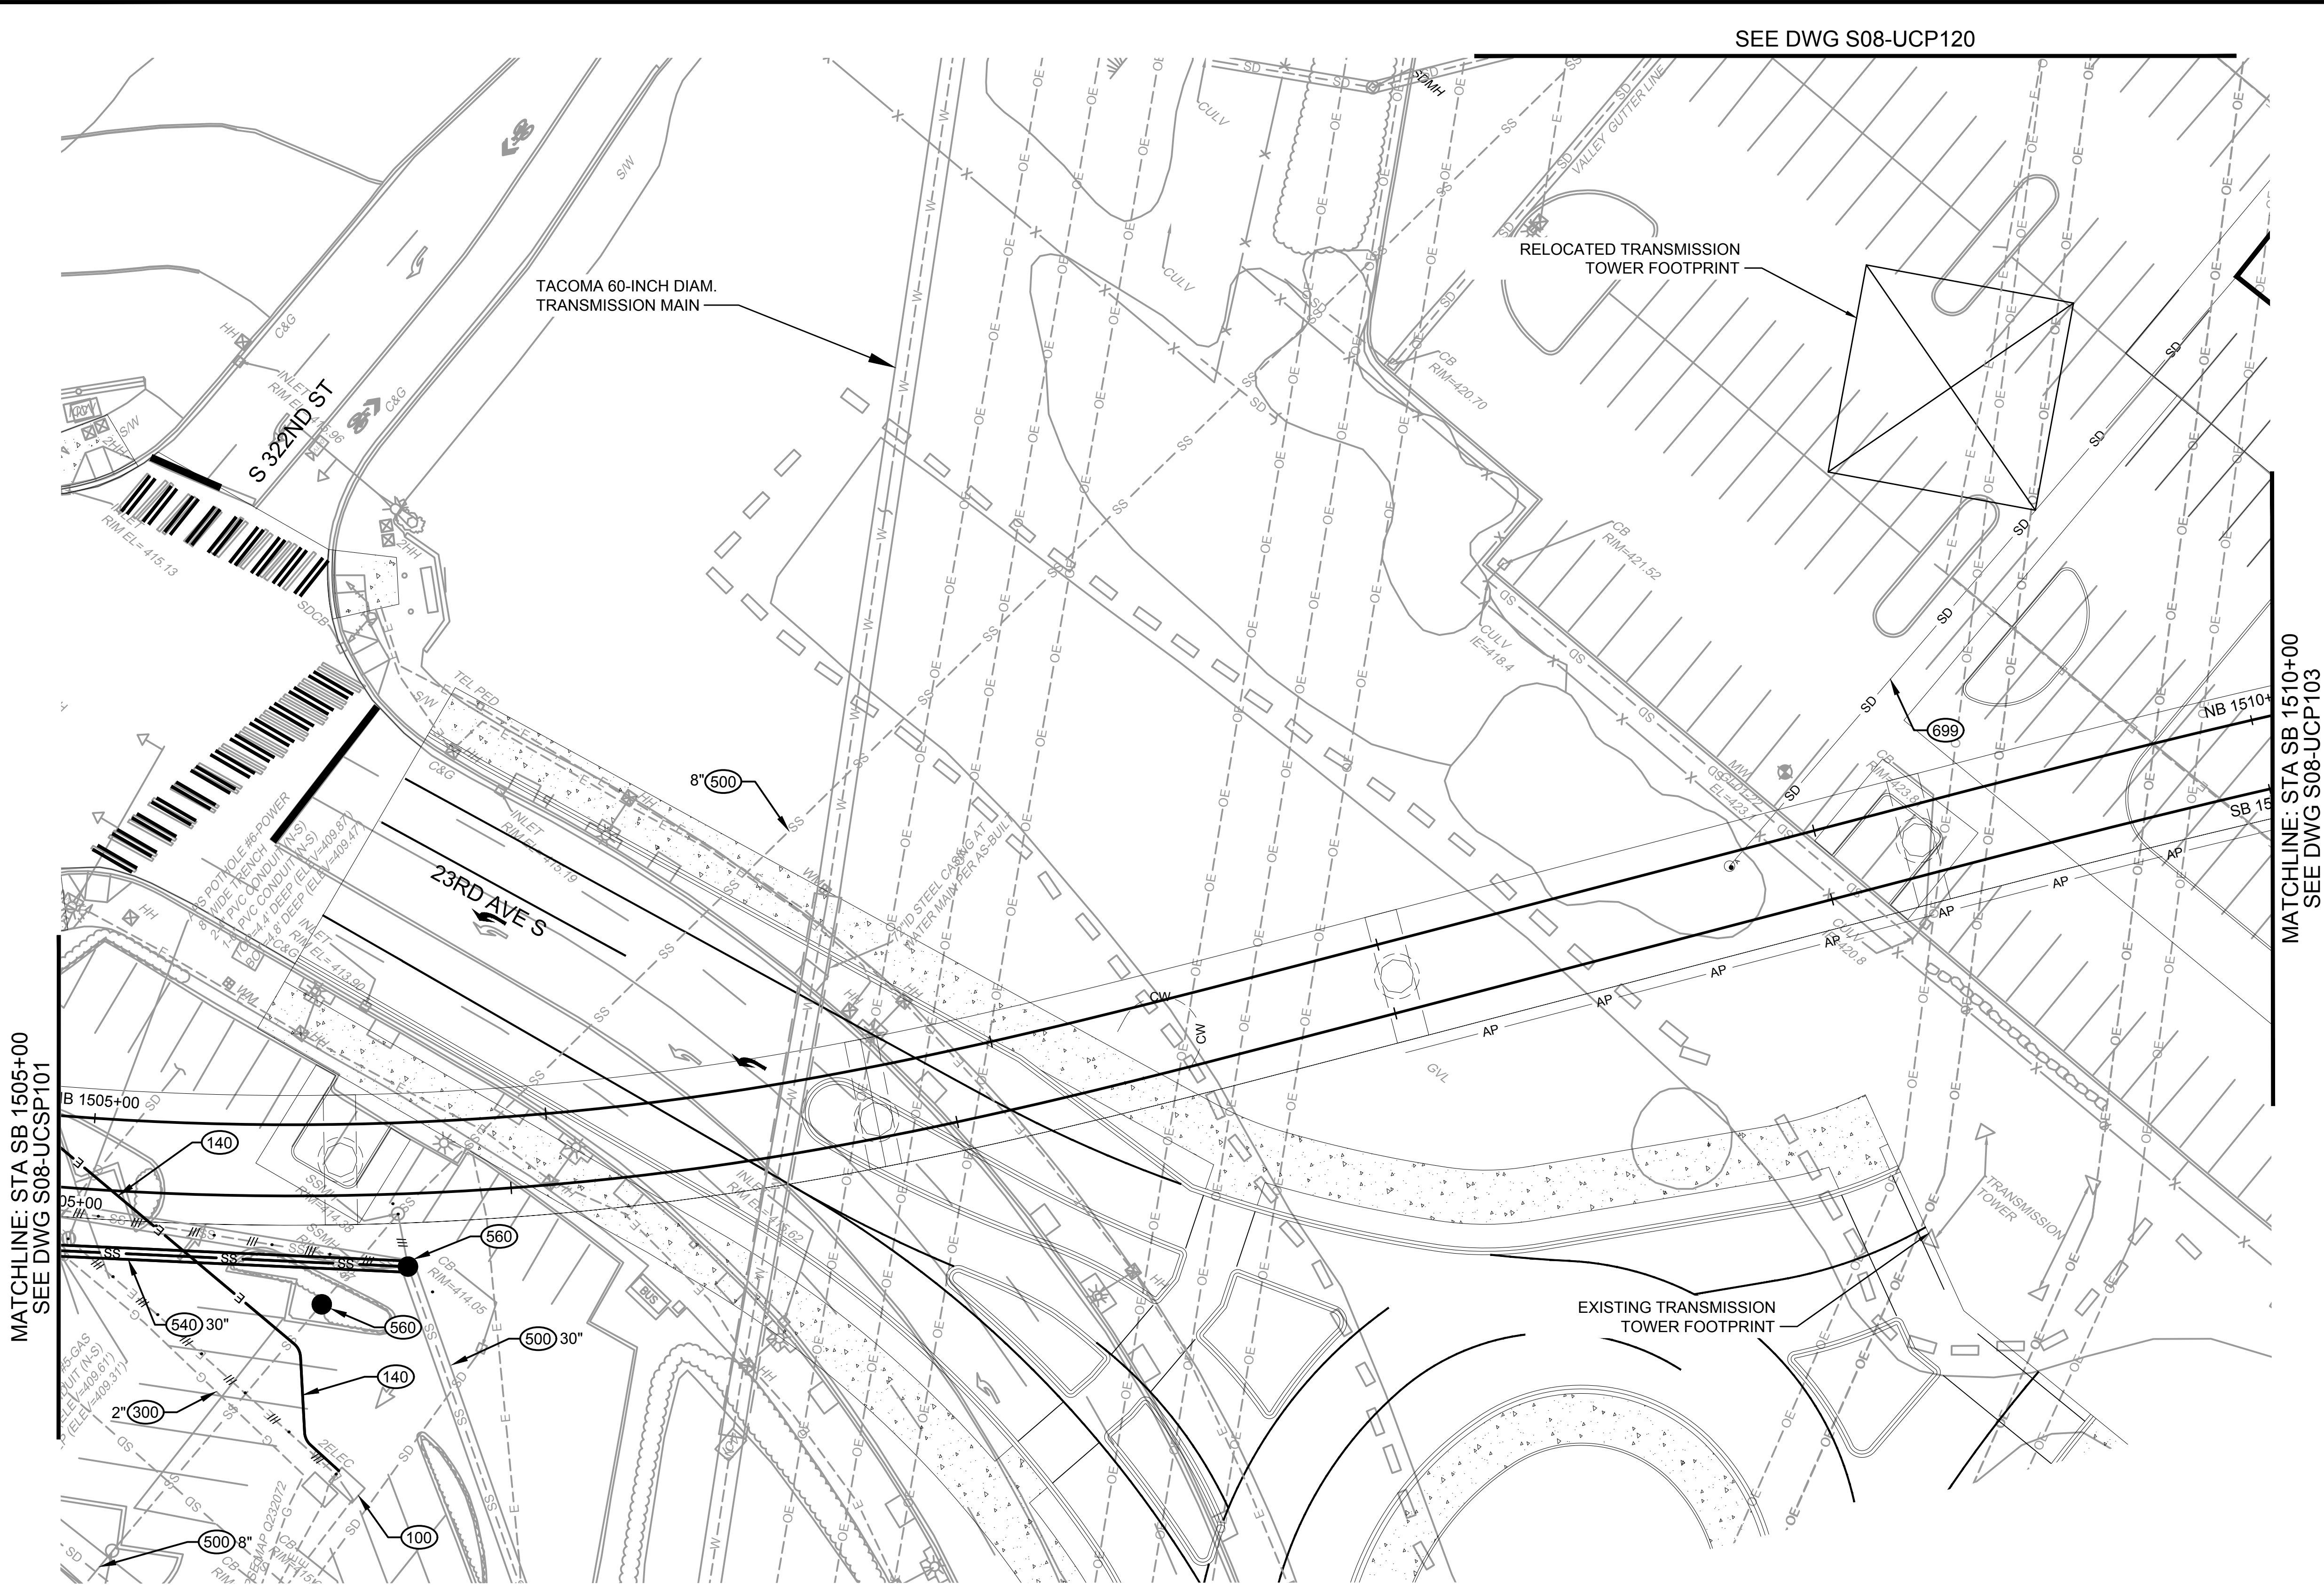

KEY NOTES:

SEE SHEET S08-UZN100 THIS SET FOR UTILITY
INSTALLATION DESCRIPTIONS AND DETAILS.

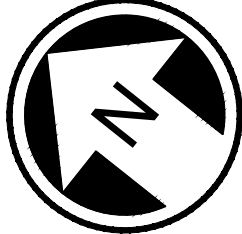

SCALE IN FEET

NOT FOR
CONSTRUCTION

02/2024 | 3:52 PM | JSANNON
C:\PWORKING\WEST01\278055\OMFS-S08-UCP101-124.DWG

MATCHLINE: STA SB 1510+00
SEE DWG S08-UCP102

Refer to the plan set COVER drawing
for disclaimers regarding this drawing.

REFERENCE CONCEPT DRAWINGS					
No.	DATE	DSN	CHK	APP	REVISION

DESIGNED BY:	J. SANNON
DRAWN BY:	E. HERRMANN
CHECKED BY:	M. STARLING
APPROVED BY:	P. LOPEZ-HILFIKER


PRELIMINARY



SUBMITTED BY:
PABLO LOPEZ-HILFIKER

DATE:
2/27/2024

REVIEWED BY:

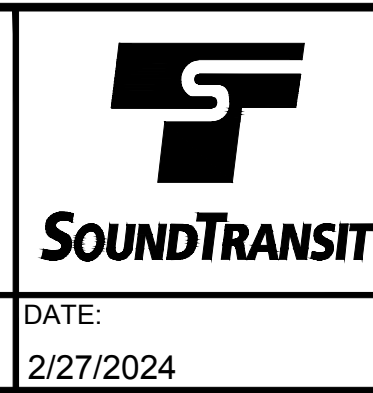

DATE:
2/27/2024


PACKAGE #

SCALE:	1"=20'
FILENAME:	OMFS-S08-UCP101-124
CONTRACT No.:	AE-0030-17
DATE:	2/27/2024

SOUND TRANSIT
PRELIMINARY ENGINEERING PLANS
OPERATIONS & MAINTENANCE FACILITY SOUTH



UTILITY
COMPOSITE UTILITY PLANS
STA SB1510+00 TO STA SB1515+00

DRAWING No.:	S08-UCP103
FACILITY ID:	S08
SHEET No.:	REV:
	0

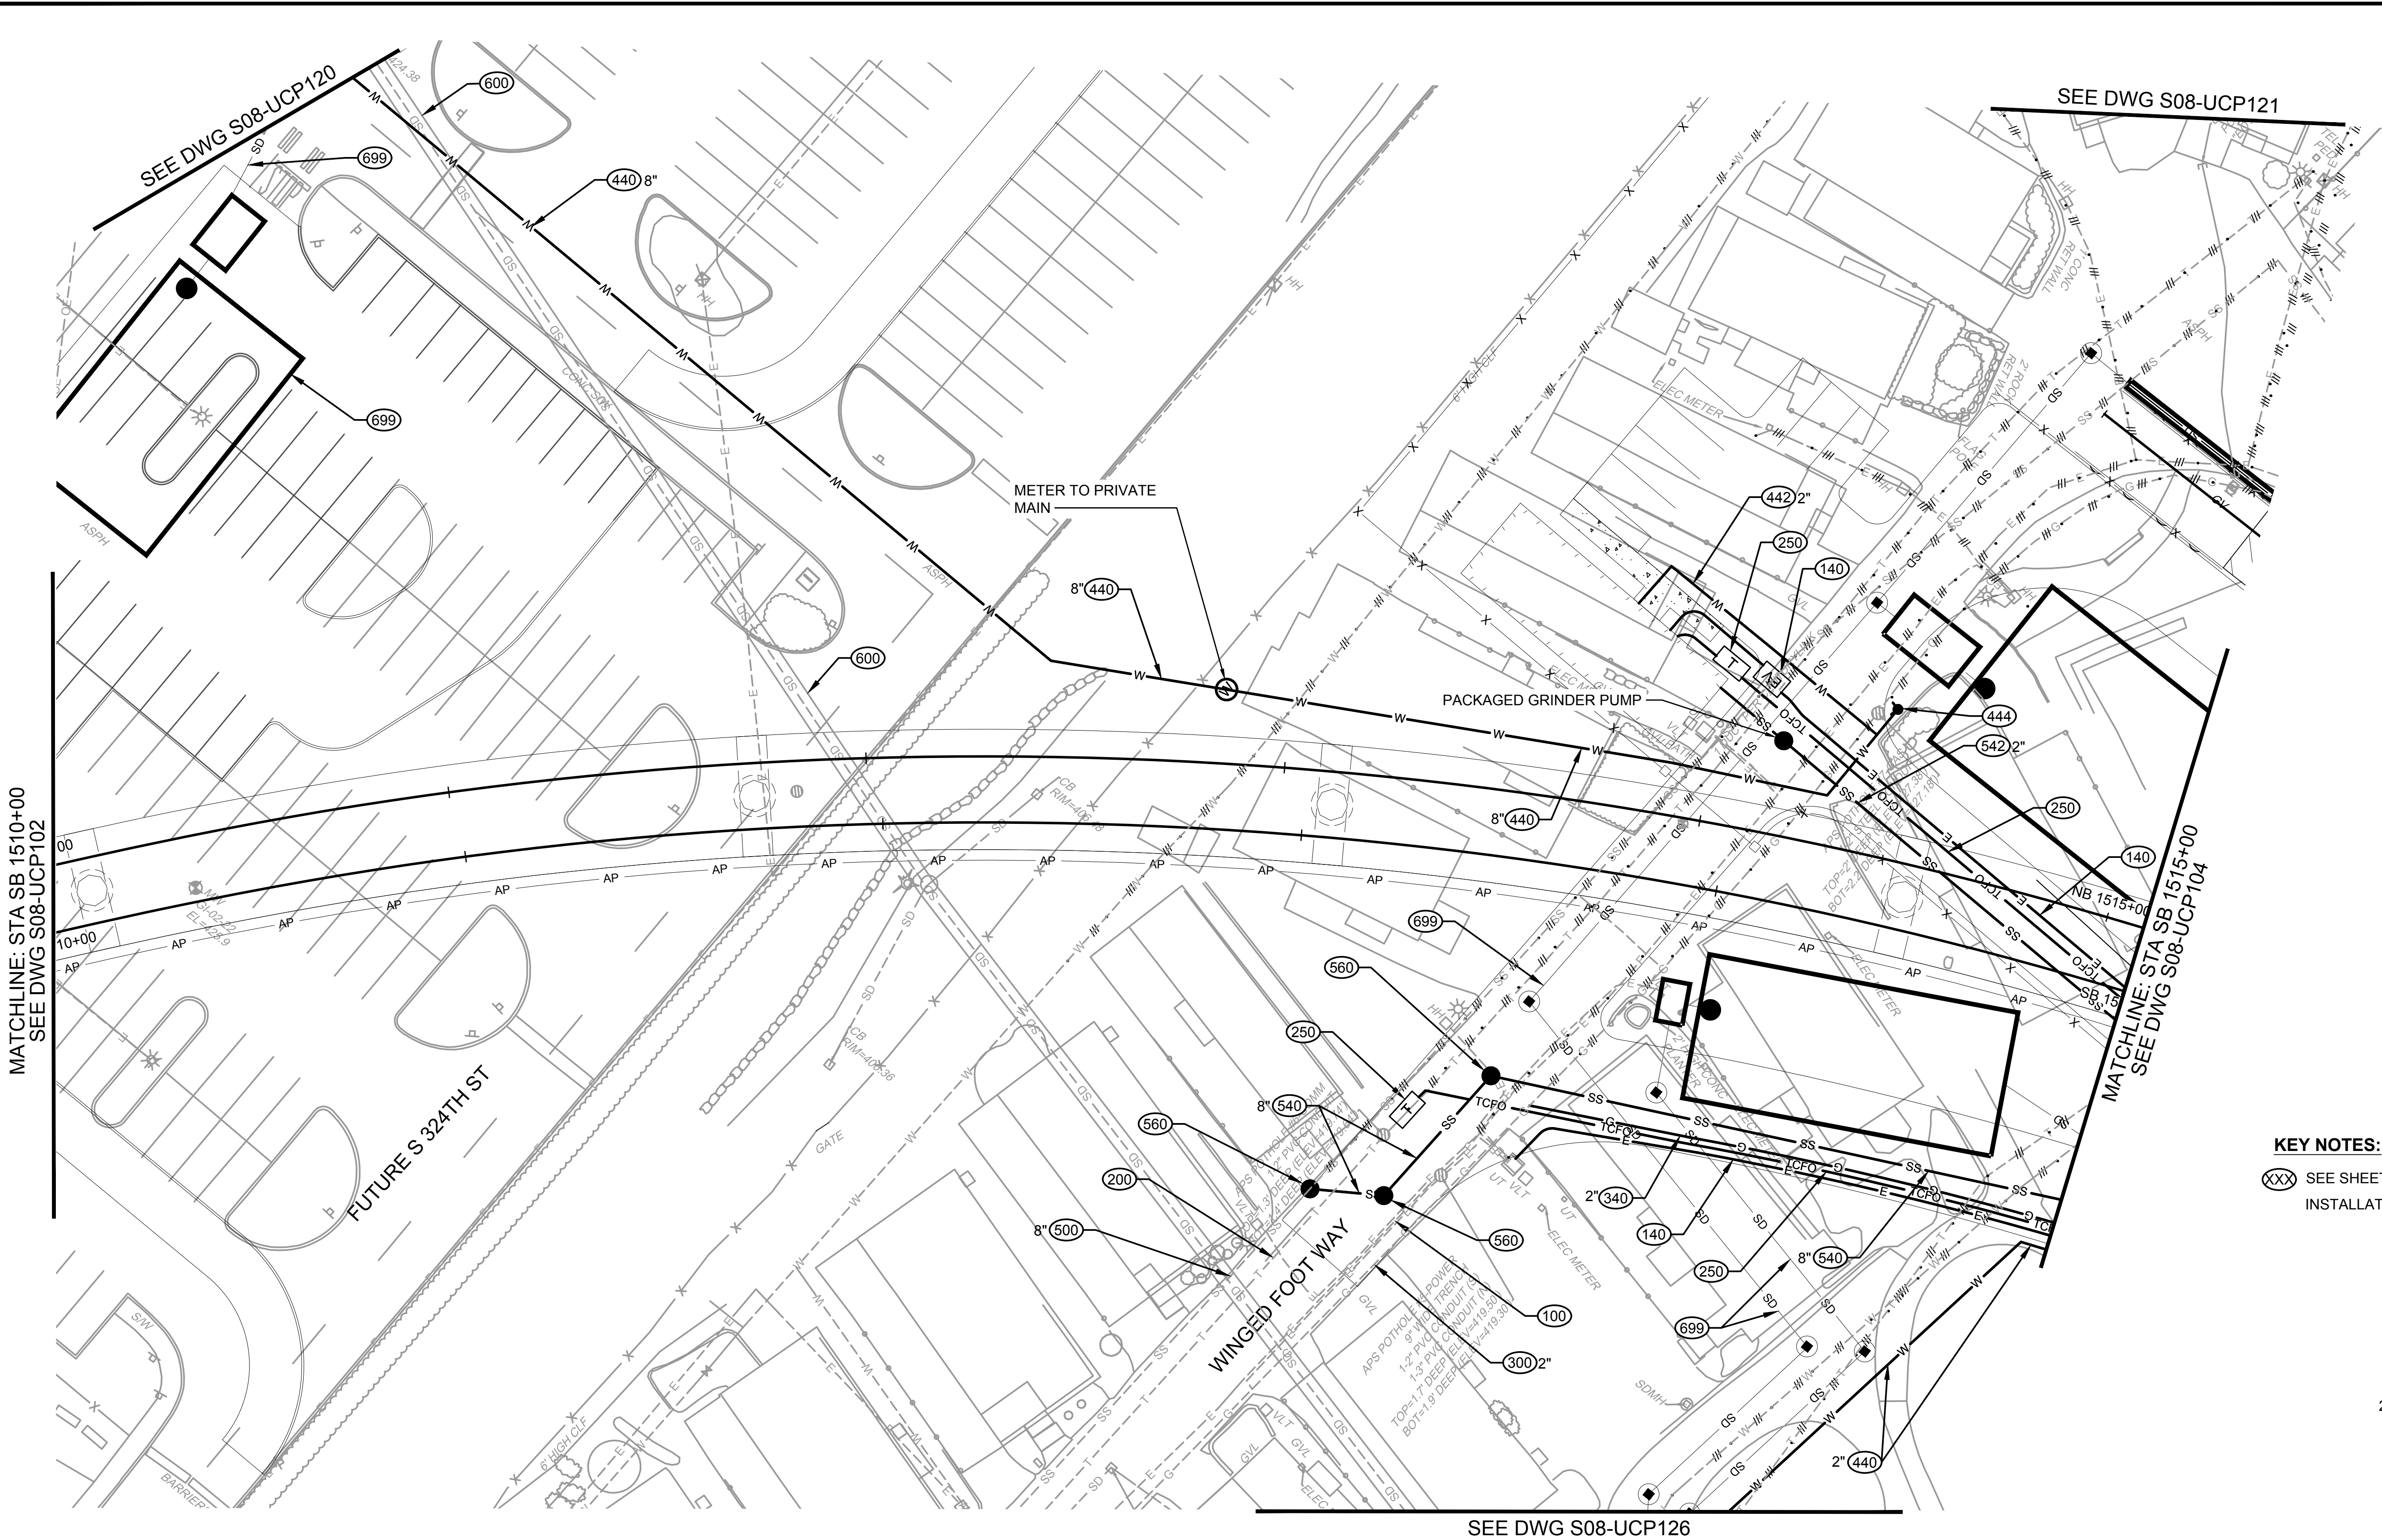

KEY NOTES:

- (XXX) SEE SHEET S08-UZN100 THIS SET FOR UTILITY
INSTALLATION DESCRIPTIONS AND DETAILS.

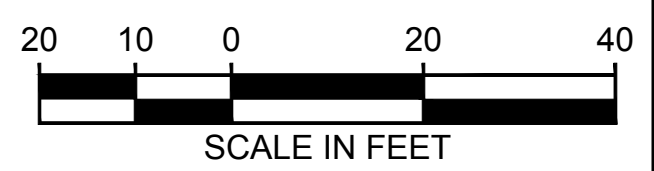
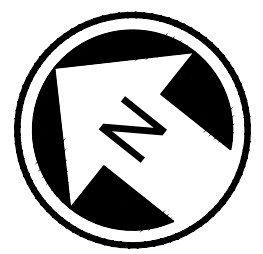


NOT FOR
CONSTRUCTION

SEE SHEET S08-UZN100 THIS SET FOR UTILITY
INSTALLATION DESCRIPTIONS AND DETAILS.

15
MATCHLINE: STA SB 1515+00
SEE DWG S08-UCP103

MATCHLINE: STA SB 1520+00
SEE DWG S08-UCP105

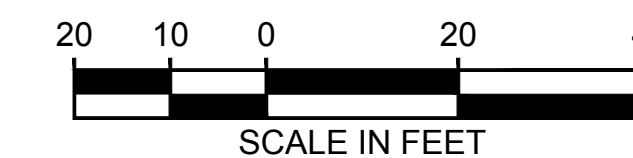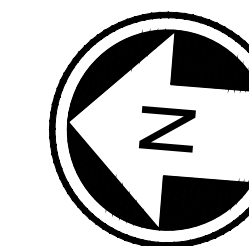

NOT FOR
CONSTRUCTION


*Refer to the plan set COVER drawing
for disclaimers regarding this drawing.*

REFERENCE CONCEPT DRAWINGS

No.	DATE	DSN	CHK	APP	REVISION

DESIGNED BY:	J. SANNON
DRAWN BY:	E. HERRMANN
CHECKED BY:	M. STARLING
APPROVED BY:	P. LOPEZ-HILFIKER

PRELIMINARY

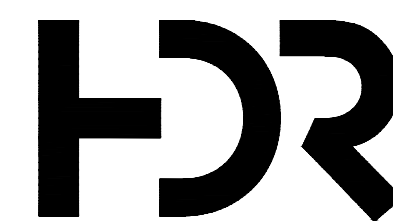SUBMITTED BY:
PABLO LOPEZ-HILFIKER

DATE:
2/27/2024

REVIEWED BY:

Full Scale

ST

SOUNDTRANSIT

DATE:
2/27/2024

PACKAGE #	
-----------	--


SCALE:	1"=20'
FILENAME:	OMFS-S08-UCP101-124
CONTRACT No.:	AE-0030-17
DATE:	2/27/2024

SOUND TRANSIT
PRELIMINARY ENGINEERING PLANS
OPERATIONS & MAINTENANCE FACILITY SOUTH
UTILITY
COMPOSITE UTILITY PLANS
STA SB1515+00 TO STA SB1520+00

DRAWING No.:	
S08-UCP104	
FACILITY ID:	
S08	
SHEET No.:	REV
	0



KEY NOTES:

SEE SHEET S08-UZN100 THIS SET FOR UTILITY
INSTALLATION DESCRIPTIONS AND DETAILS.

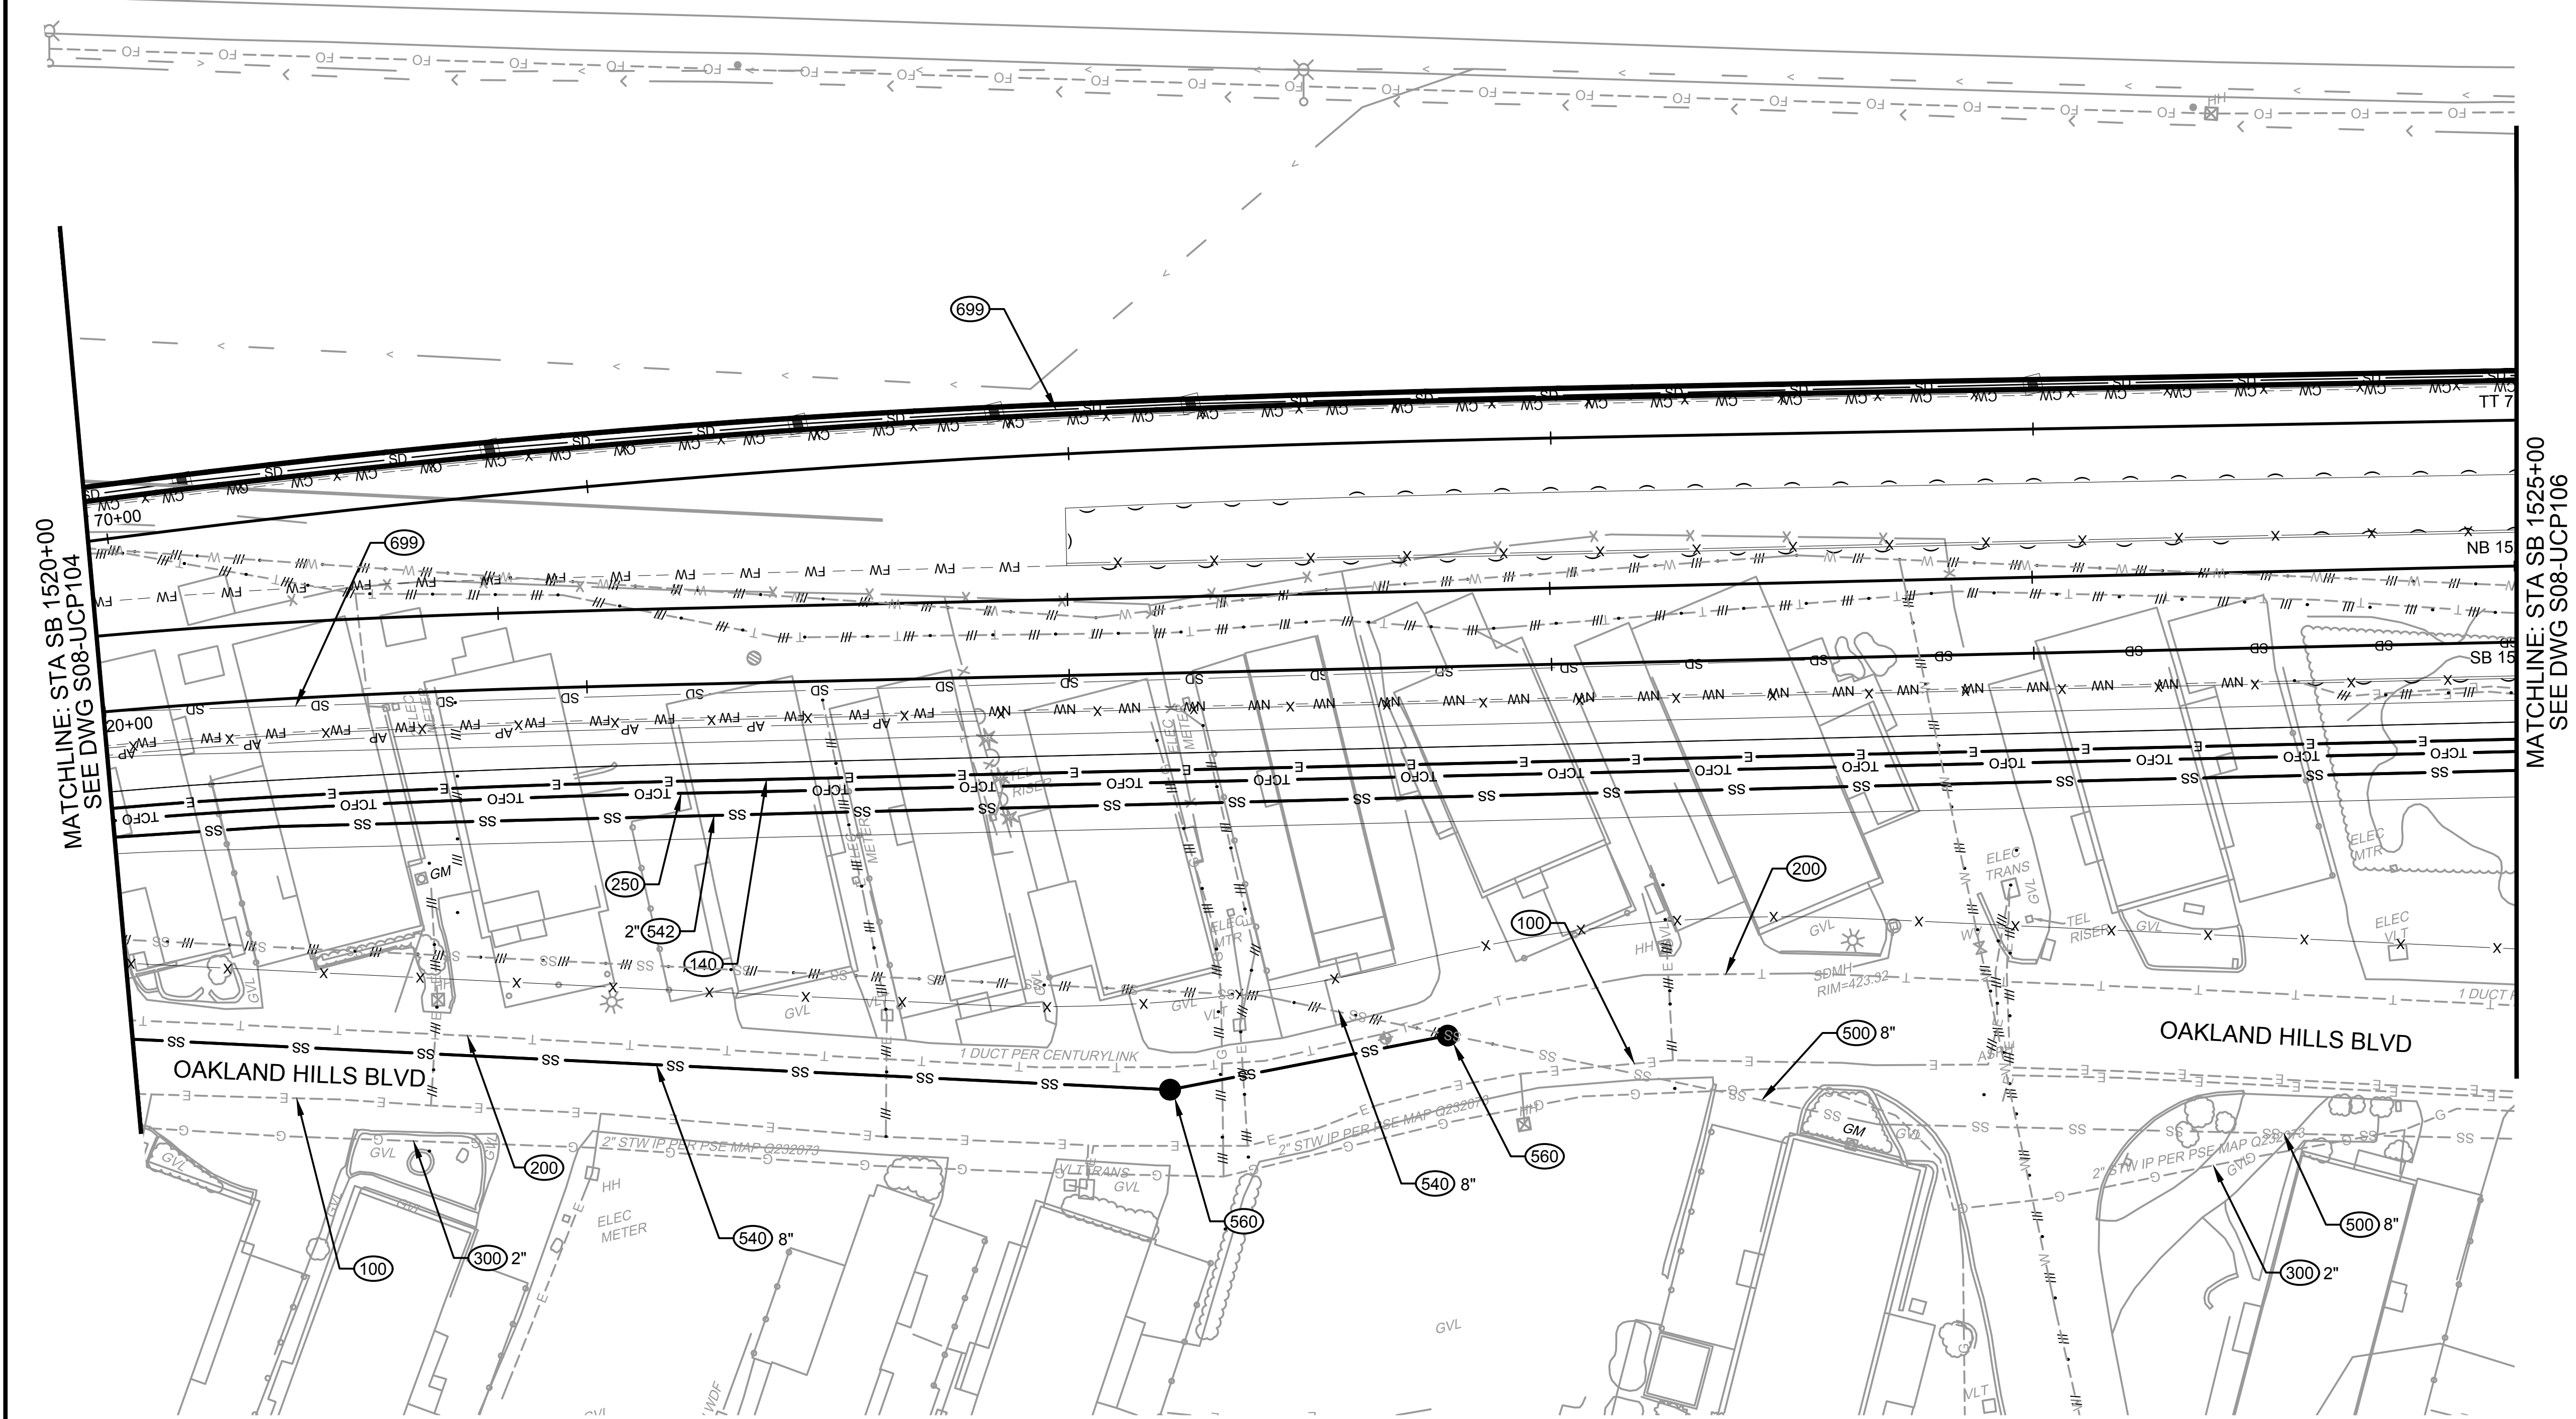

MATCHLINE: STA SB 1520+00
SEE DWG S08-UCP104

MATCHLINE: STA SB 1525+00
SEE DWG S08-UCP106

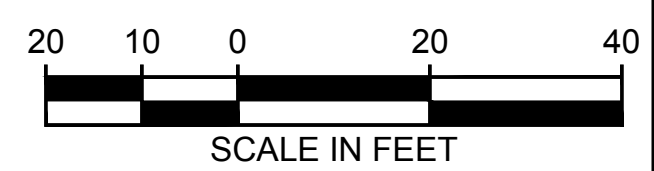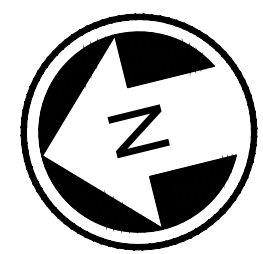

NOT FOR
CONSTRUCTION

Refer to the plan set COVER drawing
for disclaimers regarding this drawing.

REFERENCE CONCEPT DRAWINGS					
No.	DATE	DSN	CHK	APP	REVISION

DESIGNED BY:	J. SANNON
DRAWN BY:	E. HERRMANN
CHECKED BY:	M. STARLING
APPROVED BY:	P. LOPEZ-HILFIKER

AHJ: CITY OF FEDERAL WAY, LAKEHAVEN WATER AND SEWER DISTRICT							PACKAGE #				
PRELIMINARY					LINE IS 1" AT FULL SCALE		SCALE: 1"=20'		SOUND TRANSIT PRELIMINARY ENGINEERING PLANS OPERATIONS & MAINTENANCE FACILITY SOUTH UTILITY COMPOSITE UTILITY PLANS STA SB1520+00 TO STA SB1525+00	DRAWING No.: S08-UCP105	
							FILENAME: OMFS-S08-UCP101-124			FACILITY ID: S08	
							CONTRACT No.: AE-0030-17			SHEET No.: REV:	
							DATE: 2/27/2024			0	
	SUBMITTED BY: PABLO LOPEZ-HILFIKER		DATE: 2/27/2024		REVIEWED BY:		DATE: 2/27/2024				

KEY NOTES:

SEE SHEET S08-UZN100 THIS SET FOR UTILITY
INSTALLATION DESCRIPTIONS AND DETAILS.

MATCHLINE: STA SB 1525+00
SEE DWG S08-UCP105


MATCHLINE: STA SB 1530+00
SEE DWG S08-UCP107

Refer to the plan set COVER drawing
for disclaimers regarding this drawing.

REFERENCE CONCEPT DRAWINGS					
No.	DATE	DSN	CHK	APP	REVISION

DESIGNED BY:	J. SANNON
DRAWN BY:	E. HERRMANN
CHECKED BY:	M. STARLING
APPROVED BY:	P. LOPEZ-HILFIKER

AHJ: CITY OF FEDERAL WAY, LAKEHAVEN WATER AND SEWER DISTRICT					PACKAGE #				
PRELIMINARY				LINE IS 1" AT FULL SCALE 	SCALE: 1"=20'	SOUND TRANSIT PRELIMINARY ENGINEERING PLANS OPERATIONS & MAINTENANCE FACILITY SOUTH UTILITY COMPOSITE UTILITY PLANS STA SB1525+00 TO STA SB1530+00			DRAWING No.:
					FILENAME: OMFS-S08-UCP101-124				S08-UCP106
					CONTRACT No.:				FACILITY ID:
					AE-0030-17				S08
	SUBMITTED BY: PABLO LOPEZ-HILFIKER		DATE: 2/27/2024	REVIEWED BY:	DATE: 2/27/2024	DATE: 2/27/2024			SHEET No.:
									0

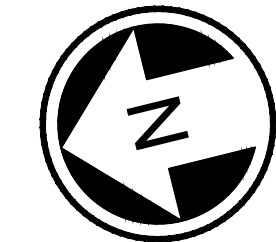

NOT FOR
CONSTRUCTION

02/20/24 1:35:21 PM J. SANNON
C:\PWORKING\WEST01\278055\OMFS-S08-UCP101-124.DWG


Refer to the plan set COVER drawing
for disclaimers regarding this drawing.

REFERENCE CONCEPT DRAWINGS

No.	DATE	DSN	CHK	APP	REVISION

DESIGNED BY:
J. SANNON
DRAWN BY:
E. HERRMANN
CHECKED BY:
M. STARLING
APPROVED BY:
P. LOPEZ-HILFIKER

PRELIMINARY

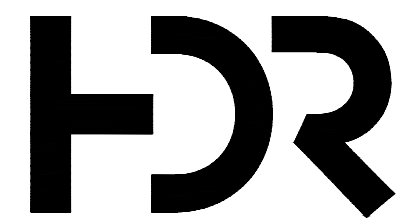

SUBMITTED BY:
PABLO LOPEZ-HILFIKER

DATE:
2/27/2024

REVIEWED BY:



DATE:
2/27/2024


PACKAGE

SCALE:
1"=20'
FILENAME:
OMFS-S08-UCP101-124
CONTRACT No.:
AE-0030-17
DATE:
2/27/2024

SOUND TRANSIT
PRELIMINARY ENGINEERING PLANS
OPERATIONS & MAINTENANCE FACILITY SOUTH



UTILITY
COMPOSITE UTILITY PLANS
STA SB1530+00 TO STA SB1535+00

DRAWING No.:
S08-UCP107
FACILITY ID:
S08
SHEET No.:
REV:
0

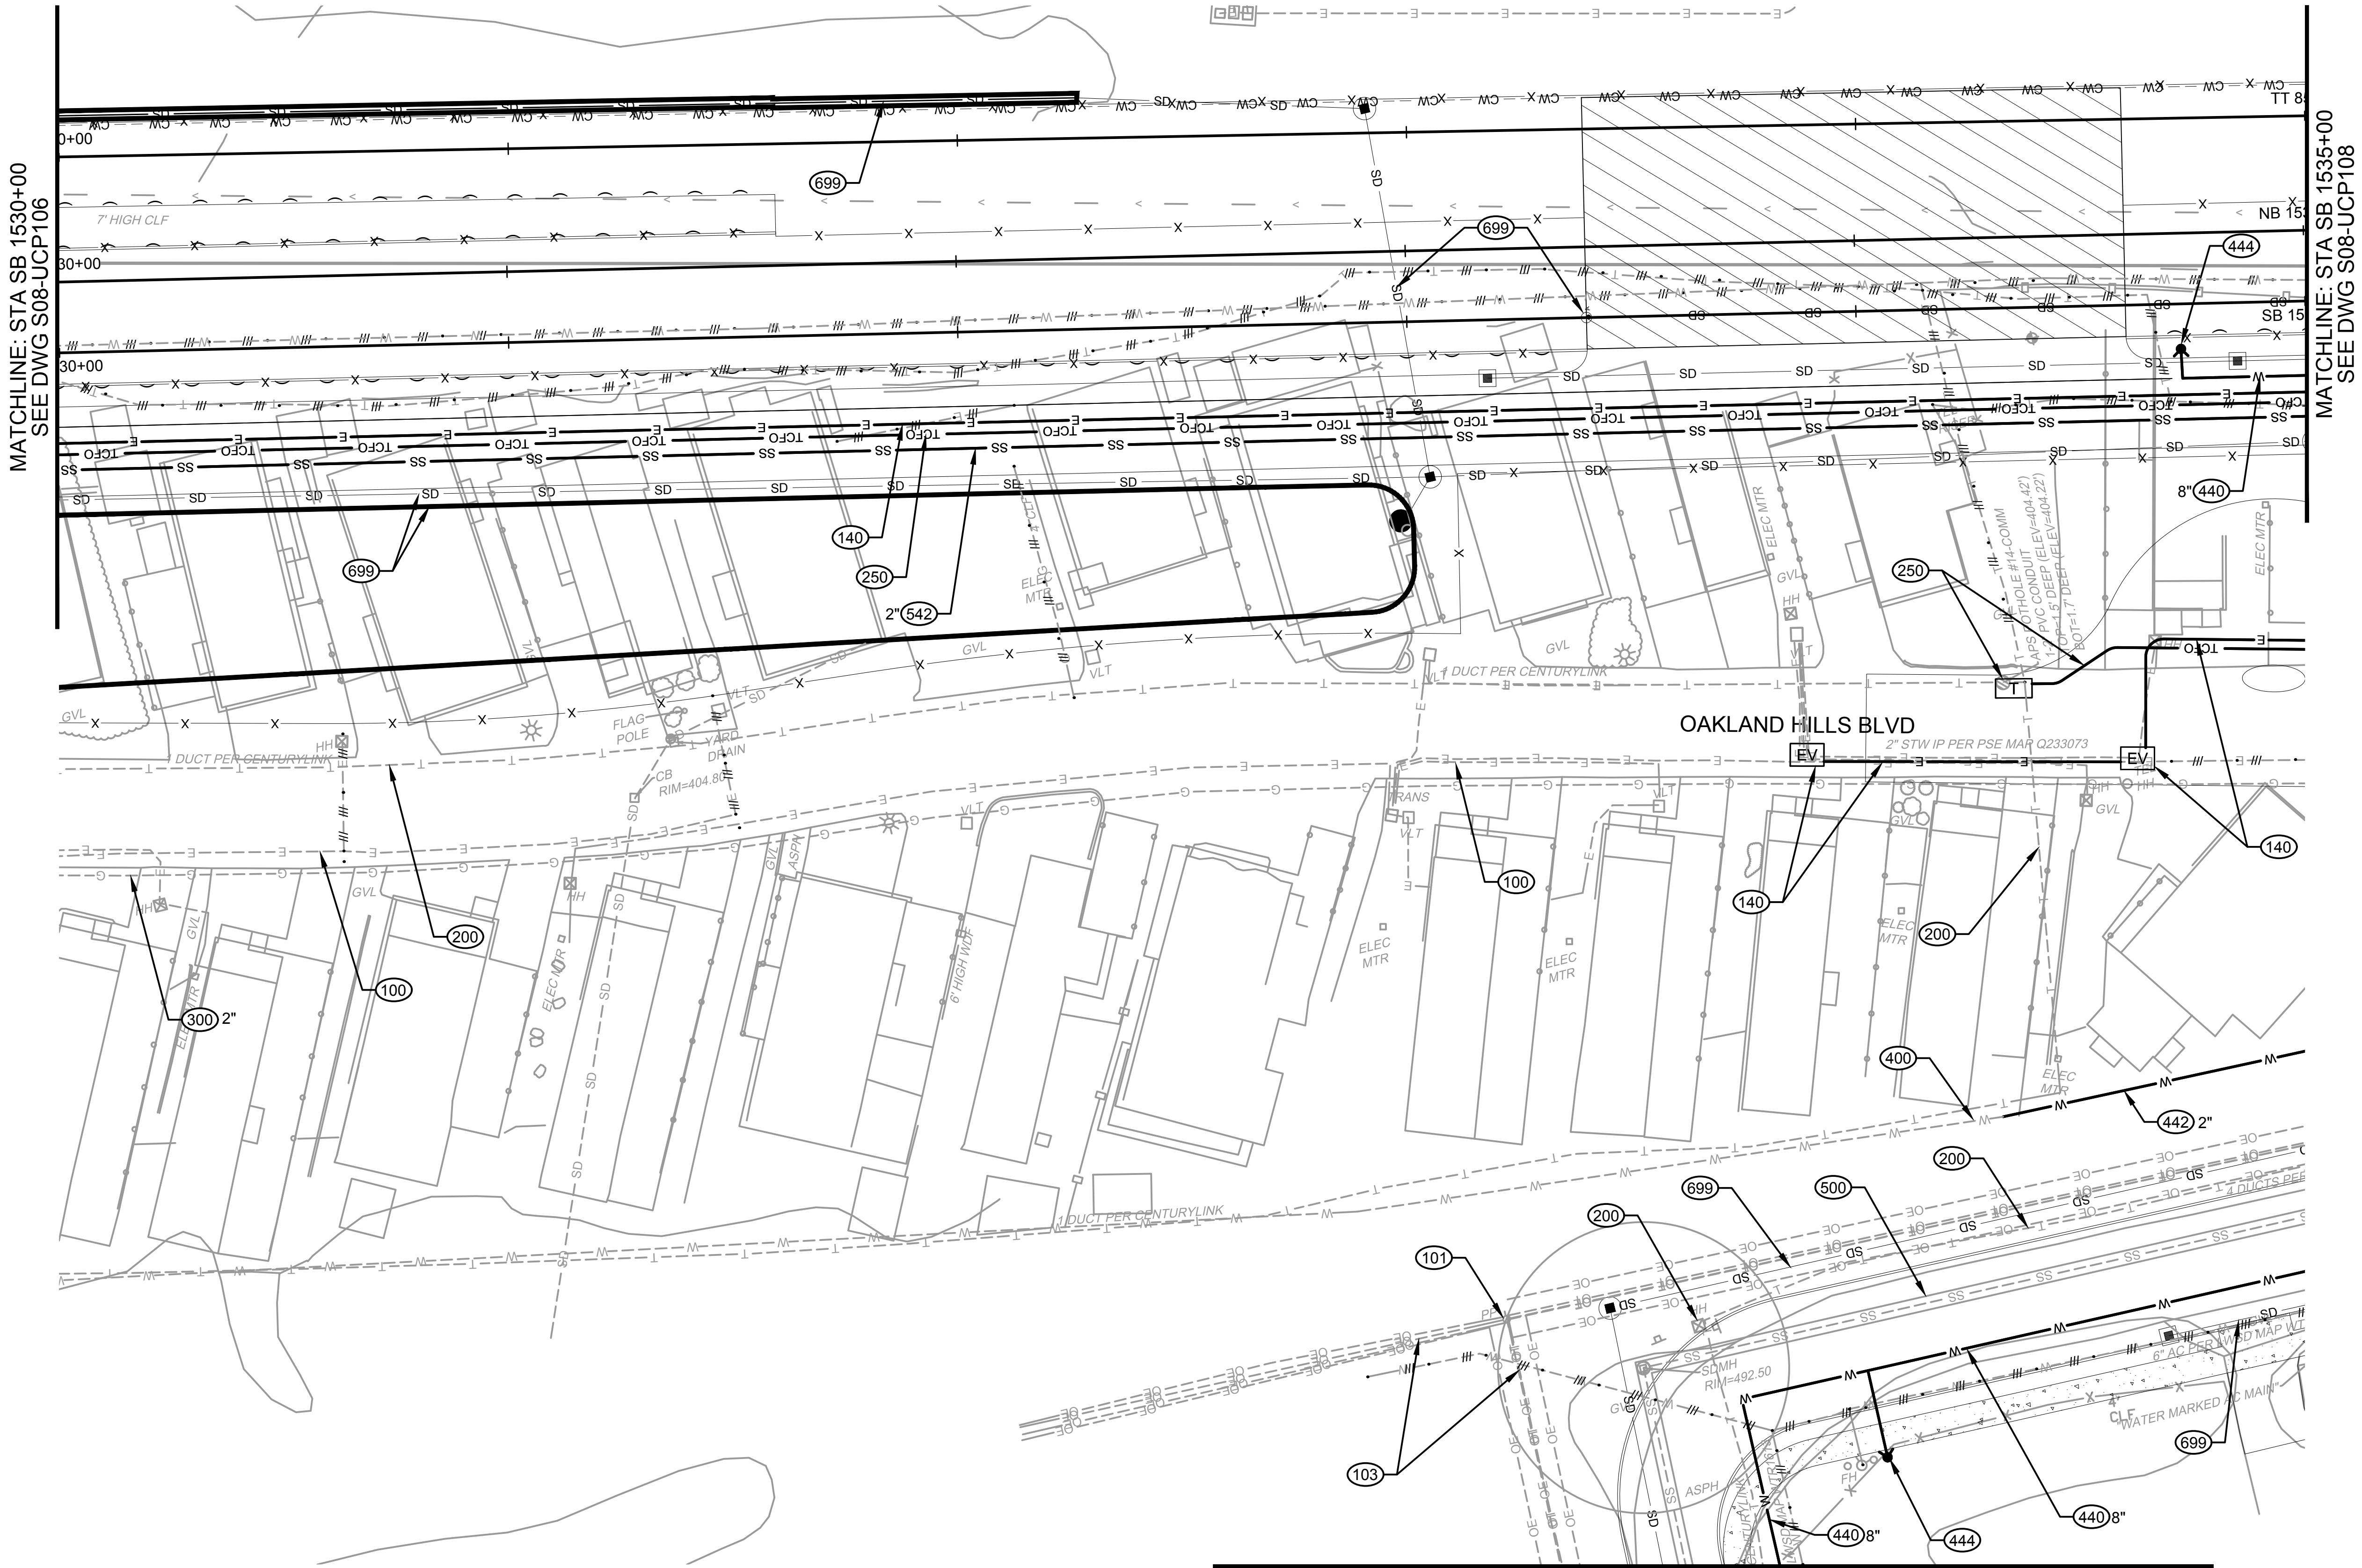

KEY NOTES:

- (XXX) SEE SHEET S08-UZN100 THIS SET FOR UTILITY
INSTALLATION DESCRIPTIONS AND DETAILS.

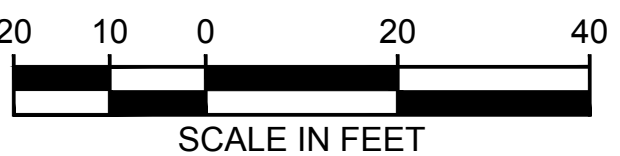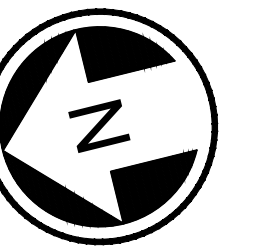


NOT FOR
CONSTRUCTION


02/20/24 1:35:22 PM J. SANNON
C:\PWORKING\WEST01\278055\OMFS-S08-UCP101-124.DWG

MATCHLINE: STA SB 1535+00
SEE DWG S08-UCP107

MATCHLINE: STA SB 1540+00
SEE DWG S08-UCP109

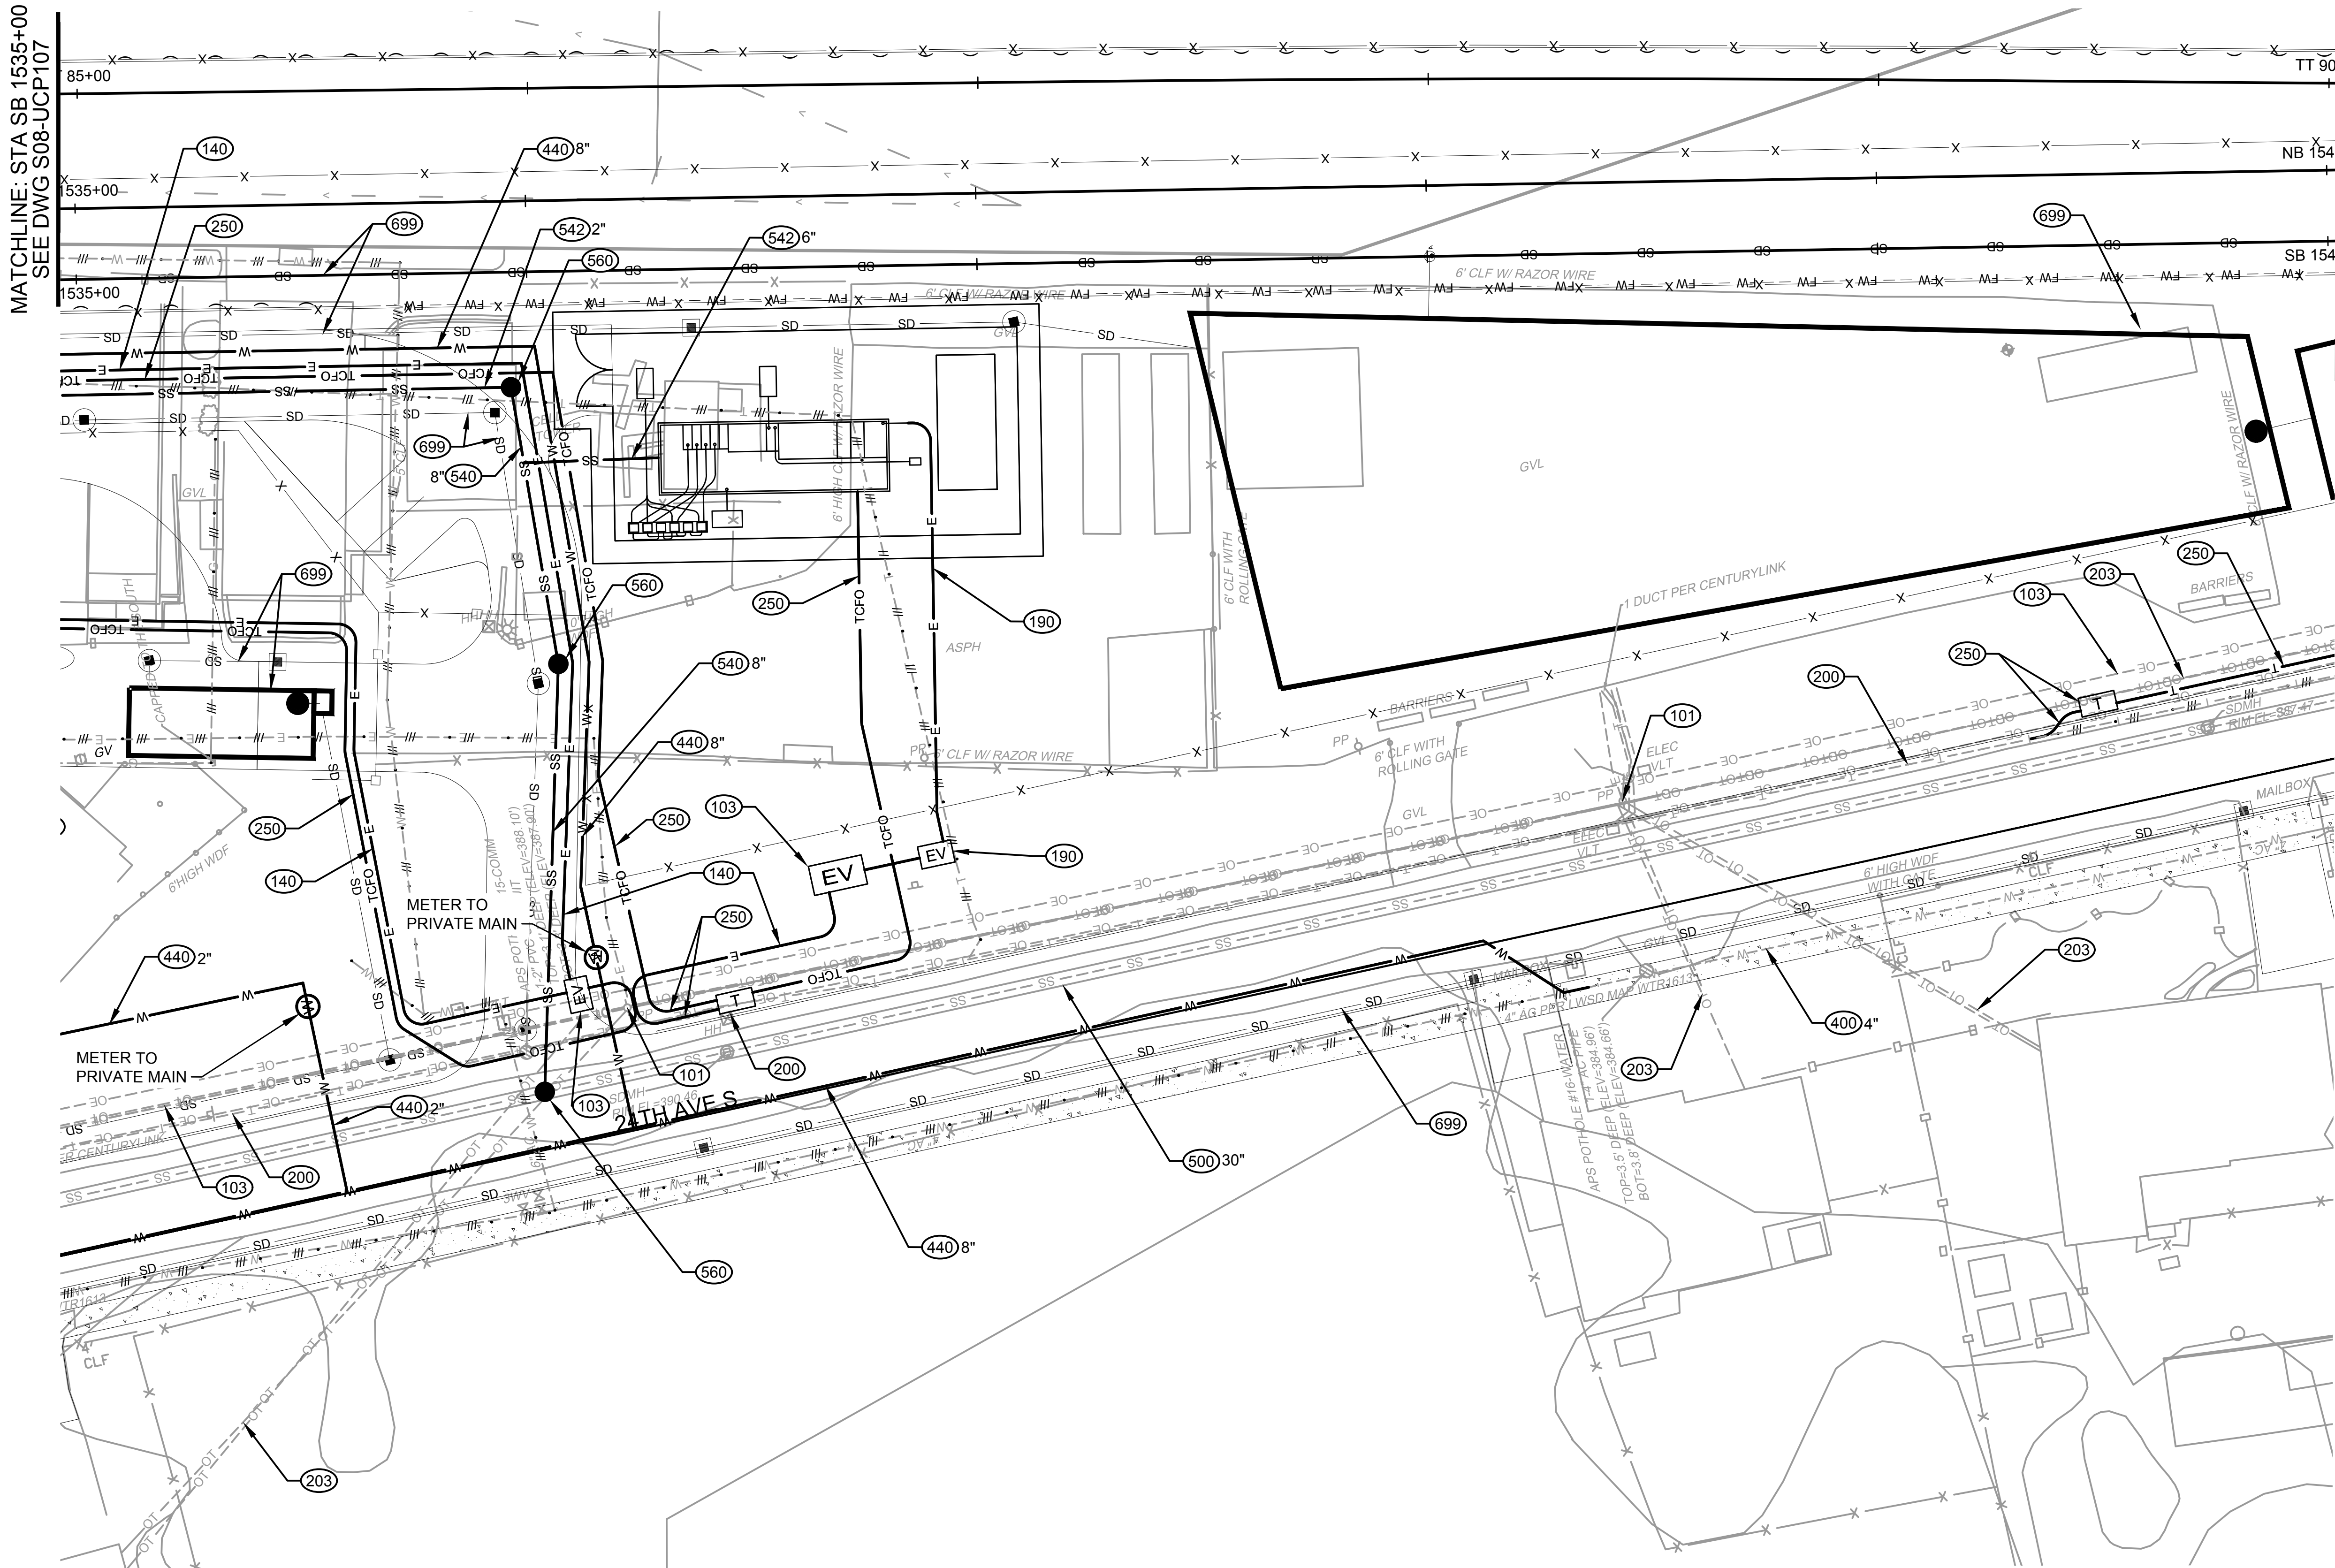

KEY NOTES:
(XXX) SEE SHEET S08-UZN100 THIS SET FOR UTILITY
INSTALLATION DESCRIPTIONS AND DETAILS.

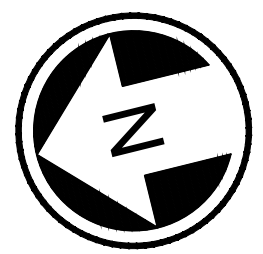

NOT FOR
CONSTRUCTION

Refer to the plan set COVER drawing
for disclaimers regarding this drawing.

REFERENCE CONCEPT DRAWINGS					
No.	DATE	DSN	CHK	APP	REVISION

DESIGNED BY:	J. SANNON
DRAWN BY:	E. HERRMANN
CHECKED BY:	M. STARLING
APPROVED BY:	P. LOPEZ-HILFIKER



AHJ: CITY OF FEDERAL WAY, LAKEHAVEN WATER AND SEWER DISTRICT					PACKAGE #							
PRELIMINARY				LINE IS 1" AT FULL SCALE	 SOUNDTRANSIT		SCALE: 1"=20'		SOUND TRANSIT PRELIMINARY ENGINEERING PLANS OPERATIONS & MAINTENANCE FACILITY SOUTH UTILITY COMPOSITE UTILITY PLANS STA SB1535+00 TO STA SB1540+00		DRAWING No.: S08-UCP108	
							FILENAME: OMFS-S08-UCP101-124				FACILITY ID: S08	
							CONTRACT No.: AE-0030-17				SHEET No.: REV:	
							DATE: 2/27/2024				0	
	SUBMITTED BY: PABLO LOPEZ-HILFIKER		DATE: 2/27/2024		REVIEWED BY:		DATE: 2/27/2024					

KEY NOTES:

SEE SHEET S08-UZN100 THIS SET FOR UTILITY
INSTALLATION DESCRIPTIONS AND DETAILS.

MATCHLINE: STA SB 1540+00
SEE DWG S08-UCP108

MATCHLINE: STA SB 1545+00
SEE DWG S08-UCP110

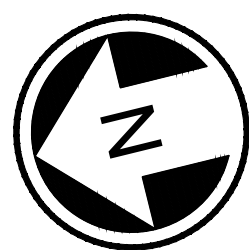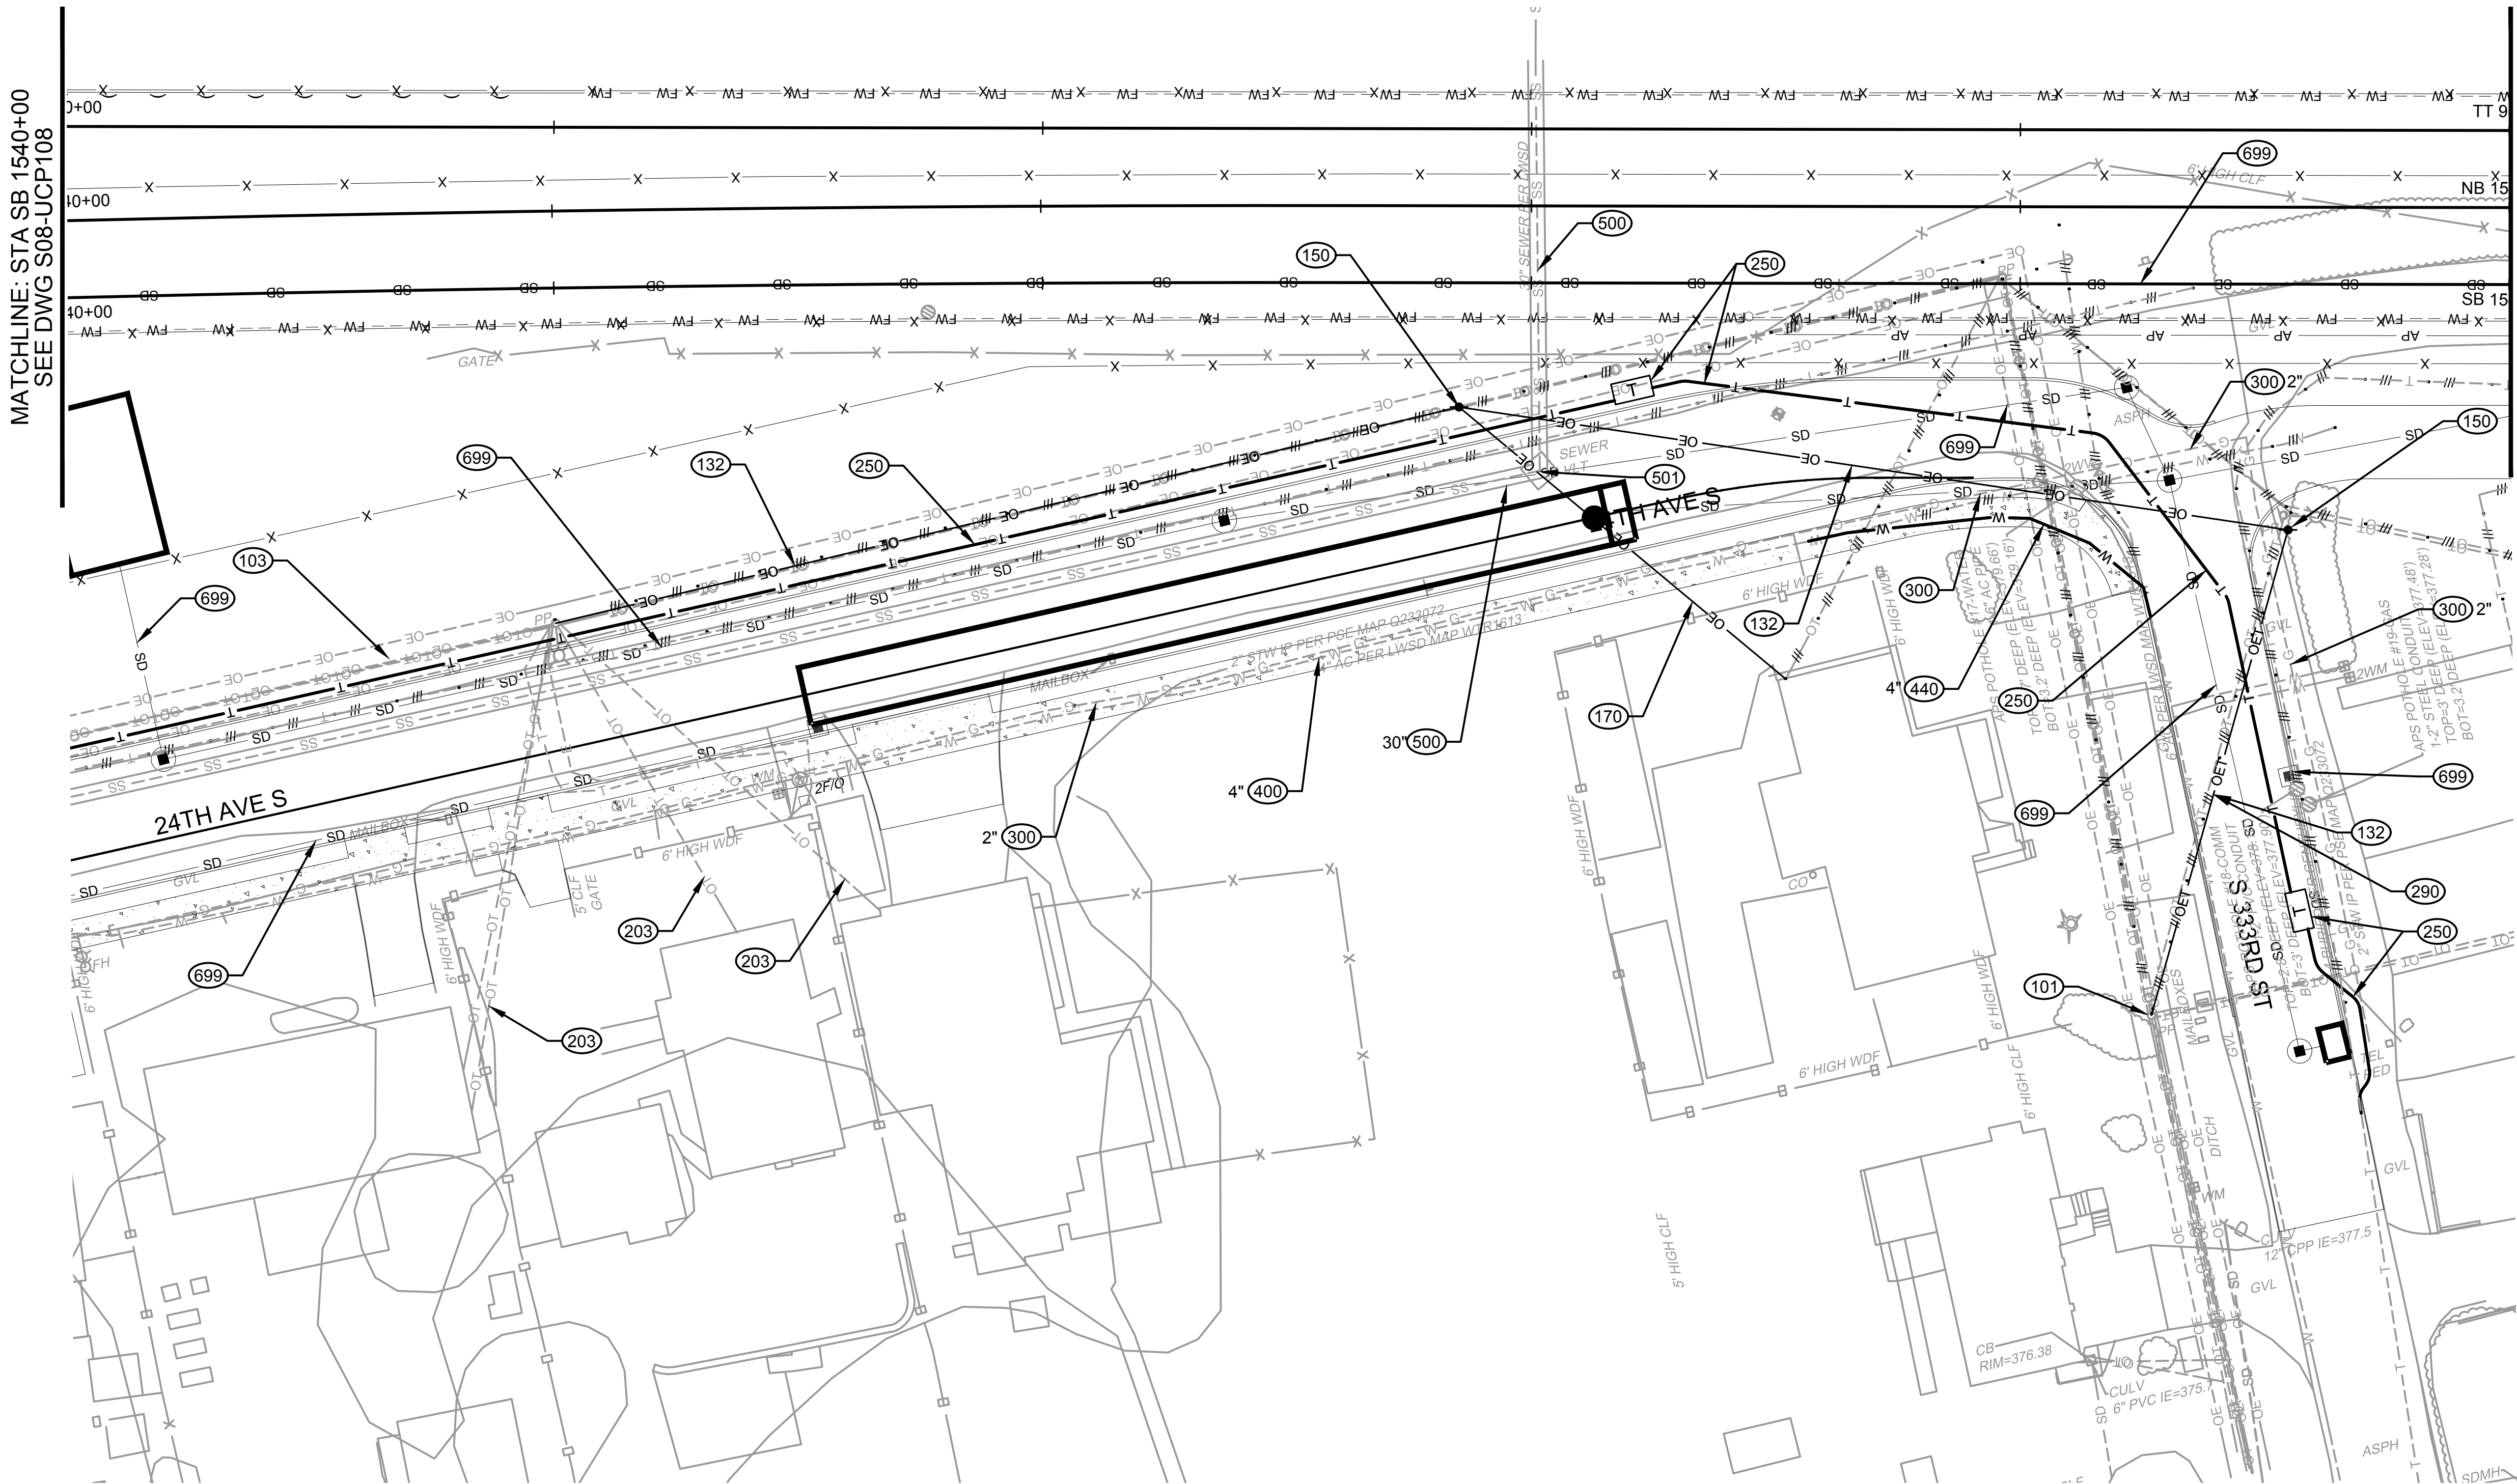

NOT FOR
CONSTRUCTION

Refer to the plan set COVER drawing
for disclaimers regarding this drawing.


REFERENCE CONCEPT DRAWINGS

No.	DATE	DSN	CHK	APP	REVISION

DESIGNED BY:
J. SANNON
DRAWN BY:
E. HERRMANN
CHECKED BY:
M. STARLING
APPROVED BY:
P. LOPEZ-HILFIKER

AHJ: CITY OF FEDERAL WAY, LAKEHAVEN WATER AND SEWER DISTRICT

PRELIMINARY

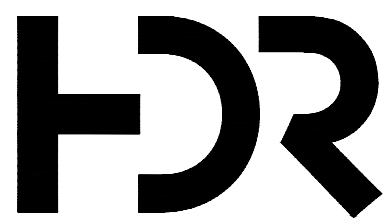

SUBMITTED BY:
PABLO LOPEZ-HILFIKER

DATE:
2/27/2024

REVIEWED BY:



DATE:
2/27/2024

PACKAGE #

SCALE:
1"=20'
FILENAME:
OMFS-S08-UCP101-124
CONTRACT No.:
AE-0030-17
DATE:
2/27/2024

SOUND TRANSIT
PRELIMINARY ENGINEERING PLANS
OPERATIONS & MAINTENANCE FACILITY SOUTH

UTILITY
COMPOSITE UTILITY PLANS
STA SB1540+00 TO STA SB1545+00

DRAWING No.:
S08-UCP109
FACILITY ID:
S08
SHEET No.:
REV:
0

KEY NOTES:

SEE SHEET S08-UZN100 THIS SET FOR UTILITY
INSTALLATION DESCRIPTIONS AND DETAILS.

MATCHLINE: STA SB 1545+00
SEE DWG S08-UCP109


MATCHLINE: STA SB 1550+00
SEE DWG S08-UCP111

Refer to the plan set COVER drawing
for disclaimers regarding this drawing.

REFERENCE CONCEPT DRAWINGS					
No.	DATE	DSN	CHK	APP	REVISION

DESIGNED BY: J. SANNON
DRAWN BY: E. HERRMANN
CHECKED BY: M. STARLING
APPROVED BY: P. LOPEZ-HILFIKER

PRELIMINARY

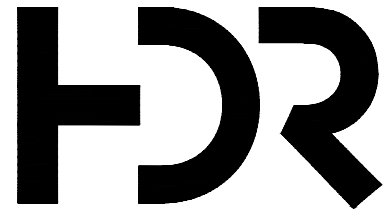

SUBMITTED BY:
PABLO LOPEZ-HILFIKER

DATE:
2/27/2024

REVIEWED BY:

LINE IS 1" AT
FULL SCALE




SOUNDTRANSIT

PACKAGE #
SCALE: 1"=20'
FILENAME: OMFS-S08-UCP101-124
CONTRACT No.: AE-0030-17
DATE: 2/27/2024

SOUND TRANSIT
PRELIMINARY ENGINEERING PLANS
OPERATIONS & MAINTENANCE FACILITY SOUTH

UTILITY
COMPOSITE UTILITY PLANS
STA SB1545+00 TO STA SB1550+00

DRAWING No.: S08-UCP110
FACILITY ID: S08
SHEET No.: REV: 0

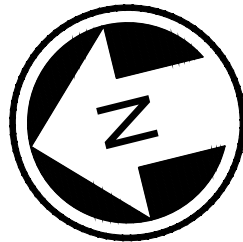

NOT FOR
CONSTRUCTION

KEY NOTES:

SEE SHEET S08-UZN100 THIS SET FOR UTILITY
INSTALLATION DESCRIPTIONS AND DETAILS.

MATCHLINE: STA SB 1550+00
SEE DWG S08-UCP110

02/20/24 1:35:33 PM J SANNON
C:\PWORKING\WEST01\278055\OMFS-S08-UCP101-124.DWG

Refer to the plan set COVER drawing
for disclaimers regarding this drawing.


REFERENCE CONCEPT DRAWINGS

No.	DATE	DSN	CHK	APP	REVISION

DESIGNED BY:
J. SANNON
DRAWN BY:
E. HERRMANN
CHECKED BY:
M. STARLING
APPROVED BY:
P. LOPEZ-HILFIKER

AHJ: CITY OF FEDERAL WAY, LAKEHAVEN WATER AND SEWER DISTRICT

PRELIMINARY

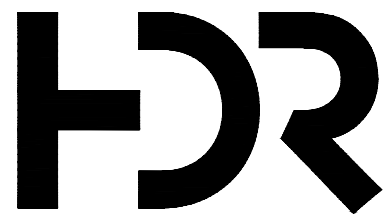

SUBMITTED BY:
PABLO LOPEZ-HILFIKER

DATE:
2/27/2024

REVIEWED BY:



DATE:
2/27/2024


PACKAGE #

SCALE:
1"=20'
FILENAME:
OMFS-S08-UCP101-124
CONTRACT No.:
AE-0030-17
DATE:
2/27/2024

SOUND TRANSIT
PRELIMINARY ENGINEERING PLANS
OPERATIONS & MAINTENANCE FACILITY SOUTH

UTILITY
COMPOSITE UTILITY PLANS
STA SB1550+00 TO STA SB1555+00

DRAWING No.:
S08-UCP111
FACILITY ID:
S08
SHEET No.:
REV:
0

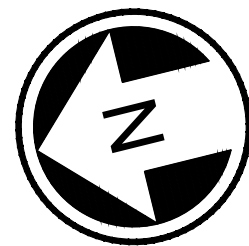

NOT FOR
CONSTRUCTION

SEE DWG S08-UCP124



02/20/24 | 3:53 PM | JSANNON
C:\PWORKING\WEST01\278055\OMFS-S08-UCP101-124.DWG

Refer to the plan set COVER drawing
for disclaimers regarding this drawing.



REFERENCE CONCEPT DRAWINGS					
No.	DATE	DSN	CHK	APP	REVISION

DESIGNED BY:	J. SANNON
DRAWN BY:	E. HERRMANN
CHECKED BY:	M. STARLING
APPROVED BY:	P. LOPEZ-HILFIKER

AHJ: CITY OF FEDERAL WAY, LAKEHAVEN WATER AND SEWER DISTRICT						PACKAGE #						
PRELIMINARY					LINE IS 1" AT FULL SCALE	 SOUNDTRANSIT	SCALE: 1"=20'	SOUND TRANSIT PRELIMINARY ENGINEERING PLANS OPERATIONS & MAINTENANCE FACILITY SOUTH UTILITY COMPOSITE UTILITY PLANS			DRAWING No.: S08-UCP118	
							FILENAME: OMFS-S08-UCP101-124				FACILITY ID: S08	
							CONTRACT No.: AE-0030-17				SHEET No.: 0	
							DATE: 2/27/2024				REV: 0	
	SUBMITTED BY: PABLO LOPEZ-HILFIKER		DATE: 2/27/2024		REVIEWED BY:		DATE: 2/27/2024					

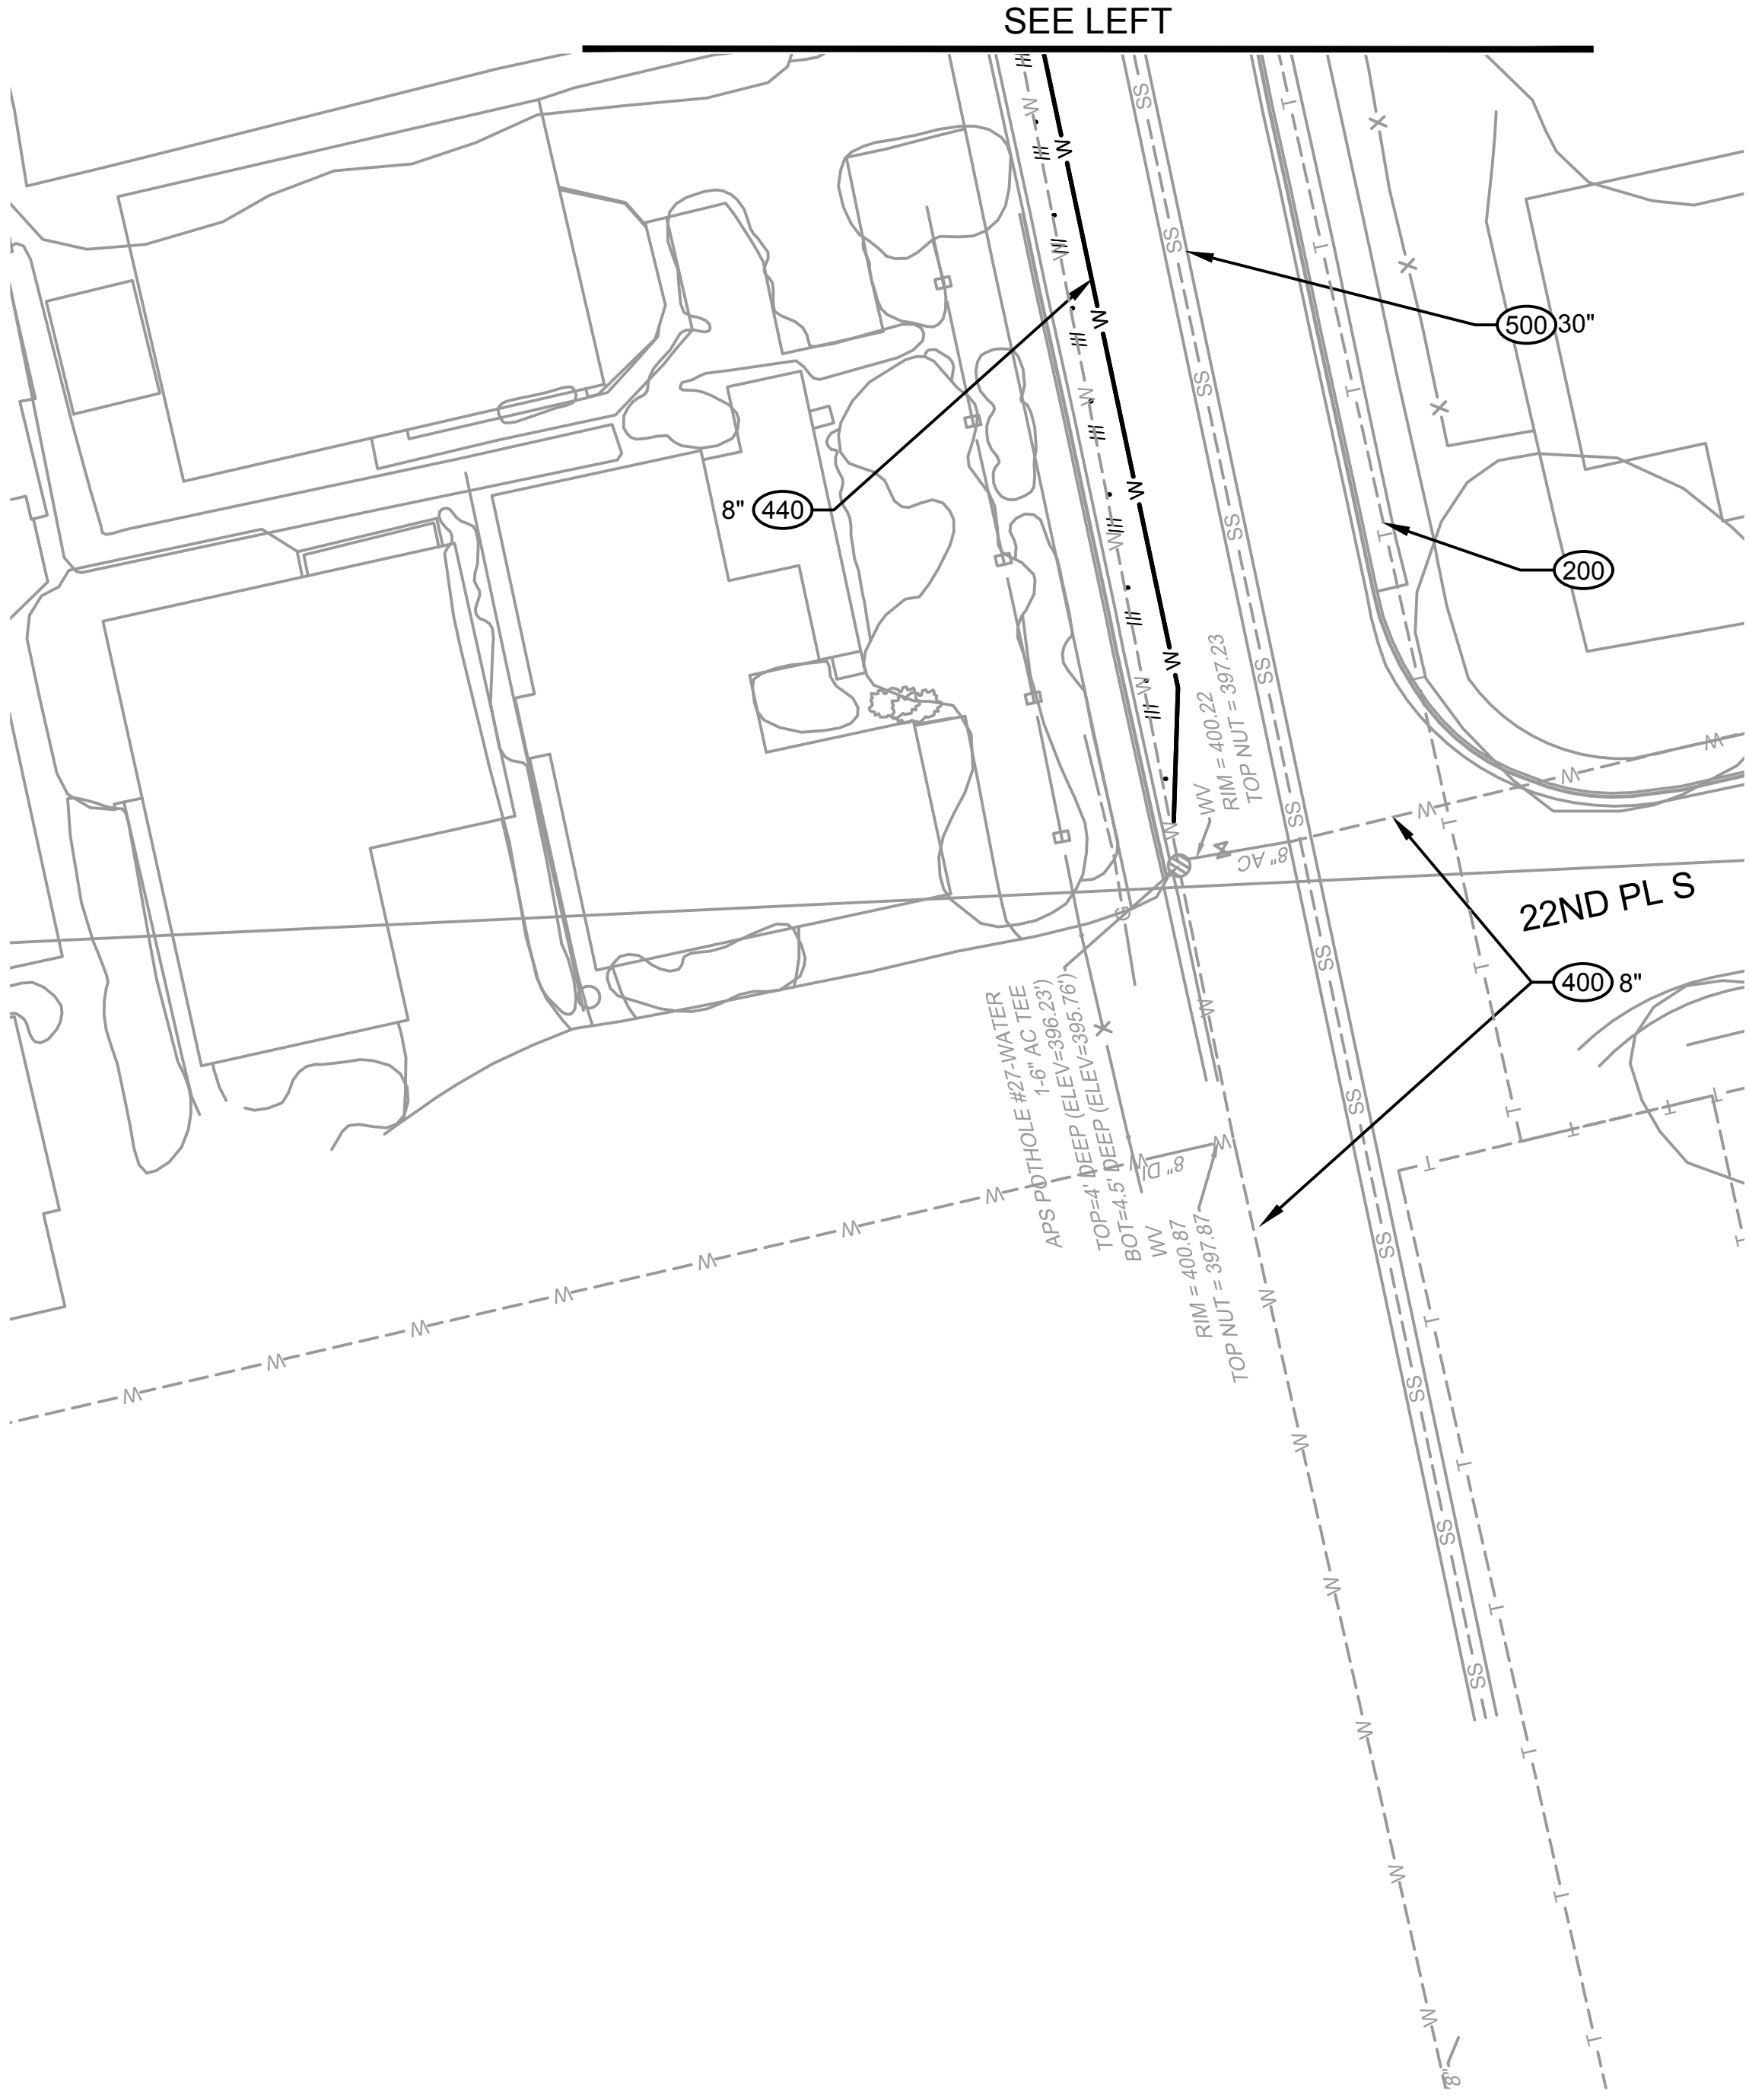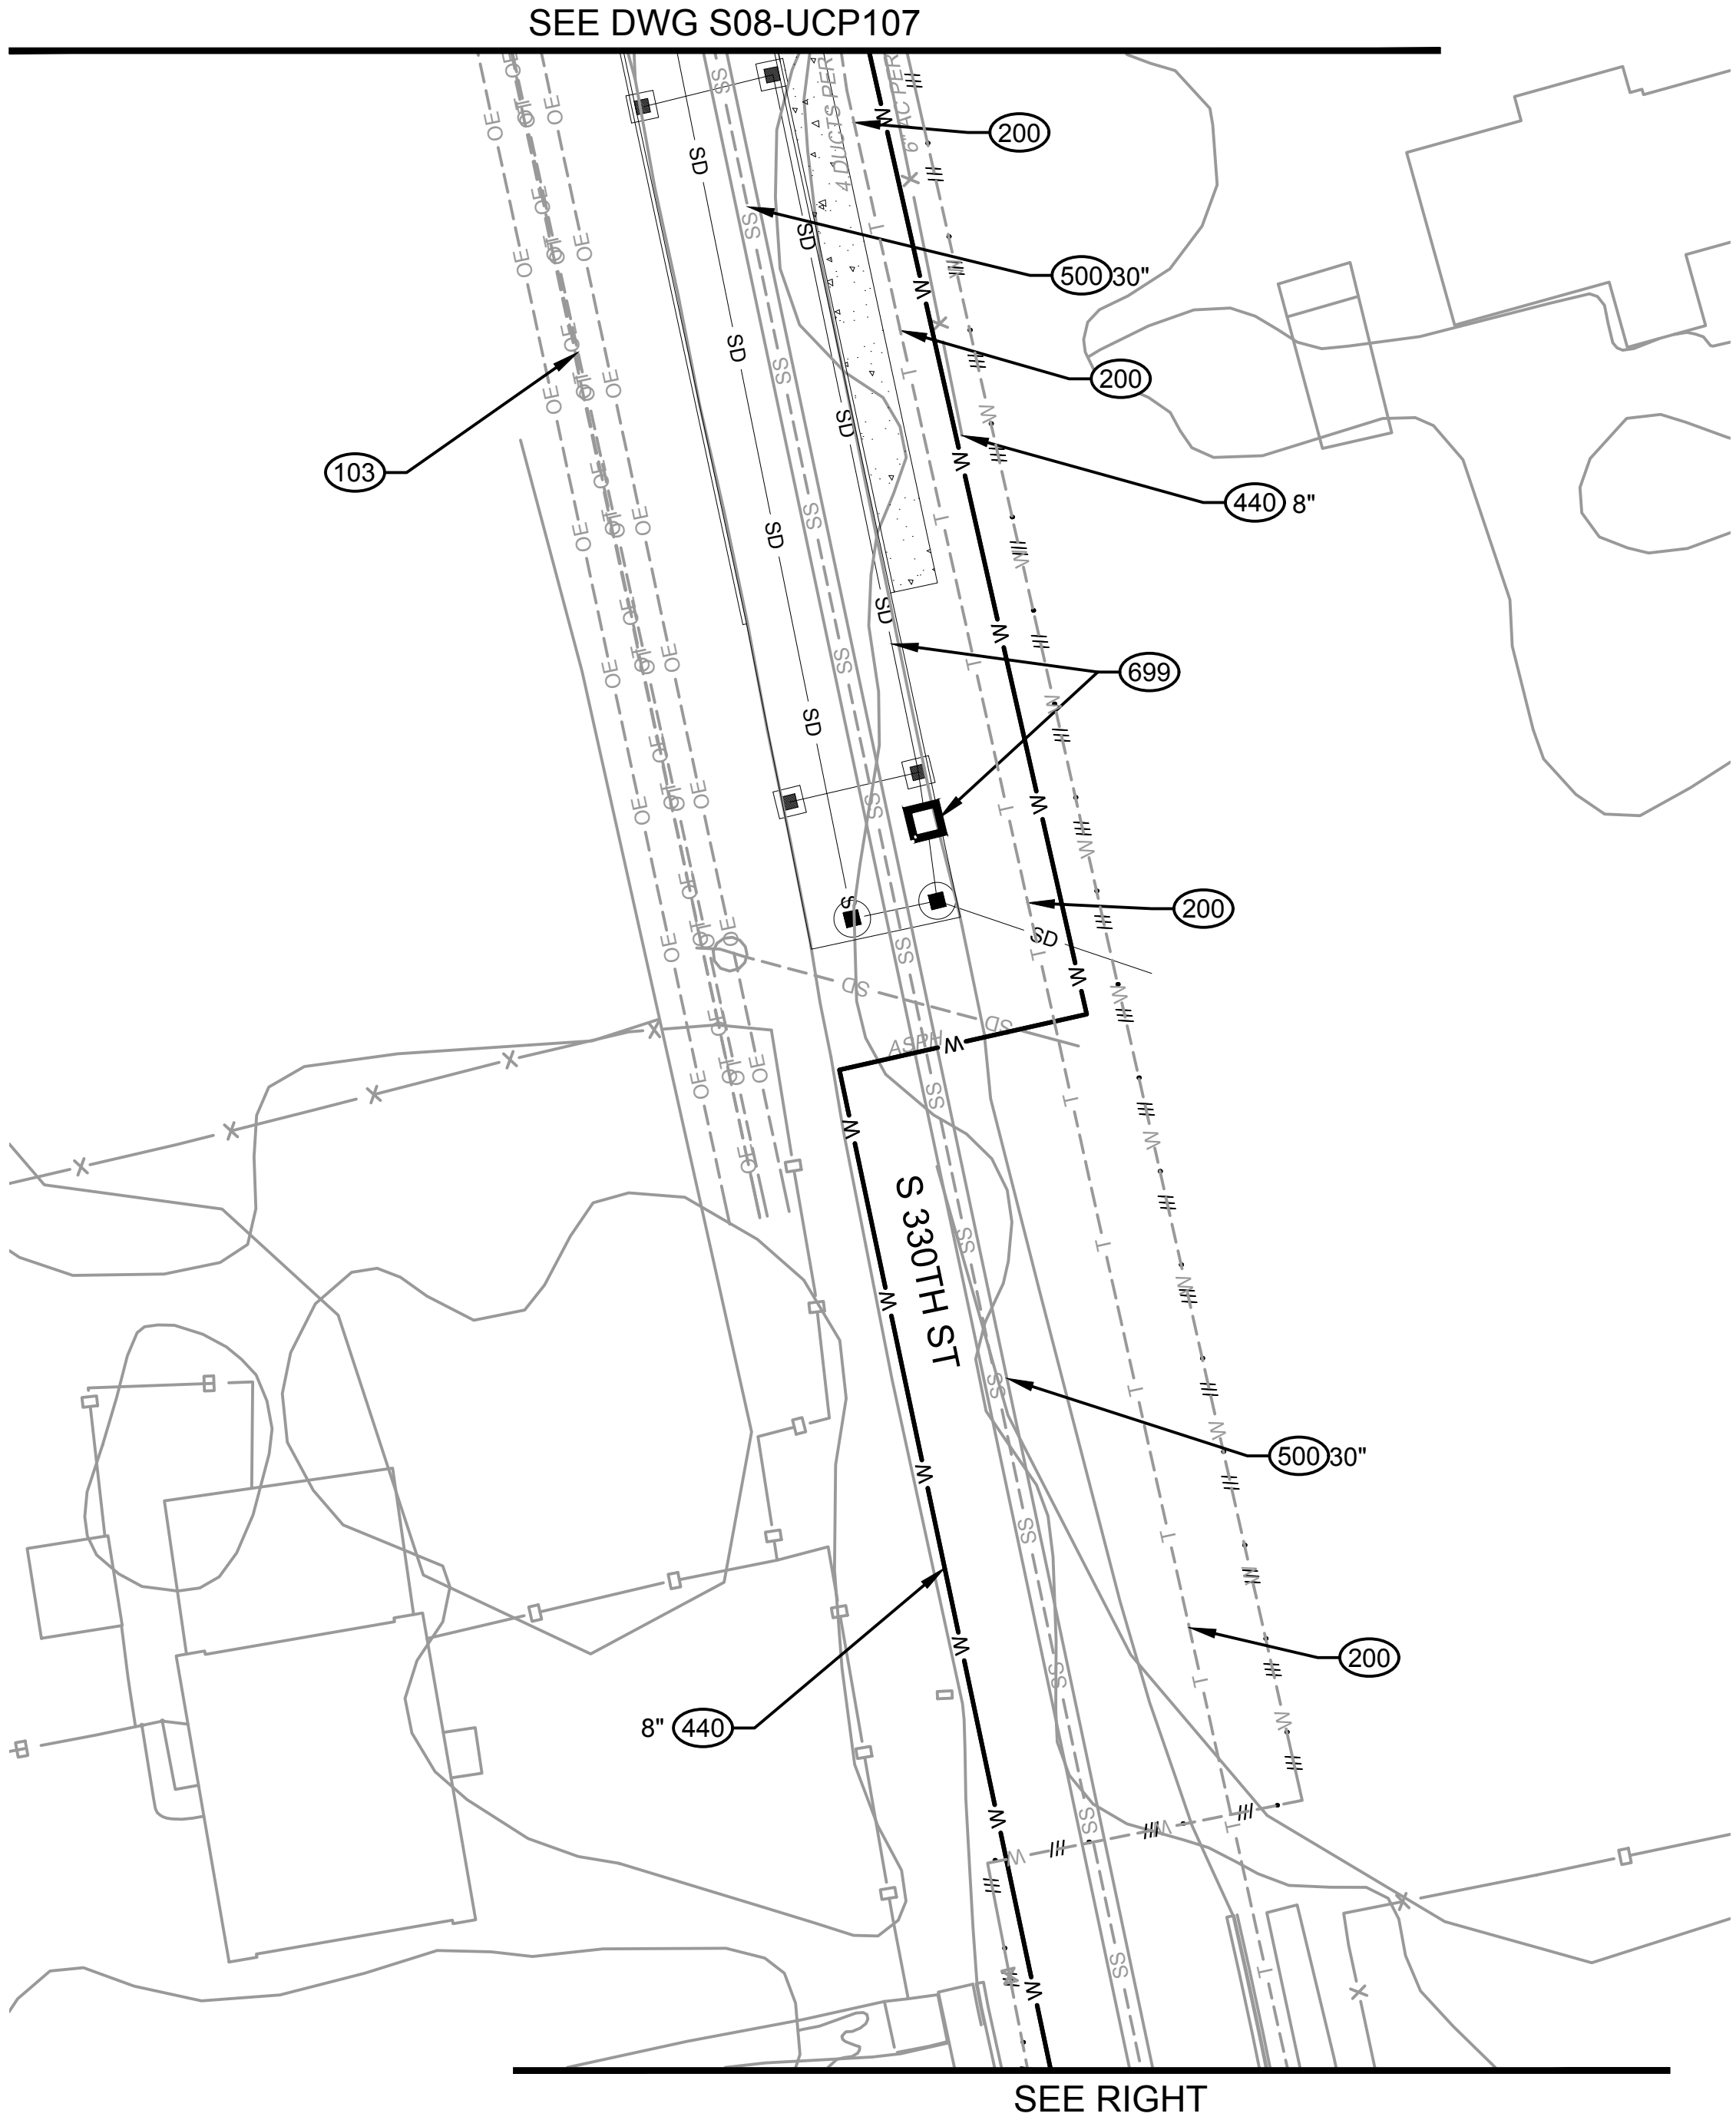


KEY NOTES:
XXX SEE SHEET S08-UZN100 THIS SET FOR UTILITY
INSTALLATION DESCRIPTIONS AND DETAILS.

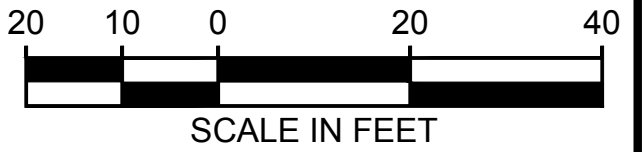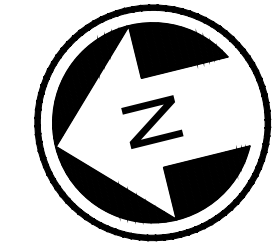

NOT FOR
CONSTRUCTION



KEY NOTES:
SEE SHEET S08-UZN100 THIS SET FOR UTILITY
INSTALLATION DESCRIPTIONS AND DETAILS.

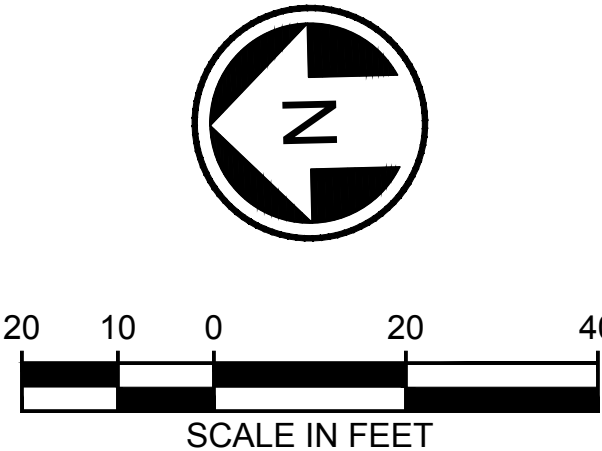

NOT FOR
CONSTRUCTION

Refer to the plan set COVER drawing
for disclaimers regarding this drawing.

REFERENCE CONCEPT DRAWINGS

No.	DATE	DSN	CHK	APP	REVISION

DESIGNED BY:	J. SANNON
DRAWN BY:	E. HERRMANN
CHECKED BY:	M. STARLING
APPROVED BY:	P. LOPEZ-HILFIKER

PRELIMINARY

SUBMITTED BY:
PABLO LOPEZ-HILFIKER

DATE:
2/27/2024

REVIEWED BY:

DATE:
2/27/2024

PACKAGE #
SCALE: 1"=20'
FILENAME: OMFS-S08-UCP101-124
CONTRACT No.: AE-0030-17
DATE: 2/27/2024

SOUND TRANSIT
PRELIMINARY ENGINEERING PLANS
OPERATIONS & MAINTENANCE FACILITY SOUTH
UTILITY
COMPOSITE UTILITY PLANS

DRAWING No.:	S08-UCP120
FACILITY ID:	S08
SHEET No.:	REV:
	0


02/20/24 | 3:53 PM | JSANNON
C:\PWORKING\WEST01\0278055\OMFS-S08-UCP101-124.DWG

Refer to the plan set COVER drawing
for disclaimers regarding this drawing.

REFERENCE CONCEPT DRAWINGS						
No.	DATE	DSN	CHK	APP	REVISION	

DESIGNED BY:	J. SANNON
DRAWN BY:	E. HERRMANN
CHECKED BY:	M. STARLING
APPROVED BY:	P. LOPEZ-HILFIKER

PRELIMINARY

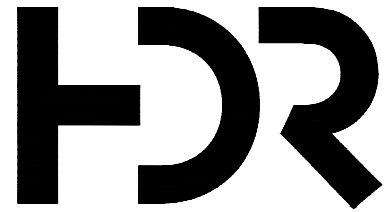

SUBMITTED BY:

PABLO LOPEZ-HILFIKER

DATE:

2/27/2024

REVIEWED BY:

LINE IS 1" AT
FULL SCALE



SOUNDTRANSIT


SCALE:	1"=20'
FILENAME:	OMFS-S08-UCP101-124
CONTRACT No.:	AE-0030-17
DATE:	2/27/2024

SOUND TRANSIT
PRELIMINARY ENGINEERING PLANS
OPERATIONS & MAINTENANCE FACILITY SOUTH
UTILITY
COMPOSITE UTILITY PLANS

DRAWING No.:	S08-UCP121
FACILITY ID:	S08
SHEET No.:	REV:
	0

KEY NOTES:
XXX SEE SHEET S08-UZN100 THIS SET FOR UTILITY
INSTALLATION DESCRIPTIONS AND DETAILS.



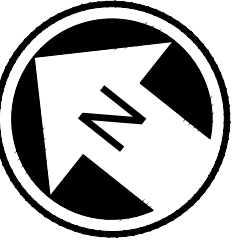

20 10 0 20 40

SCALE IN FEET

NOT FOR
CONSTRUCTION


02/2024 | 3:54 PM | JSANNON
C:\PWORKING\WEST01\278055\OMFS-S08-UCP101-124.DWG

Refer to the plan set COVER drawing
for disclaimers regarding this drawing.

REFERENCE CONCEPT DRAWINGS						
No.	DATE	DSN	CHK	APP	REVISION	

DESIGNED BY:	J. SANNON
DRAWN BY:	E. HERRMANN
CHECKED BY:	M. STARLING
APPROVED BY:	P. LOPEZ-HILFIKER

PRELIMINARY

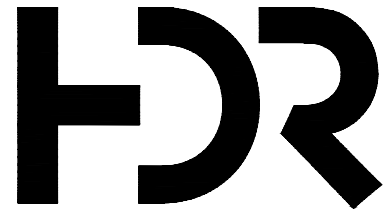

SUBMITTED BY:

PABLO LOPEZ-HILFIKER

DATE:

2/27/2024

REVIEWED BY:

LINE IS 1" AT FULL SCALE



SOUNDTRANSIT

PACKAGE #

SCALE:

1"=20'

FILENAME:

OMFS-S08-UCP101-124

CONTRACT No.:


AE-0030-17

DATE:


2/27/2024

SOUND TRANSIT
PRELIMINARY ENGINEERING PLANS
OPERATIONS & MAINTENANCE FACILITY SOUTH
UTILITY
COMPOSITE UTILITY PLANS

DRAWING No.:	S08-UCP124
FACILITY ID:	S08
SHEET No.:	REV:
	0

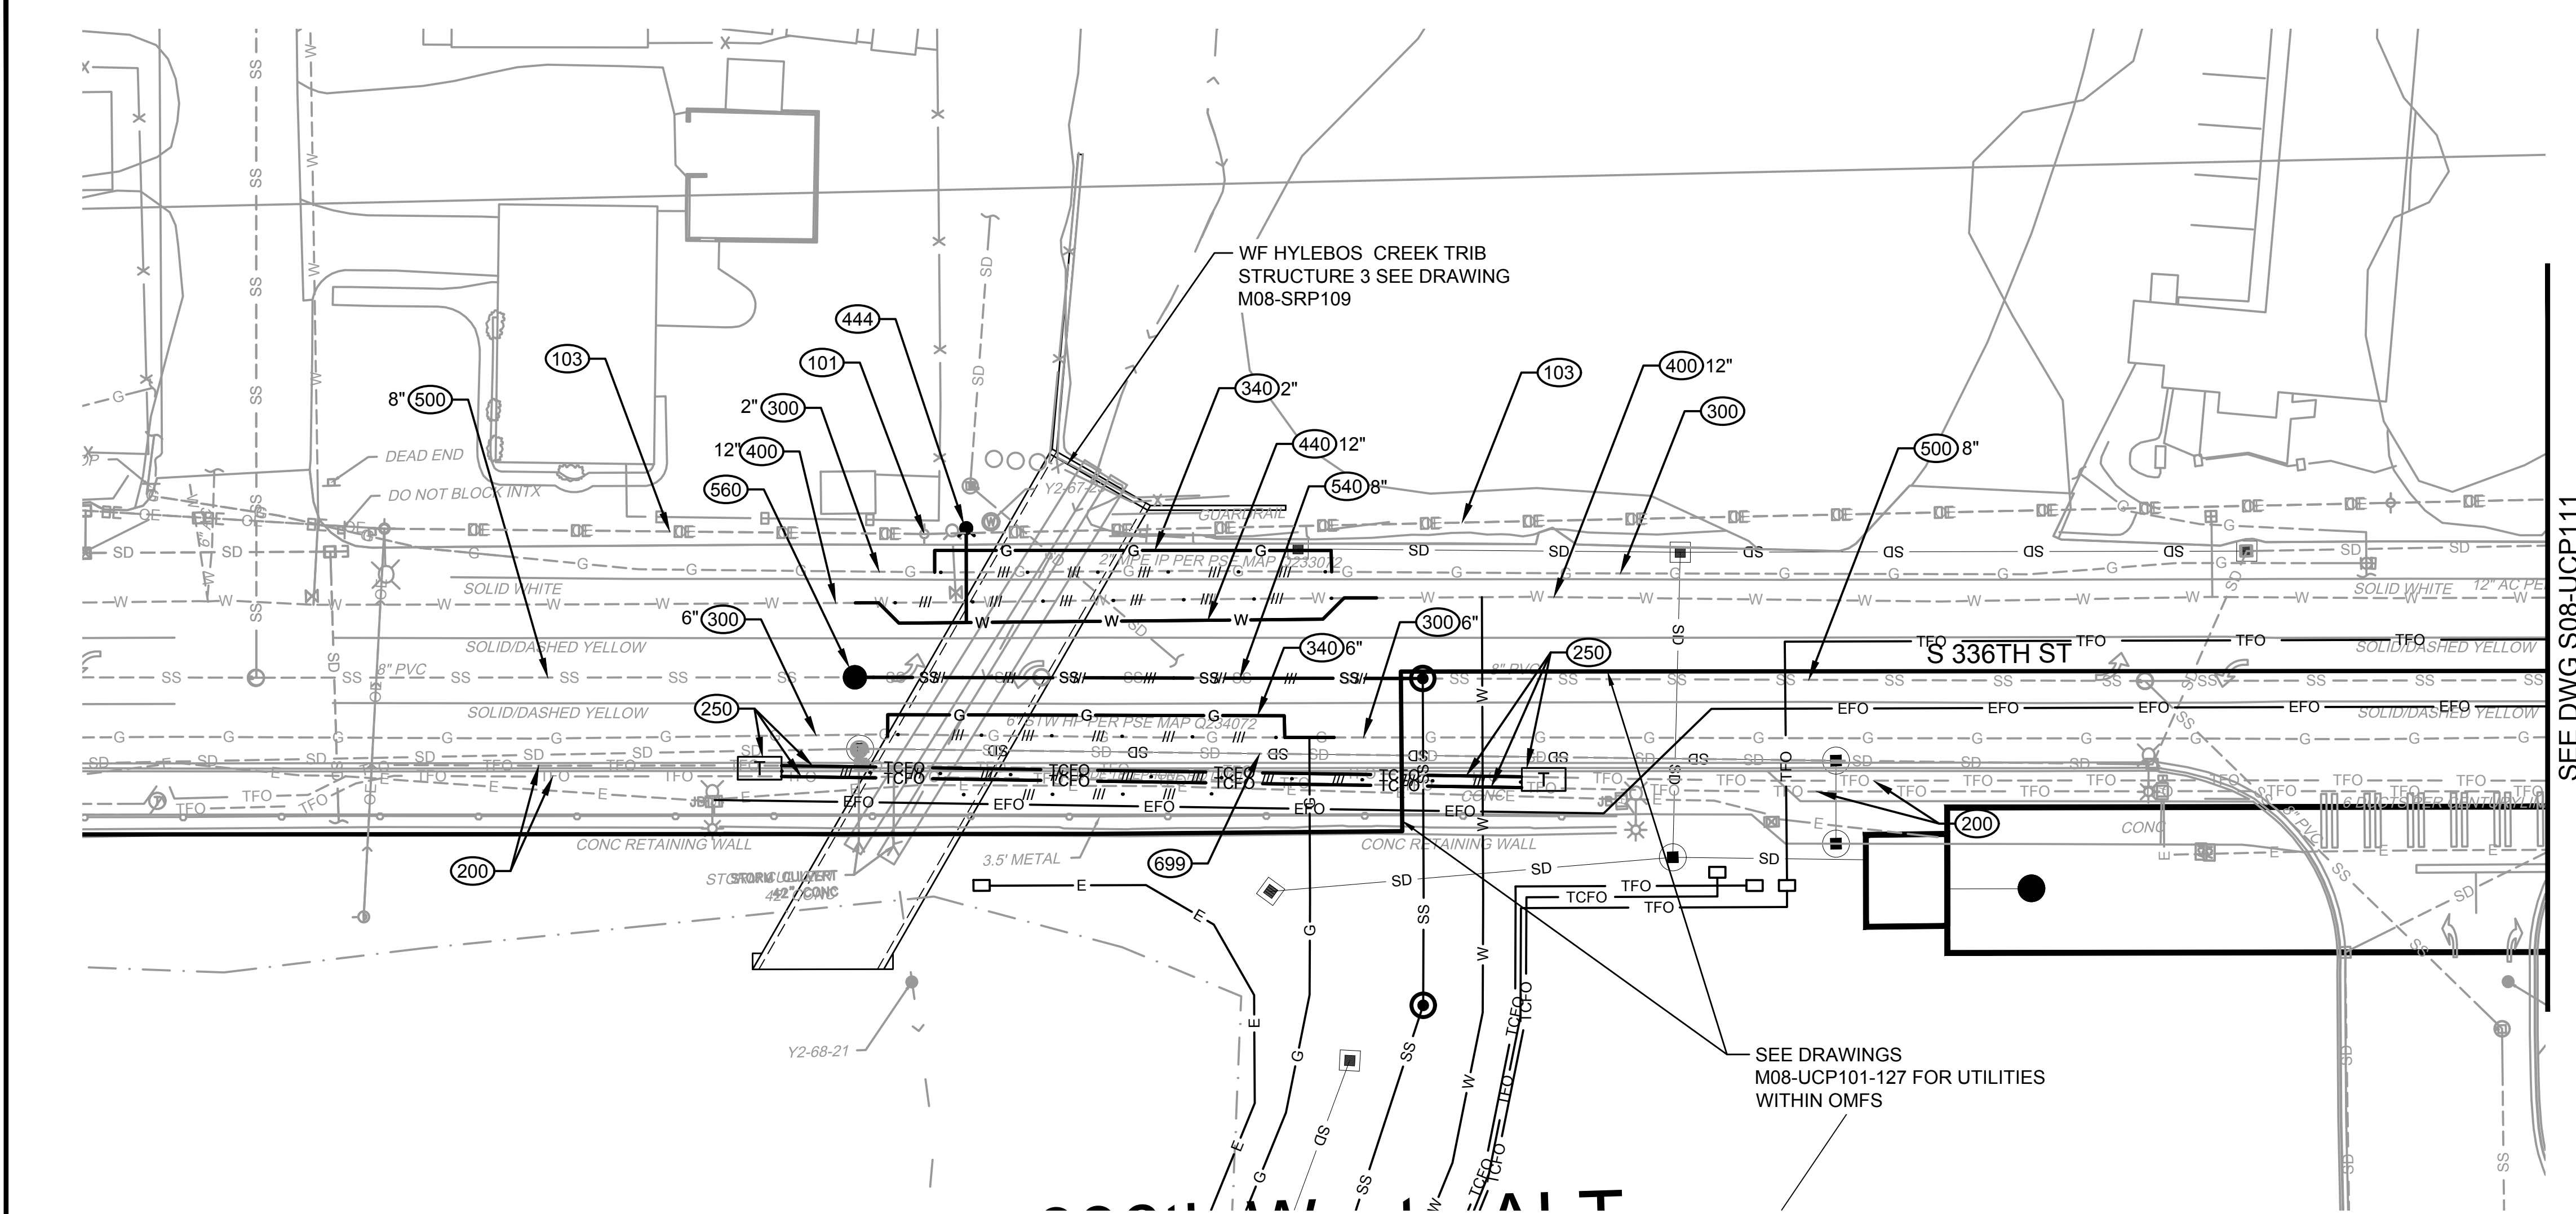

KEY NOTES:
(XXX) SEE SHEET S08-UZN100 THIS SET FOR UTILITY
INSTALLATION DESCRIPTIONS AND DETAILS.

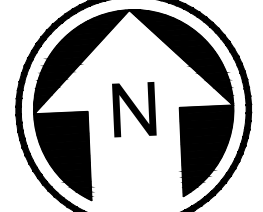



20 10 0 20 40

SCALE IN FEET

NOT FOR
CONSTRUCTION

SEE DWG S08-UCP103

KEY NOTES:
(XXX) SEE SHEET S08-UZN100 THIS SET FOR UTILITY
INSTALLATION DESCRIPTIONS AND DETAILS.

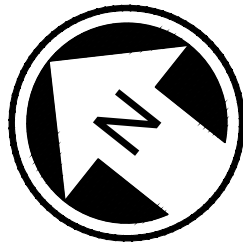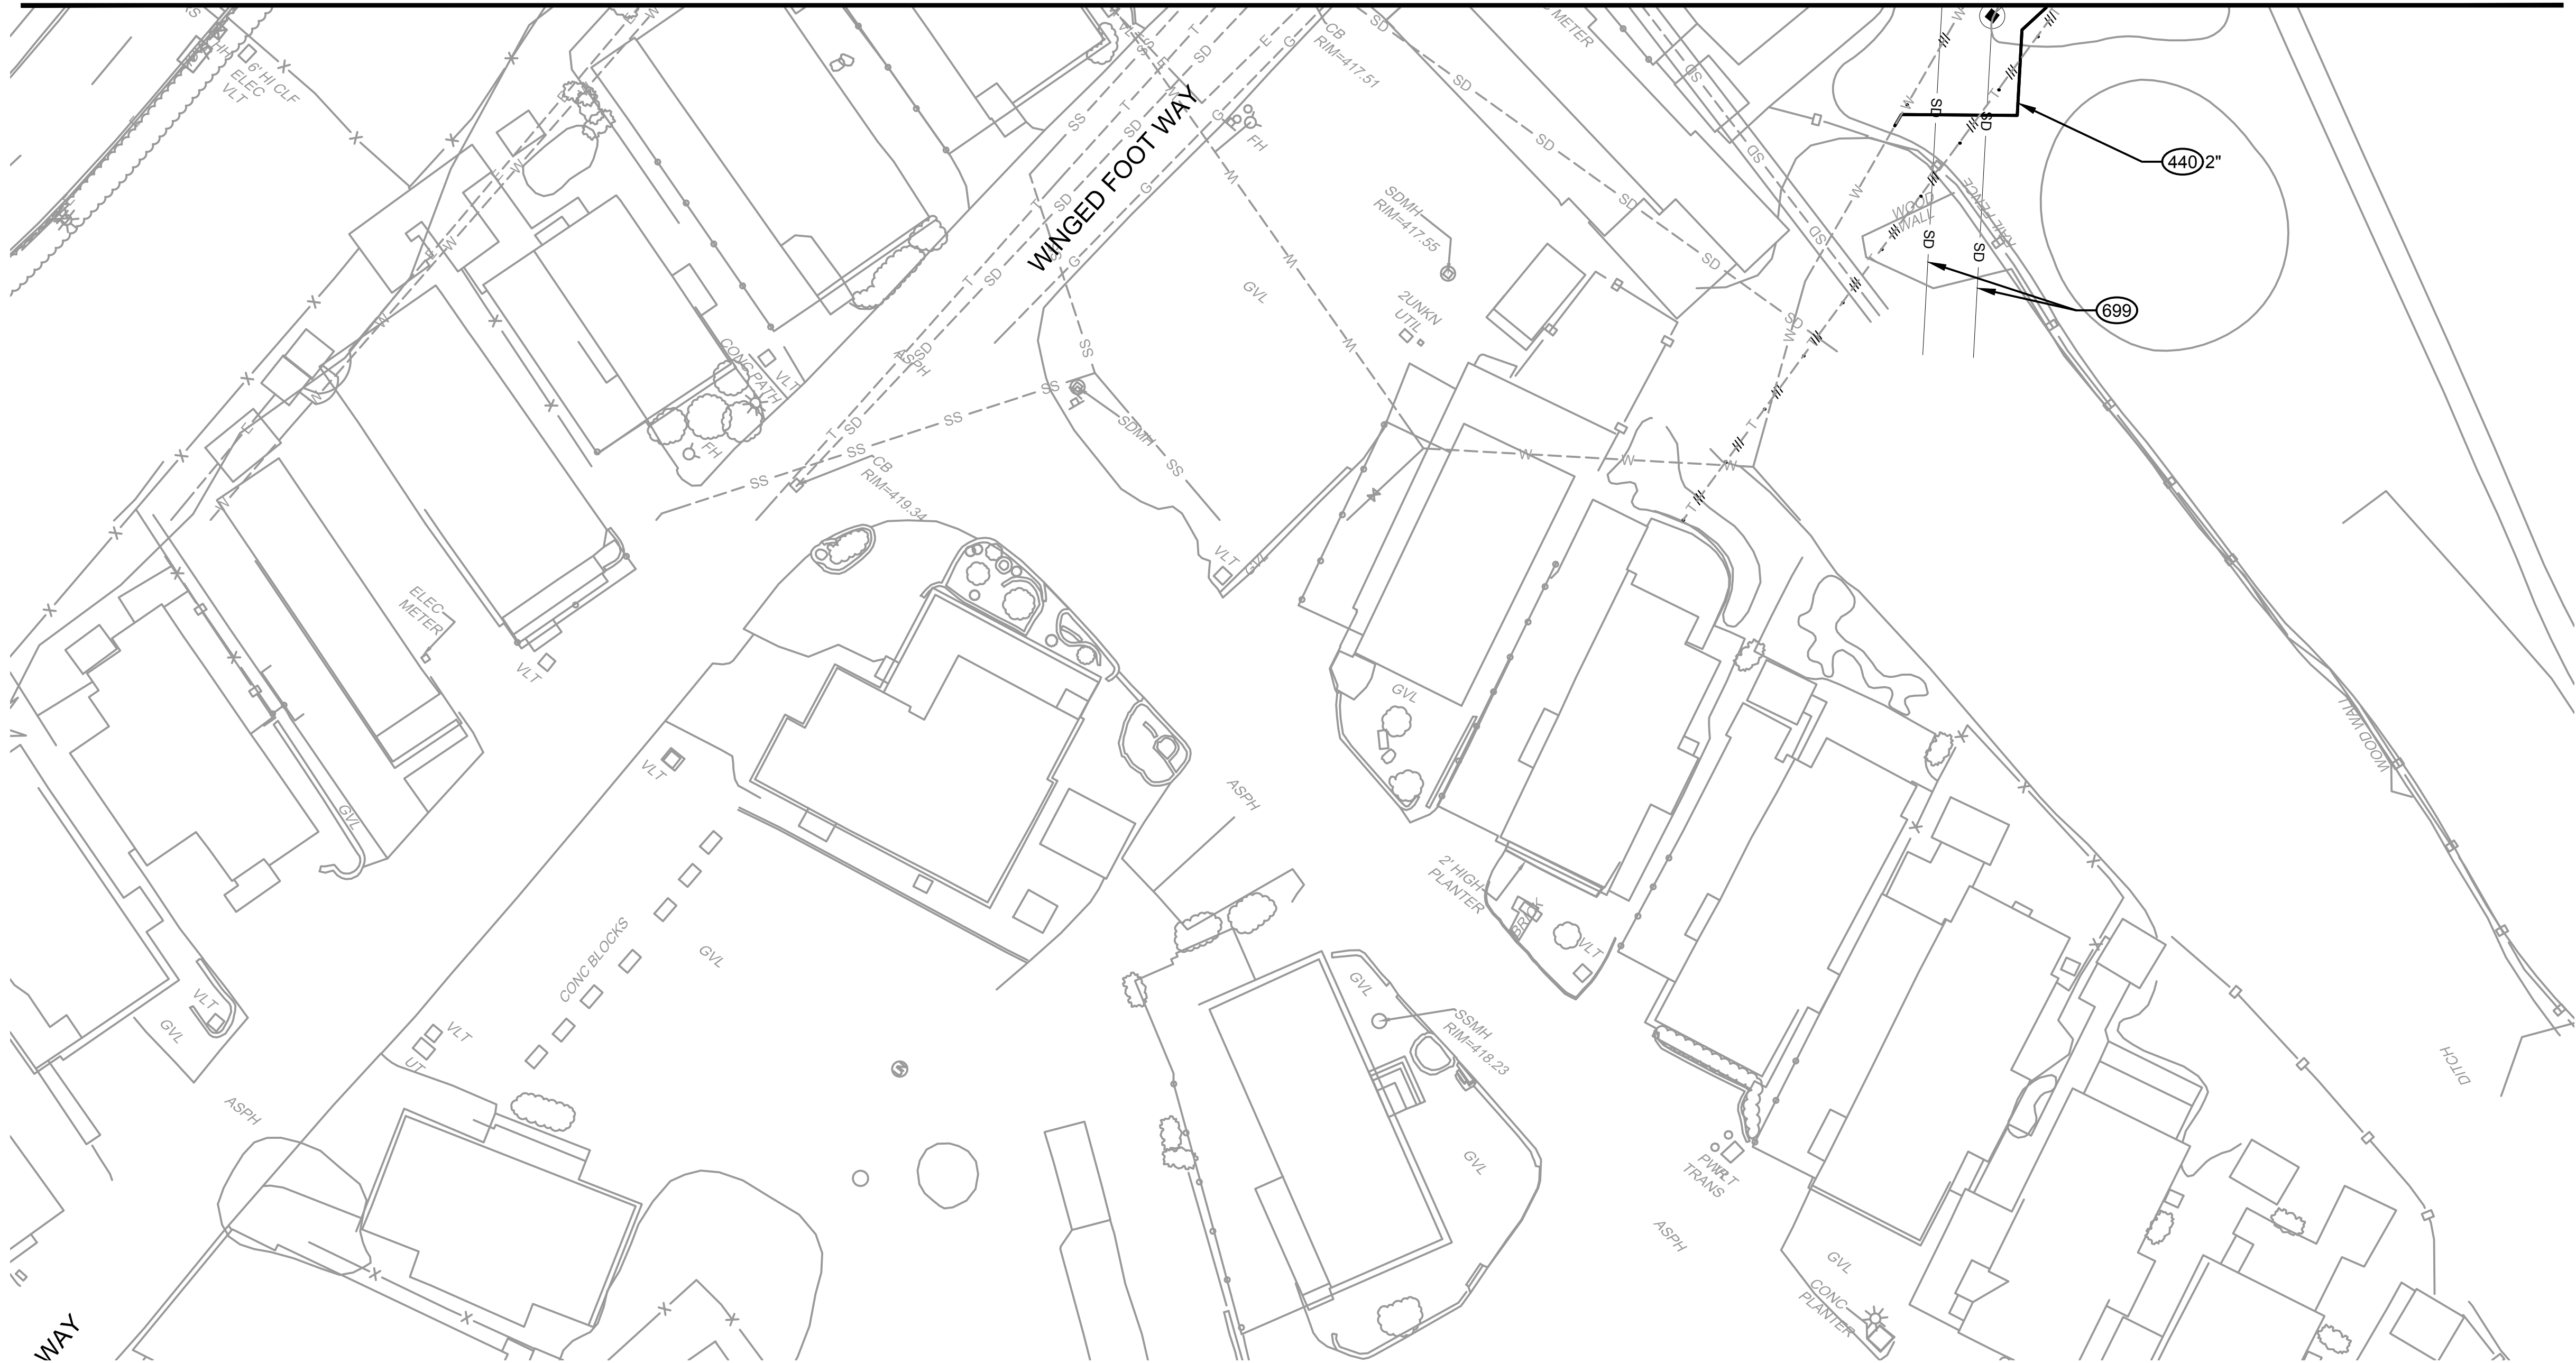


**NOT FOR
CONSTRUCTION**

Refer to the plan set COVER drawing
for disclaimers regarding this drawing.

REFERENCE CONCEPT DRAWINGS					
No.	DATE	DSN	CHK	APP	REVISION

DESIGNED BY:	J. SANNON
DRAWN BY:	E. HERRMANN
CHECKED BY:	M. STARLING
APPROVED BY:	P. LOPEZ-HILFIKER

PRELIMINARY

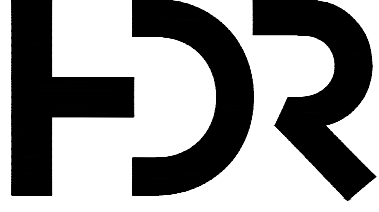

LINE IS 1" AT
FULL SCALE



SUBMITTED BY:	DATE:	REVIEWED BY:	DATE:
PABLO LOPEZ-HILFIKER	2/27/2024		2/27/2024

PACKAGE #
SCALE: 1"=20'
FILENAME: OMFS-S08-UCP101-124
CONTRACT No.: AE-0030-17
DATE: 2/27/2024

SOUND TRANSIT
PRELIMINARY ENGINEERING PLANS
OPERATIONS & MAINTENANCE FACILITY SOUTH

UTILITY
COMPOSITE UTILITY PLANS

DRAWING No.:	S08-UCP126
FACILITY ID:	S08
SHEET No.:	REV:
	0


02/23/24 | 10:47 AM | NAIRAJA
C:\PWORKING\WEST01\0309012\OMFS-S08-TCP101-103.DWG

Refer to the plan set COVER drawing
for disclaimers regarding this drawing.

REFERENCE CONCEPT DRAWINGS

No.	DATE	DSN	CHK	APP	REVISION

DESIGNED BY:	A. NAIR
DRAWN BY:	A. NAIR
CHECKED BY:	C. SCHOTT
APPROVED BY:	P. LOPEZ-HILFIKER

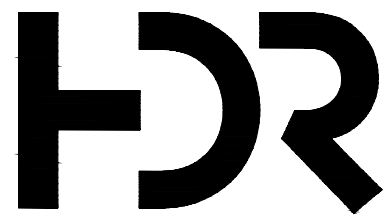

SUBMITTED BY:	DATE:	REVIEWED BY:
PABLO LOPEZ-HILFIKER	02/23/2024	

LINE IS 1" AT
FULL SCALE



DATE:
02/23/2023


PACKAGE #

SCALE:
1"=250'
FILENAME:
OMFS-S08-TCP101-103
CONTRACT No.:
AE-0030-17
DATE:
02/23/2024

SOUND TRANSIT
PRELIMINARY ENGINEERING PLANS
OPERATIONS & MAINTENANCE FACILITY SOUTH

TRAFFIC
TRAFFIC CONTROL PLAN
ROAD CLOSURE FOR S 336TH ST

DRAWING No.:
S08-TCP101
FACILITY ID:
S08
SHEET No.:
REV:
0

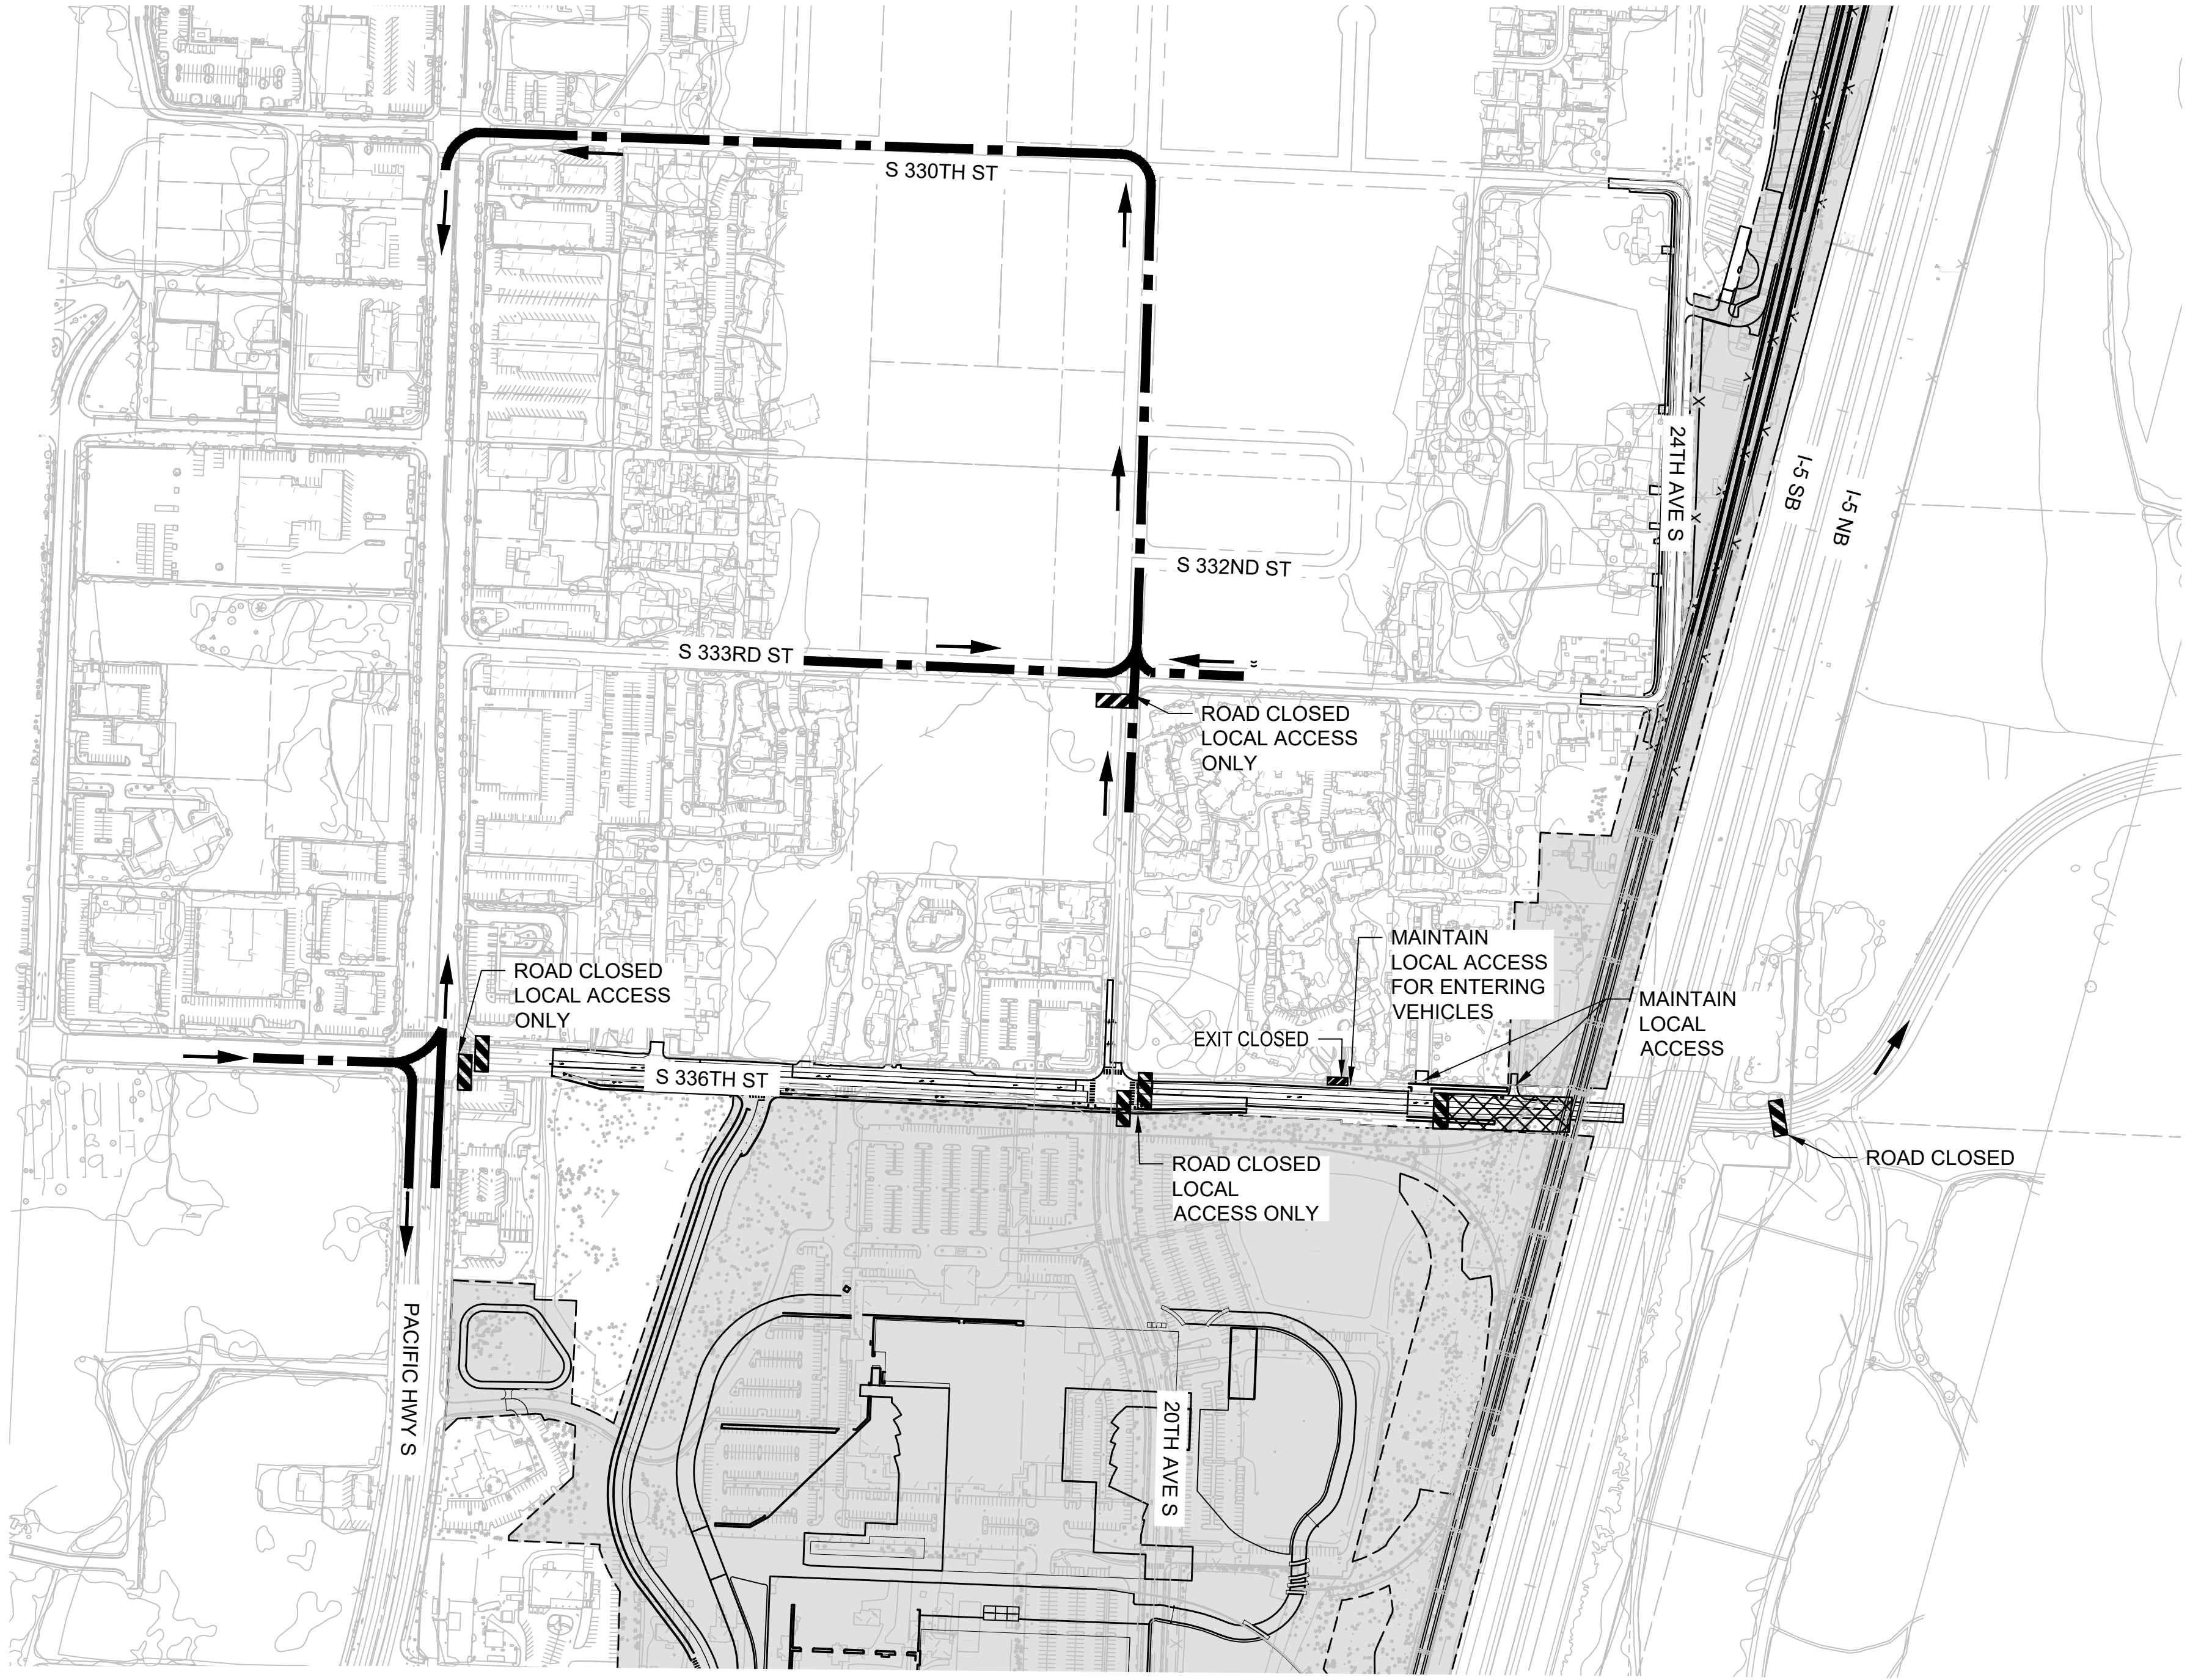

GENERAL NOTES


1. PERIODIC SHORT TERM FULL CLOSURES MAY BE REQUIRED.
2. DURATION OF CLOSURES OR RESTRICTIONS TO BE COORDINATED WITH THE CITY OF FEDERAL WAY.

LEGEND

- PROJECT DETOUR ROUTE
SEE S08-CHP SHEETS
- WORK ZONE AREA
- DIRECTION OF TRAFFIC
- TYPE 3 BARRICADE
- LOCAL DETOUR ROUTE

ACTIVITIES THAT REQUIRE CLOSURE/DETOUR

1. ROAD CLOSURE IS FOR CONSTRUCTION OF OVERHEAD STRUCTURE ACROSS S336TH ST.
2. OVERALL DETOUR ROUTE TO REMAIN SAME. SEE S08-CHP SHEETS.

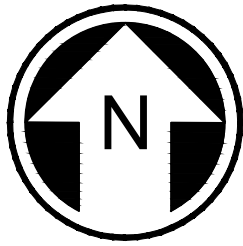


NOT FOR
CONSTRUCTION

02/23/24 | 10:44 AM | NAIRAJA
C:\PWORKING\WEST01\0309012\OMFS-S08-TCP101-103.DWG

Refer to the plan set COVER drawing
for disclaimers regarding this drawing.

REFERENCE CONCEPT DRAWINGS					
No.	DATE	DSN	CHK	APP	REVISION

DESIGNED BY:	A. NAIR
DRAWN BY:	A. NAIR
CHECKED BY:	C. SCHOTT
APPROVED BY:	P. LOPEZ-HILFIKER

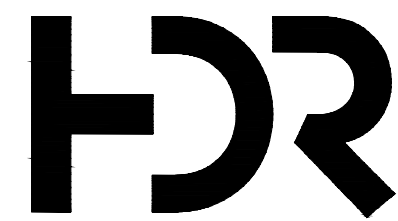

SUBMITTED BY:
PABLO LOPEZ-HILFIKER

DATE:
02/23/2024

REVIEWED BY:



DATE:
02/23/2023

PACKAGE #

SCALE: 1"=150'
FILENAME: OMFS-S08-TCP101-103
CONTRACT No.: AE-0030-17
DATE: 02/23/2024

SOUND TRANSIT
PRELIMINARY ENGINEERING PLANS
OPERATIONS & MAINTENANCE FACILITY SOUTH

TRAFFIC
TRAFFIC CONTROL PLAN
ROAD CLOSURE FOR 23RD AVE/PARK AND RIDE ACCESS

DRAWING No.:	S08-TCP103
FACILITY ID:	S08
SHEET No.:	REV:
	0



GENERAL NOTES


- PERIODIC SHORT TERM FULL CLOSURES MAY BE REQUIRED.
- DURATION OF CLOSURES OR RESTRICTIONS TO BE COORDINATED WITH THE CITY OF FEDERAL WAY.

LEGEND

- PROJECT DETOUR ROUTE
SEE S08-CHP SHEETS
- WORK ZONE AREA
- DIRECTION OF TRAFFIC
- TYPE 3 BARRICADE
- LOCAL DETOUR ROUTE

ACTIVITIES THAT REQUIRE CLOSURE/DETOUR

- ROAD CLOSURE IS FOR CONSTRUCTION OF OVERHEAD STRUCTURE ALONG 23RD AVE S.
- OVERALL DETOUR ROUTE TO REMAIN SAME. SEE S08-CHP SHEETS.

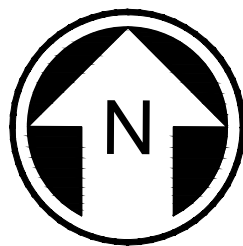

NOT FOR
CONSTRUCTION