
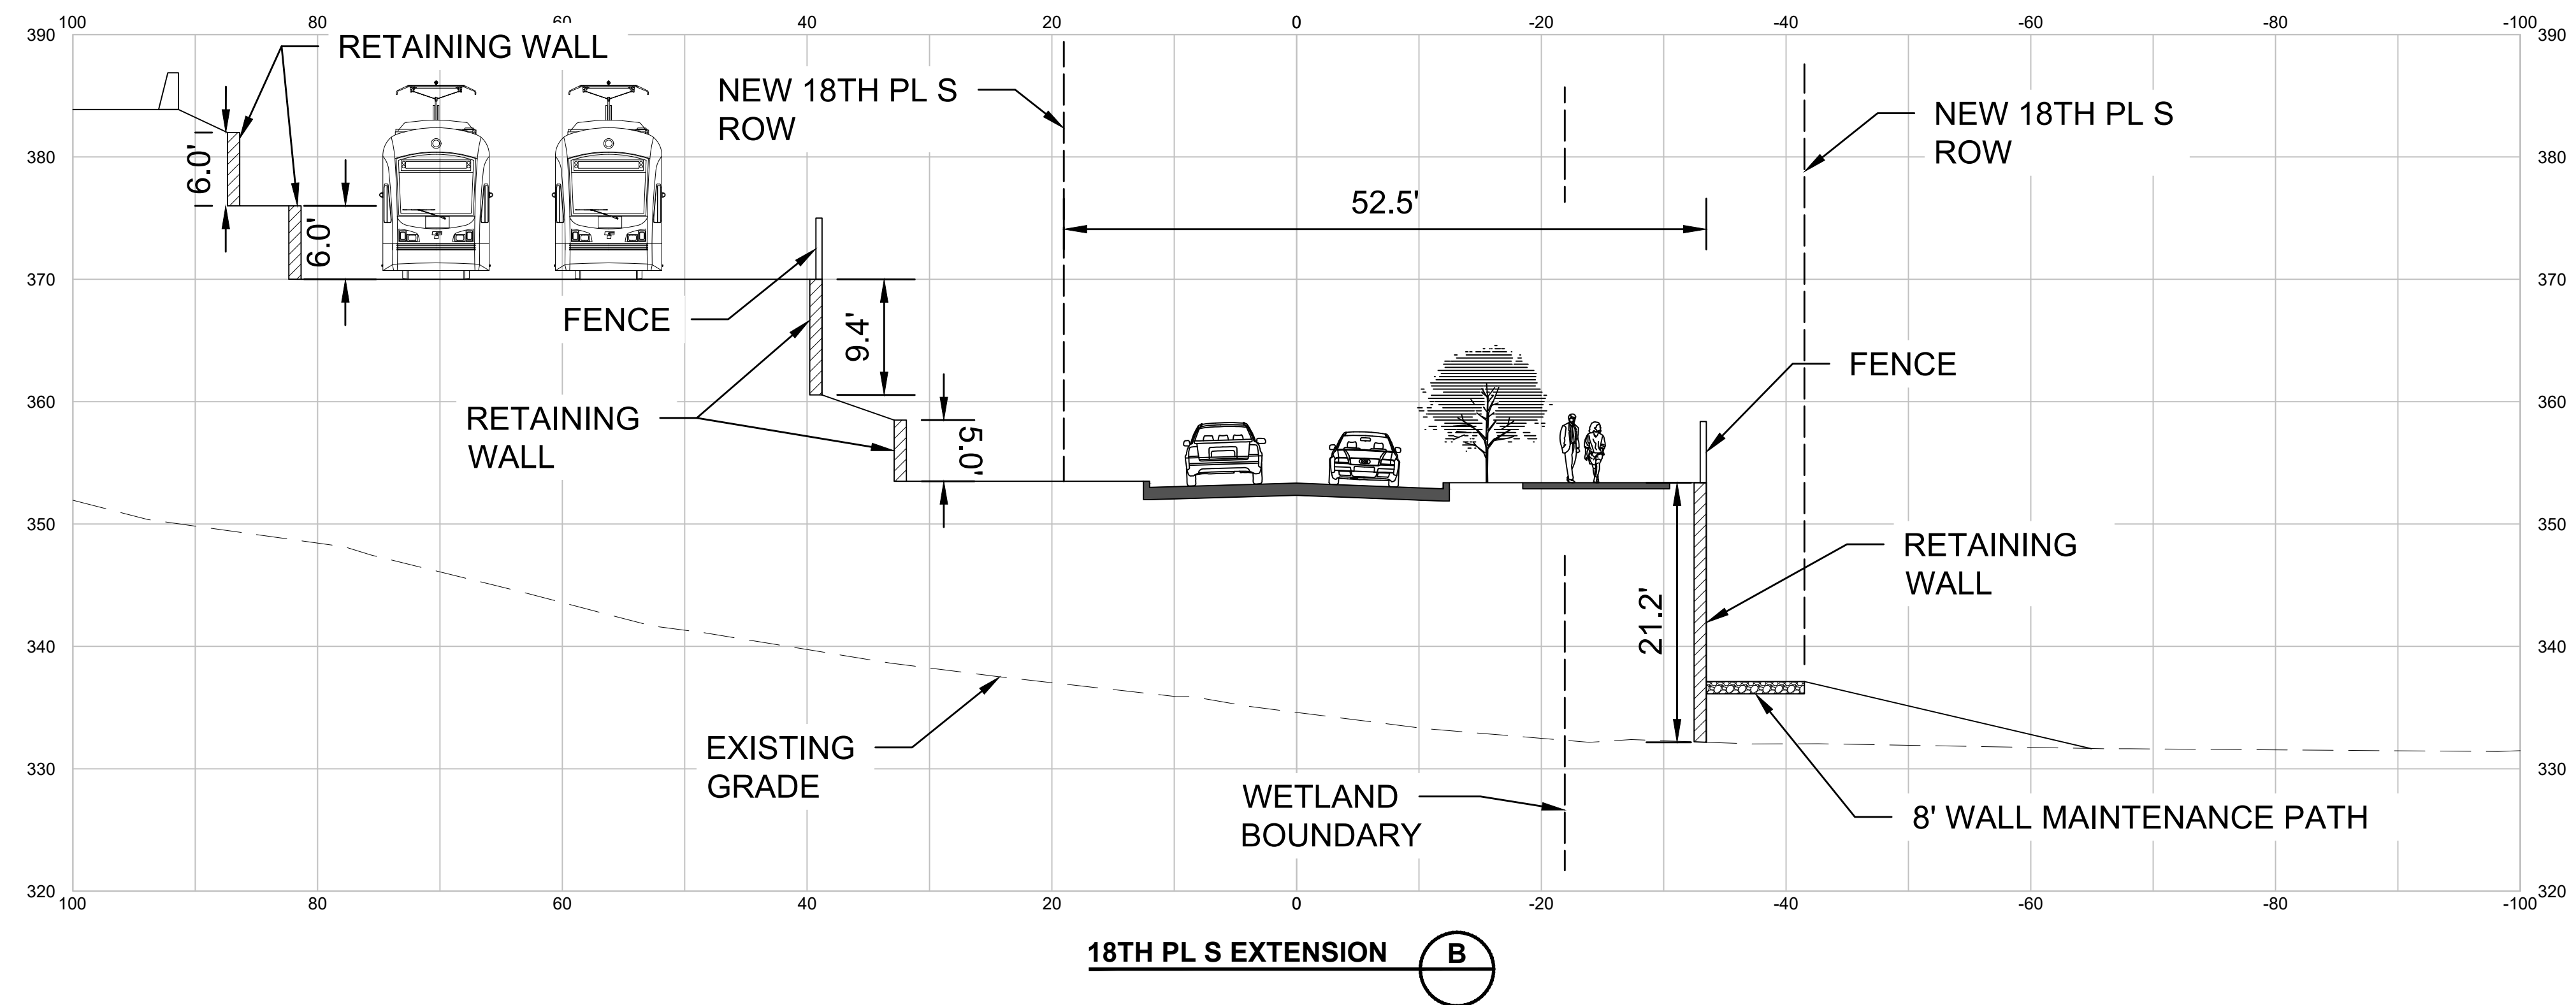


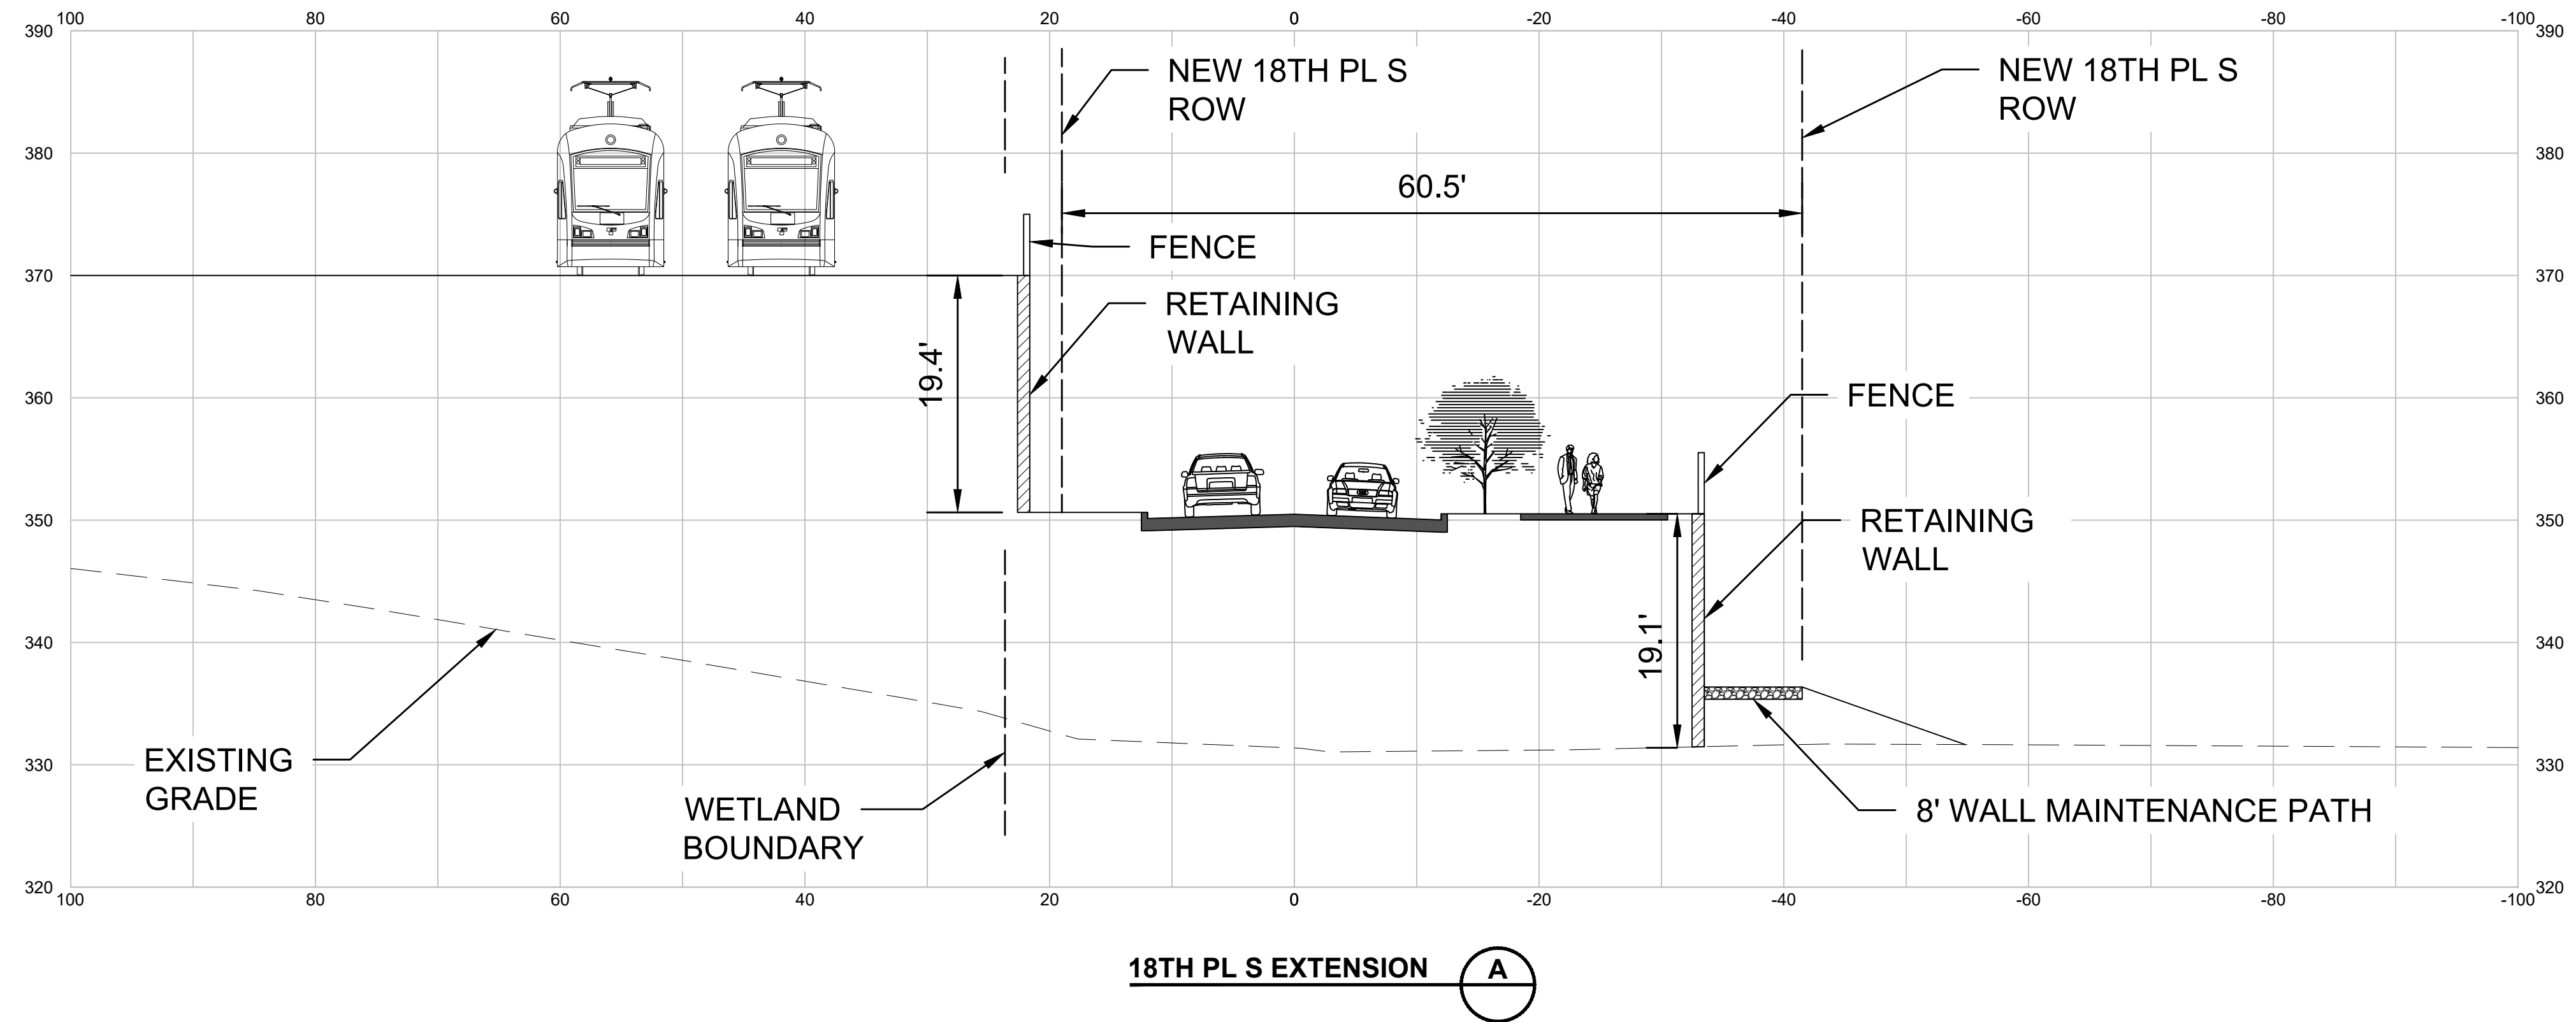


NOT FOR
CONSTRUCTION

Refer to the plan set COVER drawing
for disclaimers regarding this drawing.

REFERENCE CONCEPT DRAWINGS						
No.	DATE	DSN	CHK	APP	REVISION	

DESIGNED BY:
K. McDONALD
DRAWN BY:
J. LUM
CHECKED BY:
P. LOPEZ-HILFIKER
APPROVED BY:
P. LOPEZ-HILFIKER

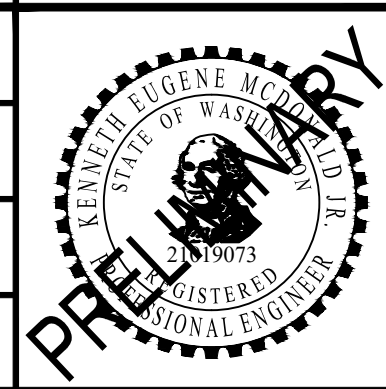

SUBMITTED BY:
PABLO LOPEZ-HILFIKER

DATE:
2/27/2024

REVIEWED BY:



LINE IS 1" AT
FULL SCALE



PACKAGE #
SCALE:
1"=100'
FILENAME:
OMFS-M08-CGX101-106
CONTRACT No.:
AE-0030-17
DATE:
2/27/2024

SOUND TRANSIT
PRELIMINARY ENGINEERING PLANS
OPERATIONS & MAINTENANCE FACILITY SOUTH
CIVIL
GRADING SECTIONS


DRAWING No.:
M08-CGX101
FACILITY ID:
M08
SHEET No.:
REV:

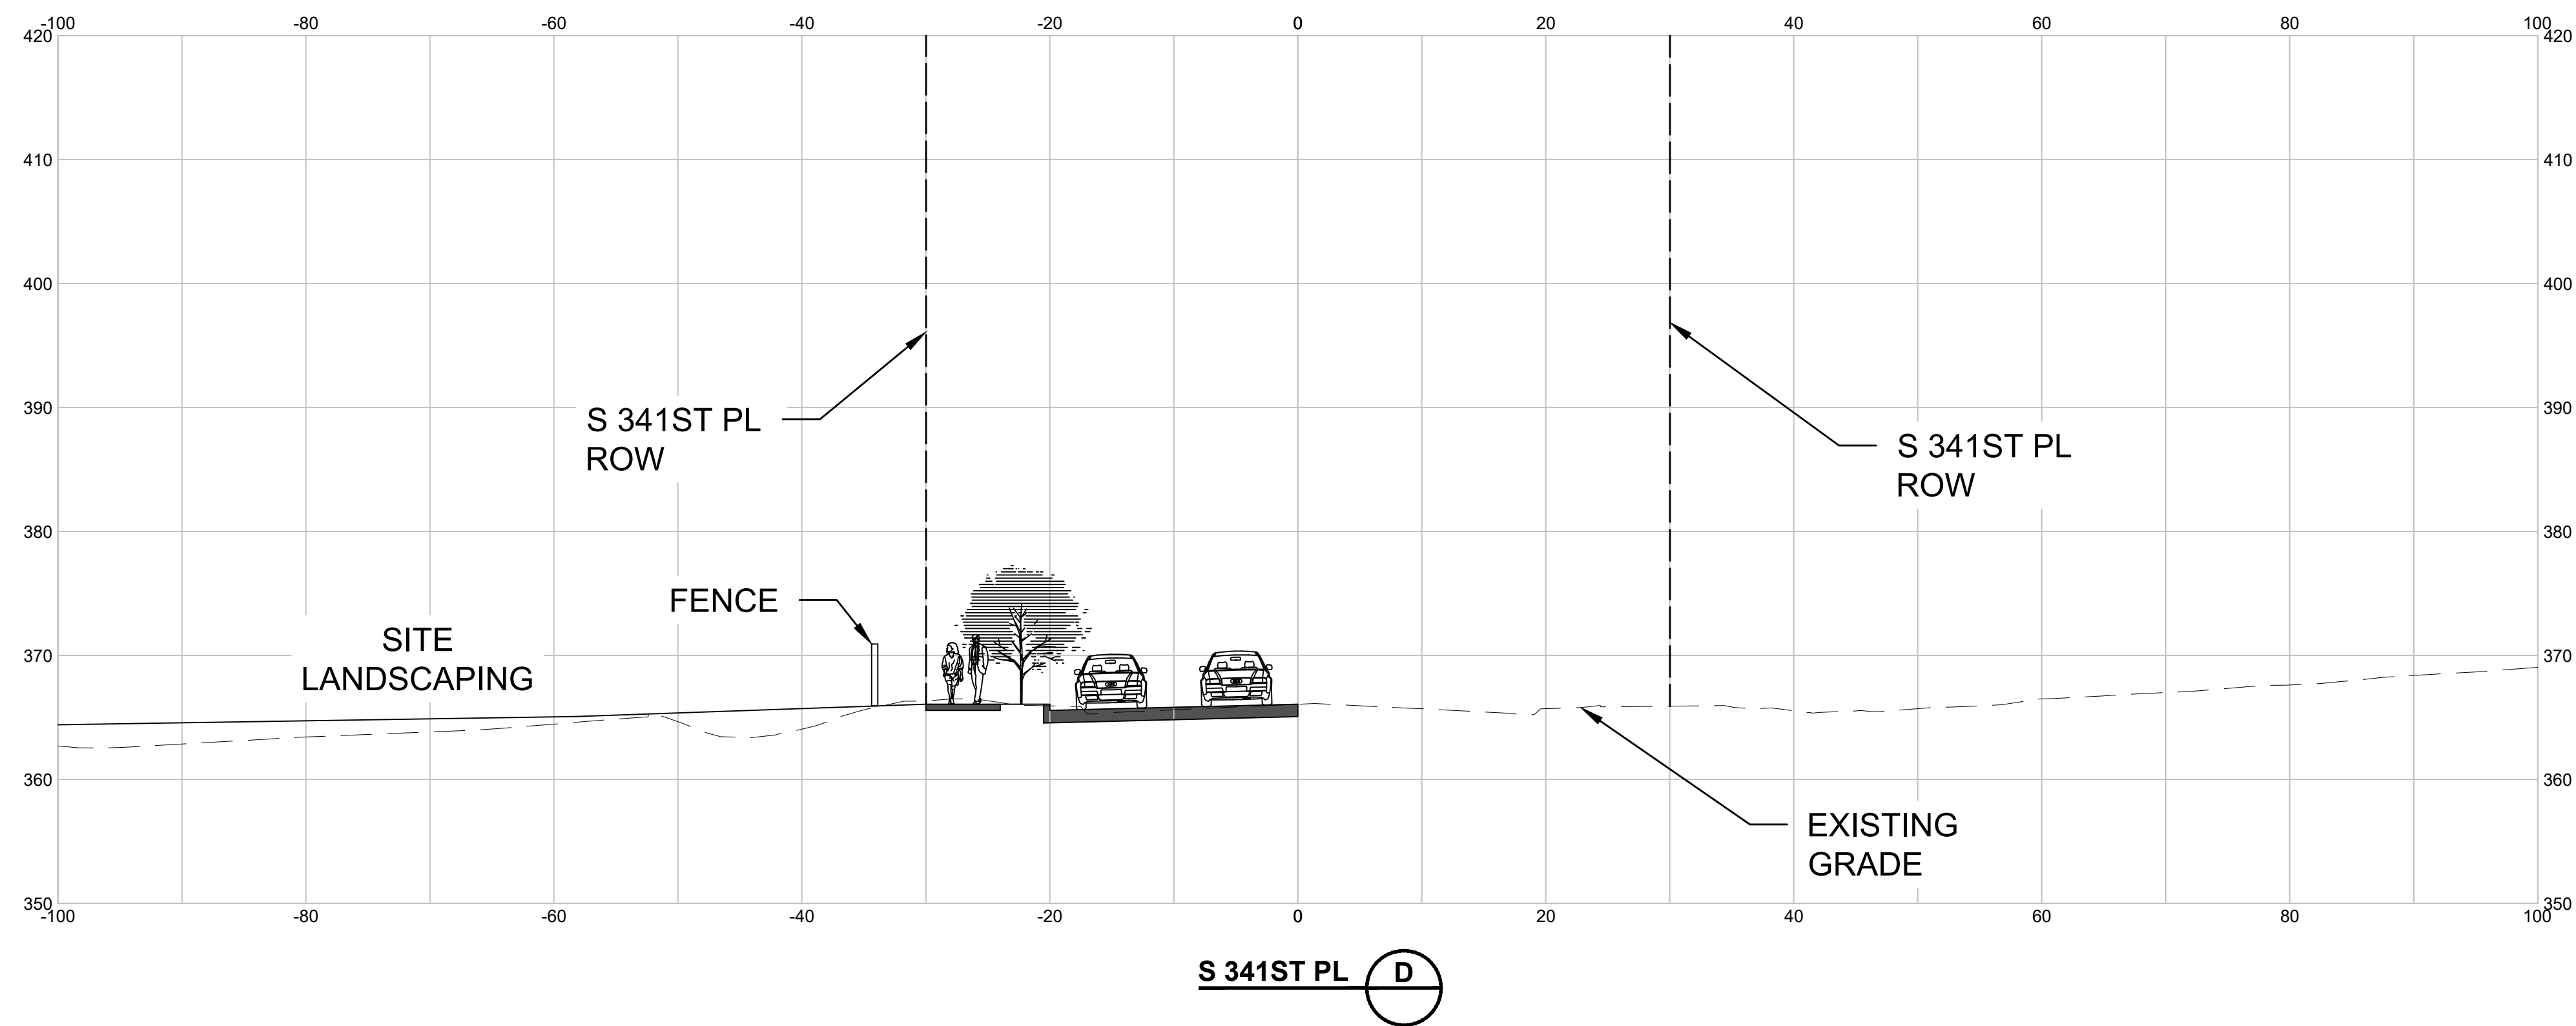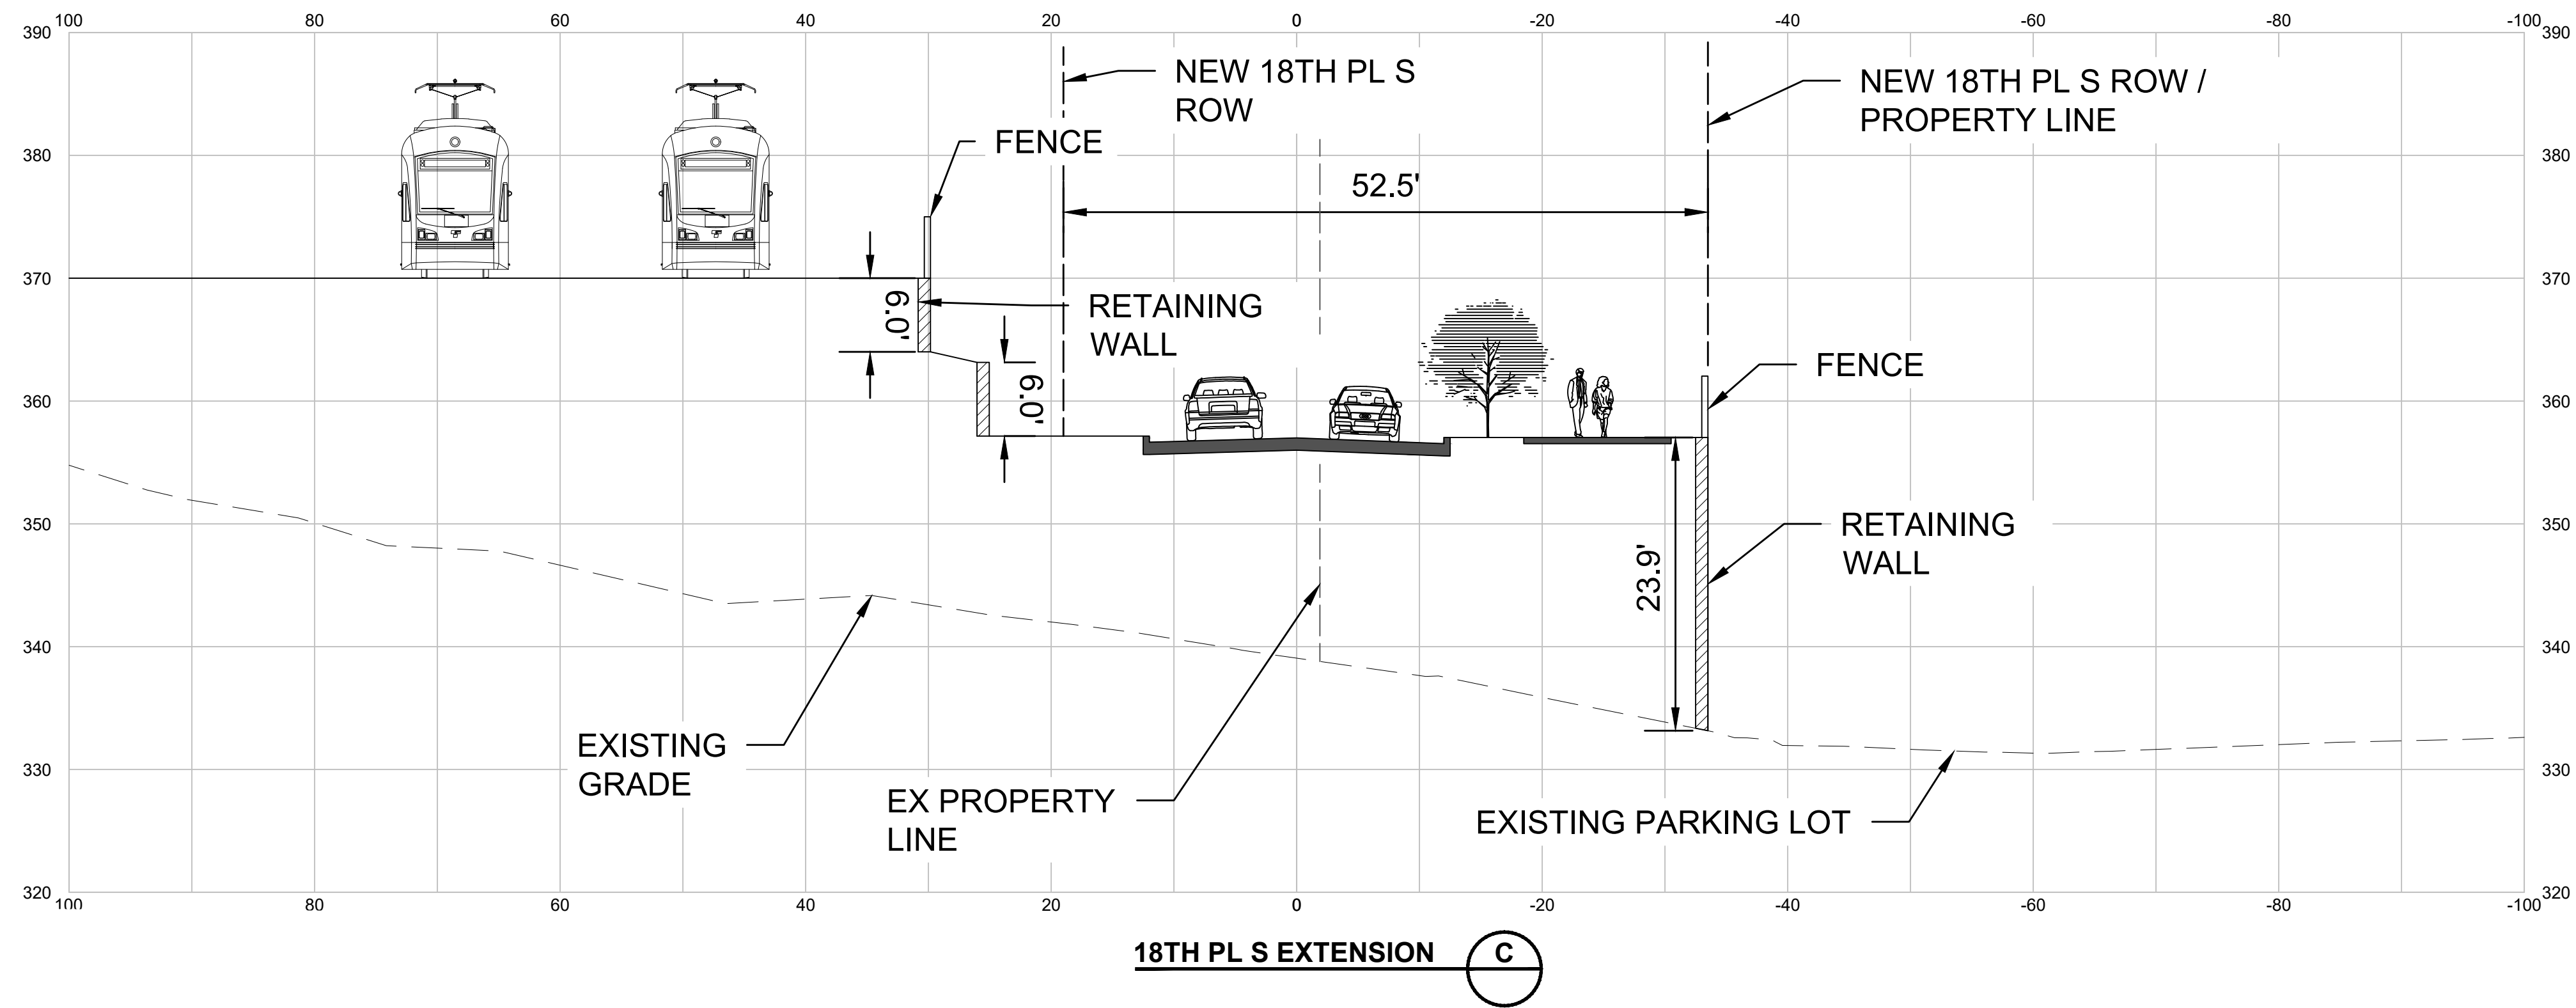

NOT FOR
CONSTRUCTION

Refer to the plan set COVER drawing
for disclaimers regarding this drawing.

AHJ:					PACKAGE #				
 PRELIMINARY				 SOUNDTRANSIT	SCALE: 1"=100'	SOUND TRANSIT PRELIMINARY ENGINEERING PLANS OPERATIONS & MAINTENANCE FACILITY SOUTH CIVIL GRADING SECTIONS		DRAWING No.: M08-CGX102	
					FILENAME: OMFS-M08-CGX101-106			FACILITY ID: M08	
					CONTRACT No.: AE-0030-17			SHEET No.: REV:	
					DATE: 2/27/2024				
SUBMITTED BY: PABLO LOPEZ-HILFIKER		DATE: 2/27/2024	REVIEWED BY:	DATE:					

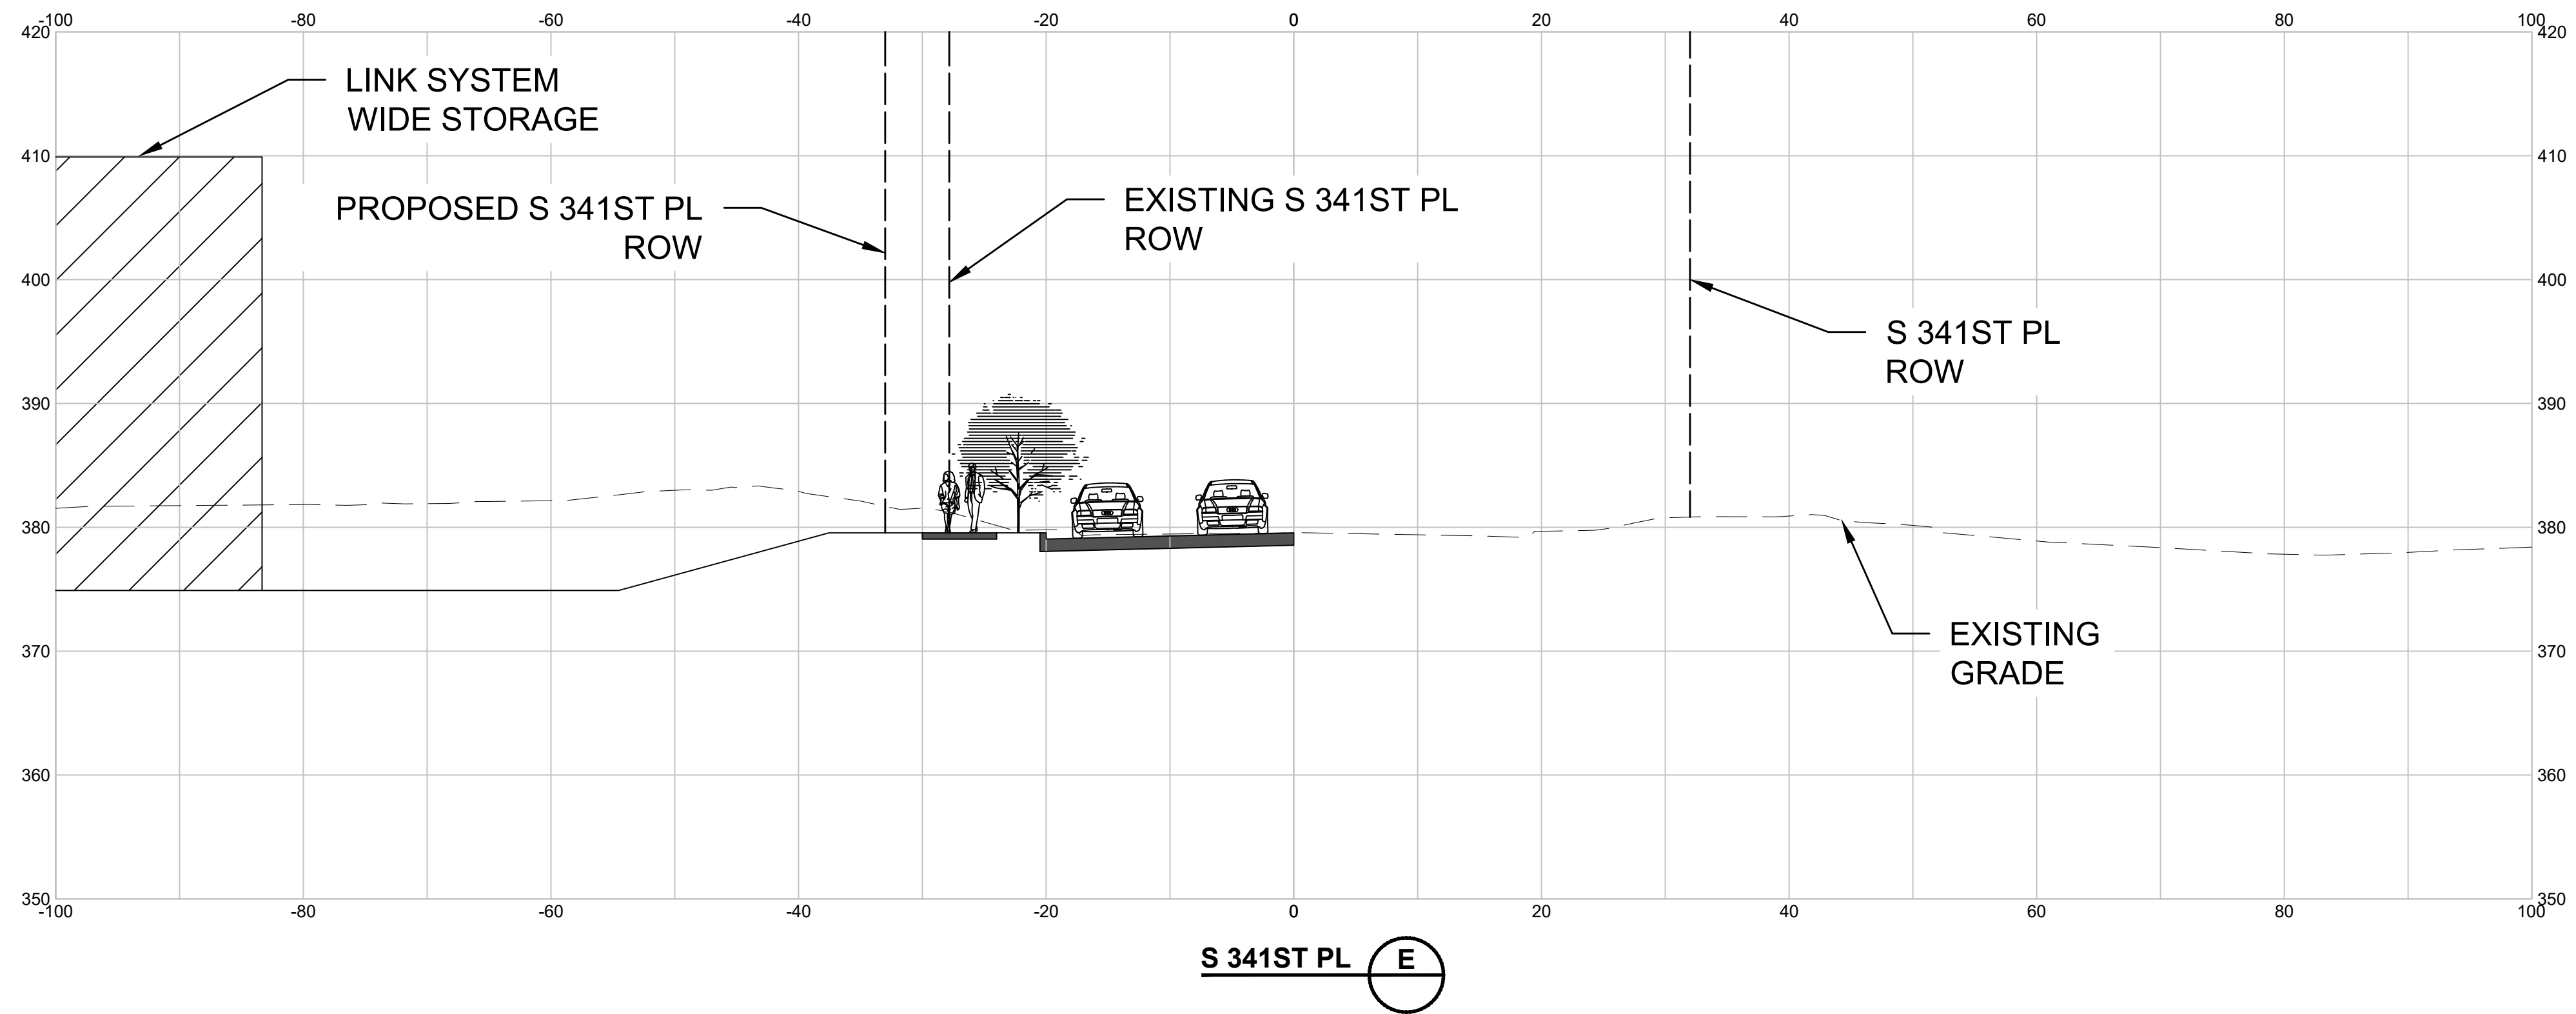


NOT FOR
CONSTRUCTION

Refer to the plan set COVER drawing
for disclaimers regarding this drawing.

REFERENCE CONCEPT DRAWINGS						
No.	DATE	DSN	CHK	APP	REVISION	

DESIGNED BY:	K. McDONALD
DRAWN BY:	J. LUM
CHECKED BY:	P. LOPEZ-HILFIKER
APPROVED BY:	P. LOPEZ-HILFIKER

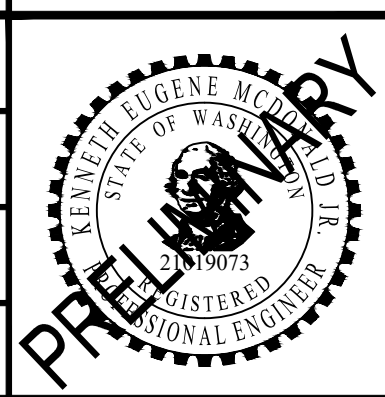

SUBMITTED BY:
PABLO LOPEZ-HILFIKER

DATE:
2/27/2024

REVIEWED BY:

LINE IS 1" AT
FULL SCALE

DATE:



PACKAGE #
SCALE:
FILENAME:
OMFS-M08-CGX101-106
CONTRACT No.:
AE-0030-17
DATE:
2/27/2024

SOUND TRANSIT
PRELIMINARY ENGINEERING PLANS
OPERATIONS & MAINTENANCE FACILITY SOUTH

CIVIL
GRADING SECTIONS

DRAWING No.:	M08-CGX103
FACILITY ID:	
SHEET No.:	REV:



02/22/24 | 3:42 PM | ASCHELPE
C:\PWORKING\WEST01\2727714\OMFS-M08-CGX101-106.DWG

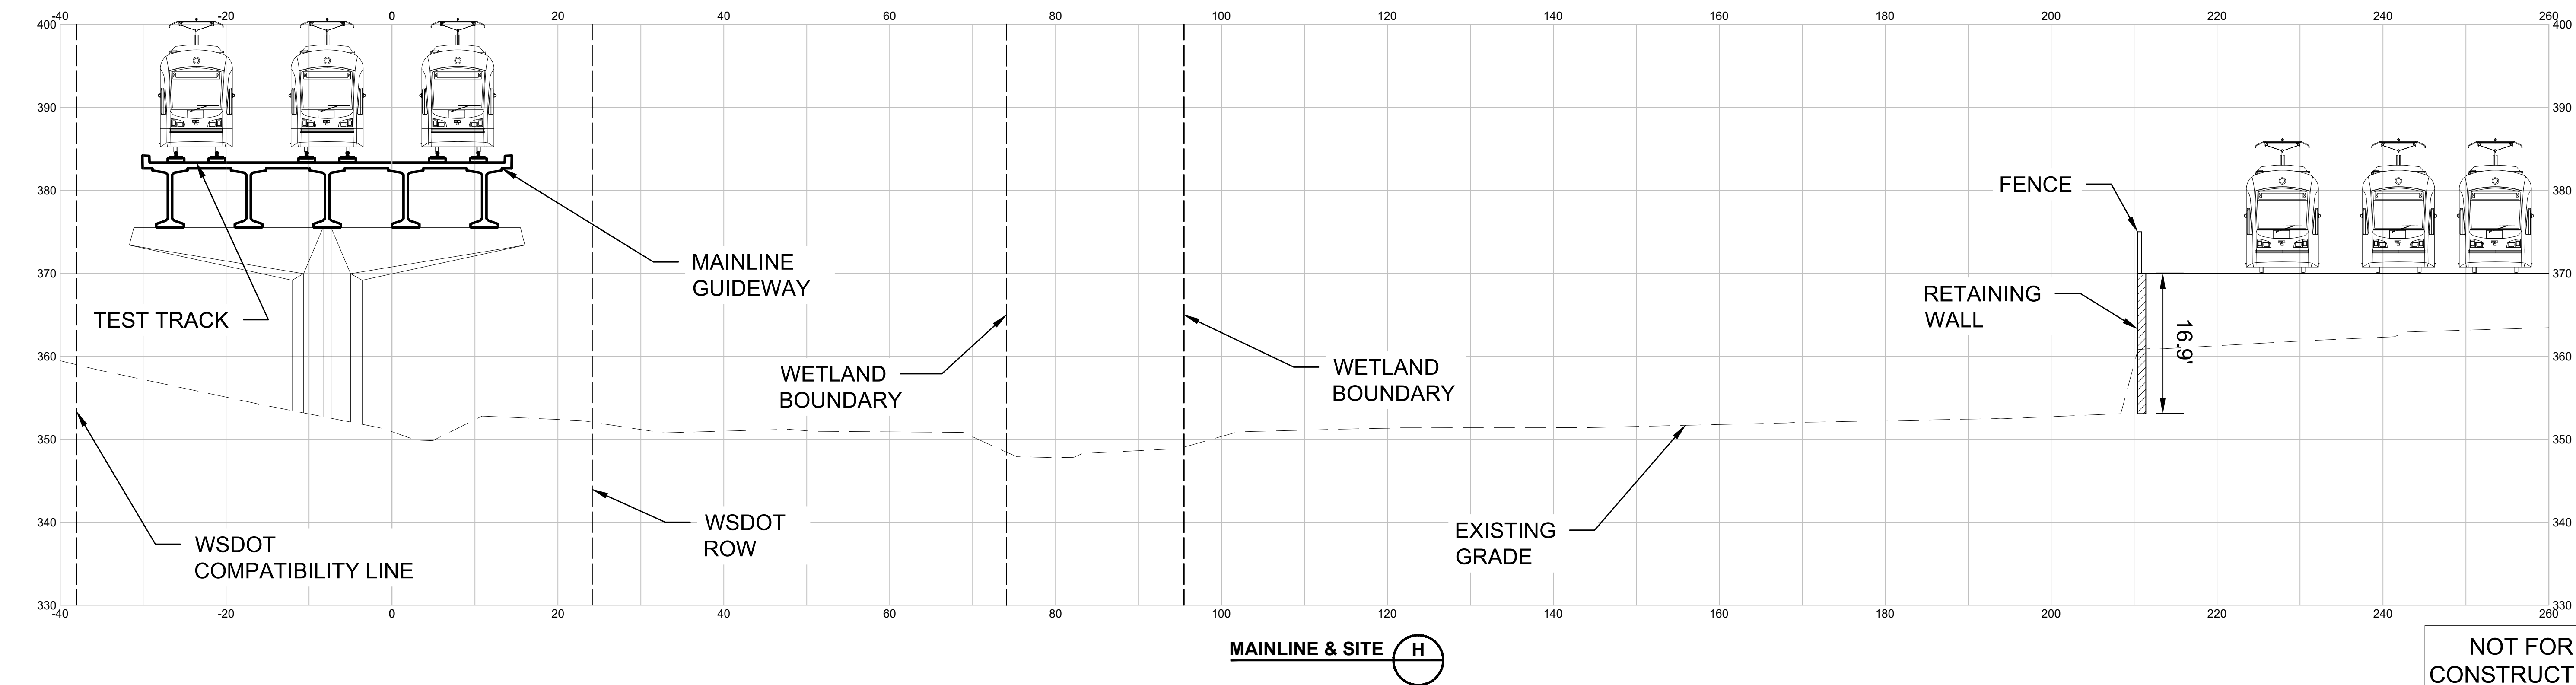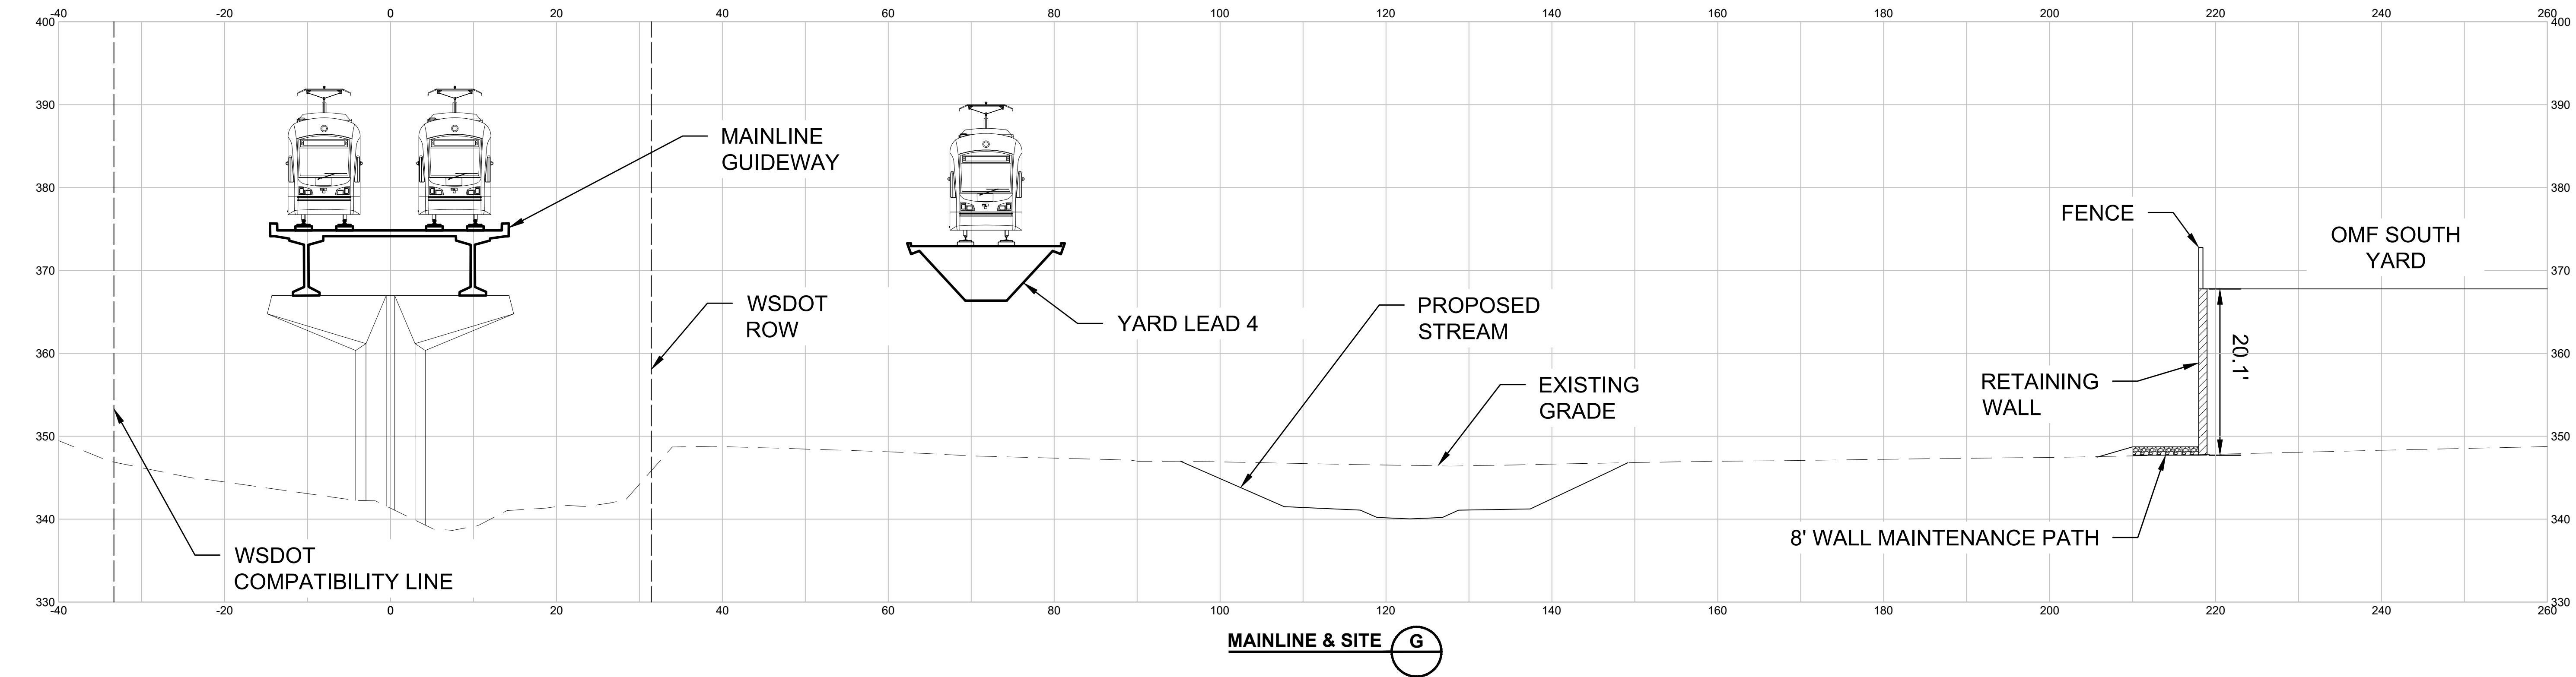

Refer to the plan set COVER drawing
for disclaimers regarding this drawing.

NOT FOR
CONSTRUCTION

REFERENCE CONCEPT DRAWINGS <table><tr><td></td><td></td><td></td><td></td><td></td><td></td></tr><tr><td></td><td></td><td></td><td></td><td></td><td></td></tr><tr><td></td><td></td><td></td><td></td><td></td><td></td></tr><tr><td></td><td></td><td></td><td></td><td></td><td></td></tr><tr><td>No.</td><td>DATE</td><td>DSN</td><td>CHK</td><td>APP</td><td>REVISION</td></tr></table>																														No.	DATE	DSN	CHK	APP	REVISION	AHJ:		PACKAGE #				DRAWING No.: M08-CGX104	
No.	DATE	DSN	CHK	APP	REVISION																																						
DESIGNED BY: K. McDONALD				LINE IS 1" AT FULL SCALE		SCALE:	SOUND TRANSIT PRELIMINARY ENGINEERING PLANS OPERATIONS & MAINTENANCE FACILITY SOUTH CIVIL GRADING SECTIONS	SHEET No.: REV:																																			
DRAWN BY: J. LUM						FILENAME: OMFS-M08-CGX101-106		FACILITY ID:																																			
CHECKED BY: P. LOPEZ-HILFIKER						CONTRACT No.: AE-0030-17		DATE:																																			
APPROVED BY:						DATE:																																					
P. LOPEZ-HILFIKER		2/27/2024																																									

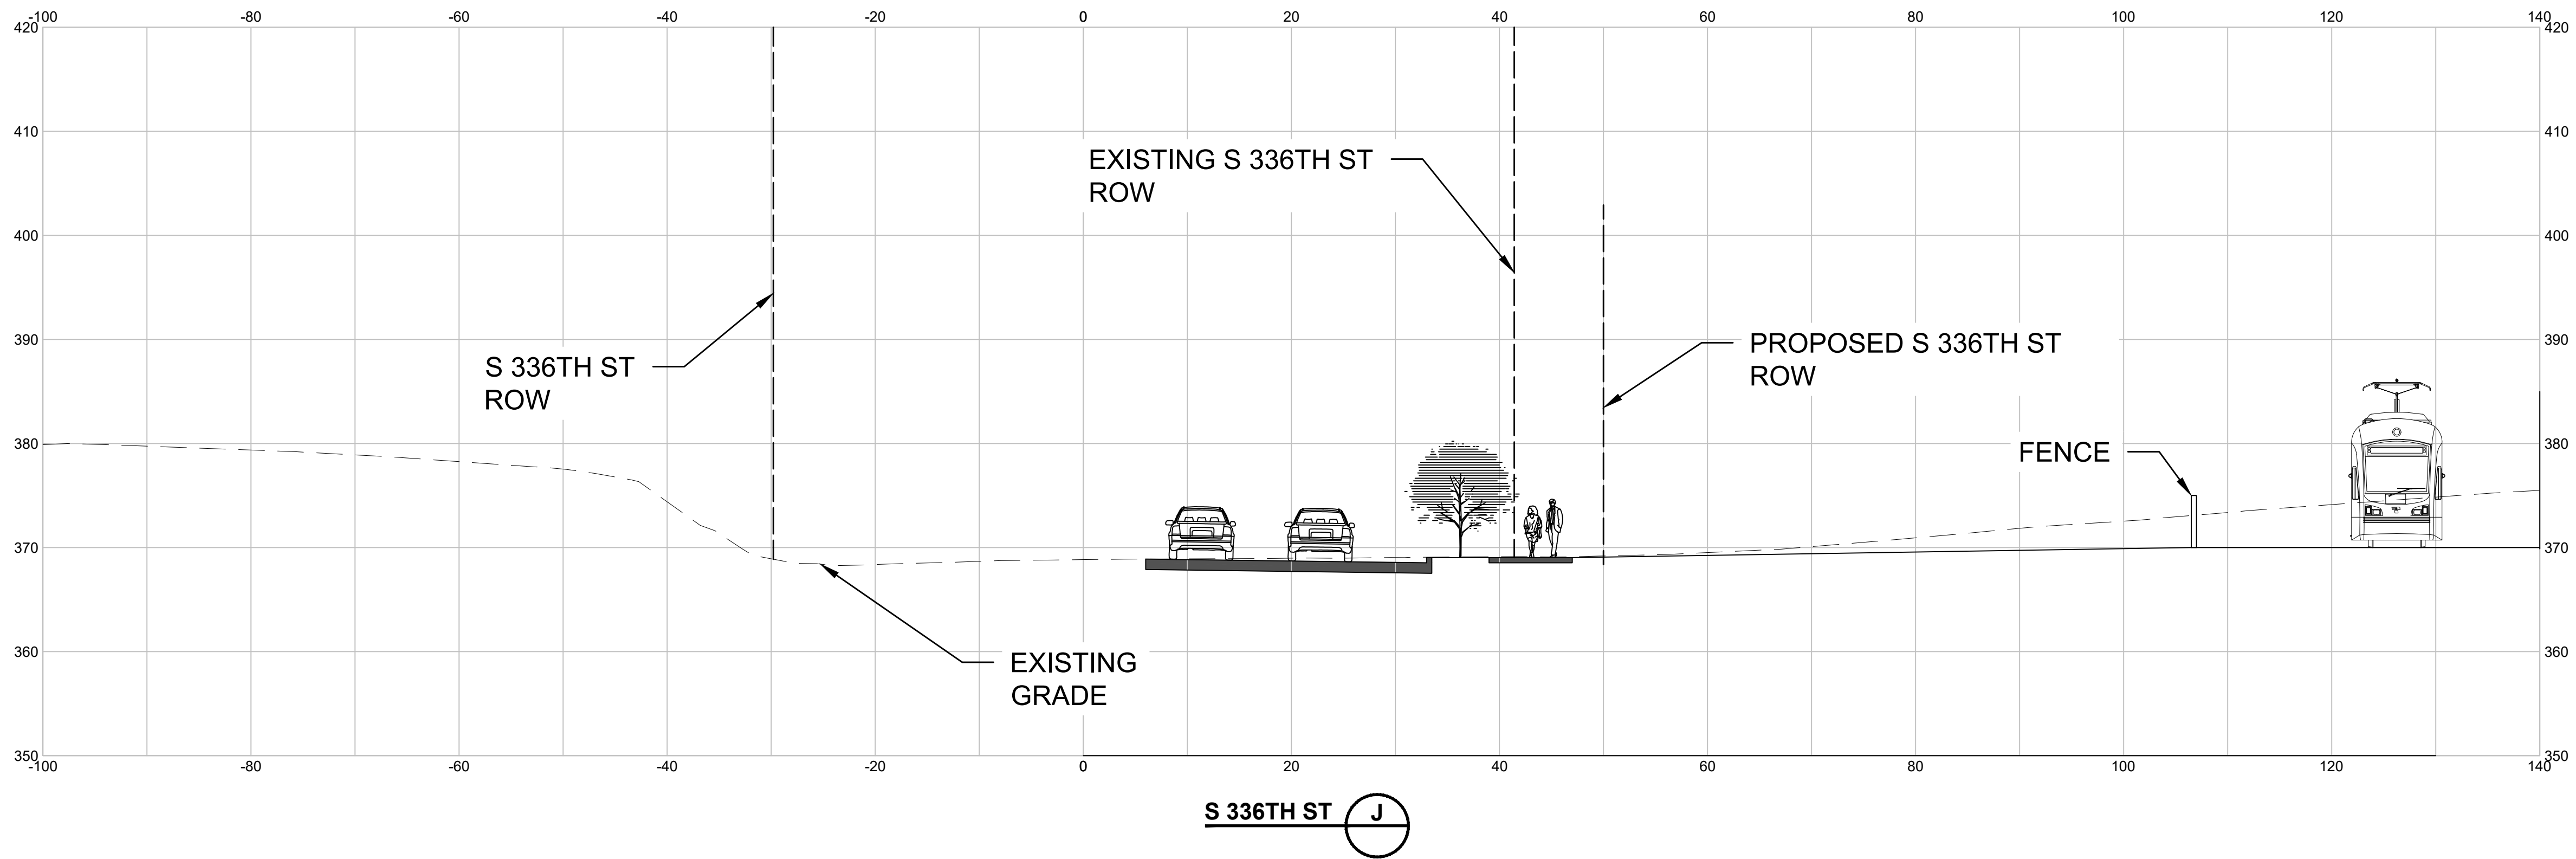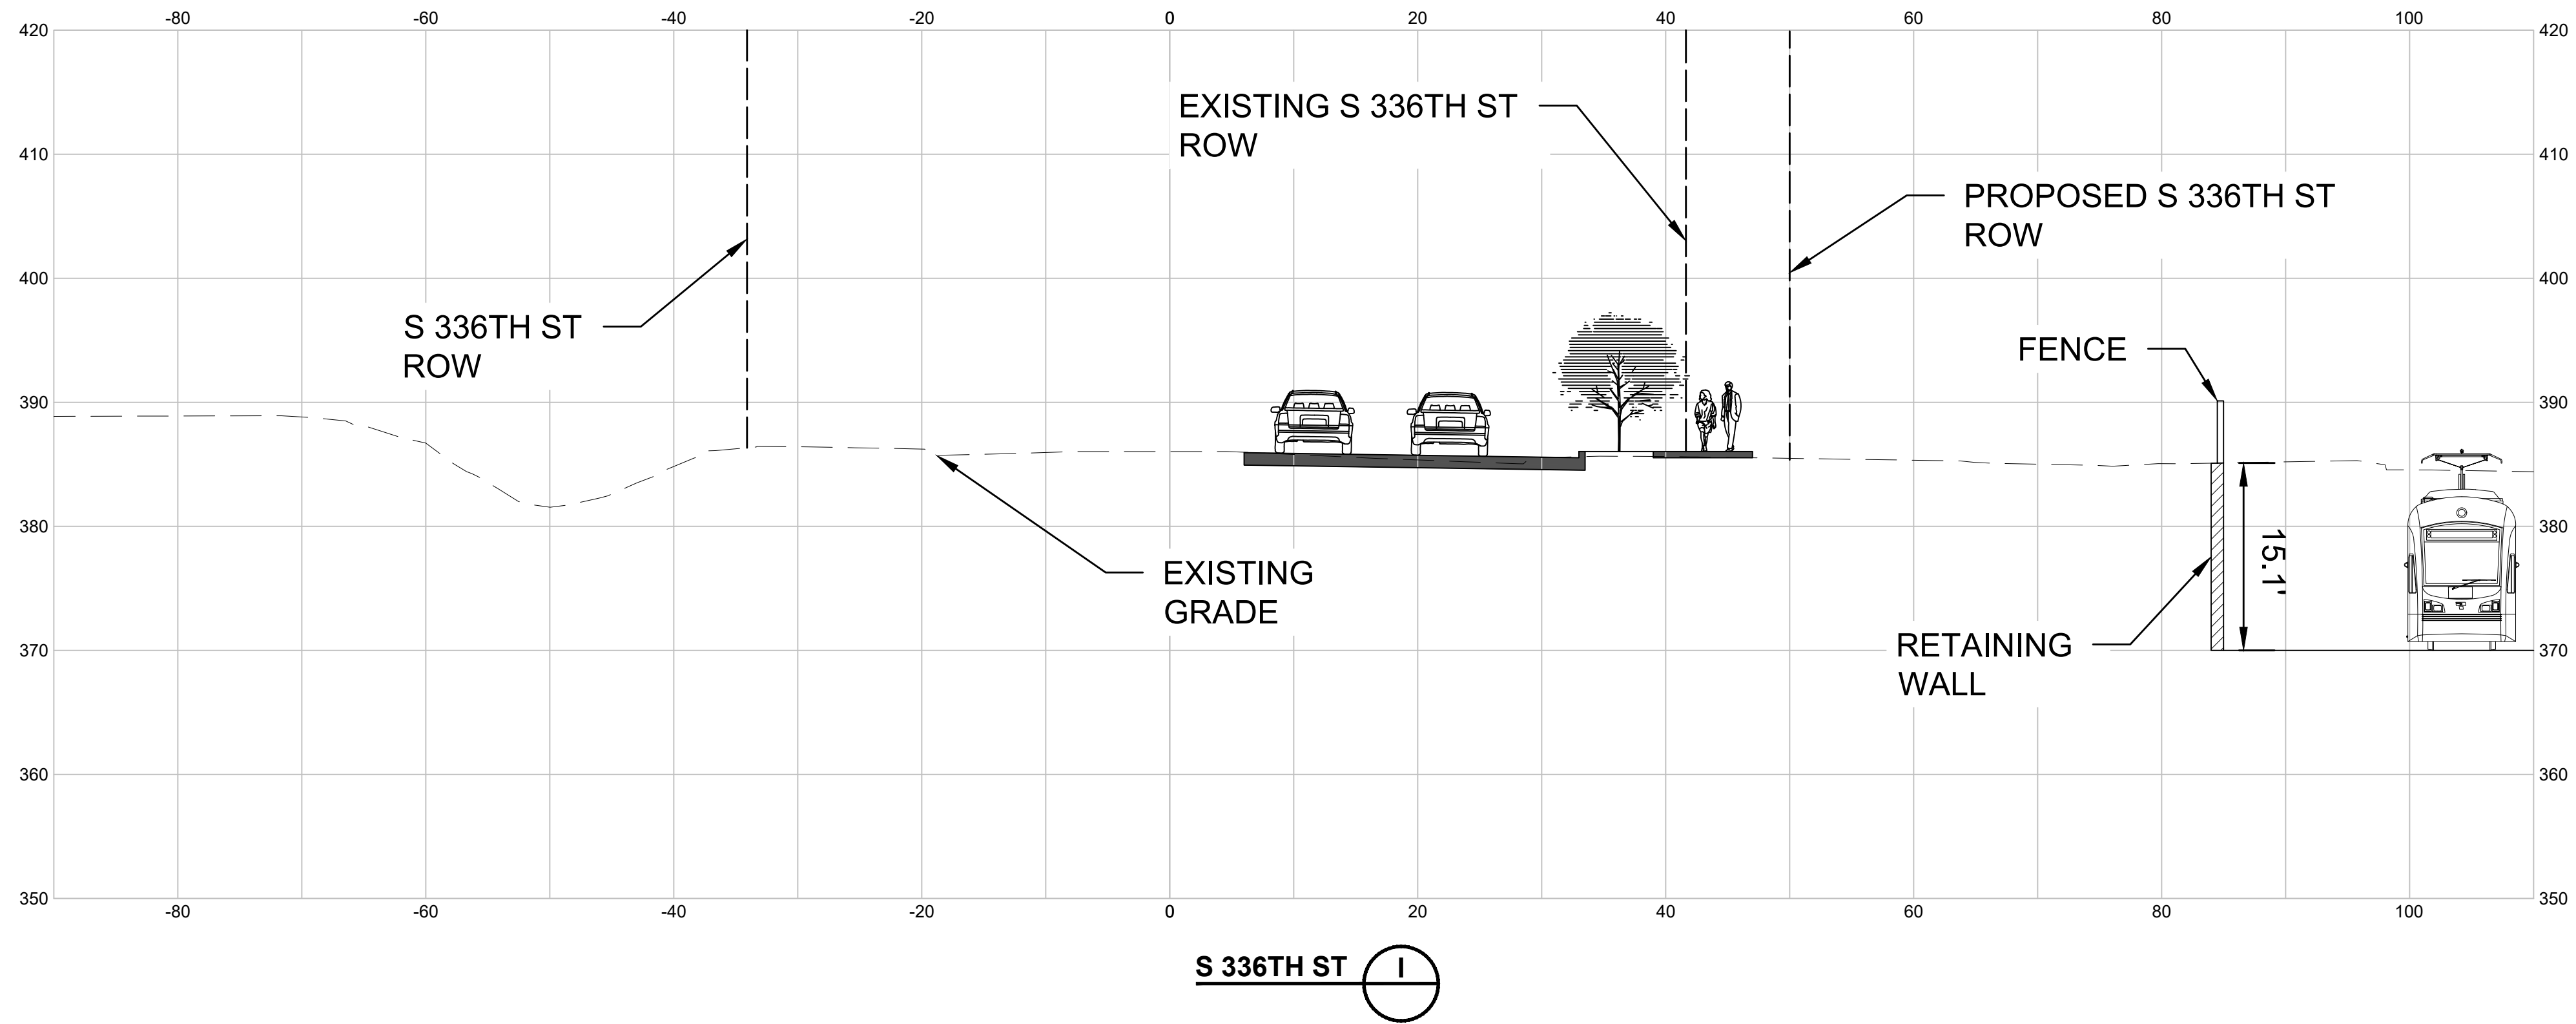


NOT FOR
CONSTRUCTION

Refer to the plan set COVER drawing
for disclaimers regarding this drawing.

REFERENCE CONCEPT DRAWINGS

No.	DATE	DSN	CHK	APP	REVISION

DESIGNED BY:
K. McDONALD
DRAWN BY:
J. LUM
CHECKED BY:
P. LOPEZ-HILFIKER
APPROVED BY:
P. LOPEZ-HILFIKER

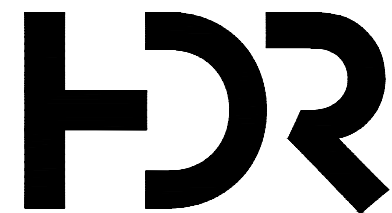

SUBMITTED BY:
PABLO LOPEZ-HILFIKER

DATE:
2/27/2024

REVIEWED BY:

LINE IS 1" AT
FULL SCALE



DATE:

PACKAGE

SCALE:
FILENAME:
OMFS-M08-CGX101-106
CONTRACT No.:
AE-0030-17
DATE:
2/27/2024


SOUND TRANSIT
PRELIMINARY ENGINEERING PLANS
OPERATIONS & MAINTENANCE FACILITY SOUTH


CIVIL
GRADING SECTIONS

DRAWING No.:
M08-CGX105
FACILITY ID:
SHEET No.: REV:

02/22/24 | 3:42 PM | ASCHEPPE
C:\PWORKING\WEST01\272774\OMFS-M08-CGX101-106.DWG

Refer to the plan set COVER drawing
for disclaimers regarding this drawing.

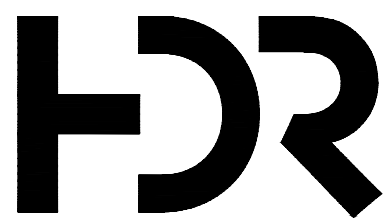REFERENCE CONCEPT DRAWINGS						DESIGNED BY: K. McDONALD		AHJ:				PACKAGE #									
						DRAWN BY: J. LUM		SUBMITTED BY: PABLO LOPEZ-HILFIKER		DATE: 2/27/2024		REVIEWED BY:		DATE: 2/27/2024							
						CHECKED BY: P. LOPEZ-HILFIKER						LINE IS 1" AT FULL SCALE				SCALE:		SOUND TRANSIT PRELIMINARY ENGINEERING PLANS OPERATIONS & MAINTENANCE FACILITY SOUTH CIVIL GRADING SECTIONS		DRAWING No.: M08-CGX106	
						CONTRACT No.: AE-0030-17										FILENAME: OMFS-M08-CGX101-106				FACILITY ID:	
						APPROVED BY: P. LOPEZ-HILFIKER		DATE:		DATE:		SHEET No.: REV:									
No.	DATE	DSN	CHK	APP	REVISION																

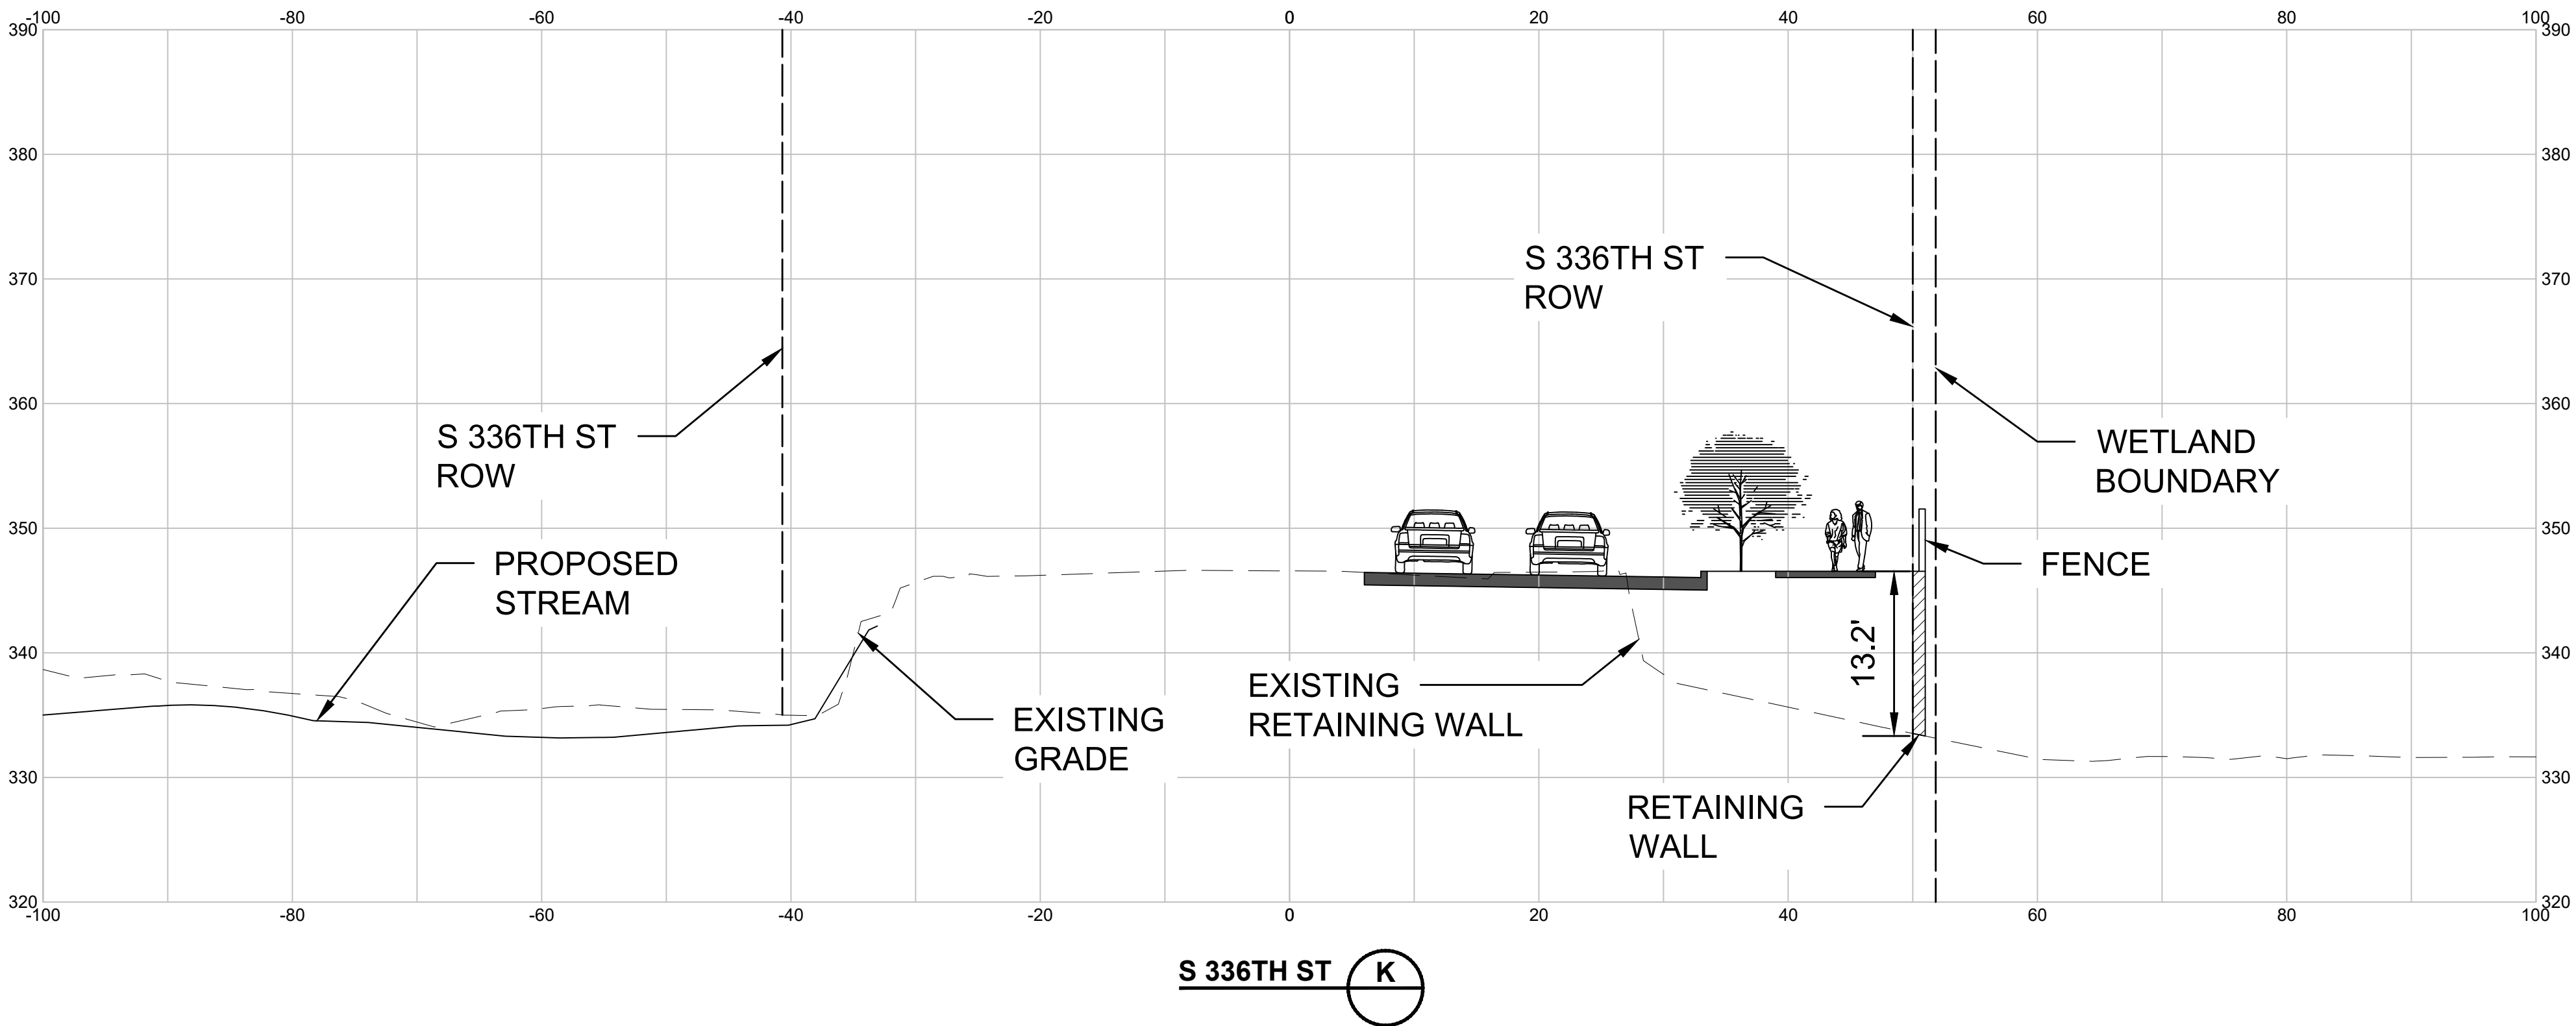


NOT FOR
CONSTRUCTION

02/21/24 | 11:53 AM | WILLIBRE
C:\PWORKING\WEST01\02772718\OMFS-M08-CDP-01-134.DWG

Refer to the plan set COVER drawing
for disclaimers regarding this drawing.

REFERENCE CONCEPT DRAWINGS					
No.	DATE	DSN	CHK	APP	REVISION

DESIGNED BY:	L. GRABOWSKI
DRAWN BY:	B. WILLIAMS
CHECKED BY:	J. WRIGHT
APPROVED BY:	J.COOP

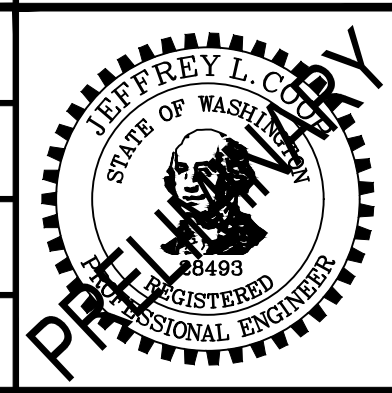


SUBMITTED BY:
PABLO LOPEZ-HILFIKER

DATE:
2/27/2024

REVIEWED BY:

LINE IS 1" AT
FULL SCALE

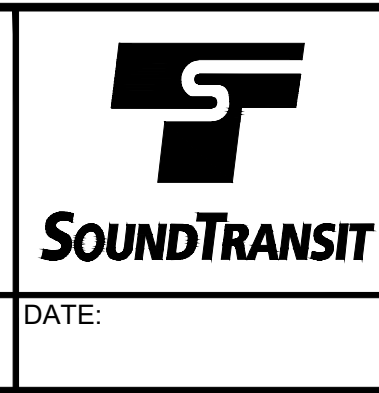


PACKAGE #
SCALE: 1"=20'
FILENAME: OMFS-M08-CDP101-134
CONTRACT No.: AE-0030-17
DATE: 2/27/2024

SOUND TRANSIT
PRELIMINARY ENGINEERING PLANS
OPERATIONS & MAINTENANCE FACILITY SOUTH

CIVIL
DRAINAGE PLAN



DRAWING No.:	M08-CDP101
FACILITY ID:	M08
SHEET No.:	REV:

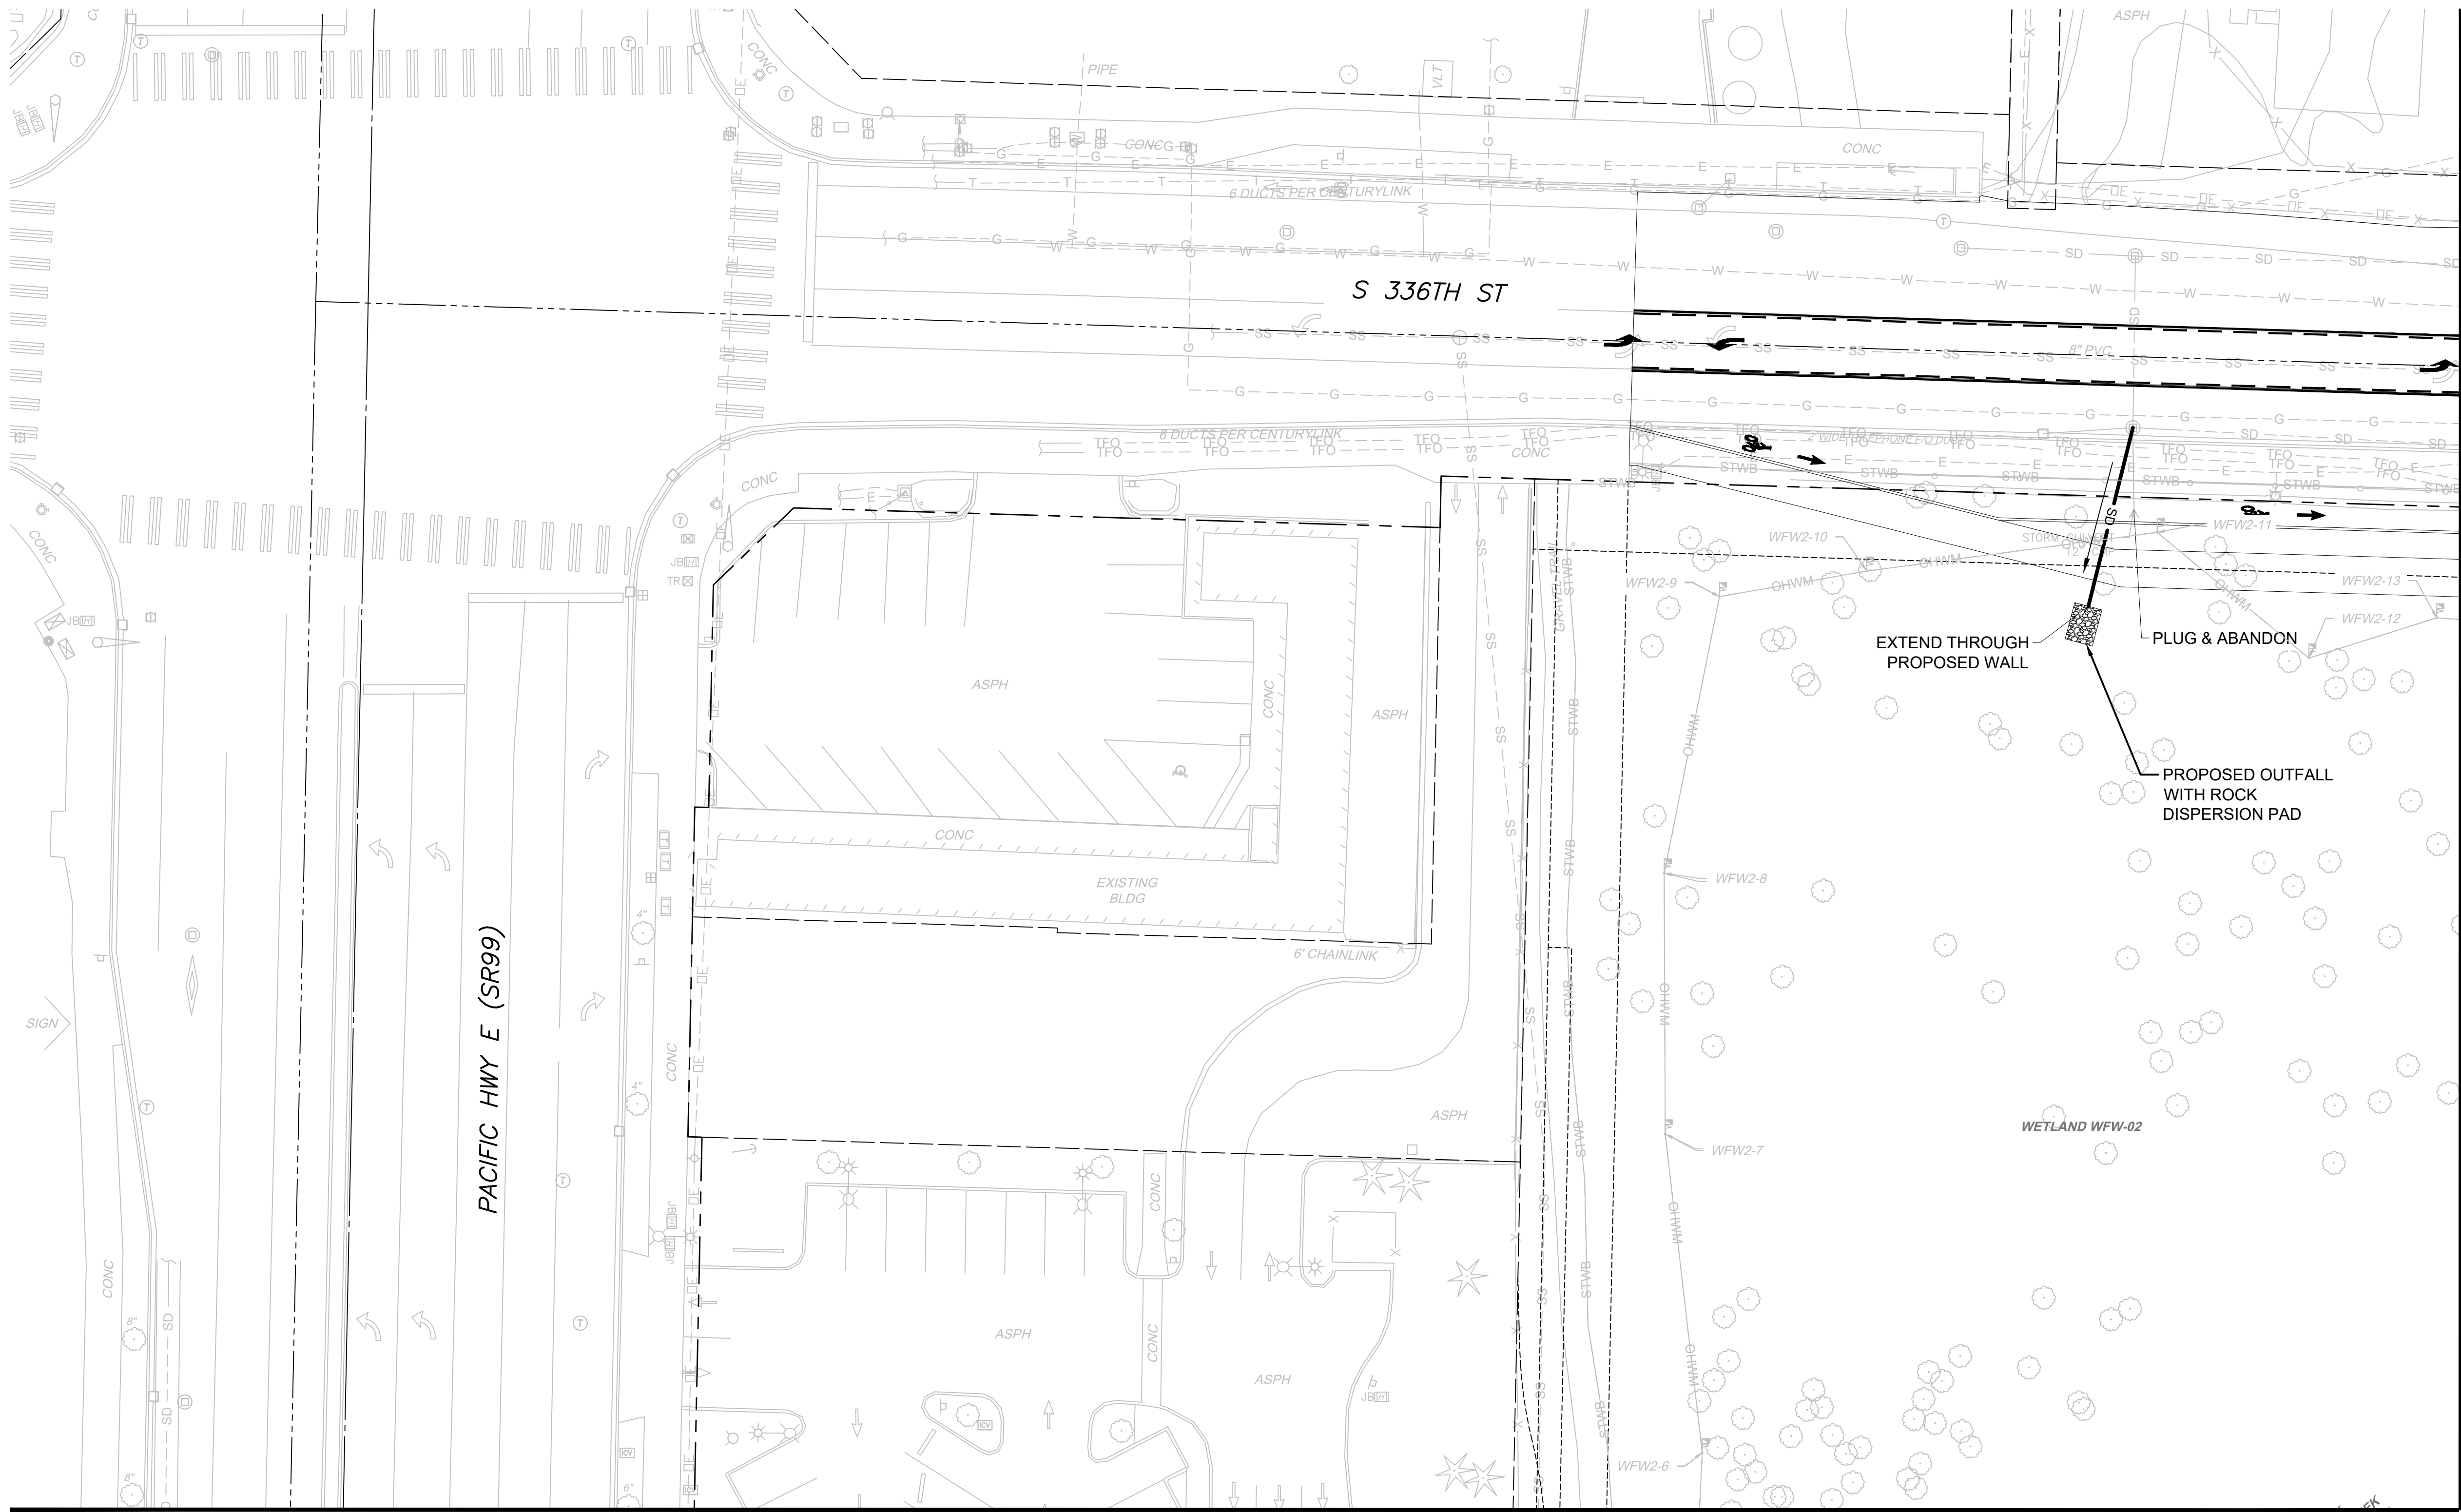

MATCHLINE:
SEE DWG M08-CDP106

MATCHLINE:
SEE DWG M08-CDP102

- NOTES:**
- REMOVE EXISTING STORM DRAINS AND DRAINAGE STRUCTURES AT CONFLICTS WITH PROPOSED STORM DRAIN, PROPOSED DRAINAGE STRUCTURES, OR PROPOSED STORMWATER FACILITIES. RELOCATE STORM DRAINS OR REPLACE EXISTING DRAINAGE STRUCTURES AS REQUIRED.
 - ALL PROPOSED UNDERGROUND STORM DRAIN 12-INCH DIAMETER UNLESS NOTED OTHERWISE.

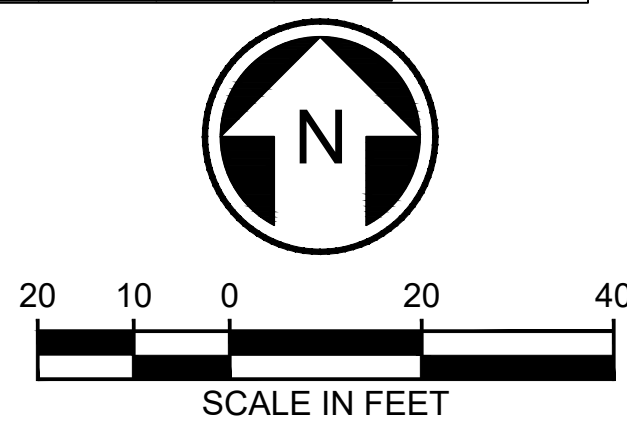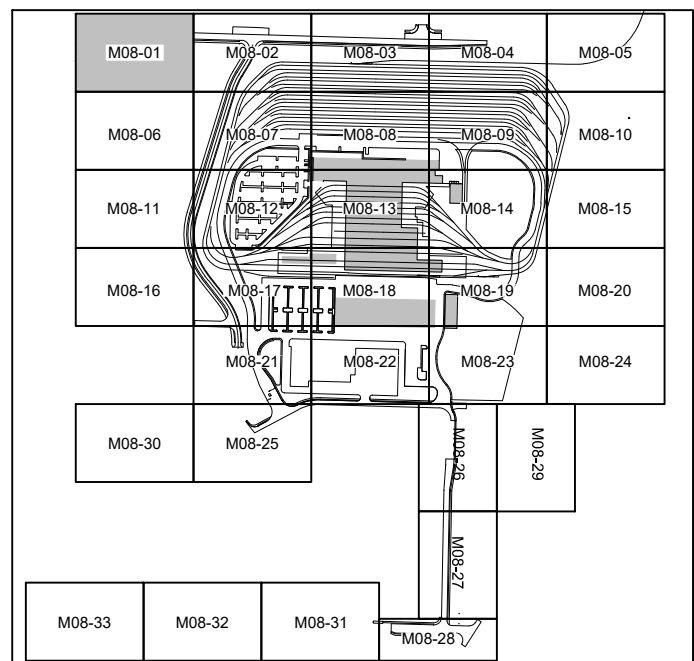

NOT FOR
CONSTRUCTION

02/21/24 | 11:53 AM | WILLIBRE
C:\PWORKING\WEST01\2727718\OMFS-M08-CDP-01-134.DWG



MATCHLINE:
SEE DWG M08-CDP101

Refer to the plan set COVER drawing
for disclaimers regarding this drawing.

REFERENCE CONCEPT DRAWINGS

No.	DATE	DSN	CHK	APP	REVISION

DESIGNED BY:
L. GRABOWSKI
DRAWN BY:
B. WILLIAMS
CHECKED BY:
J. WRIGHT
APPROVED BY:
J. COOP

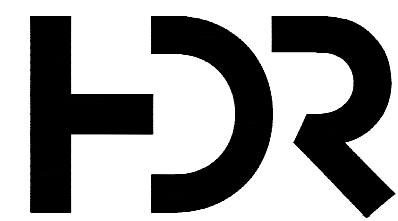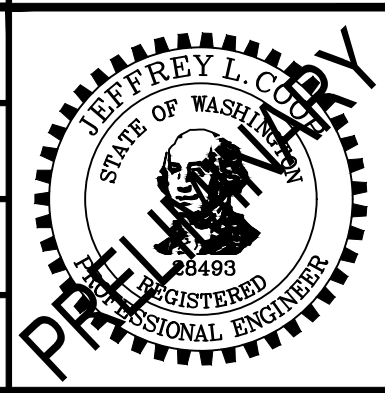

SUBMITTED BY:
PABLO LOPEZ-HILFIKER

DATE:
2/27/2024

REVIEWED BY:



DATE:


PACKAGE

SCALE:
1"=20'
FILENAME:
OMFS-M08-CDP101-134
CONTRACT No.:
AE-0030-17
DATE:
2/27/2024

SOUND TRANSIT
PRELIMINARY ENGINEERING PLANS
OPERATIONS & MAINTENANCE FACILITY SOUTH

CIVIL
DRAINAGE PLAN



DRAWING No.:
M08-CDP102
FACILITY ID:
M08
SHEET No.: REV:

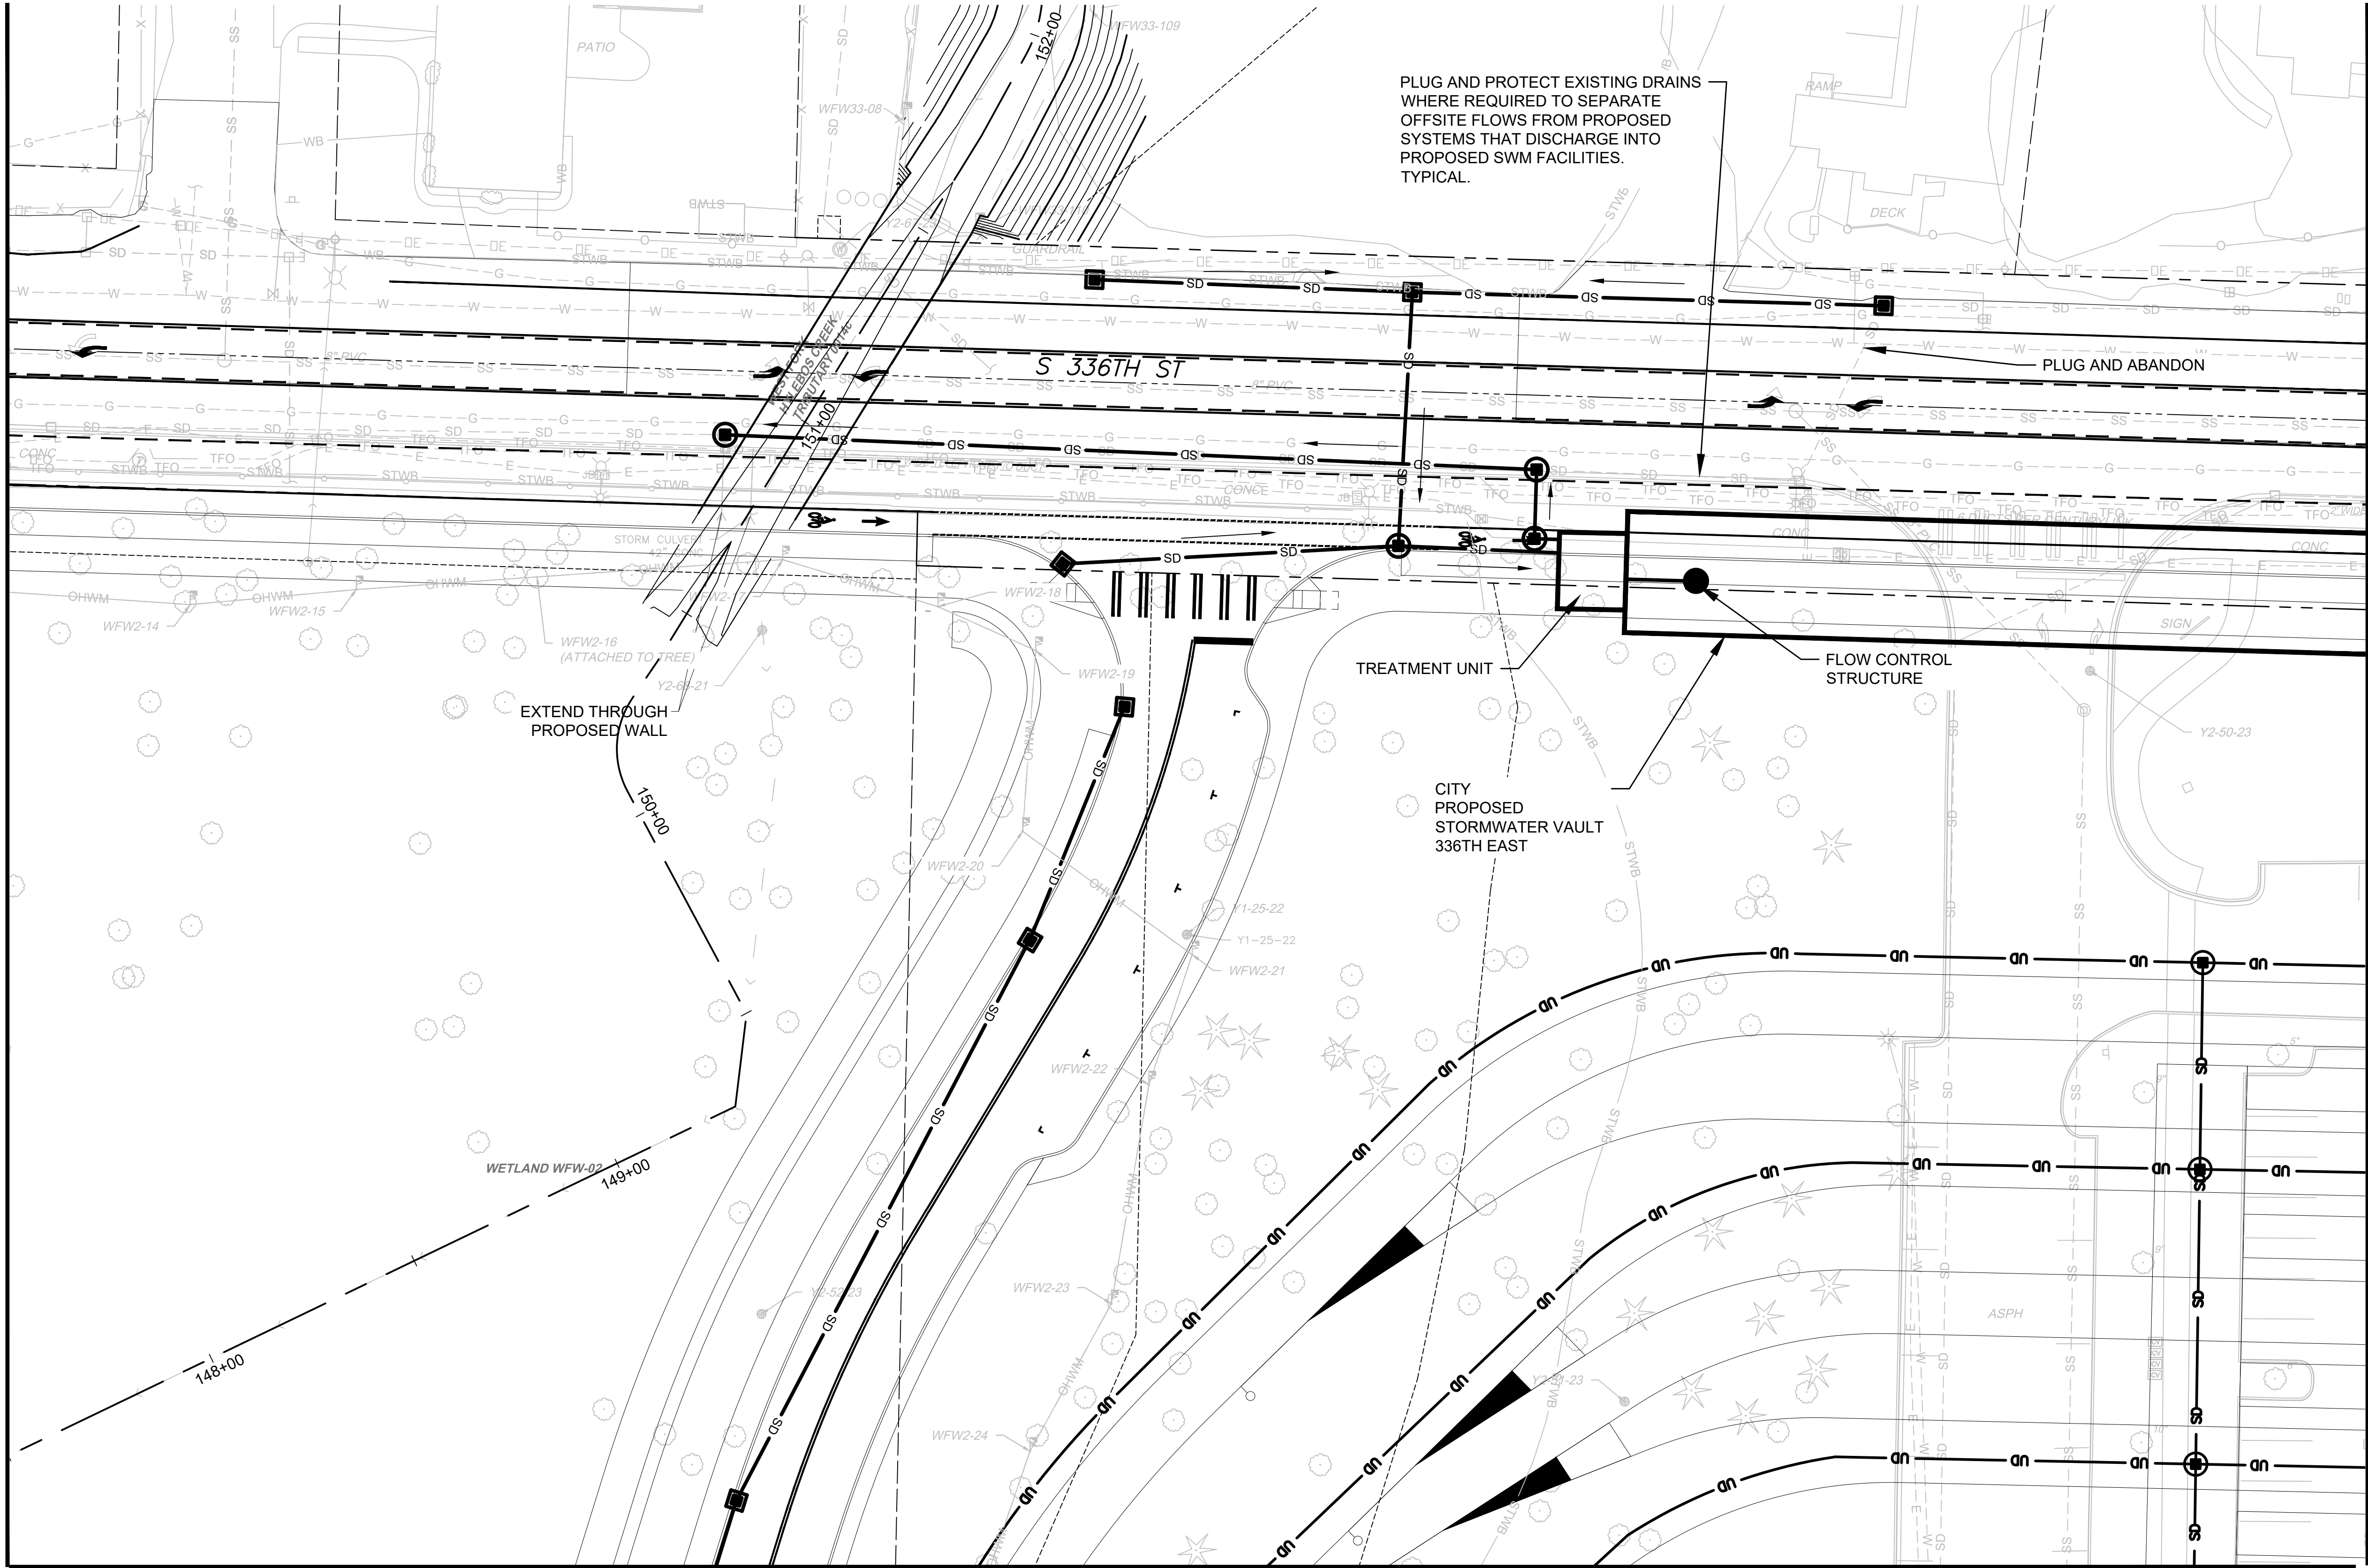

MATCHLINE:
SEE DWG M08-CDP107

MATCHLINE:
SEE DWG M08-CDP103

- NOTES:**
- REMOVE EXISTING STORM DRAINS AND DRAINAGE STRUCTURES AT CONFLICTS WITH PROPOSED STORM DRAIN, PROPOSED DRAINAGE STRUCTURES, OR PROPOSED STORMWATER FACILITIES. RELOCATE STORM DRAINS OR REPLACE EXISTING DRAINAGE STRUCTURES AS REQUIRED.
 - ALL PROPOSED UNDERGROUND STORM DRAIN 12-INCH DIAMETER UNLESS NOTED OTHERWISE.

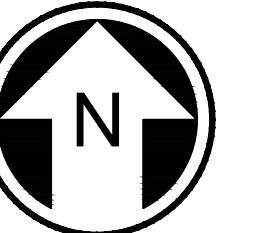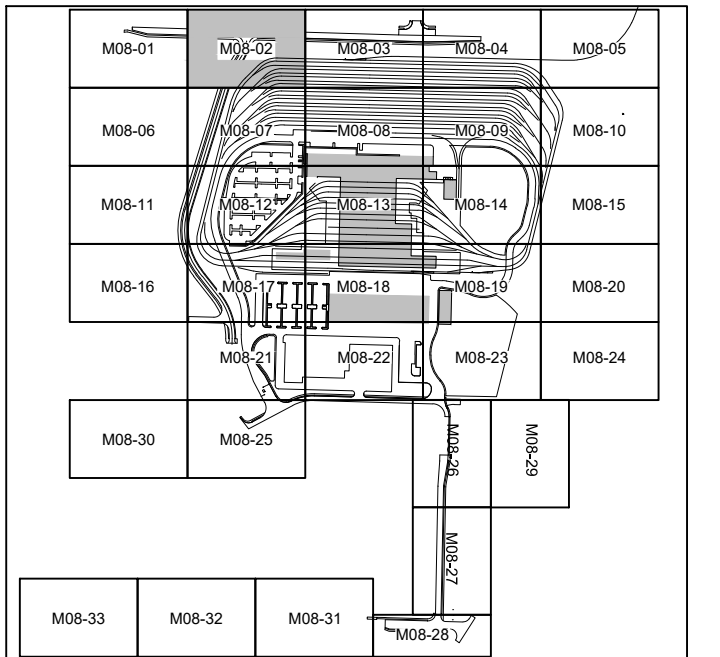


20 10 0 20 40
SCALE IN FEET

NOT FOR
CONSTRUCTION

02/21/24 | 11:54 AM | WILLIBRE
C:\PWORKING\WEST01\272718\OMFS-M08-CDP101-134.DWG



MATCHLINE:
SEE DWG M08-CDP102

Refer to the plan set COVER drawing
for disclaimers regarding this drawing.

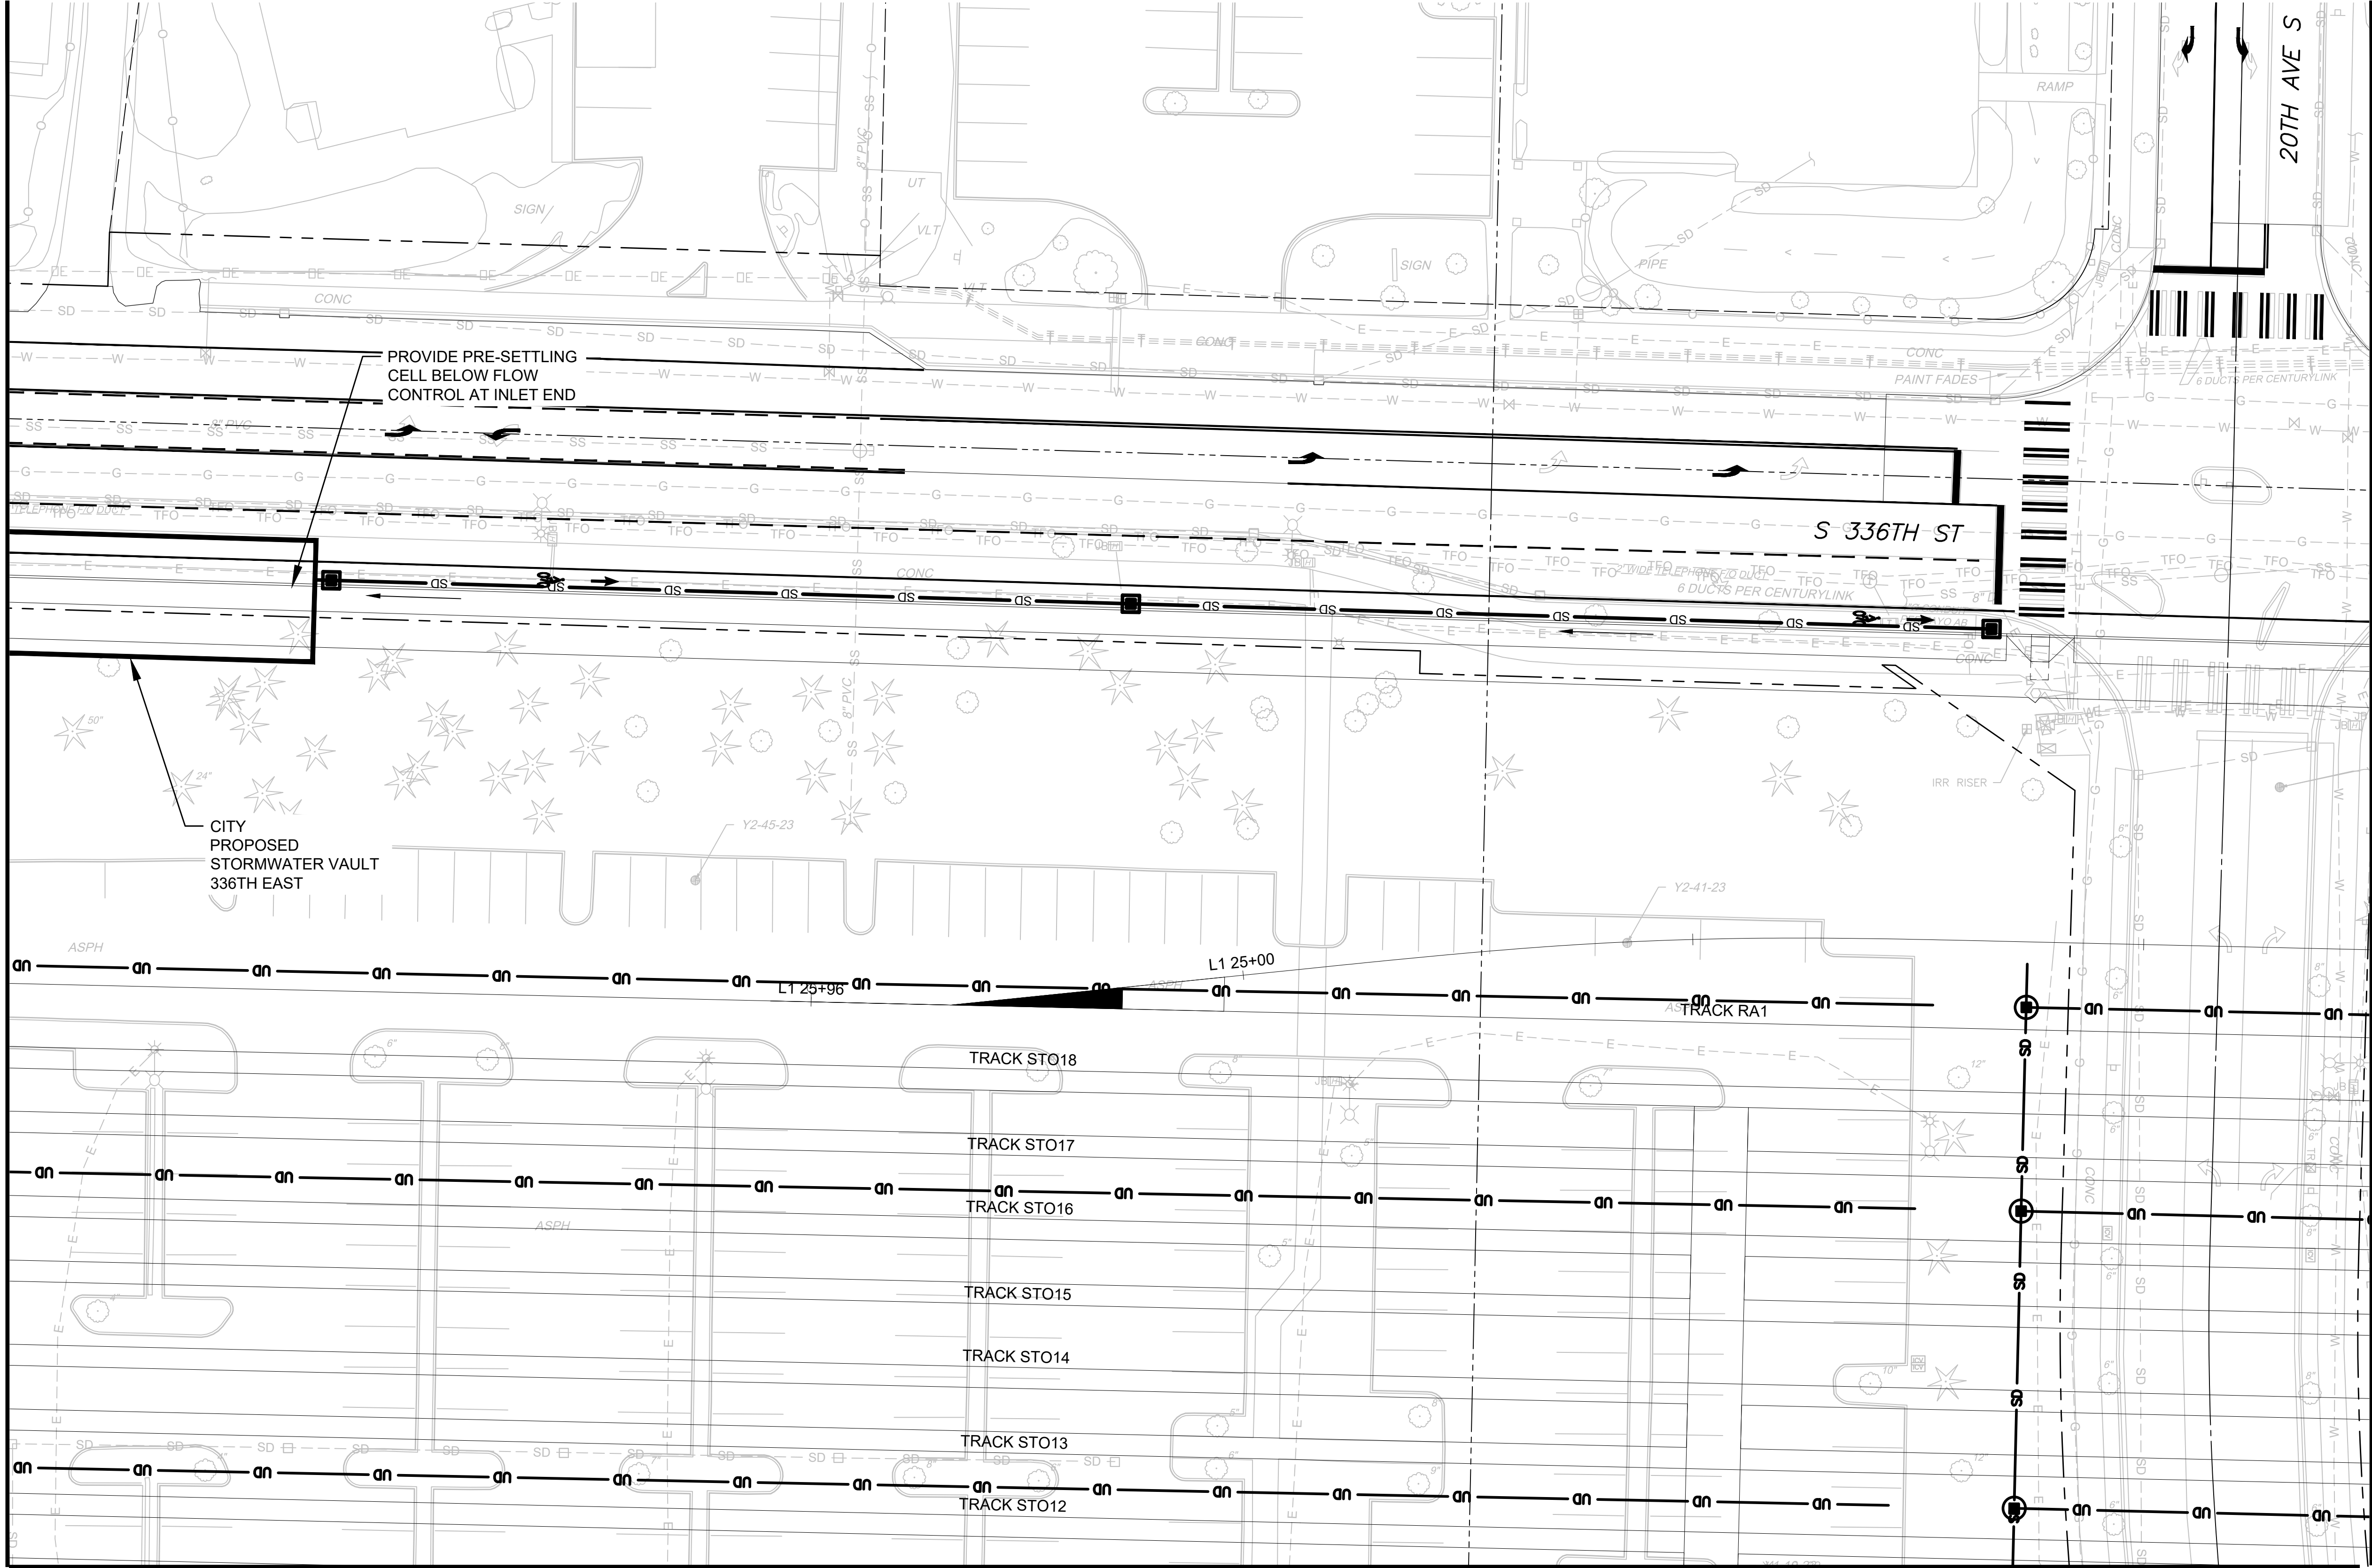

MATCHLINE:
SEE DWG M08-CDP104

- NOTES:**
1. REMOVE EXISTING STORM DRAINS AND DRAINAGE STRUCTURES AT CONFLICTS WITH PROPOSED STORM DRAIN, PROPOSED DRAINAGE STRUCTURES, OR PROPOSED STORMWATER FACILITIES. RELOCATE STORM DRAINS OR REPLACE EXISTING DRAINAGE STRUCTURES AS REQUIRED.
 2. ALL PROPOSED UNDERGROUND STORM DRAIN 12-INCH DIAMETER UNLESS NOTED OTHERWISE.

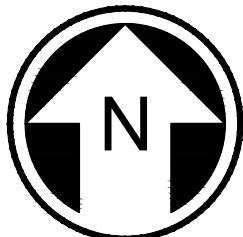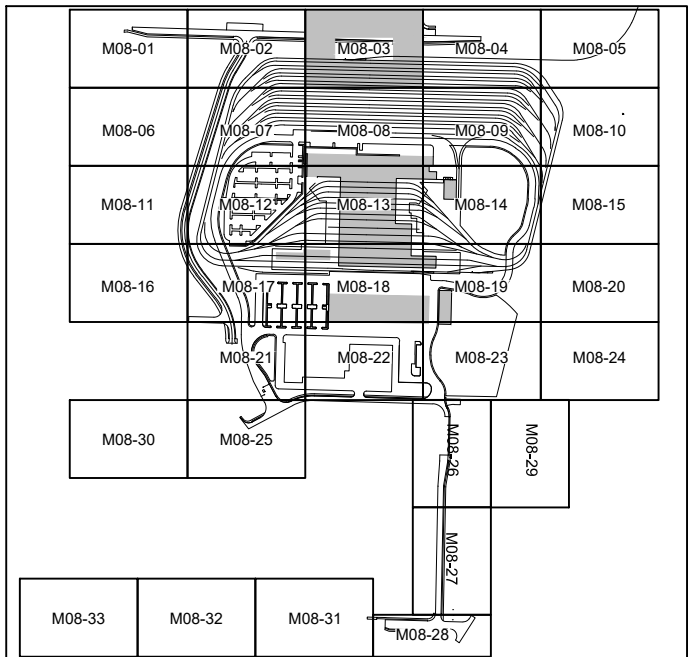

NOT FOR
CONSTRUCTION

MATCHLINE:
SEE DWG M08-CDP108


AHJ:					PACKAGE #				
				LINE IS 1" AT FULL SCALE  SOUNDTRANSIT	SCALE: 1"=20'	SOUND TRANSIT PRELIMINARY ENGINEERING PLANS OPERATIONS & MAINTENANCE FACILITY SOUTH CIVIL DRAINAGE PLAN			DRAWING No.: M08-CDP103
					FILENAME: OMFS-M08-CDP101-134				FACILITY ID: M08
					CONTRACT No.: AE-0030-17				SHEET No.: REV:
					DATE: 2/27/2024				
	SUBMITTED BY: PABLO LOPEZ-HILFIKER		DATE: 2/27/2024	REVIEWED BY:		DATE:			

02/21/24 | 11:54 AM | WILLIBRE
C:\PWORKING\WEST01\DWG\OMFS-M08-CDP101-134.DWG

Refer to the plan set COVER drawing
for disclaimers regarding this drawing.

REFERENCE CONCEPT DRAWINGS					
No.	DATE	DSN	CHK	APP	REVISION


DESIGNED BY:	L. GRABOWSKI
DRAWN BY:	B. WILLIAMS
CHECKED BY:	J. WRIGHT
APPROVED BY:	J.COOP

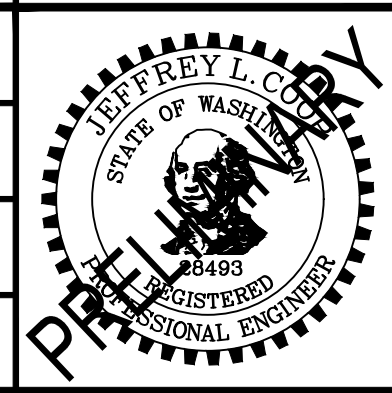

SUBMITTED BY:
PABLO LOPEZ-HILFIKER

DATE:
2/27/2024

REVIEWED BY:

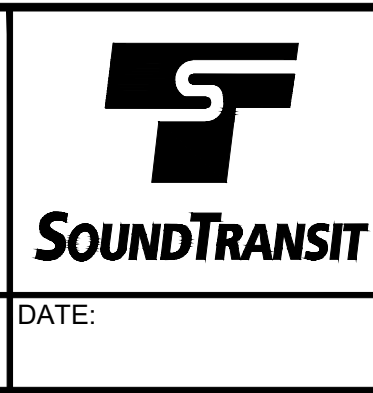


PACKAGE #
SCALE: 1"=20'
FILENAME: OMFS-M08-CDP101-134
CONTRACT No.: AE-0030-17
DATE: 2/27/2024



SOUND TRANSIT
PRELIMINARY ENGINEERING PLANS
OPERATIONS & MAINTENANCE FACILITY SOUTH

CIVIL
DRAINAGE PLAN

DRAWING No.:	M08-CDP104
FACILITY ID:	M08
SHEET No.:	REV:

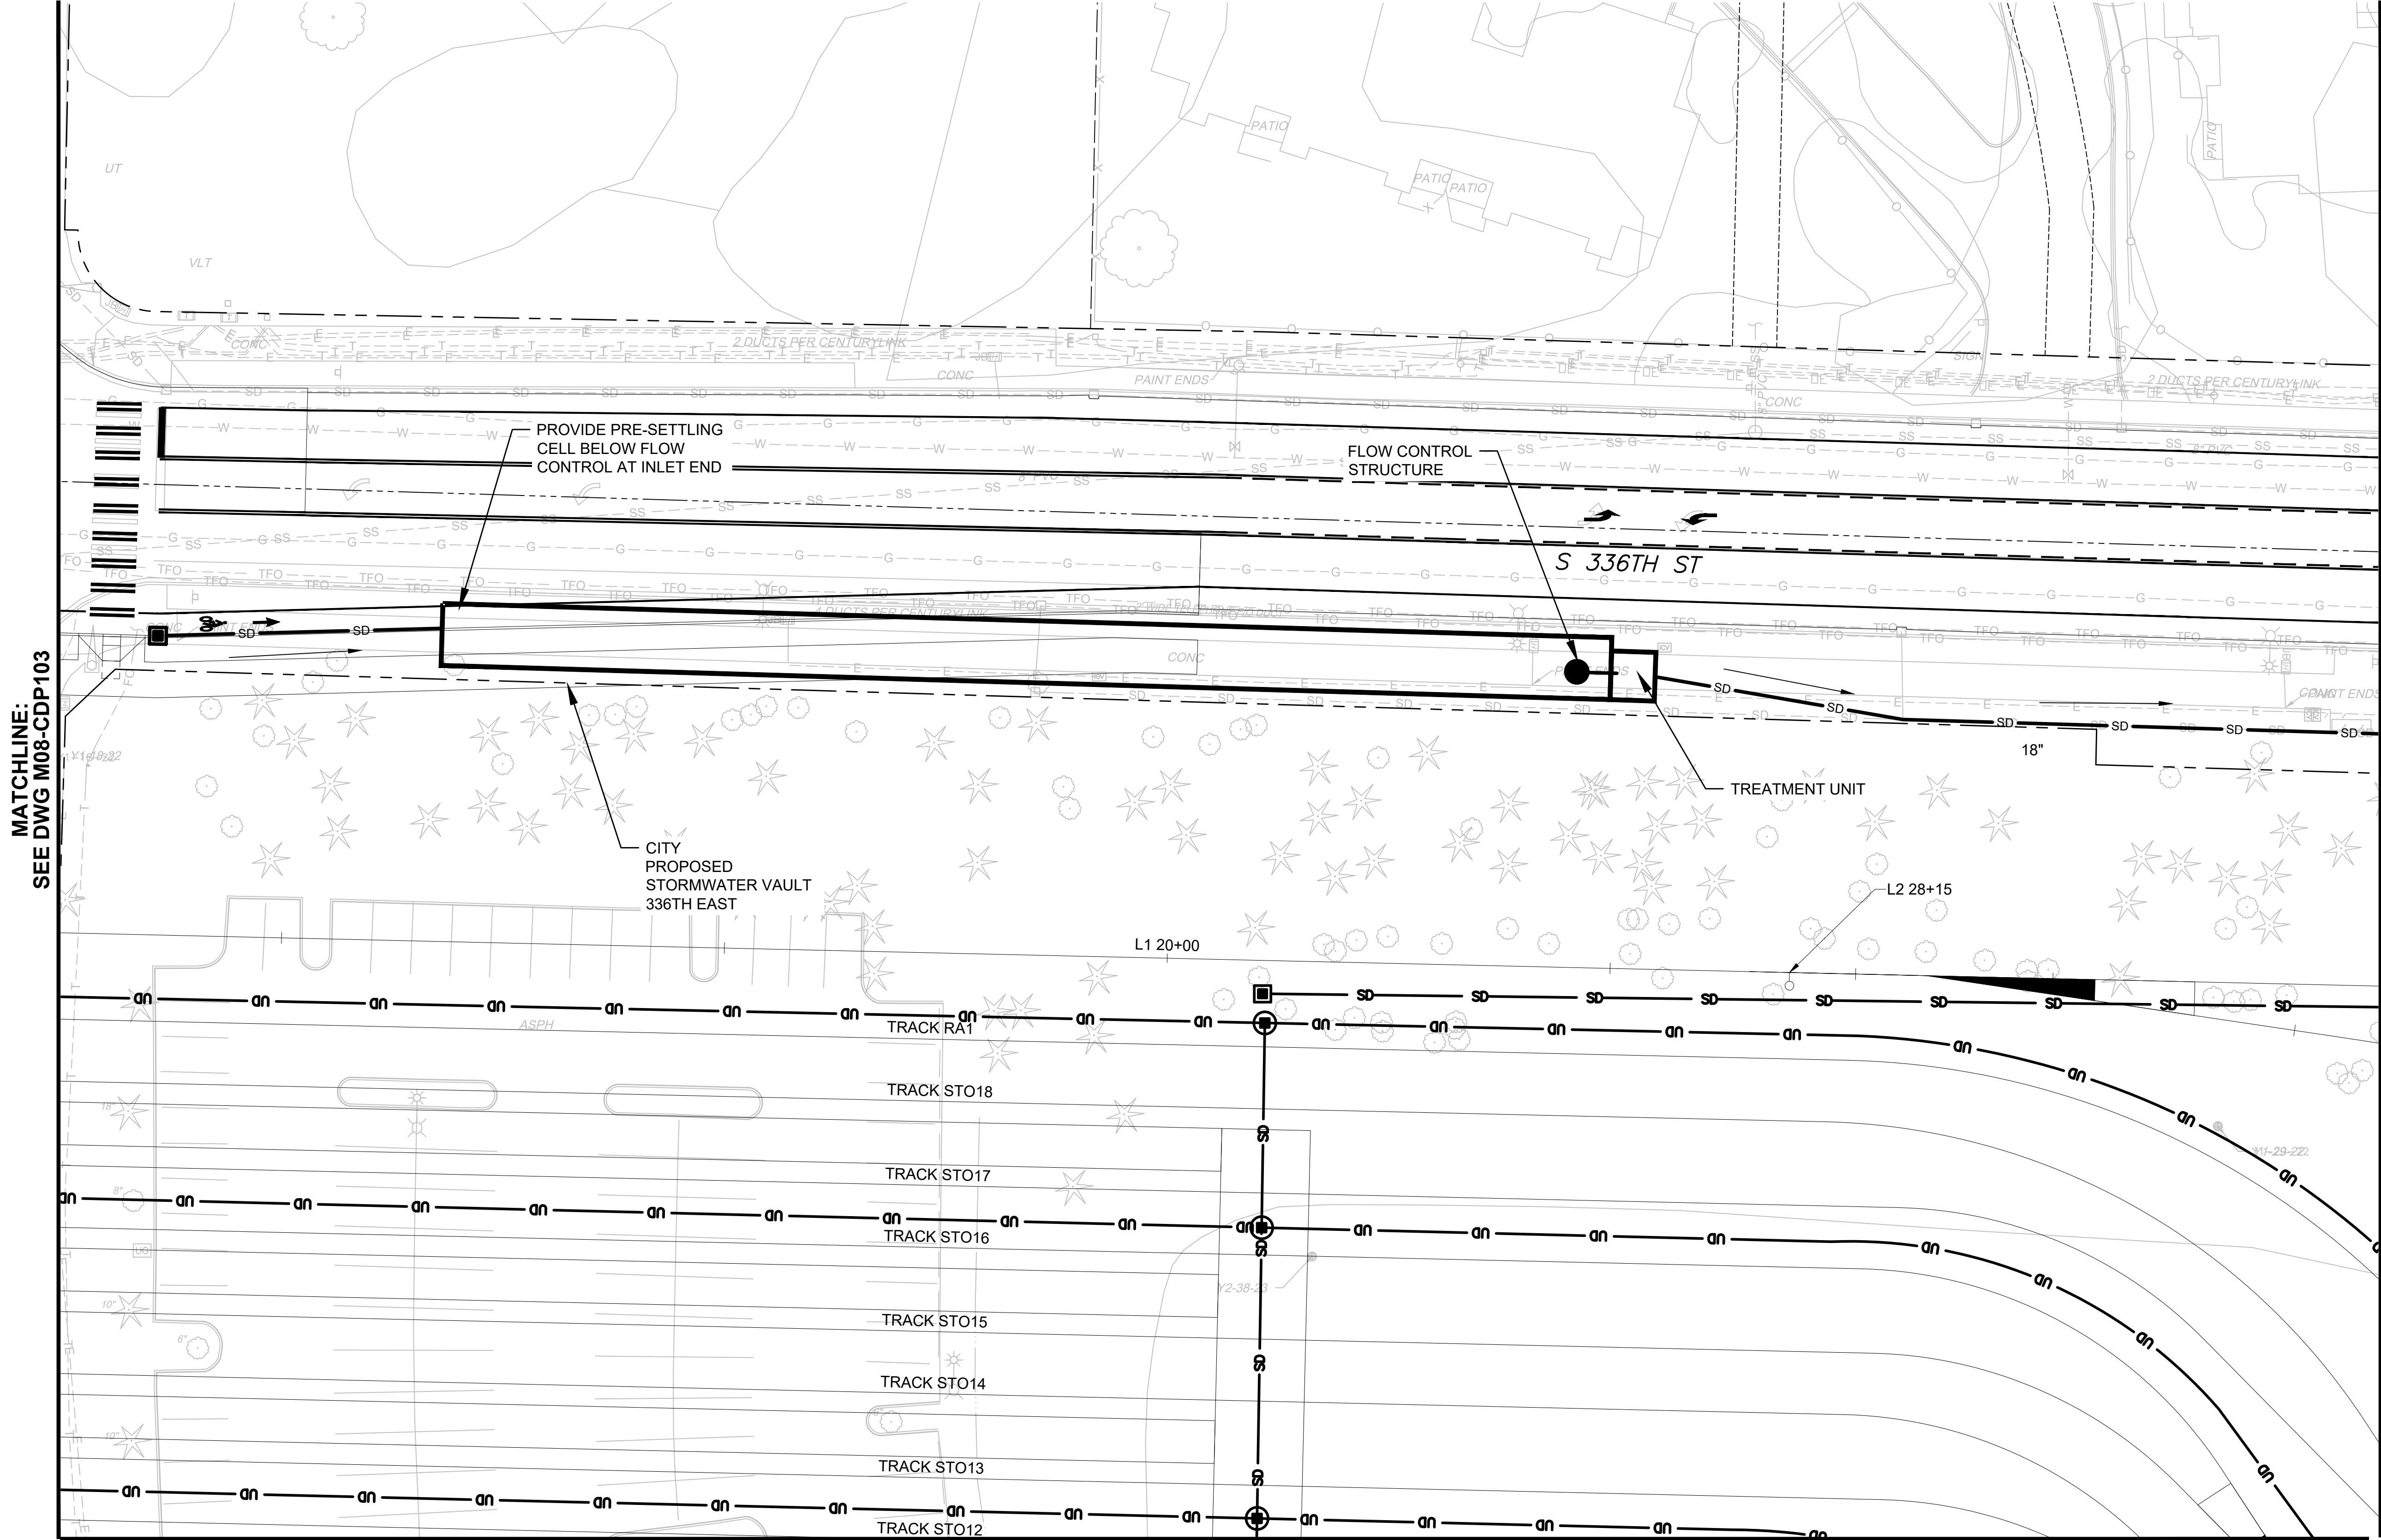

- NOTES:**
- REMOVE EXISTING STORM DRAINS AND DRAINAGE STRUCTURES AT CONFLICTS WITH PROPOSED STORM DRAIN, PROPOSED DRAINAGE STRUCTURES, OR PROPOSED STORMWATER FACILITIES. RELOCATE STORM DRAINS OR REPLACE EXISTING DRAINAGE STRUCTURES AS REQUIRED.
 - ALL PROPOSED UNDERGROUND STORM DRAIN 12-INCH DIAMETER UNLESS NOTED OTHERWISE.

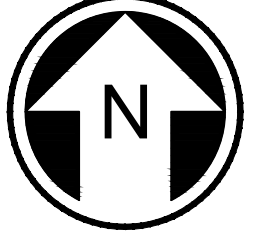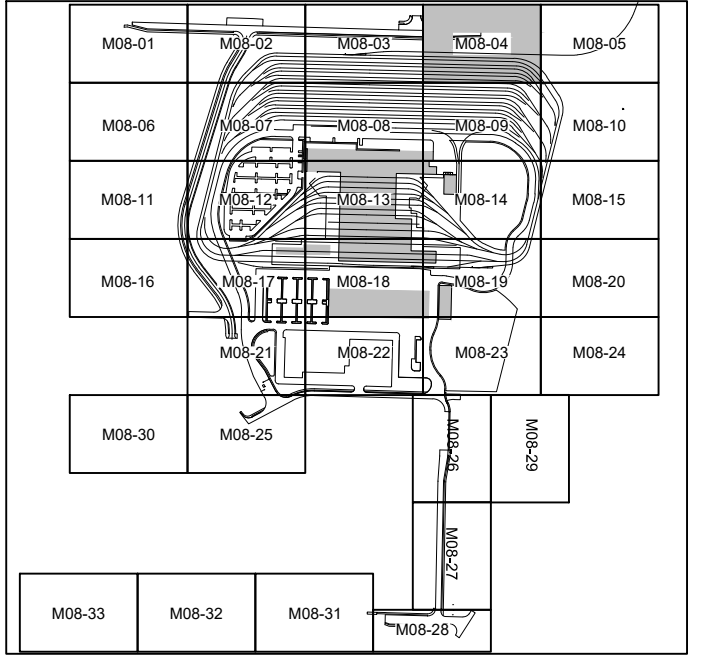


NOT FOR
CONSTRUCTION

02/21/24 | 11:54 AM | WILLIBRE
C:\PWORKING\WEST01\2727718\OMFS-M08-CDP101-134.DWG

Refer to the plan set COVER drawing
for disclaimers regarding this drawing.

REFERENCE CONCEPT DRAWINGS					
No.	DATE	DSN	CHK	APP	REVISION


DESIGNED BY:	L. GRABOWSKI
DRAWN BY:	B. WILLIAMS
CHECKED BY:	J. WRIGHT
APPROVED BY:	J.COOP

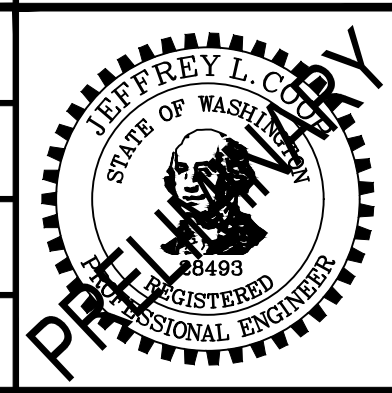

SUBMITTED BY:
PABLO LOPEZ-HILFIKER

DATE:
2/27/2024

REVIEWED BY:

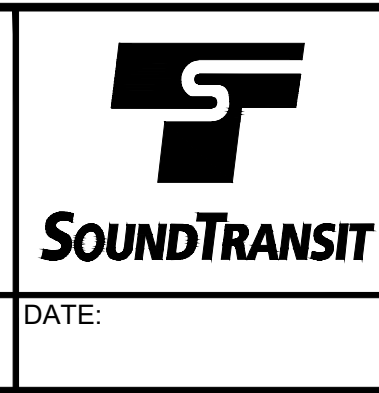

DATE:

PACKAGE #
SCALE: 1"=20'
FILENAME: OMFS-M08-CDP101-134
CONTRACT No.: AE-0030-17
DATE: 2/27/2024


SOUND TRANSIT
PRELIMINARY ENGINEERING PLANS
OPERATIONS & MAINTENANCE FACILITY SOUTH

CIVIL
DRAINAGE PLAN




DRAWING No.:	M08-CDP105
FACILITY ID:	M08
SHEET No.:	REV:

MATCHLINE:
SEE DWG M08-CDP104

MATCHLINE:
SEE DWG M08-CDP110

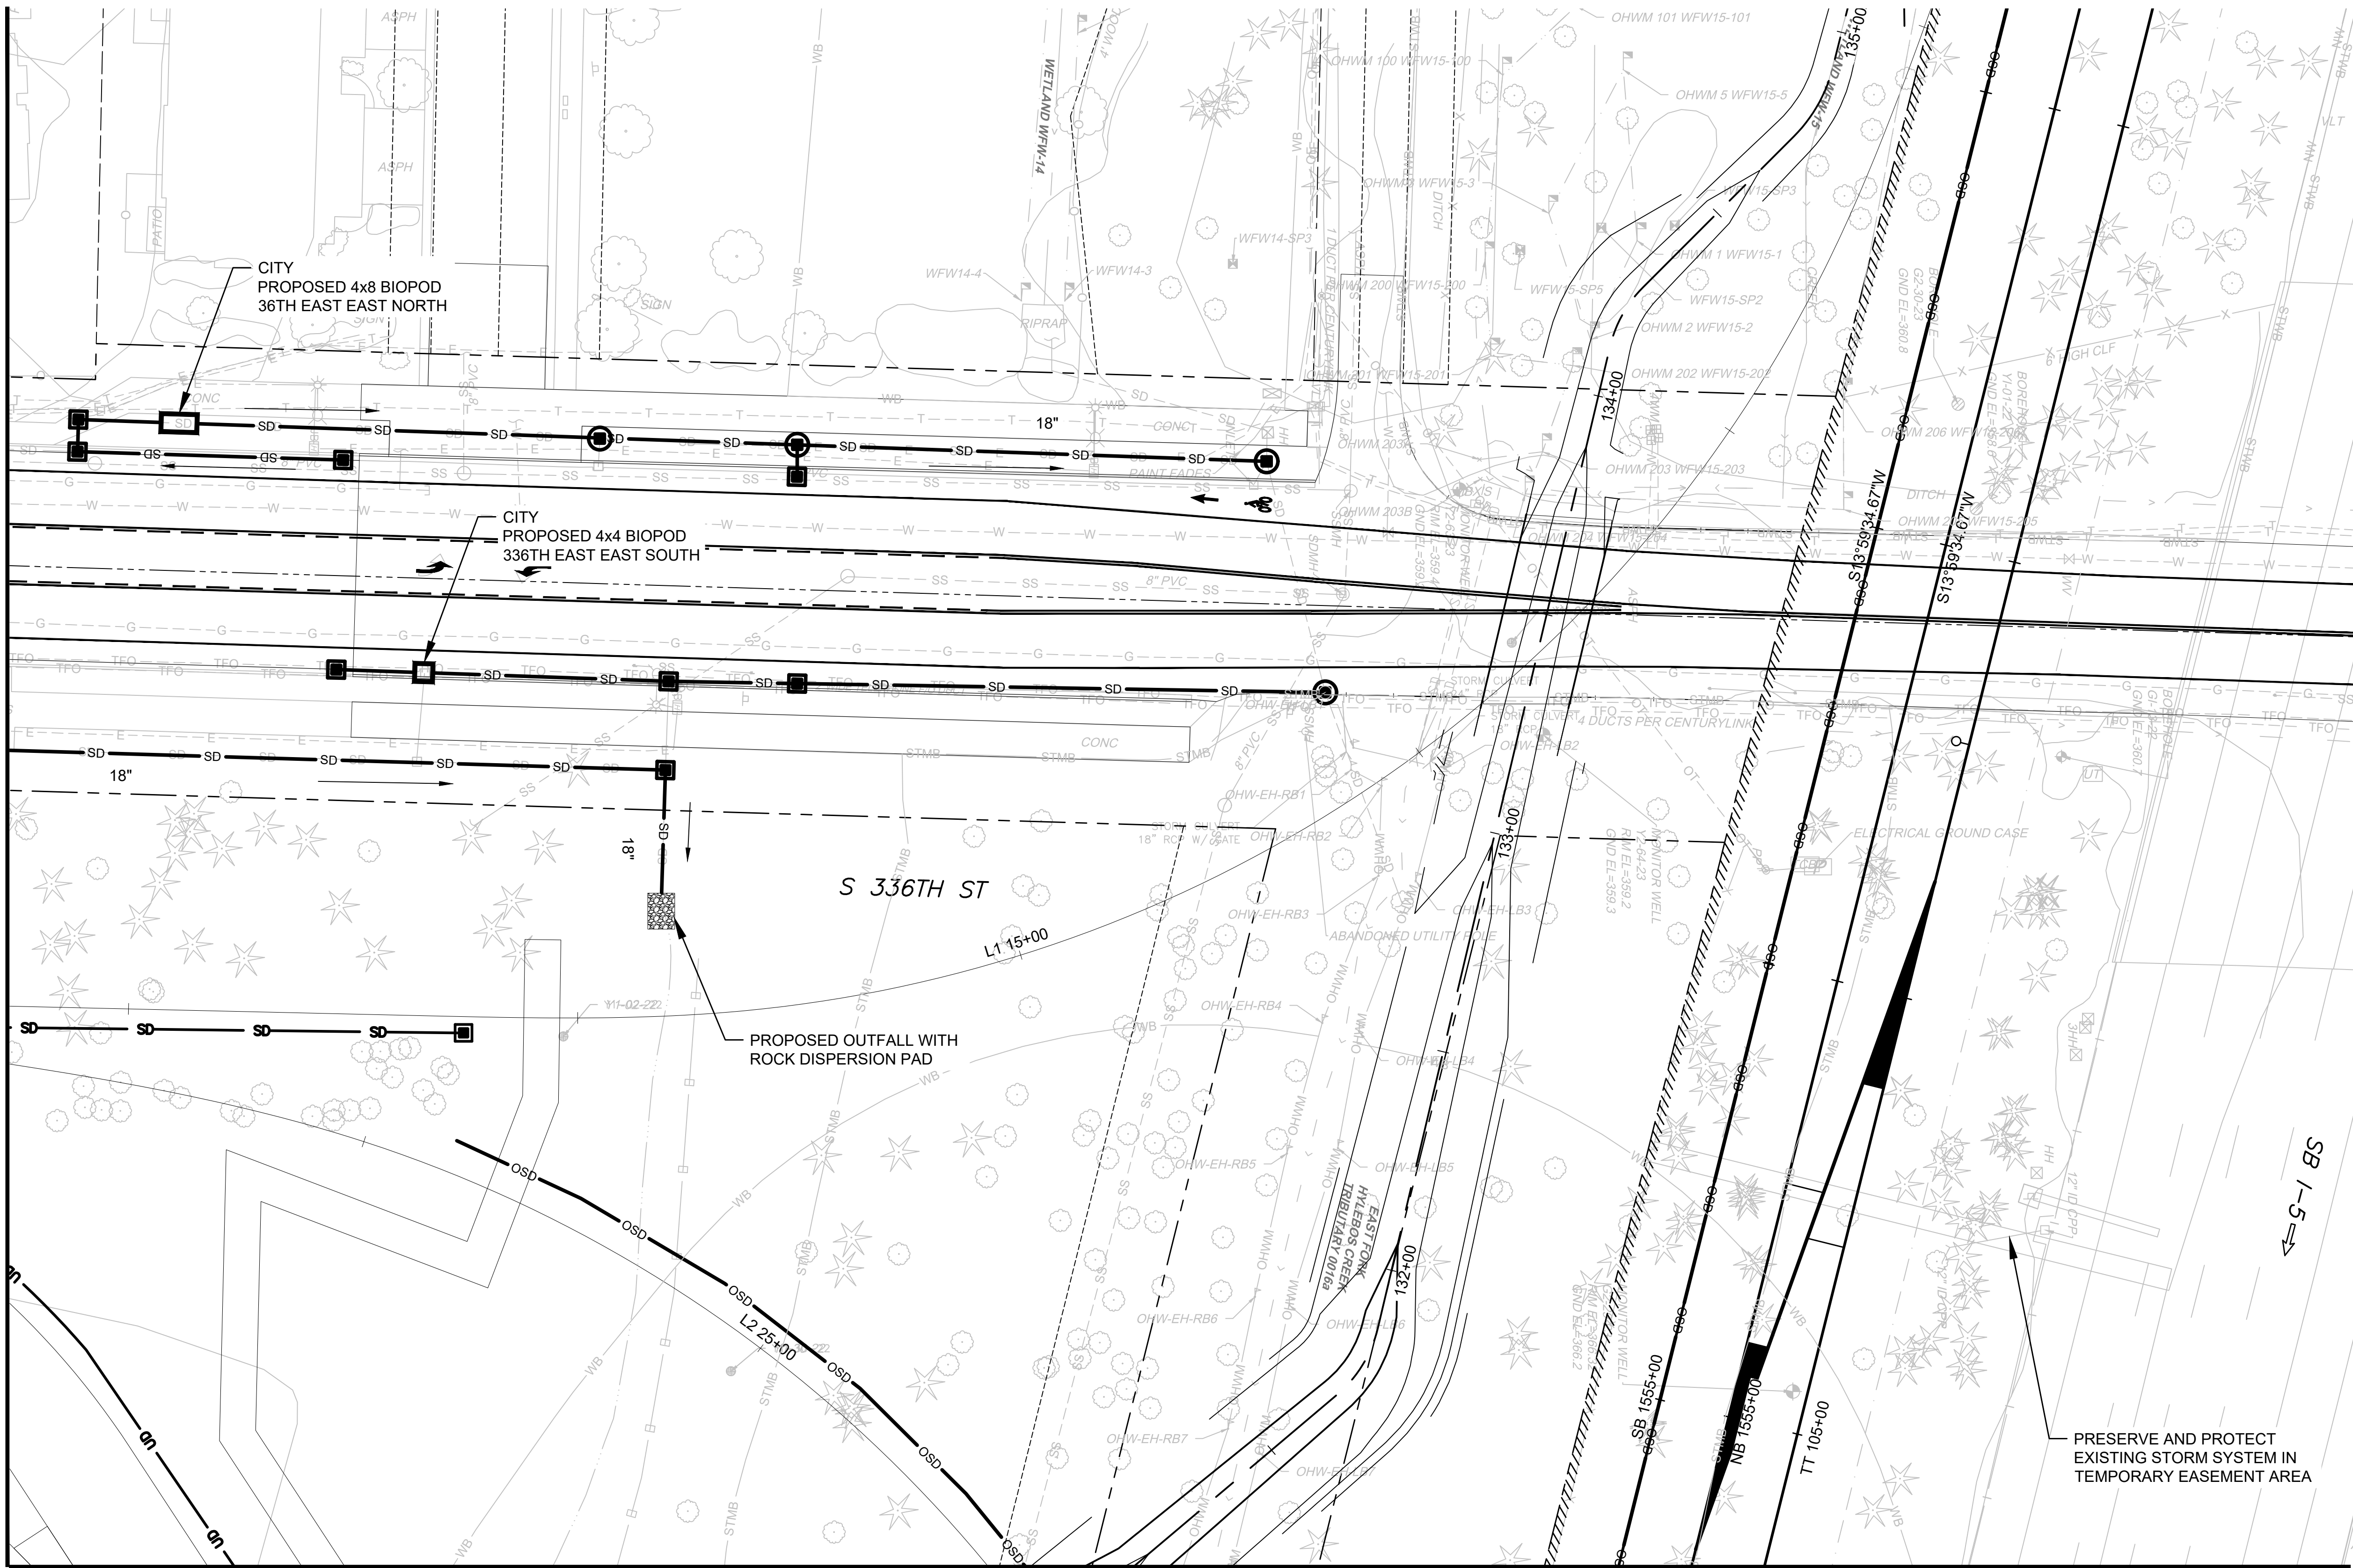

- NOTES:**
- REMOVE EXISTING STORM DRAINS AND DRAINAGE STRUCTURES AT CONFLICTS WITH PROPOSED STORM DRAIN, PROPOSED DRAINAGE STRUCTURES, OR PROPOSED STORMWATER FACILITIES. RELOCATE STORM DRAINS OR REPLACE EXISTING DRAINAGE STRUCTURES AS REQUIRED.
 - ALL PROPOSED UNDERGROUND STORM DRAIN 12-INCH DIAMETER UNLESS NOTED OTHERWISE.

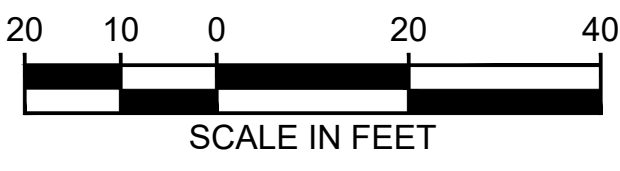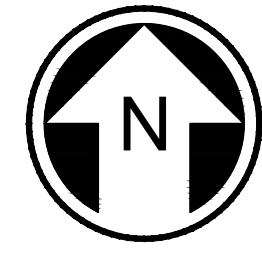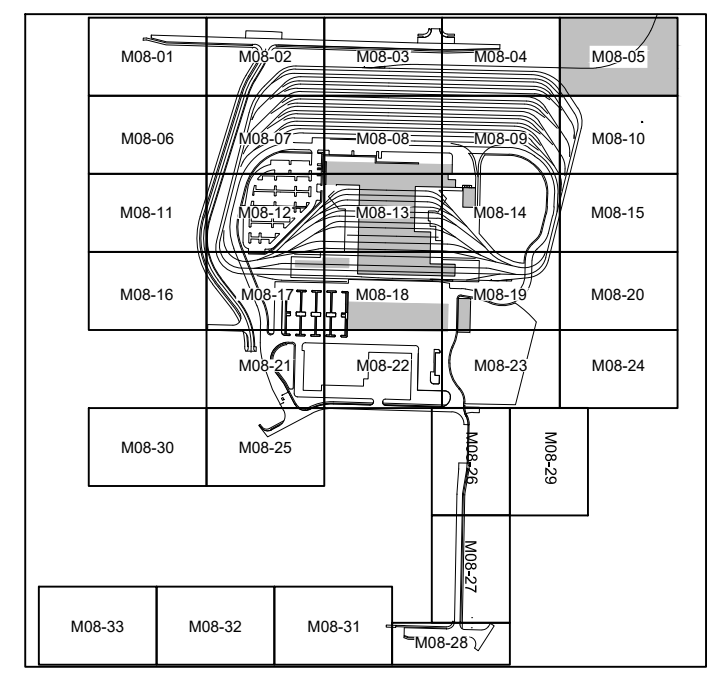


NOT FOR
CONSTRUCTION

02/21/24 | 11:55 AM | WILLIBRE
C:\PWORKING\WEST01\02772718\OMFS-M08-CDP101-134.DWG

Refer to the plan set COVER drawing
for disclaimers regarding this drawing.

REFERENCE CONCEPT DRAWINGS					
No.	DATE	DSN	CHK	APP	REVISION

DESIGNED BY:	L. GRABOWSKI
DRAWN BY:	B. WILLIAMS
CHECKED BY:	J. WRIGHT
APPROVED BY:	J.COOP

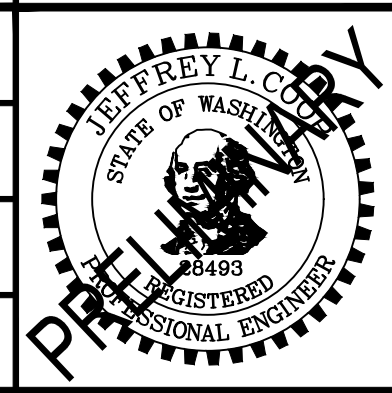

SUBMITTED BY:
PABLO LOPEZ-HILFIKER

DATE:
2/27/2024

REVIEWED BY:



DATE:


PACKAGE #
SCALE: 1"=20'
FILENAME: OMFS-M08-CDP101-134
CONTRACT No.: AE-0030-17
DATE: 2/27/2024

SOUND TRANSIT
PRELIMINARY ENGINEERING PLANS
OPERATIONS & MAINTENANCE FACILITY SOUTH

CIVIL
DRAINAGE PLAN

DRAWING No.:	M08-CDP106
FACILITY ID:	M08
SHEET No.:	REV:



MATCHLINE:
SEE DWG M08-CDP101

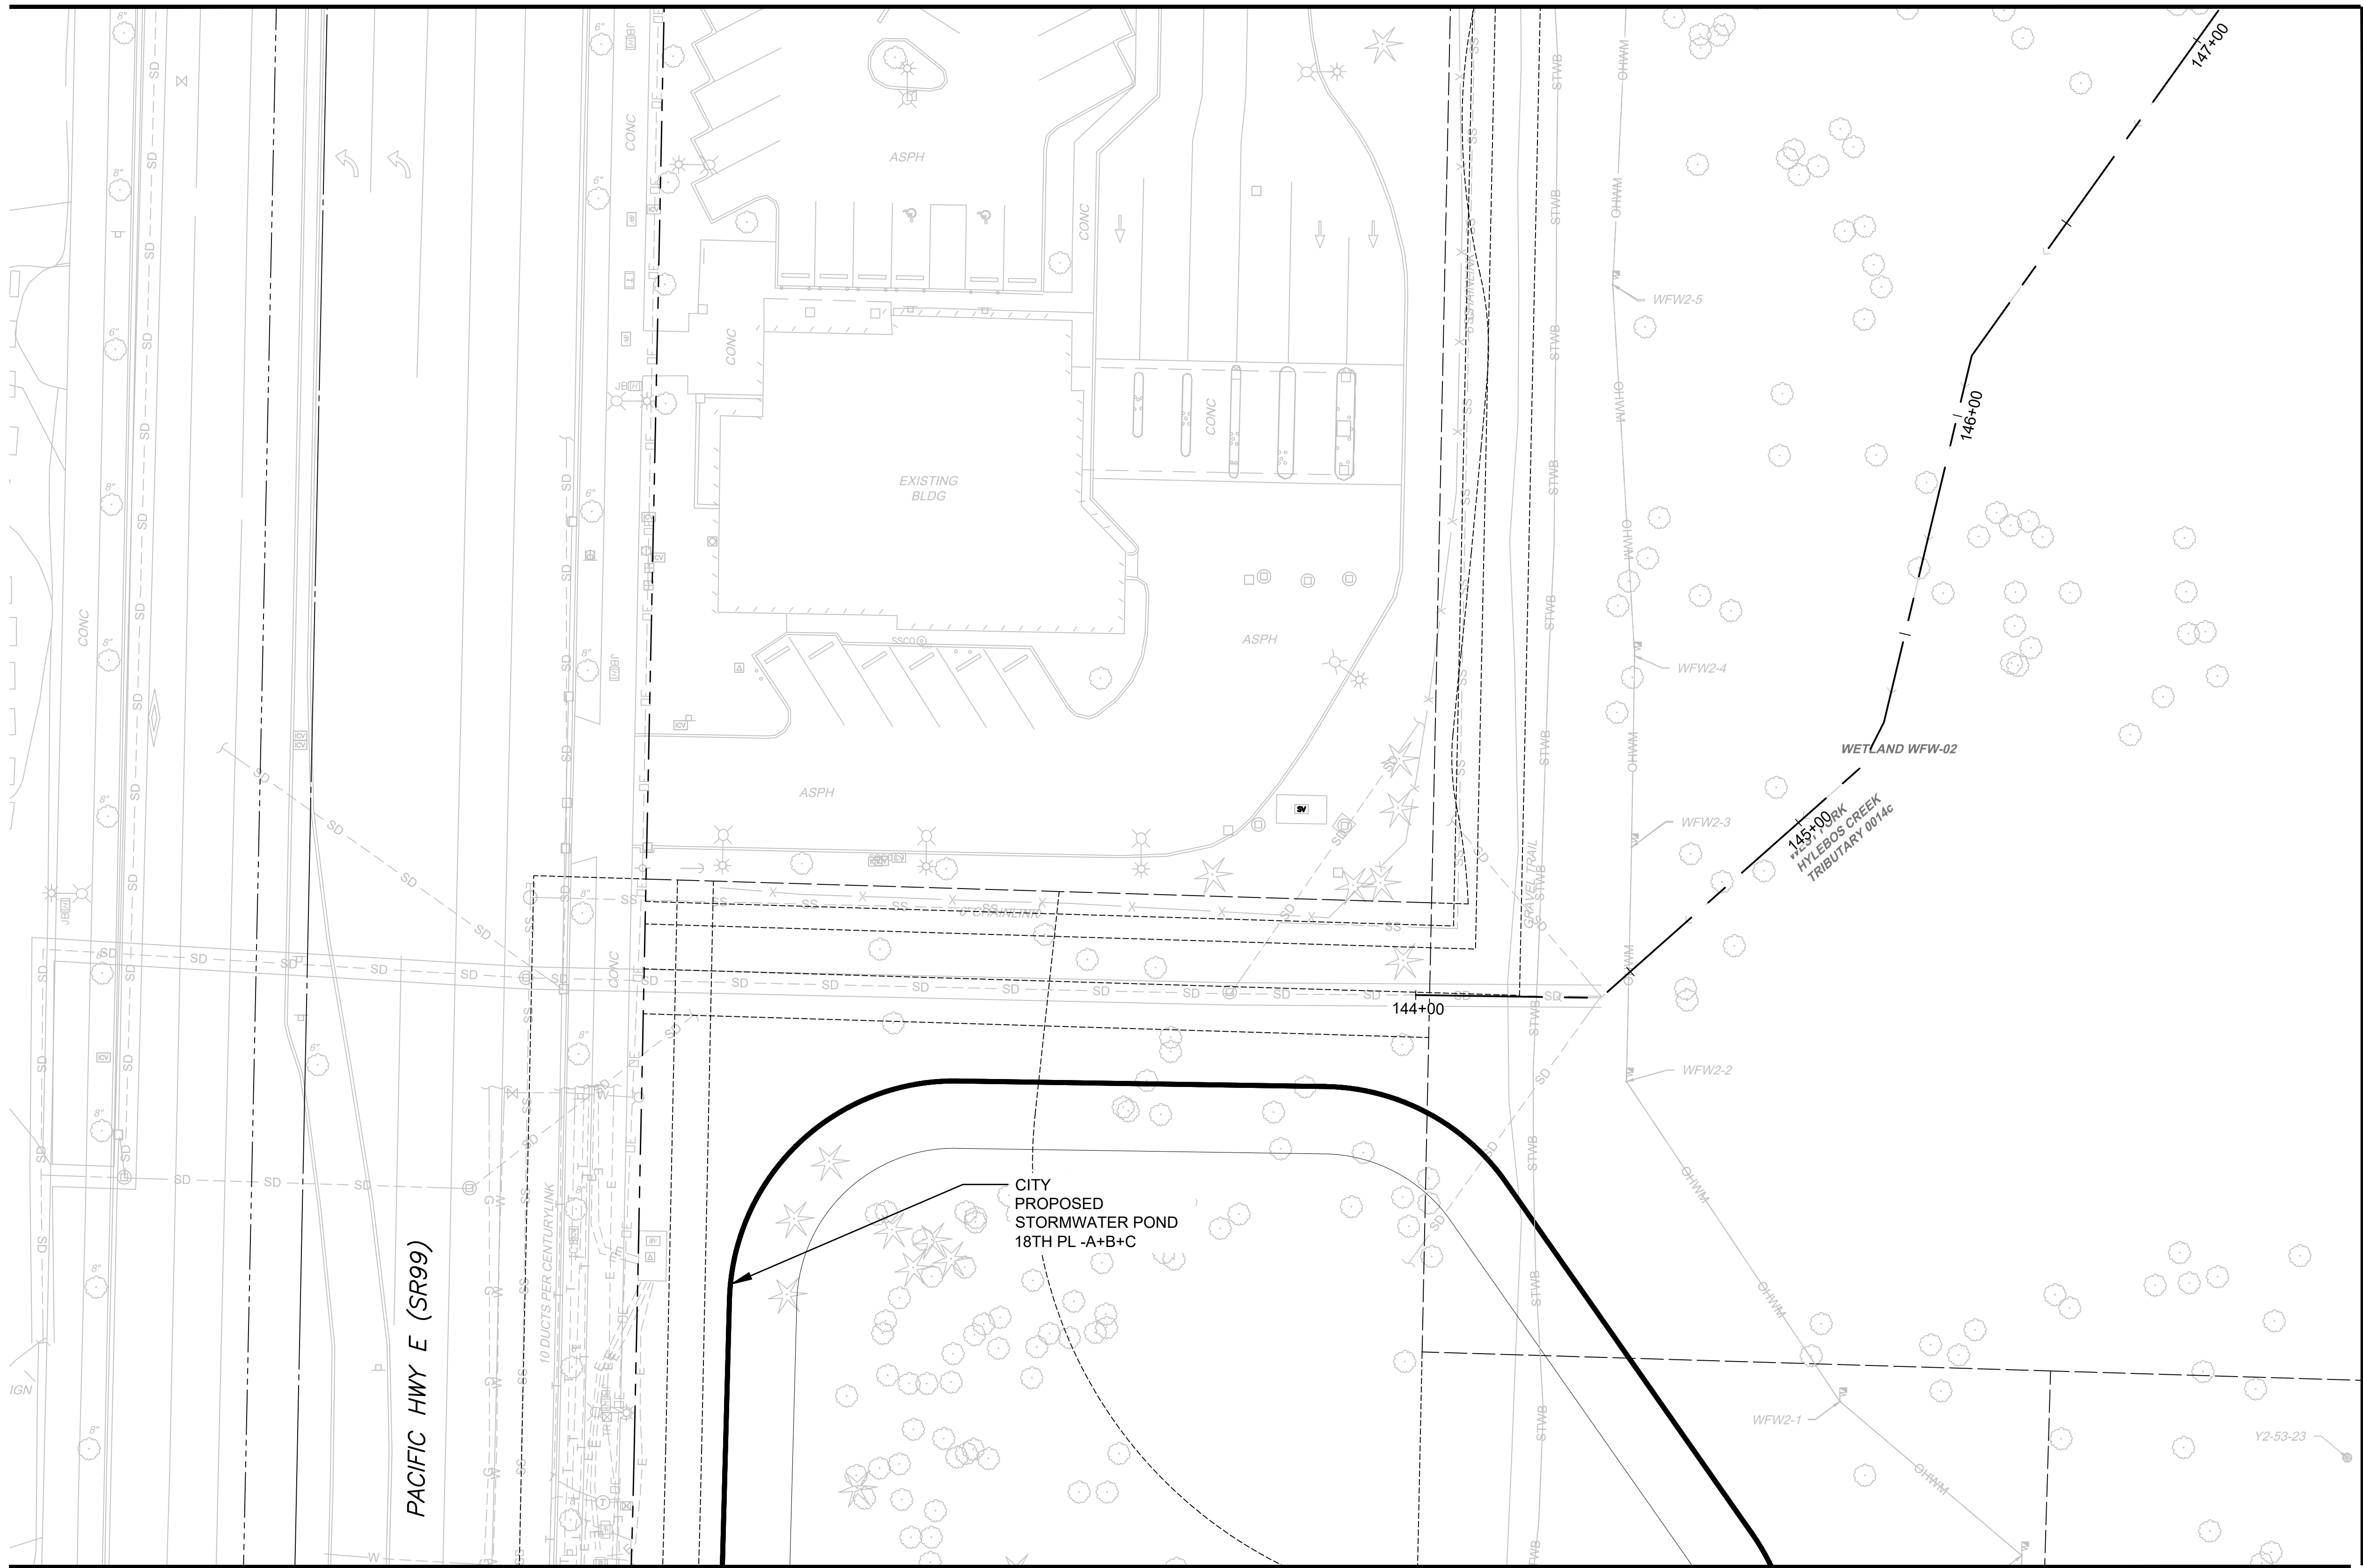

MATCHLINE:
SEE DWG M08-CDP111

- NOTES:**
- REMOVE EXISTING STORM DRAINS AND DRAINAGE STRUCTURES AT CONFLICTS WITH PROPOSED STORM DRAIN, PROPOSED DRAINAGE STRUCTURES, OR PROPOSED STORMWATER FACILITIES. RELOCATE STORM DRAINS OR REPLACE EXISTING DRAINAGE STRUCTURES AS REQUIRED.
 - ALL PROPOSED UNDERGROUND STORM DRAIN 12-INCH DIAMETER UNLESS NOTED OTHERWISE.

MATCHLINE:
SEE DWG M08-CDP107

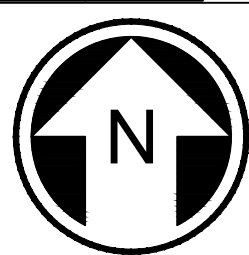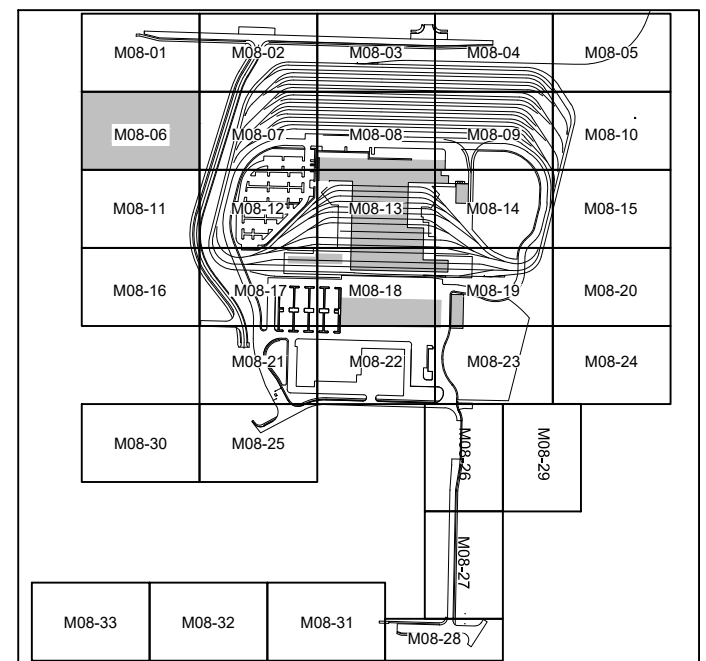


NOT FOR
CONSTRUCTION

02/21/24 | 11:55 AM | WILLIBRE
C:\PWORKING\WEST01\02772718\OMFS-M08-CDP\01-134.DWG

MATCHLINE:
SEE DWG M08-CDP106



MATCHLINE:
SEE DWG M08-CDP102

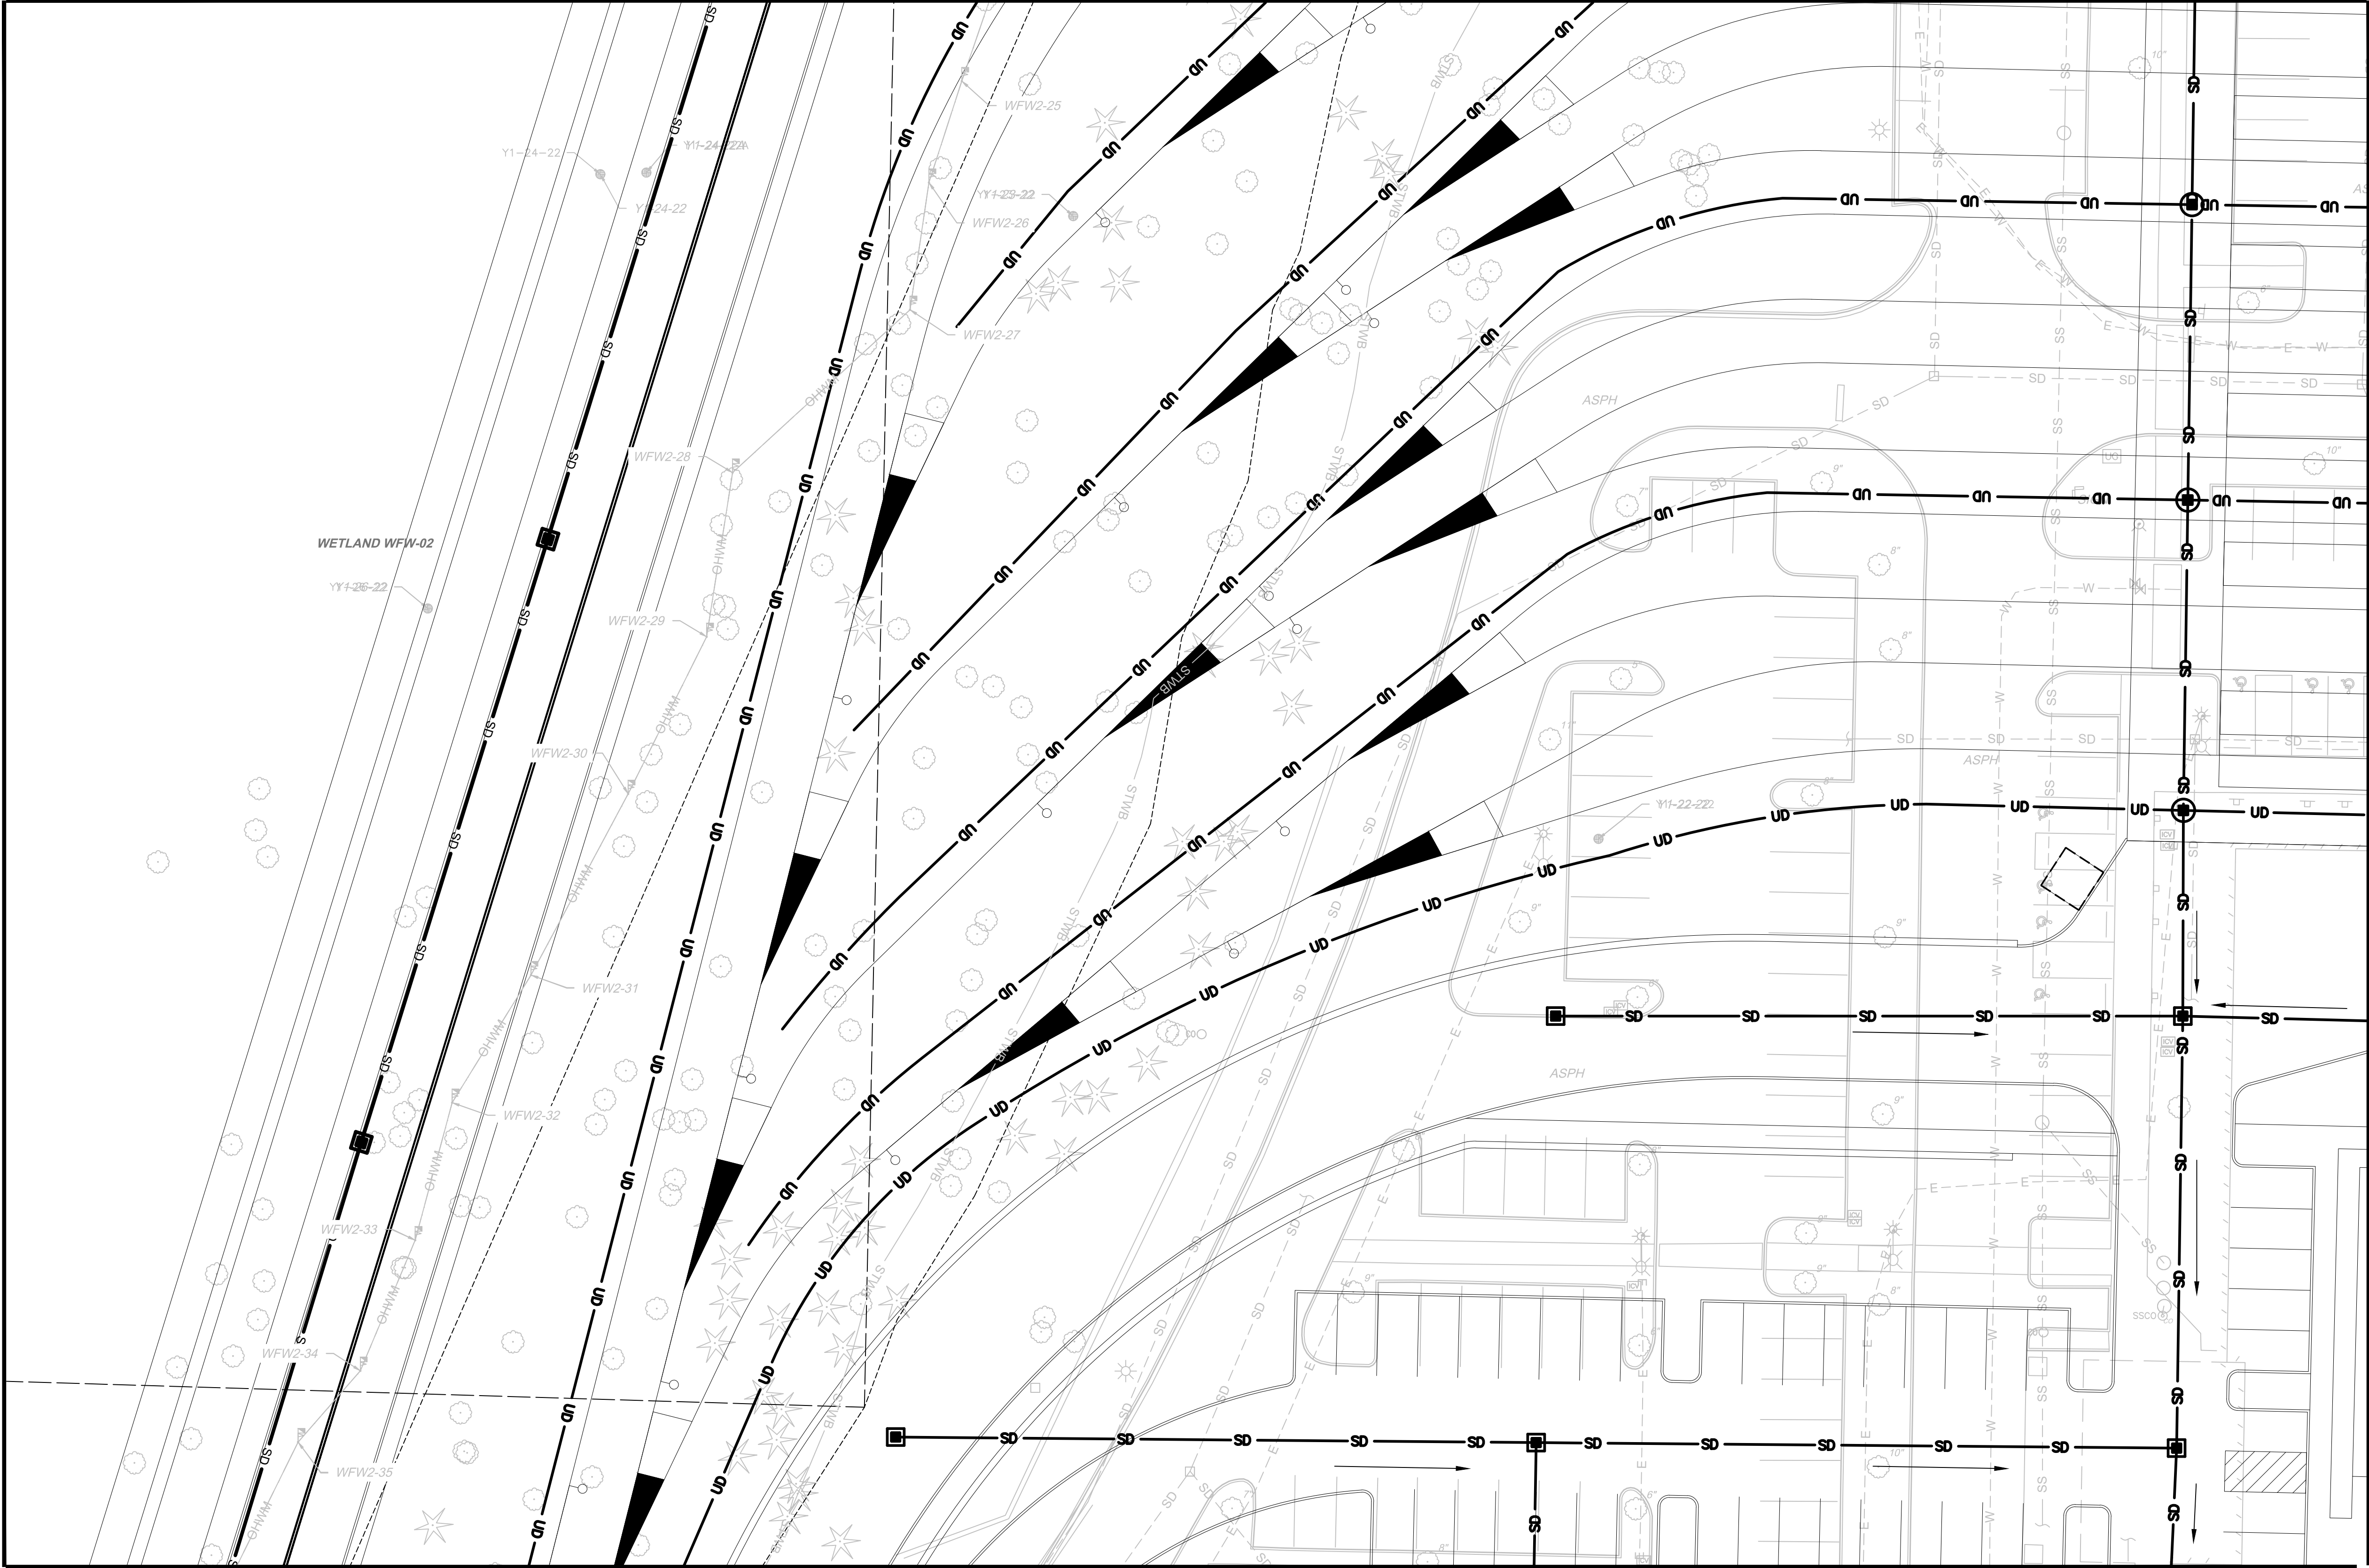

MATCHLINE:
SEE DWG M08-CDP108

NOTES:

1. REMOVE EXISTING STORM DRAINS AND DRAINAGE STRUCTURES AT CONFLICTS WITH PROPOSED STORM DRAIN, PROPOSED DRAINAGE STRUCTURES, OR PROPOSED STORMWATER FACILITIES. RELOCATE STORM DRAINS OR REPLACE EXISTING DRAINAGE STRUCTURES AS REQUIRED.
2. ALL PROPOSED UNDERGROUND STORM DRAIN 12-INCH DIAMETER UNLESS NOTED OTHERWISE.

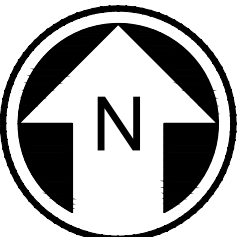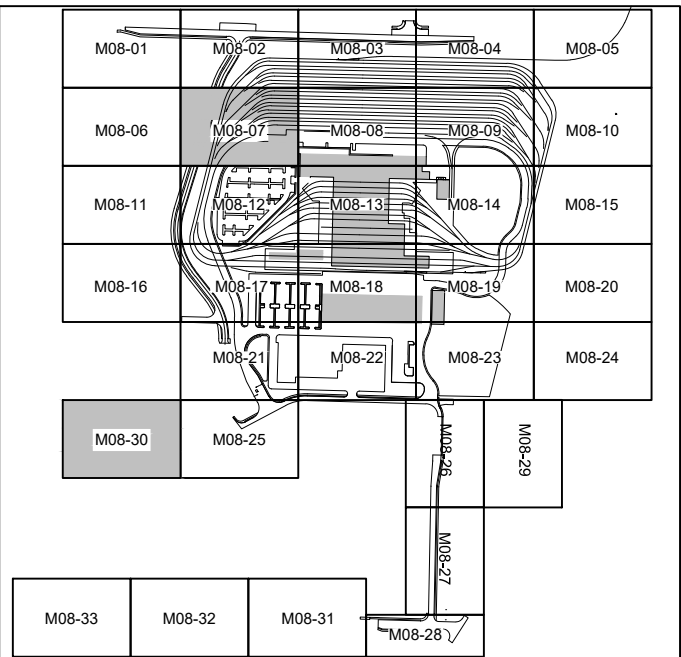



NOT FOR
CONSTRUCTION

Refer to the plan set COVER drawing
for disclaimers regarding this drawing.

REFERENCE CONCEPT DRAWINGS

No.	DATE	DSN	CHK	APP	REVISION

DESIGNED BY:
L. GRABOWSKI
DRAWN BY:
B. WILLIAMS
CHECKED BY:
J. WRIGHT
APPROVED BY:
J. COOP

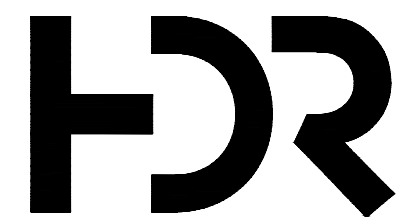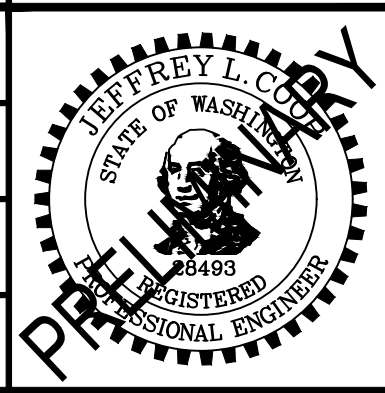

SUBMITTED BY:
PABLO LOPEZ-HILFIKER

DATE:
2/27/2024

REVIEWED BY:

LINE IS 1" AT
FULL SCALE



DATE:

PACKAGE #

SCALE:
1"=20'
FILENAME:
OMFS-M08-CDP101-134
CONTRACT No.:
AE-0030-17
DATE:
2/27/2024


**SOUND TRANSIT
PRELIMINARY ENGINEERING PLANS**
OPERATIONS & MAINTENANCE FACILITY SOUTH
CIVIL
DRAINAGE PLAN

DRAWING No.:
M08-CDP107
FACILITY ID:
M08
SHEET No.: REV:

02/21/24 | 11:56 AM | WILLIBRE
C:\PWORKING\WEST01\DWG\OMFS-M08-CDP101-134.DWG



MATCHLINE:
SEE DWG M08-CDP107

MATCHLINE:
SEE DWG M08-CDP103

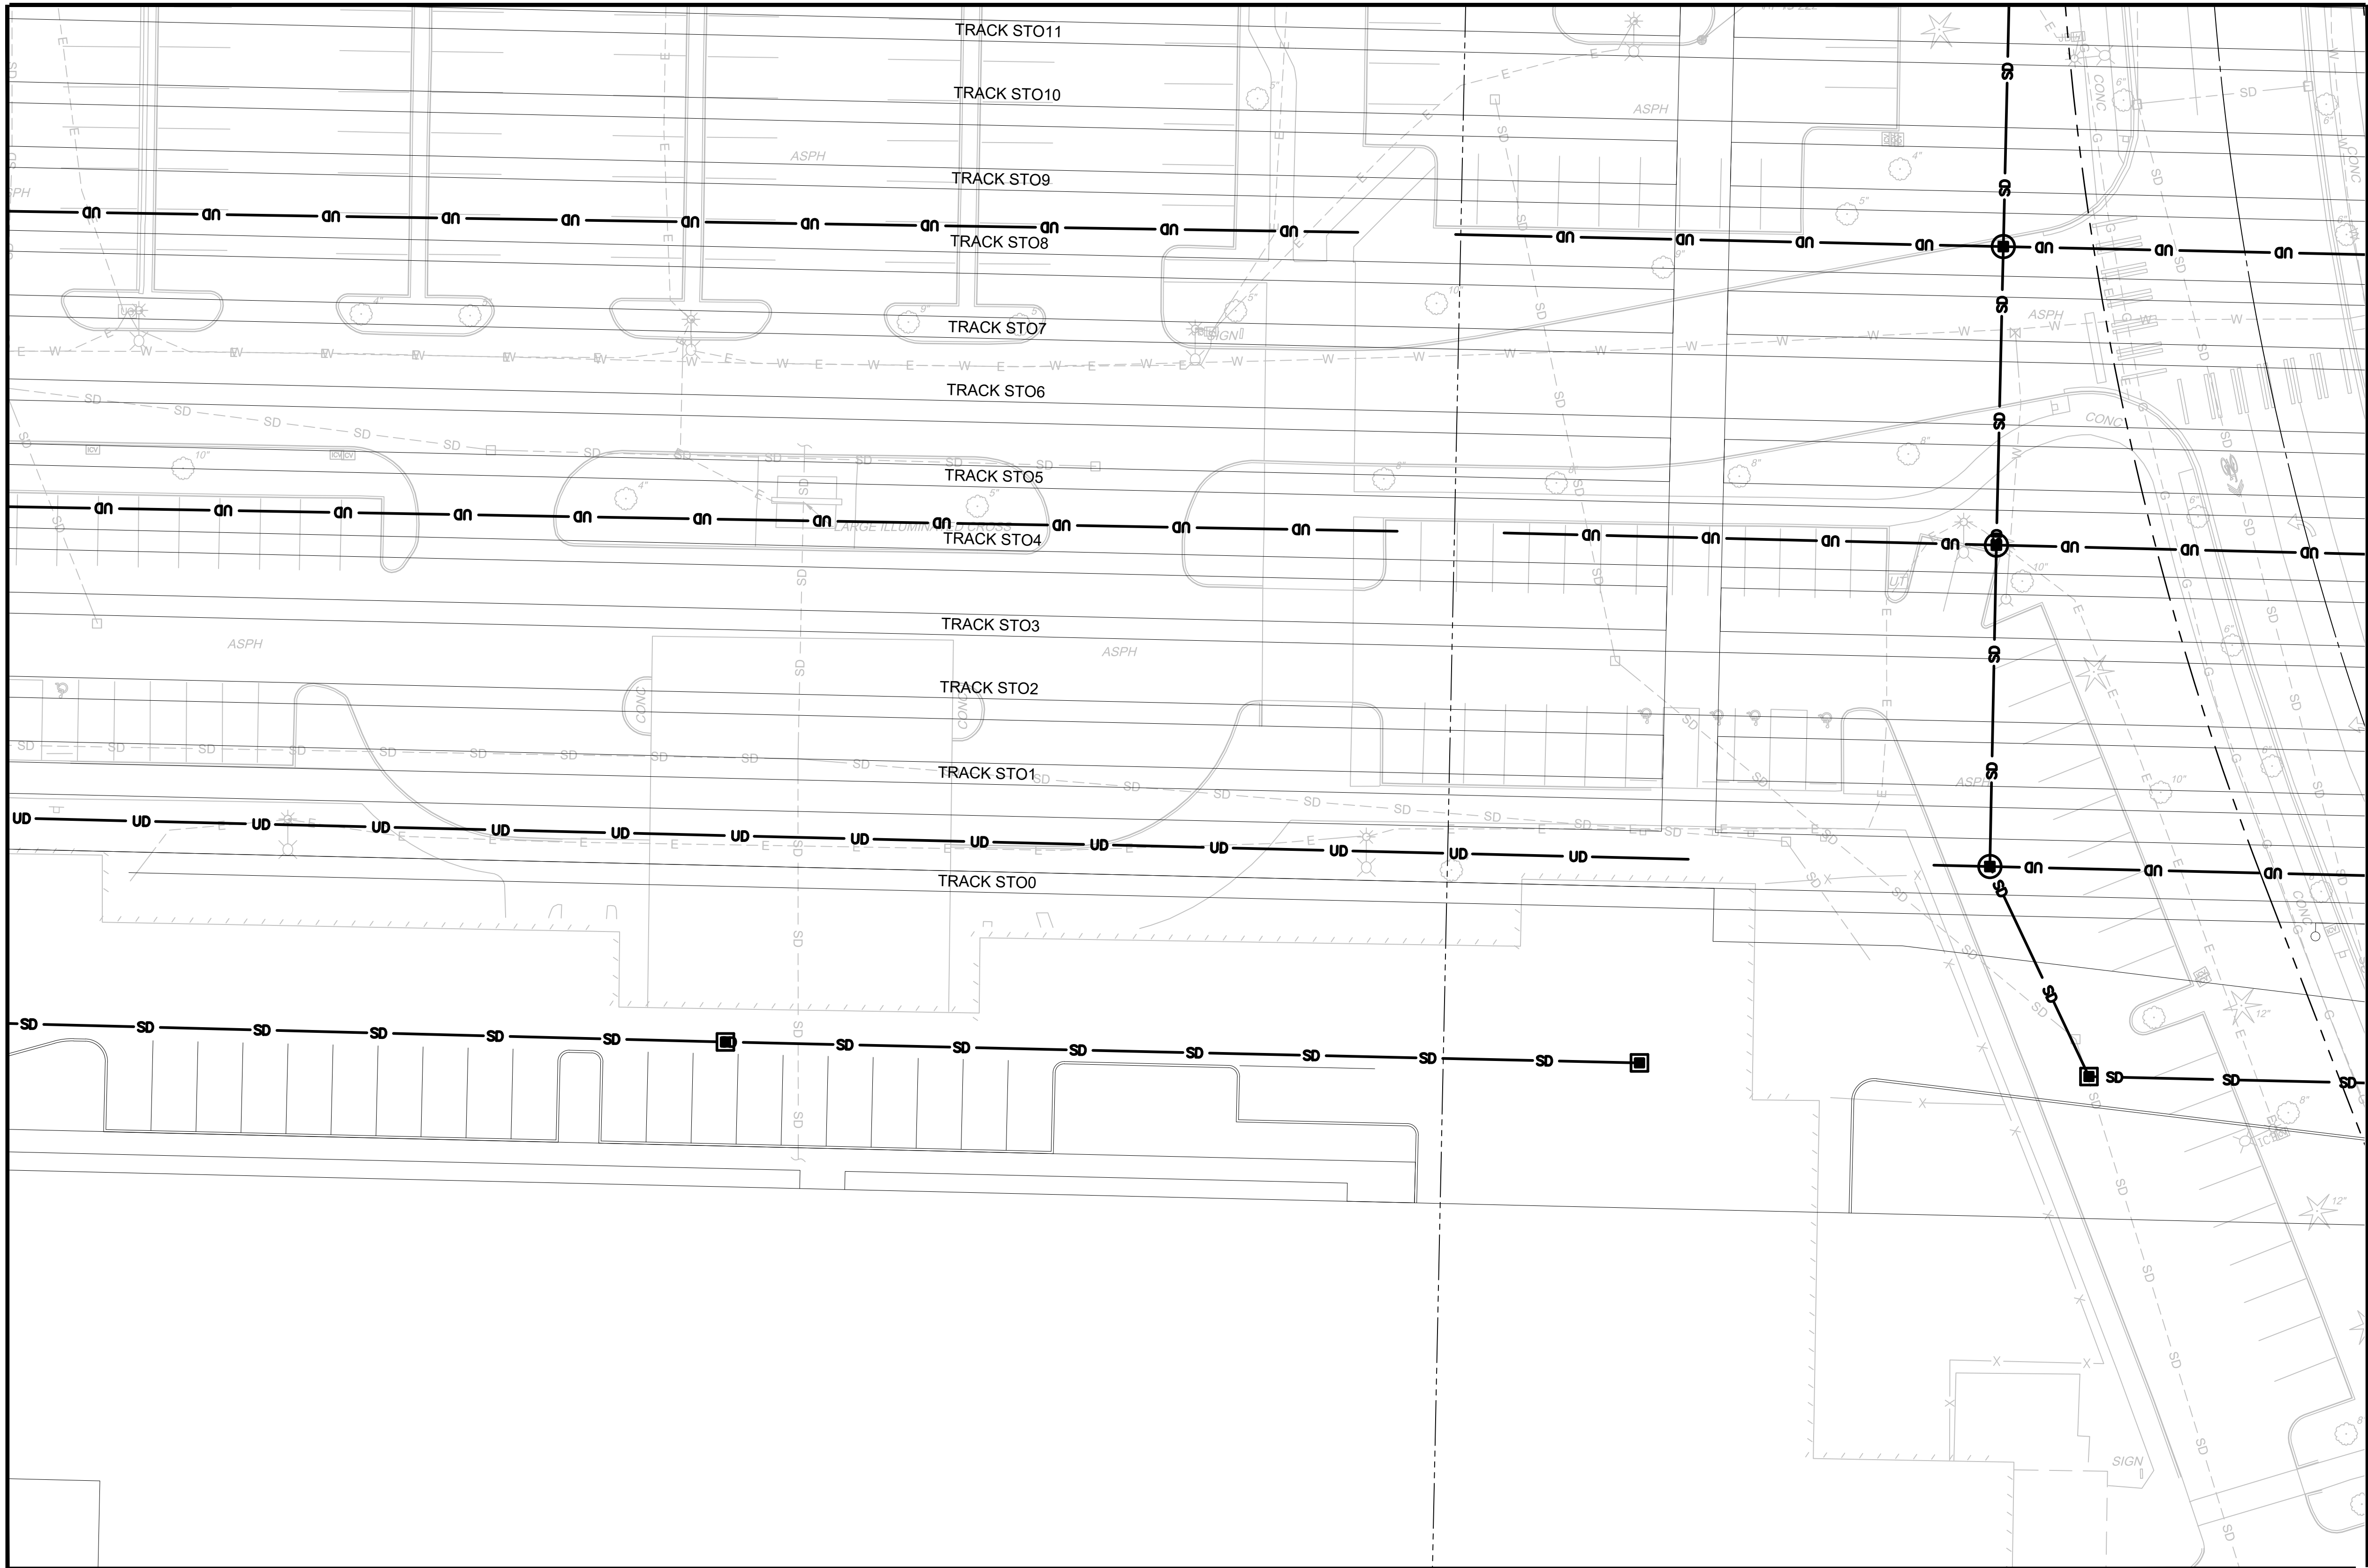

MATCHLINE:
SEE DWG M08-CDP109

- NOTES:**
1. REMOVE EXISTING STORM DRAINS AND DRAINAGE STRUCTURES AT CONFLICTS WITH PROPOSED STORM DRAIN, PROPOSED DRAINAGE STRUCTURES, OR PROPOSED STORMWATER FACILITIES. RELOCATE STORM DRAINS OR REPLACE EXISTING DRAINAGE STRUCTURES AS REQUIRED.
 2. ALL PROPOSED UNDERGROUND STORM DRAIN 12-INCH DIAMETER UNLESS NOTED OTHERWISE.

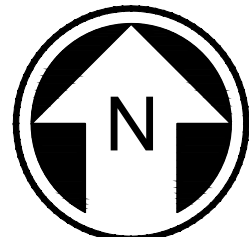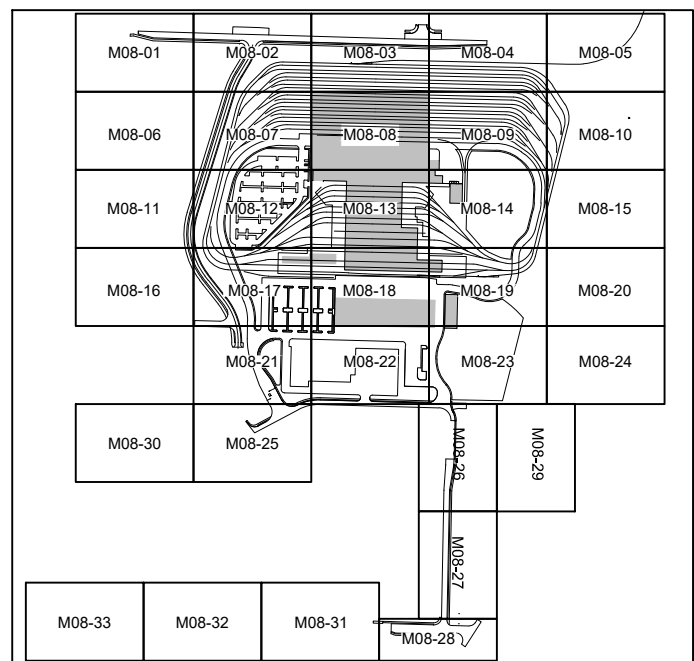

NOT FOR
CONSTRUCTION



Refer to the plan set COVER drawing
for disclaimers regarding this drawing.

MATCHLINE:
SEE DWG M08-CDP113

REFERENCE CONCEPT DRAWINGS

No.	DATE	DSN	CHK	APP	REVISION

DESIGNED BY:
L. GRABOWSKI
DRAWN BY:
B. WILLIAMS
CHECKED BY:
J. WRIGHT
APPROVED BY:
J.COOP

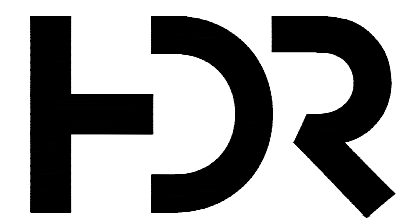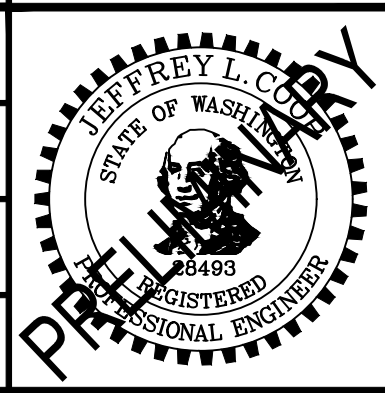

SUBMITTED BY:
PABLO LOPEZ-HILFIKER

DATE:
2/27/2024

REVIEWED BY:

LINE IS 1" AT
FULL SCALE



DATE:

PACKAGE

SCALE:
1"=20'
FILENAME:
OMFS-M08-CDP101-134
CONTRACT No.:
AE-0030-17
DATE:
2/27/2024

SOUND TRANSIT
PRELIMINARY ENGINEERING PLANS
OPERATIONS & MAINTENANCE FACILITY SOUTH

CIVIL
DRAINAGE PLAN


DRAWING No.:
M08-CDP108
FACILITY ID:
M08
SHEET No.: REV:

02/21/24 | 11:56 AM | WILLIBRE
C:\PWORKING\WEST01\DWG\OMFS-M08-CDP101-134.DWG

Refer to the plan set COVER drawing
for disclaimers regarding this drawing.

REFERENCE CONCEPT DRAWINGS					
No.	DATE	DSN	CHK	APP	REVISION

DESIGNED BY:	L. GRABOWSKI
DRAWN BY:	B. WILLIAMS
CHECKED BY:	J. WRIGHT
APPROVED BY:	J.COOP

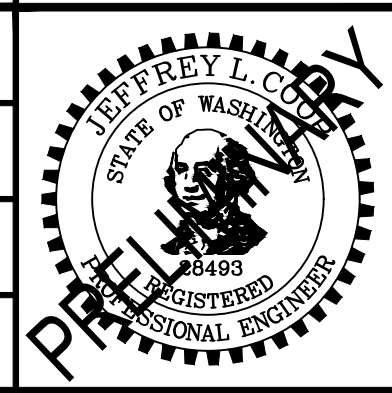

SUBMITTED BY:
PABLO LOPEZ-HILFIKER

DATE:
2/27/2024

REVIEWED BY:



DATE:

PACKAGE #
SCALE: 1"=20'
FILENAME: OMFS-M08-CDP101-134
CONTRACT No.: AE-0030-17
DATE: 2/27/2024


SOUND TRANSIT
PRELIMINARY ENGINEERING PLANS
OPERATIONS & MAINTENANCE FACILITY SOUTH

CIVIL
DRAINAGE PLAN

DRAWING No.:	M08-CDP109
FACILITY ID:	M08
SHEET No.:	REV:



MATCHLINE:
SEE DWG M08-CDP104

MATCHLINE:
SEE DWG M08-CDP108

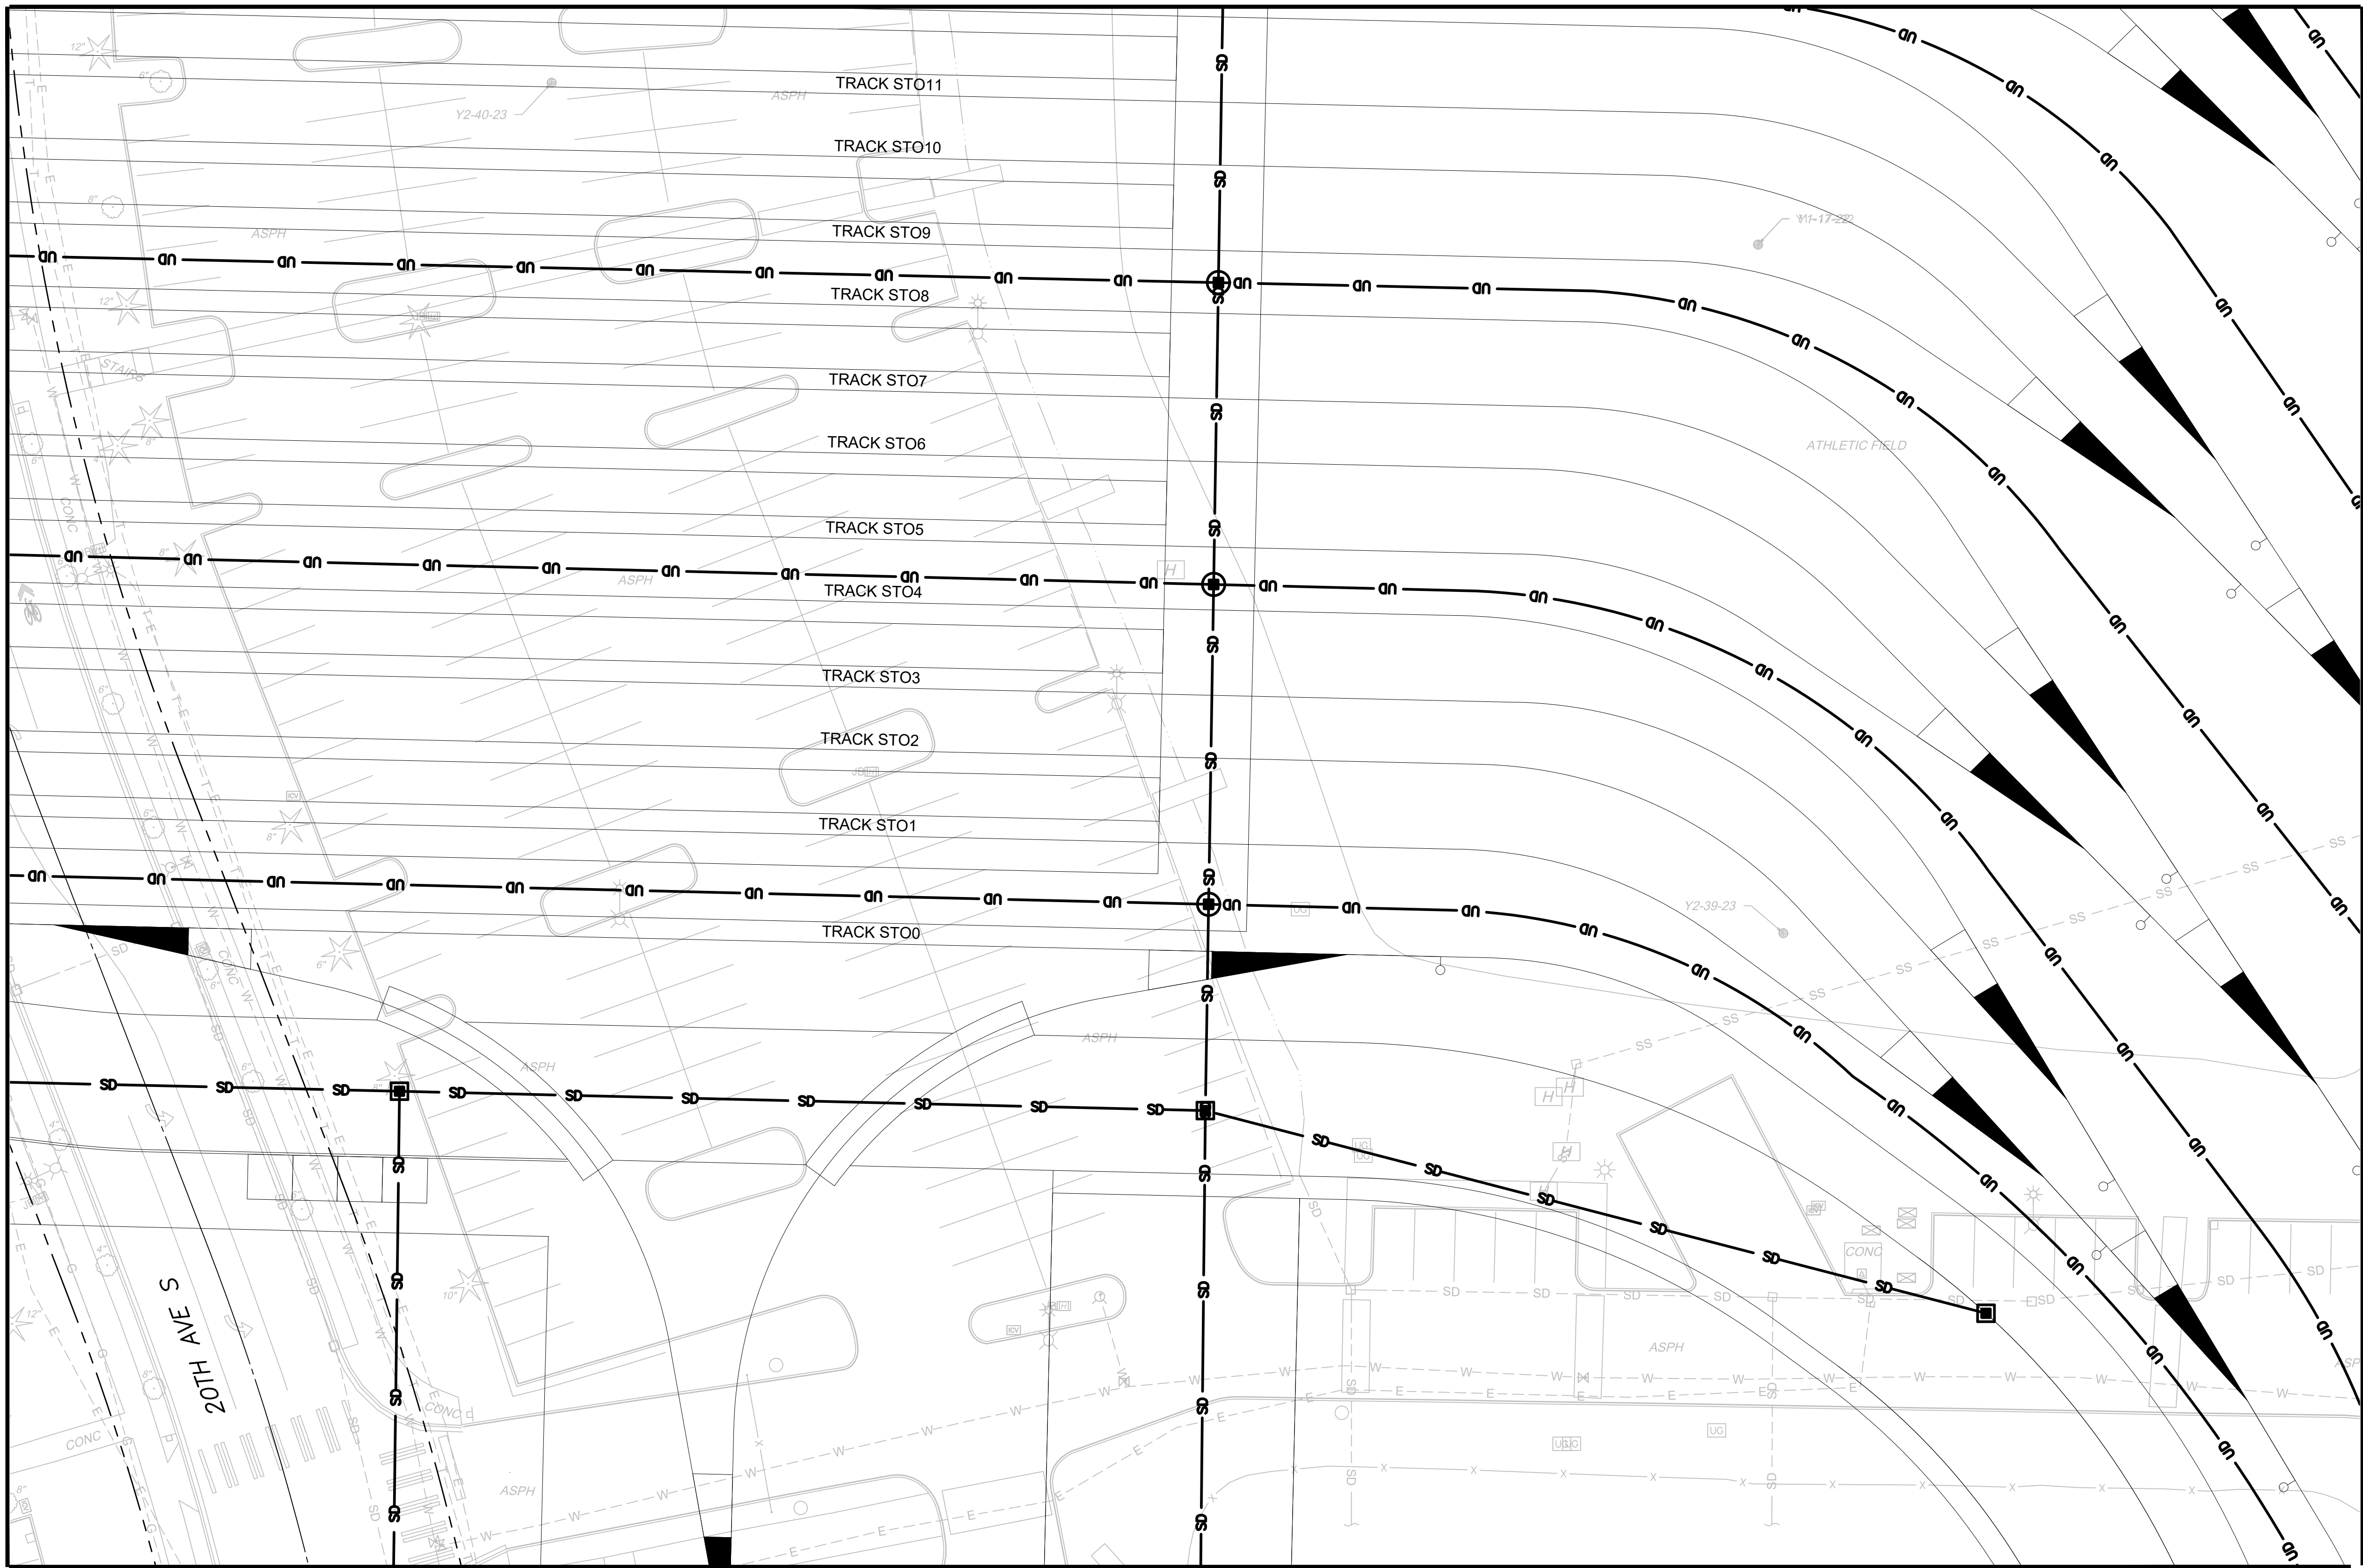

MATCHLINE:
SEE DWG M08-CDP110

- NOTES:**
- REMOVE EXISTING STORM DRAINS AND DRAINAGE STRUCTURES AT CONFLICTS WITH PROPOSED STORM DRAIN, PROPOSED DRAINAGE STRUCTURES, OR PROPOSED STORMWATER FACILITIES. RELOCATE STORM DRAINS OR REPLACE EXISTING DRAINAGE STRUCTURES AS REQUIRED.
 - ALL PROPOSED UNDERGROUND STORM DRAIN 12-INCH DIAMETER UNLESS NOTED OTHERWISE.

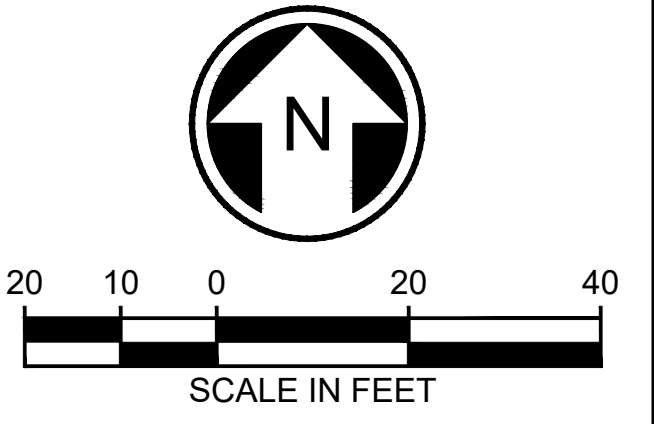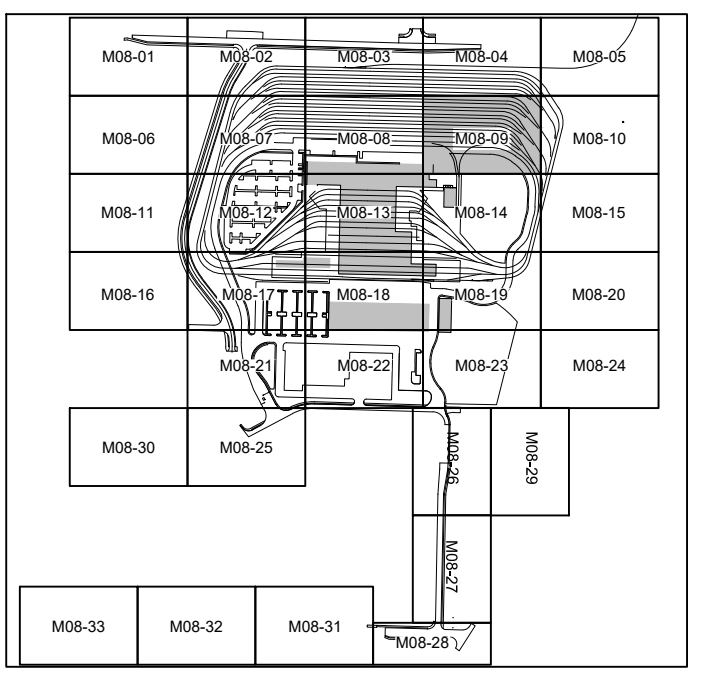

NOT FOR
CONSTRUCTION

02/21/24 | 11:56 AM | WILLIBRE
C:\PWORKING\WEST01\DWG\OMFS-M08-CDP101-134.DWG

MATCHLINE:
SEE DWG M08-CDP109



MATCHLINE:
SEE DWG M08-CDP105

MATCHLINE:
SEE DWG M08-CDP115

NOTES:

1. REMOVE EXISTING STORM DRAINS AND DRAINAGE STRUCTURES AT CONFLICTS WITH PROPOSED STORM DRAIN, PROPOSED DRAINAGE STRUCTURES, OR PROPOSED STORMWATER FACILITIES. RELOCATE STORM DRAINS OR REPLACE EXISTING DRAINAGE STRUCTURES AS REQUIRED.
2. ALL PROPOSED UNDERGROUND STORM DRAIN 12-INCH DIAMETER UNLESS NOTED OTHERWISE.

PRESERVE AND PROTECT
EXISTING STORM SYSTEM IN
TEMPORARY EASEMENT AREA

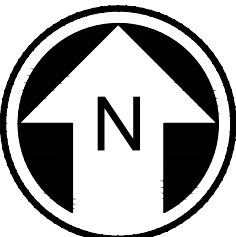
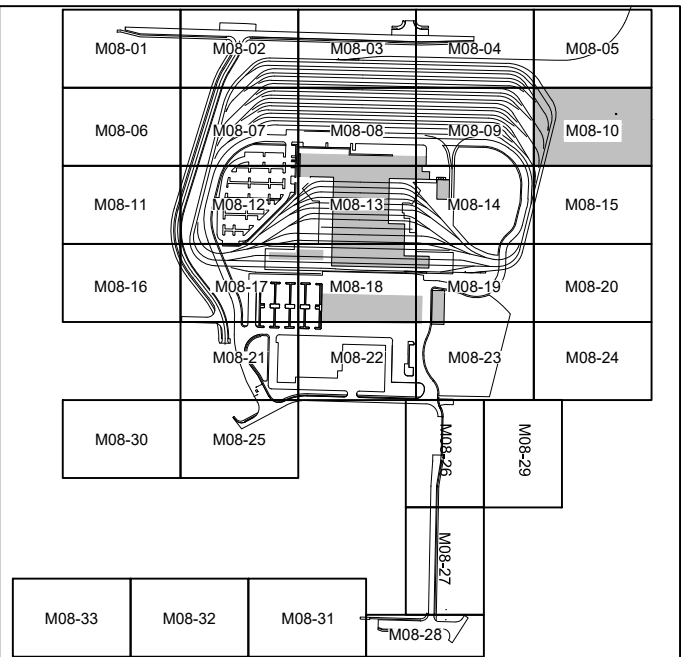


NOT FOR
CONSTRUCTION

Refer to the plan set COVER drawing
for disclaimers regarding this drawing.

REFERENCE CONCEPT DRAWINGS

DESIGNED BY:
L. GRABOWSKI
DRAWN BY:
B. WILLIAMS
CHECKED BY:
J. WRIGHT
APPROVED BY:
J.COOP

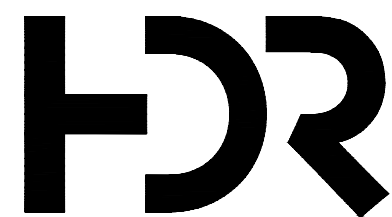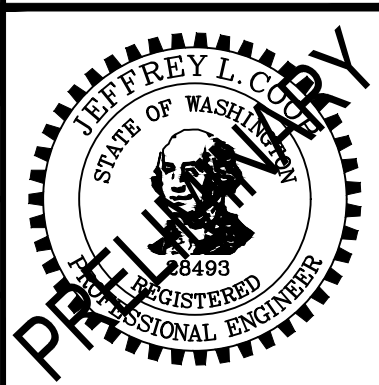

SUBMITTED BY:
PABLO LOPEZ-HILFIKER

DATE:
2/27/2024

REVIEWED BY:



DATE:


PACKAGE #

SCALE:
1"=20'
FILENAME:
OMFS-M08-CDP101-134
CONTRACT No.:
AE-0030-17
DATE:
2/27/2024

SOUND TRANSIT
PRELIMINARY ENGINEERING PLANS
OPERATIONS & MAINTENANCE FACILITY SOUTH
CIVIL
DRAINAGE PLAN

DRAWING No.:
M08-CDP110
FACILITY ID:
M08
SHEET No.: REV:



**MATCHLINE:
SEE DWG M08-CDP106**

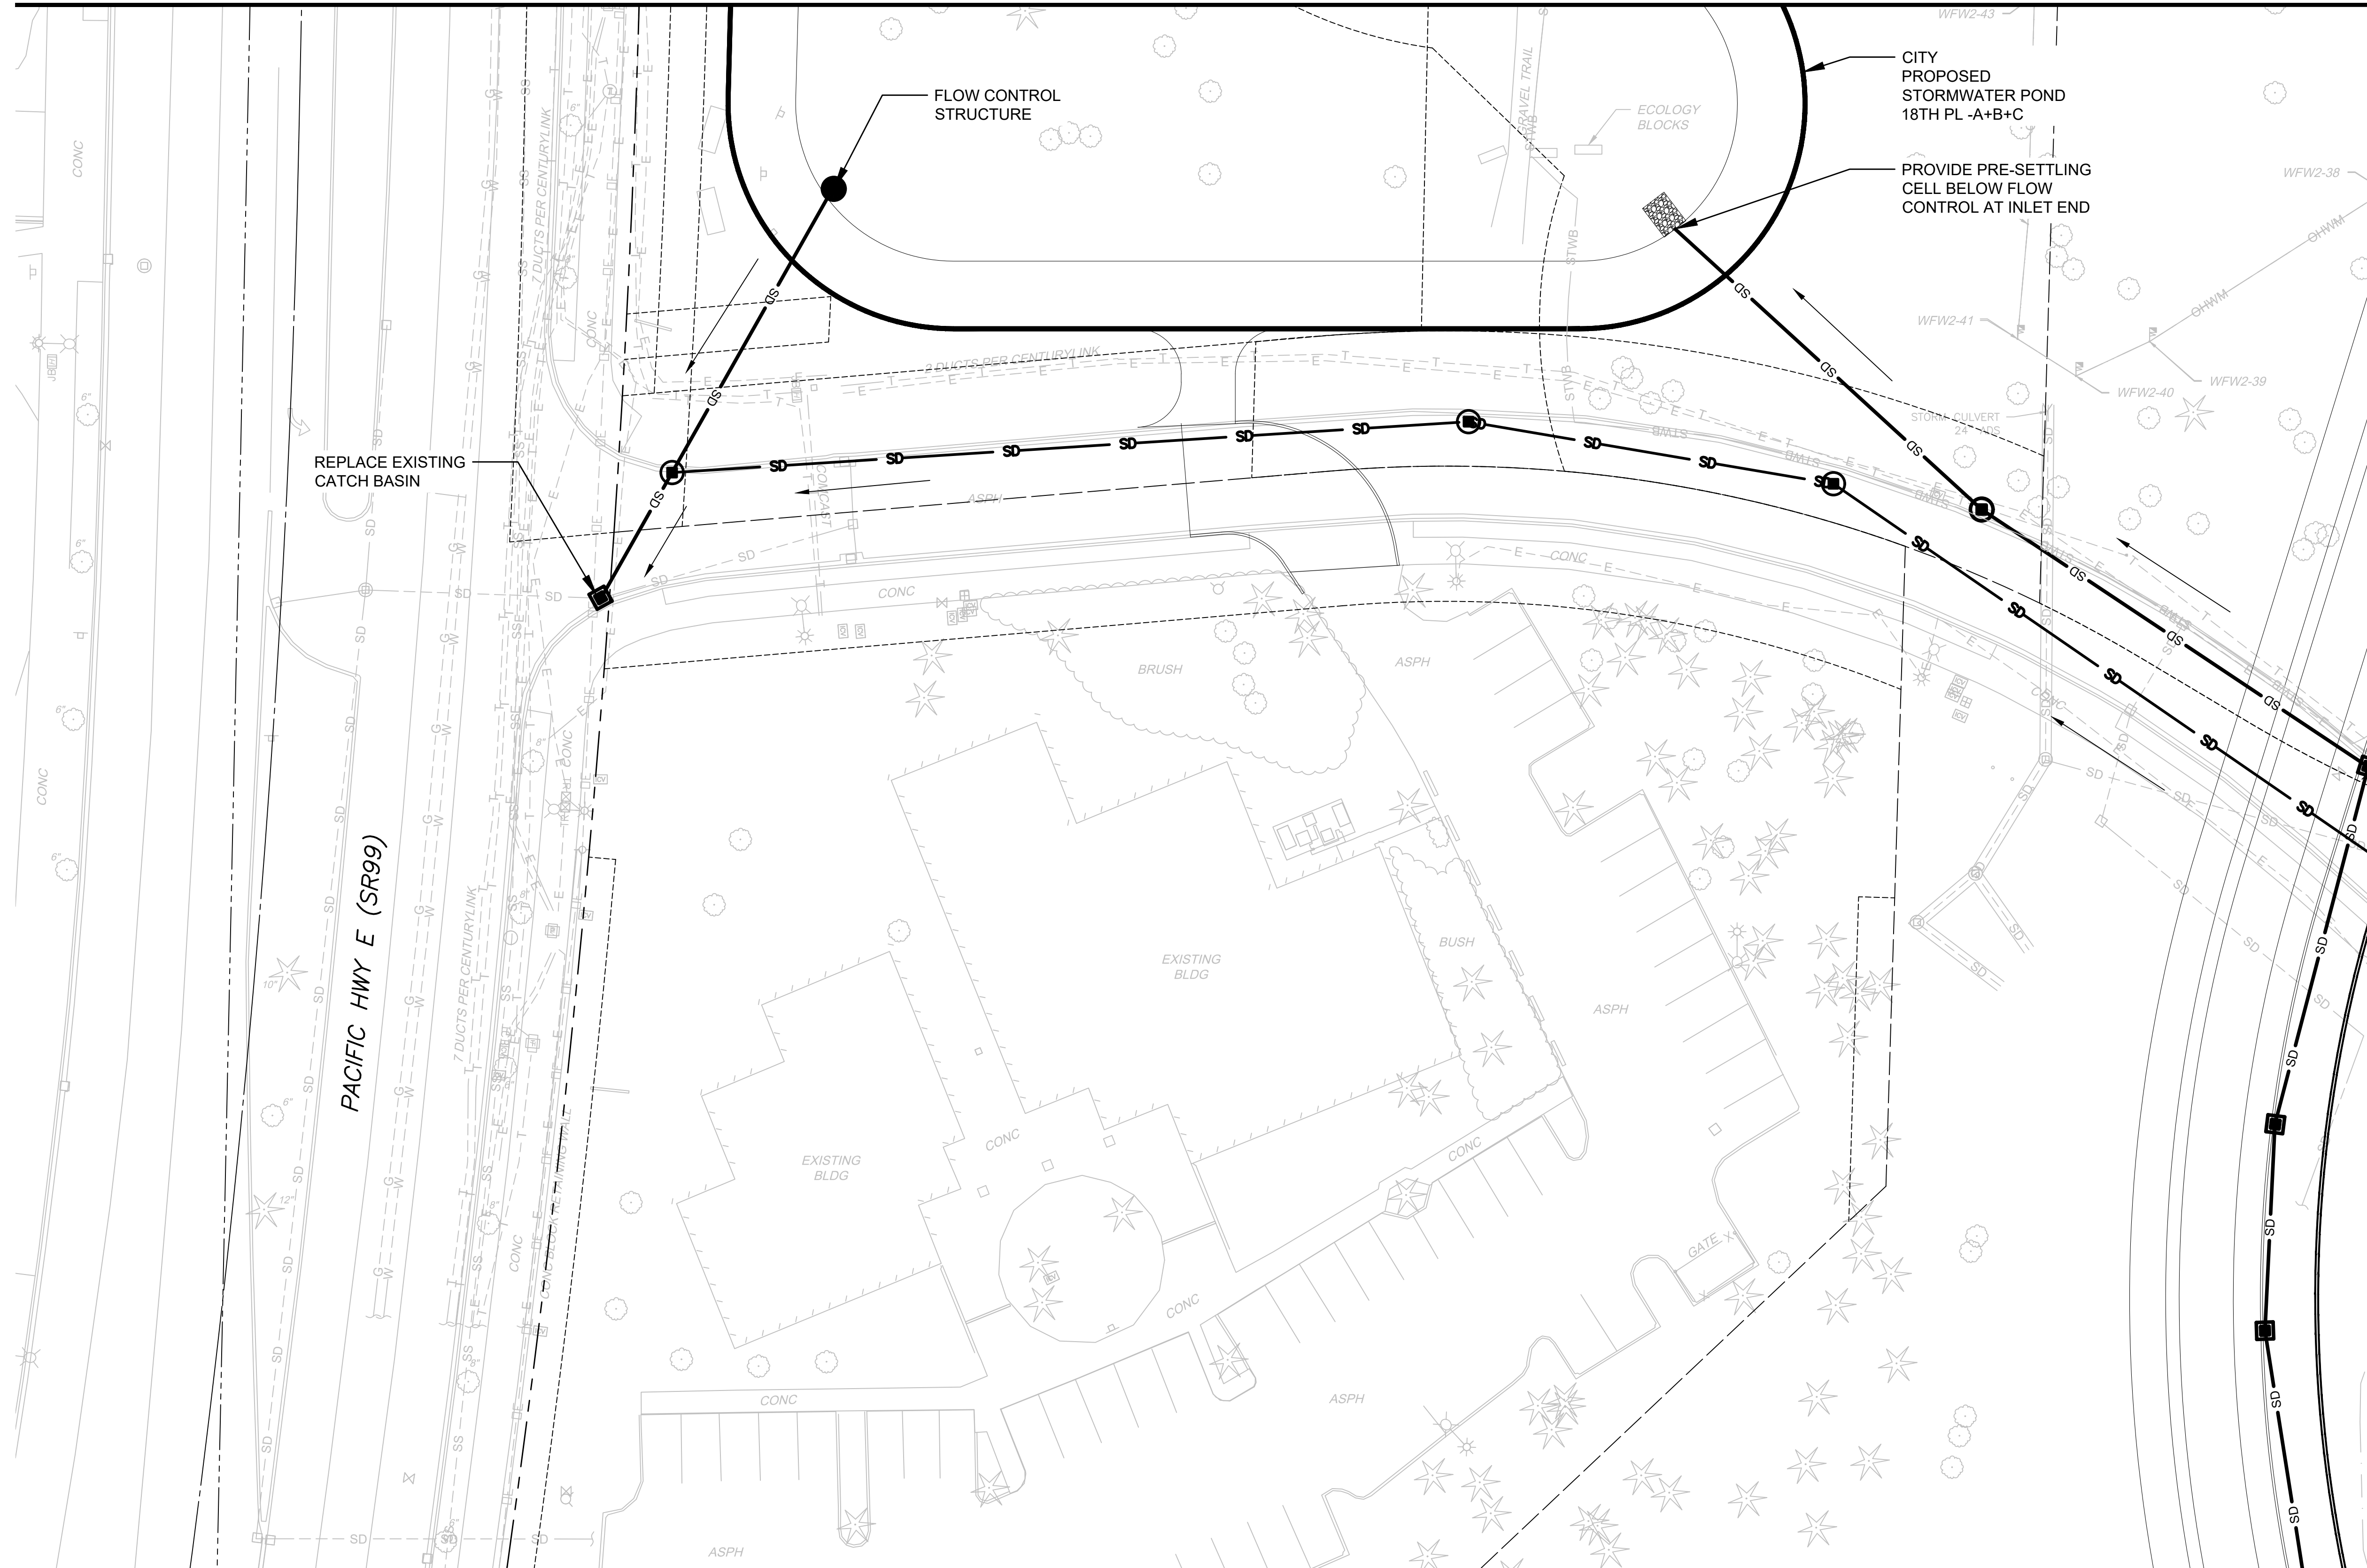

NOTES:

1. REMOVE EXISTING STORM DRAINS AND DRAINAGE STRUCTURES AT CONFLICTS WITH PROPOSED STORM DRAIN, PROPOSED DRAINAGE STRUCTURES, OR PROPOSED STORMWATER FACILITIES. RELOCATE STORM DRAINS OR REPLACE EXISTING DRAINAGE STRUCTURES AS REQUIRED.
2. ALL PROPOSED UNDERGROUND STORM DRAIN 12-INCH DIAMETER UNLESS NOTED OTHERWISE.

**MATCHLINE:
SEE DWG M08-CDP112**

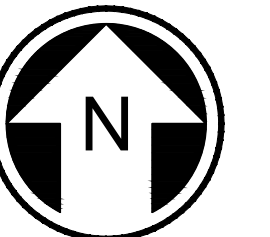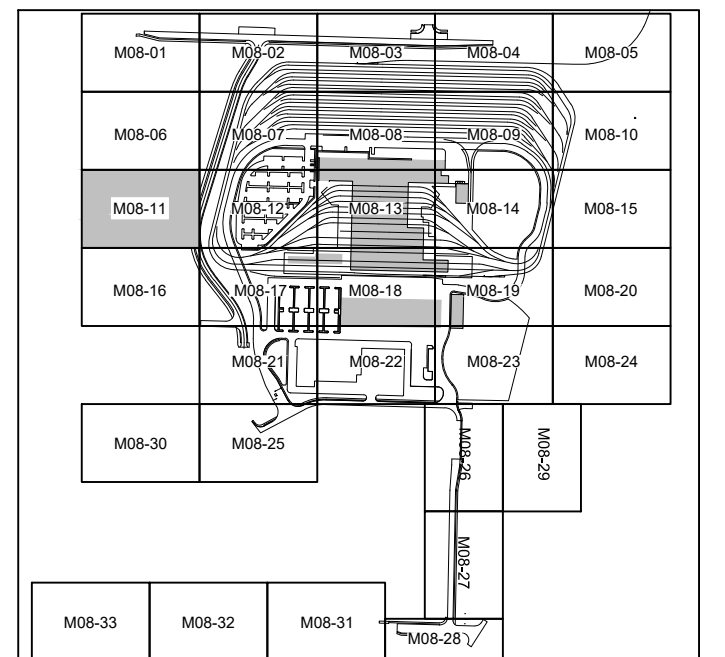



20 10 0 20 40

SCALE IN FEET

NOT FOR
CONSTRUCTION


**MATCHLINE:
SEE DWG M08-CDP116**

AHJ:

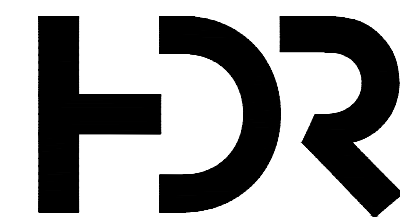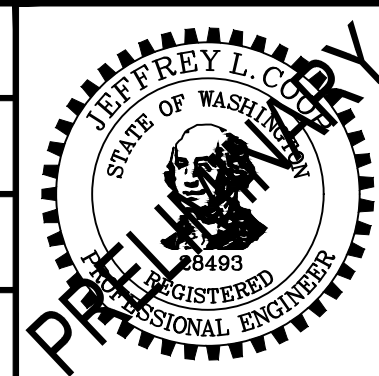SUBMITTED BY:
PABLO LOPEZ-HILFIKER

DATE:	2/27/2024
-------	-----------

 REVIEWED BY:



DATE:

PACKAGE #	
------------------	--

SCALE:	1"=20'
FILENAME:	OMFS-M08-CDP101-134
CONTRACT No.:	AE-0030-17
DATE:	2/27/2024

SOUND TRANSIT
PRELIMINARY ENGINEERING PLANS
OPERATIONS & MAINTENANCE FACILITY SOUTH

CIVIL
DRAINAGE PLAN

DRAWING No.:	
M08-CDP111	
FACILITY ID:	
M08	
SHEET No.:	REV:

REFERENCE CONCEPT DRAWINGS

No.	DATE	DSN	CHK	APP	REVISION

DESIGNED BY:	L. GRABOWSKI
DRAWN BY:	B. WILLIAMS
CHECKED BY:	J. WRIGHT
APPROVED BY:	J.COOP


*Refer to the plan set COVER drawing
for disclaimers regarding this drawing.*

02/23/24 | 9:31 AM | WILLIBRE
C:\PWORKING\WEST01\2727718\OMFS-M08-CDP-01-134.DWG

Refer to the plan set COVER drawing
for disclaimers regarding this drawing.

REFERENCE CONCEPT DRAWINGS					
No.	DATE	DSN	CHK	APP	REVISION

DESIGNED BY:	L. GRABOWSKI
DRAWN BY:	B. WILLIAMS
CHECKED BY:	J. WRIGHT
APPROVED BY:	J.COOP

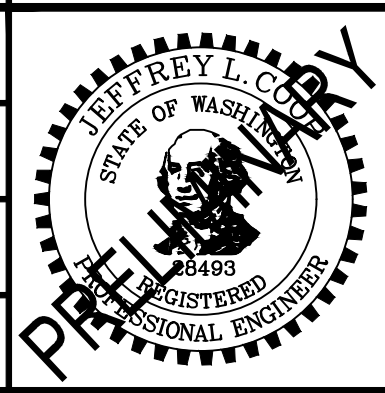

SUBMITTED BY:
PABLO LOPEZ-HILFIKER

DATE:
2/27/2024

REVIEWED BY:




DATE:

PACKAGE #
SCALE: 1"=20'
FILENAME: OMFS-M08-CDP101-134
CONTRACT No.: AE-0030-17
DATE: 2/27/2024

SOUND TRANSIT PRELIMINARY ENGINEERING PLANS OPERATIONS & MAINTENANCE FACILITY SOUTH CIVIL DRAINAGE PLAN	DRAWING No.: M08-CDP112
FACILITY ID: M08	
SHEET No.: REV:	



MATCHLINE:
SEE DWG M08-CDP107

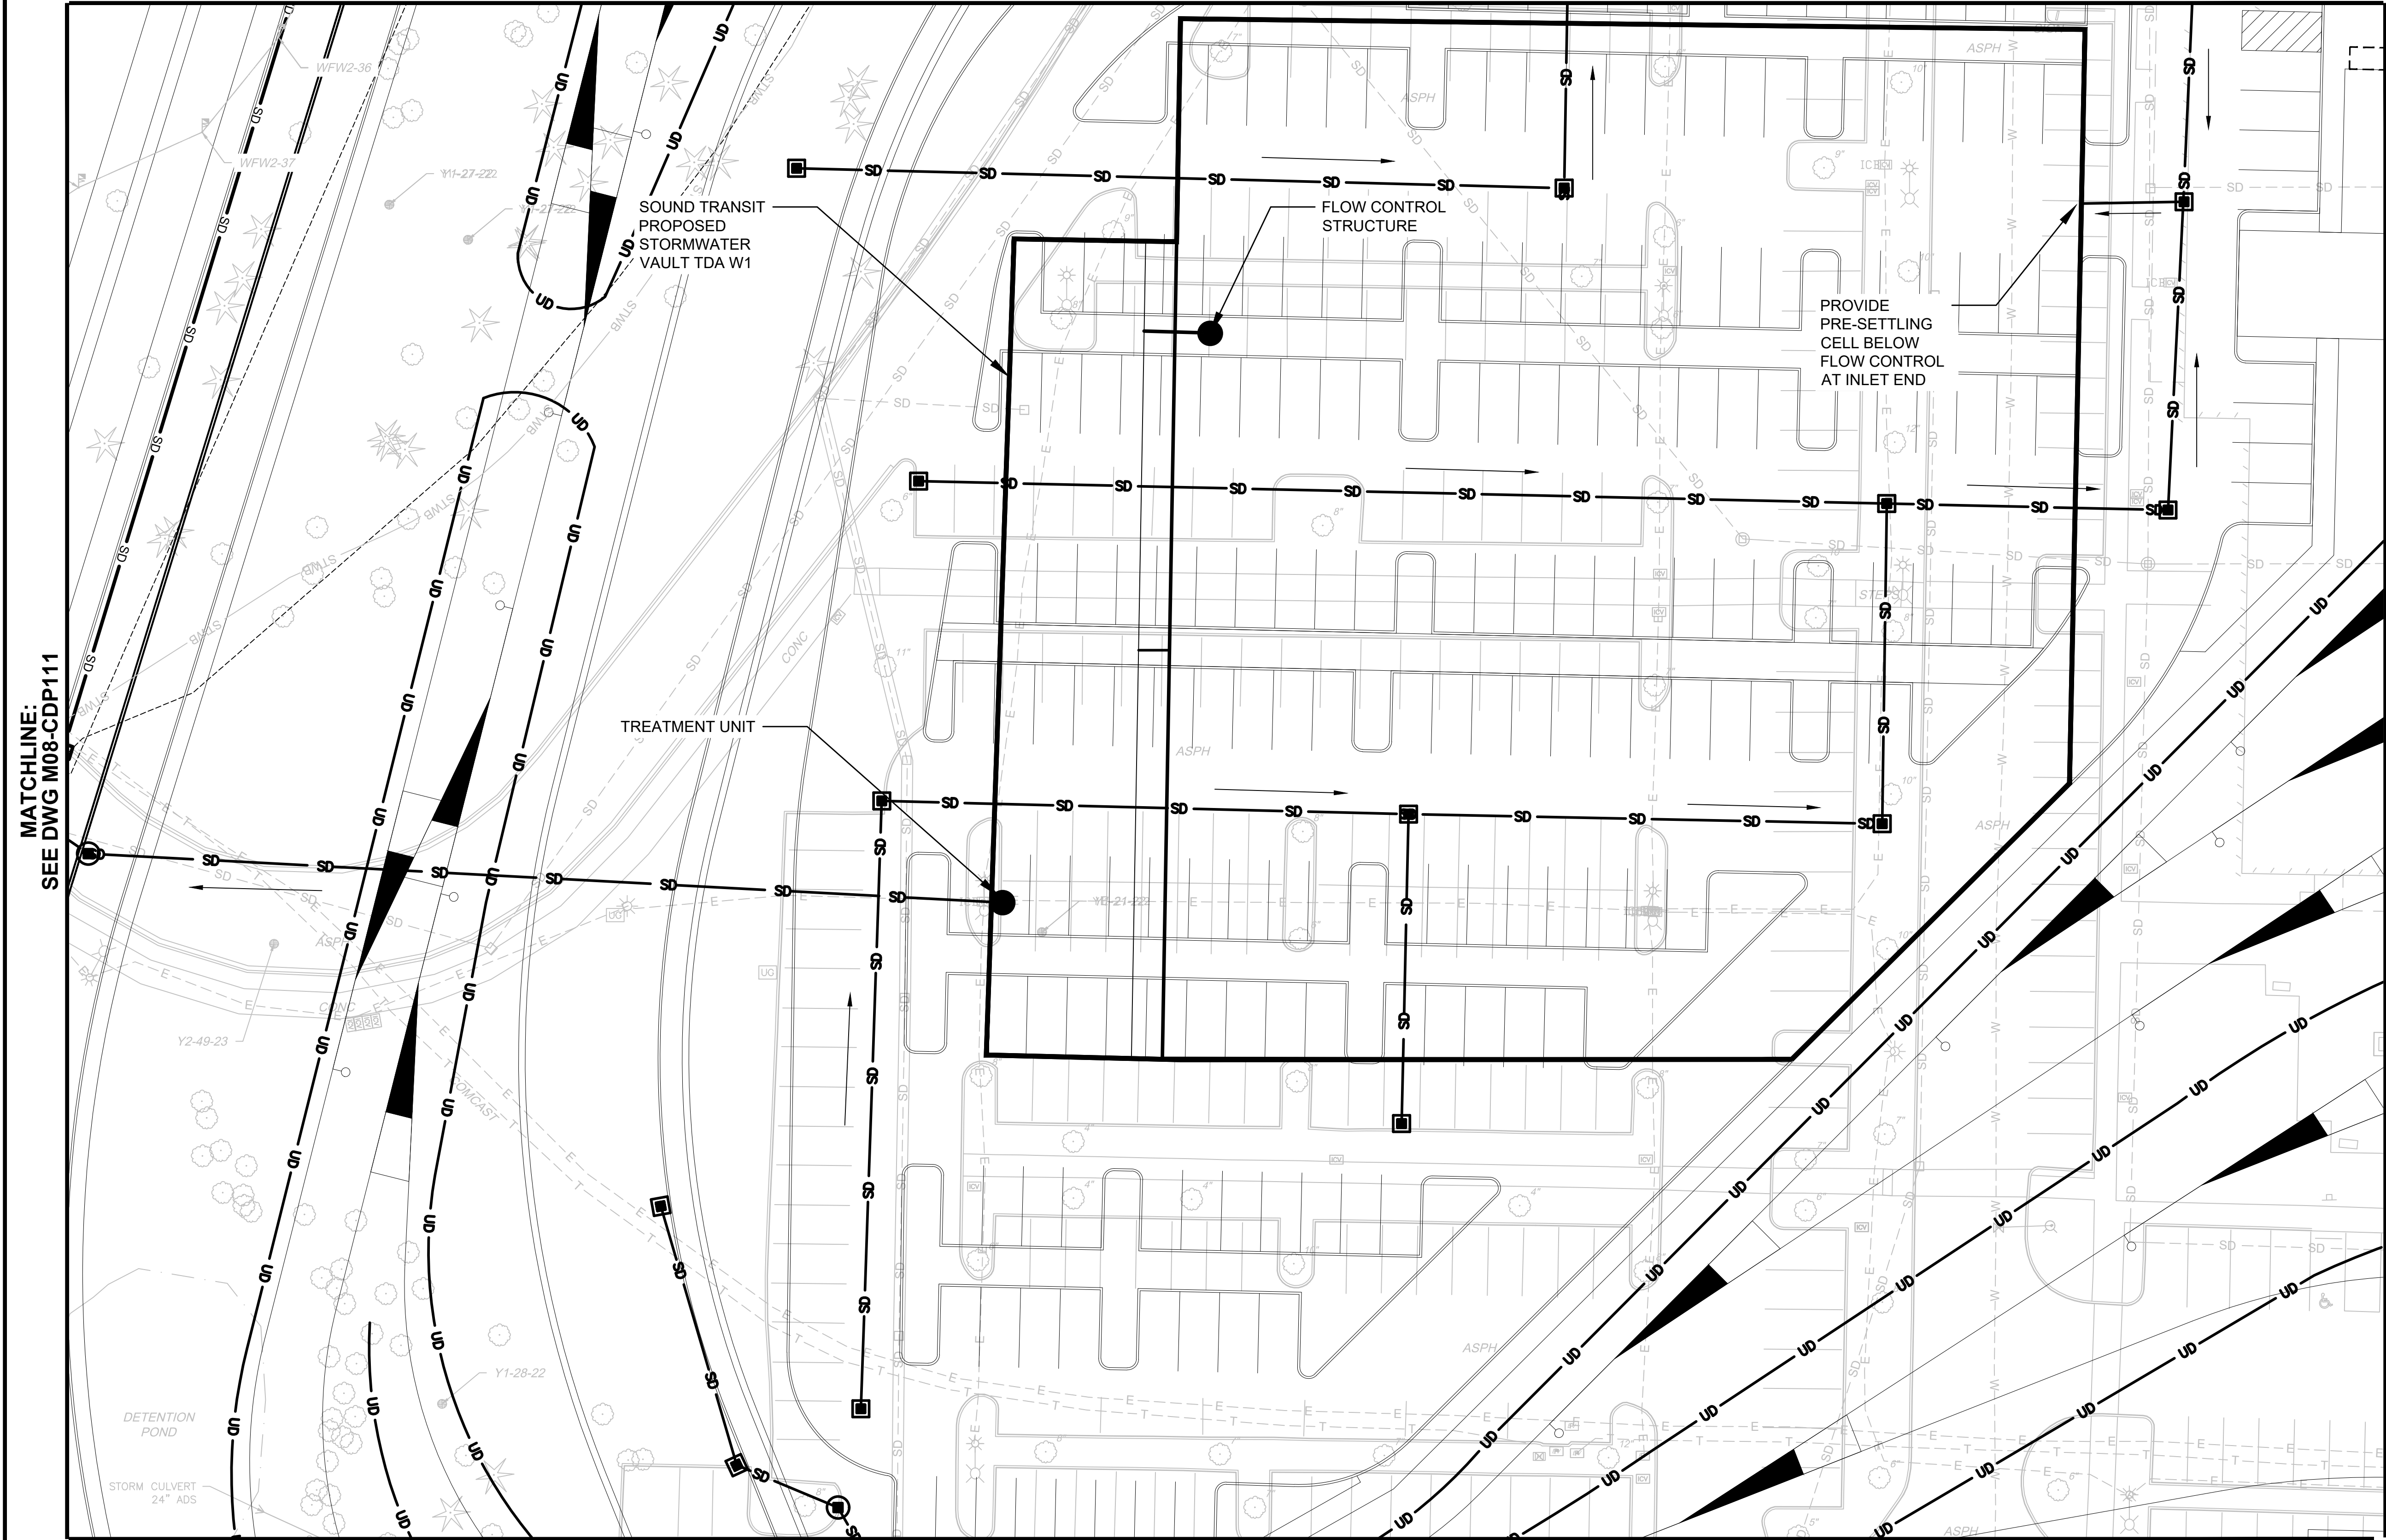

MATCHLINE:
SEE DWG M08-CDP117

NOTES:

1. REMOVE EXISTING STORM DRAINS AND DRAINAGE STRUCTURES AT CONFLICTS WITH PROPOSED STORM DRAIN, PROPOSED DRAINAGE STRUCTURES, OR PROPOSED STORMWATER FACILITIES. RELOCATE STORM DRAINS OR REPLACE EXISTING DRAINAGE STRUCTURES AS REQUIRED.
2. ALL PROPOSED UNDERGROUND STORM DRAIN 12-INCH DIAMETER UNLESS NOTED OTHERWISE.

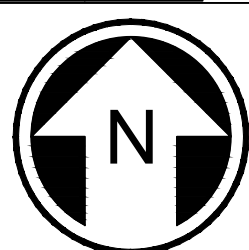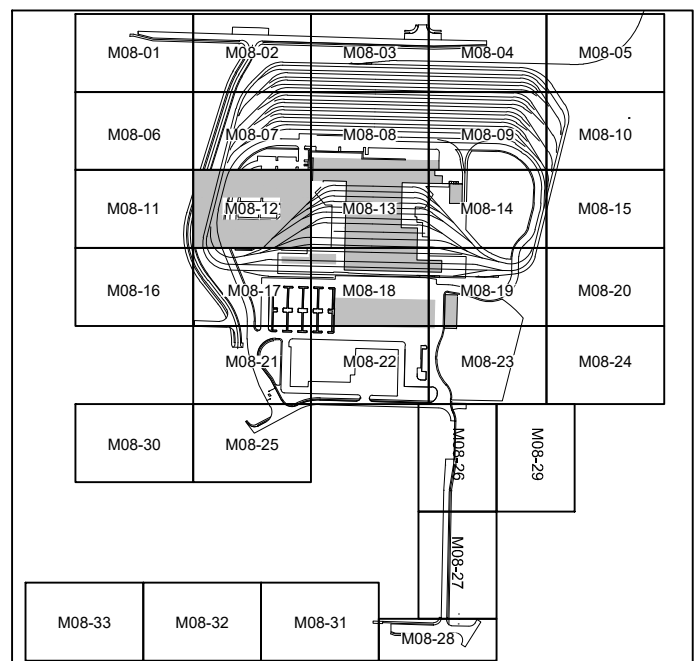

NOT FOR
CONSTRUCTION



MATCHLINE:
SEE DWG M08-CDP108

NOTES:

1. REMOVE EXISTING STORM DRAINS AND DRAINAGE STRUCTURES AT CONFLICTS WITH PROPOSED STORM DRAIN, PROPOSED DRAINAGE STRUCTURES, OR PROPOSED STORMWATER FACILITIES. RELOCATE STORM DRAINS OR REPLACE EXISTING DRAINAGE STRUCTURES AS REQUIRED.
2. ALL PROPOSED UNDERGROUND STORM DRAIN 12-INCH DIAMETER UNLESS NOTED OTHERWISE.

MATCHLINE:
SEE DWG M08-CDP112

MATCHLINE:
SEE DWG M08-CDP114

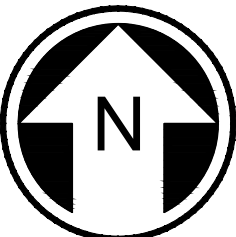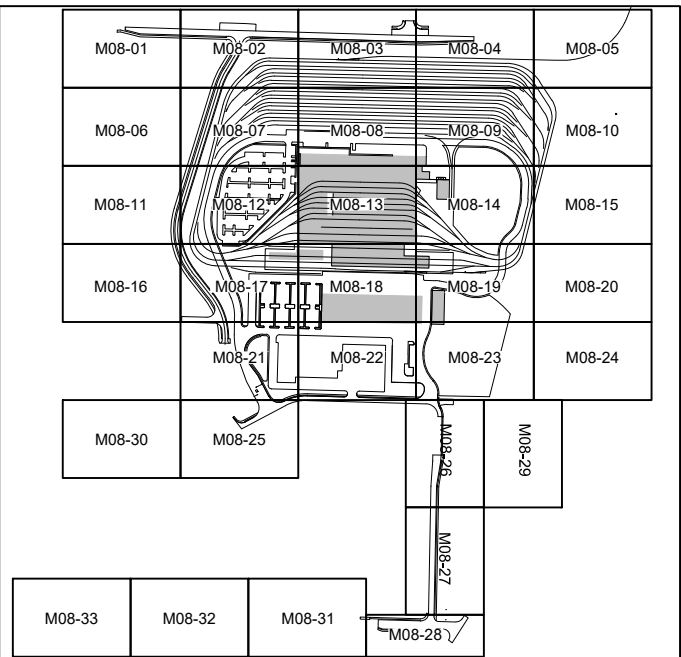

NOT FOR
CONSTRUCTION



MATCHLINE:
SEE DWG M08-CDP118

Refer to the plan set COVER drawing
for disclaimers regarding this drawing.

REFERENCE CONCEPT DRAWINGS

No.	DATE	DSN	CHK	APP	REVISION

DESIGNED BY:
L. GRABOWSKI
DRAWN BY:
B. WILLIAMS
CHECKED BY:
J. WRIGHT
APPROVED BY:
J.COOP

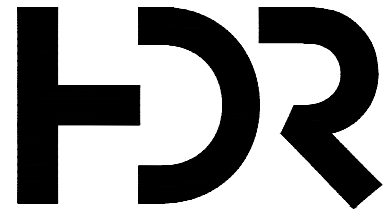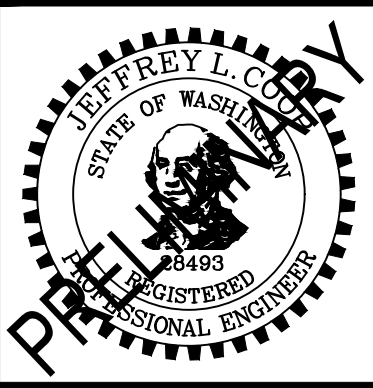

SUBMITTED BY:
PABLO LOPEZ-HILFIKER

DATE:
2/27/2024

REVIEWED BY:

LINE IS 1" AT
FULL SCALE



DATE:

PACKAGE #

SCALE:
1"=20'
FILENAME:
OMFS-M08-CDP101-134
CONTRACT No.:
AE-0030-17
DATE:
2/27/2024

SOUND TRANSIT
PRELIMINARY ENGINEERING PLANS
OPERATIONS & MAINTENANCE FACILITY SOUTH

CIVIL
DRAINAGE PLAN


DRAWING No.:
M08-CDP113
FACILITY ID:
M08
SHEET No.:
REV:

02/21/24 | 11:58 AM | WILLIBRE
C:\PWORKING\WEST01\DWG\OMFS-M08-CDP101-134.DWG

Refer to the plan set COVER drawing
for disclaimers regarding this drawing.

REFERENCE CONCEPT DRAWINGS					
No.	DATE	DSN	CHK	APP	REVISION

DESIGNED BY:	L. GRABOWSKI
DRAWN BY:	B. WILLIAMS
CHECKED BY:	J. WRIGHT
APPROVED BY:	J.COOP

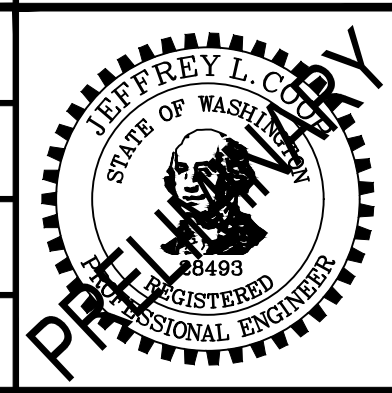

SUBMITTED BY:
PABLO LOPEZ-HILFIKER

DATE:
2/27/2024

REVIEWED BY:



DATE:

PACKAGE #
SCALE: 1"=20'
FILENAME: OMFS-M08-CDP101-134
CONTRACT No.: AE-0030-17
DATE: 2/27/2024


SOUND TRANSIT
PRELIMINARY ENGINEERING PLANS
OPERATIONS & MAINTENANCE FACILITY SOUTH

CIVIL
DRAINAGE PLAN

DRAWING No.:	M08-CDP114
FACILITY ID:	M08
SHEET No.:	REV:

MATCHLINE:
SEE DWG M08-CDP109




MATCHLINE:
SEE DWG M08-CDP113

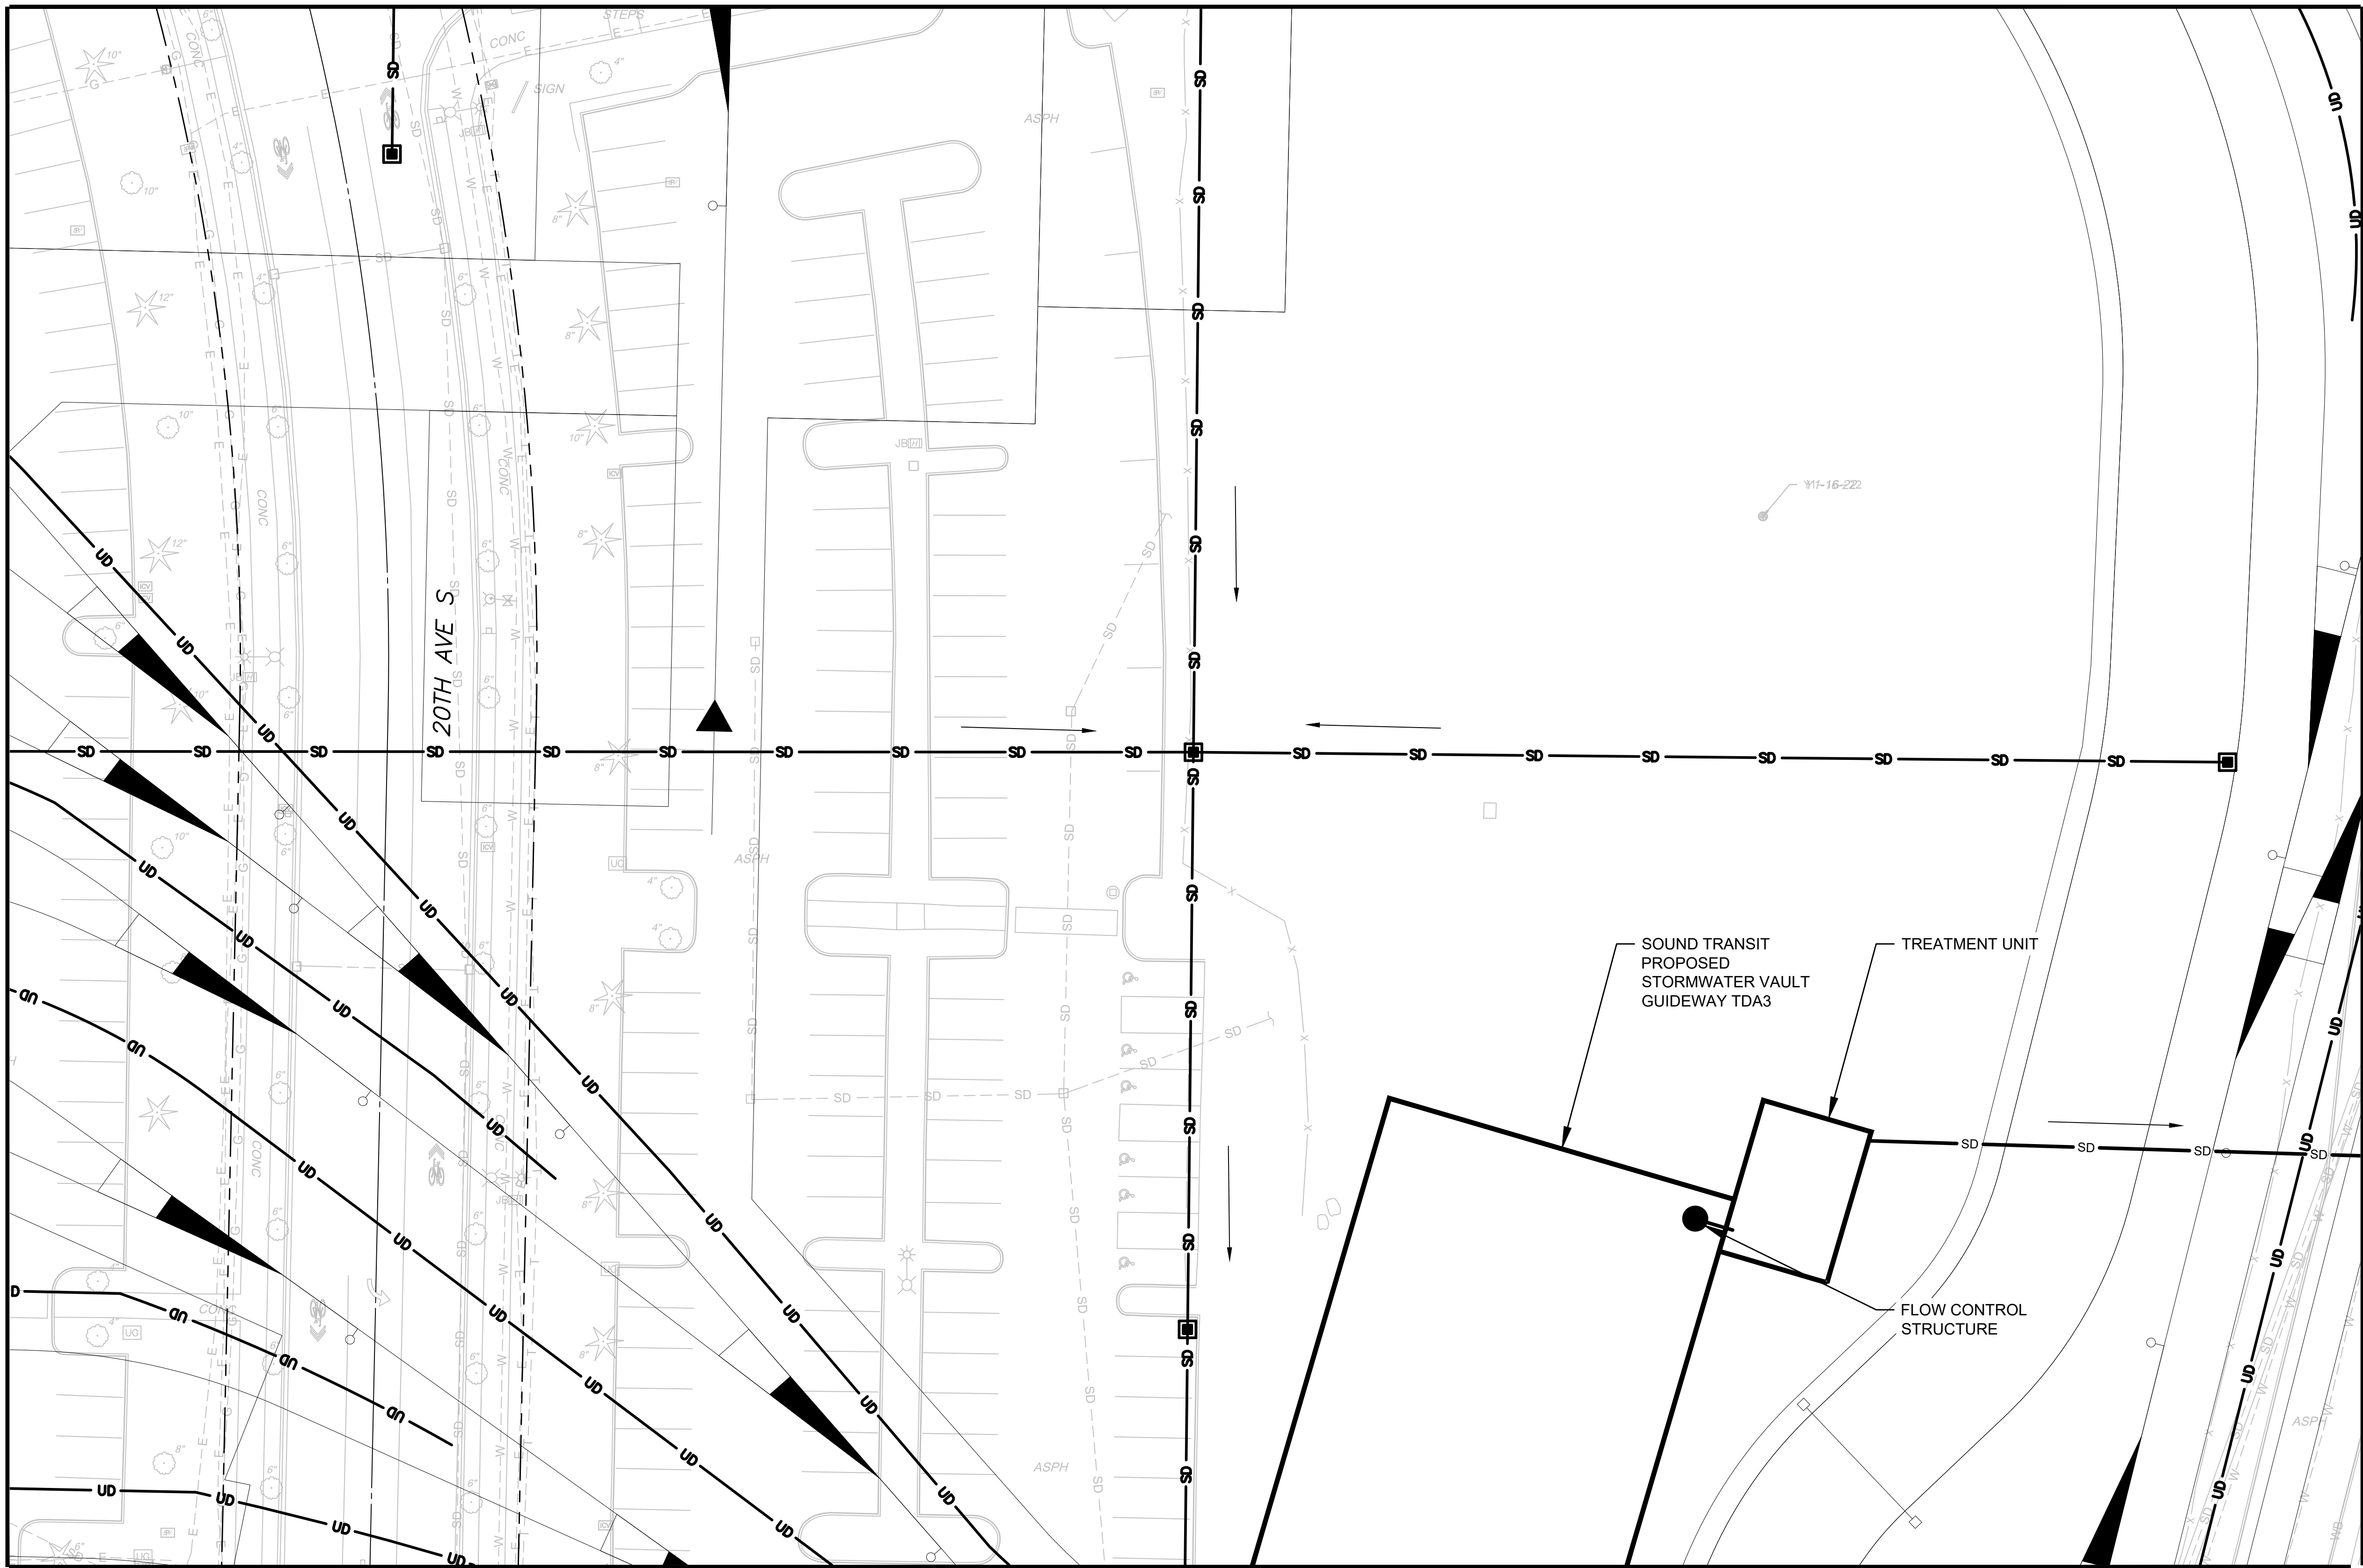

MATCHLINE:
SEE DWG M08-CDP119


MATCHLINE:
SEE DWG M08-CDP115

- NOTES:**
- REMOVE EXISTING STORM DRAINS AND DRAINAGE STRUCTURES AT CONFLICTS WITH PROPOSED STORM DRAIN, PROPOSED DRAINAGE STRUCTURES, OR PROPOSED STORMWATER FACILITIES. RELOCATE STORM DRAINS OR REPLACE EXISTING DRAINAGE STRUCTURES AS REQUIRED.
 - ALL PROPOSED UNDERGROUND STORM DRAIN 12-INCH DIAMETER UNLESS NOTED OTHERWISE.

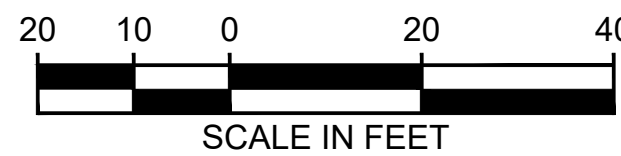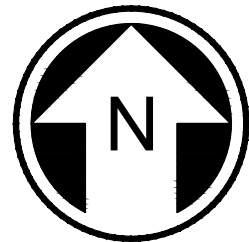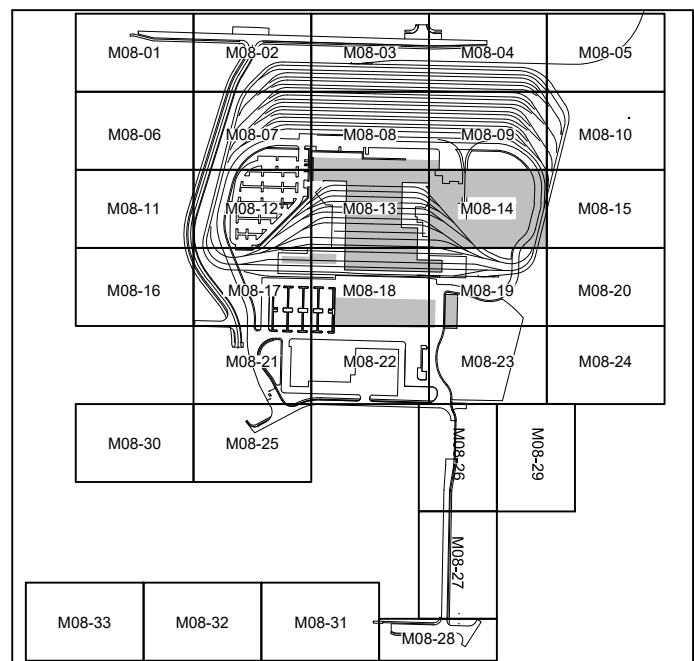



NOT FOR
CONSTRUCTION

MATCHLINE:
SEE DWG M08-CDP110

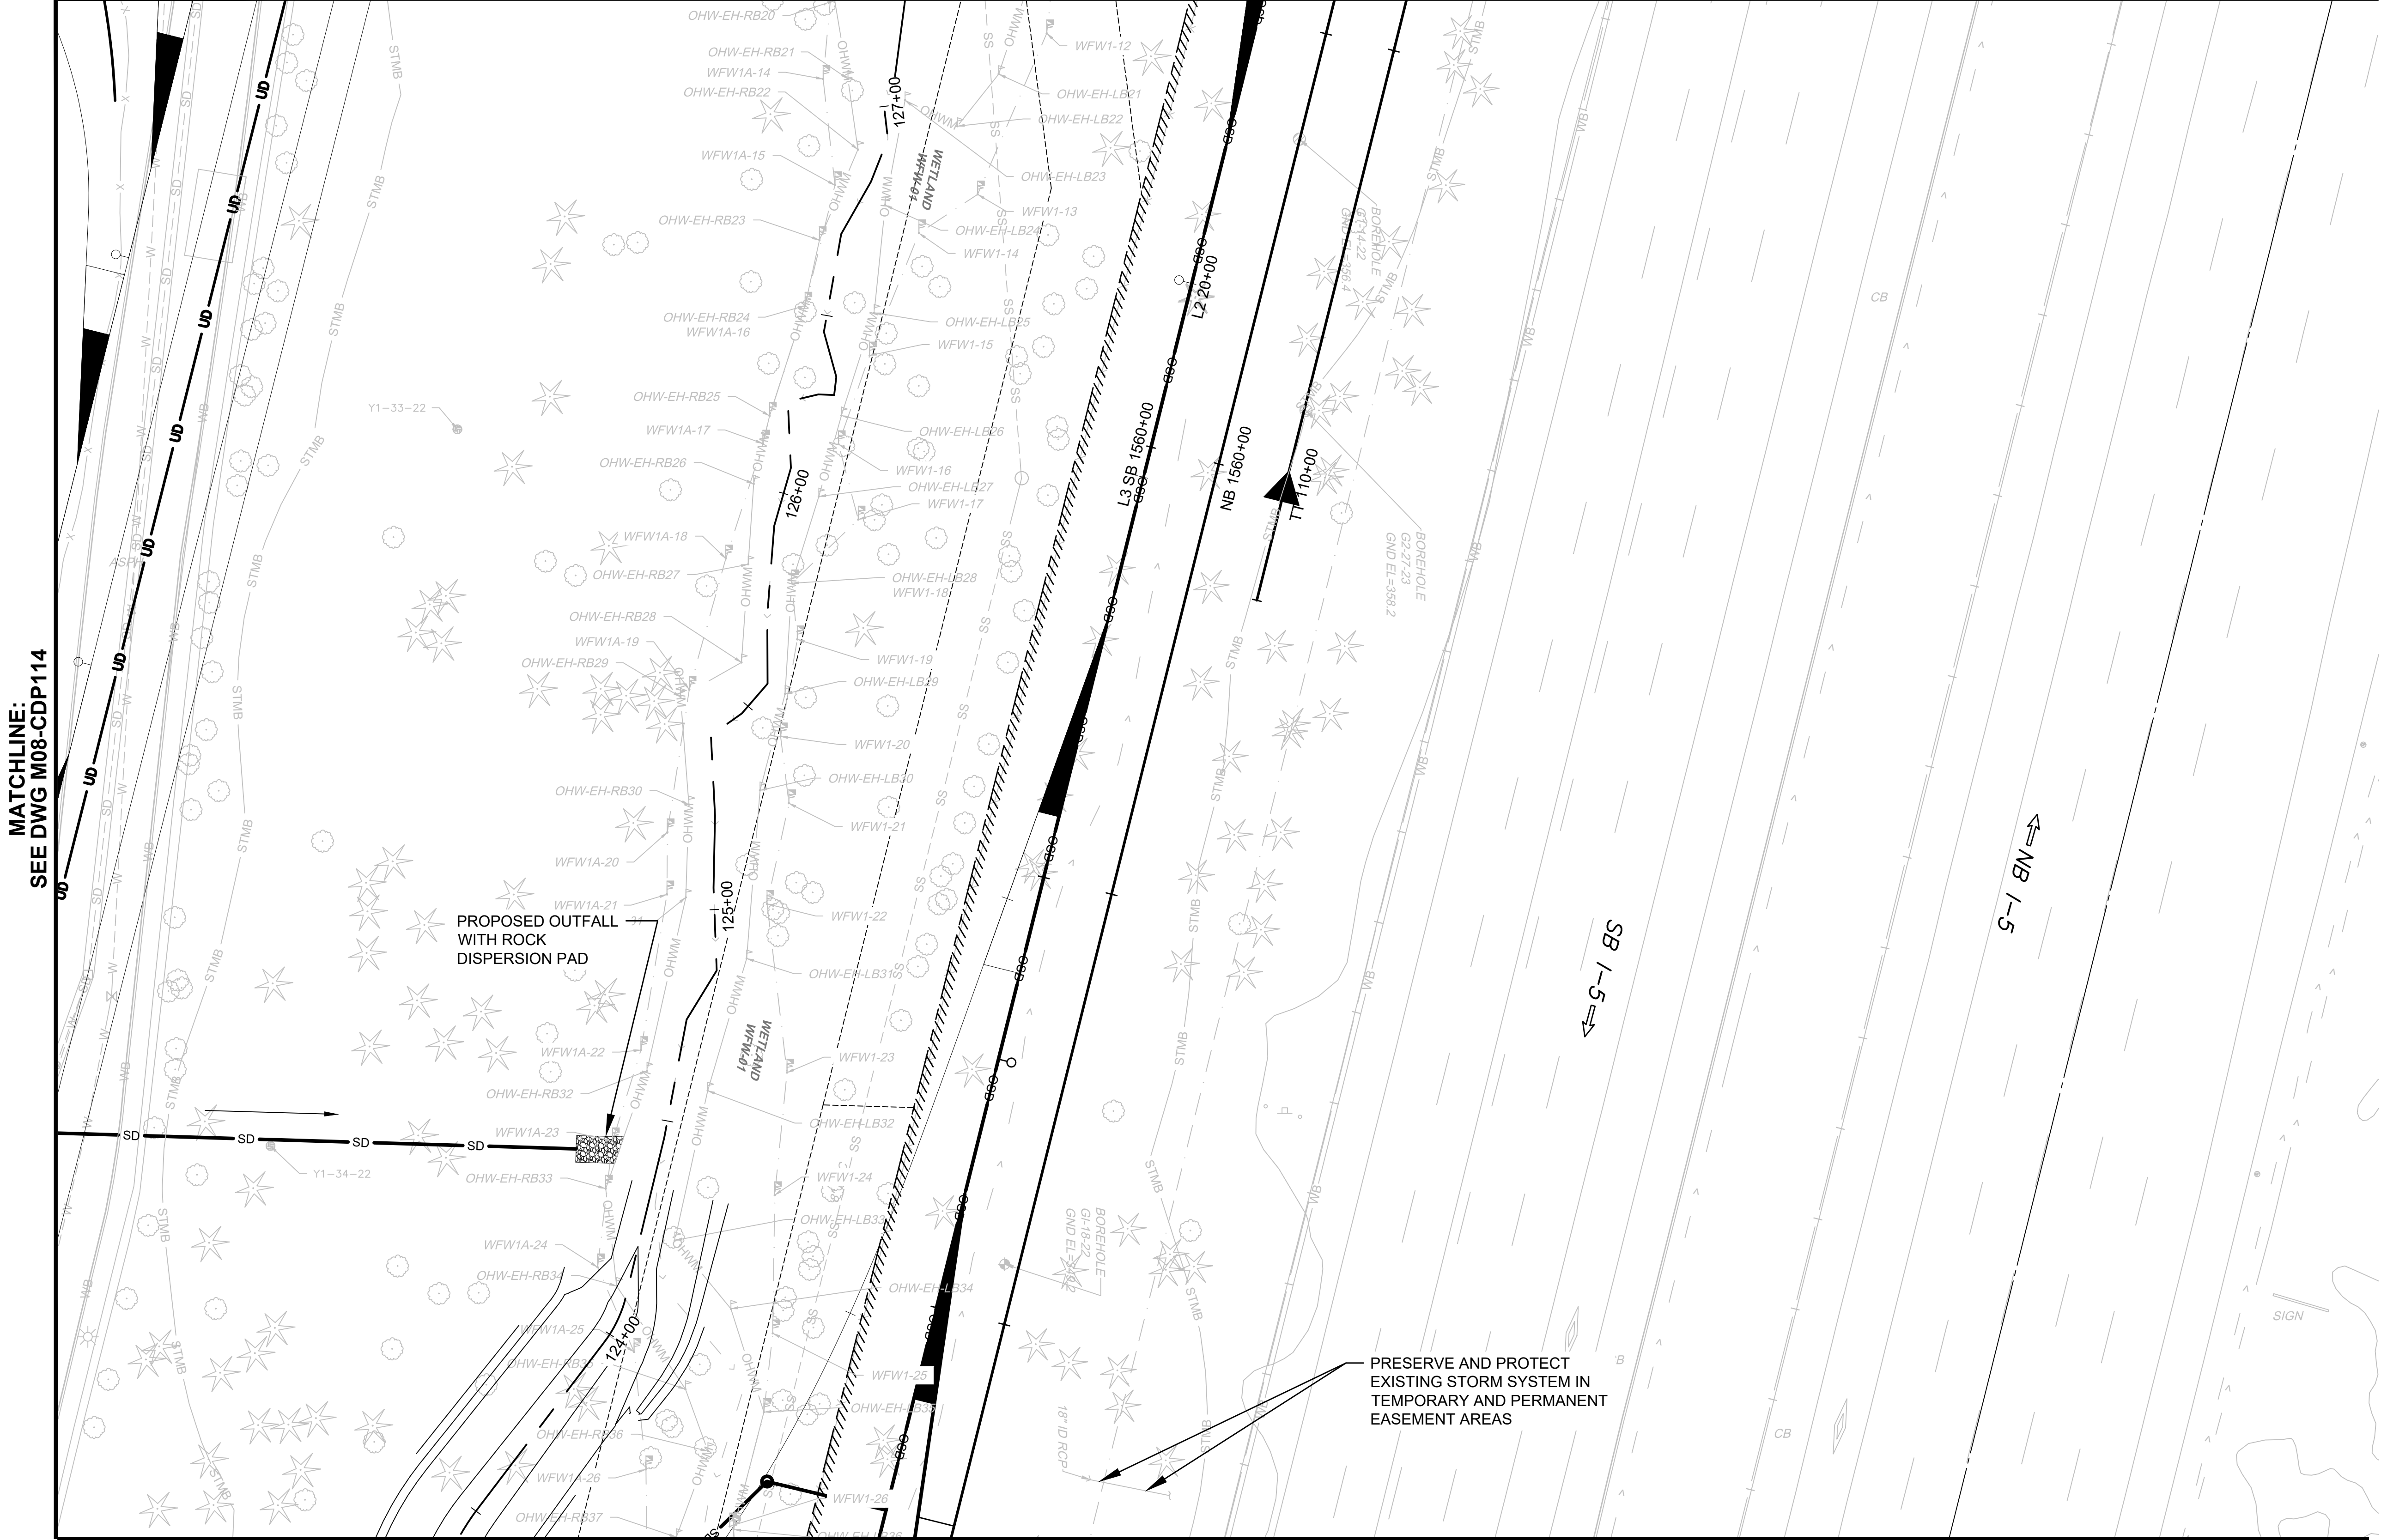

NOTES:

1. REMOVE EXISTING STORM DRAINS AND DRAINAGE STRUCTURES AT CONFLICTS WITH PROPOSED STORM DRAIN, PROPOSED DRAINAGE STRUCTURES, OR PROPOSED STORMWATER FACILITIES. RELOCATE STORM DRAINS OR REPLACE EXISTING DRAINAGE STRUCTURES AS REQUIRED.
2. ALL PROPOSED UNDERGROUND STORM DRAIN 12-INCH DIAMETER UNLESS NOTED OTHERWISE.

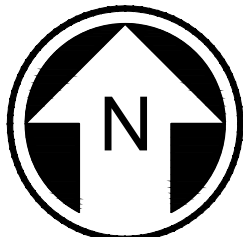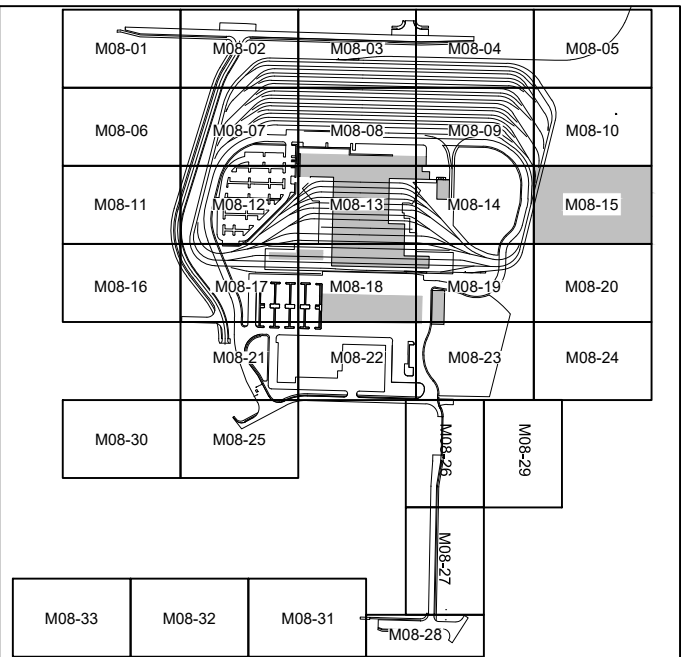



NOT FOR
CONSTRUCTION

Refer to the plan set COVER drawing
for disclaimers regarding this drawing.

REFERENCE CONCEPT DRAWINGS

No.	DATE	DSN	CHK	APP	REVISION

DESIGNED BY:
L. GRABOWSKI
DRAWN BY:
B. WILLIAMS
CHECKED BY:
J. WRIGHT
APPROVED BY:
J.COOP

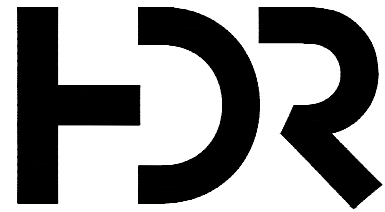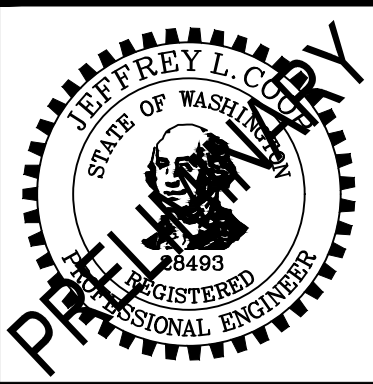

SUBMITTED BY:
PABLO LOPEZ-HILFIKER

DATE:
2/27/2024

REVIEWED BY:



DATE:

PACKAGE #

SCALE:
1"=20'
FILENAME:
OMFS-M08-CDP101-134
CONTRACT No.:
AE-0030-17
DATE:
2/27/2024

SOUND TRANSIT
PRELIMINARY ENGINEERING PLANS
OPERATIONS & MAINTENANCE FACILITY SOUTH
CIVIL
DRAINAGE PLAN



DRAWING No.:
M08-CDP115
FACILITY ID:
M08
SHEET No.:
REV:

MATCHLINE:
SEE DWG M08-CDP111

NOTES:

1. REMOVE EXISTING STORM DRAINS AND DRAINAGE STRUCTURES AT CONFLICTS WITH PROPOSED STORM DRAIN, PROPOSED DRAINAGE STRUCTURES, OR PROPOSED STORMWATER FACILITIES. RELOCATE STORM DRAINS OR REPLACE EXISTING DRAINAGE STRUCTURES AS REQUIRED.
2. ALL PROPOSED UNDERGROUND STORM DRAIN 12-INCH DIAMETER UNLESS NOTED OTHERWISE.

MATCHLINE:
SEE DWG M08-CDP117

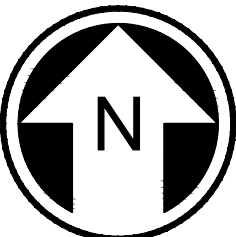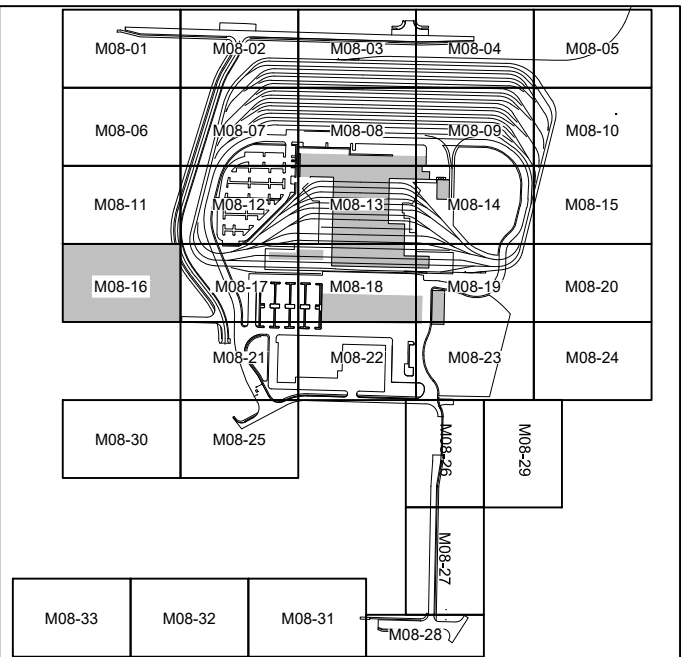



NOT FOR
CONSTRUCTION

Refer to the plan set COVER drawing
for disclaimers regarding this drawing.

REFERENCE CONCEPT DRAWINGS

No.	DATE	DSN	CHK	APP	REVISION

DESIGNED BY:
L. GRABOWSKI
DRAWN BY:
B. WILLIAMS
CHECKED BY:
J. WRIGHT
APPROVED BY:
J.COOP

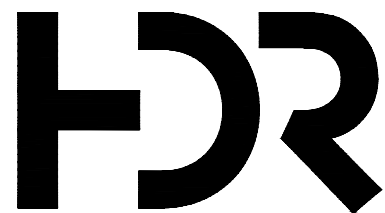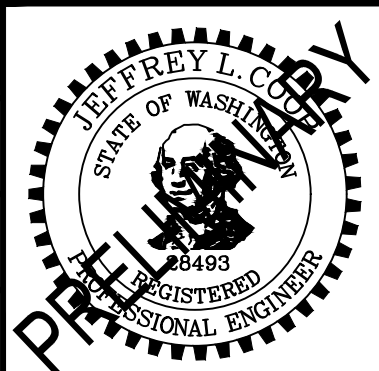

SUBMITTED BY:
PABLO LOPEZ-HILFIKER

DATE:
2/27/2024

REVIEWED BY:

LINE IS 1" AT
FULL SCALE



DATE:

PACKAGE #

SCALE:
1"=20'
FILENAME:
OMFS-M08-CDP101-134
CONTRACT No.:
AE-0030-17
DATE:
2/27/2024

SOUND TRANSIT
PRELIMINARY ENGINEERING PLANS
OPERATIONS & MAINTENANCE FACILITY SOUTH

CIVIL
DRAINAGE PLAN

DRAWING No.:
M08-CDP116
FACILITY ID:
M08
SHEET No.:
REV:

02/21/24 | 11:59 AM | WILLIBRE
C:\PWORKING\WEST01\DWG\OMFS-M08-CDP101-134.DWG

MATCHLINE:
SEE DWG M08-CDP116

MATCHLINE:
SEE DWG M08-CDP112

MATCHLINE:
SEE DWG M08-CDP118

MATCHLINE:
SEE DWG M08-CDP121



NOTES:

1. REMOVE EXISTING STORM DRAINS AND DRAINAGE STRUCTURES AT CONFLICTS WITH PROPOSED STORM DRAIN, PROPOSED DRAINAGE STRUCTURES, OR PROPOSED STORMWATER FACILITIES. RELOCATE STORM DRAINS OR REPLACE EXISTING DRAINAGE STRUCTURES AS REQUIRED.
2. ALL PROPOSED UNDERGROUND STORM DRAIN 12-INCH DIAMETER UNLESS NOTED OTHERWISE.

SOUND TRANSIT
PROPOSED
STORMWATER
VAULT TDA W2

TREATMENT UNIT

FLOW CONTROL
STRUCTURE

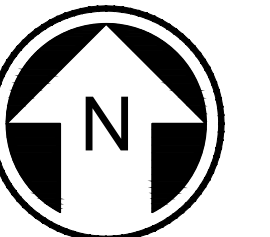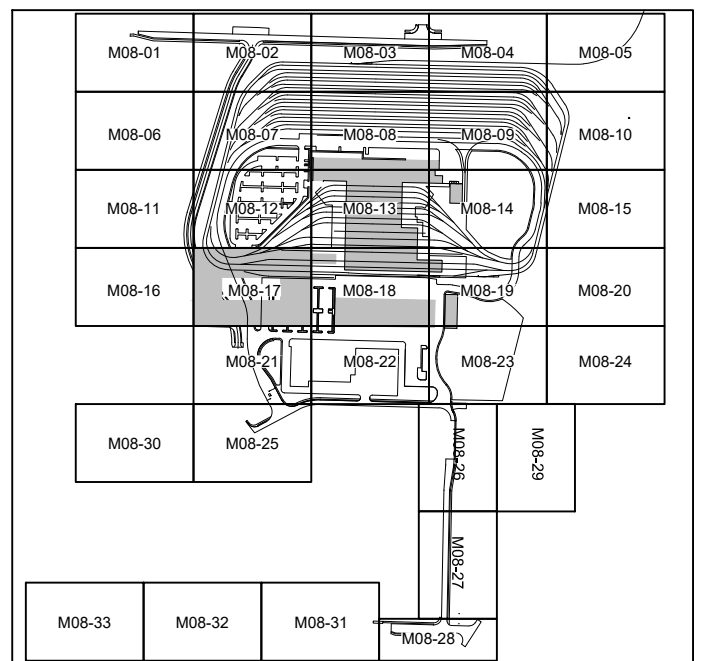

NOT FOR
CONSTRUCTION

Refer to the plan set COVER drawing
for disclaimers regarding this drawing.

REFERENCE CONCEPT DRAWINGS



No.	DATE	DSN	CHK	APP	REVISION

DESIGNED BY:
L. GRABOWSKI

DRAWN BY:
B. WILLIAMS

CHECKED BY:
J. WRIGHT

APPROVED BY:
J.COOP

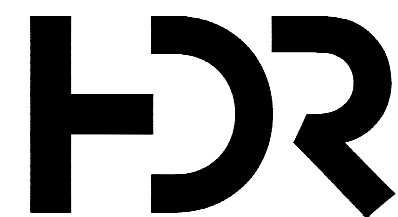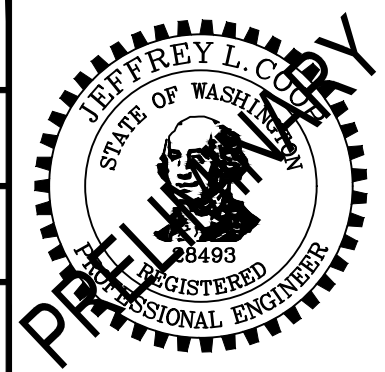

SUBMITTED BY:
PABLO LOPEZ-HILFIKER

DATE:
2/27/2024

REVIEWED BY:

LINE IS 1" AT
FULL SCALE



DATE:

PACKAGE #

SCALE:
1"=20'

FILENAME:
OMFS-M08-CDP101-134

CONTRACT No.:
AE-0030-17

DATE:
2/27/2024

SOUND TRANSIT
PRELIMINARY ENGINEERING PLANS
OPERATIONS & MAINTENANCE FACILITY SOUTH

CIVIL
DRAINAGE PLAN

DRAWING No.:
M08-CDP117


FACILITY ID:
M08

SHEET No.: REV:

02/21/24 | 11:59 AM | WILLIBRE
C:\PWORKING\WEST01\DWG\OMFS-M08-CDP101-134.DWG

MATCHLINE:
SEE DWG M08-CDP117



MATCHLINE:
SEE DWG M08-CDP113

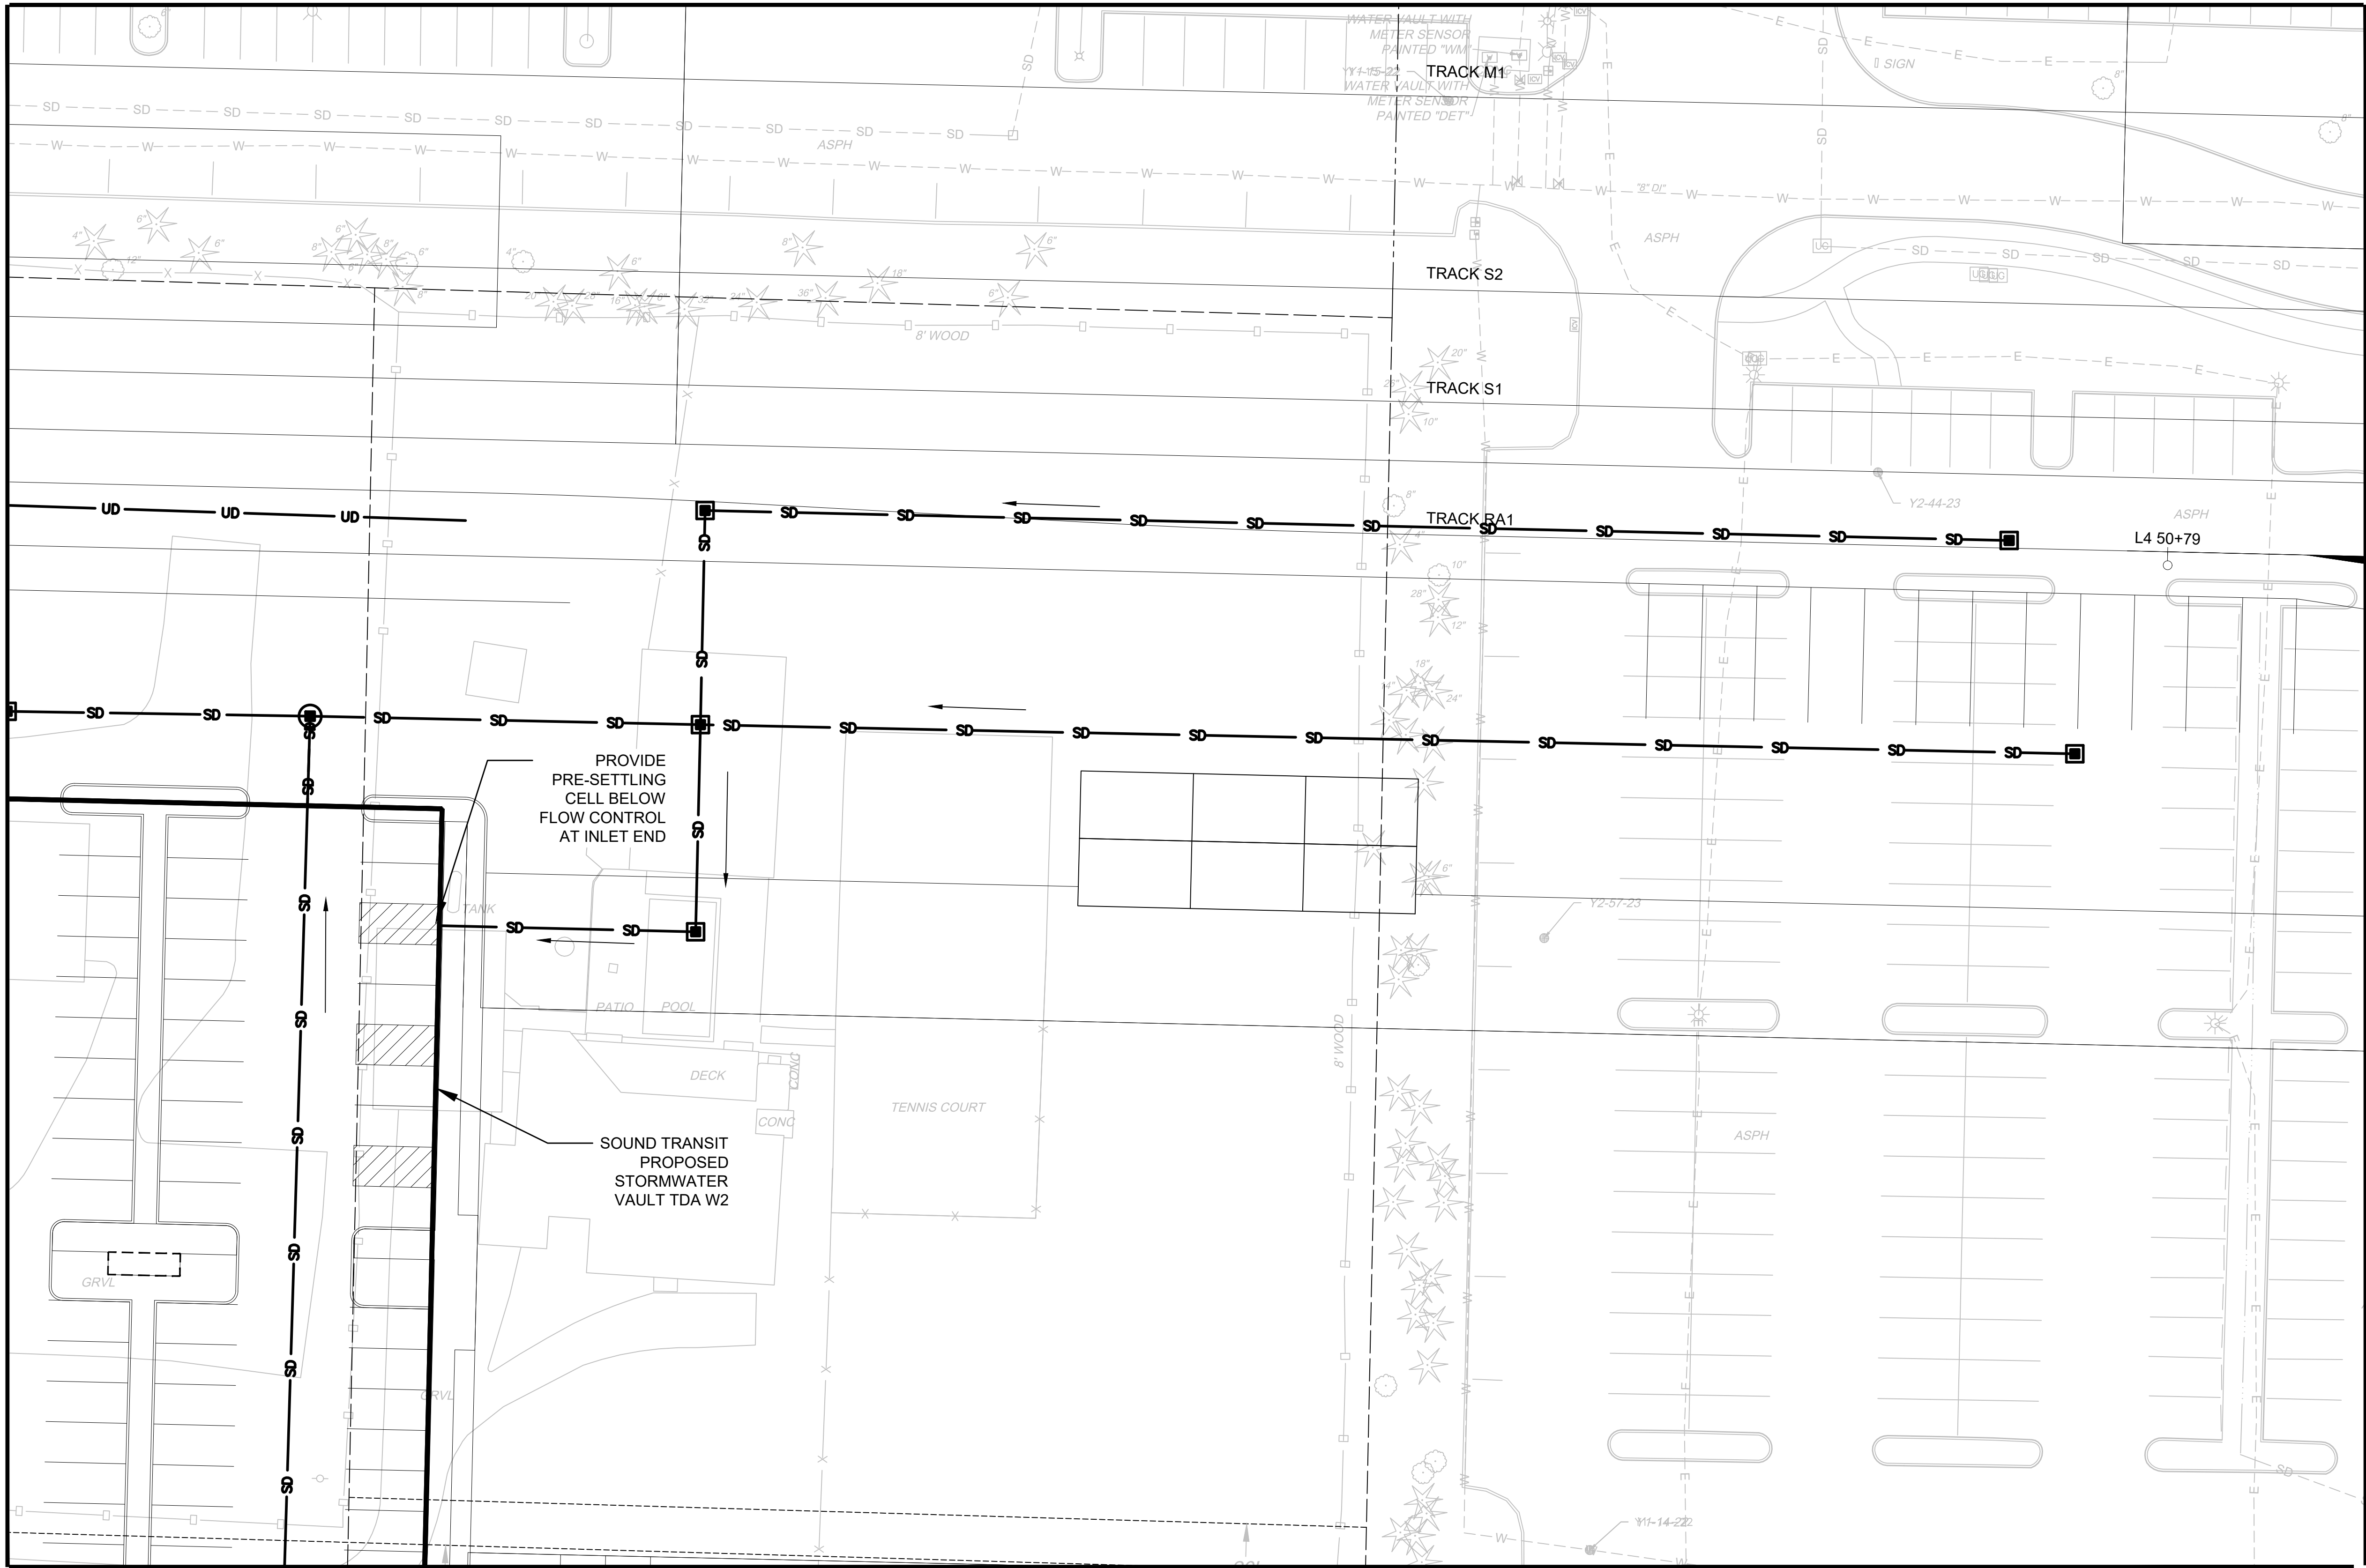

MATCHLINE:
SEE DWG M08-CDP119

NOTES:

1. REMOVE EXISTING STORM DRAINS AND DRAINAGE STRUCTURES AT CONFLICTS WITH PROPOSED STORM DRAIN, PROPOSED DRAINAGE STRUCTURES, OR PROPOSED STORMWATER FACILITIES. RELOCATE STORM DRAINS OR REPLACE EXISTING DRAINAGE STRUCTURES AS REQUIRED.
2. ALL PROPOSED UNDERGROUND STORM DRAIN 12-INCH DIAMETER UNLESS NOTED OTHERWISE.

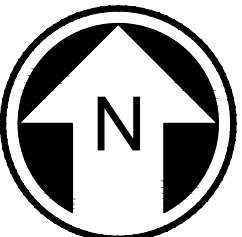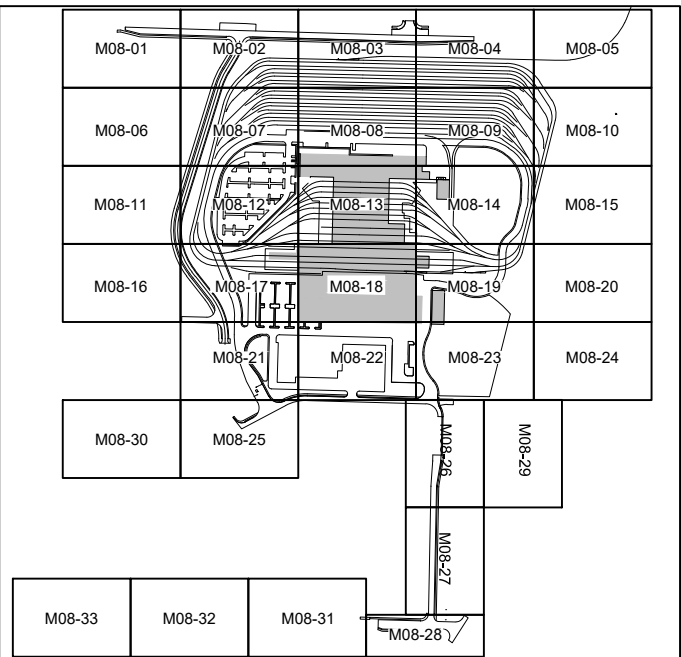

NOT FOR
CONSTRUCTION



Refer to the plan set COVER drawing
for disclaimers regarding this drawing.

MATCHLINE:
SEE DWG M08-CDP122

REFERENCE CONCEPT DRAWINGS

No.	DATE	DSN	CHK	APP	REVISION

DESIGNED BY:
L. GRABOWSKI
DRAWN BY:
B. WILLIAMS
CHECKED BY:
J. WRIGHT
APPROVED BY:
J.COOP

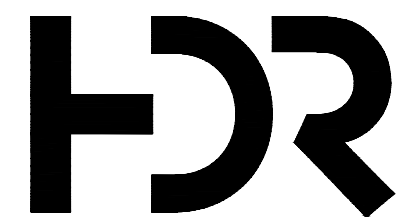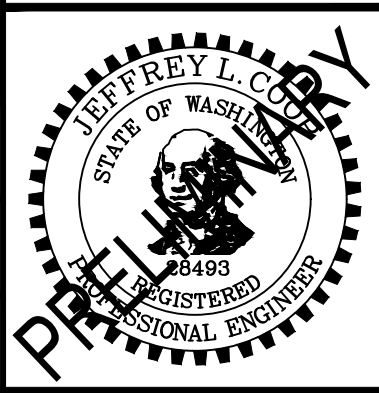

SUBMITTED BY:
PABLO LOPEZ-HILFIKER

DATE:
2/27/2024

REVIEWED BY:

LINE IS 1" AT
FULL SCALE



DATE:

PACKAGE #

SCALE:
1"=20'
FILENAME:
OMFS-M08-CDP101-134
CONTRACT No.:
AE-0030-17
DATE:
2/27/2024


**SOUND TRANSIT
PRELIMINARY ENGINEERING PLANS**
OPERATIONS & MAINTENANCE FACILITY SOUTH
CIVIL
DRAINAGE PLAN

DRAWING No.:
M08-CDP118
FACILITY ID:
M08
SHEET No.:
REV:

02/21/24 | 11:59 AM | WILLIBRE
C:\PWORKING\WEST01\D2772718\OMFS-M08-CDP101-134.DWG

MATCHLINE:
SEE DWG M08-CDP118

Refer to the plan set COVER drawing
for disclaimers regarding this drawing.


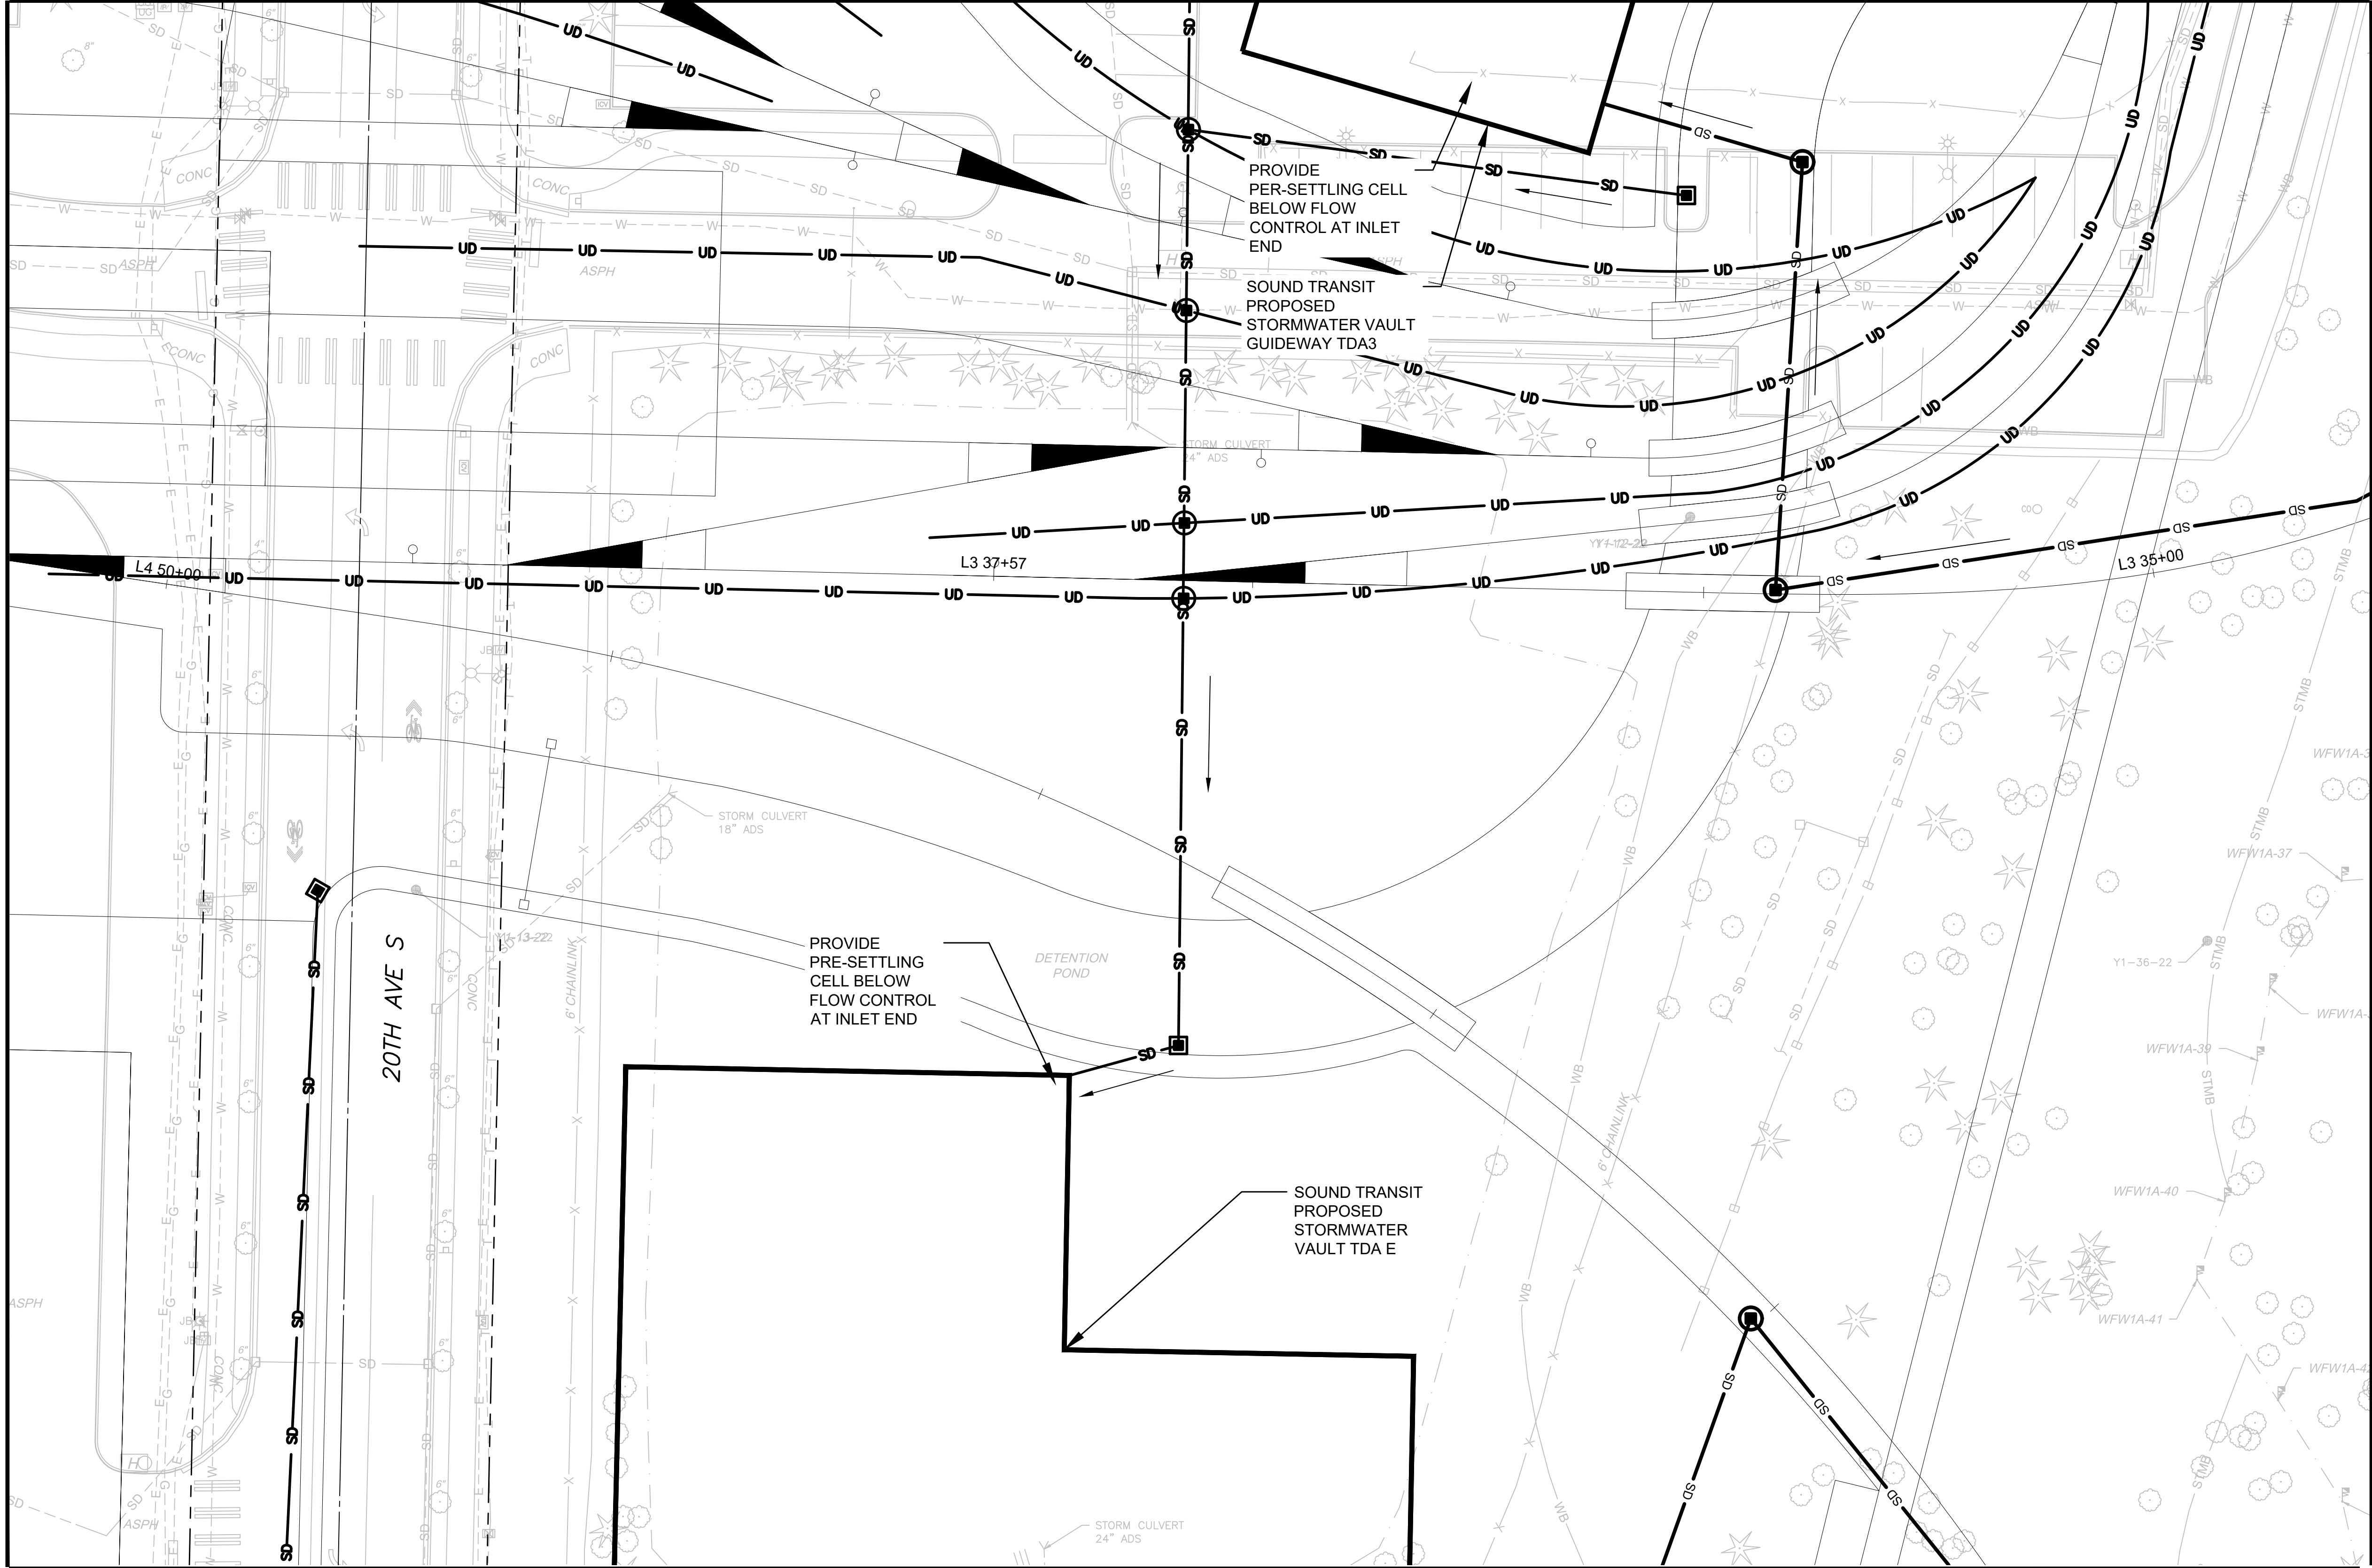


MATCHLINE:
SEE DWG M08-CDP114

MATCHLINE:
SEE DWG M08-CDP120

MATCHLINE:
SEE DWG M08-CDP123

- NOTES:**
1. REMOVE EXISTING STORM DRAINS AND DRAINAGE STRUCTURES AT CONFLICTS WITH PROPOSED STORM DRAIN, PROPOSED DRAINAGE STRUCTURES, OR PROPOSED STORMWATER FACILITIES. RELOCATE STORM DRAINS OR REPLACE EXISTING DRAINAGE STRUCTURES AS REQUIRED.
 2. ALL PROPOSED UNDERGROUND STORM DRAIN 12-INCH DIAMETER UNLESS NOTED OTHERWISE.

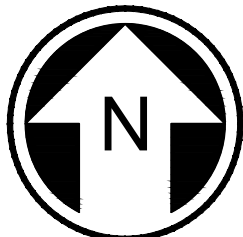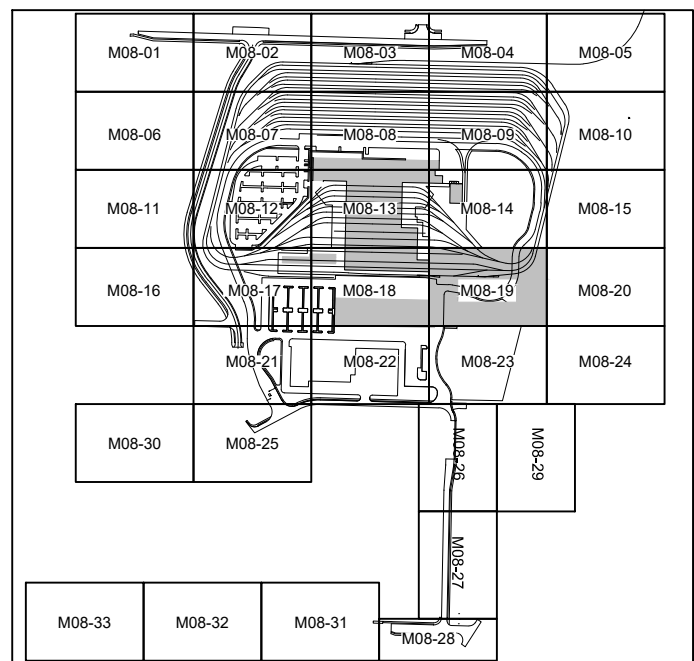



20 10 0 20 40
SCALE IN FEET

NOT FOR
CONSTRUCTION

REFERENCE CONCEPT DRAWINGS

No.	DATE	DSN	CHK	APP	REVISION

DESIGNED BY:
L. GRABOWSKI
DRAWN BY:
B. WILLIAMS
CHECKED BY:
J. WRIGHT
APPROVED BY:
J.COOP

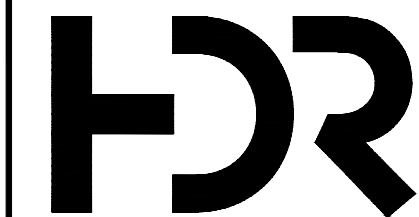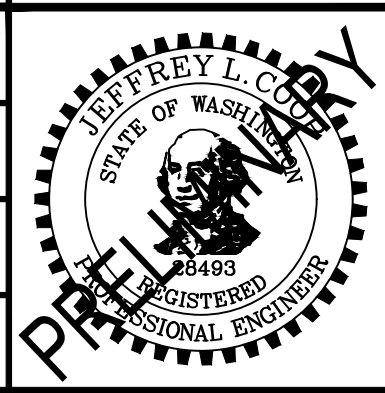

SUBMITTED BY:
PABLO LOPEZ-HILFIKER

DATE:
2/27/2024

REVIEWED BY:



DATE:

PACKAGE

SCALE:
1"=20'
FILENAME:
OMFS-M08-CDP101-134
CONTRACT No.:
AE-0030-17
DATE:
2/27/2024

**SOUND TRANSIT
PRELIMINARY ENGINEERING PLANS**
OPERATIONS & MAINTENANCE FACILITY SOUTH

CIVIL
DRAINAGE PLAN



DRAWING No.:
M08-CDP119
FACILITY ID:
M08
SHEET No.:
REV:

MATCHLINE:
SEE DWG M08-CDP115

NOTES:

1. REMOVE EXISTING STORM DRAINS AND DRAINAGE STRUCTURES AT CONFLICTS WITH PROPOSED STORM DRAIN, PROPOSED DRAINAGE STRUCTURES, OR PROPOSED STORMWATER FACILITIES. RELOCATE STORM DRAINS OR REPLACE EXISTING DRAINAGE STRUCTURES AS REQUIRED.
2. ALL PROPOSED UNDERGROUND STORM DRAIN 12-INCH DIAMETER UNLESS NOTED OTHERWISE.

MATCHLINE:
SEE DWG M08-CDP119

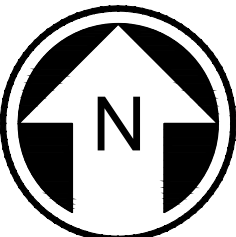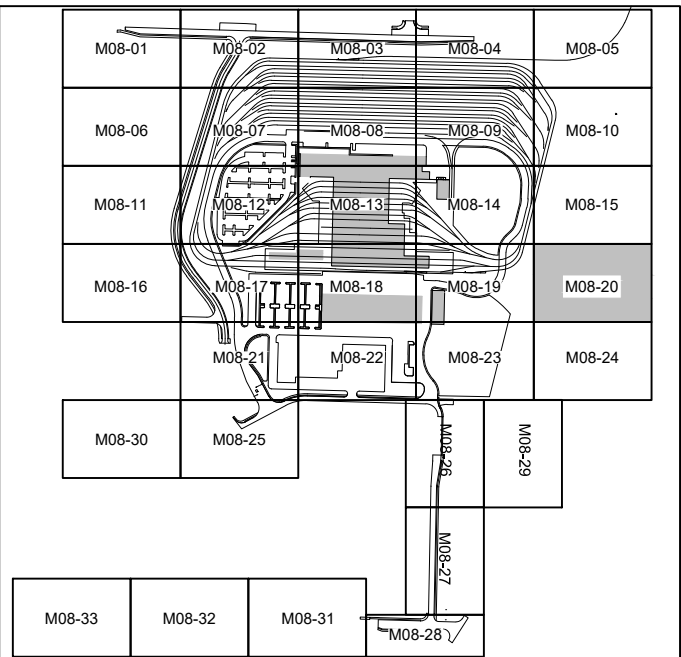

NOT FOR
CONSTRUCTION



MATCHLINE:
SEE DWG M08-CDP124

Refer to the plan set COVER drawing
for disclaimers regarding this drawing.

REFERENCE CONCEPT DRAWINGS

No.	DATE	DSN	CHK	APP	REVISION

DESIGNED BY:
L. GRABOWSKI
DRAWN BY:
B. WILLIAMS
CHECKED BY:
J. WRIGHT
APPROVED BY:
J.COOP

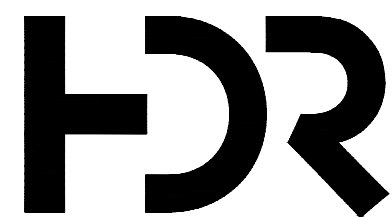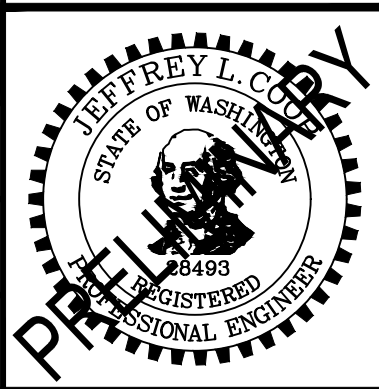

SUBMITTED BY:
PABLO LOPEZ-HILFIKER

DATE:
2/27/2024

REVIEWED BY:



DATE:

PACKAGE #

SCALE:
1"=20'
FILENAME:
OMFS-M08-CDP101-134
CONTRACT No.:
AE-0030-17
DATE:
2/27/2024

SOUND TRANSIT
PRELIMINARY ENGINEERING PLANS
OPERATIONS & MAINTENANCE FACILITY SOUTH
CIVIL
DRAINAGE PLAN


DRAWING No.:
M08-CDP120
FACILITY ID:
M08
SHEET No.: REV:


02/21/24 | 12:00 PM | WILLIBRE
C:\PWORKING\WEST01\DWG\OMFS-M08-CDP101-134.DWG

Refer to the plan set COVER drawing
for disclaimers regarding this drawing.

REFERENCE CONCEPT DRAWINGS					
No.	DATE	DSN	CHK	APP	REVISION

DESIGNED BY:	L. GRABOWSKI
DRAWN BY:	B. WILLIAMS
CHECKED BY:	J. WRIGHT
APPROVED BY:	J.COOP

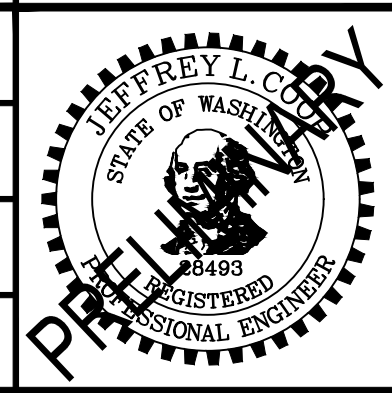

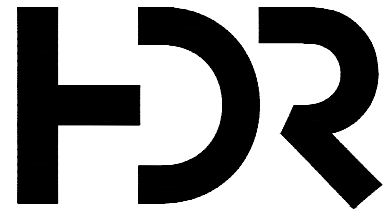

SUBMITTED BY:

PABLO LOPEZ-HILFIKER

DATE:

2/27/2024

REVIEWED BY:



DATE:

2/27/2024

PACKAGE #

SCALE: 1"=20'

FILENAME: OMFS-M08-CDP101-134

CONTRACT No.: AE-0030-17


DATE: 2/27/2024

SOUND TRANSIT
PRELIMINARY ENGINEERING PLANS
OPERATIONS & MAINTENANCE FACILITY SOUTH

CIVIL
DRAINAGE PLAN

DRAWING No.:	M08-CDP121
FACILITY ID:	M08
SHEET No.:	REV:

MATCHLINE:
SEE DWG M08-CDP117


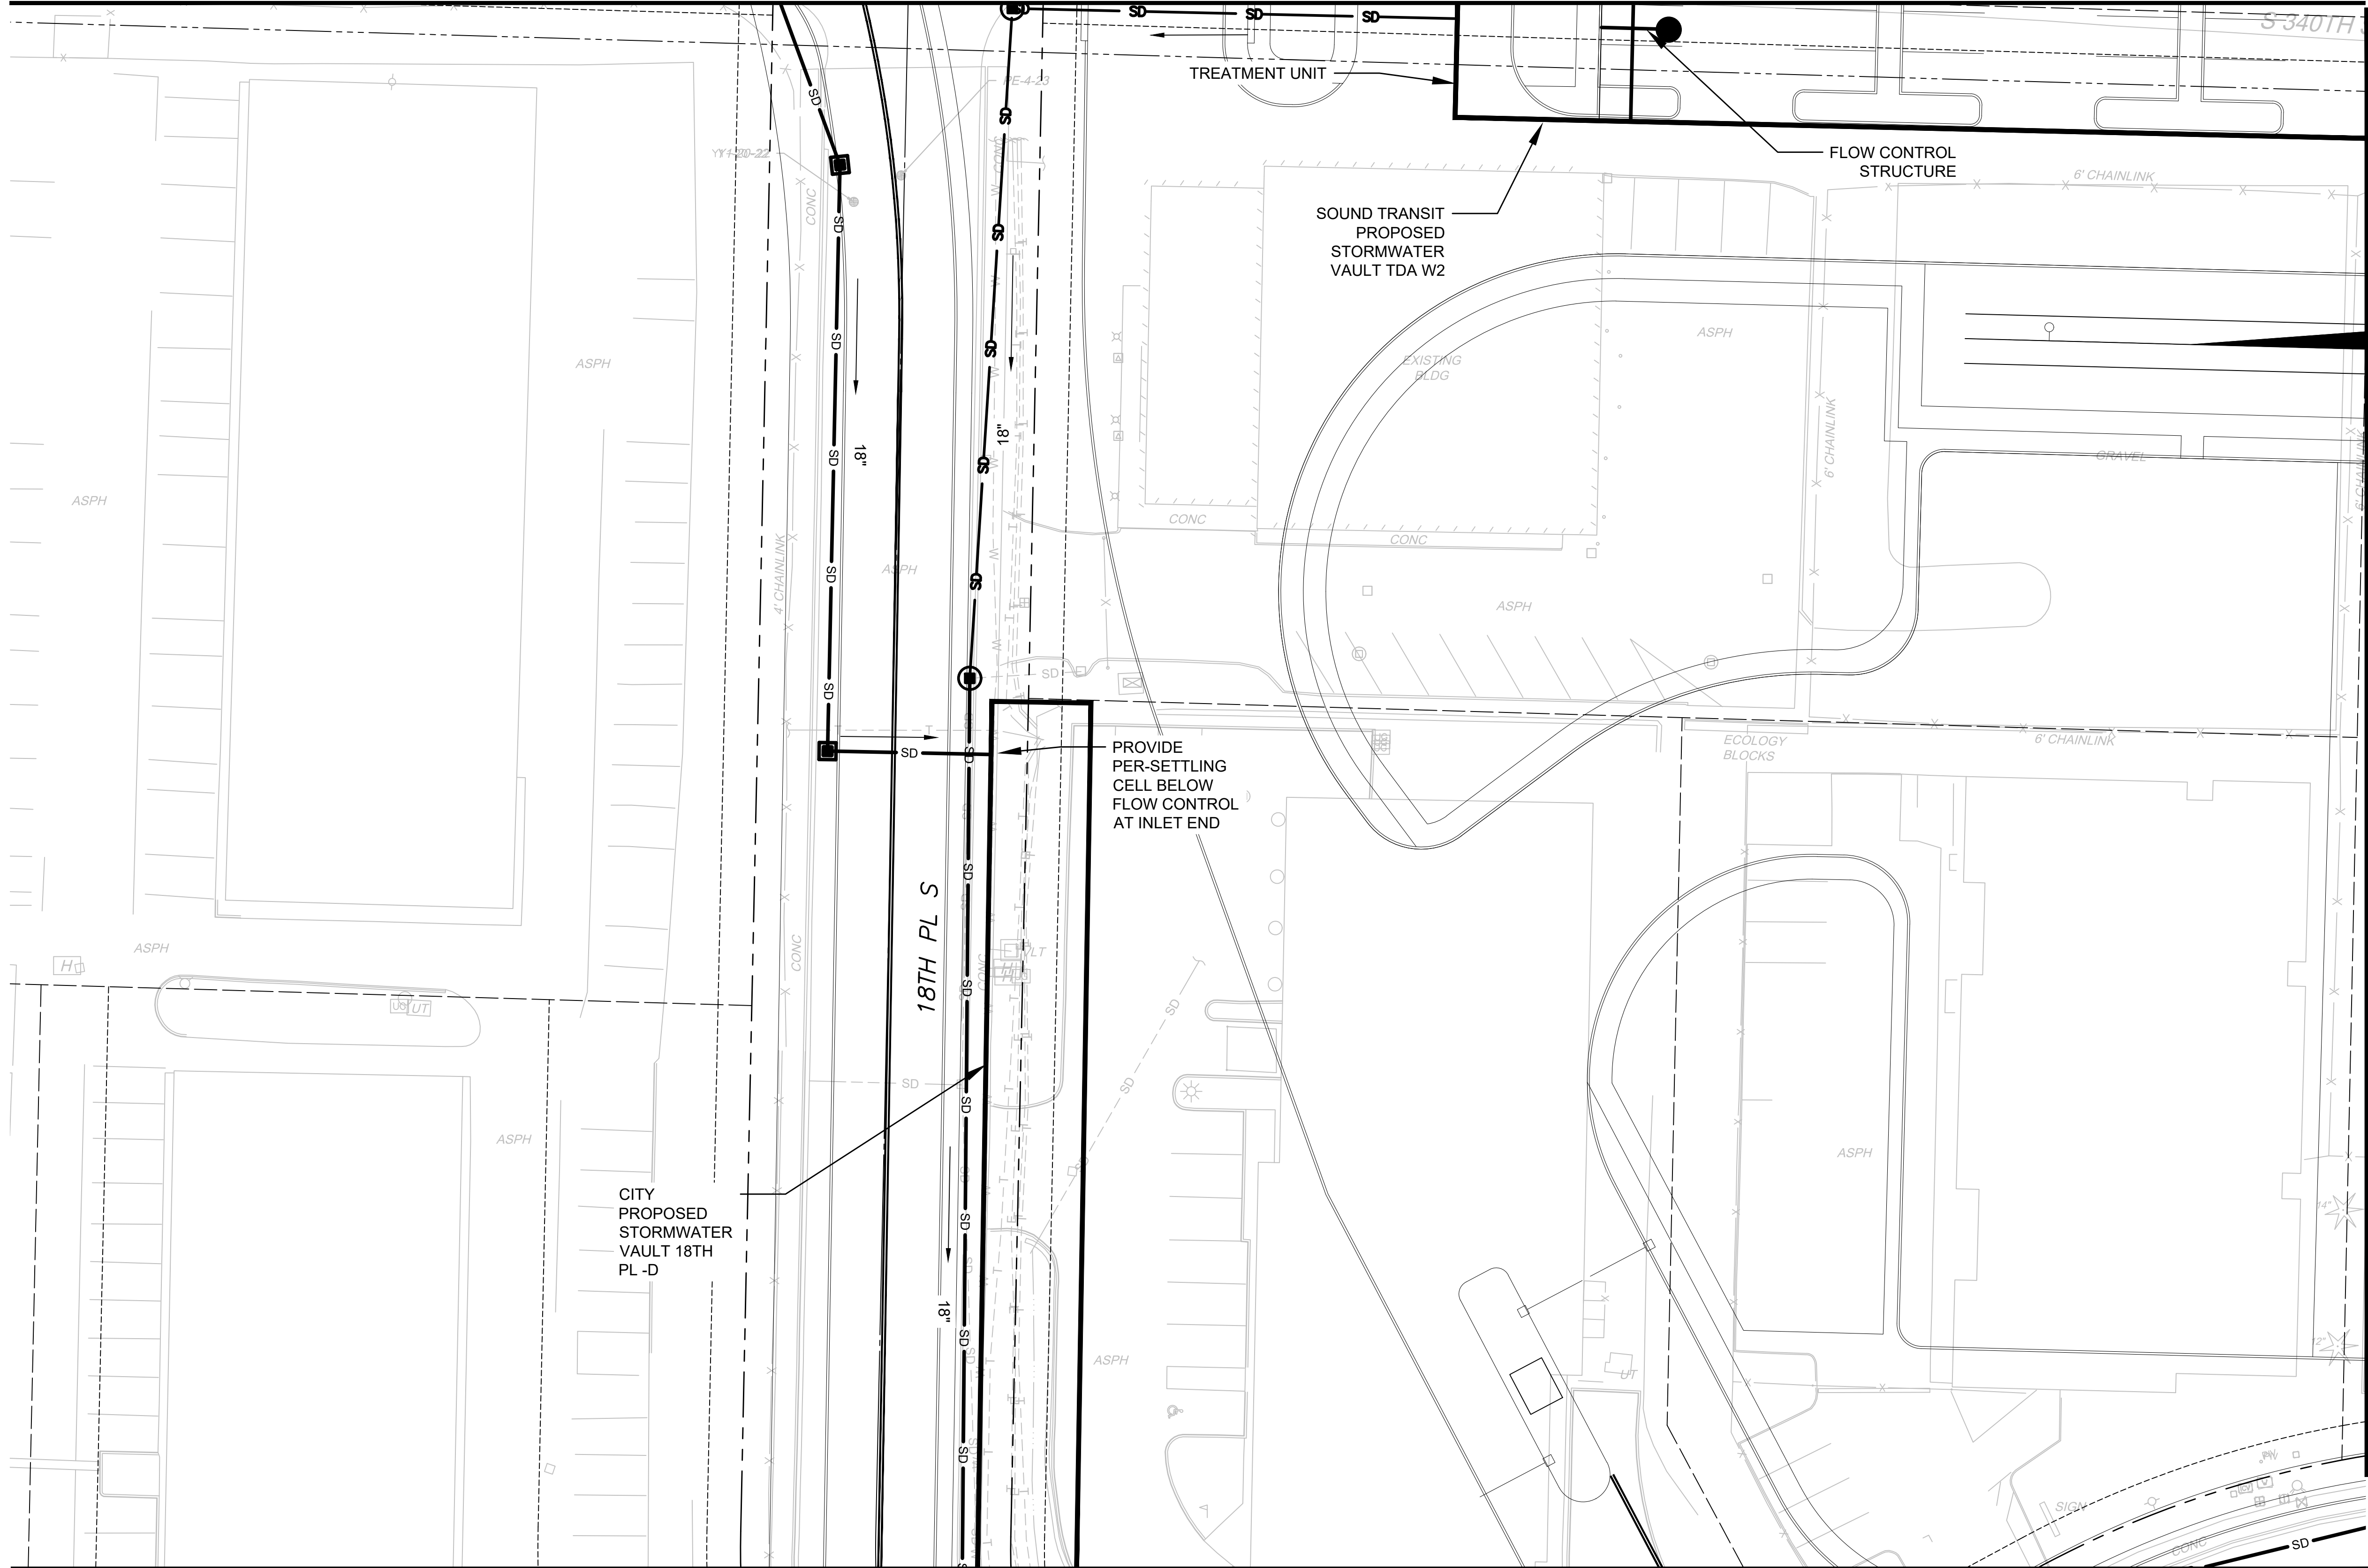


MATCHLINE:
SEE DWG M08-CDP125

NOTES:

1. REMOVE EXISTING STORM DRAINS AND DRAINAGE STRUCTURES AT CONFLICTS WITH PROPOSED STORM DRAIN, PROPOSED DRAINAGE STRUCTURES, OR PROPOSED STORMWATER FACILITIES. RELOCATE STORM DRAINS OR REPLACE EXISTING DRAINAGE STRUCTURES AS REQUIRED.
2. ALL PROPOSED UNDERGROUND STORM DRAIN 12-INCH DIAMETER UNLESS NOTED OTHERWISE.

MATCHLINE:
SEE DWG M08-CDP122

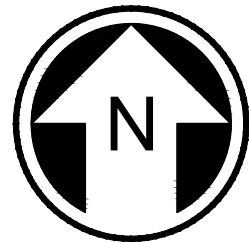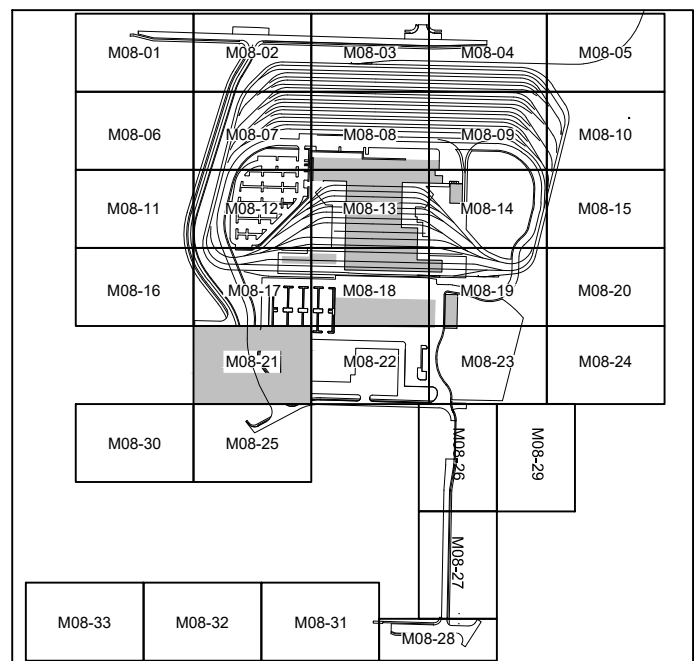

NOT FOR
CONSTRUCTION



MATCHLINE:
SEE DWG M08-CDP118

NOTES:

1. REMOVE EXISTING STORM DRAINS AND DRAINAGE STRUCTURES AT CONFLICTS WITH PROPOSED STORM DRAIN, PROPOSED DRAINAGE STRUCTURES, OR PROPOSED STORMWATER FACILITIES. RELOCATE STORM DRAINS OR REPLACE EXISTING DRAINAGE STRUCTURES AS REQUIRED.
2. ALL PROPOSED UNDERGROUND STORM DRAIN 12-INCH DIAMETER UNLESS NOTED OTHERWISE.

MATCHLINE:
SEE DWG M08-CDP121

MATCHLINE:
SEE DWG M08-CDP123

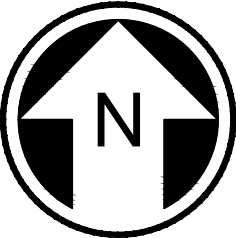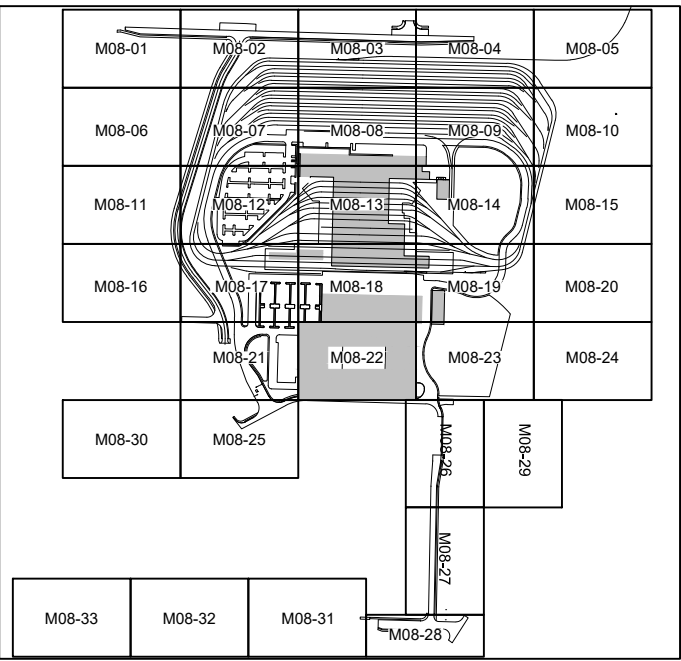

NOT FOR
CONSTRUCTION



MATCHLINE:
SEE DWG M08-CDP126

Refer to the plan set COVER drawing
for disclaimers regarding this drawing.

REFERENCE CONCEPT DRAWINGS

No.	DATE	DSN	CHK	APP	REVISION

DESIGNED BY:
L. GRABOWSKI
DRAWN BY:
B. WILLIAMS
CHECKED BY:
J. WRIGHT
APPROVED BY:
J.COOP

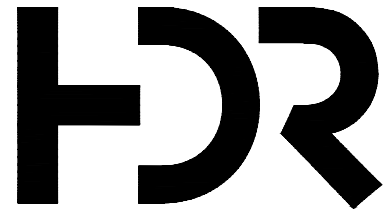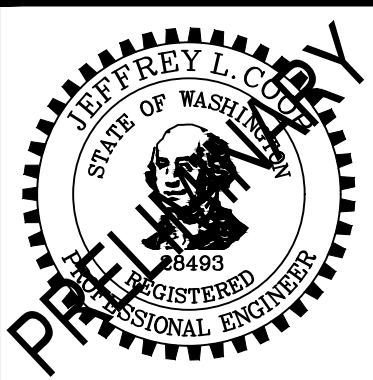

SUBMITTED BY:
PABLO LOPEZ-HILFIKER

DATE:
2/27/2024

REVIEWED BY:

LINE IS 1" AT
FULL SCALE



DATE:

PACKAGE #

SCALE:
1"=20'
FILENAME:
OMFS-M08-CDP101-134
CONTRACT No.:
AE-0030-17
DATE:
2/27/2024

**SOUND TRANSIT
PRELIMINARY ENGINEERING PLANS**
OPERATIONS & MAINTENANCE FACILITY SOUTH

CIVIL
DRAINAGE PLAN

DRAWING No.:
M08-CDP122
FACILITY ID:
M08
SHEET No.: REV:

**MATCHLINE:
SEE DWG M08-CDP120**

NOTES:



1. REMOVE EXISTING STORM DRAINS AND DRAINAGE STRUCTURES AT CONFLICTS WITH PROPOSED STORM DRAIN. PROPOSED DRAINAGE STRUCTURES, OR PROPOSED STORMWATER FACILITIES, RELOCATE STORM DRAINS OR REPLACE EXISTING DRAINAGE STRUCTURES AS REQUIRED.
2. ALL PROPOSED UNDERGROUND STORM DRAIN 12-INCH DIAMETER UNLESS NOTED OTHERWISE.

**MATCHLINE:
SEE DWG M08-CDP123**

PRESERVE AND PROTECT
EXISTING STORM SYSTEM IN
TEMPORARY AND PERMANENT
EASEMENT AREAS

↑ NB 1-5

SB 1-5 →

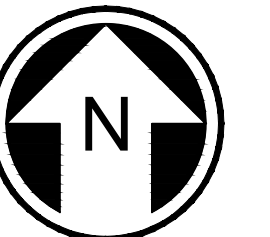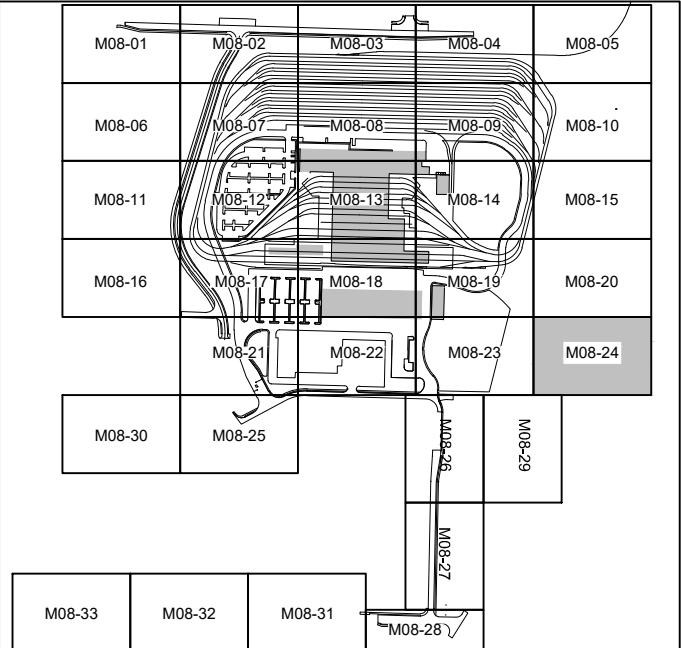

20 10 0 20 40

SCALE IN FEET



NOT FOR
CONSTRUCTION

*Refer to the plan set COVER drawing
for disclaimers regarding this drawing*

REFERENCE CONCEPT DRAWINGS

No.	DATE	DSN	CHK	APP	REVISION

DESIGNED BY:	L. GRABOWSKI
DRAWN BY:	B. WILLIAMS
CHECKED BY:	J. WRIGHT
APPROVED BY:	J. COOP

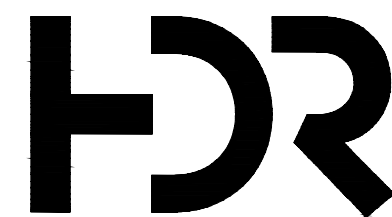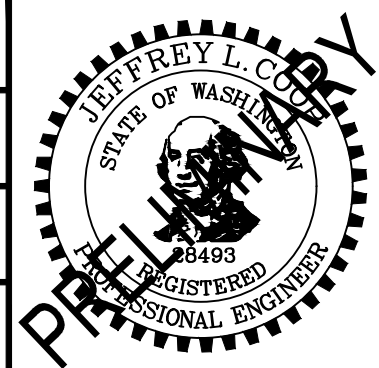SUBMITTED BY:
PABLO LOPEZ-HILFIKER

DATE:
2/27/2024

REVIEWED BY

LINE IS 1" AT
FULL SCALE

**PACKAGE #**

SCALE:
1"=20'
FILENAME:
OMFS-M08-CDP101-13
CONTRACT No.:
AE-0030-17
DATE:
2/27/2024

SOUND TRANSIT
PRELIMINARY ENGINEERING PLANS
OPERATIONS & MAINTENANCE FACILITY SOUTH


CIVIL
DRAINAGE PLAN

RAWING No.:
M08-CDP124
FACILITY ID:
M08
SHEET No.: REV:

02/23/24 | 5:23 PM | GRABOLEN
C:\PWORKING\WEST01\2772718\OMFS-M08-CDP-01-134.DWG



MATCHLINE:
SEE DWG M08-CDP130

MATCHLINE:
SEE DWG M08-CDP121

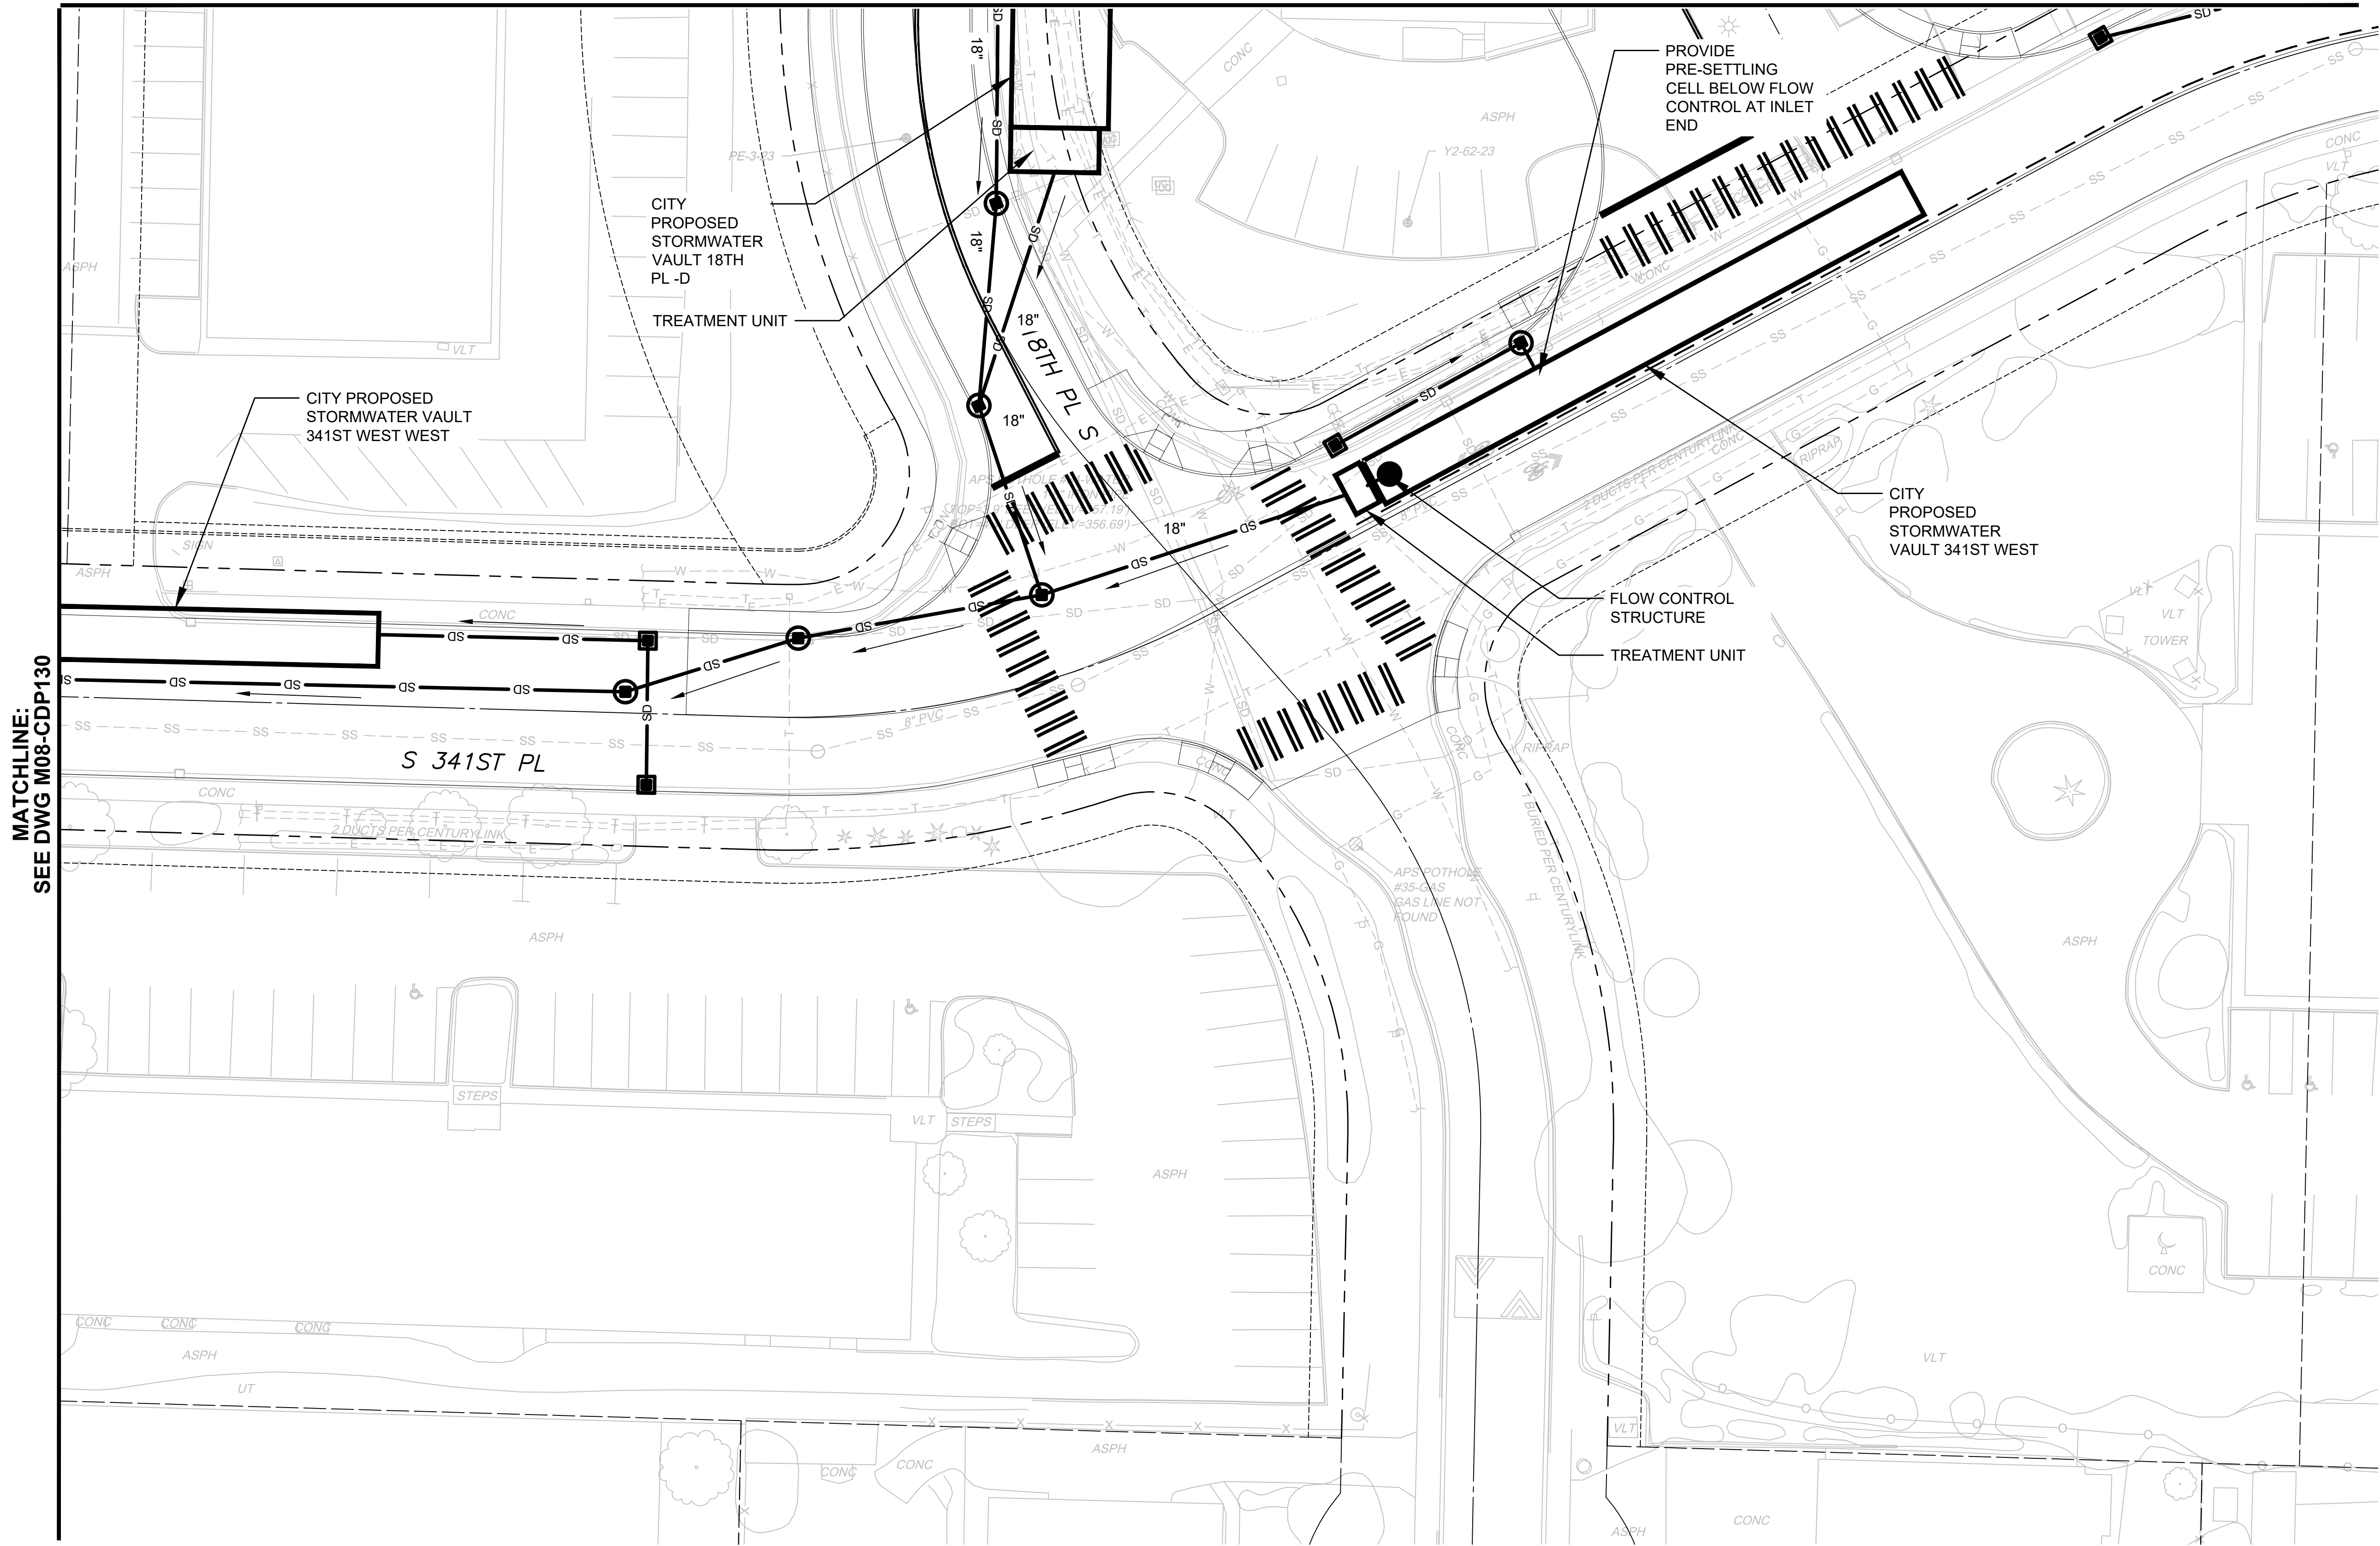

NOTES:

1. REMOVE EXISTING STORM DRAINS AND DRAINAGE STRUCTURES AT CONFLICTS WITH PROPOSED STORM DRAIN, PROPOSED DRAINAGE STRUCTURES, OR PROPOSED STORMWATER FACILITIES. RELOCATE STORM DRAINS OR REPLACE EXISTING DRAINAGE STRUCTURES AS REQUIRED.
2. ALL PROPOSED UNDERGROUND STORM DRAIN 12-INCH DIAMETER UNLESS NOTED OTHERWISE.

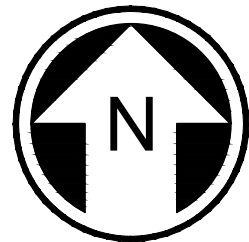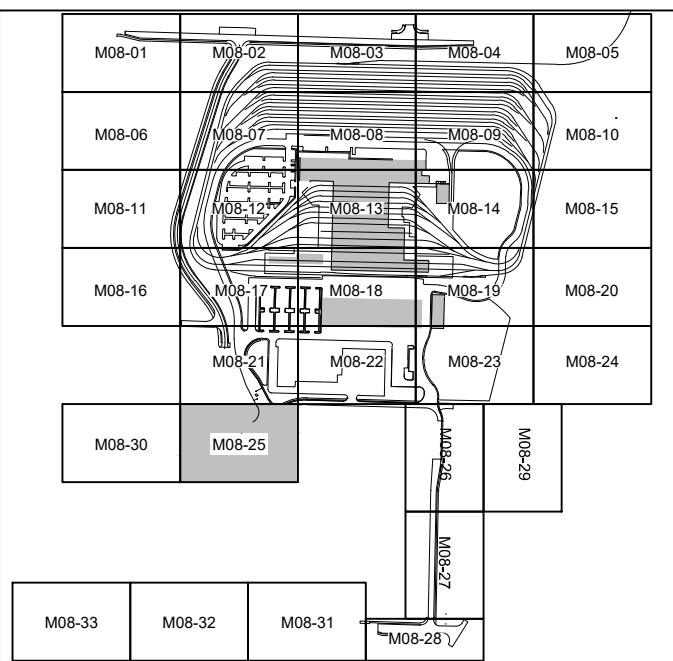


NOT FOR
CONSTRUCTION

Refer to the plan set COVER drawing
for disclaimers regarding this drawing.

REFERENCE CONCEPT DRAWINGS					
No.	DATE	DSN	CHK	APP	REVISION

DESIGNED BY:	L. GRABOWSKI
DRAWN BY:	B. WILLIAMS
CHECKED BY:	J. WRIGHT
APPROVED BY:	J.COOP

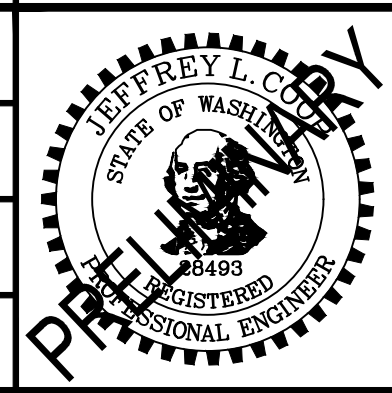


SUBMITTED BY:
PABLO LOPEZ-HILFIKER

DATE:
2/27/2024

REVIEWED BY:

LINE IS 1" AT
FULL SCALE

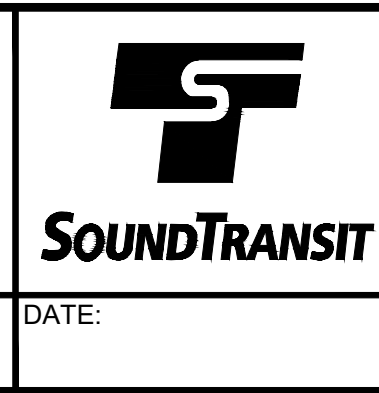

DATE:

PACKAGE #
SCALE: 1"=20'
FILENAME: OMFS-M08-CDP101-134
CONTRACT No.: AE-0030-17
DATE: 2/27/2024

SOUND TRANSIT
PRELIMINARY ENGINEERING PLANS
OPERATIONS & MAINTENANCE FACILITY SOUTH


CIVIL
DRAINAGE PLAN

DRAWING No.:	M08-CDP125
FACILITY ID:	M08
SHEET No.:	REV:

Refer to the plan set COVER drawing
for disclaimers regarding this drawing.



for disclaimers regarding this drawing.						AHJ:		PACKAGE #		SOUND TRANSIT PRELIMINARY ENGINEERING PLANS OPERATIONS & MAINTENANCE FACILITY SOUTH CIVIL DRAINAGE PLAN				DRAWING No.: M08-CDP126					
REFERENCE CONCEPT DRAWINGS						DESIGNED BY: L. GRABOWSKI		JEFFREY L. COOP STATE OF WASHINGTON 28493 REGISTERED PROFESSIONAL ENGINEER						LINE IS 1" AT FULL SCALE HDR		1"=20' FILENAME: OMFS-M08-CDP101-134 CONTRACT No.: AE-0030-17 DATE: 2/27/2024		FACILITY ID:	
																		M08	
																		SHEET No.: REV:	
No.	DATE	DSN	CHK	APP	REVISION	APPROVED BY: J.COOP		SUBMITTED BY: PABLO LOPEZ-HILFIKER		DATE: 2/27/2024		REVIEWED BY:		DATE: 2/27/2024					

MATCHLINE:
SEE DWG M08-CDP125

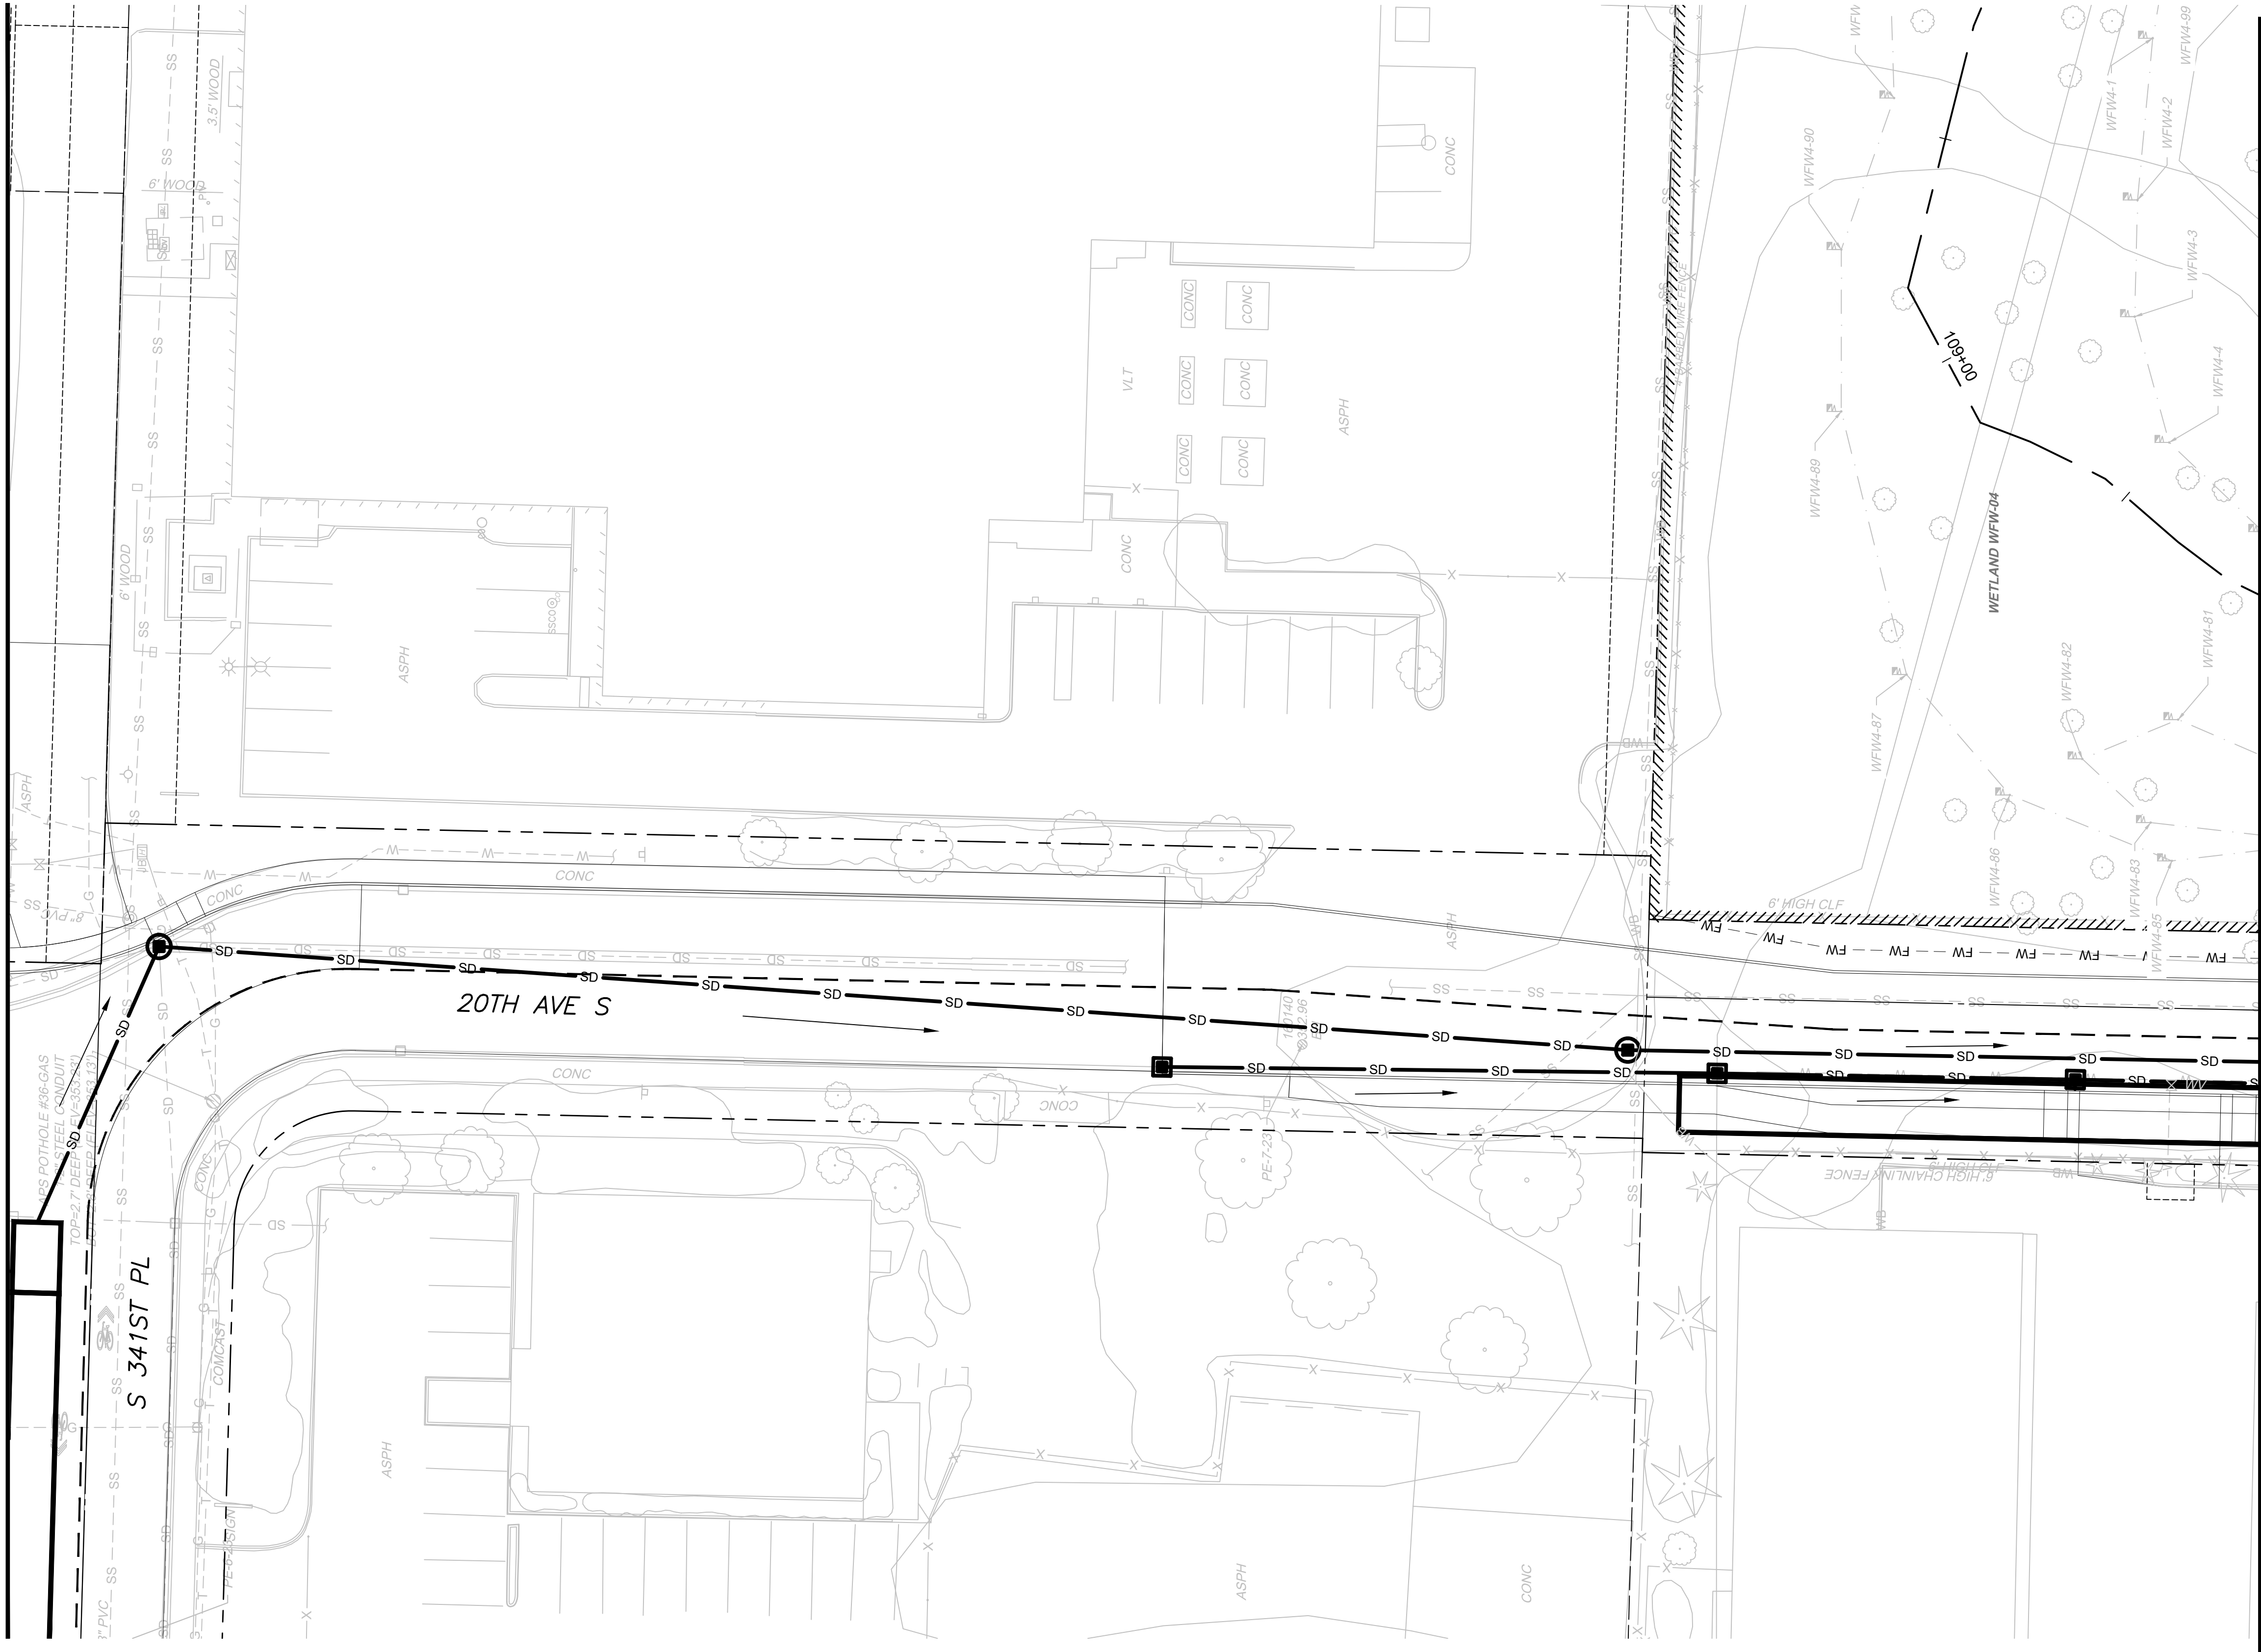

MATCHLINE:
SEE DWG M08-CDP127

- NOTES:**
- REMOVE EXISTING STORM DRAINS AND DRAINAGE STRUCTURES AT CONFLICTS WITH PROPOSED STORM DRAIN, PROPOSED DRAINAGE STRUCTURES, OR PROPOSED STORMWATER FACILITIES. RELOCATE STORM DRAINS OR REPLACE EXISTING DRAINAGE STRUCTURES AS REQUIRED.
 - ALL PROPOSED UNDERGROUND STORM DRAIN 12-INCH DIAMETER UNLESS NOTED OTHERWISE.

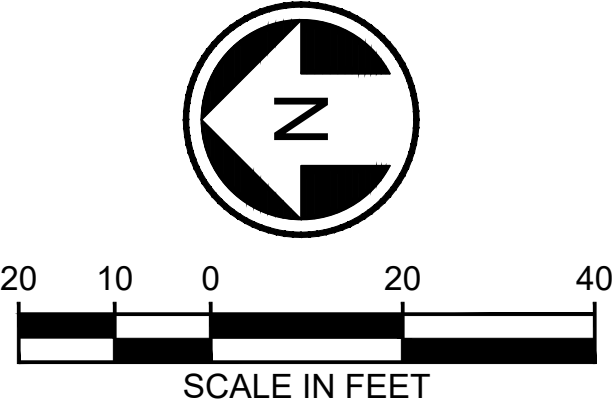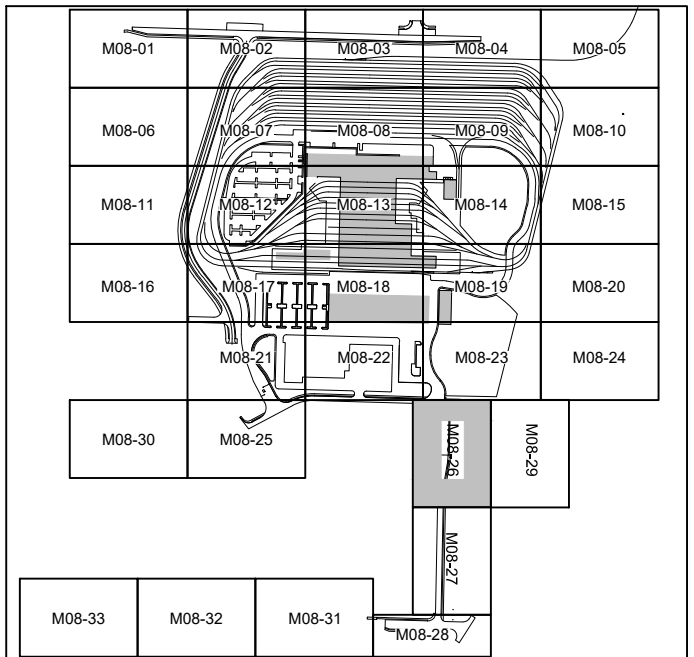


NOT FOR
CONSTRUCTION



02/21/24 | 12:02 PM | WILLIBRE
C:\PWORKING\WEST01\02772718\OMFS-M08-CDP-101-134.DWG

Refer to the plan set COVER drawing
for disclaimers regarding this drawing.

REFERENCE CONCEPT DRAWINGS						DESIGNED BY: L. GRABOWSKI	DRAWN BY: B. WILLIAMS	CHECKED BY: J. WRIGHT	APPROVED BY: J.COOP	AHJ:			SUBMITTED BY: PABLO LOPEZ-HILFIKER	DATE: 2/27/2024	REVIEWED BY:	DATE:		PACKAGE #	SCALE: 1"=20'	FILENAME: OMFS-M08-CDP101-134	CONTRACT No.: AE-0030-17	DATE: 2/27/2024	DRAWING No.: M08-CDP127	FACILITY ID: M08	SHEET No.: REV:	SOUND TRANSIT PRELIMINARY ENGINEERING PLANS OPERATIONS & MAINTENANCE FACILITY SOUTH CIVIL DRAINAGE PLAN																																																																																																																																																																																																																																																																																																																																																																																																																																																																																																																																																																																																																								
No.	DATE	DSN	CHK	APP	REVISION																																																																																																																																																																																																																																																																																																																																																																																																																																																																																																																																																																																																																																													

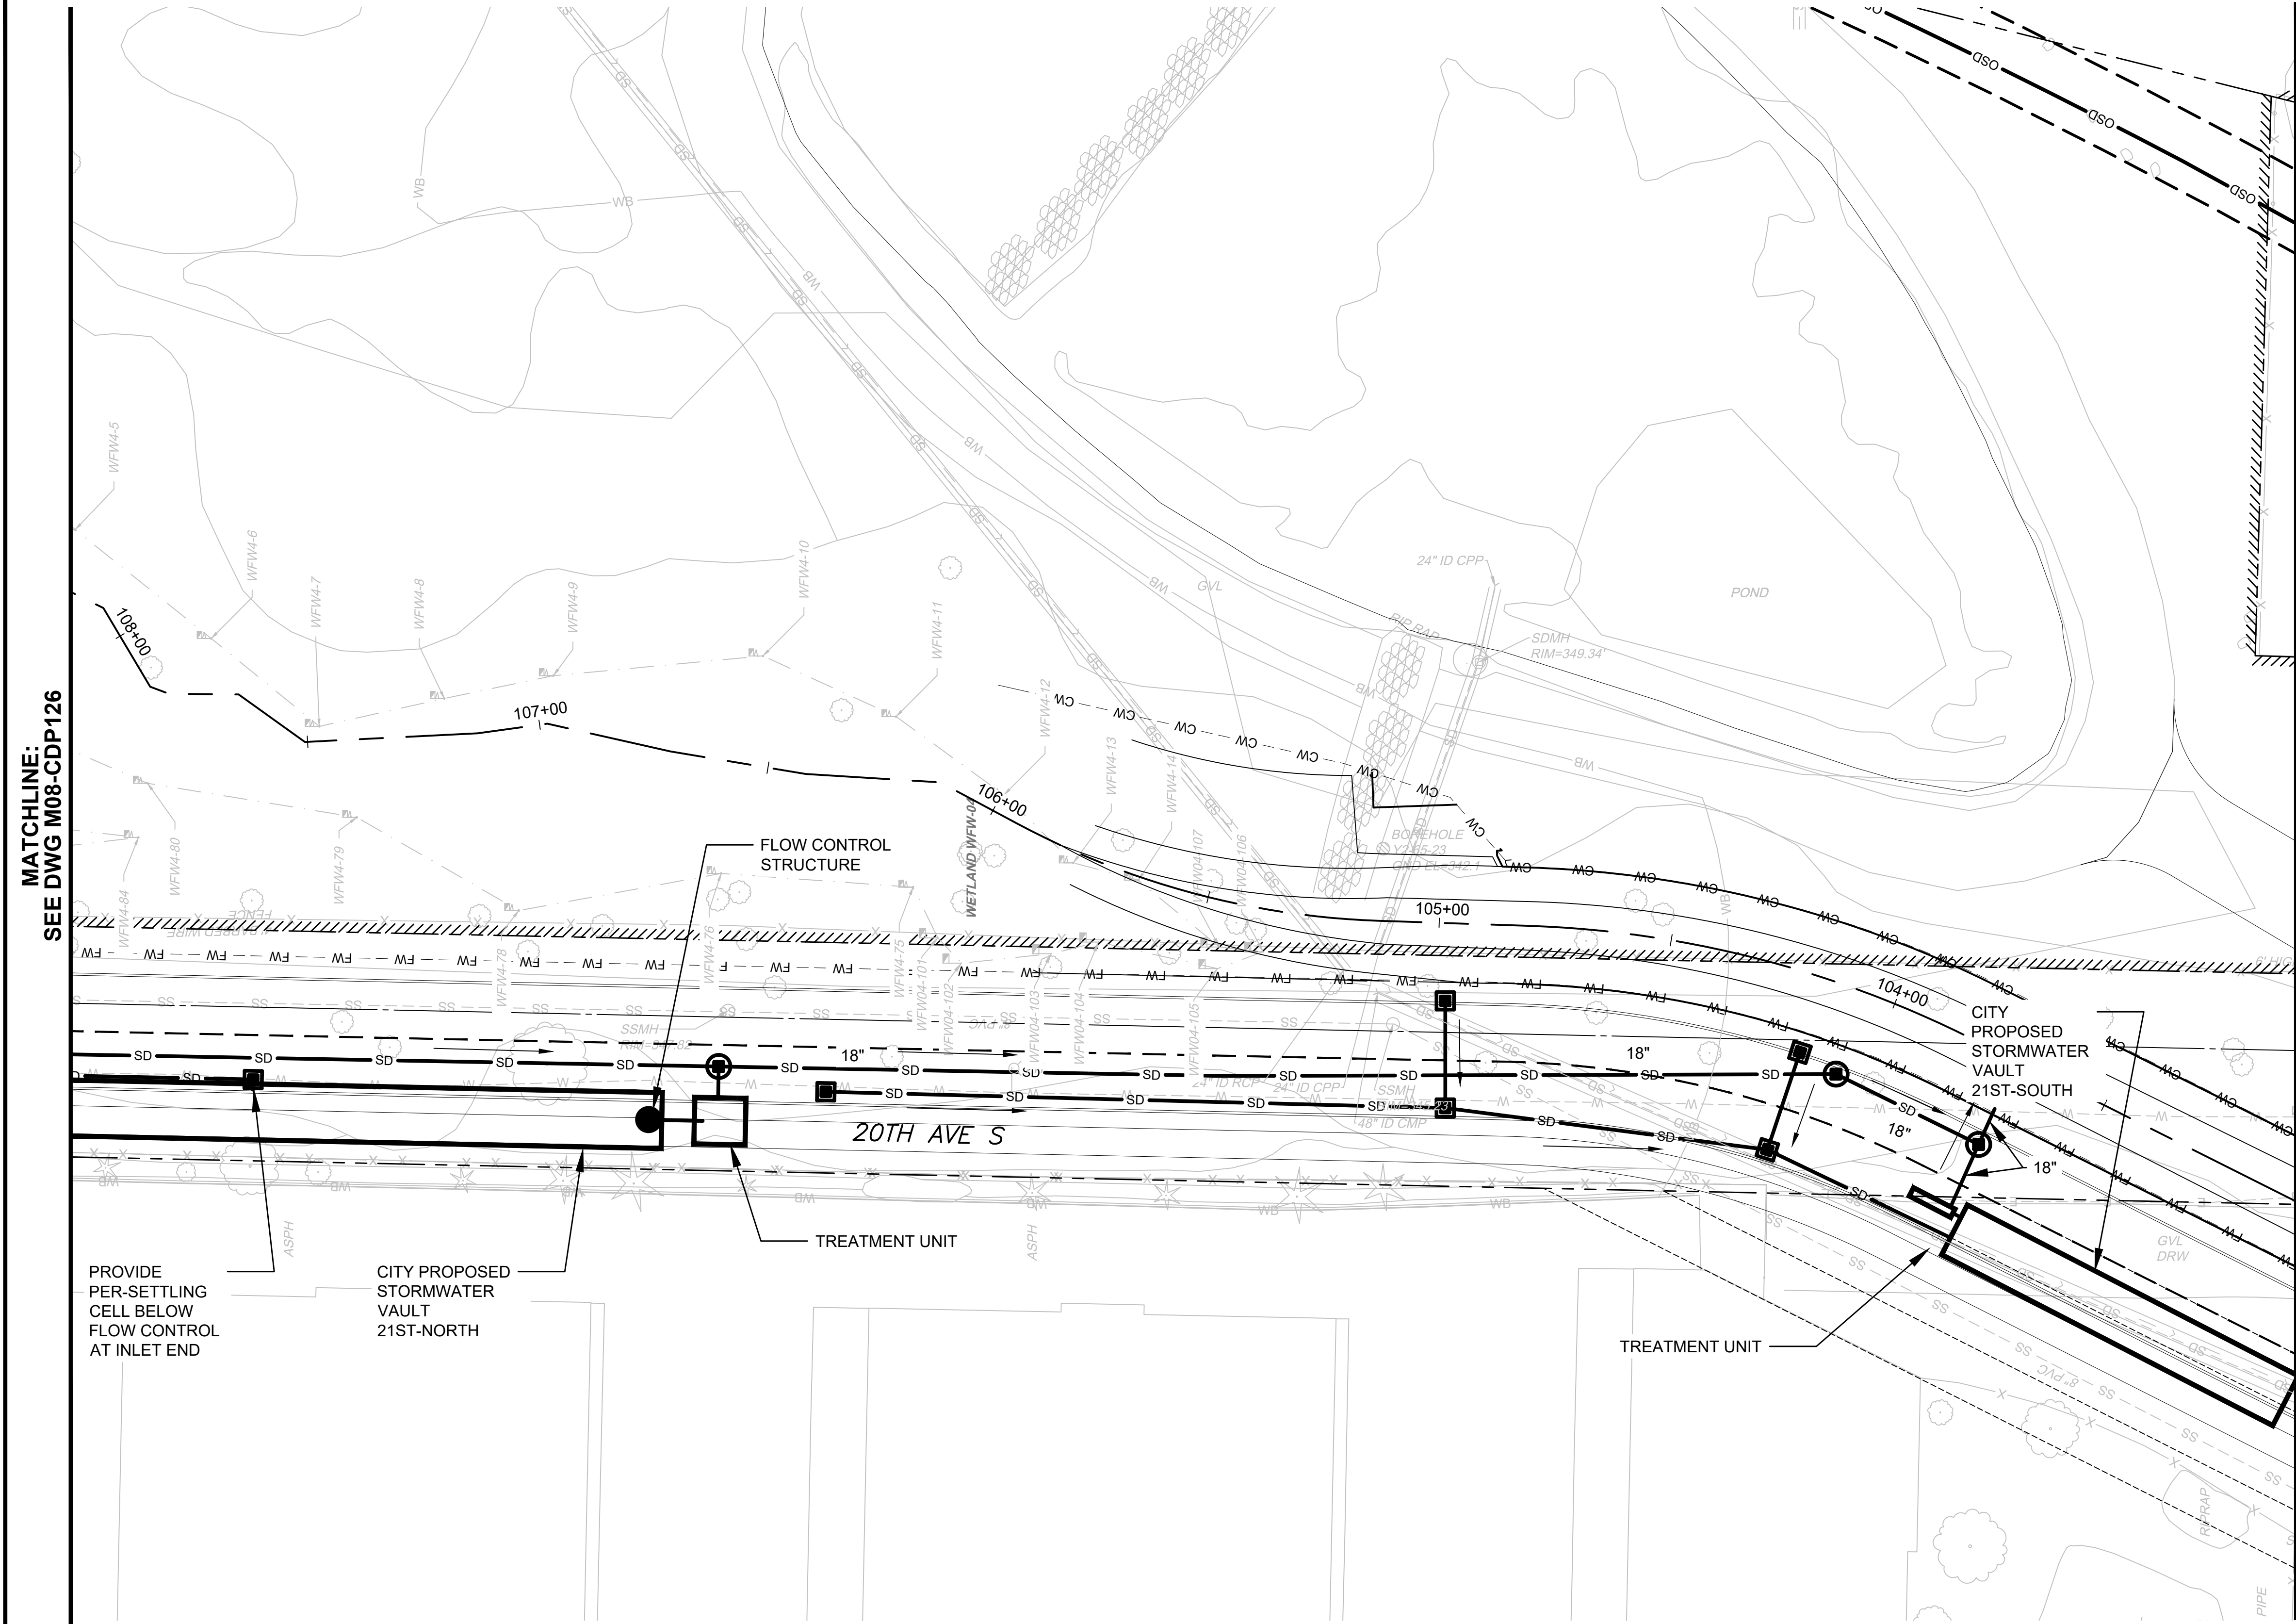

- NOTES:**
1. REMOVE EXISTING STORM DRAINS AND DRAINAGE STRUCTURES AT CONFLICTS WITH PROPOSED STORM DRAIN, PROPOSED DRAINAGE STRUCTURES, OR PROPOSED STORMWATER FACILITIES. RELOCATE STORM DRAINS OR REPLACE EXISTING DRAINAGE STRUCTURES AS REQUIRED.
 2. ALL PROPOSED UNDERGROUND STORM DRAIN 12-INCH DIAMETER UNLESS NOTED OTHERWISE.

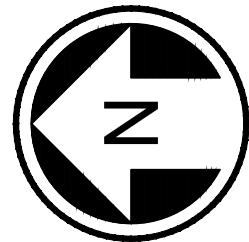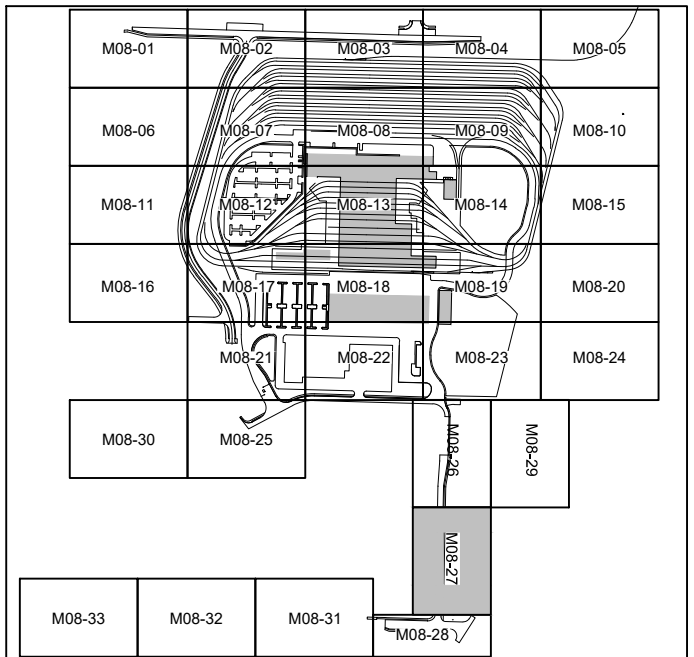


NOT FOR
CONSTRUCTION

02/23/24 | 10:04 AM | WILLIBRE
C:\PWORKING\WEST01\2727718\OMFS-M08-CDP-01-134.DWG

Refer to the plan set COVER drawing
for disclaimers regarding this drawing.

REFERENCE CONCEPT DRAWINGS					
No.	DATE	DSN	CHK	APP	REVISION

DESIGNED BY:	L. GRABOWSKI
DRAWN BY:	B. WILLIAMS
CHECKED BY:	J. WRIGHT
APPROVED BY:	J.COOP

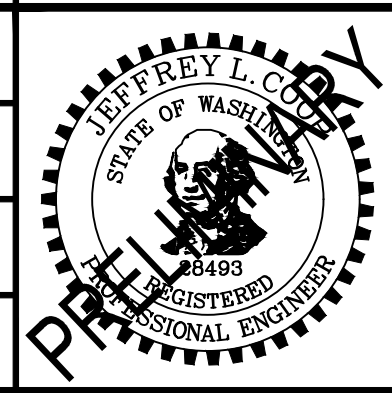

SUBMITTED BY:
PABLO LOPEZ-HILFIKER

DATE:
2/27/2024

REVIEWED BY:




DATE:

PACKAGE #
SCALE: 1"=20'
FILENAME: OMFS-M08-CDP101-134
CONTRACT No.: AE-0030-17
DATE: 2/27/2024



SOUND TRANSIT
PRELIMINARY ENGINEERING PLANS
OPERATIONS & MAINTENANCE FACILITY SOUTH

CIVIL
DRAINAGE PLAN

DRAWING No.:	M08-CDP128
FACILITY ID:	M08
SHEET No.:	REV:

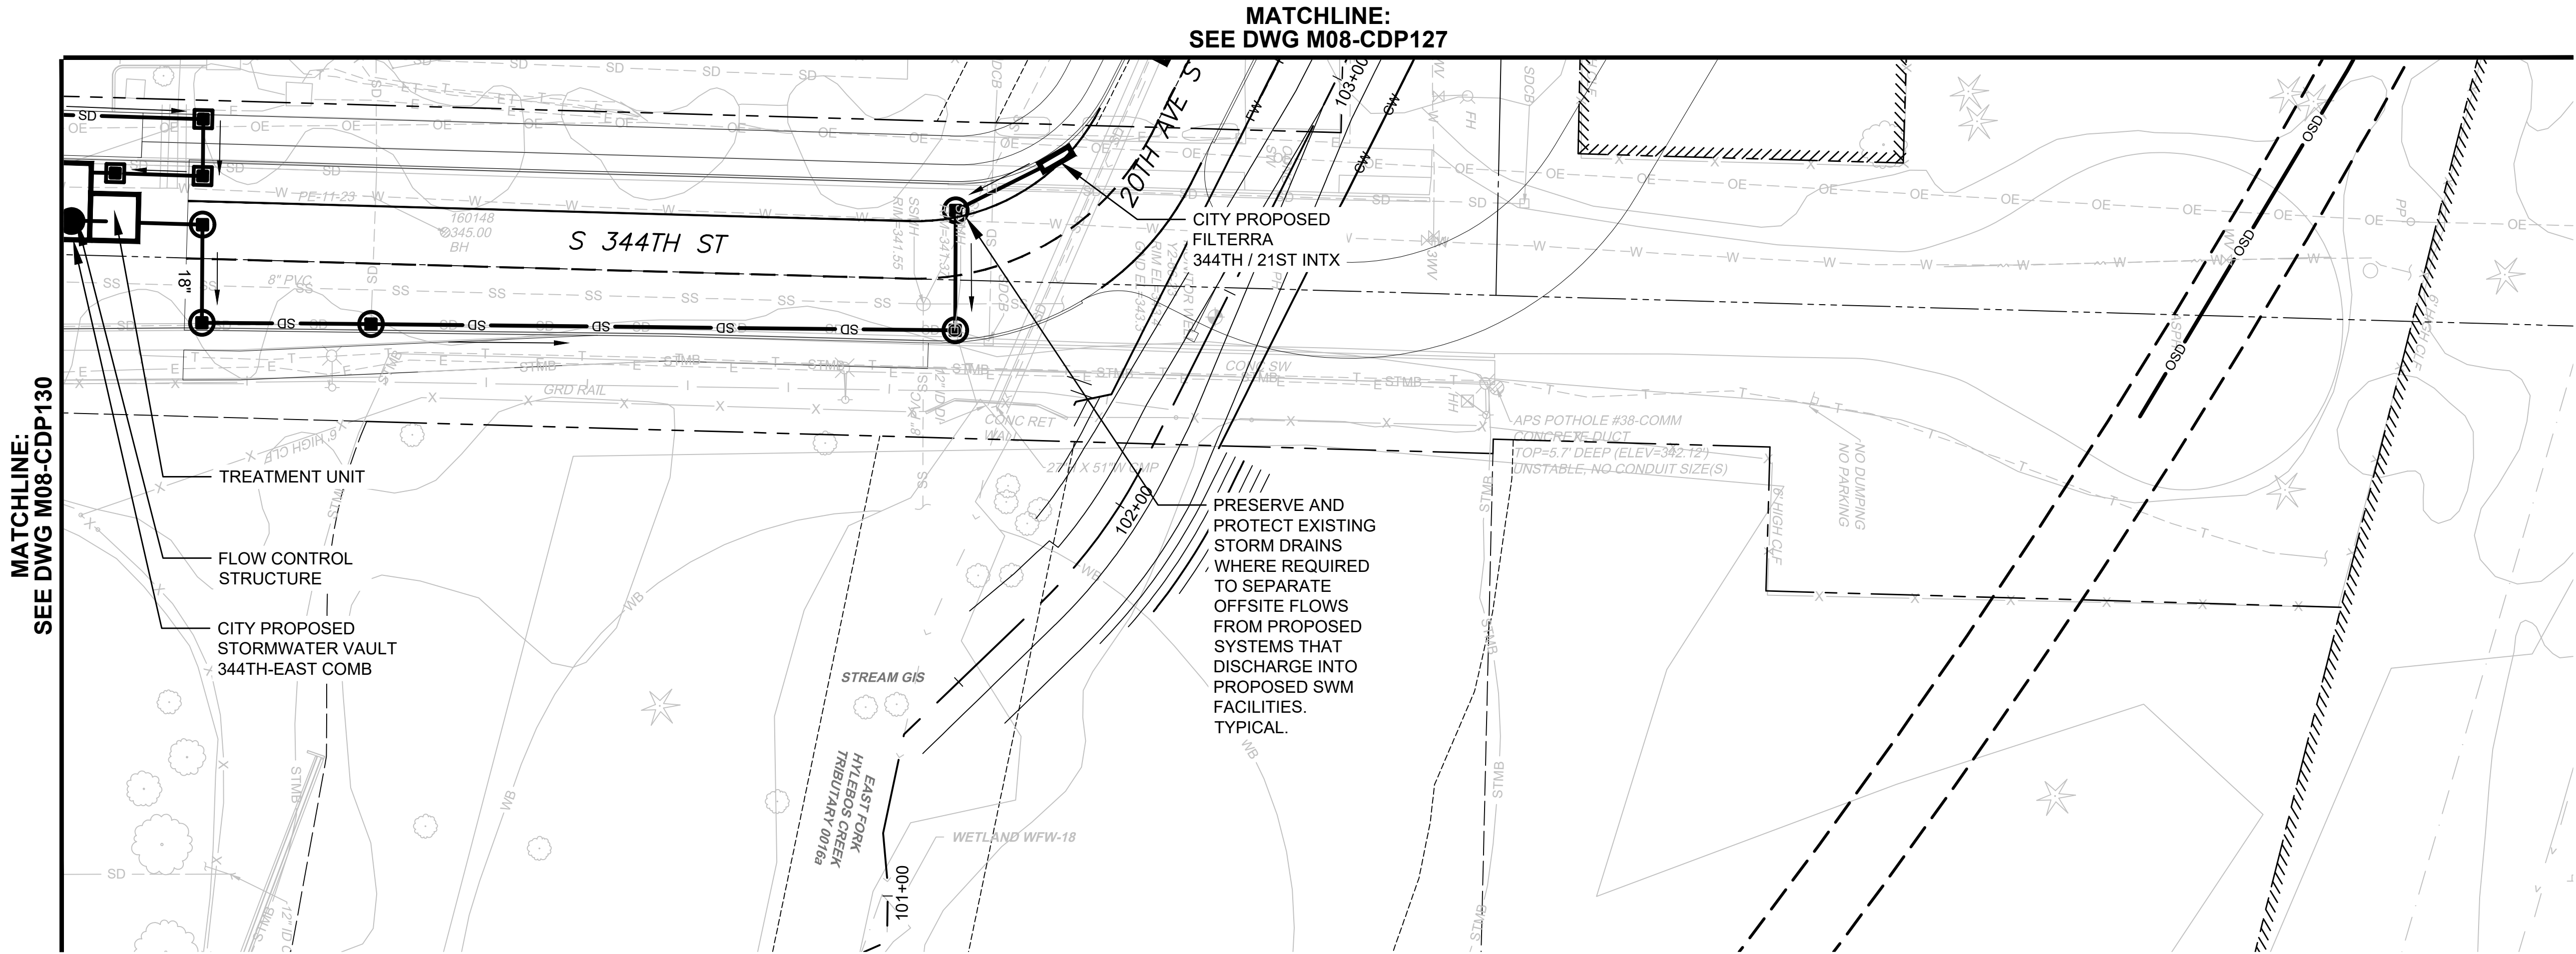

- NOTES:**
- REMOVE EXISTING STORM DRAINS AND DRAINAGE STRUCTURES AT CONFLICTS WITH PROPOSED STORM DRAIN, PROPOSED DRAINAGE STRUCTURES, OR PROPOSED STORMWATER FACILITIES. RELOCATE STORM DRAINS OR REPLACE EXISTING DRAINAGE STRUCTURES AS REQUIRED.
 - ALL PROPOSED UNDERGROUND STORM DRAIN 12-INCH DIAMETER UNLESS NOTED OTHERWISE.

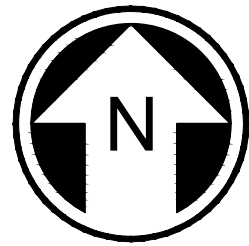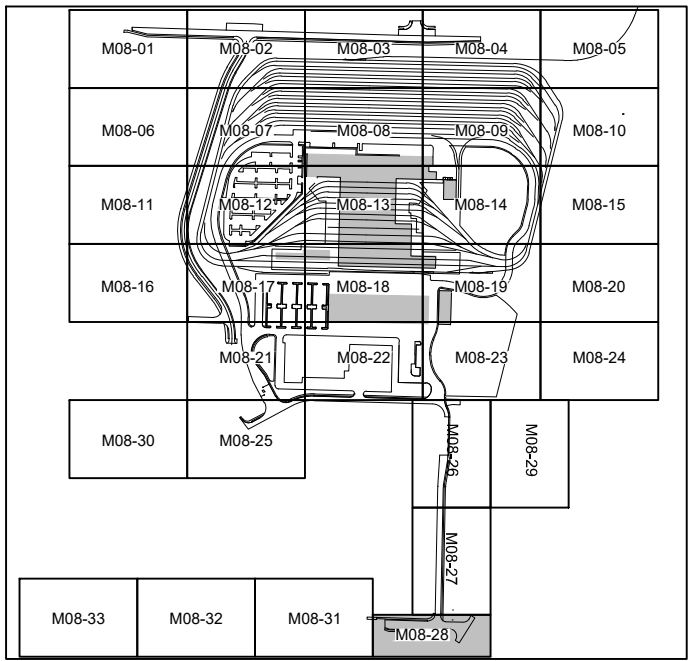


NOT FOR
CONSTRUCTION


02/23/24 | 10:06 AM | WILLIBRE
C:\P\WORKING\WEST01\DWG\OMFS-M08-CDP-01-134.DWG

Refer to the plan set COVER drawing
for disclaimers regarding this drawing.

REFERENCE CONCEPT DRAWINGS					
No.	DATE	DSN	CHK	APP	REVISION

DESIGNED BY:	L. GRABOWSKI
DRAWN BY:	B. WILLIAMS
CHECKED BY:	J. WRIGHT
APPROVED BY:	J.COOP

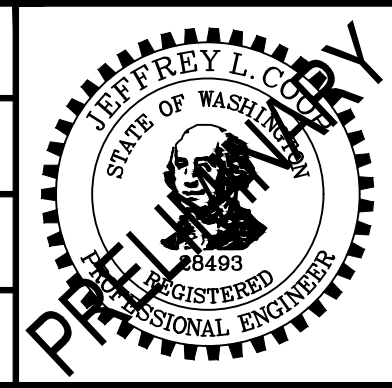

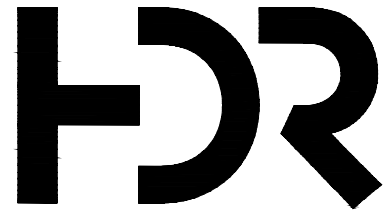

SUBMITTED BY:

PABLO LOPEZ-HILFIKER

DATE:

2/27/2024

REVIEWED BY:



DATE:

2/27/2024

PACKAGE #

SCALE:
1"=20'


FILENAME:
OMFS-M08-CDP101-134

CONTRACT No.:
AE-0030-17

SOUND TRANSIT
PRELIMINARY ENGINEERING PLANS
OPERATIONS & MAINTENANCE FACILITY SOUTH


CIVIL
DRAINAGE PLAN


DRAWING No.:	M08-CDP130
FACILITY ID:	M08
SHEET No.:	REV:

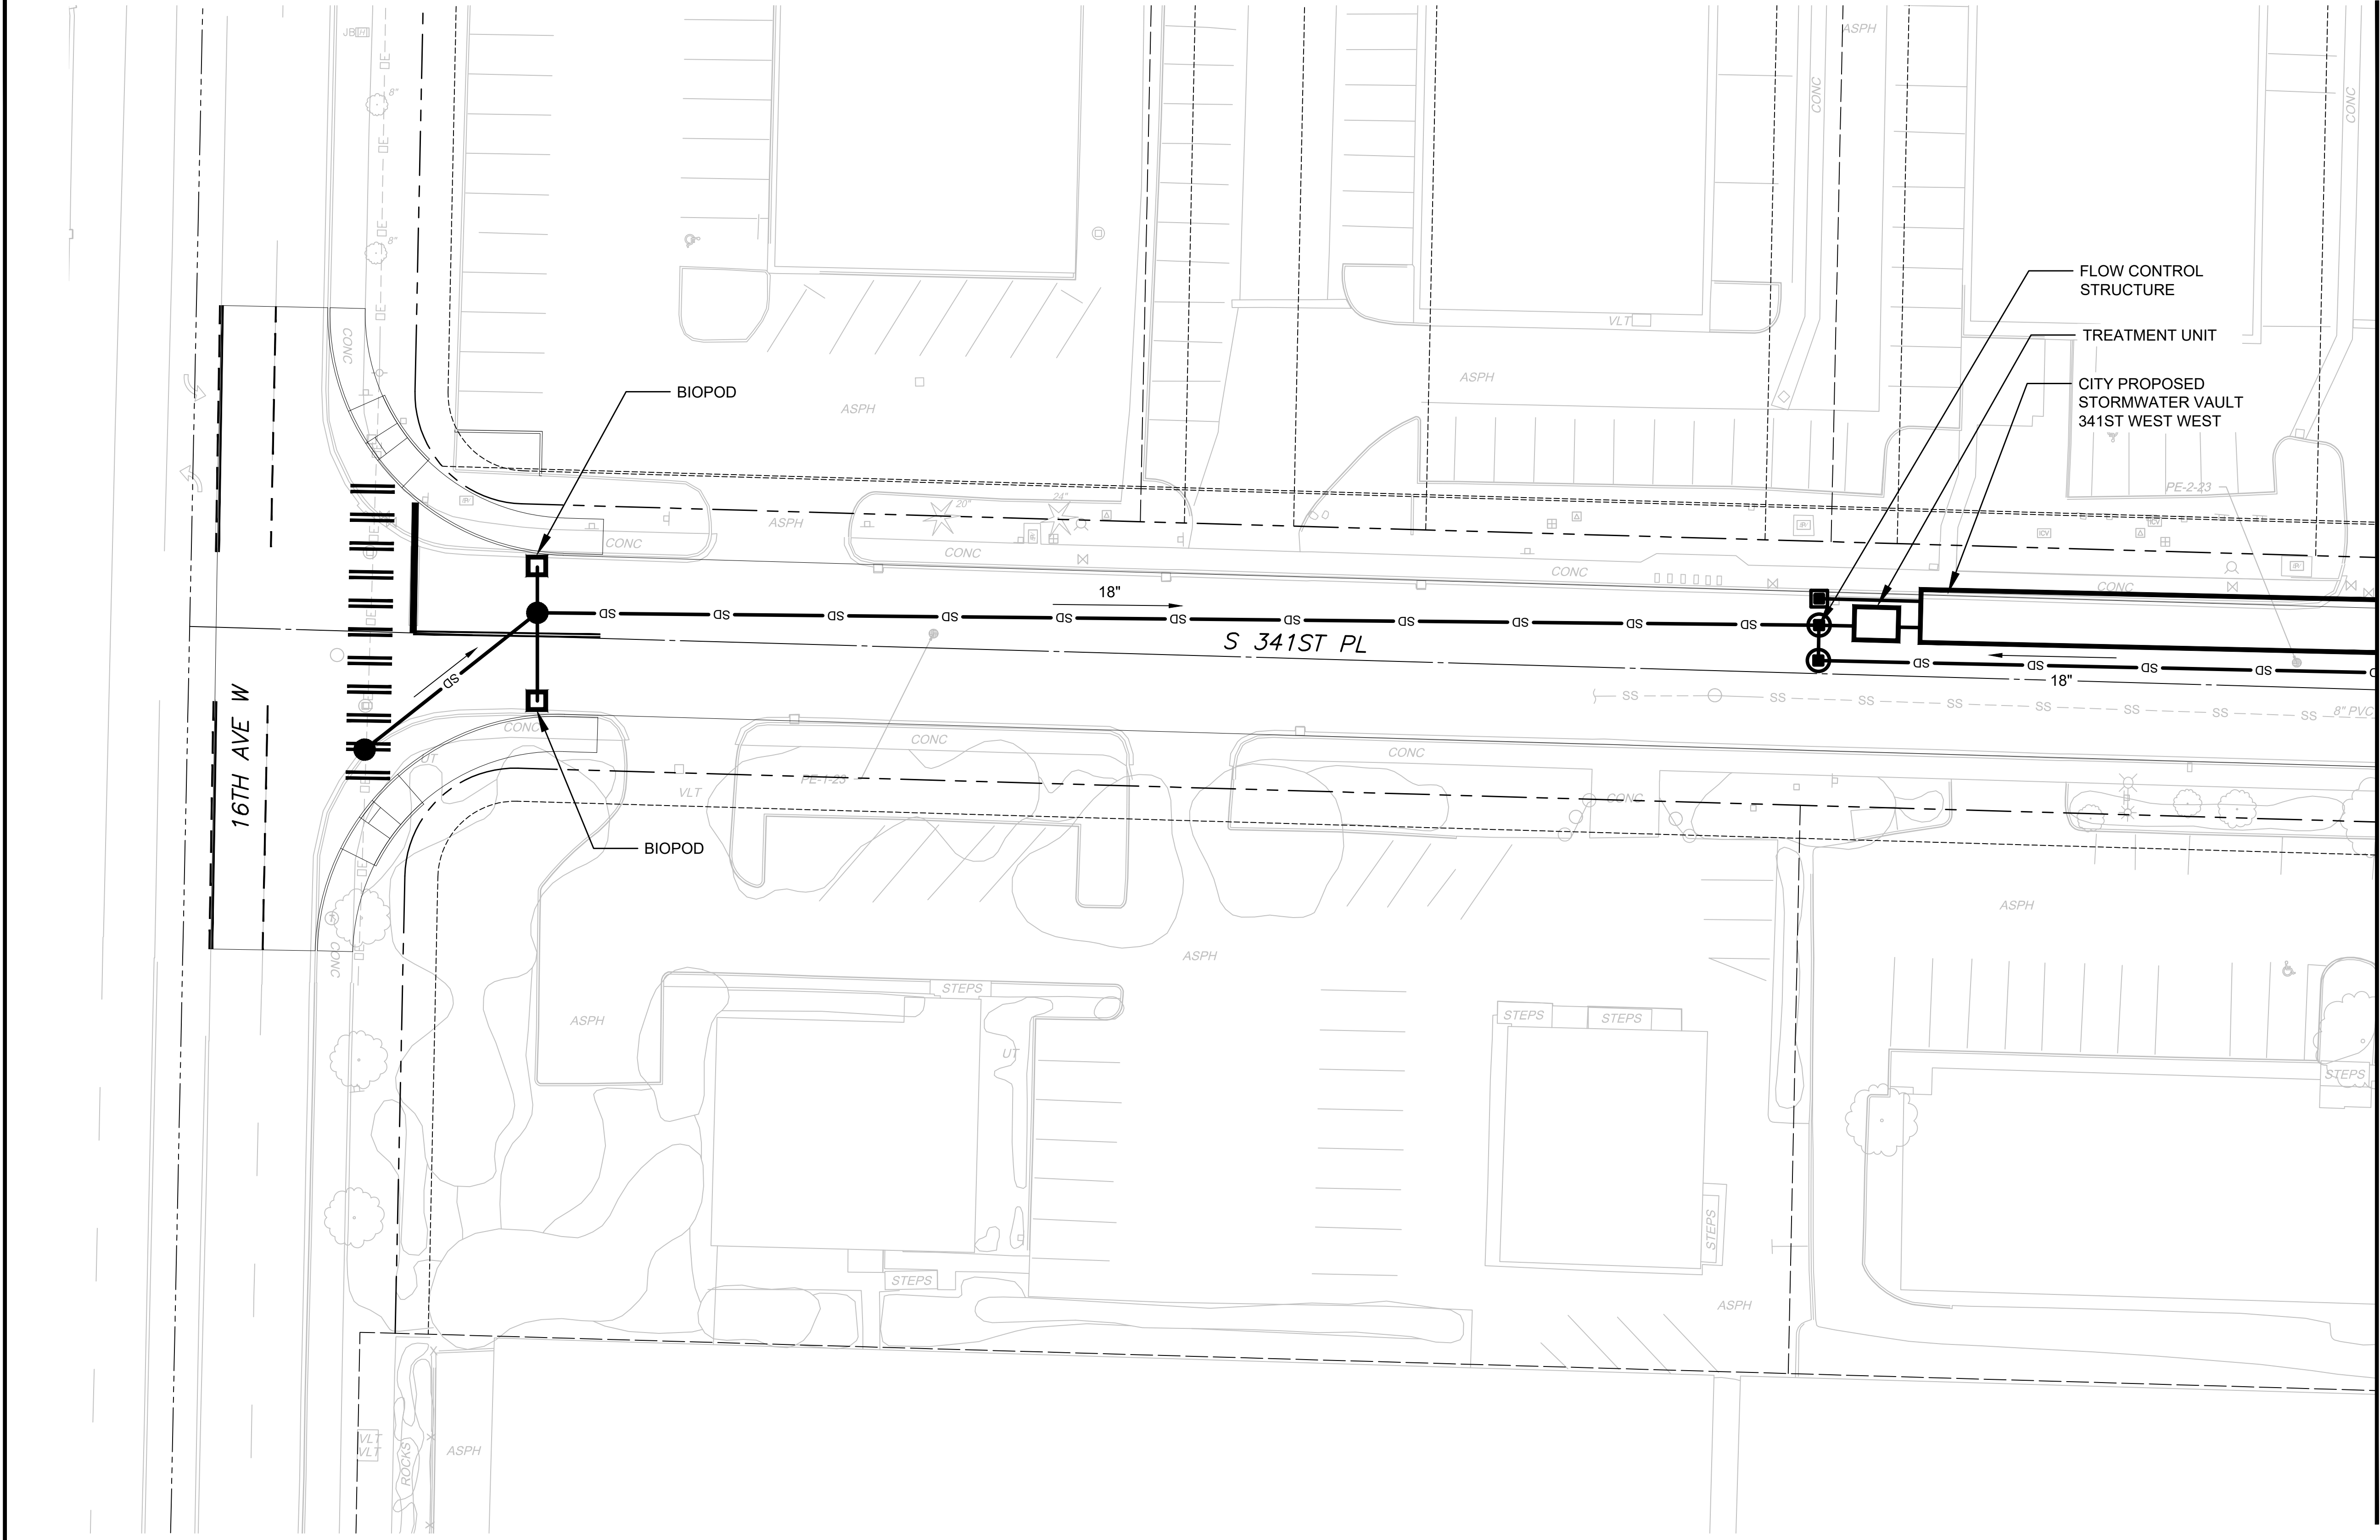

MATCHLINE:
SEE DWG M08-CDP125

- NOTES:**
1. REMOVE EXISTING STORM DRAINS AND DRAINAGE STRUCTURES AT CONFLICTS WITH PROPOSED STORM DRAIN, PROPOSED DRAINAGE STRUCTURES, OR PROPOSED STORMWATER FACILITIES. RELOCATE STORM DRAINS OR REPLACE EXISTING DRAINAGE STRUCTURES AS REQUIRED.
 2. ALL PROPOSED UNDERGROUND STORM DRAIN 12-INCH DIAMETER UNLESS NOTED OTHERWISE.

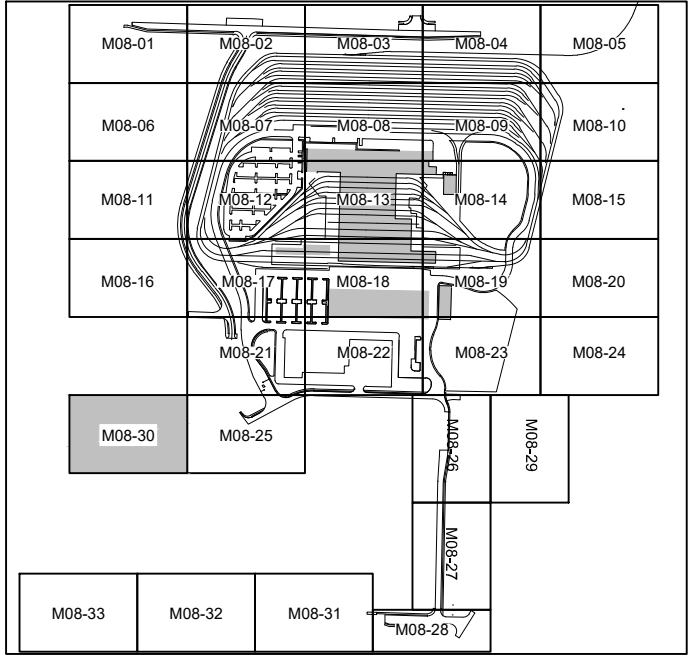

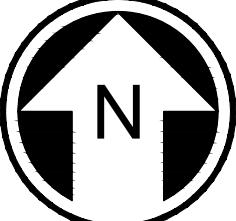

20 10 0 20 40

SCALE IN FEET

NOT FOR
CONSTRUCTION

02/23/24 | 10:07 AM | WILLIBRE
C:\PWORKING\WEST01\D2772718\OMFS-M08-CDP-01-134.DWG

Refer to the plan set COVER drawing
for disclaimers regarding this drawing.

REFERENCE CONCEPT DRAWINGS

No.	DATE	DSN	CHK	APP	REVISION

DESIGNED BY:
L. GRABOWSKI

DRAWN BY:
B. WILLIAMS

CHECKED BY:
J. WRIGHT

APPROVED BY:
J.COOP

AHJ:

PREPARED BY
TERREY L. COOPER
REGISTERED PROFESSIONAL ENGINEER
28493
STATE OF WASHINGTON

HR

SUBMITTED BY:
PABLO LOPEZ-HILFIKER

DATE:
2/27/2024

REVIEWED BY:

PACKAGE #

SCALE:
1"=20'

FILENAME:
OMFS-M08-CDP101-134

CONTRACT No.:
AE-0030-17

DATE:
2/27/2024

SOUND TRANSIT

PRELIMINARY ENGINEERING PLANS


OPERATIONS & MAINTENANCE FACILITY SOUTH

CIVIL DRAINAGE PLAN



DRAWING No.:
M08-CDP131

FACILITY ID:
M08

SHEET No.:
REV:

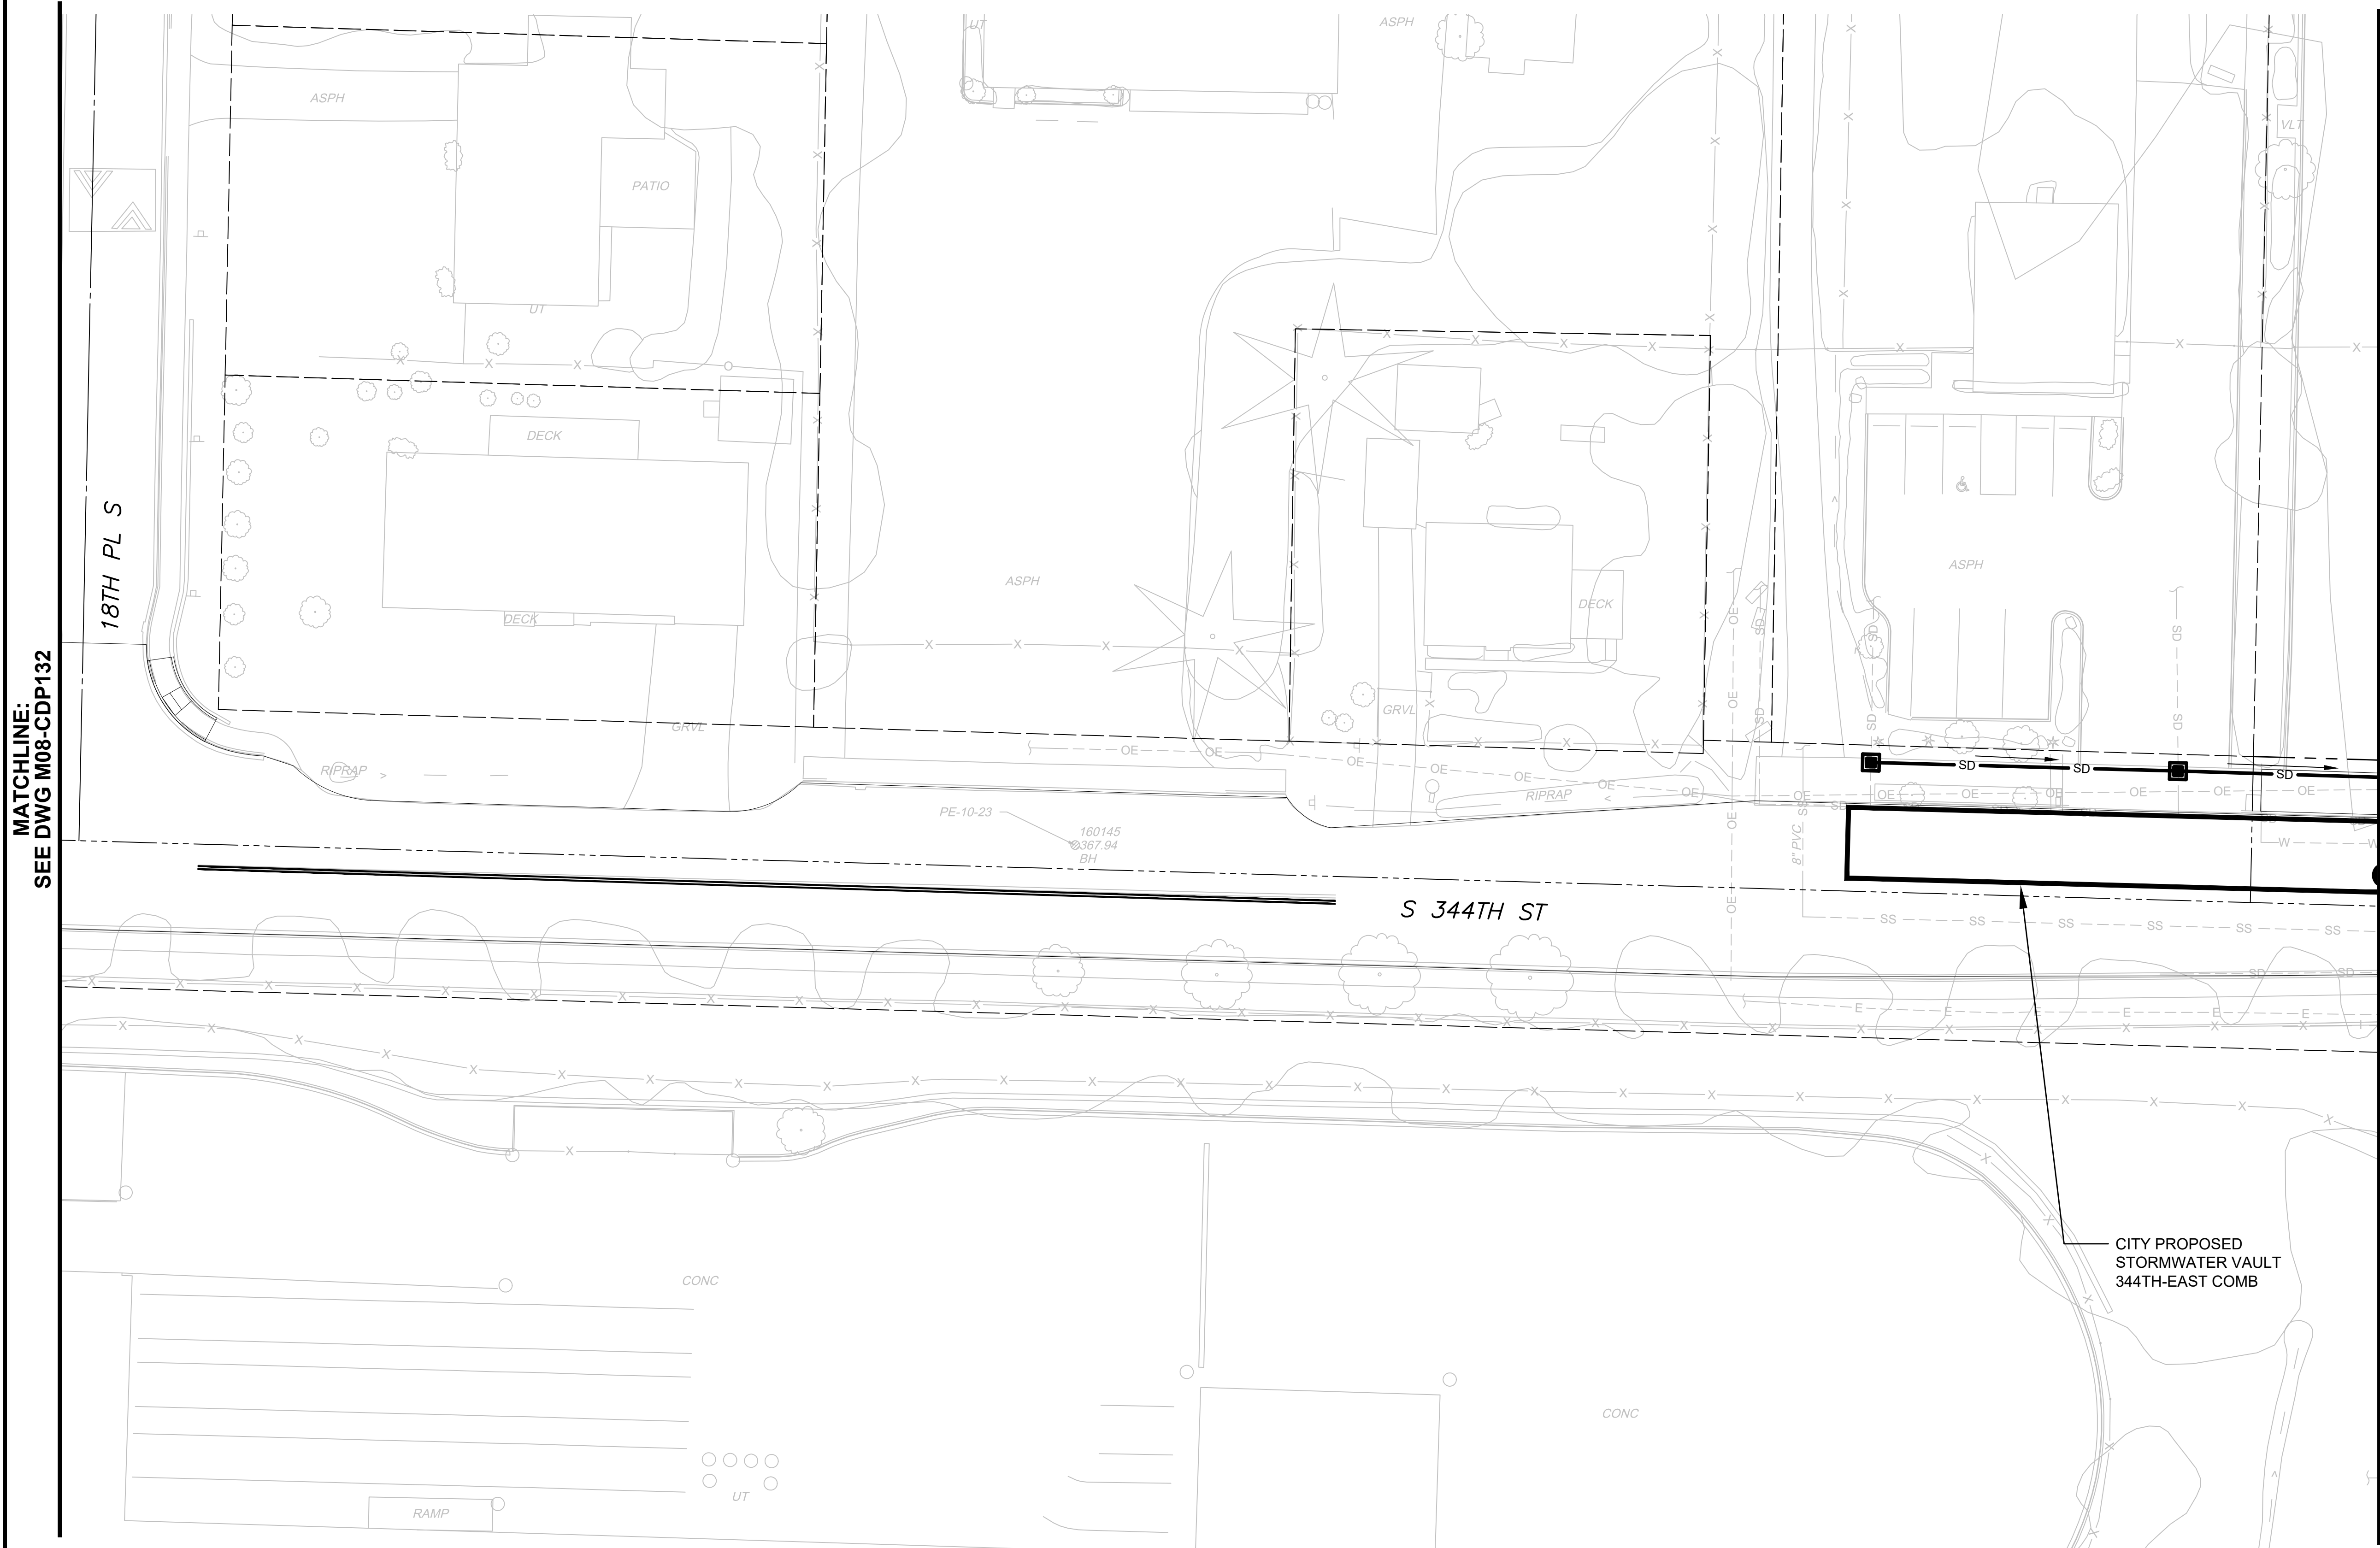

- NOTES:**
1. REMOVE EXISTING STORM DRAINS AND DRAINAGE STRUCTURES AT CONFLICTS WITH PROPOSED STORM DRAIN, PROPOSED DRAINAGE STRUCTURES, OR PROPOSED STORMWATER FACILITIES. RELOCATE STORM DRAINS OR REPLACE EXISTING DRAINAGE STRUCTURES AS REQUIRED.
 2. ALL PROPOSED UNDERGROUND STORM DRAIN 12-INCH DIAMETER UNLESS NOTED OTHERWISE.

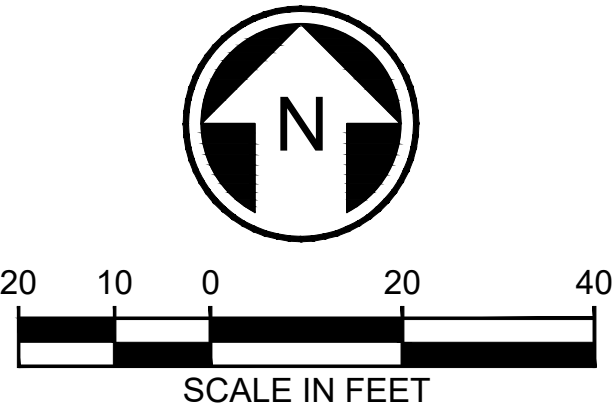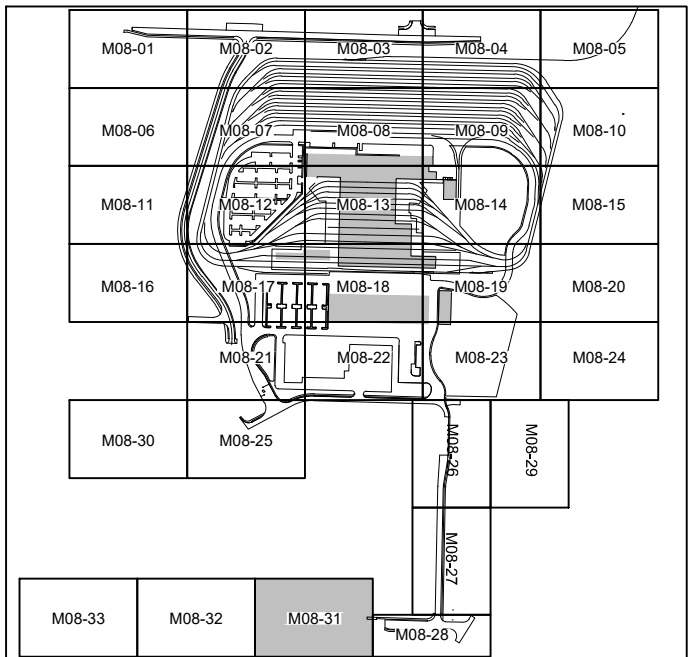

NOT FOR
CONSTRUCTION

02/23/24 | 10:09 AM | WILLIBRE
C:\PWORKING\WEST01\2727718\OMFS-M08-CDP-01-134.DWG


MATCHLINE:
SEE DWG M08-CDP133


MATCHLINE:
SEE DWG M08-CDP131

Refer to the plan set COVER drawing
for disclaimers regarding this drawing.

REFERENCE CONCEPT DRAWINGS					
No.	DATE	DSN	CHK	APP	REVISION

DESIGNED BY:	L. GRABOWSKI
DRAWN BY:	B. WILLIAMS
CHECKED BY:	J. WRIGHT
APPROVED BY:	J.COOP

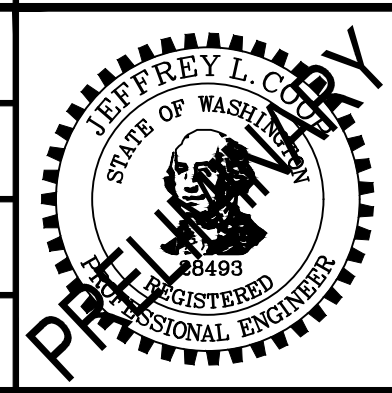

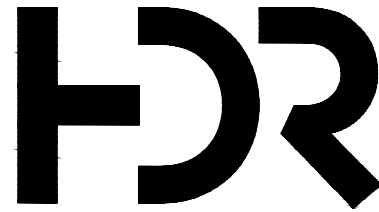

SUBMITTED BY:

PABLO LOPEZ-HILFIKER

DATE:

2/27/2024

REVIEWED BY:



DATE:

2/27/2024

PACKAGE #

SCALE:
1"=20'

FILENAME:
OMFS-M08-CDP101-134


CONTRACT No.:
AE-0030-17

DATE:
2/27/2024



SOUND TRANSIT
PRELIMINARY ENGINEERING PLANS
OPERATIONS & MAINTENANCE FACILITY SOUTH

CIVIL
DRAINAGE PLAN

DRAWING No.:	M08-CDP132
FACILITY ID:	M08
SHEET No.:	REV:

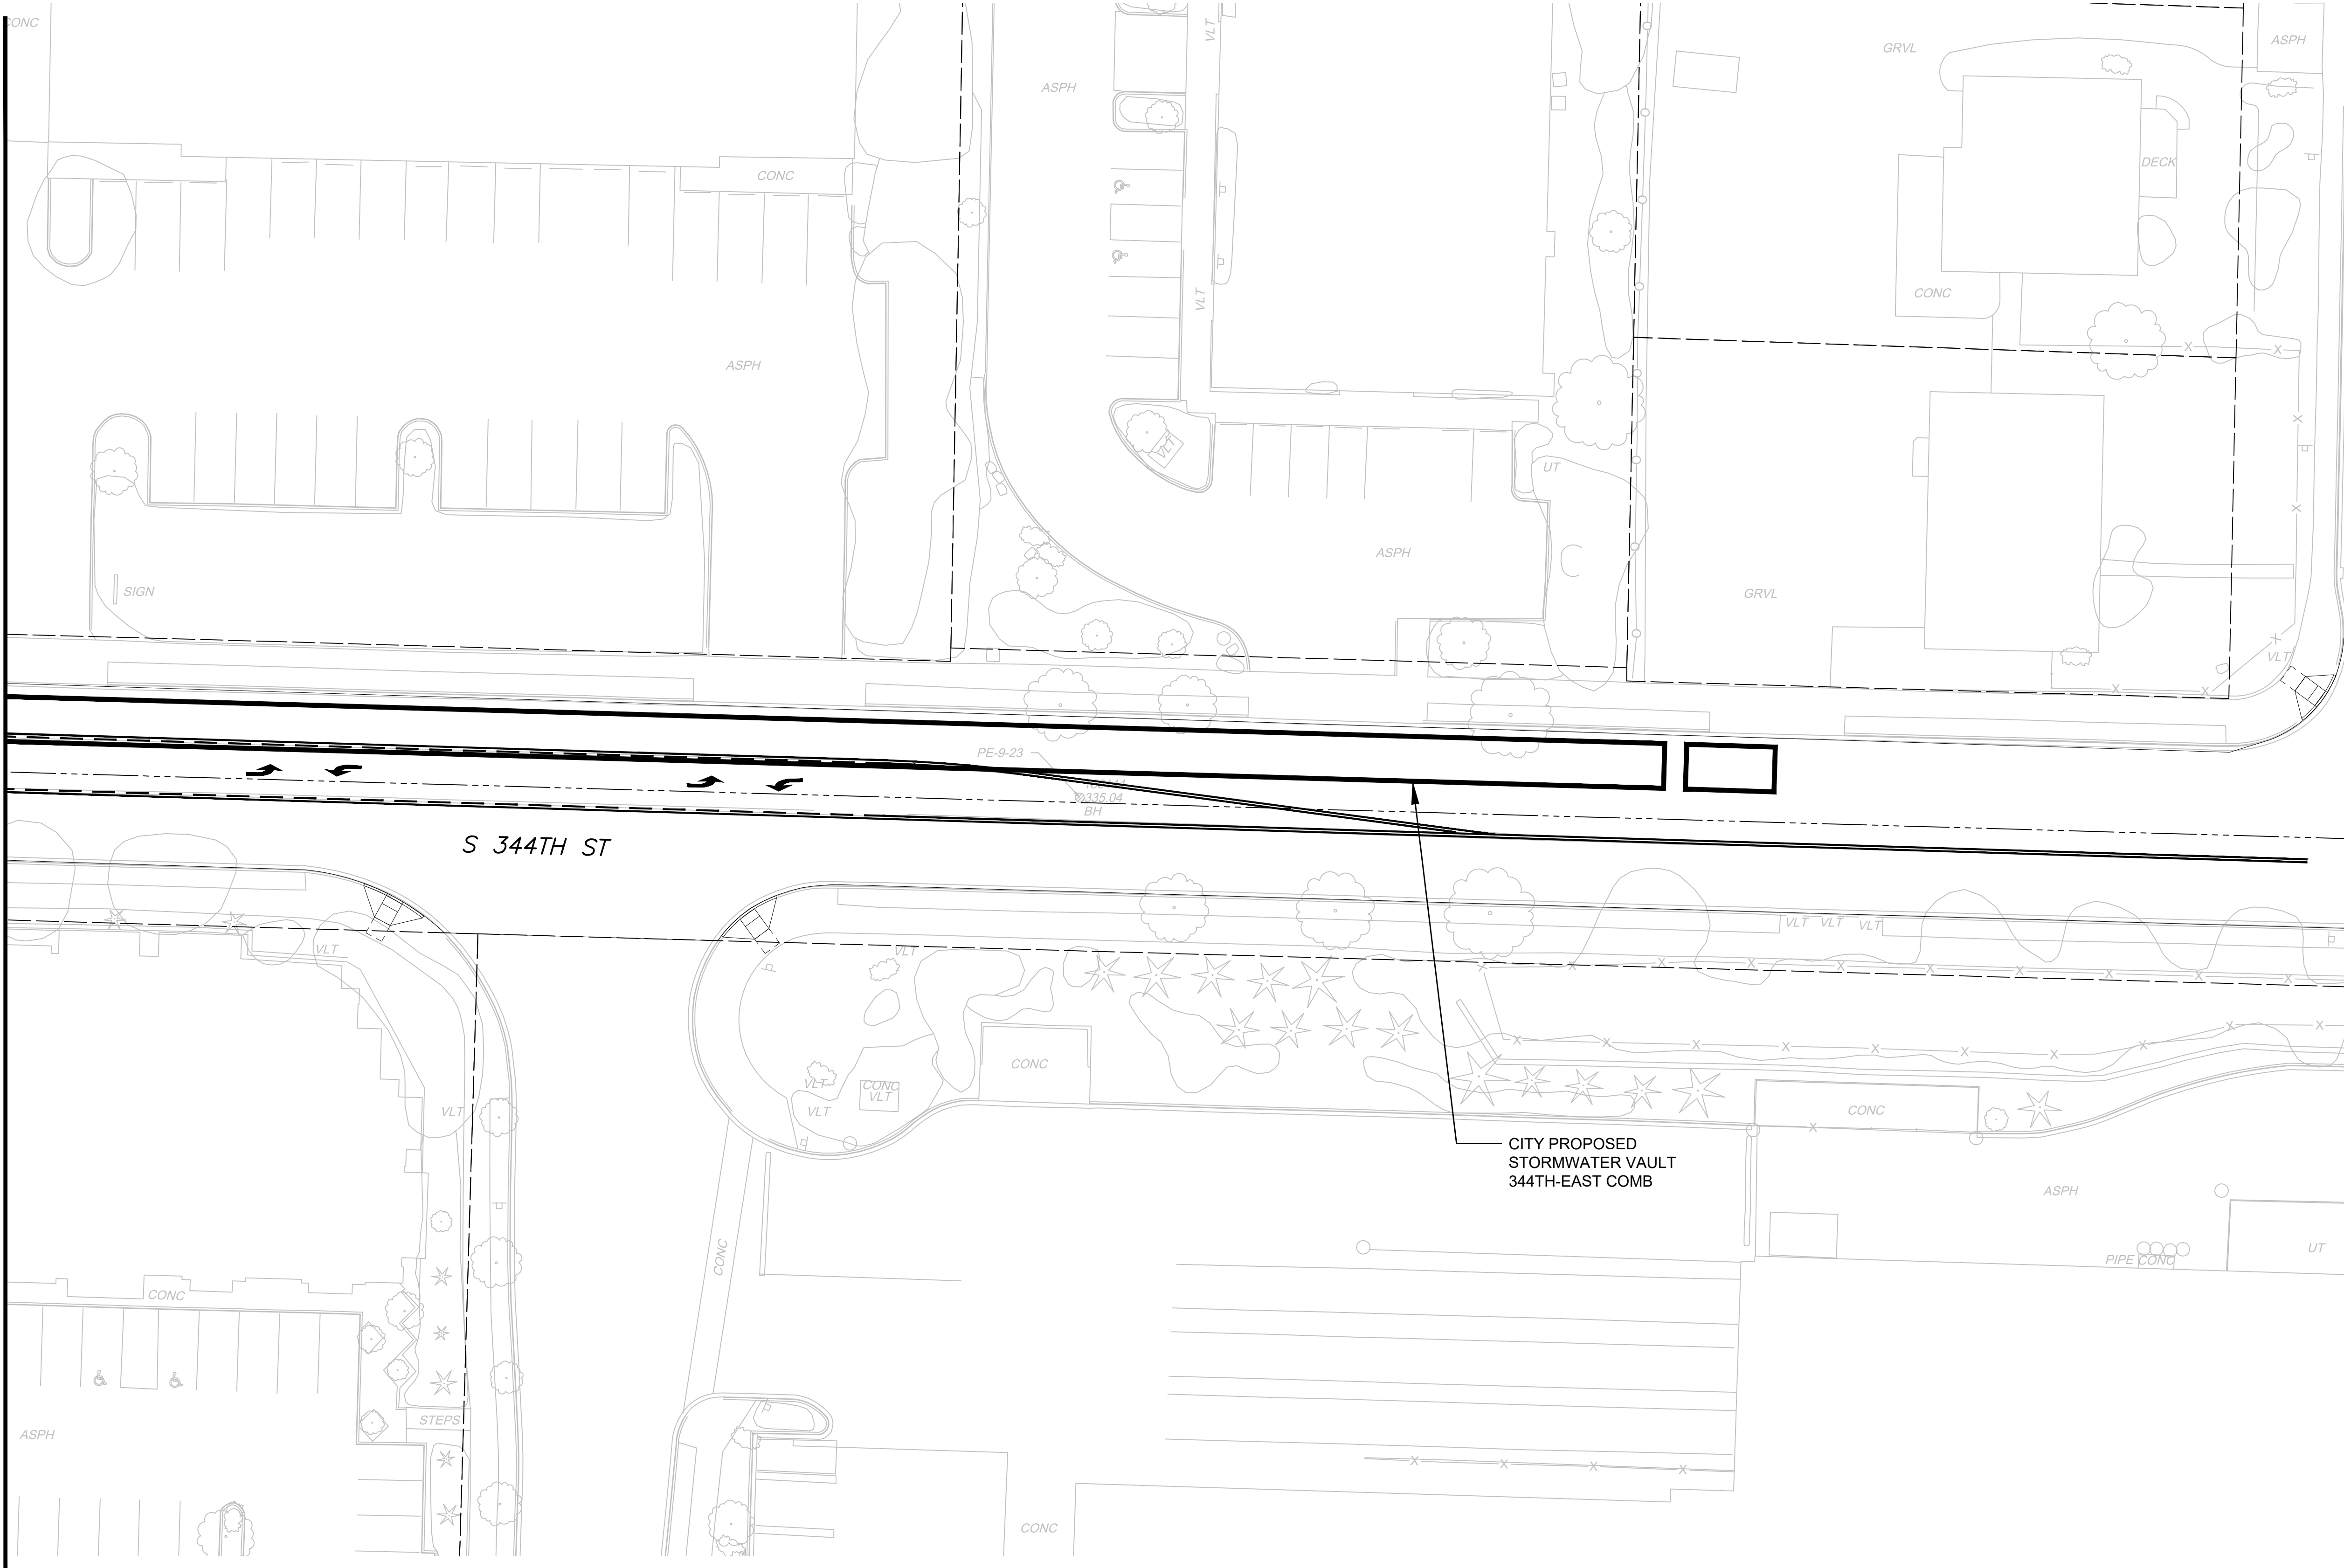

- NOTES:**
- REMOVE EXISTING STORM DRAINS AND DRAINAGE STRUCTURES AT CONFLICTS WITH PROPOSED STORM DRAIN, PROPOSED DRAINAGE STRUCTURES, OR PROPOSED STORMWATER FACILITIES. RELOCATE STORM DRAINS OR REPLACE EXISTING DRAINAGE STRUCTURES AS REQUIRED.
 - ALL PROPOSED UNDERGROUND STORM DRAIN 12-INCH DIAMETER UNLESS NOTED OTHERWISE.

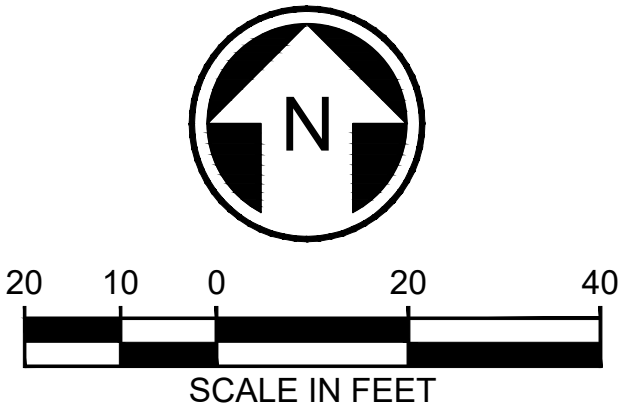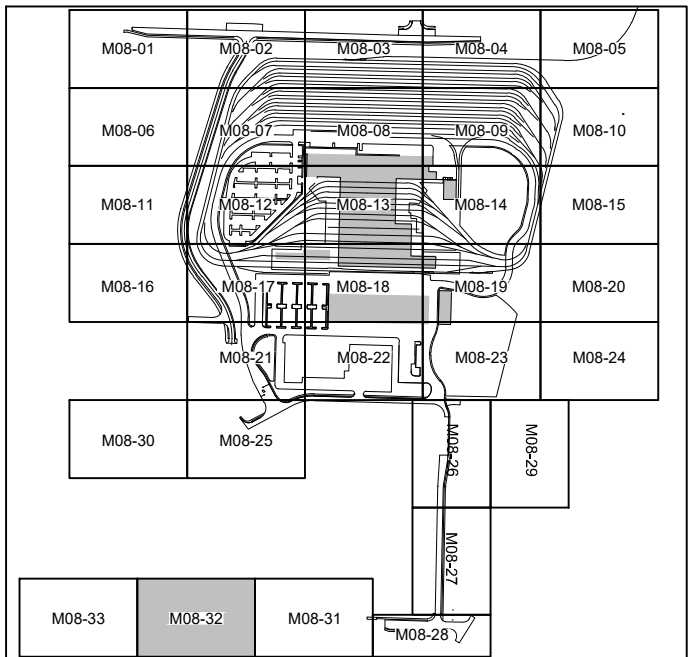


NOT FOR
CONSTRUCTION

02/23/24 | 10:10 AM | WILLIBRE
C:\PWORKING\WEST01\02772718\OMFS-M08-CDP-01-134.DWG

Refer to the plan set COVER drawing
for disclaimers regarding this drawing.

REFERENCE CONCEPT DRAWINGS						
No.	DATE	DSN	CHK	APP	REVISION	

DESIGNED BY:	L. GRABOWSKI
DRAWN BY:	B. WILLIAMS
CHECKED BY:	J. WRIGHT
APPROVED BY:	J.COOP

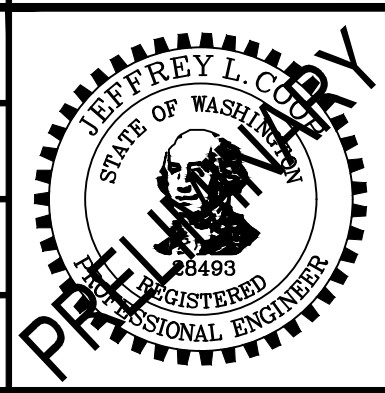


SUBMITTED BY:
PABLO LOPEZ-HILFIKER

DATE:
2/27/2024

REVIEWED BY:

LINE IS 1" AT
FULL SCALE

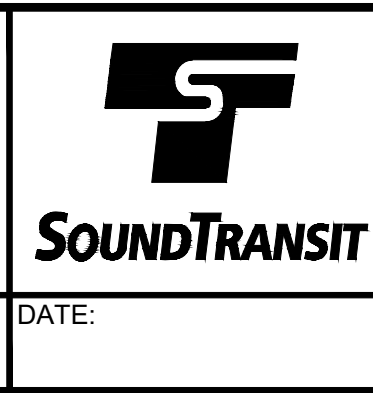


DATE:

PACKAGE #
SCALE: 1"=20'
FILENAME: OMFS-M08-CDP101-134
CONTRACT No.: AE-0030-17
DATE: 2/27/2024

SOUND TRANSIT
PRELIMINARY ENGINEERING PLANS
OPERATIONS & MAINTENANCE FACILITY SOUTH



CIVIL
DRAINAGE PLAN

DRAWING No.:	M08-CDP133
FACILITY ID:	M08
SHEET No.:	REV:

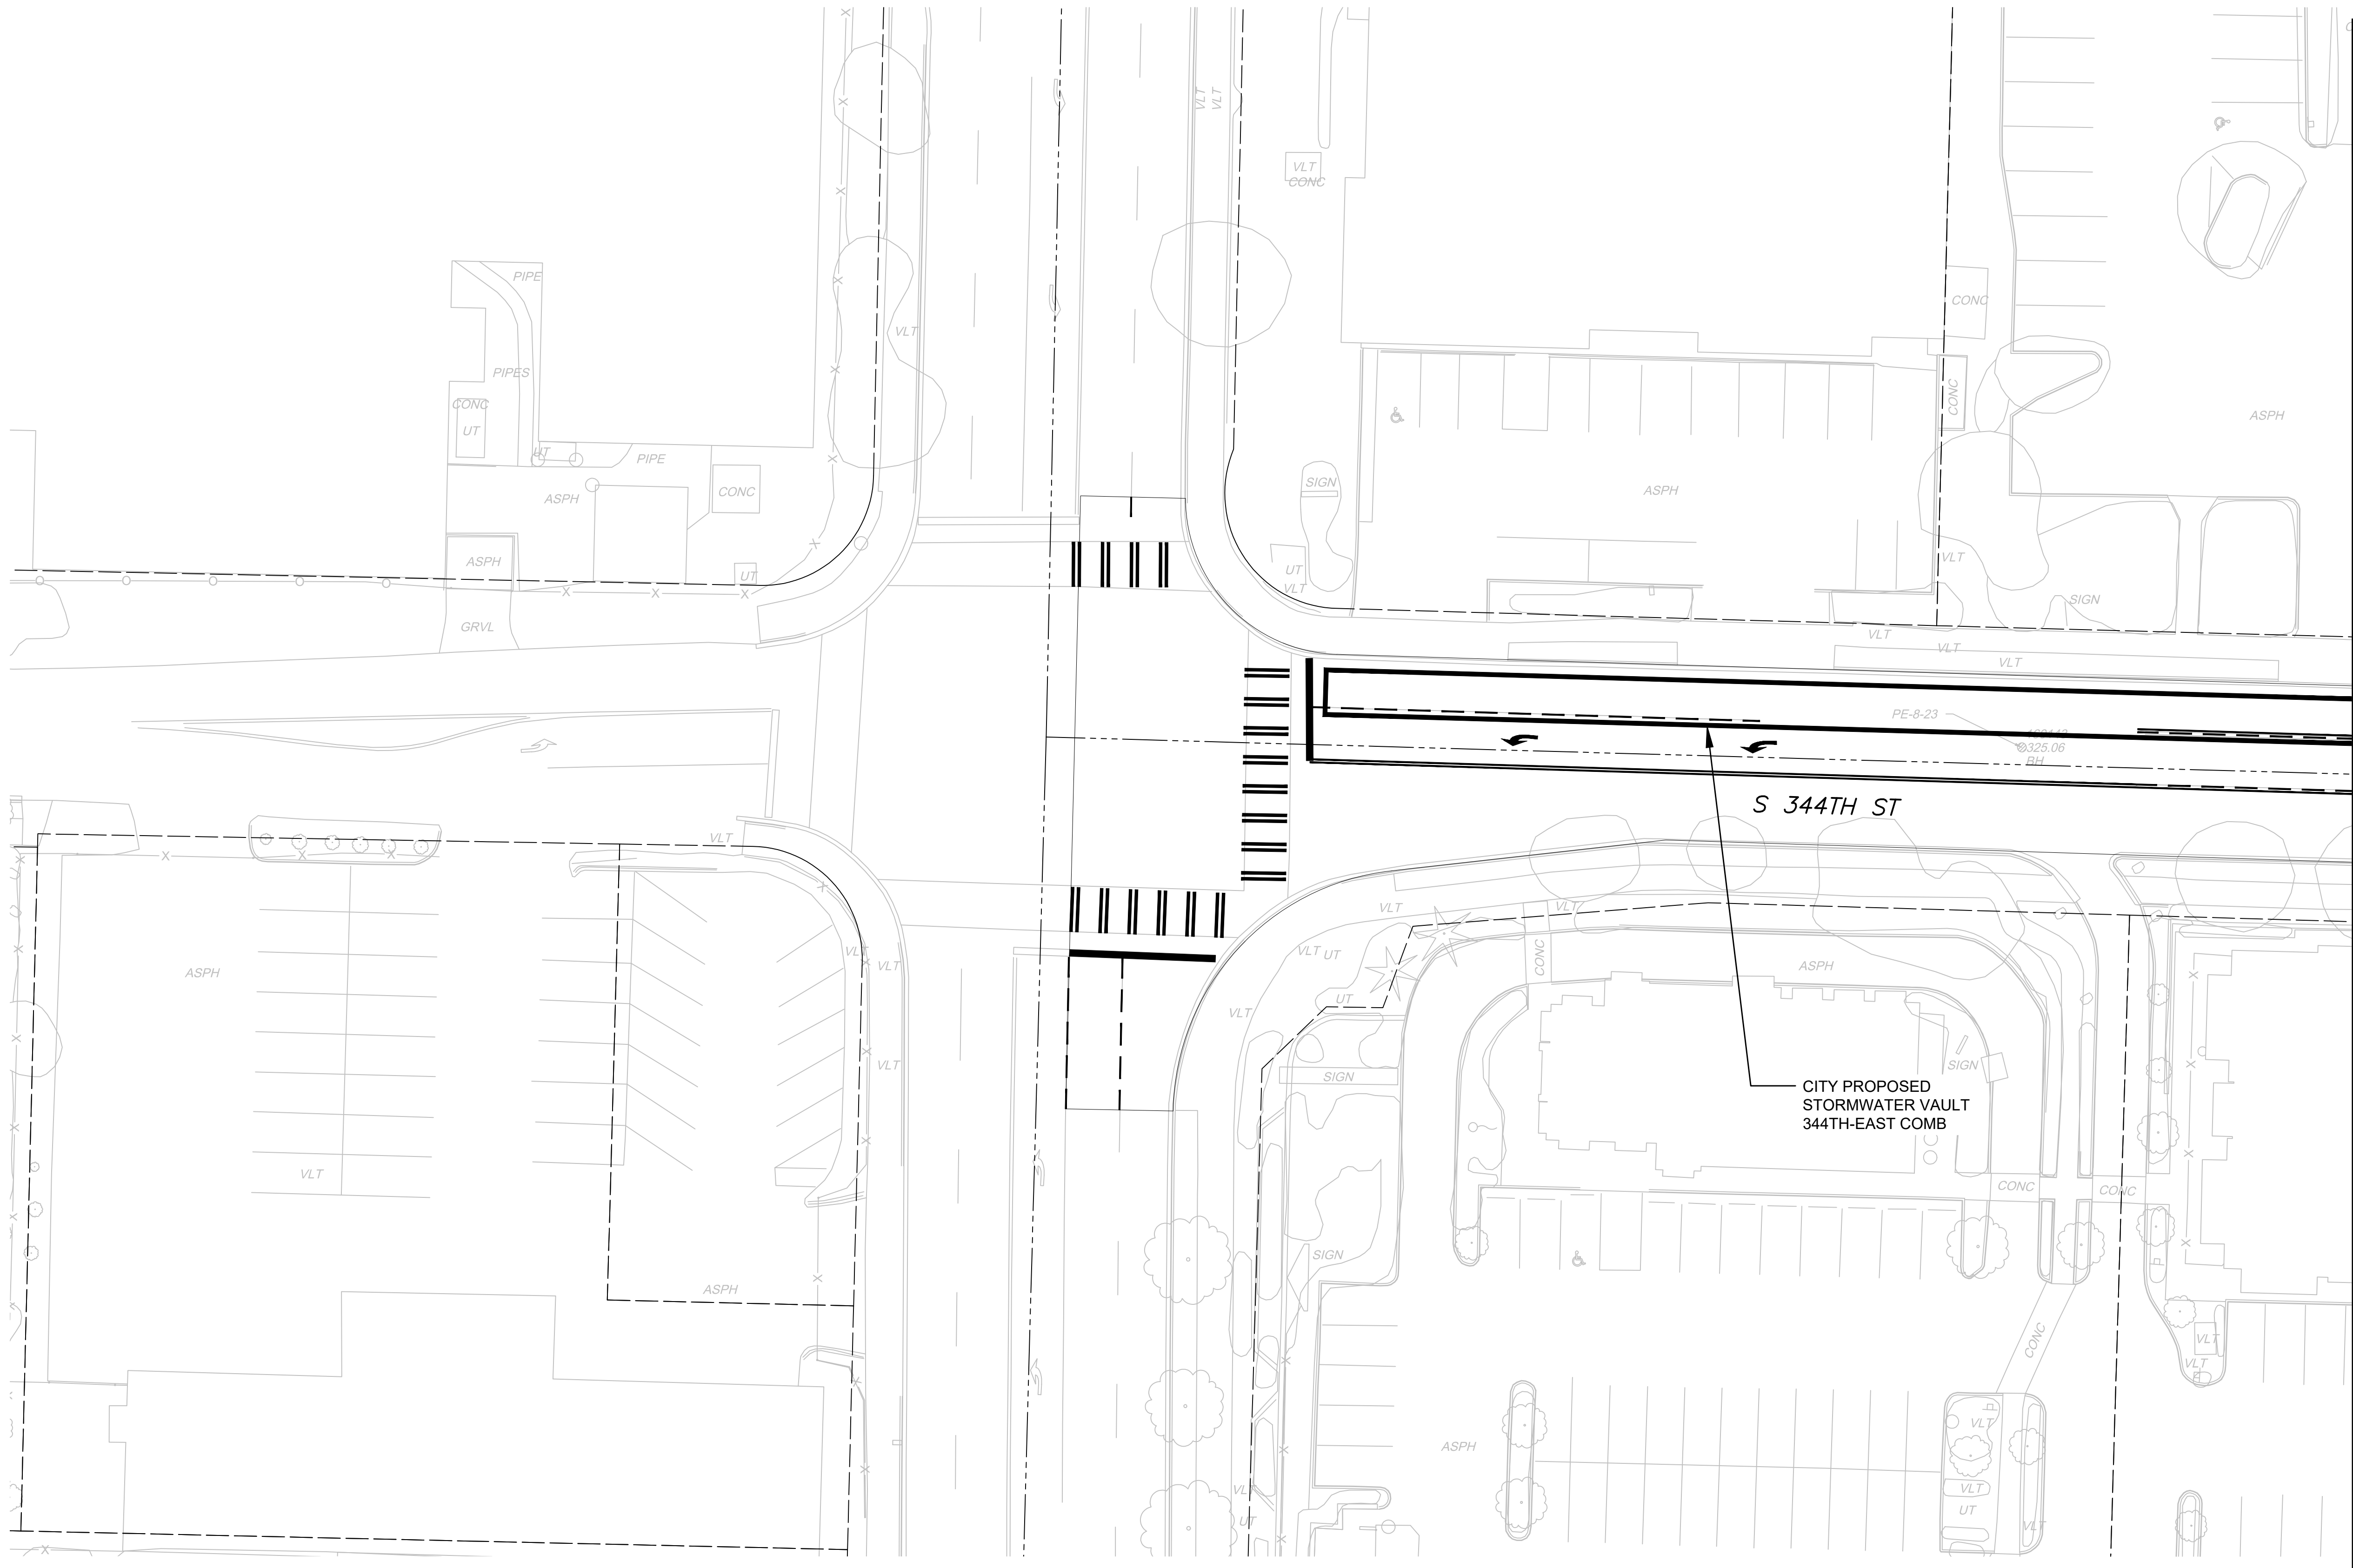

MATCHLINE:
SEE DWG M08-CDP132

- NOTES:**
1. REMOVE EXISTING STORM DRAINS AND DRAINAGE STRUCTURES AT CONFLICTS WITH PROPOSED STORM DRAIN, PROPOSED DRAINAGE STRUCTURES, OR PROPOSED STORMWATER FACILITIES. RELOCATE STORM DRAINS OR REPLACE EXISTING DRAINAGE STRUCTURES AS REQUIRED.
 2. ALL PROPOSED UNDERGROUND STORM DRAIN 12-INCH DIAMETER UNLESS NOTED OTHERWISE.

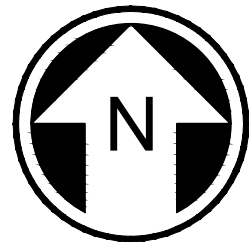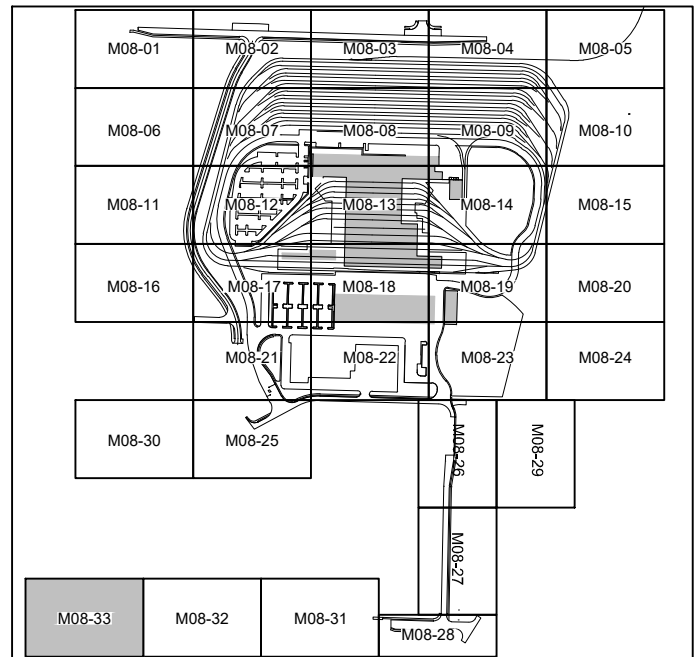

NOT FOR
CONSTRUCTION

StormFilter treatment BMPs for City or Private facilities		
No flow control structure		
Facility		344TH / 21ST INTX
On-line treatment flow rate	cfs	0.0292
	gpm	13.11
Cartridge height	in	18
Flow rate per cartridge	gpm/each	7.5
# of cartridges		2.0
hydraulic Drop	ft	2.30
100 year flow rate	cfs	0.14
Unit peak hydraulic capacity per unit	cfs	1.00

Notes:
Based on 2 cartridge Catch Basin StormFilter which comes with 18" or 27" cartridge.



NOT FOR
CONSTRUCTION




02/21/24 | 12:18 PM | WILLIBRE
C:\P\WORKING\WEST01\ID272716\OMFS-M08-CDX001-003.DWG

Refer to the plan set COVER drawing
for disclaimers regarding this drawing.

REFERENCE CONCEPT DRAWINGS					
No.	DATE	DSN	CHK	APP	REVISION

DESIGNED BY:	L. GRABOWSKI
DRAWN BY:	B. WILLIAMS
CHECKED BY:	J. WRIGHT
APPROVED BY:	J.COOP

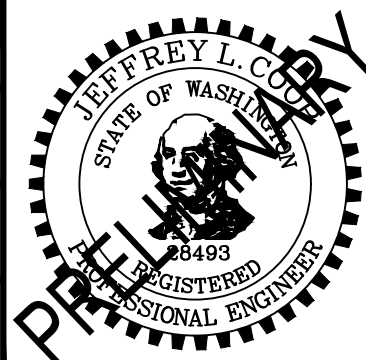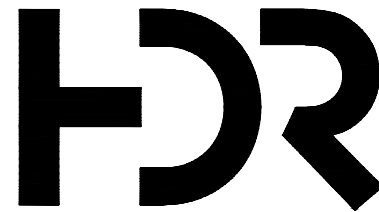AHJ:					PACKAGE #				
				LINE IS 1" AT FULL SCALE 	SCALE: 1"=5'	SOUND TRANSIT PRELIMINARY ENGINEERING PLANS OPERATIONS & MAINTENANCE FACILITY SOUTH CIVIL DRAINAGE SECTIONS AND DETAILS SWM FACILITY SECTIONS		DRAWING No.: M08-CDX001	
					FILENAME: OMFS-M08-CDX001-003			FACILITY ID: M08	
					CONTRACT No.: AE-0030-17			SHEET No.: REV:	
					DATE: 2/27/2024				
SUBMITTED BY: PABLO LOPEZ-HILFIKER		DATE: 2/27/2024		REVIEWED BY:		DATE:			

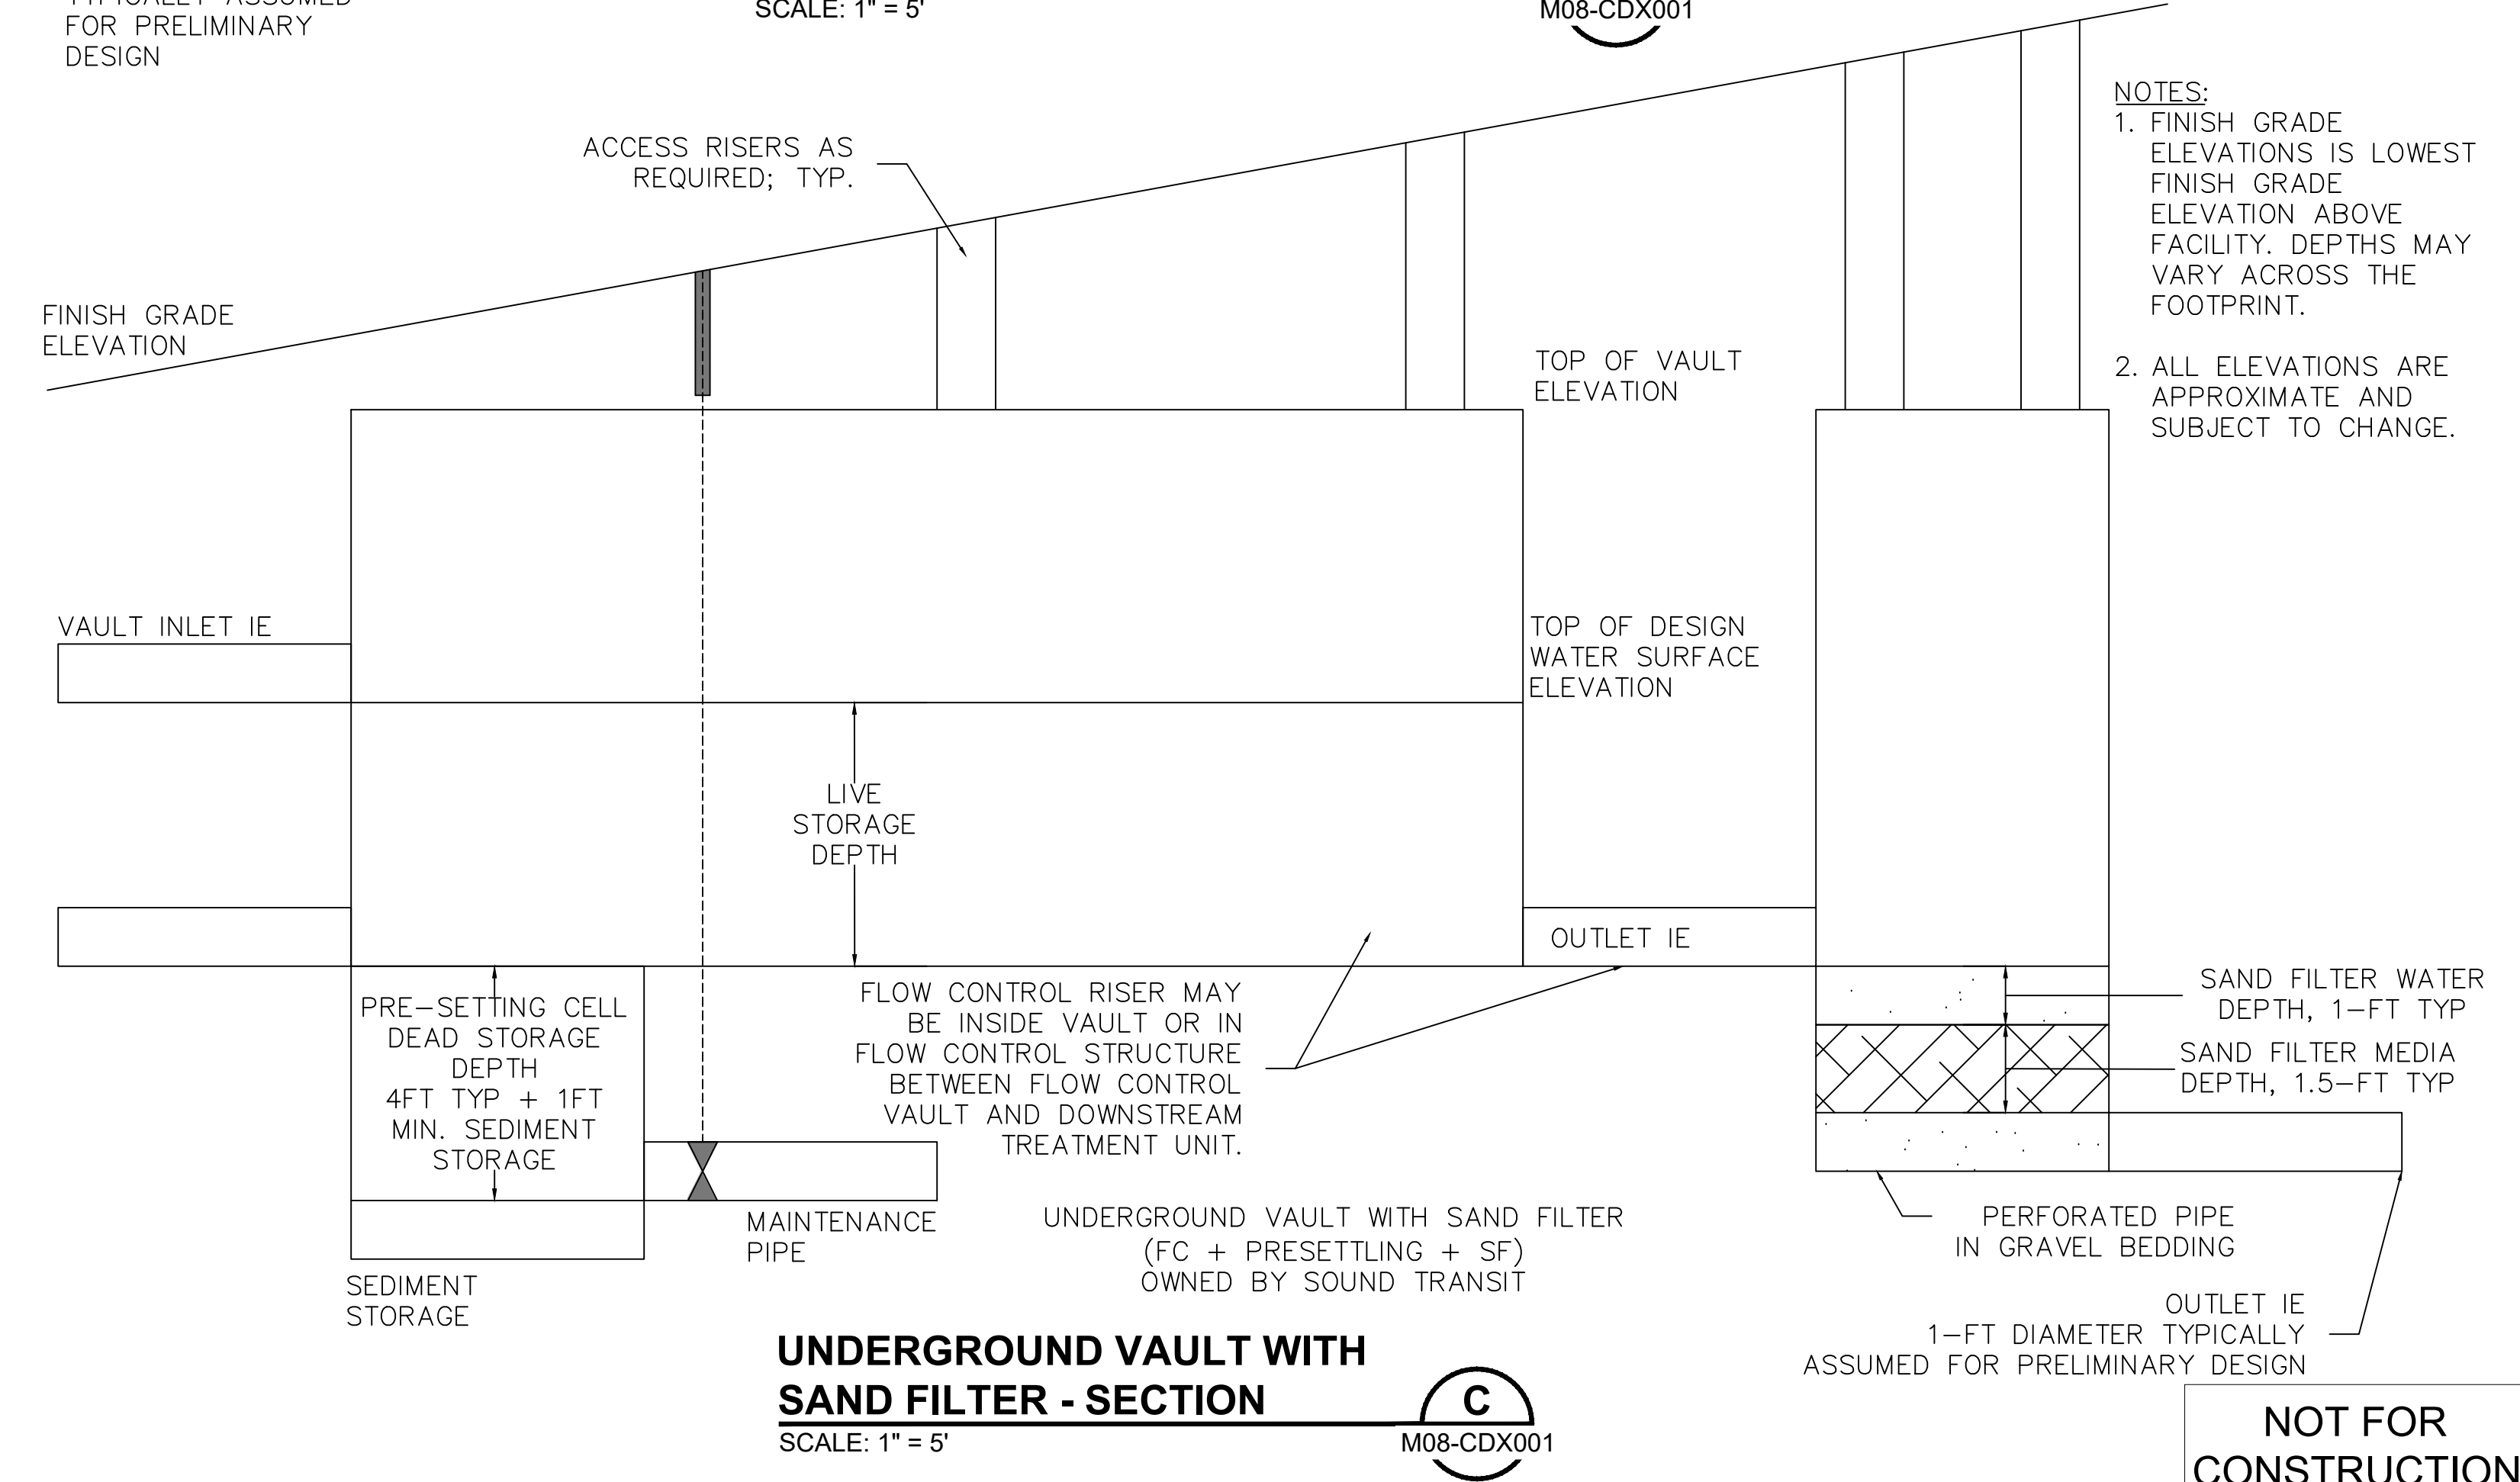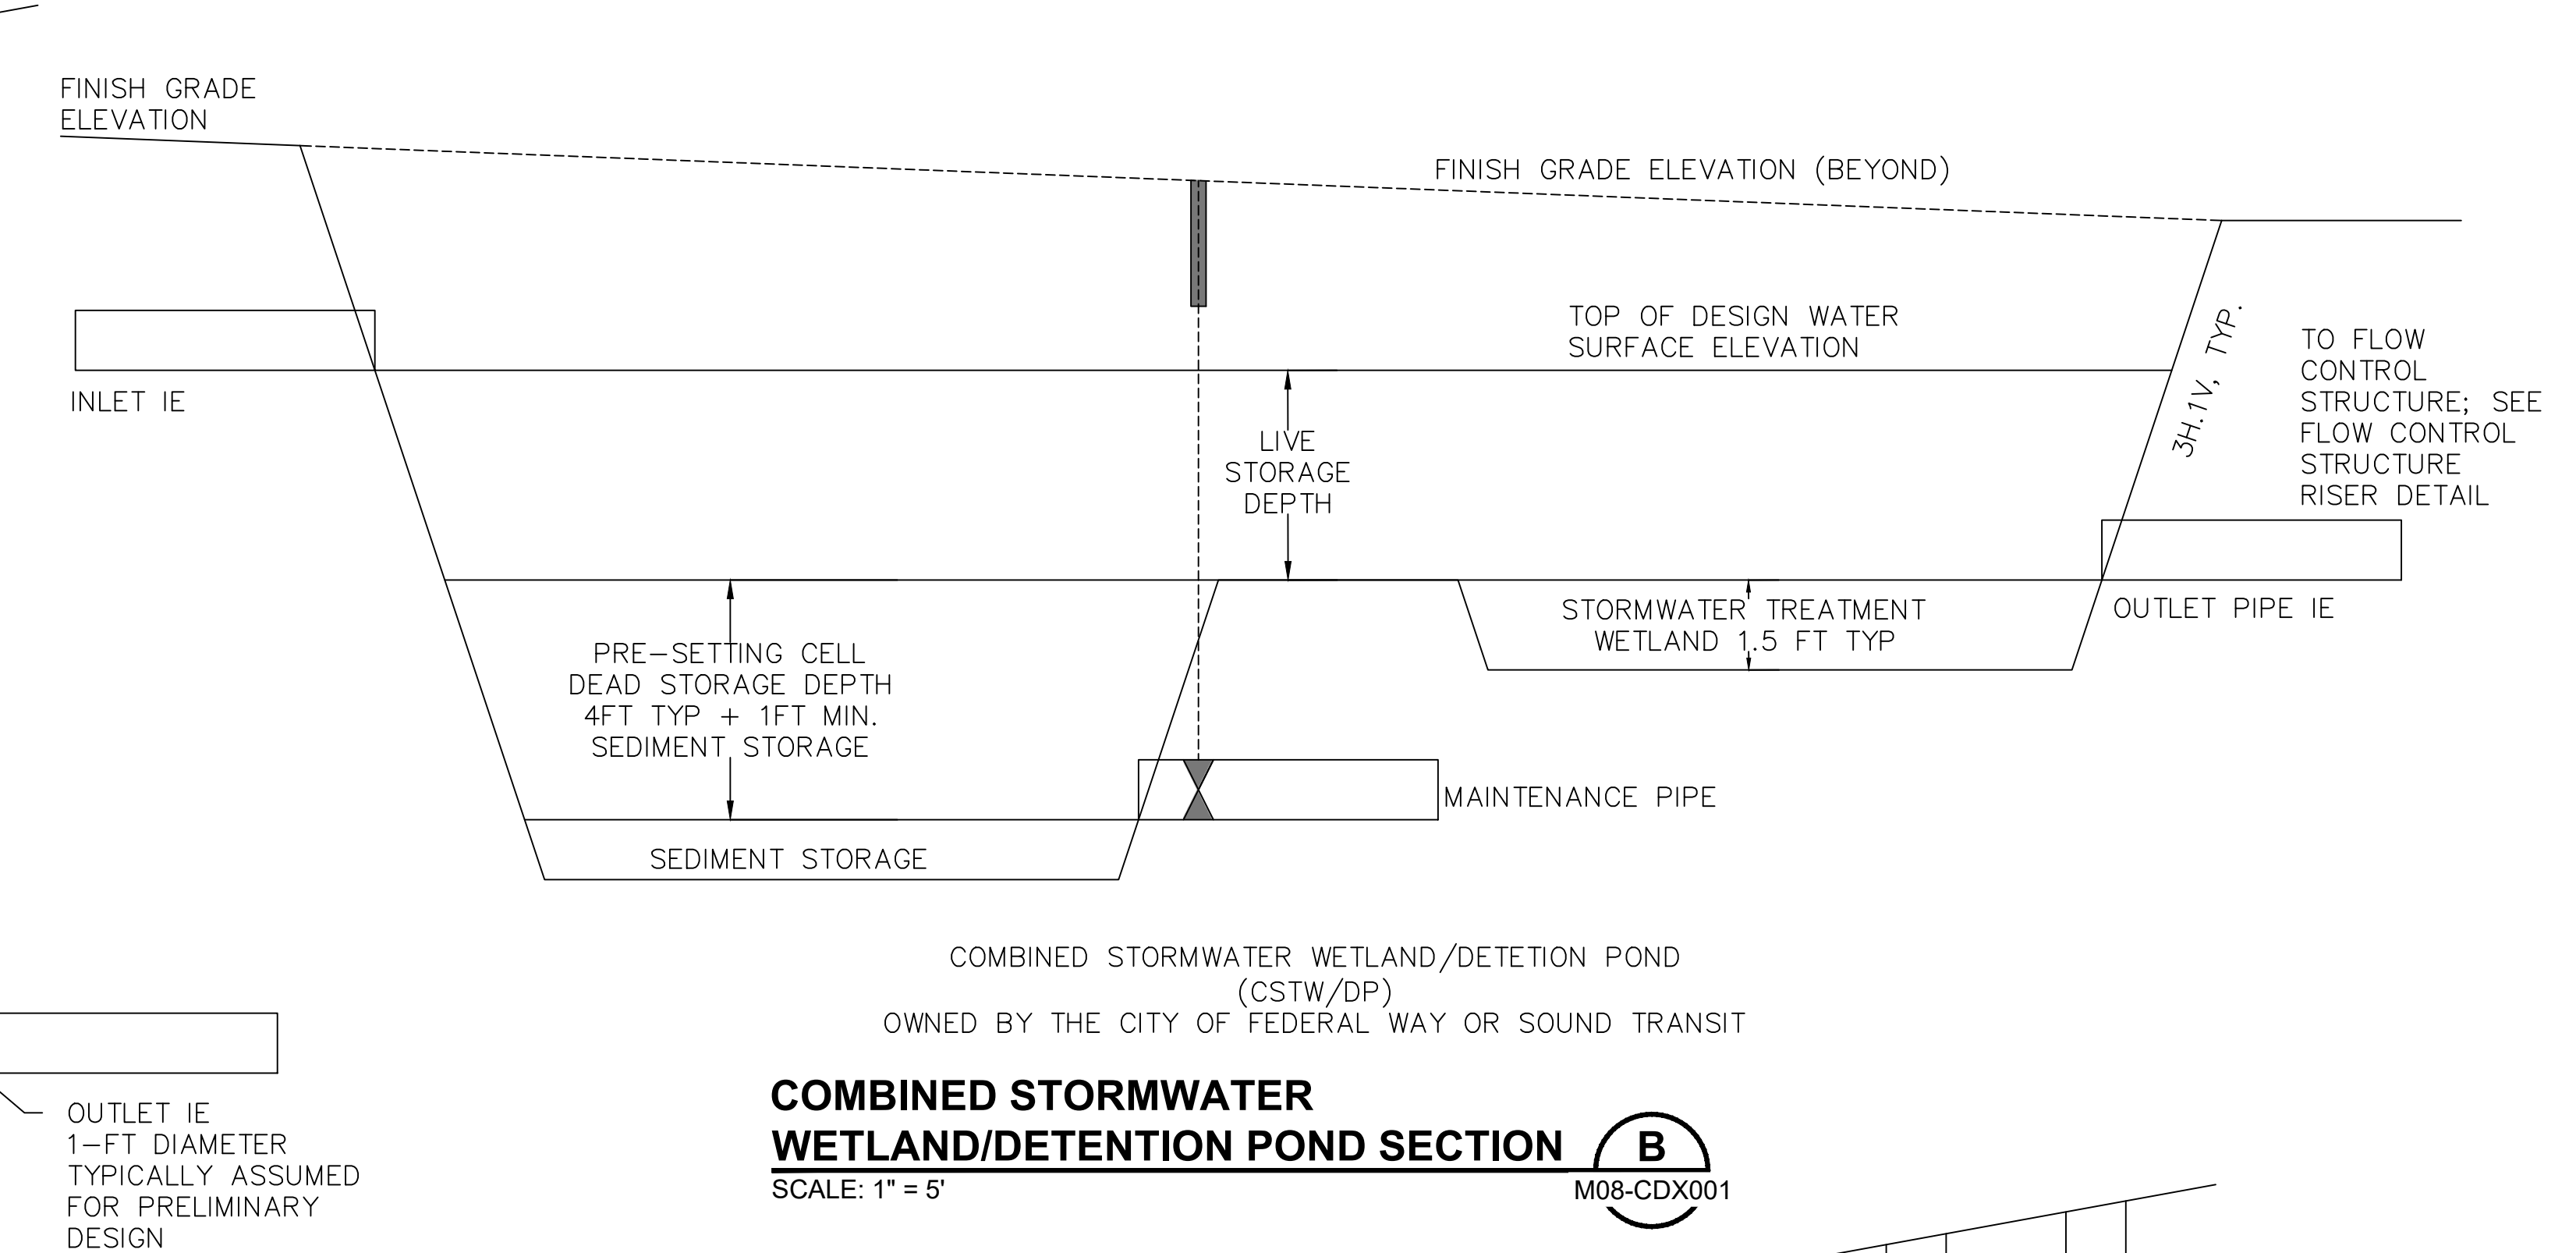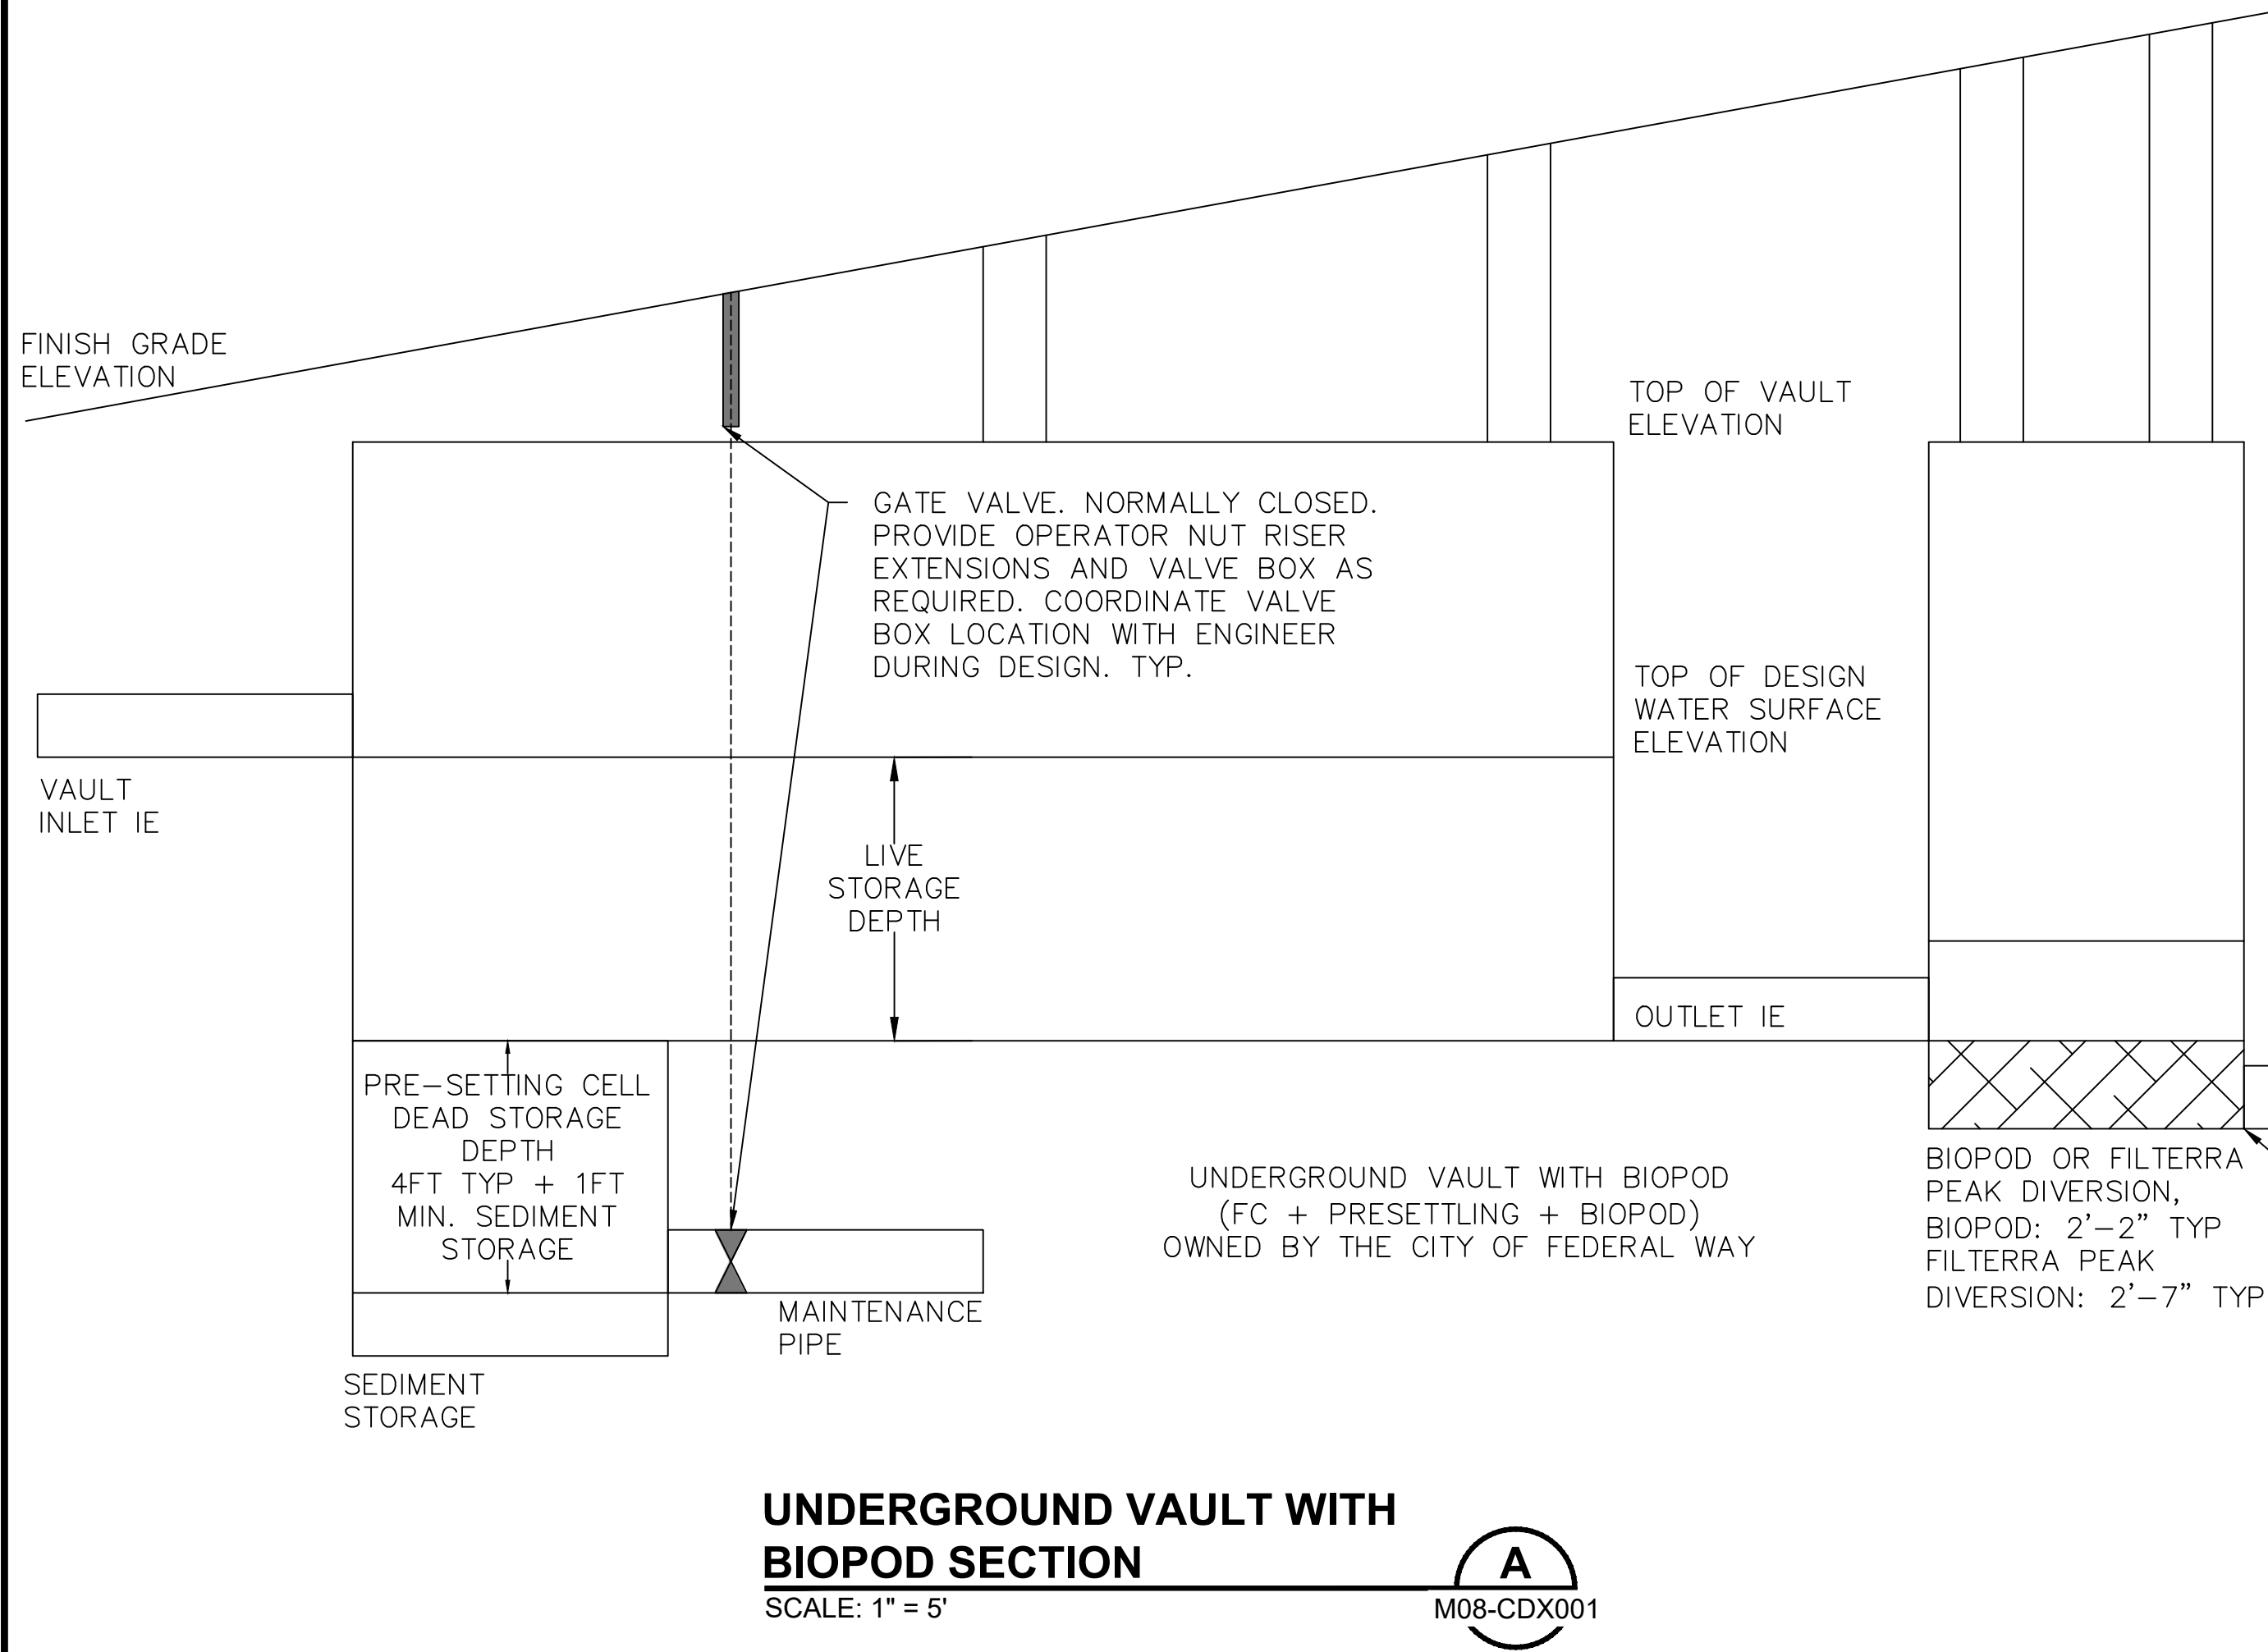

- NOTES:
1. FINISH GRADE ELEVATIONS IS LOWEST FINISH GRADE ELEVATION ABOVE FACILITY. DEPTHS MAY VARY ACROSS THE FOOTPRINT.
 2. ALL ELEVATIONS ARE APPROXIMATE AND SUBJECT TO CHANGE.

**NOT FOR
CONSTRUCTION**



[1] ROCK LINING MUST BE QUARRY SPALLS WITH GRADATION AS FOLLOWS:

PASSING 8-INCH-SQUARE SIEVE:	100%
PASSING 3-INCH-SQUARE SIEVE:	40% TO 60% MAXIMUM
PASSING ¾-INCH-SQUARE SIEVE:	0 TO 10% MAXIMUM

[2] RIPRAP MUST BE REASONABLY WELL-GRADED WITH GRADATION AS FOLLOWS:

MAXIMUM STONE SIZE:	24 INCHES (NOMINAL DIAMETER)
MEDIAN STONE SIZE:	16 INCHES MINIMUM STONE
SIZE:	4 INCHES

PROVIDE ROCK LINING ROCK PROTECTION FOR PIPE OUTFALLS FROM THE FOLLOWING SWM FACILITIES:
WINGED FOOT
COMBINED OUTFALL FROM 2A SOUTH NORTH POND, 2A SOUTH SOUTH POND, OAKLAND HILLS + 24TH 2A
COMBINED OUTFALL FROM 2B, TPSS, 24TH 2B + 24TH 2B WQ
336TH EAST
DISCHARGE PIPE INTO 18TH A+B+C POND
COMBINED OUTFALL FROM 341ST EAST, 21ST NORTH + 21ST SOUTH

PROVIDE RIPRAP ROCK PROTECTION FOR PIPE OUTFALLS FROM THE FOLLOWING SWM FACILITIES:
2A NORTH
3
COMBINED OUTFALL FROM 4 + SITE E
WSDOT POND R OUTFALL MODIFICATION

1. FLOW CONTROL STRUCTURE DETAIL FOR STRUCTURE EXTERNAL TO FLOW CONTROL FACILITY, RISER, ORIFICE, AND NOTCH INFORMATION ALSO USED FOR PRELIMINARY DESIGN PURPOSES FOR FLOW CONTROL RISER INSIDE OF FLOW CONTROL VAULTS.
2. SEE WSDOT STANDARD PLAN B-10-40-02 FOR FURTHER DETAILS.
3. ORIFICE OPENING IN RESTRICTOR PLATE TO BE CUT ROUND AND SMOOTH.

A
M08-CDX00

NOT FOR
CONSTRUCTION

*Refer to the plan set COVER drawing
for disclaimers regarding this drawing*

