




SR 522 Bus Rapid Transit

APPENDIX A-2 Set 2

Lake Forest Park Conceptual Engineering Plans

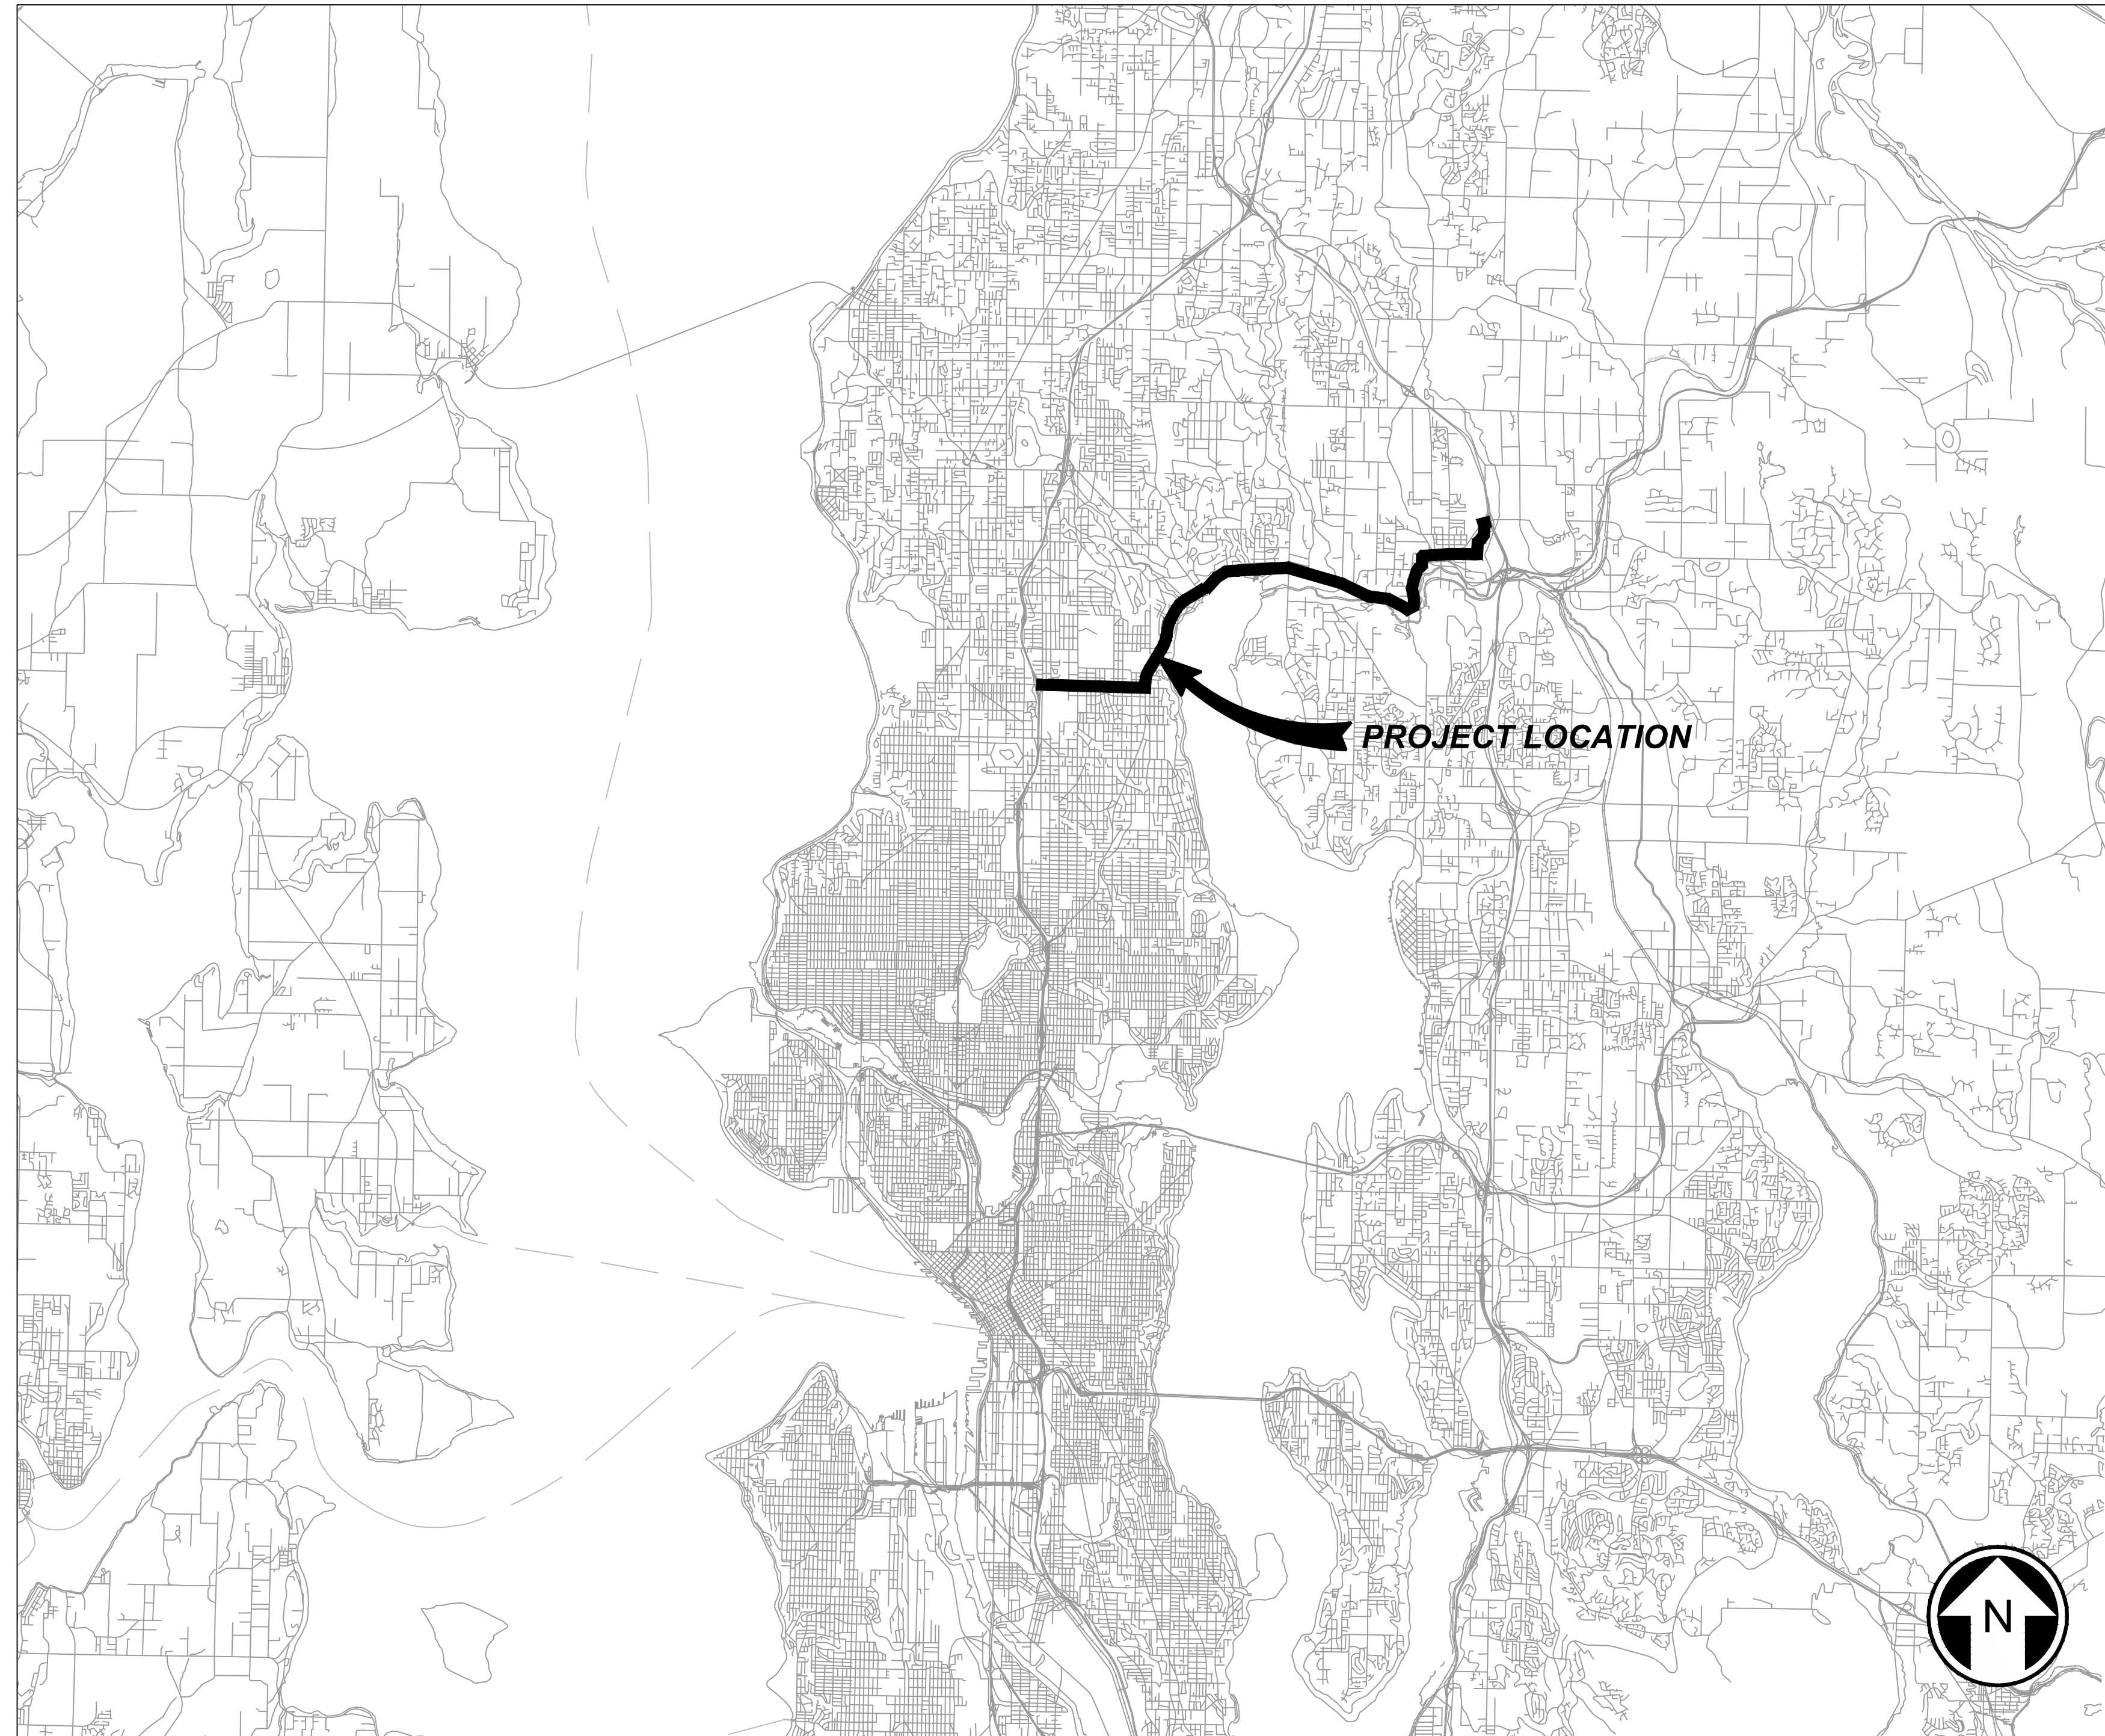

CONTRACT LOCATION MAP

SOUND TRANSIT BUS RAPID TRANSIT

**AE 0055-17
SR 522 / NE 145TH BRT**

**DRAFT 30% SUBMITTAL
09/11/2020**



**DAVID EVANS
AND ASSOCIATES INC.**
14432 SE Eastgate Way, Suite 400
Bellevue Washington 98007
Phone: 425.519.6500

PREPARED BY:

CONTRACT PREPARED BY:

SUBMITTED BY: _____ DATE: _____

NAME: D. SCHOCK
TITLE: PROJECT MANAGER

REVIEWED BY: _____ DATE: _____

NAME: B. KEMPER
TITLE: CORRIDOR DESIGN MANAGER

09/09/20 | 11:54 PM | SJRO
C:\PW_WORK\DEA\STEVEN ROSE\DWG\06724\BRT-522-GZT002.DWG

INDEX OF DRAWINGS												
SHT. No. DWG. No.				REV	TITLE	SHT. No. DWG. No.				REV	TITLE	
GENERAL SHEETS						TYPICAL ROADWAY SECTIONS (CONTINUED)						
1	522-GZT201				CONTRACT LOCATION MAP	53	522-CRY205			TYPICAL ROADWAY SECTIONS		
2	522-GZT202				INDEX OF DRAWINGS	54	522-CRY206			TYPICAL ROADWAY SECTIONS		
3	522-GZT203				INDEX OF DRAWINGS	55	522-CRY207			TYPICAL ROADWAY SECTIONS		
4	522-GZT204				INDEX OF DRAWINGS	56	522-CRY208			TYPICAL ROADWAY SECTIONS		
5	522-GZN201				LEGEND, NOTES, AND ABBREVIATIONS	57	522-CRY209			TYPICAL ROADWAY SECTIONS		
6	522-GZK201				KEY PLAN	58	522-CRY210			TYPICAL ROADWAY SECTIONS		
RIGHT-OF-WAY PLANS						59	522-CRY211			TYPICAL ROADWAY SECTIONS		
7	522-RPP201				RIGHT-OF-WAY PLANS STA. 506+00 TO STA. 511+50	60	522-CRY212			TYPICAL ROADWAY SECTIONS		
8	522-RPP202				RIGHT-OF-WAY PLANS STA. 511+50 TO STA. 514+25	61	522-CRY213			TYPICAL ROADWAY SECTIONS		
9	522-RPP203				RIGHT-OF-WAY PLANS STA. 514+25 TO STA. 518+75	SITE PREPARATION PLANS						
10	522-RPP204				RIGHT-OF-WAY PLANS STA. 518+75 TO STA. 523+25	62	522-CSP201			SITE PREPARATION PLANS STA. 506+00 TO STA. 511+50		
11	522-RPP205				RIGHT-OF-WAY PLANS STA. 523+25 TO STA. 527+75	63	522-CSP202			SITE PREPARATION PLANS STA. 511+50 TO STA. 514+25		
12	522-RPP206				RIGHT-OF-WAY PLANS STA. 527+75 TO STA. 532+25	64	522-CSP203			SITE PREPARATION PLANS STA. 514+25 TO STA. 518+75		
13	522-RPP207				RIGHT-OF-WAY PLANS STA. 532+25 TO STA. 536+75	65	522-CSP204			SITE PREPARATION PLANS STA. 518+75 TO STA. 523+25		
14	522-RPP208				RIGHT-OF-WAY PLANS STA. 536+75 TO STA. 541+25	66	522-CSP205			SITE PREPARATION PLANS STA. 523+25 TO STA. 527+75		
15	522-RPP209				RIGHT-OF-WAY PLANS STA. 541+25 TO STA. 545+75	67	522-CSP206			SITE PREPARATION PLANS STA. 527+75 TO STA. 532+25		
16	522-RPP210				RIGHT-OF-WAY PLANS STA. 545+75 TO STA. 550+25	68	522-CSP207			SITE PREPARATION PLANS STA. 532+25 TO STA. 536+75		
17	522-RPP211				RIGHT-OF-WAY PLANS STA. 550+25 TO STA. 554+75	69	522-CSP208			SITE PREPARATION PLANS STA. 536+75 TO STA. 541+25		
18	522-RPP212				RIGHT-OF-WAY PLANS STA. 554+75 TO STA. 559+25	70	522-CSP209			SITE PREPARATION PLANS STA. 541+25 TO STA. 545+75		
19	522-RPP213				RIGHT-OF-WAY PLANS STA. 559+25 TO STA. 563+75	71	522-CSP210			SITE PREPARATION PLANS STA. 545+75 TO STA. 550+25		
20	522-RPP214				RIGHT-OF-WAY PLANS STA. 563+75 TO STA. 567+75	72	522-CSP211			SITE PREPARATION PLANS STA. 550+25 TO STA. 554+75		
21	522-RPP215				RIGHT-OF-WAY PLANS STA. 567+75 TO STA. 571+75	73	522-CSP212			SITE PREPARATION PLANS STA. 554+75 TO STA. 559+25		
22	522-RPP216				RIGHT-OF-WAY PLANS STA. 571+75 TO STA. 575+75	74	522-CSP213			SITE PREPARATION PLANS STA. 559+25 TO STA. 563+75		
23	522-RPP217				RIGHT-OF-WAY PLANS STA. 575+75 TO STA. 579+75	75	522-CSP214			SITE PREPARATION PLANS STA. 563+75 TO STA. 567+75		
24	522-RPP218				RIGHT-OF-WAY PLANS STA. 579+75 TO STA. 584+75	76	522-CSP215			SITE PREPARATION PLANS STA. 567+75 TO STA. 571+75		
25	522-RPP219				RIGHT-OF-WAY PLANS STA. 584+75 TO STA. 590+75	77	522-CSP216			SITE PREPARATION PLANS STA. 571+75 TO STA. 575+75		
26	522-RPP220				RIGHT-OF-WAY PLANS STA. 590+75 TO STA. 595+75	78	522-CSP217			SITE PREPARATION PLANS STA. 575+75 TO STA. 579+75		
27	522-RPP221				RIGHT-OF-WAY PLANS	79	522-CSP218			SITE PREPARATION PLANS STA. 579+75 TO STA. 584+75		
28	522-RPP222				RIGHT-OF-WAY PLANS	80	522-CSP219			SITE PREPARATION PLANS STA. 584+75 TO STA. 590+75		
ALIGNMENT PLANS						81	522-CSP220			SITE PREPARATION PLANS STA. 590+75 TO STA. 595+75		
29	522-CAP201				ALIGNMENT PLANS STA. 506+00 TO STA. 511+50	CONSTRUCTION STAGING AREA DETAILS						
30	522-CAP202				ALIGNMENT PLANS STA. 511+50 TO STA. 514+25	82	522-CSD201			CONSTRUCTION STAGING AREA DETAILS		
31	522-CAP203				ALIGNMENT PLANS STA. 514+25 TO STA. 518+75	83	522-CSD202			CONSTRUCTION STAGING AREA DETAILS		
32	522-CAP204				ALIGNMENT PLANS STA. 518+75 TO STA. 523+25	84	522-CSD203			CONSTRUCTION STAGING AREA DETAILS		
33	522-CAP205				ALIGNMENT PLANS STA. 523+25 TO STA. 527+75	PAVING PLANS						
34	522-CAP206				ALIGNMENT PLANS STA. 527+75 TO STA. 532+25	85	522-CPP201			PAVING PLANS STA. 506+00 TO STA. 511+50		
35	522-CAP207				ALIGNMENT PLANS STA. 532+25 TO STA. 536+75	86	522-CPP202			PAVING PLANS STA. 511+50 TO STA. 514+25		
36	522-CAP208				ALIGNMENT PLANS STA. 536+75 TO STA. 541+25	87	522-CPP203			PAVING PLANS STA. 514+25 TO STA. 518+75		
37	522-CAP209				ALIGNMENT PLANS STA. 541+25 TO STA. 545+75	88	522-CPP204			PAVING PLANS STA. 518+75 TO STA. 523+25		
38	522-CAP210				ALIGNMENT PLANS STA. 545+75 TO STA. 550+25	89	522-CPP205			PAVING PLANS STA. 523+25 TO STA. 527+75		
39	522-CAP211				ALIGNMENT PLANS STA. 550+25 TO STA. 554+75	90	522-CPP206			PAVING PLANS STA. 527+75 TO STA. 532+25		
40	522-CAP212				ALIGNMENT PLANS STA. 554+75 TO STA. 559+25	91	522-CPP207			PAVING PLANS STA. 532+25 TO STA. 536+75		
41	522-CAP213				ALIGNMENT PLANS STA. 559+25 TO STA. 563+75	92	522-CPP208			PAVING PLANS STA. 536+75 TO STA. 541+25		
42	522-CAP214				ALIGNMENT PLANS STA. 563+75 TO STA. 567+75	93	522-CPP209			PAVING PLANS STA. 541+25 TO STA. 545+75		
43	522-CAP215				ALIGNMENT PLANS STA. 567+75 TO STA. 571+75	94	522-CPP210			PAVING PLANS STA. 545+75 TO STA. 550+25		
44	522-CAP216				ALIGNMENT PLANS STA. 571+75 TO STA. 575+75	95	522-CPP211			PAVING PLANS STA. 550+25 TO STA. 554+75		
45	522-CAP217				ALIGNMENT PLANS STA. 575+75 TO STA. 579+75	96	522-CPP212			PAVING PLANS STA. 554+75 TO STA. 559+25		
46	522-CAP218				ALIGNMENT PLANS STA. 579+75 TO STA. 584+75	97	522-CPP213			PAVING PLANS STA. 559+25 TO STA. 563+75		
47	522-CAP219				ALIGNMENT PLANS STA. 584+75 TO STA. 590+75	98	522-CPP214			PAVING PLANS STA. 563+75 TO STA. 567+75		
48	522-CAP220				ALIGNMENT PLANS STA. 590+75 TO STA. 595+75	99	522-CPP215			PAVING PLANS STA. 567+75 TO STA. 571+75		
TYPICAL ROADWAY SECTIONS						100	522-CPP216			PAVING PLANS STA. 571+75 TO STA. 575+75		
49	522-CRY201				TYPICAL ROADWAY SECTIONS	101	522-CPP217			PAVING PLANS STA. 575+75 TO STA. 579+75		
50	522-CRY202				TYPICAL ROADWAY SECTIONS	102	522-CPP218			PAVING PLANS STA. 579+75 TO STA. 584+75		
51	522-CRY203				TYPICAL ROADWAY SECTIONS	103	522-CPP219			PAVING PLANS STA. 584+75 TO STA. 590+75		
52	522-CRY204				TYPICAL ROADWAY SECTIONS	104	522-CPP220			PAVING PLANS STA. 590+75 TO STA. 595+75		

DRAFT 30% SUBMITTAL						DESIGNED BY: C. MATYAS		 DAVID EVANS AND ASSOCIATES INC. 14432 SE Eastgate Way, Suite 400 Bellevue Washington 98007 Phone: 425.519.6500			LINE IS 1" AT FULL SCALE		SCALE: NTS	SR 522 / NE 145TH BRT		DRAWING No.: 522-GZT202
						FILENAME: BRT-522-GZT002										
CONTRACT No.: AE 0055-17	FACILITY ID: 522															
DATE: 09/11/2020	SHEET No.: 2 OF 283															
No.	DATE	DSN	CHK	APP	REVISION	APPROVED BY: M. FELIBERTI	SUBMITTED BY: D.SCHOCK	DATE: 09/11/2020	REVIEWED BY: B.KEMPER	DATE: 09/11/2020	DATE: 09/11/2020	CIVIL INDEX OF DRAWINGS SR522 (BOTHELL WAY NE) (LAKE FOREST PARK)				

09/09/20 | 11:54 PM | SJRO
C:\PW_WORK\DEA\STEVEN ROSE\DWG\06724\BRT-522-GZT002.DWG

INDEX OF DRAWINGS												
SHT. No.		DWG. No.	REV	TITLE	SHT. No.		DWG. No.	REV	TITLE			
ROADWAY PLAN AND PROFILES					ADA RAMP DETAILS (CONTINUED)							
105	522-CRV201		NE 153RD ST PLAN AND PROFILE STA. 10+00 TO STA. 11+79.39		158	522-CRD204		ADA CURB RAMP DETAILS SR522 (BOTHELL WAY NE) & 38TH AVE NE				
106	522-CRV202		NE 155TH ST PLAN AND PROFILE STA. 10+00 TO STA. 12+59.55		159	522-CRD205		ADA CURB RAMP DETAILS SR522 (BOTHELL WAY NE) & 39TH AVE NE				
107	522-CRV203		39TH AVE NE PLAN AND PROFILE STA. 10+00 TO STA. 13+59.01		160	522-CRD206		ADA CURB RAMP DETAILS SR522 (BOTHELL WAY NE) & NE 165TH ST				
108	522-CRV204		NE 165TH ST PLAN AND PROFILE STA. 10+00 TO STA. 11+95.53		161	522-CRD207		ADA CURB RAMP DETAILS SR522 (BOTHELL WAY NE) & NE 165TH ST				
DRIVEWAY PLAN AND PROFILES					162	522-CRD208		ADA CURB RAMP DETAILS SR522 (BOTHELL WAY NE) & 41ST AVE NE				
109	522-CRV205		DRIVEWAY PLAN AND PROFILE BRS223 STA. 10+00 TO STA. 11+21		CHANNELIZATION PLANS							
110	522-CRV206		DRIVEWAY PLAN AND PROFILES BRS236-S & BRS236-N STA. 10+00 TO STA. 11+11.51		163	522-CMP201		CHANNELIZATION & SIGNING PLANS STA. 506+00 TO STA. 511+50				
111	522-CRV207		DRIVEWAY PLAN AND PROFILES BRS238-S & BRS238-N STA. 10+00 TO STA. 11+13.69		164	522-CMP202		CHANNELIZATION & SIGNING PLANS STA. 511+50 TO STA. 514+25				
112	522-CRV208		DRIVEWAY PLAN AND PROFILES BRS240-BRS242 STA. 10+00 TO STA. 11+45.54		165	522-CMP203		CHANNELIZATION & SIGNING PLANS STA. 514+25 TO STA. 518+75				
113	522-CRV209		DRIVEWAY PLAN AND PROFILES BRS243-S, BRS243 N-S & BRS243-N		166	522-CMP204		CHANNELIZATION & SIGNING PLANS STA. 518+75 TO STA. 523+25				
114	522-CRV210		DRIVEWAY PLAN AND PROFILE BRS246 STA. 10+00 TO STA. 10+96.73		167	522-CMP205		CHANNELIZATION & SIGNING PLANS STA. 523+25 TO STA. 527+75				
115	522-CRV211		DRIVEWAY PLAN AND PROFILE BRS246-N STA. 10+00 TO STA. 10+83.20		168	522-CMP206		CHANNELIZATION & SIGNING PLANS STA. 527+75 TO STA. 532+25				
116	522-CRV212		DRIVEWAY PLAN AND PROFILE BRS250 STA. 10+00 TO STA. 11+21.21		169	522-CMP207		CHANNELIZATION & SIGNING PLANS STA. 532+25 TO STA. 536+75				
117	522-CRV213		DRIVEWAY PLAN AND PROFILE BRS250-N STA. 10+00 TO STA. 10+45.27		170	522-CMP208		CHANNELIZATION & SIGNING PLANS STA. 536+75 TO STA. 541+25				
118	522-CRV214		DRIVEWAY PLAN AND PROFILE BRS253 STA. 10+00 TO STA. 10+85.00		171	522-CMP209		CHANNELIZATION & SIGNING PLANS STA. 541+25 TO STA. 545+75				
119	522-CRV215		DRIVEWAY PLAN AND PROFILE BRS255-256 STA. 10+00 TO STA. 11+11.27		172	522-CMP210		CHANNELIZATION & SIGNING PLANS STA. 545+75 TO STA. 550+25				
120	522-CRV216		DRIVEWAY PLAN AND PROFILES BRS258-S, BRS258 N-S & BRS258-N		173	522-CMP211		CHANNELIZATION & SIGNING PLANS STA. 550+25 TO STA. 554+75				
121	522-CRV217		DRIVEWAY PLAN AND PROFILE BRS260 STA. 10+00 TO STA. 11+12.35		174	522-CMP212		CHANNELIZATION & SIGNING PLANS STA. 554+75 TO STA. 559+25				
122	522-CRV218		DRIVEWAY PLAN AND PROFILE BRS262 STA. 10+00 TO STA. 10+78.38		175	522-CMP213		CHANNELIZATION & SIGNING PLANS STA. 559+25 TO STA. 563+75				
123	522-CRV219		DRIVEWAY PLAN AND PROFILE NE 157TH PL STA. 10+00 TO STA. 12+45.97		176	522-CMP214		CHANNELIZATION & SIGNING PLANS STA. 563+75 TO STA. 567+75				
124	522-CRV220		DRIVEWAY PLAN AND PROFILE NE 157TH LN STA. 10+00 TO STA. 13+74.51		177	522-CMP215		CHANNELIZATION & SIGNING PLANS STA. 567+75 TO STA. 571+75				
125	522-CRV221		DRIVEWAY PLAN AND PROFILES NE 158TH LN-N, NE 158TH LN-S STA. 10+00 TO STA. 11+54.54		178	522-CMP216		CHANNELIZATION & SIGNING PLANS STA. 571+75 TO STA. 575+75				
126	522-CRV222		DRIVEWAY PLAN AND PROFILE BRS279 STA. 10+00 TO STA. 10+98.06		179	522-CMP217		CHANNELIZATION & SIGNING PLANS STA. 575+75 TO STA. 579+75				
127	522-CRV223		DRIVEWAY PLAN AND PROFILE BRS280.1 STA. 10+00 TO STA. 10+96.29		180	522-CMP218		CHANNELIZATION & SIGNING PLANS STA. 579+75 TO STA. 584+75				
128	522-CRV224		DRIVEWAY PLAN AND PROFILE BRS282 STA. 10+00 TO STA. 10+83.22		181	522-CMP219		CHANNELIZATION & SIGNING PLANS STA. 584+75 TO STA. 590+75				
129	522-CRV225		DRIVEWAY PLAN AND PROFILES BRS283-S & BRS283-N STA. 10+00 TO STA. 10+85.71		182	522-CMP220		CHANNELIZATION & SIGNING PLANS STA. 590+75 TO STA. 595+75				
130	522-CRV226		DRIVEWAY PLAN AND PROFILE BRS285 STA. 10+00 TO STA. 10+96.30		DRAINAGE PLANS							
131	522-CRV227		DRIVEWAY PLAN AND PROFILE BRS287 STA. 10+00 TO STA. 11+08.12		183	522-CDP201		DRAINAGE PLANS STA. 506+00 TO STA. 511+50				
132	522-CRV228		DRIVEWAY PLAN AND PROFILES BRS289-S & BRS289-N STA. 10+00 TO STA. 10+78.74		184	522-CDP202		DRAINAGE PLANS STA. 511+50 TO STA. 514+25				
133	522-CRV229		DRIVEWAY PLAN AND PROFILE BRS291 STA. 10+00 TO STA. 10+81.50		185	522-CDP203		DRAINAGE PLANS STA. 514+25 TO STA. 518+75				
134	522-CRV230		DRIVEWAY PLAN AND PROFILE BRS293 STA. 10+00 TO STA. 10+80.42		186	522-CDP204		DRAINAGE PLANS STA. 518+75 TO STA. 523+25				
135	522-CRV231		DRIVEWAY PLAN AND PROFILE BRS295 STA. 10+00 TO STA. 10+85.42		187	522-CDP205		DRAINAGE PLANS STA. 523+25 TO STA. 527+75				
136	522-CRV232		DRIVEWAY PLAN AND PROFILE BRS297 STA. 10+00 TO STA. 11+63.75		188	522-CDP206		DRAINAGE PLANS STA. 527+75 TO STA. 532+25				
137	522-CRV233		DRIVEWAY PLAN AND PROFILE BRS299 STA. 10+00 TO STA. 10+80.69		189	522-CDP207		DRAINAGE PLANS STA. 532+25 TO STA. 536+75				
138	522-CRV234		DRIVEWAY PLAN AND PROFILE BRS300 STA. 10+00 TO STA. 11+31.70		190	522-CDP208		DRAINAGE PLANS STA. 536+75 TO STA. 541+25				
139	522-CRV235		DRIVEWAY PLAN AND PROFILE BRS302-S STA. 10+00 TO STA. 10+80.45		191	522-CDP209		DRAINAGE PLANS STA. 541+25 TO STA. 545+75				
140	522-CRV236		DRIVEWAY PLAN AND PROFILE BRS304 STA. 10+00 TO STA. 11+03.66		192	522-CDP210		DRAINAGE PLANS STA. 545+75 TO STA. 550+25				
141	522-CRV237		DRIVEWAY PLAN AND PROFILE BRS306 STA. 10+00 TO STA. 10+57.64		193	522-CDP211		DRAINAGE PLANS STA. 550+25 TO STA. 554+75				
142	522-CRV238		DRIVEWAY PLAN AND PROFILE BRS 306.1 STA. 10+00 TO STA. 10+87.33		194	522-CDP212		DRAINAGE PLANS STA. 554+75 TO STA. 559+25				
143	522-CRV239		DRIVEWAY PLAN AND PROFILE BRS 308 STA. 10+00 TO STA. 10+98.29		195	522-CDP213		DRAINAGE PLANS STA. 559+25 TO STA. 563+75				
144	522-CRV240		DRIVEWAY PLAN AND PROFILE BRS 308.1 STA. 10+00 TO STA. 10+59.72		196	522-CDP214		DRAINAGE PLANS STA. 563+75 TO STA. 567+75				
145	522-CRV241		DRIVEWAY PLAN AND PROFILE BRS310 STA. 10+00 TO STA. 10+86.58		197	522-CDP215		DRAINAGE PLANS STA. 567+75 TO STA. 571+75				
146	522-CRV242		DRIVEWAY PLAN AND PROFILE BRS312 STA. 10+00 TO STA. 10+84.41		198	522-CDP216		DRAINAGE PLANS STA. 571+75 TO STA. 575+75				
147	522-CRV243		DRIVEWAY PLAN AND PROFILE BRS314 STA. 10+00 TO STA. 10+66.47		199	522-CDP217		DRAINAGE PLANS STA. 575+75 TO STA. 579+75				
148	522-CRV244		DRIVEWAY PLAN AND PROFILE BRS316 STA. 10+00 TO STA. 11+08.10		200	522-CDP218		DRAINAGE PLANS STA. 579+75 TO STA. 584+75				
149	522-CRV245		DRIVEWAY PLAN AND PROFILES BRS317-S & BRS317-N STA. 10+00 TO STA. 11+08.34		201	522-CDP219		DRAINAGE PLANS STA. 584+75 TO STA. 590+75				
150	522-CRV246		DRIVEWAY PLAN AND PROFILE BRS320 STA. 10+00 TO STA. 11+44+26		202	522-CDP220		DRAINAGE PLANS STA. 590+75 TO STA. 595+75				
151	522-CRV247		DRIVEWAY PLAN AND PROFILE BRS322 STA. 10+00 TO STA. 11+19.44		ILLUMINATION PLANS							
152	522-CRV248		DRIVEWAY PLAN AND PROFILE BRS323 STA. 10+00 TO STA. 10+91.76		203	522-TLP201		ILLUMINATION PLANS STA. 527+90 TO STA. 535+00				
153	522-CRV249		DRIVEWAY PLAN AND PROFILE BRS325 STA. 10+00 TO STA. 10+84.19		204	522-TLP202		ILLUMINATION PLANS STA. 562+60 TO STA. 568+50				
154	522-CRV250		DRIVEWAY PLAN AND PROFILE BRS337 STA. 10+00 TO STA. 10+80		205	522-TLP203		ILLUMINATION PLANS ONE-LINE DIAGRAM				
ADA RAMP DETAILS					COMPOSITE UTILITY PLANS							
155	522-CRD201		ADA CURB RAMP DETAILS SR522 (BOTHELL WAY NE) & NE 147TH ST		206	522-URP201		COMPOSITE UTILITY PLANS STA. 506+00 TO STA. 511+50				
156	522-CRD202		ADA CURB RAMP DETAILS SR522 (BOTHELL WAY NE) & NE153RD ST		207	522-URP202		COMPOSITE UTILITY PLANS STA. 511+50 TO STA. 514+25				
157	522-CRD203		ADA CURB RAMP DETAILS SR522 (BOTHELL WAY NE) & NE 155TH ST									

DRAFT 30% SUBMITTAL						DESIGNED BY: C.MATYAS		 DAVID EVANS AND ASSOCIATES INC. 14432 SE Eastgate Way, Suite 400 Bellevue Washington 98007 Phone: 425.519.6500			LINE IS T A T FULL SCALE		SCALE: NTS	SR 522 / NE 145TH BRT		DRAWING No.: 522-GTZ203
						DRAWN BY: O.AHRENSFELD							FILENAME: BRT-522-GZT002			FACILITY ID: 522
						CHECKED BY: R. KOESTER							CONTRACT No.: AE 0055-17			SHEET No.: 3 OF 283
						APPROVED BY: M.FELIBERTI							DATE: 09/11/2020			REV: CIVIL INDEX OF DRAWINGS SR522 (BOTHELL WAY NE) (LAKE FOREST PARK)
No.	DATE	DSN	CHK	APP	REVISION		SUBMITTED BY: D.SCHOCK	DATE: 09/11/2020	REVIEWED BY: B.KEMPER	DATE: 09/11/2020	DATE: 09/11/2020					

09/09/20 | 11:54 PM | SJRO
C:\PW_WORK\DEA\STEVEN ROSE\DWG\506724\BRT-522-GZT002.DWG

INDEX OF DRAWINGS																								
SHT. No. DWG. No.				REV	TITLE	SHT. No. DWG. No.				REV	TITLE													
COMPOSITE UTILITY PLANS (CONTINUED)						ARCHITECTURAL STATION PLANS AND DETAILS (CONTINUED)																		
208	522-URP203				COMPOSITE UTILITY PLANS STA. 514+25 TO STA. 518+75	260	522-APD213				ARCHITECTURAL STATION DETAILS LAKE FOREST PARK TOWN CENTER													
209	522-URP204				COMPOSITE UTILITY PLANS STA. 518+75 TO STA. 523+25	261	522-ASX214				ARCHITECTURAL STATION SECTIONS LAKE FOREST PARK TOWN CENTER													
210	522-URP205				COMPOSITE UTILITY PLANS STA. 523+25 TO STA. 527+75	LANDSCAPE PLANTING PLANS AND DETAILS																		
211	522-URP206				COMPOSITE UTILITY PLANS STA. 527+75 TO STA. 532+25	262	522-LPP201				LANDSCAPE PLANTING PLANS STA. 506+00 TO STA. 511+50													
212	522-URP207				COMPOSITE UTILITY PLANS STA. 532+25 TO STA. 536+75	263	522-LPP202				LANDSCAPE PLANTING PLANS STA. 511+50 TO STA. 514+25													
213	522-URP208				COMPOSITE UTILITY PLANS STA. 536+75 TO STA. 541+25	264	522-LPP203				LANDSCAPE PLANTING PLANS STA. 514+25 TO STA. 518+75													
214	522-URP209				COMPOSITE UTILITY PLANS STA. 541+25 TO STA. 545+75	265	522-LPP204				LANDSCAPE PLANTING PLANS STA. 518+75 TO STA. 523+25													
215	522-URP210				COMPOSITE UTILITY PLANS STA. 545+75 TO STA. 550+25	266	522-LPP205				LANDSCAPE PLANTING PLANS STA. 523+25 TO STA. 527+75													
216	522-URP211				COMPOSITE UTILITY PLANS STA. 550+25 TO STA. 554+75	267	522-LPP206				LANDSCAPE PLANTING PLANS STA. 527+75 TO STA. 532+25													
217	522-URP212				COMPOSITE UTILITY PLANS STA. 554+75 TO STA. 559+25	268	522-LPP207				LANDSCAPE PLANTING PLANS STA. 532+25 TO STA. 536+75													
218	522-URP213				COMPOSITE UTILITY PLANS STA. 559+25 TO STA. 563+75	269	522-LPP208				LANDSCAPE PLANTING PLANS STA. 536+75 TO STA. 541+25													
219	522-URP214				COMPOSITE UTILITY PLANS STA. 563+75 TO STA. 567+75	270	522-LPP209				LANDSCAPE PLANTING PLANS STA. 541+25 TO STA. 545+75													
220	522-URP215				COMPOSITE UTILITY PLANS STA. 567+75 TO STA. 571+75	271	522-LPP210				LANDSCAPE PLANTING PLANS STA. 545+75 TO STA. 550+25													
221	522-URP216				COMPOSITE UTILITY PLANS STA. 571+75 TO STA. 575+75	272	522-LPP211				LANDSCAPE PLANTING PLANS STA. 550+25 TO STA. 554+75													
222	522-URP217				COMPOSITE UTILITY PLANS STA. 575+75 TO STA. 579+75	273	522-LPP212				LANDSCAPE PLANTING PLANS STA. 554+75 TO STA. 559+25													
223	522-URP218				COMPOSITE UTILITY PLANS STA. 579+75 TO STA. 584+75	274	522-LPP213				LANDSCAPE PLANTING PLANS STA. 559+25 TO STA. 563+75													
224	522-URP219				COMPOSITE UTILITY PLANS STA. 584+75 TO STA. 590+75	275	522-LPP214				LANDSCAPE PLANTING PLANS STA. 563+75 TO STA. 567+75													
225	522-URP220				COMPOSITE UTILITY PLANS STA. 590+75 TO STA. 595+75	276	522-LPP215				LANDSCAPE PLANTING PLANS STA. 567+75 TO STA. 571+75													
TRAFFIC SIGNALIZATION PLANS						277	522-LPP216				LANDSCAPE PLANTING PLANS STA. 571+75 TO STA. 575+75													
226	522-TSN201				SIGNAL PLANS LEGEND AND NOTES	278	522-LPP217				LANDSCAPE PLANTING PLANS STA. 575+75 TO STA. 579+75													
227	522-TSP201				SIGNAL PLANS SR522 (BOTHELL WAY NE) & 153RD ST	279	522-LPP218				LANDSCAPE PLANTING PLANS STA. 579+75 TO STA. 584+75													
228	522-TSP202				SIGNAL PLANS SR522 (BOTHELL WAY NE) & 165TH ST	280	522-LPP219				LANDSCAPE PLANTING PLANS STA. 584+75 TO STA. 590+75													
229	522-TSP203				SIGNAL PLANS SR522 (BOTHELL WAY NE) & 165TH ST	281	522-LPP220				LANDSCAPE PLANTING PLANS STA. 590+75 TO STA. 595+75													
WALL PLAN AND PROFILES						282	522-LPD201				LANDSCAPE PLANTING DETAILS													
230	522-SWP201				WALL PLAN AND PROFILE STA. 520+50 TO STA. 524+00	283	522-LPD202				LANDSCAPE PLANTING DETAILS													
231	522-SWP202				WALL PLAN AND PROFILE STA. 525+50 TO STA. 528+25																			
232	522-SWP203				WALL PLAN AND PROFILE STA. 531+75 TO STA. 536+25																			
233	522-SWP204				WALL PLAN AND PROFILE STA. 537+75 TO STA. 542+75																			
234	522-SWP205				WALL PLAN AND PROFILE STA. 544+00 TO STA. 548+25																			
235	522-SWP206				WALL PLAN AND PROFILE STA. 548+25 TO STA. 552+25																			
236	522-SWP207				WALL PLAN AND PROFILE STA. 563+75 TO STA. 566+50																			
237	522-SWP208				WALL PLAN AND PROFILE STA. 572+50 TO STA. 577+50																			
238	522-SWP209				WALL PLAN AND PROFILE STA. 529+50 TO STA. 531+50																			
239	522-SWP210				WALL PLAN AND PROFILE STA. 538+00 TO STA. 541+00																			
240	522-SWP211				WALL PLAN AND PROFILE STA. 541+25 TO STA. 545+50																			
241	522-SWP212				WALL PLAN AND PROFILE STA. 545+50 TO STA. 550+00																			
242	522-SWP213				WALL PLAN AND PROFILE STA. 550+00 TO STA. 552+50																			
243	522-SWP214				WALL PLAN AND PROFILE STA. 552+50 TO STA. 557+00																			
244	522-SWP215				WALL PLAN AND PROFILE STA. 557+00 TO STA. 561+50																			
245	522-SWP216				WALL PLAN AND PROFILE STA. 561+50 TO STA. 565+25																			
246	522-SWP217				WALL PLAN AND PROFILE STA. 565+50 TO STA. 570+00																			
247	522-SWP218				WALL PLAN AND PROFILE STA. 570+00 TO STA. 575+50																			
248	522-SWP219				WALL PLAN AND PROFILE STA. 10+00 TO STA. 13+50																			
249	522-SWP220				WALL PLAN AND PROFILE STA. 10+00 TO STA. 11+50																			
ARCHITECTURAL STATION PLANS AND DETAILS																								
250	522-ASP201				ARCHITECTURAL STATION SITE PLAN NE 153RD ST & SR522																			
251	522-APD202				ARCHITECTURAL STATION DETAILS NE 153RD ST & SR522																			
252	522-APD203				ARCHITECTURAL STATION DETAILS NE 153RD ST & SR522																			
253	522-ASX204				ARCHITECTURAL STATION SECTIONS NE 153RD ST & SR522																			
254	522-ASP205				ARCHITECTURAL STATION SITE PLAN NE 165TH ST & SR522																			
255	522-APD206				ARCHITECTURAL STATION DETAILS NE 165TH ST & SR522																			
256	522-APD207				ARCHITECTURAL STATION DETAILS NE 165TH ST & SR522																			
257	522-ASX208				ARCHITECTURAL STATION SECTIONS NE 165TH ST & SR522																			
258	522-ASP211				ARCHITECTURAL STATION SITE PLAN LAKE FOREST PARK TOWN CENTER																			
259	522-APD212				ARCHITECTURAL STATION DETAILS LAKE FOREST PARK TOWN CENTER																			
DRAFT 30% SUBMITTAL						DESIGNED BY: C. MATYAS			 DAVID EVANS AND ASSOCIATES INC. 14432 SE Eastgate Way, Suite 400 Bellevue Washington 98007 Phone: 425.519.6500						SCALE: NTS		SR 522 / NE 145TH BRT SR 522 (BOTHELL WAY NE) CIVIL INDEX OF DRAWINGS SR522 (BOTHELL WAY NE) (LAKE FOREST PARK)		DRAWING No.: 522-GTZ204					
						DRAWN BY: O.AHRENSFELD																		
						CHECKED BY: R. KOESTER																		
						APPROVED BY: M. FELIBERTI																		
No.	DATE	DSN	CHK	APP	REVISION	SUBMITTED BY: D.SCHOCK		DATE: 09/11/2020		REVIEWED BY: B.KEMPER		DATE: 09/11/2020		DATE: 09/11/2020				4 OF 283						

1. CONTRACTOR SHALL FAMILIARIZE THEMSELVES WITH THE SITE AND SHALL BRING ANY DISCREPANCIES TO THE ATTENTION OF THE ENGINEER PRIOR TO UNDERTAKING THE AFFECTED WORK.
2. ANY DISCREPANCIES IN THESE DRAWINGS, SPECIFICATIONS, THESE NOTES AND SITE CONDITIONS SHALL BE REPORTED TO THE ENGINEER, WHO SHALL CORRECT SUCH DISCREPANCY IN WRITING AFTER REVIEWING ANY CHANGES. ANY WORK PERFORMED BY THE CONTRACTOR AFTER THE DISCOVERY OF SUCH DISCREPANCY SHALL BE PERFORMED AT THE CONTRACTOR'S OWN RISK. THE CONTRACTOR SHALL VERIFY AND COORDINATE THE DIMENSIONS AMONG ALL DRAWINGS PRIOR TO PROCEEDING WITH ANY WORK.
3. IT IS THE RESPONSIBILITY OF THE CONTRACTOR WHEN IN THE VICINITY OF ANY UTILITY LINES TO NOTIFY ALL UTILITIES/AGENCIES WHEN CONSTRUCTION WORK BEGINS AND TO ARRANGE FOR A REPRESENTATIVE OF THE UTILITY/AGENCY TO BE PRESENT. THE CONTRACTOR SHALL COORDINATE ITS ACTIVITIES WITH ALL UTILITIES/AGENCIES.
4. NO FIELD CHANGES WILL BE PERMITTED WITHOUT DIRECT WRITTEN AUTHORIZATION FROM THE RESIDENT ENGINEER.
5. CONTRACTOR SHALL COORDINATE WORK WHICH AFFECTS ADJACENT PROPERTY OWNERS. ANY QUESTIONS OR AGREEMENTS BETWEEN ADJACENT PROPERTY OWNERS AND CONTRACTOR SHALL BE MADE IN WRITING. A COPY OF SUCH AGREEMENT SHALL BE PROVIDED TO SOUND TRANSIT.
6. SOME EXISTING UNDERGROUND UTILITIES SUCH AS STREET LIGHT UNDERGROUND POWER IN LOCALIZED AREAS, MAY NOT BE INDICATED ON THE UTILITY BASEMAP.
7. SEE SHEETS 522-CDP201 THROUGH 522-CDP220 FOR PROPOSED STORM DRAINAGE.
8. EXISTING UTILITY SERVICES TO PRIVATE PROPERTIES ARE NOT SHOWN ON THIS DRAWING.

1. THE CONTRACTOR SHALL CALL 1-800-424-5555 (OR 811) NO LATER THAN 48 HOURS BEFORE AND NO EARLIER THAN 15 DAYS BEFORE BEGINNING EXCAVATION WHERE ANY UNDERGROUND UTILITIES MAY BE LOCATED. FAILURE TO DO SO COULD MEAN BEARING SUBSTANTIAL REPAIR COSTS (UP TO THREE TIMES THE COST OF REPAIRS TO THE SERVICE).
2. THE CONTRACTOR SHALL PROTECT, IN PLACE, ALL UTILITIES AND/OR THEIR STRUCTURES WHETHER OR NOT THEY ARE SHOWN ON THE PLANS. DAMAGE DUE TO THE CONTRACTOR'S OPERATIONS SHALL BE REPAIRED AT THE CONTRACTOR'S EXPENSE TO CURRENT AGENCY STANDARDS.

UNDERGROUND UTILITIES SHOWN REPRESENT VARIOUS SUBSURFACE UTILITY QUALITY LEVELS. FOLLOWING IS A GENERAL DESCRIPTION OF THE UTILITIES REPRESENTED HEREON:

WATER, NATURAL GAS, UNDERGROUND ELECTRIC, UNDERGROUND COMMUNICATIONS LINES:
THE MAJORITY OF THESE UTILITY FEATURES ARE BASED ON FIELD SURVEYED PAINT MARKS AS PLACED ON THE GROUND BY A UTILITY LOCATE SERVICE AND ARE CATEGORIZED AS SUBSURFACE UTILITY QUALITY LEVEL B. IN CASES WHERE THESE UTILITIES WERE EITHER NON-CONDUCTIBLE OR INACCESSIBLE, GIS RECORDS WERE UTILIZED TO DETERMINE UTILITY LOCATIONS AND THE UTILITY LINES WERE CATEGORIZED AS **SUBSURFACE UTILITY QUALITY LEVEL D.**

THESE SYSTEMS ARE SHOWN BASED ON A SURVEY OF MANHOLES AND CATCH BASINS. ALL STRUCTURES WERE OPENED TO DETERMINE PIPE SIZE, TYPE AND DIRECTION. WITH MINOR EXCEPTION ALL SANITARY SEWER AND STORM DRAIN SYSTEMS SHOWN HEREON ARE CATEGORIZED AS **SUBSURFACE UTILITY QUALITY LEVEL C**. IN CASES WHERE THE LOCATION OF THE SYSTEMS WAS NOT EVIDENT BASED ON THE LOCATION OF SURFACE FEATURES, GIS RECORDS WERE UTILIZED TO DETERMINE UTILITY LOCATIONS AND THOSE UTILITY LINES WERE CATEGORIZED AS **SUBSURFACE UTILITY QUALITY LEVEL D**.

UTILITY QUALITY LEVEL A - IS THE HIGHEST LEVEL OF ACCURACY INVOLVING THE FULL USE OF THE SUBSURFACE UTILITY ENGINEERING SERVICES. IT PROVIDES INFORMATION FOR THE PRECISE PLAN AND PROFILE MAPPING OF UNDERGROUND UTILITIES THROUGH THE NONDESTRUCTIVE EXPOSURE OF UNDERGROUND UTILITIES, AND ALSO PROVIDES THE TYPE, SIZE, CONDITION, MATERIAL AND OTHER CHARACTERISTICS OF UNDERGROUND FEATURES. UNLESS OTHERWISE NOTED, QUALITY LEVEL A IS ONLY APPLICABLE AT THE SPECIFIC LOCATIONS NOTED ON THE DRAWING. AT ALL OTHER AREAS, THE UTILITY SHOULD BE ASSUMED TO BE QUALITY LEVEL B.

UTILITY QUALITY LEVEL B - UTILITY LOCATIONS DERIVED FROM APPLICATION OF APPROPRIATE SURFACE GEOPHYSICAL METHODS TO DETERMINE THE EXISTENCE AND HORIZONTAL POSITION OF UTILITIES. INFORMATION PROVIDED BY QL-B IS SUFFICIENT TO SUPPORT PRELIMINARY ENGINEERING.


UTILITY QUALITY LEVEL C - UTILITY LOCATIONS DERIVED BY SURVEY OF VISIBLE UTILITY FACILITIES (E.G., MANHOLES, VALVE BOXES, ETC.) AND CORRELATING THIS INFORMATION WITH EXISTING UTILITY RECORDS (QI-D INFORMATION). ITS USEFULNESS, IS PRIMARILY ON RURAL PROJECTS WHERE UTILITIES ARE NOT PREVALENT.

UTILITY QUALITY LEVEL D - IS THE MOST BASIC LEVEL OF INFORMATION FOR UTILITY LOCATIONS AND IS BASED SOLELY ON EXISTING UTILITY RECORDS OR VERBAL RECOLLECTIONS. QL-D IS USEFUL PRIMARILY FOR PROJECT PLANNING AND ROUTE SELECTION ACTIVITIES.

EXISTING	PROPOSED	DESCRIPTION
		ASPHALT CONCRETE
		CONCRETE
		LANDSCAPING AREA
		CEMENT CONCRETE REMOVAL AREA
		ASPHALT REMOVAL AREA
		OBJECT/STRUCTURE REMOVAL
		CB TYPE 1
		CB TYPE 2
SD	SD	STORM DRAIN PIPE
		REMOVE EX. FEATURE
		POLE & LED LUMINAIRE
	E	ELECTRICAL CONDUIT
		JUNCTION BOX (TYPE 1, 2, & 3)
		SERVICE CABINET
		SIGN
G	G	GAS UNDERGROUND LINE
E	E	POWER UNDERGROUND LINE
OE	OE	POWER OVERHEAD LINE
SS	SS	SANITARY SEWER LINE
T	T	TELEPHONE UNDERGROUND LINE
W	W	WATER LINE
		INLET PROTECTION
		FILL RETAINING WALL
		CUT RETAINING WALL
	HVF	HIGH VISIBILITY FENCE
		SAWCUT
		CEMENT CONCRETE CURB & GUTTER REMOVAL
		EXTRUDED CURB REMOVAL
		CLEARING & GRUBBING LIMITS
		RIGHT OF WAY
		PROPERTY LINE
		WSDOT LIMITED ACCESS
		PERMANENT EASEMENT
		TEMPORARY EASEMENT
		UTILITY EASEMENT
		STATION IMPROVEMENTS OUTLINE



AC	ASPHALT	IR	IRON ROD
APPROX	APPROXIMATELY	JBOX	JUNCTION BOX
ASTM	ASTM INTERNATIONAL	LF	LINEAR FEET
BAT	BUSINESS ACCESS AND TRANSIT	MH	MANHOLE
BP	BRASS PIN	MAX	MAXIMUM
BOH	BUILDING OVERHANG	MIN	MINIMUM
BRS	SOUND TRANSIT PARCEL IDENTIFICATION	ML	MAINLINE
(C)	CALCULATED	MPH	MILES PER HOUR
CB	CATCH BASIN	MON	MONUMENT
CDF	CONTROLLED DENSITY FILL	MW	MONITORING WELL
CFS	CUBIC FEET PER SECOND	OC	ON CENTER
CG	CURB AND GUTTER	OCS	OVERHEAD CONTACT SYSTEM
CIP	CAST IN PLACE	OH	OVERHEAD
CL	CENTERLINE	OMF	OPERATIONS AND MAINTENANCE FACILITY
CLF	CHAIN LINK FENCE	OP	OVERHEAD POWER
CO	CLEANOUT	OWS	OIL-WATER SEPARATOR
CONC	CONCRETE	PP	POWER POLE
CSBC	CRUSHED SURFACING BASE COURSE	SB	SURFACE BRASS MONUMENT
CULV	CULVERT	SCL	SEATTLE CITY LIGHT
DI	DUCTILE IRON	SD	STORM DRAIN
DIA	DIAMETER	SDMH	STORM DRAIN MANHOLE
DEA	DAVID EVANS AND ASSOCIATES INC.	SS	SANITARY SEWER
DWG	DRAWING	SSMH	SANITARY SEWER MANHOLE
EA	EACH	ST	SOUND TRANSIT
ECC	EXTRUDED CONCRETE CURB	TESC	TEMPORARY EROSION AND SEDIMENT CONTROL
ELEC	ELECTRICAL	TO	TURNOUT
ELEV	ELEVATION	TYP	TYPICAL
EP	EDGE OF PAVEMENT	WM	WATER METER
EX	EXISTING	WQ	WATER QUALITY
FD	FOUND	WV	WATER VALVE
FH	FIRE HYDRANT		
FT	FOOT		
GALV	GALVANIZED		
GM	GAS METER		
GND	GROUND		
IE	INVERT ELEVATION		
IN	INCH		

PROJECT CONTACTS		
AGENCY	CONTACT	PHONE
SOUND TRANSIT	--	-
WSDOT	-	-
-	-	-

 DRAFT 30% SUBMITTAL						DESIGNED BY: C.MATYAS		DAVID EVANS AND ASSOCIATES INC. 14432 SE Eastgate Way, Suite 400 Bellevue Washington 98007 Phone: 425.519.6500			LINE IS 1" AT FULL SCALE		SCALE: NTS	SR 522 / NE 145TH BRT SR 522 (BOTHELL WAY NE) CIVIL LEGEND, NOTES, AND ABBREVIATIONS SR522 (BOTHELL WAY NE) (LAKE FOREST PARK)			DRAWING No.: GZN201								
						DRAWN BY: O.AHRENSFELD					FILENAME: BRT-522-GZN201	FACILITY ID: 522													
						CHECKED BY: R. KOESTER					CONTRACT No.: AE 0055-17	SHEET No.: 5 OF 283													
						APPROVED BY: M.FELIBERTI						REV:													
<table><tr><td>No.</td><td>DATE</td><td>DSN</td><td>CHK</td><td>APP</td><td>REVISION</td></tr><tr><td></td><td></td><td></td><td></td><td></td><td></td></tr></table>						No.		DATE	DSN	CHK	APP	REVISION											SUBMITTED BY: D.SCHOCK		DATE: 09/11/2020
No.	DATE	DSN	CHK	APP	REVISION																				

CROSS REFERENCING OF DRAWINGS																				
BASE SHEET TITLE	01	02	03	04	05	06	07	08	09	10	11	12	13	14	15	16	17	18	19	20
1"=20' DRAWING SETS	522-**P201	522-**P202	522-**P203	522-**P204	522-**P205	522-**P206	522-**P207	522-**P208	522-**P209	522-**P210	522-**P211	522-**P212	522-**P213	522-**P214	522-**P215	522-**P216	522-**P217	522-**P218	522-**P219	522-**P220

**P = DESIGN ELEMENT PLAN VIEW DESIGNATION
RPP- RIGHT-OF-WAY
CAP- CIVIL ALIGNMENT
CSP- SITE PREPARATION
CPP- CIVIL PAVING
CMP- CHANNELIZATION AND SIGNING PLAN
CDP- CIVIL DRAINAGE
URP- COMPOSITE UTILITY
LPP - LANDSCAPE PLANTING PLANS

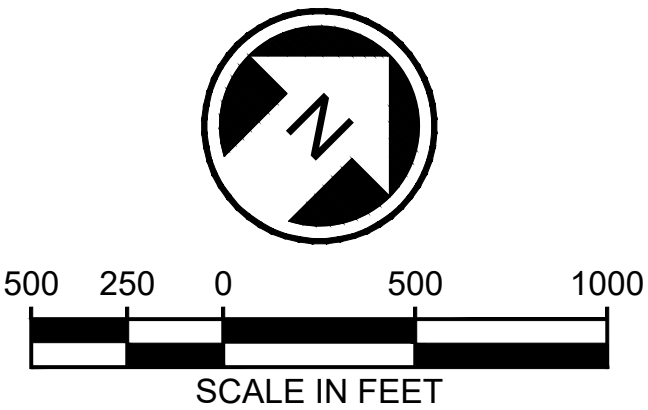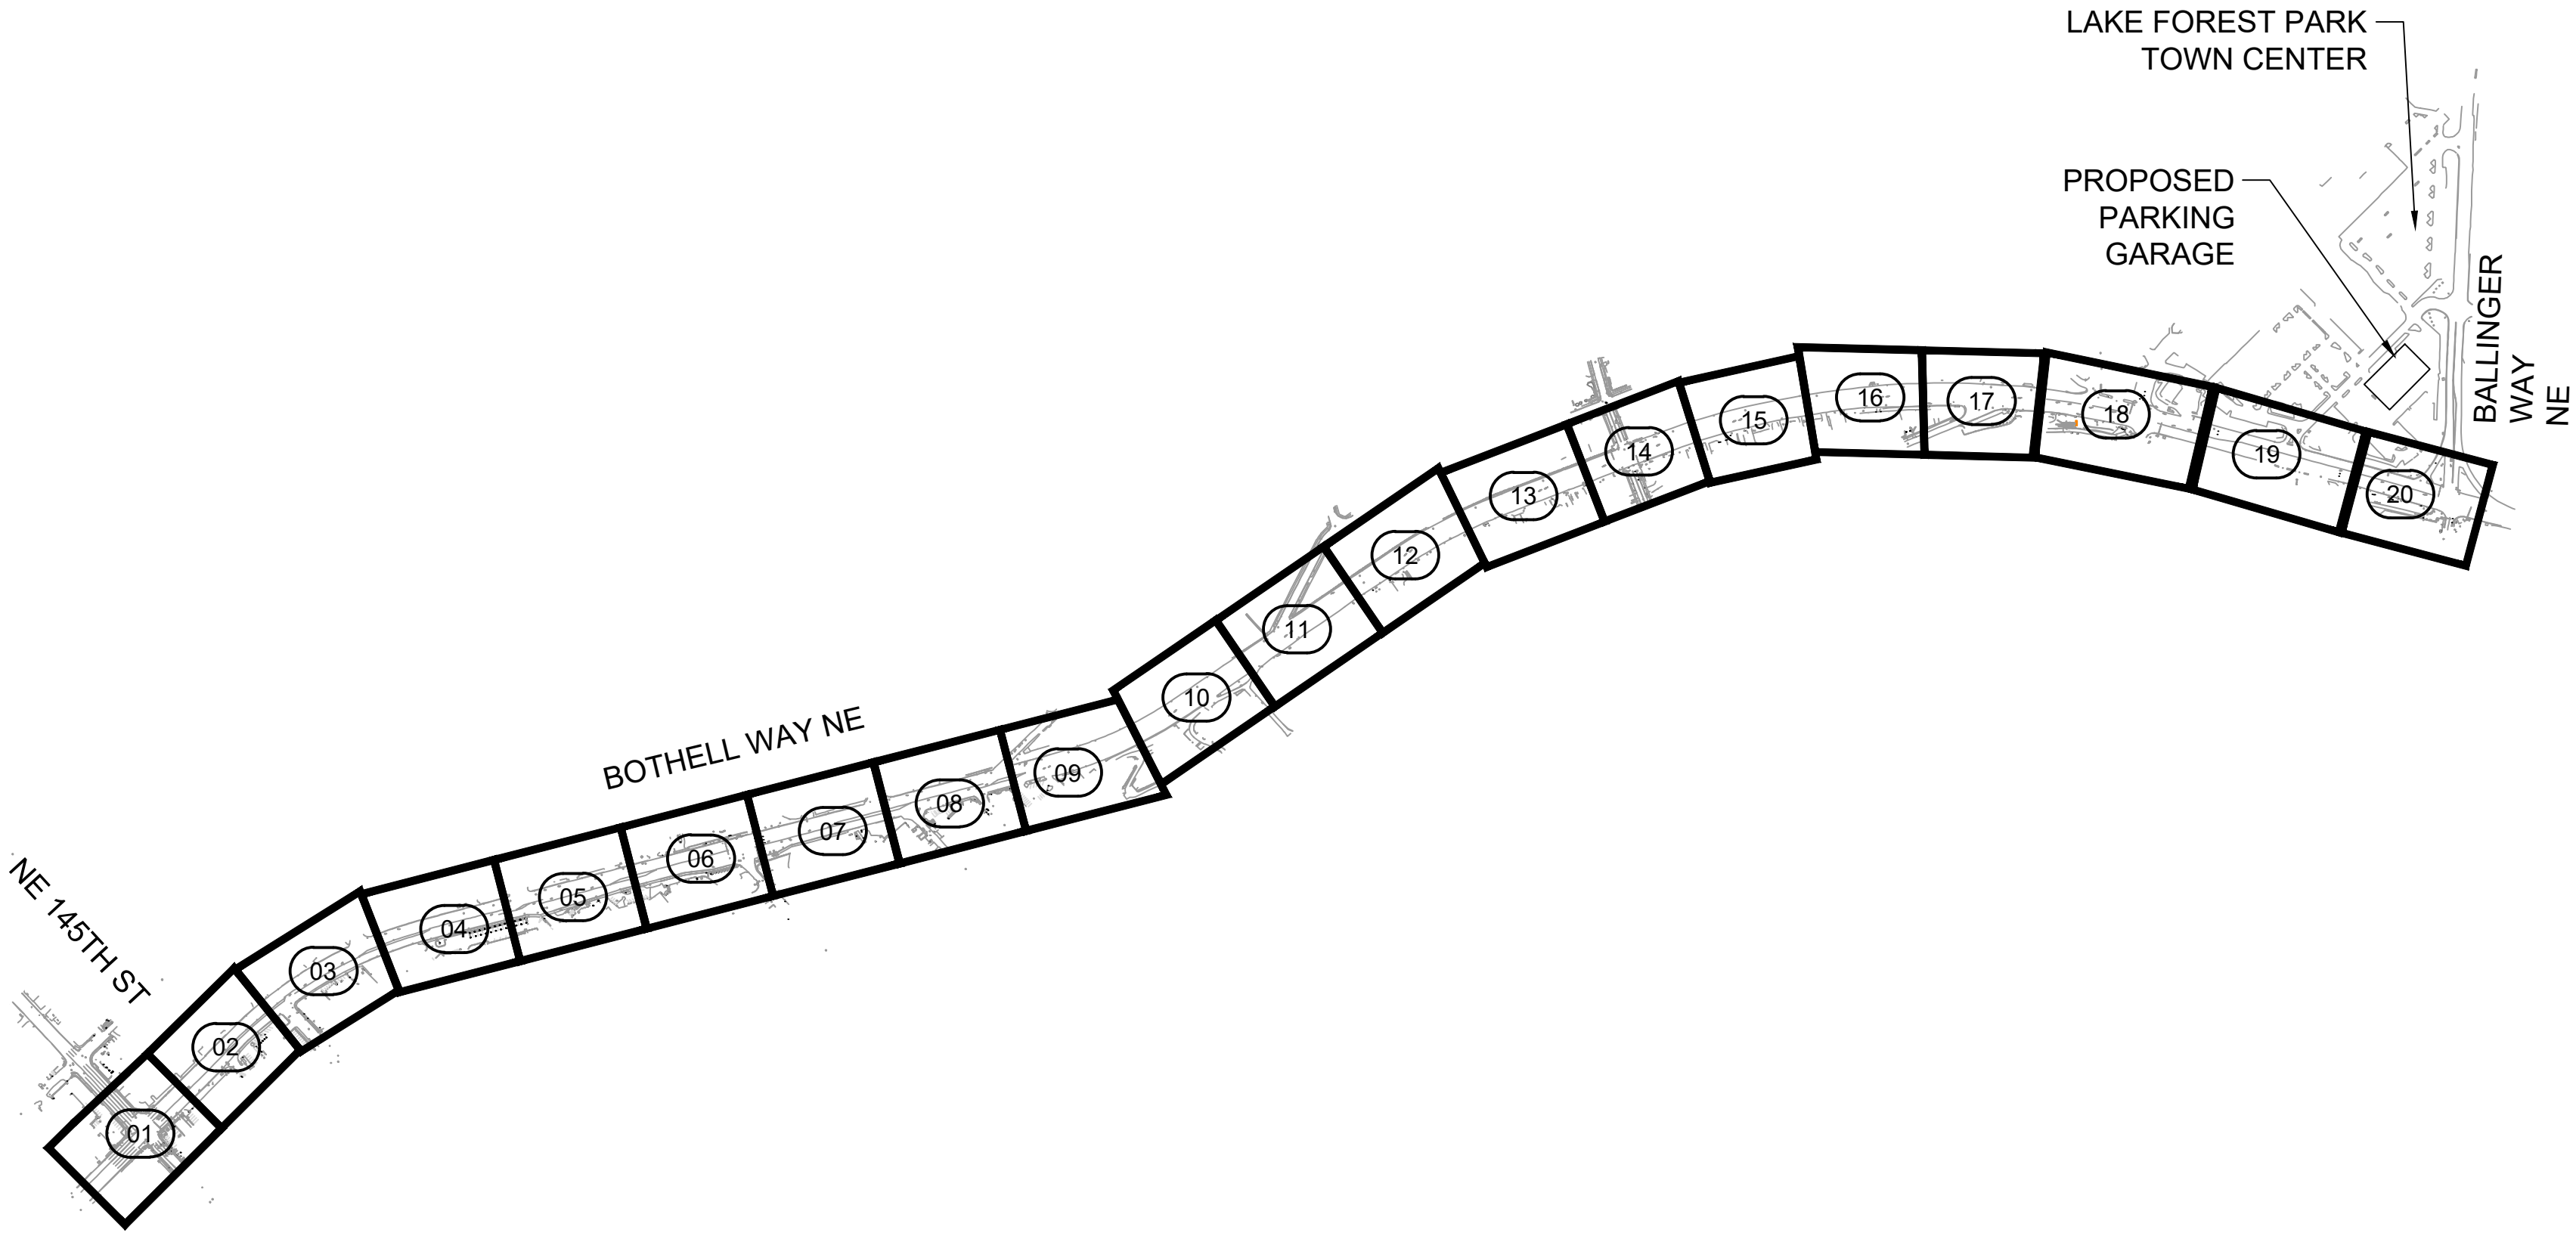

09/09/20 | 11:55 PM | SJRO
C:\PW_WORK\DAE\STEVEN ROSE\DWG\BRT-522-GZK001-GZK002.DWG

DRAFT 30% SUBMITTAL

No.	DATE	DSN	CHK	APP	REVISION

DESIGNED BY:
C.MATYAS

DRAWN BY:
O.AHRENSFELD

CHECKED BY:
A. WILEN

APPROVED BY:
M.FELIBERTI

DAVID EVANS
AND ASSOCIATES INC.

14432 SE Eastgate Way, Suite 400
Bellevue Washington 98007
Phone: 425.519.6500

SUBMITTED BY:
D.SCHOCK

DATE:
09/11/2020

REVIEWED BY:
B.KEMPER

DATE:
09/11/2020

SCALE:
1"=500'
FILENAME:
BRT-522-GZK001-GZK002
CONTRACT No.:
AE 0055-17
DATE:
09/11/2020

SR 522 / NE 145TH BRT

SR 522 (BOTHELL WAY NE)

CIVIL
KEY PLAN
SR522 (BOTHELL WAY NE) (LAKE FOREST PARK)


DRAWING No.:
522-GZK001

FACILITY ID:
522



SHEET No.:
6 OF 283

REV:

09/10/20 | 1:02 AM | SJRO
C:\PW_WORK\DEA\STEVEN ROSE\DWG\506735\BRT-522-CRV201-204.DWG

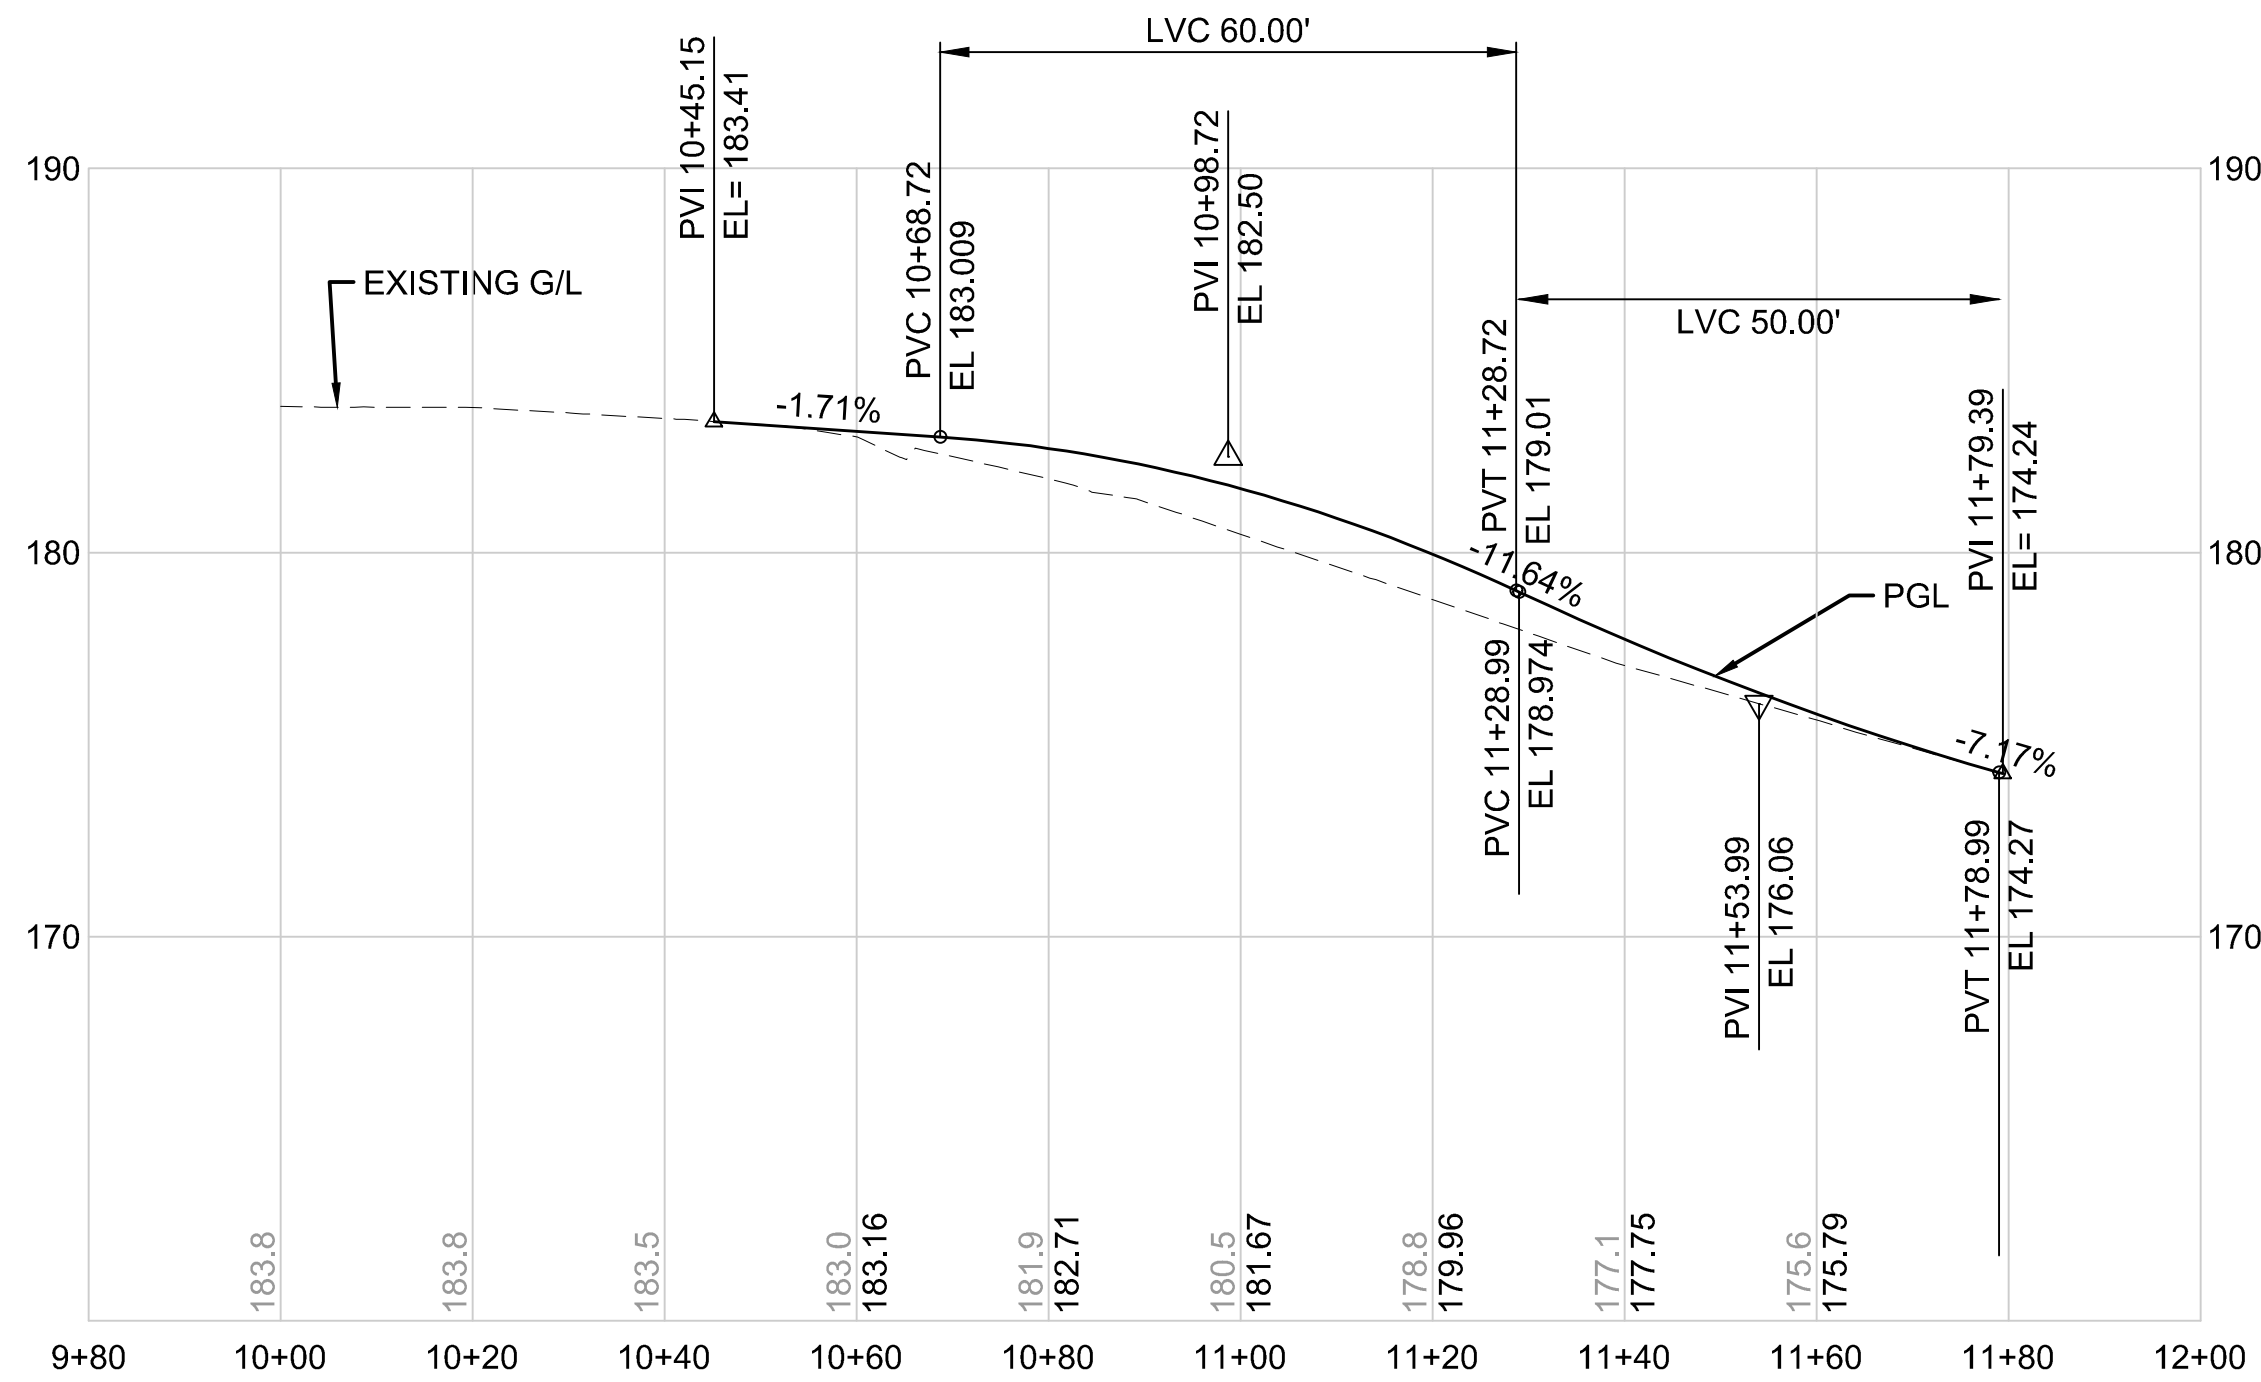

153RD LINE
HORIZONTAL SCALE: 1"=20'
VERTICAL SCALE: 1"=5'

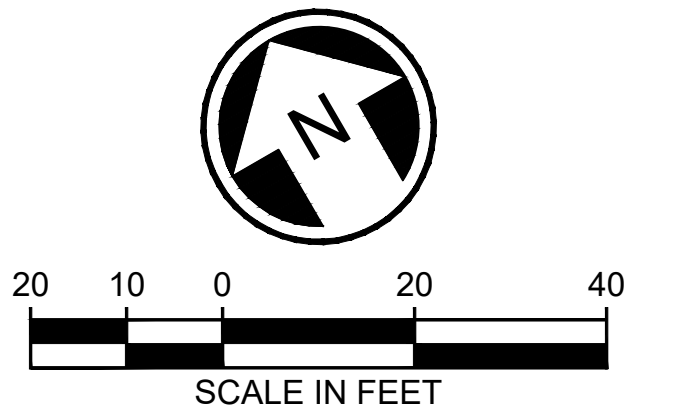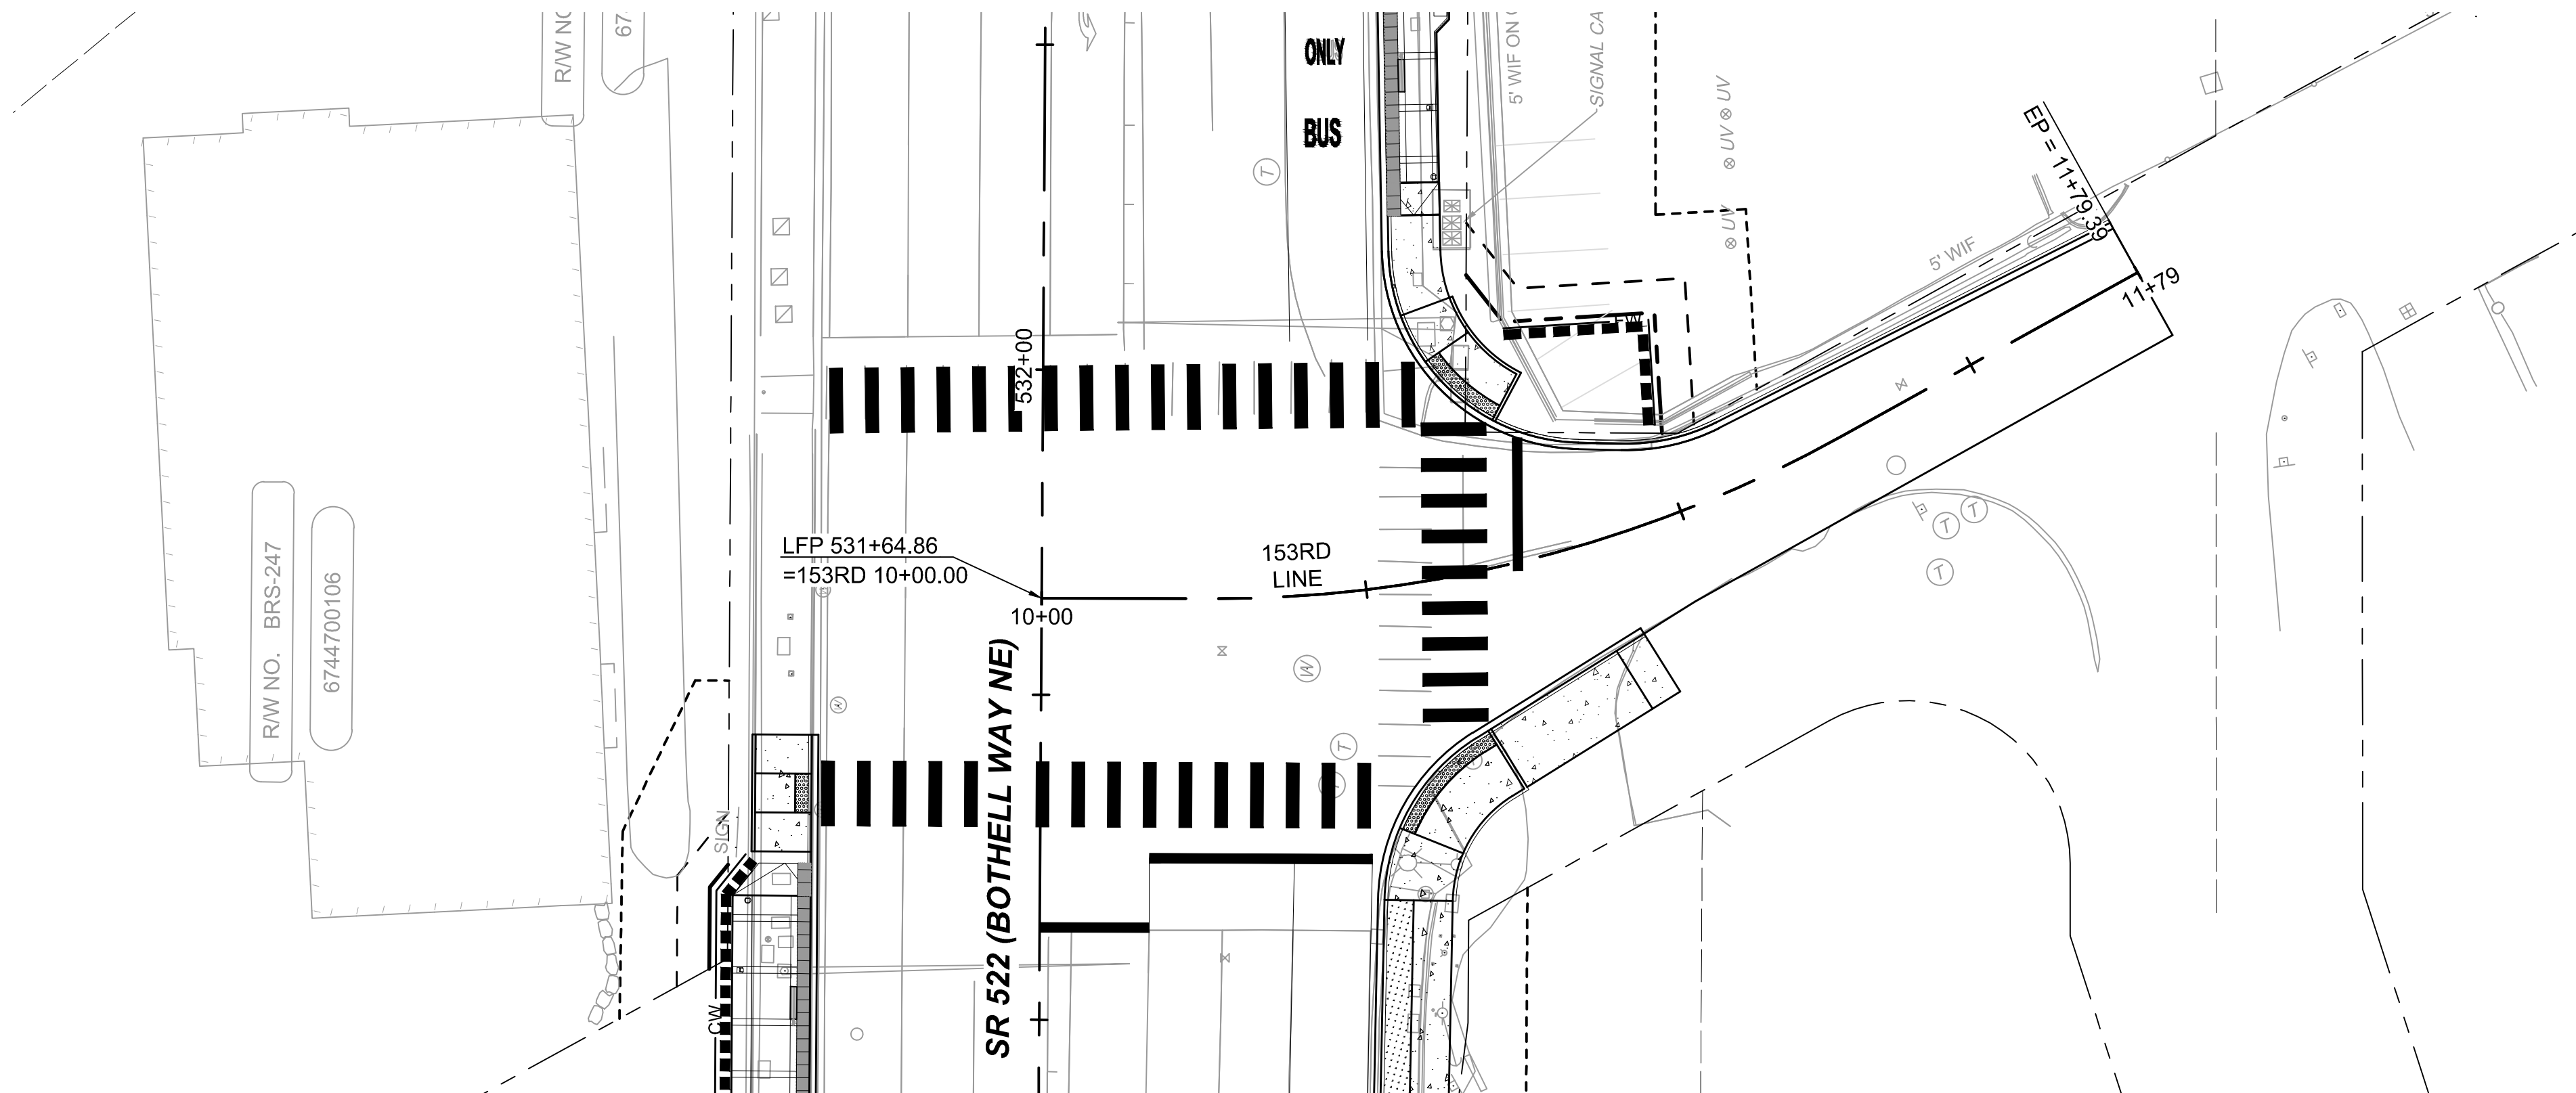


DRAFT 30% SUBMITTAL

No.	DATE	DSN	CHK	APP	REVISION

DESIGNED BY:
C.MATYAS
DRAWN BY:
C.BRESLEY
CHECKED BY:
R.KOESTER
APPROVED BY:
M.FELIBERTI



 DAVID EVANS
AND ASSOCIATES INC.
14432 SE Eastgate Way, Suite 400
Bellevue Washington 98007
Phone: 425.519.6500



SOUNDTRANSIT




SCALE:
1"=20'
FILENAME:
BRT-522-CRV201-204
CONTRACT No.:
AE 0055-17
DATE:
09/11/2020

SR 522 / NE 145TH BRT
SR 522 (BOTHELL WAY NE)
CIVIL
NE 153RD ST PLAN AND PROFILE
STA. 10+00 TO STA. 11+79.39

DRAWING No.:
522-CRV201
FACILITY ID:
522
SHEET No.:
105 OF 283
REV:

SUBMITTED BY: D.SCHOCK
DATE: 09/11/2020
REVIEWED BY: B.KEMPER
DATE: 09/11/2020

09/10/20 | 1:03 AM | SJRO
C:\PW_WORK\DAVE\STEVEN ROSE\DWG\506735\BRT-522-CRV201-204.DWG

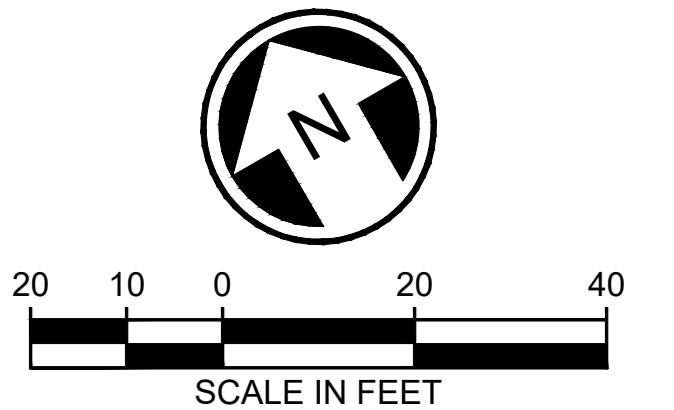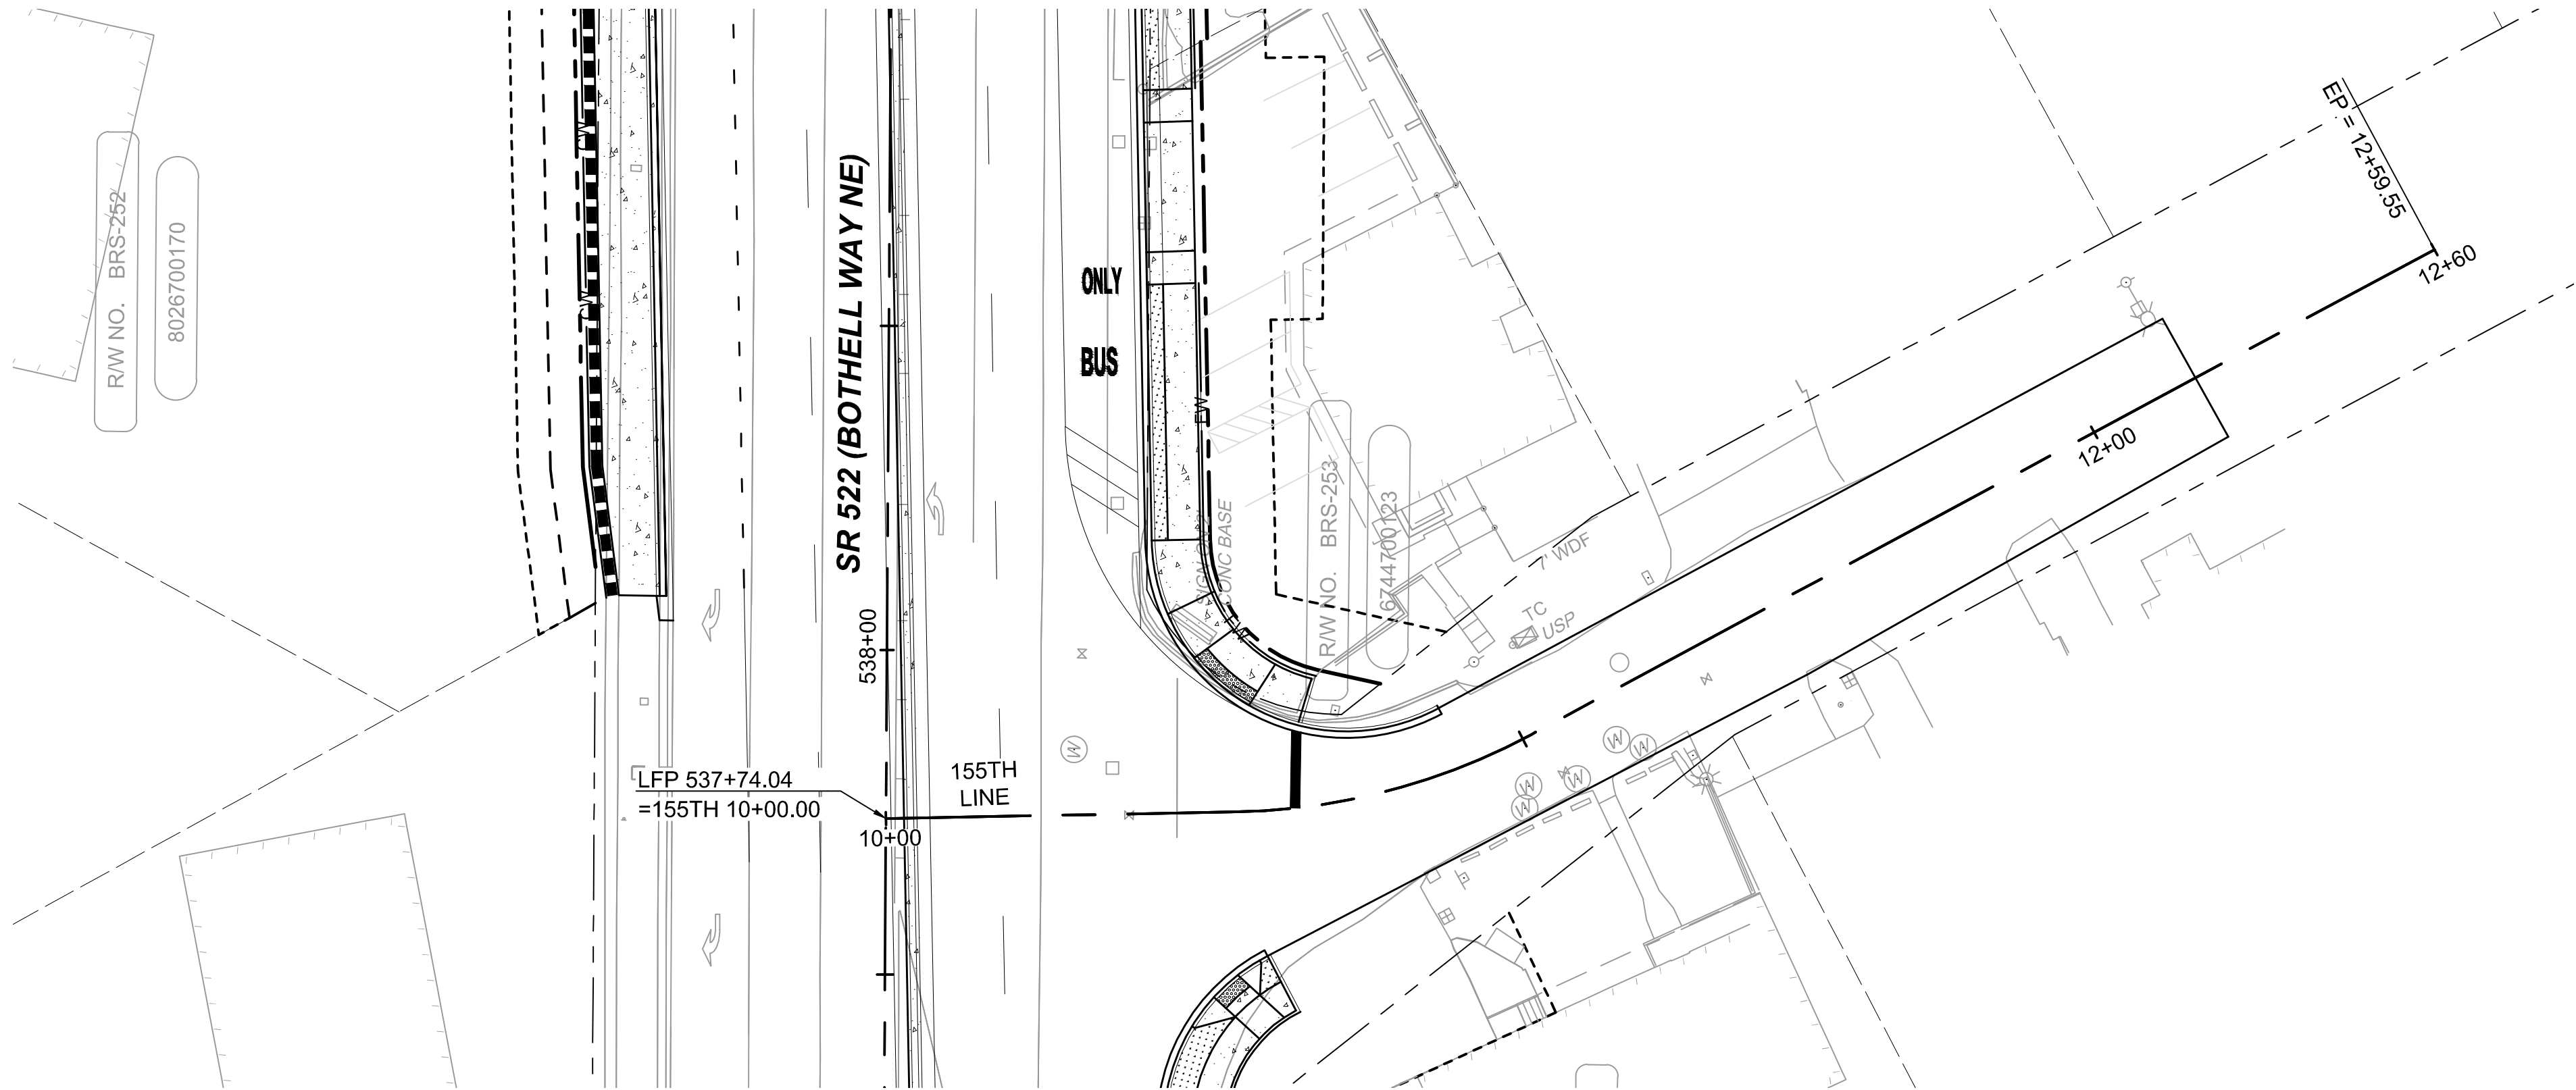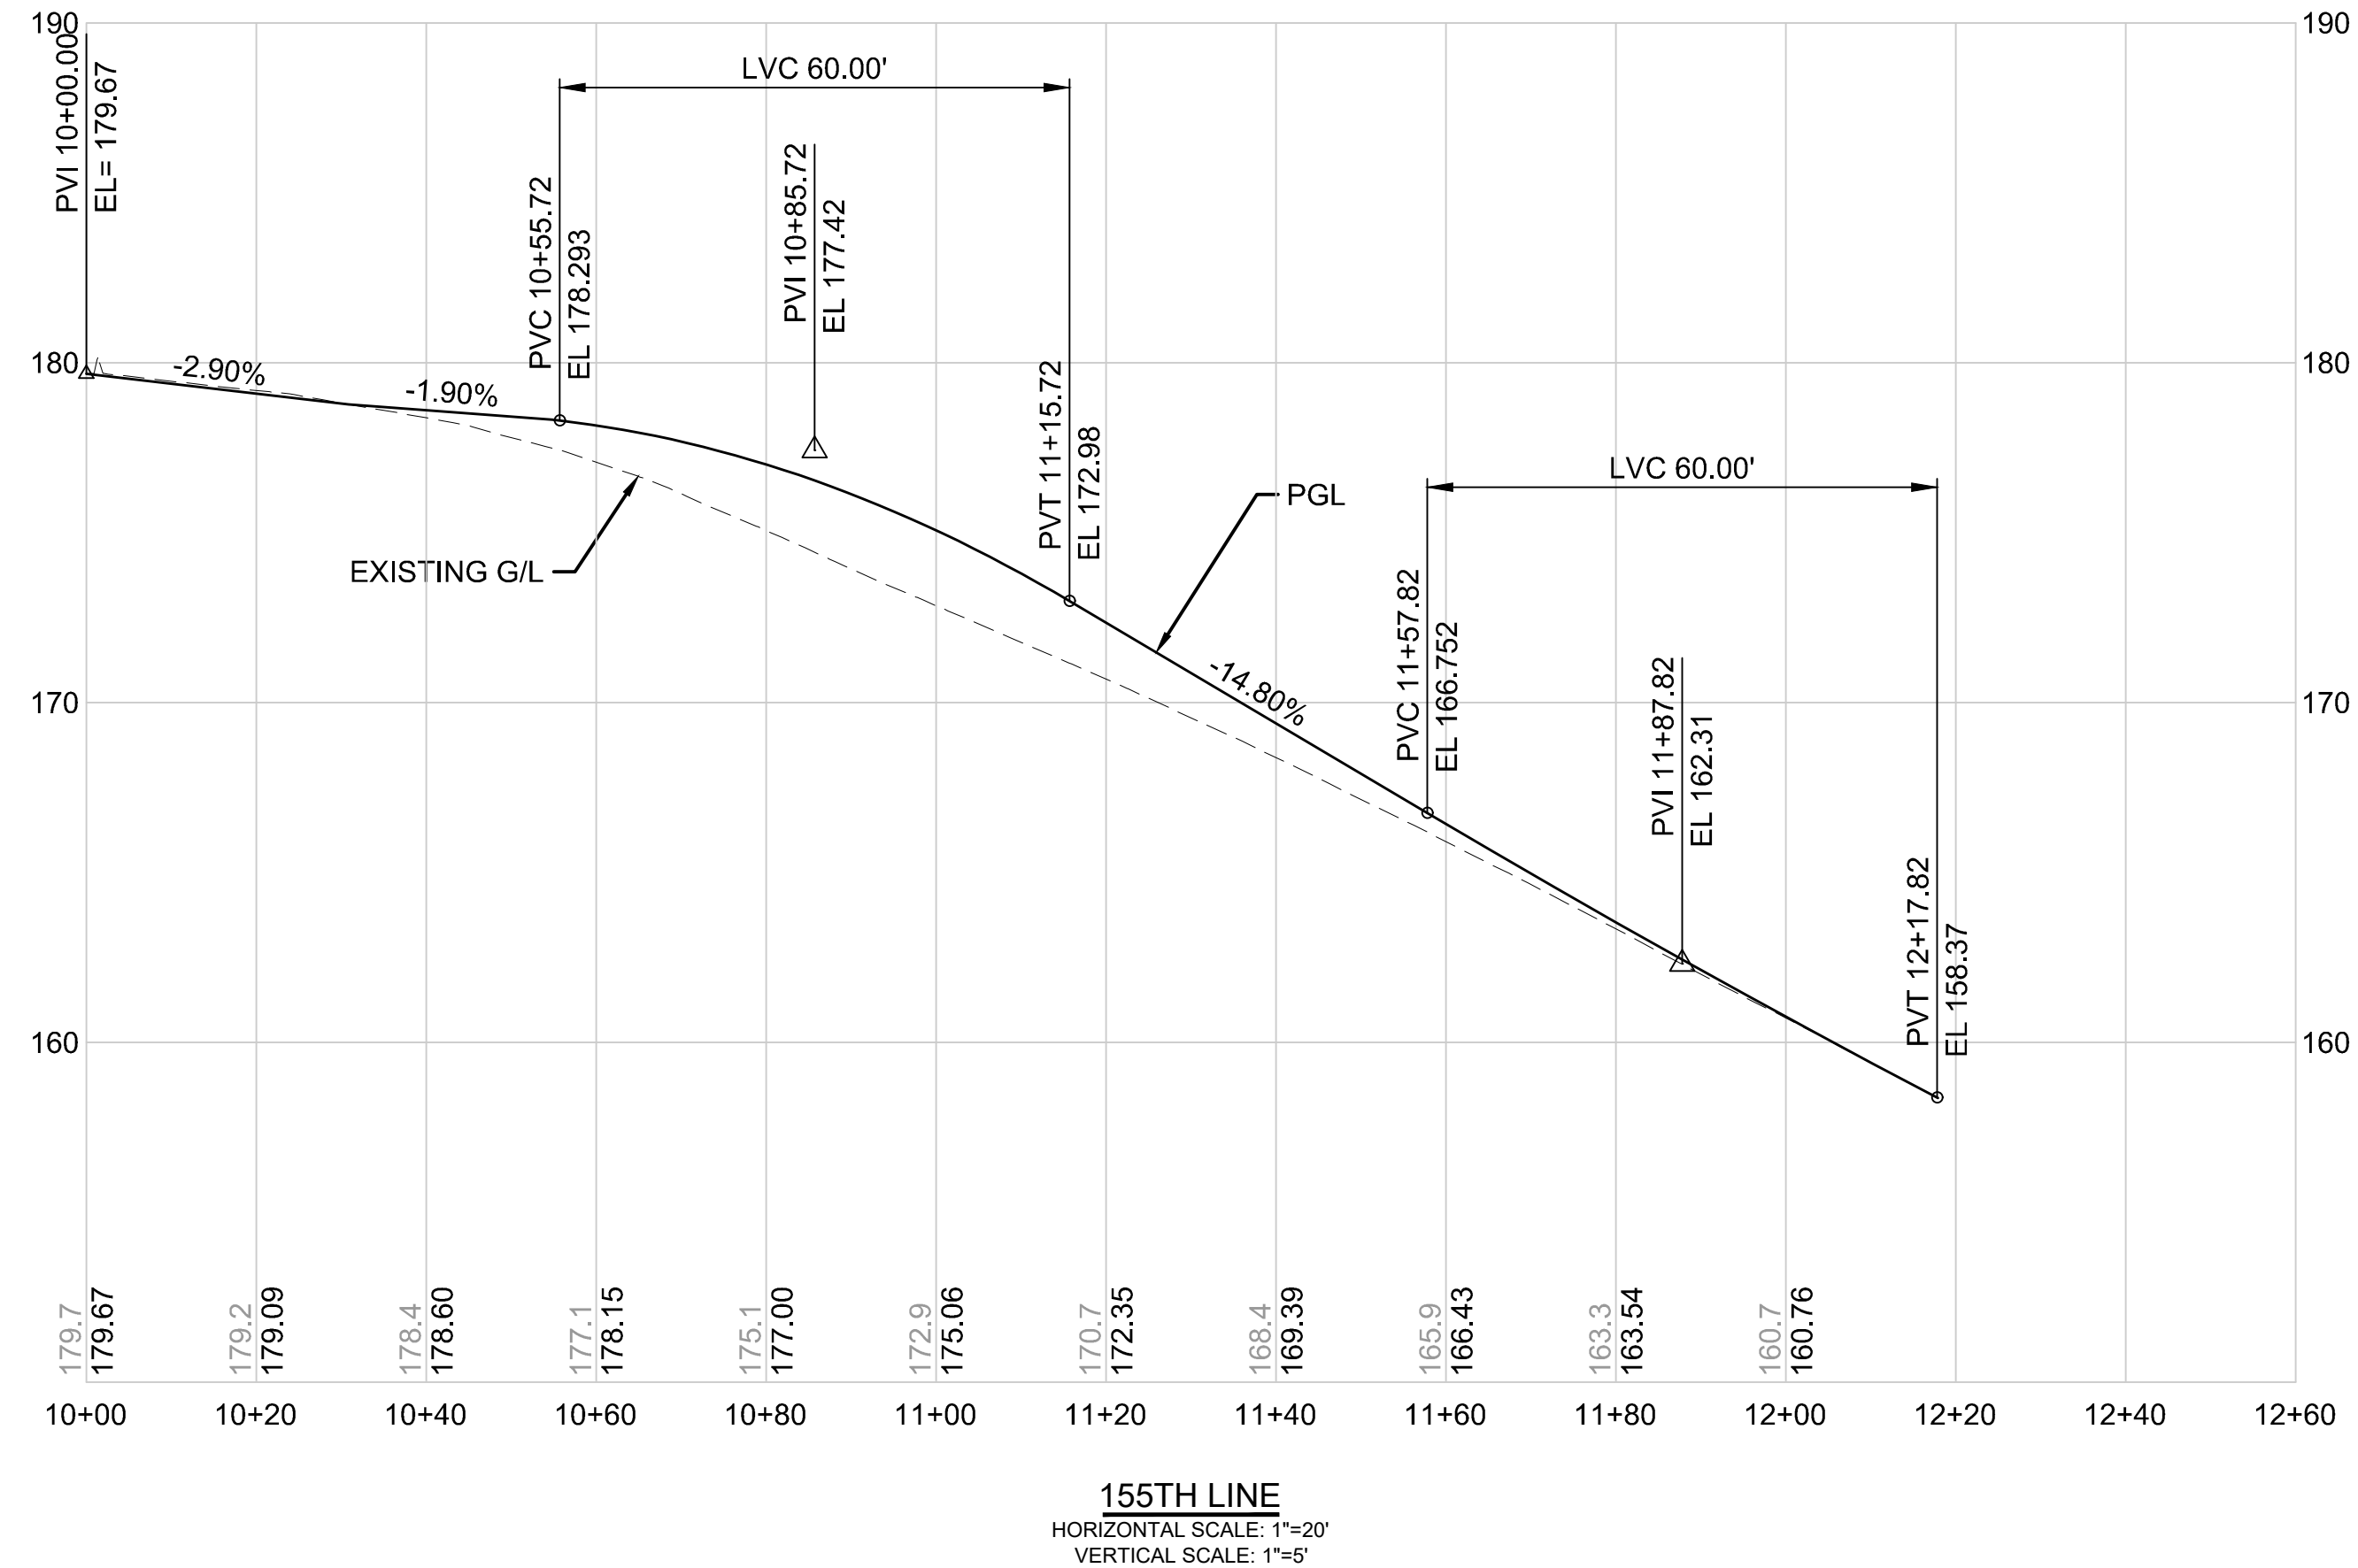


DRAFT 30% SUBMITTAL

No.	DATE	DSN	CHK	APP	REVISION

DESIGNED BY:
C.MATYAS
DRAWN BY:
C.BRESLEY
CHECKED BY:
R.KOESTER
APPROVED BY:
M.FELIBERTI



 **DAVID EVANS
AND ASSOCIATES INC.**
14432 SE Eastgate Way, Suite 400
Bellevue Washington 98007
Phone: 425.519.6500






SCALE:
1"=20'
FILENAME:
BRT-522-CRV201-204
CONTRACT No.:
AE 0055-17
DATE:
09/11/2020

SR 522 / NE 145TH BRT
SR 522 (BOTHELL WAY NE)
CIVIL
NE 155TH ST PLAN AND PROFILE
STA. 10+00 TO STA. 12+59.55

DRAWING No.:
522-CRV202
FACILITY ID:
522
SHEET No.:
106 OF 283
REV:

09/10/20 | 1:04 AM | SJRO
C:\PW_WORK\DEA\STEVEN ROSE\DWG\506735\BRT-522-CRV201-204.DWG

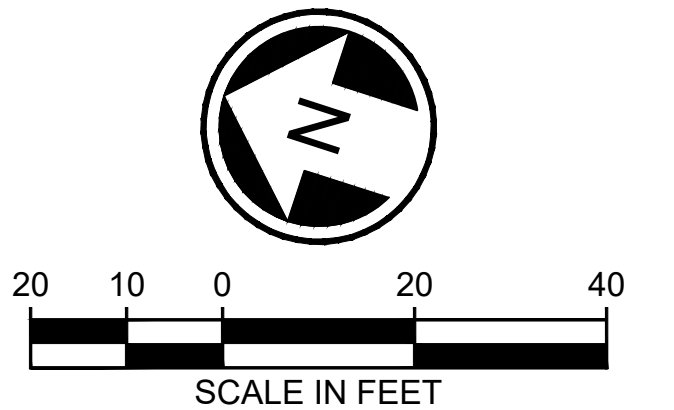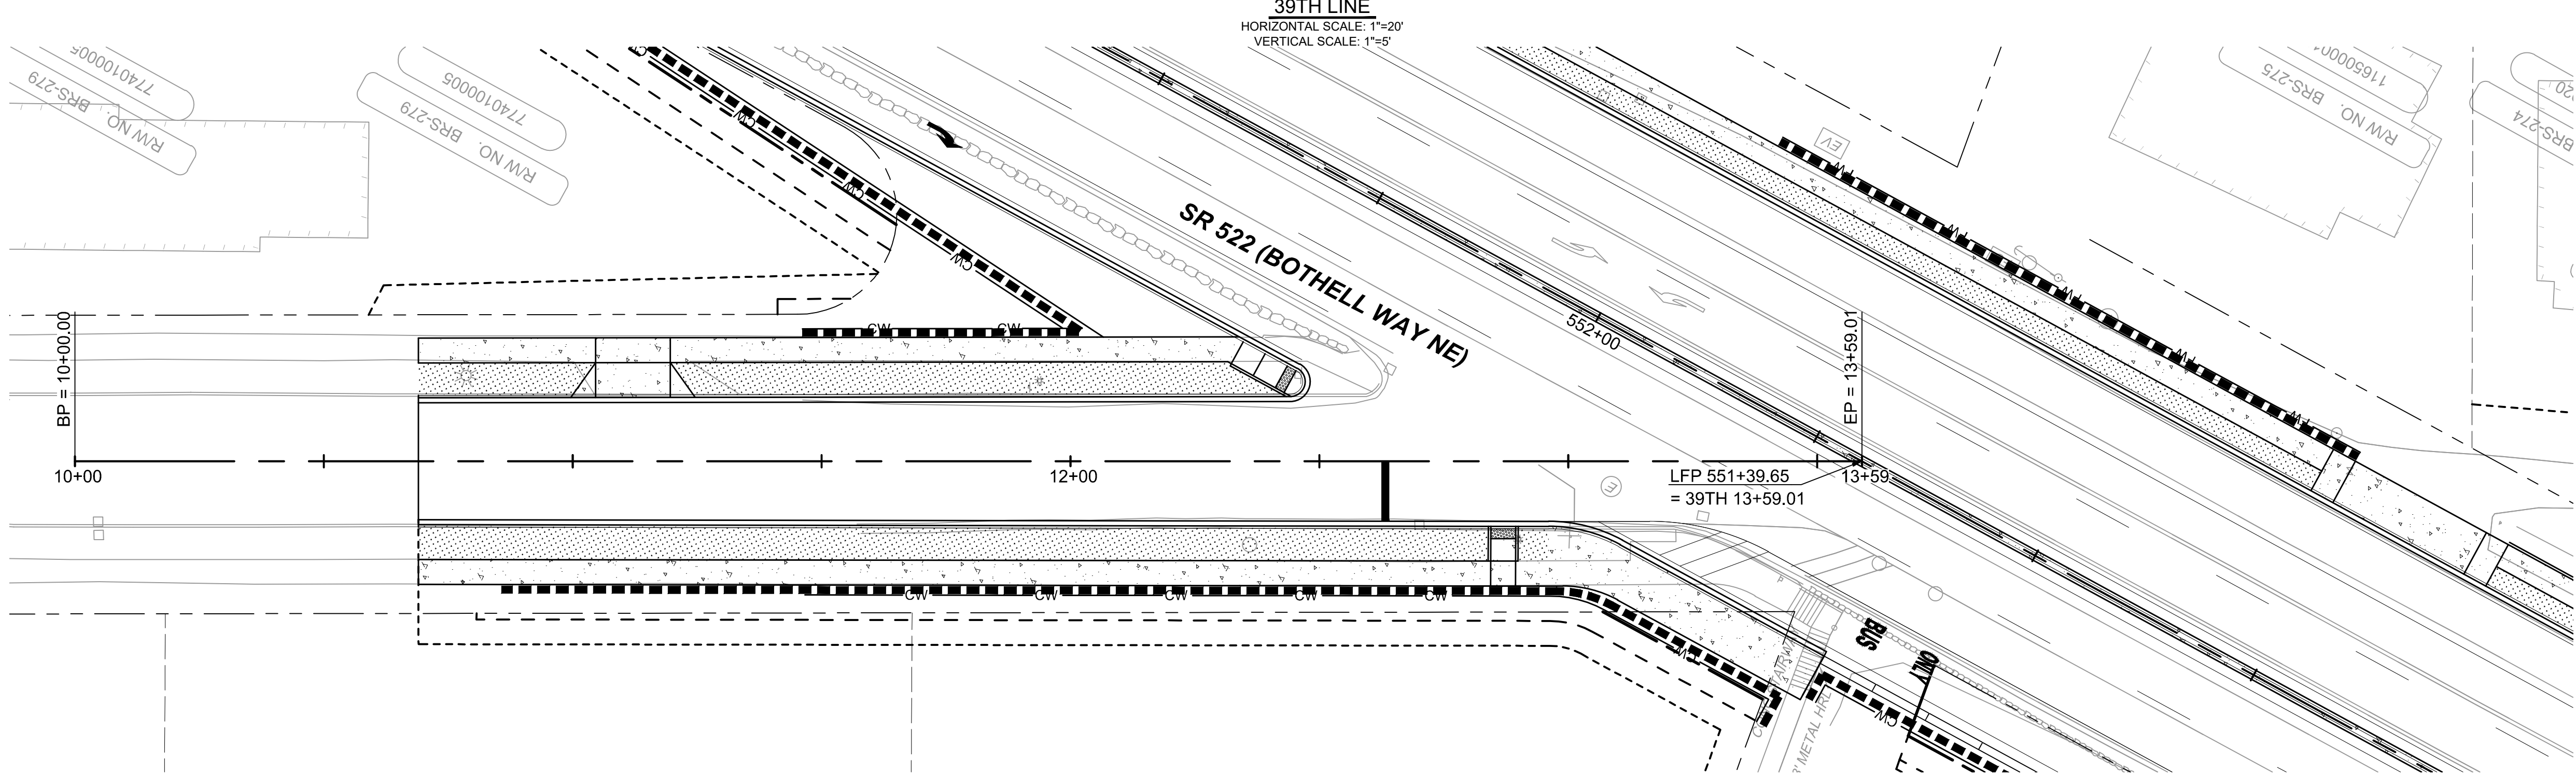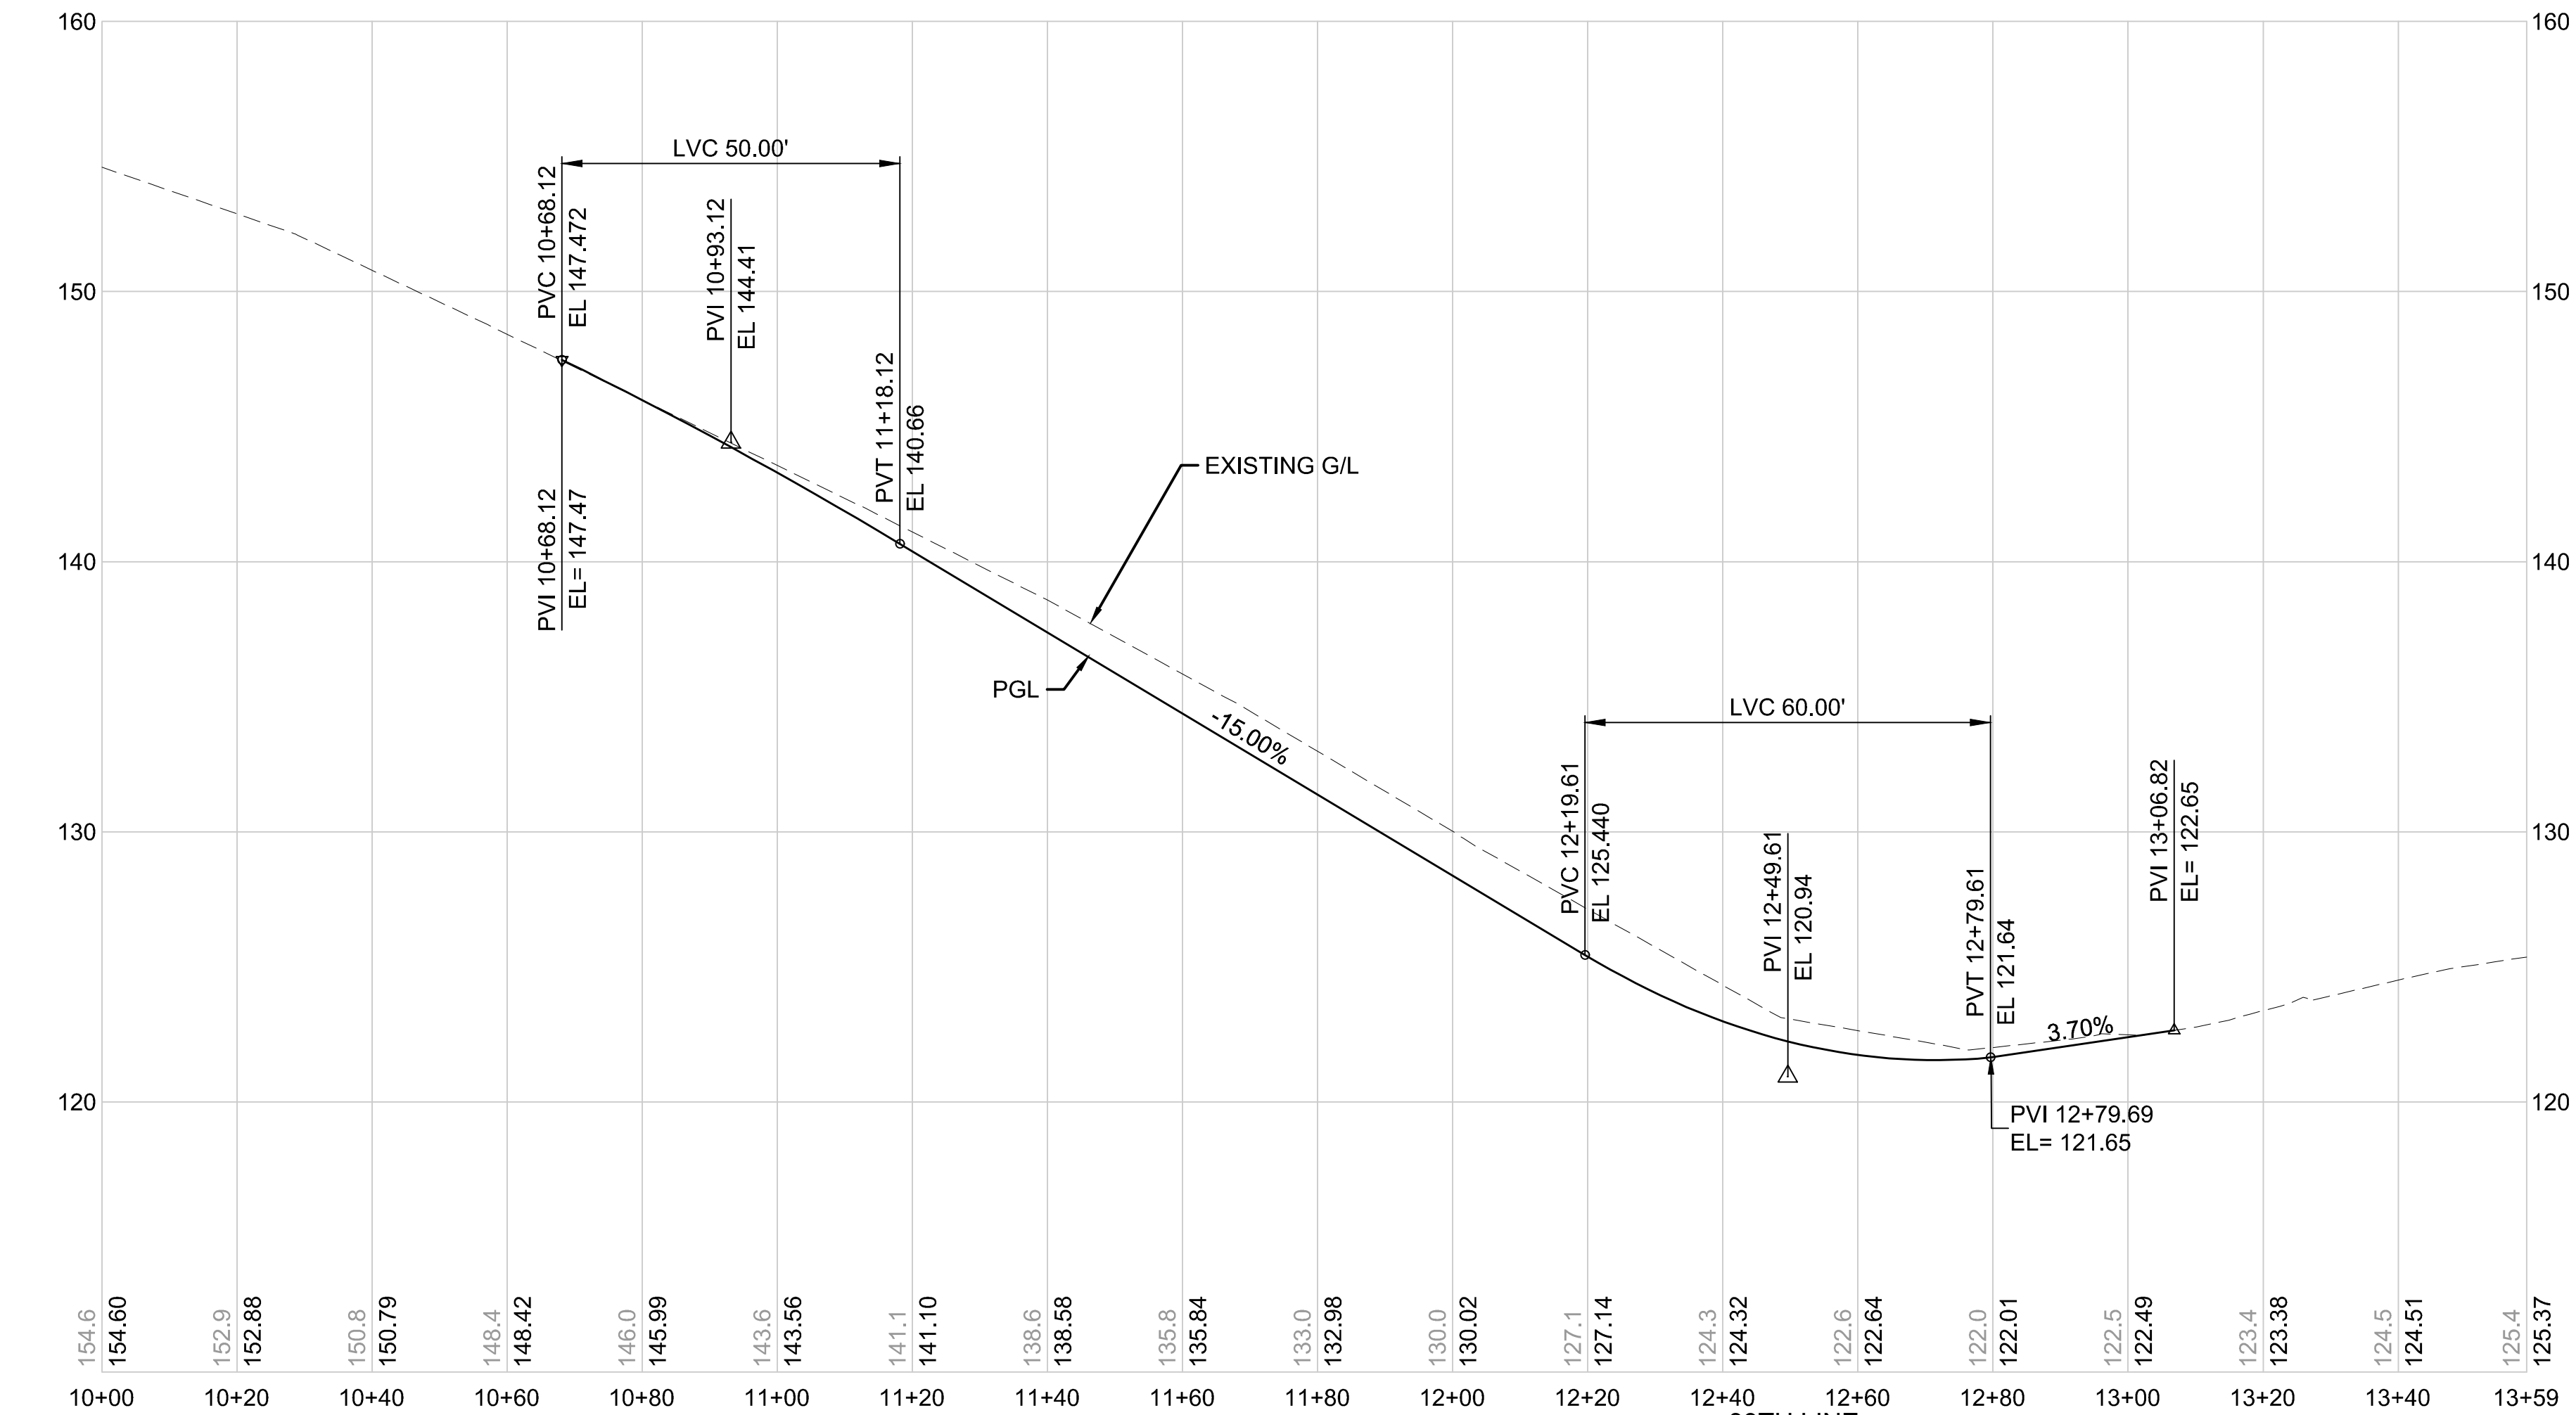

DRAFT 30% SUBMITTAL

No.	DATE	DSN	CHK	APP	REVISION

DESIGNED BY:	C.MATYAS
DRAWN BY:	C.BRESLEY
CHECKED BY:	R.KOESTER
APPROVED BY:	M.FELIBERTI



**DAVID EVANS
AND ASSOCIATES INC.**
14432 SE Eastgate Way, Suite 400
Bellevue Washington 98007
Phone: 425.519.6500

SUBMITTED BY:
D.SCHOCK

DATE:
09/11/2020

REVIEWED BY:
B.KEMPER



DATE:
09/11/2020




SCALE: 1"=20'
FILENAME: BRT-522-CRV201-204
CONTRACT No.: AE 0055-17
DATE: 09/11/2020

SR 522 / NE 145TH BRT

SR 522 (BOTHELL WAY NE)

CIVIL
39TH AVE NE PLAN AND PROFILE
STA. 10+00 TO STA. 13+59.01

DRAWING No.:	522-CRV203
FACILITY ID:	522
SHEET No.:	107 OF 283
REV:	

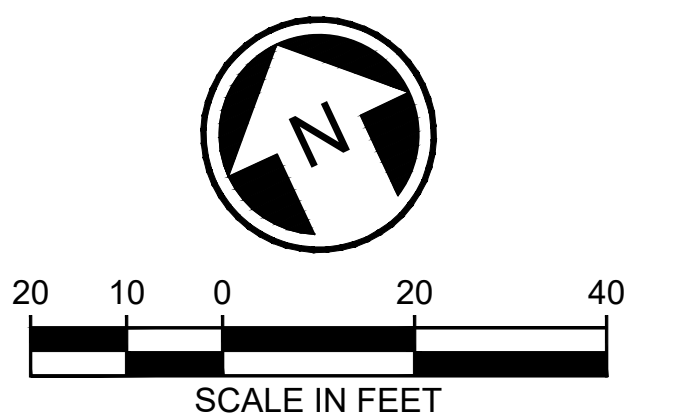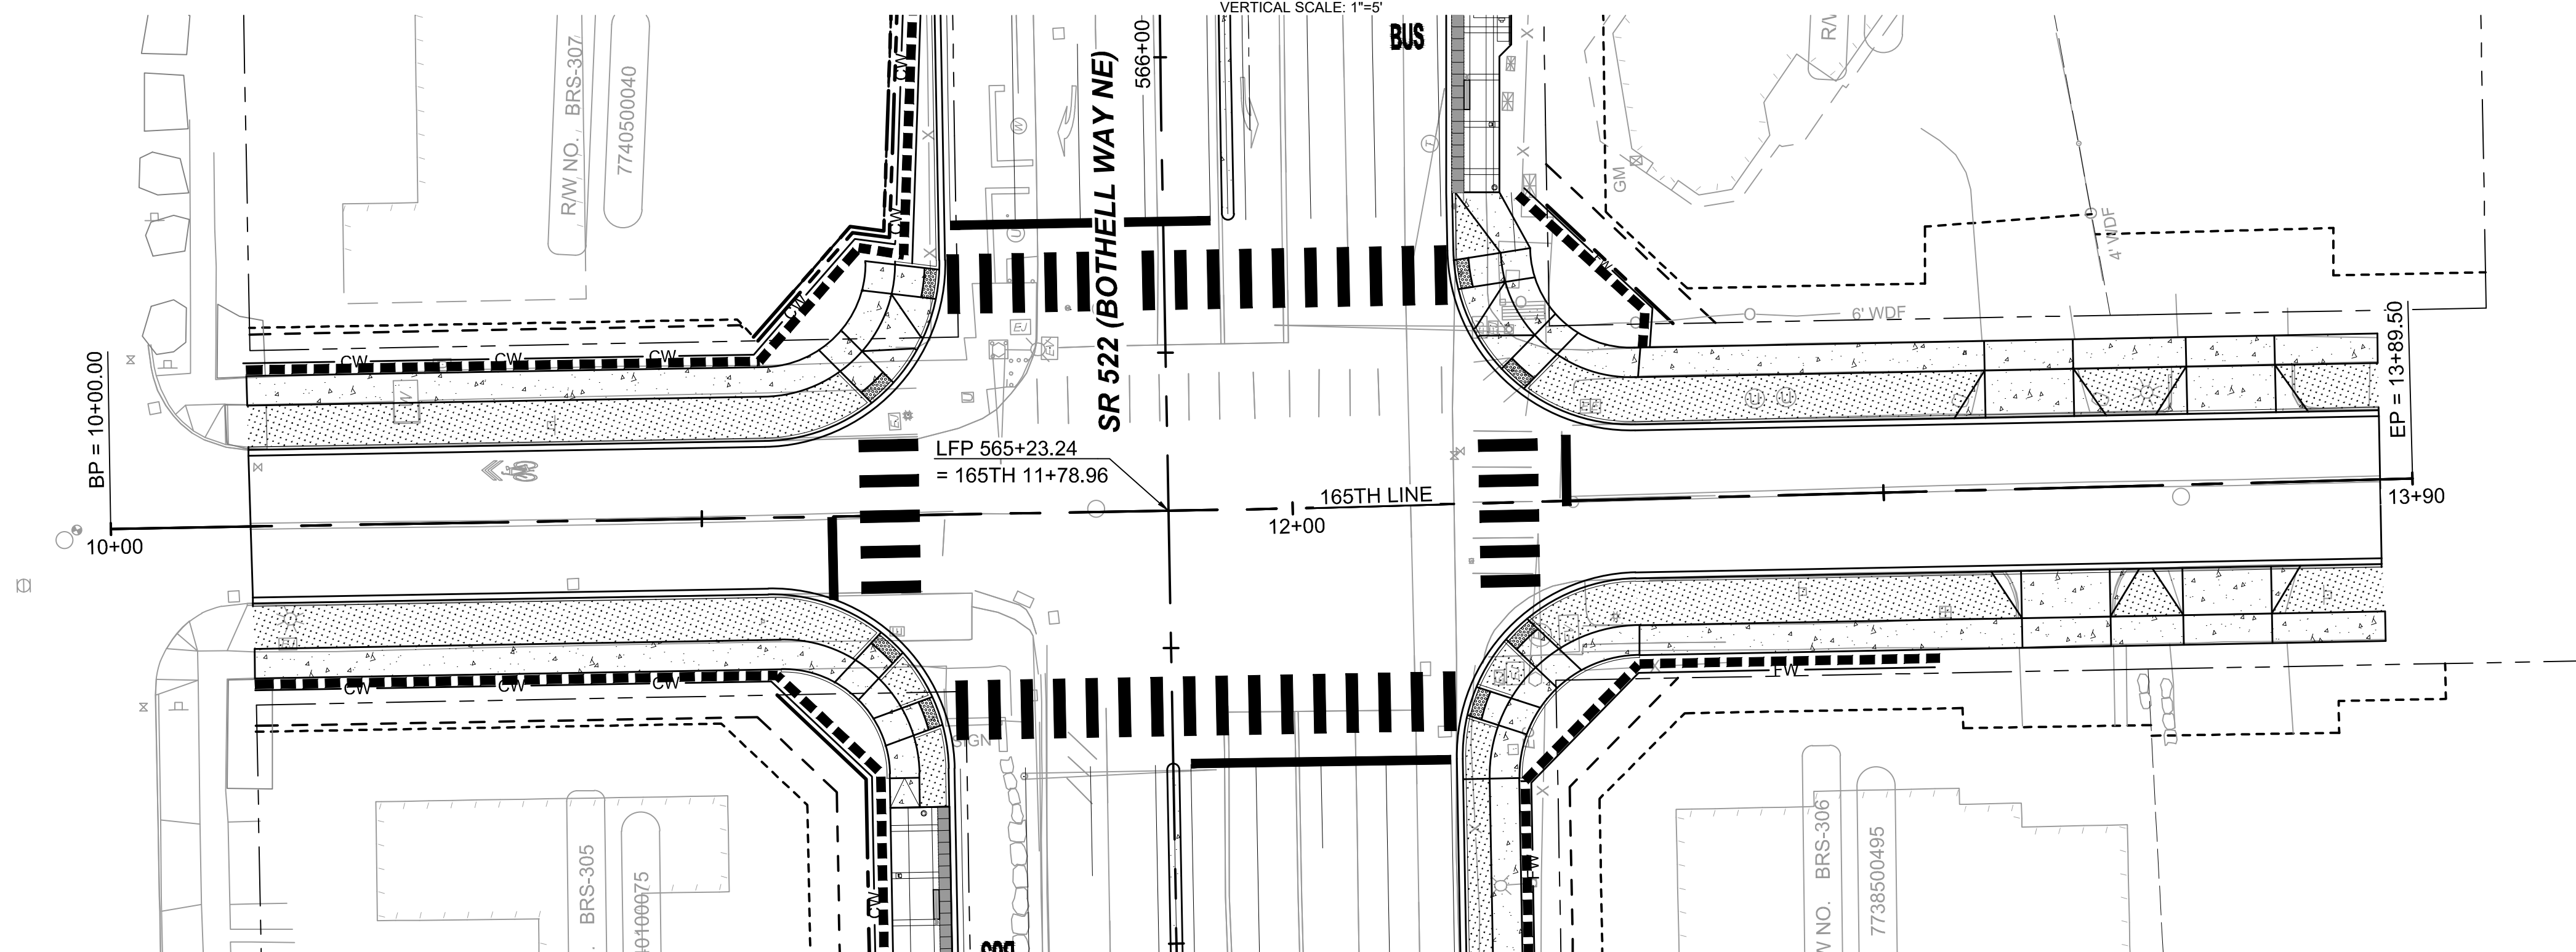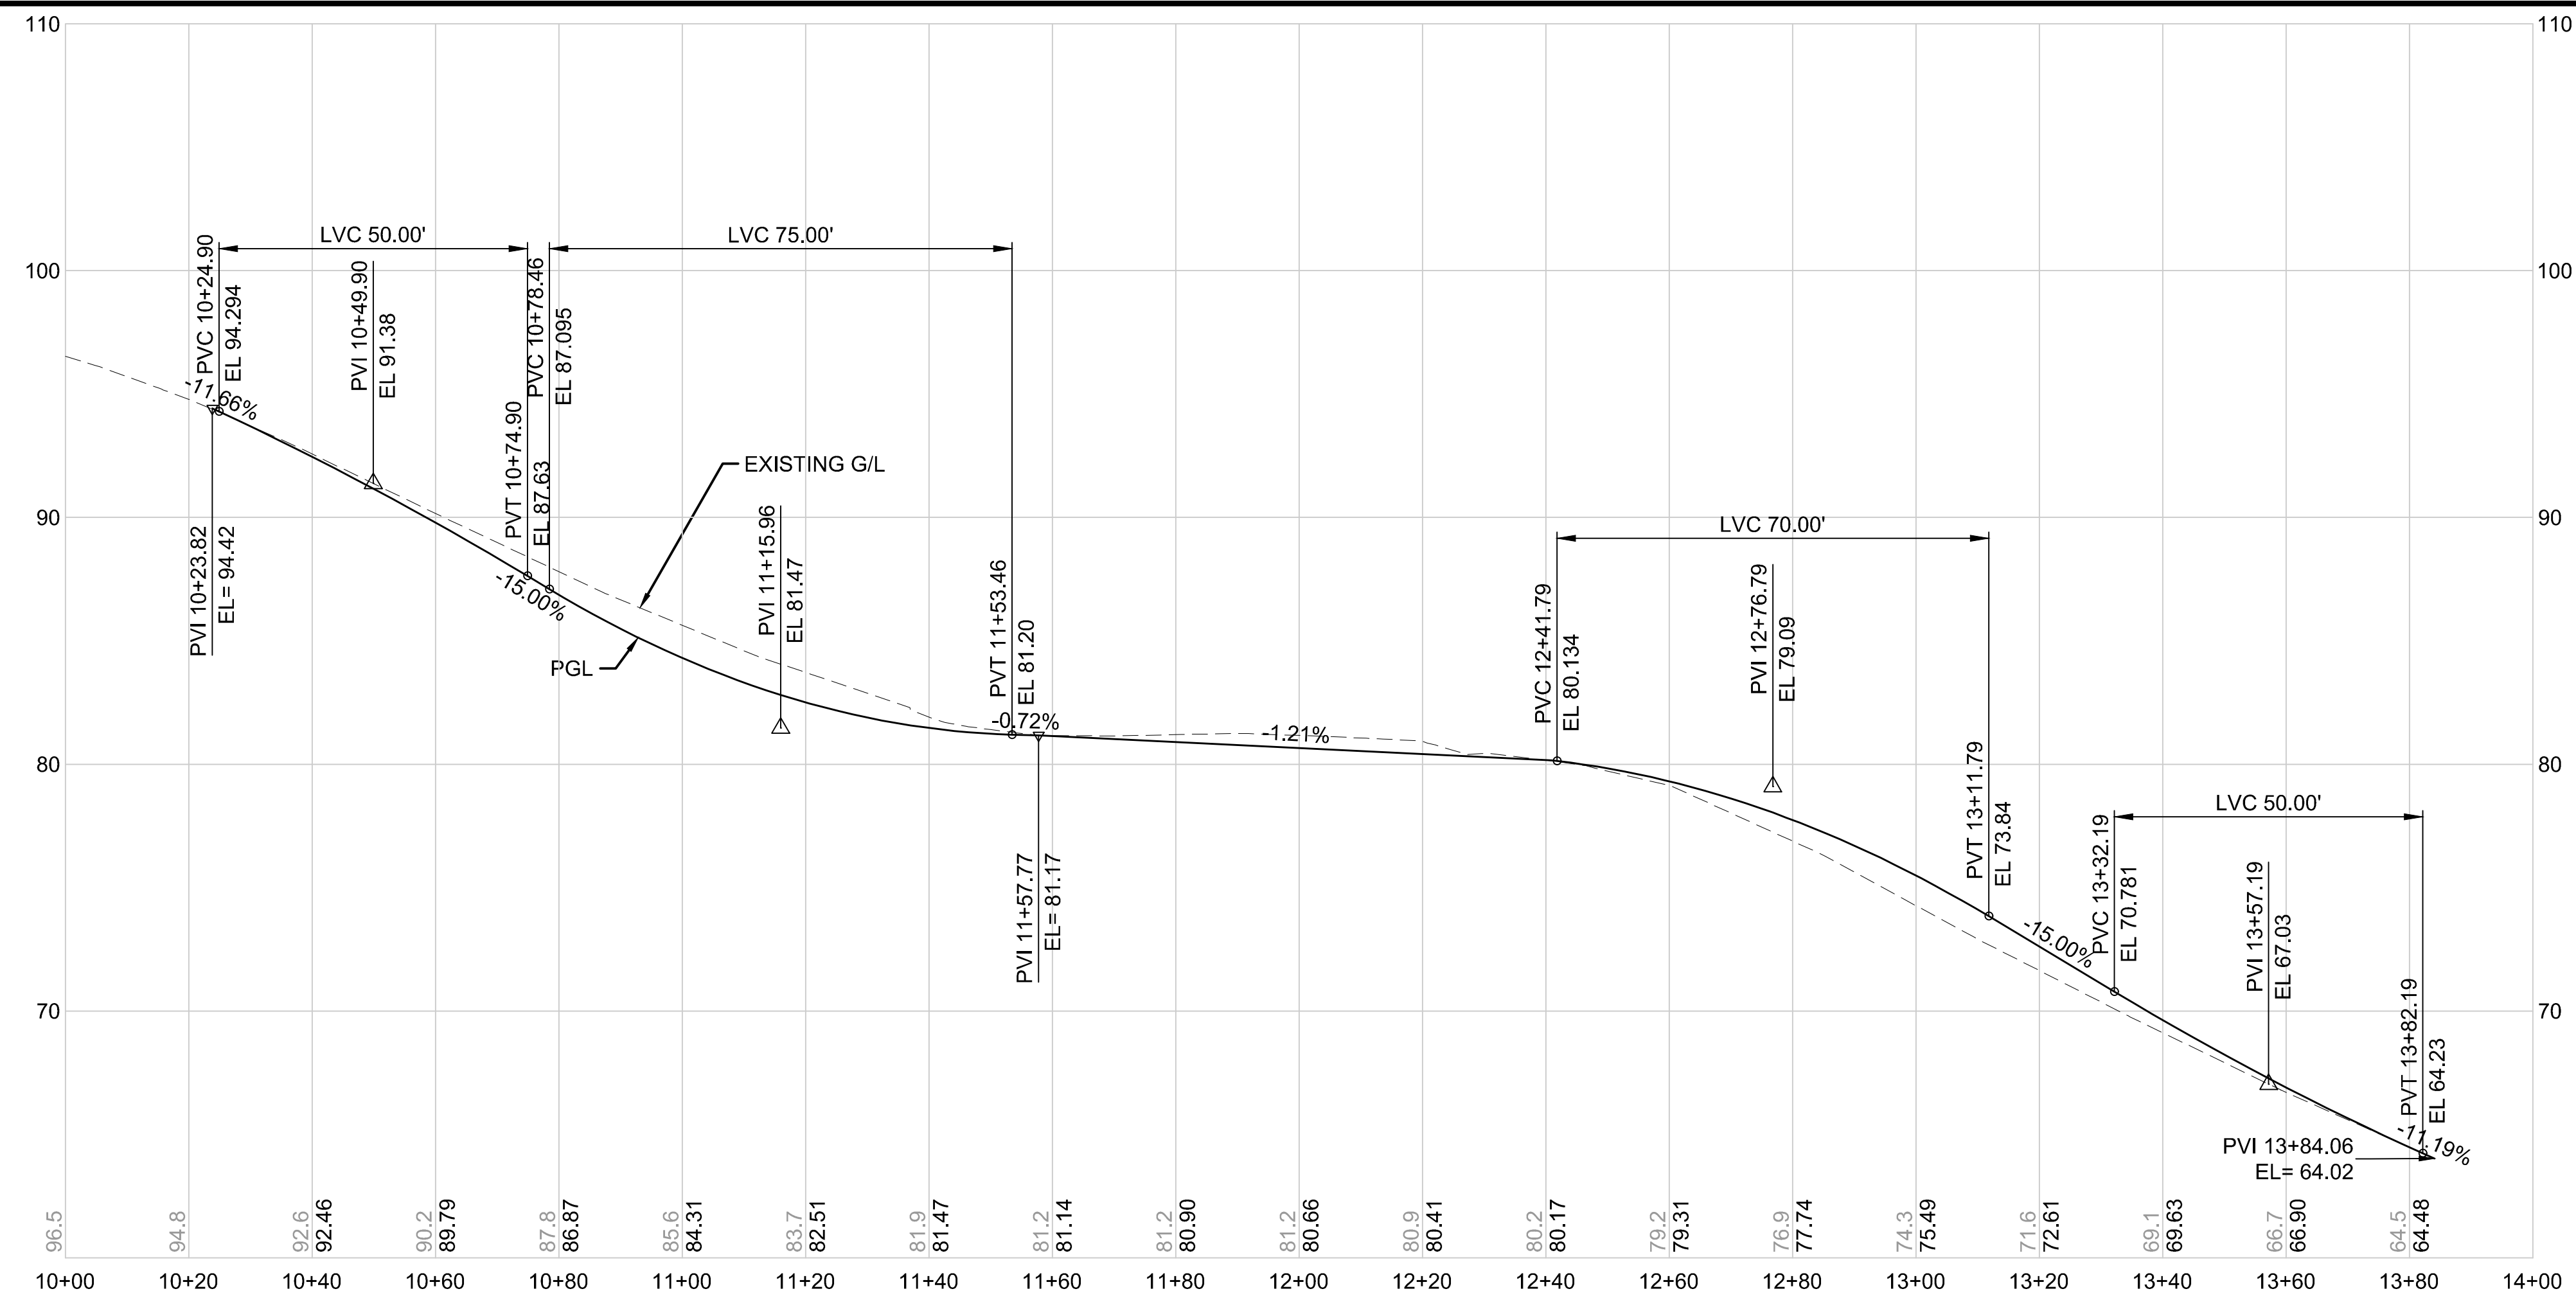

DRAFT 30% SUBMITTAL

No.	DATE	DSN	CHK	APP	REVISION

DESIGNED BY:	C.MATYAS
DRAWN BY:	C.BRESLEY
CHECKED BY:	R.KOESTER
APPROVED BY:	M.FELIBERT



DAVID EVANS
AND ASSOCIATES INC.
14432 SE Eastgate Way, Suite 400
Bellevue Washington 98007
Phone: 425.519.6500

LINE IS 1" AT

**SOUNDTRANSIT**

SCALE:	1"=20'
FILENAME:	BRT-522-CRV201-204
CONTRACT No.:	AE 0055-17
DATE:	09/11/2020


SR 522 / NE 145TH BRT

SR 522 (BOTHELL WAY NE)



CIVIL
NE 165TH ST PLAN AND PROFILE
STA. 10+00 TO STA. 11+95.53

DRAWING No.:	
522-CRV204	
FACILITY ID:	
522	
SHEET No.:	REV:
108 OF 283	

09/10/20 | 1:09 AM | SJRO
C:\PW_WORK\DAE\STEVEN ROSE\DWG\BRT-522-CRV205-211.DWG

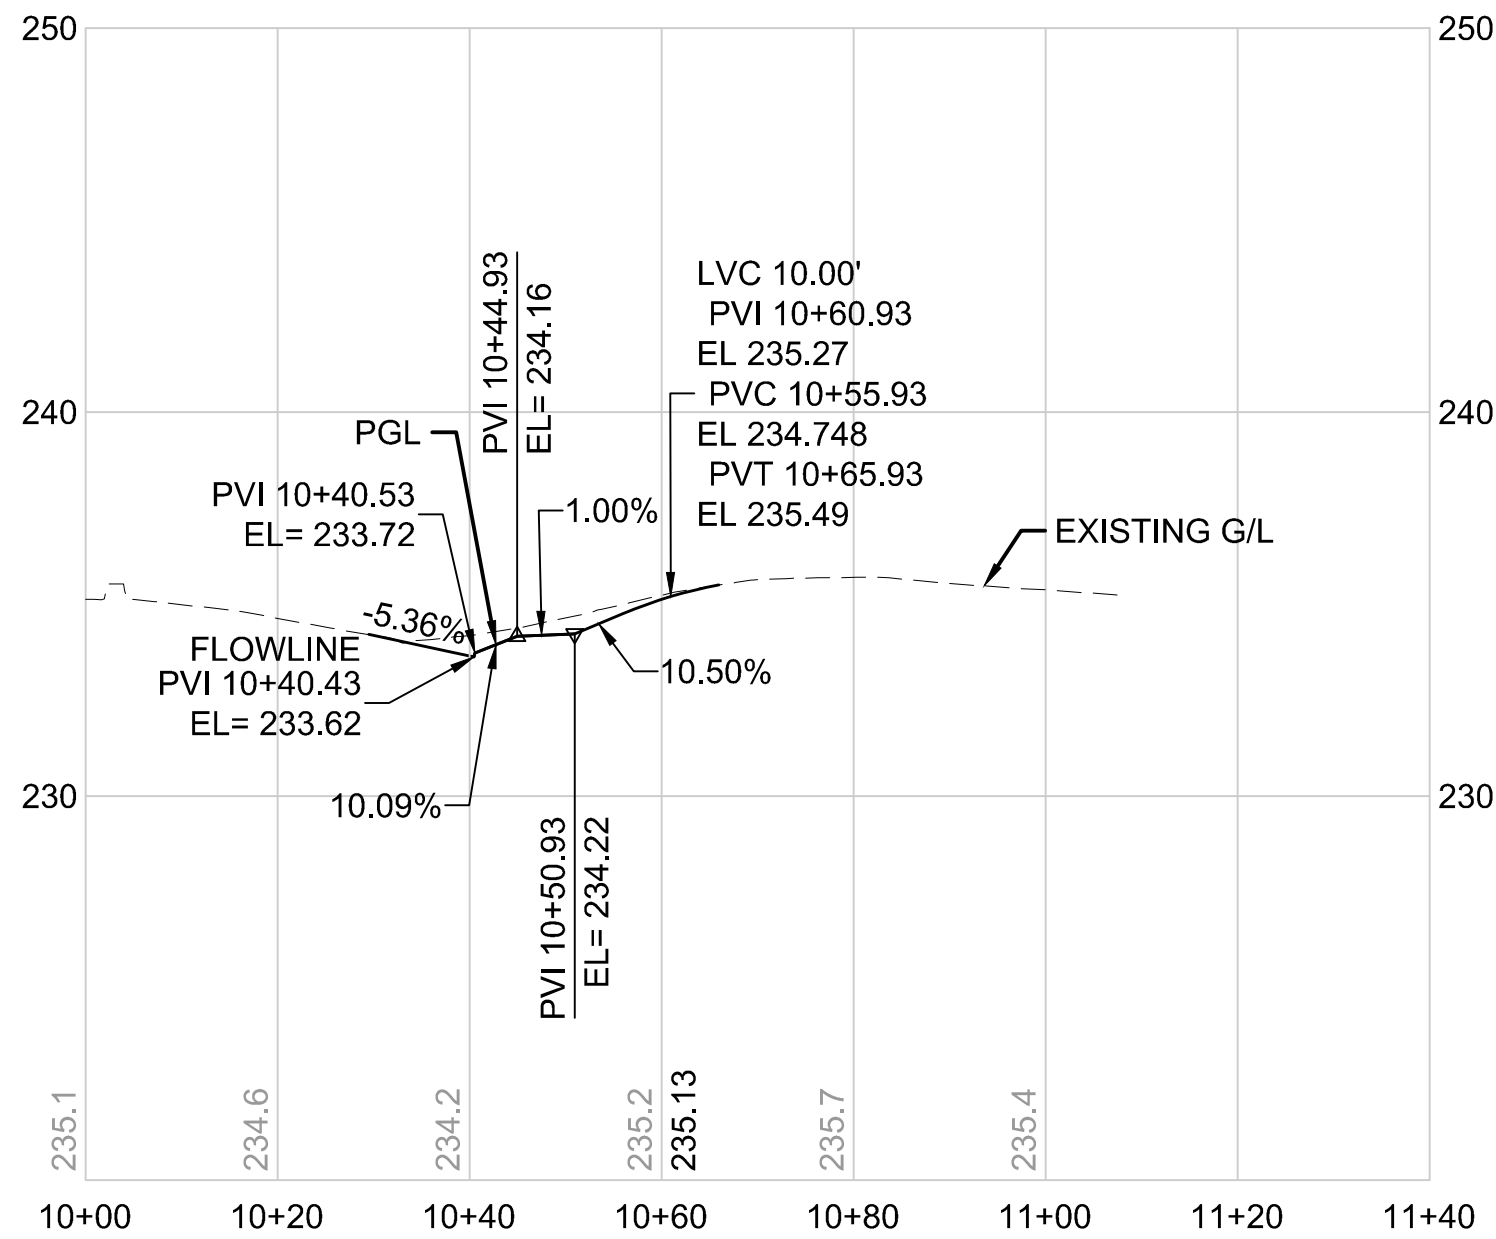

BRS223 LINE
HORIZONTAL SCALE: 1"=20'
VERTICAL SCALE: 1"=5'

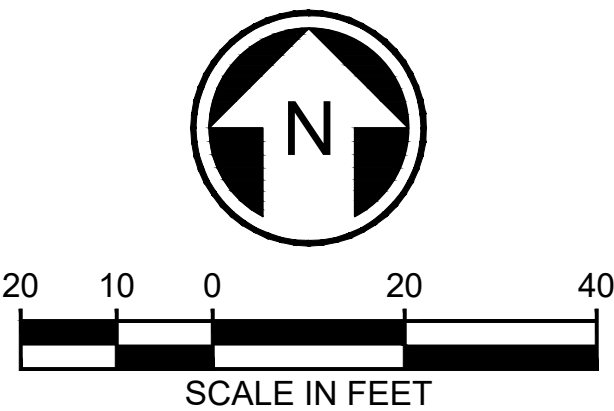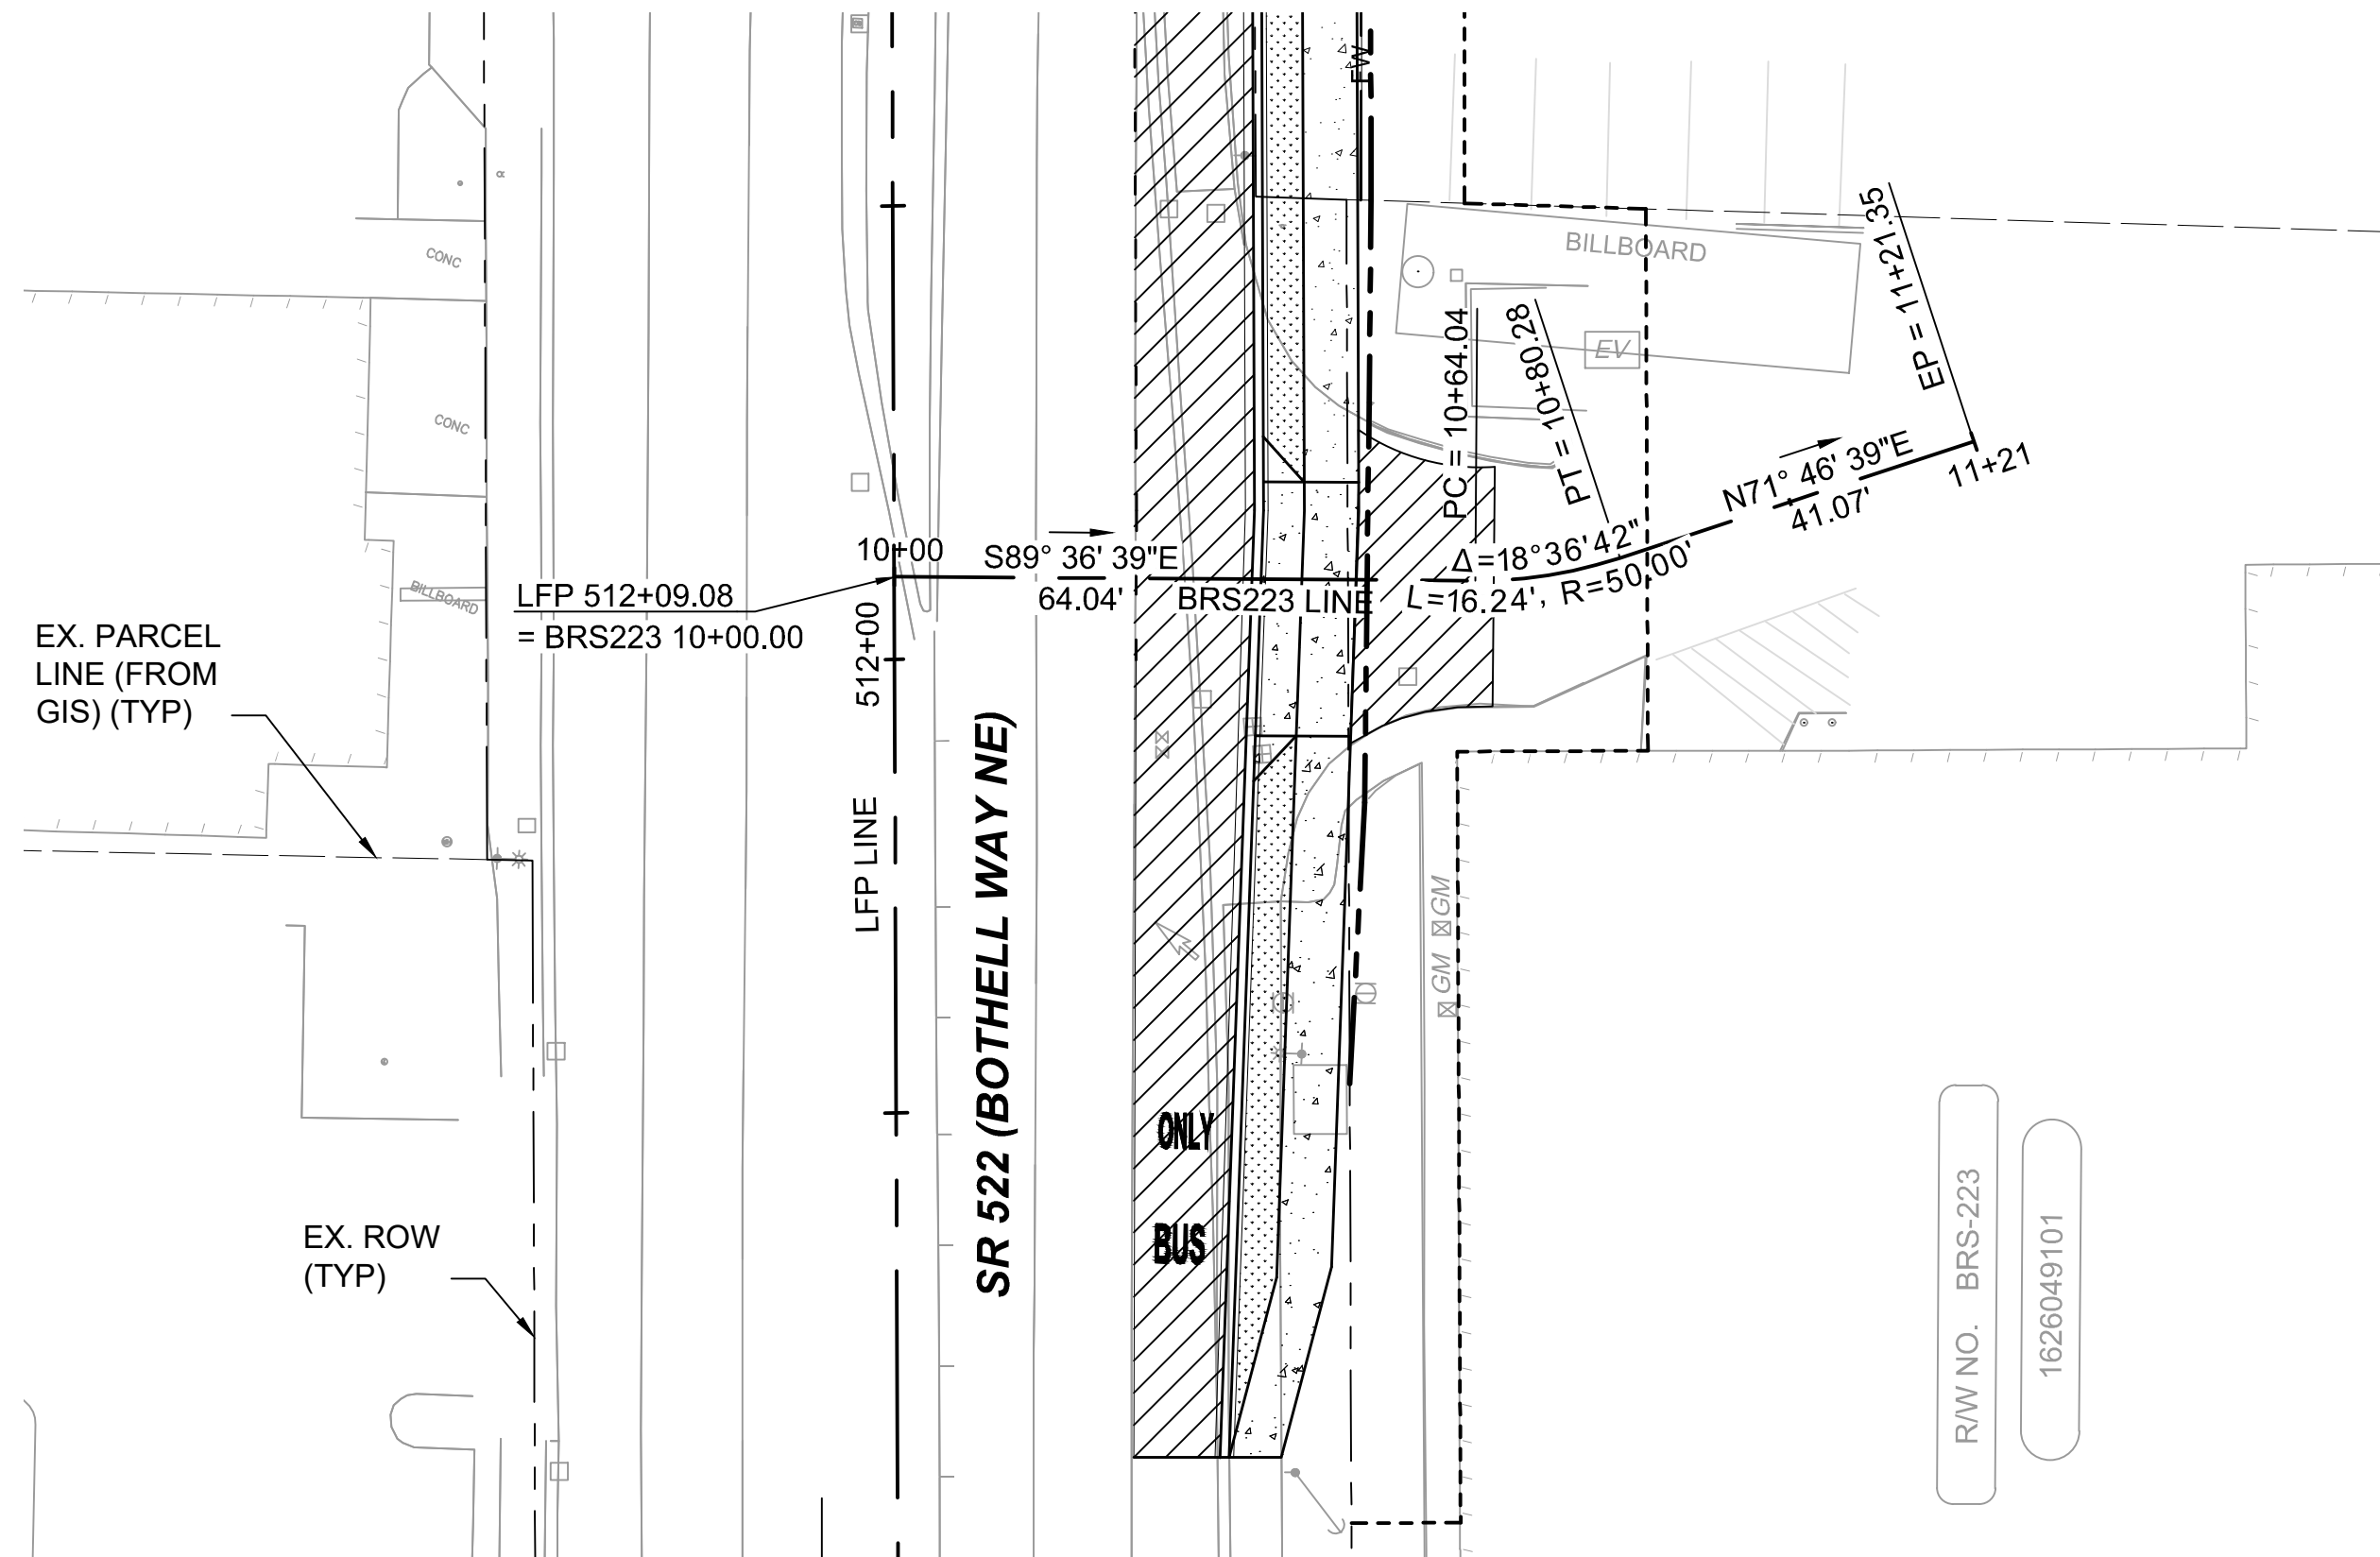

DRAFT 30% SUBMITTAL


No.	DATE	DSN	CHK	APP	REVISION

DESIGNED BY:	C.MATYAS
DRAWN BY:	C.BRESLEY
CHECKED BY:	R.KOESTER
APPROVED BY:	M.FELIBERTI



**DAVID EVANS
AND ASSOCIATES INC.**
14432 SE Eastgate Way, Suite 400
Bellevue Washington 98007
Phone: 425.519.6500

SUBMITTED BY:	DATE:	REVIEWED BY:
D.SCHOCK	09/11/2020	B.KEMPER

 




SOUND TRANSIT

SCALE:	1"=20'
FILENAME:	BRT-522-CRV205-211
CONTRACT No.:	AE 0055-17
DATE:	09/11/2020

SR 522 / NE 145TH BRT
SR 522 (BOTHELL WAY NE)
CIVIL
DRIVEWAY PLAN AND PROFILE BRS223
STA. 10+00 TO STA. 11+21.35

DRAWING No.:	522-CRV205
FACILITY ID:	522
SHEET No.:	109 OF 283
REV:	

09/10/20 | 1:10 AM | SJRO
C:\PW_WORK\DEA\STEVEN ROSE\DWG\BRT-522-CRV205-211.DWG

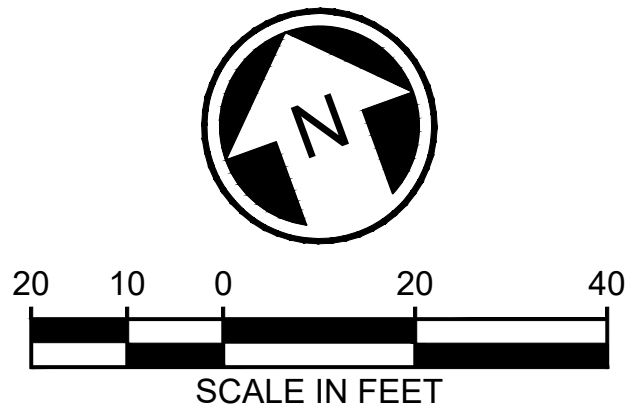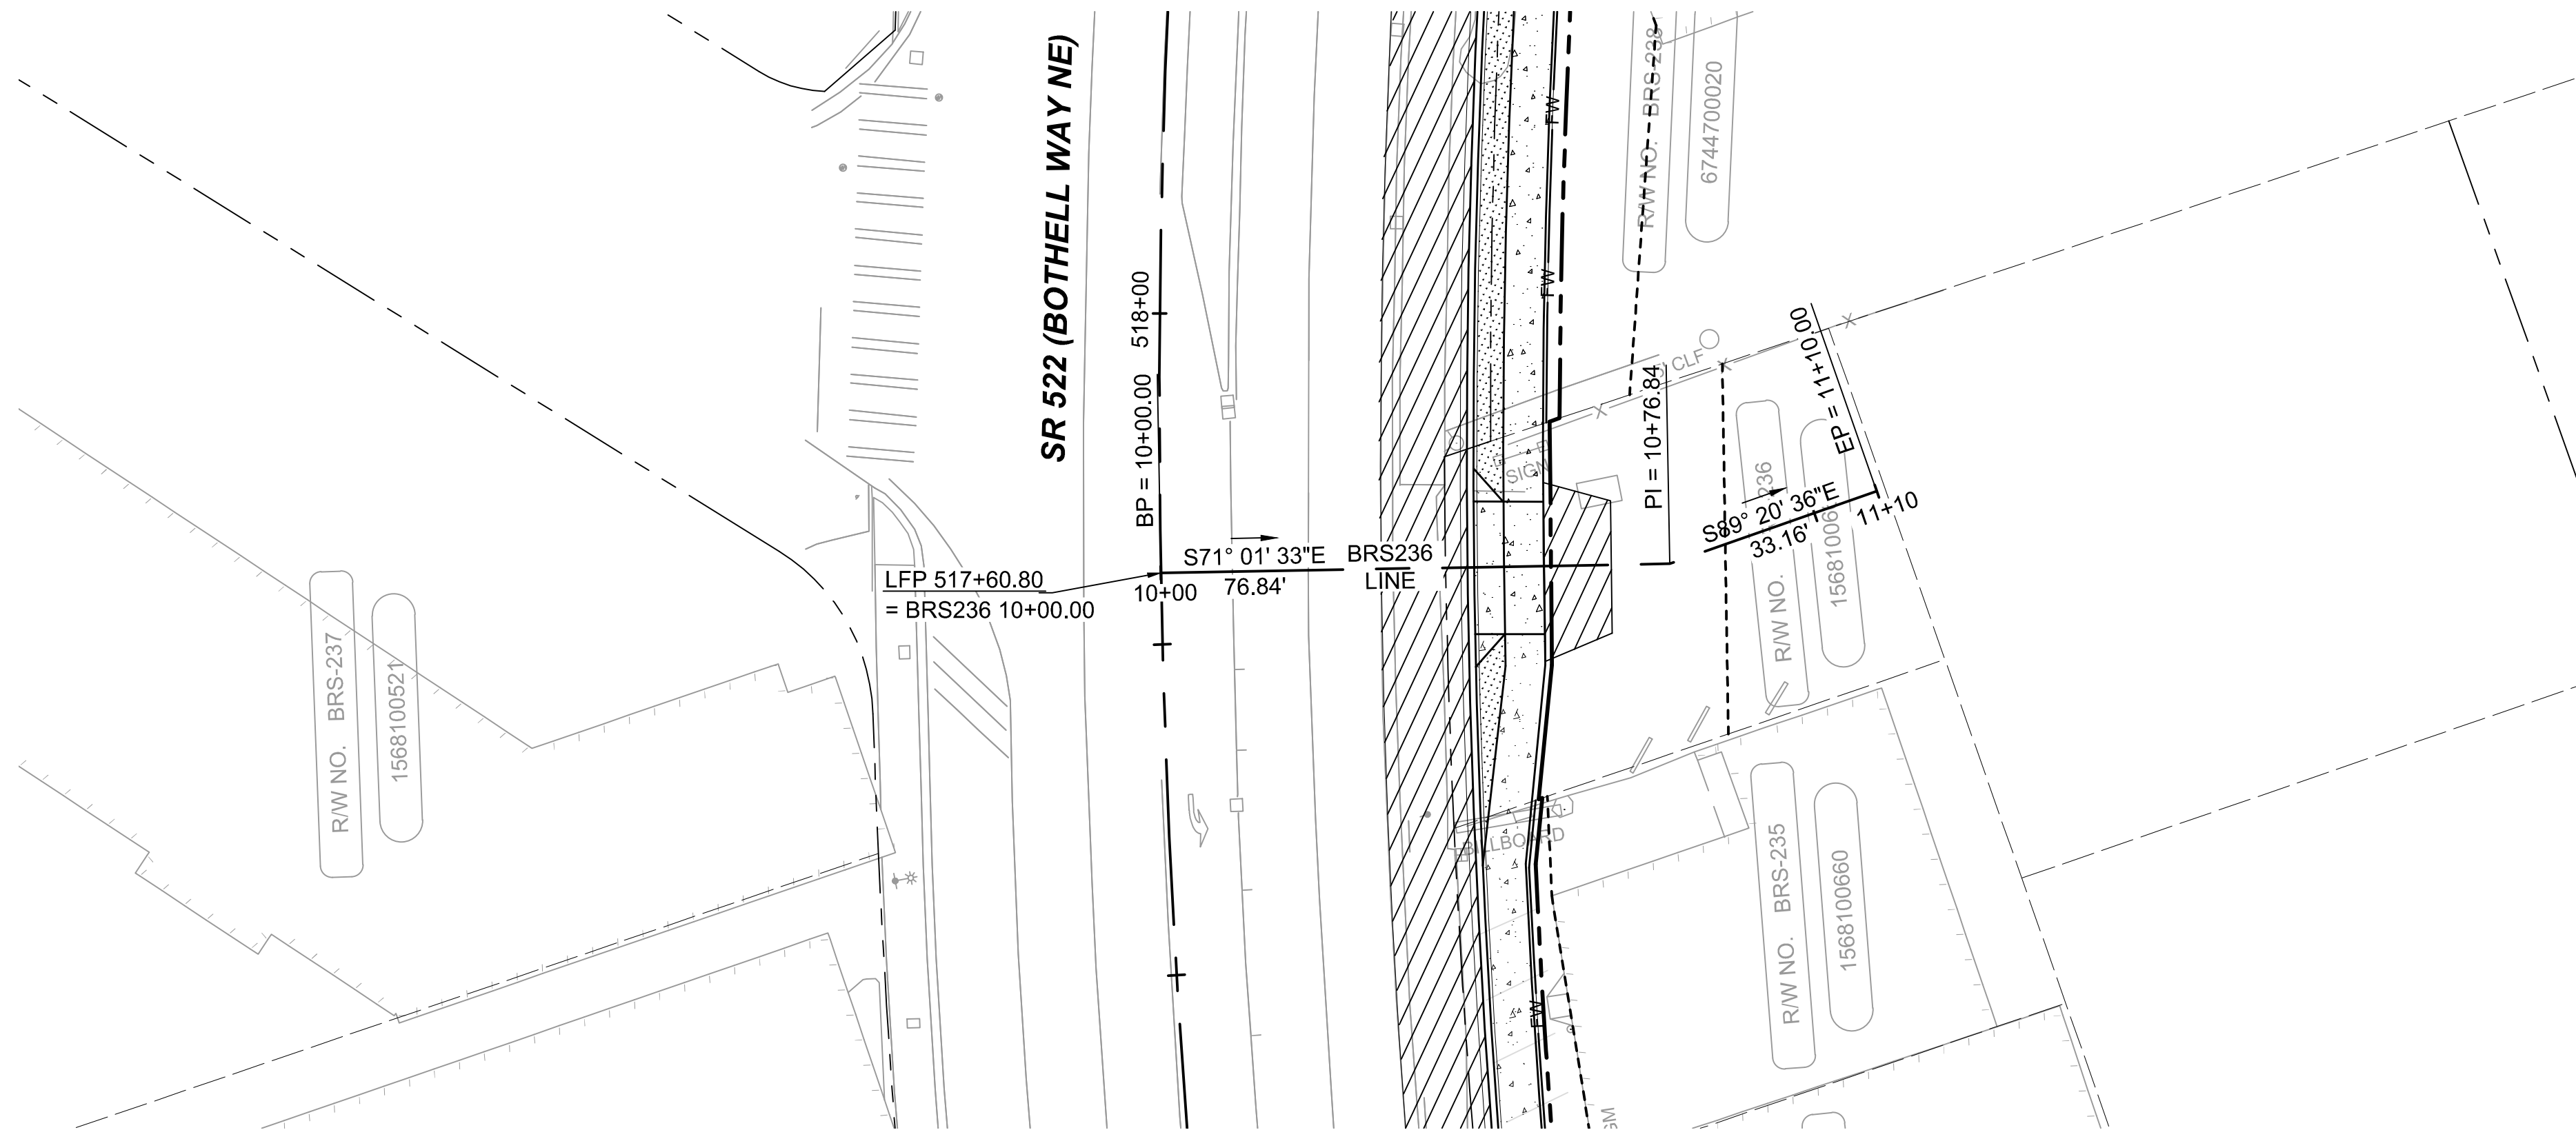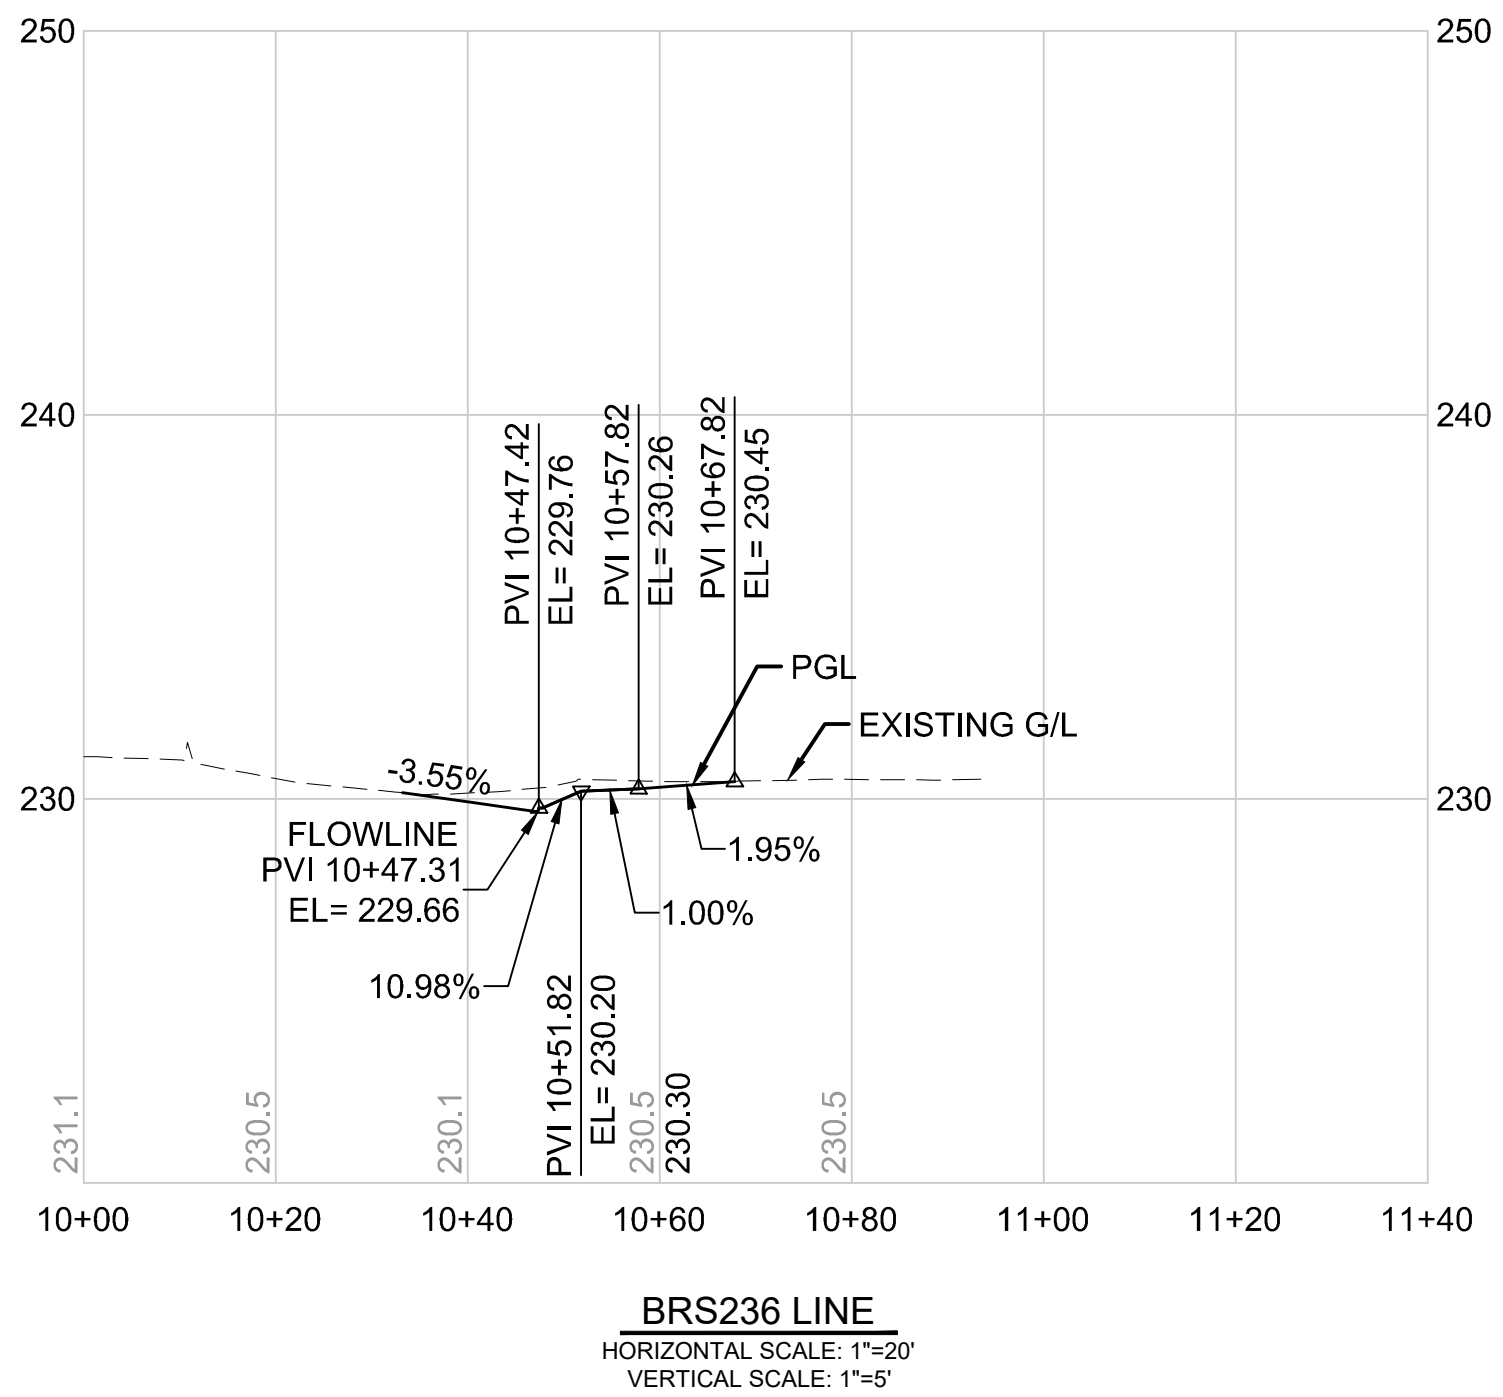

DRAFT 30% SUBMITTAL


No.	DATE	DSN	CHK	APP	REVISION

DESIGNED BY:	C.MATYAS
DRAWN BY:	C.BRESLEY
CHECKED BY:	R.KOESTER
APPROVED BY:	M.FELIBERTI



**DAVID EVANS
AND ASSOCIATES INC.**
14432 SE Eastgate Way, Suite 400
Bellevue Washington 98007
Phone: 425.519.6500

SUBMITTED BY:	DATE:	REVIEWED BY:
D.SCHOCK	09/11/2020	B.KEMPER






 


SCALE:	1"=20'
FILENAME:	BRT-522-CRV205-211
CONTRACT No.:	AE 0055-17
DATE:	09/11/2020

SR 522 / NE 145TH BRT
SR 522 (BOTHELL WAY NE)
CIVIL
DRIVEWAY PLAN AND PROFILES BRS236-S & BRS236-N
STA. 10+00 TO STA. 11+11.51

DRAWING No.:	522-CRV206
FACILITY ID:	522
SHEET No.:	110 OF 283
REV:	

09/10/20 | 1:12 AM | SJRO
C:\PW_WORK\DAE\STEVEN ROSE\DWG\506735\BRT-522-CRV205-211.DWG

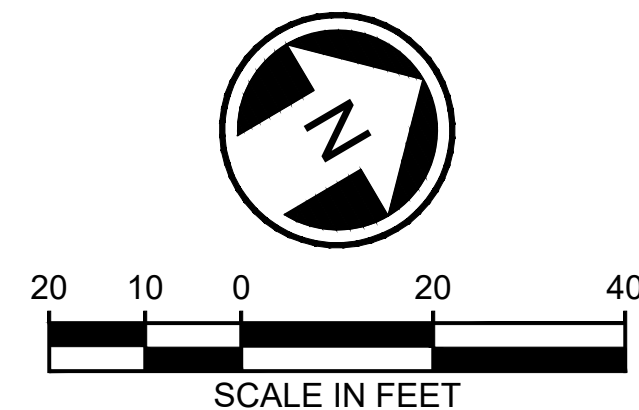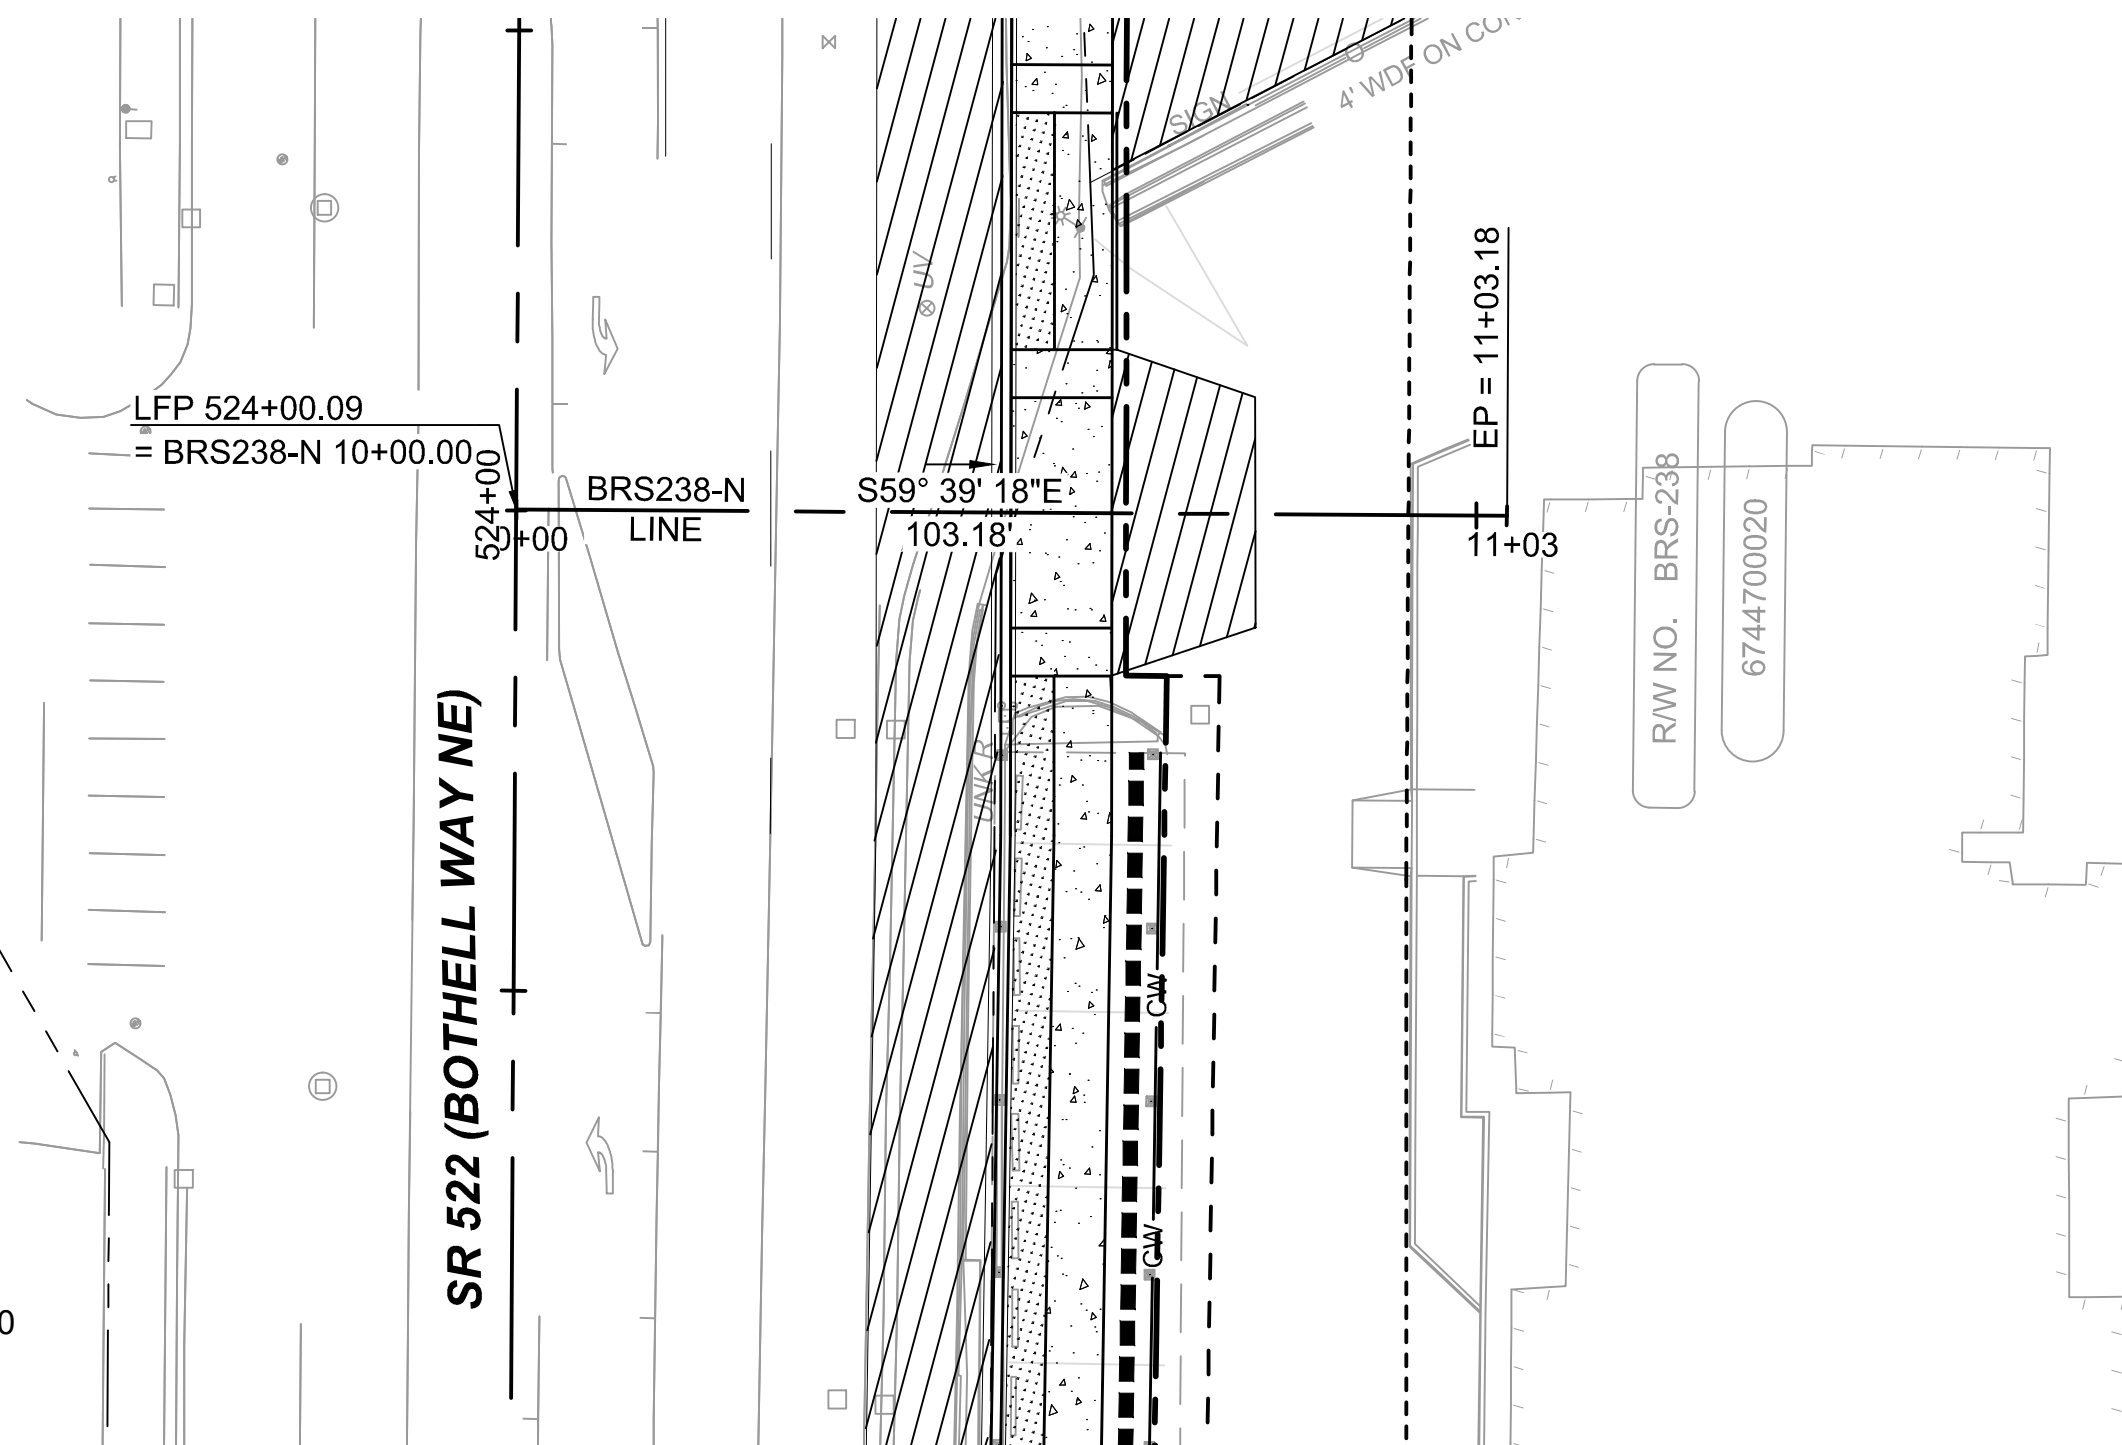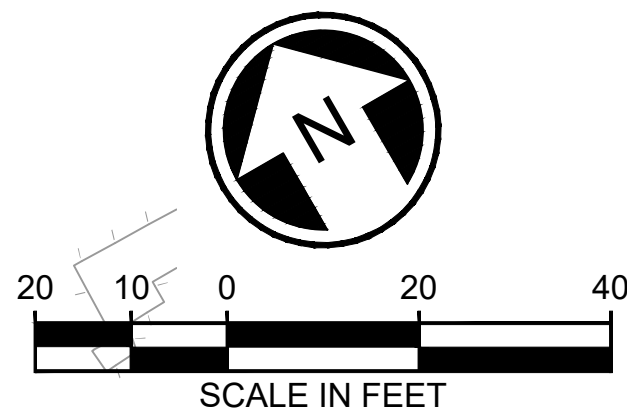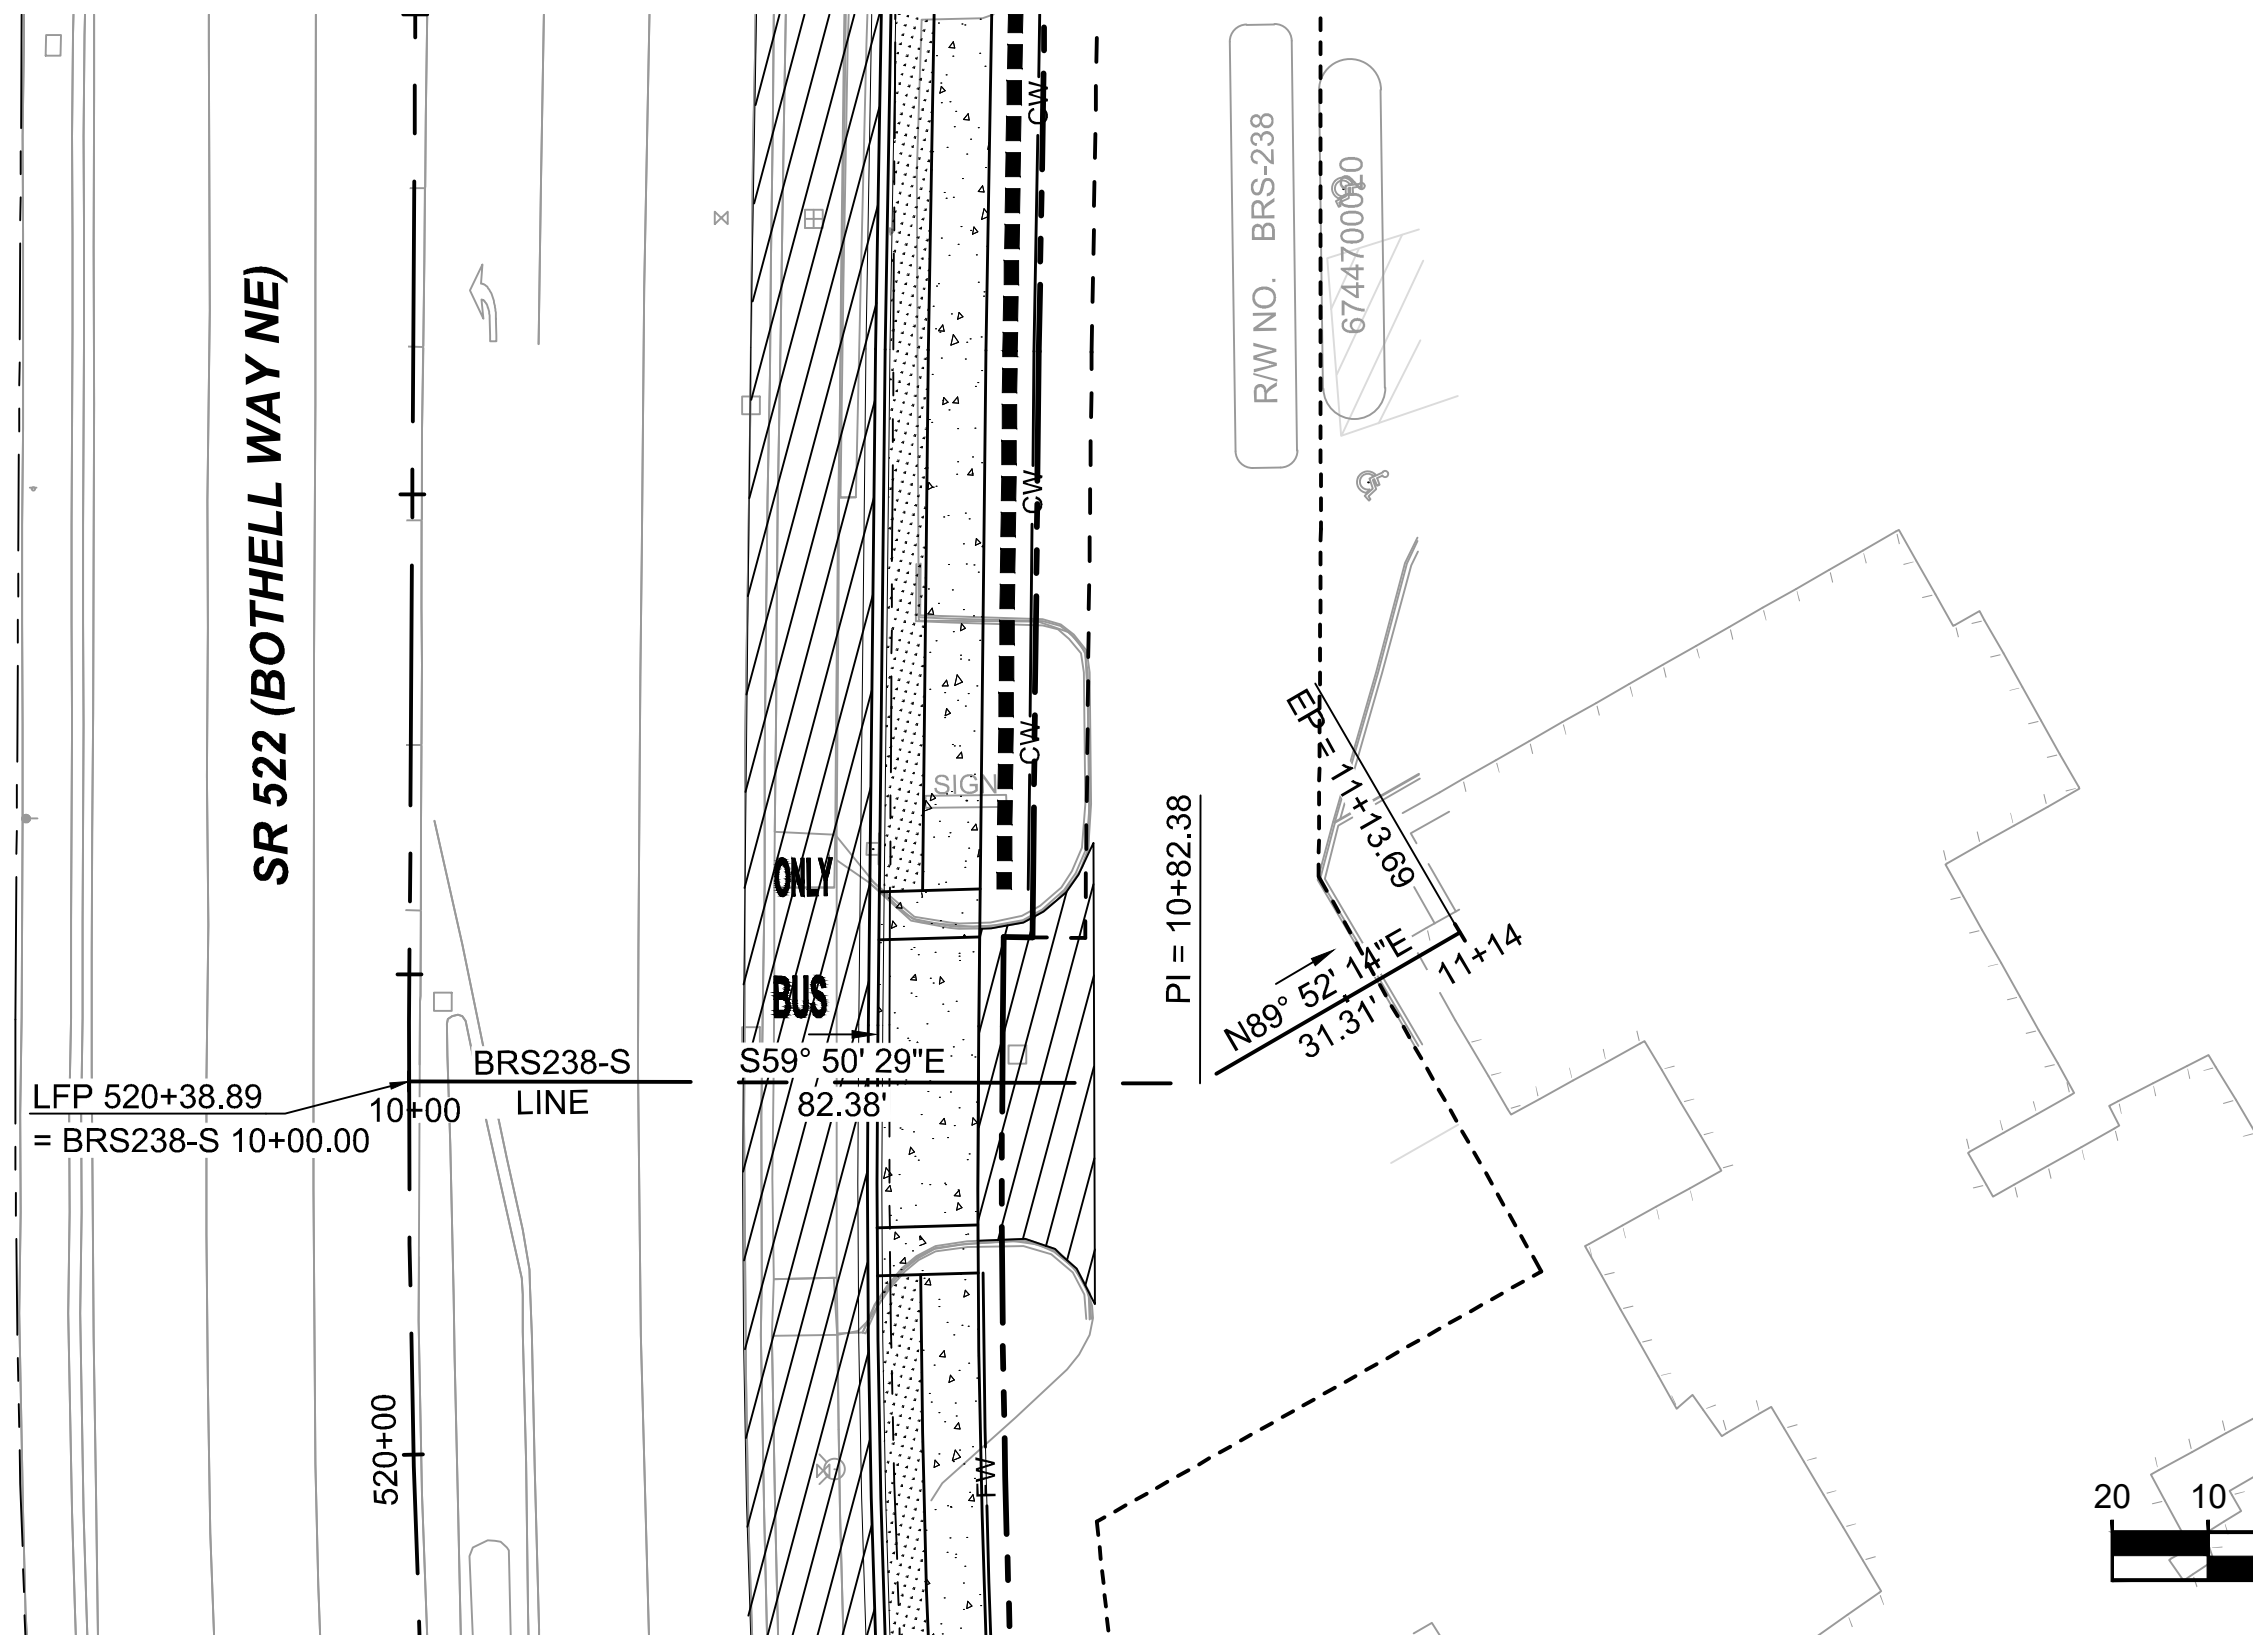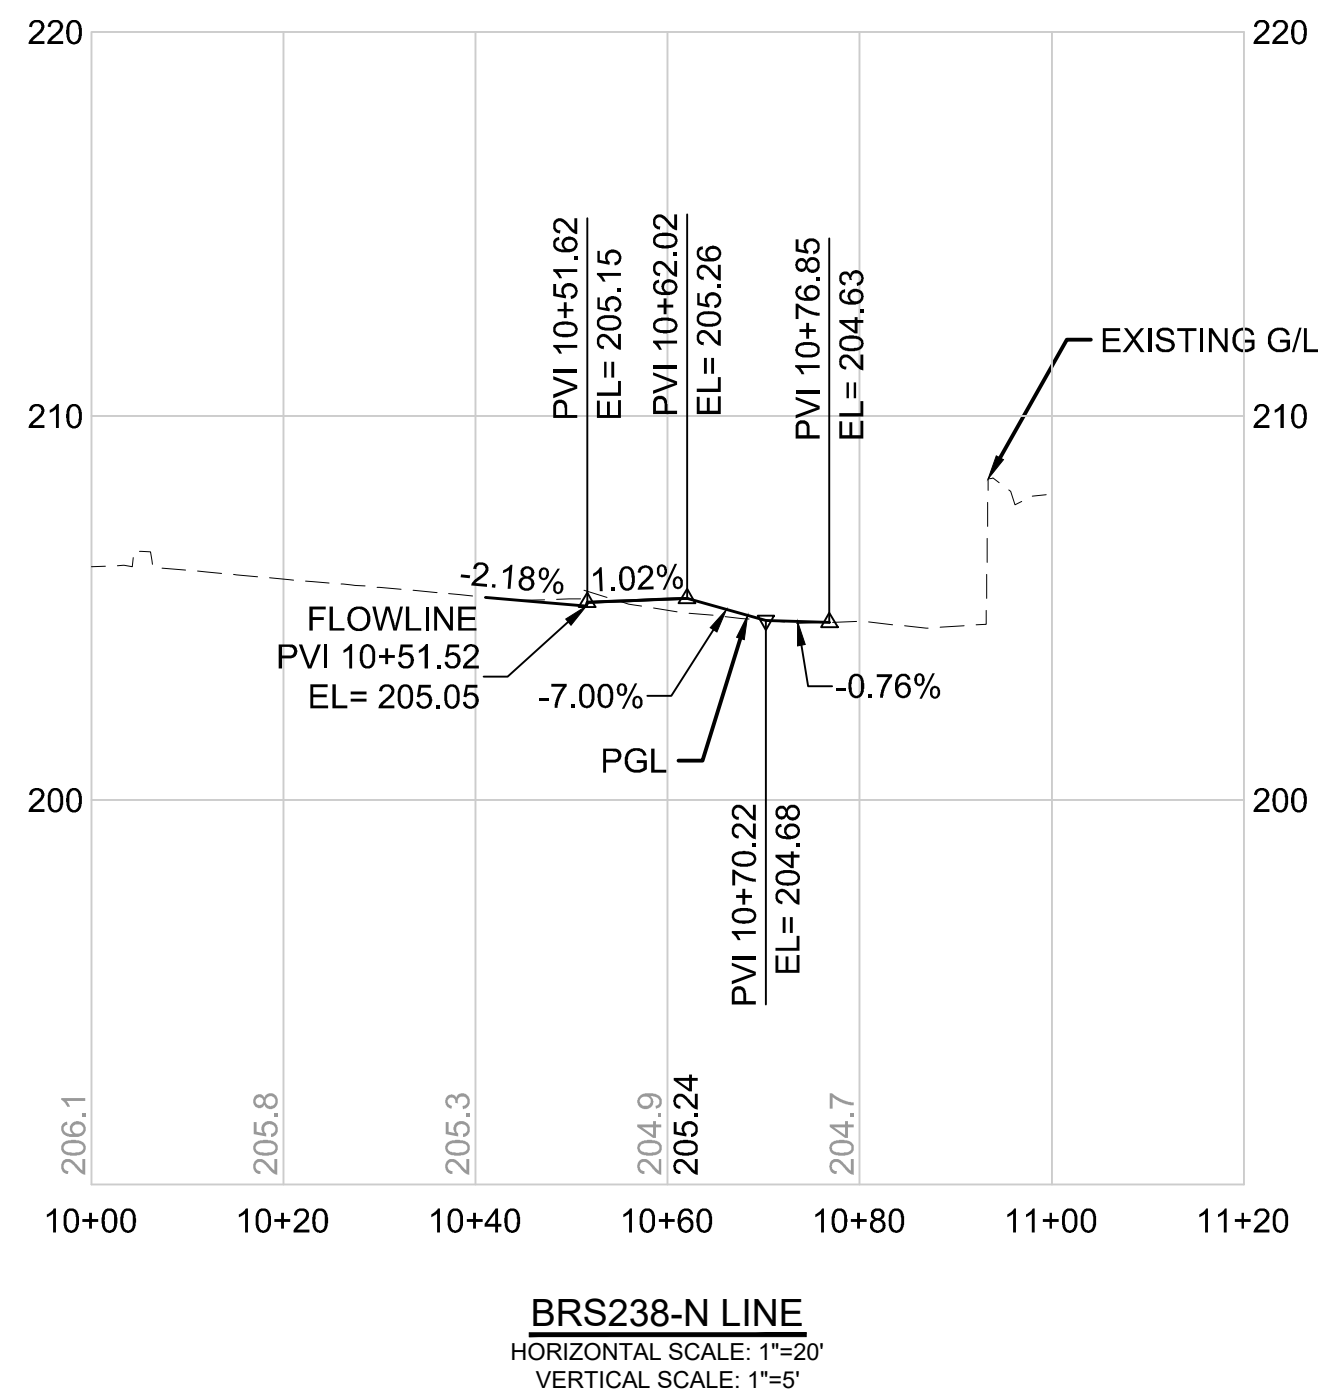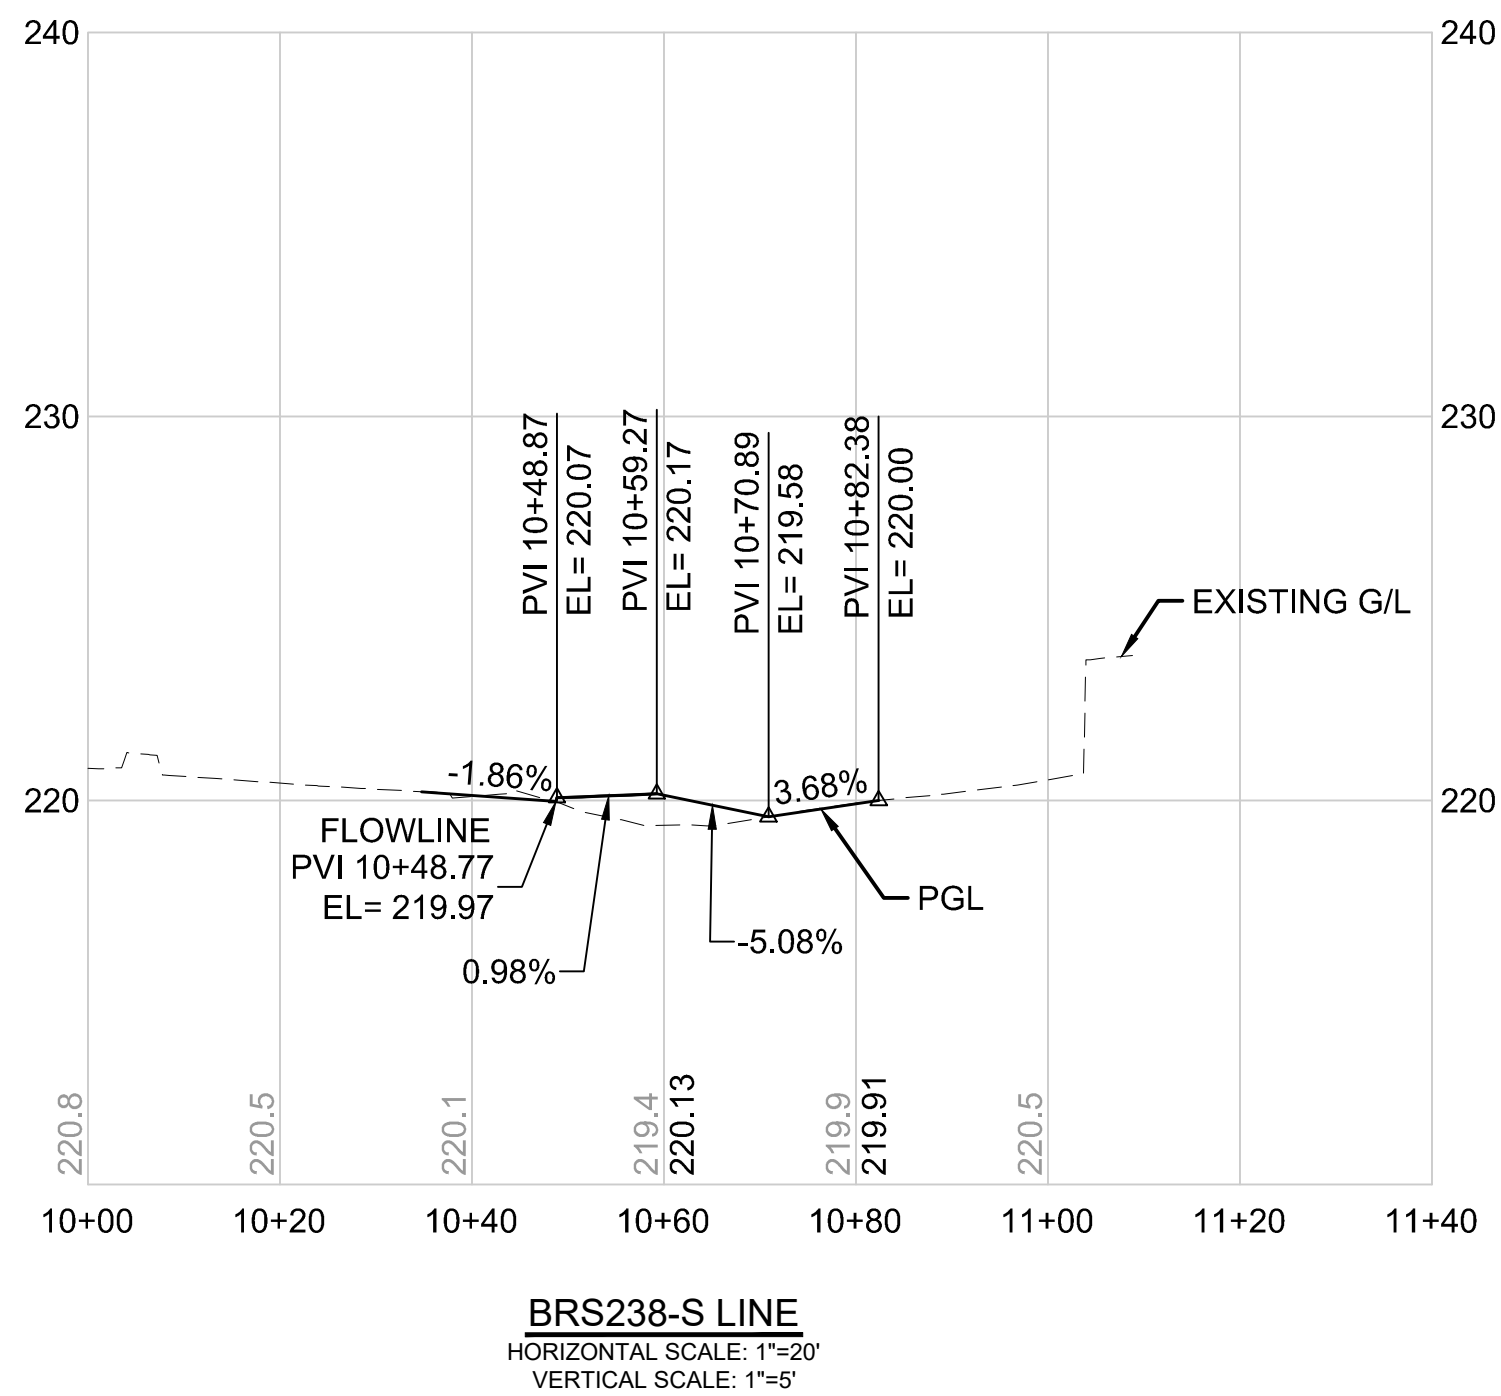


DRAFT 30% SUBMITTAL

DESIGNED BY:
C.MATYAS
DRAWN BY:
C.BRESLEY
CHECKED BY:
R.KOESTER
APPROVED BY:
M.FELIBERTI



 **DAVID EVANS
AND ASSOCIATES INC.**
14432 SE Eastgate Way, Suite 400
Bellevue Washington 98007
Phone: 425.519.6500




SOUNDTRANSIT

SCALE:
1"=20'
FILENAME:
BRT-522-CRV205-211
CONTRACT No.:
AE 0055-17
DATE:
09/11/2020



SR 522 / NE 145TH BRT
SR 522 (BOTHELL WAY NE)
CIVIL
DRIVEWAY PLAN AND PROFILES BRS238-S & BRS238-N
STA. 10+00 TO STA. 11+13.69

DRAWING No.:
522-CRV207
FACILITY ID:
522
SHEET No.:
111 OF 283

09/10/20 | 1:13 AM | SJRO
C:\PW_WORK\DAE\STEVEN ROSE\DWG\BRT-522-CRV205-211.DWG

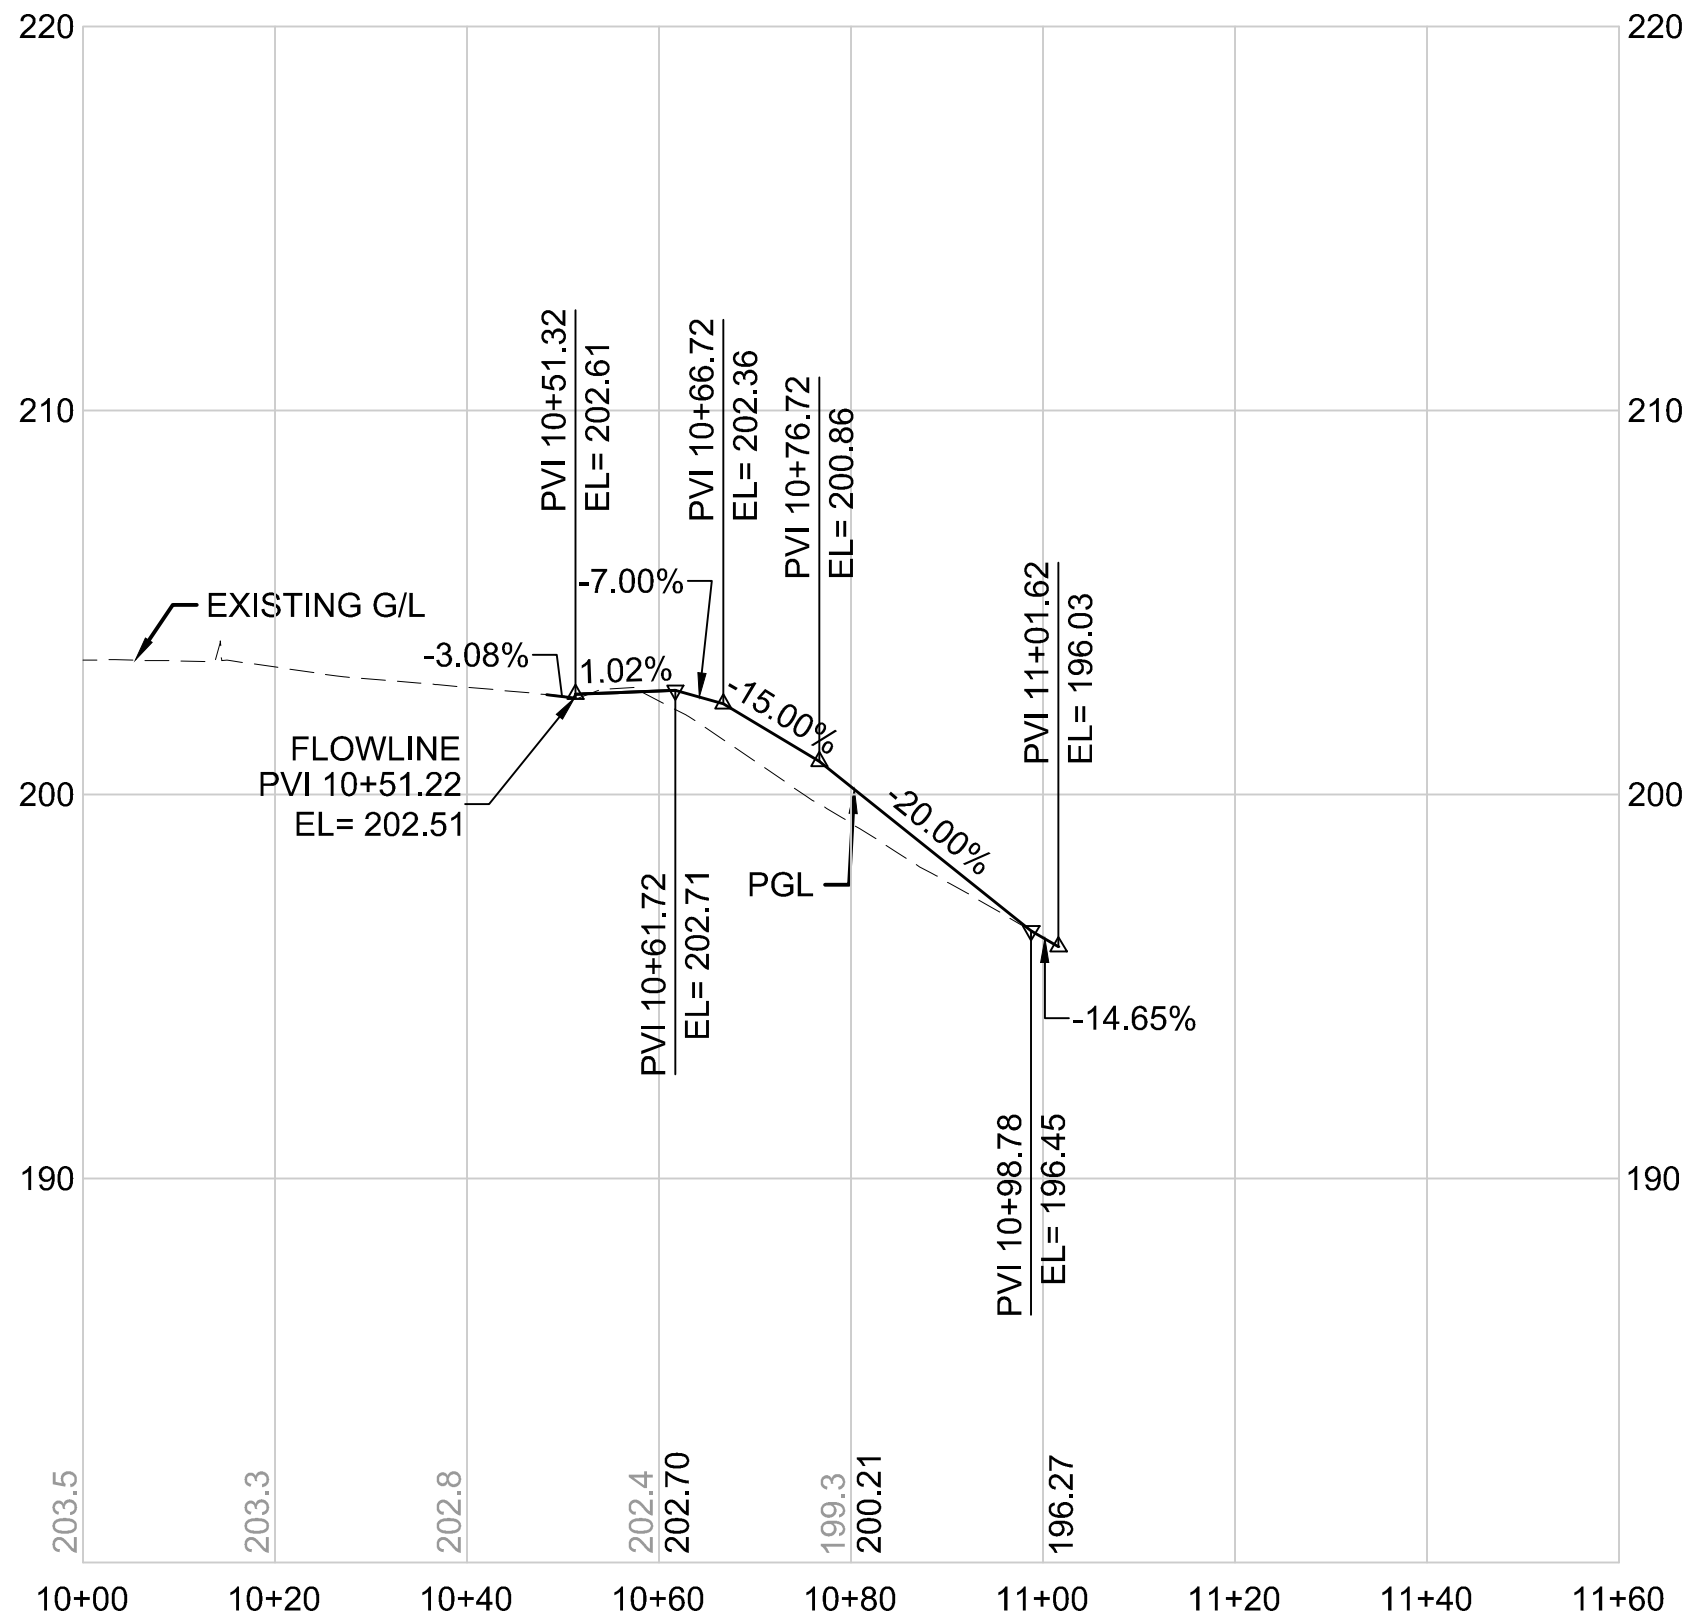

BRS240-242 LINE
HORIZONTAL SCALE: 1"=20'
VERTICAL SCALE: 1"=5'

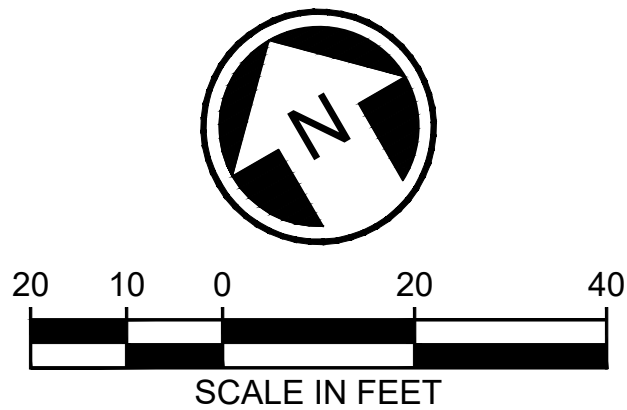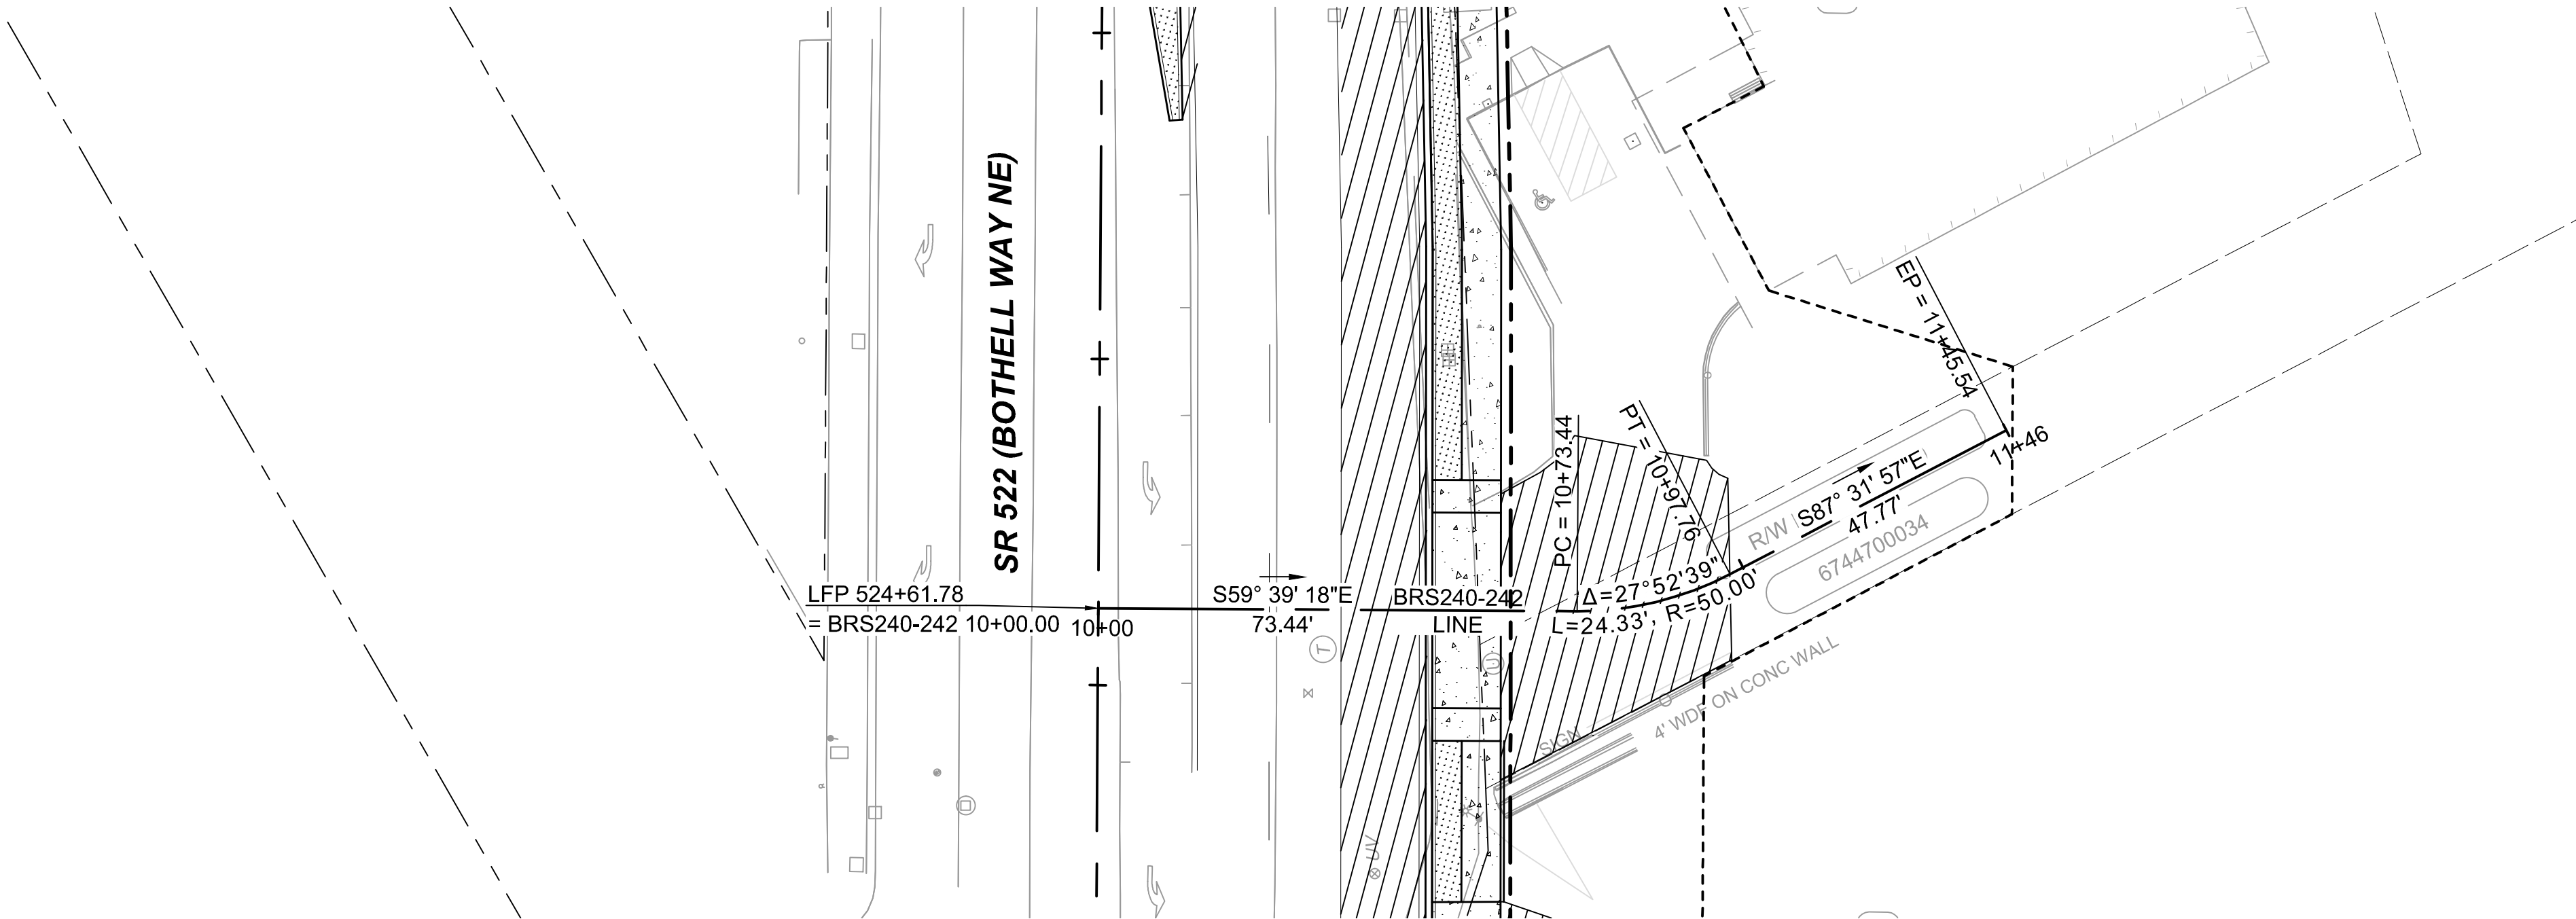


DRAFT 30% SUBMITTAL

No.	DATE	DSN	CHK	APP	REVISION

DESIGNED BY:	C.MATYAS
DRAWN BY:	C.BRESLEY
CHECKED BY:	R.KOESTER
APPROVED BY:	M.FELIBERTI



 **DAVID EVANS
AND ASSOCIATES INC.**
14432 SE Eastgate Way, Suite 400
Bellevue Washington 98007
Phone: 425.519.6500




SOUNDTRANSIT

SCALE:	1"=20'
FILENAME:	BRT-522-CRV205-211
CONTRACT No.:	AE 0055-17
DATE:	09/11/2020


SR 522 / NE 145TH BRT
SR 522 (BOTHELL WAY NE)
CIVIL
DRIVEWAY PLAN AND PROFILES BRS240-242
STA. 10+00 TO STA. 11+45.54

DRAWING No.:	522-CRV208
FACILITY ID:	522
SHEET No.:	112 OF 283


09/10/20 | 1:14 AM | SJRO
C:\PW_WORK\DEA\STEVEN ROSE\DWG\BRT-522-CRV205-211.DWG

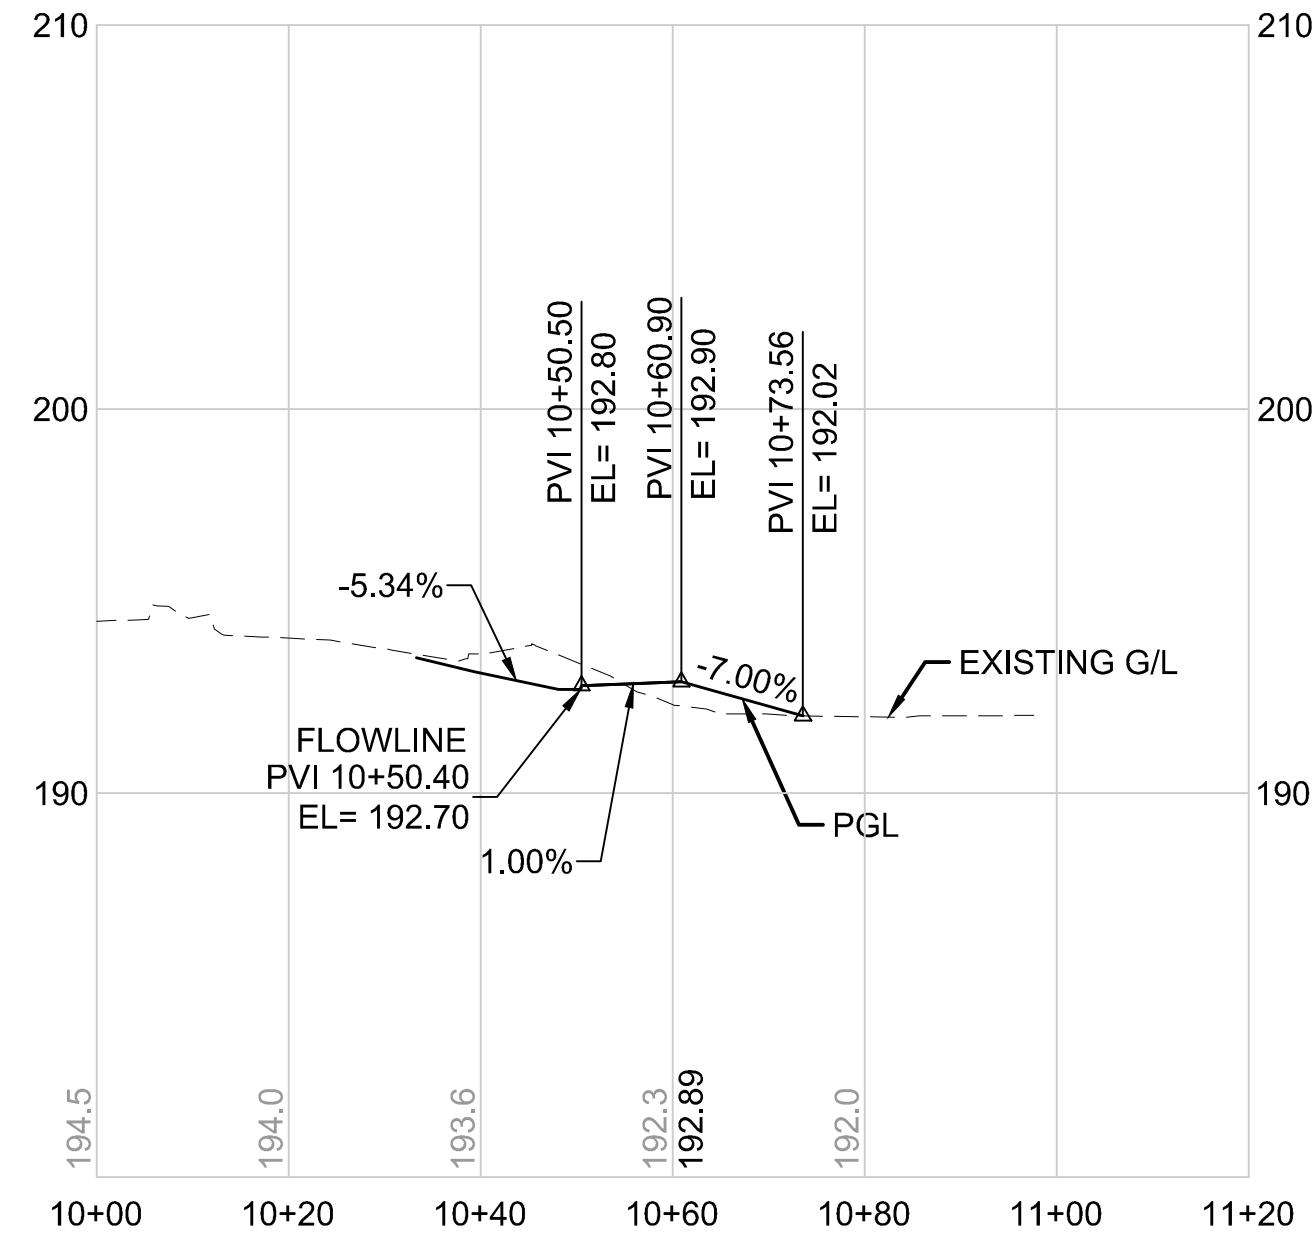


BRS243-S LINE
HORIZONTAL SCALE: 1"=20'
VERTICAL SCALE: 1"=5'

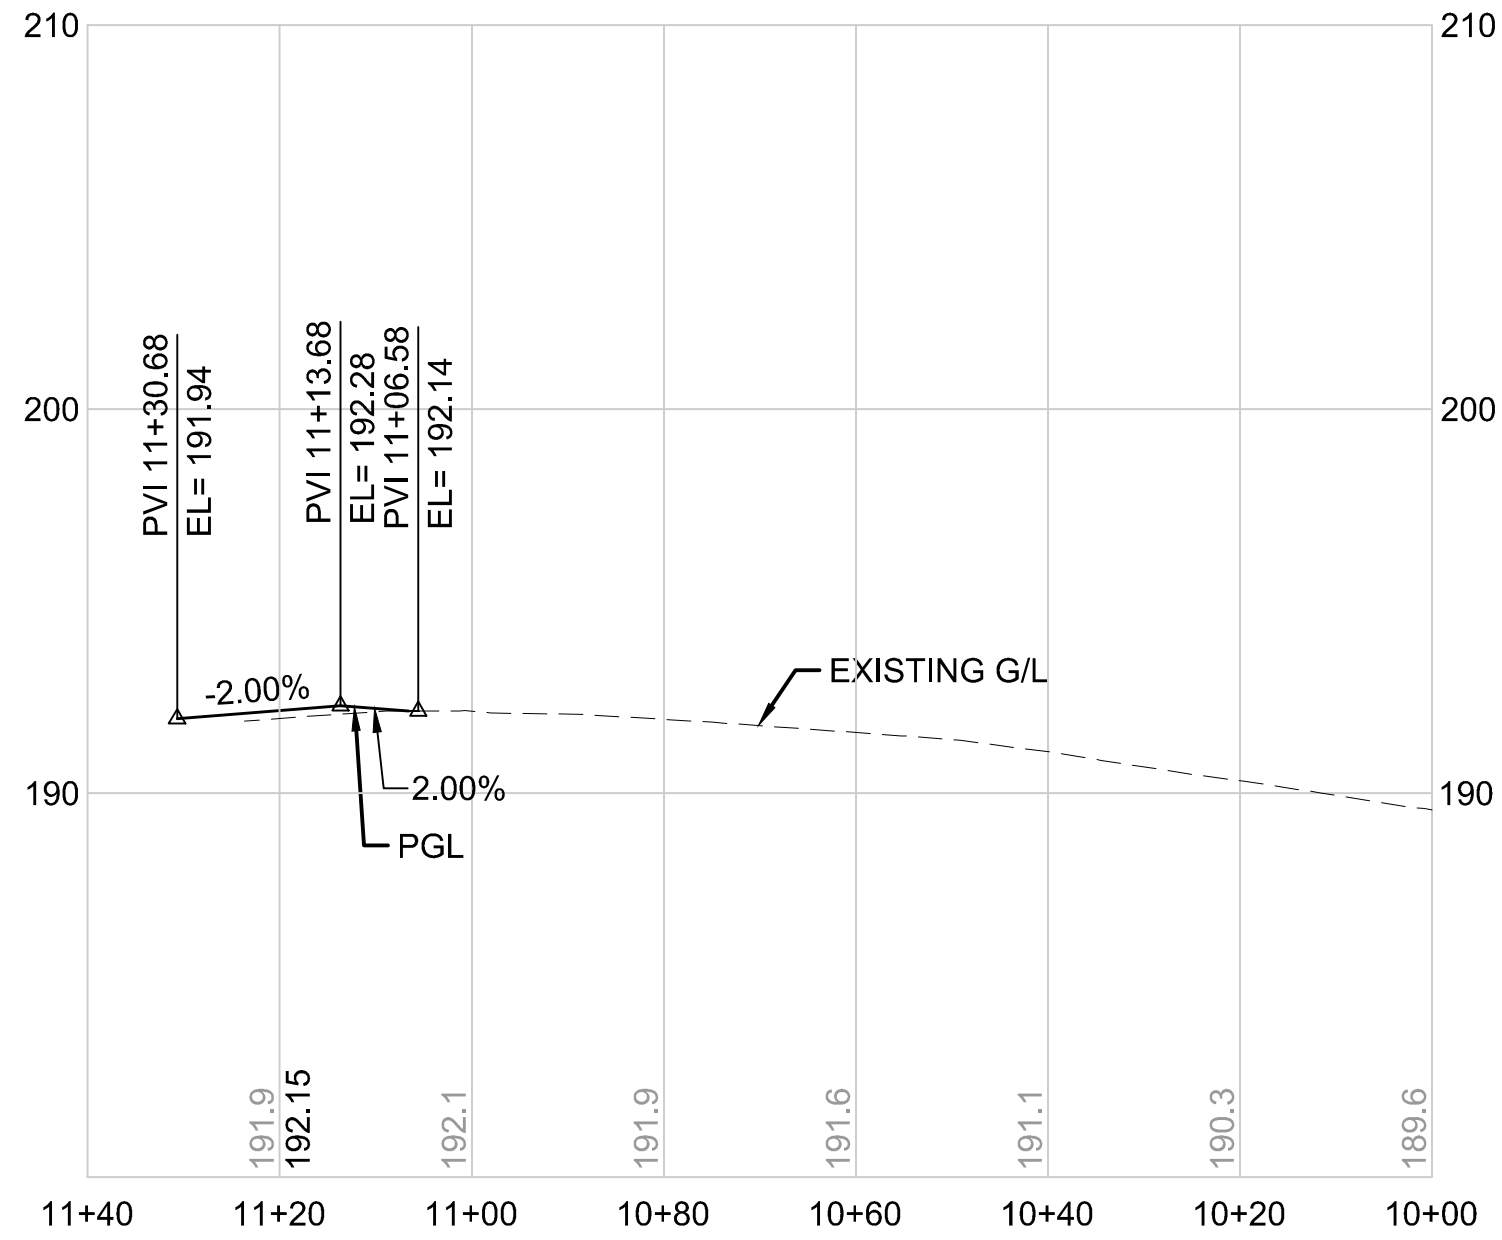

BRS243 N-S LINE
HORIZONTAL SCALE: 1"=20'
VERTICAL SCALE: 1"=5'

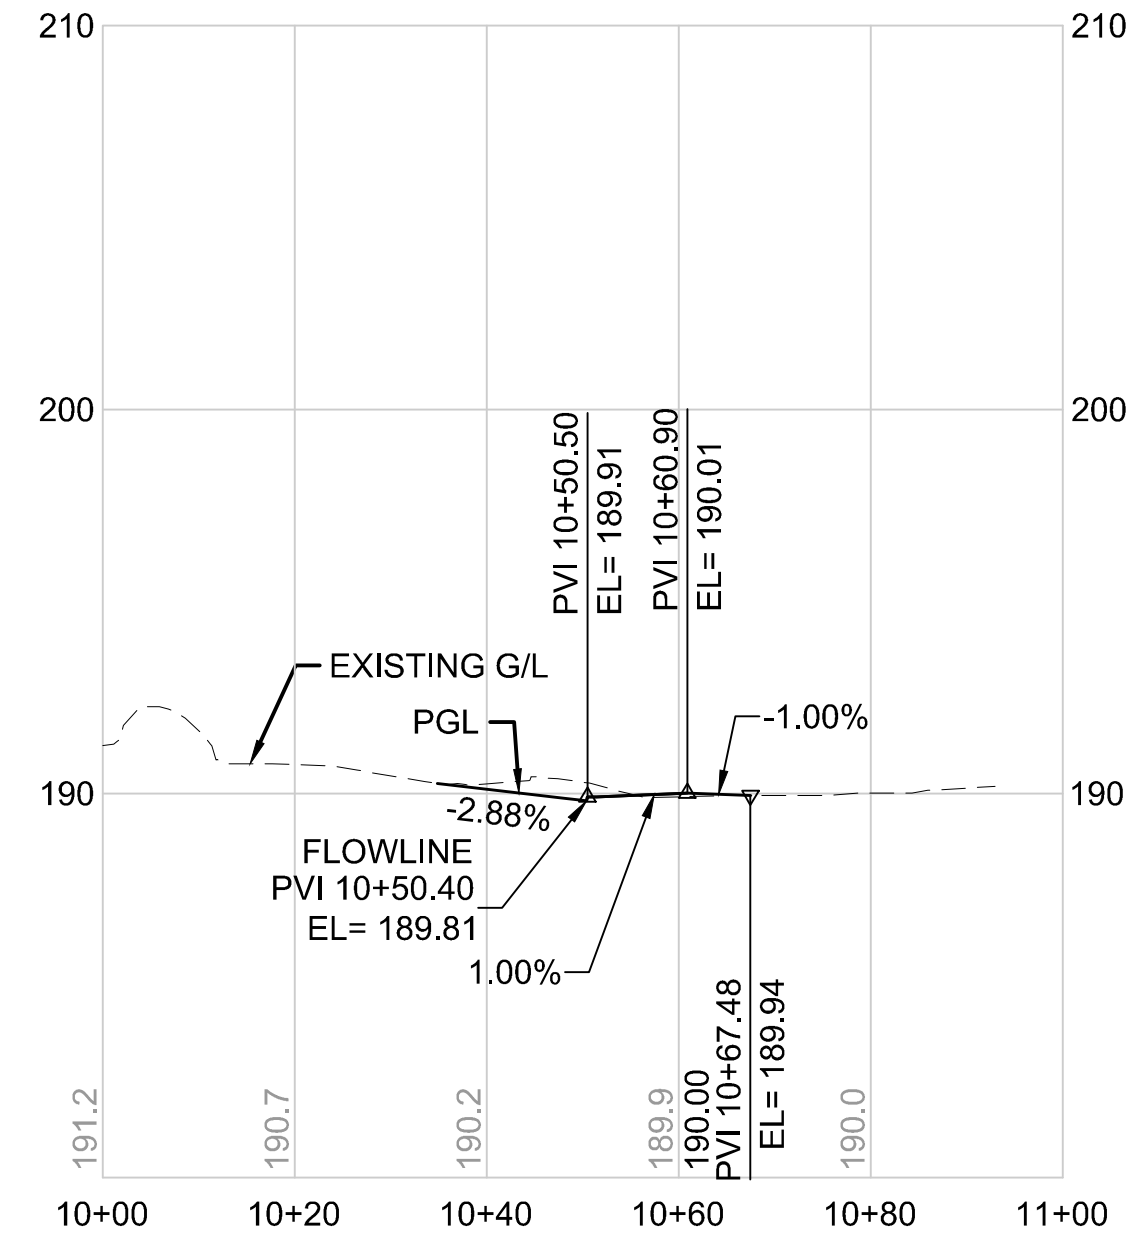

BRS243-N LINE
HORIZONTAL SCALE: 1"=20'
VERTICAL SCALE: 1"=5'

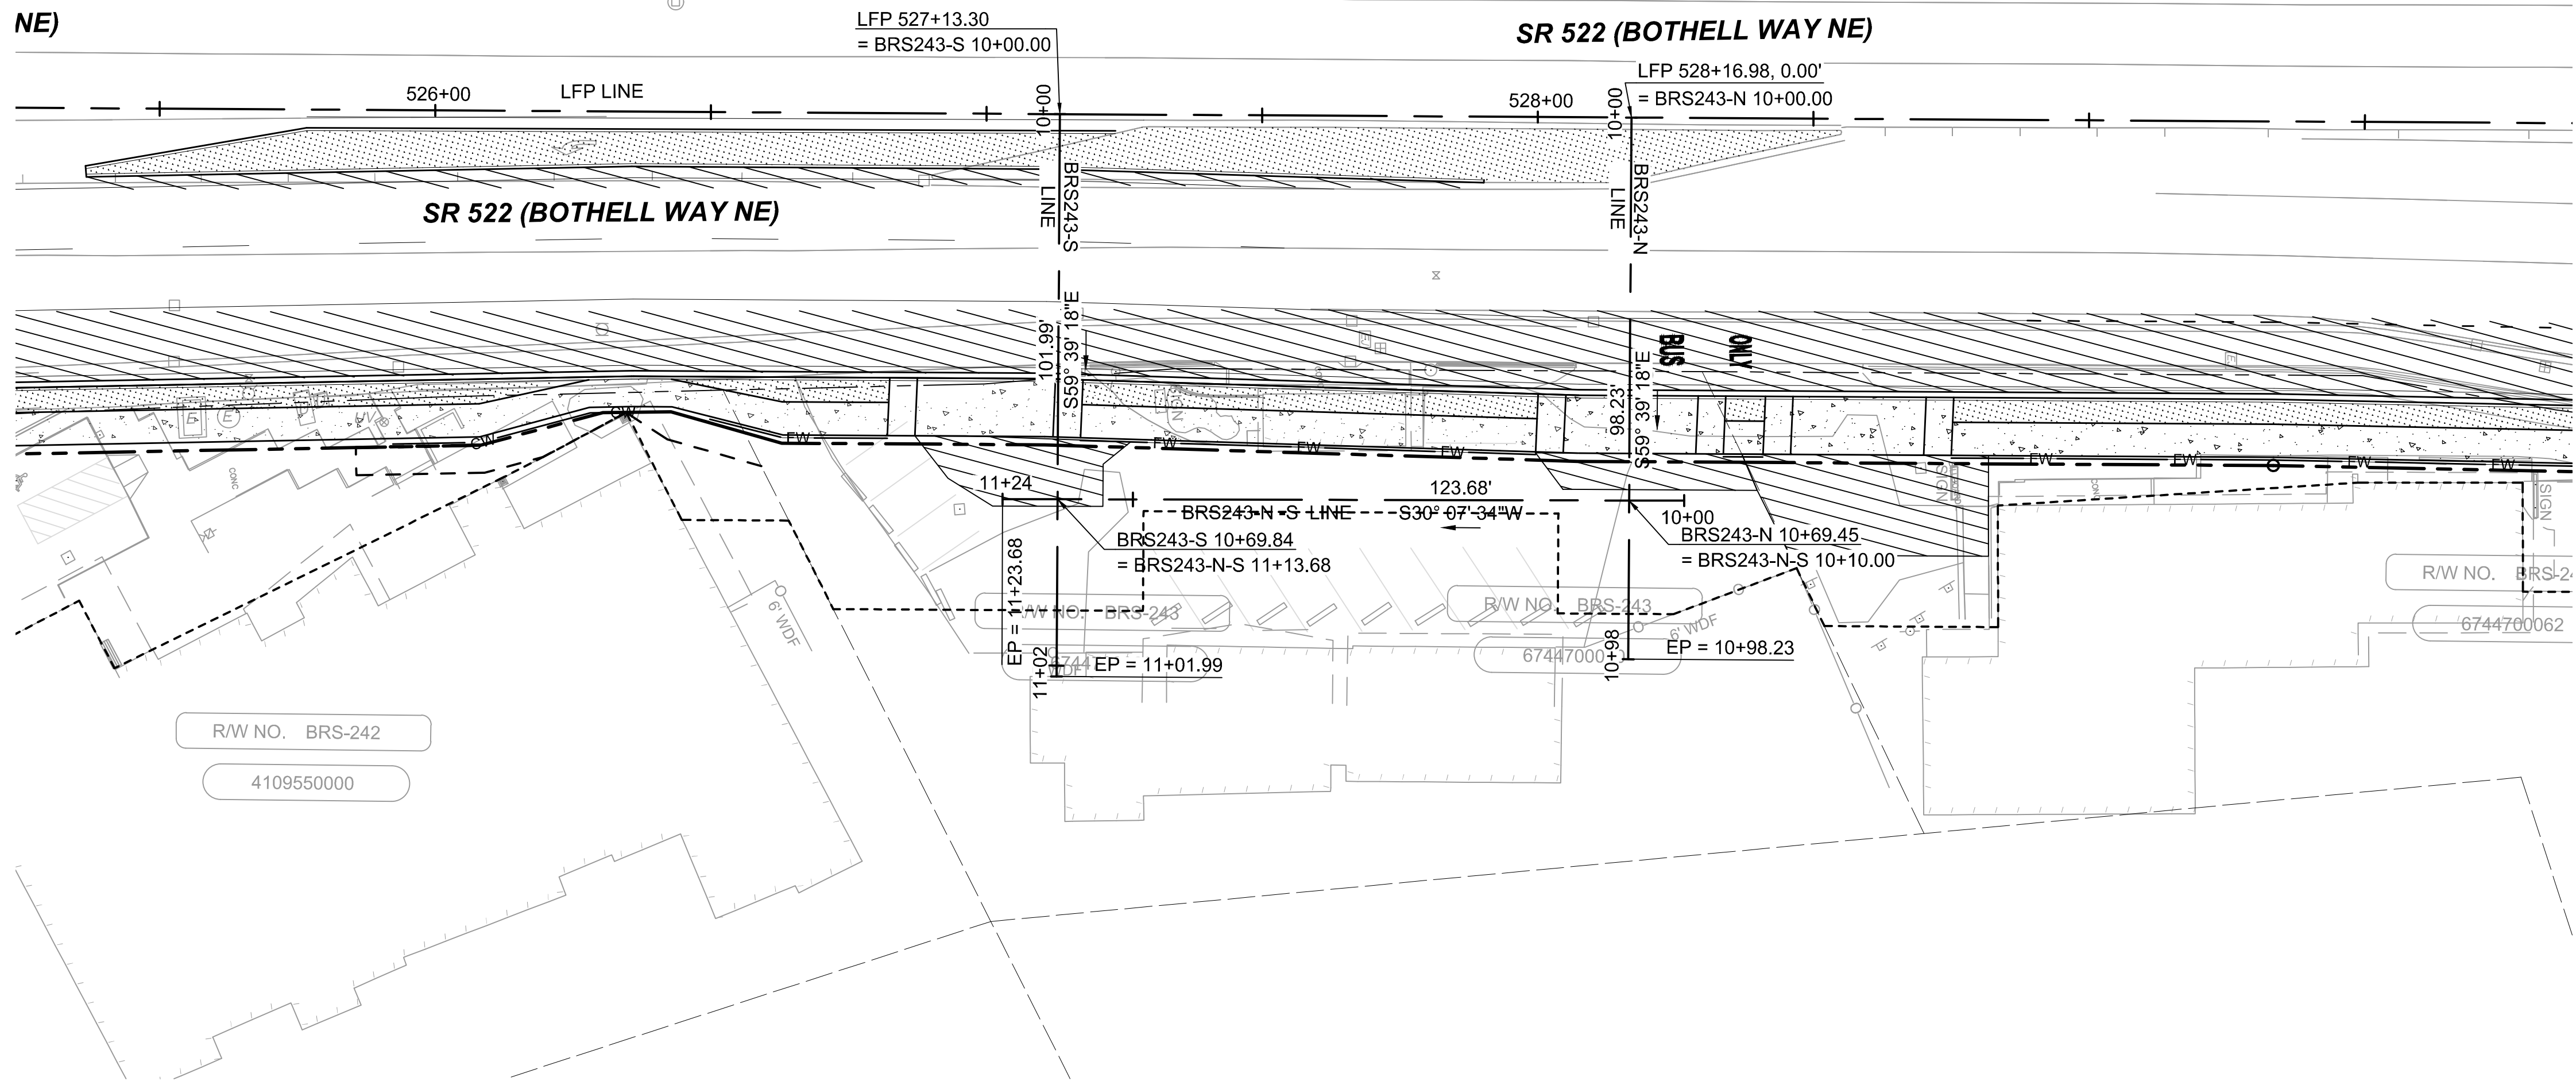

DRAFT 30% SUBMITTAL

DESIGNED BY:
C.MATYAS
DRAWN BY:
C.BRESLEY
CHECKED BY:
R.KOESTER
APPROVED BY:
M.FELIBERTI



**DAVID EVANS
AND ASSOCIATES INC.**
14432 SE Eastgate Way, Suite 400
Bellevue Washington 98007
Phone: 425.519.6500

SUBMITTED BY:
D.SCHOCK

DATE:
09/11/2020

REVIEWED BY:
B.KEMPER




DATE:
09/11/2020

SCALE:
1"=20'
FILENAME:
BRT-522-CRV205-211
CONTRACT No.:
AE 0055-17
DATE:
09/11/2020



SR 522 / NE 145TH BRT
SR 522 (BOTHELL WAY NE)
CIVIL
**DRIVEWAY PLAN AND PROFILES BRS243-S, BRS243 N-S
& BRS243-N**

DRAWING No.:
522-CRV209
FACILITY ID:
522
SHEET No.:
113 OF 283

09/10/20 | 1:15 AM | SJRO
C:\PW_WORK\DAE\STEVEN ROSE\DMIS06735\BRT-522-CRV205-211.DWG

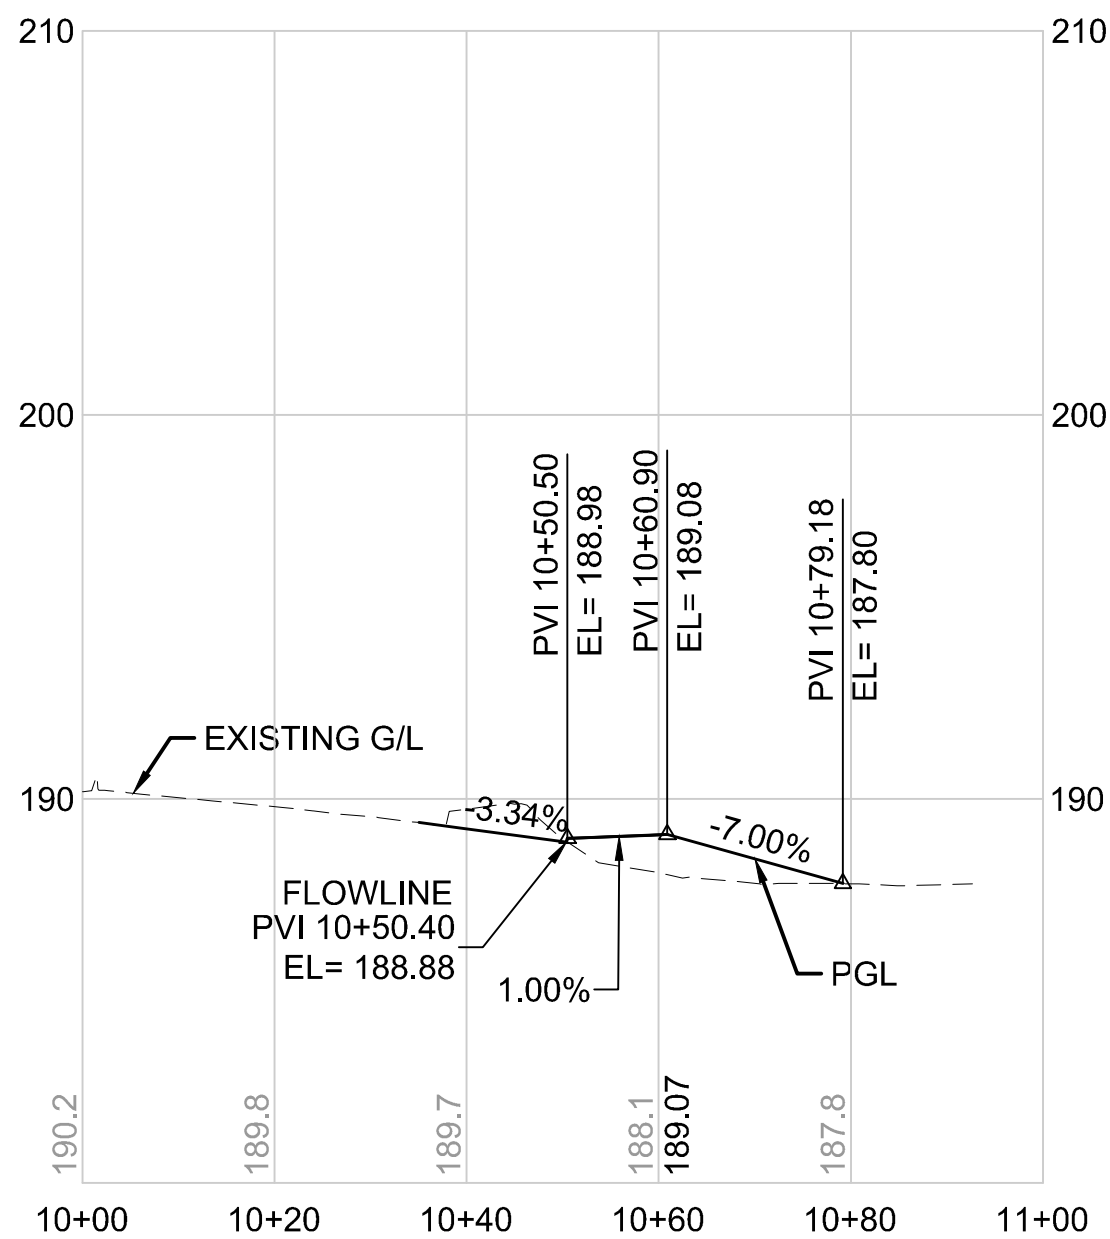

BRS246 LINE
HORIZONTAL SCALE: 1"=20'
VERTICAL SCALE: 1"=5'

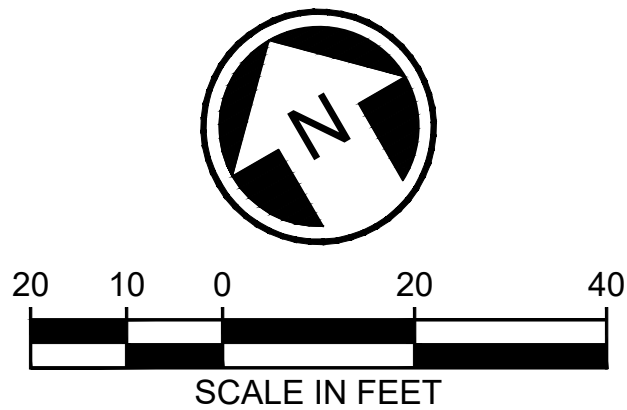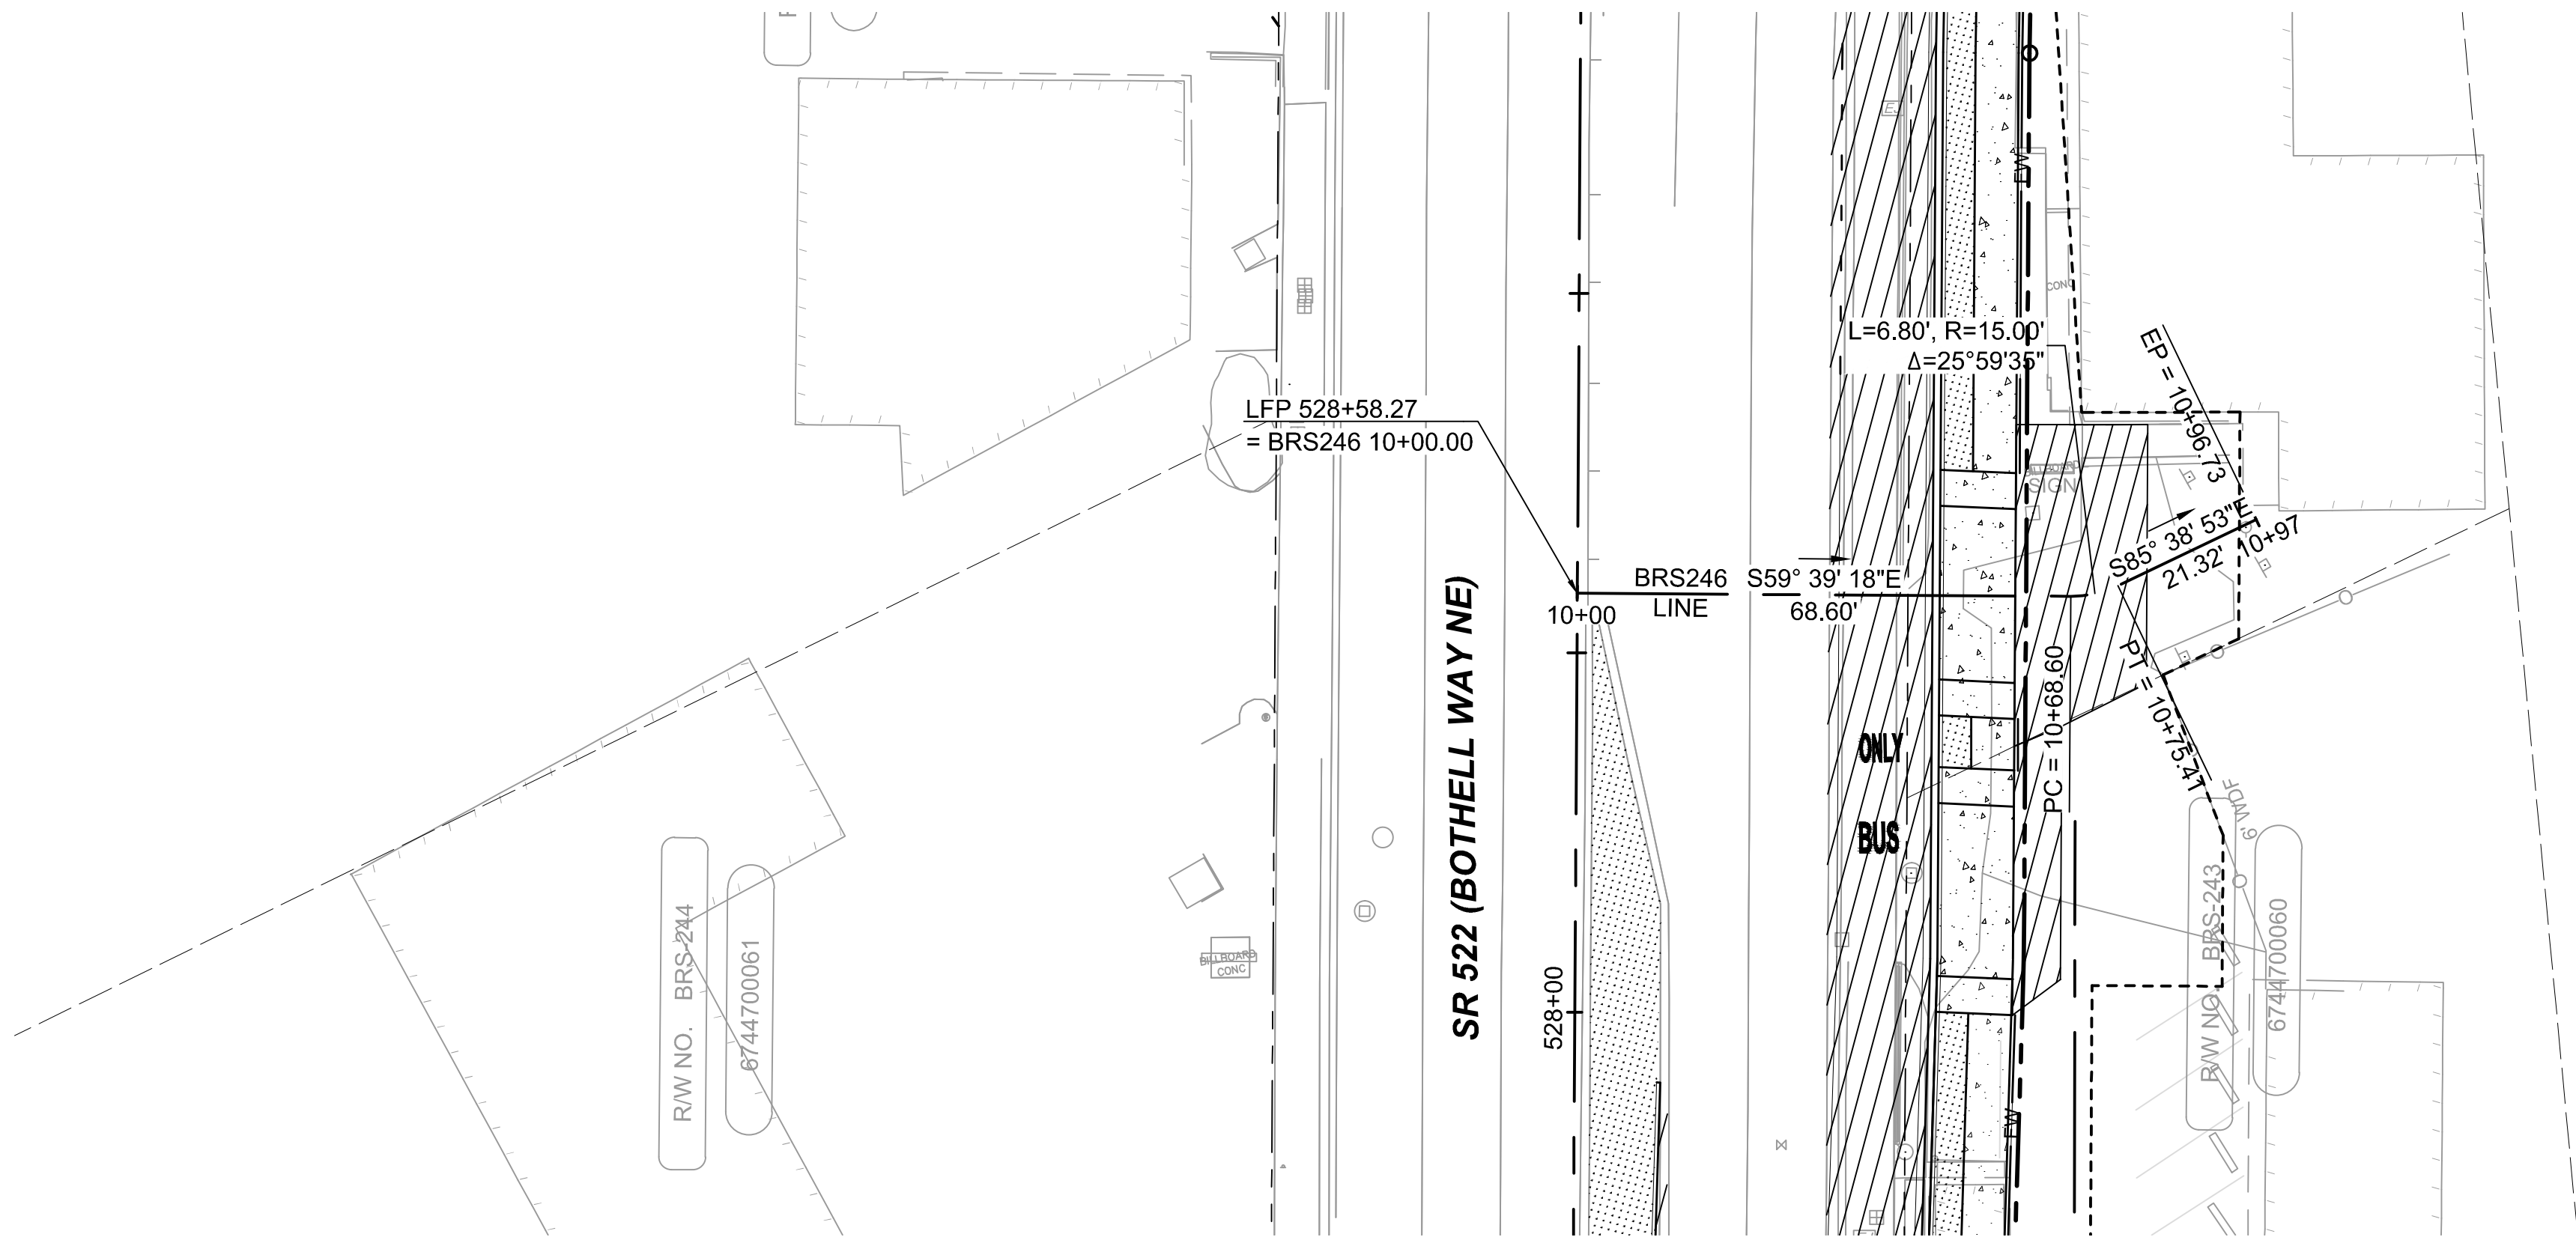

DRAFT 30% SUBMITTAL


No.	DATE	DSN	CHK	APP	REVISION

DESIGNED BY:	C.MATYAS
DRAWN BY:	C.BRESLEY
CHECKED BY:	R.KOESTER
APPROVED BY:	M.FELIBERTI



DAVID EVANS
AND ASSOCIATES INC.
14432 SE Eastgate Way, Suite 400
Bellevue Washington 98007
Phone: 425.519.6500

SUBMITTED BY:	DATE:	REVIEWED BY:	DATE:
D.SCHOCK	09/11/2020	B.KEMPER	09/11/2020



 


SOUNDTRANSIT

SCALE:	1"=20'
FILENAME:	BRT-522-CRV205-211
CONTRACT No.:	AE 0055-17
DATE:	09/11/2020

SR 522 / NE 145TH BRT
SR 522 (BOTHELL WAY NE)
CIVIL
DRIVEWAY PLAN AND PROFILE BRS246
STA. 10+00 TO STA. 10+96.73


DRAWING No.:	522-CRV210
FACILITY ID:	522
SHEET No.:	114 OF 283
REV:	

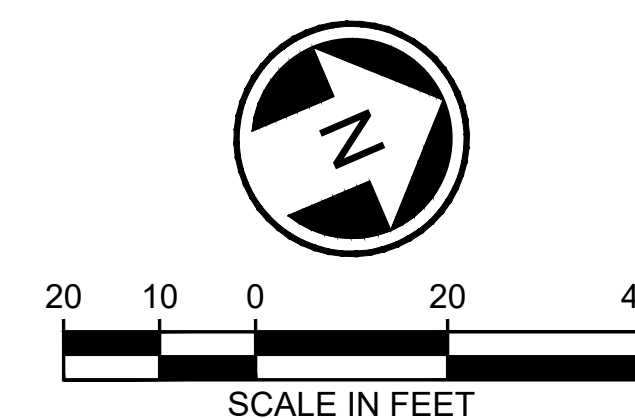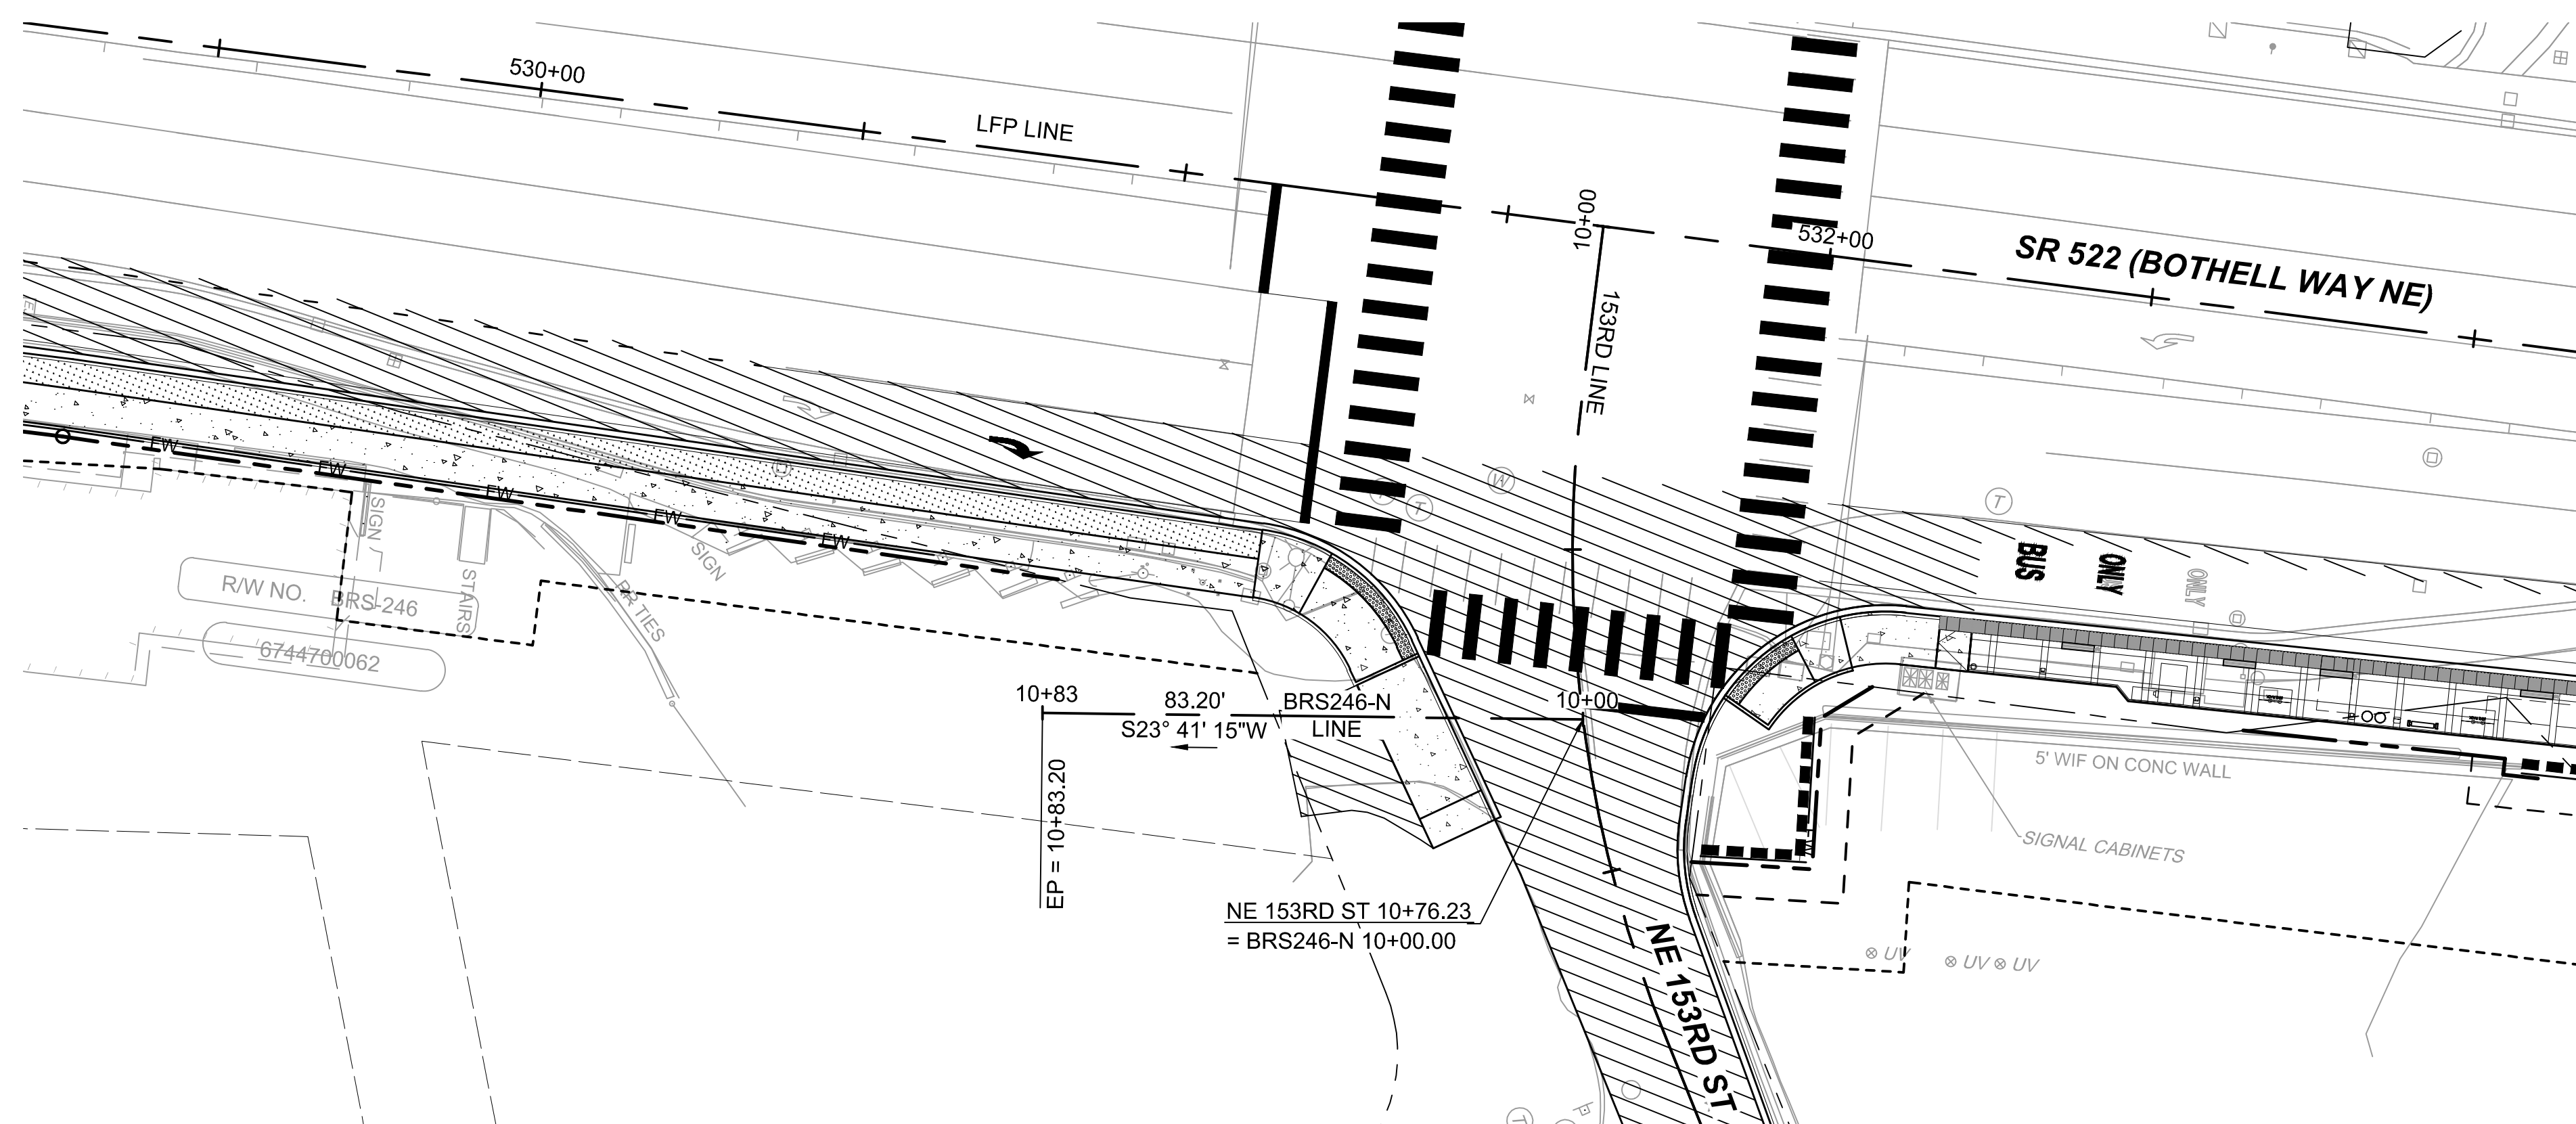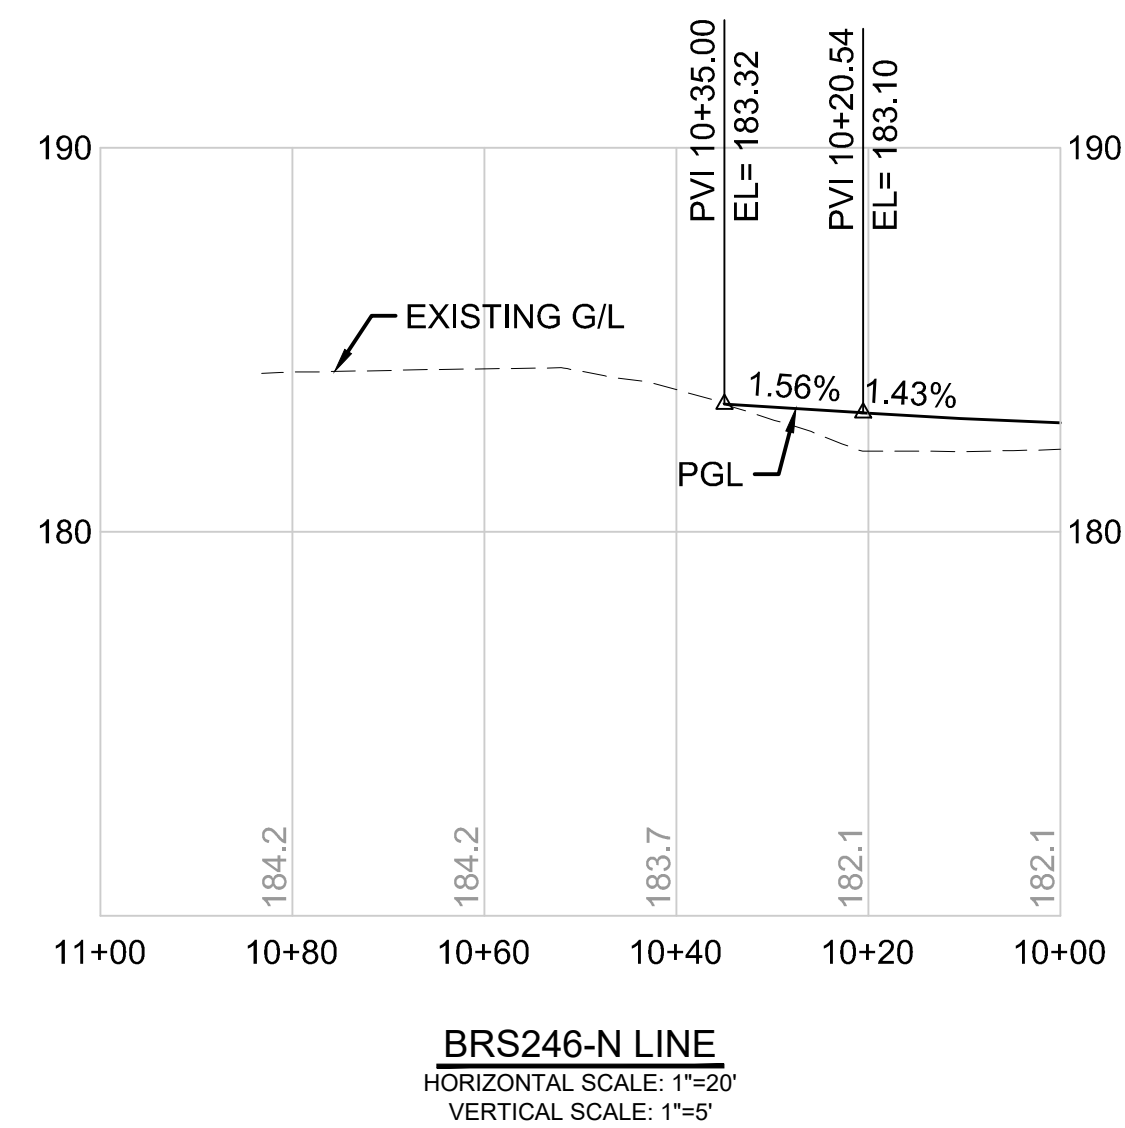

DRAFT 30% SUBMITTAL

No.	DATE	DSN	CHK	APP	REVISION

DESIGNED BY:	C.MATYAS
DRAWN BY:	C.BRESLEY
CHECKED BY:	R.KOESTER
APPROVED BY:	M.FELIBERTI

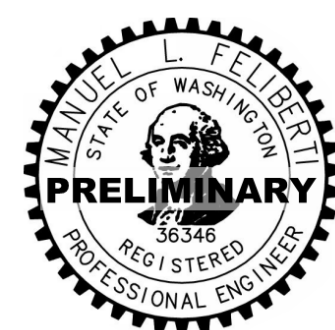

**DAVID EVANS
AND ASSOCIATES INC.**
14432 SE Eastgate Way, Suite 400
Bellevue Washington 98007
Phone: 425.519.6500

LINE IS 1" AT



SCALE:	1"=20'
FILENAME:	BRT-522-CRV205-211
CONTRACT No.:	AE 0055-17
DATE:	09/11/2020

SR 522 / NE 145TH BRT




SR 522 (BOTHHELL WAY NE)

CIVIL

DRIVEWAY PLAN AND PROFILE BRS246-N

STA. 10+00 TO STA. 10+83.20

DRAWING No.:	
522-CRV211	
FACILITY ID:	
522	
SHEET No.:	REV
115 OF 283	

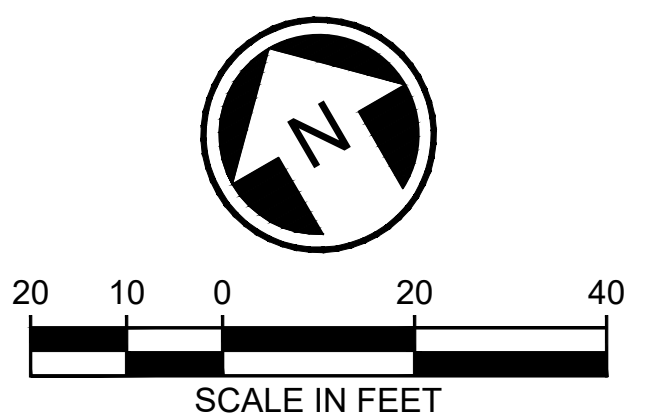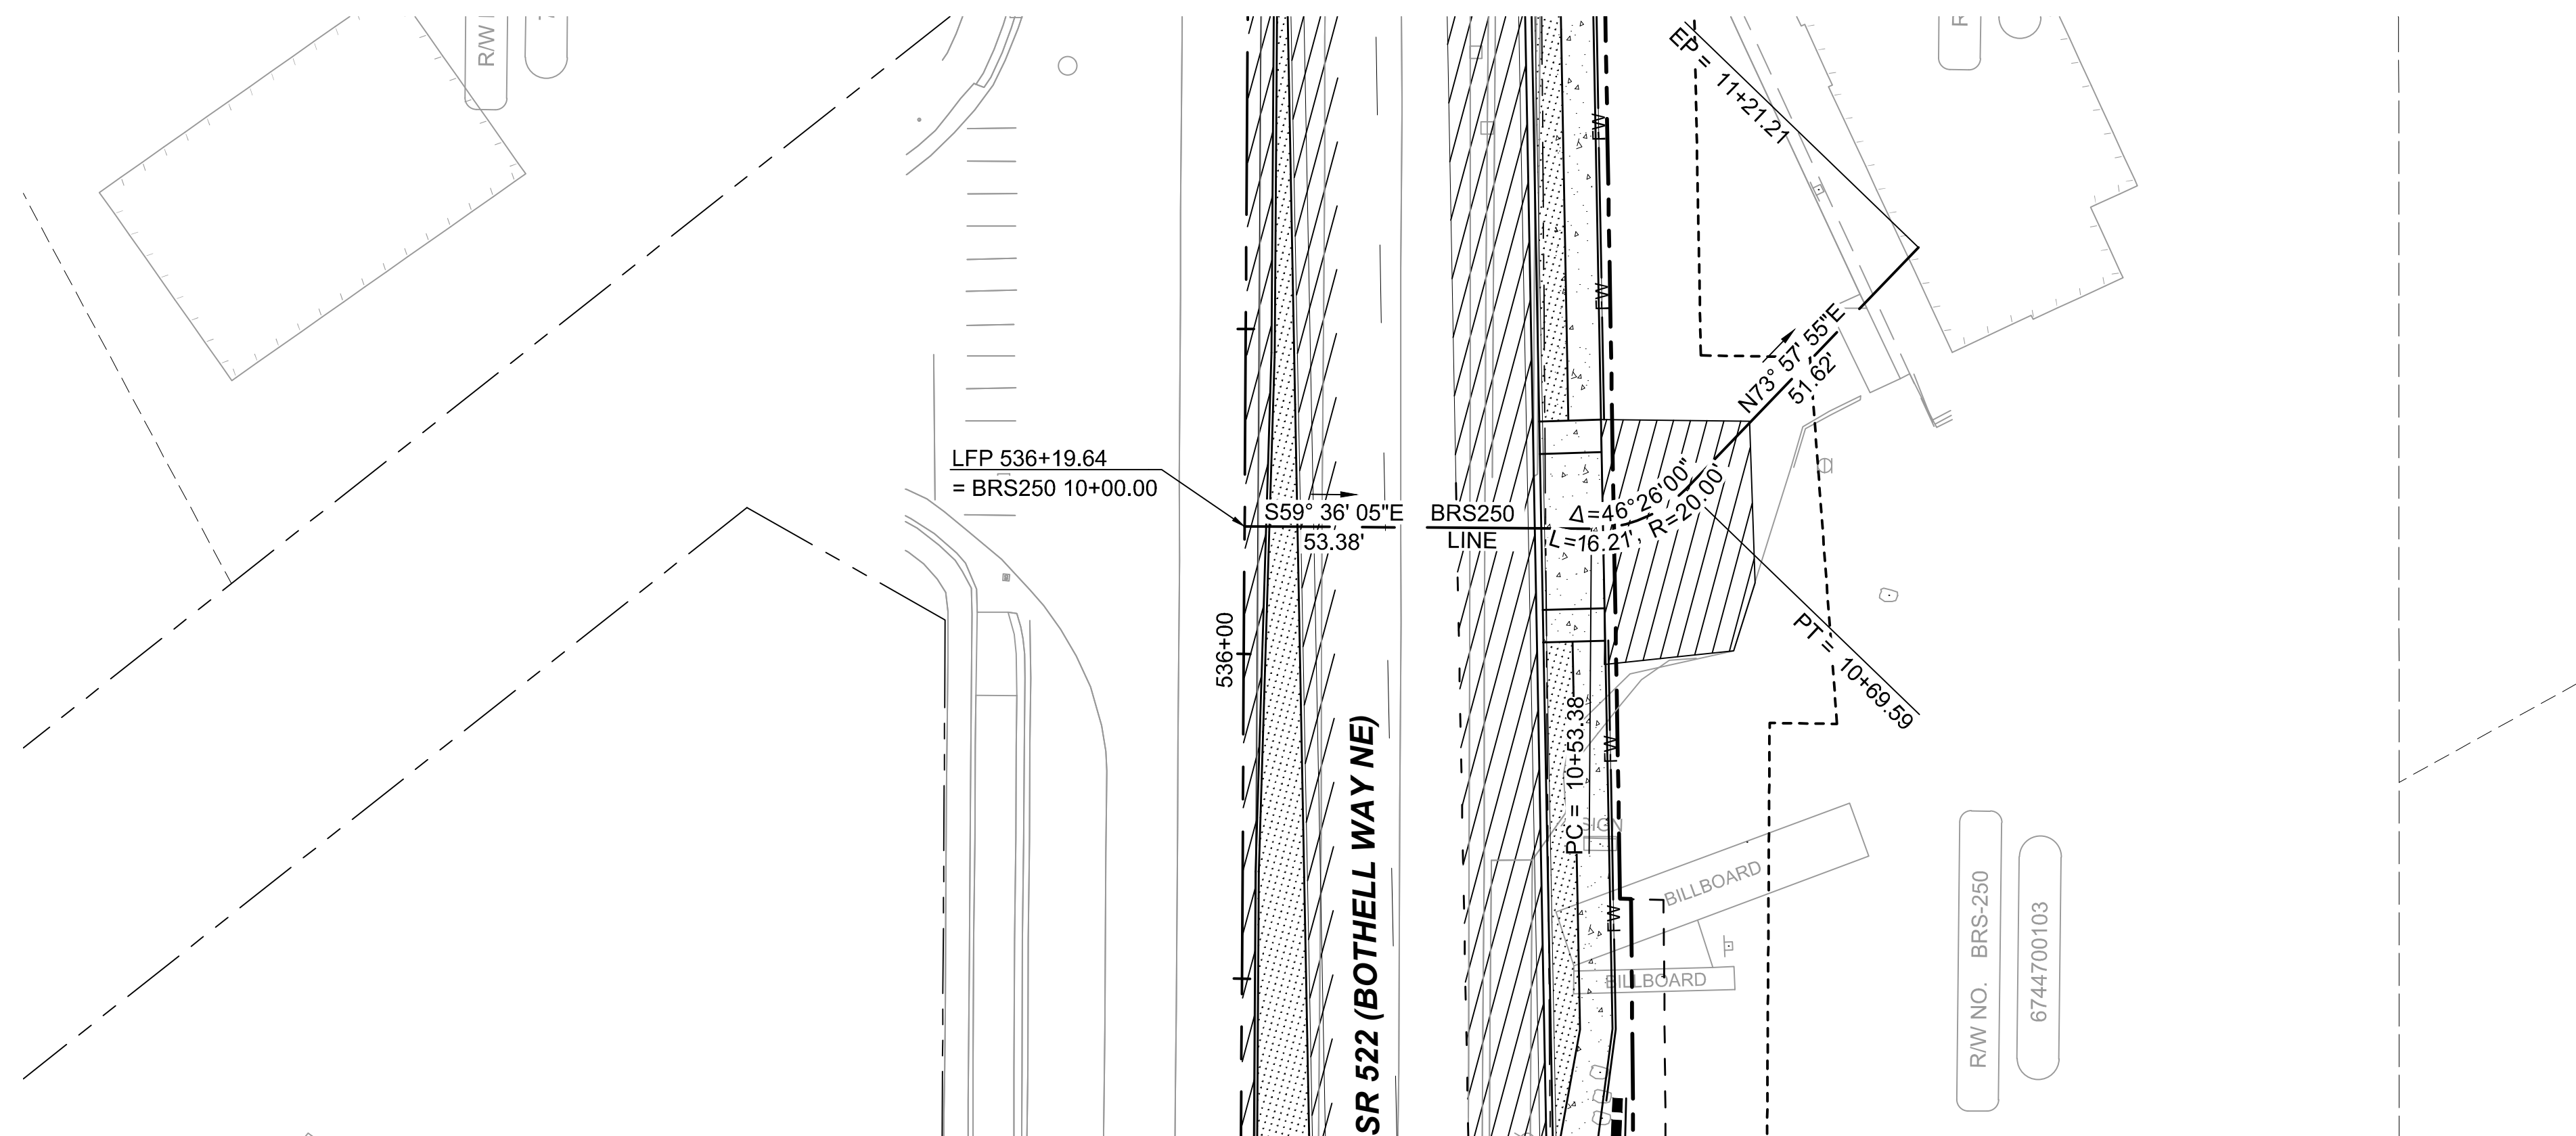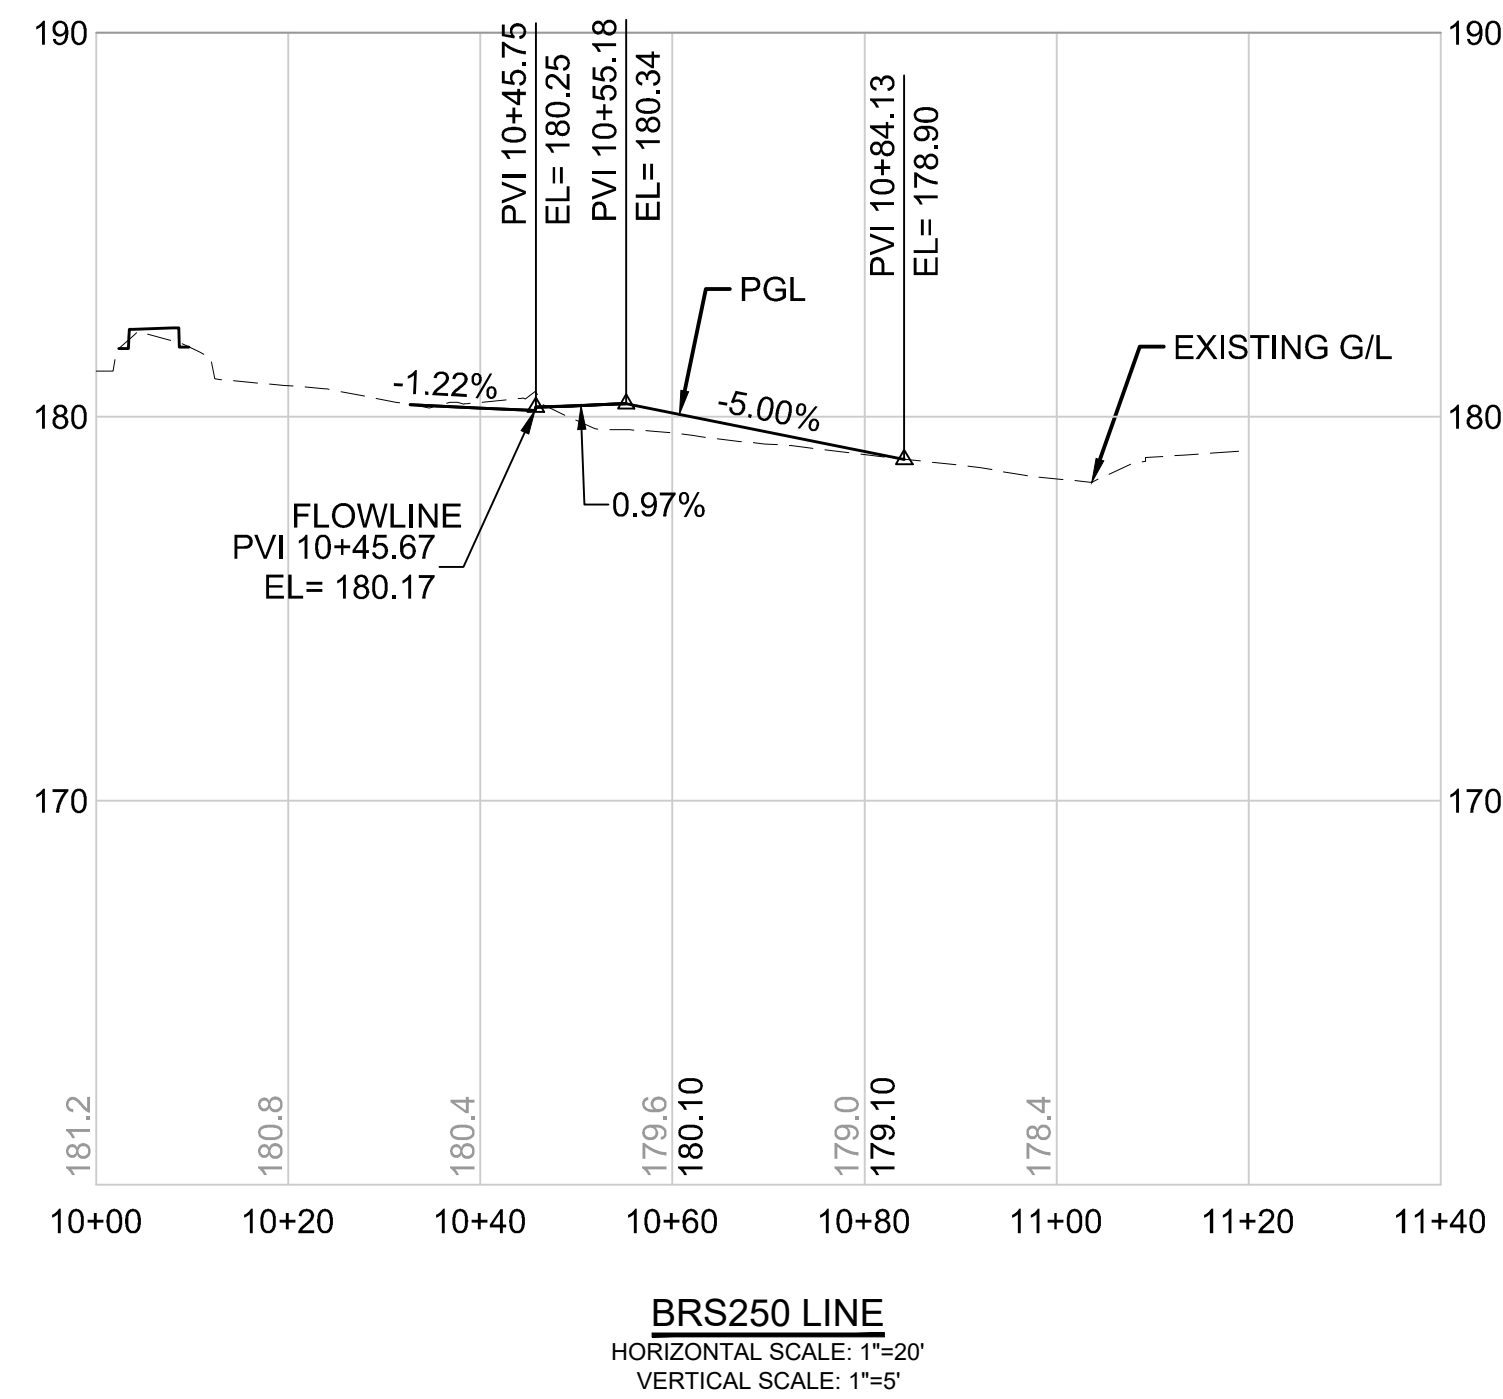

DRAFT 30% SUBMITTAL

No.	DATE	DSN	CHK	APP	REVISION

DESIGNED BY:	C.MATYAS
DRAWN BY:	C.BRESLEY
CHECKED BY:	R.KOESTER
APPROVED BY:	M.FELIBERTI



**DAVID EVANS
AND ASSOCIATES INC.**
14432 SE Eastgate Way, Suite 400
Bellevue Washington 98007
Phone: 425.519.6500

SUBMITTED BY
D.SCHOCK

DATE:	09/11/2020
-------	------------

REVIEWED BY	
B.KEMPER	

DATE:	09/11/2020
-------	------------

SCALE:	1"=20'
FILENAME:	BRT-522-CRV212-226
CONTRACT No.:	AE 0055-17
DATE:	09/11/2020

SR 522 / NE 145TH BRT

SR 522 (BOTHELL WAY NE)




CIVIL

DRIVEWAY PLAN AND PROFILE BRS250

STA. 10+00 TO STA. 11+21.21

DRAWING No.:	
522-CRV212	
FACILITY ID:	
522	
SHEET No.:	REV:
116 OF 283	

09/10/20 | 1:22 AM | SJRO
C:\PW_WORK\DAVIDEVANS\ROSE\DWG\BRT-522-CRV212-226.DWG

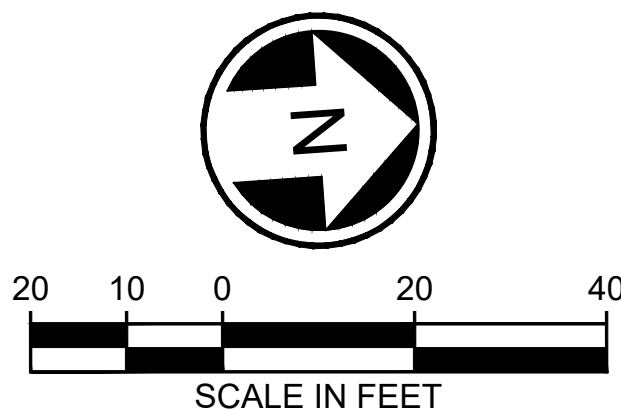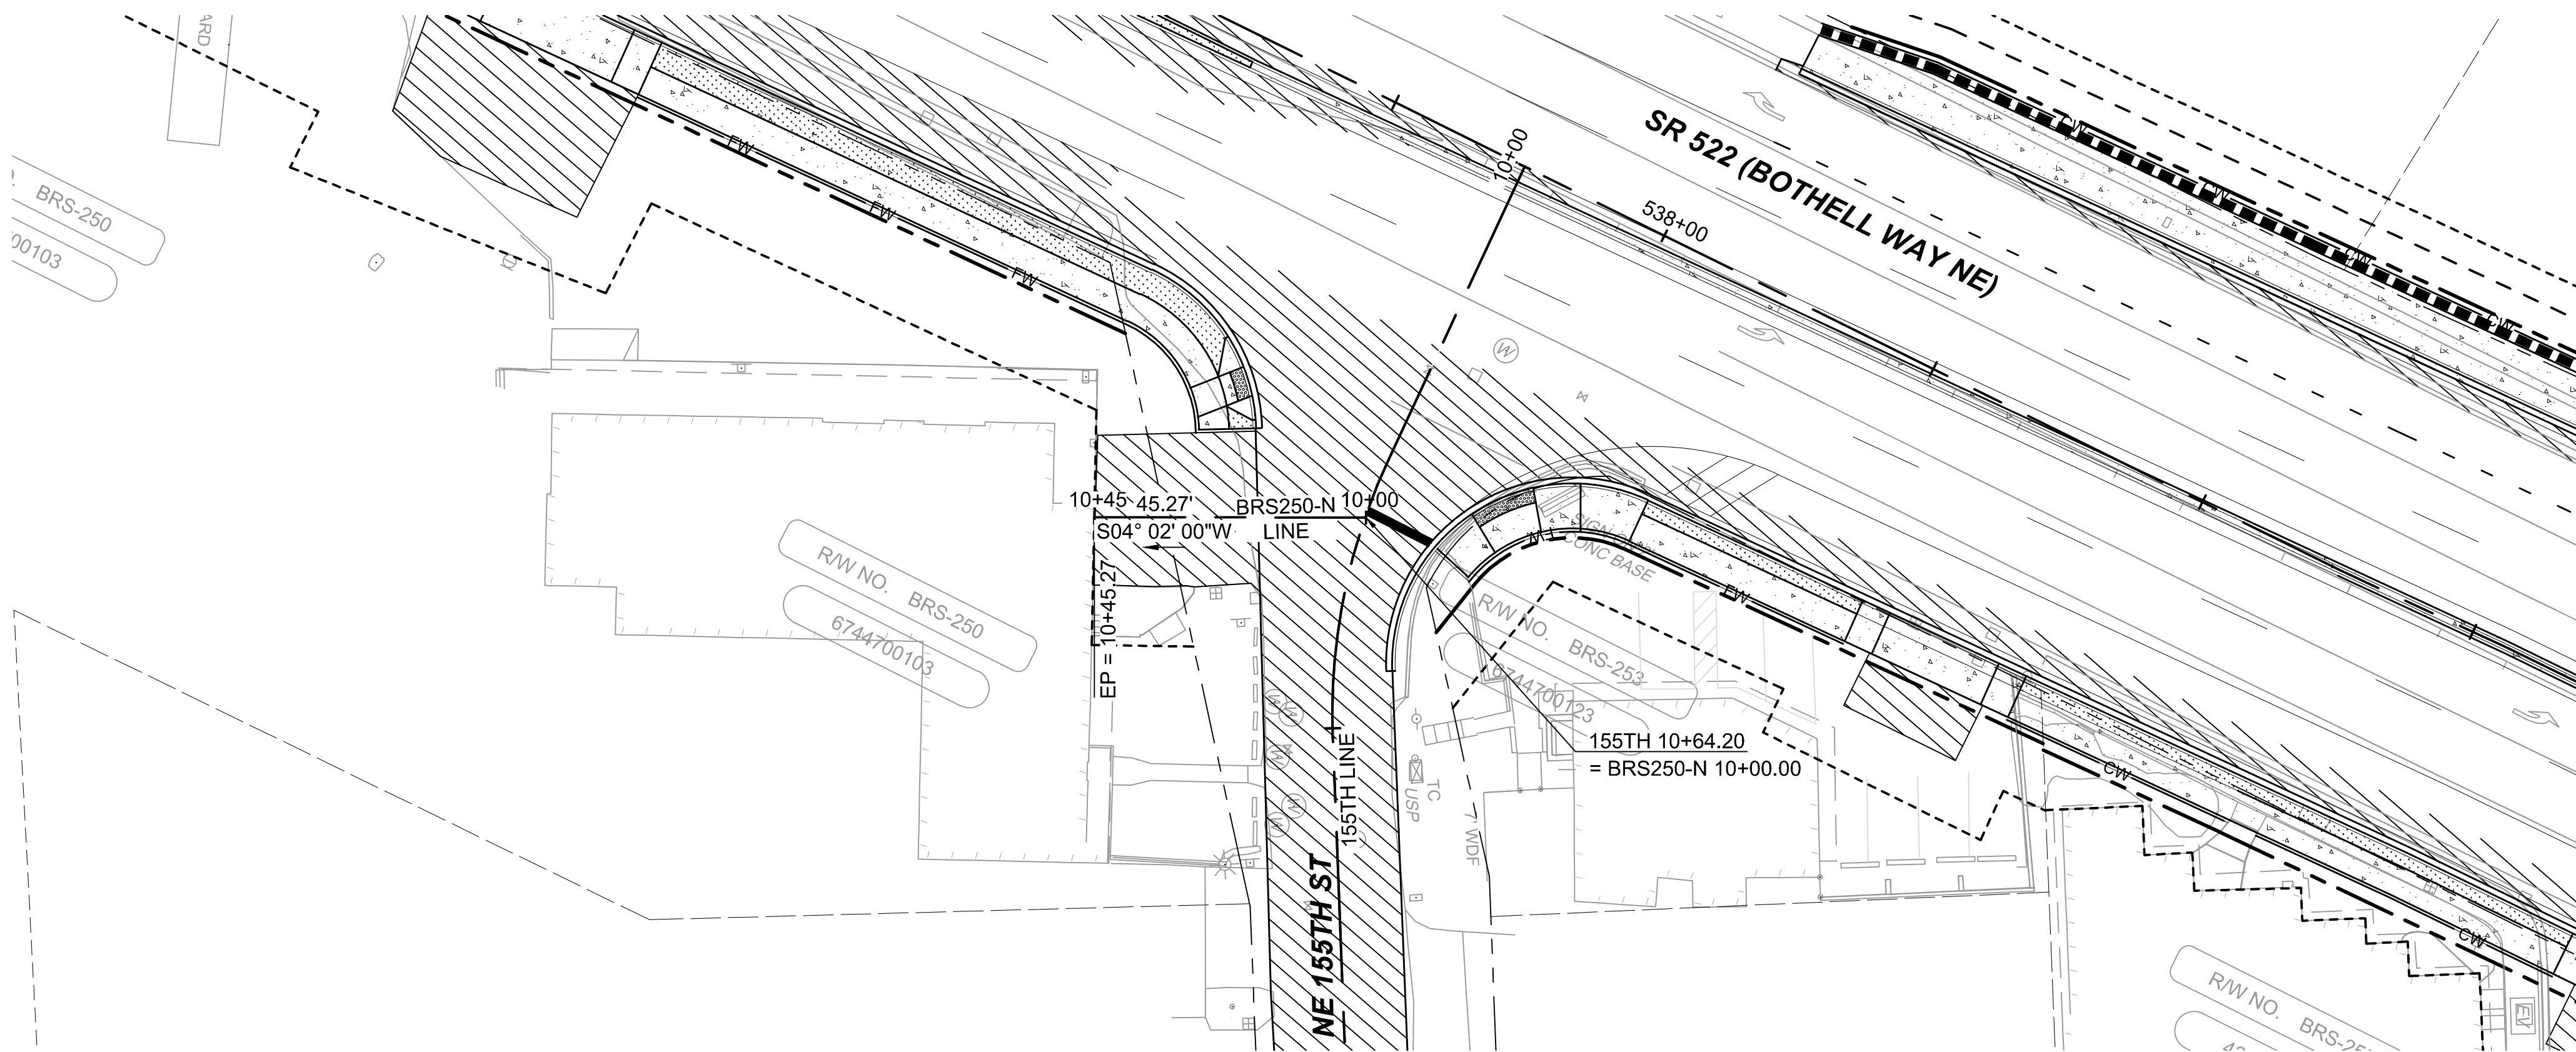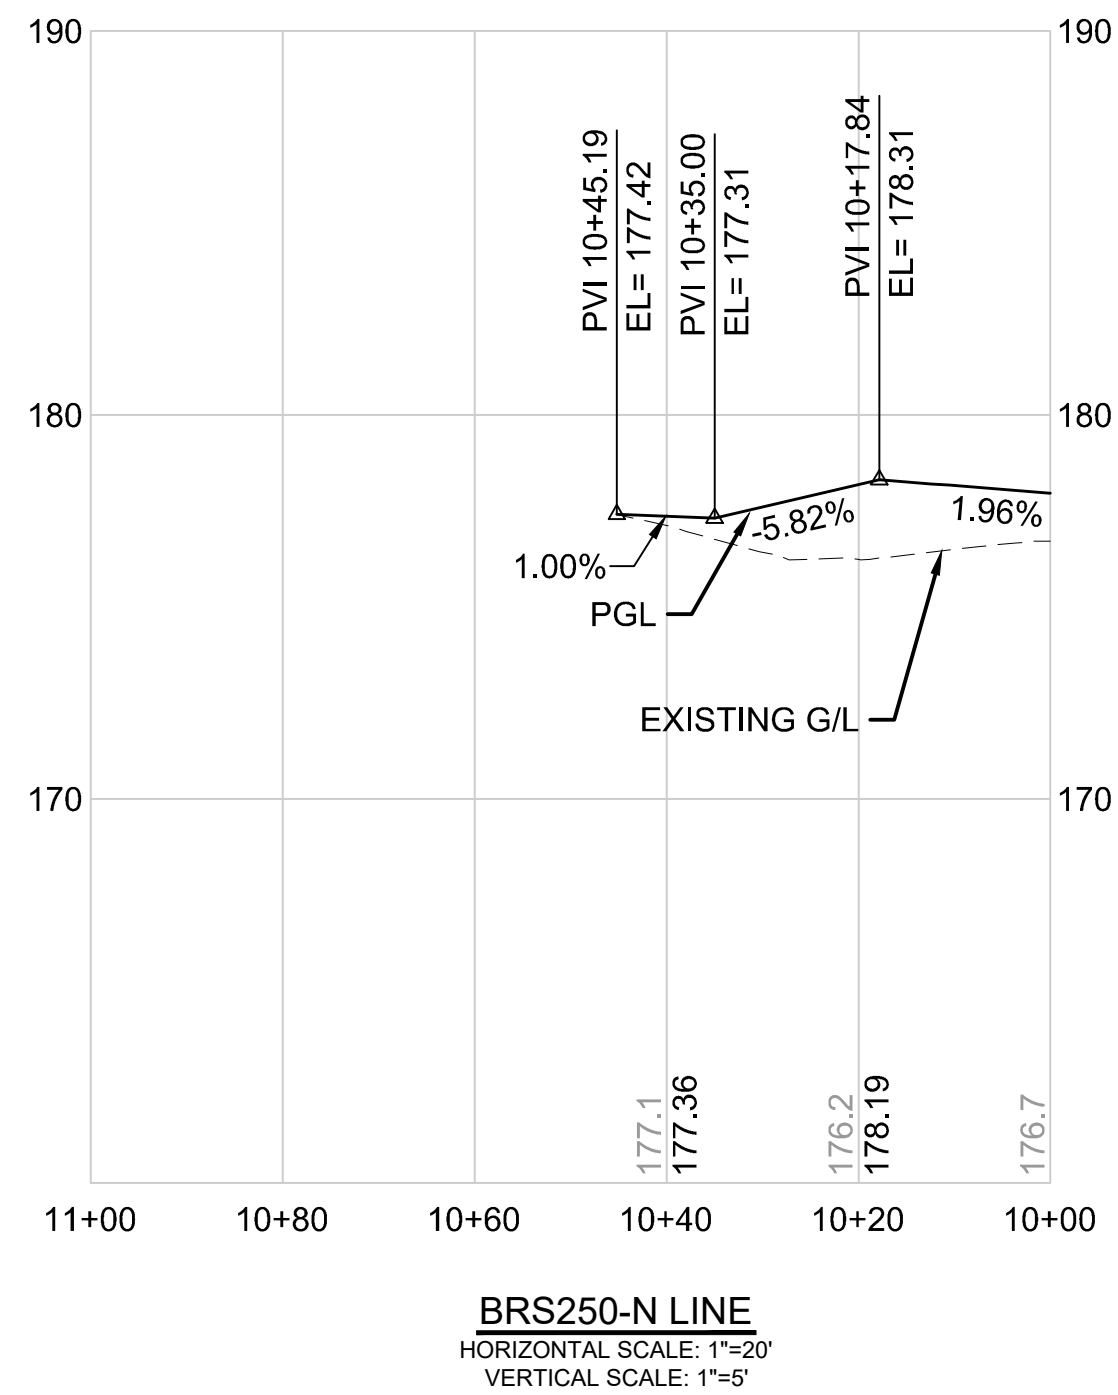

DRAFT 30% SUBMITTAL


No.	DATE	DSN	CHK	APP	REVISION

DESIGNED BY:	C.MATYAS
DRAWN BY:	C.BRESLEY
CHECKED BY:	R.KOESTER
APPROVED BY:	M.FELIBERTI



**DAVID EVANS
AND ASSOCIATES INC.**
14432 SE Eastgate Way, Suite 400
Bellevue Washington 98007
Phone: 425.519.6500


SUBMITTED BY:	DATE:	REVIEWED BY:	DATE:
D.SCHOCK	09/11/2020	B.KEMPER	09/11/2020

 

SCALE:	1"=20'
FILENAME:	BRT-522-CRV212-226
CONTRACT No.:	AE 0055-17
DATE:	09/11/2020

SR 522 / NE 145TH BRT
SR 522 (BOTHELL WAY NE)
CIVIL
DRIVEWAY PLAN AND PROFILE BRS250-N
STA. 10+00 TO STA. 10+45.27

DRAWING No.:	522-CRV213
FACILITY ID:	522
SHEET No.:	117 OF 283
REV:	

 

DRAFT 30% SUBMITTAL

No.	DATE	DSN	CHK	APP	REVISION
-----	------	-----	-----	-----	----------

DESIGNED BY:	C.MATYAS
DRAWN BY:	C.BRESLEY
CHECKED BY:	R.KOESTER
APPROVED BY:	M.FELIBERT



**DAVID EVANS
AND ASSOCIATES INC.**
14432 SE Eastgate Way, Suite 400
Bellevue Washington 98007
Phone: 425.519.6500

LINE IS 1" AT FULL SCALE

**SOUNDTRANSIT**

SCALE:	1"=20'
FILENAME:	BRT-522-CRV212-226
CONTRACT No.:	AE 0055-17
DATE:	09/11/2020


SR 522 / NE 145TH BRT

SR 522 (BOTHELL WAY NE)



CIVIL
DRIVEWAY PLAN AND PROFILE BRS253
STA. 10+00 TO STA. 10+85.00

DRAWING No.:	
522-CRV214	
FACILITY ID:	
522	
SHEET No.:	REV
118 OF 283	

09/10/20 | 1:24 AM | SJRO
C:\PW_WORK\DEA\STEVEN ROSE\DWG\BRT-522-CRV212-226.DWG

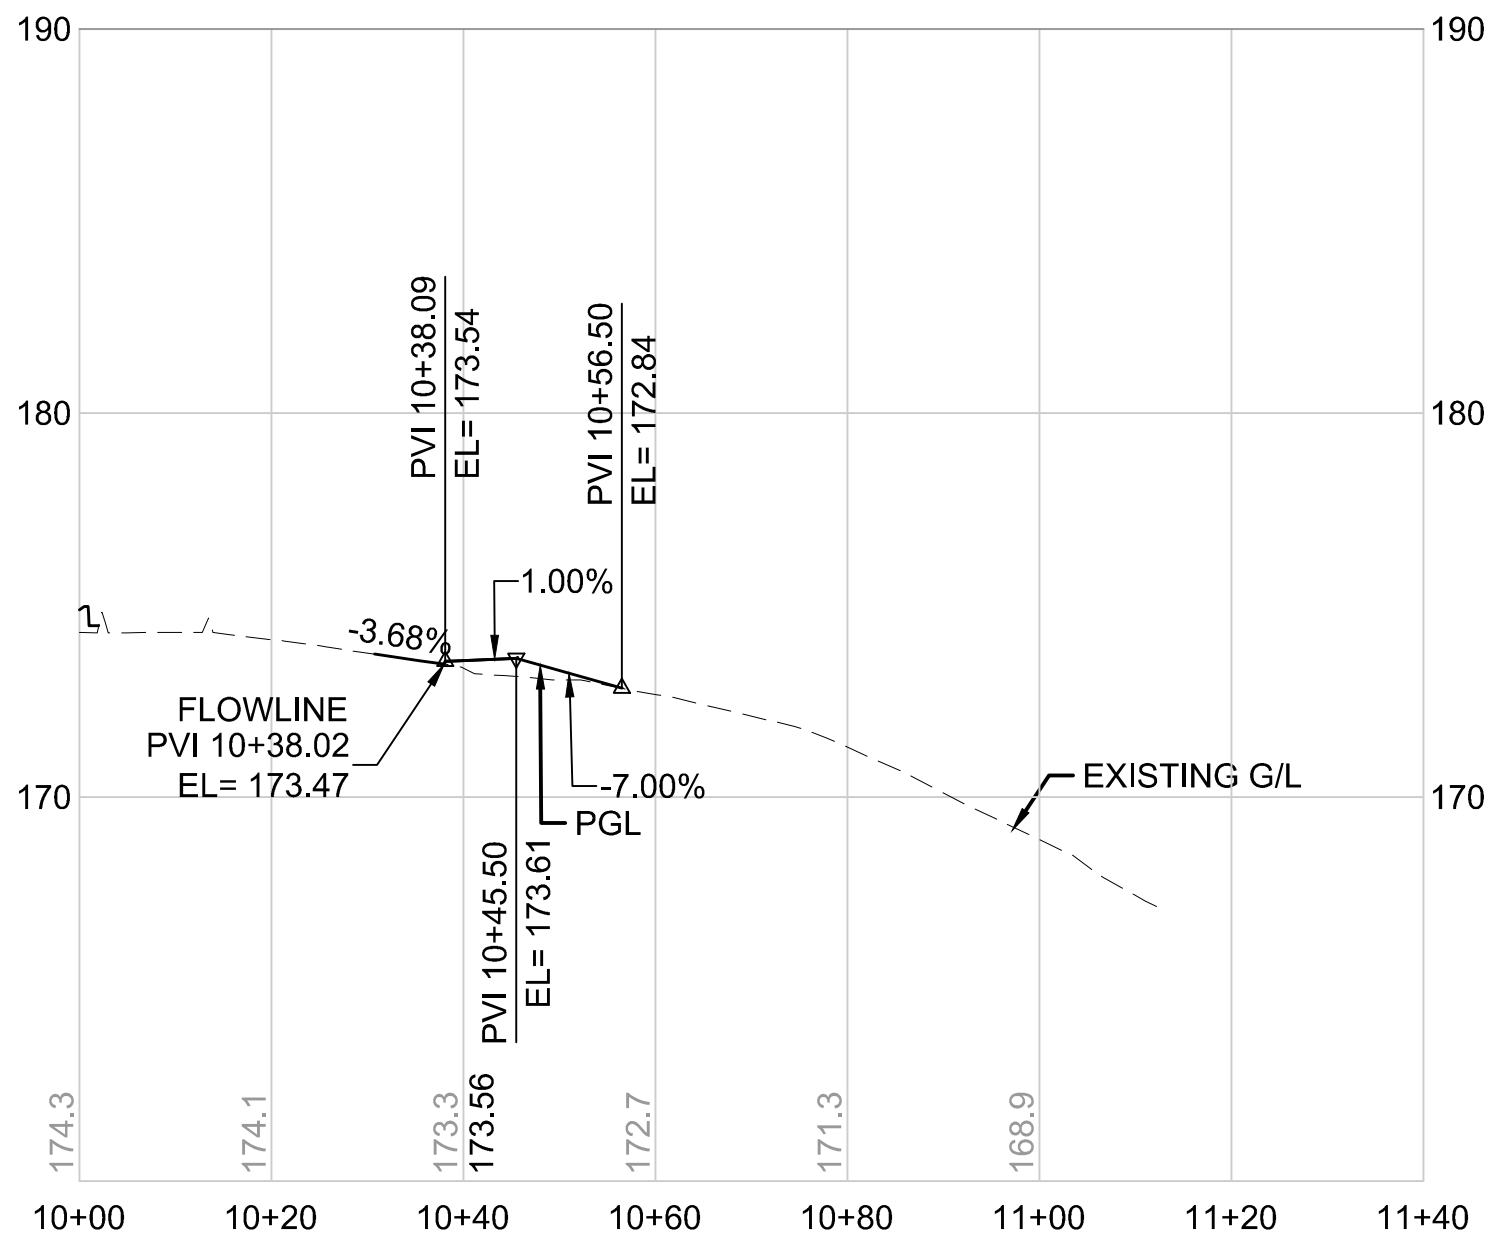

BRS255-256 LINE
HORIZONTAL SCALE: 1"=20'
VERTICAL SCALE: 1"=5'

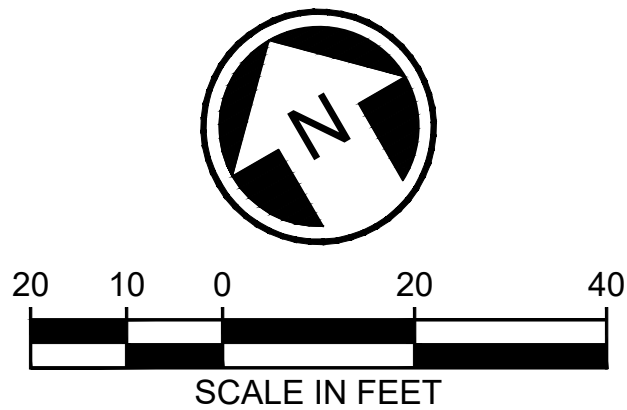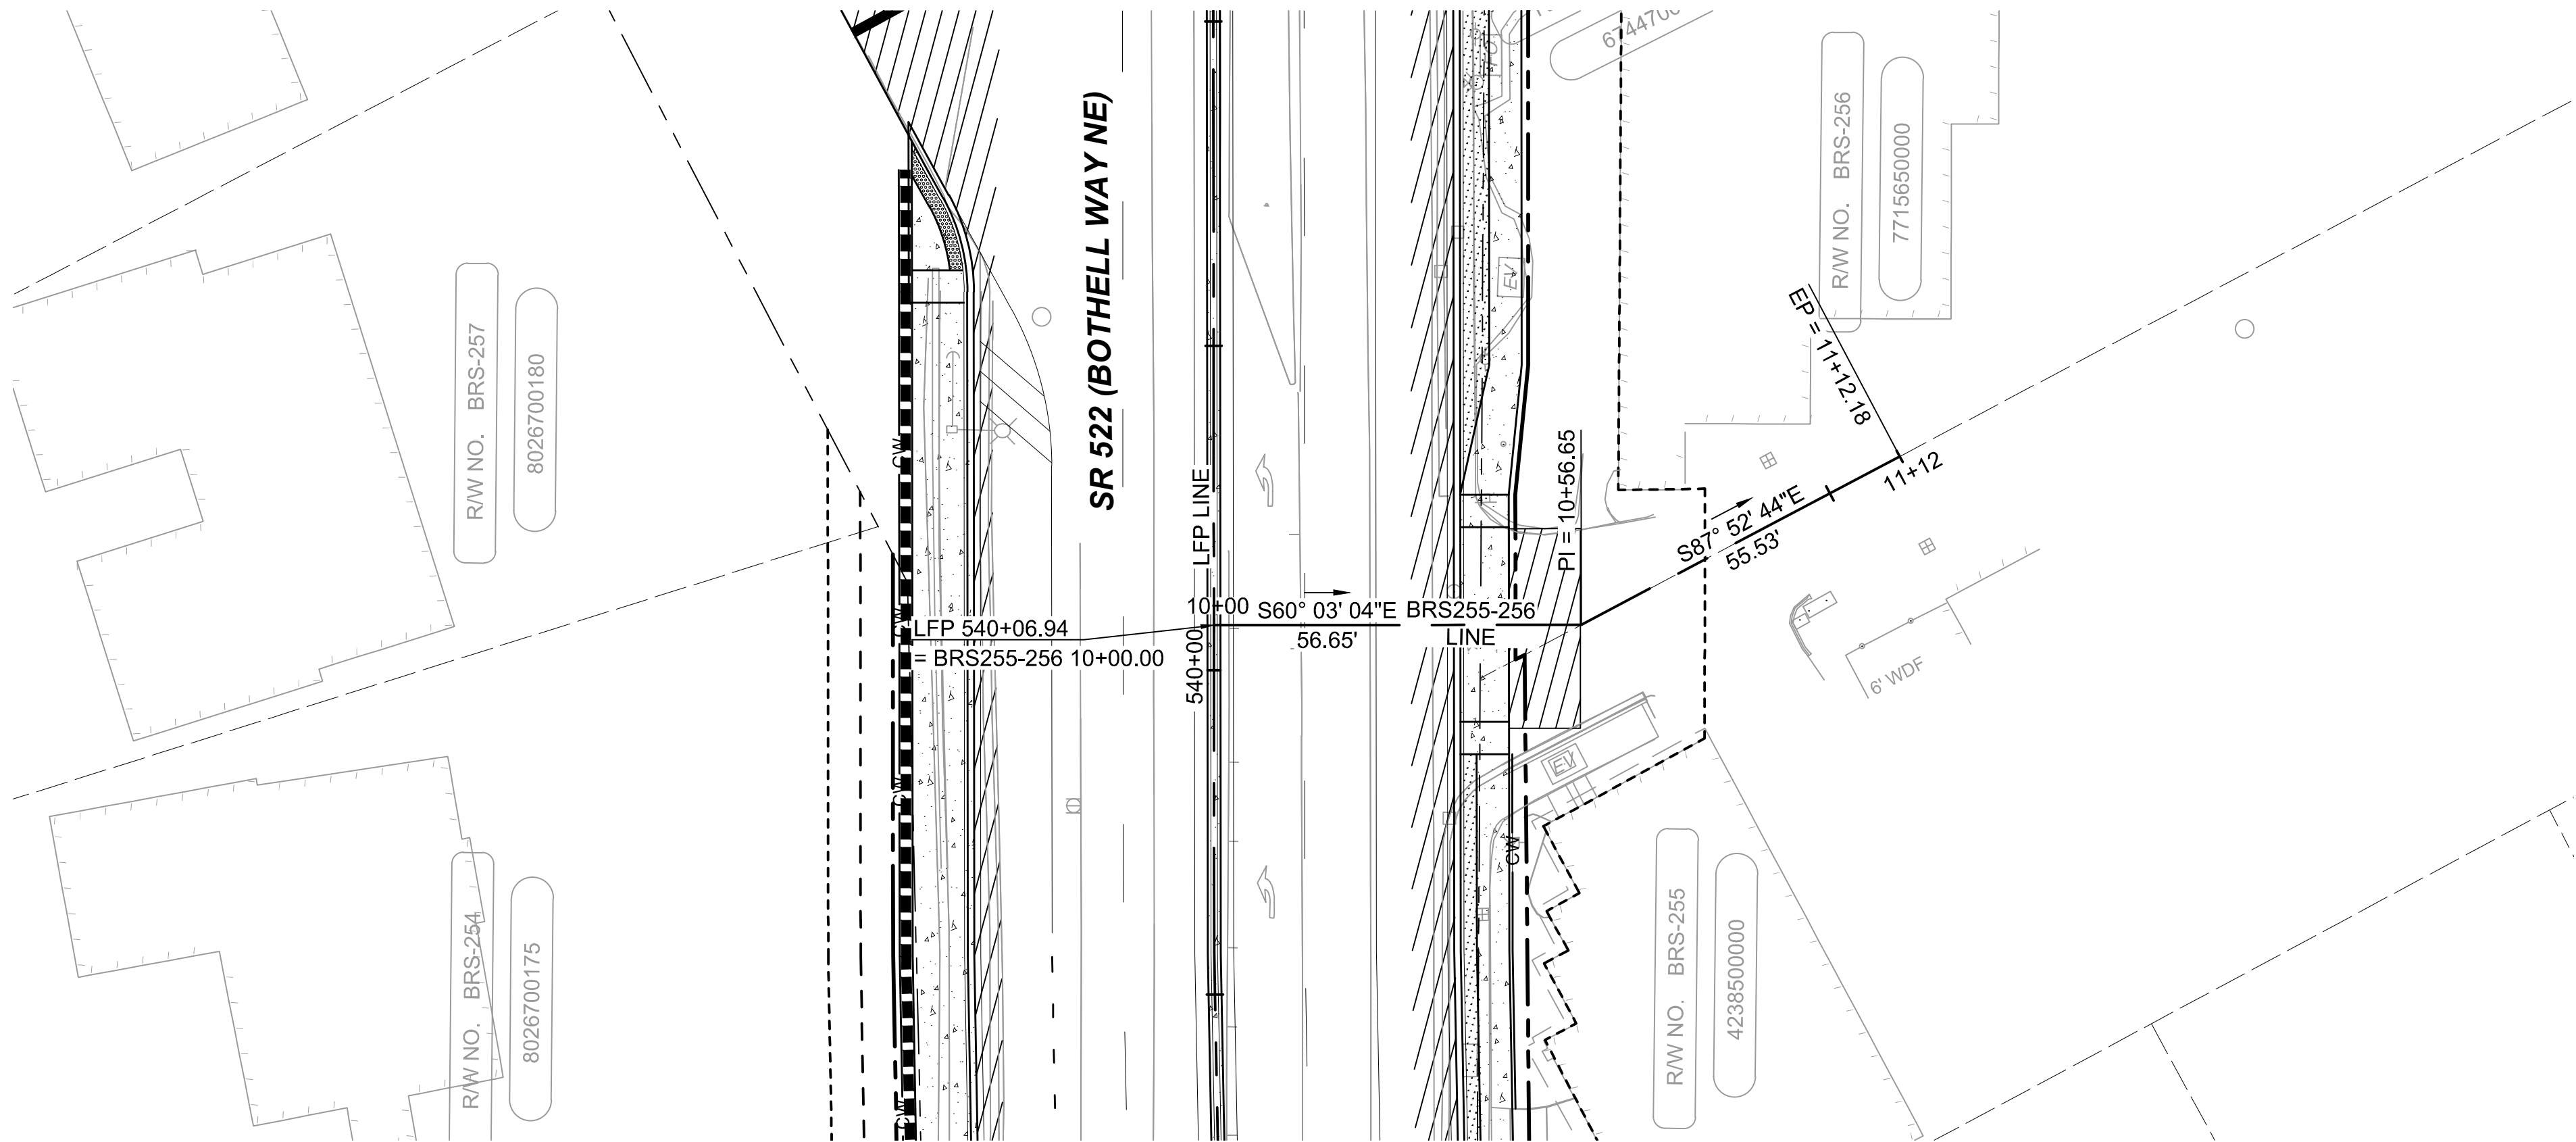


DRAFT 30% SUBMITTAL

No.	DATE	DSN	CHK	APP	REVISION

DESIGNED BY:
C.MATYAS
DRAWN BY:
C.BRESLEY
CHECKED BY:
R.KOESTER
APPROVED BY:
M.FELIBERTI



 DAVID EVANS
AND ASSOCIATES INC.
14432 SE Eastgate Way, Suite 400
Bellevue Washington 98007
Phone: 425.519.6500



SOUNDTRANSIT

SUBMITTED BY:
D.SCHOCK

DATE:
09/11/2020

REVIEWED BY:
B.KEMPER


DATE:
09/11/2020

SCALE:
1"=20'
FILENAME:
BRT-522-CRV212-226
CONTRACT No.:
AE 0055-17
DATE:
09/11/2020


SR 522 / NE 145TH BRT
SR 522 (BOTHELL WAY NE)
CIVIL
DRIVEWAY PLAN AND PROFILE BRS255-256
STA. 10+00 TO STA. 11+12.18

DRAWING No.:
522-CRV215
FACILITY ID:
522
SHEET No.:
119 OF 283
REV:


09/10/20 | 1:25 AM | SJRO
C:\PW_WORK\DEA\STEVEN ROSE\DWG\BRT-522-CRV212-226.DWG

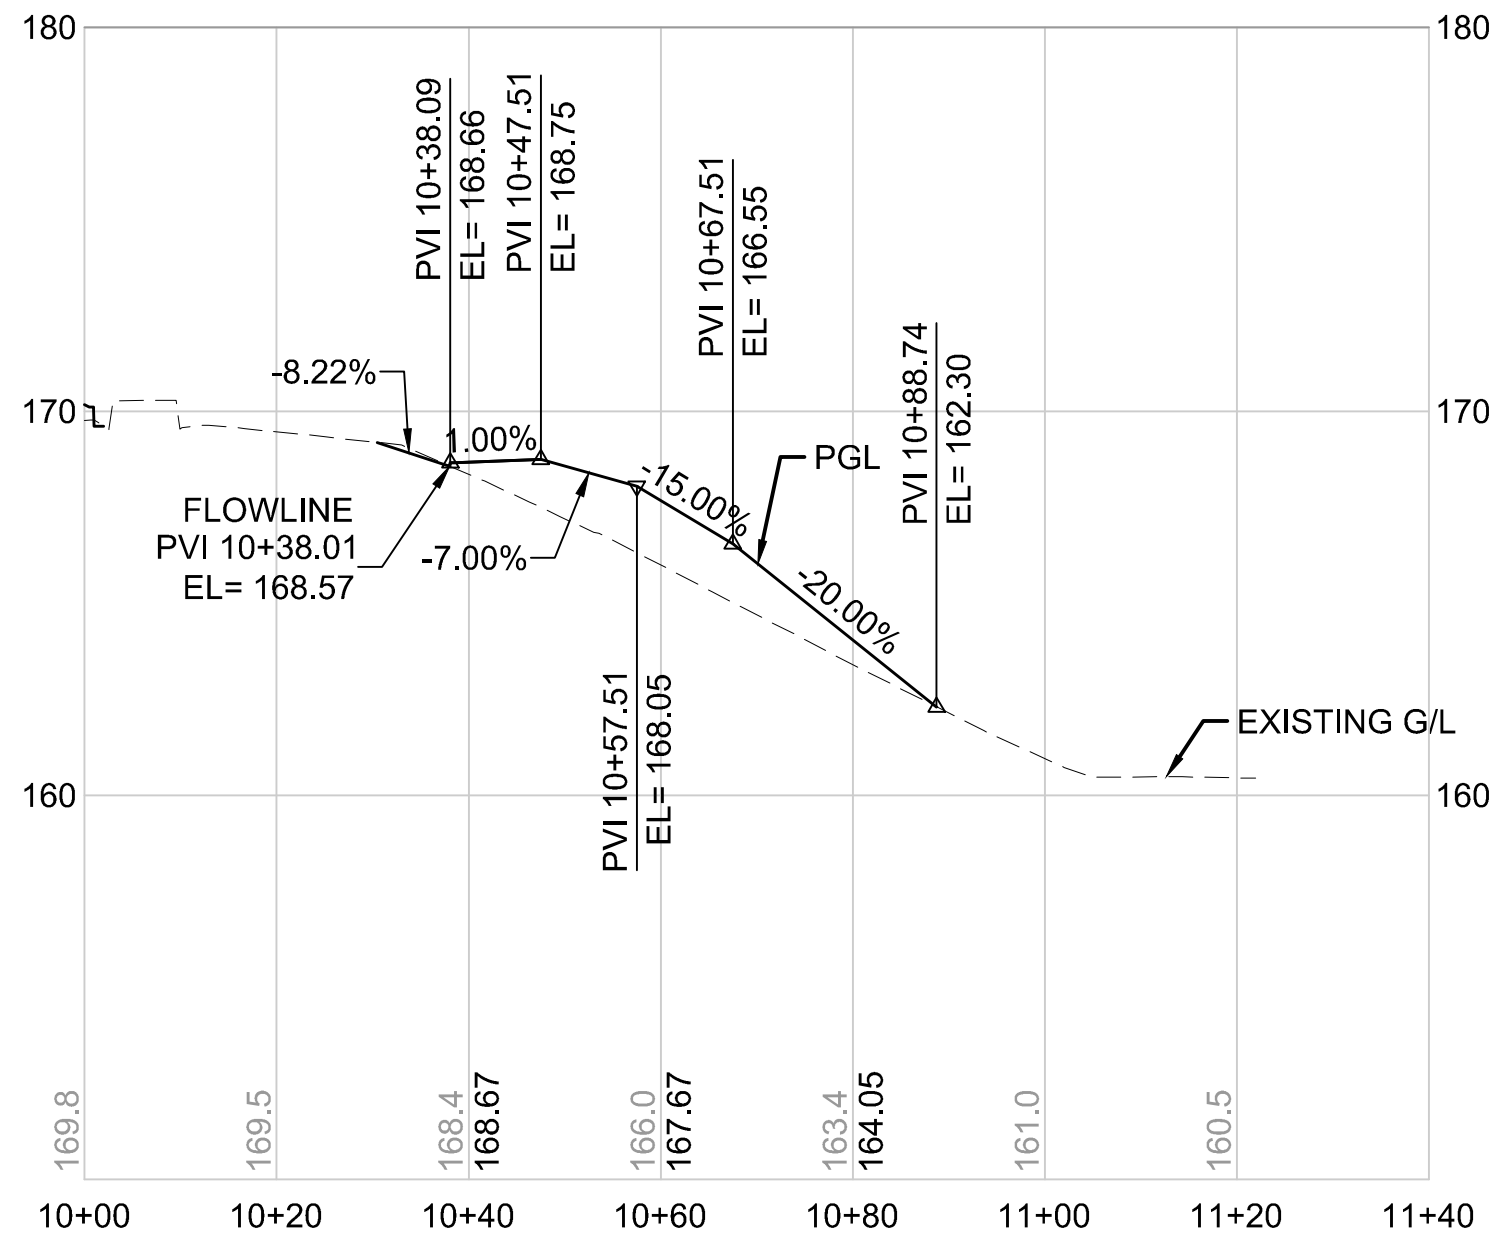



BRS258-S LINE
HORIZONTAL SCALE: 1"=20'
VERTICAL SCALE: 1"=5'

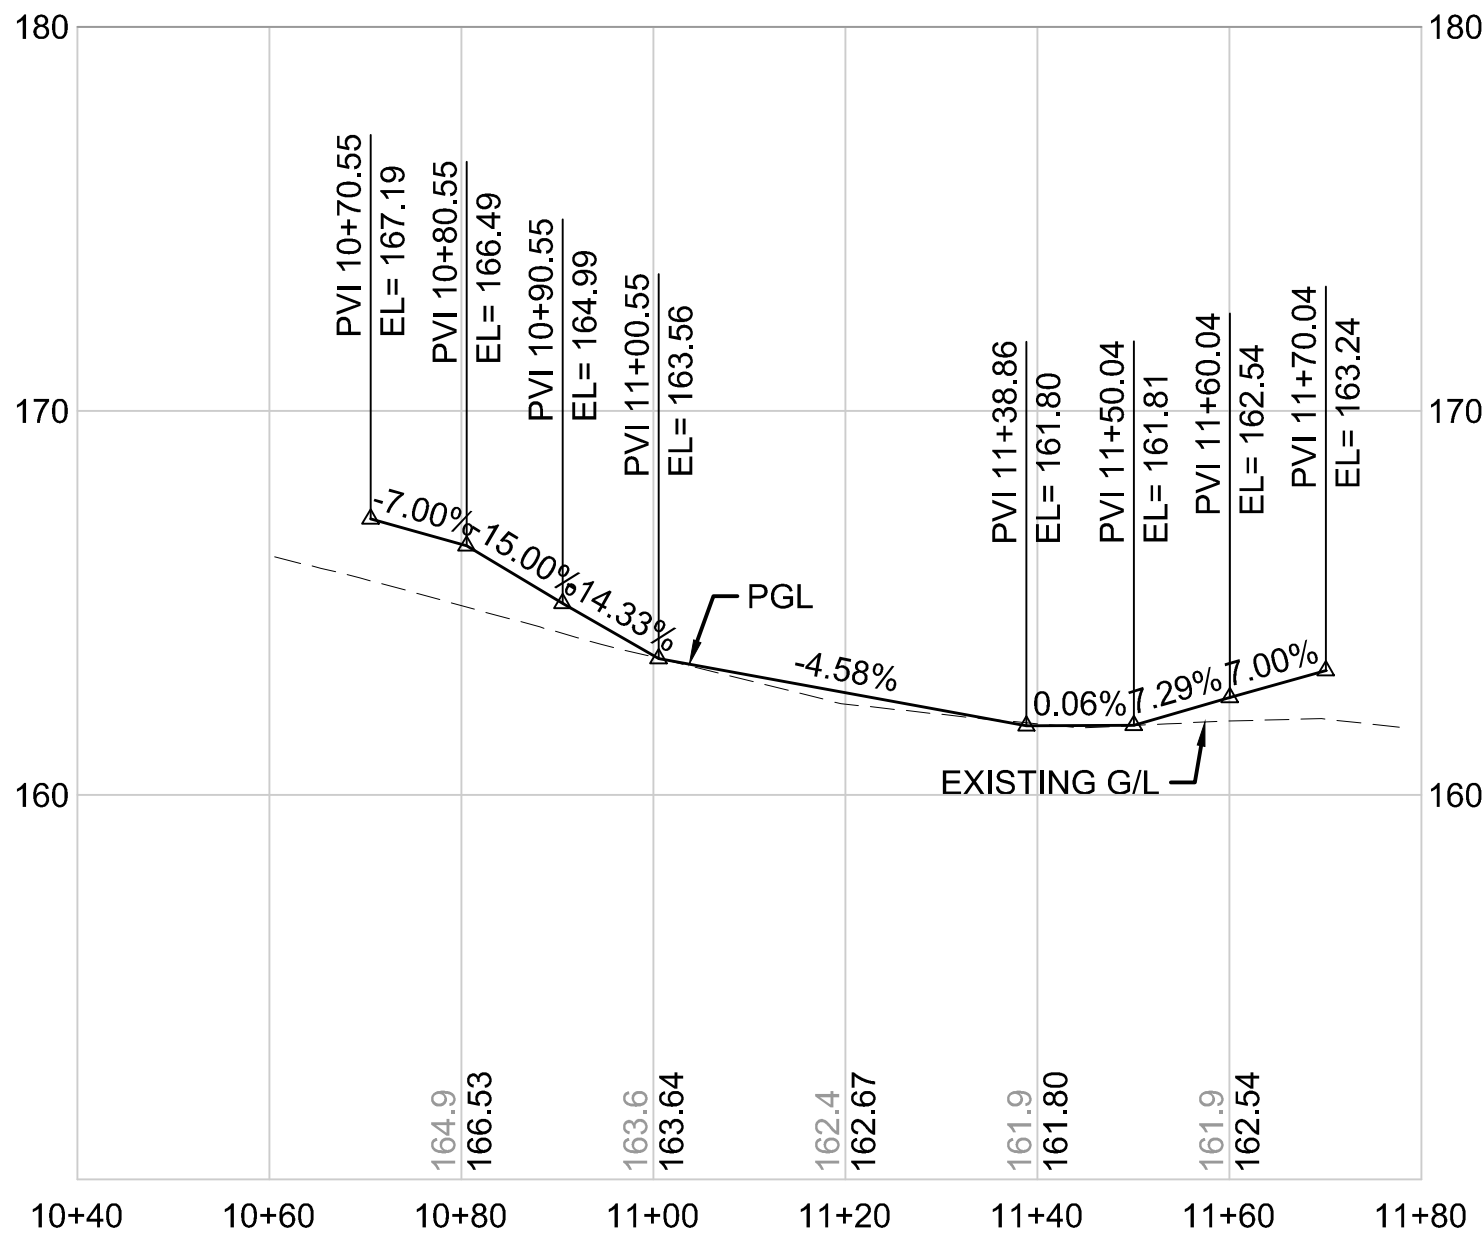

BRS258 N-S LINE
HORIZONTAL SCALE: 1"=20'
VERTICAL SCALE: 1"=5'

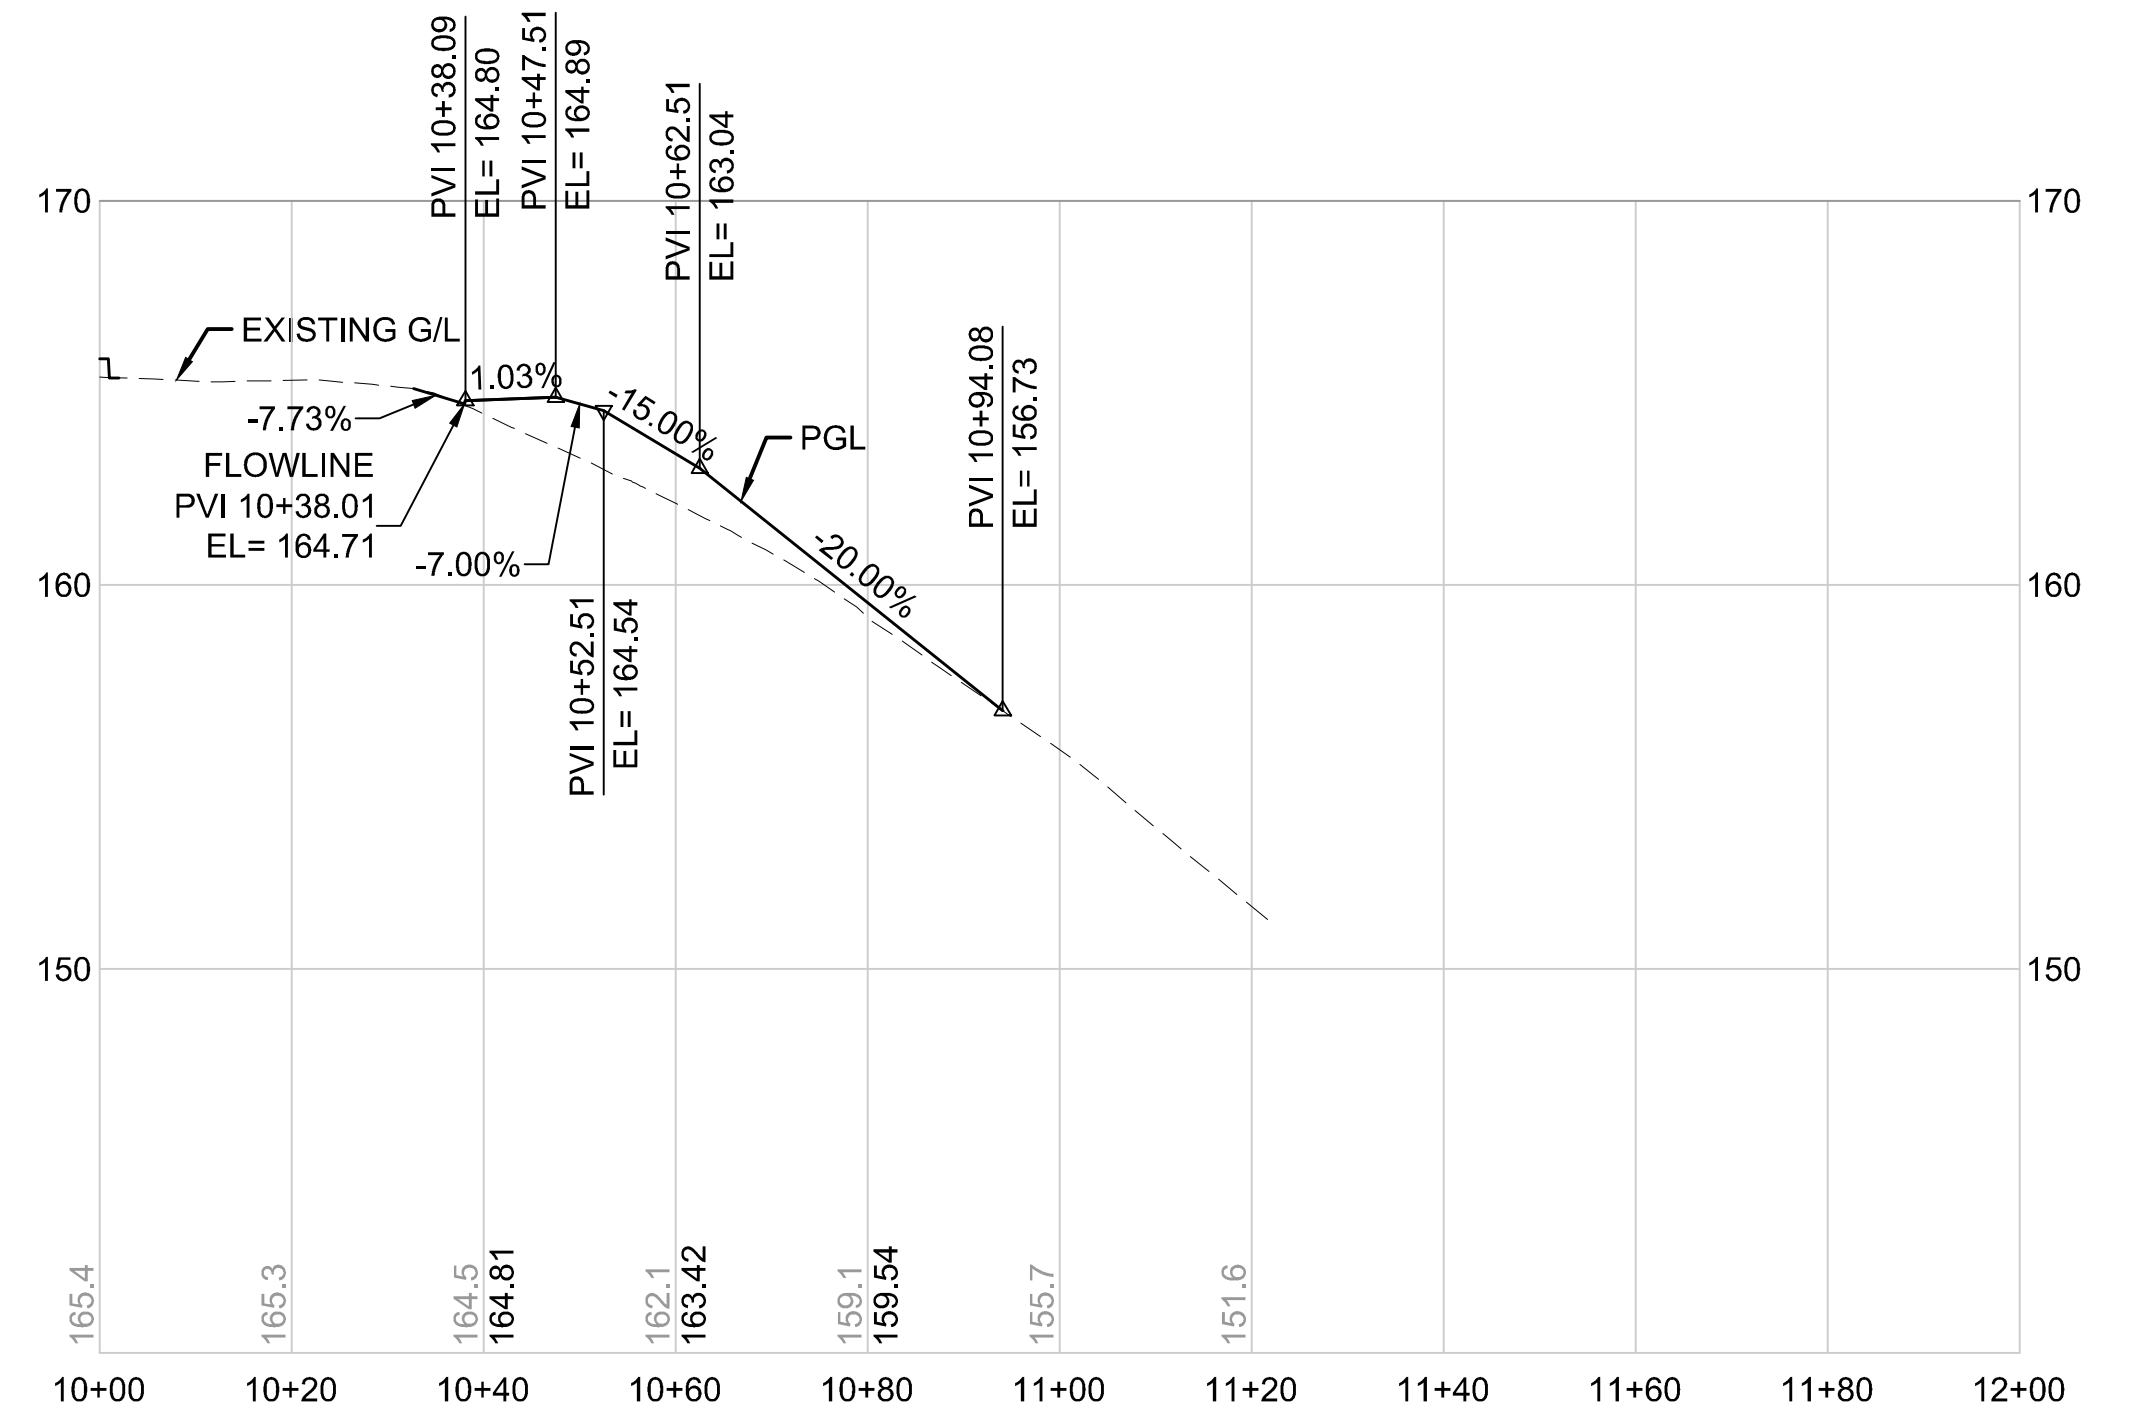

BRS258-N LINE
HORIZONTAL SCALE: 1"=20'
VERTICAL SCALE: 1"=5'

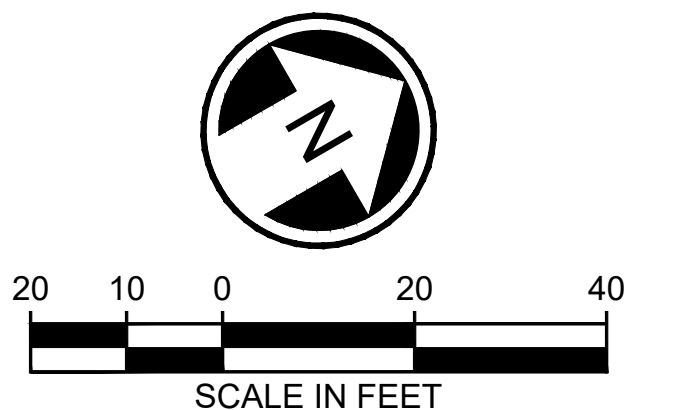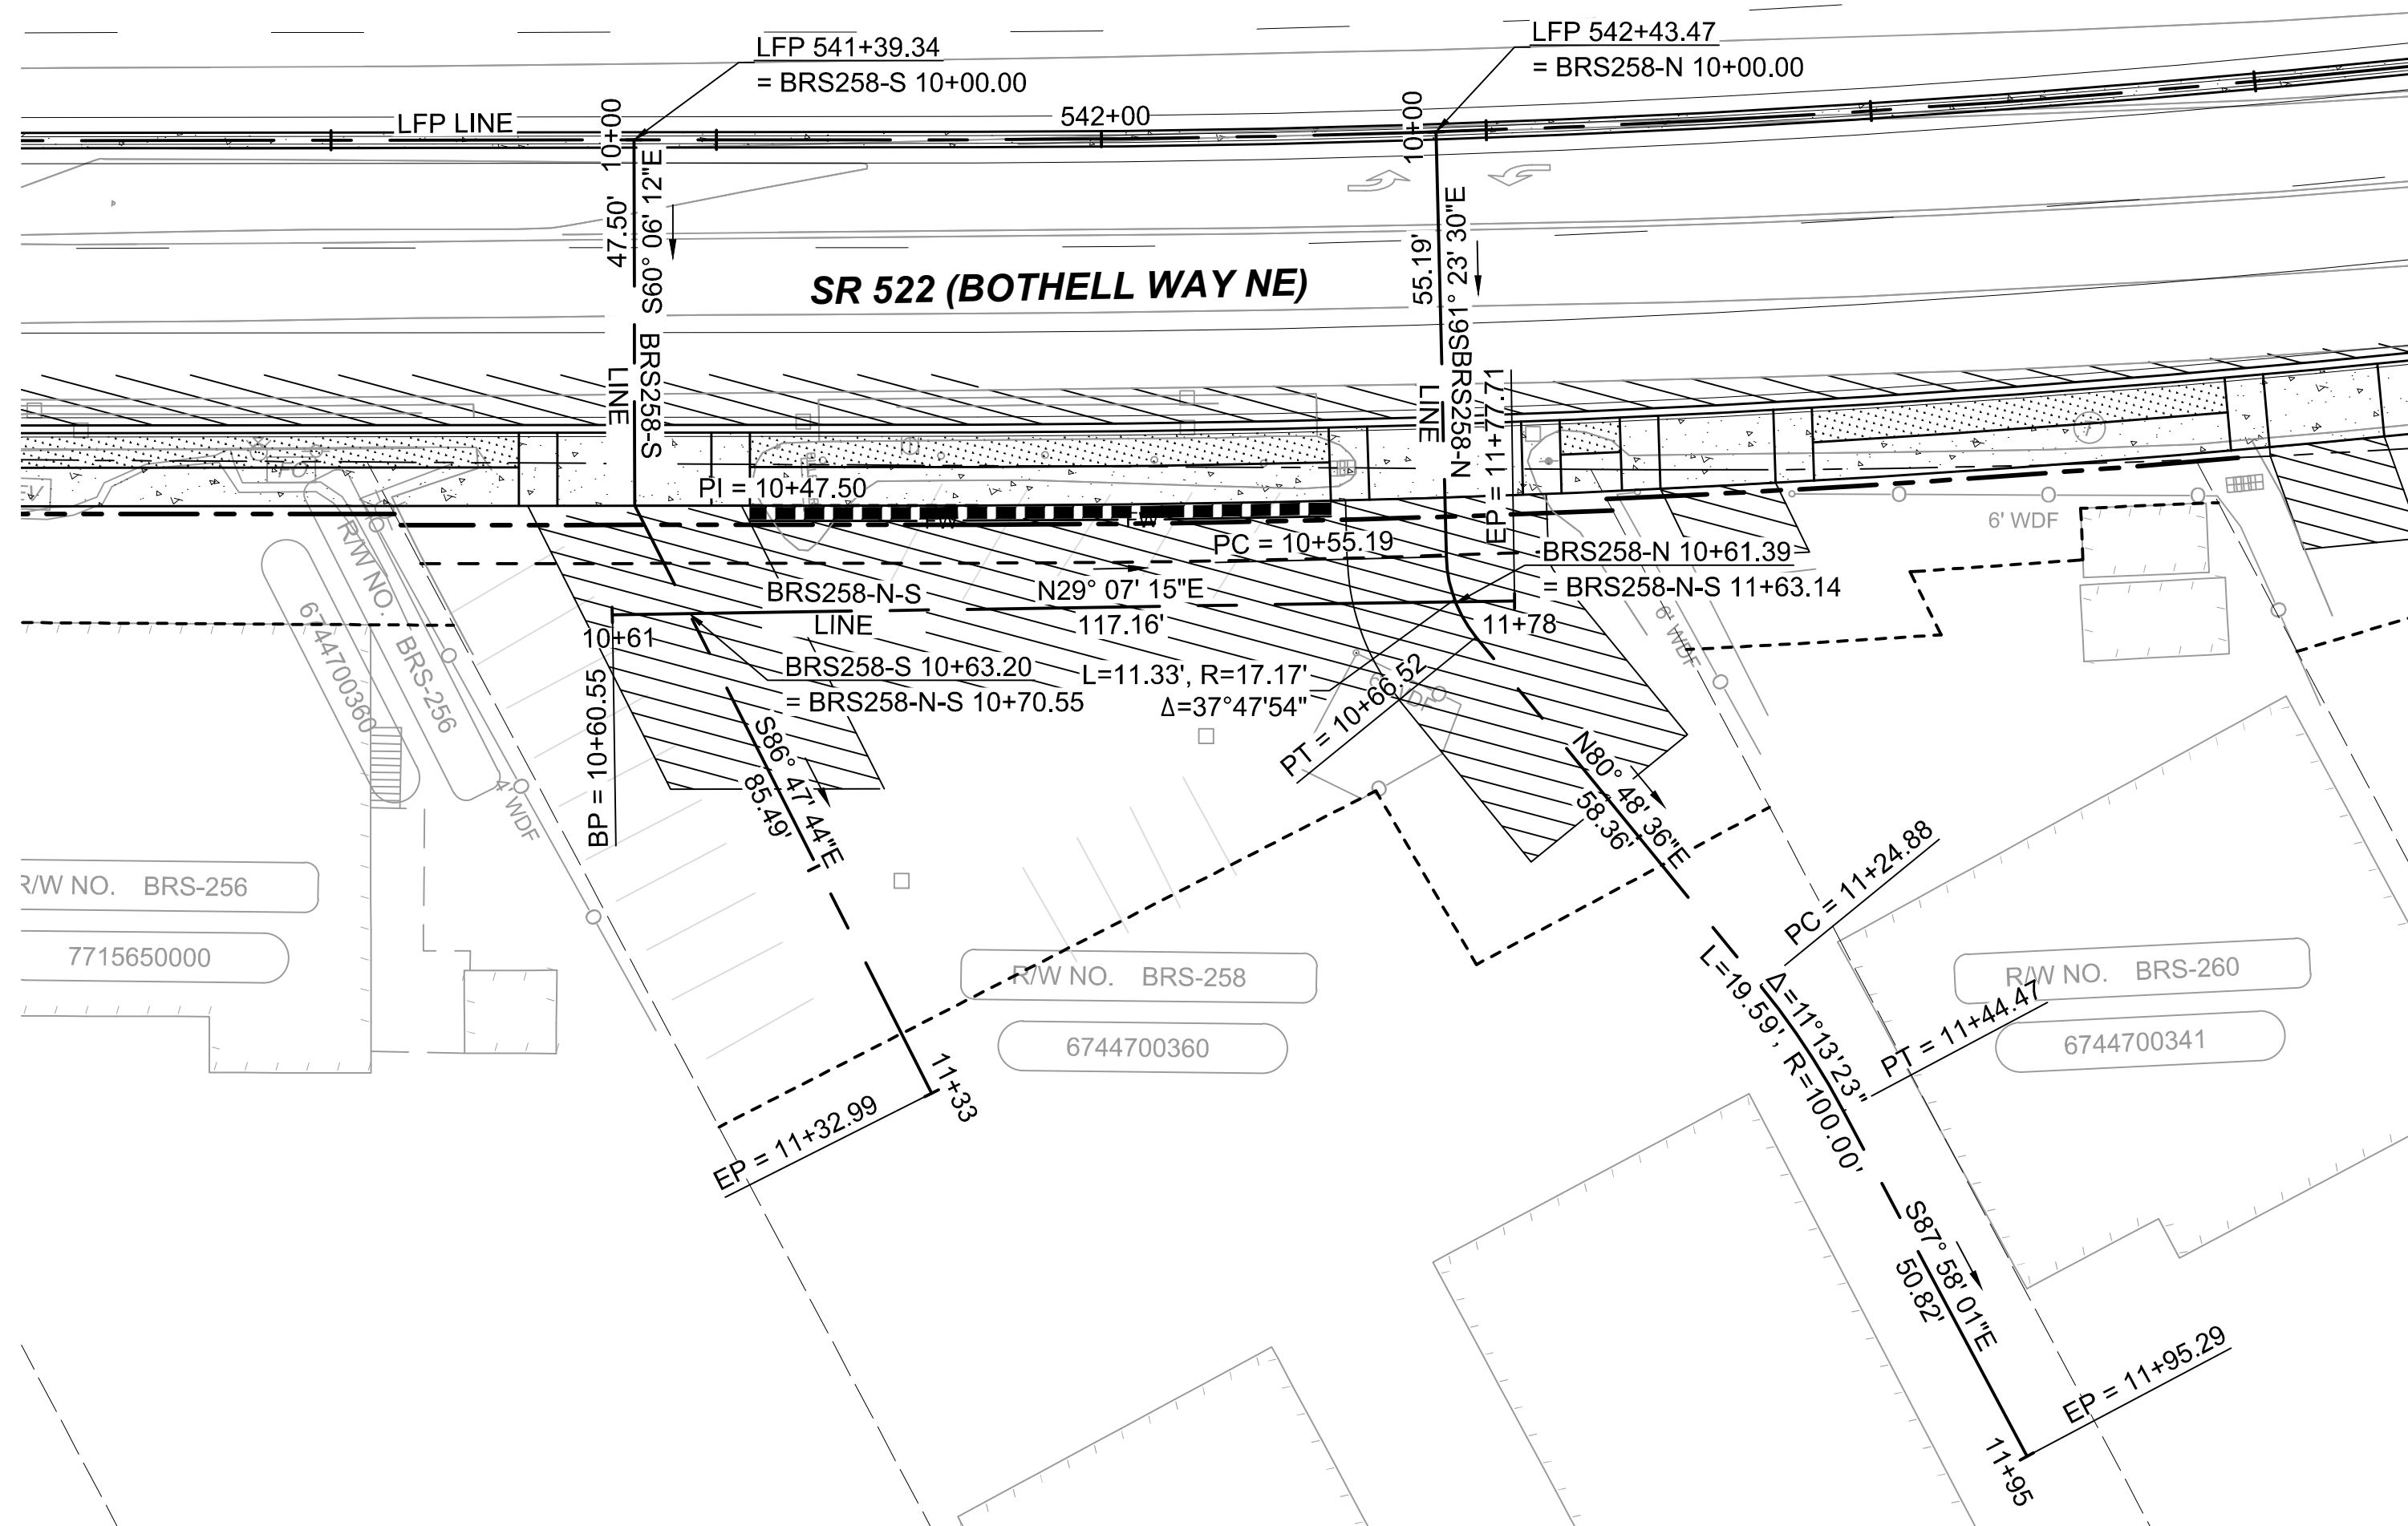


DRAFT 30% SUBMITTAL

No.	DATE	DSN	CHK	APP	REVISION

DESIGNED BY:
C.MATYAS
DRAWN BY:
C.BRESLEY
CHECKED BY:
R.KOESTER
APPROVED BY:
M.FELIBERTI



 **DAVID EVANS
AND ASSOCIATES INC.**
14432 SE Eastgate Way, Suite 400
Bellevue Washington 98007
Phone: 425.519.6500



SOUNDTRANSIT

SUBMITTED BY:
D.SCHOCK

DATE:
09/11/2020


REVIEWED BY:
B.KEMPER

DATE:
09/11/2020



SCALE:
1"=20'
FILENAME:
BRT-522-CRV212-226
CONTRACT No.:
AE 0055-17
DATE:
09/11/2020

SR 522 / NE 145TH BRT
SR 522 (BOTHELL WAY NE)
CIVIL
**DRIVEWAY PLAN AND PROFILES BRS258-S, BRS258 N-S
& BRS258-N STA. 10+00 TO STA. 11+95.29**

DRAWING No.:
522-CRV216
FACILITY ID:
522
SHEET No.:
120 OF 283
REV:

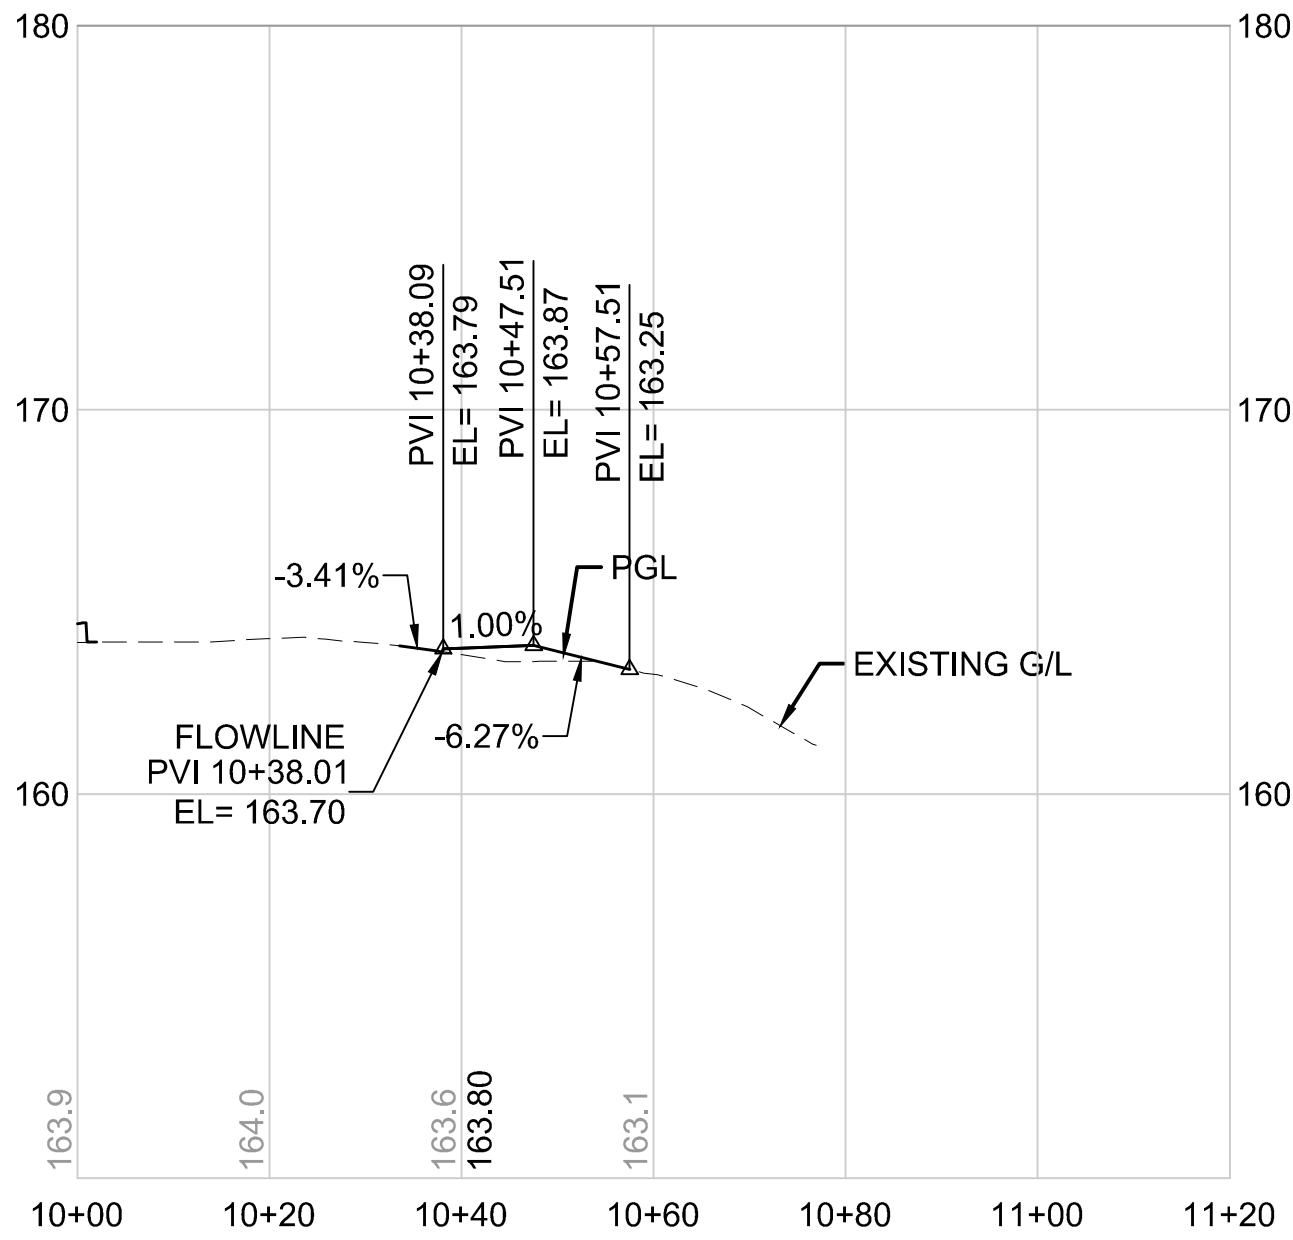

BRS260 LINE
HORIZONTAL SCALE: 1"=20'
VERTICAL SCALE: 1"=5'

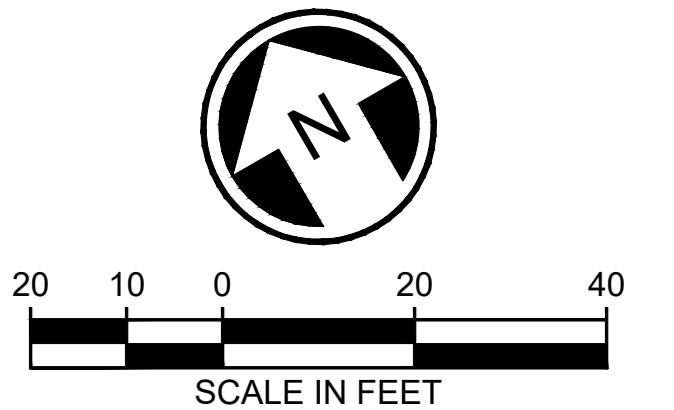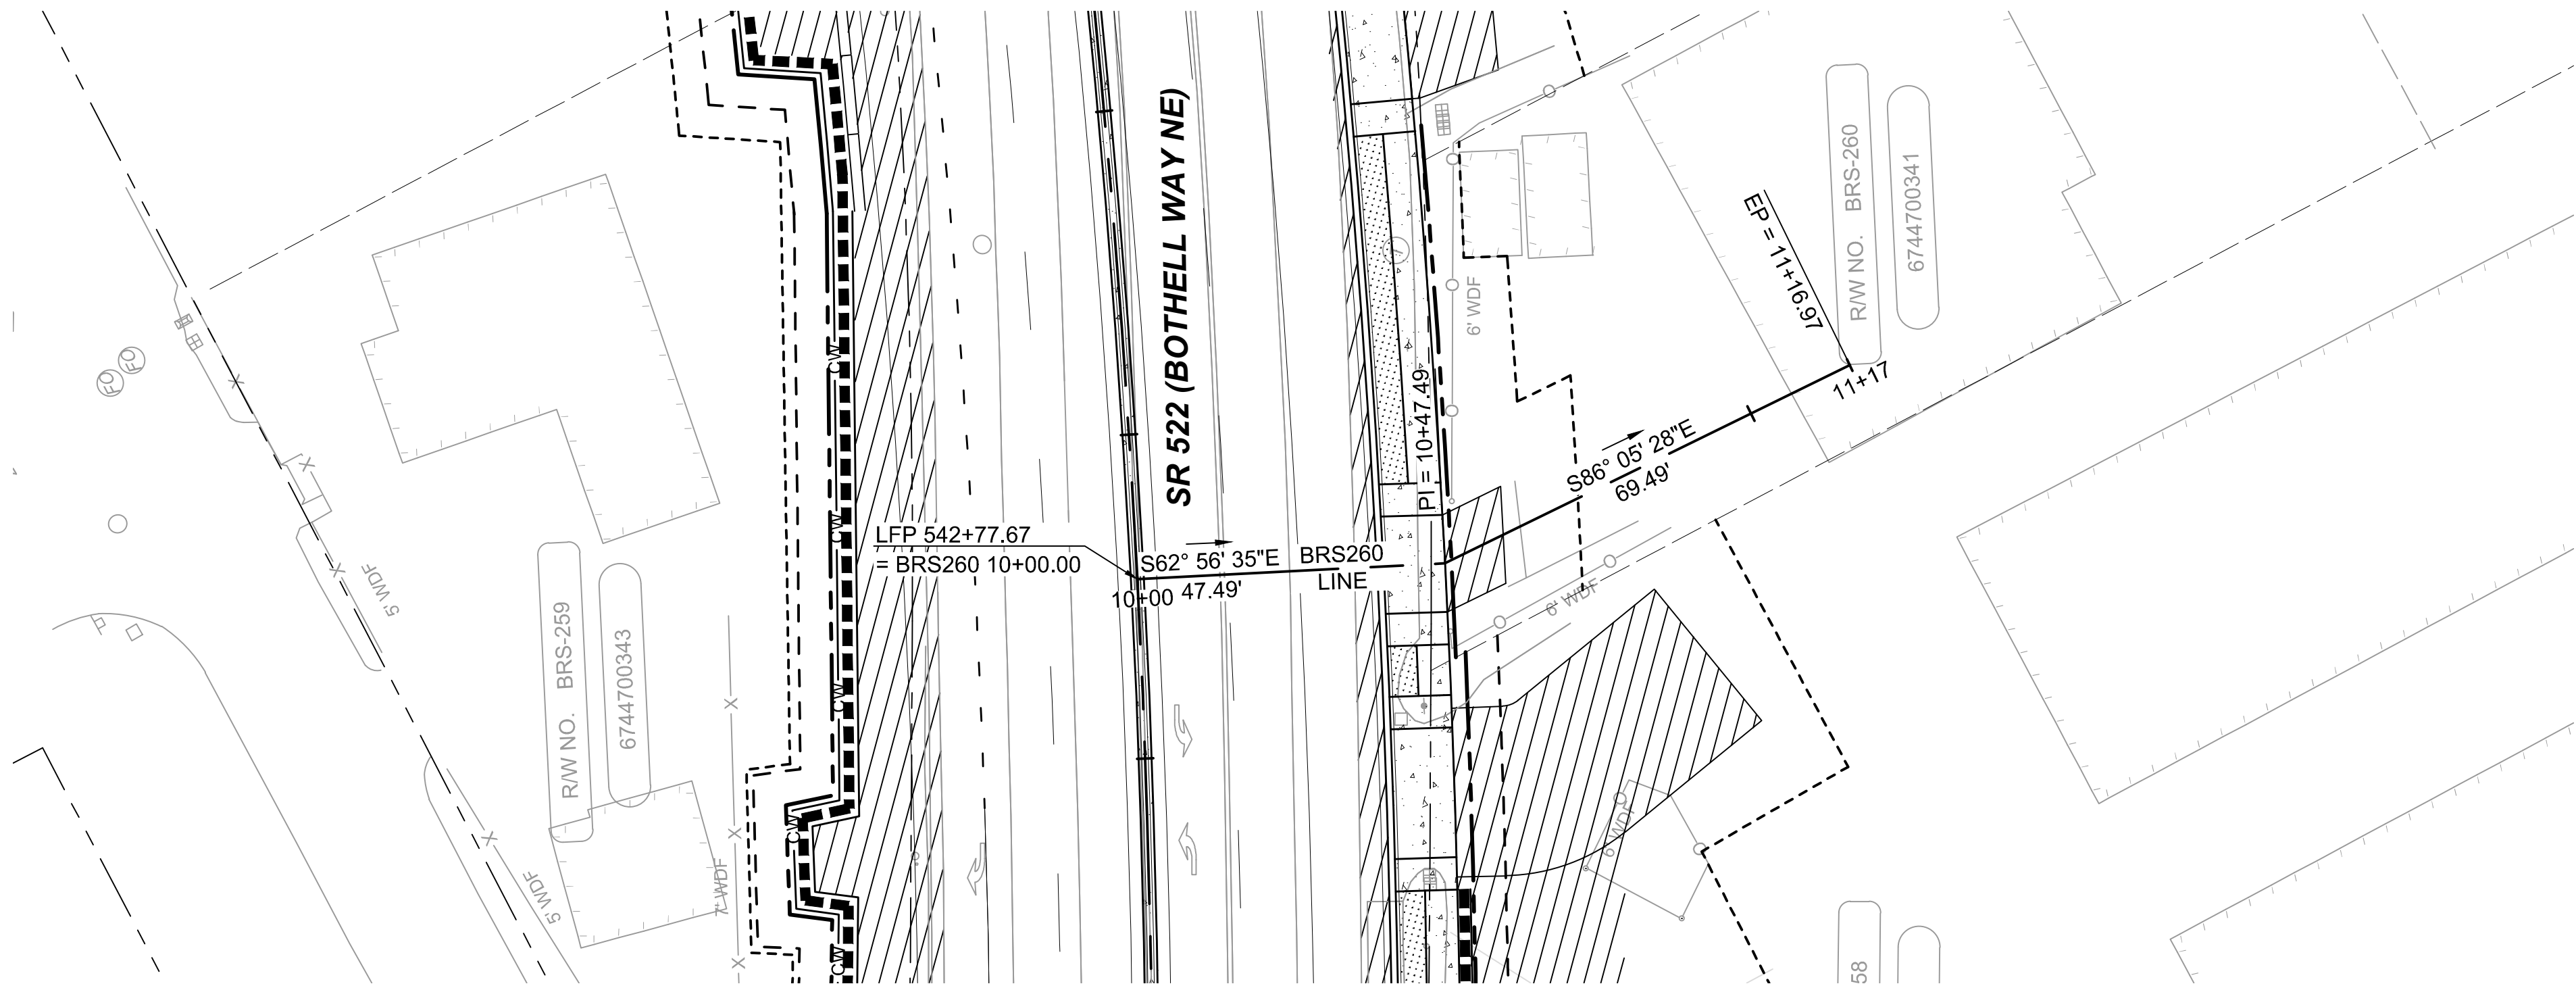

DRAFT 30% SUBMITTAL


No.	DATE	DSN	CHK	APP	REVISION

DESIGNED BY:	C. MATYAS
DRAWN BY:	C. BRESLEY
CHECKED BY:	R.KOESTER
APPROVED BY:	M. FELIBERTI



**DAVID EVANS
AND ASSOCIATES INC.**
14432 SE Eastgate Way, Suite 400
Bellevue Washington 98007
Phone: 425.519.6500

SUBMITTED BY:	DATE:	REVIEWED BY:
D.SCHOCK	09/11/2020	B.KEMPER

 


SCALE:	1"=20'
FILENAME:	BRT-522-CRV212-226
CONTRACT No.:	AE 0055-17
DATE:	09/11/2020



SR 522 / NE 145TH BRT
SR 522 (BOTHELL WAY NE)
CIVIL
DRIVEWAY PLAN AND PROFILE BRS260
STA. 10+00 TO STA. 11+16.97

DRAWING No.:	522-CRV217
FACILITY ID:	522
SHEET No.:	121 OF 283
REV:	

09/10/20 | 1:27 AM | SJRO
C:\PW_WORK\DEA\STEVEN ROSE\DWG\BRT-522-CRV212-226.DWG

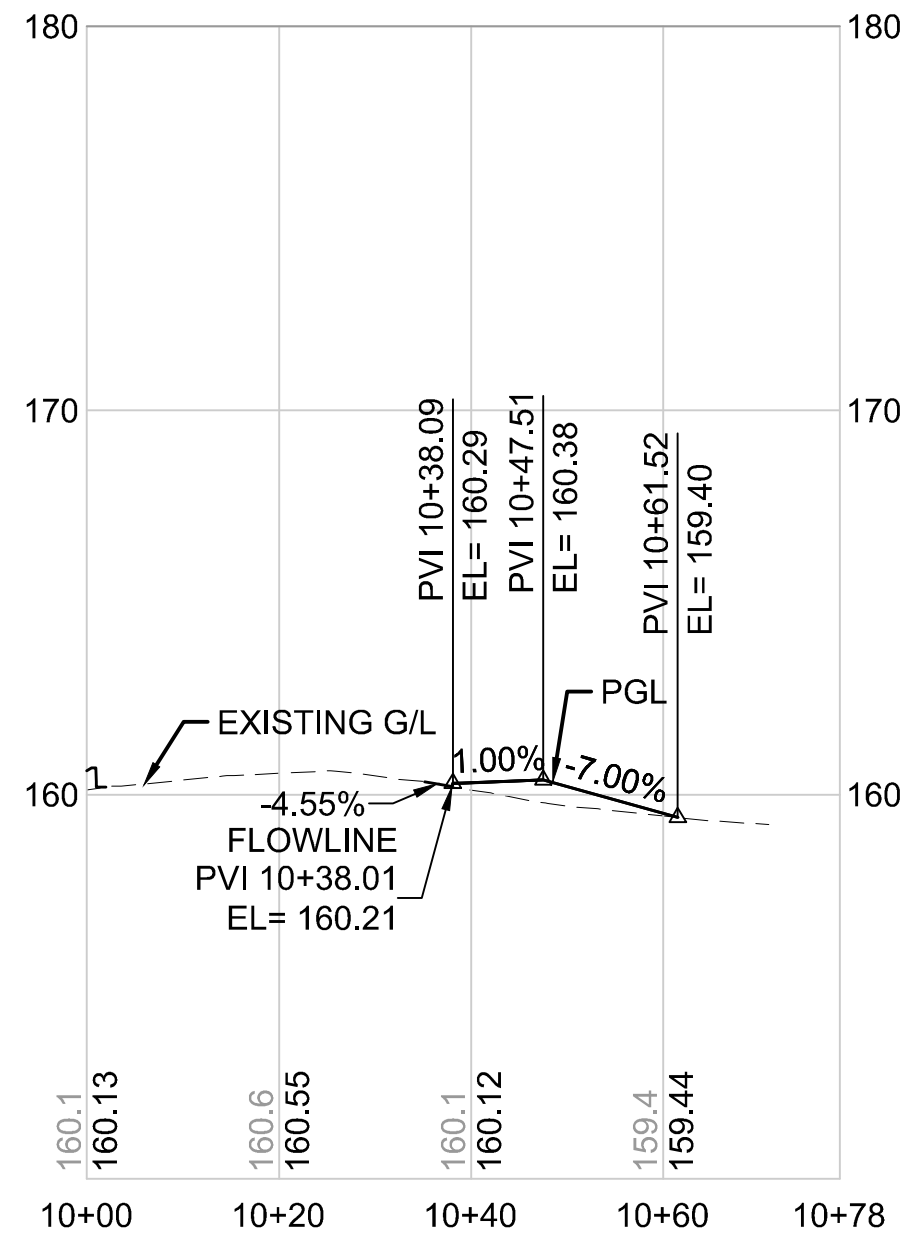

BRS262 LINE
HORIZONTAL SCALE: 1"=20'
VERTICAL SCALE: 1"=5'

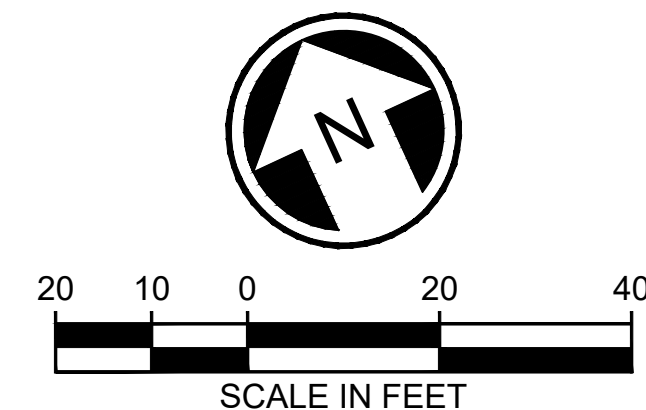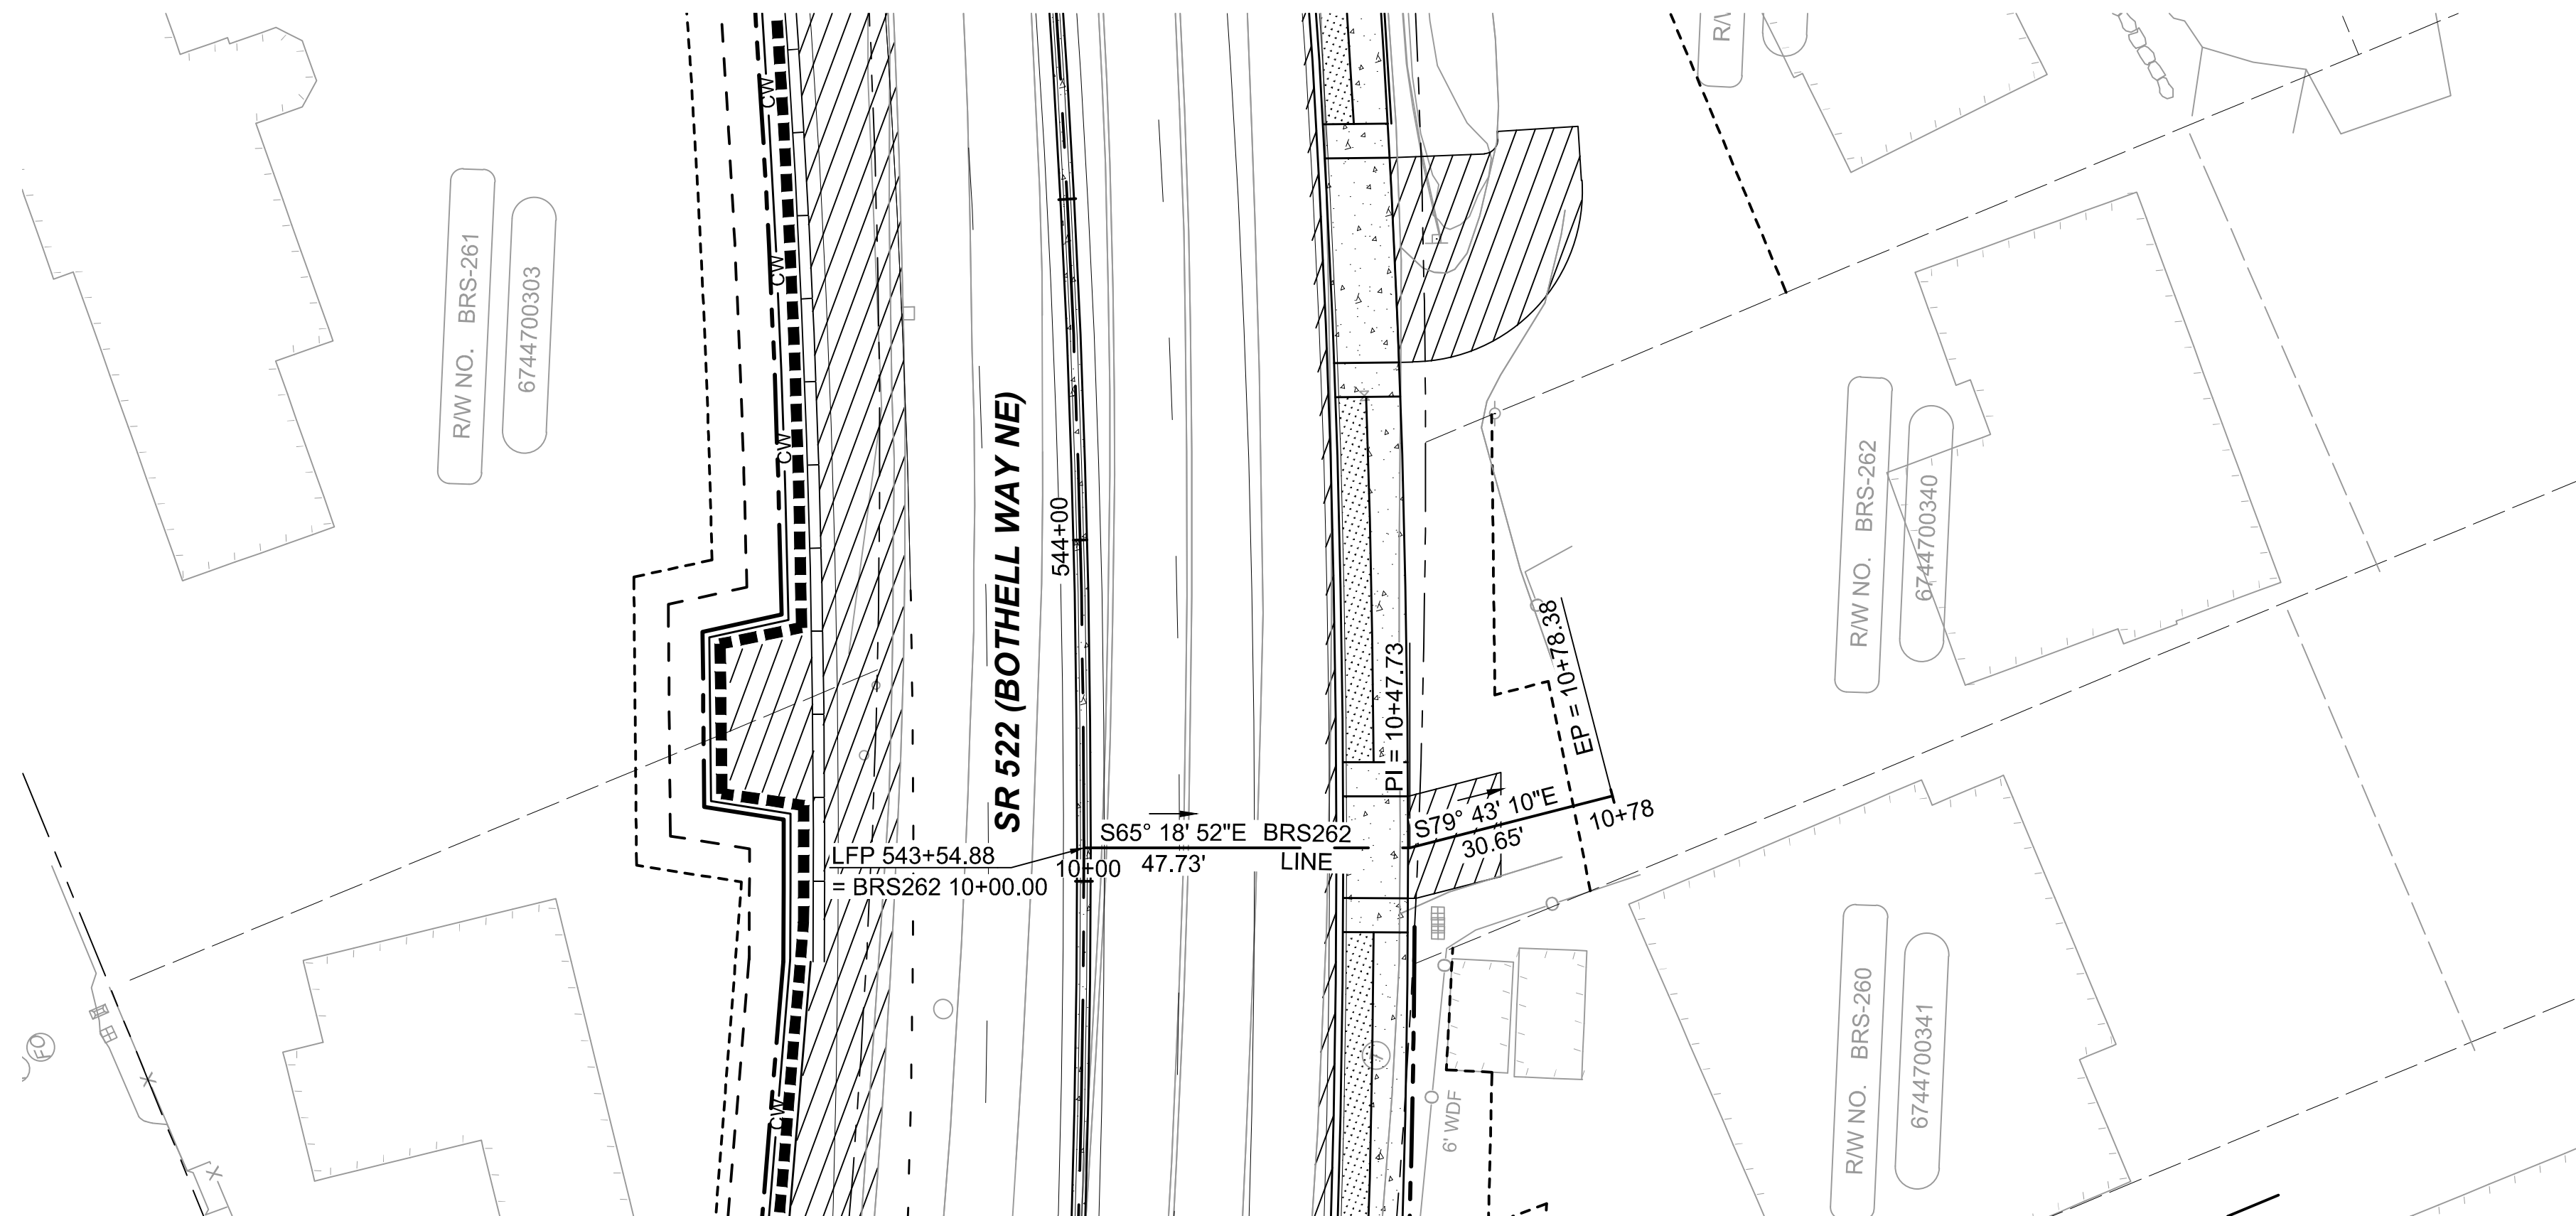

DRAFT 30% SUBMITTAL


No.	DATE	DSN	CHK	APP	REVISION

DESIGNED BY:	C.MATYAS
DRAWN BY:	C.BRESLEY
CHECKED BY:	R.KOESTER
APPROVED BY:	M.FELIBERTI



**DAVID EVANS
AND ASSOCIATES INC.**
14432 SE Eastgate Way, Suite 400
Bellevue Washington 98007
Phone: 425.519.6500

SUBMITTED BY:	DATE:	REVIEWED BY:	DATE:
D.SCHOCK	09/11/2020	B.KEMPER	09/11/2020

 


SOUNDTRANSIT

SCALE:	1"=20'
FILENAME:	BRT-522-CRV212-226
CONTRACT No.:	AE 0055-17
DATE:	09/11/2020



SR 522 / NE 145TH BRT
SR 522 (BOTHELL WAY NE)
CIVIL
DRIVEWAY PLAN AND PROFILE BRS262
STA. 10+00 TO STA. 10+78.38

DRAWING No.:	522-CRV218
FACILITY ID:	522
SHEET No.:	122 OF 283
REV:	

09/10/20 | 1:28 AM | SJRO
C:\PW_WORK\DEA\STEVEN ROSE\DWG\SR522\BRT-522-CRV212-226.DWG

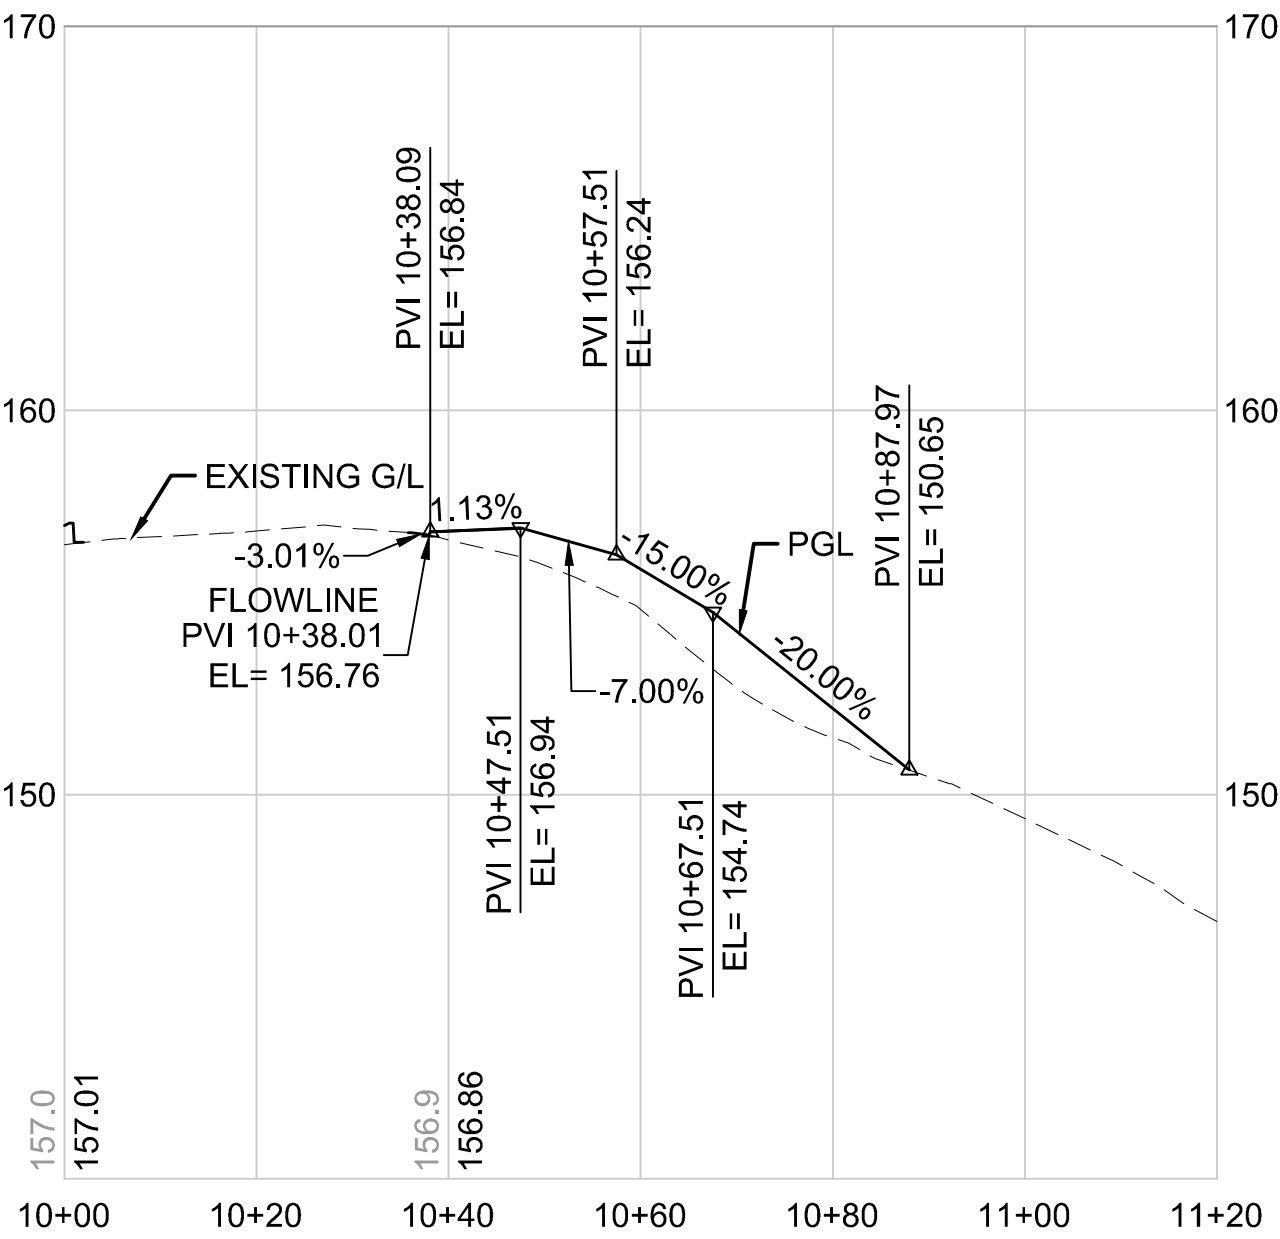

NE 157TH PL LINE
HORIZONTAL SCALE: 1"=20'
VERTICAL SCALE: 1"=5'

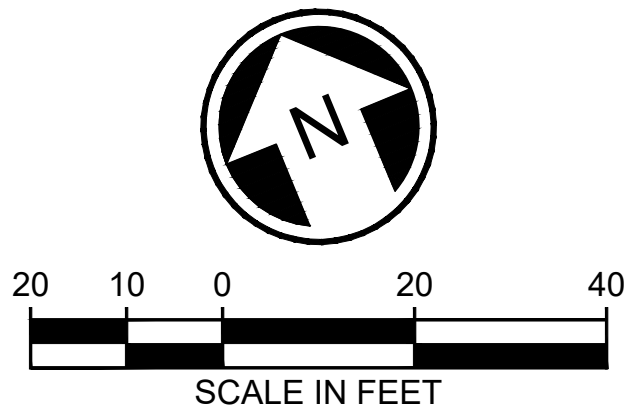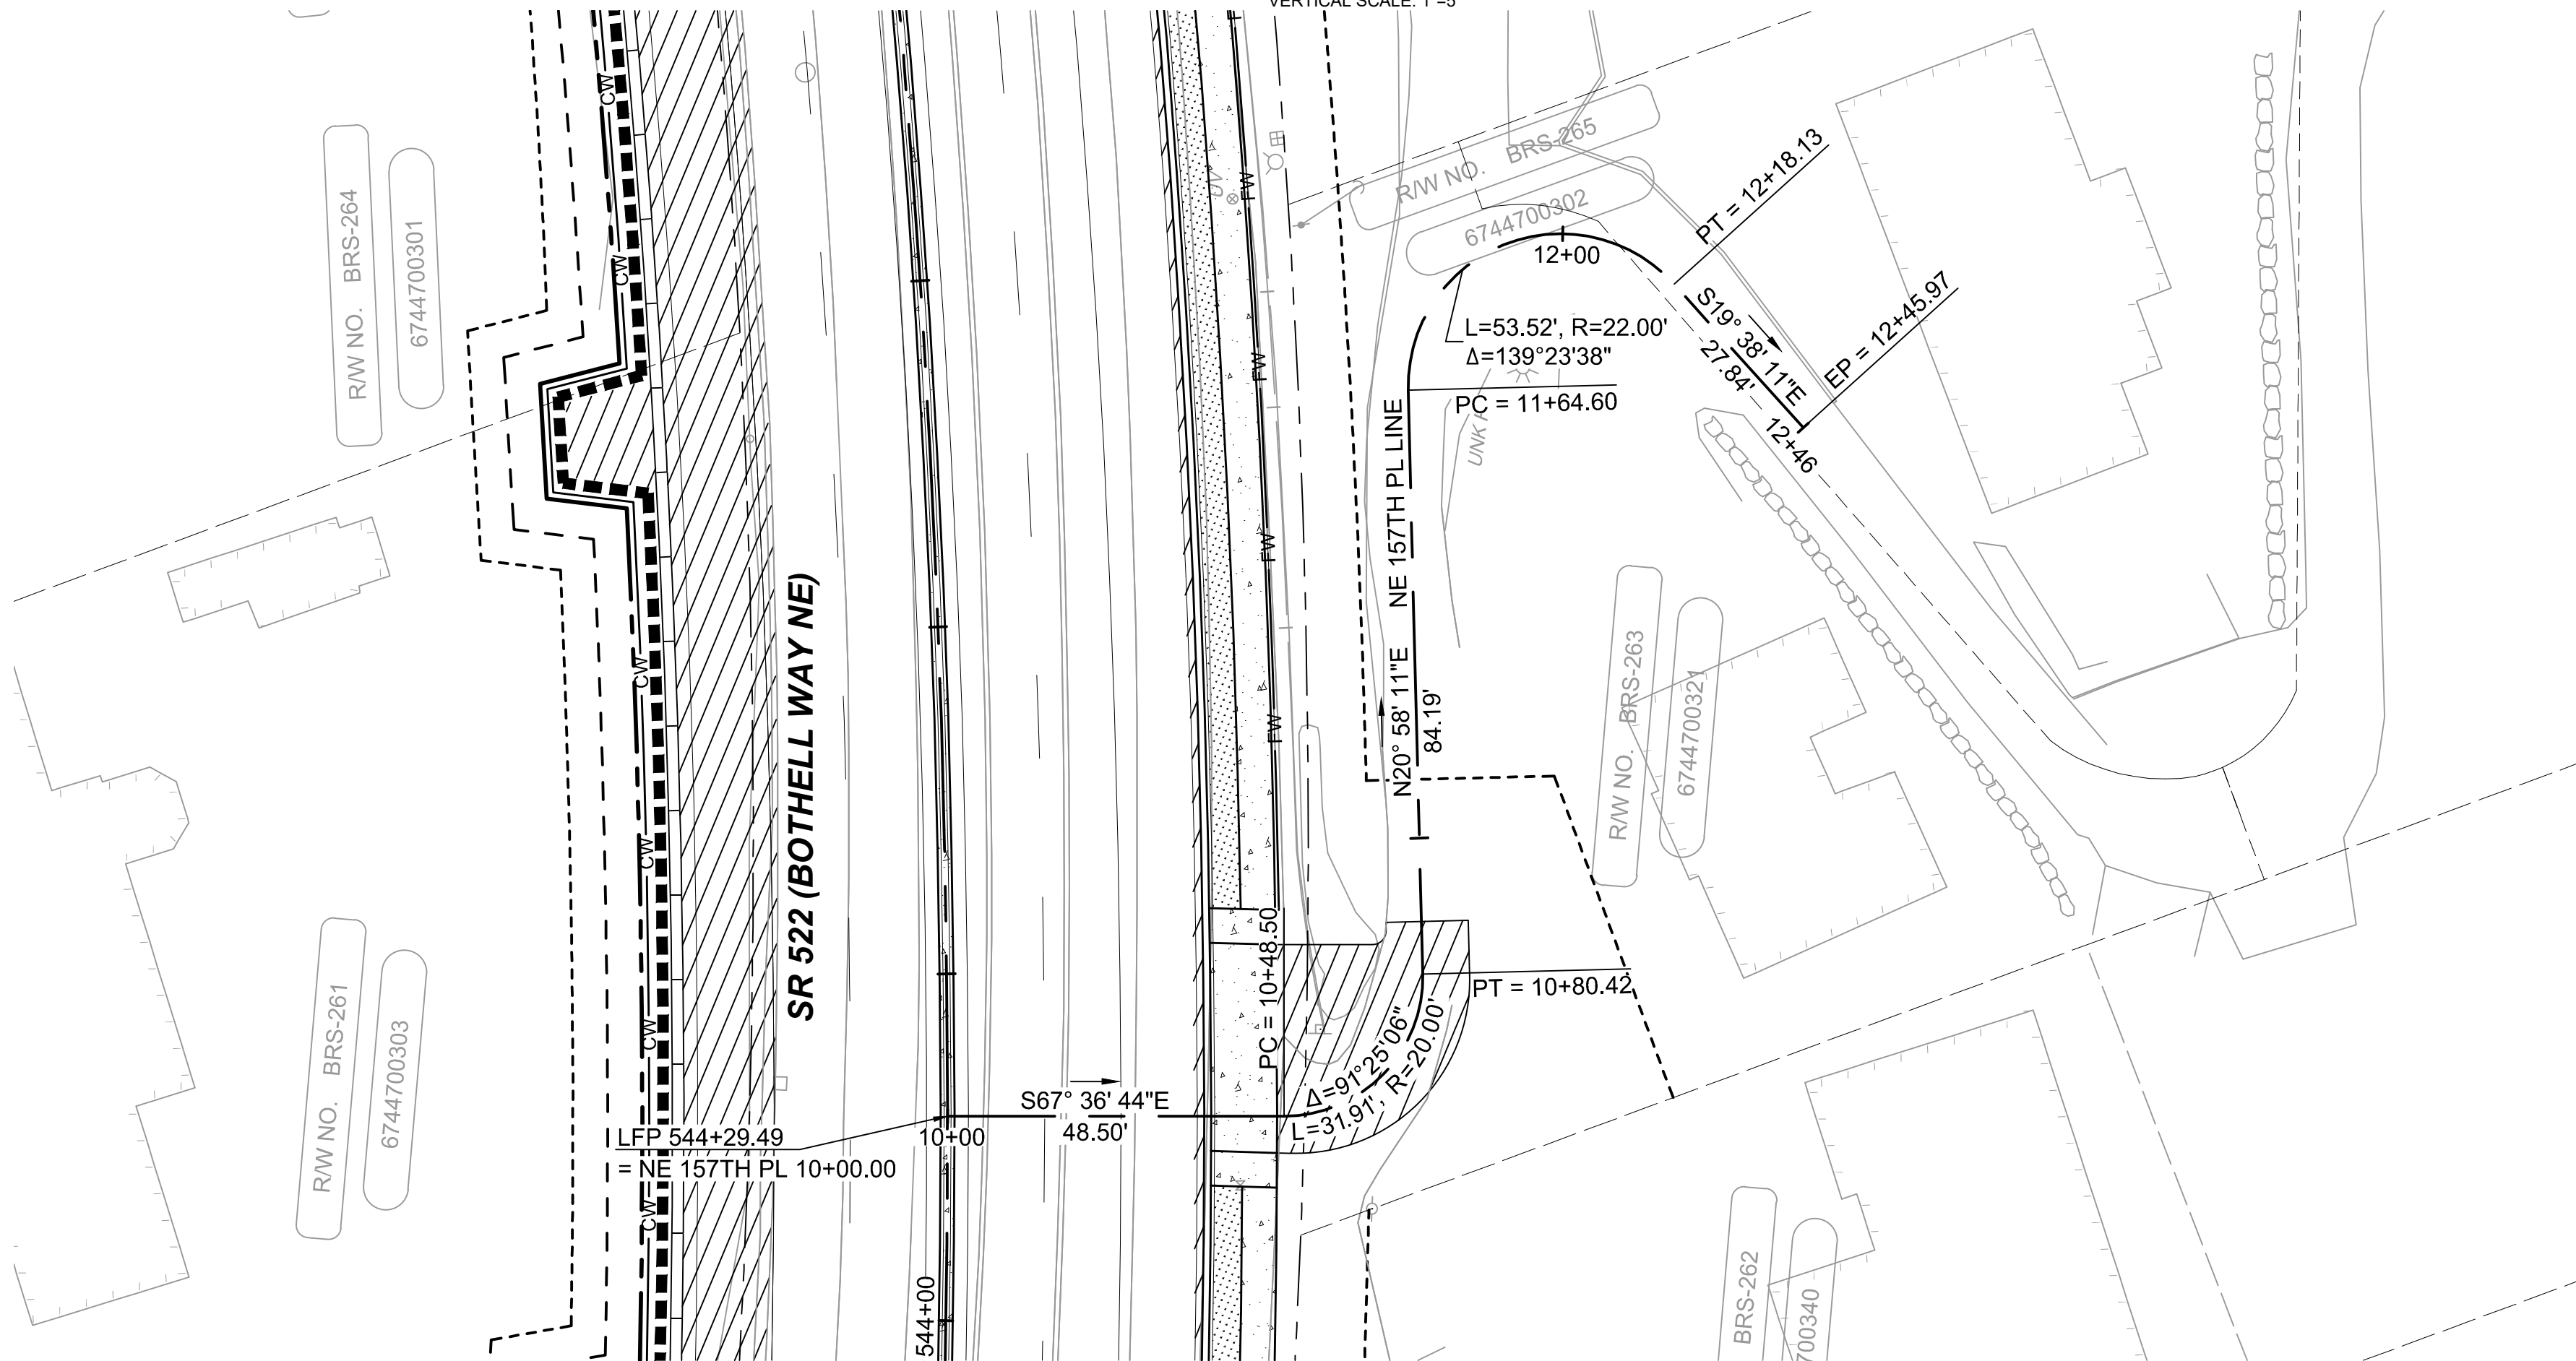

DRAFT 30% SUBMITTAL


No.	DATE	DSN	CHK	APP	REVISION

DESIGNED BY:
C. MATYAS
DRAWN BY:
C. BRESLEY
CHECKED BY:
R.KOESTER
APPROVED BY:
M. FELIBERTI



DAVID EVANS
AND ASSOCIATES INC.
14432 SE Eastgate Way, Suite 400
Bellevue Washington 98007
Phone: 425.519.6500



 
SUBMITTED BY: D.SCHOCK
DATE: 09/11/2020
REVIEWED BY: B.KEMPER
DATE: 09/11/2020



SCALE:
1"=20'
FILENAME:
BRT-522-CRV212-226
CONTRACT No.:
AE 0055-17
DATE:
09/11/2020

SR 522 / NE 145TH BRT
SR 522 (BOTHELL WAY NE)
CIVIL
DRIVEWAY PLAN AND PROFILE NE 157TH PL
STA. 10+00 TO STA. 12+45.97

DRAWING No.:
522-CRV219
FACILITY ID:
522
SHEET No.:
123 OF 283

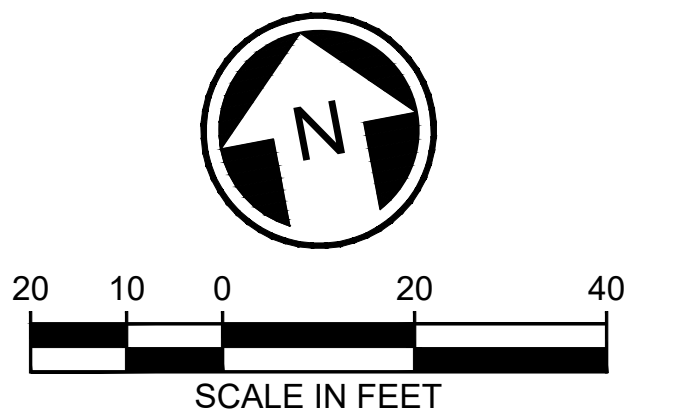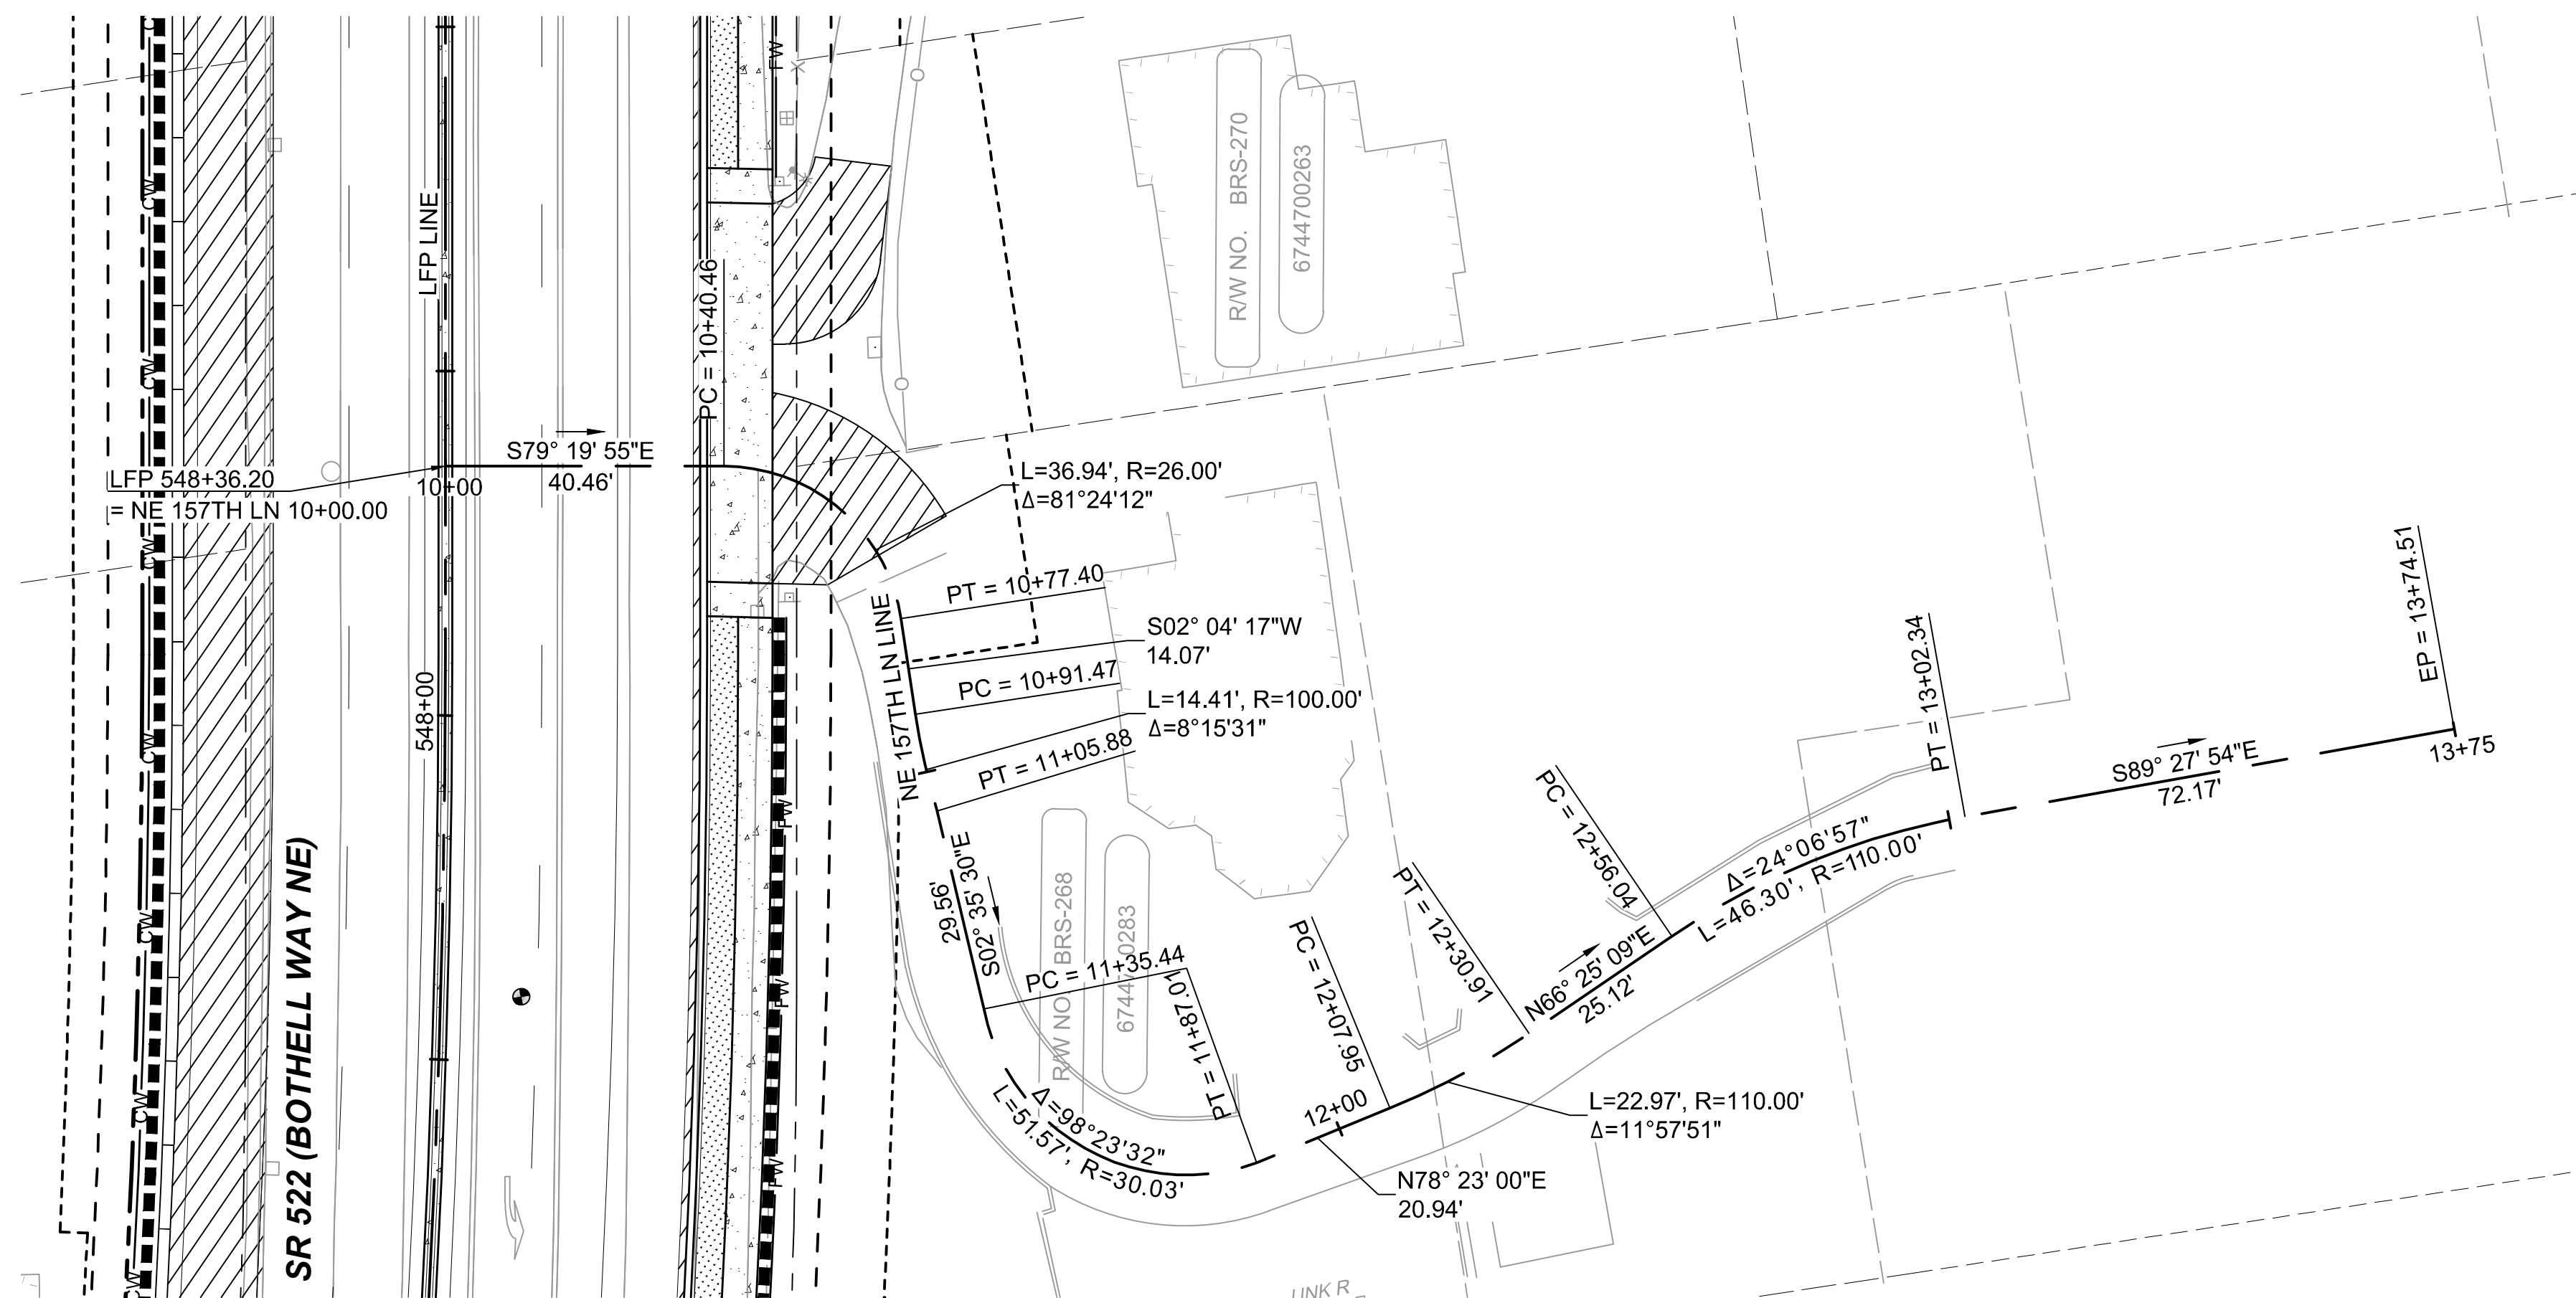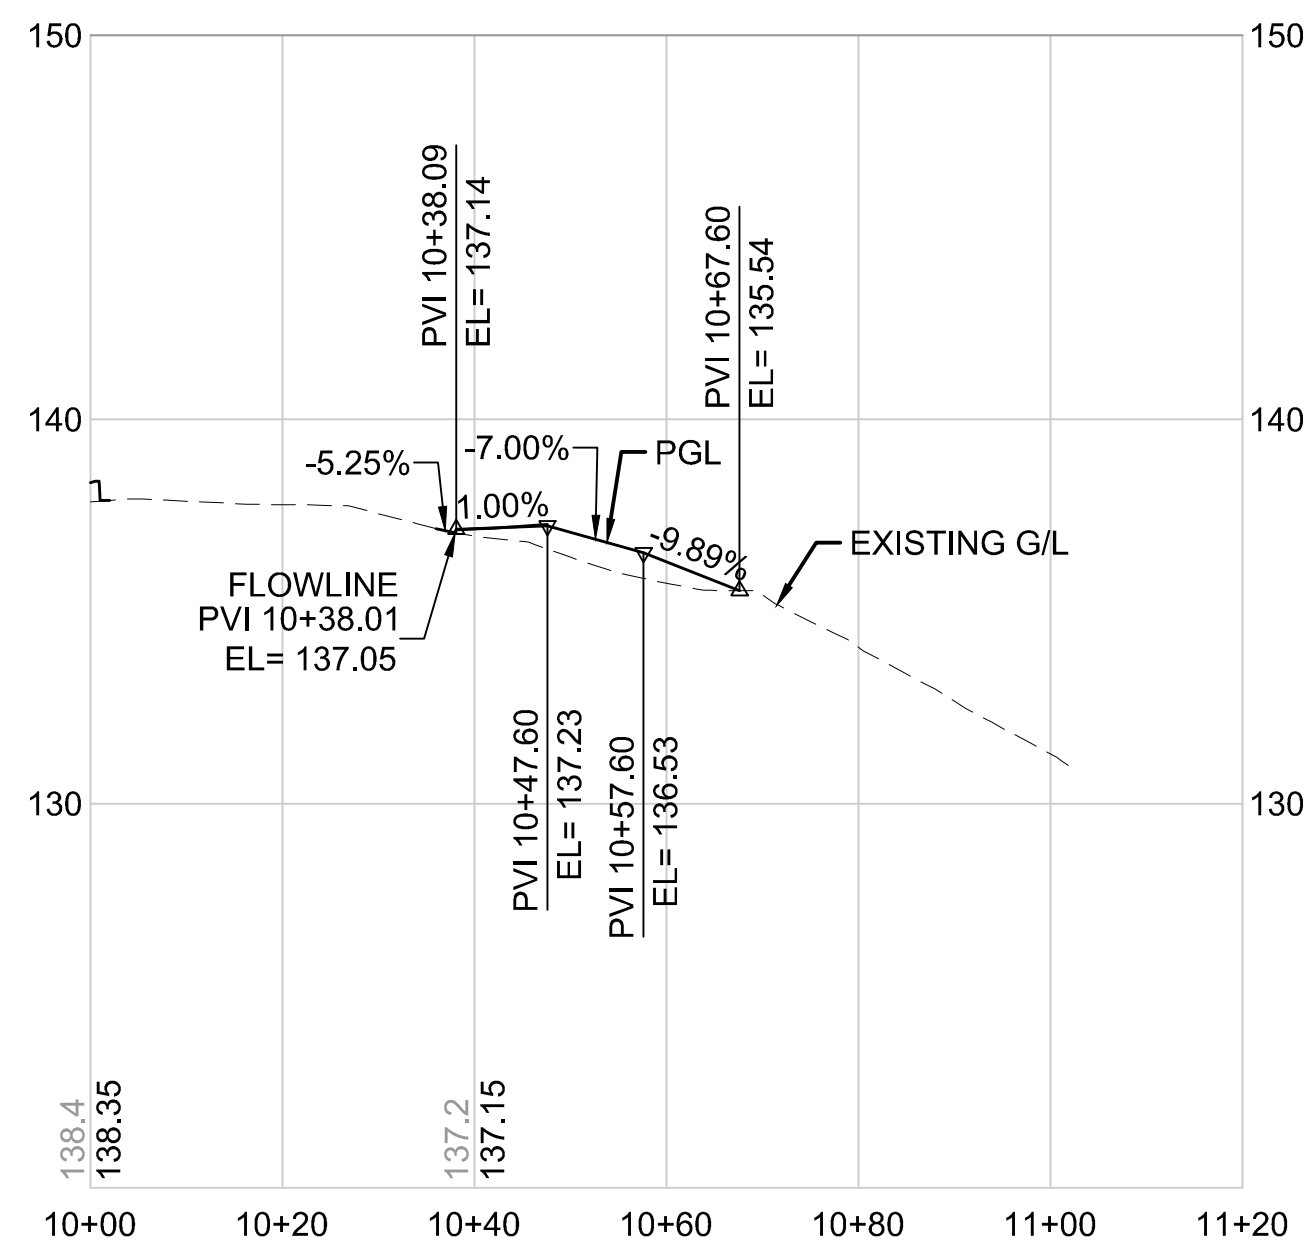

DRAFT 30% SUBMITTAL

No.	DATE	DSN	CHK	APP	REVISION

DESIGNED BY:	C. MATYAS
DRAWN BY:	C. BRESLEY
CHECKED BY:	R.KOESTER
APPROVED BY:	M. FELIBERT



DAVID EVANS
AND ASSOCIATES INC.
14432 SE Eastgate Way, Suite 400
Bellevue Washington 98007
Phone: 425.519.6500

LINE IS 1" AT



SCALE:	1"=20'
FILENAME:	BRT-522-CRV212-226
CONTRACT No.:	AE 0055-17
DATE:	09/11/2020

SR 522 / NE 145TH BRT



SR 522 (BOTHHELL WAY NE)

CIVIL

DRIVEWAY PLAN AND PROFILE NE 157TH LN
STA. 10+00 TO STA. 13+74.51

DRAWING No.:	
522-CRV220	
FACILITY ID:	
522	
SHEET No.:	REV:
124 OF 283	

09/10/20 | 1:30 AM | SJRO
C:\PW_WORK\DEA\STEVEN ROSE\DWG\SR522\BRT-522-CRV212-226.DWG

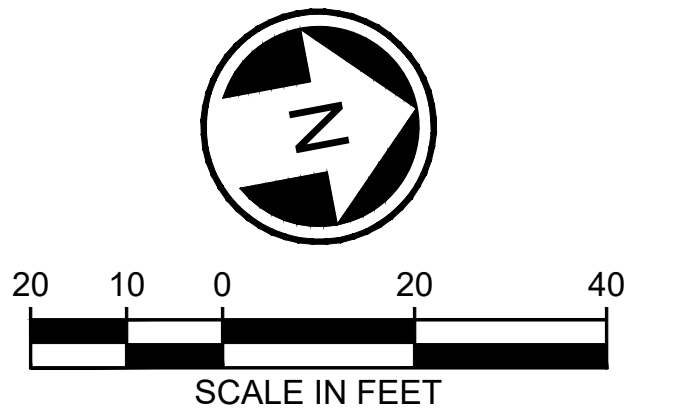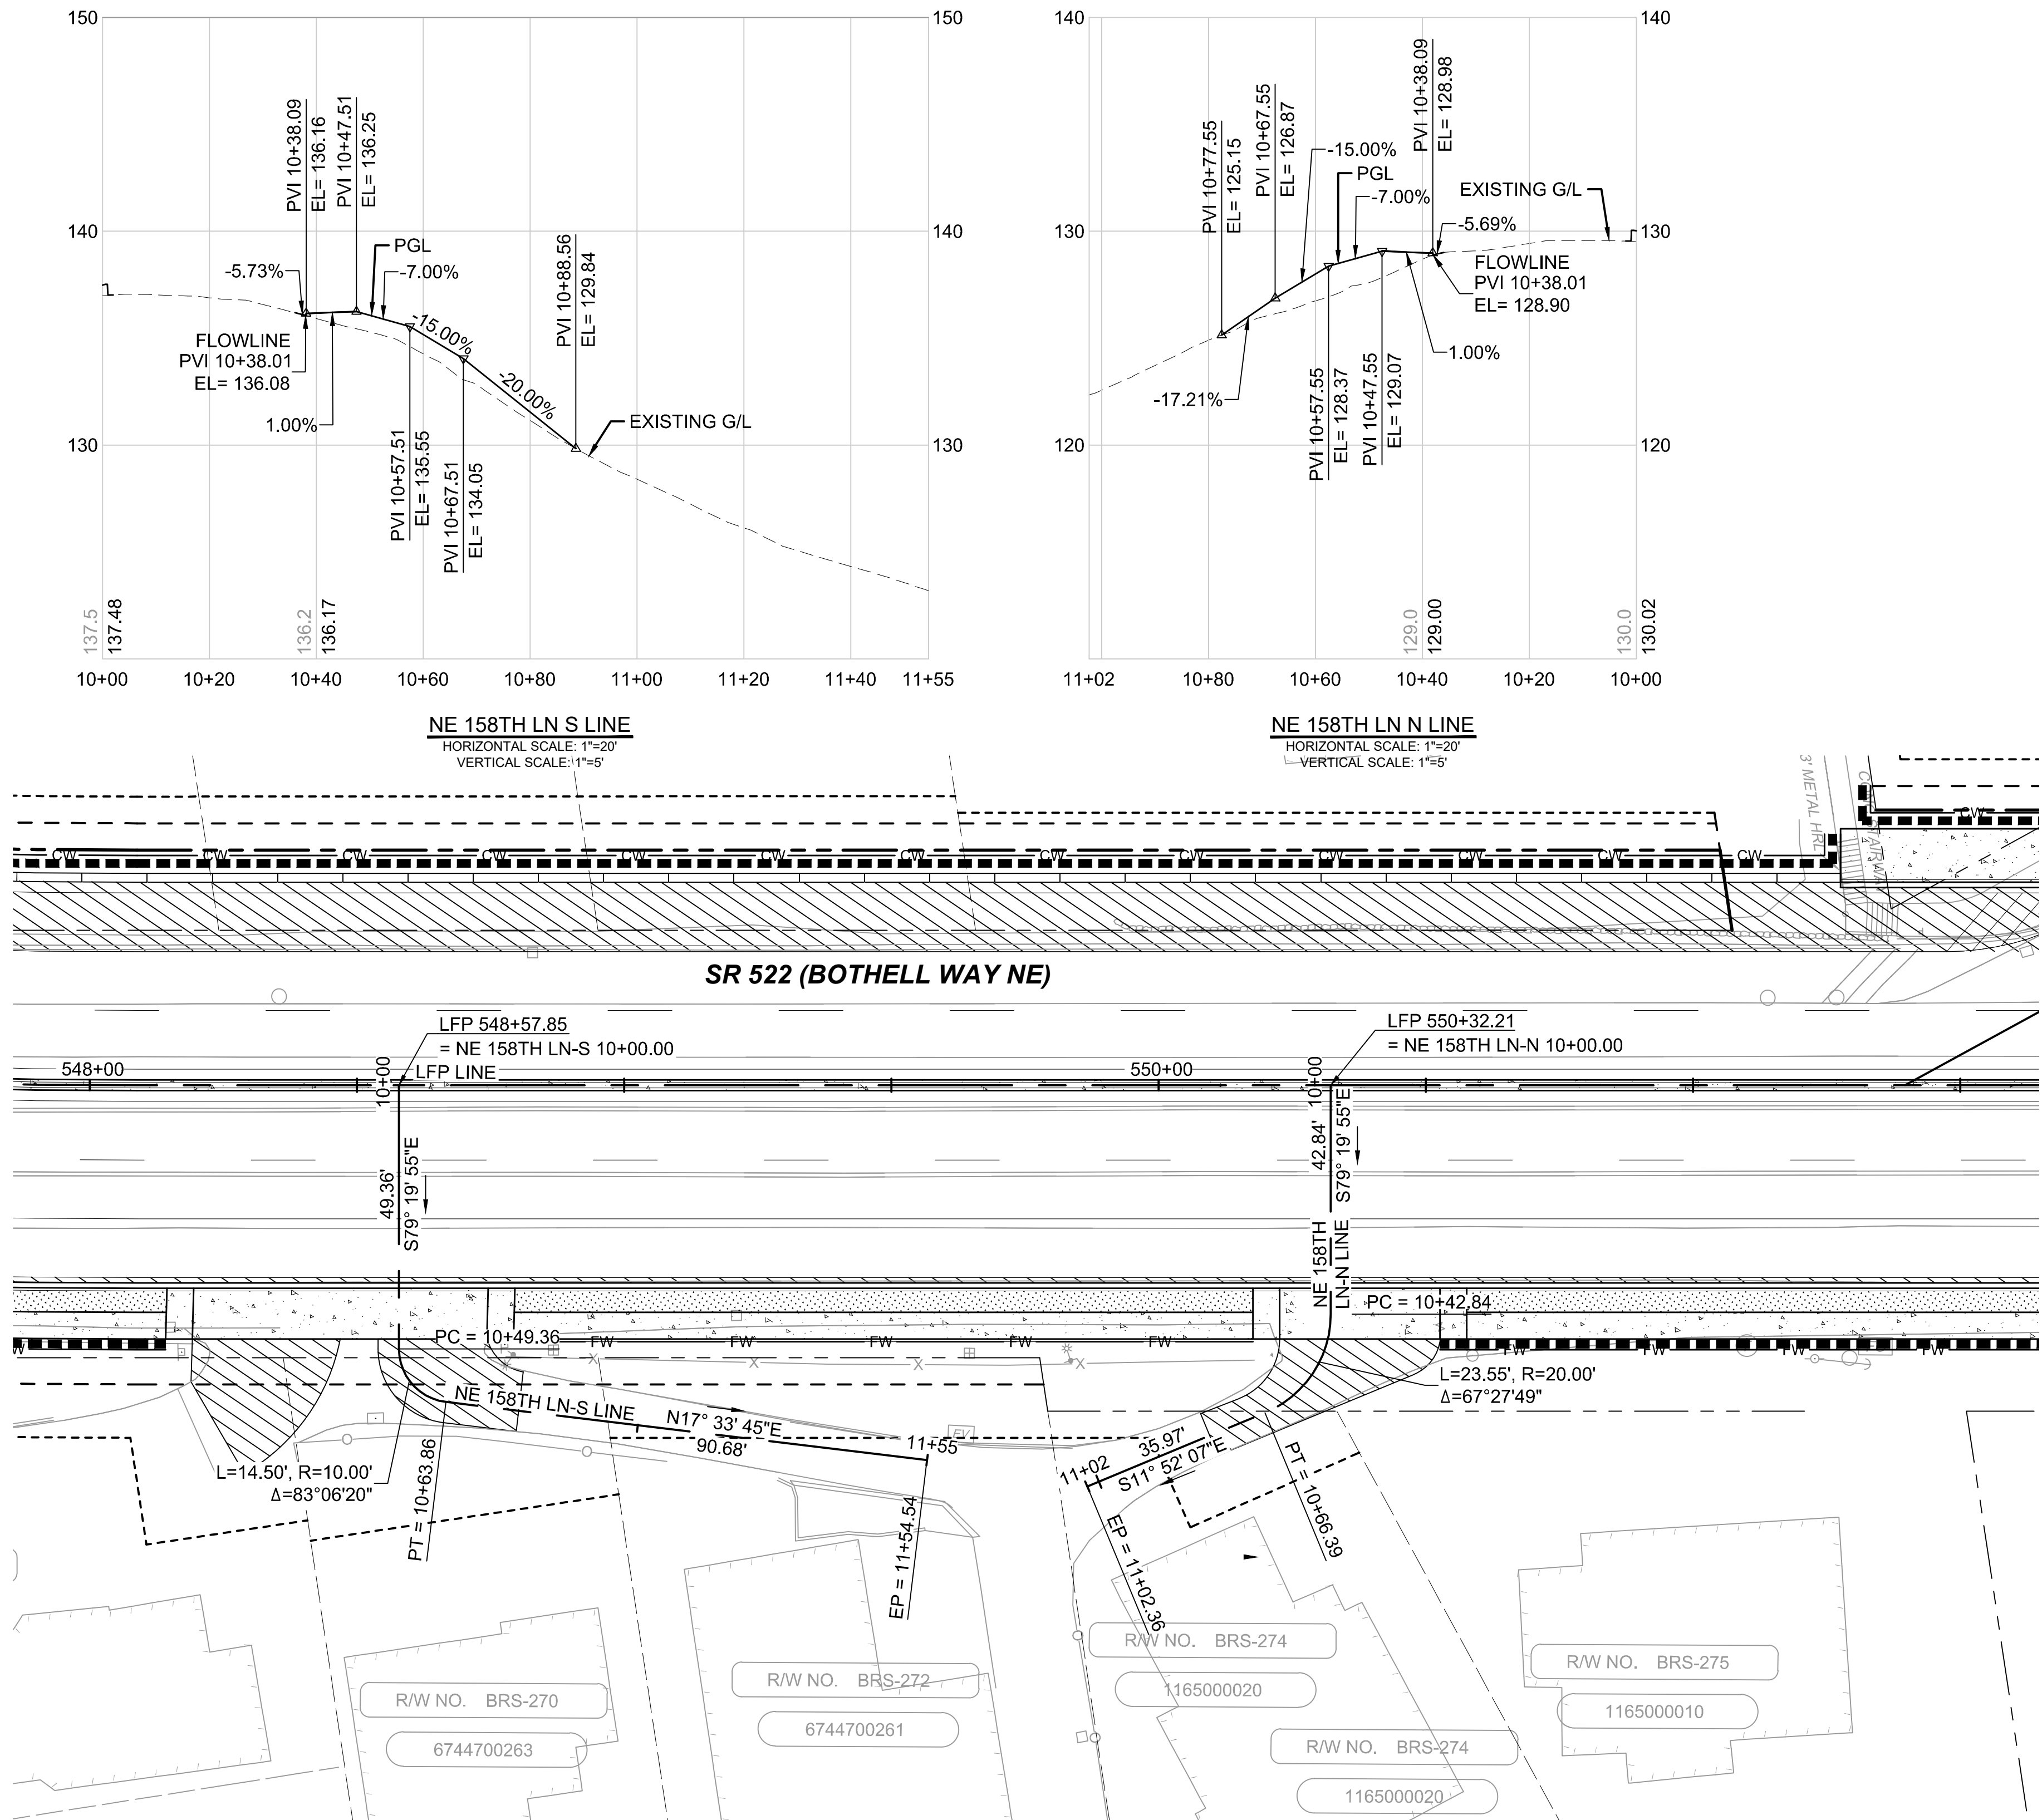

DRAFT 30% SUBMITTAL

DESIGNED BY:
C. MATYAS
DRAWN BY:
C. BRESLEY
CHECKED BY:
R.KOESTER
APPROVED BY:
M. FELIBERTI



DAVID EVANS
AND ASSOCIATES INC.
14432 SE Eastgate Way, Suite 400
Bellevue Washington 98007
Phone: 425.519.6500




LINE IS 1" AT
FULL SCALE



SCALE:
1"=20'
FILENAME:
BRT-522-CRV212-226
CONTRACT No.:
AE 0055-17
DATE:
09/11/2020

SR 522 / NE 145TH BRT
SR 522 (BOTHELL WAY NE)
CIVIL
DRIVEWAY PLAN AND PROFILES NE 158TH LN-N
& NE 158TH LN-S STA. 10+00 TO STA. 11+54.54

DRAWING No.:
522-CRV221
FACILITY ID:
522
SHEET No.:
125 OF 283
REV:

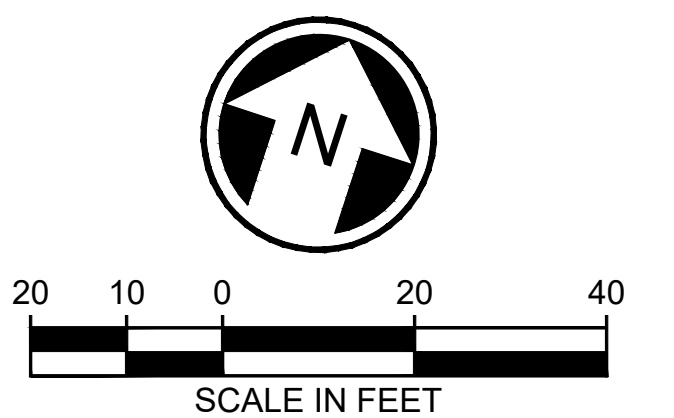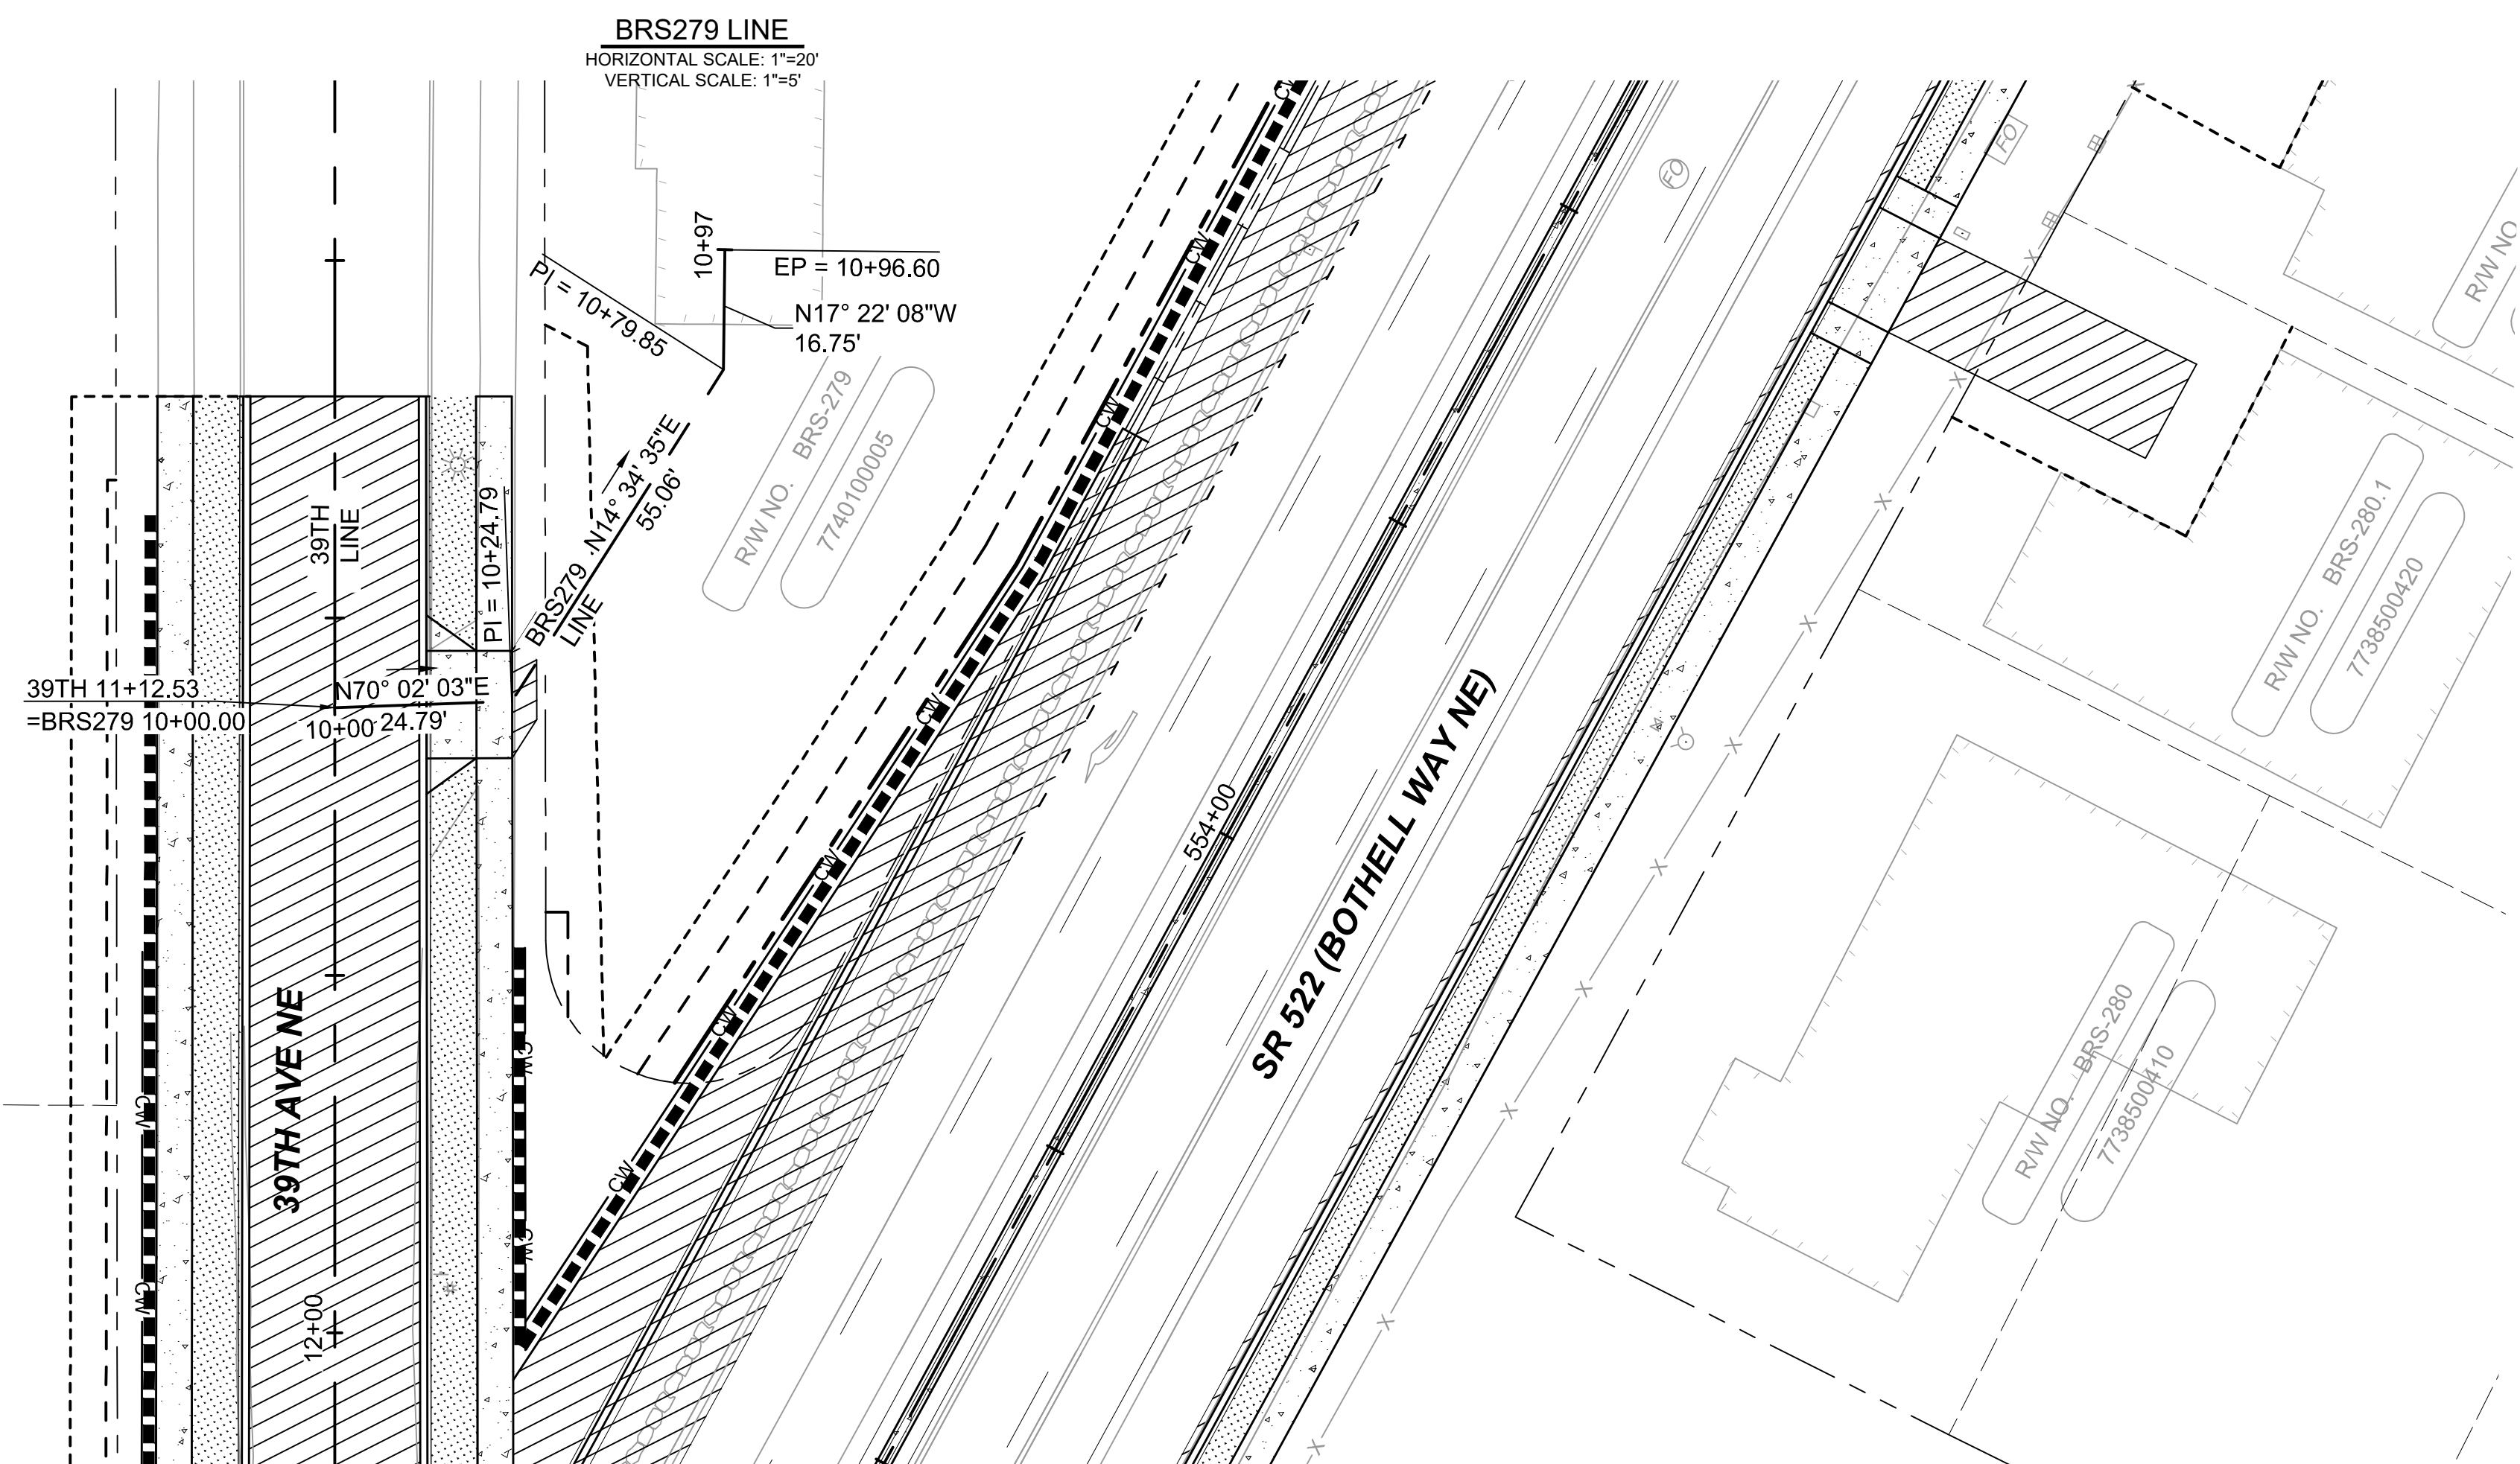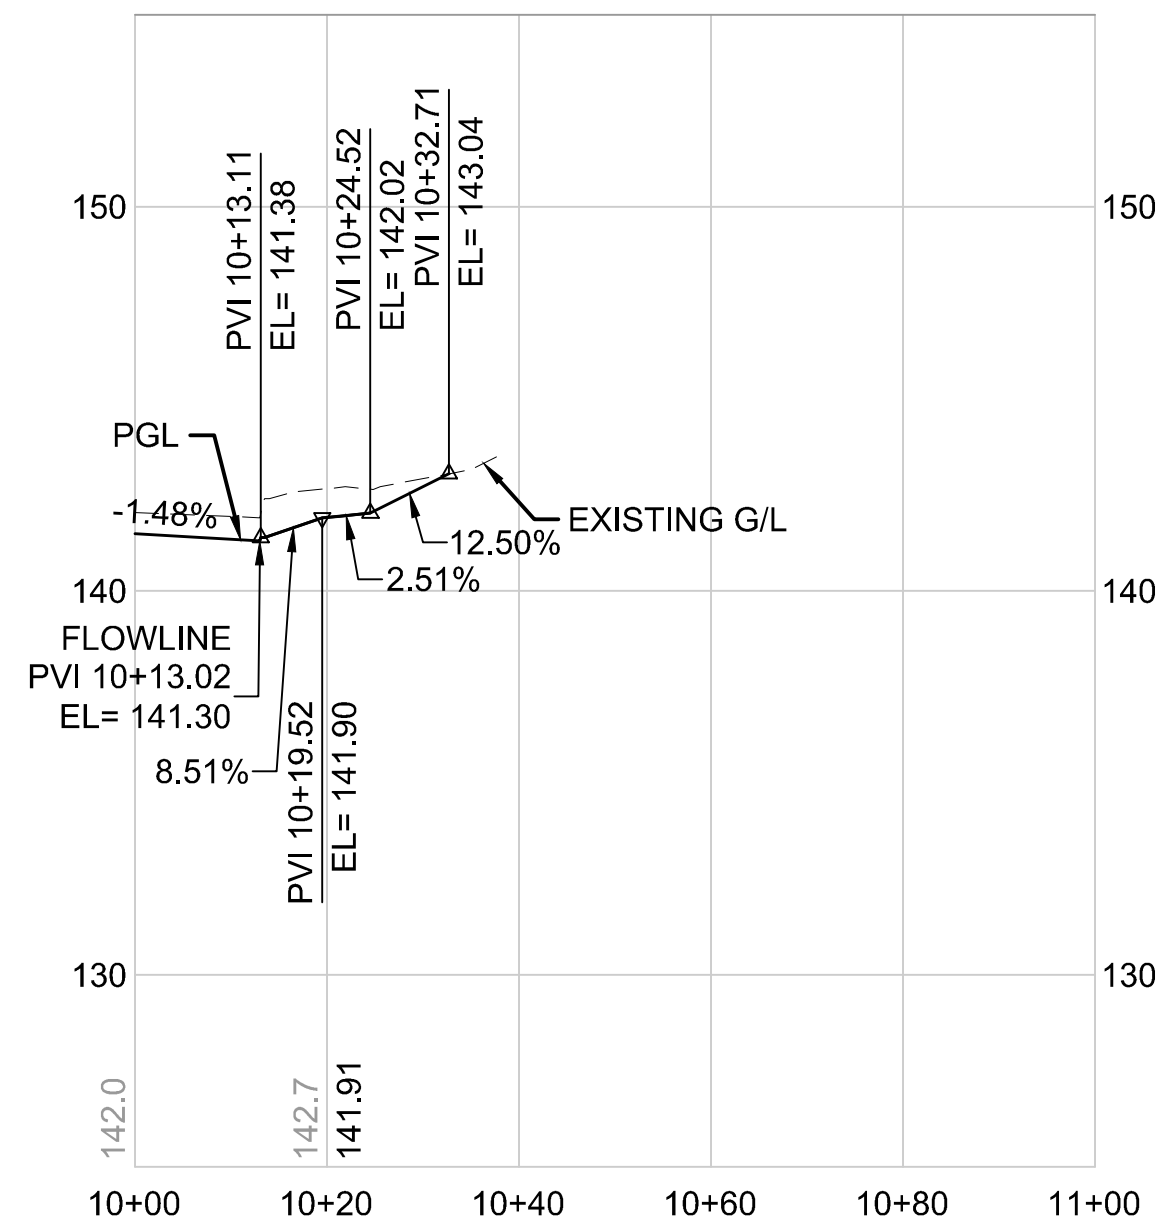

DRAFT 30% SUBMITTAL

No.	DATE	DSN	CHK	APP	REVISION

DESIGNED BY:	C.MATYAS
DRAWN BY:	C.BRESLEY
CHECKED BY:	R.KOESTER
APPROVED BY:	M.FELIBERTI



**DAVID EVANS
AND ASSOCIATES INC.**

14432 SE Eastgate Way, Suite 400
Bellevue Washington 98007
Phone: 425.519.6500

LINE IS 1" AT
FULL SCALE






SCALE:	1"=20'
FILENAME:	BRT-522-CRV212-226
CONTRACT No.:	AE 0055-17
DATE:	09/11/2020

SR 522 / NE 145TH BRT

SR 522 (BOTHILL WAY NE)
CIVIL
DRIVEWAY PLAN AND PROFILE BRS279
STA. 10+00 TO STA. 10+98.06

DRAWING No.:	
522-CRV222	
FACILITY ID:	
522	
SHEET No.:	REV:
126 OF 283	

09/10/20 | 1:32 AM | SJRO
C:\PW_WORK\DEA\STEVEN ROSE\DWG\BRT-522-CRV212-226.DWG

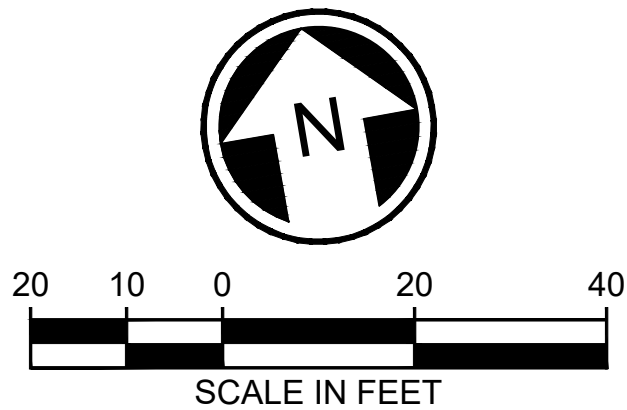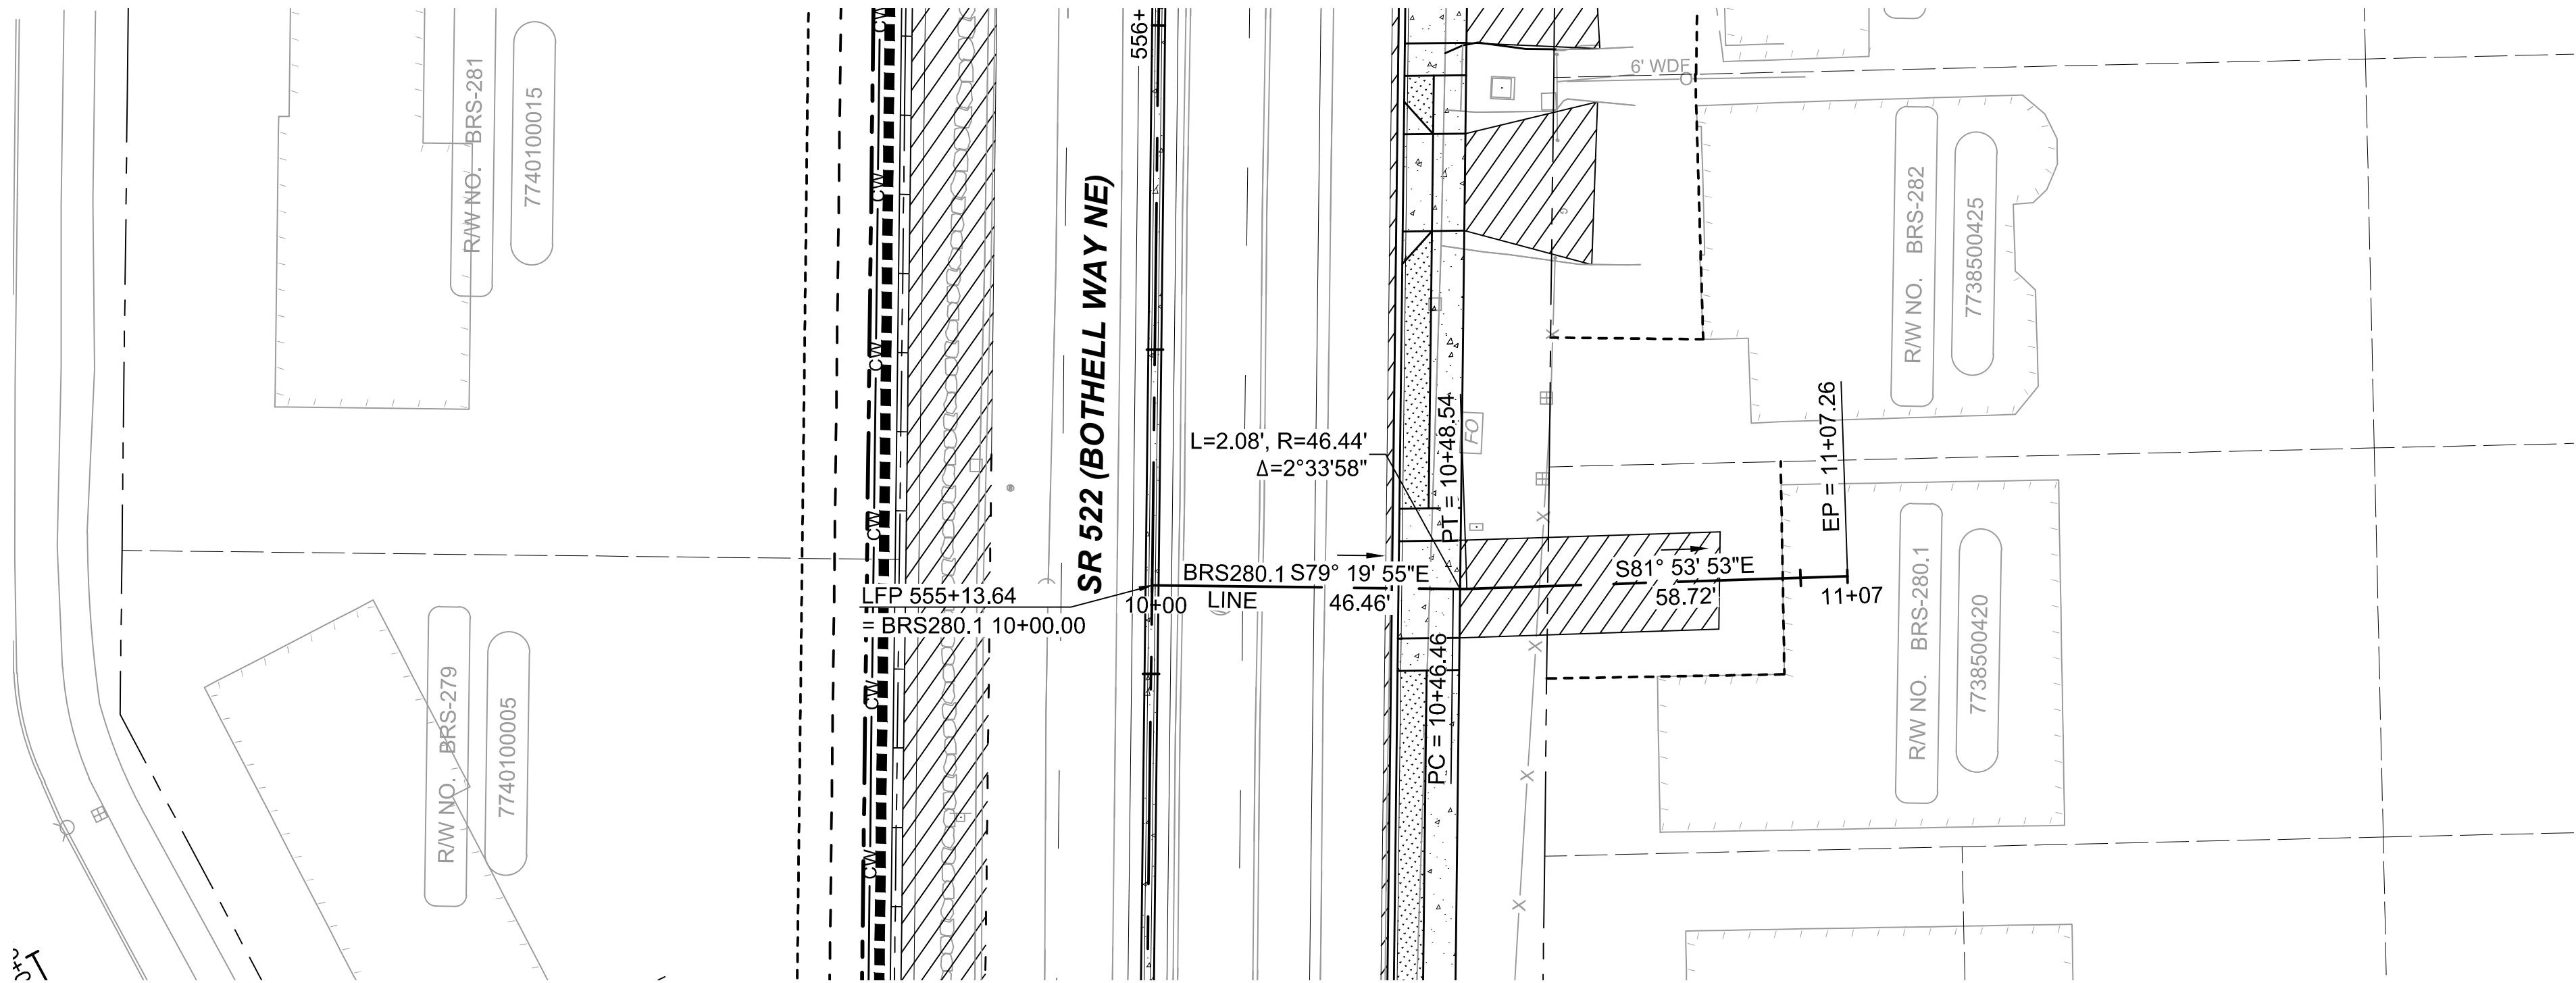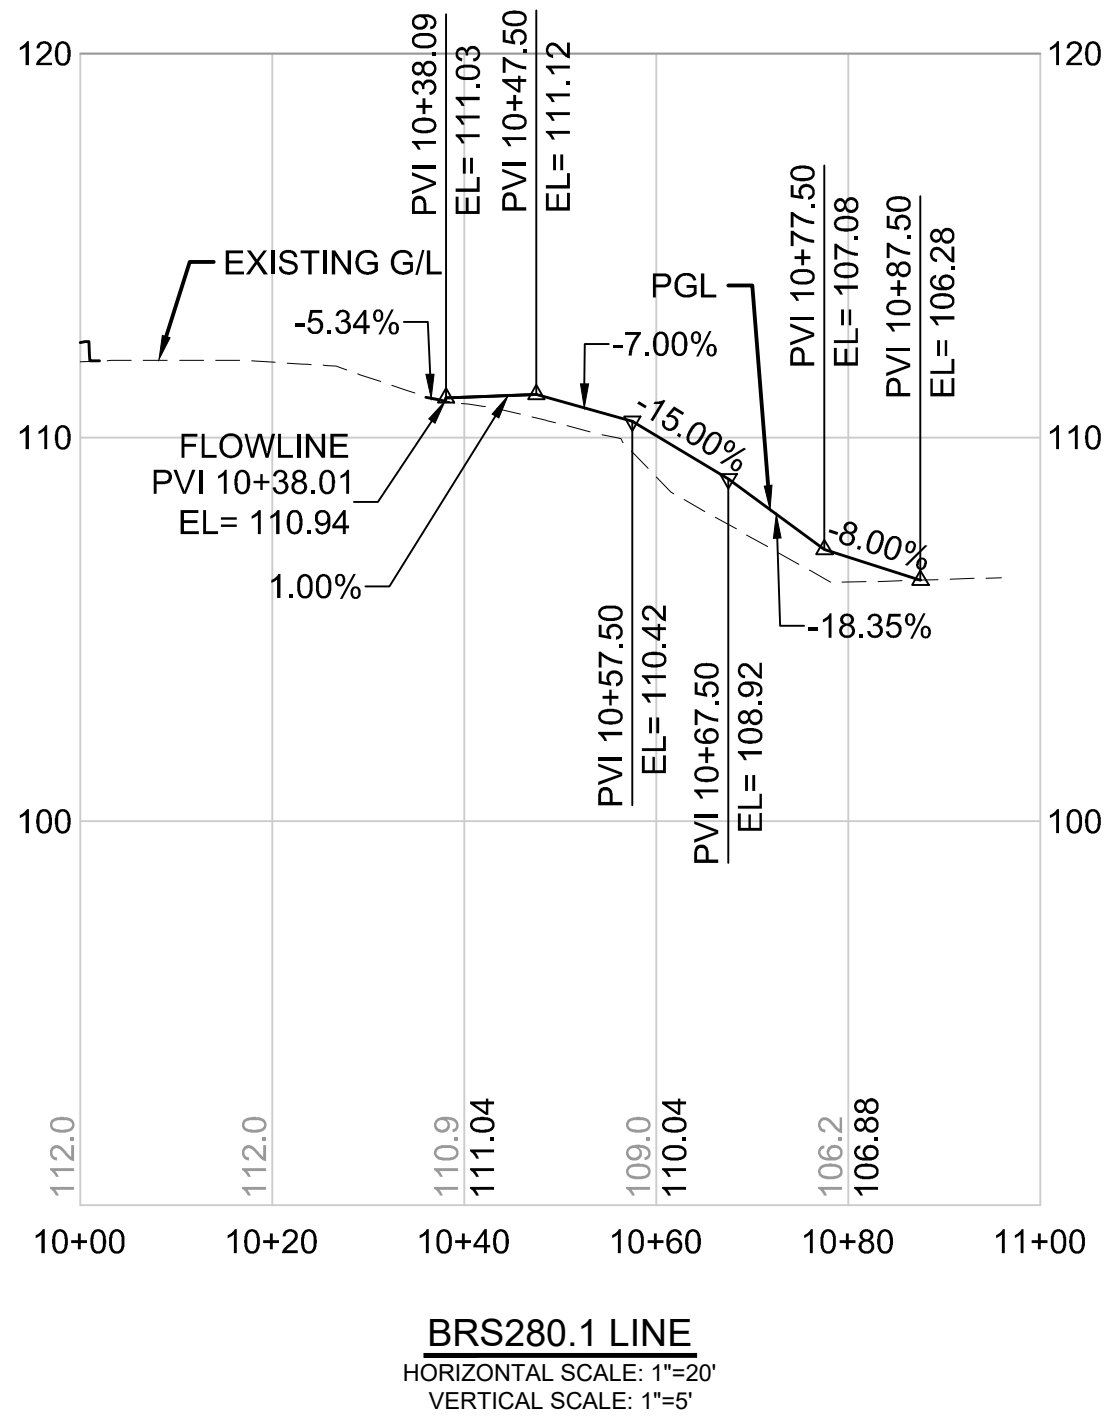

DRAFT 30% SUBMITTAL


No.	DATE	DSN	CHK	APP	REVISION

DESIGNED BY:	C.MATYAS
DRAWN BY:	C.BRESLEY
CHECKED BY:	R.KOESTER
APPROVED BY:	M.FELIBERTI



**DAVID EVANS
AND ASSOCIATES INC.**
14432 SE Eastgate Way, Suite 400
Bellevue Washington 98007
Phone: 425.519.6500

SUBMITTED BY:	DATE:	REVIEWED BY:	DATE:
D.SCHOCK	09/11/2020	B.KEMPER	09/11/2020

 




SOUND TRANSIT

SCALE:	1"=20'
FILENAME:	BRT-522-CRV212-226
CONTRACT No.:	AE 0055-17
DATE:	09/11/2020

SR 522 / NE 145TH BRT
SR 522 (BOTHELL WAY NE)
CIVIL
DRIVEWAY PLAN AND PROFILE BRS280.1
STA. 10+00 TO STA. 11+07.26





DRAWING No.:	522-CRV223
FACILITY ID:	522
SHEET No.:	127 OF 283
REV:	

09/10/20 | 1:33 AM | SJRO
C:\PW_WORK\DEA\STEVEN ROSE\DWG\506735\BRT-522-CRV212-226.DWG

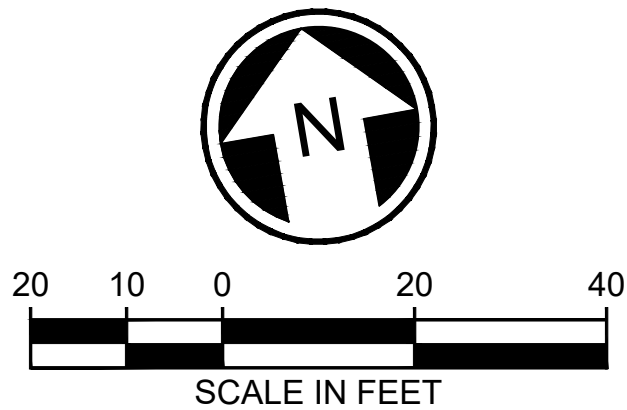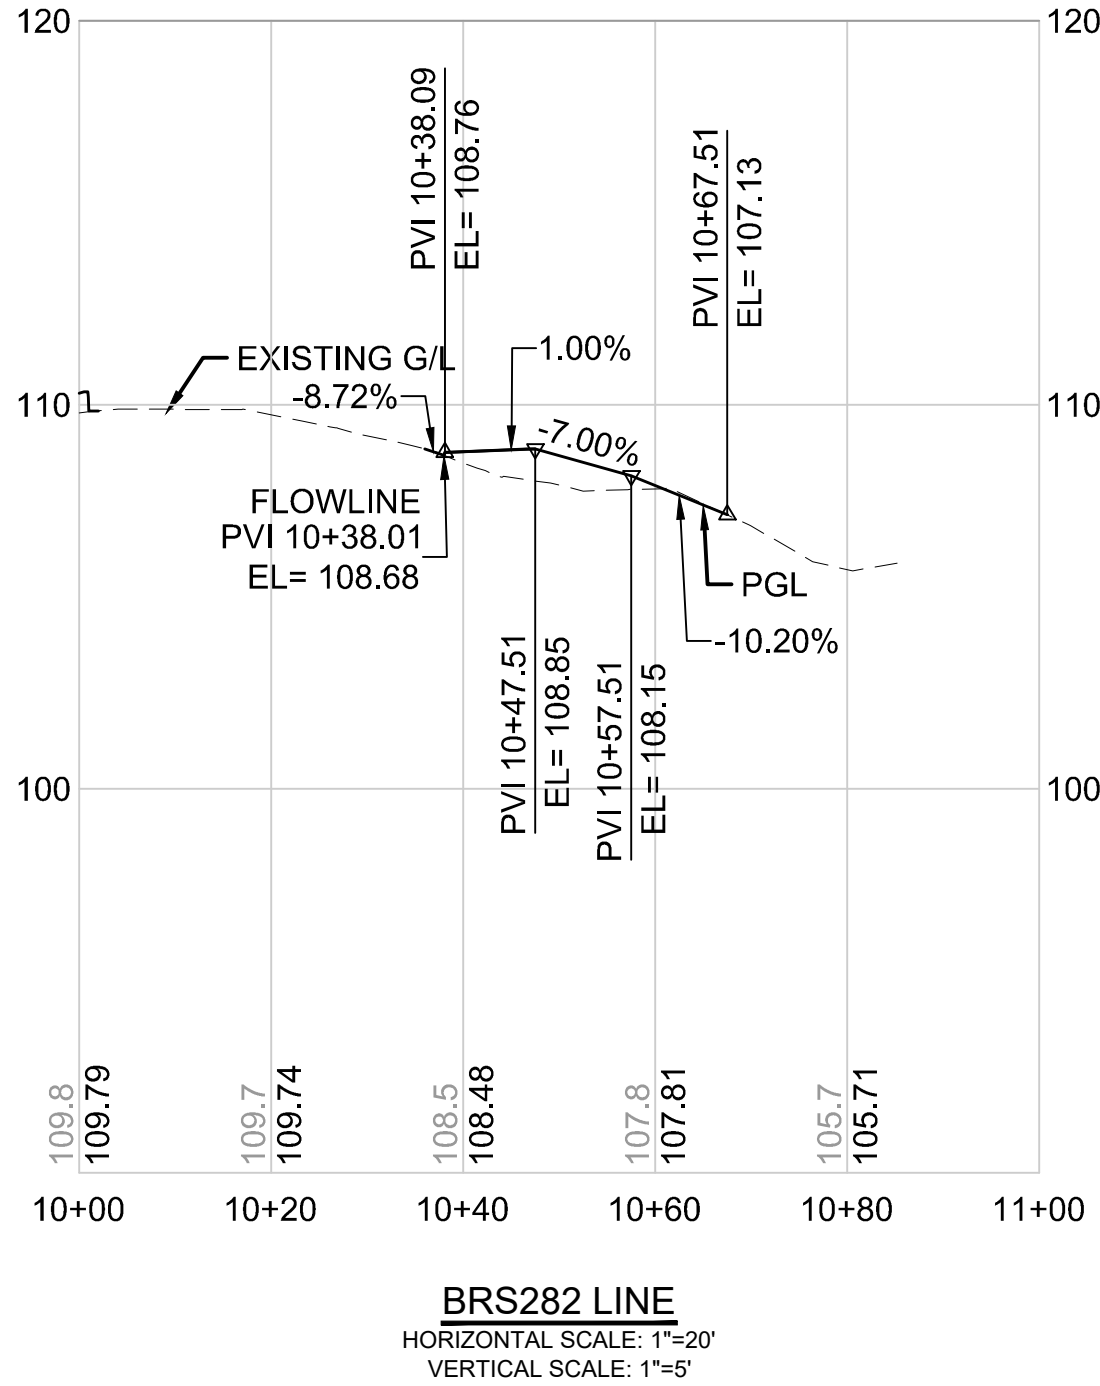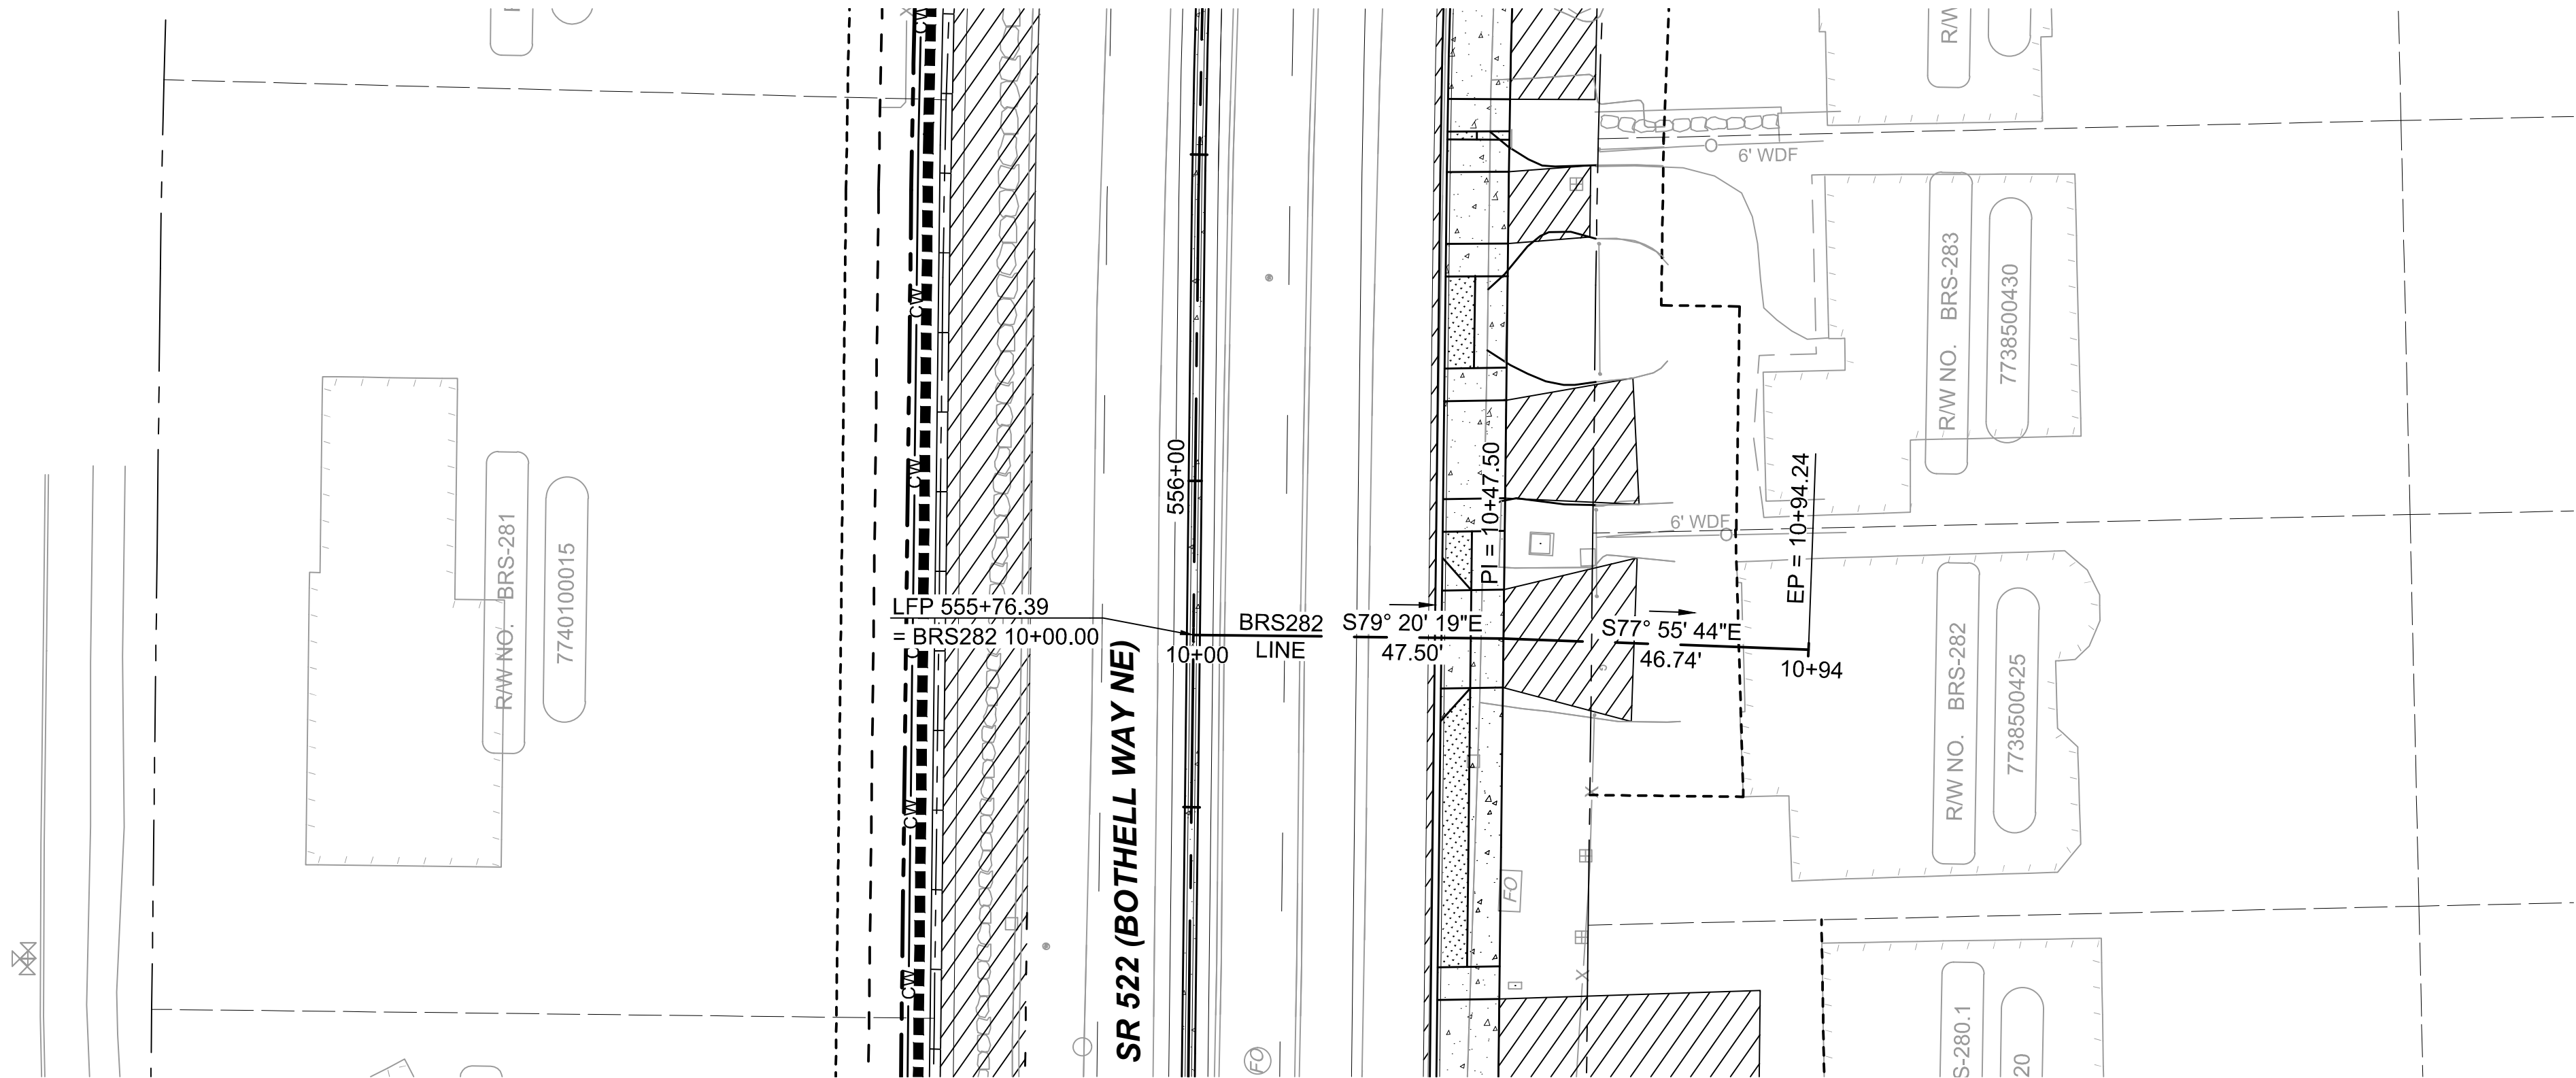

DRAFT 30% SUBMITTAL						DESIGNED BY: C.MATYAS		 DAVID EVANS AND ASSOCIATES INC. 14432 SE Eastgate Way, Suite 400 Bellevue Washington 98007 Phone: 425.519.6500			LINE IS 1" AT FULL SCALE 	SCALE: 1"=20'	SR 522 / NE 145TH BRT SR 522 (BOTHELL WAY NE) CIVIL DRIVEWAY PLAN AND PROFILE BRS282 STA. 10+00 TO STA. 10+94.24						DRAWING No.: 522-CRV224																																																																																																																																																																																																																																																																																																																																																																																																																																																																																										
DRAWN BY: C.BRESLEY	FILENAME: BRT-522-CRV212-226	FACILITY ID: 522																																																																																																																																																																																																																																																																																																																																																																																																																																																																																																											
CHECKED BY: R.KOESTER	CONTRACT No.: AE 0055-17	SHEET No.: 128 OF 283																																																																																																																																																																																																																																																																																																																																																																																																																																																																																																											
APPROVED BY:	DATE:			REVIEWED BY:	DATE:																																																																																																																																																																																																																																																																																																																																																																																																																																																																																																								
M.FELIBERTI	D.SCHOCK			09/11/2020	B.KEMPER	09/11/2020																																																																																																																																																																																																																																																																																																																																																																																																																																																																																																							
No.	DATE	DSN	CHK	APP	REVISION																																																																																																																																																																																																																																																																																																																																																																																																																																																																																																								

09/10/20 | 1:34 AM | SJRO
C:\PW_WORK\DEA\STEVEN ROSE\DWG\506735\BRT-522-CRV212-226.DWG

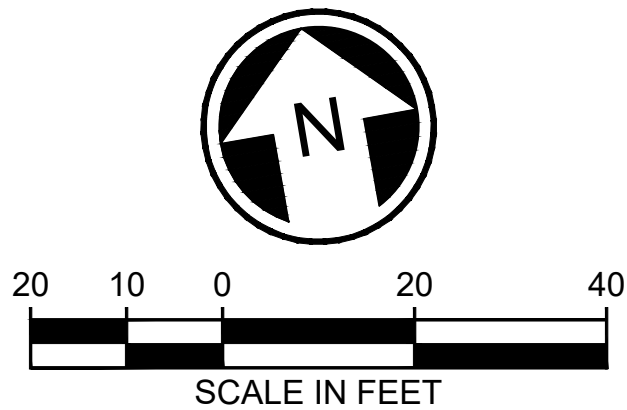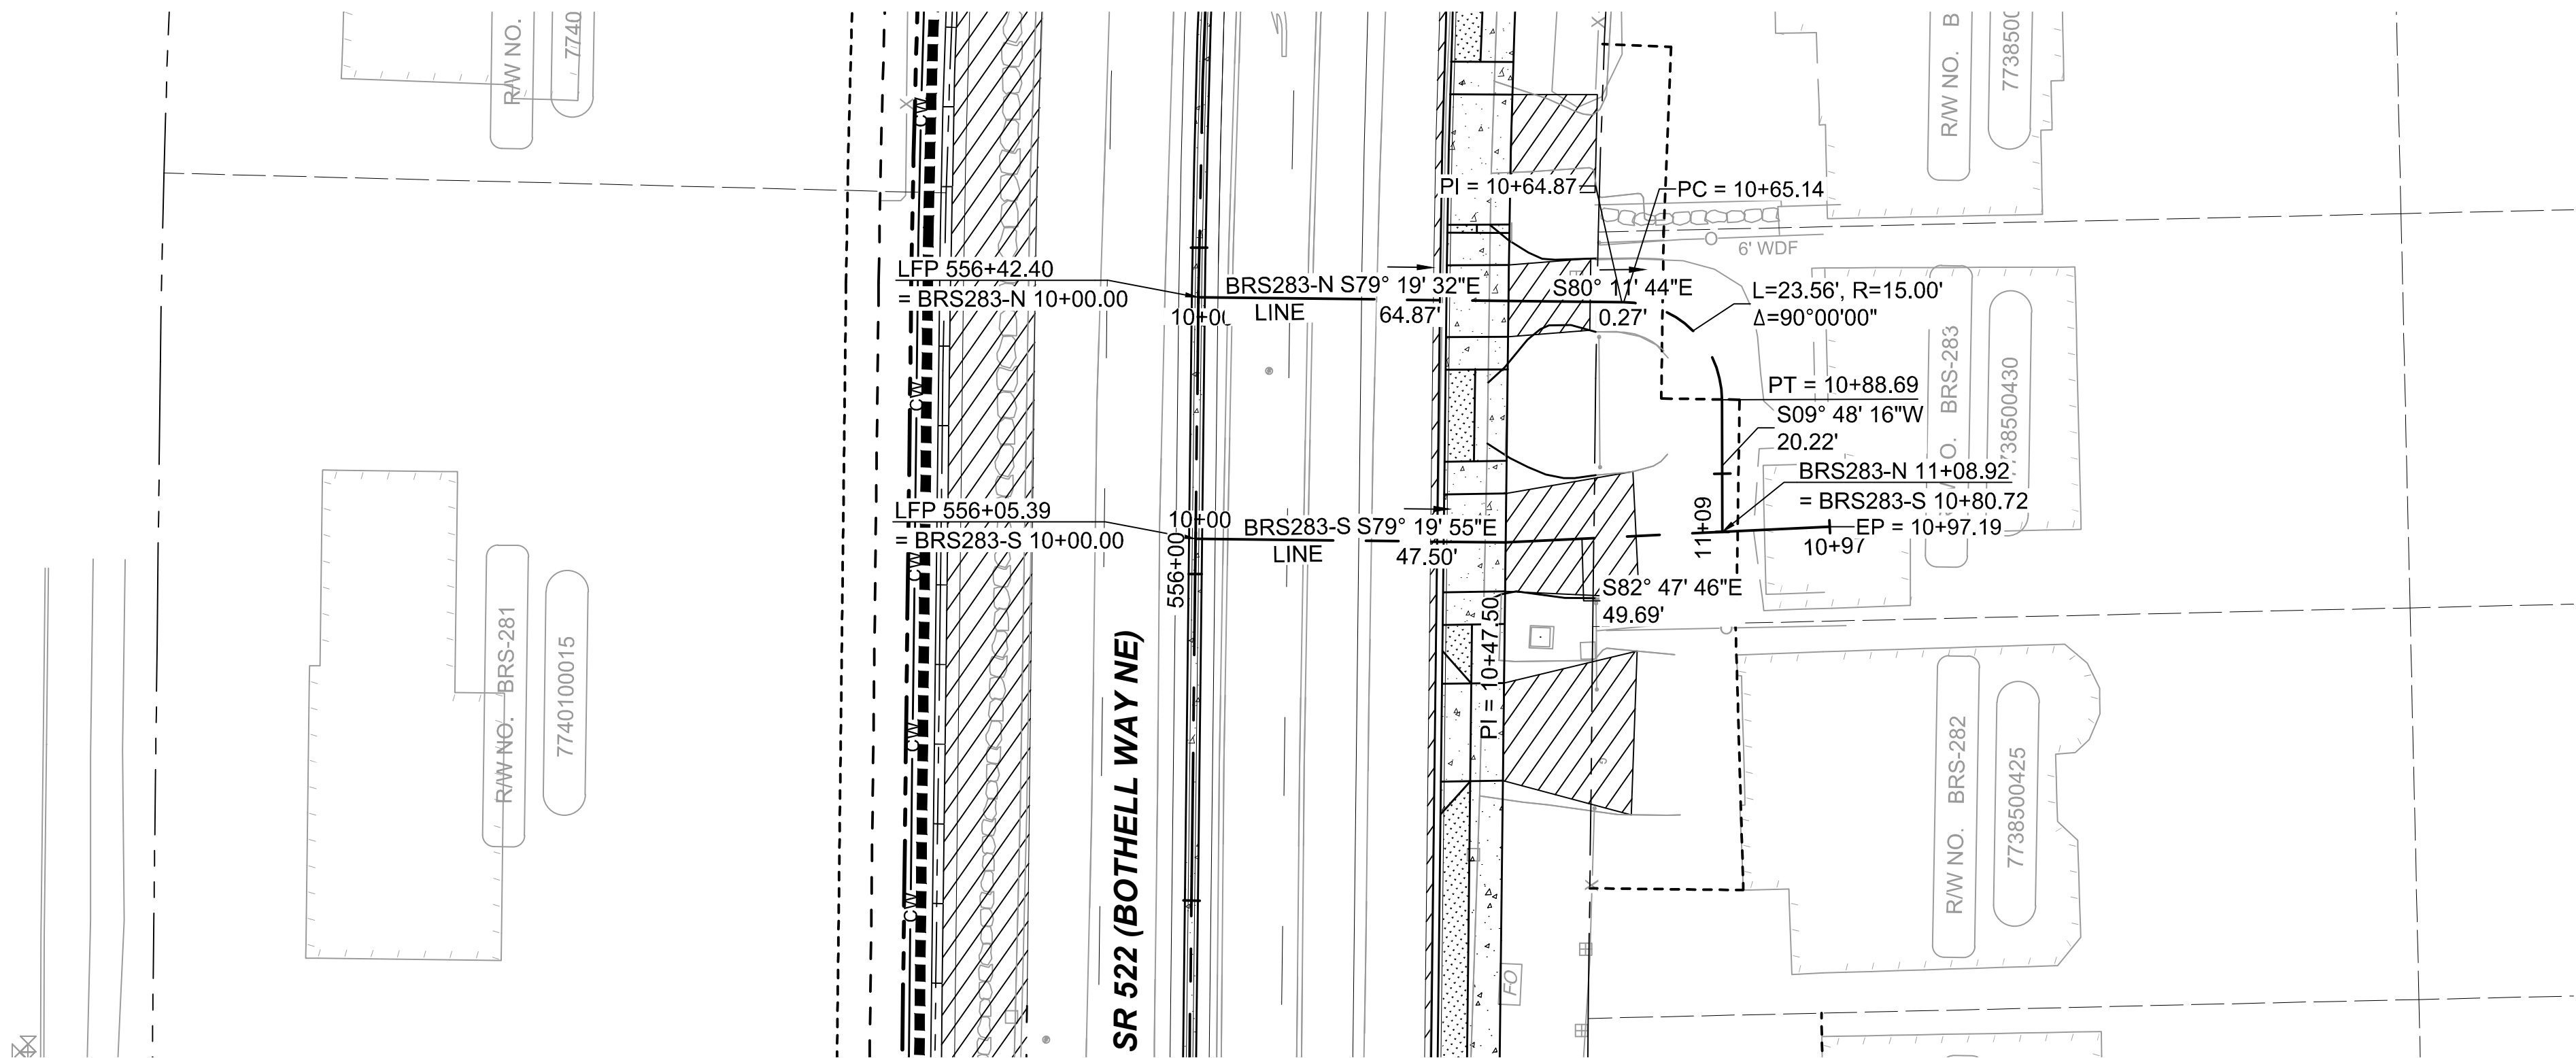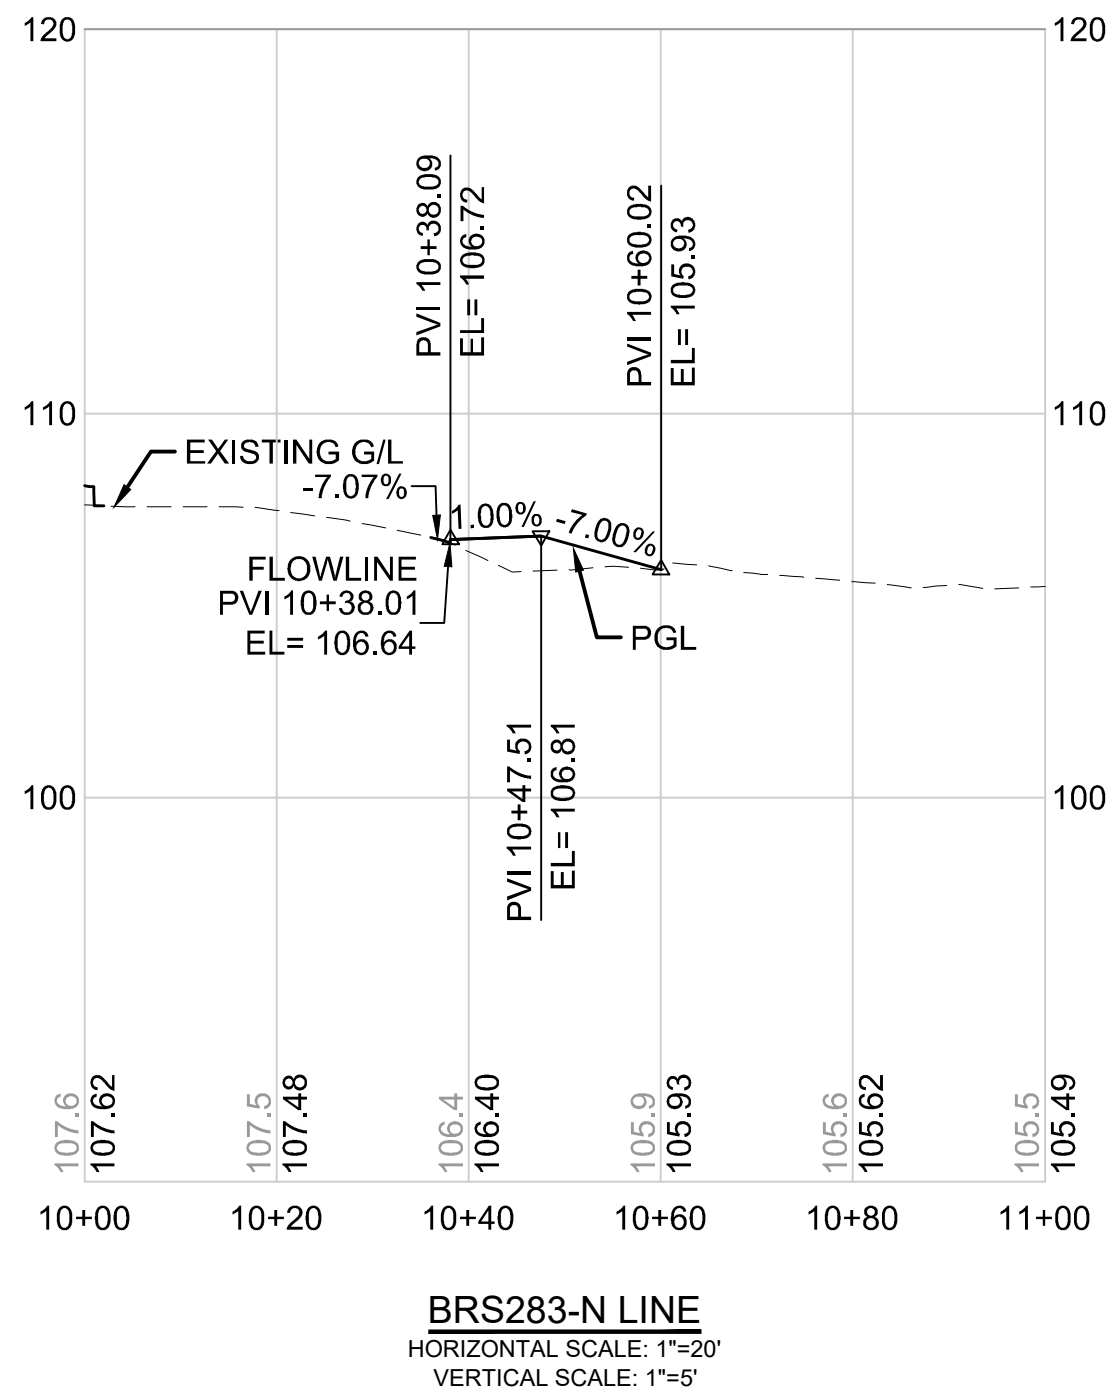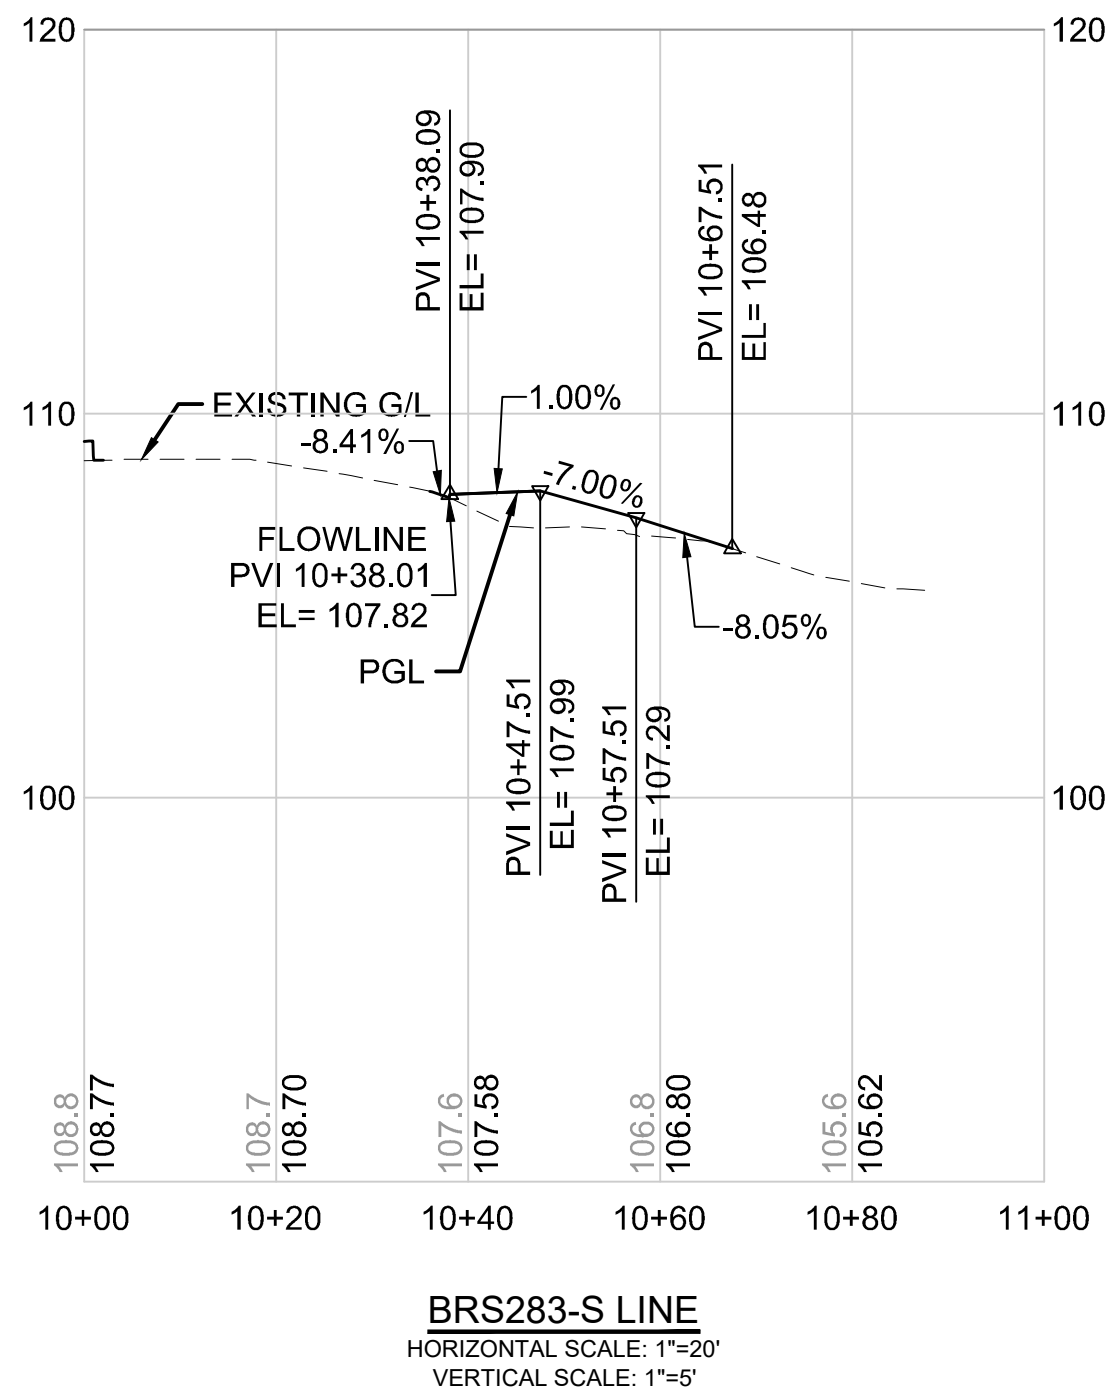

DRAFT 30% SUBMITTAL

DESIGNED BY:
C.MATYAS
DRAWN BY:
C.BRESLEY
CHECKED BY:
R.KOESTER
APPROVED BY:
M.FELIBERTI



**DAVID EVANS
AND ASSOCIATES INC.**
14432 SE Eastgate Way, Suite 400
Bellevue Washington 98007
Phone: 425.519.6500

SUBMITTED BY:
D.SCHOCK

DATE:
09/11/2020

REVIEWED BY:
B.KEMPER






DATE:
09/11/2020

SCALE:
1"=20'
FILENAME:
BRT-522-CRV212-226
CONTRACT No.:
AE 0055-17
DATE:
09/11/2020

SR 522 / NE 145TH BRT
SR 522 (BOTHELL WAY NE)
CIVIL
DRIVEWAY PLAN AND PROFILES BRS283-S & BRS283-N
STA. 10+00 TO STA. 11+08.92


DRAWING No.:
522-CRV225
FACILITY ID:
522
SHEET No.:
129 OF 283
REV:

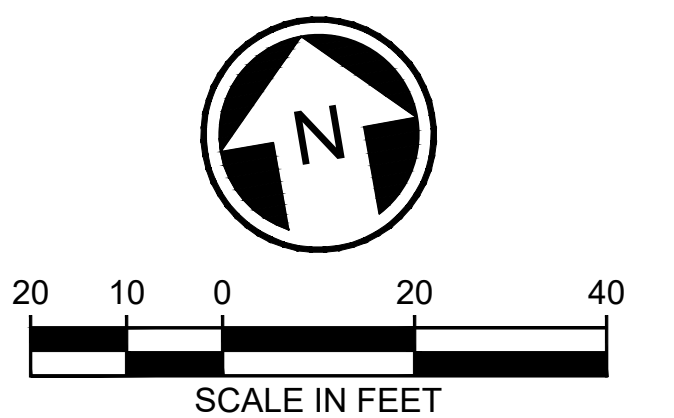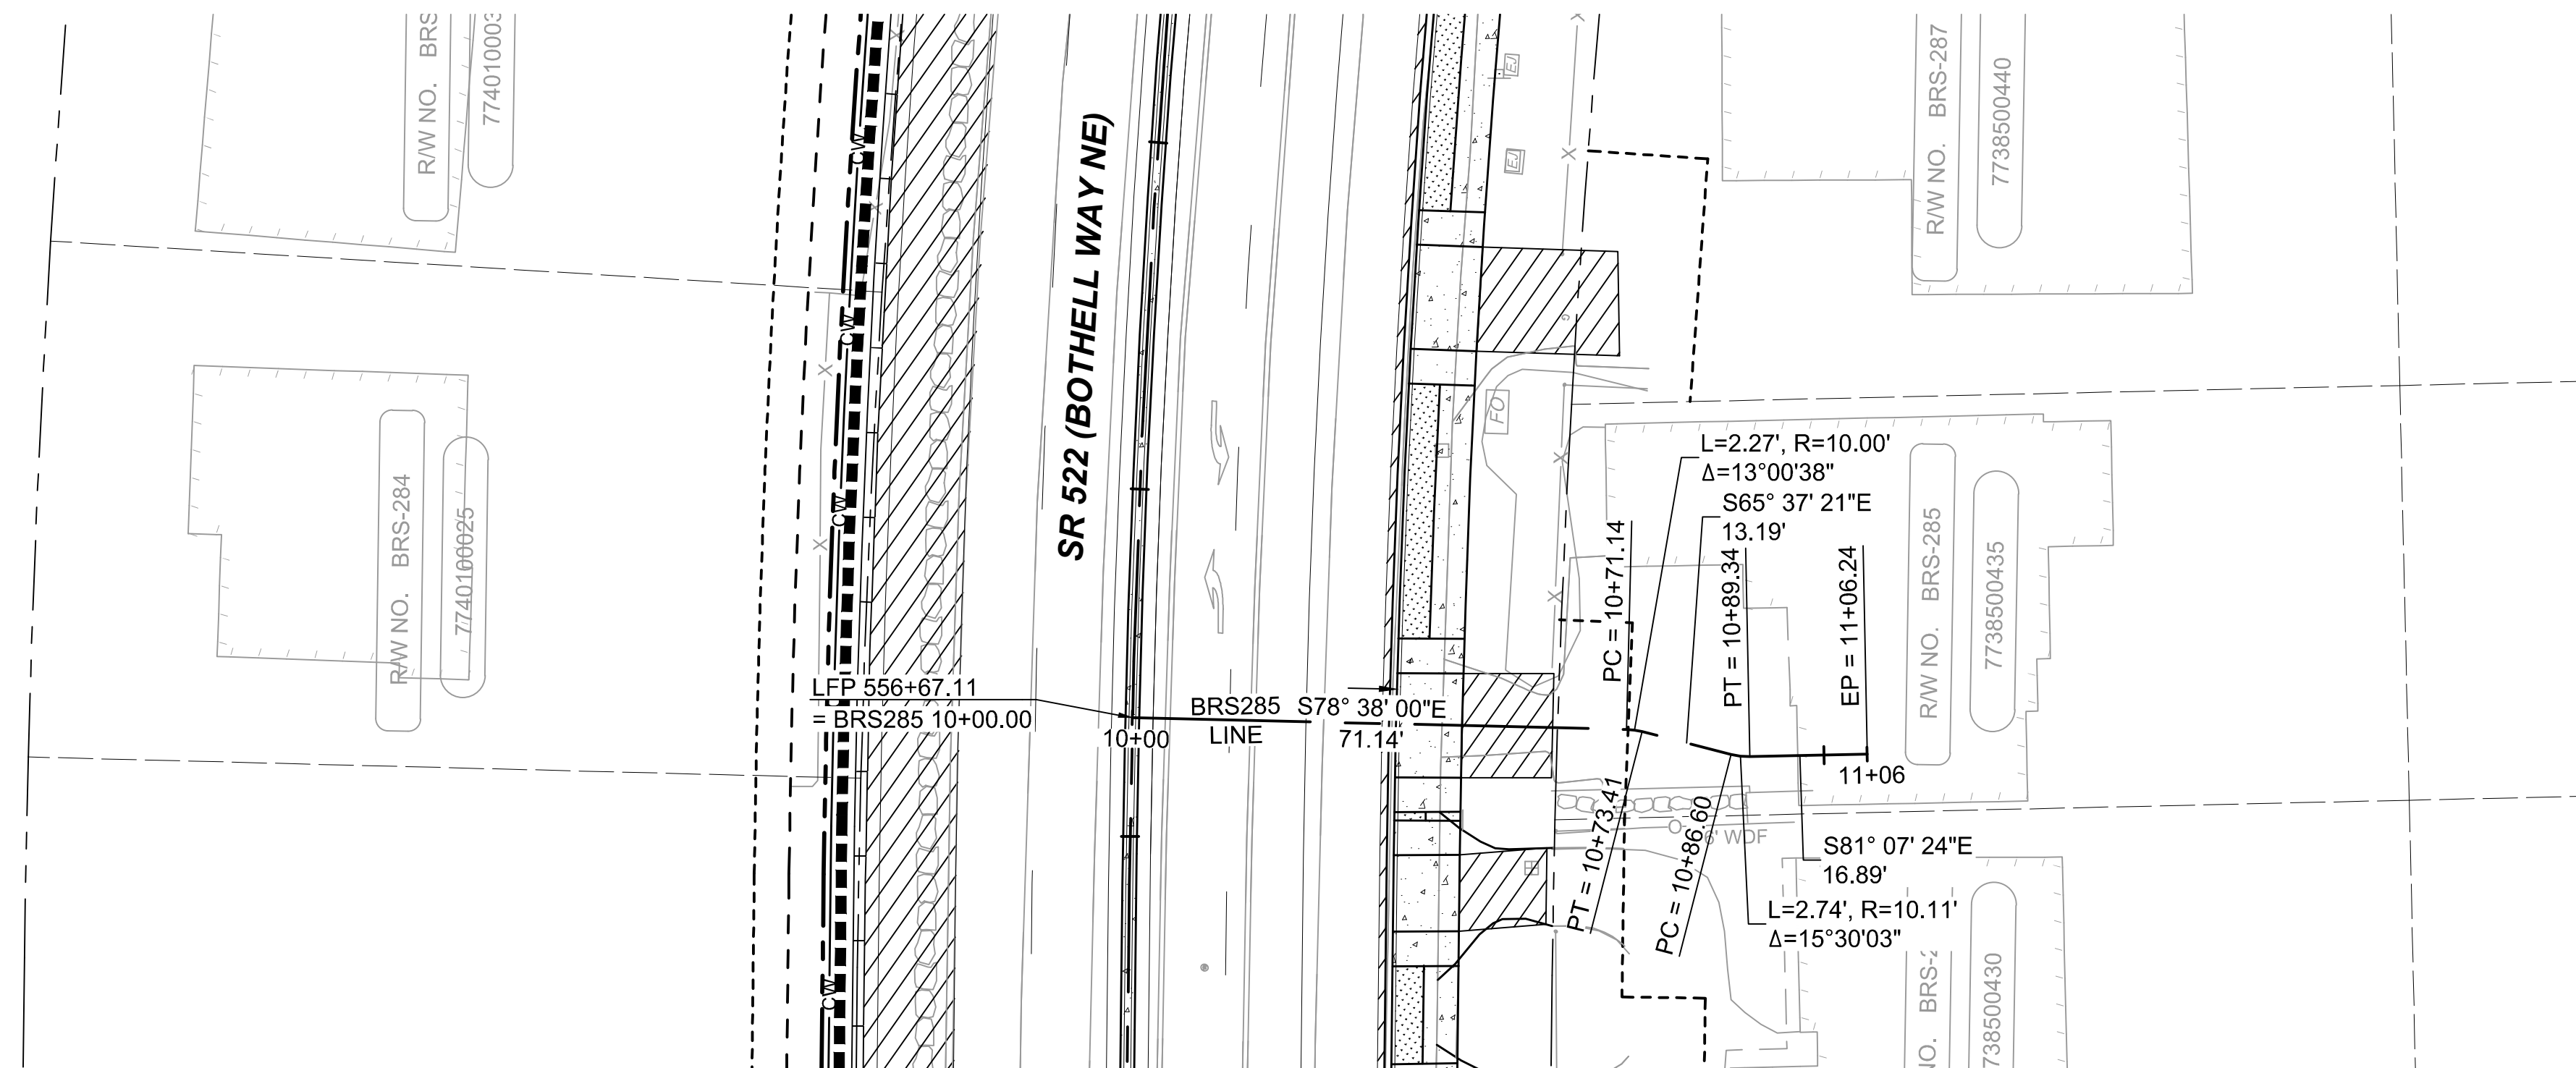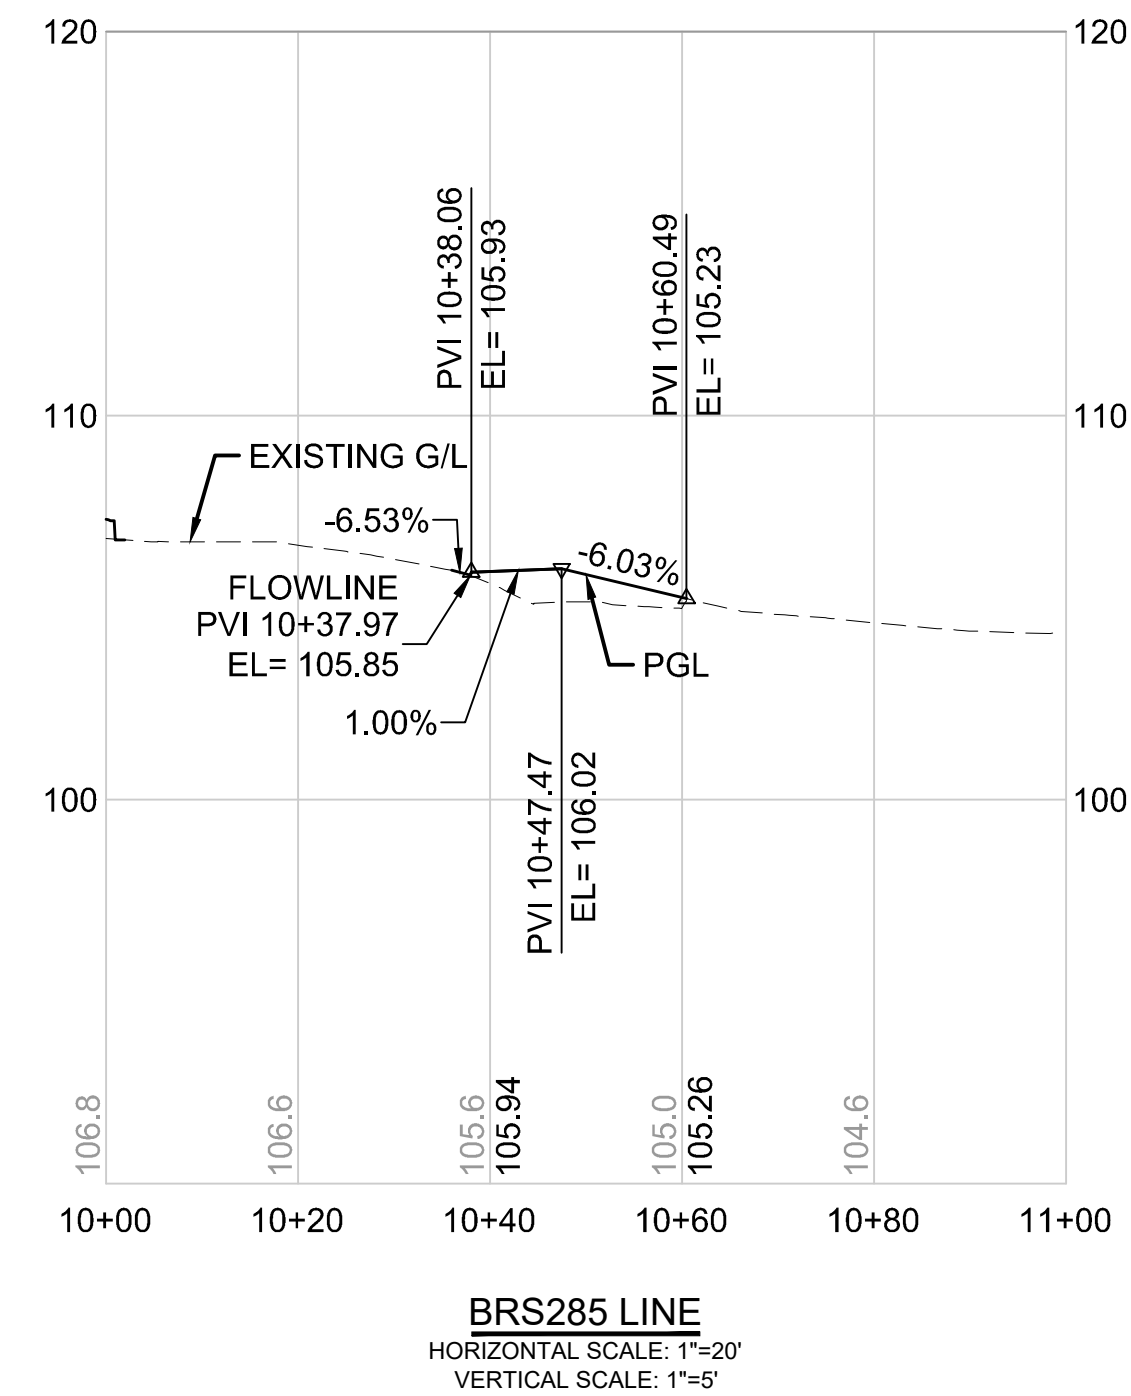

DRAFT 30% SUBMITTAL

No.	DATE	DSN	CHK	APP	REVISION

DESIGNED BY:	C.MATYAS
DRAWN BY:	C.BRESLEY
CHECKED BY:	R.KOESTER
APPROVED BY:	M.FELIBERTI

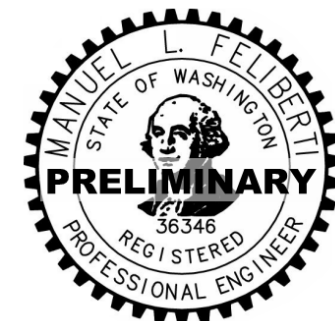

**DAVID EVANS
AND ASSOCIATES INC.**
14432 SE Eastgate Way, Suite 400
Bellevue Washington 98007
Phone: 425.519.6500

LINE IS 1" AT



SCALE:	1"=20'
FILENAME:	BRT-522-CRV212-226
CONTRACT No.:	AE 0055-17
DATE:	09/11/2020

SR 522 / NE 145TH BRT

SR 522 (BOTHELL WAY NE)


CIVIL

DRIVEWAY PLAN AND PROFILE BRS285


STA. 10+00 TO STA. 11+06.24

DRAWING No.:	
522-CRV226	
FACILITY ID:	
522	
SHEET No.:	REV:
130 OF 283	

09/10/20 | 1:40 AM | SJRO
C:\PW_WORK\DEA\STEVEN ROSE\DWG\BRT-522-CRV227-236.DWG

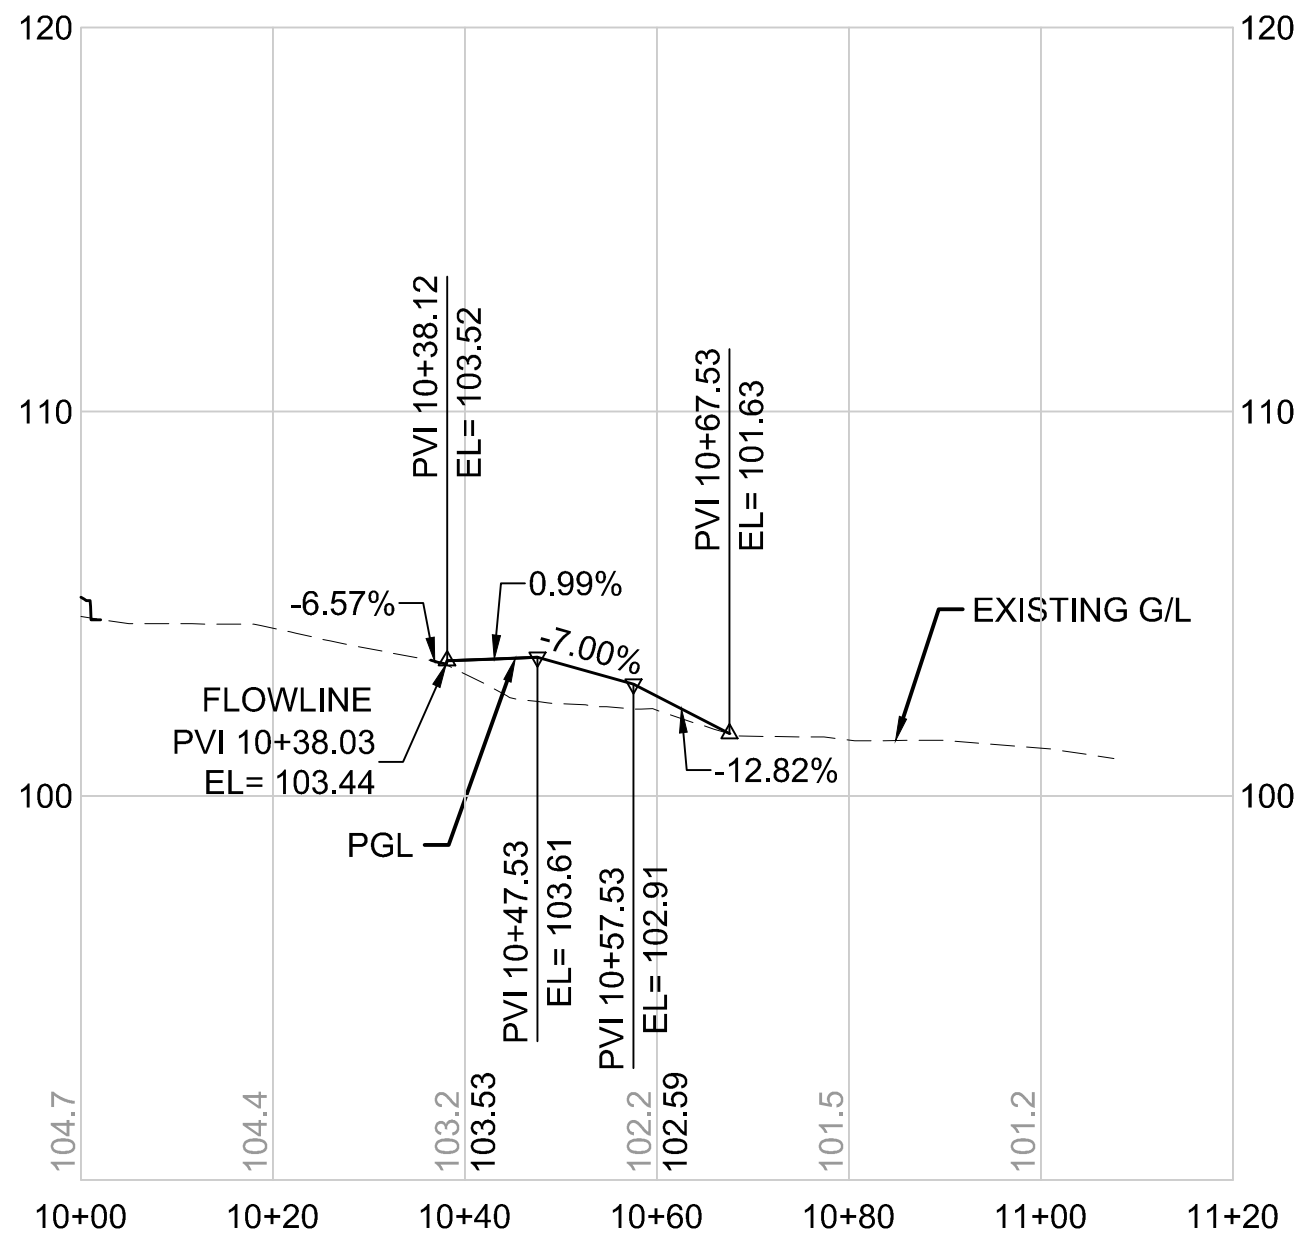

BRS287 LINE
HORIZONTAL SCALE: 1"=20'
VERTICAL SCALE: 1"=5'

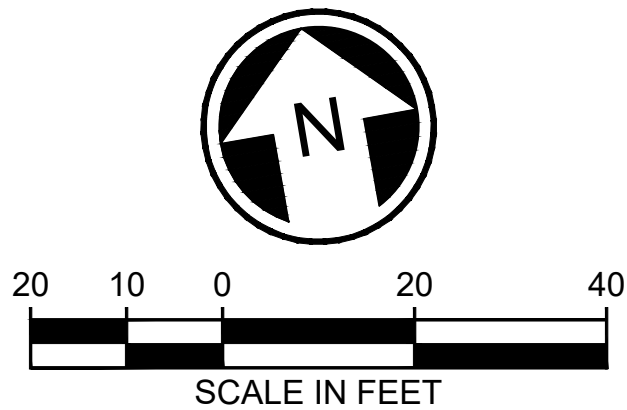

DRAFT 30% SUBMITTAL


No.	DATE	DSN	CHK	APP	REVISION

DESIGNED BY:	C.MATYAS
DRAWN BY:	C.BRESLEY
CHECKED BY:	R.KOESTER
APPROVED BY:	M.FELIBERTI



DAVID EVANS
AND ASSOCIATES INC.
14432 SE Eastgate Way, Suite 400
Bellevue Washington 98007
Phone: 425.519.6500

SUBMITTED BY:	DATE:	REVIEWED BY:
D.SCHOCK	09/11/2020	B.KEMPER

 


SOUNDTRANSIT

SCALE:	1"=20'
FILENAME:	BRT-522-CRV227-236
CONTRACT No.:	AE 0055-17
DATE:	09/11/2020


SR 522 / NE 145TH BRT
SR 522 (BOTHELL WAY NE)
CIVIL
DRIVEWAY PLAN AND PROFILE BRS287
STA. 10+00 TO STA. 11+19.77

DRAWING No.:	522-CRV227
FACILITY ID:	522
SHEET No.:	131 OF 283



09/10/20 | 1:42 AM | SJRO
C:\PW_WORK\DEA\STEVEN ROSE\DWG\522\BRT-522-CRV227-236.DWG

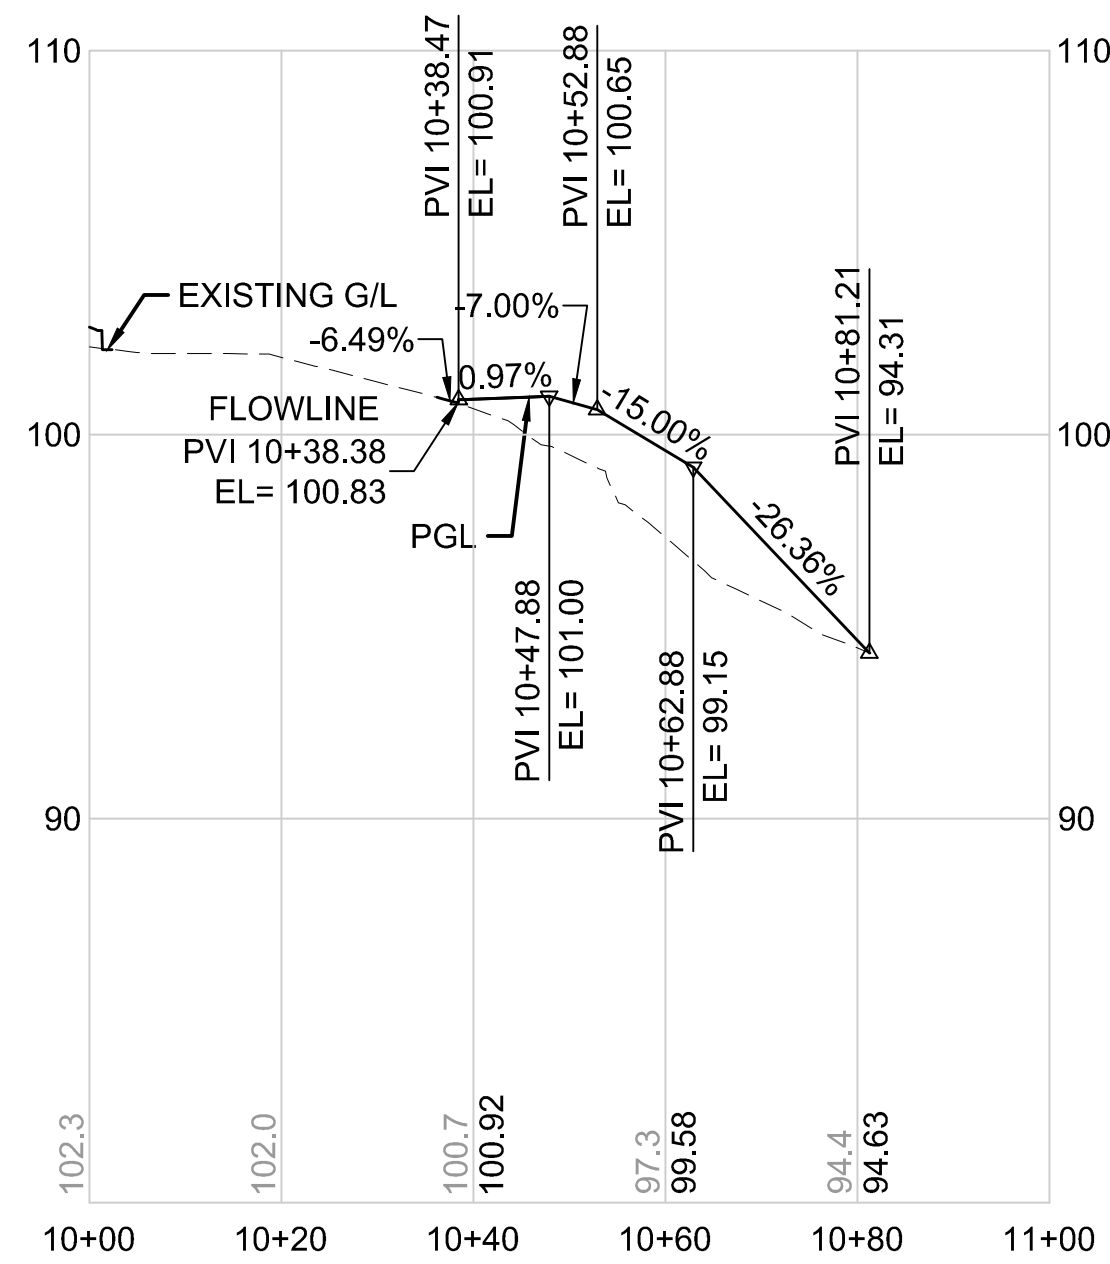

BRS289-S LINE
HORIZONTAL SCALE: 1"=20'
VERTICAL SCALE: 1"=5'

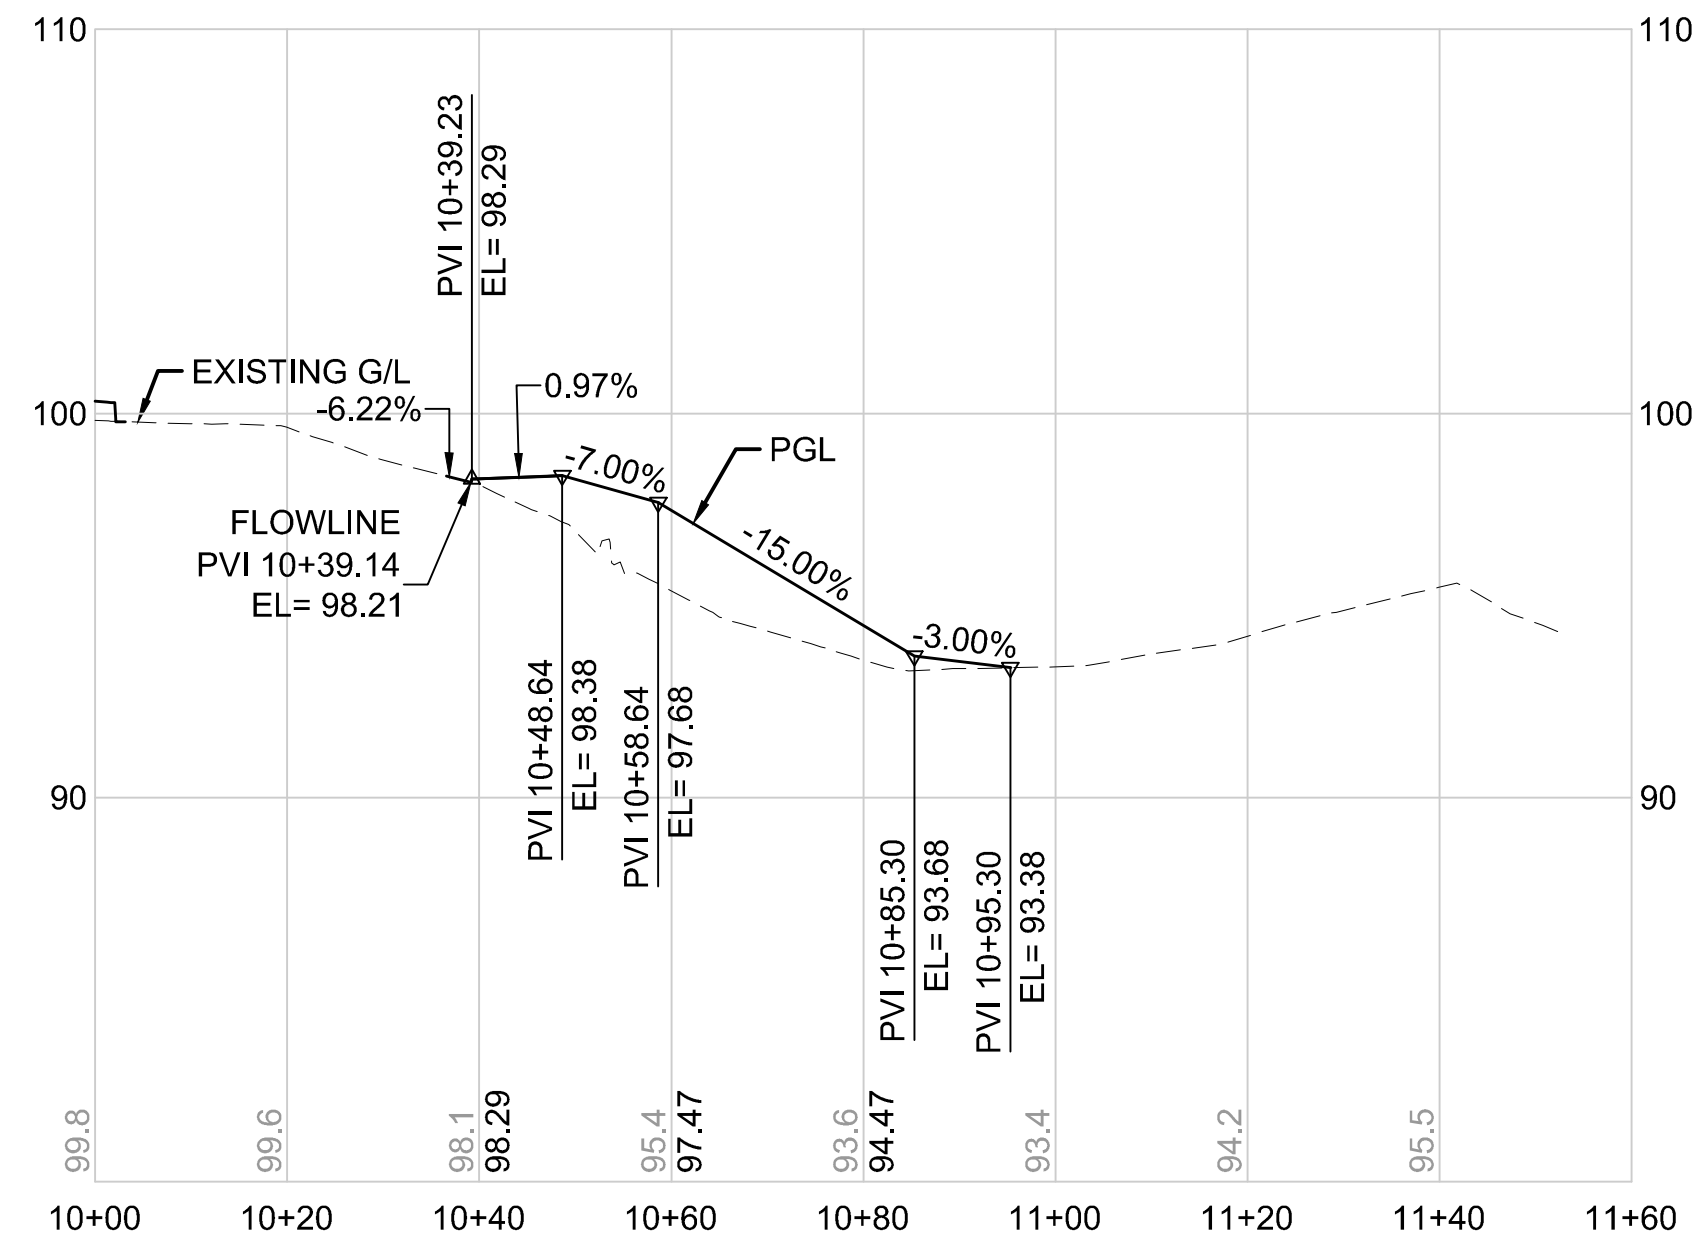

BRS289-N LINE
HORIZONTAL SCALE: 1"=20'
VERTICAL SCALE: 1"=5'

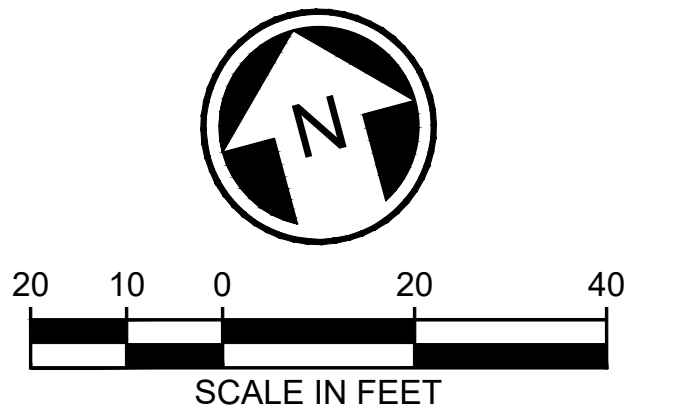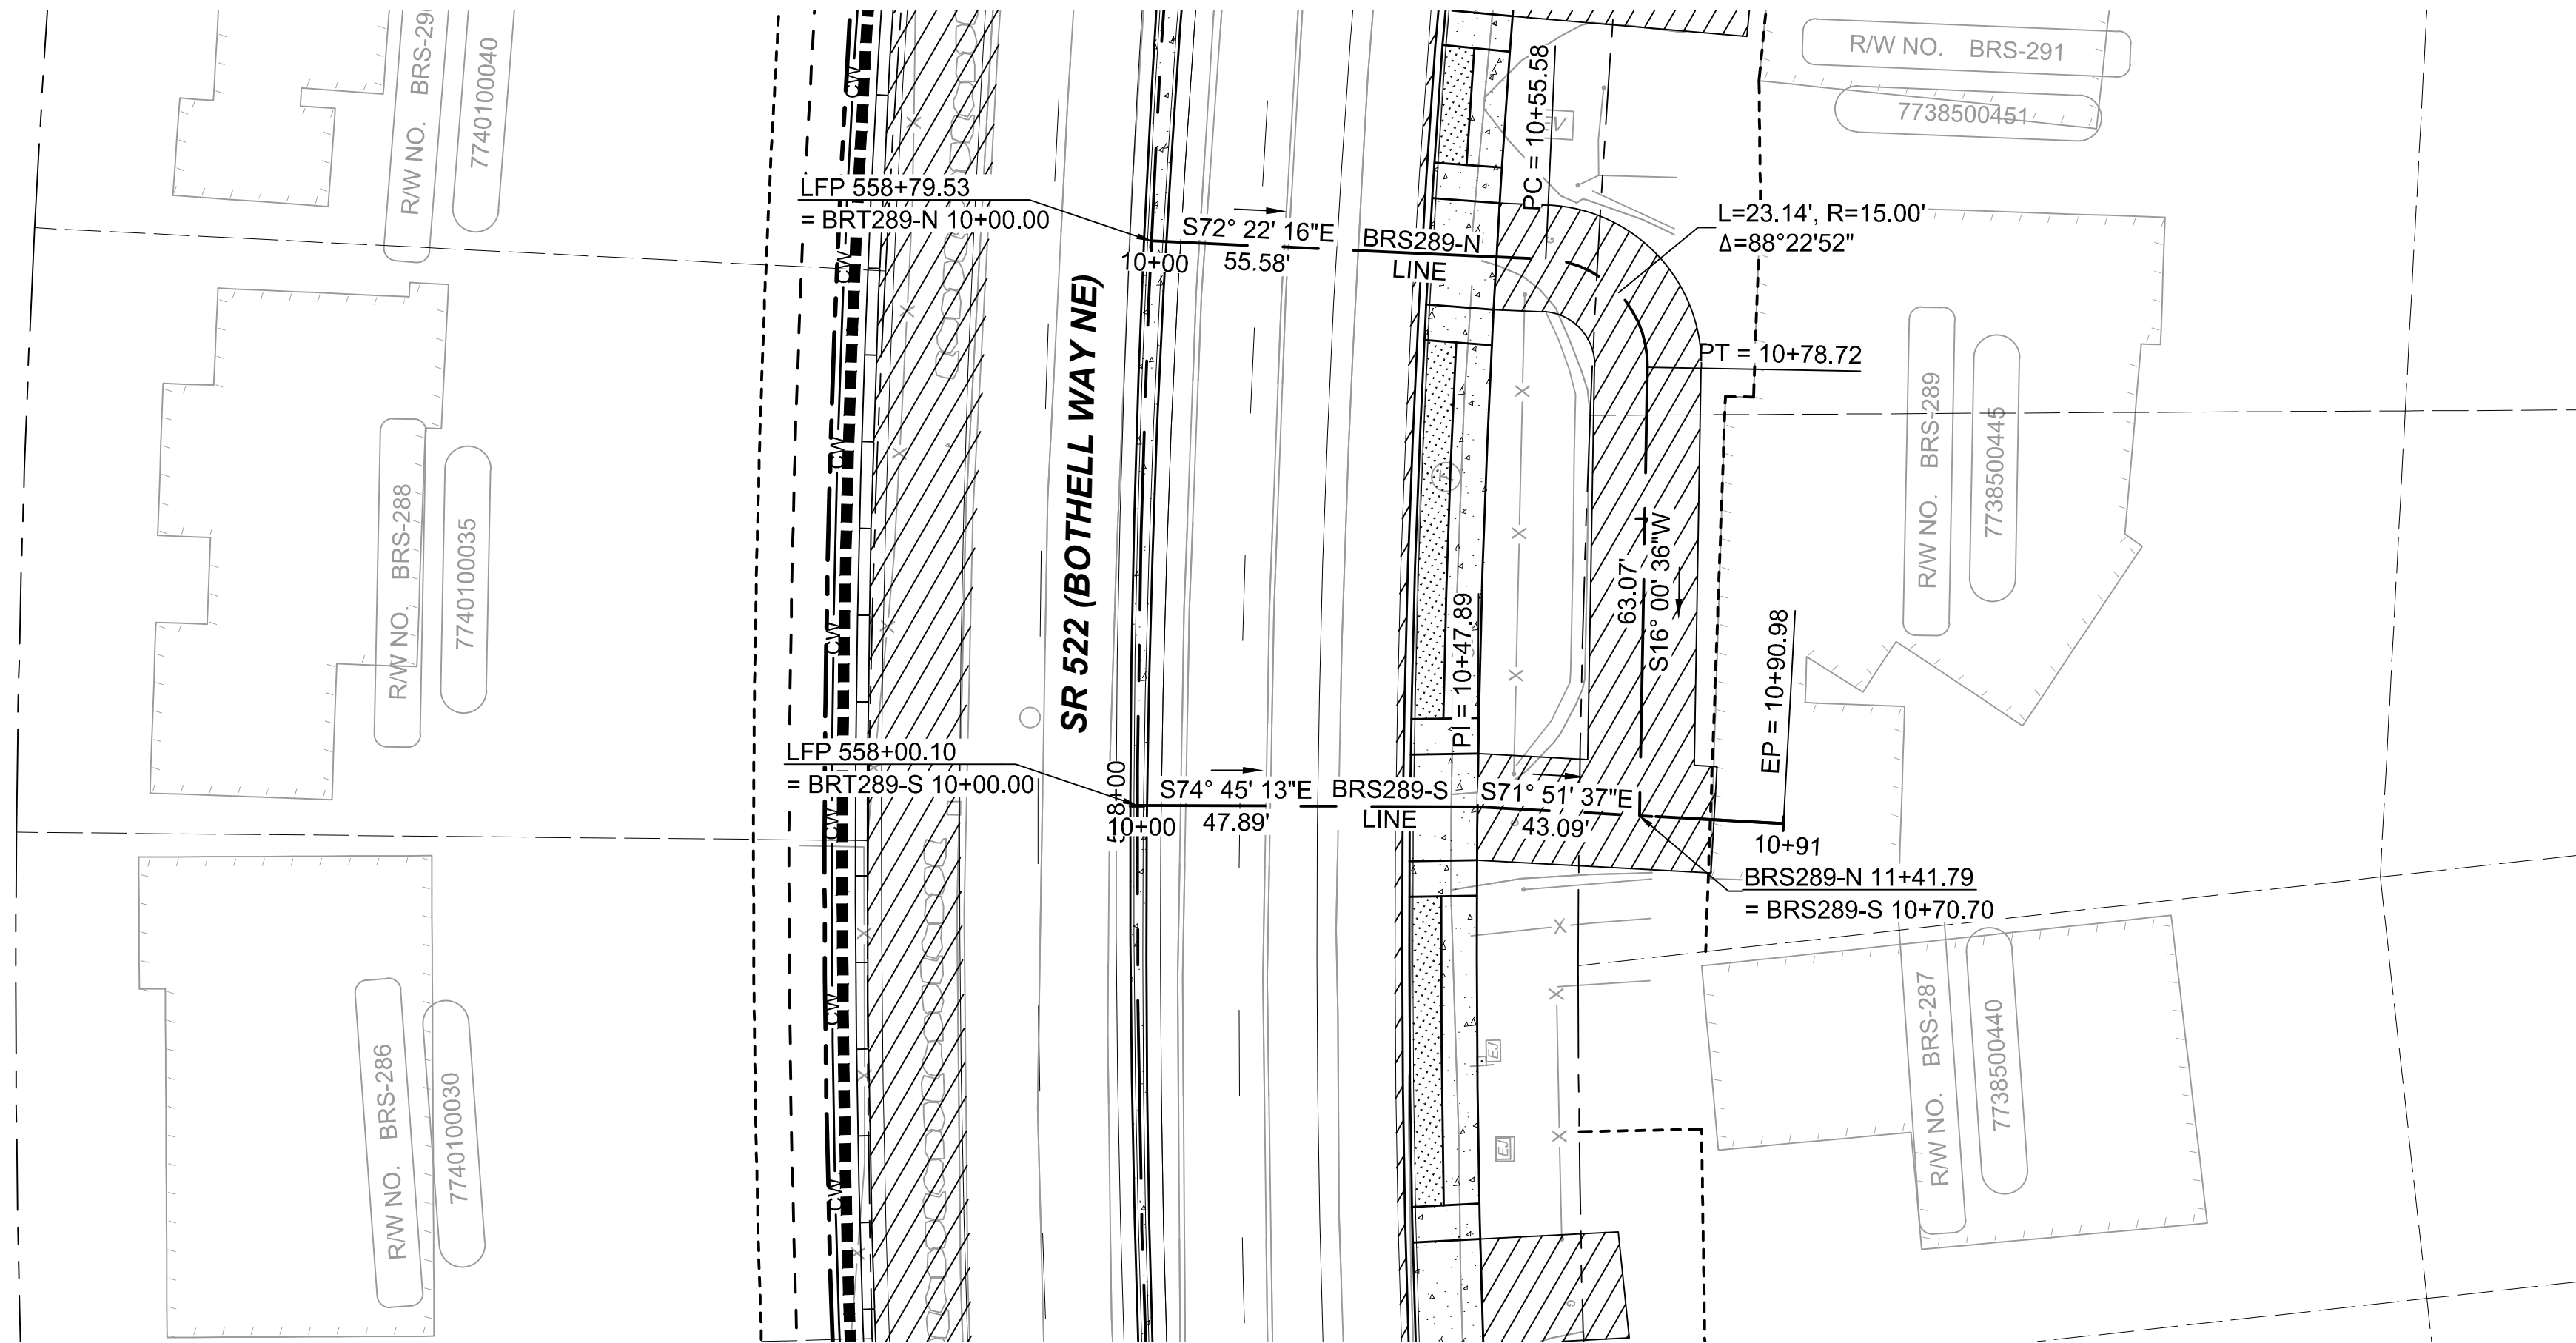

DRAFT 30% SUBMITTAL

DESIGNED BY:
C.MATYAS
DRAWN BY:
C.BRESLEY
CHECKED BY:
R.KOESTER
APPROVED BY:
M.FELIBERTI



DAVID EVANS
AND ASSOCIATES INC.
14432 SE Eastgate Way, Suite 400
Bellevue Washington 98007
Phone: 425.519.6500

LINE IS 1" AT
FULL SCALE






SCALE:
1"=20'
FILENAME:
BRT-522-CRV227-236
CONTRACT No.:
AE 0055-17
DATE:
09/11/2020

SR 522 / NE 145TH BRT
SR 522 (BOTHELL WAY NE)
CIVIL
DRIVEWAY PLAN AND PROFILES BRS289-S & BRS289-N
STA. 10+00 TO STA. 11+41.79

DRAWING No.:
522-CRV228
FACILITY ID:
522
SHEET No.:
132 OF 283
REV:

09/10/20 | 1:43 AM | SJRO
C:\PW_WORK\DEA\STEVEN ROSE\DWG\506735\BRT-522-CRV227-236.DWG

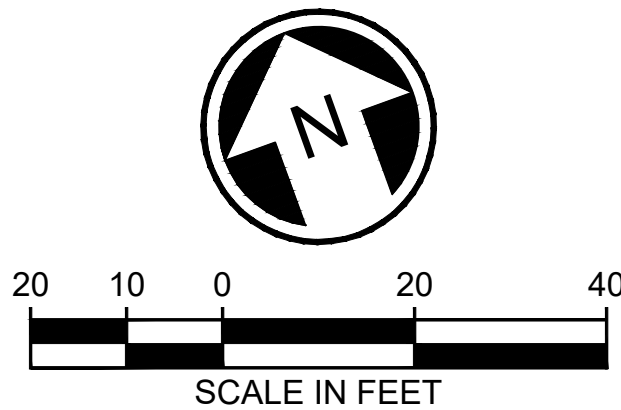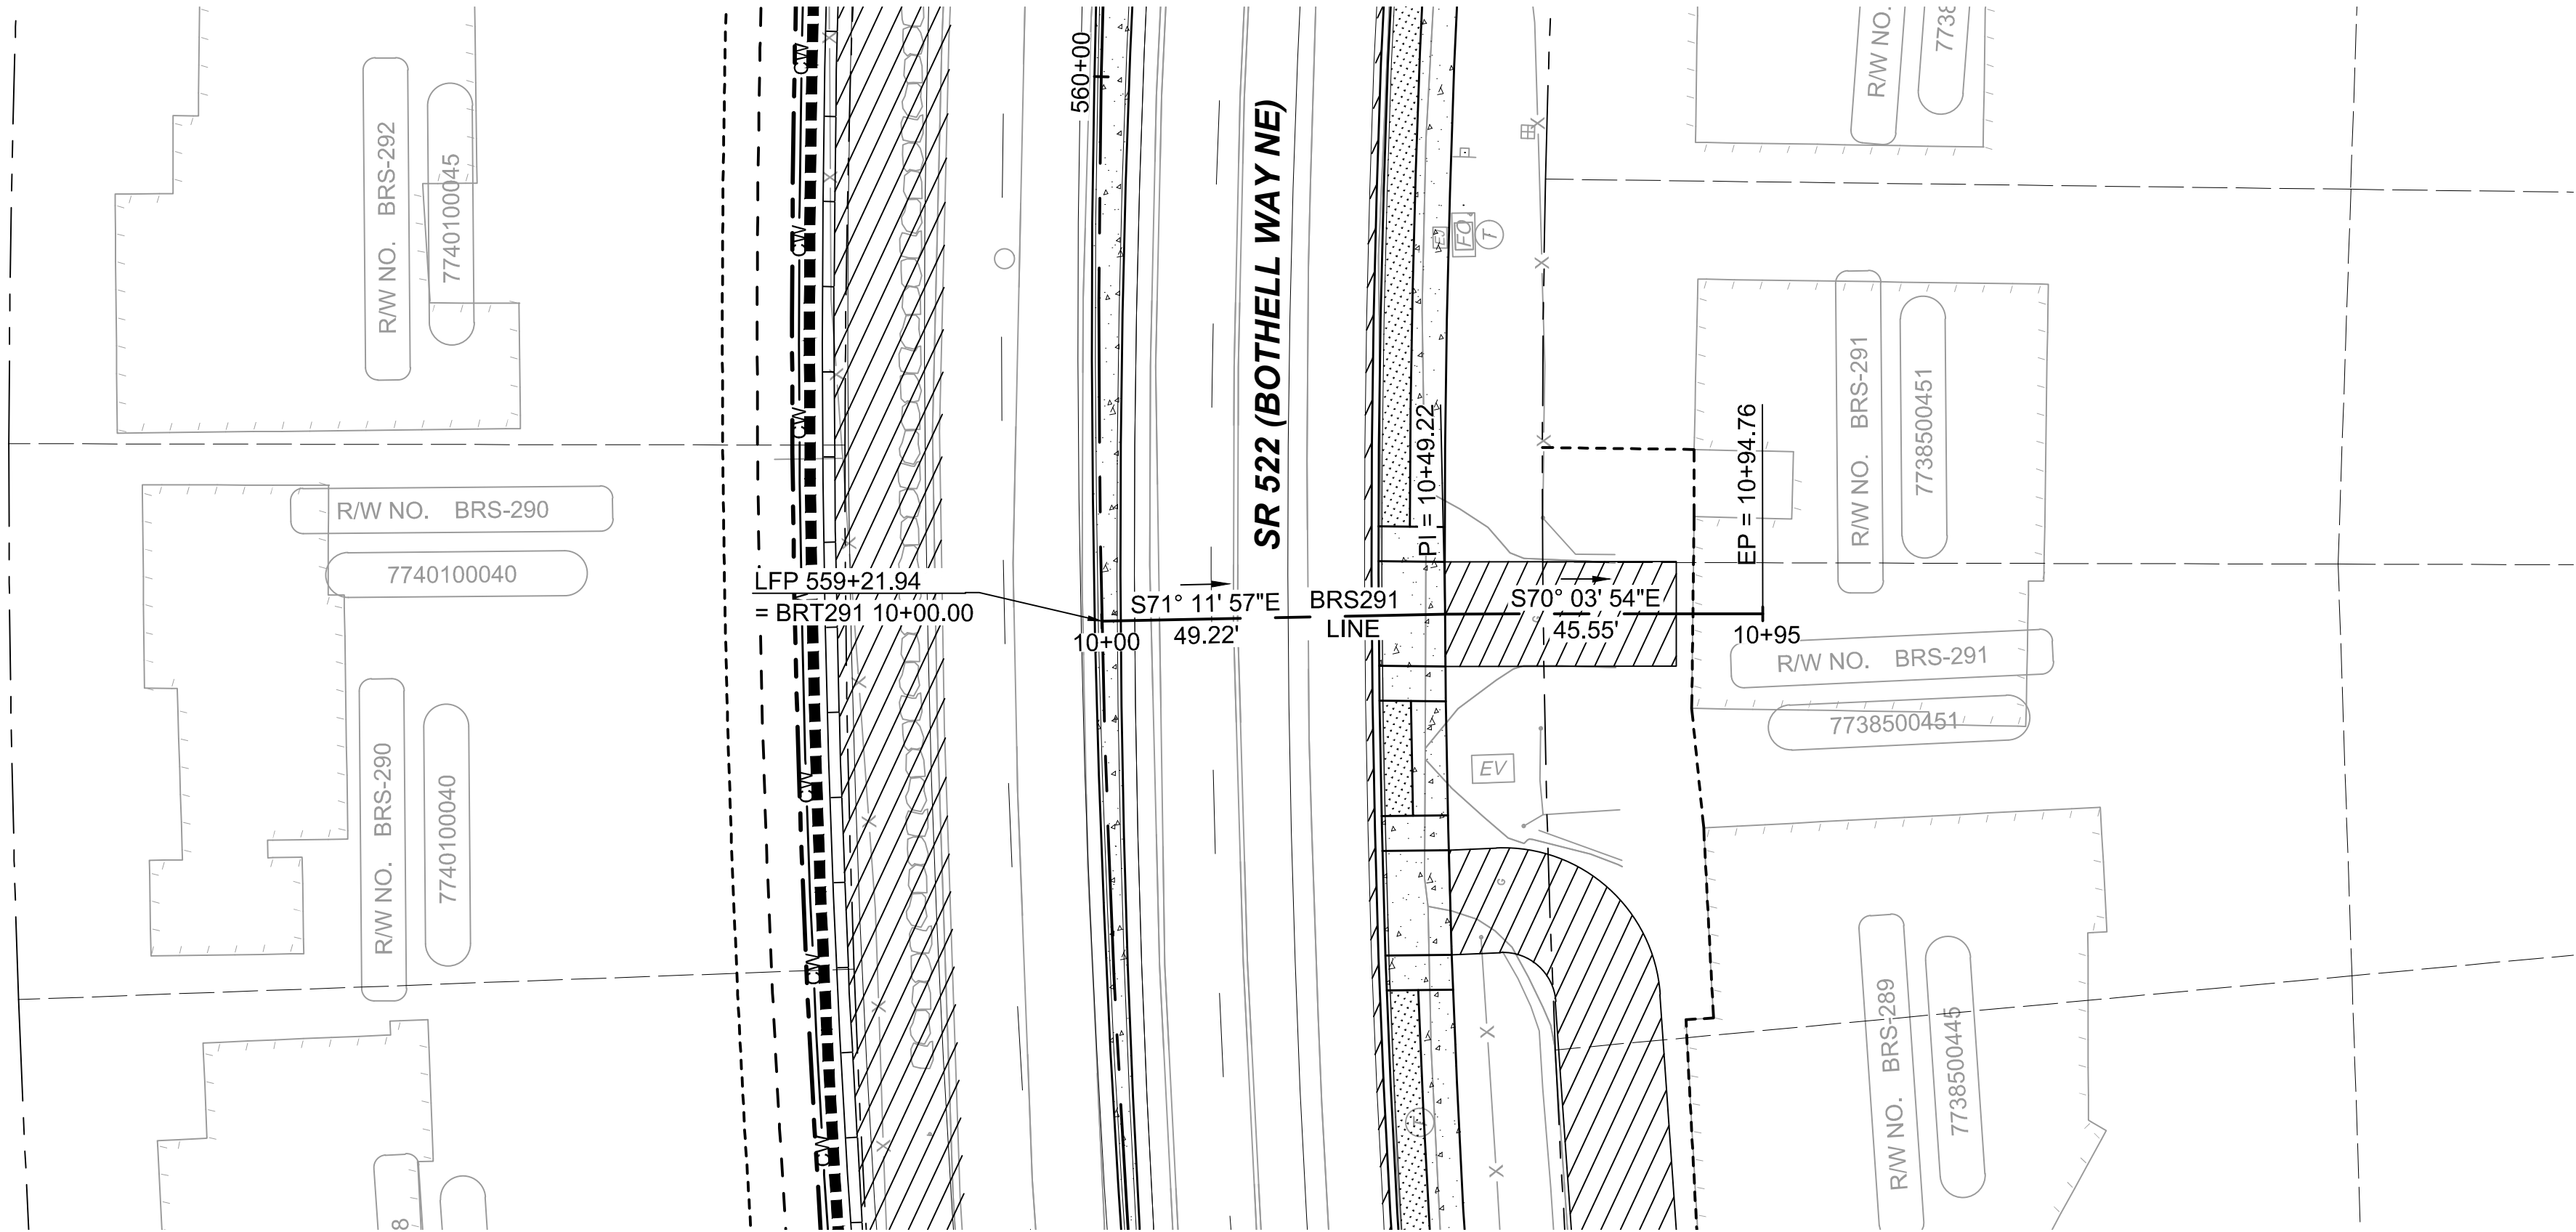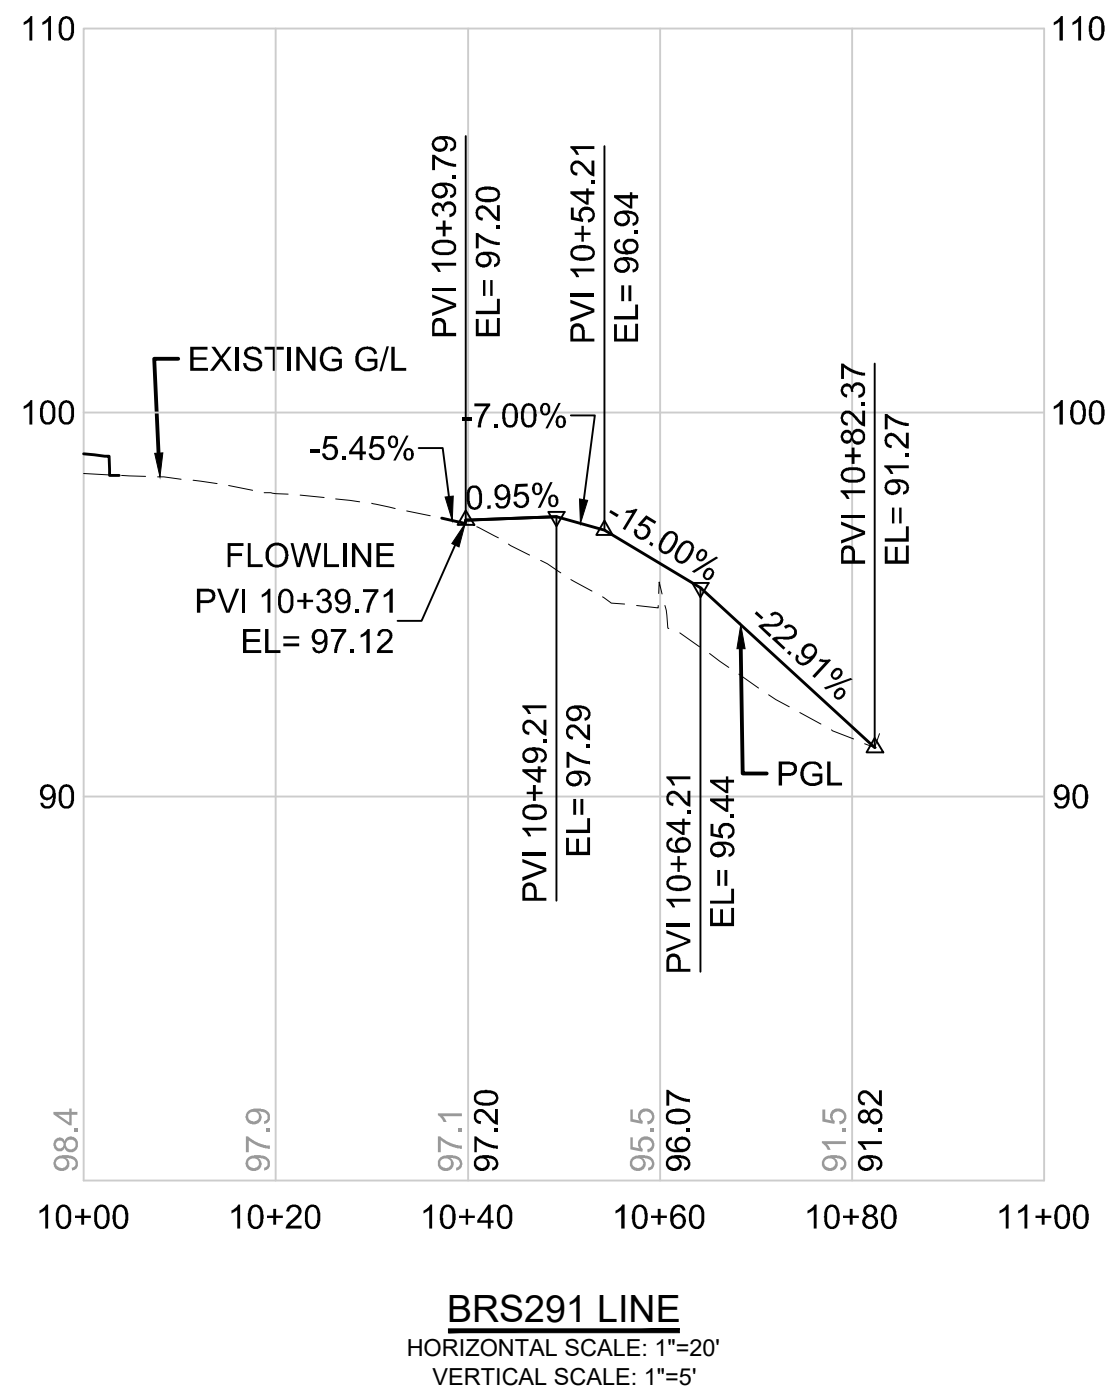

DRAFT 30% SUBMITTAL

No.	DATE	DSN	CHK	APP	REVISION

DESIGNED BY:
C.MATYAS
DRAWN BY:
C.BRESLEY
CHECKED BY:
R.KOESTER
APPROVED BY:
M.FELIBERTI



DAVID EVANS
AND ASSOCIATES INC.
14432 SE Eastgate Way, Suite 400
Bellevue Washington 98007
Phone: 425.519.6500

SUBMITTED BY:
D.SCHOCK

DATE:
09/11/2020

REVIEWED BY:
B.KEMPER






DATE:
09/11/2020

SCALE:
1"=20'
FILENAME:
BRT-522-CRV227-236
CONTRACT No.:
AE 0055-17
DATE:
09/11/2020

SR 522 / NE 145TH BRT
SR 522 (BOTHELL WAY NE)
CIVIL
DRIVEWAY AND PROFILE BRS291
STA. 10+00 TO STA. 10+94.76

DRAWING No.:
522-CRV229
FACILITY ID:
522
SHEET No.:
133 OF 283
REV:

09/10/20 | 1:43 AM | SJRO
C:\PW_WORK\DEA\STEVEN ROSE\DWG\BRT-522-CRV227-236.DWG

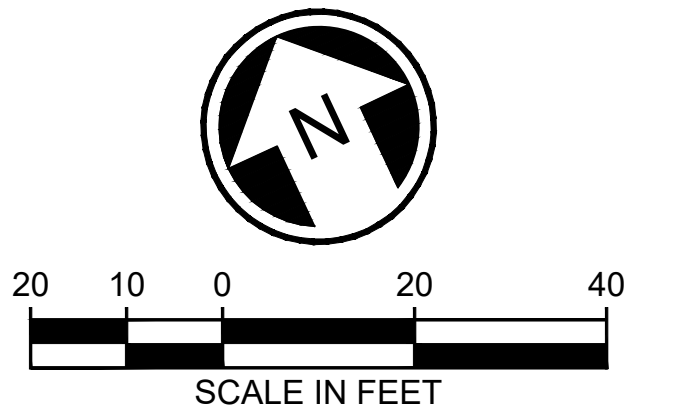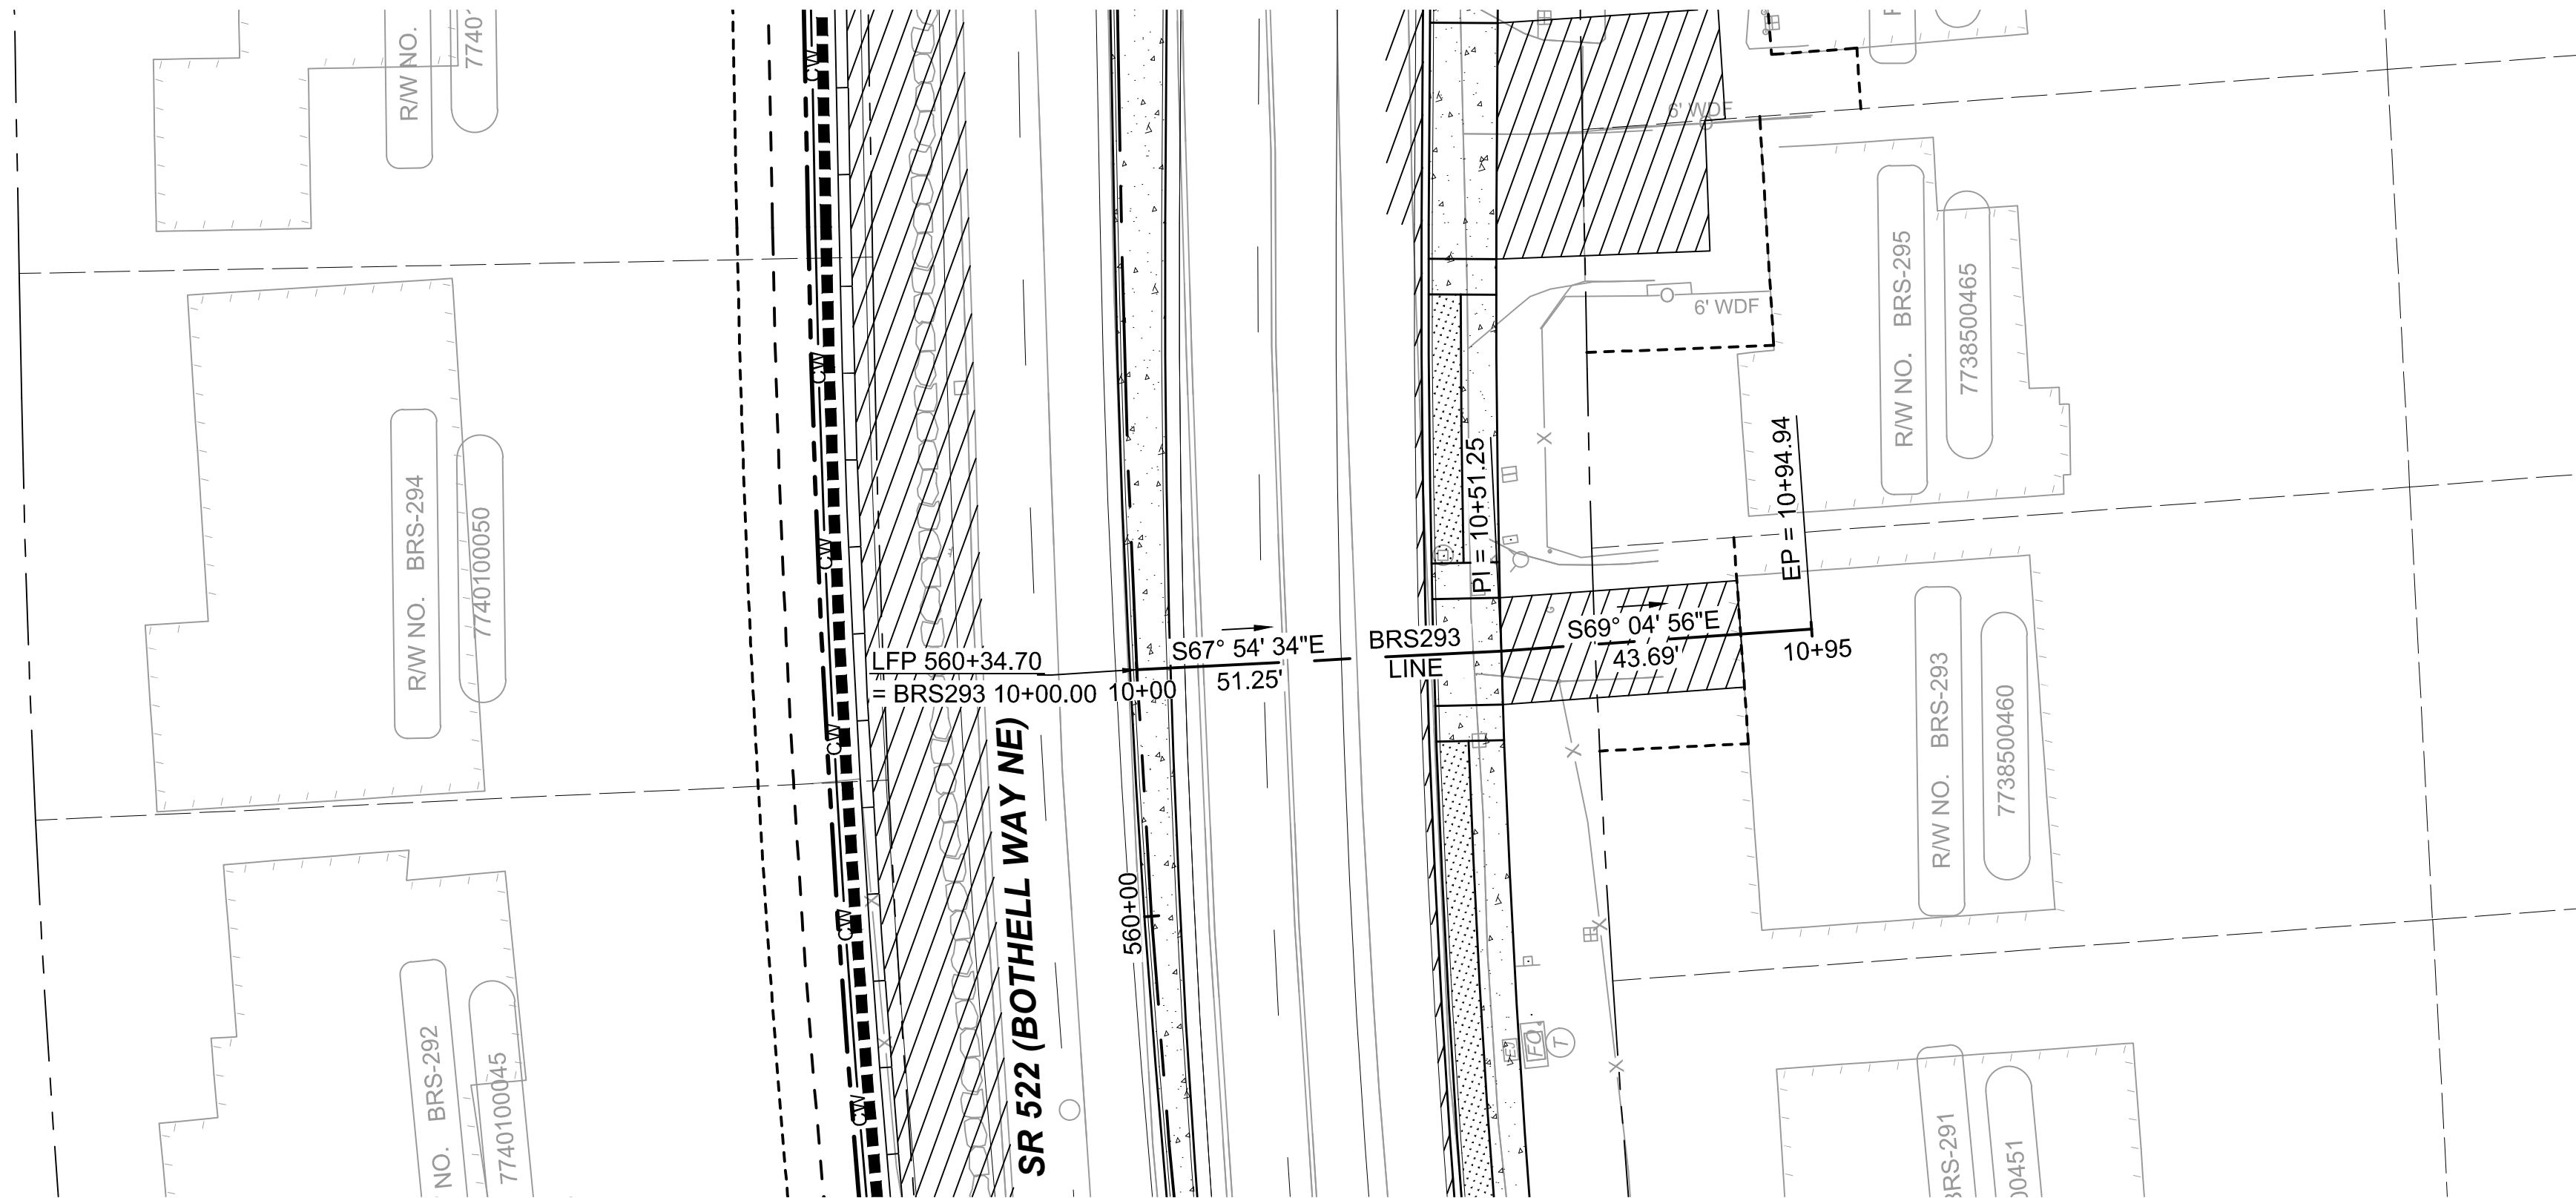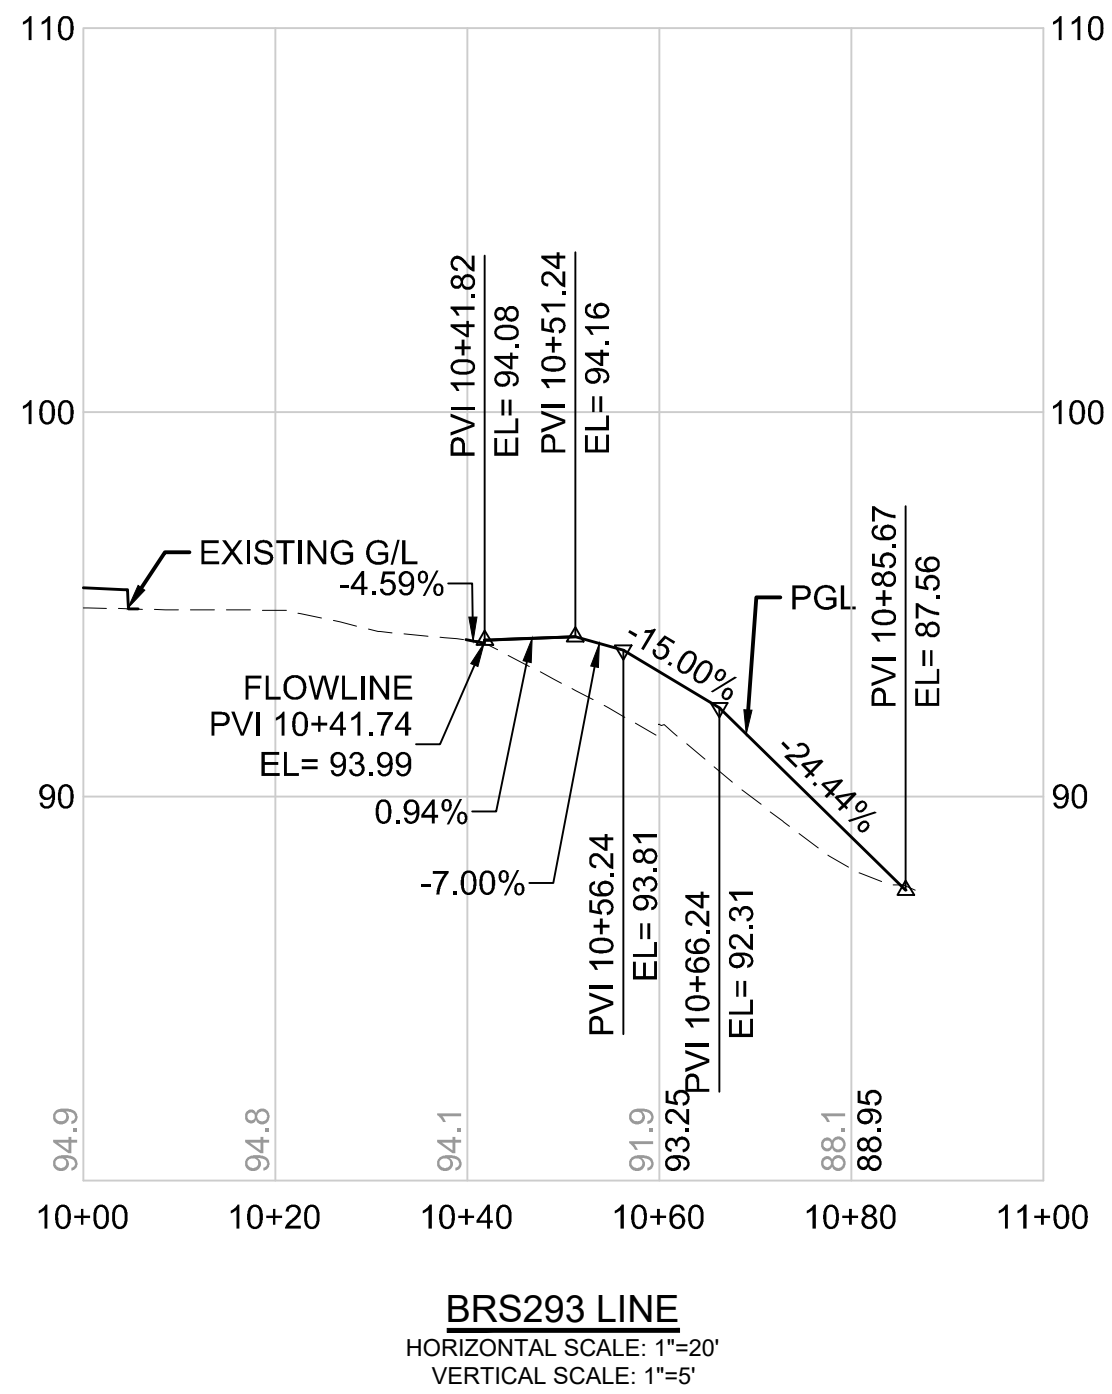

DRAFT 30% SUBMITTAL


No.	DATE	DSN	CHK	APP	REVISION

DESIGNED BY:	C.MATYAS
DRAWN BY:	C.BRESLEY
CHECKED BY:	R.KOESTER
APPROVED BY:	M.FELIBERTI



**DAVID EVANS
AND ASSOCIATES INC.**
14432 SE Eastgate Way, Suite 400
Bellevue Washington 98007
Phone: 425.519.6500

SUBMITTED BY:	DATE:	REVIEWED BY:	DATE:
D.SCHOCK	09/11/2020	B.KEMPER	09/11/2020



 


SCALE:	1"=20'
FILENAME:	BRT-522-CRV227-236
CONTRACT No.:	AE 0055-17
DATE:	09/11/2020

SR 522 / NE 145TH BRT
SR 522 (BOTHELL WAY NE)
CIVIL
DRIVEWAY AND PROFILE BRS293
STA. 10+00 TO STA. 10+94.94

DRAWING No.:	522-CRV230
FACILITY ID:	522
SHEET No.:	134 OF 283
REV:	

09/10/20 | 1:44 AM | SJRO
C:\PW_WORK\DEA\STEVEN ROSE\DWG\522\BRT-522-CRV227-236.DWG

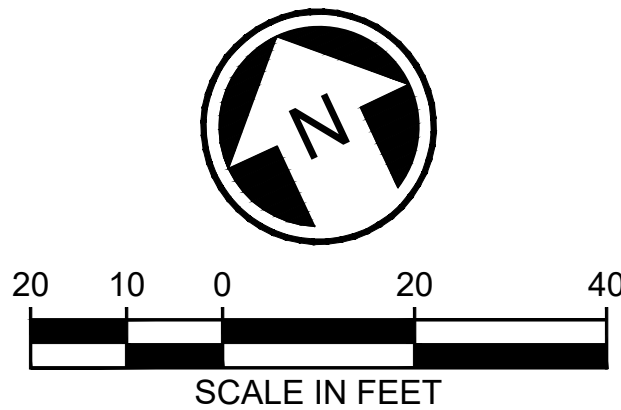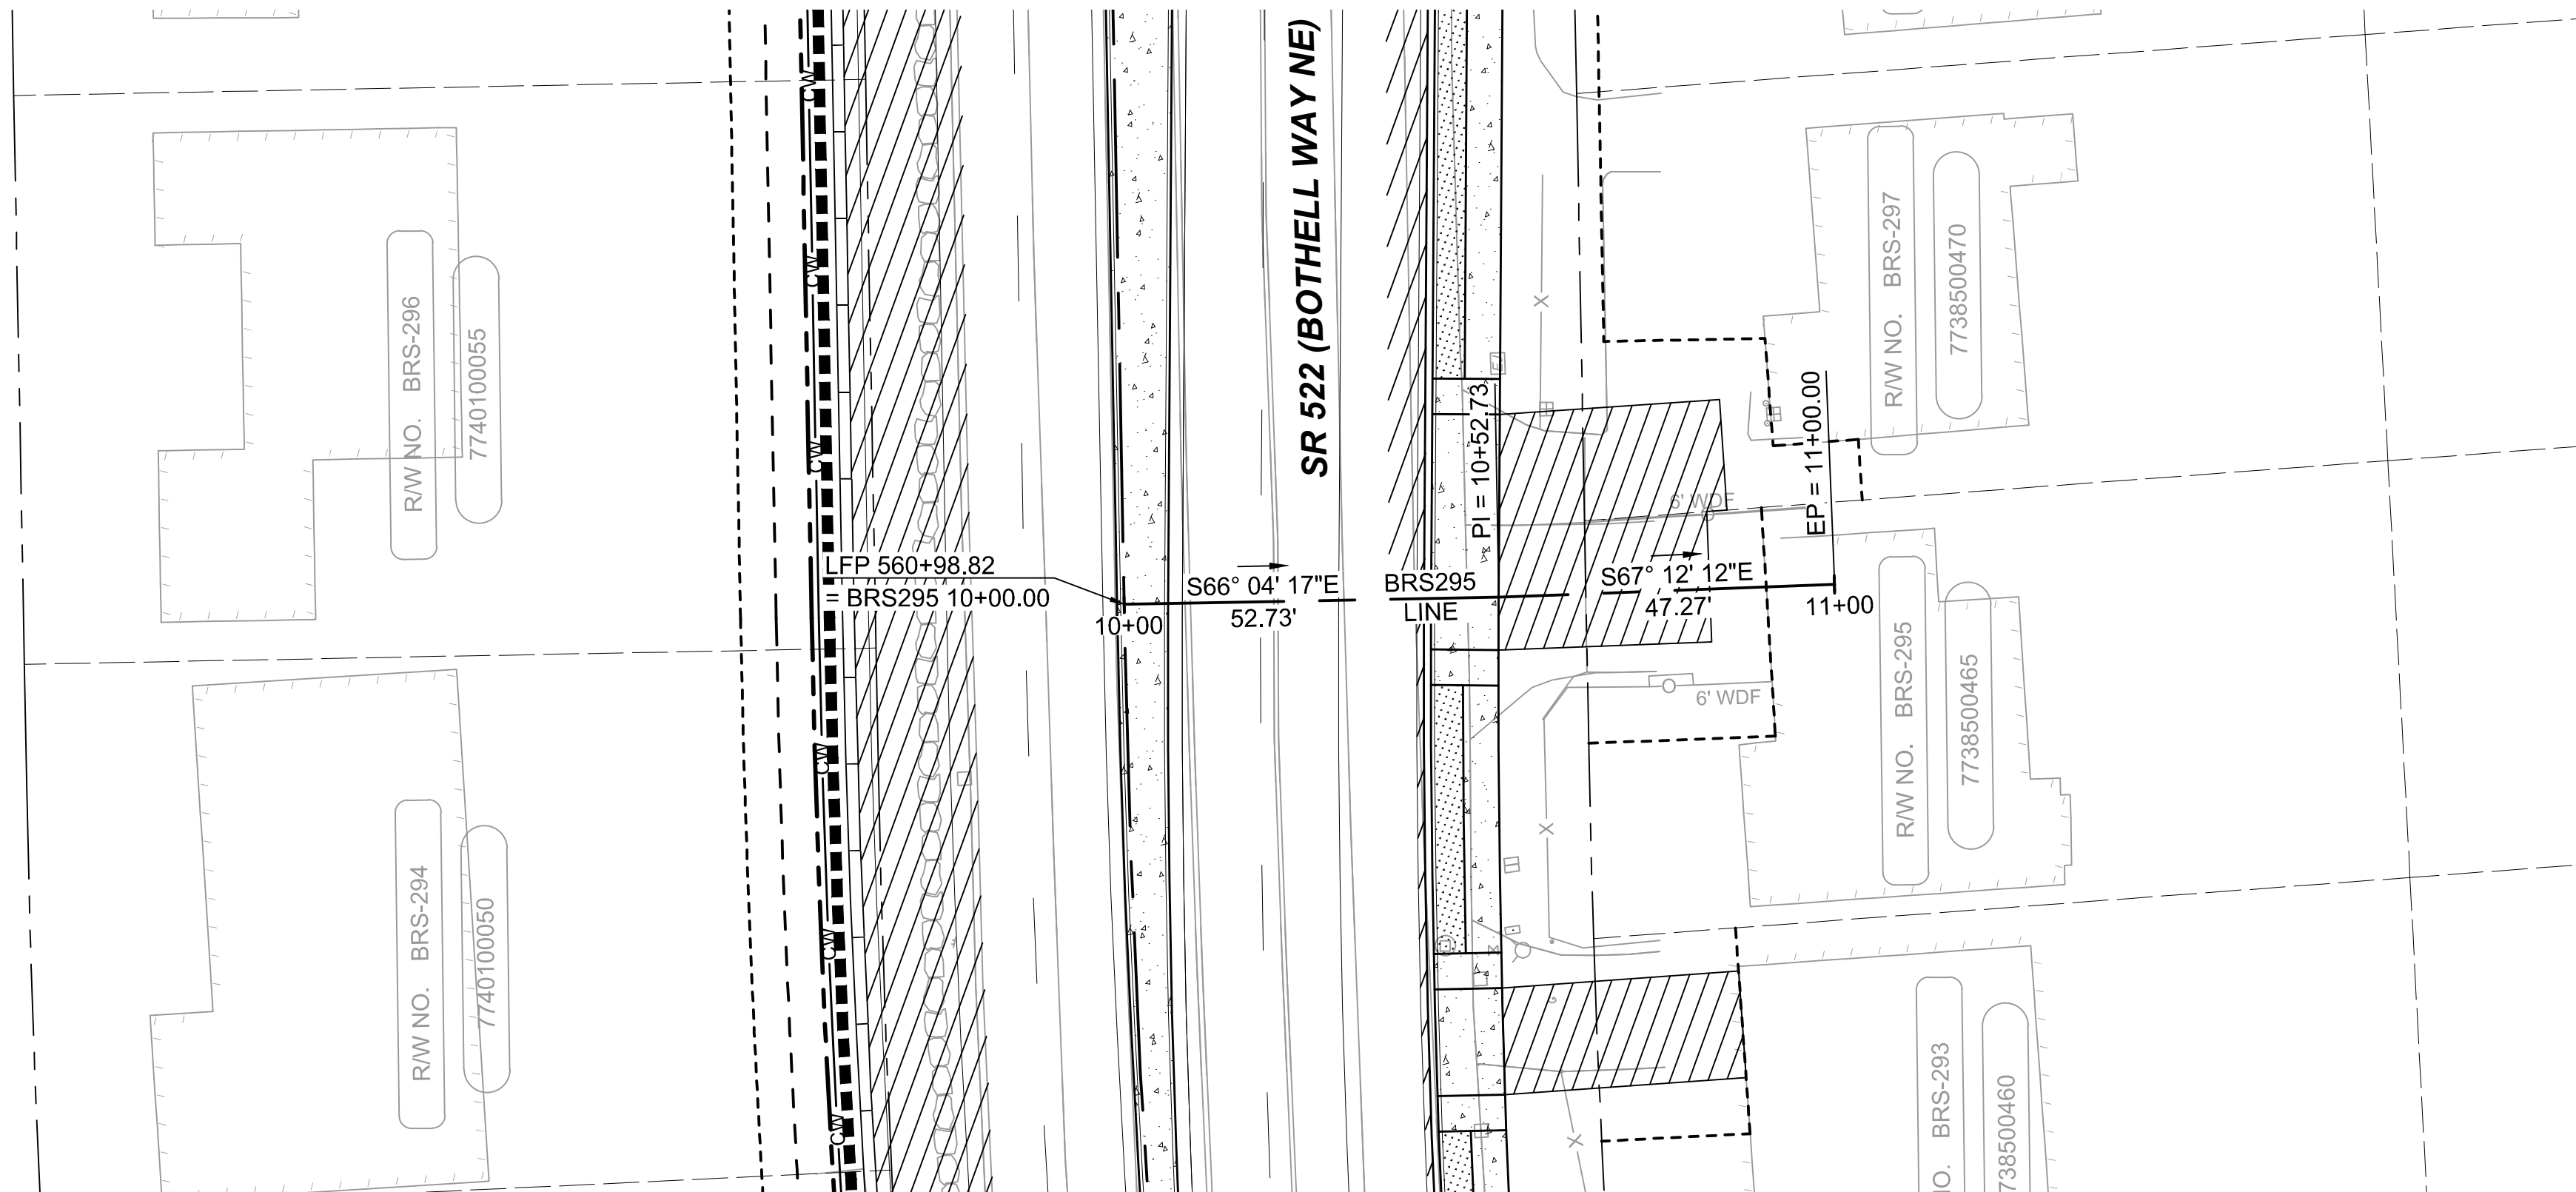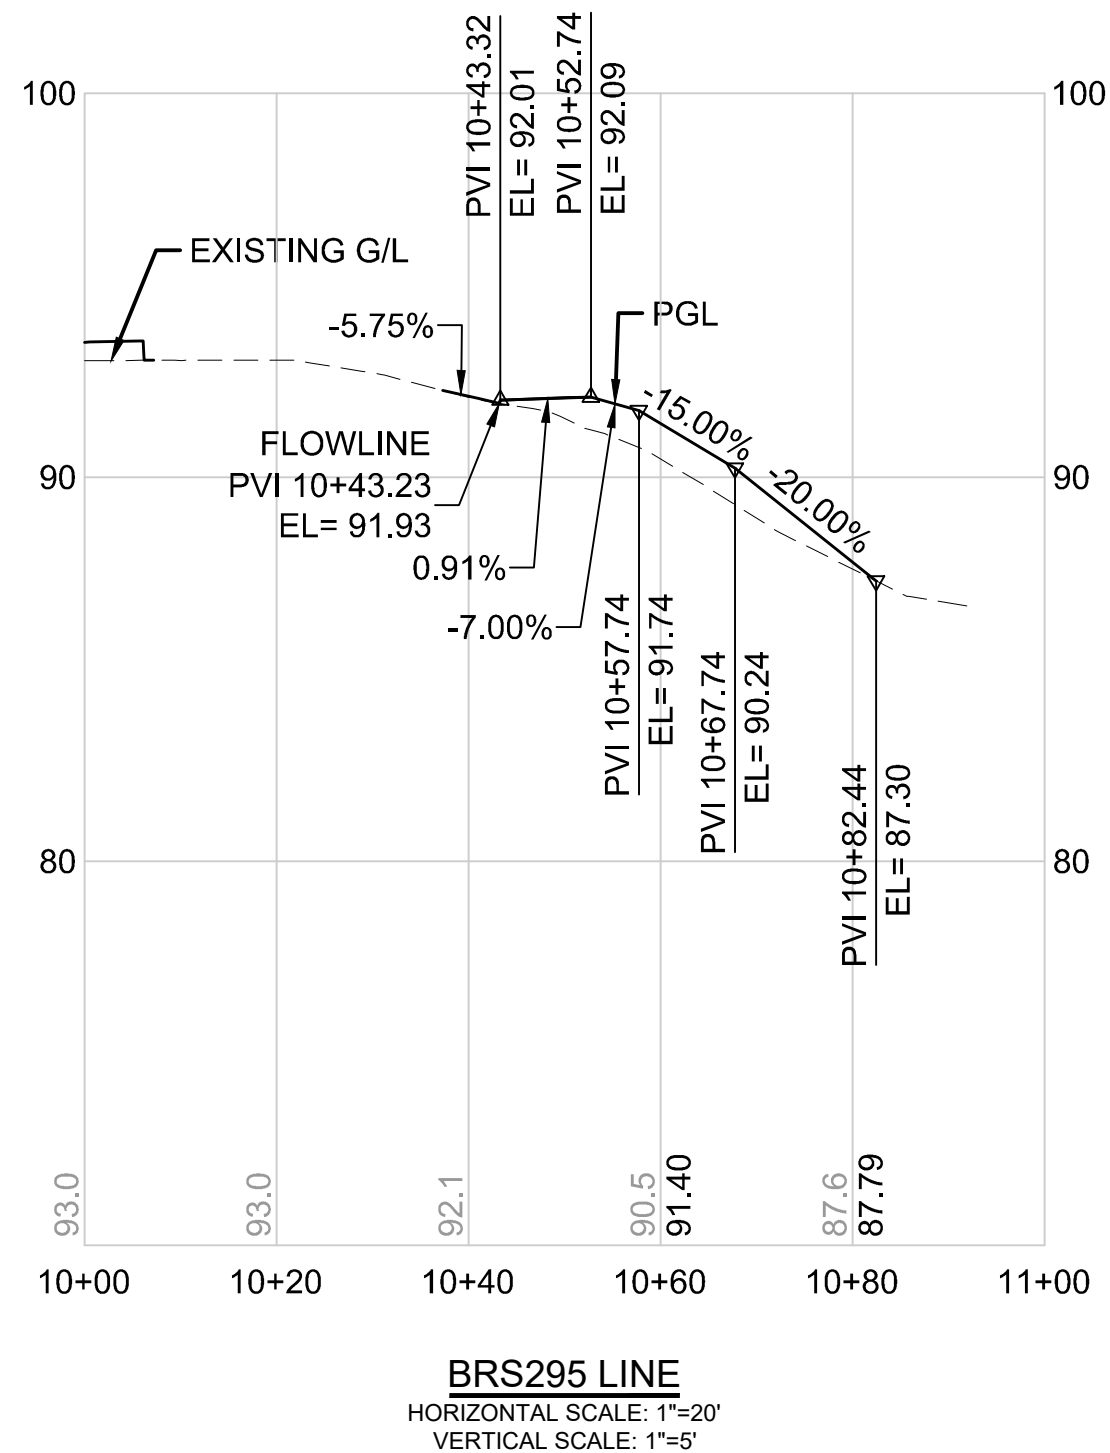

DRAFT 30% SUBMITTAL


No.	DATE	DSN	CHK	APP	REVISION

DESIGNED BY:	C.MATYAS
DRAWN BY:	C.BRESLEY
CHECKED BY:	R.KOESTER
APPROVED BY:	M.FELIBERTI



**DAVID EVANS
AND ASSOCIATES INC.**
14432 SE Eastgate Way, Suite 400
Bellevue Washington 98007
Phone: 425.519.6500

SUBMITTED BY:	DATE:	REVIEWED BY:
D.SCHOCK	09/11/2020	B.KEMPER


 


SCALE:	1"=20'
FILENAME:	BRT-522-CRV227-236
CONTRACT No.:	AE 0055-17
DATE:	09/11/2020

SR 522 / NE 145TH BRT
SR 522 (BOTHELL WAY NE)
CIVIL
DRIVEWAY AND PROFILE BRS295
STA. 10+00 TO STA. 11+00.00

DRAWING No.:	522-CRV231
FACILITY ID:	522
SHEET No.:	135 OF 283
REV:	

09/10/20 | 1:45 AM | SJRO
C:\PW_WORK\DEA\STEVEN ROSE\DMIS06735\BRT-522-CRV227-236.DWG

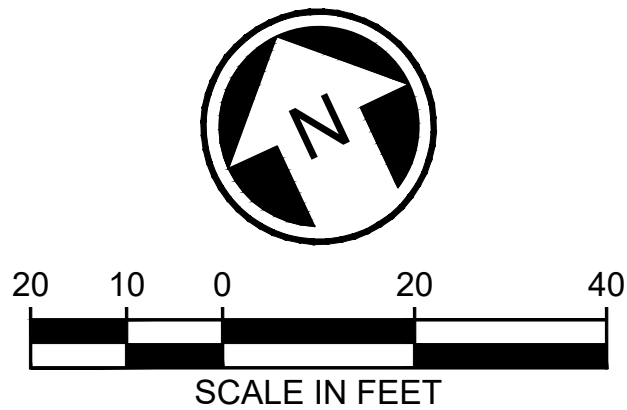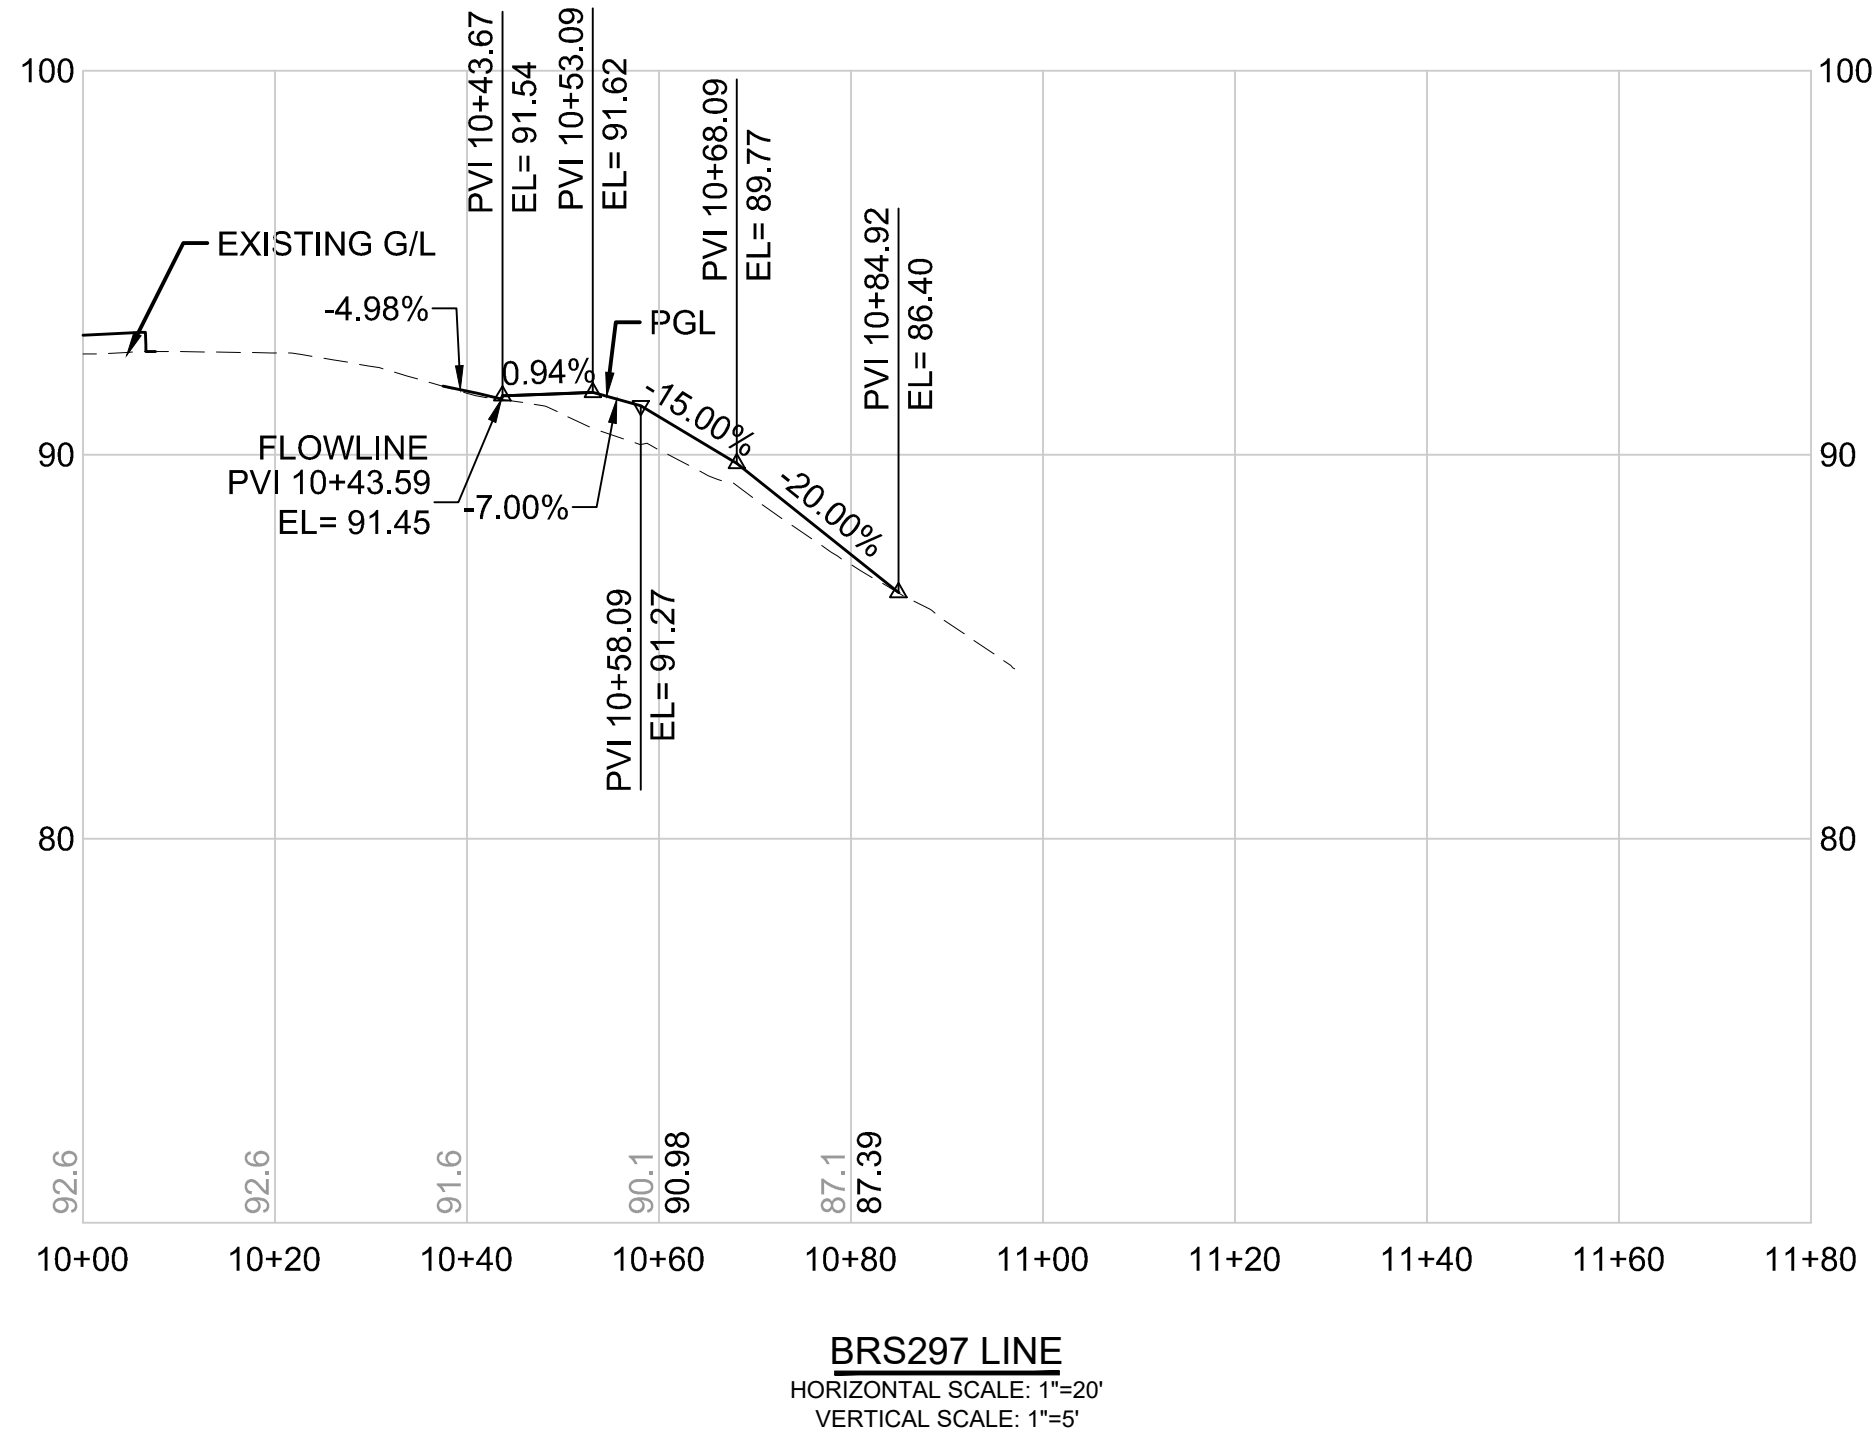

DRAFT 30% SUBMITTAL


No.	DATE	DSN	CHK	APP	REVISION

DESIGNED BY:	C.MATYAS
DRAWN BY:	C.BRESLEY
CHECKED BY:	R.KOESTER
APPROVED BY:	M.FELIBERTI



**DAVID EVANS
AND ASSOCIATES INC.**
14432 SE Eastgate Way, Suite 400
Bellevue Washington 98007
Phone: 425.519.6500

SUBMITTED BY:	DATE:	REVIEWED BY:	DATE:
D.SCHOCK	09/11/2020	B.KEMPER	09/11/2020


 


SOUNDTRANSIT

SCALE:	1"=20'
FILENAME:	BRT-522-CRV227-236
CONTRACT No.:	AE 0055-17
DATE:	09/11/2020

SR 522 / NE 145TH BRT
SR 522 (BOTHELL WAY NE)
CIVIL
DRIVEWAY PLAN AND PROFILE BRS297
STA. 10+00 TO STA. 11+78.75

DRAWING No.:	522-CRV232
FACILITY ID:	522
SHEET No.:	136 OF 283
REV:	

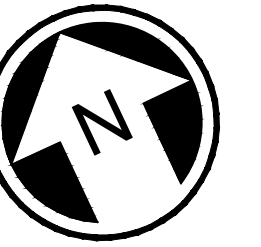 

DRAFT 30% SUBMITTAL

No.	DATE	DSN	CHK	APP	REVISION

DESIGNED BY:	C.MATYAS
DRAWN BY:	C.BRESLEY
CHECKED BY:	R.KOESTER
APPROVED BY:	M.FELIBERT



**DAVID EVANS
AND ASSOCIATES INC.**
14432 SE Eastgate Way, Suite 400
Bellevue Washington 98007
Phone: 425.519.6500

LINE IS 1" AT FULL SCALE






SCALE:
1"=20'
FILENAME:
BRT-522-CRV227-236
CONTRACT No.:
AE 0055-17
DATE:
09/11/2020

SR 522 / NE 145TH BRT

SR 522 (BOTHELL WAY NE)


CIVIL
DRIVEWAY PLAN AND PROFILE BRS299
STA. 10+00 TO STA. 10+95.64

AWING No.:
522-CRV233
CILITY ID:
522
HEET No.: REV:
137 OF 283

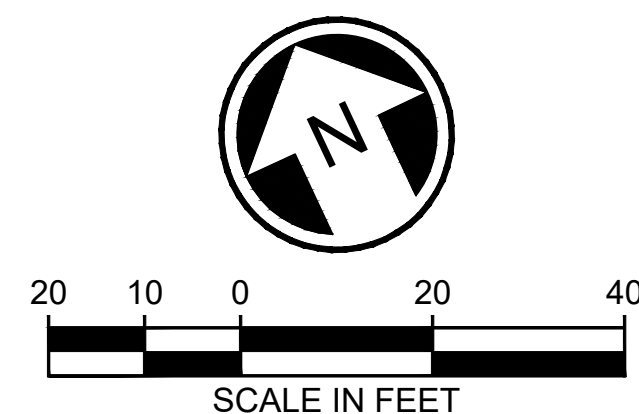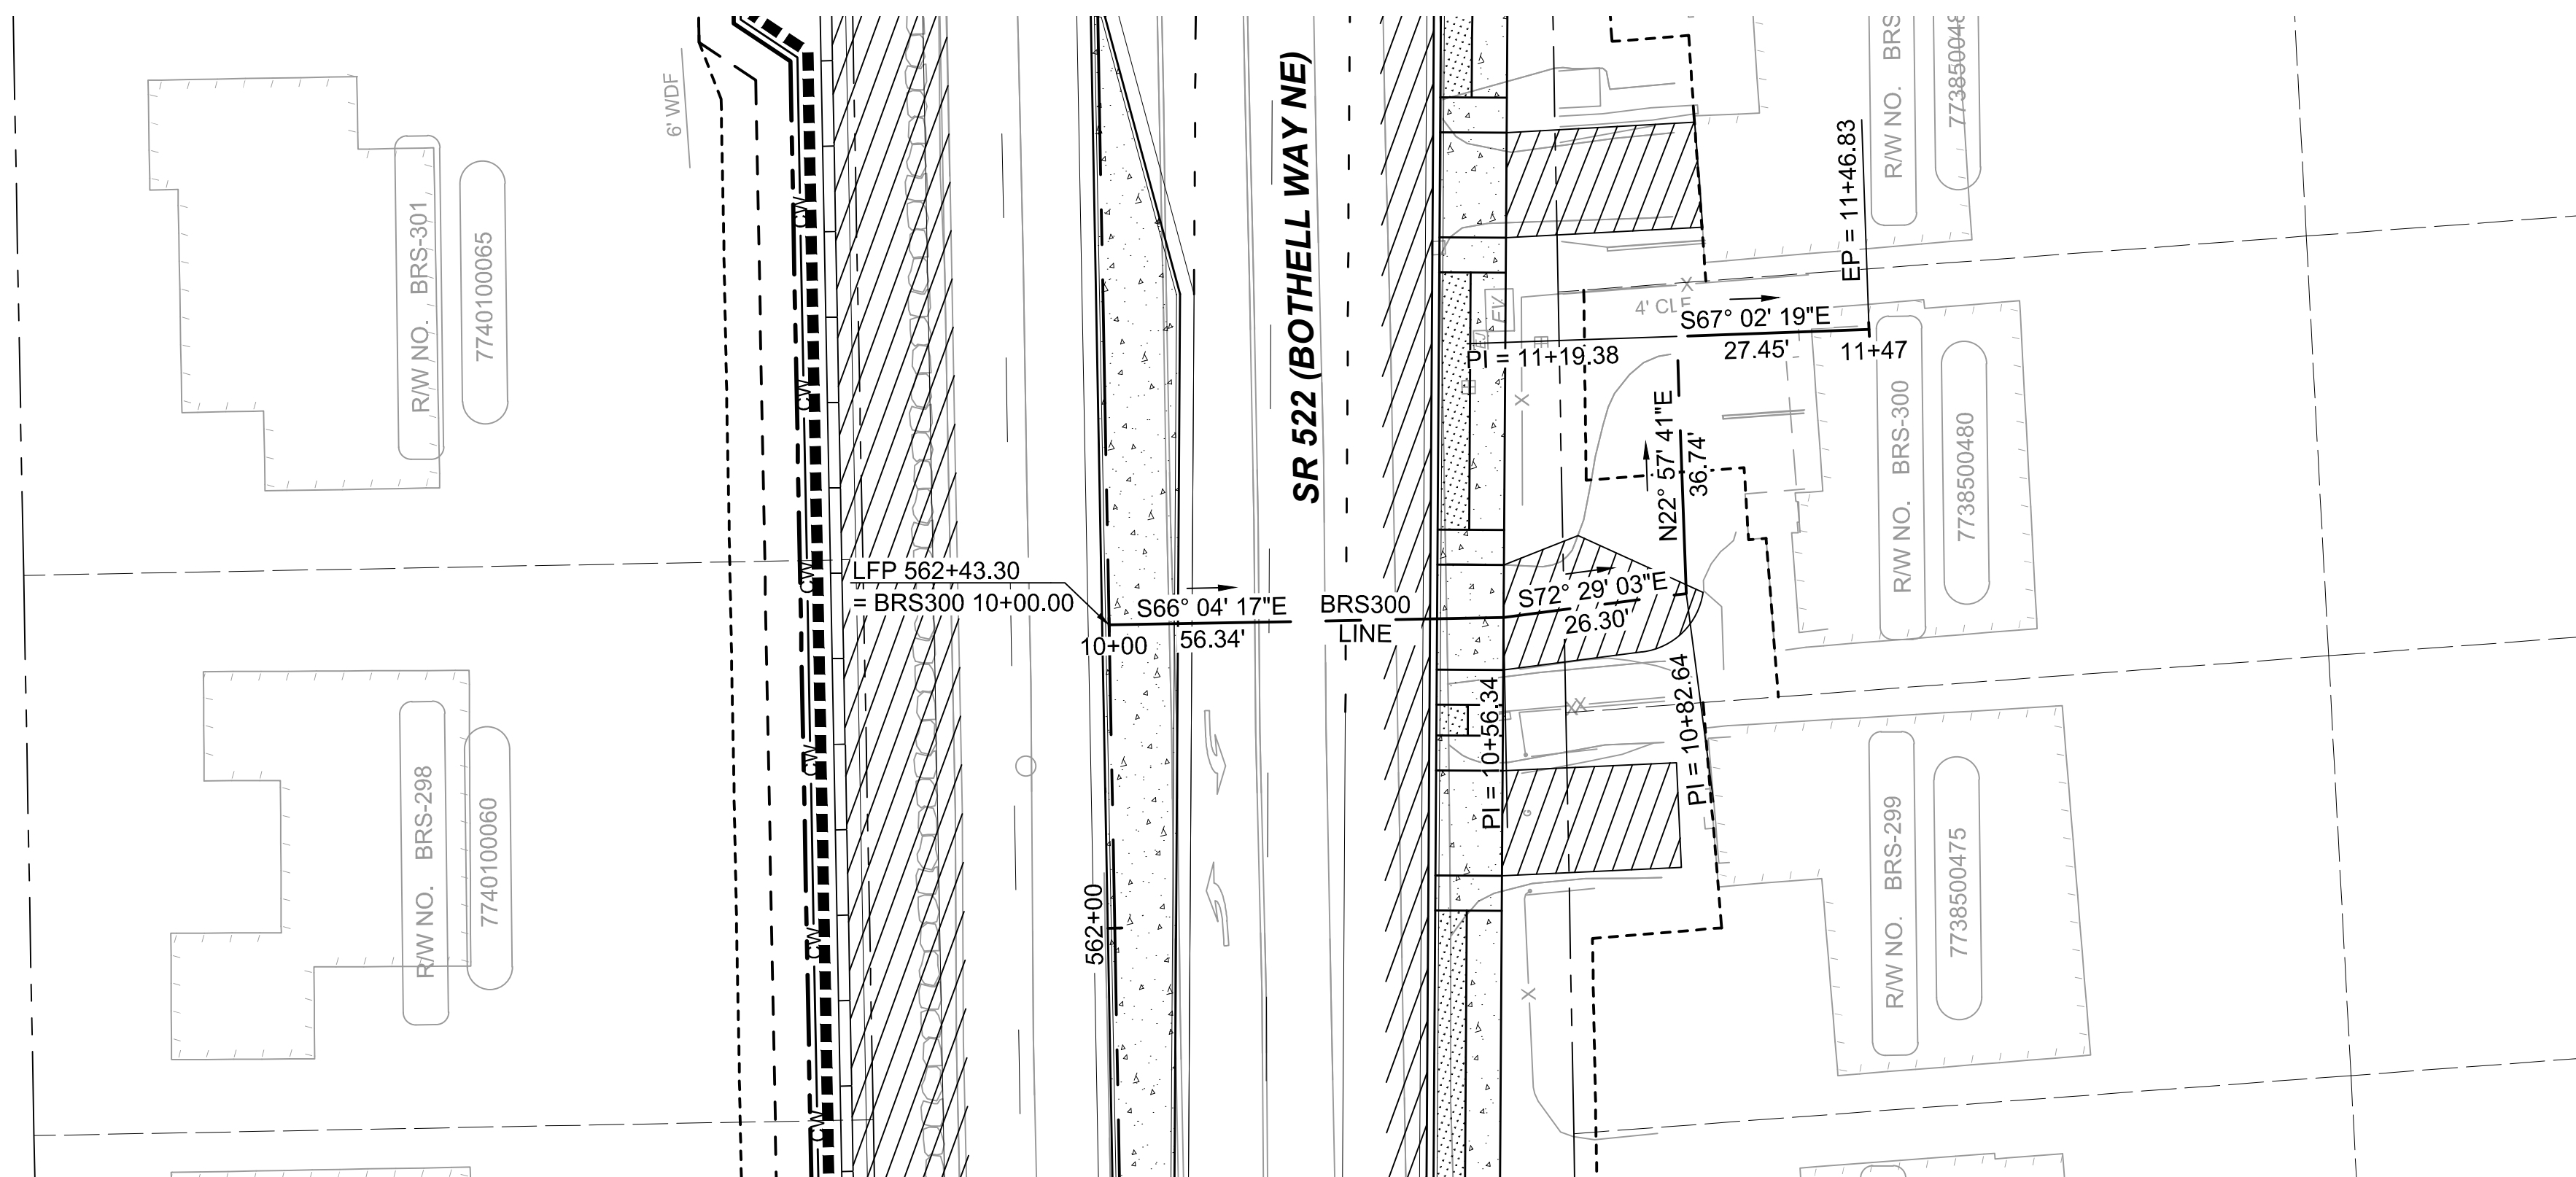
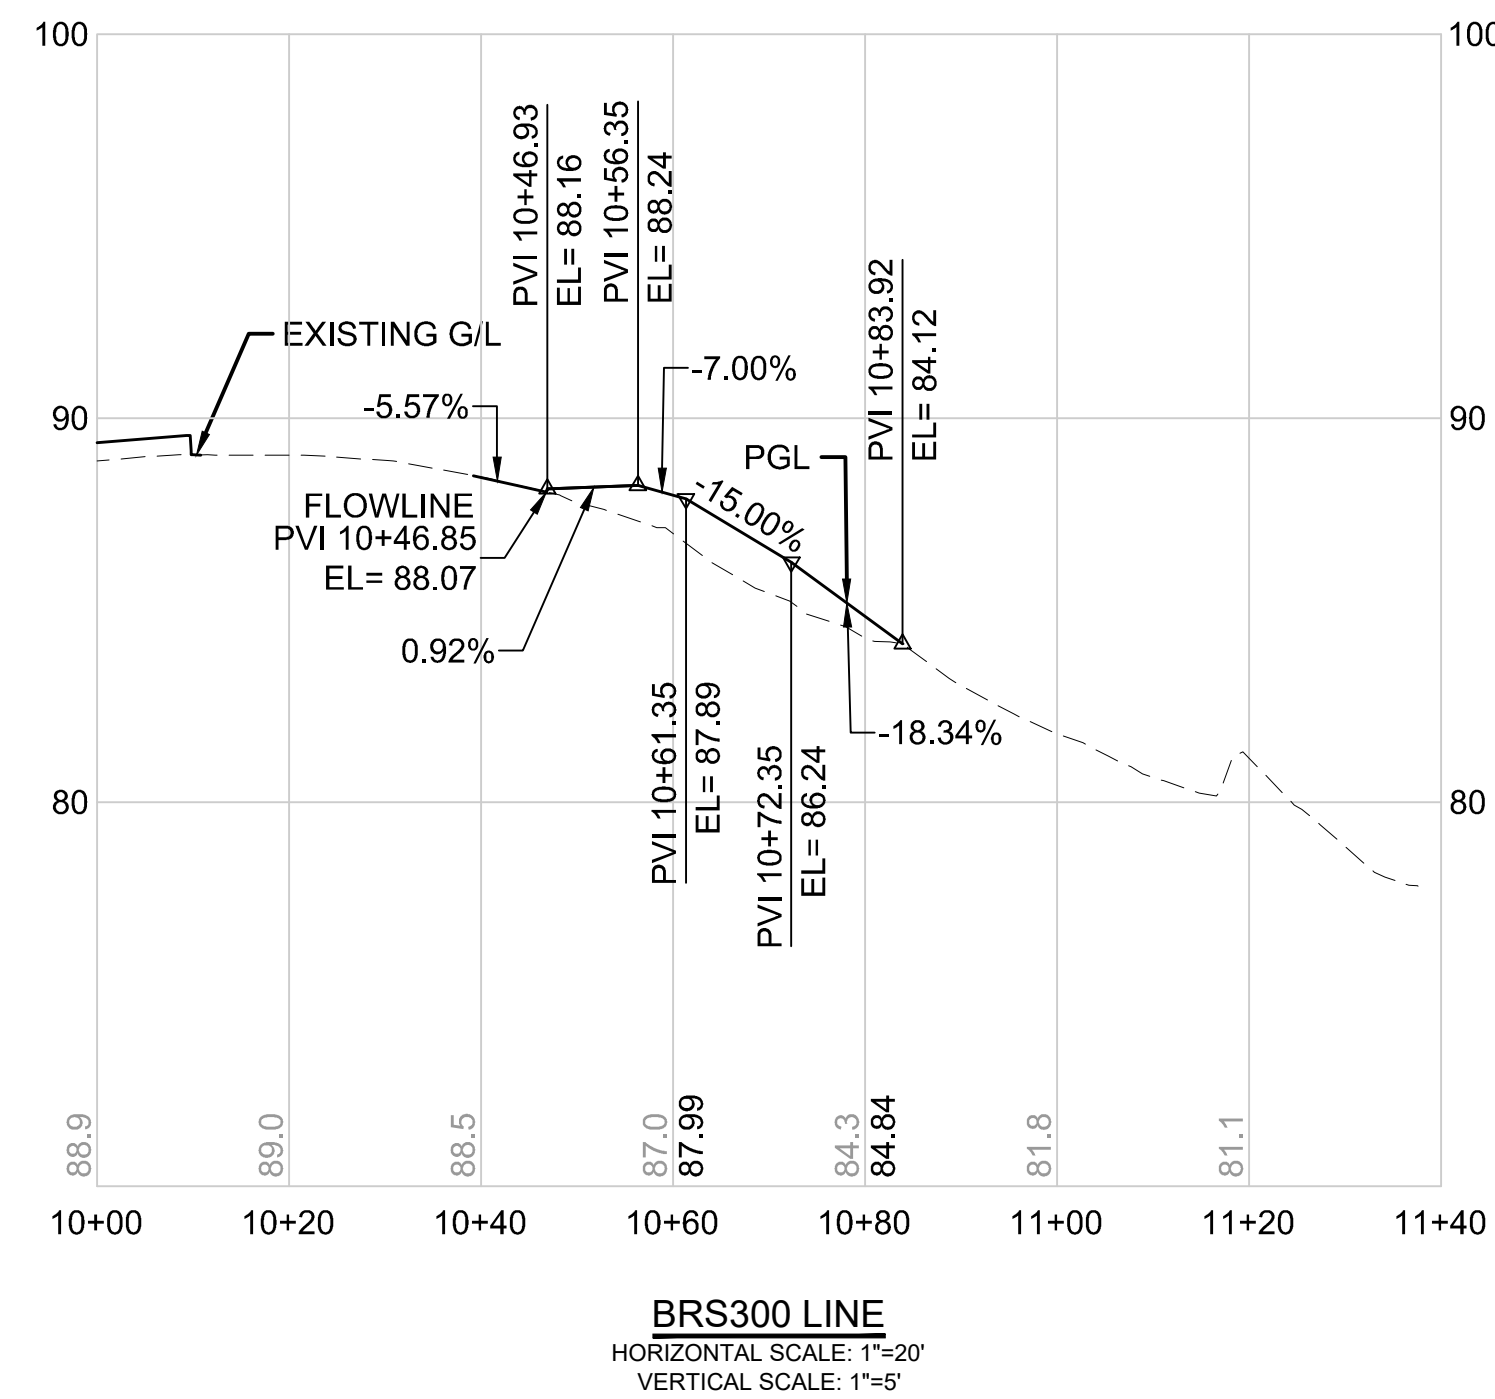


DRAFT 30% SUBMITTAL						DESIGNED BY: C.MATYAS		MANUEL L. FELIBERTI STATE OF WASHINGTON PRELIMINARY REGISTERED PROFESSIONAL ENGINEER 36546	DE DAVID EVANS AND ASSOCIATES INC. 14432 SE Eastgate Way, Suite 400 Bellevue Washington 98007 Phone: 425.519.6500 LINE IS 1" AT FULL SCALE ST SOUNDTRANSIT				SCALE: 1"=20'		SR 522 / NE 145TH BRT SR 522 (BOTHELL WAY NE) CIVIL DRIVEWAY PLAN AND PROFILE BRS300 STA. 10+00 TO STA. 11+31.70				DRAWING No.: 522-CRV234	
						DRAWN BY: C.BRESLEY							FILENAME: BRT-522-CRV227-236						FACILITY ID: 522	
CHECKED BY: R.KOESTER		CONTRACT No.: AE 0055-17		SHEET No.: 138 OF 283																
APPROVED BY:		DATE:		DATE:		REV:														
M.FELIBERTI		D.SCHOCK		B.KEMPER																
		09/11/2020		09/11/2020		09/11/2020														
No.	DATE	DSN	CHK	APP	REVISION															

09/10/20 | 1:48 AM | SJRO
C:\PW_WORK\DEA\STEVEN ROSE\DWG\BRT-522-CRV227-236.DWG

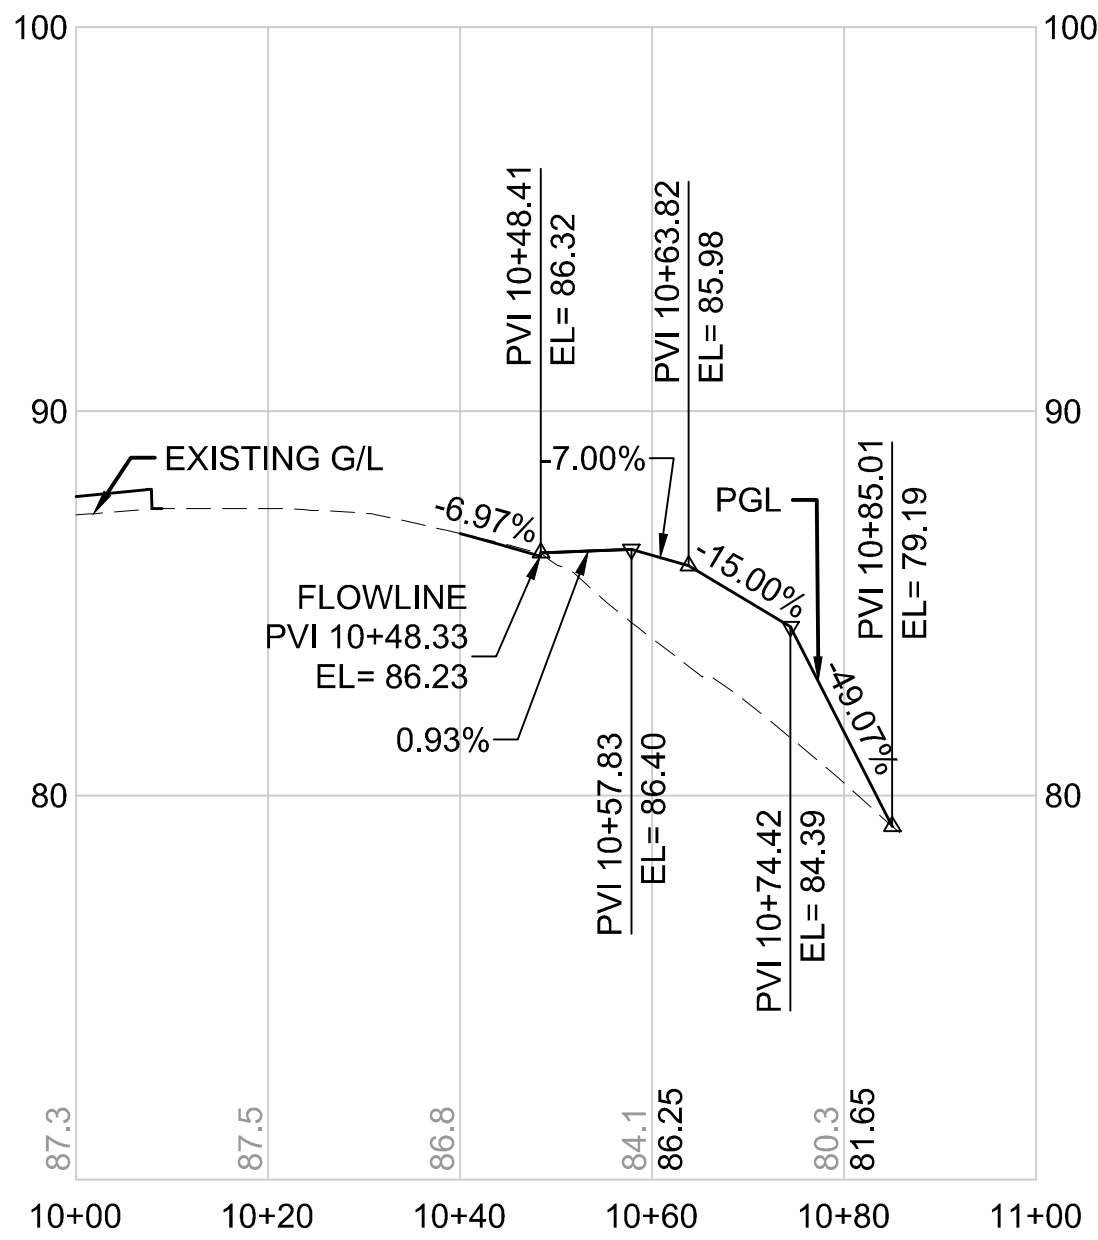

BRS302-S LINE
HORIZONTAL SCALE: 1"=20'
VERTICAL SCALE: 1"=5'

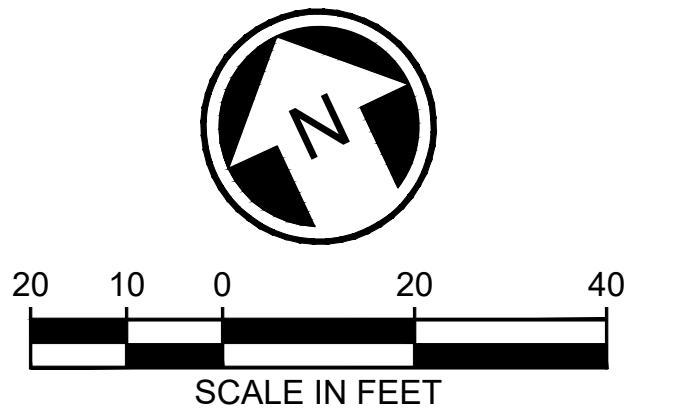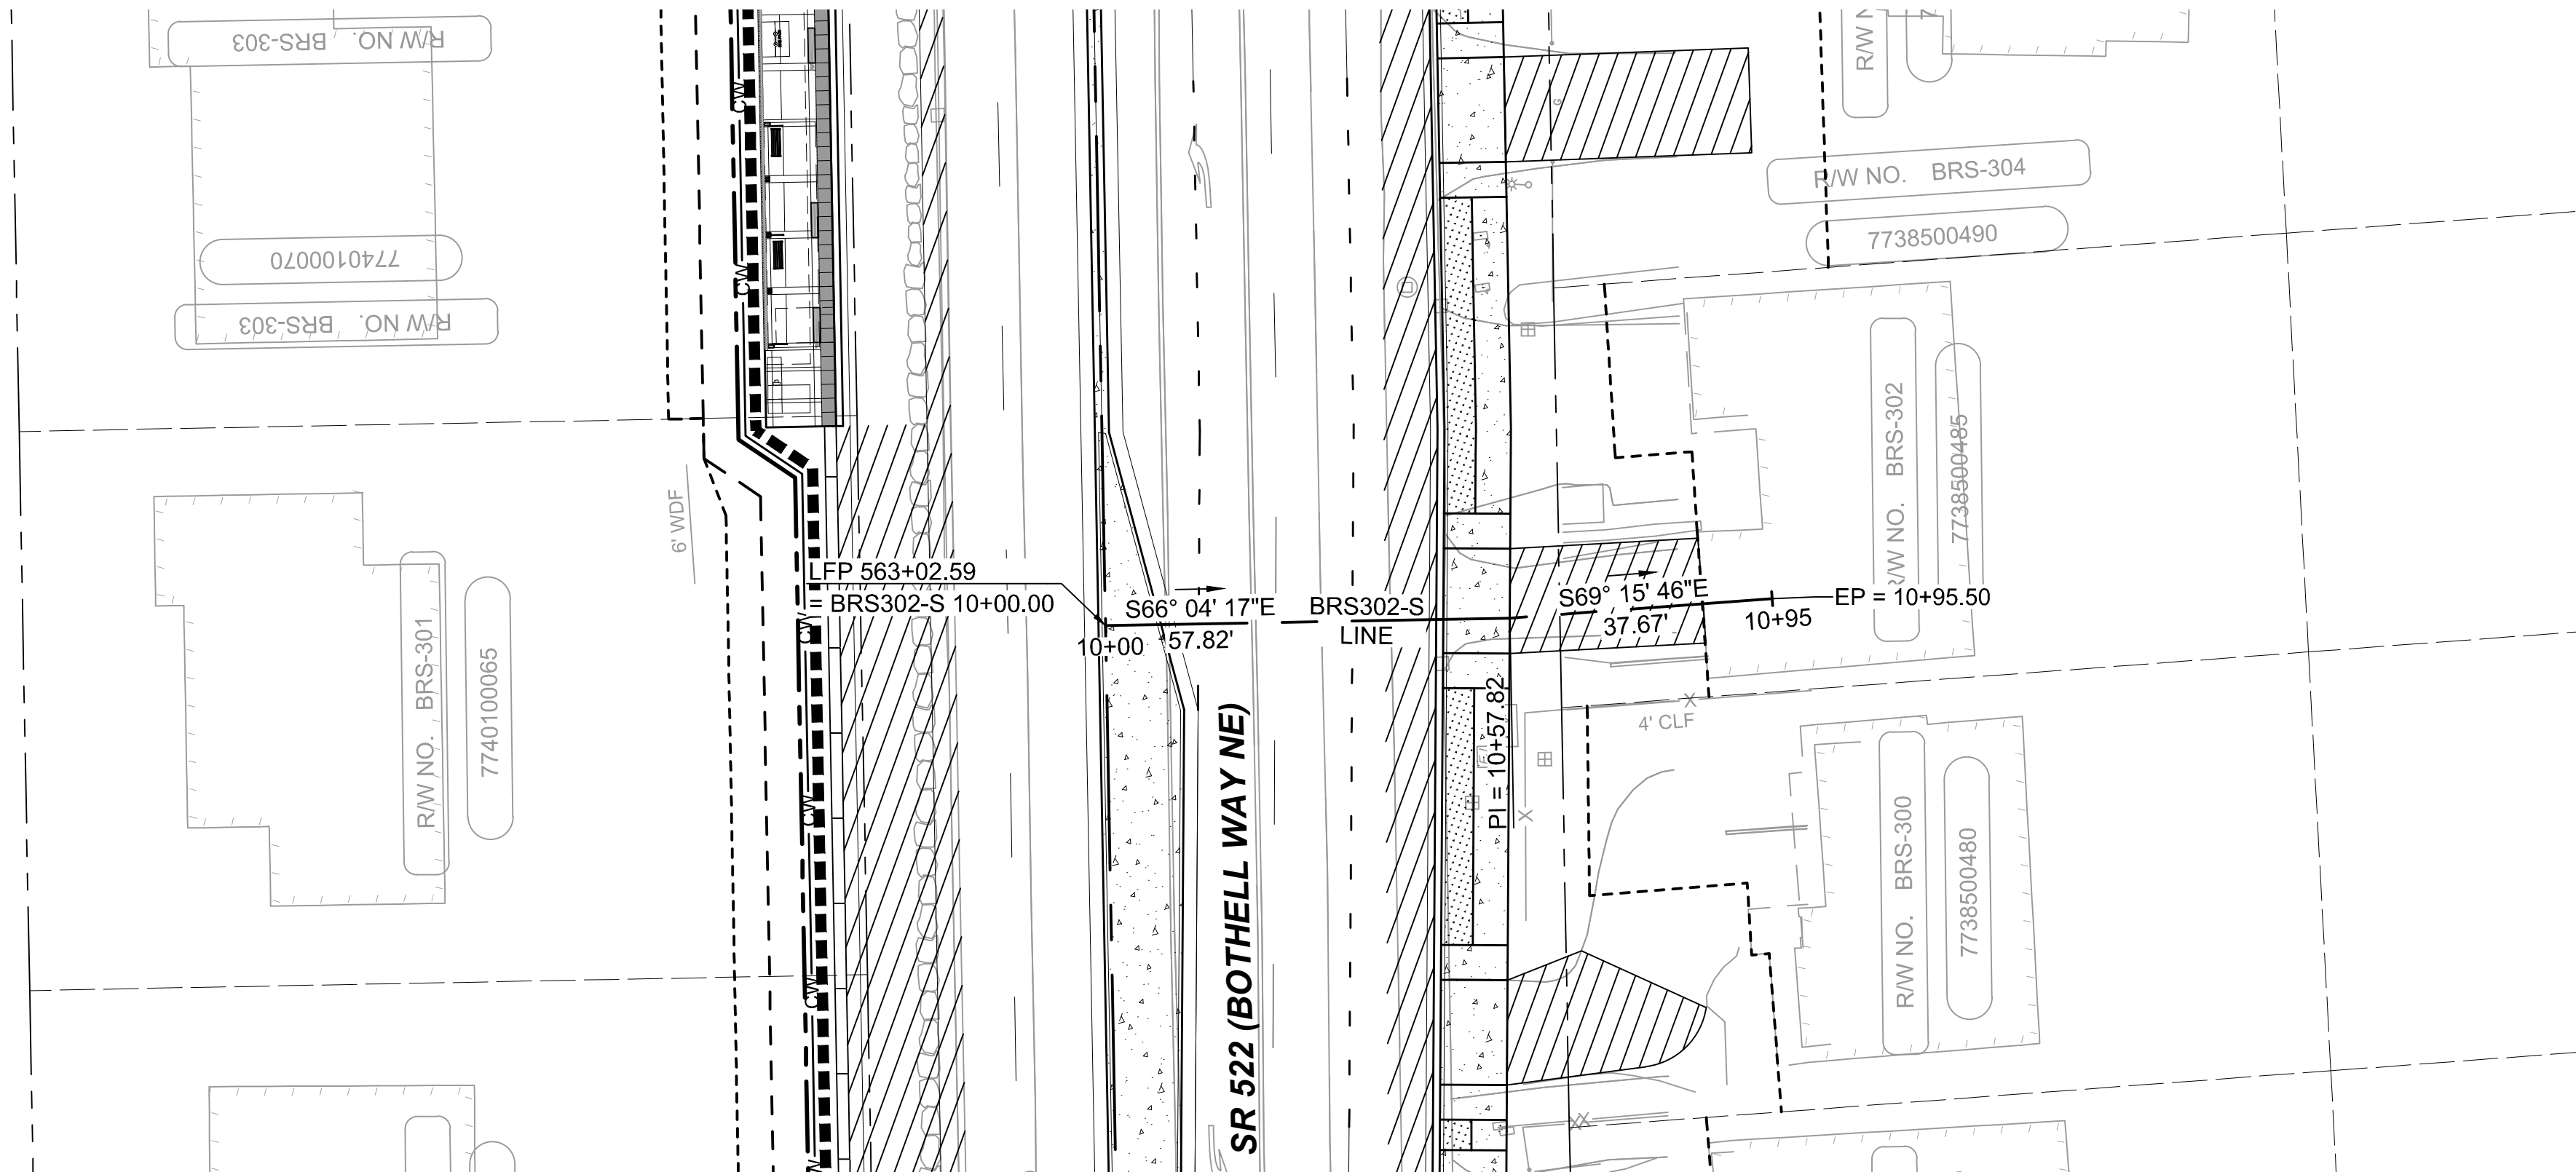

DRAFT 30% SUBMITTAL


No.	DATE	DSN	CHK	APP	REVISION

DESIGNED BY:	C.MATYAS
DRAWN BY:	C.BRESLEY
CHECKED BY:	R.KOESTER
APPROVED BY:	M.FELIBERTI



DAVID EVANS
AND ASSOCIATES INC.
14432 SE Eastgate Way, Suite 400
Bellevue Washington 98007
Phone: 425.519.6500

SUBMITTED BY:	DATE:	REVIEWED BY:
D.SCHOCK	09/11/2020	B.KEMPER



 


SCALE:	1"=20'
FILENAME:	BRT-522-CRV227-236
CONTRACT No.:	AE 0055-17
DATE:	09/11/2020

SR 522 / NE 145TH BRT
SR 522 (BOTHELL WAY NE)
CIVIL
DRIVEWAY PLAN AND PROFILE BRS302-S
STA. 10+00 TO STA. 10+95.50

DRAWING No.:	522-CRV235
FACILITY ID:	522
SHEET No.:	139 OF 283
REV:	

09/10/20 | 1:49 AM | SJRO
C:\PW_WORK\DEA\STEVEN ROSE\DMIS06735\BRT-522-CRV227-236.DWG

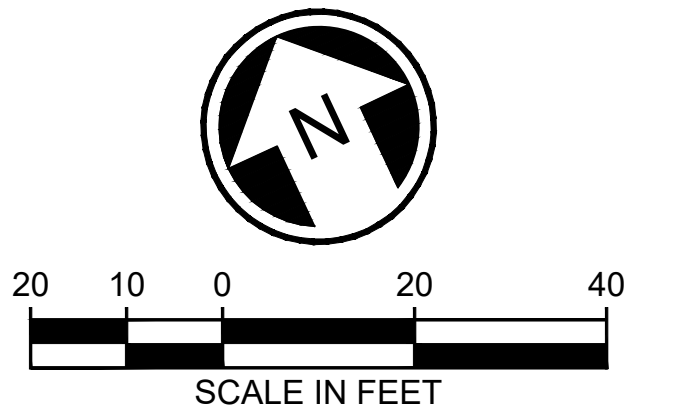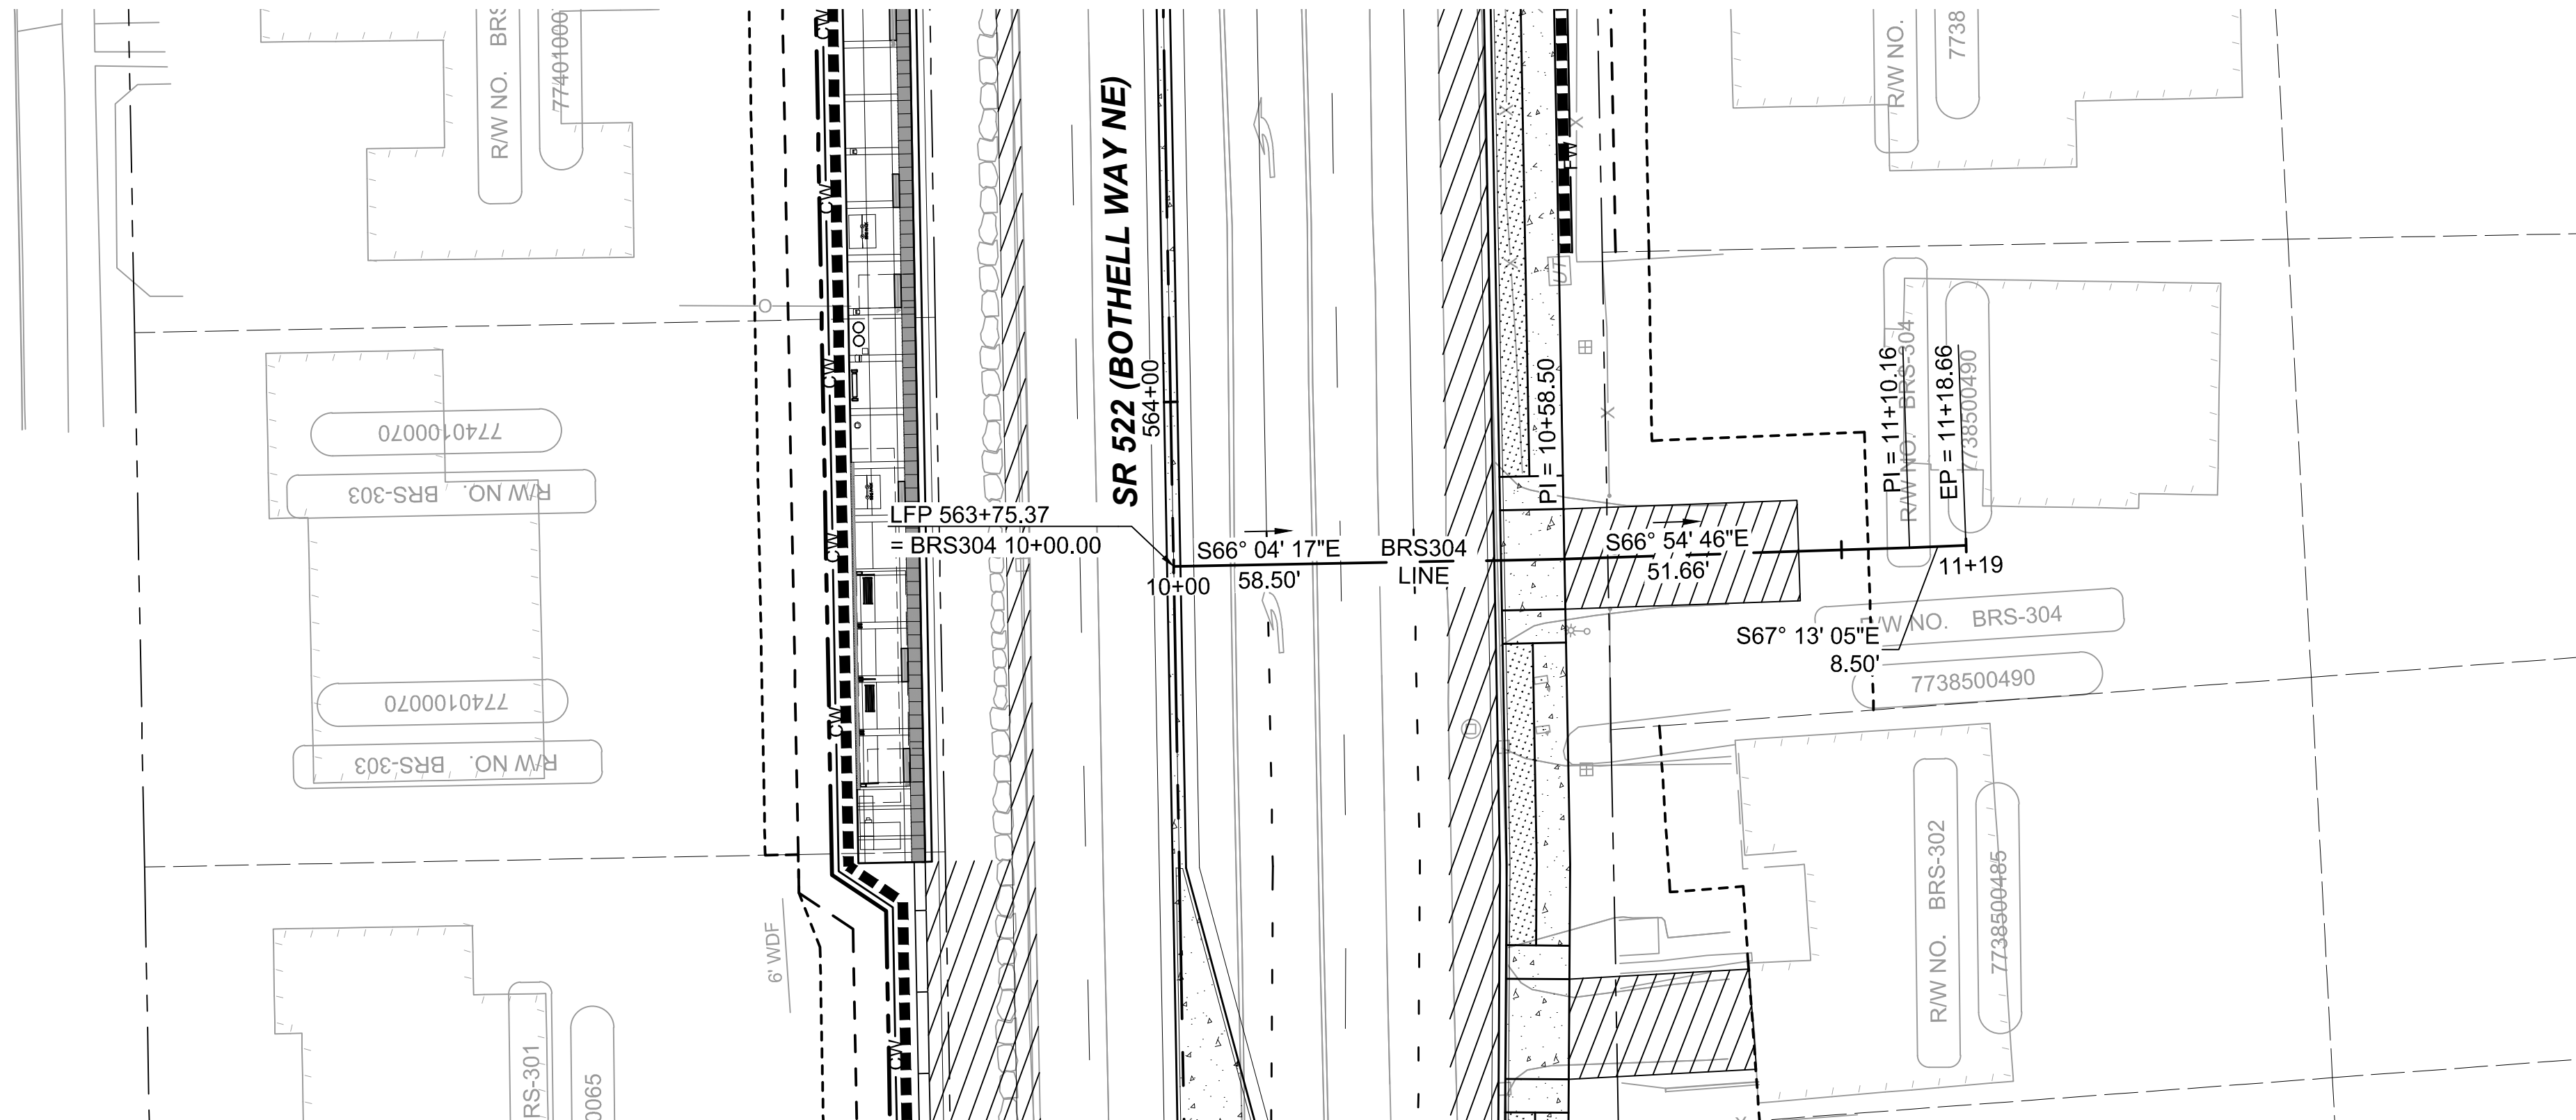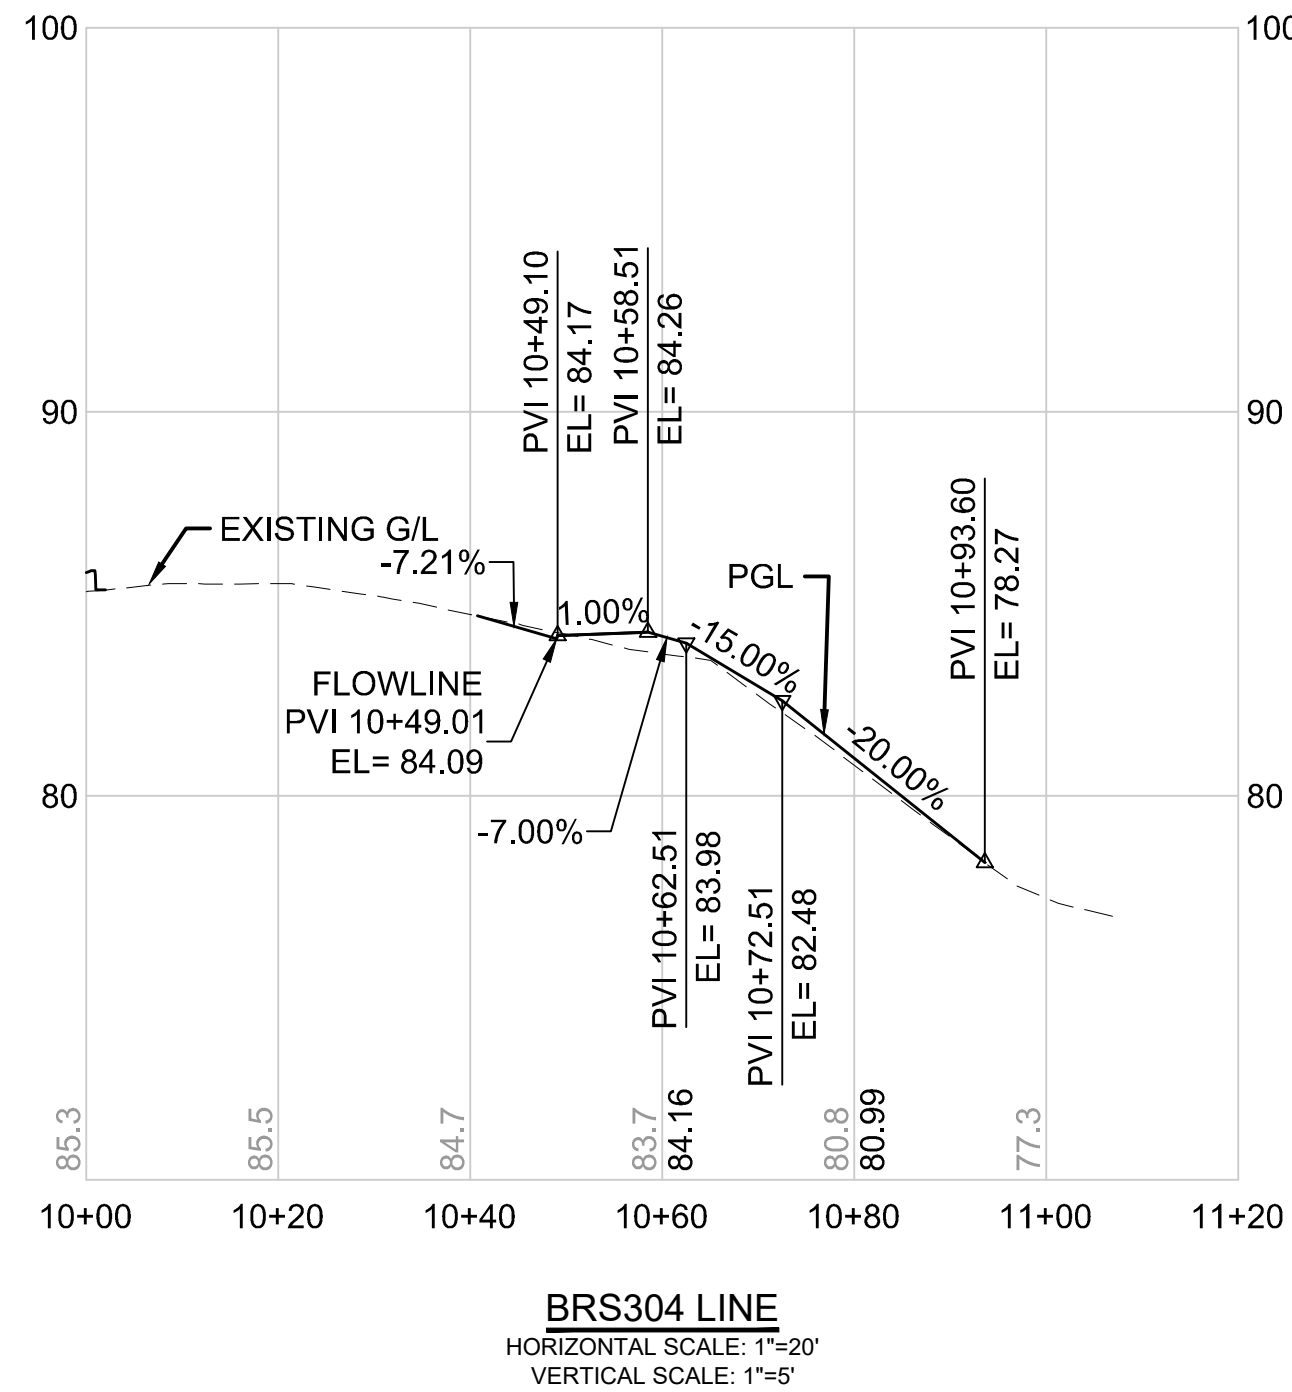

DRAFT 30% SUBMITTAL

No.	DATE	DSN	CHK	APP	REVISION

DESIGNED BY:
C.MATYAS

DRAWN BY:
C.BRESLEY

CHECKED BY:
R.KOESTER

APPROVED BY:
M.FELIBERTI



**DAVID EVANS
AND ASSOCIATES INC.**
14432 SE Eastgate Way, Suite 400
Bellevue Washington 98007
Phone: 425.519.6500

SUBMITTED BY:
D.SCHOCK

DATE:
09/11/2020

REVIEWED BY:
B.KEMPER



DATE:
09/11/2020

SCALE:
1"=20'

FILENAME:
BRT-522-CRV227-236

CONTRACT No.:
AE 0055-17

DATE:
09/11/2020

SR 522 / NE 145TH BRT

SR 522 (BOTHELL WAY NE)

CIVIL

DRIVEWAY PLAN AND PROFILE BRS304




STA. 10+00 TO STA. 11+18.66

DRAWING No.:
522-CRV236

FACILITY ID:
522

SHEET No.:
140 OF 283

09/10/20 | 1:55 AM | SJRO
C:\PW_WORK\DEA\STEVEN ROSE\DWG\BRT-522-CRV\237-250.DWG

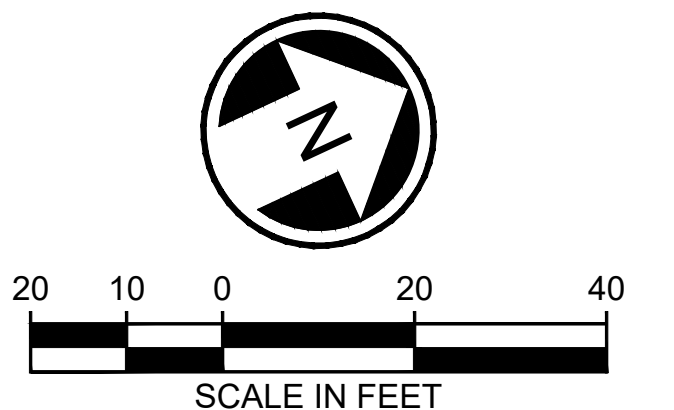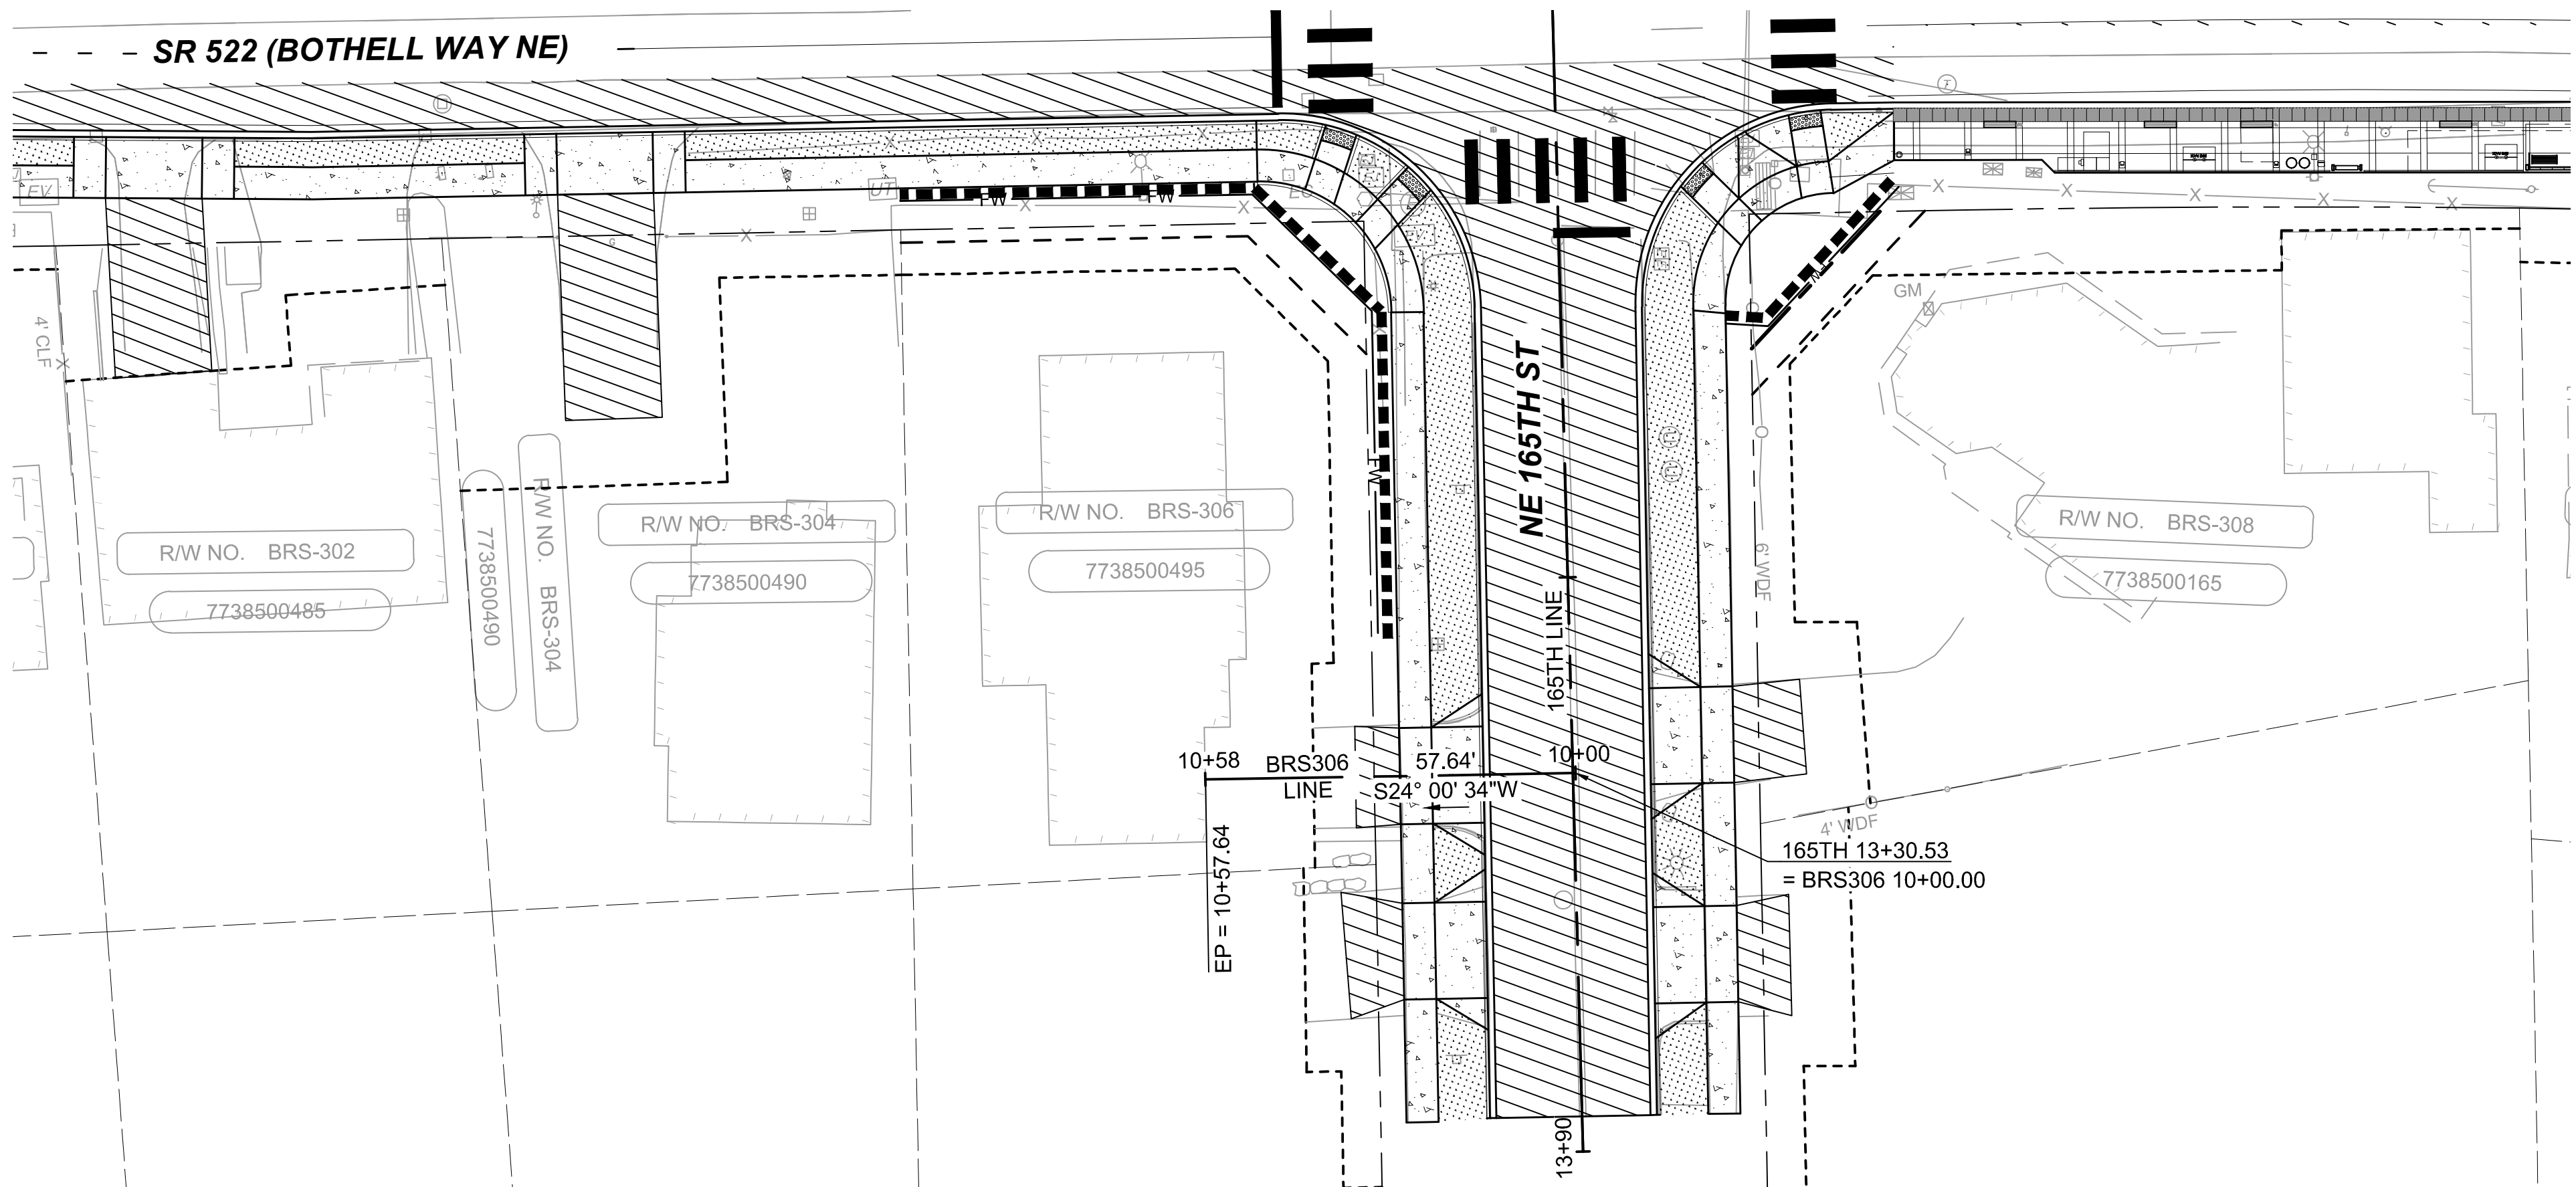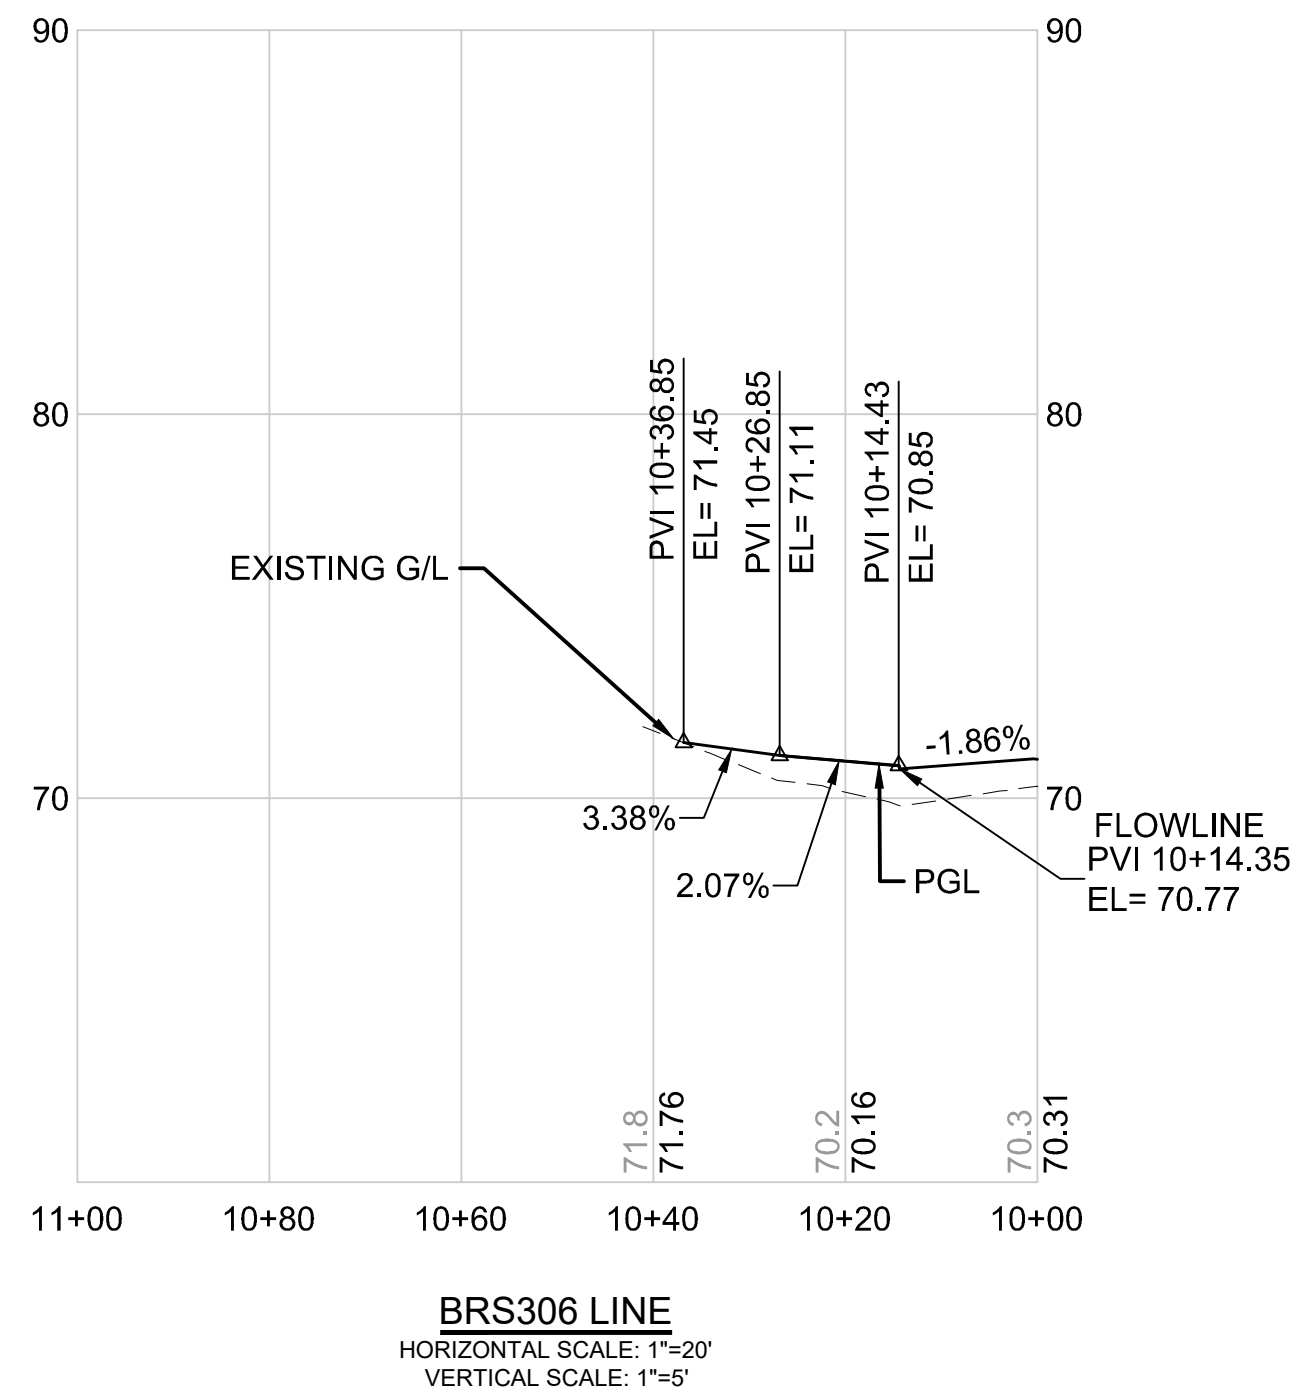


DRAFT 30% SUBMITTAL

DESIGNED BY:
C.MATYAS
DRAWN BY:
C.BRESLEY
CHECKED BY:
R.KOESTER
APPROVED BY:
M.FELIBERTI



 **DAVID EVANS
AND ASSOCIATES INC.**
14432 SE Eastgate Way, Suite 400
Bellevue Washington 98007
Phone: 425.519.6500



SOUNDTRANSIT


SCALE:
1"=20'
FILENAME:
BRT-522-CRV237-250
CONTRACT No.:
AE 0055-17
DATE:
09/11/2020

SR 522 / NE 145TH BRT
SR 522 (BOTHELL WAY NE)
CIVIL
DRIVEWAY PLAN AND PROFILE BRS306
STA. 10+00 TO STA. 10+57.64



DRAWING No.:
522-CRV237
FACILITY ID:
522
SHEET No.:
141 OF 283
REV:

SUBMITTED BY: D.SCHOCK
DATE: 09/11/2020
REVIEWED BY: B.KEMPER
DATE: 09/11/2020

09/10/20 | 1:56 AM | SJRO
C:\PW_WORK\DEA\STEVEN ROSE\DWG\BRT-522-CRV\237-250.DWG

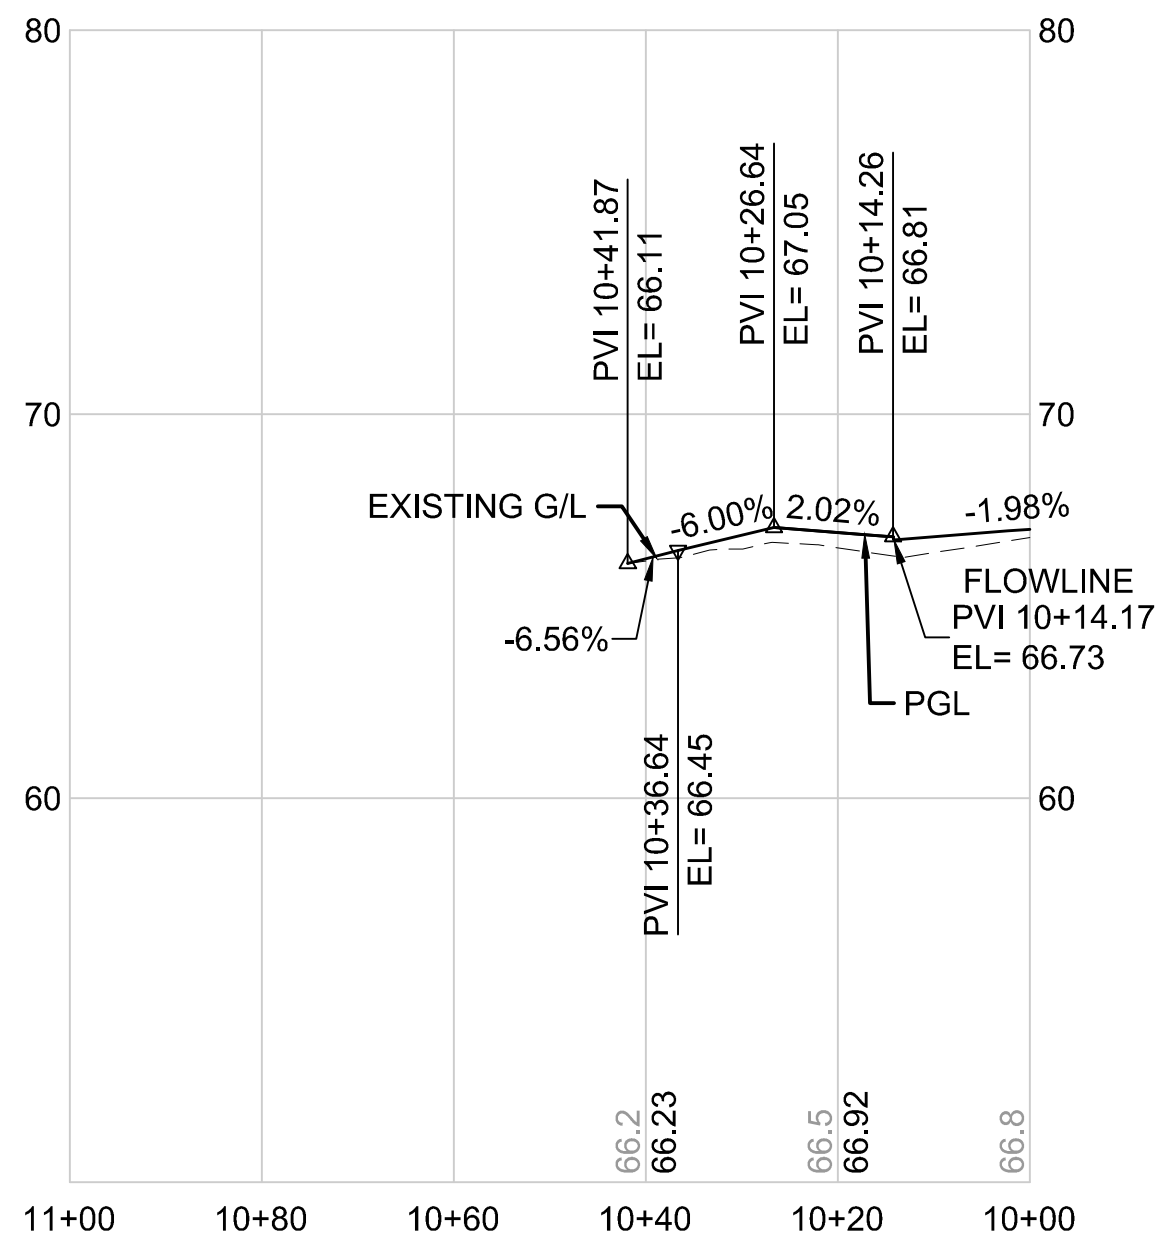

BRS306.1 LINE
HORIZONTAL SCALE: 1"=20'
VERTICAL SCALE: 1"=5'

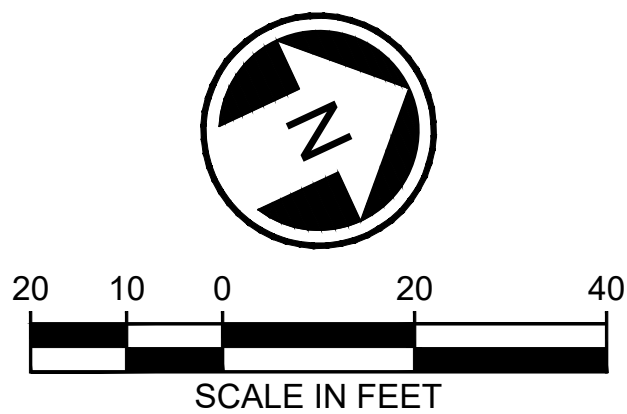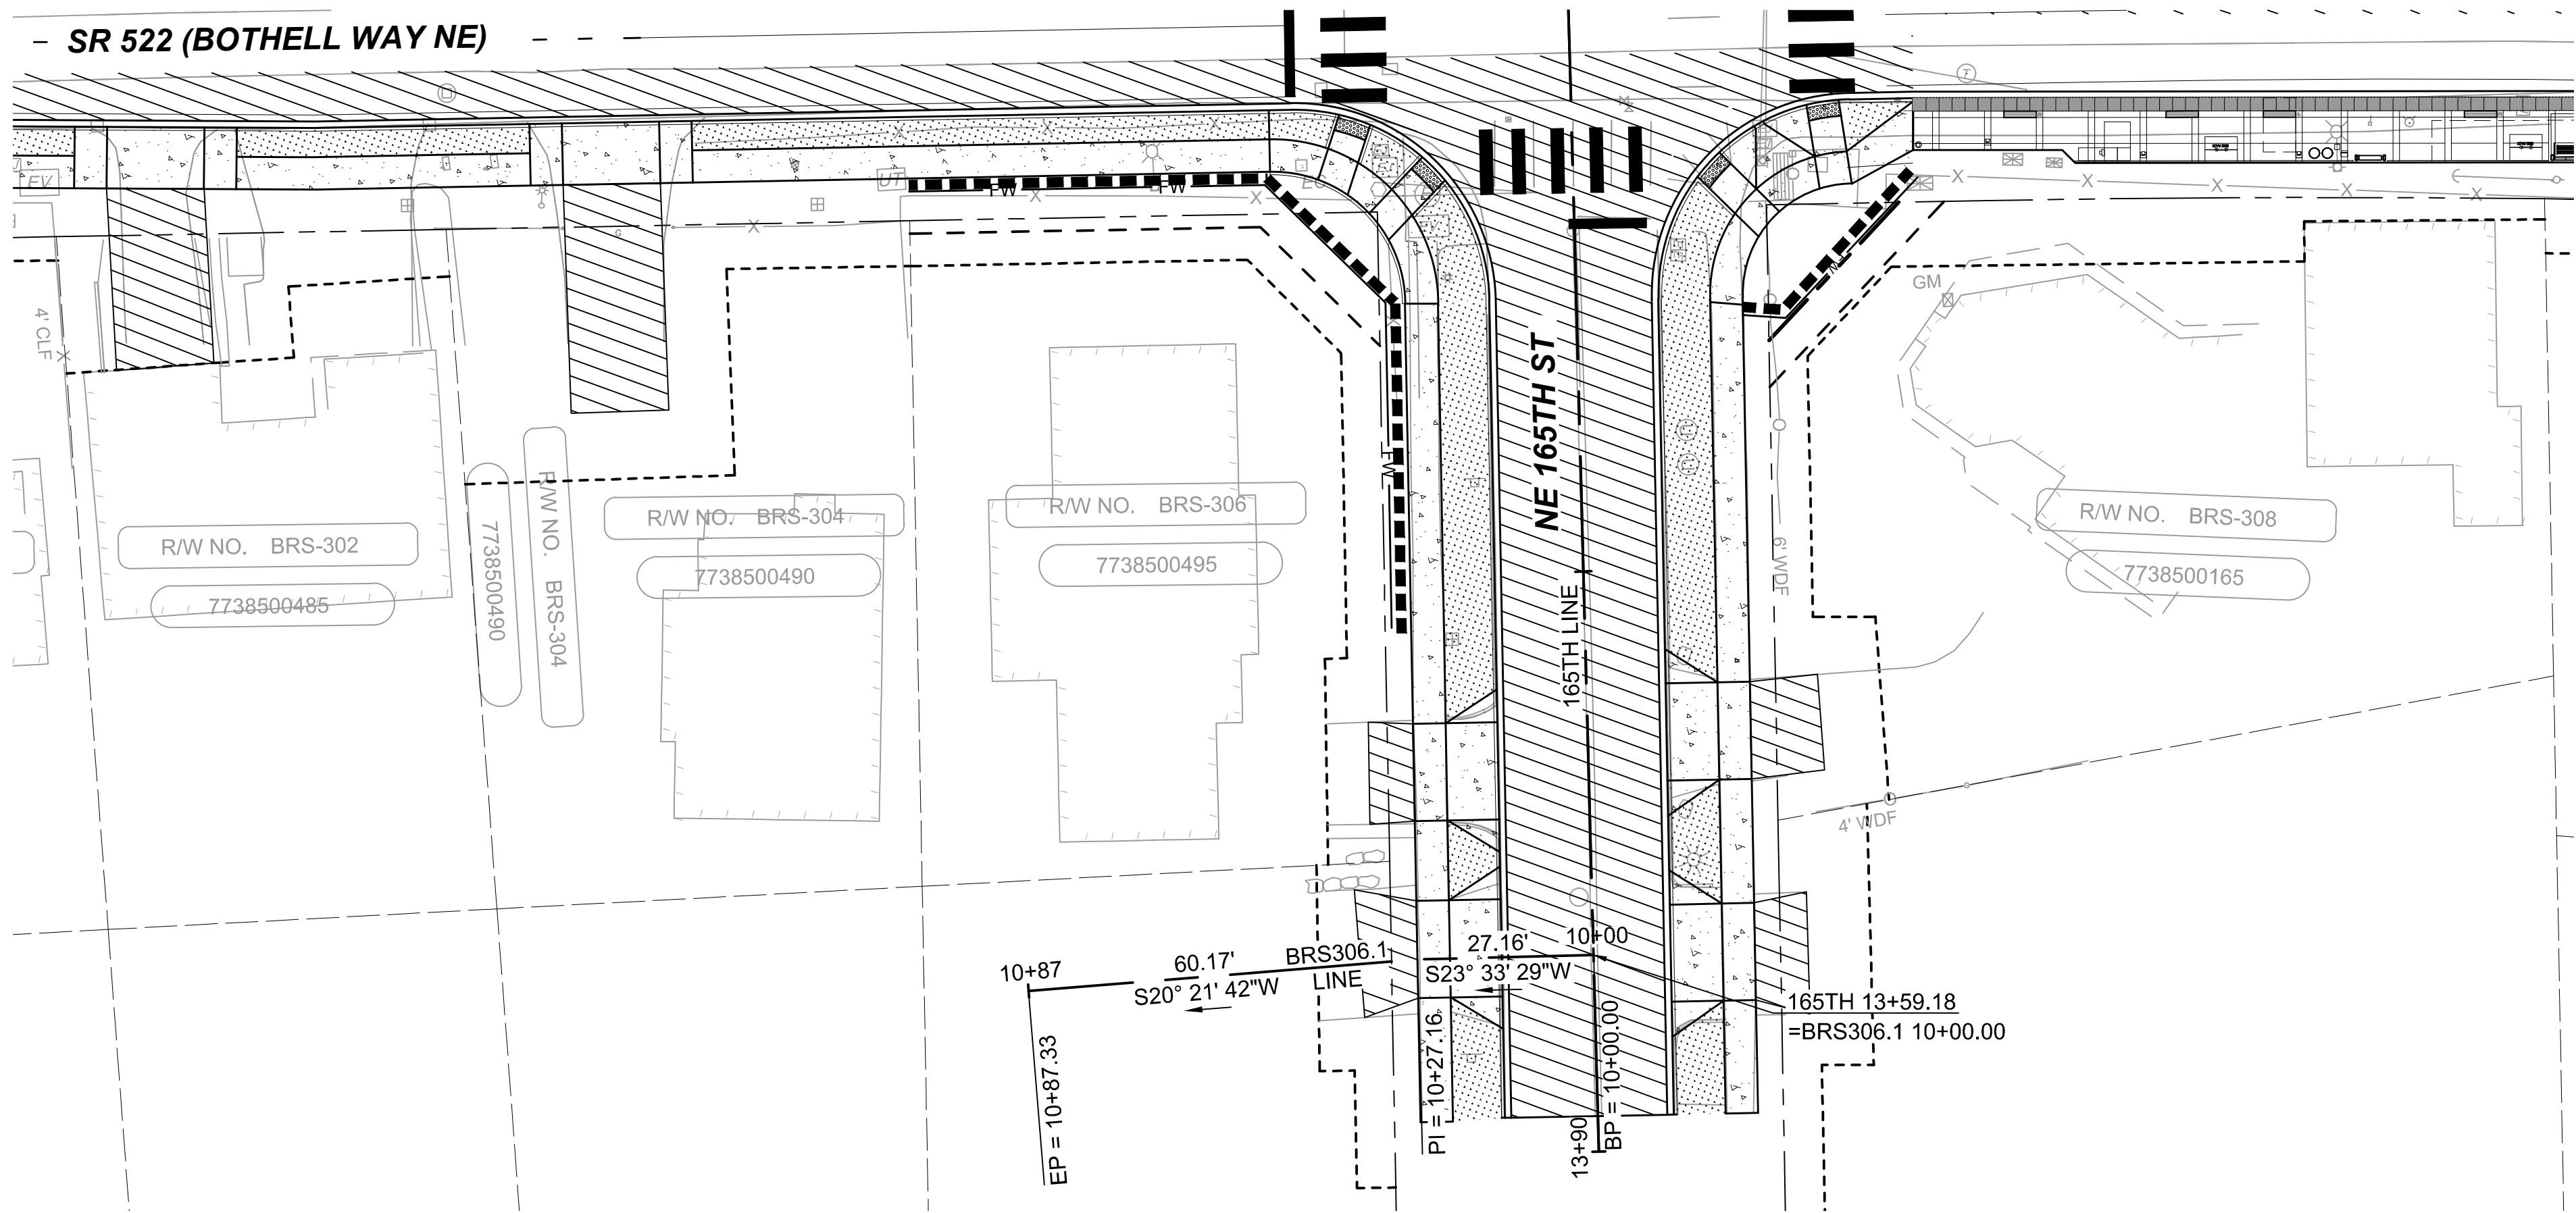

DRAFT 30% SUBMITTAL


No.	DATE	DSN	CHK	APP	REVISION

DESIGNED BY:	C.MATYAS
DRAWN BY:	C.BRESLEY
CHECKED BY:	R.KOESTER
APPROVED BY:	M.FELIBERTI



**DAVID EVANS
AND ASSOCIATES INC.**
14432 SE Eastgate Way, Suite 400
Bellevue Washington 98007
Phone: 425.519.6500

SUBMITTED BY:	DATE:	REVIEWED BY:	DATE:
D.SCHOCK	09/11/2020	B.KEMPER	09/11/2020



 


SCALE:	1"=20'
FILENAME:	BRT-522-CRV237-250
CONTRACT No.:	AE 0055-17
DATE:	09/11/2020

SR 522 / NE 145TH BRT
SR 522 (BOTHELL WAY NE)
CIVIL
DRIVEWAY PLAN AND PROFILE BRS306.1
STA. 10+00 TO STA. 10+87.33

DRAWING No.:	522-CRV238
FACILITY ID:	522
SHEET No.:	142 OF 283
REV:	

09/10/20 | 1:57 AM | SJRO
C:\PW_WORK\DEA\STEVEN ROSE\DWG\BRT-522-CRV237-250.DWG

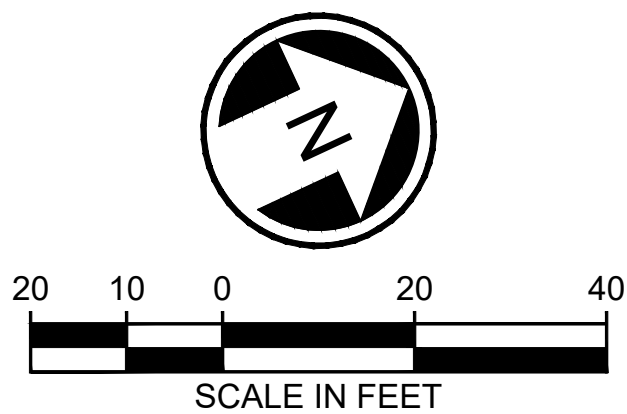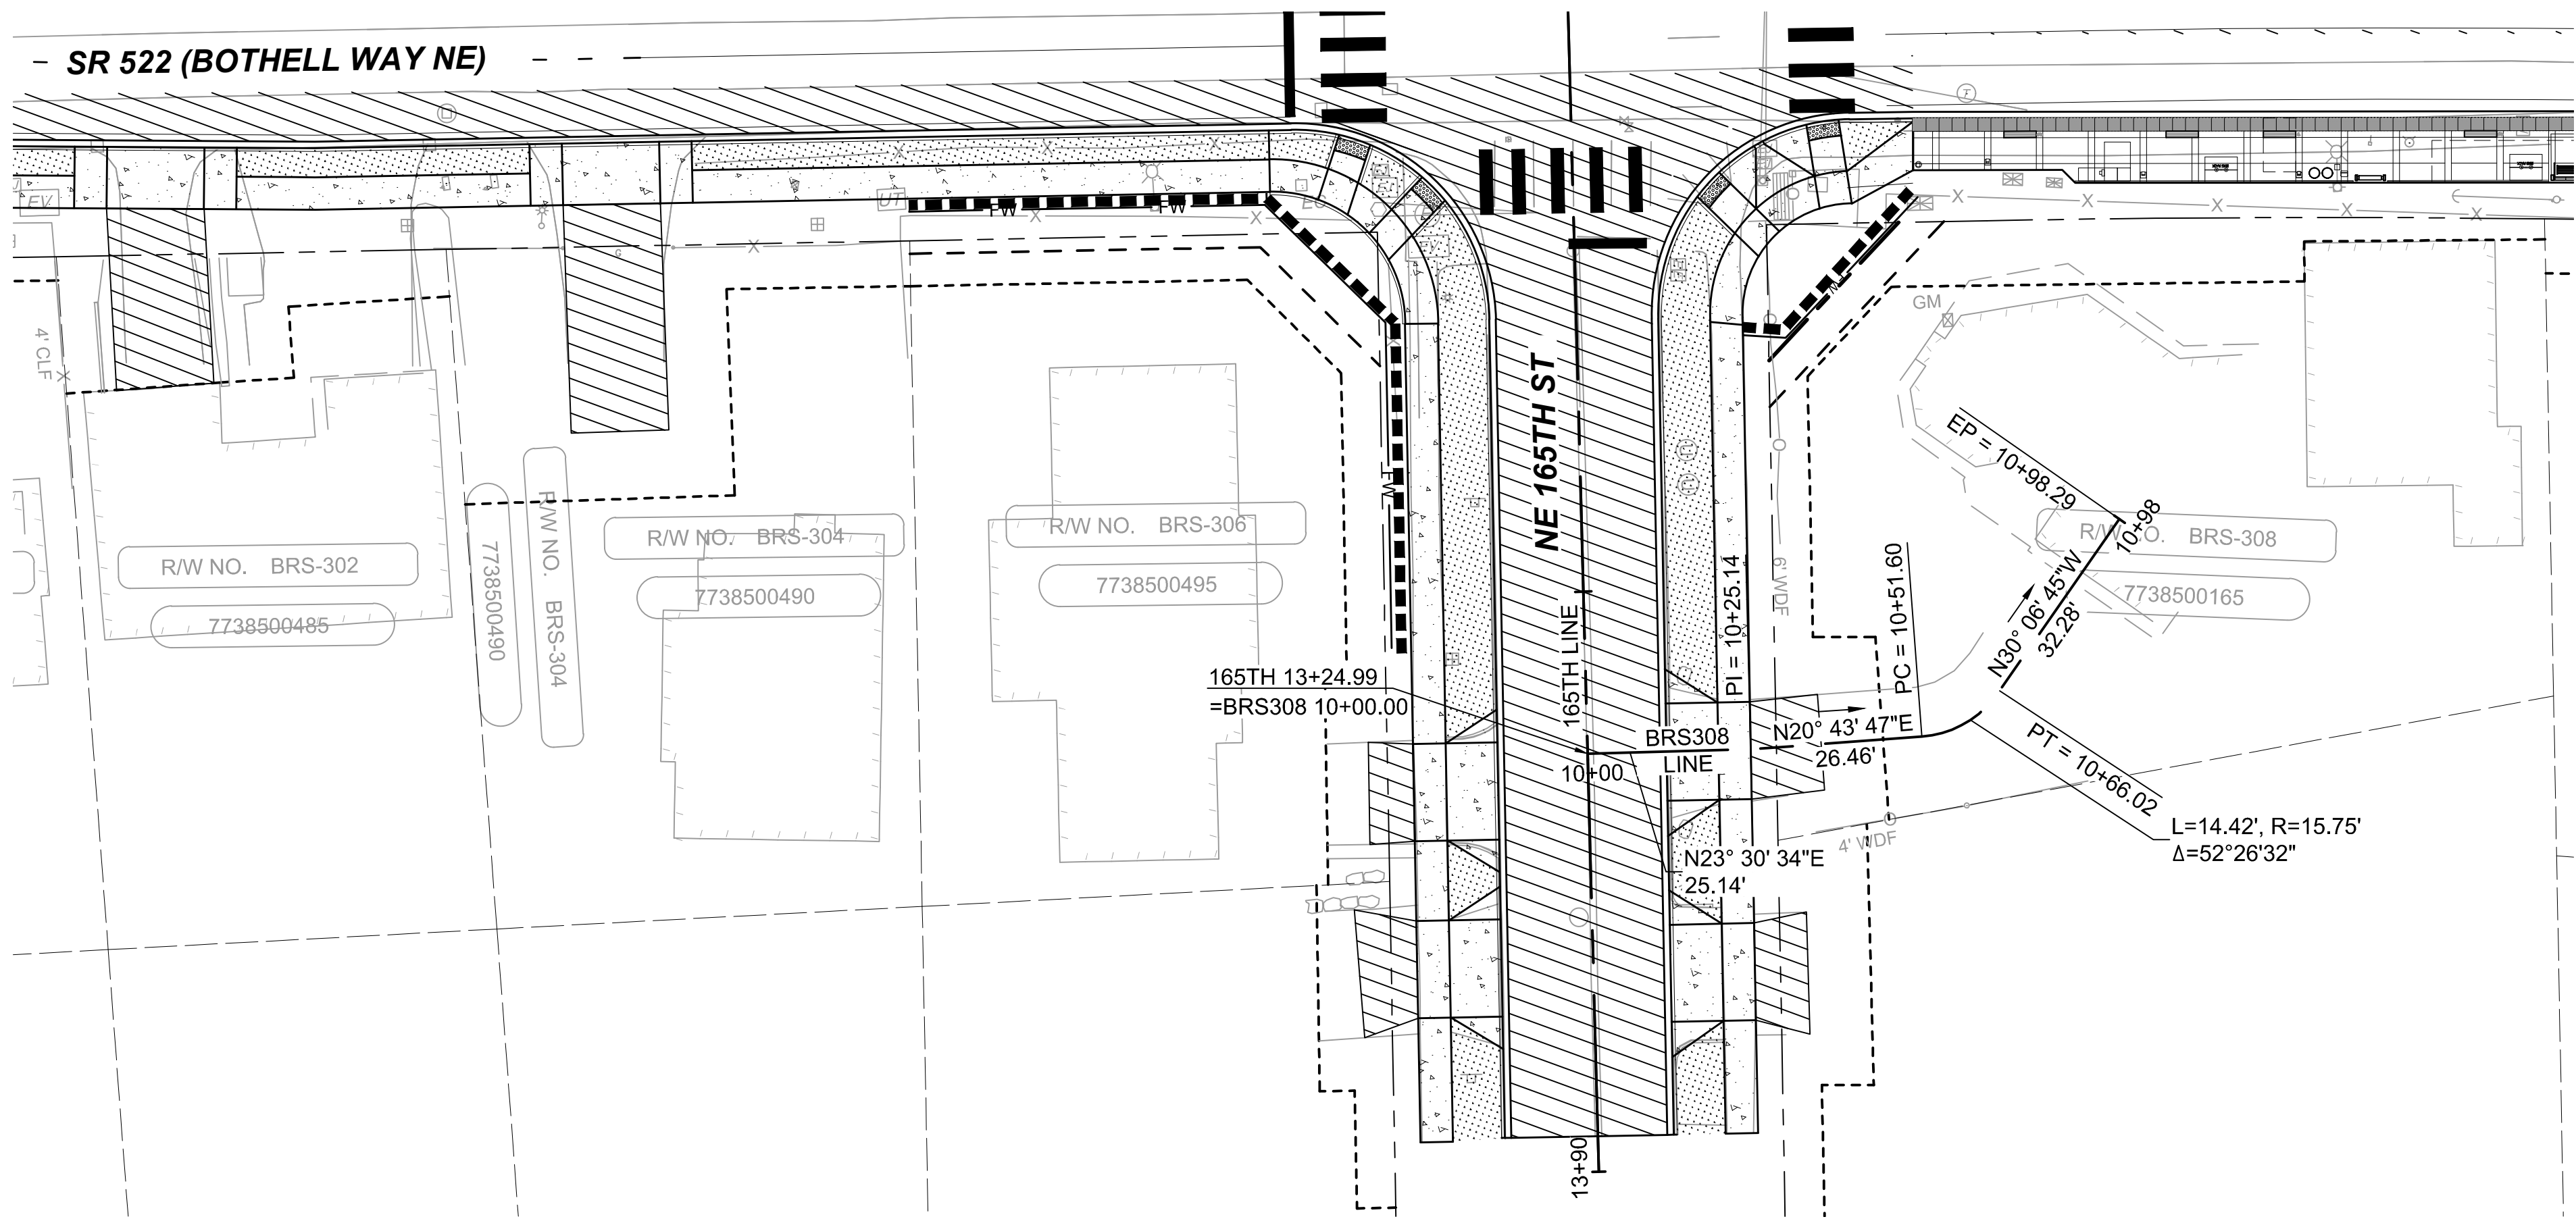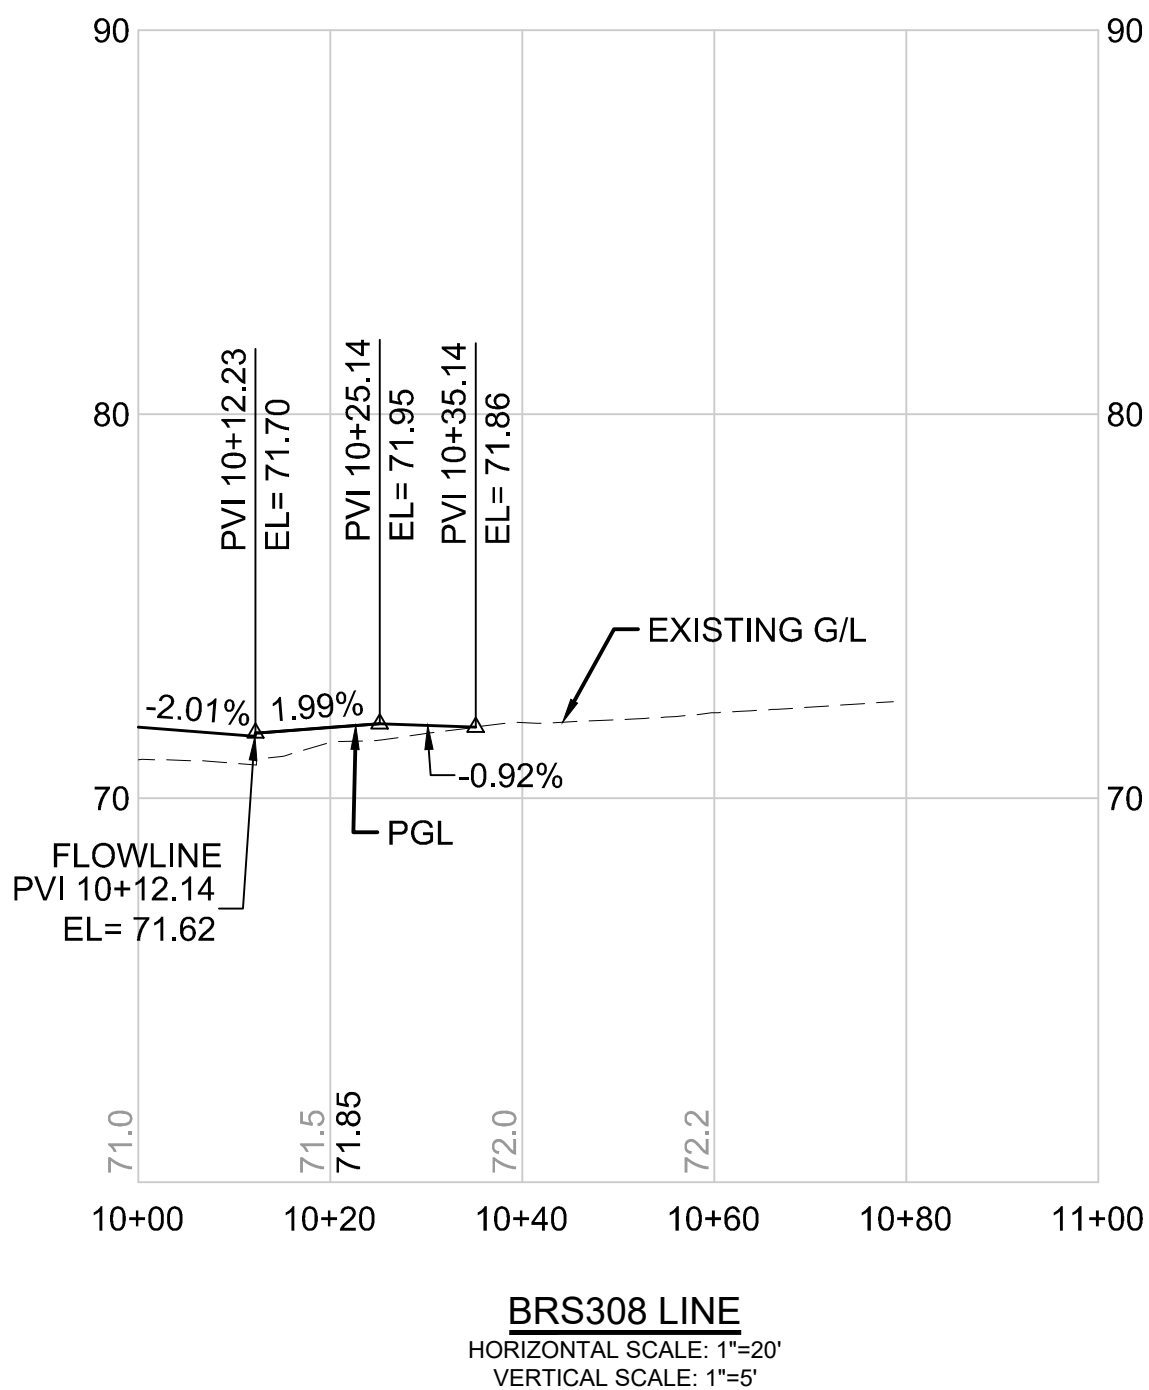

DRAFT 30% SUBMITTAL

No.	DATE	DSN	CHK	APP	REVISION

DESIGNED BY:
C.MATYAS
DRAWN BY:
C.BRESLEY
CHECKED BY:
R.KOESTER
APPROVED BY:
M.FELIBERTI



**DAVID EVANS
AND ASSOCIATES INC.**
14432 SE Eastgate Way, Suite 400
Bellevue Washington 98007
Phone: 425.519.6500

SUBMITTED BY:
D.SCHOCK

DATE:
09/11/2020

REVIEWED BY:
B.KEMPER






DATE:
09/11/2020

SCALE:
1"=20'
FILENAME:
BRT-522-CRV237-250
CONTRACT No.:
AE 0055-17
DATE:
09/11/2020

SR 522 / NE 145TH BRT
SR 522 (BOTHELL WAY NE)
CIVIL
DRIVEWAY PLAN AND PROFILE BRS308
STA. 10+00 TO STA. 10+98.29

DRAWING No.:
522-CRV239
FACILITY ID:
522
SHEET No.:
143 OF 283
REV:

09/10/20 | 1:58 AM | SJRO
C:\PW_WORK\DEA\STEVEN ROSE\DWG\BRT-522-CRV\237-250.DWG

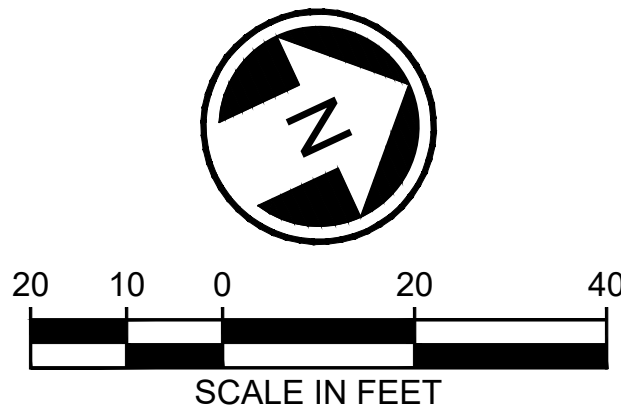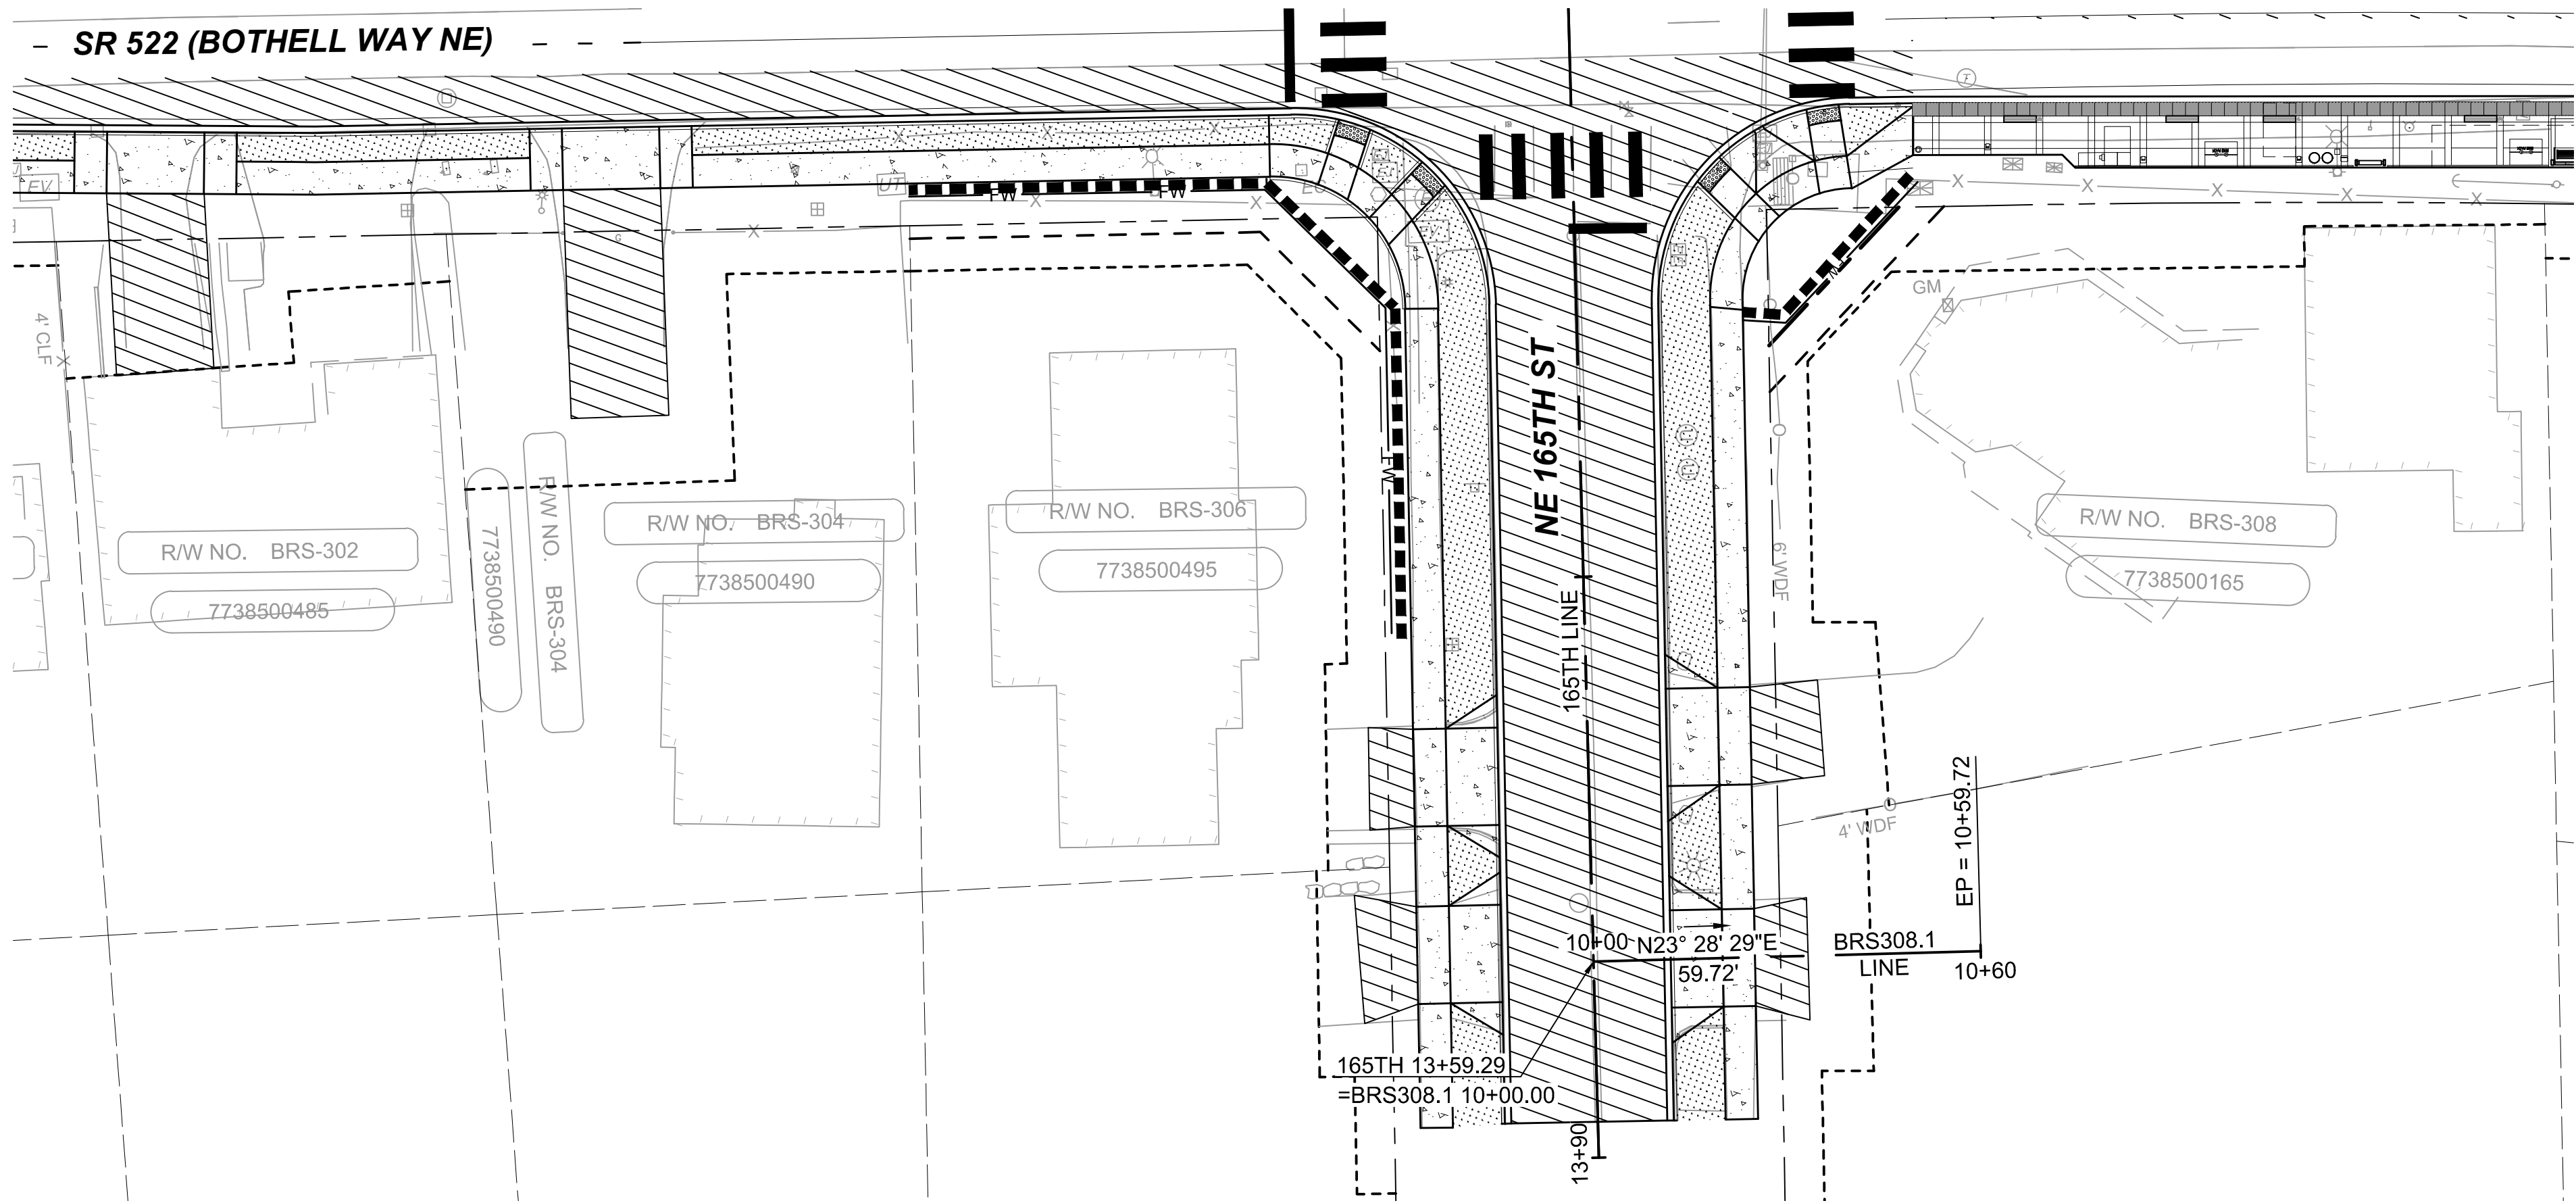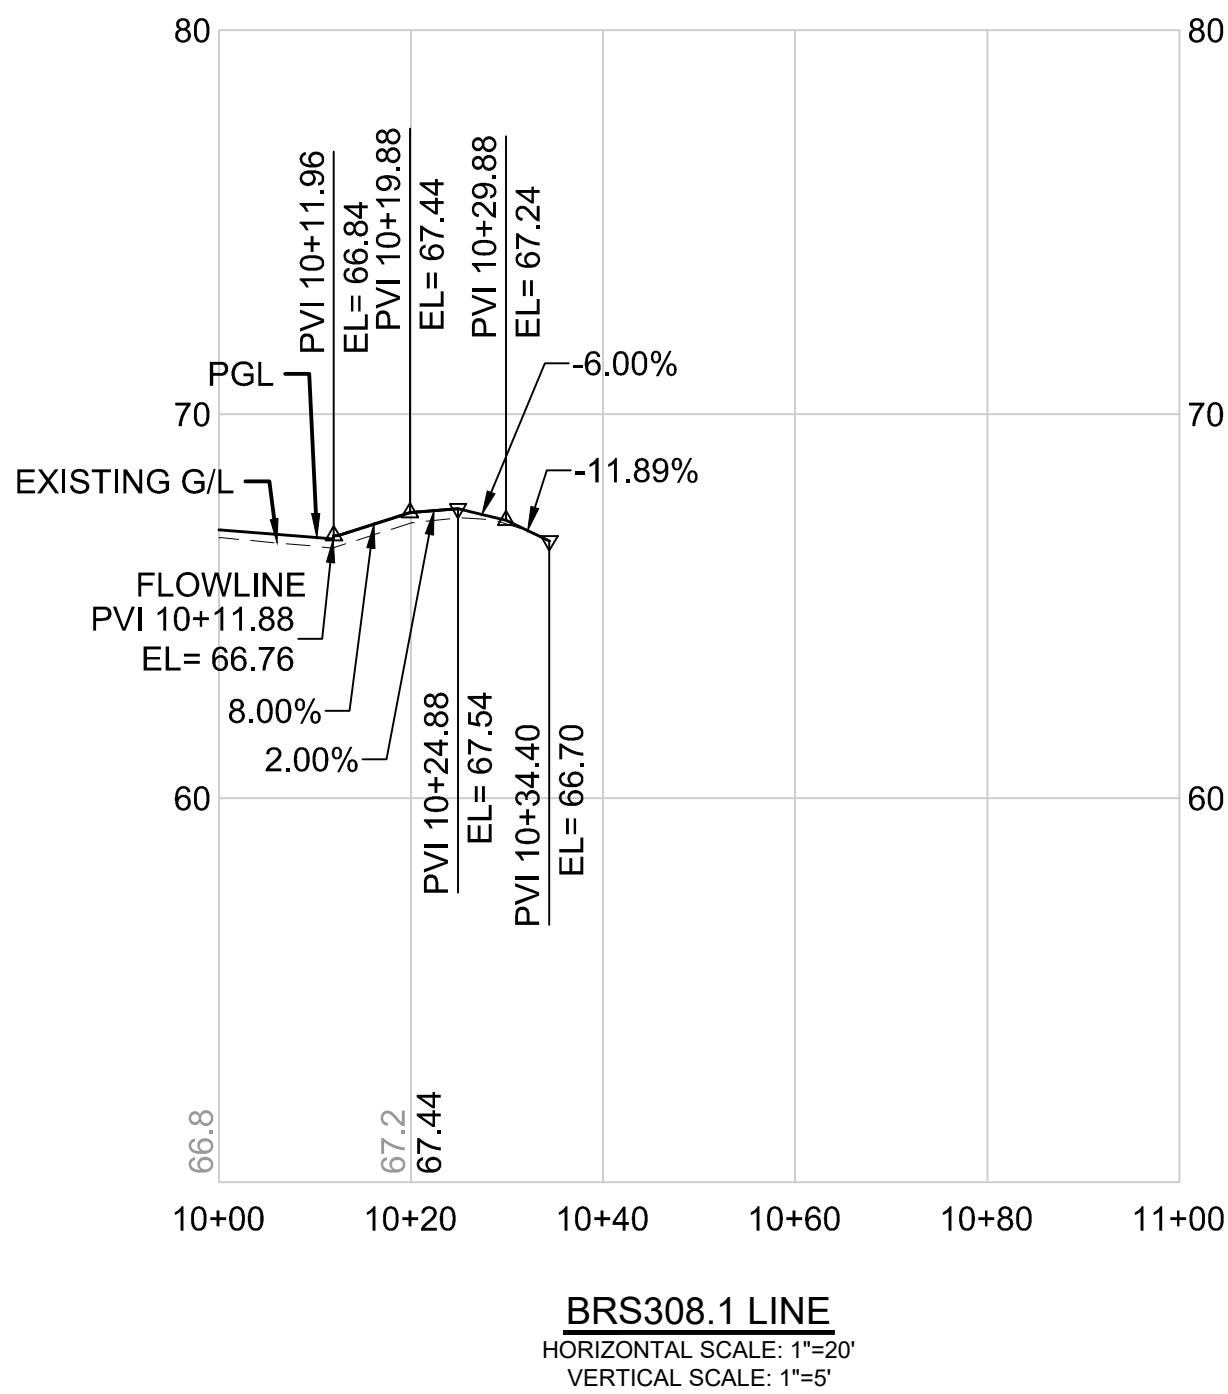

DRAFT 30% SUBMITTAL

No.	DATE	DSN	CHK	APP	REVISION

DESIGNED BY:
C.MATYAS
DRAWN BY:
C.BRESLEY
CHECKED BY:
R.KOESTER
APPROVED BY:
M.FELIBERTI



**DAVID EVANS
AND ASSOCIATES INC.**
14432 SE Eastgate Way, Suite 400
Bellevue Washington 98007
Phone: 425.519.6500

SUBMITTED BY:
D.SCHOCK

DATE:
09/11/2020

REVIEWED BY:
B.KEMPER




DATE:
09/11/2020

SCALE:
1"=20'
FILENAME:
BRT-522-CRV237-250
CONTRACT No.:
AE 0055-17
DATE:
09/11/2020



SR 522 / NE 145TH BRT
SR 522 (BOTHELL WAY NE)
CIVIL
DRIVEWAY PLAN AND PROFILE BRS308.1
STA. 10+00 TO STA. 10+59.72

DRAWING No.:
522-CRV240
FACILITY ID:
522
SHEET No.:
144 OF 283
REV:

09/10/20 | 1:59 AM | SJRO
C:\PW_WORK\DEA\STEVEN ROSE\DWG\506735\BRT-522-CRV237-250.DWG

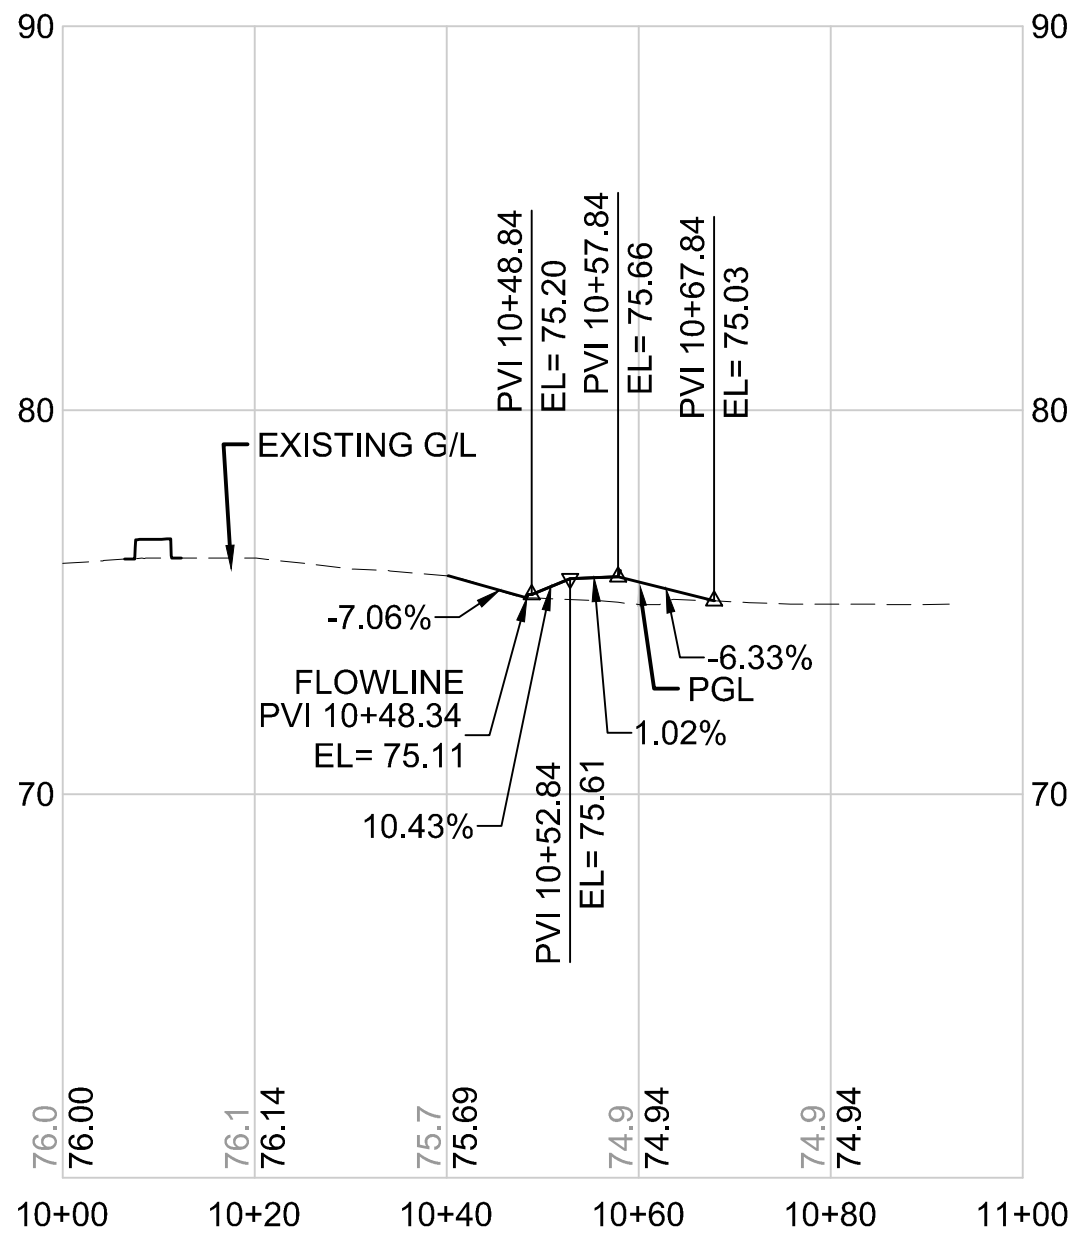

BRS310 LINE
HORIZONTAL SCALE: 1"=20'
VERTICAL SCALE: 1"=5'

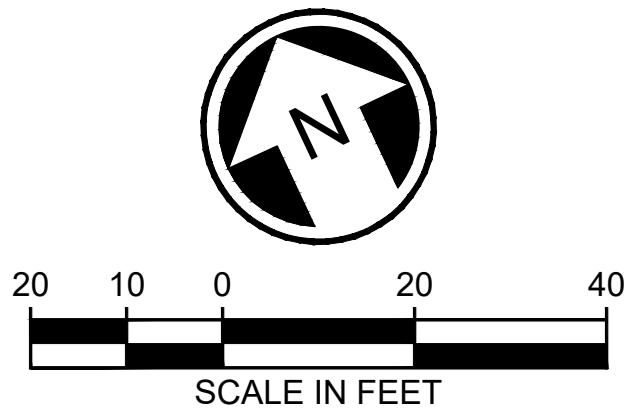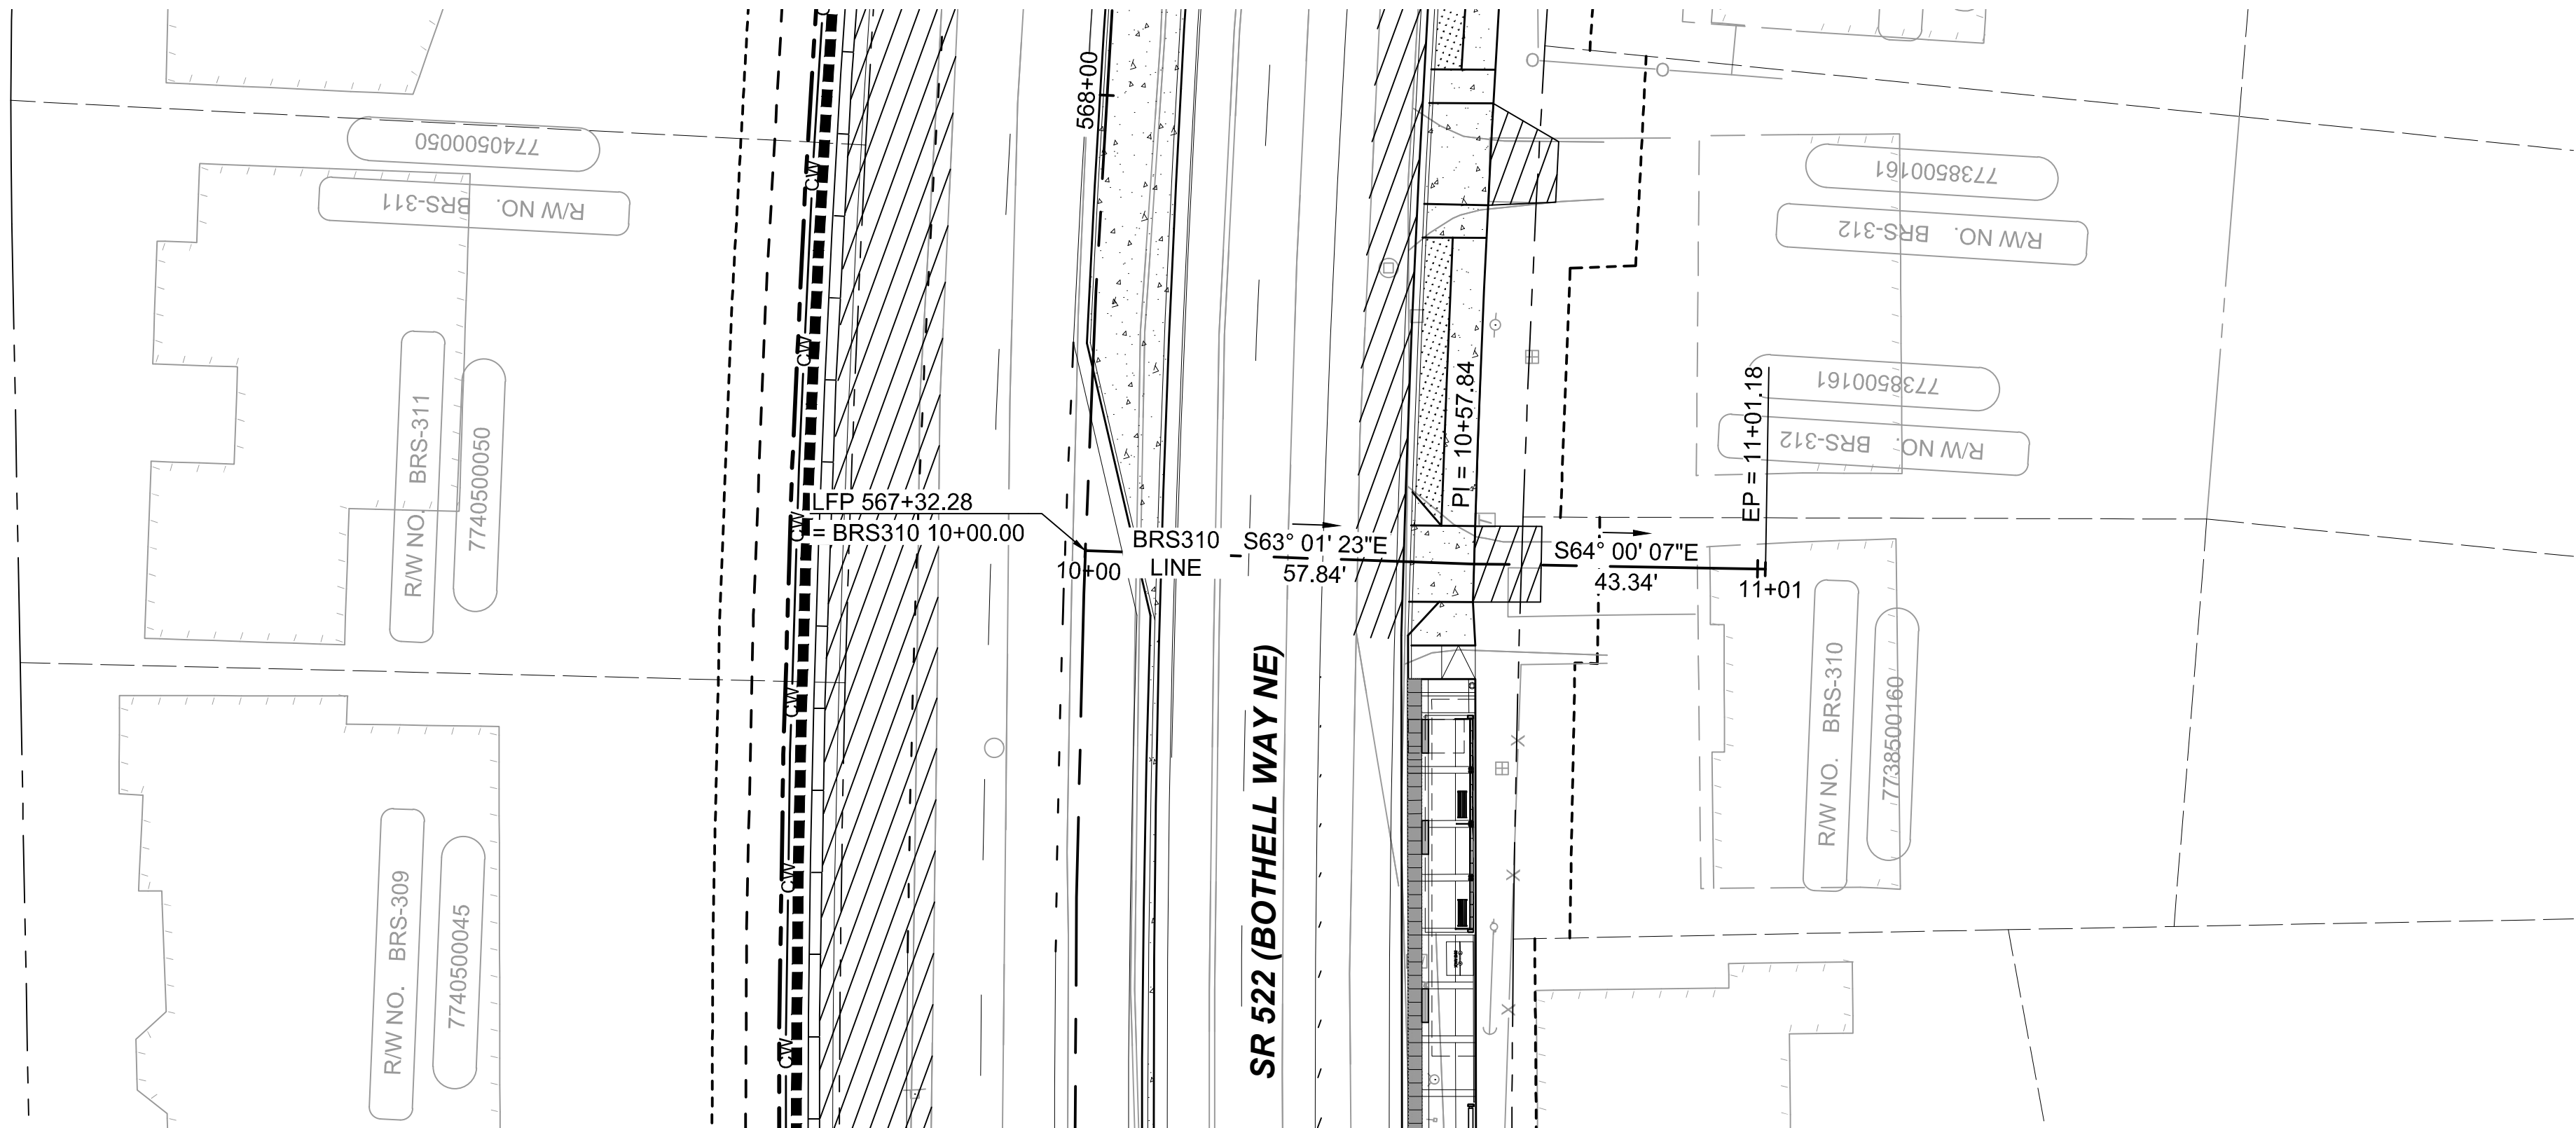

DRAFT 30% SUBMITTAL


No.	DATE	DSN	CHK	APP	REVISION

DESIGNED BY:	C.MATYAS
DRAWN BY:	C.BRESLEY
CHECKED BY:	R.KOESTER
APPROVED BY:	M.FELIBERTI



**DAVID EVANS
AND ASSOCIATES INC.**
14432 SE Eastgate Way, Suite 400
Bellevue Washington 98007
Phone: 425.519.6500

SUBMITTED BY:	DATE:	REVIEWED BY:
D.SCHOCK	09/11/2020	B.KEMPER

 


SCALE:	1"=20'
FILENAME:	BRT-522-CRV237-250
CONTRACT No.:	AE 0055-17
DATE:	09/11/2020



SR 522 / NE 145TH BRT
SR 522 (BOTHELL WAY NE)
CIVIL
DRIVEWAY PLAN AND PROFILE BRS310
STA. 10+00 TO STA. 11+01.18

DRAWING No.:	522-CRV241
FACILITY ID:	522
SHEET No.:	145 OF 283

09/10/20 | 2:00 AM | SJRO
C:\PW_WORK\DEA\STEVEN ROSE\DWG\506735\BRT-522-CRV237-250.DWG

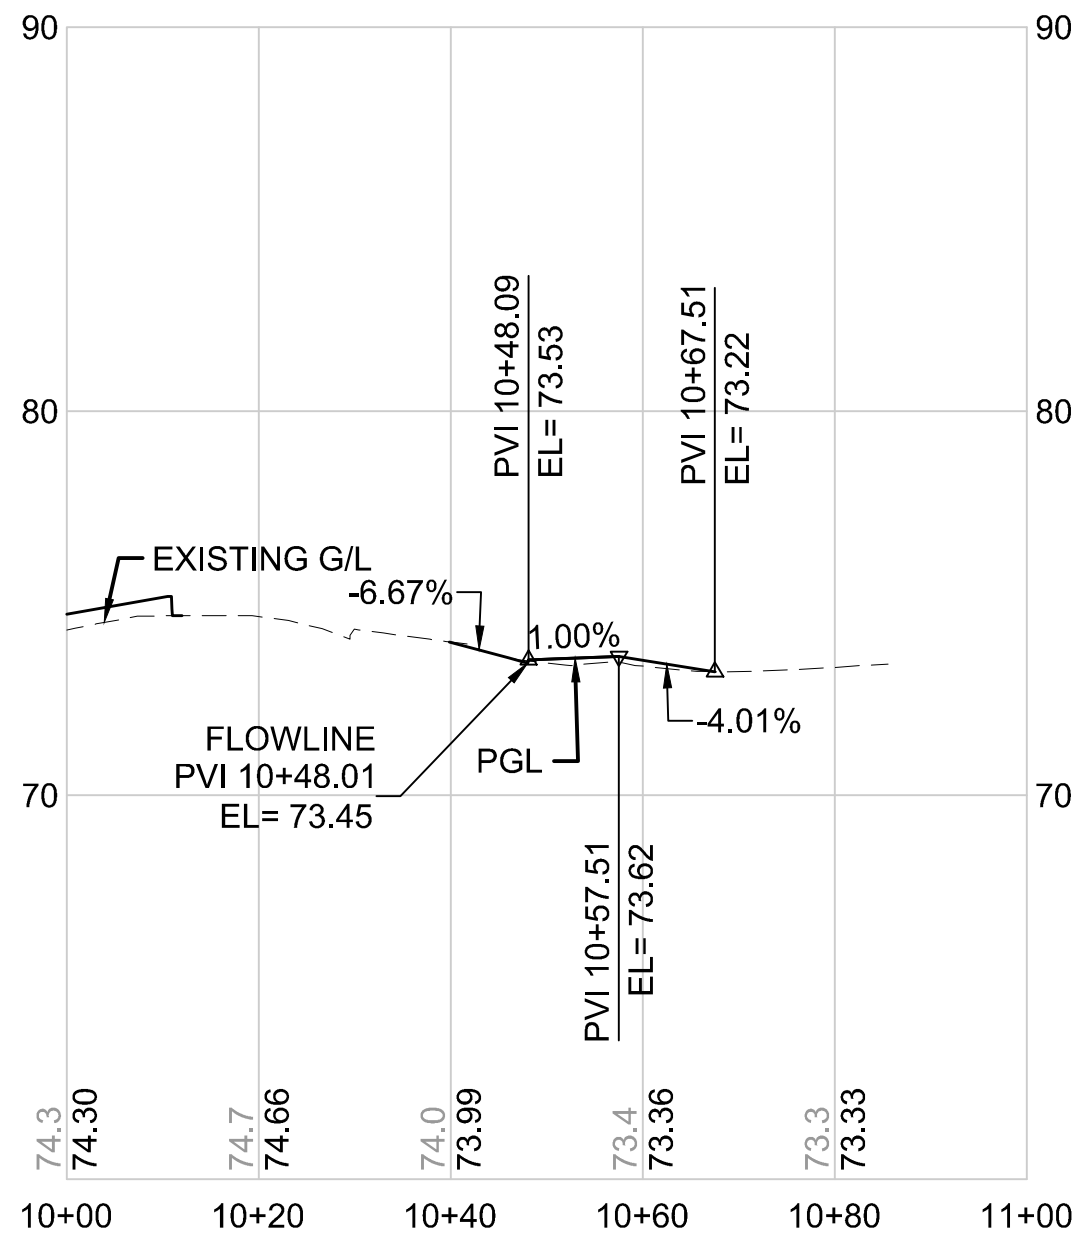

BRS312 LINE
HORIZONTAL SCALE: 1"=20'
VERTICAL SCALE: 1"=5'

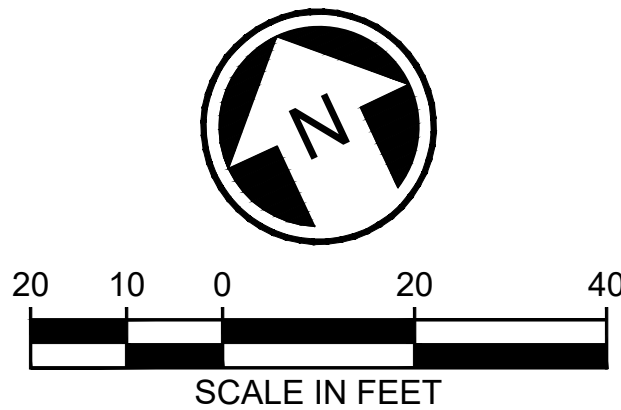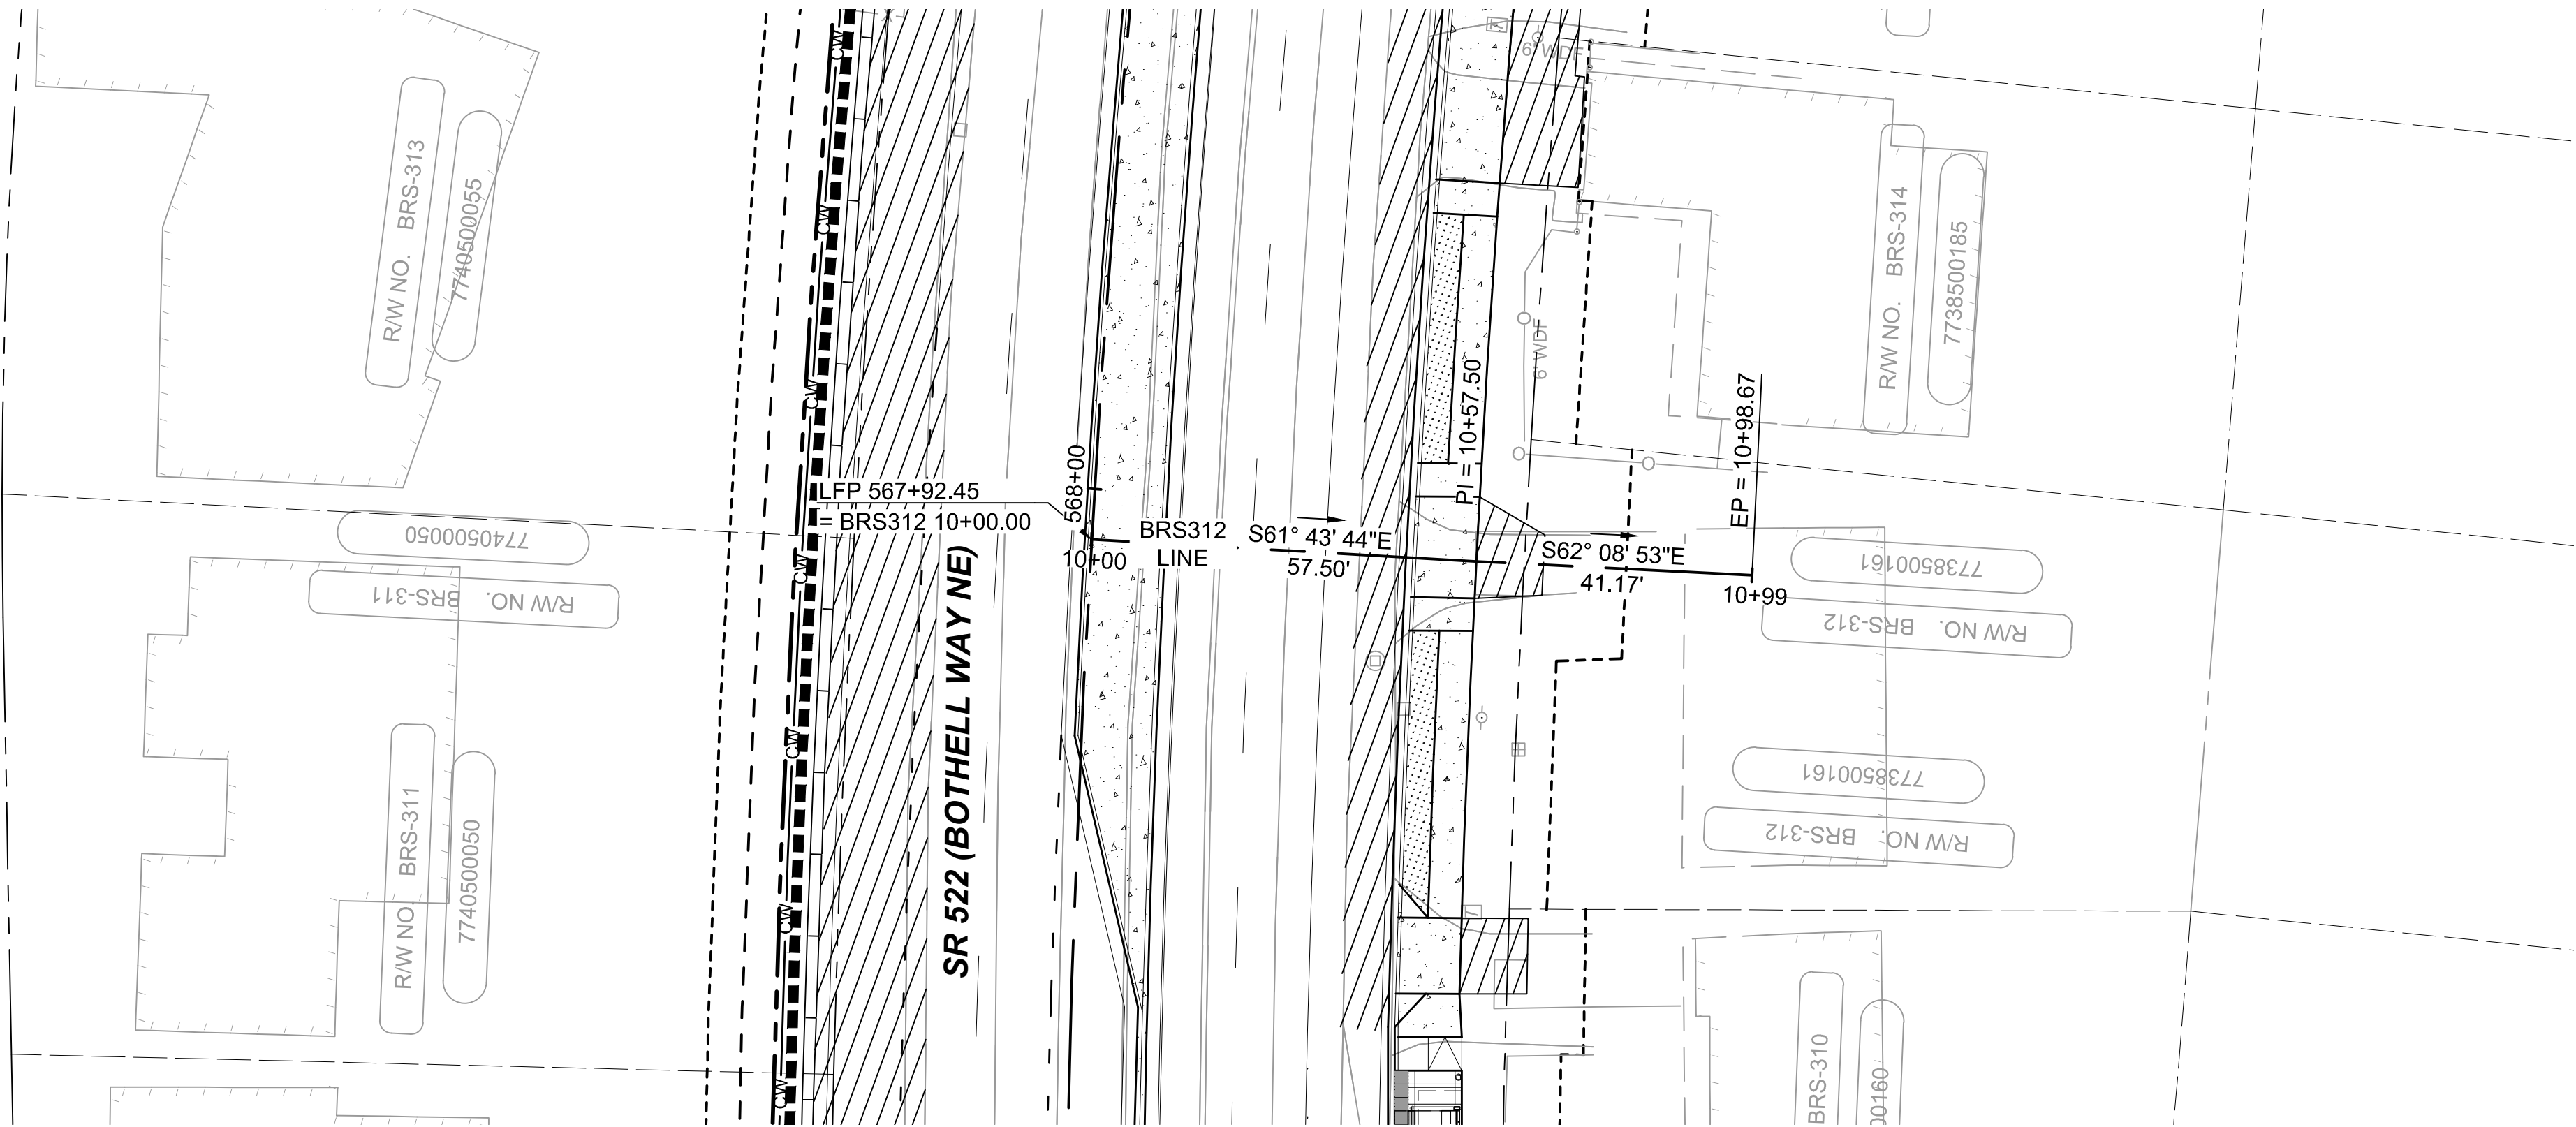

DRAFT 30% SUBMITTAL

No.	DATE	DSN	CHK	APP	REVISION

DESIGNED BY:
C.MATYAS
DRAWN BY:
C.BRESLEY
CHECKED BY:
R.KOESTER
APPROVED BY:
M.FELIBERTI



**DAVID EVANS
AND ASSOCIATES INC.**
14432 SE Eastgate Way, Suite 400
Bellevue Washington 98007
Phone: 425.519.6500

SUBMITTED BY:
D.SCHOCK

DATE:
09/11/2020

REVIEWED BY:
B.KEMPER


 


DATE:
09/11/2020

SCALE:
1"=20'
FILENAME:
BRT-522-CRV237-250
CONTRACT No.:
AE 0055-17
DATE:
09/11/2020

SR 522 / NE 145TH BRT
SR 522 (BOTHELL WAY NE)
CIVIL
DRIVEWAY PLAN AND PROFILE BRS312
STA. 10+TO STA. 10+98.67

DRAWING No.:
522-CRV242
FACILITY ID:
522
SHEET No.:
146 OF 283
REV:

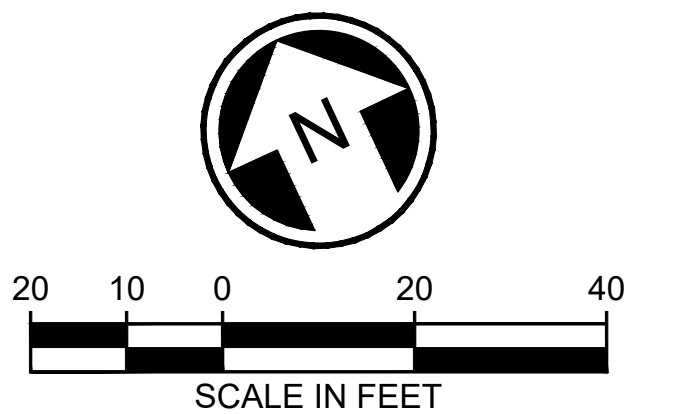

DATE	DSN	CHK	APP	REVISION

DESIGNED BY:	C.MATYAS
DRAWN BY:	C.BRESLEY
CHECKED BY:	R.KOESTER
APPROVED BY:	M.FELIBERTI



**DAVID EVANS
AND ASSOCIATES INC.**

14432 SE Eastgate Way, Suite 400
Bellevue Washington 98007
Phone: 425.519.6500

SCALE:	1"=20'
FILENAME:	BRT-522-CRV237-250
CONTRACT No.:	AE 0055-17
DATE:	09/11/2020

SR 522 / NE 145TH BRT

SR 522 (BOTHELL WAY NE)



CIVIL

DRIVEWAY PLAN AND PROFILE BRS314

STA. 10+00 TO STA. 10+80.23





DRAWING No.:	
522-CRV243	
FACILITY ID:	
522	
SHEET No.:	REV:
147 OF 283	

09/10/20 | 2:02 AM | SJRO
C:\PW_WORK\DEA\STEVEN ROSE\DWG\BRT-522-CRV237-250.DWG

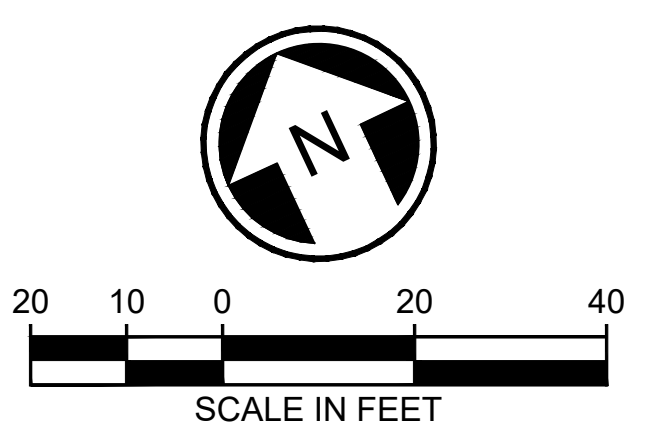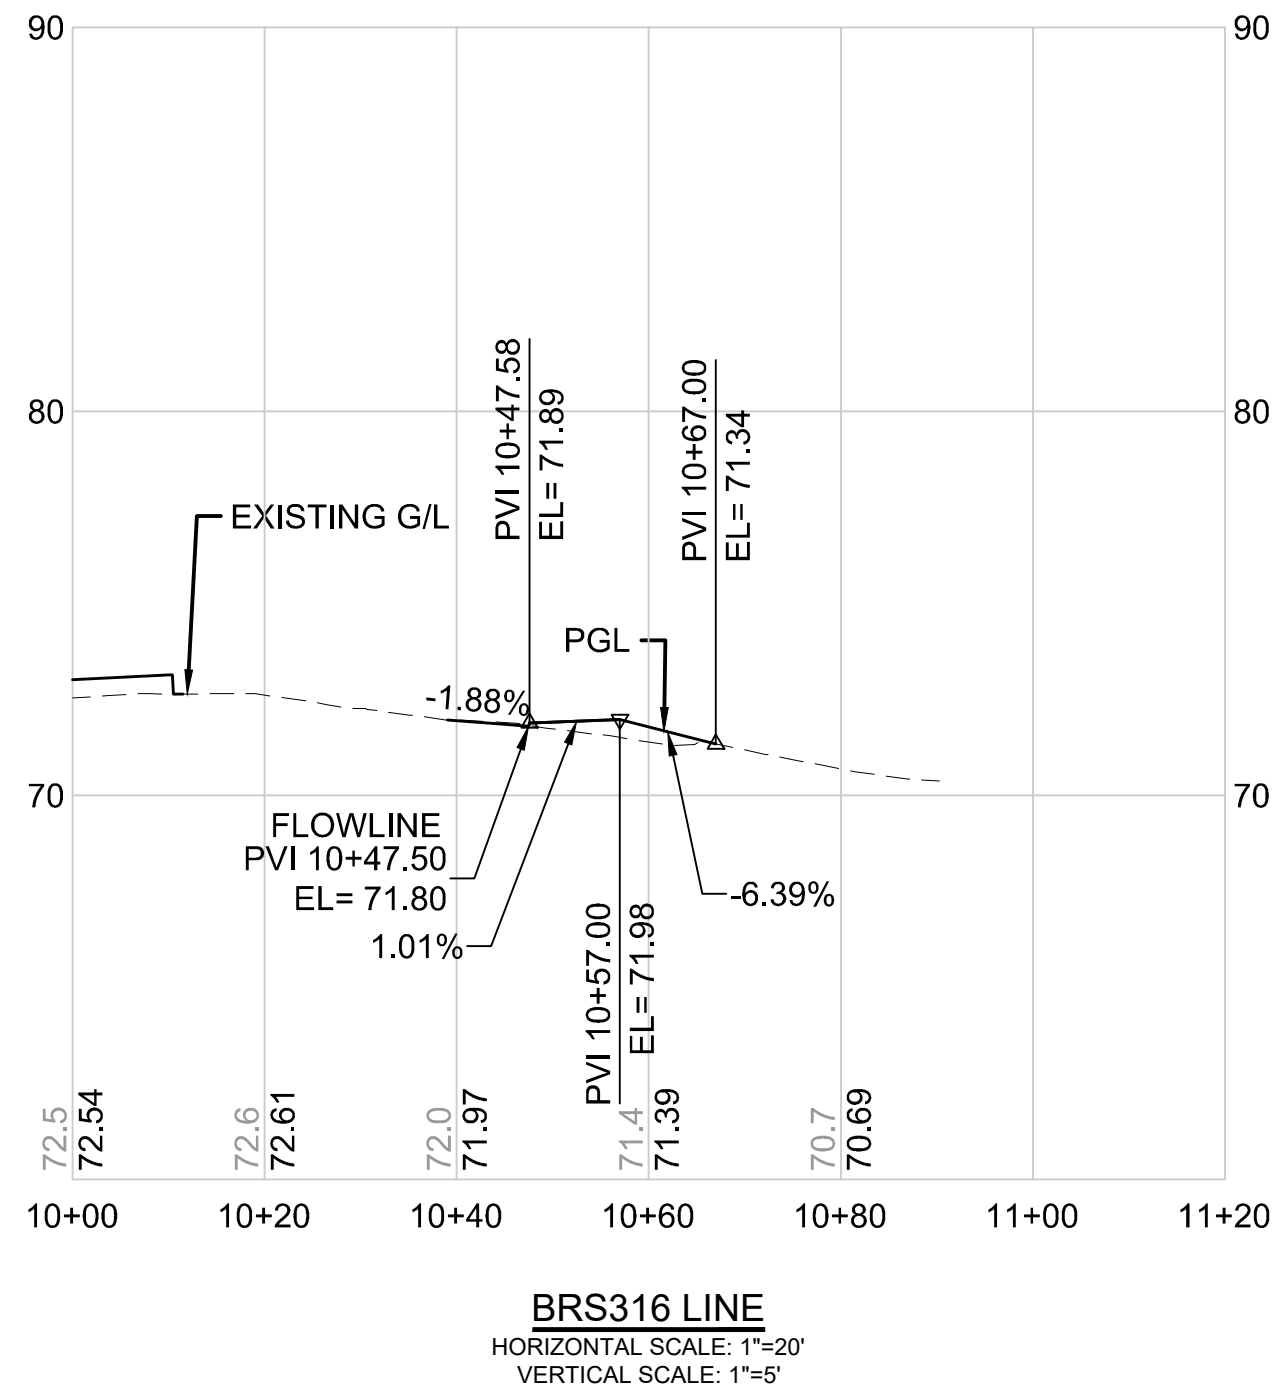

DRAFT 30% SUBMITTAL						DESIGNED BY: C.MATYAS			DAVID EVANS AND ASSOCIATES INC. 14432 SE Eastgate Way, Suite 400 Bellevue Washington 98007 Phone: 425.519.6500				LINE IS 1" AT FULL SCALE SOUNDTRANSIT	SCALE: 1"=20'		SR 522 / NE 145TH BRT SR 522 (BOTHELL WAY NE) CIVIL DRIVEWAY PLAN AND PROFILE BRS316 STA. 10+00 TO STA. 11+21.70				DRAWING No.: 522-CRV244	
						DRAWN BY: C.BRESLEY			FILENAME: BRT-522-CRV237-250		FACILITY ID: 522										
						CHECKED BY: R.KOESTER			CONTRACT No.: AE 0055-17		SHEET No.: 148 OF 283										
						APPROVED BY: M.FELIBERTI			DATE: 09/11/2020		REVIEWED BY: B.KEMPER										
						SUBMITTED BY: D.SCHOCK			DATE: 09/11/2020		DATE: 09/11/2020										
No.	DATE	DSN	CHK	APP	REVISION																

09/10/20 | 2:04 AM | SJRO
C:\PW_WORK\DEA\STEVEN ROSE\DWG\BRT-522-CRV237-250.DWG

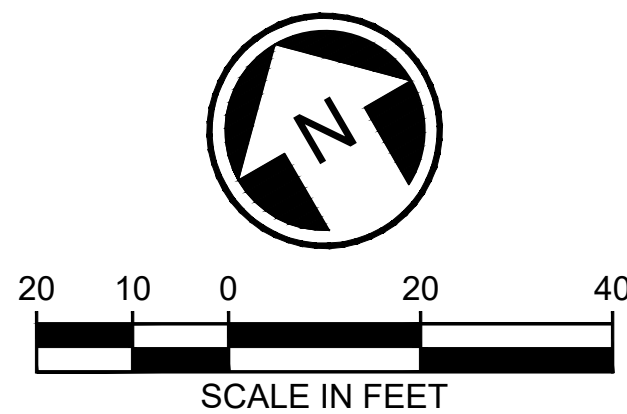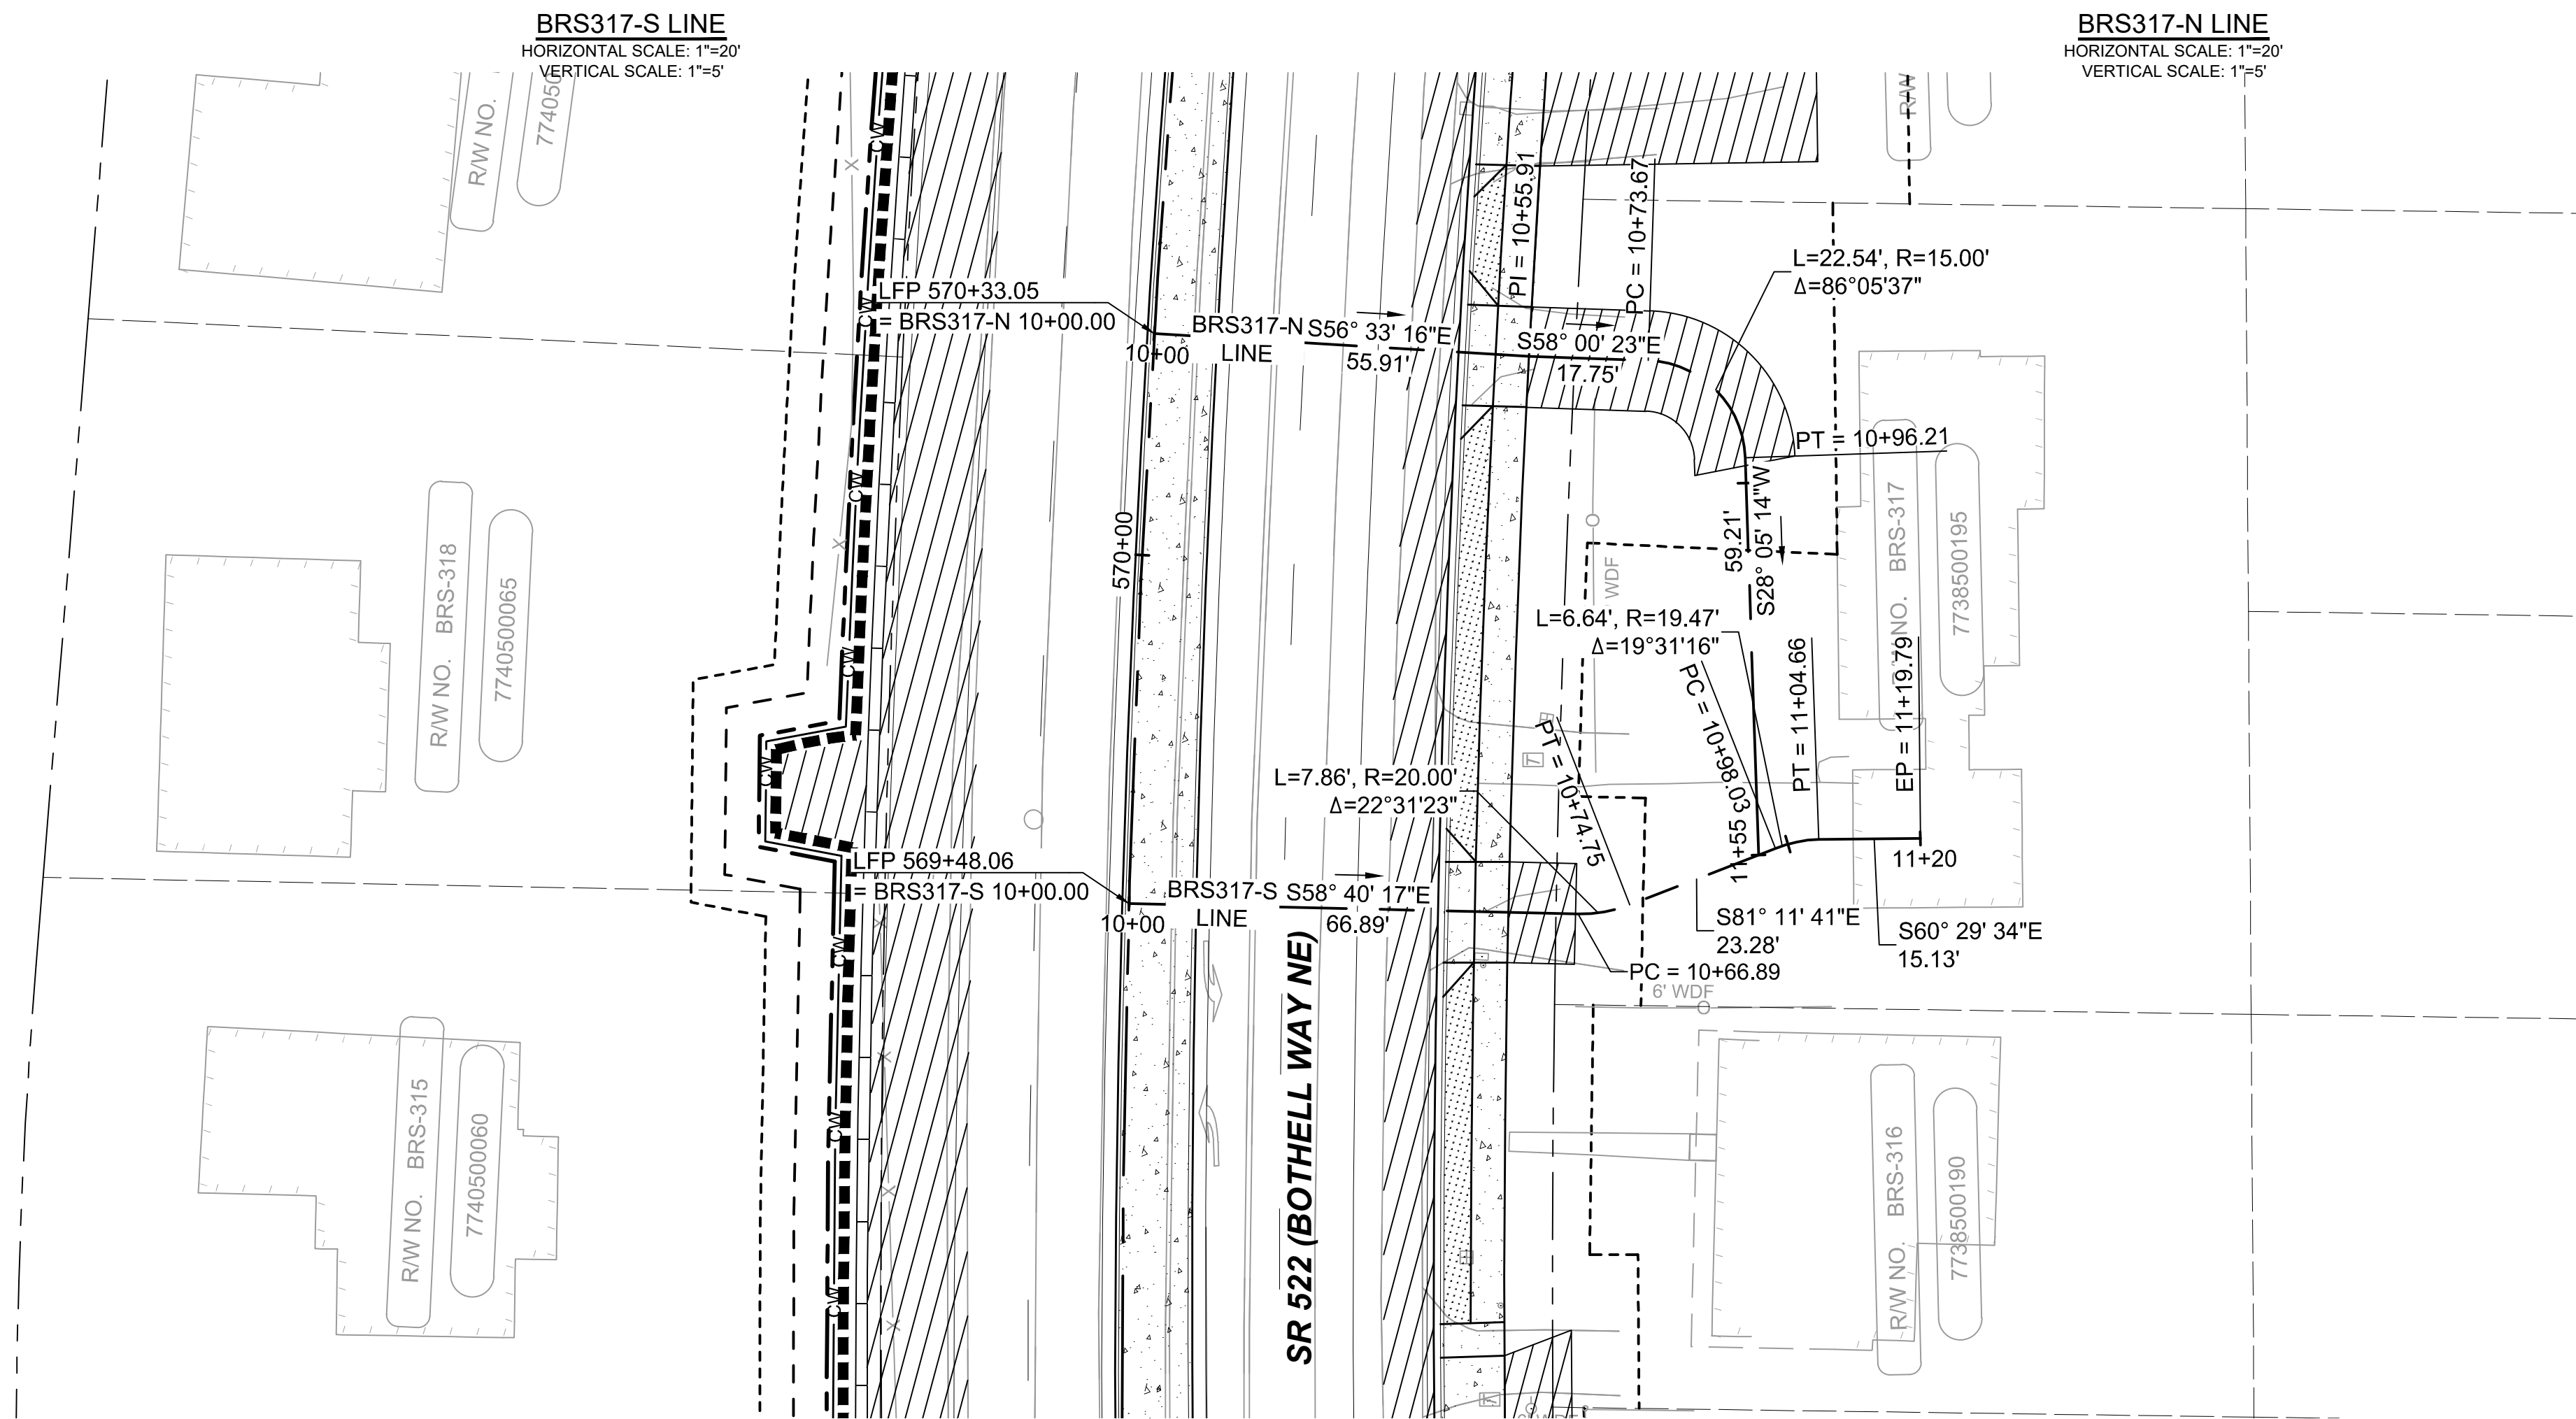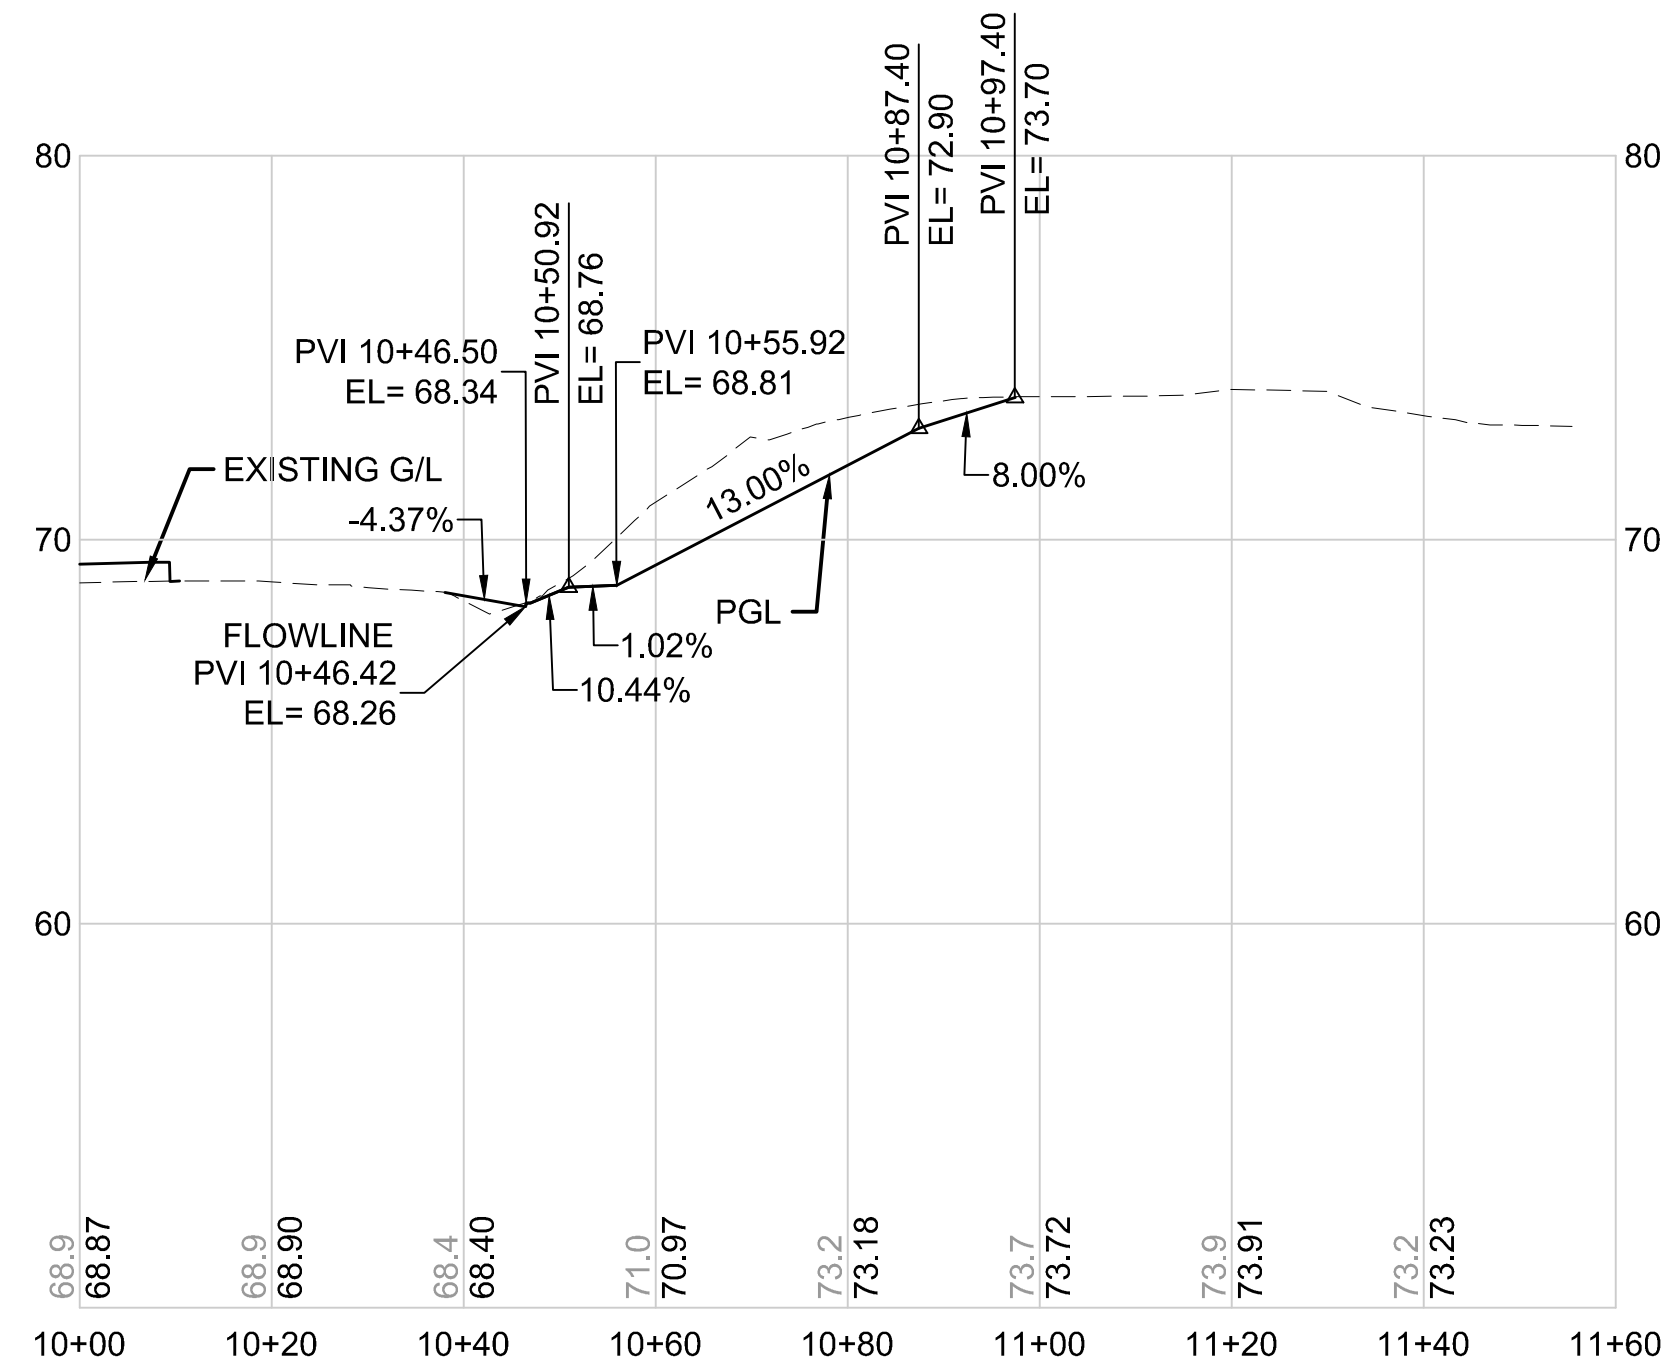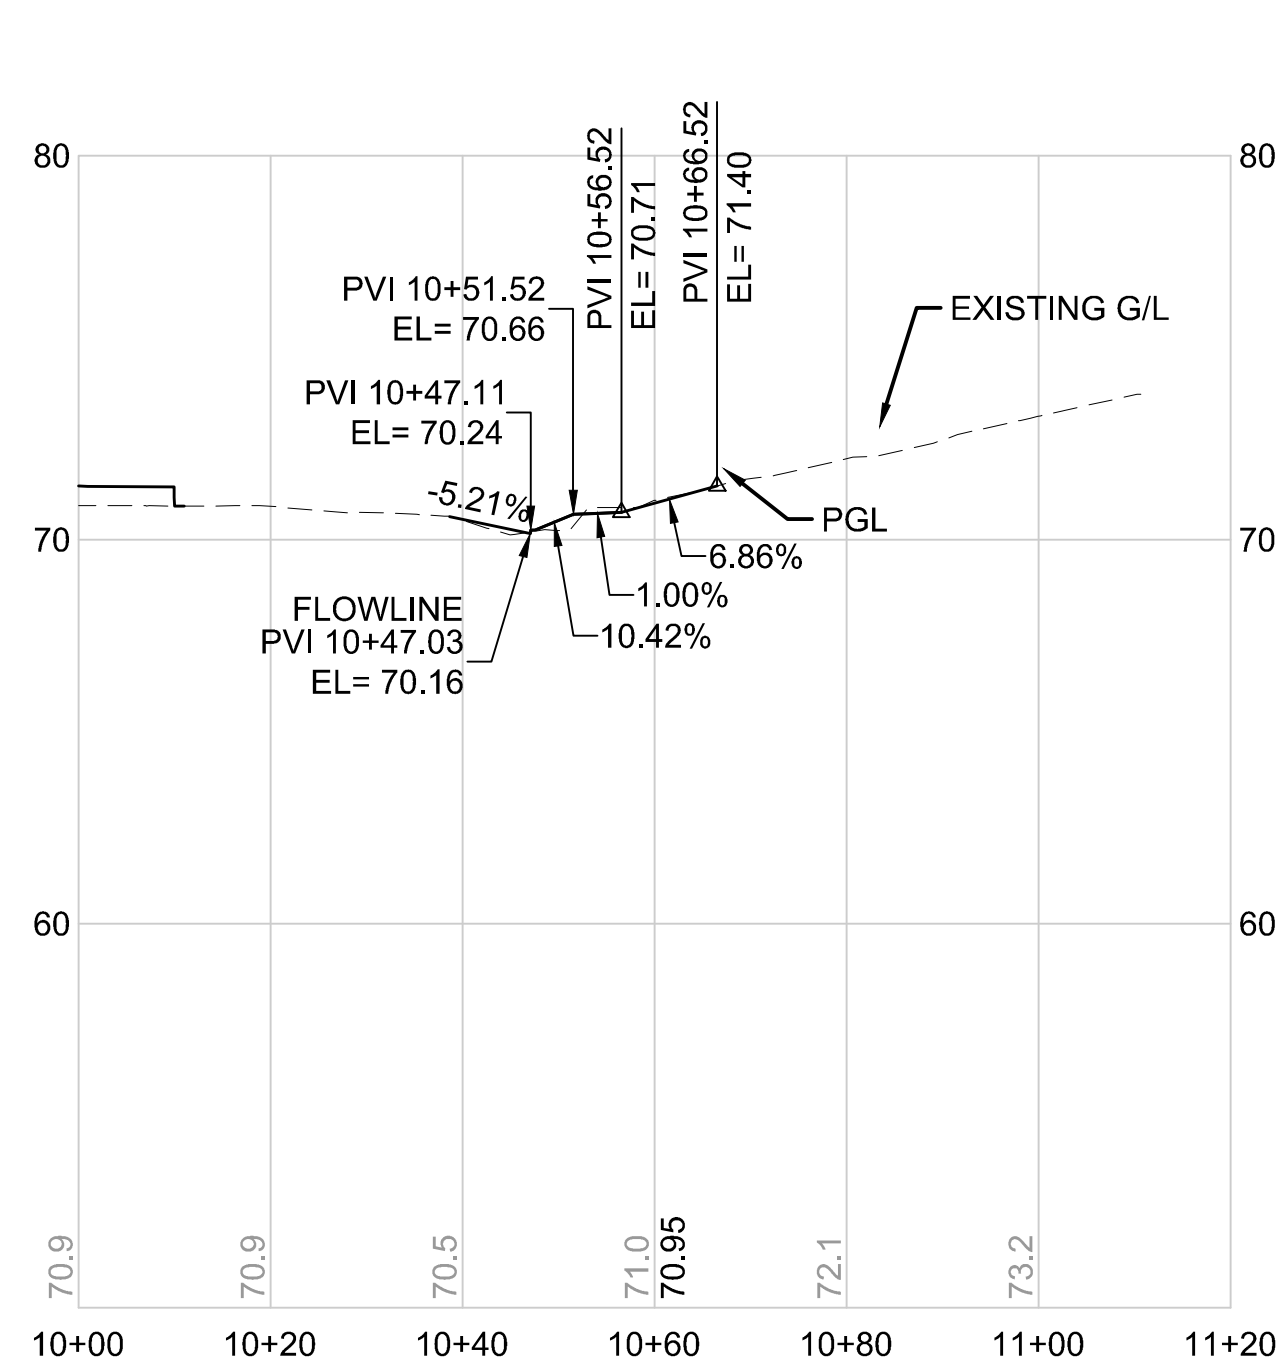

DRAFT 30% SUBMITTAL

No.	DATE	DSN	CHK	APP	REVISION

DESIGNED BY:
C.MATYAS
DRAWN BY:
C.BRESLEY
CHECKED BY:
R.KOESTER
APPROVED BY:
M.FELIBERTI



DAVID EVANS
AND ASSOCIATES INC.
14432 SE Eastgate Way, Suite 400
Bellevue Washington 98007
Phone: 425.519.6500

LINE IS 1" AT
FULL SCALE






SCALE:
1"=20'
FILENAME:
BRT-522-CRV237-250
CONTRACT No.:
AE 0055-17
DATE:
09/11/2020

SR 522 / NE 145TH BRT
SR 522 (BOTHELL WAY NE)
CIVIL
DRIVEWAY PLAN AND PROFILES BRS317-S & BRS317-N
STA. 10+00 TO STA. 11+55.41

DRAWING No.:
522-CRV245
FACILITY ID:
522
SHEET No.:
149 OF 283
REV:

09/10/20 | 2:05 AM | SJRO
C:\PW_WORK\DAE\STEVEN ROSE\DWG\06735\BRT-522-CRV237-250.DWG

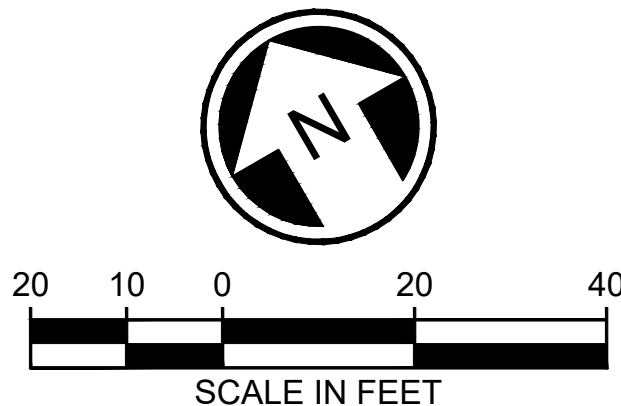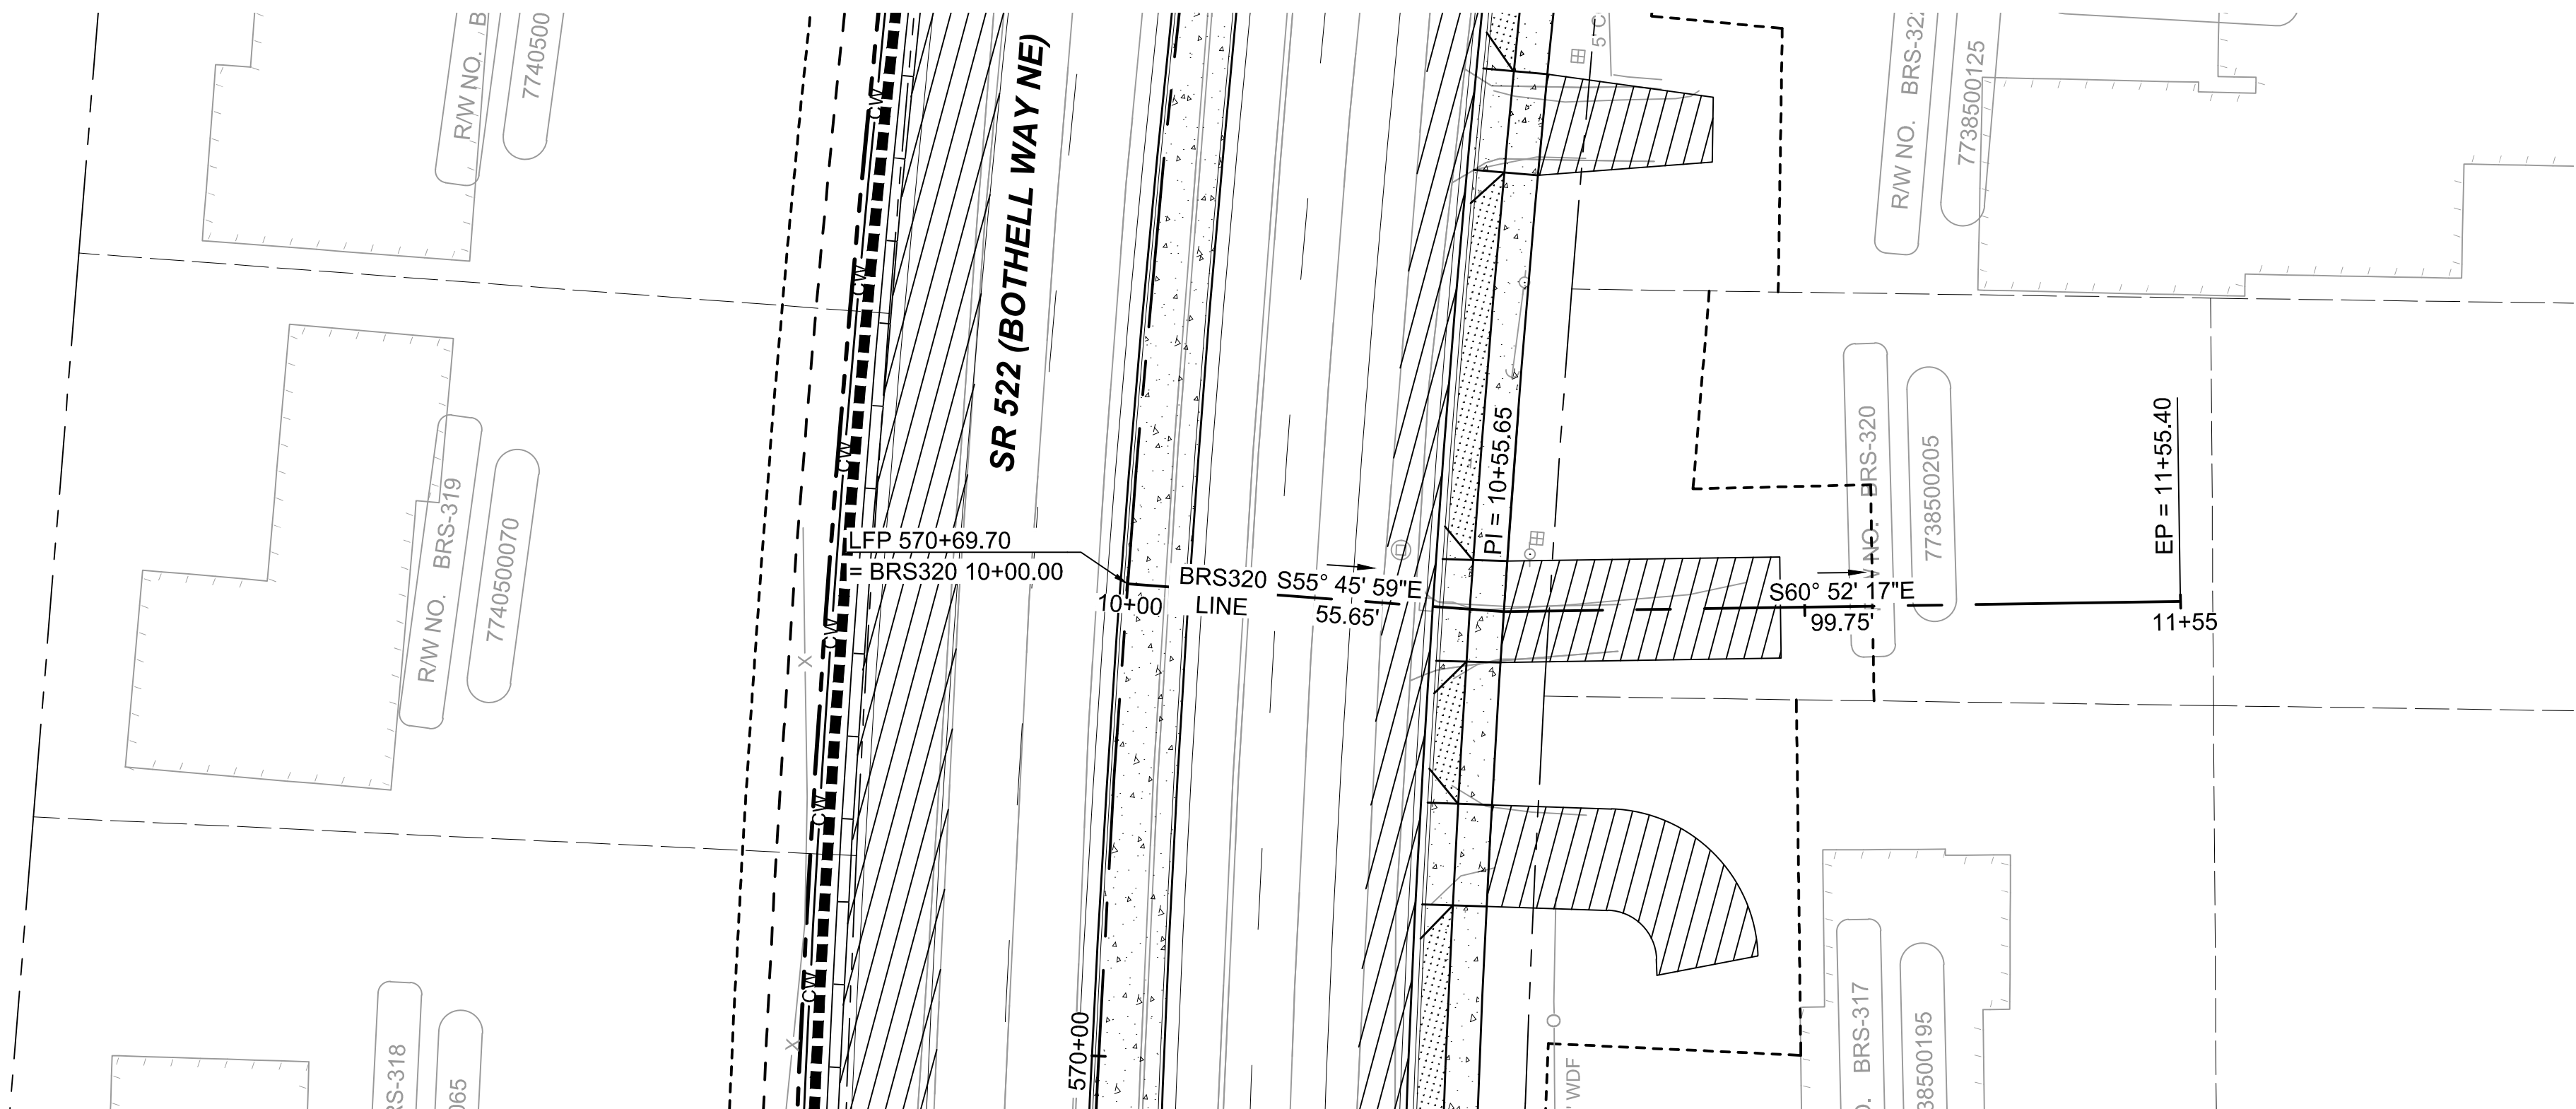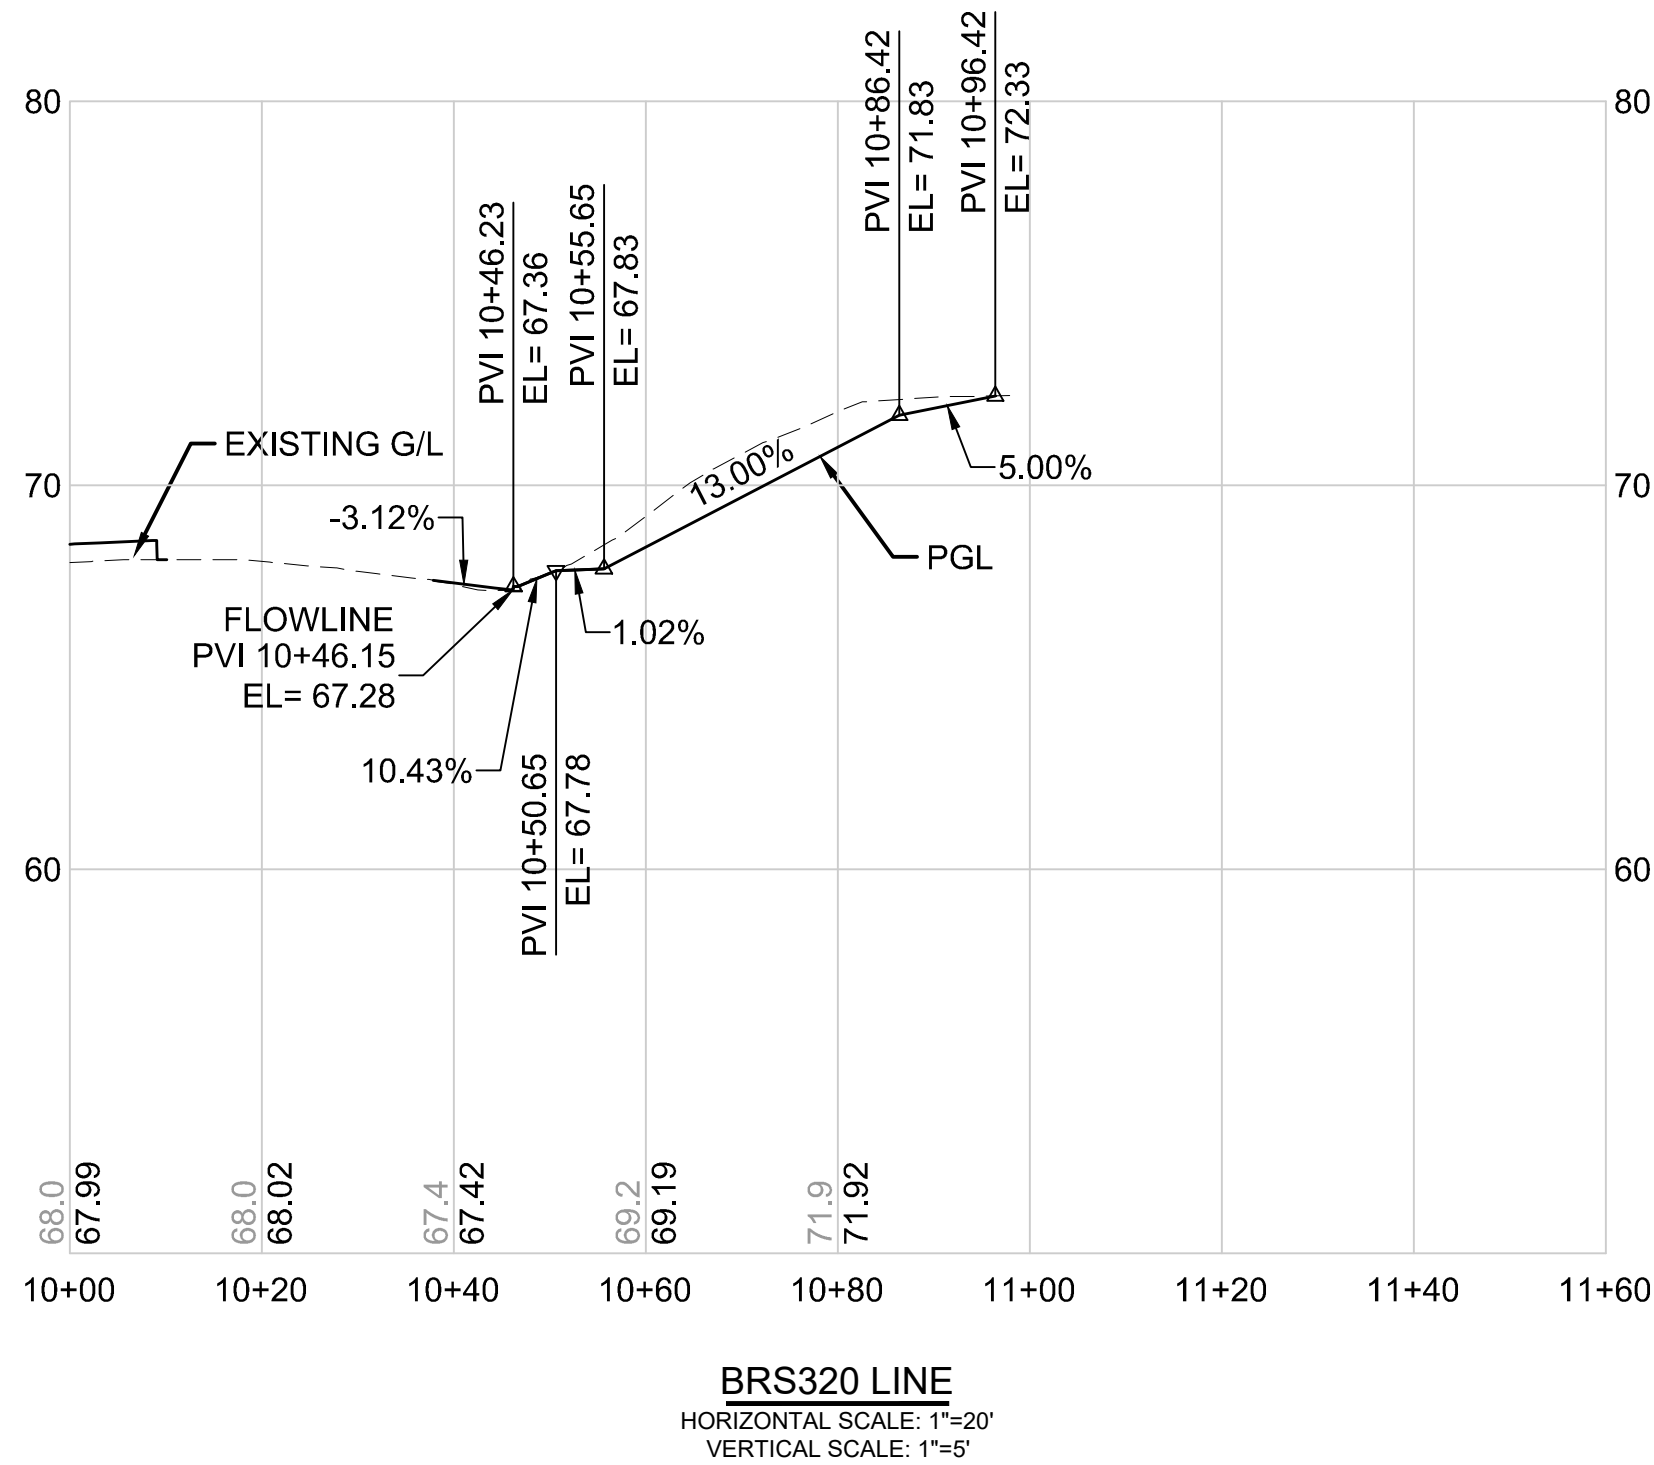

DRAFT 30% SUBMITTAL


No.	DATE	DSN	CHK	APP	REVISION

DESIGNED BY:	C.MATYAS
DRAWN BY:	C.BRESLEY
CHECKED BY:	R.KOESTER
APPROVED BY:	M.FELIBERTI



**DAVID EVANS
AND ASSOCIATES INC.**
14432 SE Eastgate Way, Suite 400
Bellevue Washington 98007
Phone: 425.519.6500

SUBMITTED BY:	DATE:	REVIEWED BY:	DATE:
D.SCHOCK	09/11/2020	B.KEMPER	09/11/2020

 


SOUNDTRANSIT

SCALE:	1"=20'
FILENAME:	BRT-522-CRV237-250
CONTRACT No.:	AE 0055-17
DATE:	09/11/2020



SR 522 / NE 145TH BRT
SR 522 (BOTHELL WAY NE)
CIVIL
DRIVEWAY PLAN AND PROFILE BRS320
STA. 10+00 TO STA. 11+55.40

DRAWING No.:	522-CRV246
FACILITY ID:	522
SHEET No.:	150 OF 283

09/10/20 | 2:05 AM | SJRO
C:\PW_WORK\DAE\STEVEN ROSE\DWG\506735\BRT-522-CRV237-250.DWG

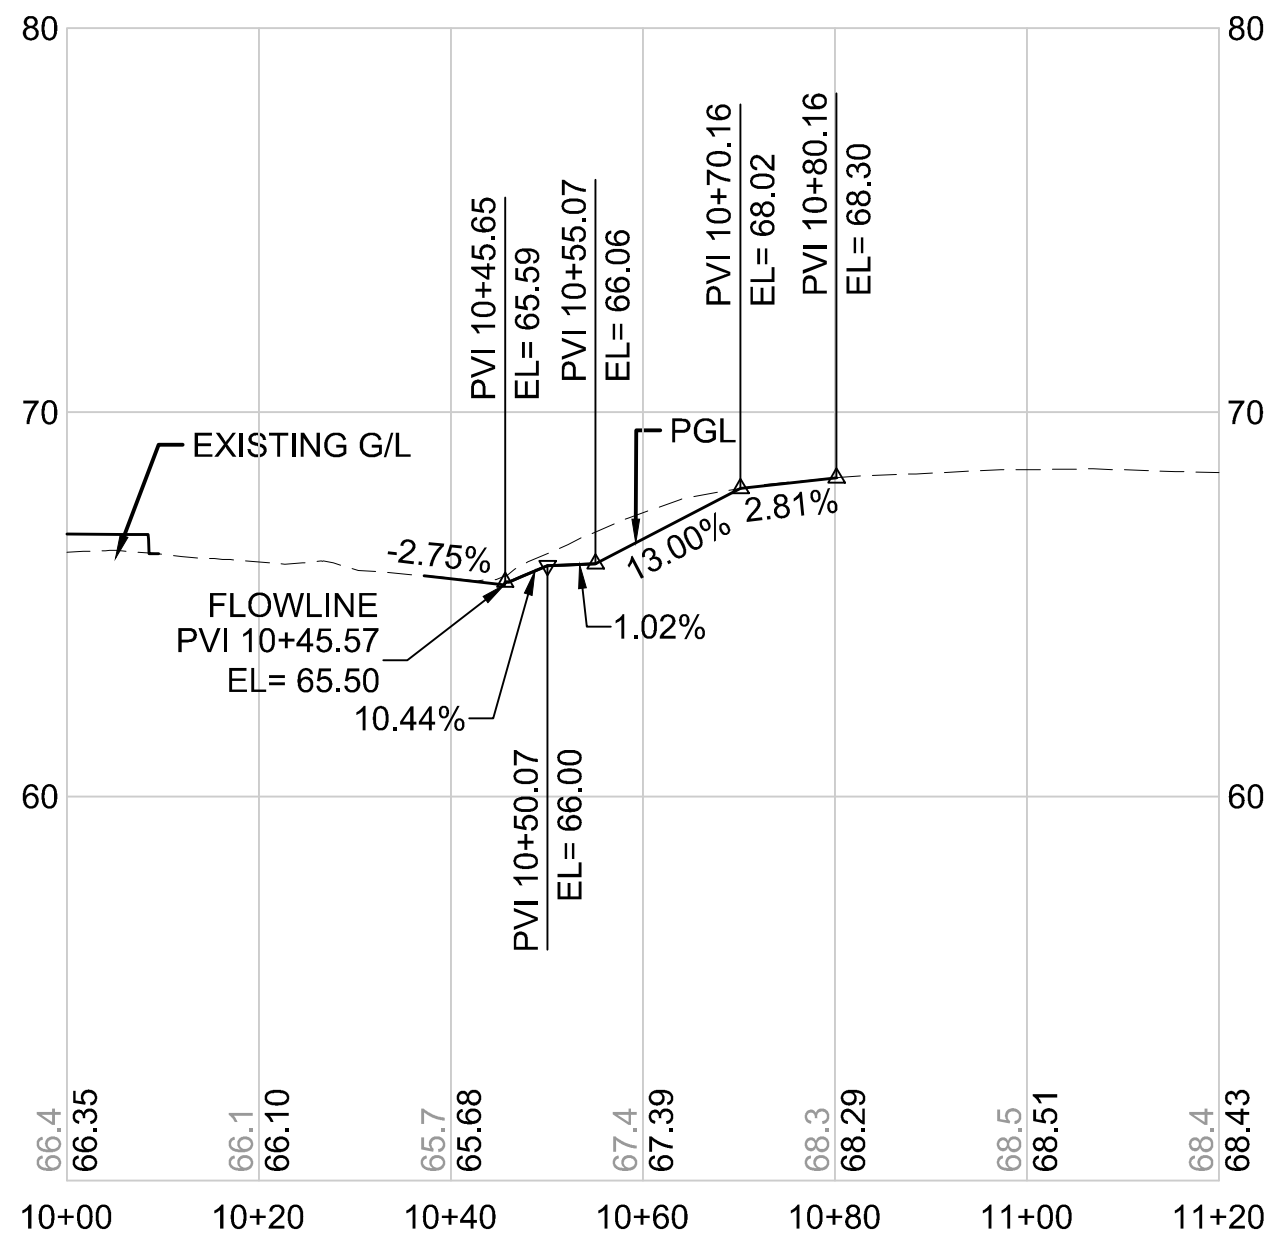

BRS322 LINE
HORIZONTAL SCALE: 1"=20'
VERTICAL SCALE: 1"=5'

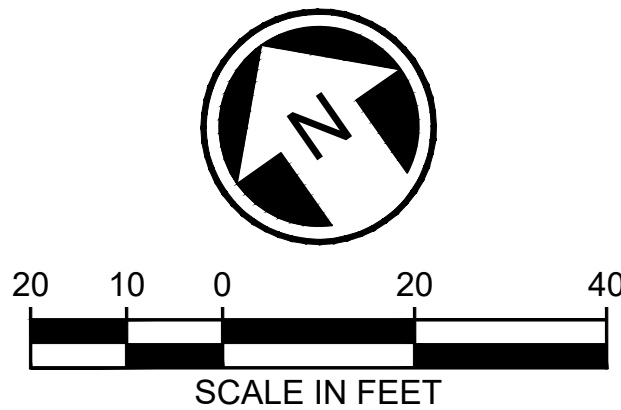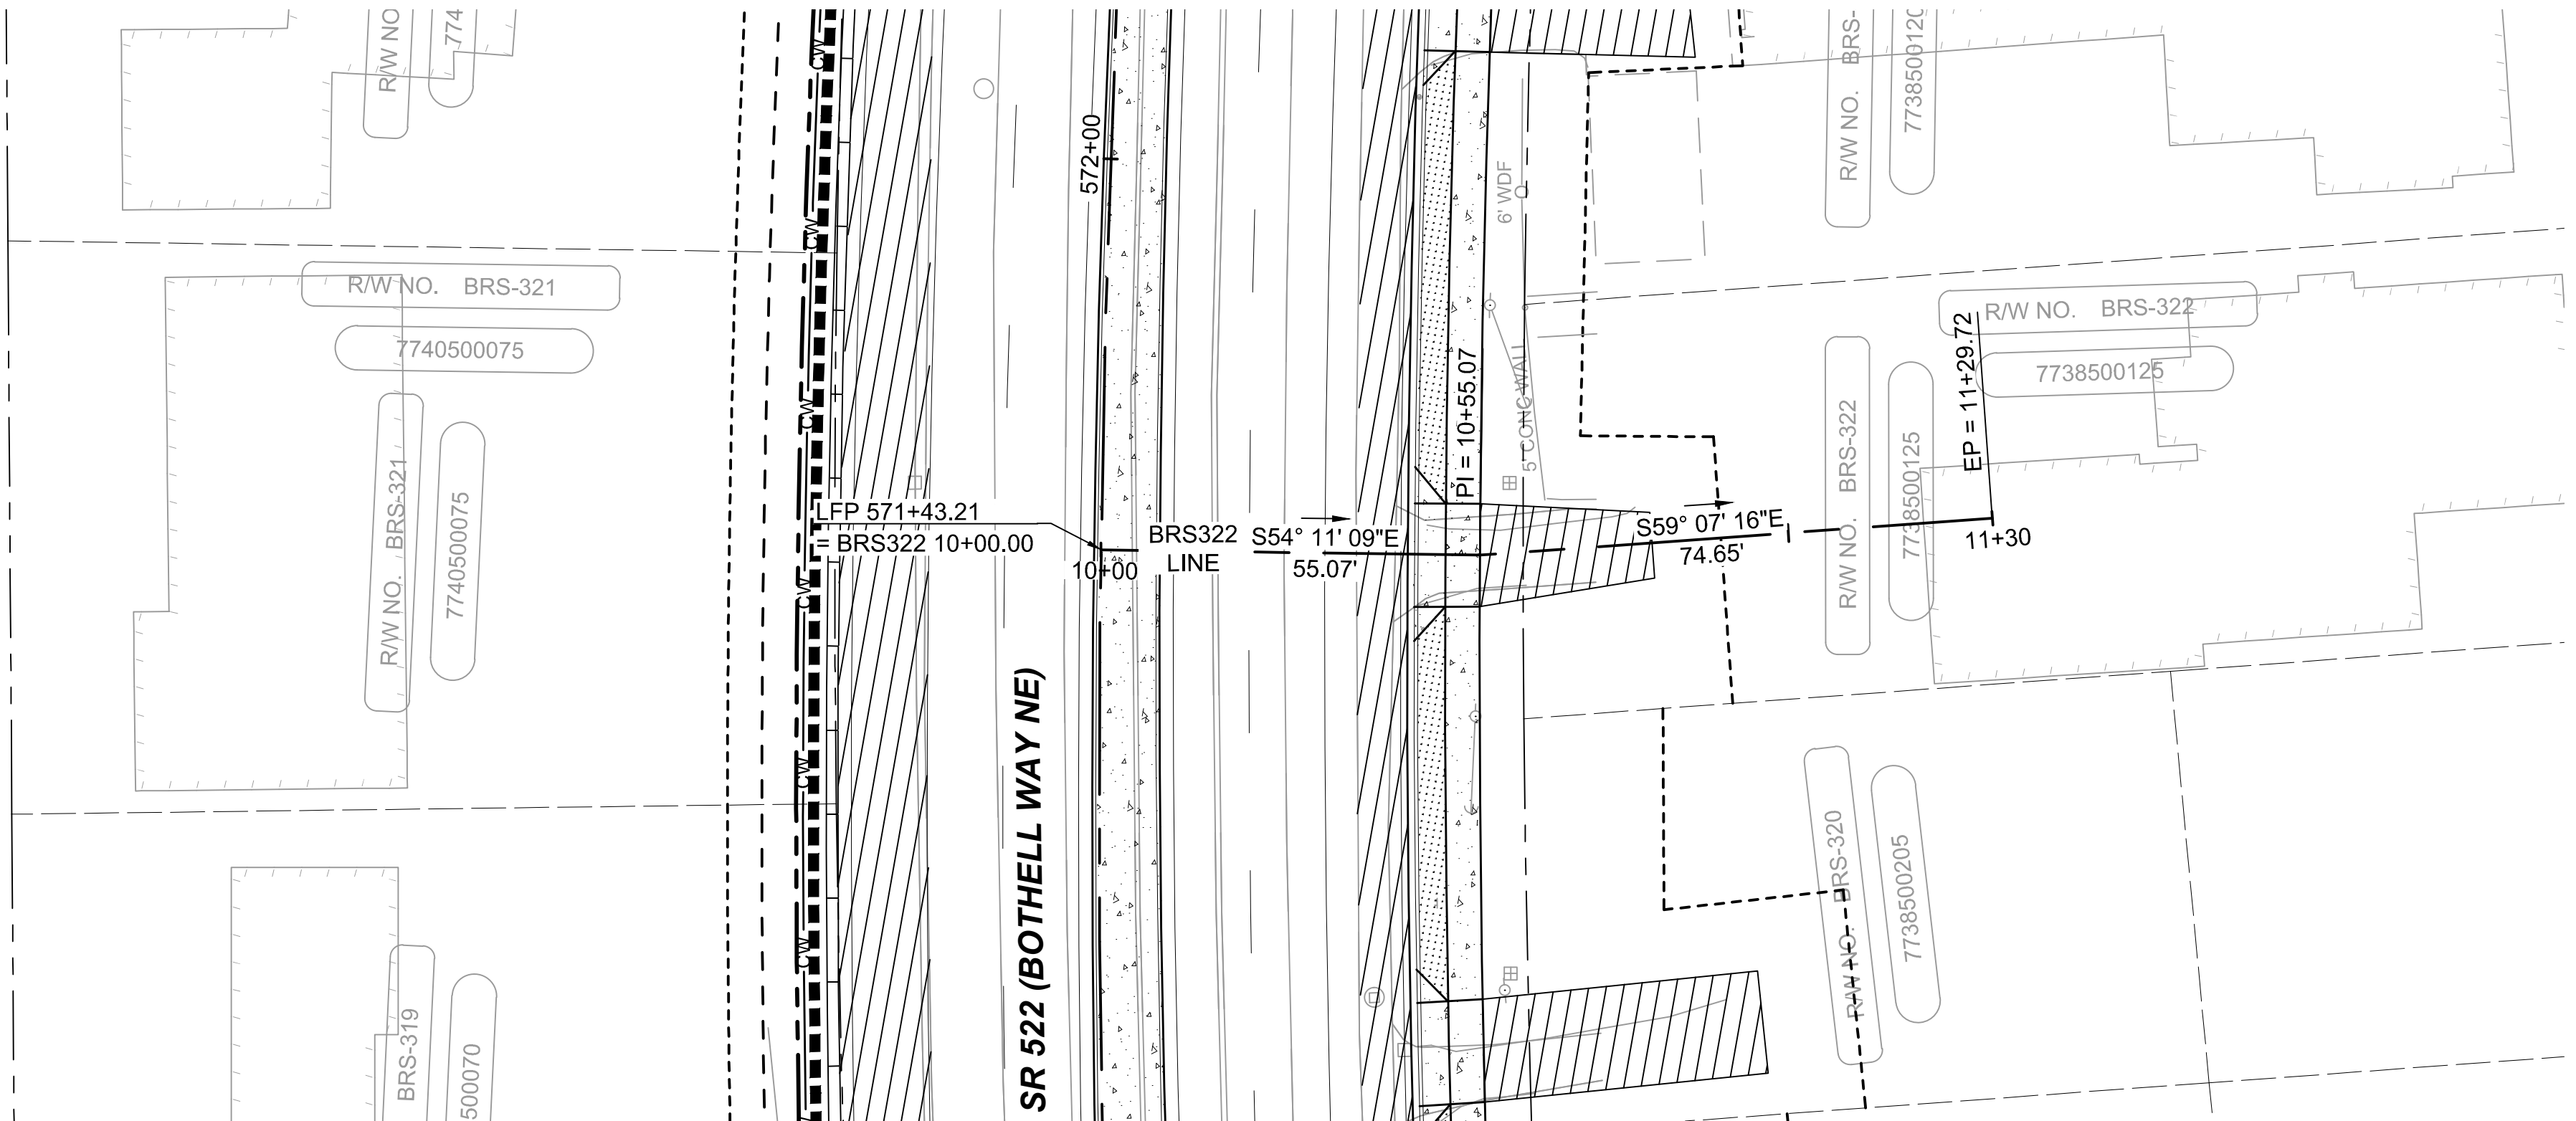

DRAFT 30% SUBMITTAL

No.	DATE	DSN	CHK	APP	REVISION

DESIGNED BY:
C.MATYAS

DRAWN BY:
C.BRESLEY

CHECKED BY:
R.KOESTER

APPROVED BY:
M.FELIBERTI



**DAVID EVANS
AND ASSOCIATES INC.**
14432 SE Eastgate Way, Suite 400
Bellevue Washington 98007
Phone: 425.519.6500

SUBMITTED BY:
D.SCHOCK

DATE:
09/11/2020

REVIEWED BY:
B.KEMPER



DATE:
09/11/2020

SCALE:
1"=20'

FILENAME:
BRT-522-CRV237-250

CONTRACT No.:
AE 0055-17

DATE:
09/11/2020

SR 522 / NE 145TH BRT

SR 522 (BOTHELL WAY NE)

CIVIL

DRIVEWAY PLAN AND PROFILE BRS322

STA. 10+00 TO STA. 11+29.72


DRAWING No.:
522-CRV247

FACILITY ID:
522


SHEET No.:
151 OF 283

REV:

09/10/20 | 2:06 AM | SJRO
C:\PW_WORK\DEA\STEVEN ROSE\DWG\BRT-522-CRV237-250.DWG

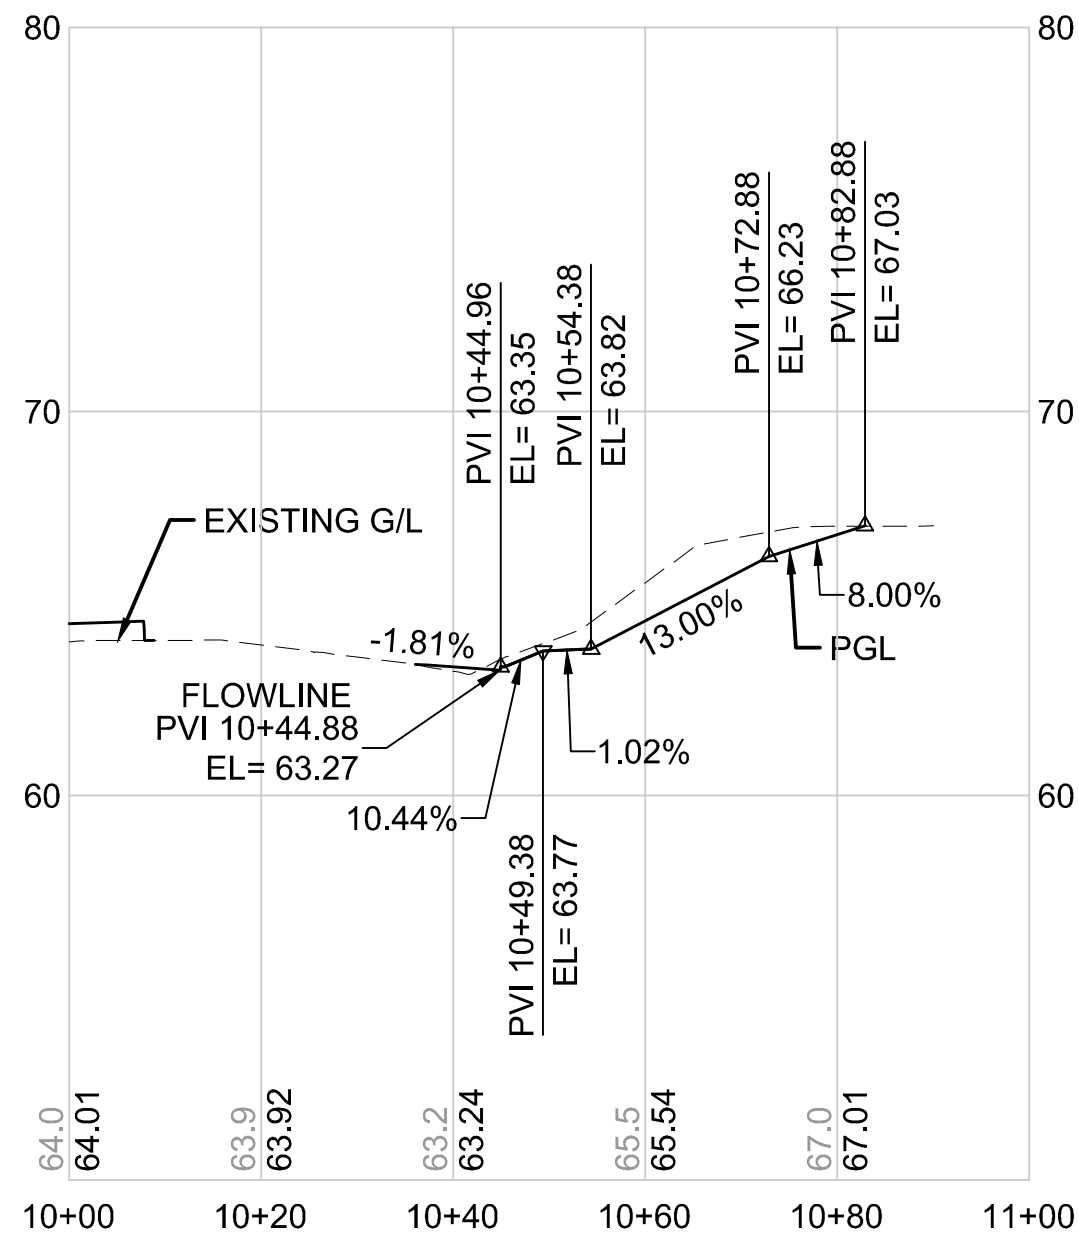

BRS323 LINE
HORIZONTAL SCALE: 1"=20'
VERTICAL SCALE: 1"=5'

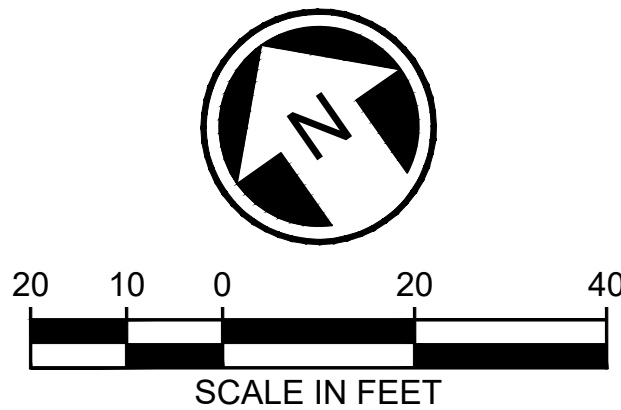

DRAFT 30% SUBMITTAL

No.	DATE	DSN	CHK	APP	REVISION

DESIGNED BY:
C.MATYAS
DRAWN BY:
C.BRESLEY
CHECKED BY:
R.KOESTER
APPROVED BY:
M.FELIBERTI



DAVID EVANS
AND ASSOCIATES INC.
14432 SE Eastgate Way, Suite 400
Bellevue Washington 98007
Phone: 425.519.6500

SUBMITTED BY:
D.SCHOCK

DATE:
09/11/2020

REVIEWED BY:
B.KEMPER






DATE:
09/11/2020

SCALE:
1"=20'
FILENAME:
BRT-522-CRV237-250
CONTRACT No.:
AE 0055-17
DATE:
09/11/2020

SR 522 / NE 145TH BRT
SR 522 (BOTHELL WAY NE)
CIVIL
DRIVEWAY PLAN AND PROFILE BRS323
STA 10+00 TO STA. 11+00.83

DRAWING No.:
522-CRV248
FACILITY ID:
522
SHEET No.:
152 OF 283
REV:

09/10/20 | 2:07 AM | SJRO
C:\PW_WORK\DEA\STEVEN ROSE\DWG\506735\BRT-522-CRV237-250.DWG

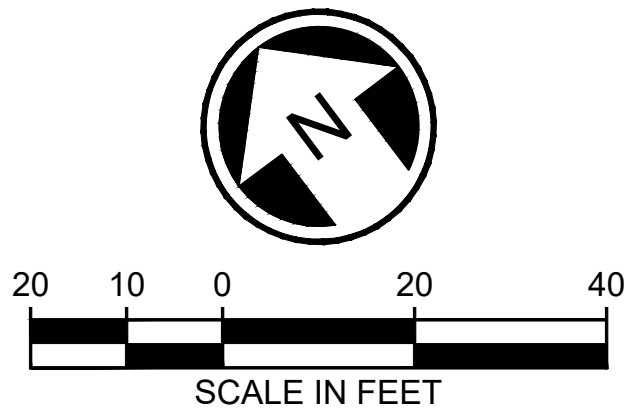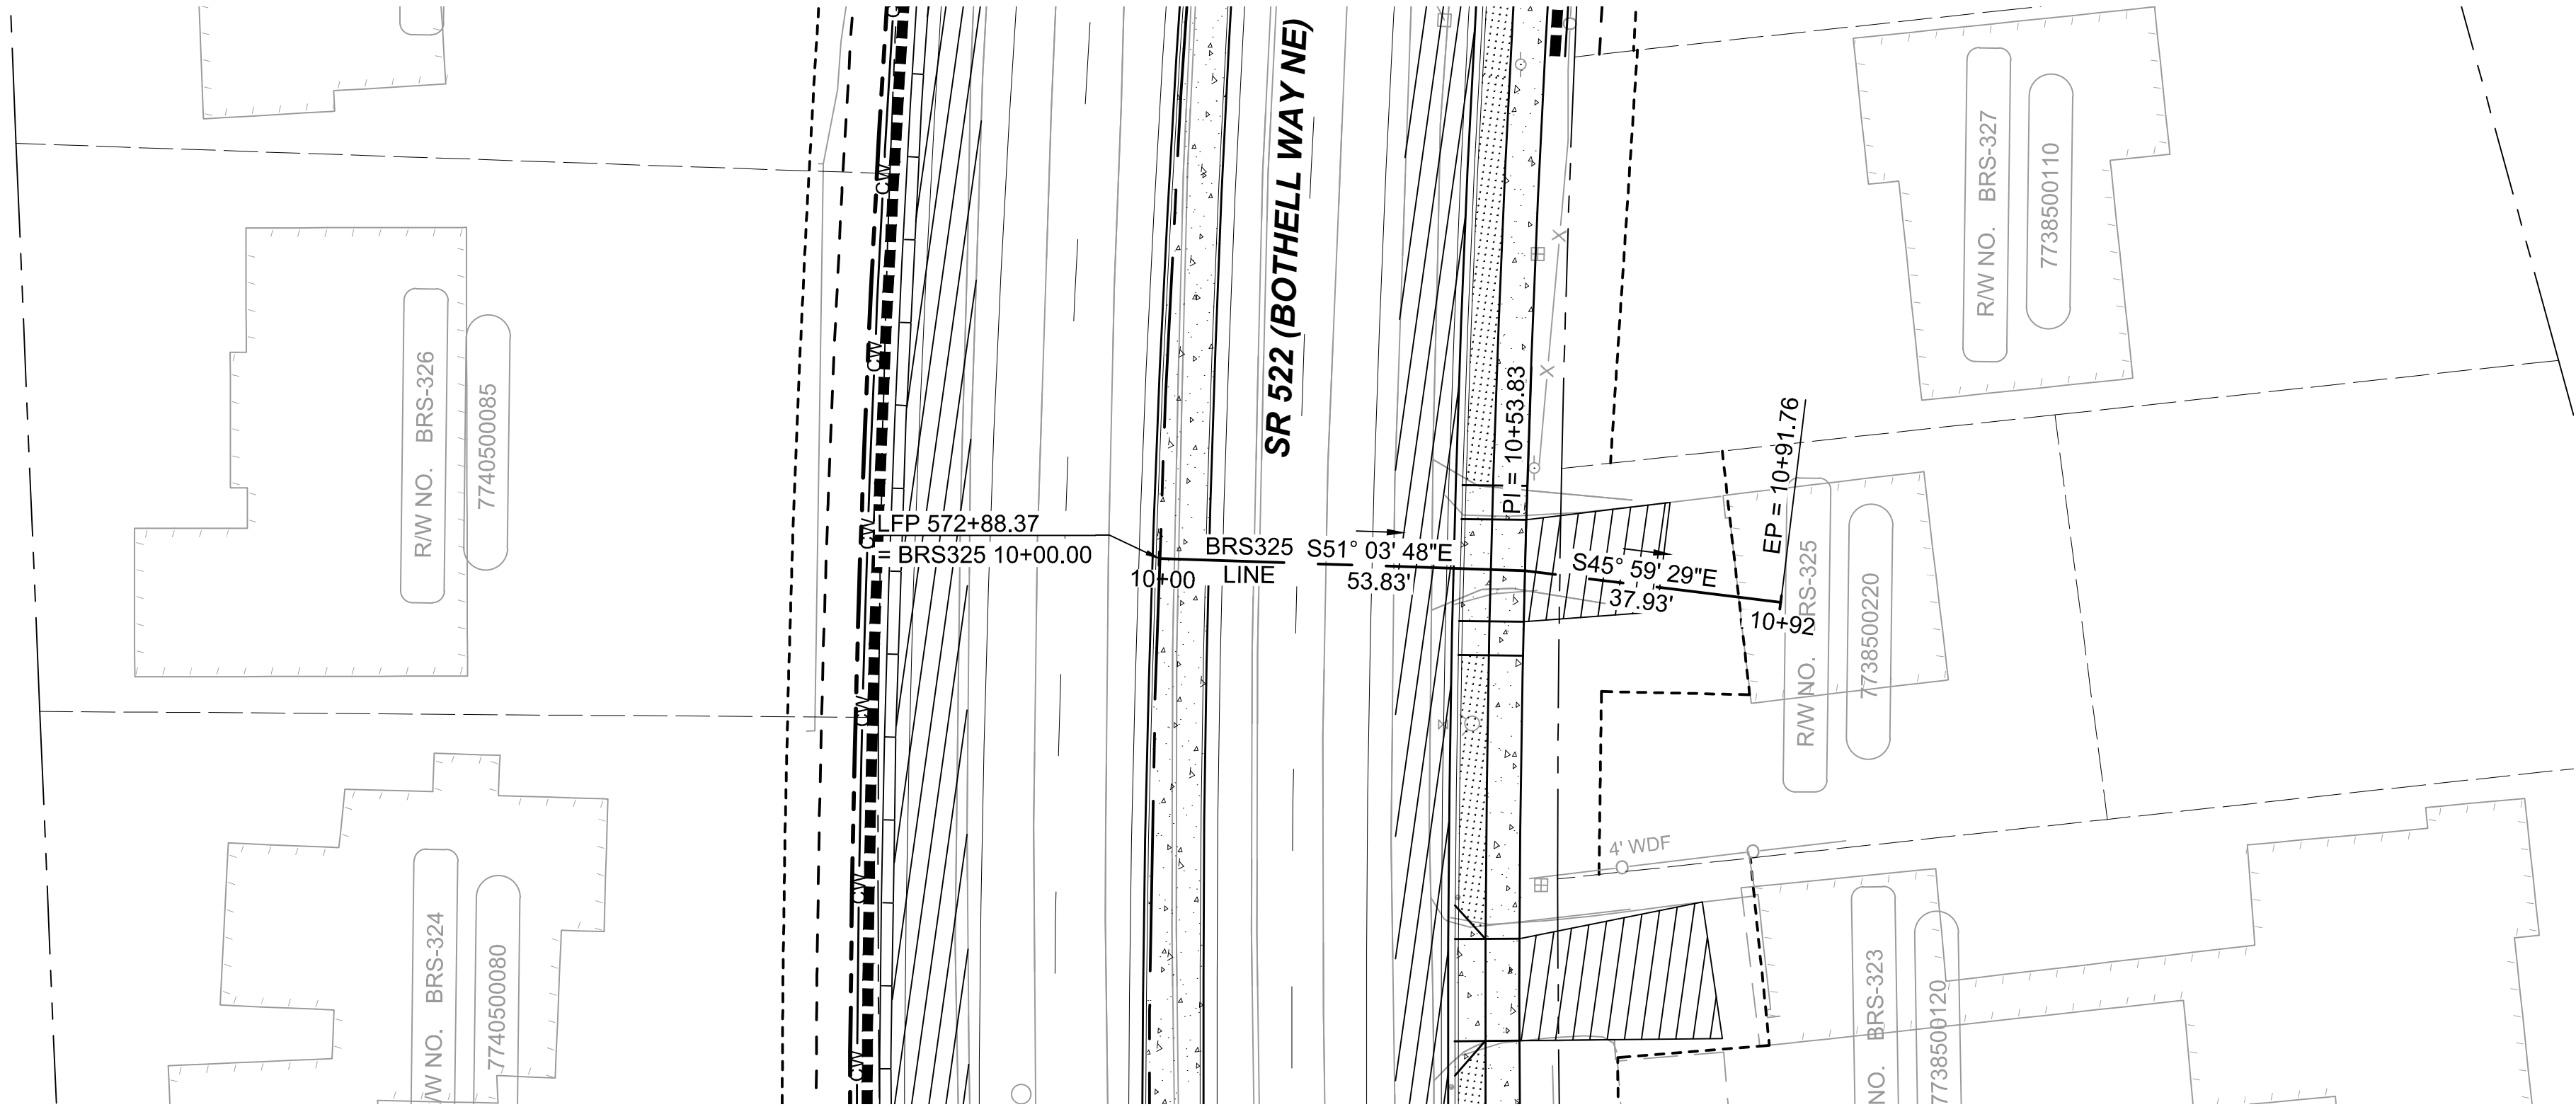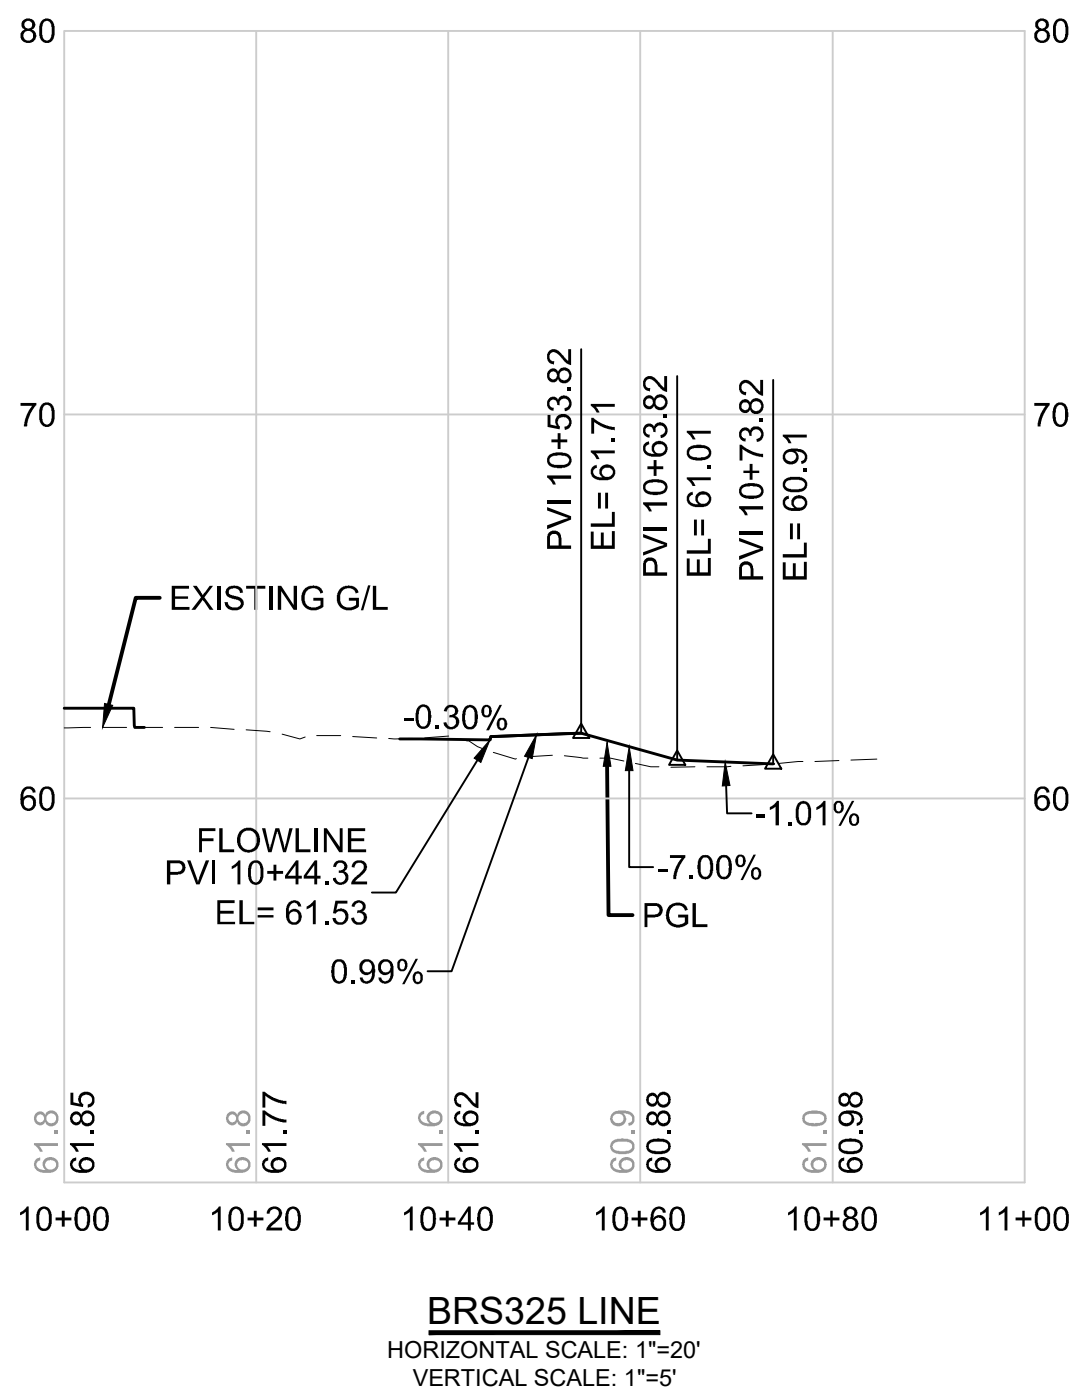

DRAFT 30% SUBMITTAL


No.	DATE	DSN	CHK	APP	REVISION

DESIGNED BY:	C.MATYAS
DRAWN BY:	C.BRESLEY
CHECKED BY:	R.KOESTER
APPROVED BY:	M.FELIBERTI



**DAVID EVANS
AND ASSOCIATES INC.**
14432 SE Eastgate Way, Suite 400
Bellevue Washington 98007
Phone: 425.519.6500

SUBMITTED BY:	DATE:	REVIEWED BY:
D.SCHOCK	09/11/2020	B.KEMPER

 


DATE:
09/11/2020

SCALE:	1"=20'
FILENAME:	BRT-522-CRV237-250
CONTRACT No.:	AE 0055-17
DATE:	09/11/2020



SR 522 / NE 145TH BRT
SR 522 (BOTHELL WAY NE)
CIVIL
DRIVEWAY PLAN AND PROFILE BRS325
STA. 10+00 TO STA 10+91.76

DRAWING No.:	522-CRV249
FACILITY ID:	522
SHEET No.:	153 OF 283
REV:	

09/10/20 | 2:08 AM | SJRO
C:\PW_WORK\DEA\STEVEN ROSE\DWG\BRT-522-CRV237-250.DWG

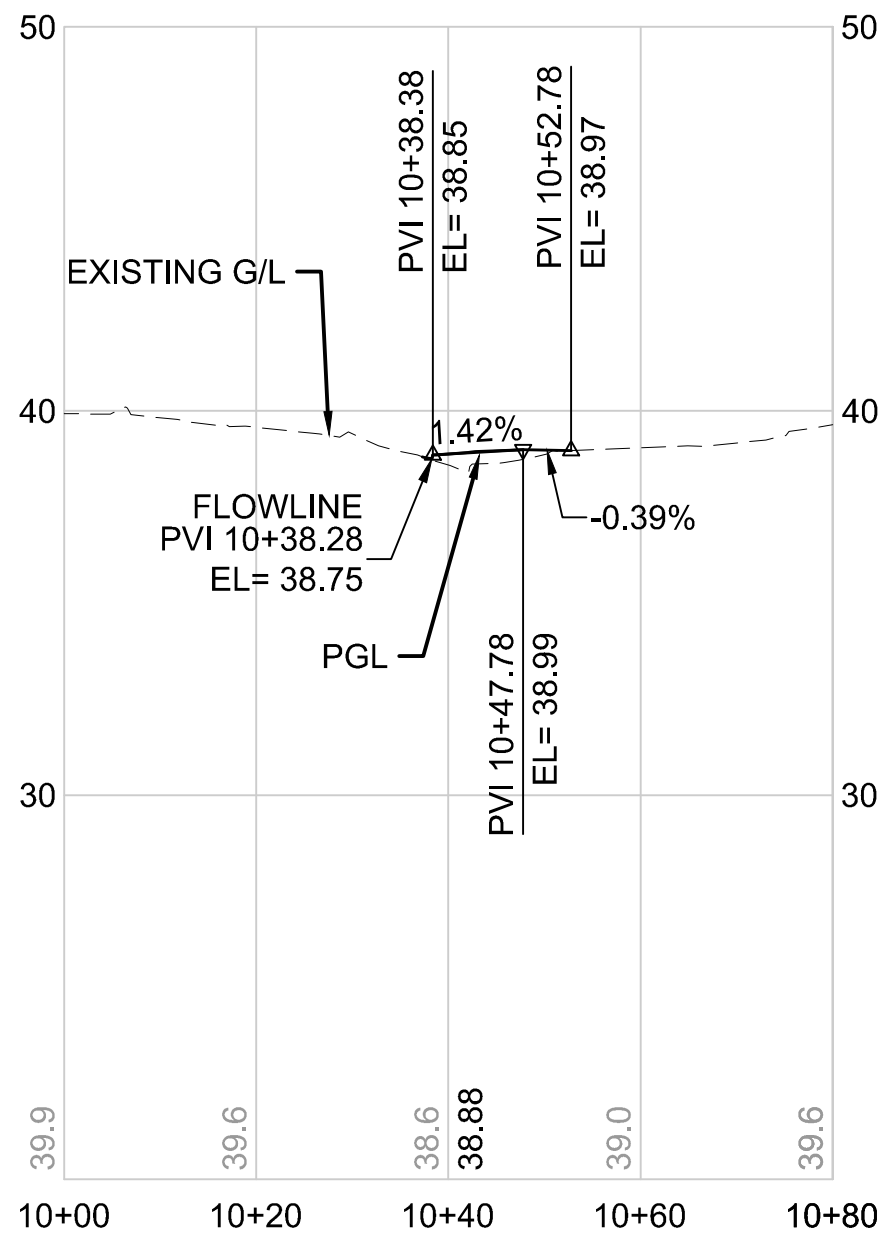

BRS337 LINE
HORIZONTAL SCALE: 1"=20'
VERTICAL SCALE: 1"=5'

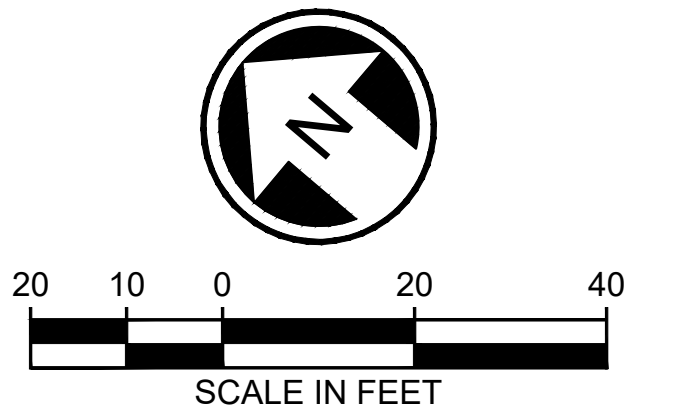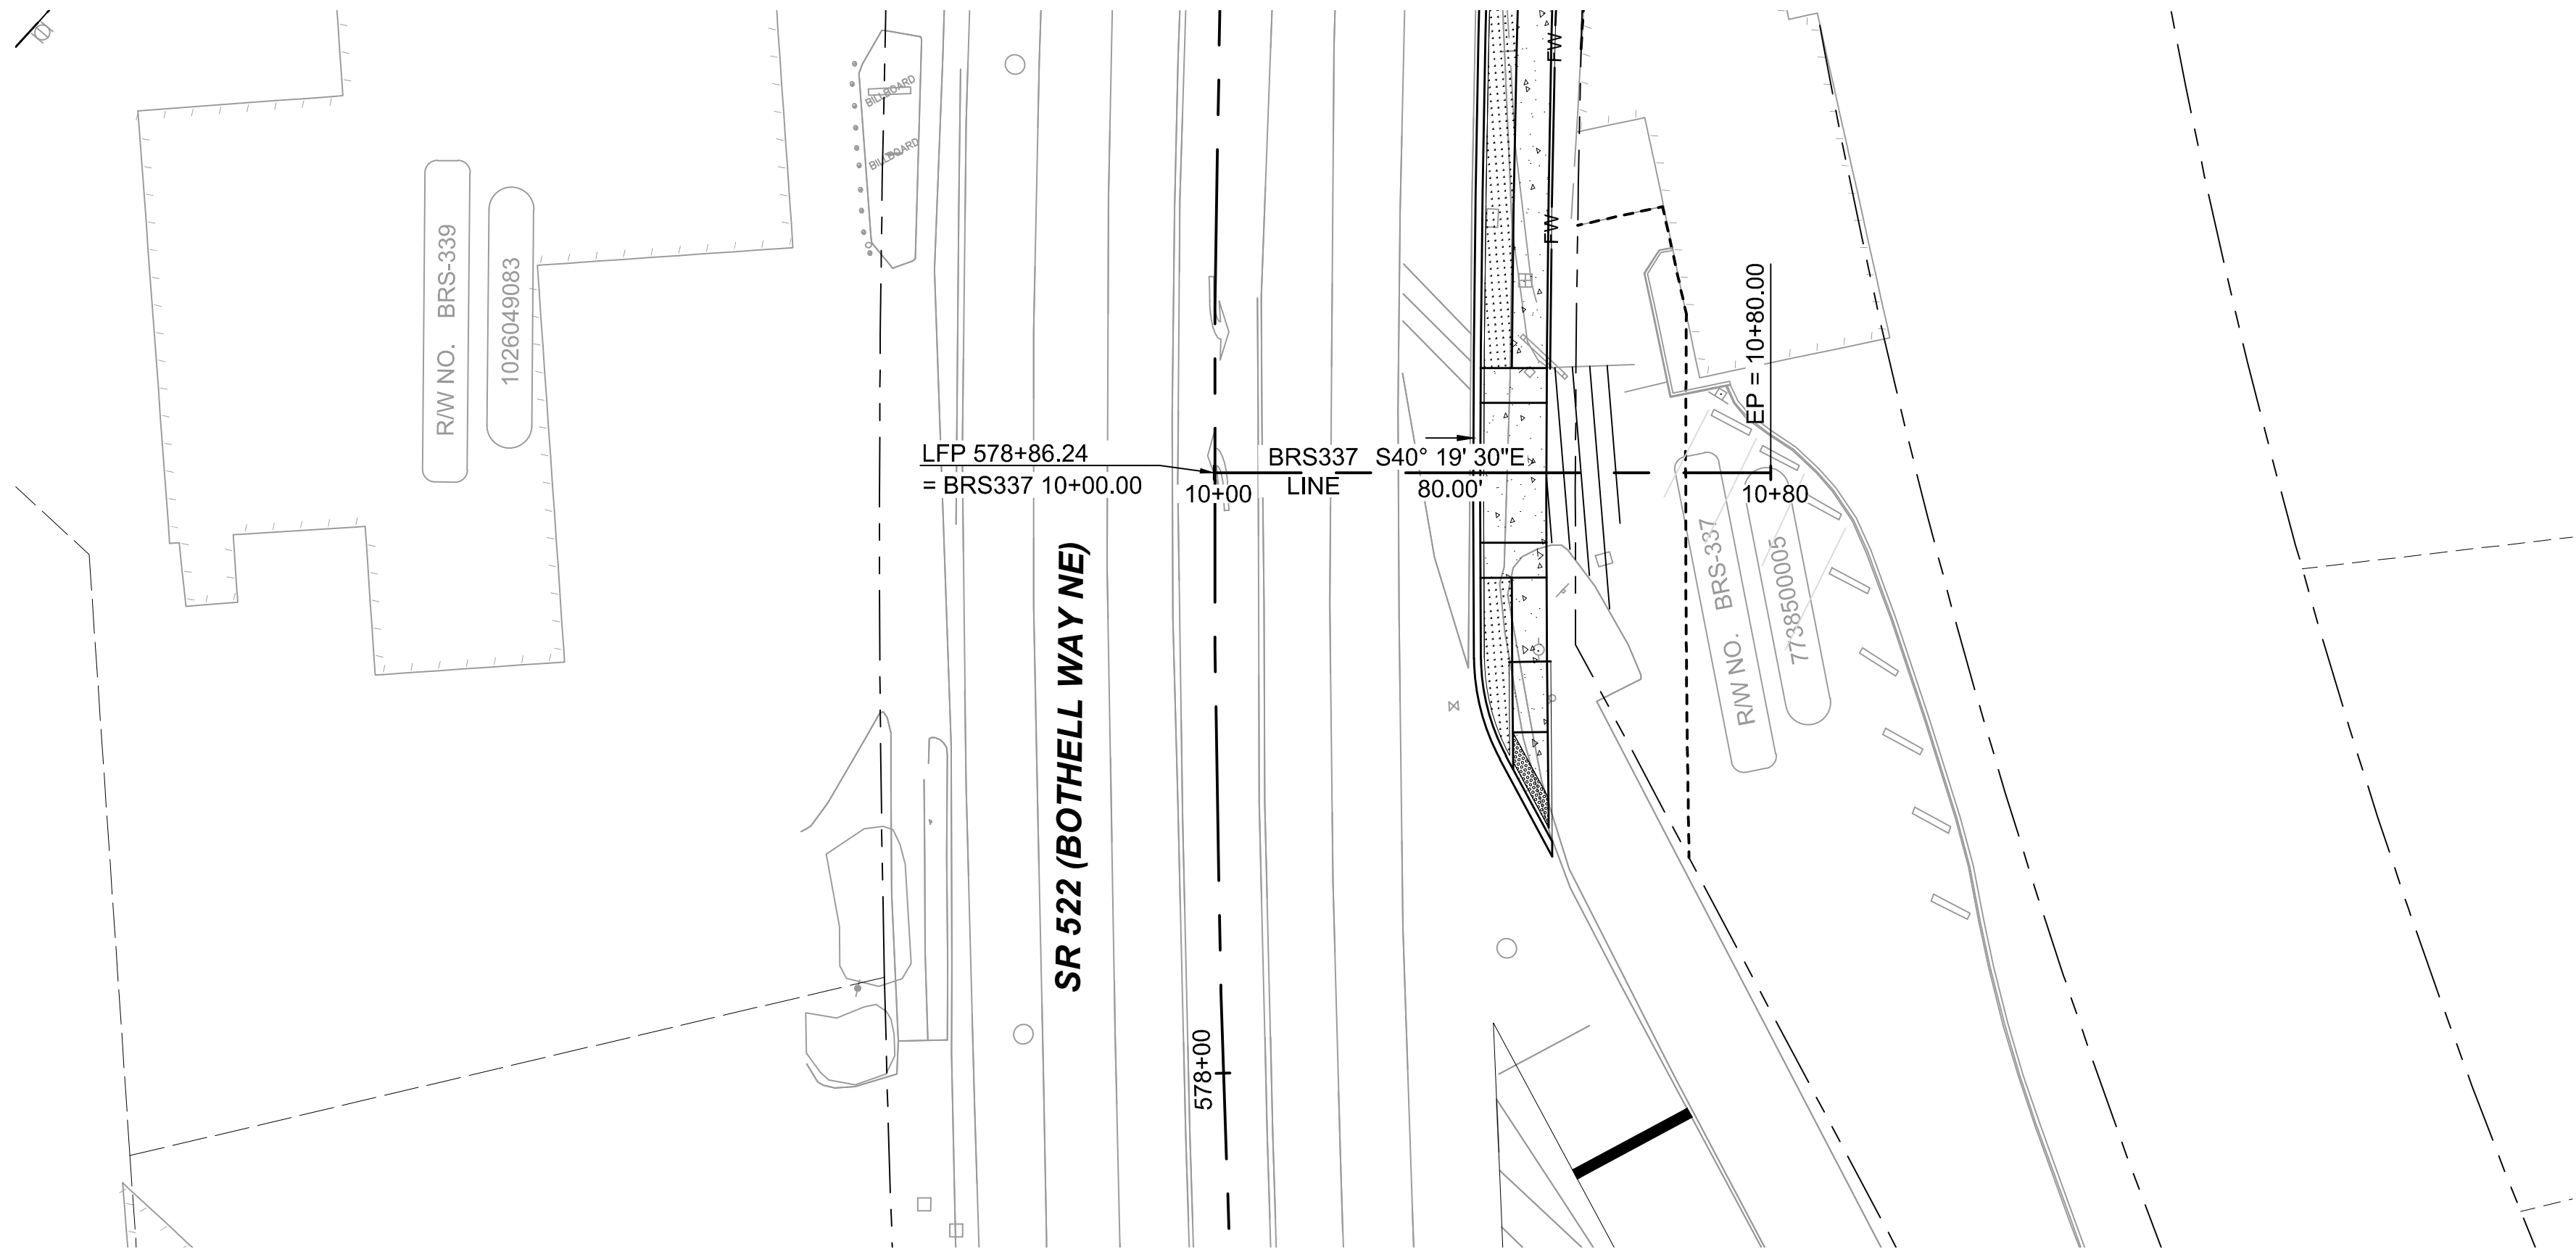

DRAFT 30% SUBMITTAL


No.	DATE	DSN	CHK	APP	REVISION

DESIGNED BY:	C. MATYAS
DRAWN BY:	C. BRESLEY
CHECKED BY:	R.KOESTER
APPROVED BY:	M. FELIBERTI



**DAVID EVANS
AND ASSOCIATES INC.**
14432 SE Eastgate Way, Suite 400
Bellevue Washington 98007
Phone: 425.519.6500

SUBMITTED BY:	DATE:	REVIEWED BY:
D.SCHOCK	09/11/2020	B.KEMPER

 

SOUNDTRANSIT


SCALE:	1"=20'
FILENAME:	BRT-522-CRV237-250
CONTRACT No.:	AE 0055-17
DATE:	09/11/2020

SR 522 / NE 145TH BRT
SR 522 (BOTHELL WAY NE)
CIVIL
DRIVEWAY PLAN AND PROFILE BRS337
STA. 10+00 TO STA. 10+80

DRAWING No.:	522-CRV250
FACILITY ID:	522
SHEET No.:	154 OF 283
REV:	

09/10/20 | 10:42 AM | APDC
C:\PW_WORK\IDEA\APRIL COLEMAN\IDMS06735\BRT-522-CRD201-208.DWG

SR 522 (BOTHELL WAY NE)

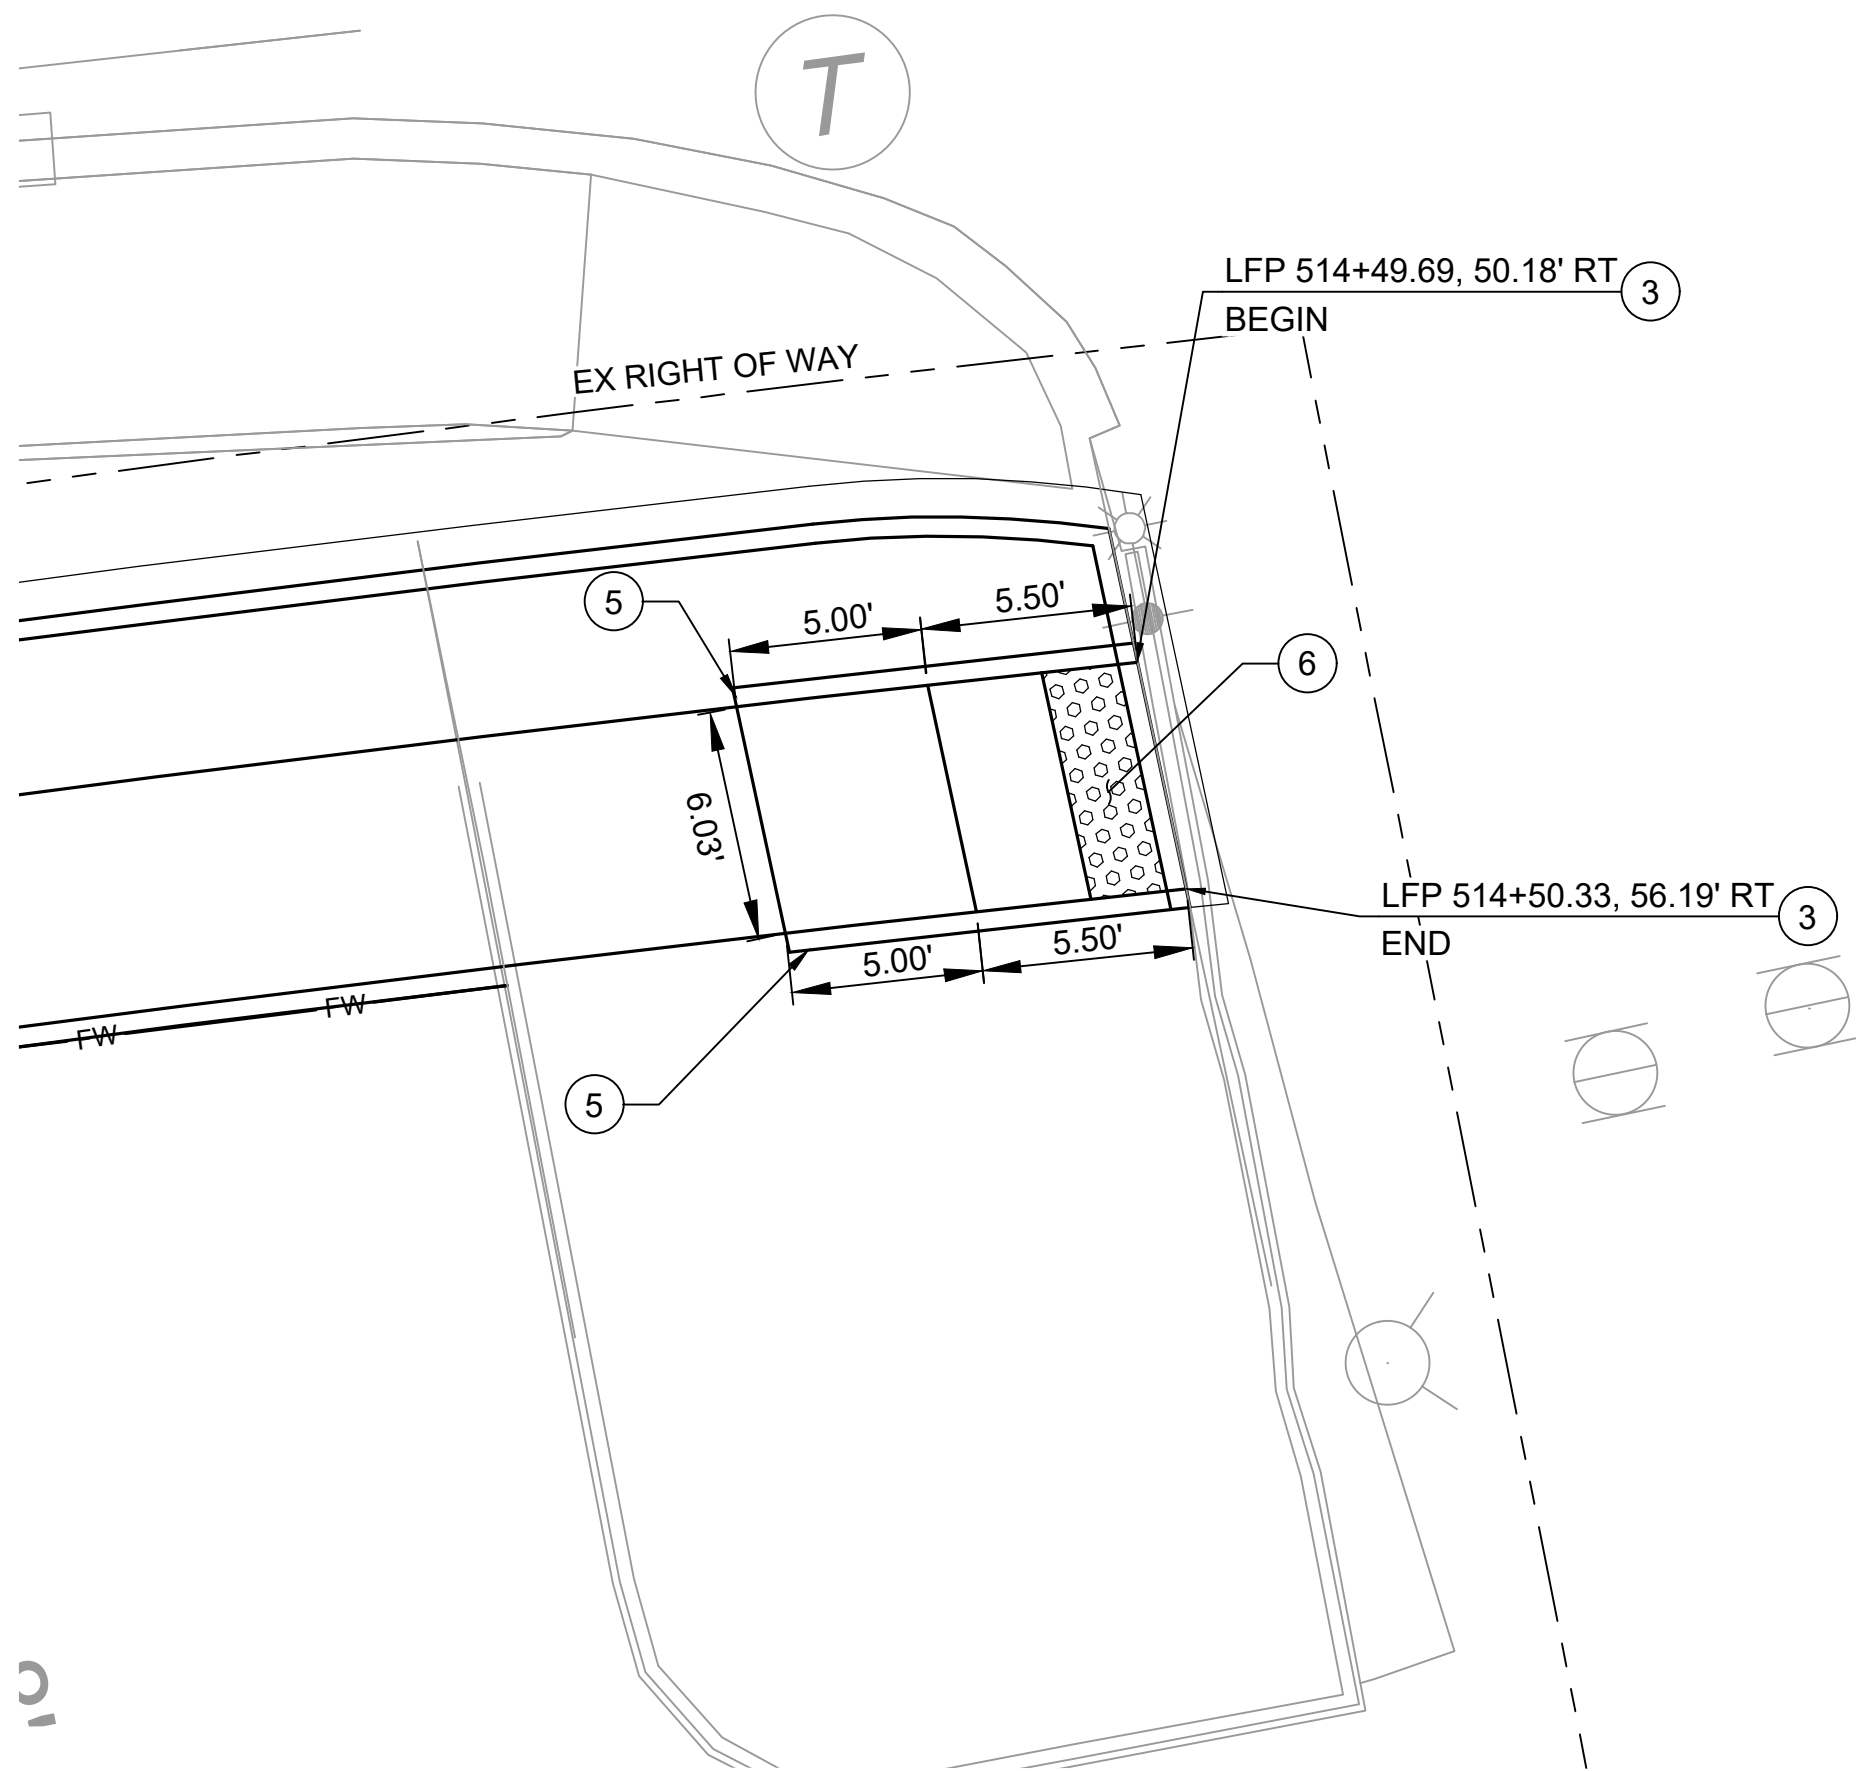

NE 147TH ST

CURB RAMP DETAIL

SCALE: 1" = 5'

1
CPP203

 
CONSTRUCTION NOTES:

1. INSTALL CEMENT CONCRETE PARALLEL TYPE A CURB RAMP PER WSDOT STD PLAN F-40.12-03
2. INSTALL CEMENT CONCRETE PERPENDICULAR CURB RAMP PER WSDOT STD PLAN F-40.15-03
3. INSTALL CEMENT CONCRETE SINGLE DIRECTION CURB RAMP PER WSDOT STD. PLAN F-40.16-03
4. INSTALL CEMENT CONCRETE COMBINATION CURB RAMP PER WSDOT STD. PLAN F-40.14-03
5. INSTALL CEMENT CONCRETE PEDESTRIAN CURB PER WSDOT STD. PLAN F-10.12-03
6. INSTALL YELLOW DETECTABLE WARNING SURFACE PER WSDOT STD. PLAN F-45.10-02


GENERAL NOTES:

1. FOR CEMENT CONCRETE MIX DESIGN STRENGTH, SEE SPECIFICATIONS (TO BE PROVIDED POST 30% DESIGN).
2. STATIONS, OFFSETS, DIMENSIONS, AND HORIZONTAL CONTROL ARE TO FACE OF CURB UNLESS OTHERWISE NOTED.
3. ELEVATIONS ARE MEASURED AT FLOW LINE OF CURB AND GUTTER UNLESS OTHERWISE NOTED (TO BE PROVIDED POST 30% DESIGN).
4. ALL CURBS ARE 6 INCHES TALL UNLESS OTHERWISE NOTED.
5. SEE SHEETS 522-CRY201 - 522-CRY213 FOR TYPICAL ROADWAY SECTIONS
6. SEE SHEETS 522-CPP201 - 522-CPP220 FOR ROADWAY PAVING PLANS
7. SEE SHEETS 522-ASP201 - 522-ASX214 FOR ARCHITECTURAL STATION PLANS AND DETAILS

LEGEND:



DETECTABLE WARNING SURFACE

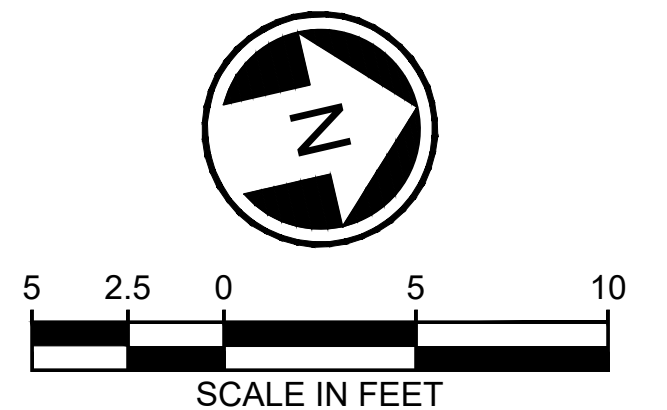

DRAFT 30% SUBMITTAL

DESIGNED BY:
C. MATYAS
DRAWN BY:
J. JACKSON
CHECKED BY:
R. KOESTER
APPROVED BY:
M. FELIBERTI

 


**DAVID EVANS
AND ASSOCIATES INC.**
14432 SE Eastgate Way, Suite 400
Bellevue Washington 98007
Phone: 425.519.6500

SUBMITTED BY:
D.SCHOCK

DATE:
09/11/2020

REVIEWED BY:
B.KEMPER




SOUND TRANSIT

SCALE:
1"=5'
FILENAME:
BRT-522-CRD201-208
CONTRACT No.:
AE 0055-17
DATE:
09/11/2020

SR 522 / NE 145TH BRT
SR 522 (BOTHELL WAY NE)
CIVIL
CURB RAMP PLAN AND DETAILS
SR 522 (BOTHELL WAY NE) & NE 147TH ST

DRAWING No.:
522-CRD201
FACILITY ID:
522
SHEET No.:
155 OF 283
REV:

09/10/20 | 10:43 AM | APDC
C:\PW_WORK\DEA\APRIL COLEMAN\DWG\BRT-522-CRD201-208.DWG

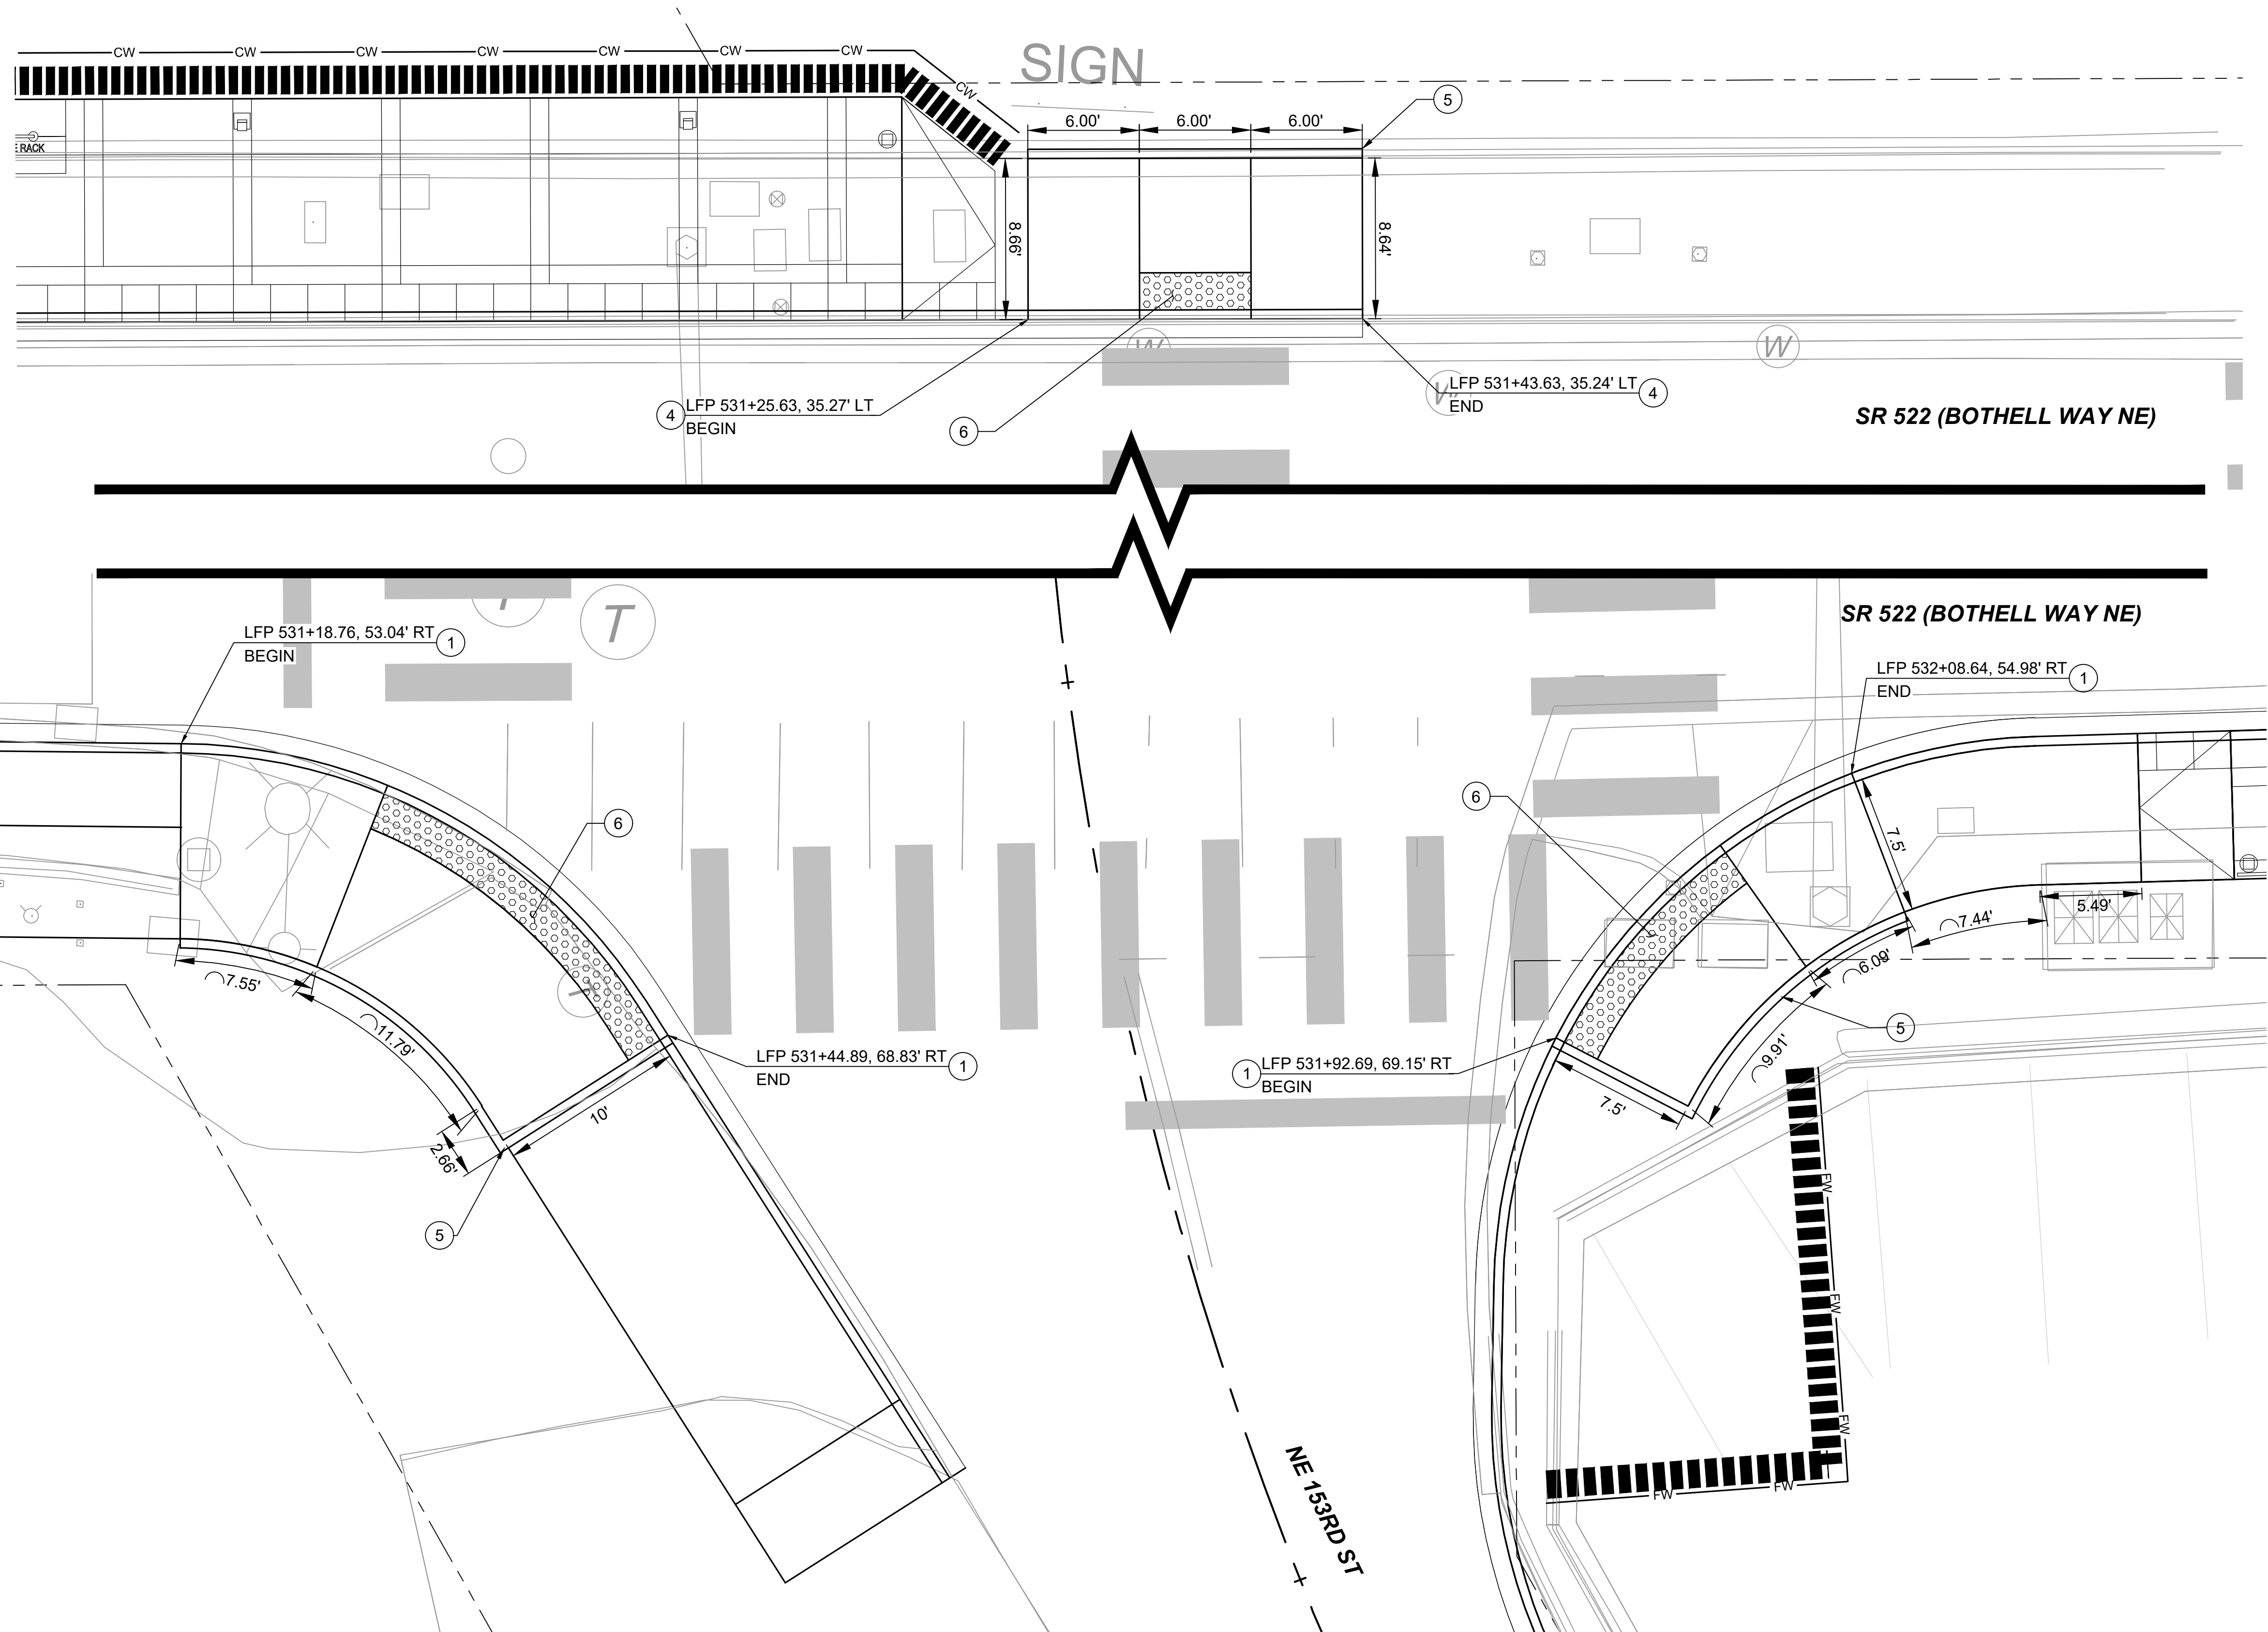

CURB RAMP DETAIL
SCALE: 1" = 5'

2
CPP206

 
CONSTRUCTION NOTES:


1. INSTALL CEMENT CONCRETE PARALLEL TYPE A CURB RAMP PER WSDOT STD PLAN F-40.12-03
2. INSTALL CEMENT CONCRETE PERPENDICULAR CURB RAMP PER WSDOT STD PLAN F-40.15-03
3. INSTALL CEMENT CONCRETE SINGLE DIRECTION CURB RAMP PER WSDOT STD. PLAN F-40.16-03
4. INSTALL CEMENT CONCRETE COMBINATION CURB RAMP PER WSDOT STD. PLAN F-40.14-03
5. INSTALL CEMENT CONCRETE PEDESTRIAN CURB PER WSDOT STD. PLAN F-10.12-03
6. INSTALL YELLOW DETECTABLE WARNING SURFACE PER WSDOT STD. PLAN F-45.10-02

GENERAL NOTES:

1. FOR CEMENT CONCRETE MIX DESIGN STRENGTH, SEE SPECIFICATIONS (TO BE PROVIDED POST 30% DESIGN).
2. STATIONS, OFFSETS, DIMENSIONS, AND HORIZONTAL CONTROL ARE TO FACE OF CURB UNLESS OTHERWISE NOTED.
3. ELEVATIONS ARE MEASURED AT FLOW LINE OF CURB AND GUTTER UNLESS OTHERWISE NOTED (TO BE PROVIDED POST 30% DESIGN).
4. ALL CURBS ARE 6 INCHES TALL UNLESS OTHERWISE NOTED.
5. SEE SHEETS 522-CRY201 - 522-CRY213 FOR TYPICAL ROADWAY SECTIONS
6. SEE SHEETS 522-CPP201 - 522-CPP220 FOR ROADWAY PAVING PLANS
7. SEE SHEETS 522-ASP201 - 522-ASX214 FOR ARCHITECTURAL STATION PLANS AND DETAILS

LEGEND:

 DETECTABLE WARNING SURFACE

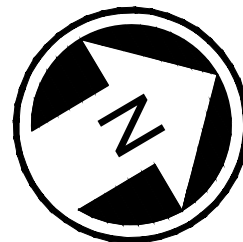

DRAFT 30% SUBMITTAL

No.	DATE	DSN	CHK	APP	REVISION

DESIGNED BY:
C. MATYAS
DRAWN BY:
J. JACKSON
CHECKED BY:
R. KOESTER
APPROVED BY:
M. FELIBERTI



**DAVID EVANS
AND ASSOCIATES INC.**
14432 SE Eastgate Way, Suite 400
Bellevue Washington 98007
Phone: 425.519.6500

SUBMITTED BY:
D.SCHOCK

DATE:
09/11/2020

REVIEWED BY:
B.KEMPER




DATE:
09/11/2020

SCALE:
1"=5'
FILENAME:
BRT-522-CRD201-208
CONTRACT No.:
AE 0055-17
DATE:
09/11/2020

SR 522 / NE 145TH BRT
SR 522 (BOTHELL WAY NE)
CIVIL
CURB RAMP PLAN AND DETAILS
SR 522 (BOTHELL WAY NE) & NE 153RD ST

DRAWING No.:
522-CRD202
FACILITY ID:
522
SHEET No.:
156 OF 283
REV:

09/10/20 | 10:43 AM | APDC
C:\PW\WORK\DEA\APRIL COLEMAN\DWG\SR 522-CRD201-208.DWG

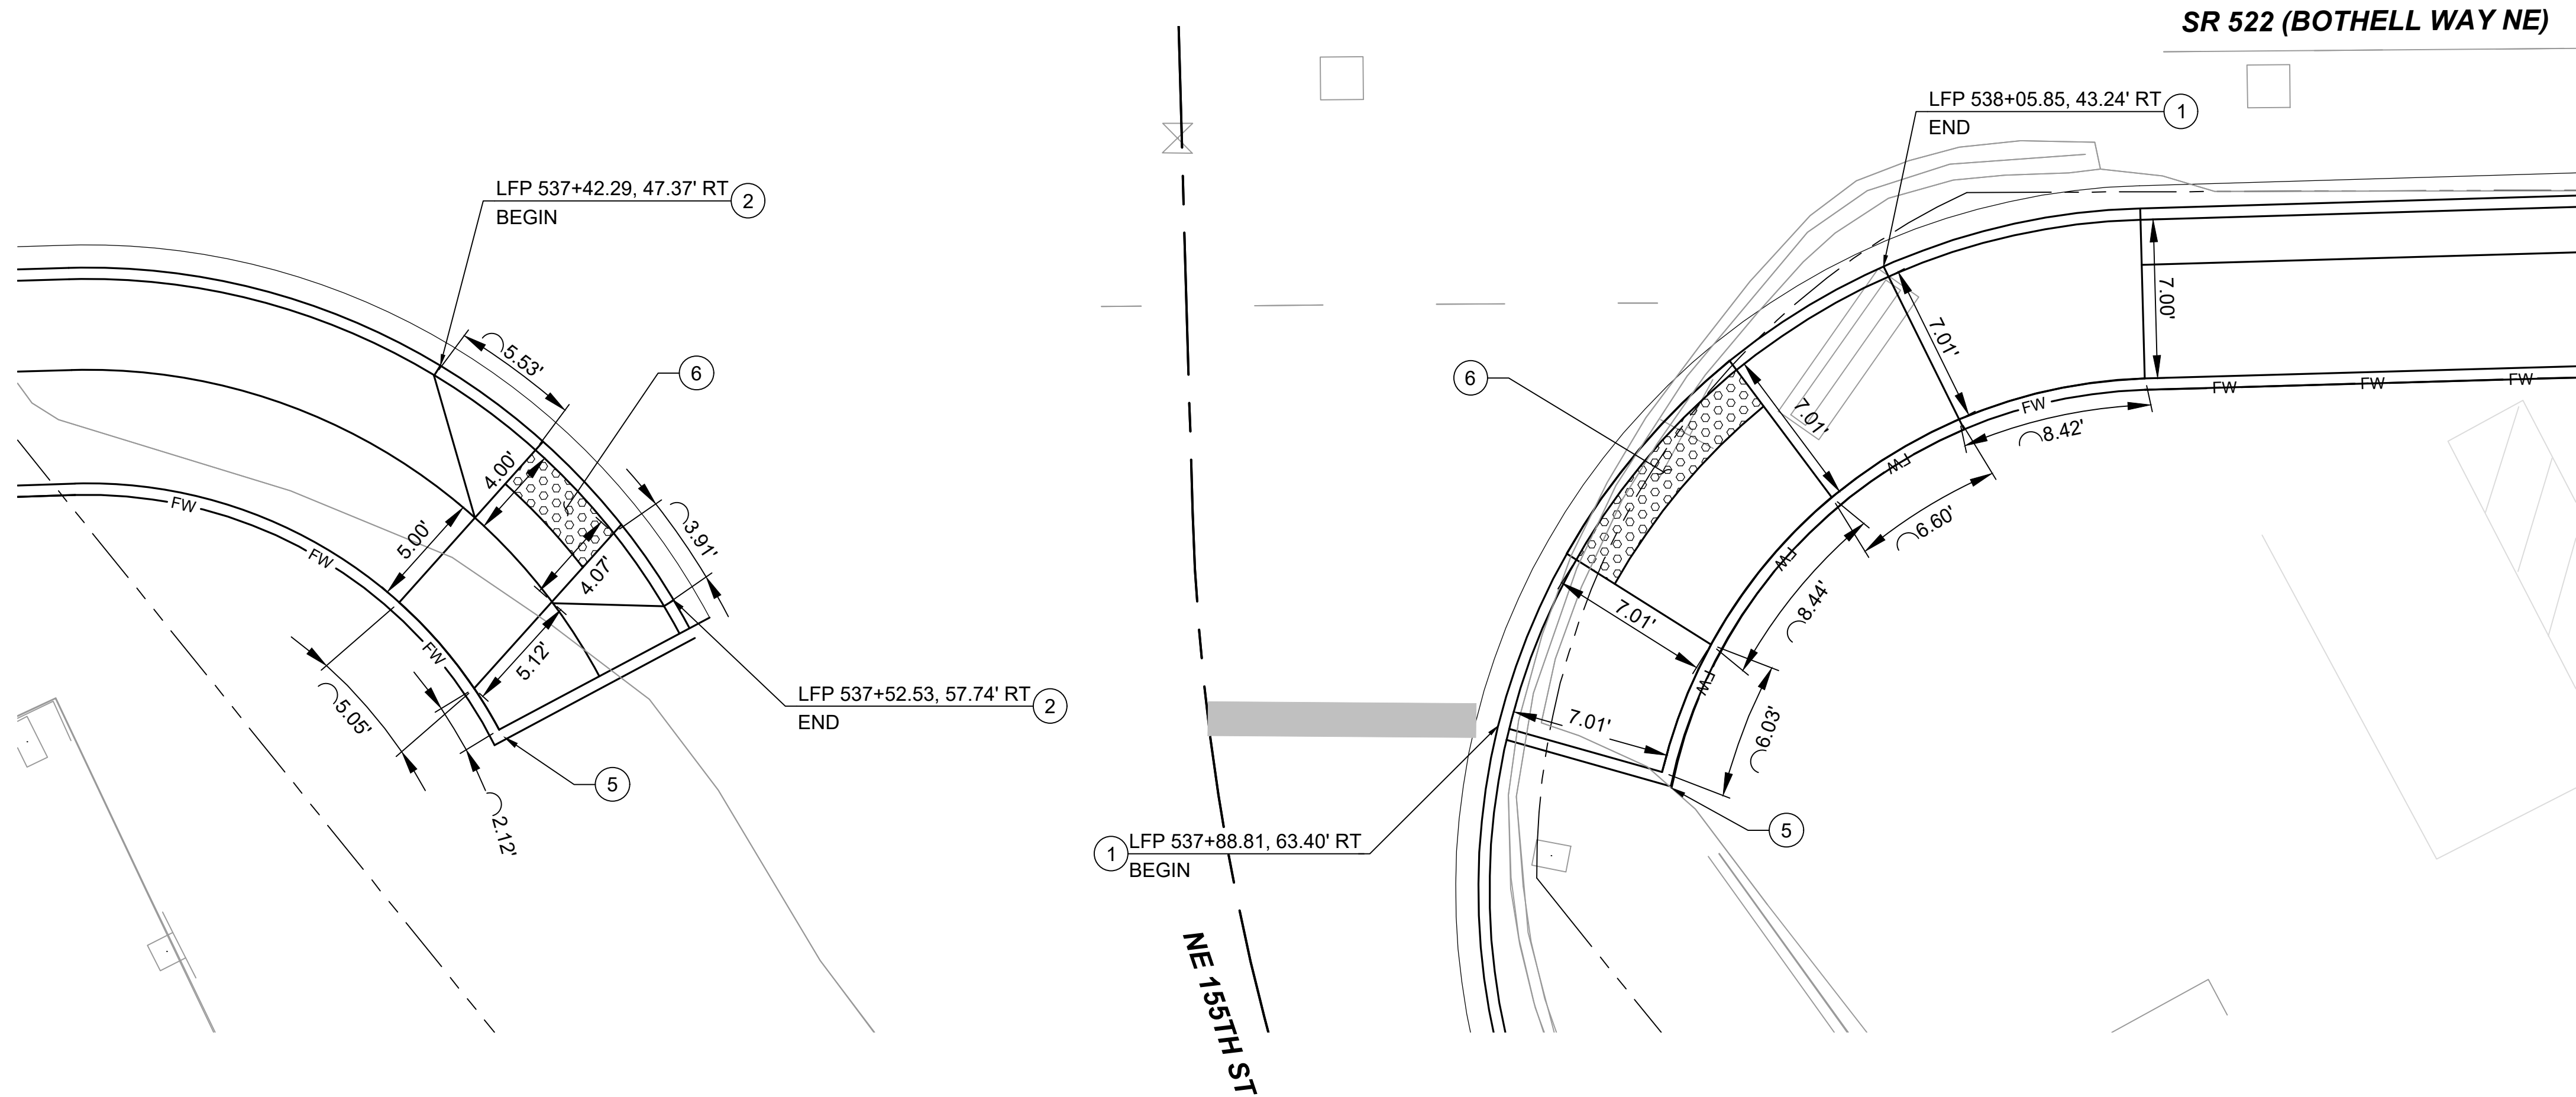

CURB RAMP DETAIL
SCALE: 1" = 5'

3
CPP208

 
CONSTRUCTION NOTES:

1. INSTALL CEMENT CONCRETE PARALLEL TYPE A CURB RAMP PER WSDOT STD PLAN F-40.12-03
2. INSTALL CEMENT CONCRETE PERPENDICULAR CURB RAMP PER WSDOT STD PLAN F-40.15-03
3. INSTALL CEMENT CONCRETE SINGLE DIRECTION CURB RAMP PER WSDOT STD. PLAN F-40.16-03
4. INSTALL CEMENT CONCRETE COMBINATION CURB RAMP PER WSDOT STD. PLAN F-40.14-03
5. INSTALL CEMENT CONCRETE PEDESTRIAN CURB PER WSDOT STD. PLAN F-10.12-03
6. INSTALL YELLOW DETECTABLE WARNING SURFACE PER WSDOT STD. PLAN F-45.10-02


GENERAL NOTES:

1. FOR CEMENT CONCRETE MIX DESIGN STRENGTH, SEE SPECIFICATIONS (TO BE PROVIDED POST 30% DESIGN).
2. STATIONS, OFFSETS, DIMENSIONS, AND HORIZONTAL CONTROL ARE TO FACE OF CURB UNLESS OTHERWISE NOTED.
3. ELEVATIONS ARE MEASURED AT FLOW LINE OF CURB AND GUTTER UNLESS OTHERWISE NOTED (TO BE PROVIDED POST 30% DESIGN).
4. ALL CURBS ARE 6 INCHES TALL UNLESS OTHERWISE NOTED.
5. SEE SHEETS 522-CRY201 - 522-CRY213 FOR TYPICAL ROADWAY SECTIONS
6. SEE SHEETS 522-CPP201 - 522-CPP220 FOR ROADWAY PAVING PLANS
7. SEE SHEETS 522-ASP201 - 522-ASX214 FOR ARCHITECTURAL STATION PLANS AND DETAILS

LEGEND:



DETECTABLE WARNING SURFACE

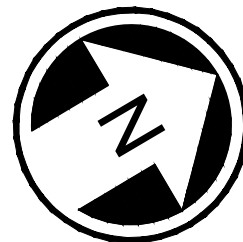

DRAFT 30% SUBMITTAL

No.	DATE	DSN	CHK	APP	REVISION

DESIGNED BY:
C. MATYAS
DRAWN BY:
J. JACKSON
CHECKED BY:
R. KOESTER
APPROVED BY:
M. FELIBERTI



DAVID EVANS
AND ASSOCIATES INC.
14432 SE Eastgate Way, Suite 400
Bellevue Washington 98007
Phone: 425.519.6500

SUBMITTED BY:
D.SCHOCK

DATE:
09/11/2020

REVIEWED BY:
B.KEMPER



DATE:
09/11/2020

SCALE:
1"=5'
FILENAME:
BRT-522-CRD201-208
CONTRACT No.:
AE 0055-17
DATE:
09/11/2020

SR 522 / NE 145TH BRT
SR 522 (BOTHELL WAY NE)
CIVIL
CURB RAMP PLAN AND DETAILS
SR 522 (BOTHELL WAY NE) & NE 155TH ST

DRAWING No.:
522-CRD203
FACILITY ID:
522
SHEET No.:
157 OF 283
REV:

09/10/20 | 10:44 AM | APDC
C:\PW_WORK\DEA\APRIL COLEMAN\DWG\BRT-522-CRD201-208.DWG

 
CONSTRUCTION NOTES:


1. INSTALL CEMENT CONCRETE PARALLEL TYPE A CURB RAMP PER WSDOT STD PLAN F-40.12-03
2. INSTALL CEMENT CONCRETE PERPENDICULAR CURB RAMP PER WSDOT STD PLAN F-40.15-03
3. INSTALL CEMENT CONCRETE SINGLE DIRECTION CURB RAMP PER WSDOT STD. PLAN F-40.16-03
4. INSTALL CEMENT CONCRETE COMBINATION CURB RAMP PER WSDOT STD. PLAN F-40.14-03
5. INSTALL CEMENT CONCRETE PEDESTRIAN CURB PER WSDOT STD. PLAN F-10.12-03
6. INSTALL YELLOW DETECTABLE WARNING SURFACE PER WSDOT STD. PLAN F-45.10-02

GENERAL NOTES:

1. FOR CEMENT CONCRETE MIX DESIGN STRENGTH, SEE SPECIFICATIONS (TO BE PROVIDED POST 30% DESIGN).
2. STATIONS, OFFSETS, DIMENSIONS, AND HORIZONTAL CONTROL ARE TO FACE OF CURB UNLESS OTHERWISE NOTED.
3. ELEVATIONS ARE MEASURED AT FLOW LINE OF CURB AND GUTTER UNLESS OTHERWISE NOTED (TO BE PROVIDED POST 30% DESIGN).
4. ALL CURBS ARE 6 INCHES TALL UNLESS OTHERWISE NOTED.
5. SEE SHEETS 522-CRY201 - 522-CRY213 FOR TYPICAL ROADWAY SECTIONS
6. SEE SHEETS 522-CPP201 - 522-CPP220 FOR ROADWAY PAVING PLANS
7. SEE SHEETS 522-ASP201 - 522-ASX214 FOR ARCHITECTURAL STATION PLANS AND DETAILS


LEGEND:

 DETECTABLE WARNING SURFACE

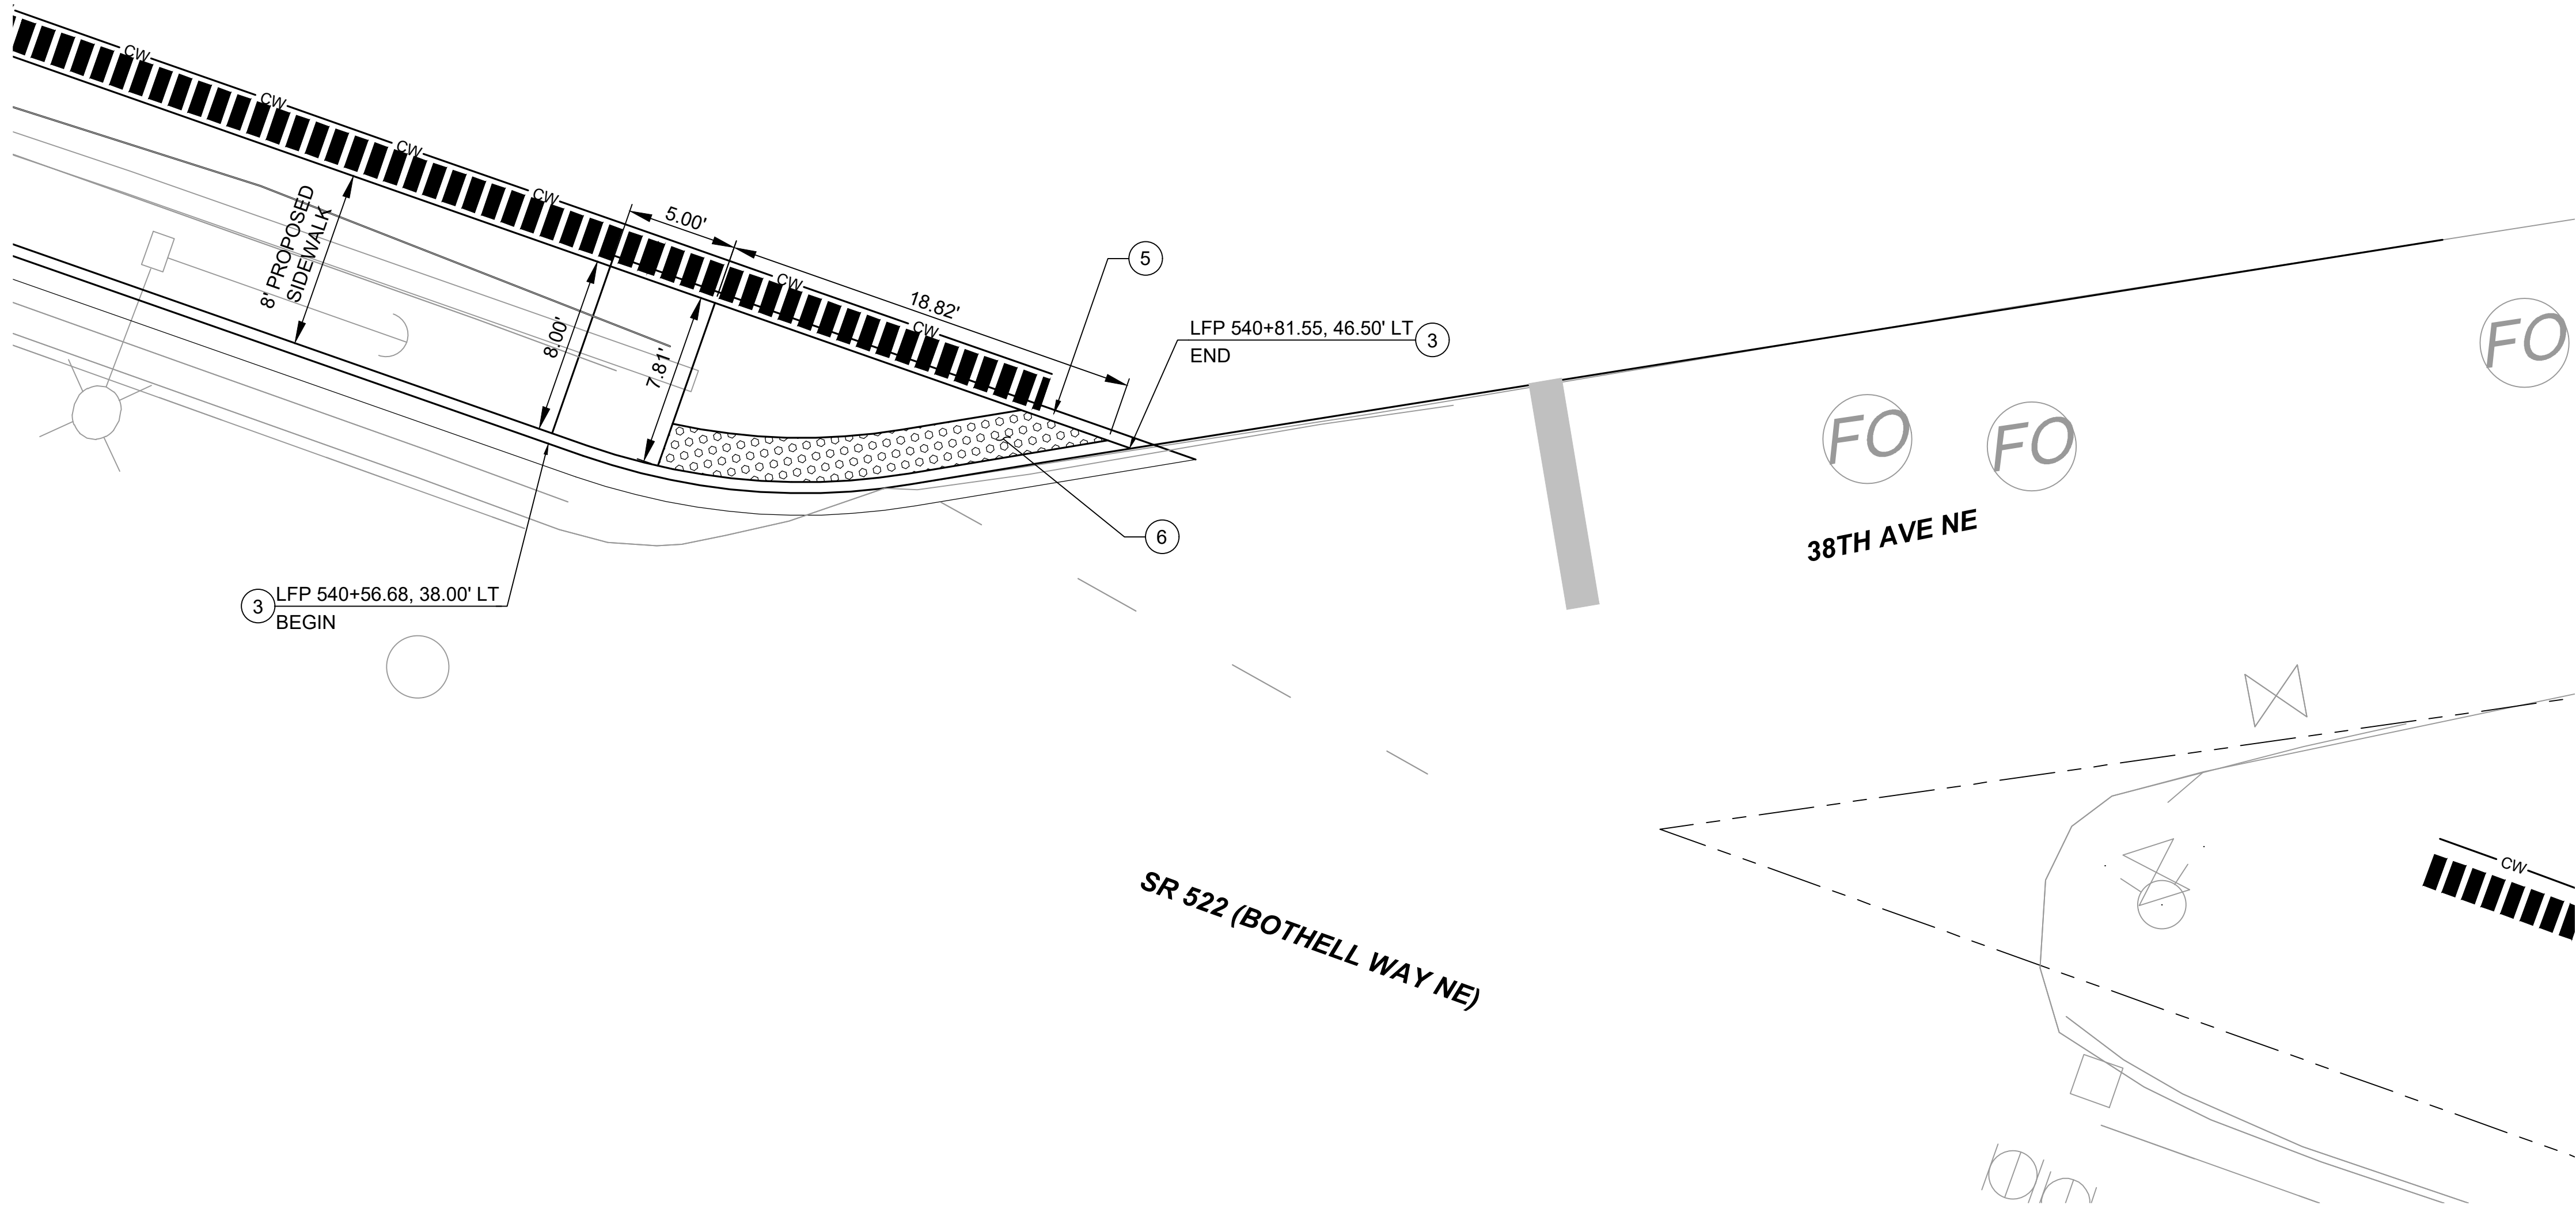

CURB RAMP DETAIL
SCALE: 1" = 5'

4
CPP208

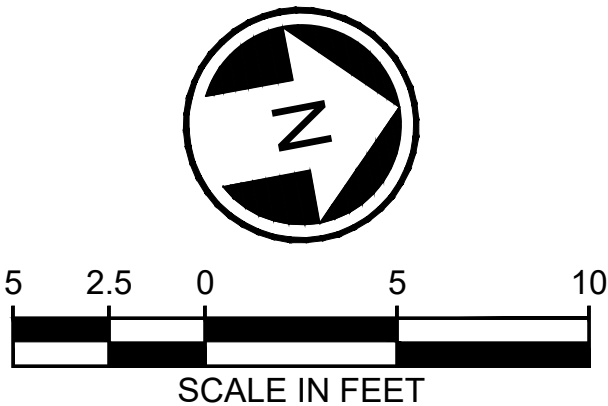

DRAFT 30% SUBMITTAL

No.	DATE	DSN	CHK	APP	REVISION

DESIGNED BY:
C. MATYAS
DRAWN BY:
J. JACKSON
CHECKED BY:
R. KOESTER
APPROVED BY:
M. FELIBERTI



DAVID EVANS
AND ASSOCIATES INC.
14432 SE Eastgate Way, Suite 400
Bellevue Washington 98007
Phone: 425.519.6500

SUBMITTED BY:
D.SCHOCK

DATE:
09/11/2020

REVIEWED BY:
B.KEMPER

LINE IS 1" AT
FULL SCALE




DATE:
09/11/2020

SCALE:
1"=5'
FILENAME:
BRT-522-CRD201-208
CONTRACT No.:
AE 0055-17
DATE:
09/11/2020

SR 522 / NE 145TH BRT
SR 522 (BOTHELL WAY NE)
CIVIL
CURB RAMP PLAN AND DETAILS
SR 522 (BOTHELL WAY NE) & 38TH AVE NE

DRAWING No.:
522-CRD204
FACILITY ID:
522
SHEET No.:
158 OF 283
REV:

09/10/20 | 10:44 AM | APDC
C:\PW\WORK\DEA\APRIL COLEMAN\DWG\BRT-522-CRD201-208.DWG

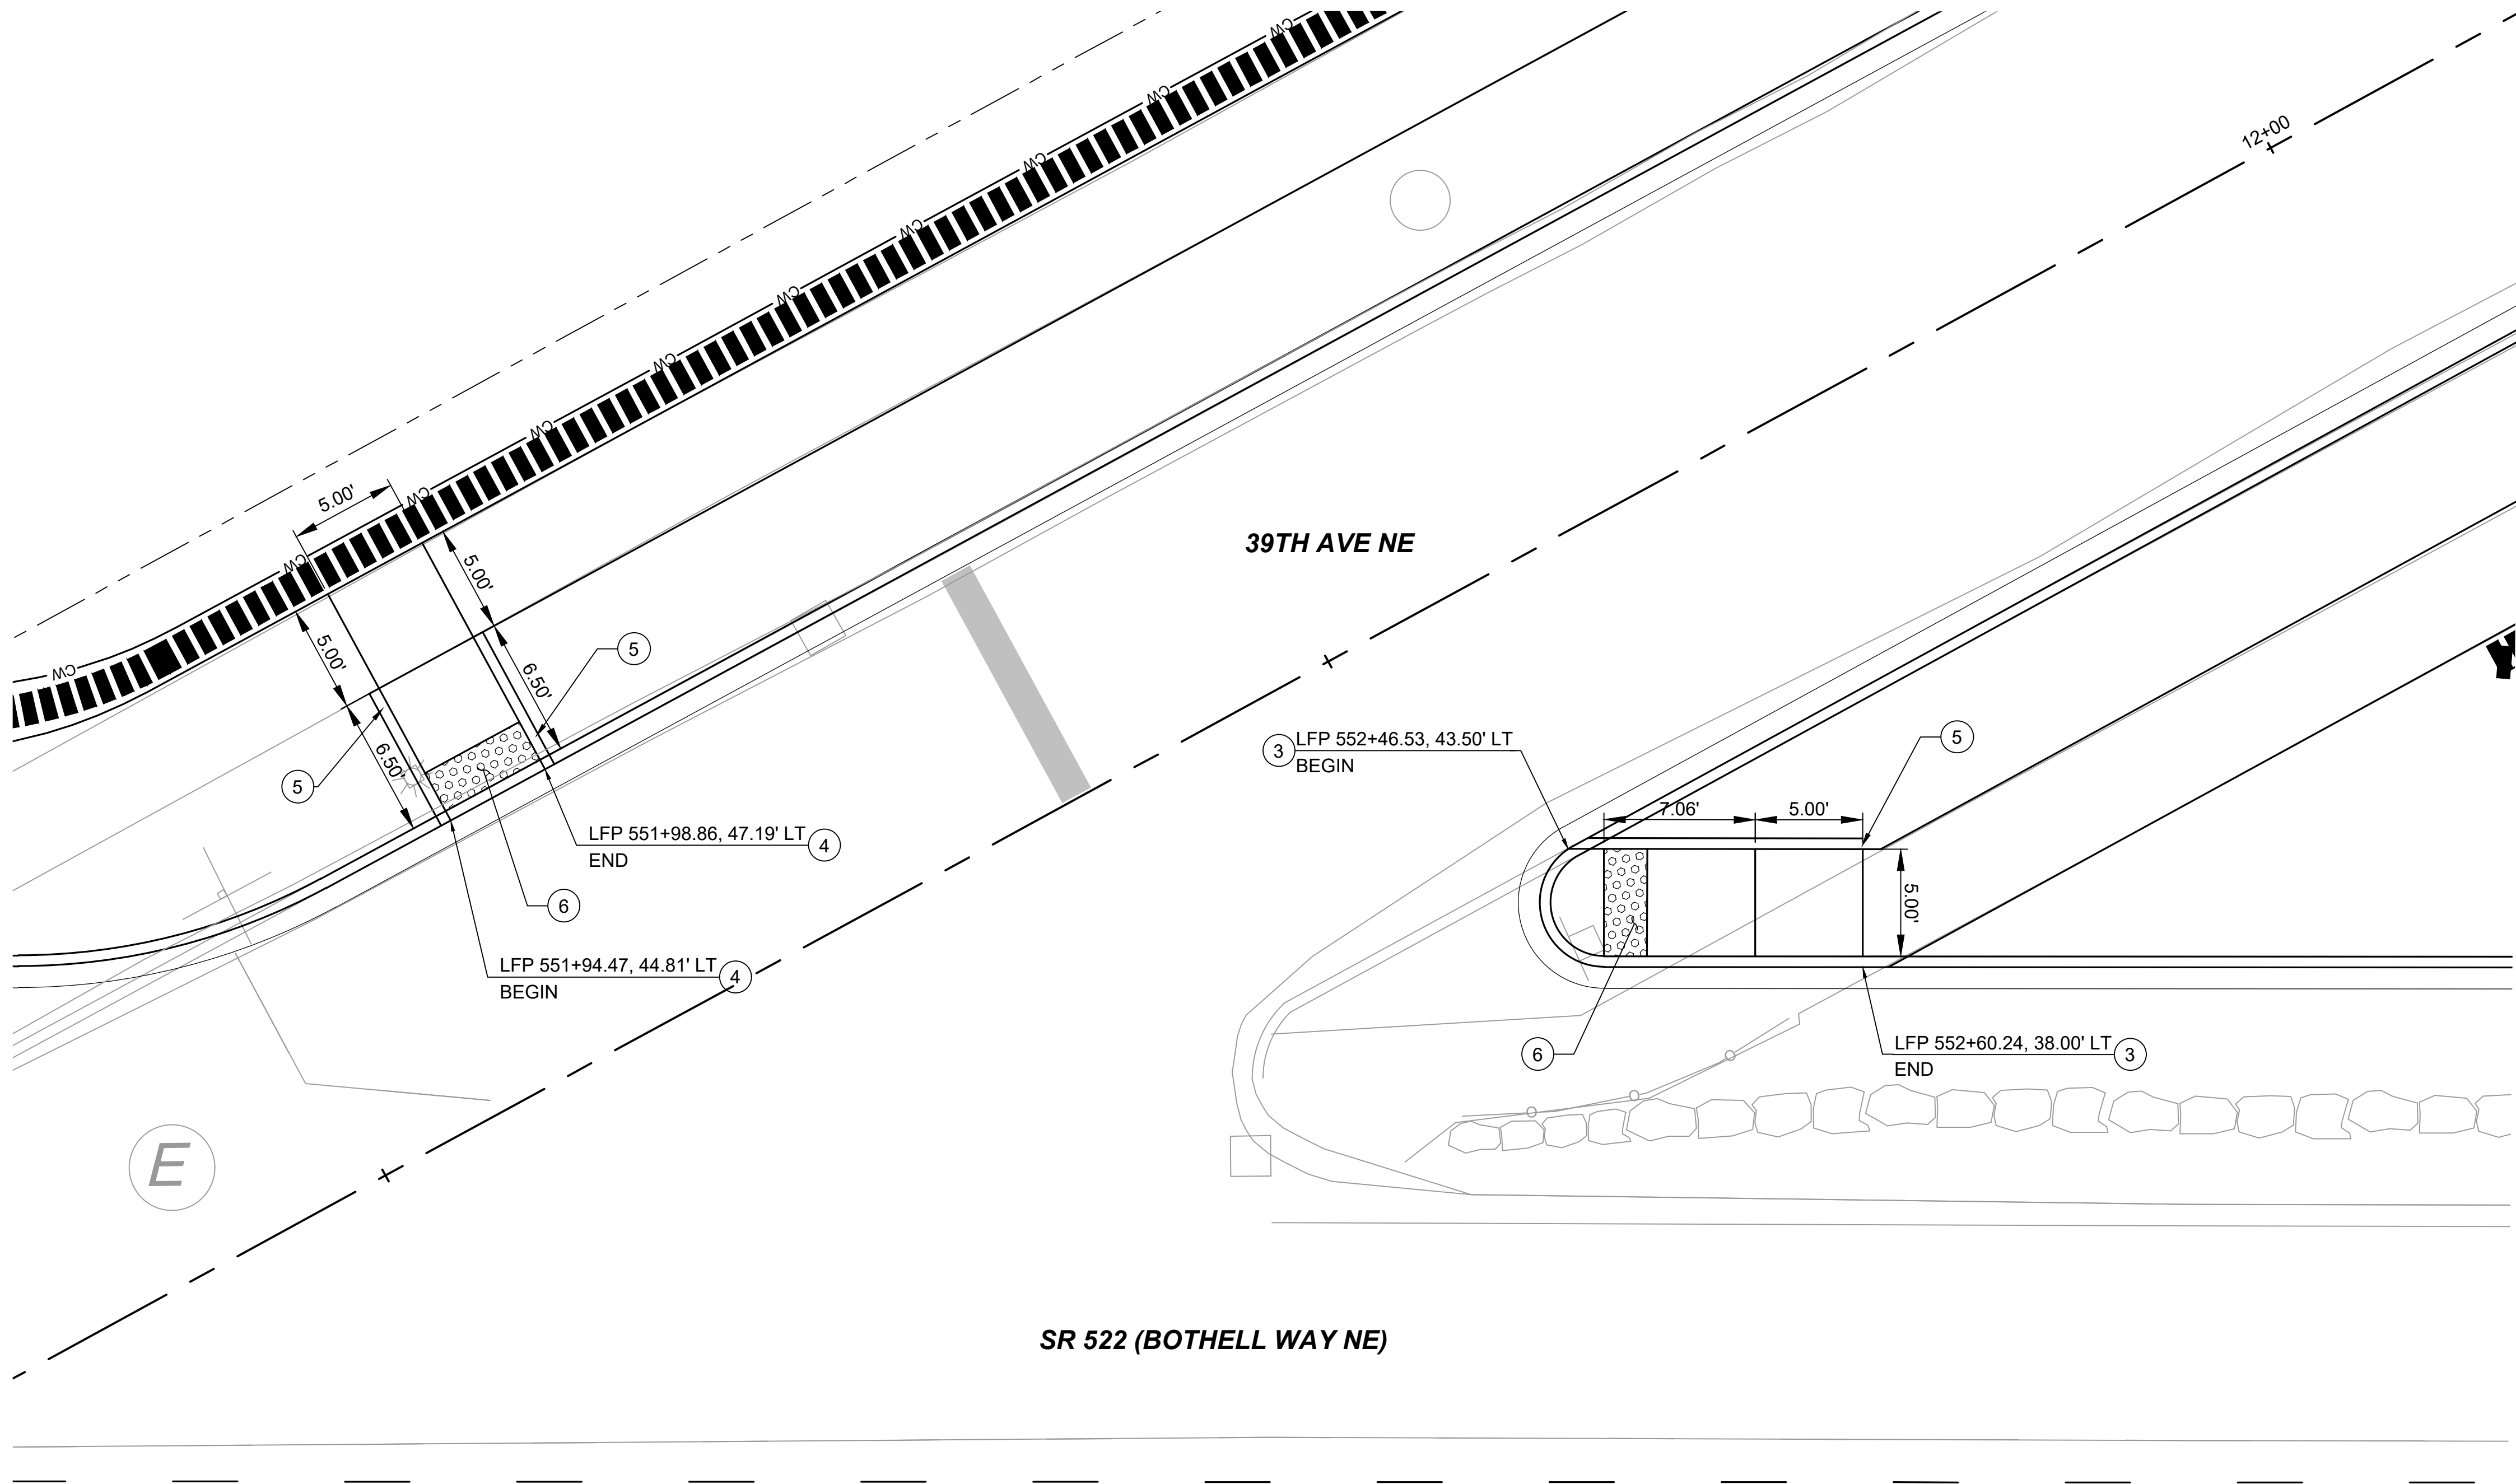


CONSTRUCTION NOTES:

1. INSTALL CEMENT CONCRETE PARALLEL TYPE A CURB RAMP PER WSDOT STD PLAN F-40.12-03
2. INSTALL CEMENT CONCRETE PERPENDICULAR CURB RAMP PER WSDOT STD PLAN F-40.15-03
3. INSTALL CEMENT CONCRETE SINGLE DIRECTION CURB RAMP PER WSDOT STD. PLAN F-40.16-03
4. INSTALL CEMENT CONCRETE COMBINATION CURB RAMP PER WSDOT STD. PLAN F-40.14-03
5. INSTALL CEMENT CONCRETE PEDESTRIAN CURB PER WSDOT STD. PLAN F-10.12-03
6. INSTALL YELLOW DETECTABLE WARNING SURFACE PER WSDOT STD. PLAN F-45.10-02

GENERAL NOTES:


1. FOR CEMENT CONCRETE MIX DESIGN STRENGTH, SEE SPECIFICATIONS (TO BE PROVIDED POST 30% DESIGN).
2. STATIONS, OFFSETS, DIMENSIONS, AND HORIZONTAL CONTROL ARE TO FACE OF CURB UNLESS OTHERWISE NOTED.
3. ELEVATIONS ARE MEASURED AT FLOW LINE OF CURB AND GUTTER UNLESS OTHERWISE NOTED (TO BE PROVIDED POST 30% DESIGN).
4. ALL CURBS ARE 6 INCHES TALL UNLESS OTHERWISE NOTED.
5. SEE SHEETS 522-CRY201 - 522-CRY213 FOR TYPICAL ROADWAY SECTIONS
6. SEE SHEETS 522-CPP201 - 522-CPP220 FOR ROADWAY PAVING PLANS
7. SEE SHEETS 522-ASP201 - 522-ASX214 FOR ARCHITECTURAL STATION PLANS AND DETAILS

 LEGEND:

 DETECTABLE WARNING SURFACE


CURB RAMP DETAIL
SCALE: 1" = 5'

5
CPP211

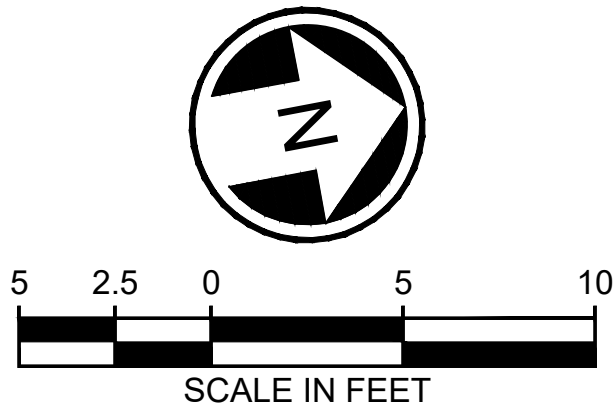

DRAFT 30% SUBMITTAL							DESIGNED BY: C. MATYAS		 DAVID EVANS AND ASSOCIATES INC. 14432 SE Eastgate Way, Suite 400 Bellevue Washington 98007 Phone: 425.519.6500			 SOUND TRANSIT	SCALE: 1"=5'	SR 522 / NE 145TH BRT SR 522 (BOTHELL WAY NE) CIVIL CURB RAMP PLAN AND DETAILS SR 522 (BOTHELL WAY NE) & 39TH AVE NE		DRAWING No.: 522-CRD205
							DRAWN BY: J. JACKSON						FILENAME: BRT-522-CRD201-208			FACILITY ID: 522
							CHECKED BY: R. KOESTER						CONTRACT No.: AE 0055-17			SHEET No.: 159 OF 283
							APPROVED BY: M. FELIBERTI						DATE: 09/11/2020			REV:
No.	DATE	DSN	CHK	APP	REVISION				SUBMITTED BY: D.SCHOCK	DATE: 09/11/2020	REVIEWED BY: B.KEMPER	DATE: 09/11/2020	DATE: 09/11/2020			

09/10/20 | 10:45 AM | APDC
C:\PW_WORK\DEA\APRIL COLEMAN\DWG\SR 522-CRD201-208.DWG

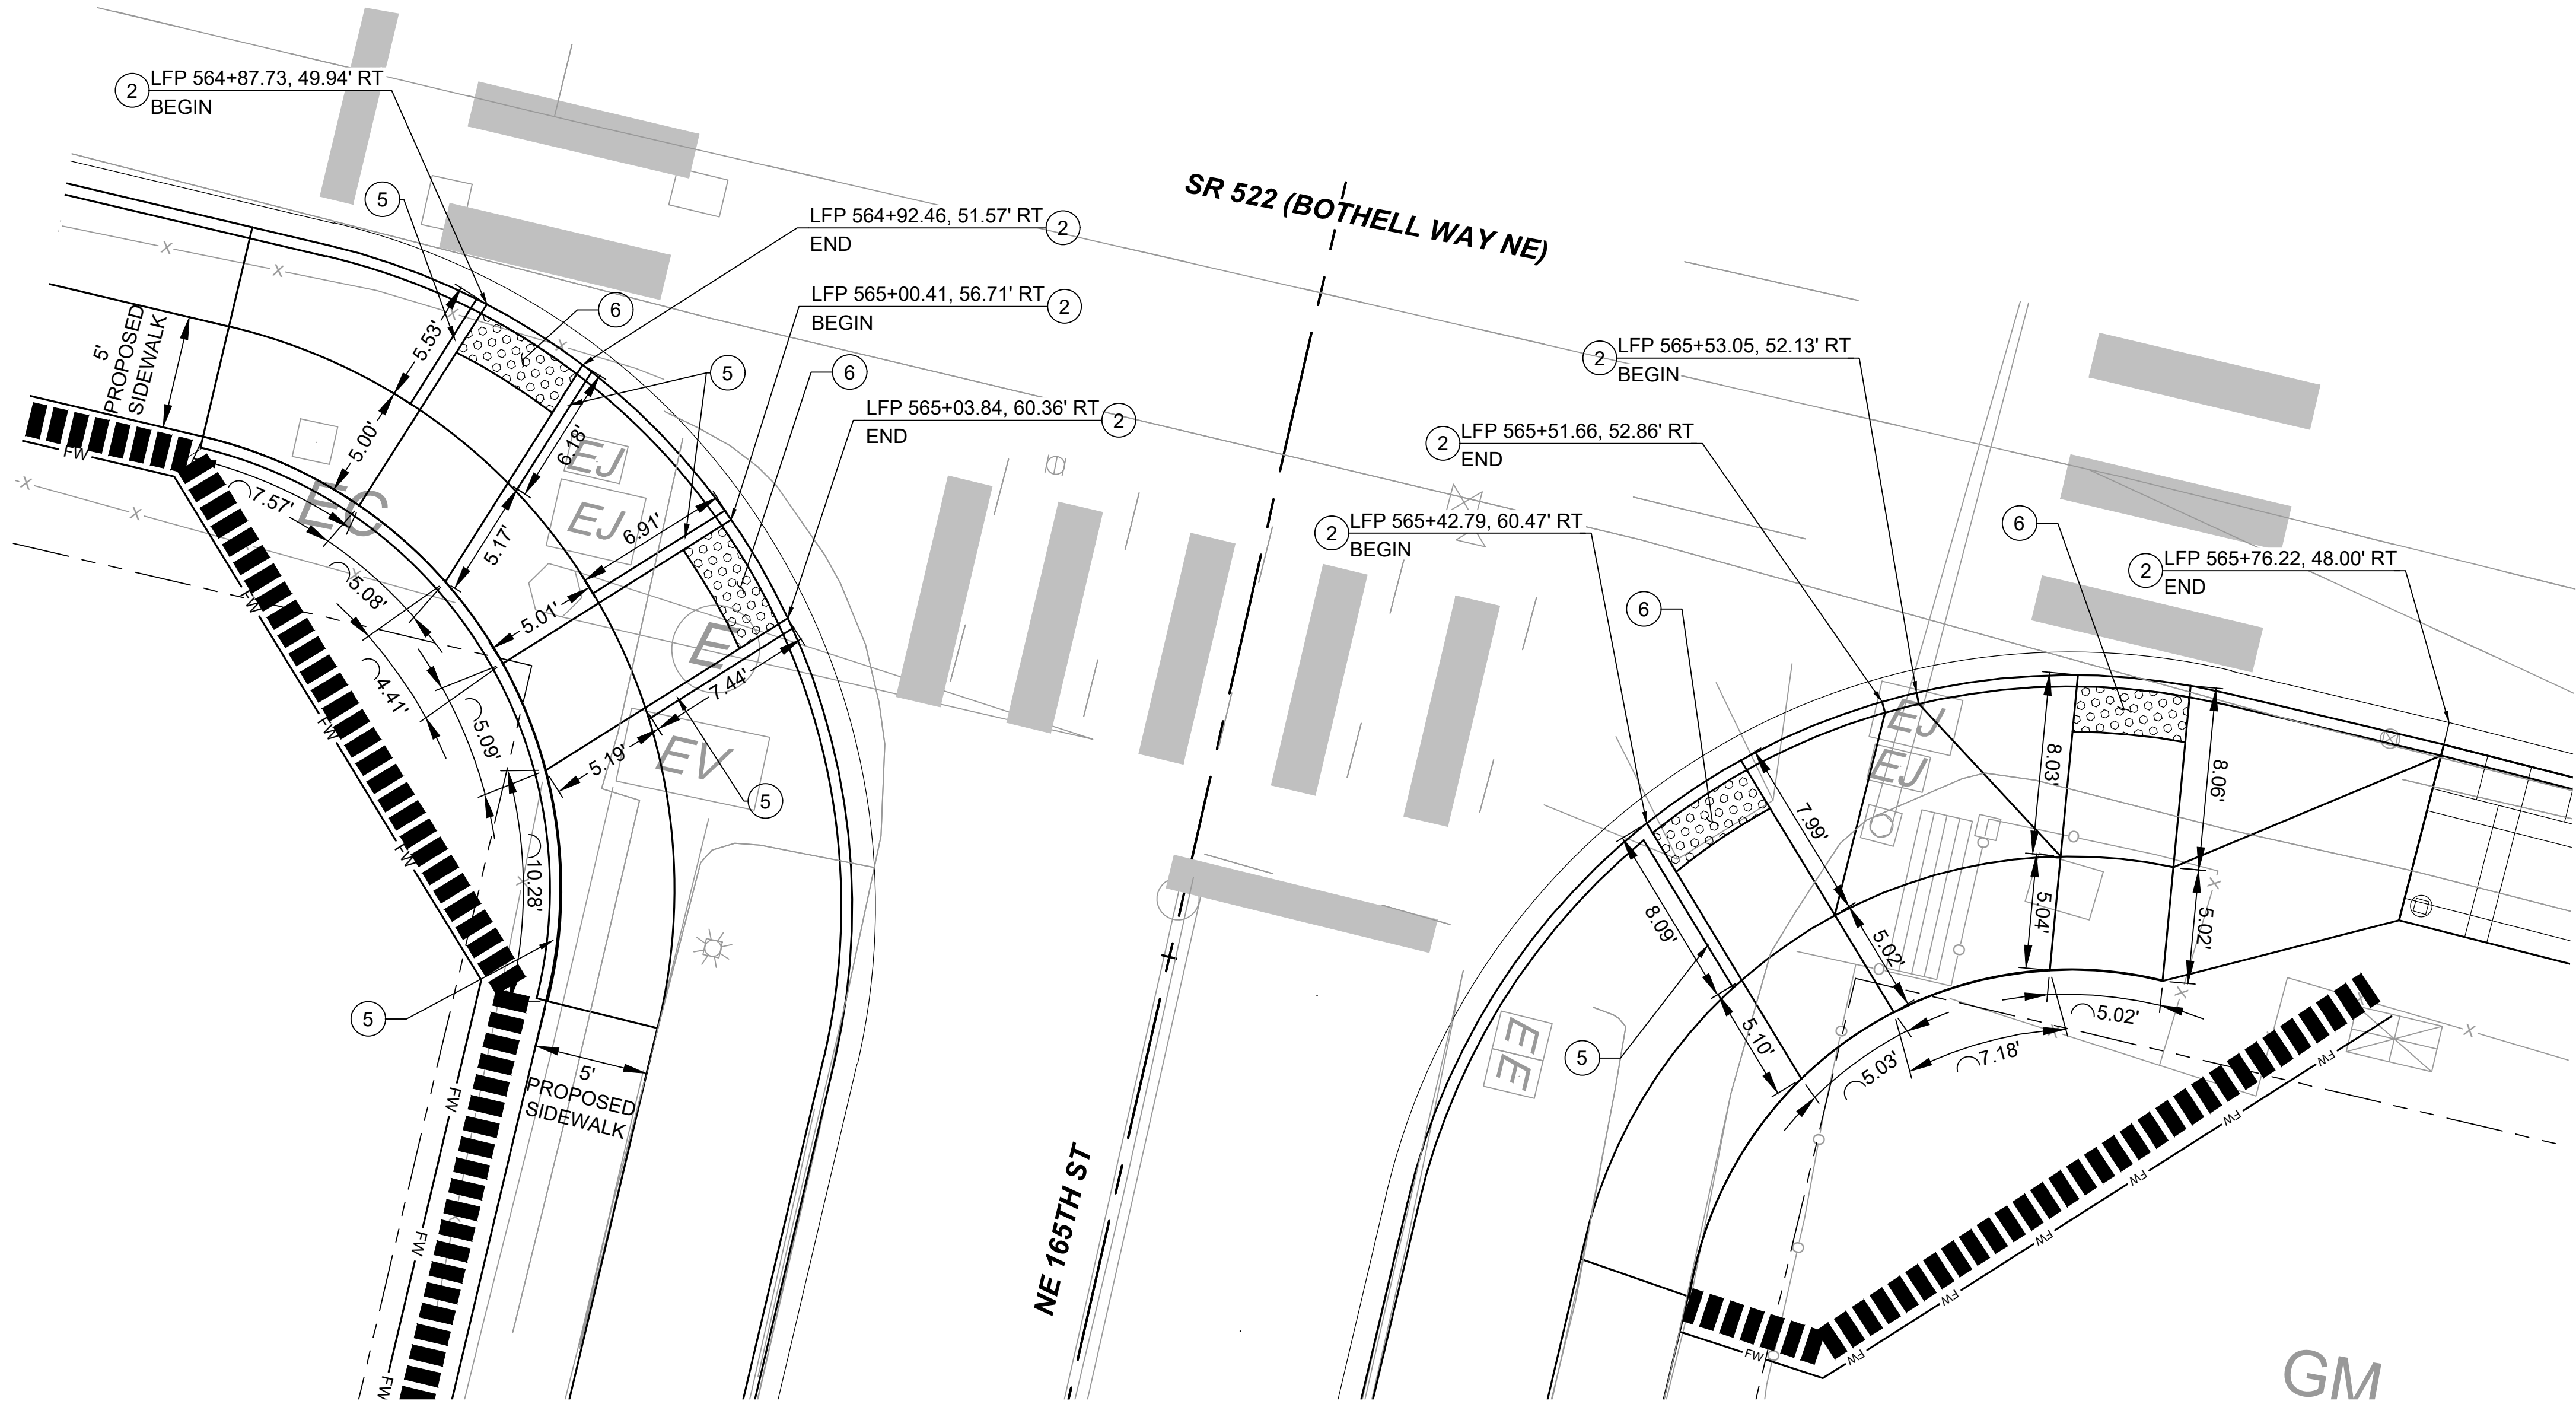

CURB RAMP DETAIL
SCALE: 1" = 5'

6
CPP214

 
CONSTRUCTION NOTES:

1. INSTALL CEMENT CONCRETE PARALLEL TYPE A CURB RAMP PER WSDOT STD PLAN F-40.12-03
2. INSTALL CEMENT CONCRETE PERPENDICULAR CURB RAMP PER WSDOT STD PLAN F-40.15-03
3. INSTALL CEMENT CONCRETE SINGLE DIRECTION CURB RAMP PER WSDOT STD. PLAN F-40.16-03
4. INSTALL CEMENT CONCRETE COMBINATION CURB RAMP PER WSDOT STD. PLAN F-40.14-03
5. INSTALL CEMENT CONCRETE PEDESTRIAN CURB PER WSDOT STD. PLAN F-10.12-03
6. INSTALL YELLOW DETECTABLE WARNING SURFACE PER WSDOT STD. PLAN F-45.10-02


GENERAL NOTES:

1. FOR CEMENT CONCRETE MIX DESIGN STRENGTH, SEE SPECIFICATIONS (TO BE PROVIDED POST 30% DESIGN).
2. STATIONS, OFFSETS, DIMENSIONS, AND HORIZONTAL CONTROL ARE TO FACE OF CURB UNLESS OTHERWISE NOTED.
3. ELEVATIONS ARE MEASURED AT FLOW LINE OF CURB AND GUTTER UNLESS OTHERWISE NOTED (TO BE PROVIDED POST 30% DESIGN).
4. ALL CURBS ARE 6 INCHES TALL UNLESS OTHERWISE NOTED.
5. SEE SHEETS 522-CRY201 - 522-CRY213 FOR TYPICAL ROADWAY SECTIONS
6. SEE SHEETS 522-CPP201 - 522-CPP220 FOR ROADWAY PAVING PLANS
7. SEE SHEETS 522-ASP201 - 522-ASX214 FOR ARCHITECTURAL STATION PLANS AND DETAILS

LEGEND:



DETECTABLE WARNING SURFACE

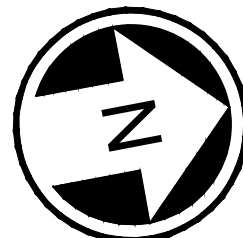

DRAFT 30% SUBMITTAL

No.	DATE	DSN	CHK	APP	REVISION

DESIGNED BY:
C. MATYAS
DRAWN BY:
J. JACKSON
CHECKED BY:
R. KOESTER
APPROVED BY:
M. FELIBERTI



**DAVID EVANS
AND ASSOCIATES INC.**
14432 SE Eastgate Way, Suite 400
Bellevue Washington 98007
Phone: 425.519.6500

SUBMITTED BY:
D.SCHOCK

DATE:
09/11/2020

REVIEWED BY:
B.KEMPER




DATE:
09/11/2020

SCALE:
1"=5'
FILENAME:
BRT-522-CRD201-208
CONTRACT No.:
AE 0055-17
DATE:
09/11/2020

SR 522 / NE 145TH BRT
SR 522 (BOTHELL WAY NE)
CIVIL
CURB RAMP PLAN AND DETAILS
SR 522 (BOTHELL WAY NE) & NE 165TH ST

DRAWING No.:
522-CRD206
FACILITY ID:
522
SHEET No.:
160 OF 283
REV:

09/10/20 | 10:45 AM | APDC
C:\PW\WORK\DEA\APRIL COLEMAN\DWG\SR522\522-CRD201-208.DWG

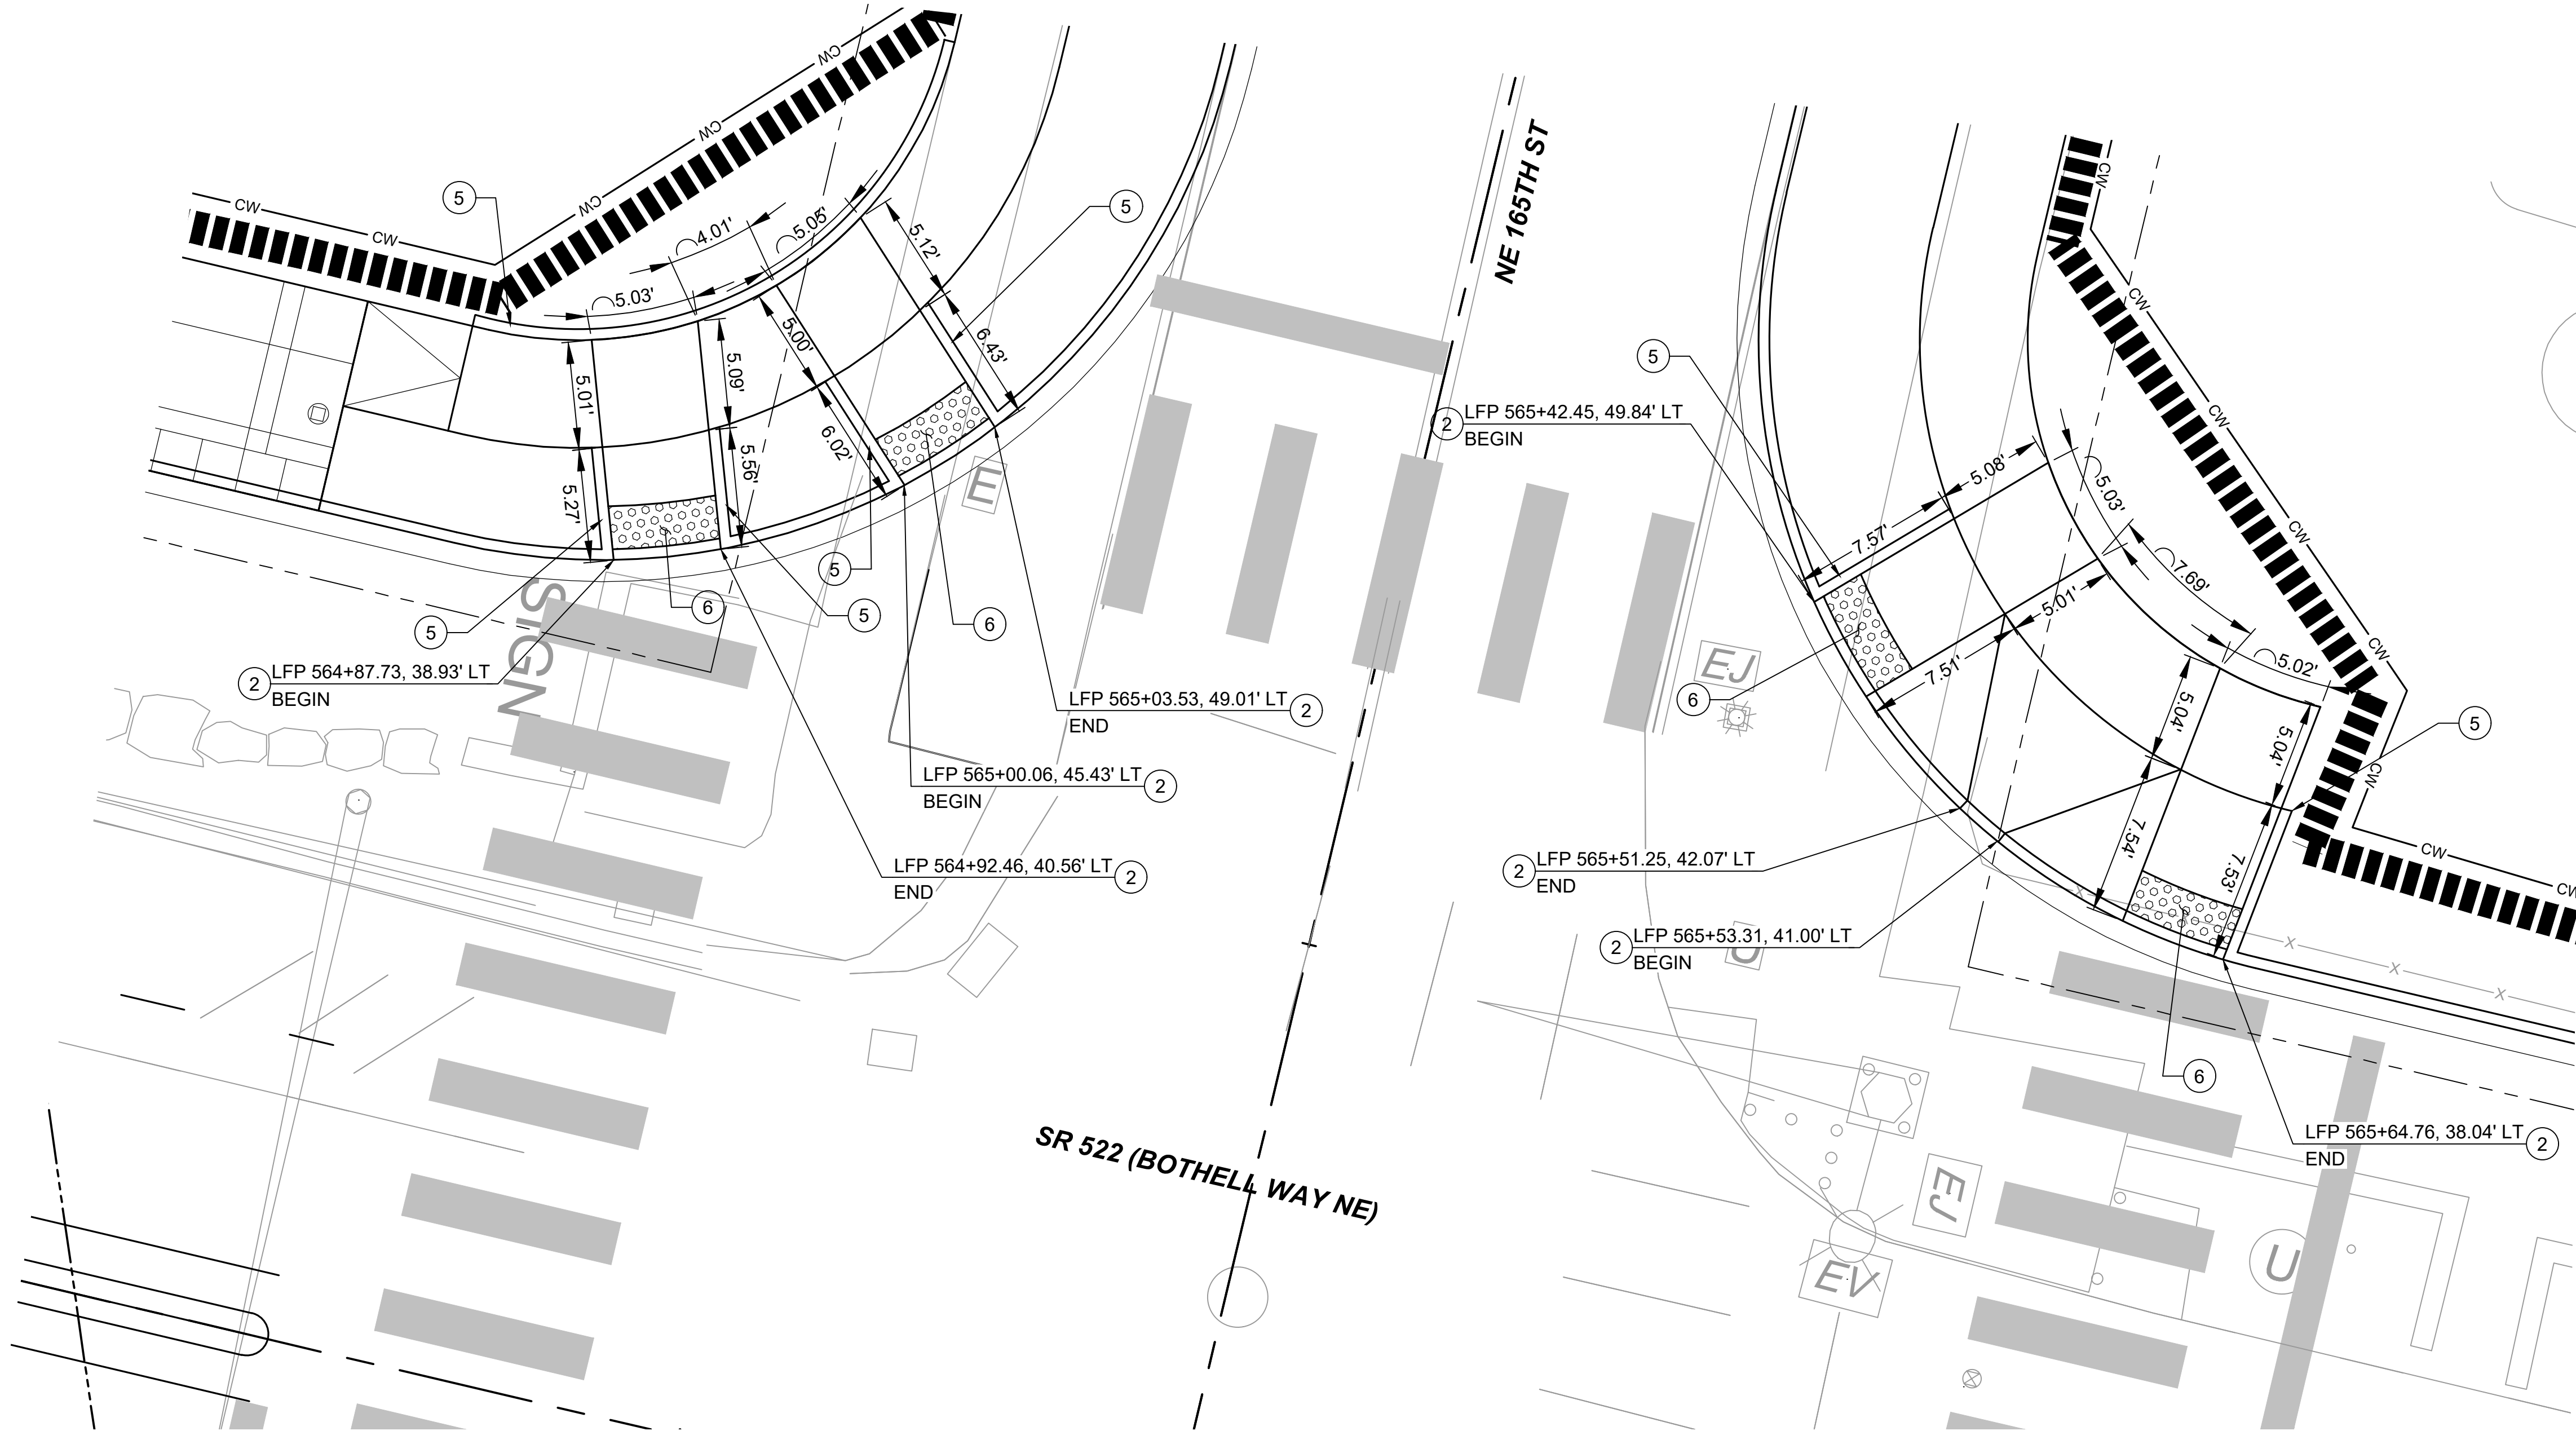

CURB RAMP DETAIL
SCALE: 1" = 5'

7
CPP214

 
CONSTRUCTION NOTES:

1. INSTALL CEMENT CONCRETE PARALLEL TYPE A CURB RAMP PER WSDOT STD PLAN F-40.12-03
2. INSTALL CEMENT CONCRETE PERPENDICULAR CURB RAMP PER WSDOT STD PLAN F-40.15-03
3. INSTALL CEMENT CONCRETE SINGLE DIRECTION CURB RAMP PER WSDOT STD. PLAN F-40.16-03
4. INSTALL CEMENT CONCRETE COMBINATION CURB RAMP PER WSDOT STD. PLAN F-40.14-03
5. INSTALL CEMENT CONCRETE PEDESTRIAN CURB PER WSDOT STD. PLAN F-10.12-03
6. INSTALL YELLOW DETECTABLE WARNING SURFACE PER WSDOT STD. PLAN F-45.10-02


GENERAL NOTES:

1. FOR CEMENT CONCRETE MIX DESIGN STRENGTH, SEE SPECIFICATIONS (TO BE PROVIDED POST 30% DESIGN).
2. STATIONS, OFFSETS, DIMENSIONS, AND HORIZONTAL CONTROL ARE TO FACE OF CURB UNLESS OTHERWISE NOTED.
3. ELEVATIONS ARE MEASURED AT FLOW LINE OF CURB AND GUTTER UNLESS OTHERWISE NOTED (TO BE PROVIDED POST 30% DESIGN).
4. ALL CURBS ARE 6 INCHES TALL UNLESS OTHERWISE NOTED.
5. SEE SHEETS 522-CRY201 - 522-CRY213 FOR TYPICAL ROADWAY SECTIONS
6. SEE SHEETS 522-CPP201 - 522-CPP220 FOR ROADWAY PAVING PLANS
7. SEE SHEETS 522-ASP201 - 522-ASX214 FOR ARCHITECTURAL STATION PLANS AND DETAILS

LEGEND:



DETECTABLE WARNING SURFACE

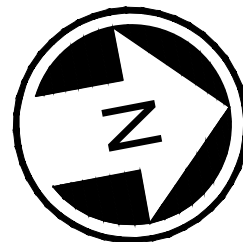

DRAFT 30% SUBMITTAL

No.	DATE	DSN	CHK	APP	REVISION

DESIGNED BY:
C. MATYAS
DRAWN BY:
J. JACKSON
CHECKED BY:
R. KOESTER
APPROVED BY:
M. FELIBERTI



**DAVID EVANS
AND ASSOCIATES INC.**
14432 SE Eastgate Way, Suite 400
Bellevue Washington 98007
Phone: 425.519.6500

SUBMITTED BY:
D.SCHOCK

DATE:
09/11/2020

REVIEWED BY:
B.KEMPER




DATE:
09/11/2020

SCALE:
1"=5'
FILENAME:
BRT-522-CRD201-208
CONTRACT No.:
AE 0055-17
DATE:
09/11/2020


SR 522 / NE 145TH BRT
SR 522 (BOTHELL WAY NE)
CIVIL
CURB RAMP PLAN AND DETAILS
SR 522 (BOTHELL WAY NE) & NE 165TH ST

DRAWING No.:
522-CRD207
FACILITY ID:
522
SHEET No.:
161 OF 283
REV:

09/10/20 | 10:46 AM | APDC
C:\PW_WORK\DEA\APRIL COLEMAN\DWG\SR 522-CRD201-208.DWG

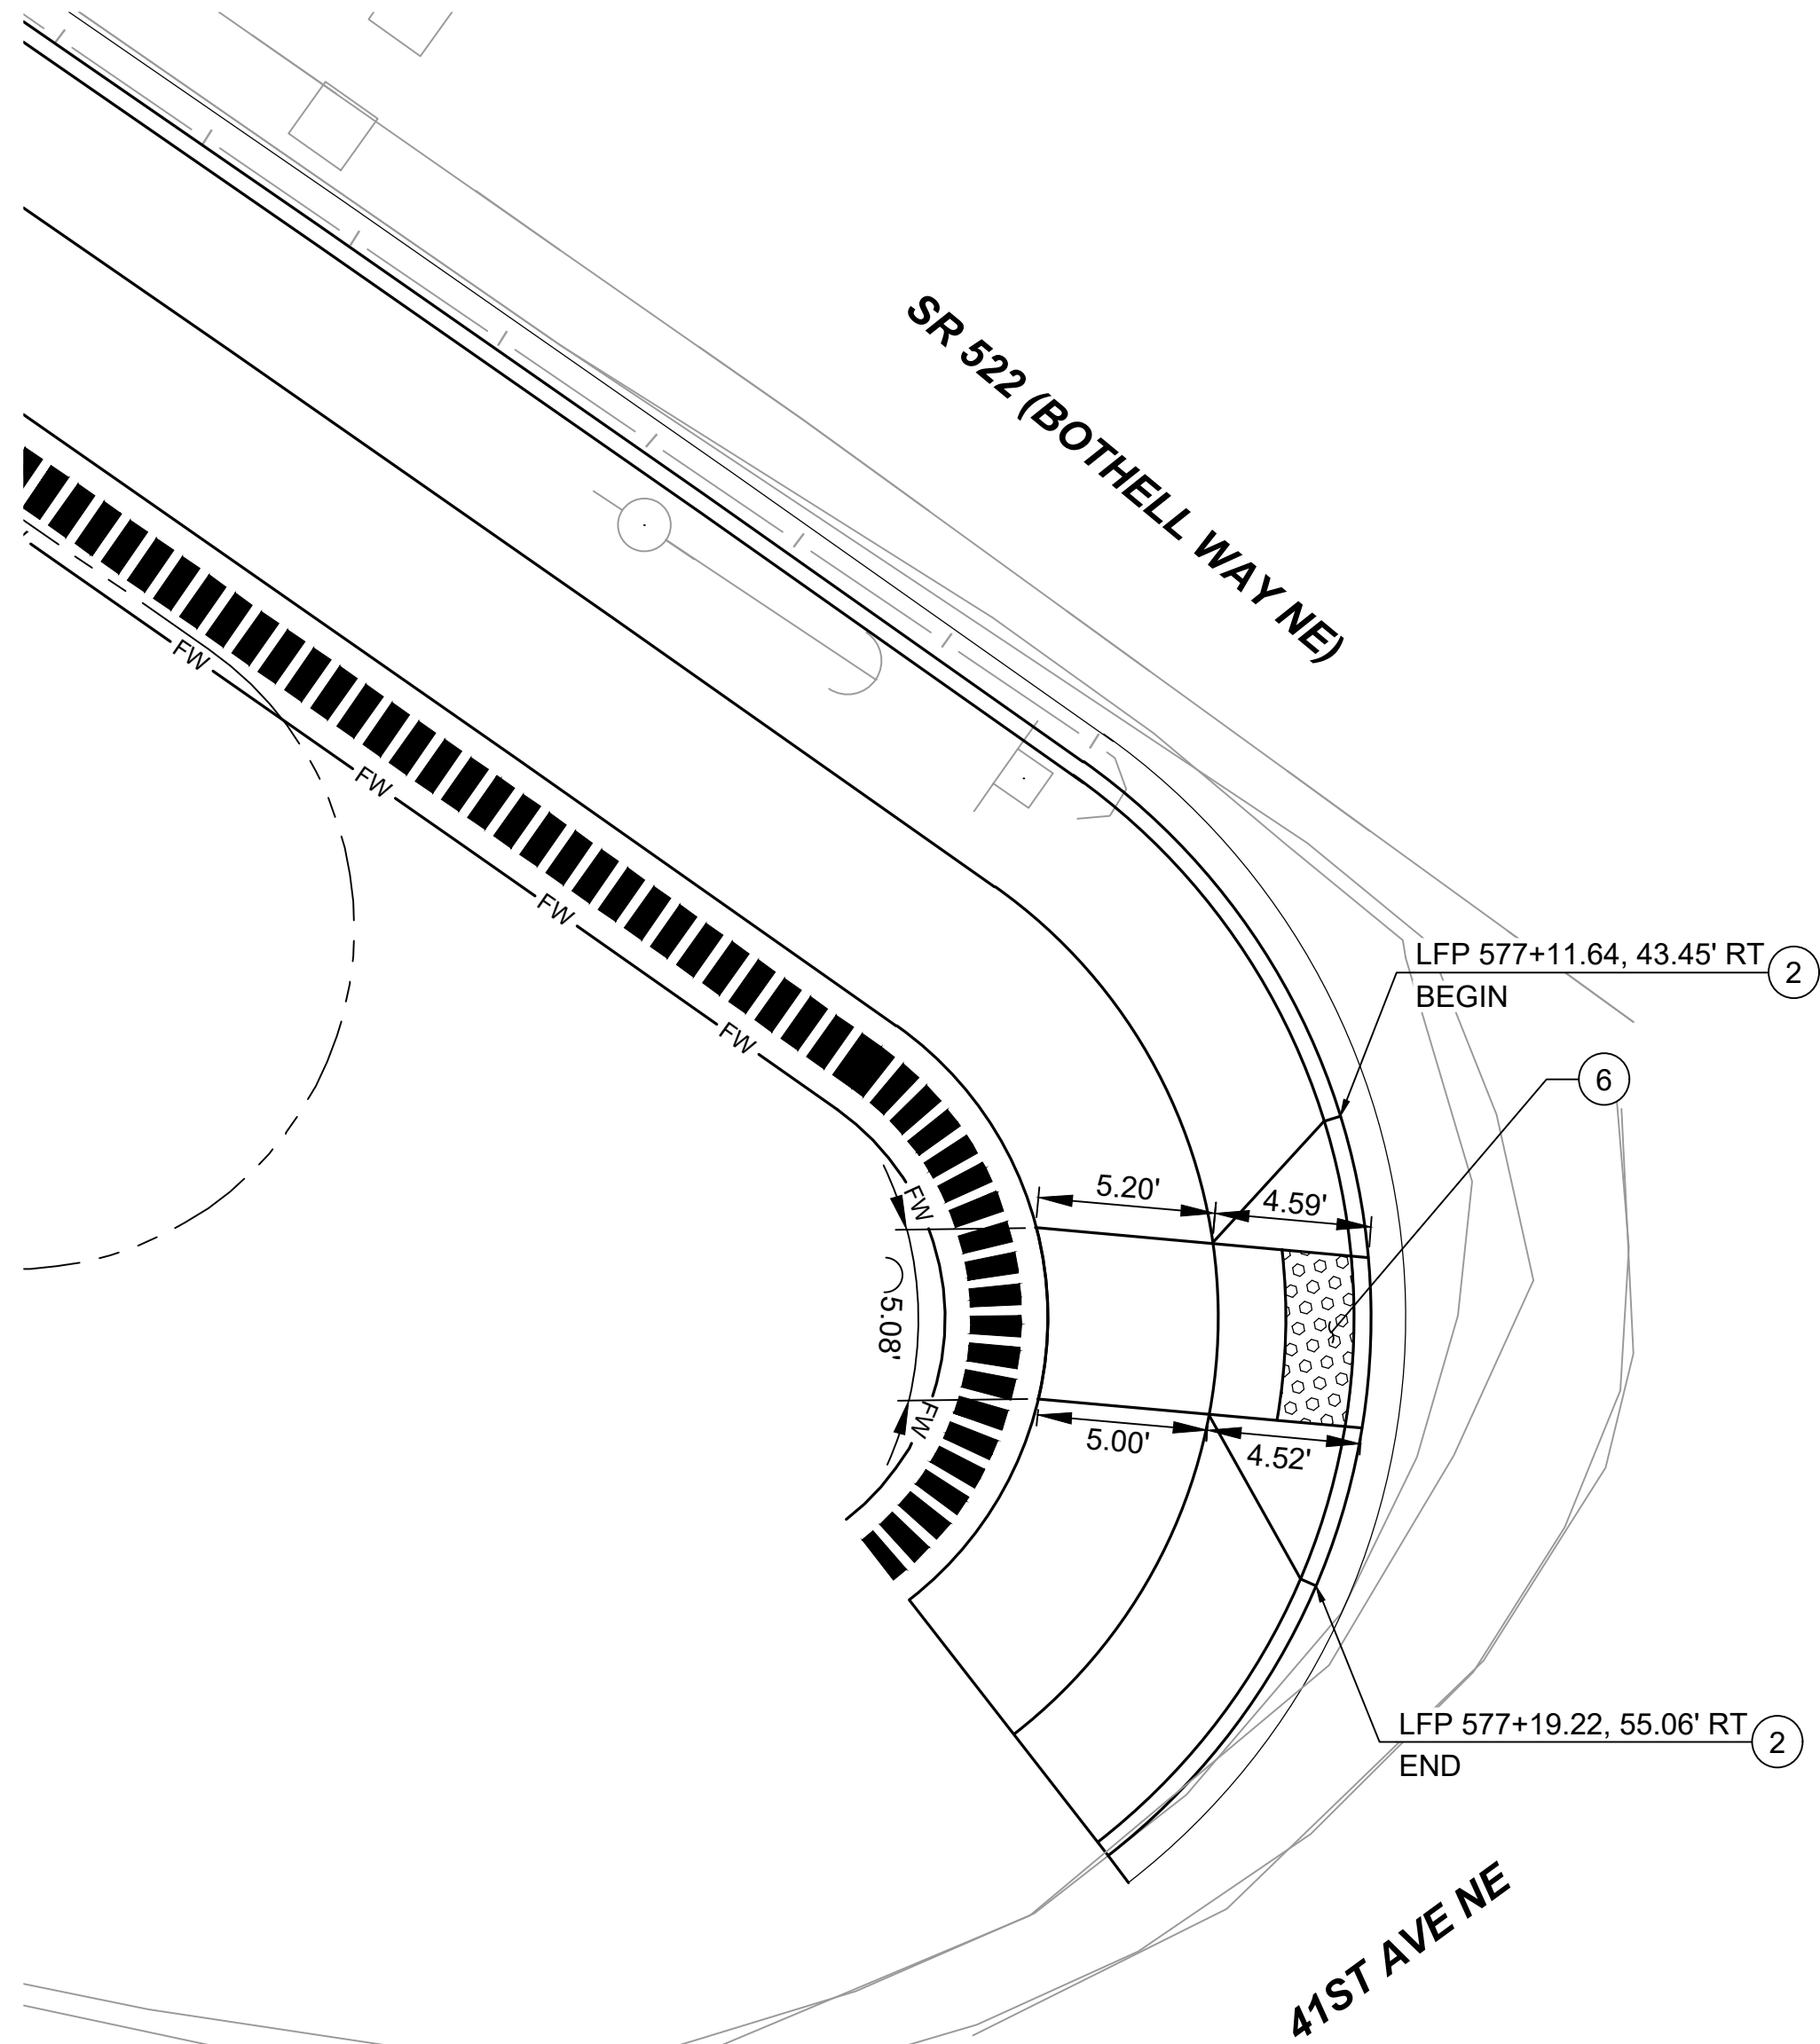


CURB RAMP DETAIL 8
SCALE: 1" = 5'

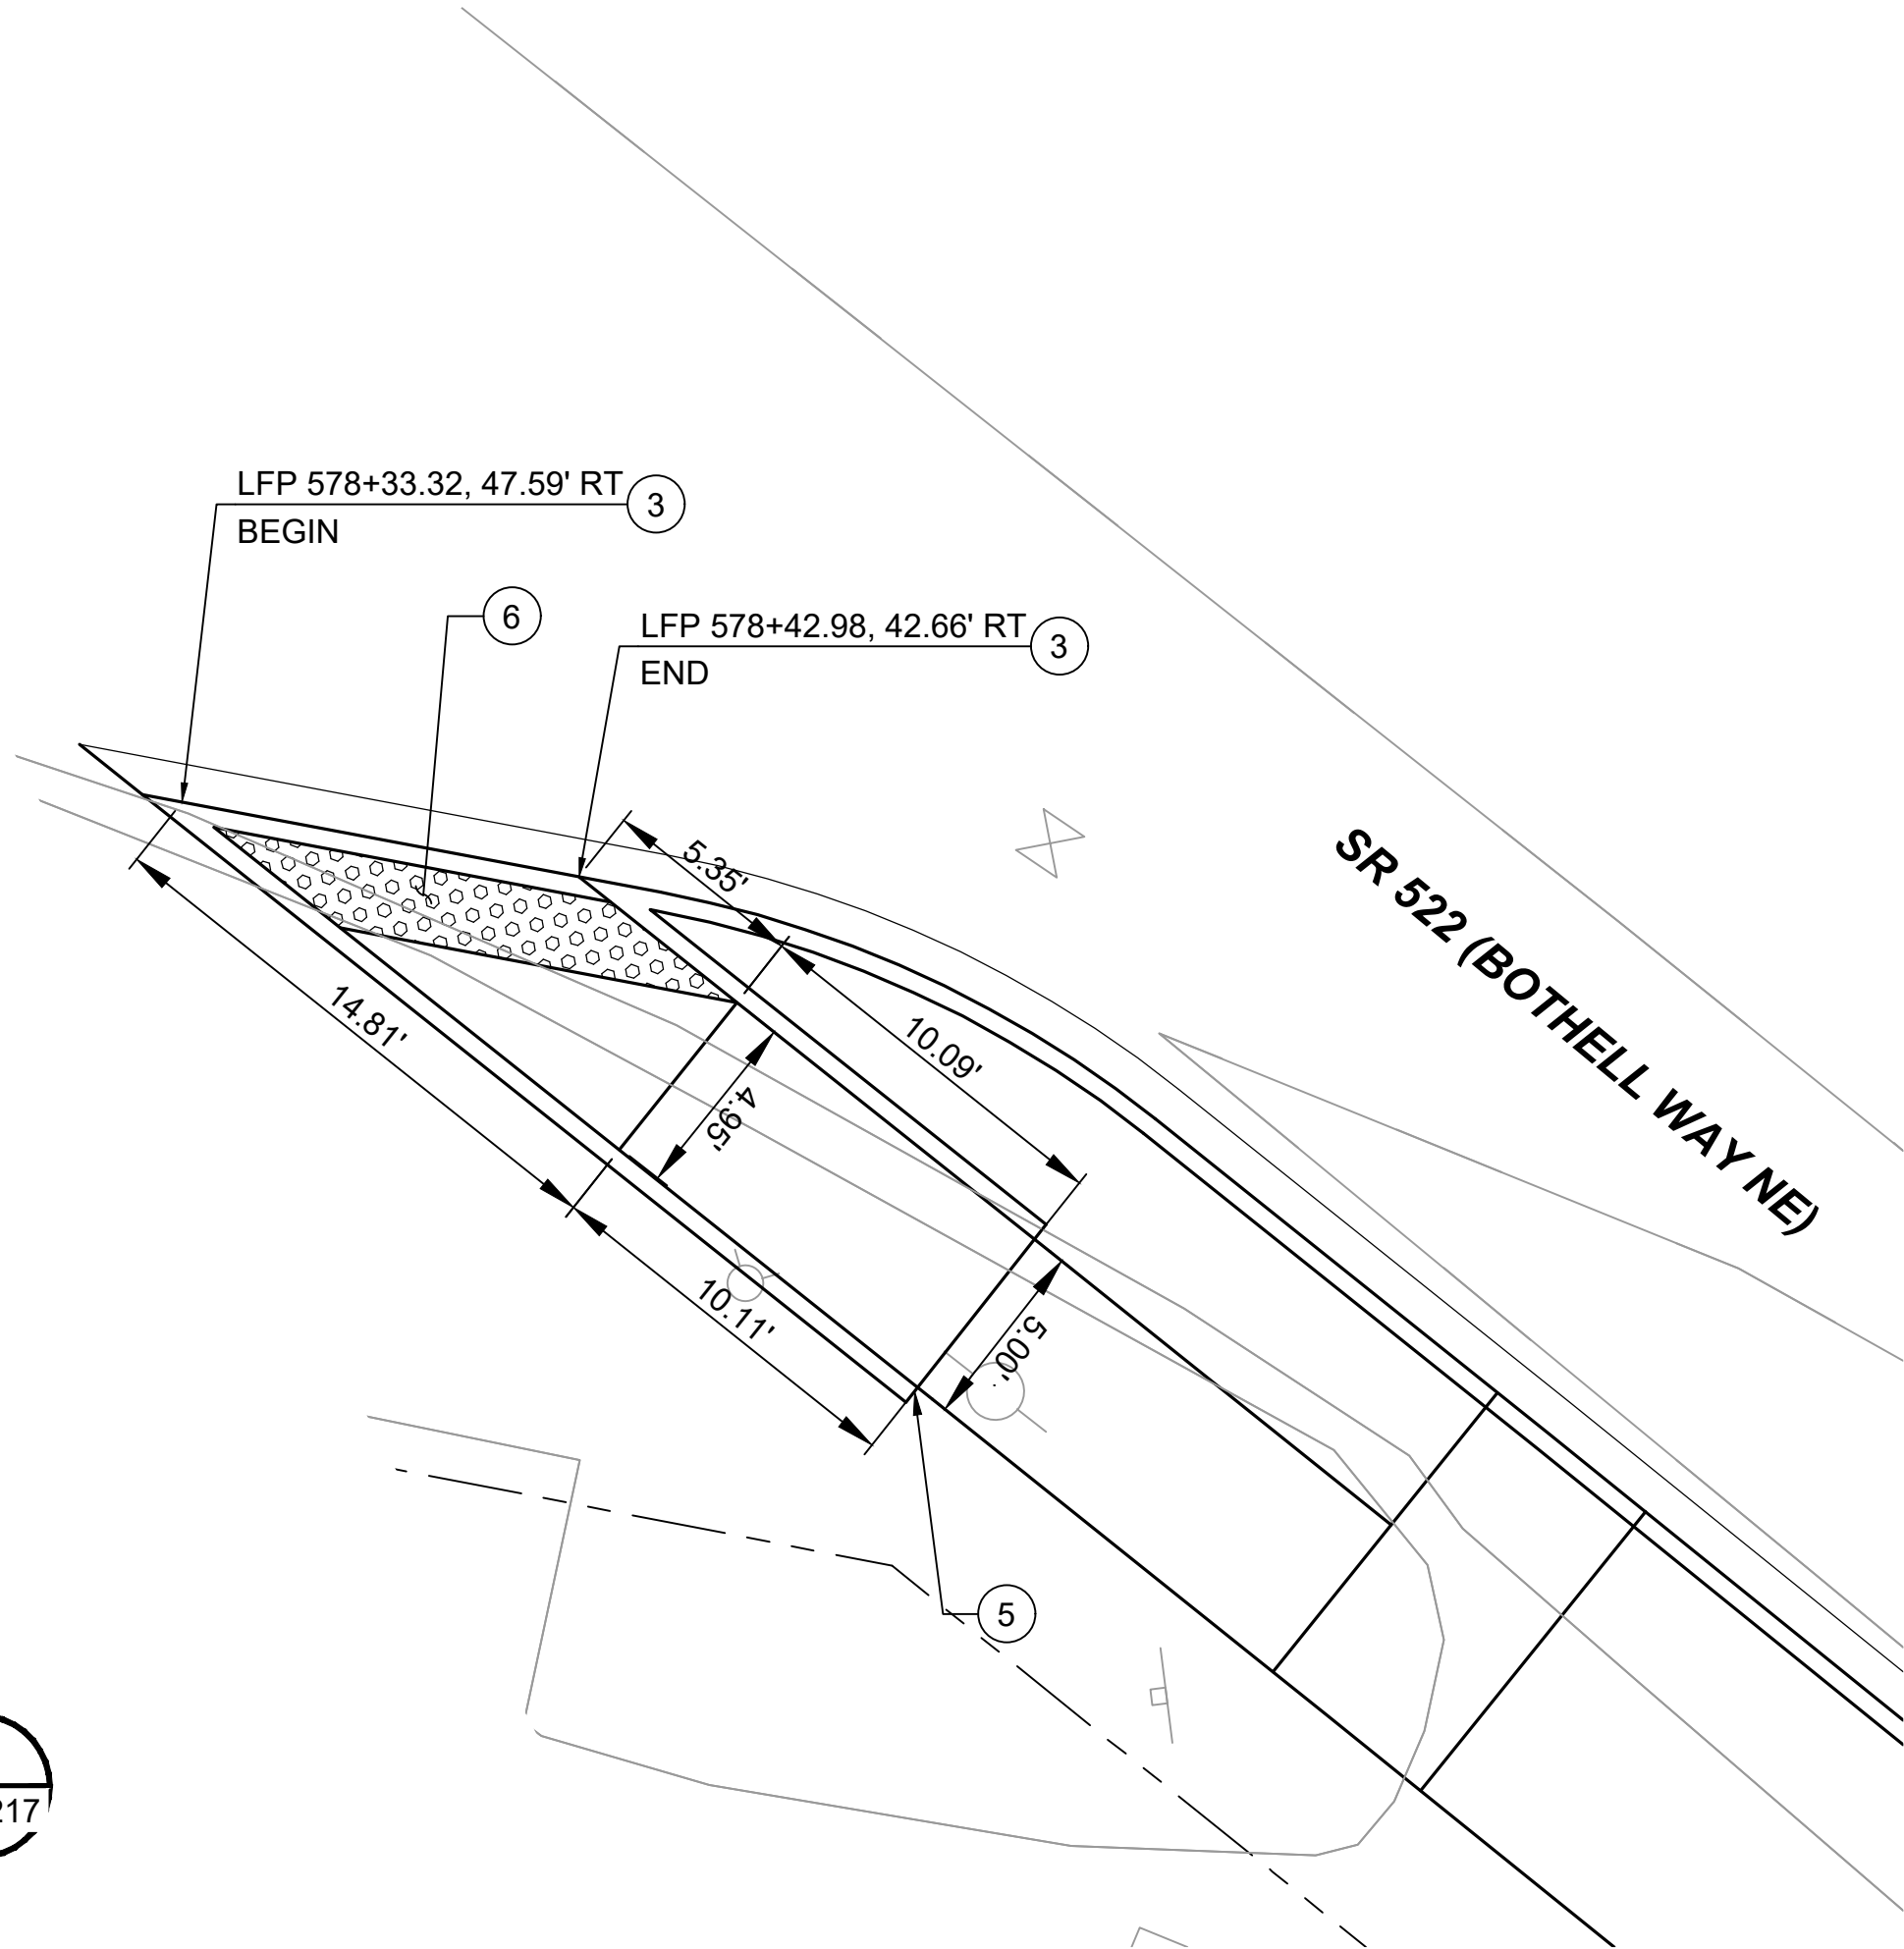


- CONSTRUCTION NOTES:**
1. INSTALL CEMENT CONCRETE PARALLEL TYPE A CURB RAMP PER WSDOT STD PLAN F-40.12-03
 2. INSTALL CEMENT CONCRETE PERPENDICULAR CURB RAMP PER WSDOT STD PLAN F-40.15-03
 3. INSTALL CEMENT CONCRETE SINGLE DIRECTION CURB RAMP PER WSDOT STD. PLAN F-40.16-03
 4. INSTALL CEMENT CONCRETE COMBINATION CURB RAMP PER WSDOT STD. PLAN F-40.14-03
 5. INSTALL CEMENT CONCRETE PEDESTRIAN CURB PER WSDOT STD. PLAN F-10.12-03
 6. INSTALL YELLOW DETECTABLE WARNING SURFACE PER WSDOT STD. PLAN F-45.10-02

- GENERAL NOTES:**
1. FOR CEMENT CONCRETE MIX DESIGN STRENGTH, SEE SPECIFICATIONS (TO BE PROVIDED POST 30% DESIGN).
 2. STATIONS, OFFSETS, DIMENSIONS, AND HORIZONTAL CONTROL ARE TO FACE OF CURB UNLESS OTHERWISE NOTED.
 3. ELEVATIONS ARE MEASURED AT FLOW LINE OF CURB AND GUTTER UNLESS OTHERWISE NOTED (TO BE PROVIDED POST 30% DESIGN).
 4. ALL CURBS ARE 6 INCHES TALL UNLESS OTHERWISE NOTED.
 5. SEE SHEETS 522-CRY201 - 522-CRY213 FOR TYPICAL ROADWAY SECTIONS
 6. SEE SHEETS 522-CPP201 - 522-CPP220 FOR ROADWAY PAVING PLANS
 7. SEE SHEETS 522-ASP201 - 522-ASX214 FOR ARCHITECTURAL STATION PLANS AND DETAILS

 LEGEND:

 DETECTABLE WARNING SURFACE

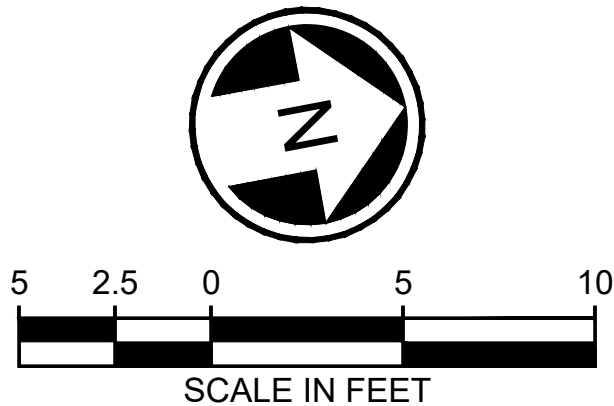

DRAFT 30% SUBMITTAL

No.	DATE	DSN	CHK	APP	REVISION

DESIGNED BY:
C. MATYAS
DRAWN BY:
J. JACKSON
CHECKED BY:
R. KOESTER
APPROVED BY:
M. FELIBERTI



**DAVID EVANS
AND ASSOCIATES INC.**
14432 SE Eastgate Way, Suite 400
Bellevue Washington 98007
Phone: 425.519.6500

SUBMITTED BY:
D.SCHOCK

DATE:
09/11/2020

REVIEWED BY:
B.KEMPER




DATE:
09/11/2020

SCALE:
1"=5'
FILENAME:
BRT-522-CRD201-208
CONTRACT No.:
AE 0055-17
DATE:
09/11/2020

SR 522 / NE 145TH BRT
SR 522 (BOTHELL WAY NE)
CIVIL
CURB RAMP PLAN AND DETAILS
SR 522 (BOTHELL WAY NE) & 41ST AVE NE

DRAWING No.:
522-CRD208
FACILITY ID:
522
SHEET No.:
162 OF 283
REV:

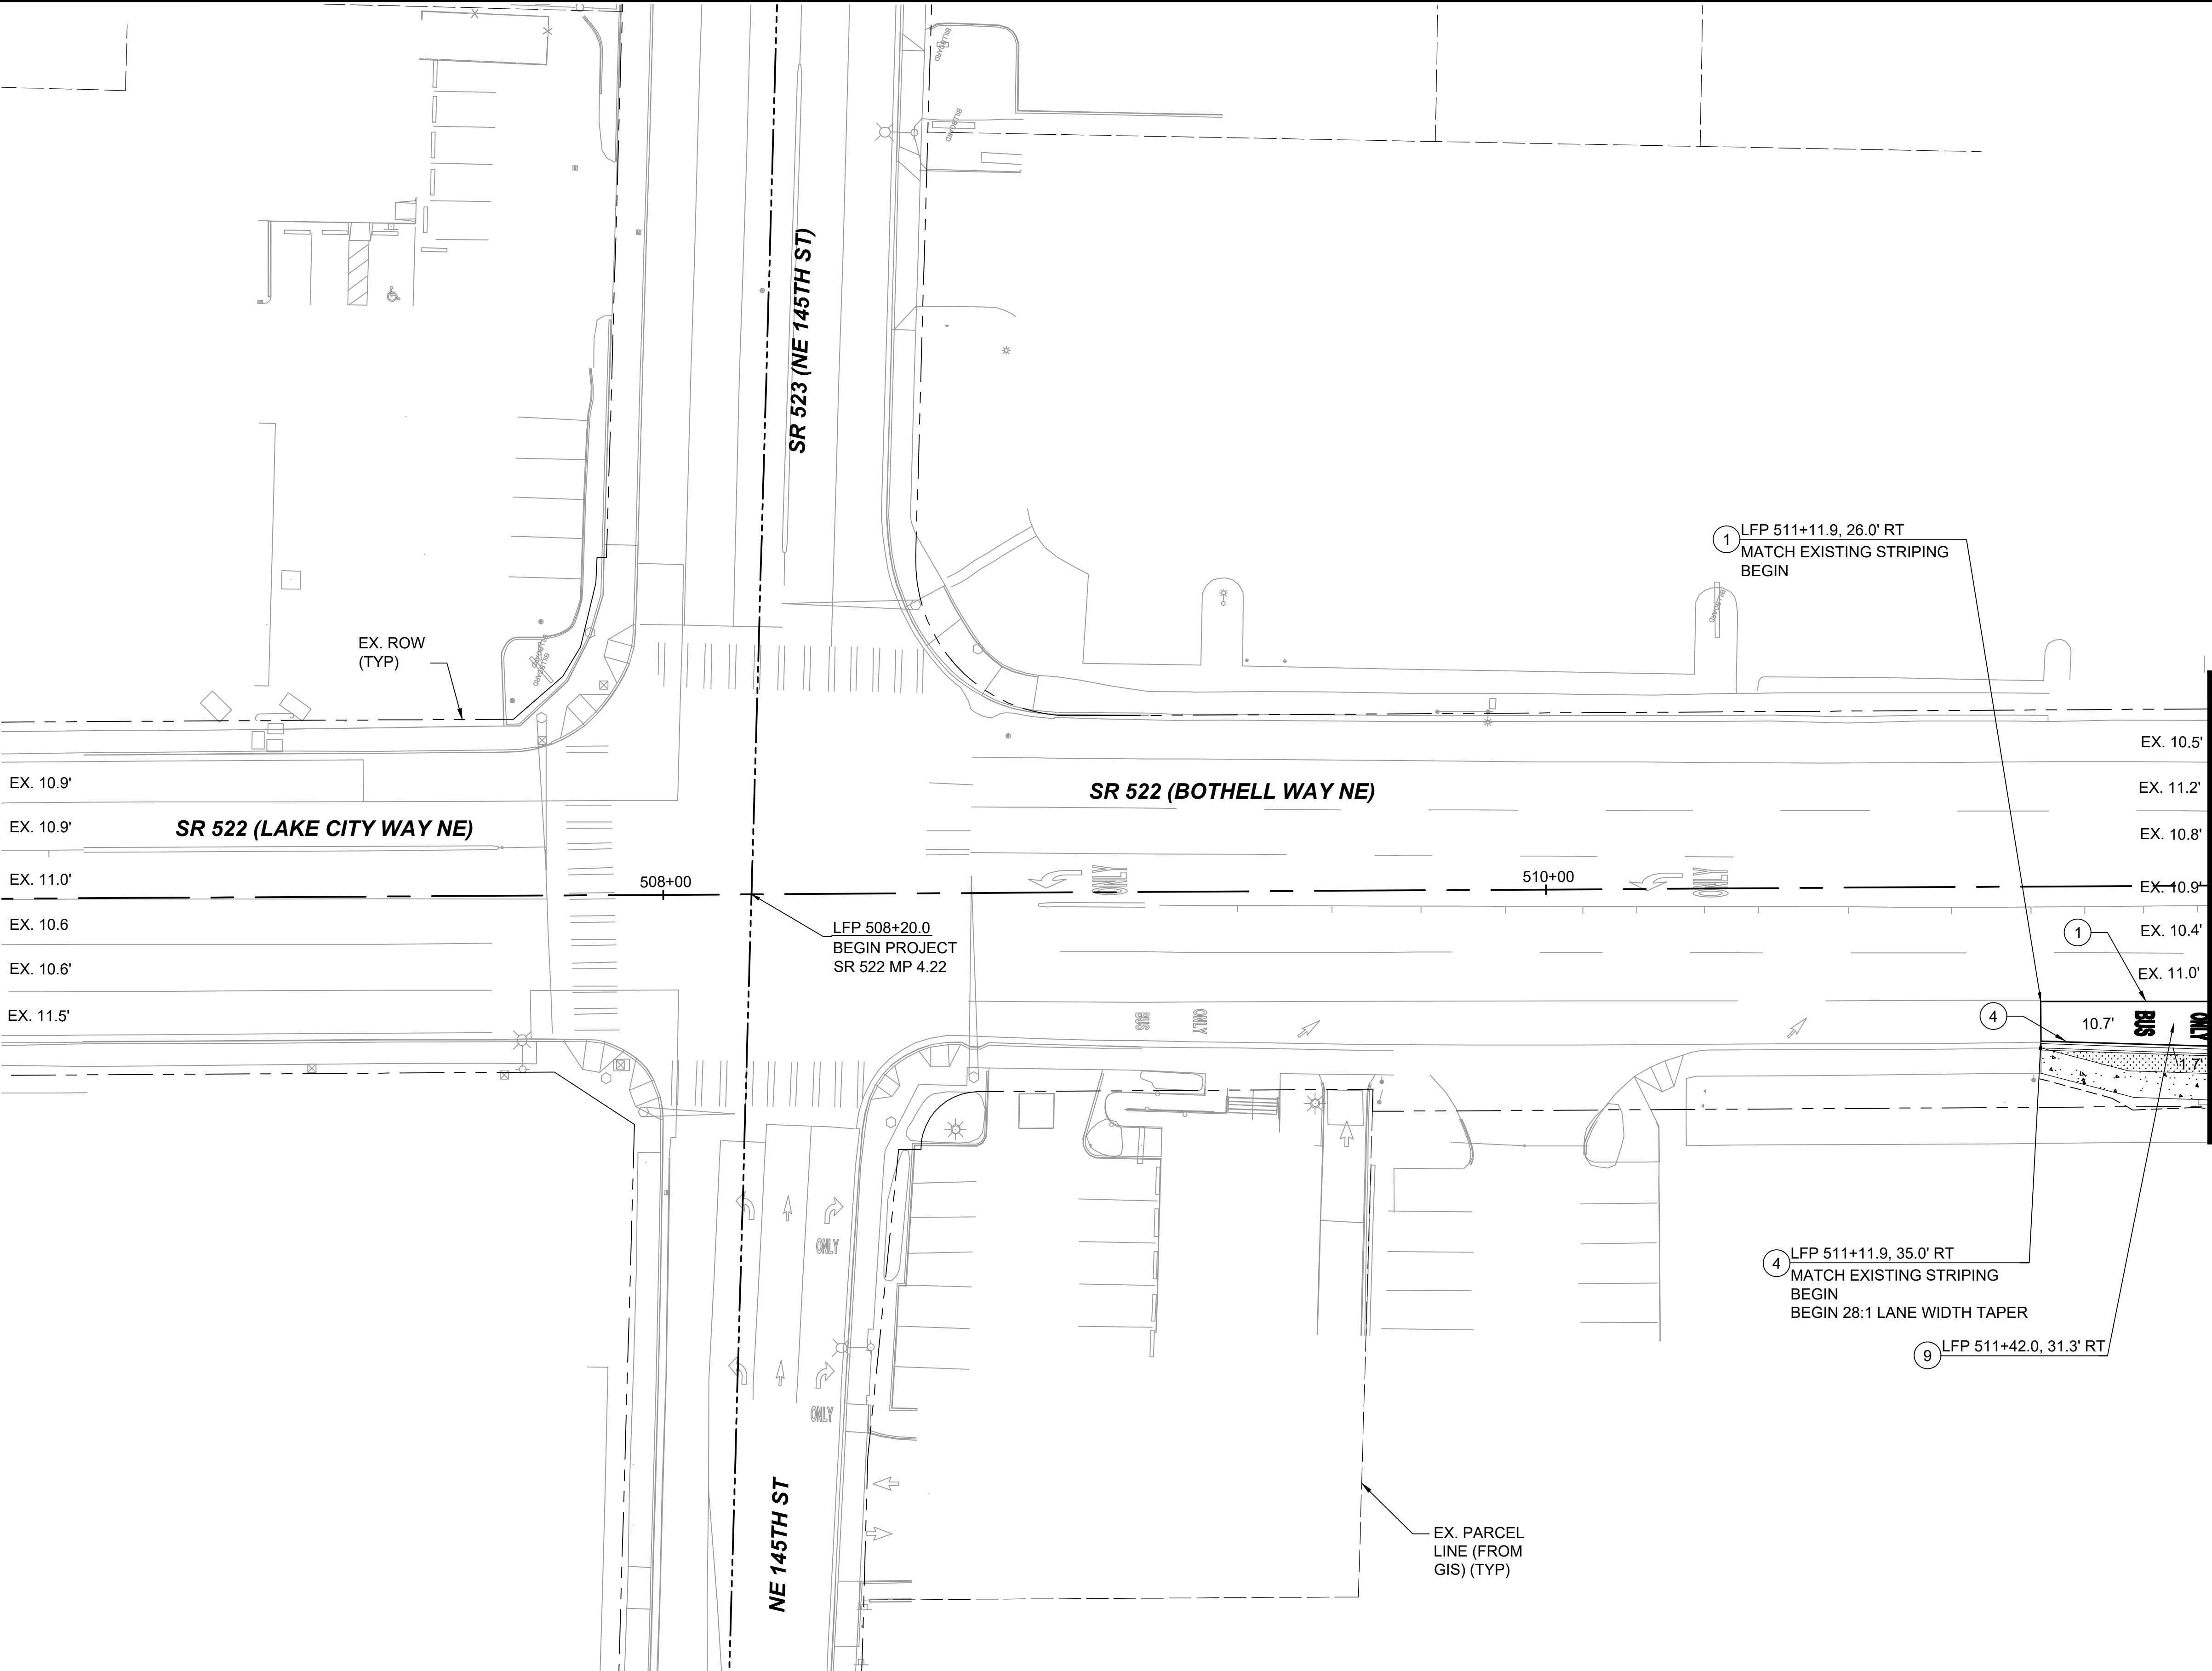


CHANNELIZATION NOTES:

- ① WHITE WIDE LANE LINE PER WSDOT STD. PLAN M-20.10-02
- ② WHITE LANE LINE PER WSDOT STD. PLAN M-20.10-02
- ③ YELLOW EDGE LINE PER WSDOT STD. PLAN M-20.10-02
- ④ WHITE EDGE LINE PER WSDOT STD. PLAN M-20.10-02
- ⑤ WHITE WIDE DOTTED EXTENSION LINE PER WSDOT STD. PLAN M-20.10-02
- ⑥ WHITE DOTTED EXTENSION LINE PER WSDOT STD. PLAN M-20.10-02
- ⑦ STOP LINE PER WSDOT STD. PLAN M-24.60-04
- ⑧ CROSSWALK LINE PER WSDOT STD. PLAN M-15.10-01
- ⑨ "BUS ONLY" HIGH SPEED TRAFFIC LETTERS PER WSDOT STD. PLAN M-80.10-01
- ⑩ TYPE 2SL TRAFFIC ARROW PER WSDOT STD. PLAN M-24.40-02
- ⑪ TYPE 2SR TRAFFIC ARROW PER WSDOT STD. PLAN M-24.40-02
- ⑫ WHITE DIAGONAL MARKING PER WSDOT STD. PLAN M-24.60-04, SPACED 3.5' ON CENTERS

GENERAL NOTES:

1. ONLY SIGNS THAT SHOW ACCESS CHANGES ARE INCLUDED IN THIS SET FOR INFORMATIONAL PURPOSES. FULL SIGNING PLANS WILL BE DEVELOPED POST 30% DESIGN.

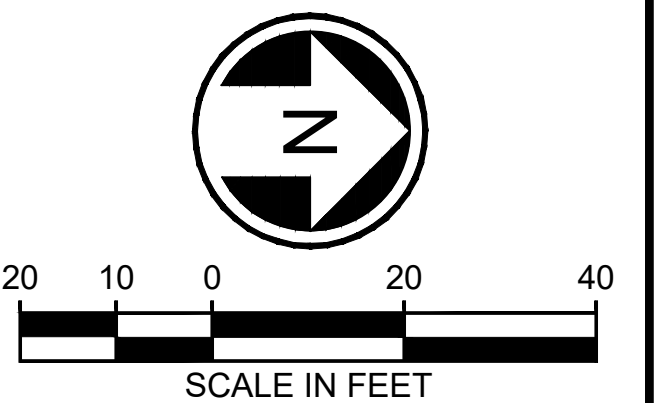

DRAFT 30% SUBMITTAL

No.	DATE	DSN	CHK	APP	REVISION

DESIGNED BY:	C.MATYAS
DRAWN BY:	O.AHRENSFELD
CHECKED BY:	R.KOESTER
APPROVED BY:	M.FELIBERTI



**DAVID EVANS
AND ASSOCIATES INC.**
14432 SE Eastgate Way, Suite 400
Bellevue Washington 98007
Phone: 425.519.6500

LINE IS 1" AT FULL SCALE



SCALE:	1"=20'
FILENAME:	BRT-522-CMP201-210
CONTRACT No.:	AE 0055-17
DATE:	09/11/2020

SR 522 / NE 145TH BRT


SR 522 (BOTHELL WAY NE)

CIVIL
CHANNELIZATION & SIGNING PLAN
STA. 506+00 TO STA. 511+50

DRAWING No.:	
522-CMP201	
FACILITY ID:	
522	
SHEET No.:	REV:
163 OF 283	

09/10/20 | 10:38 AM | CLMA
C:\PW_WORK\DEA\CHERIE.MATYAS\DWG\BRT-522-CMP201-210.DWG

MATCHLINE, SEE SHEET 522-CMP201

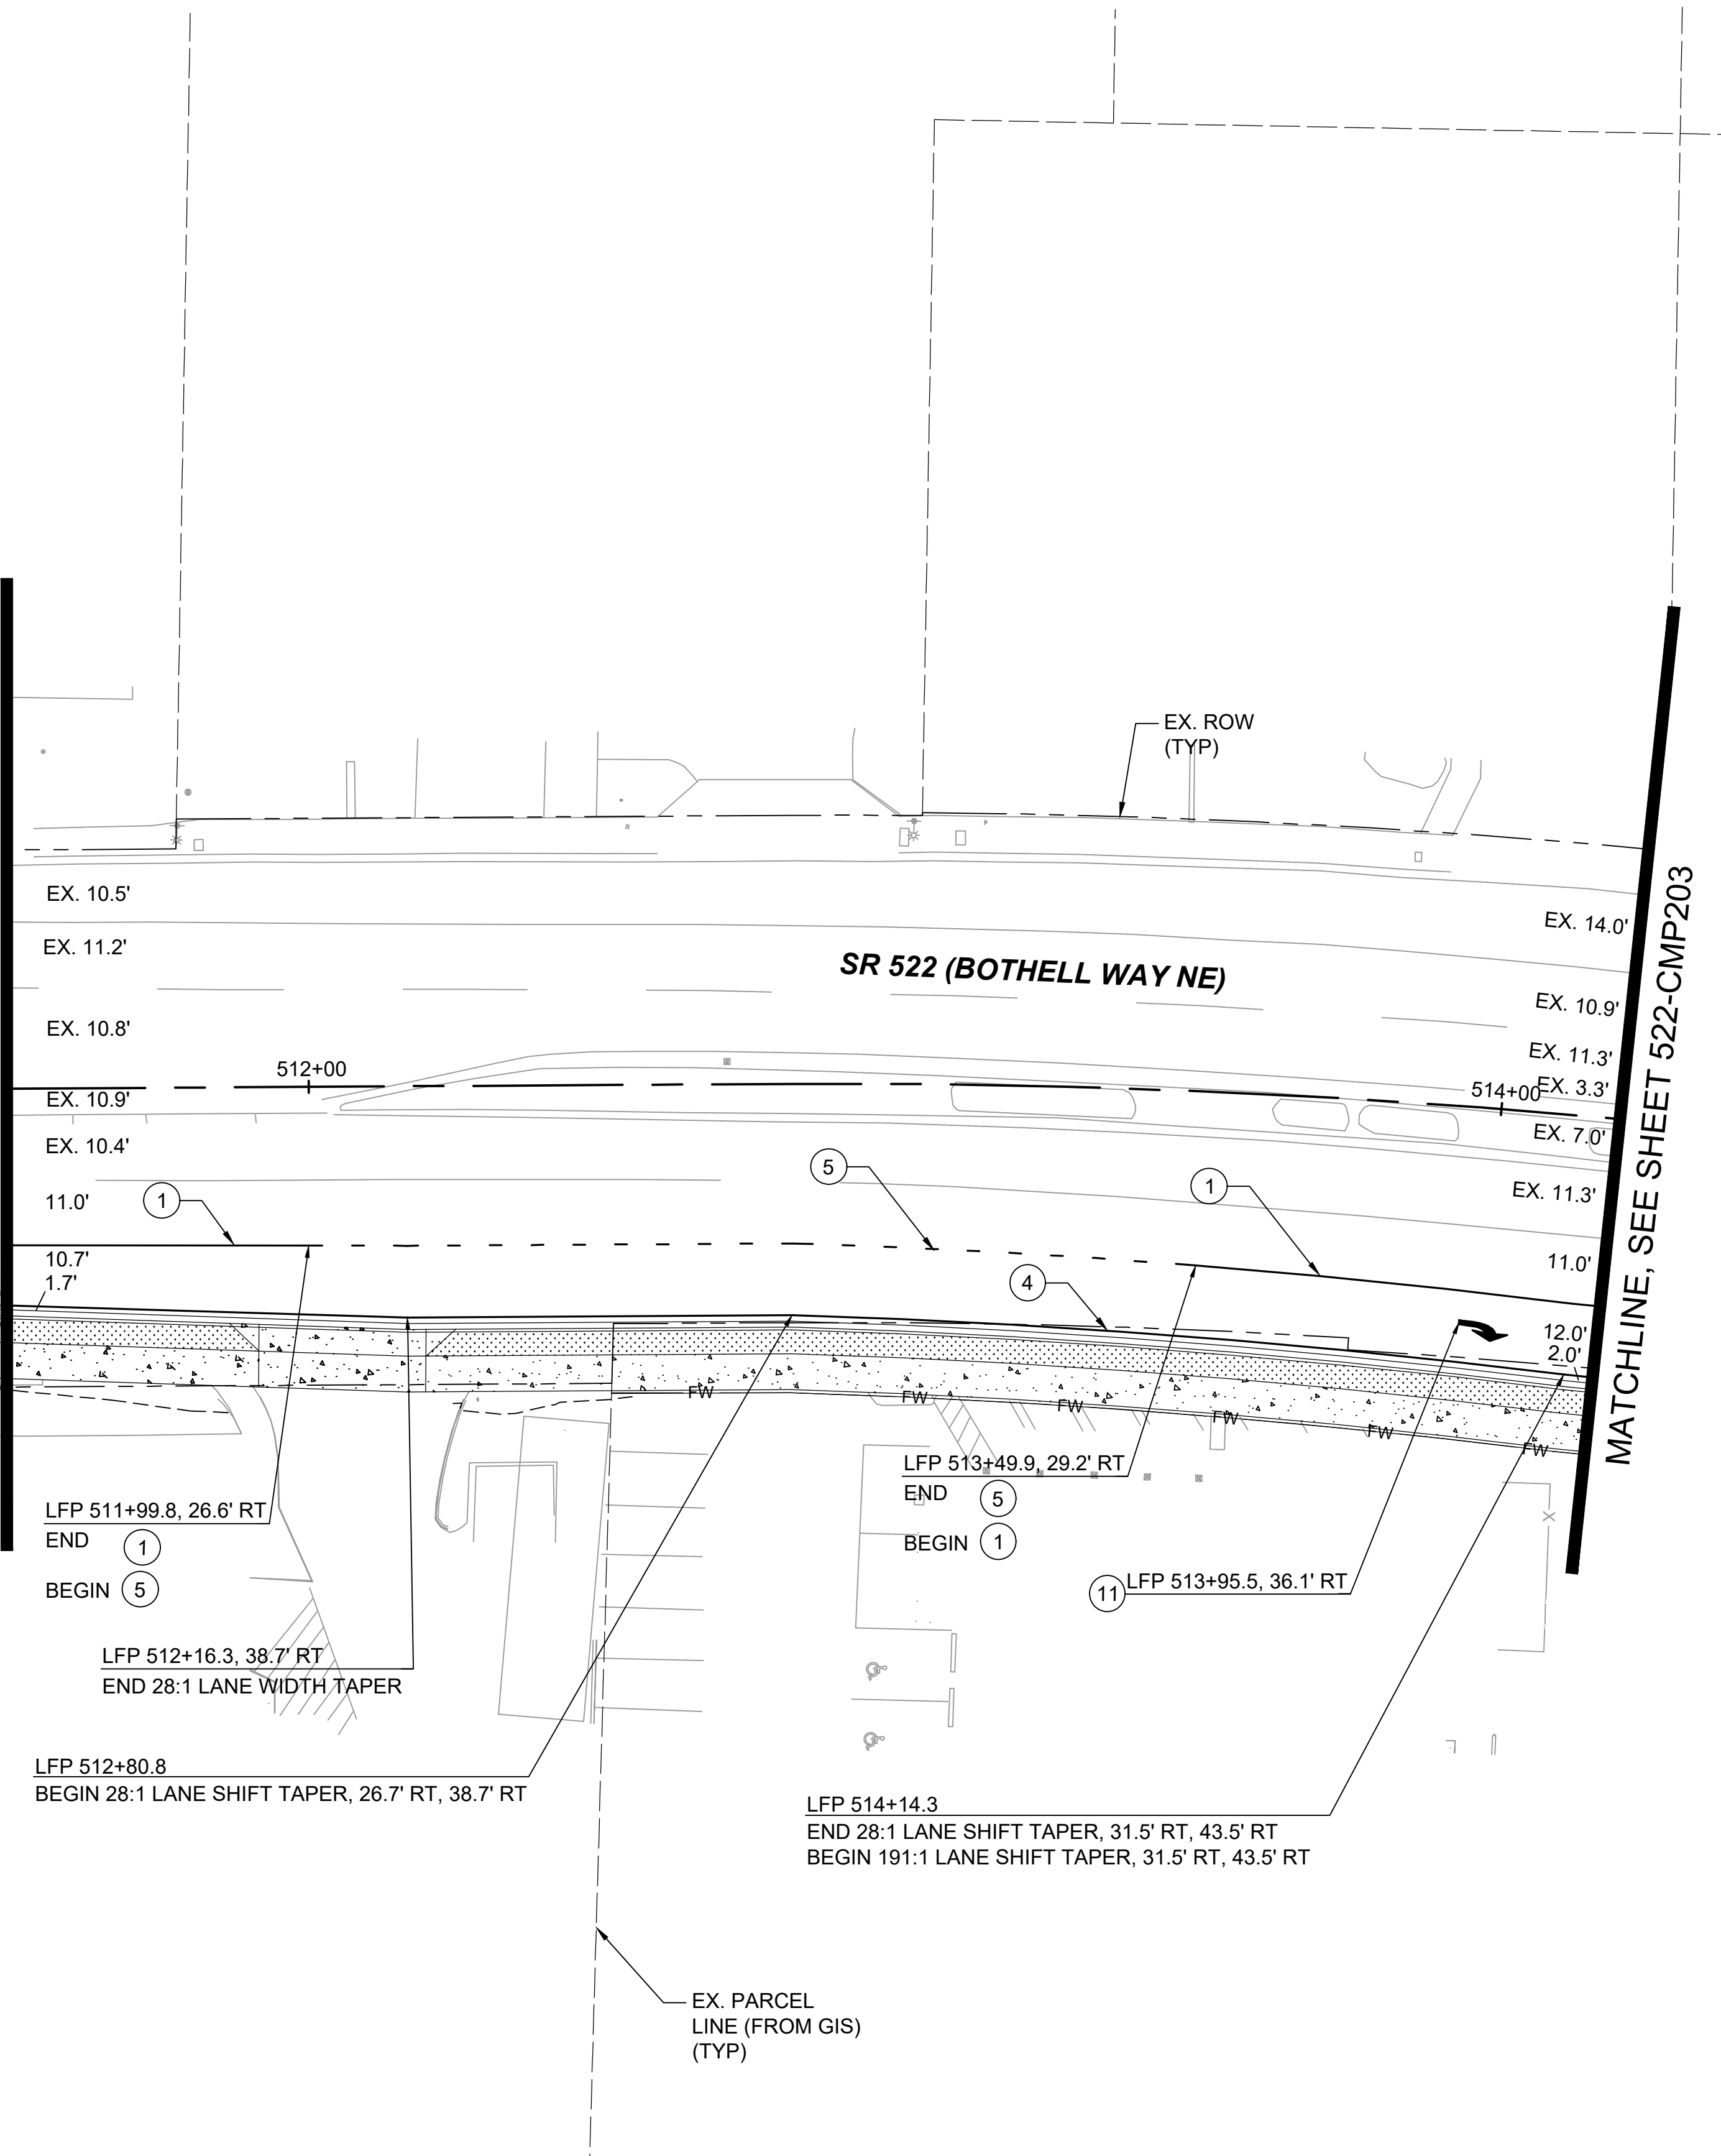


MATCHLINE, SEE SHEET 522-CMP203

CHANNELIZATION NOTES:

- 1 WHITE WIDE LANE LINE PER WSDOT STD. PLAN M-20.10-02
- 2 WHITE LANE LINE PER WSDOT STD. PLAN M-20.10-02
- 3 YELLOW EDGE LINE PER WSDOT STD. PLAN M-20.10-02
- 4 WHITE EDGE LINE PER WSDOT STD. PLAN M-20.10-02
- 5 WHITE WIDE DOTTED EXTENSION LINE PER WSDOT STD. PLAN M-20.10-02
- 6 WHITE DOTTED EXTENSION LINE PER WSDOT STD. PLAN M-20.10-02
- 7 STOP LINE PER WSDOT STD. PLAN M-24.60-04
- 8 CROSSWALK LINE PER WSDOT STD. PLAN M-15.10-01
- 9 "BUS ONLY" HIGH SPEED TRAFFIC LETTERS PER WSDOT STD. PLAN M-80.10-01
- 10 TYPE 2SL TRAFFIC ARROW PER WSDOT STD. PLAN M-24.40-02
- 11 TYPE 2SR TRAFFIC ARROW PER WSDOT STD. PLAN M-24.40-02
- 12 WHITE DIAGONAL MARKING PER WSDOT STD. PLAN M-24.60-04, SPACED 3.5' ON CENTERS

GENERAL NOTES:

1. ONLY SIGNS THAT SHOW ACCESS CHANGES ARE INCLUDED IN THIS SET FOR INFORMATIONAL PURPOSES. FULL SIGNING PLANS WILL BE DEVELOPED POST 30% DESIGN.

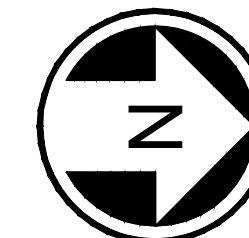


DRAFT 30% SUBMITTAL

No.	DATE	DSN	CHK	APP	REVISION

DESIGNED BY:
C.MATYAS
DRAWN BY:
O.AHRENSFELD
CHECKED BY:
R.KOESTER
APPROVED BY:
M.FELIBERTI



 DAVID EVANS
AND ASSOCIATES INC.
14432 SE Eastgate Way, Suite 400
Bellevue Washington 98007
Phone: 425.519.6500



SOUND TRANSIT

SCALE:
1"=20'
FILENAME:
BRT-522-CMP201-210
CONTRACT No.:
AE 0055-17
DATE:
09/11/2020

SR 522 / NE 145TH BRT

SR 522 (BOTHELL WAY NE)

CIVIL
CHANNELIZATION & SIGNING PLAN
STA. 511+50 TO STA. 514+25

DRAWING No.:
522-CMP202
FACILITY ID:
522
SHEET No.:
164 OF 283
REV:

SUBMITTED BY:
D.SCHOCK

DATE:
09/11/2020

REVIEWED BY:
B.KEMPER

DATE:
09/11/2020

09/10/20 | 10:38 AM | CLMA
C:\PW_WORK\DEACHERIE\MATYAS\DWG\BRT-522-CMP201-210.DWG


DRAFT 30% SUBMITTAL

No.	DATE	DSN	CHK	APP	REVISION

DESIGNED BY:	C.MATYAS
DRAWN BY:	O.AHRENSFELD
CHECKED BY:	R.KOESTER
APPROVED BY:	M.FELIBERTI



 **DAVID EVANS
AND ASSOCIATES INC.**
14432 SE Eastgate Way, Suite 400
Bellevue Washington 98007
Phone: 425.519.6500




SCALE:	1"=20'
FILENAME:	BRT-522-CMP201-210
CONTRACT No.:	AE 0055-17
DATE:	09/11/2020

SR 522 / NE 145TH BRT

SR 522 (BOTHELL WAY NE)

CIVIL
CHANNELIZATION & SIGNING PLAN
STA. 514+25 TO STA. 518+75

DRAWING No.:	522-CMP203
FACILITY ID:	522
SHEET No.:	165 OF 283
REV:	

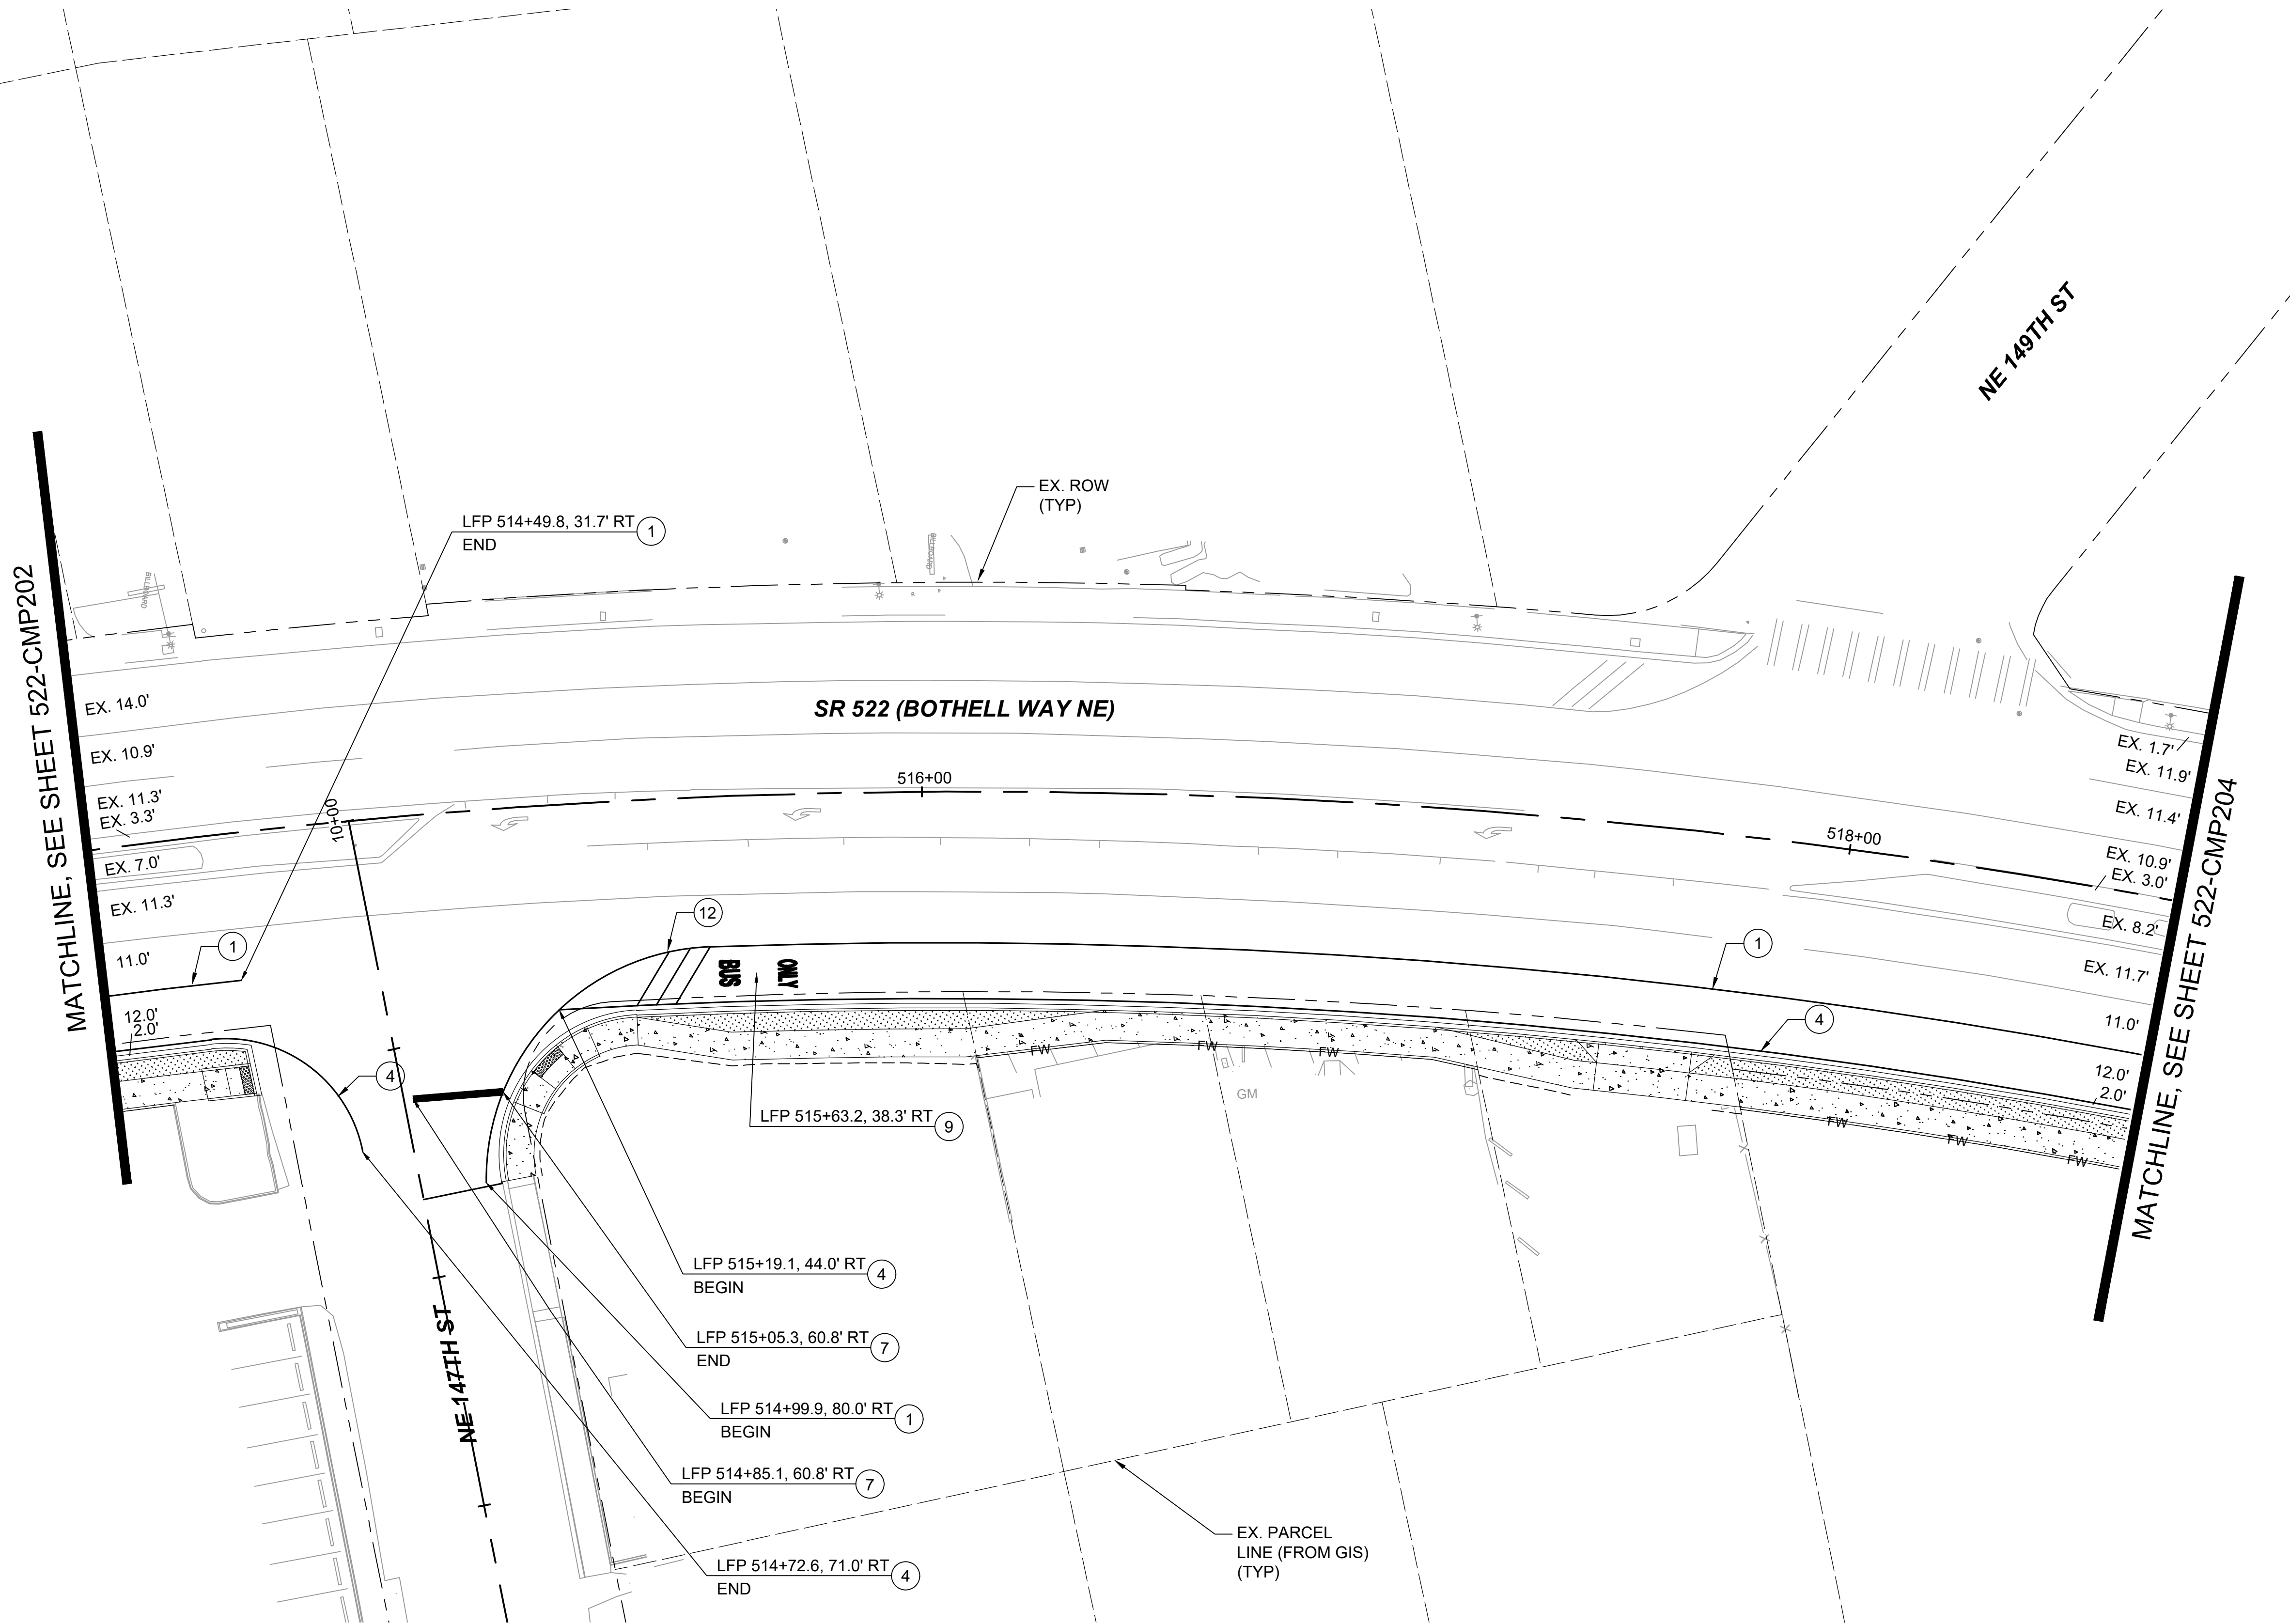


CHANNELIZATION NOTES:

- 1 WHITE WIDE LANE LINE PER WSDOT STD. PLAN M-20.10-02
- 2 WHITE LANE LINE PER WSDOT STD. PLAN M-20.10-02
- 3 YELLOW EDGE LINE PER WSDOT STD. PLAN M-20.10-02
- 4 WHITE EDGE LINE PER WSDOT STD. PLAN M-20.10-02
- 5 WHITE WIDE DOTTED EXTENSION LINE PER WSDOT STD. PLAN M-20.10-02
- 6 WHITE DOTTED EXTENSION LINE PER WSDOT STD. PLAN M-20.10-02
- 7 STOP LINE PER WSDOT STD. PLAN M-24.60-04
- 8 CROSSWALK LINE PER WSDOT STD. PLAN M-15.10-01
- 9 "BUS ONLY" HIGH SPEED TRAFFIC LETTERS PER WSDOT STD. PLAN M-80.10-01
- 10 TYPE 2SL TRAFFIC ARROW PER WSDOT STD. PLAN M-24.40-02
- 11 TYPE 2SR TRAFFIC ARROW PER WSDOT STD. PLAN M-24.40-02
- 12 WHITE DIAGONAL MARKING PER WSDOT STD. PLAN M-24.60-04, SPACED 3.5' ON CENTERS

GENERAL NOTES:


1. ONLY SIGNS THAT SHOW ACCESS CHANGES ARE INCLUDED IN THIS SET FOR INFORMATIONAL PURPOSES. FULL SIGNING PLANS WILL BE DEVELOPED POST 30% DESIGN.

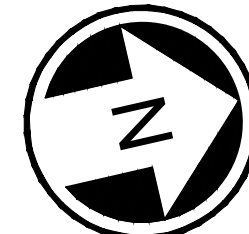

09/10/20 | 10:39 AM | CLMA
C:\PW_WORK\DEACHERIE\MATYAS\DWG\BRT-522-CMP201-210.DWG

MATCHLINE, SEE SHEET 522-CMP203

MATCHLINE, SEE SHEET 522-CMP205

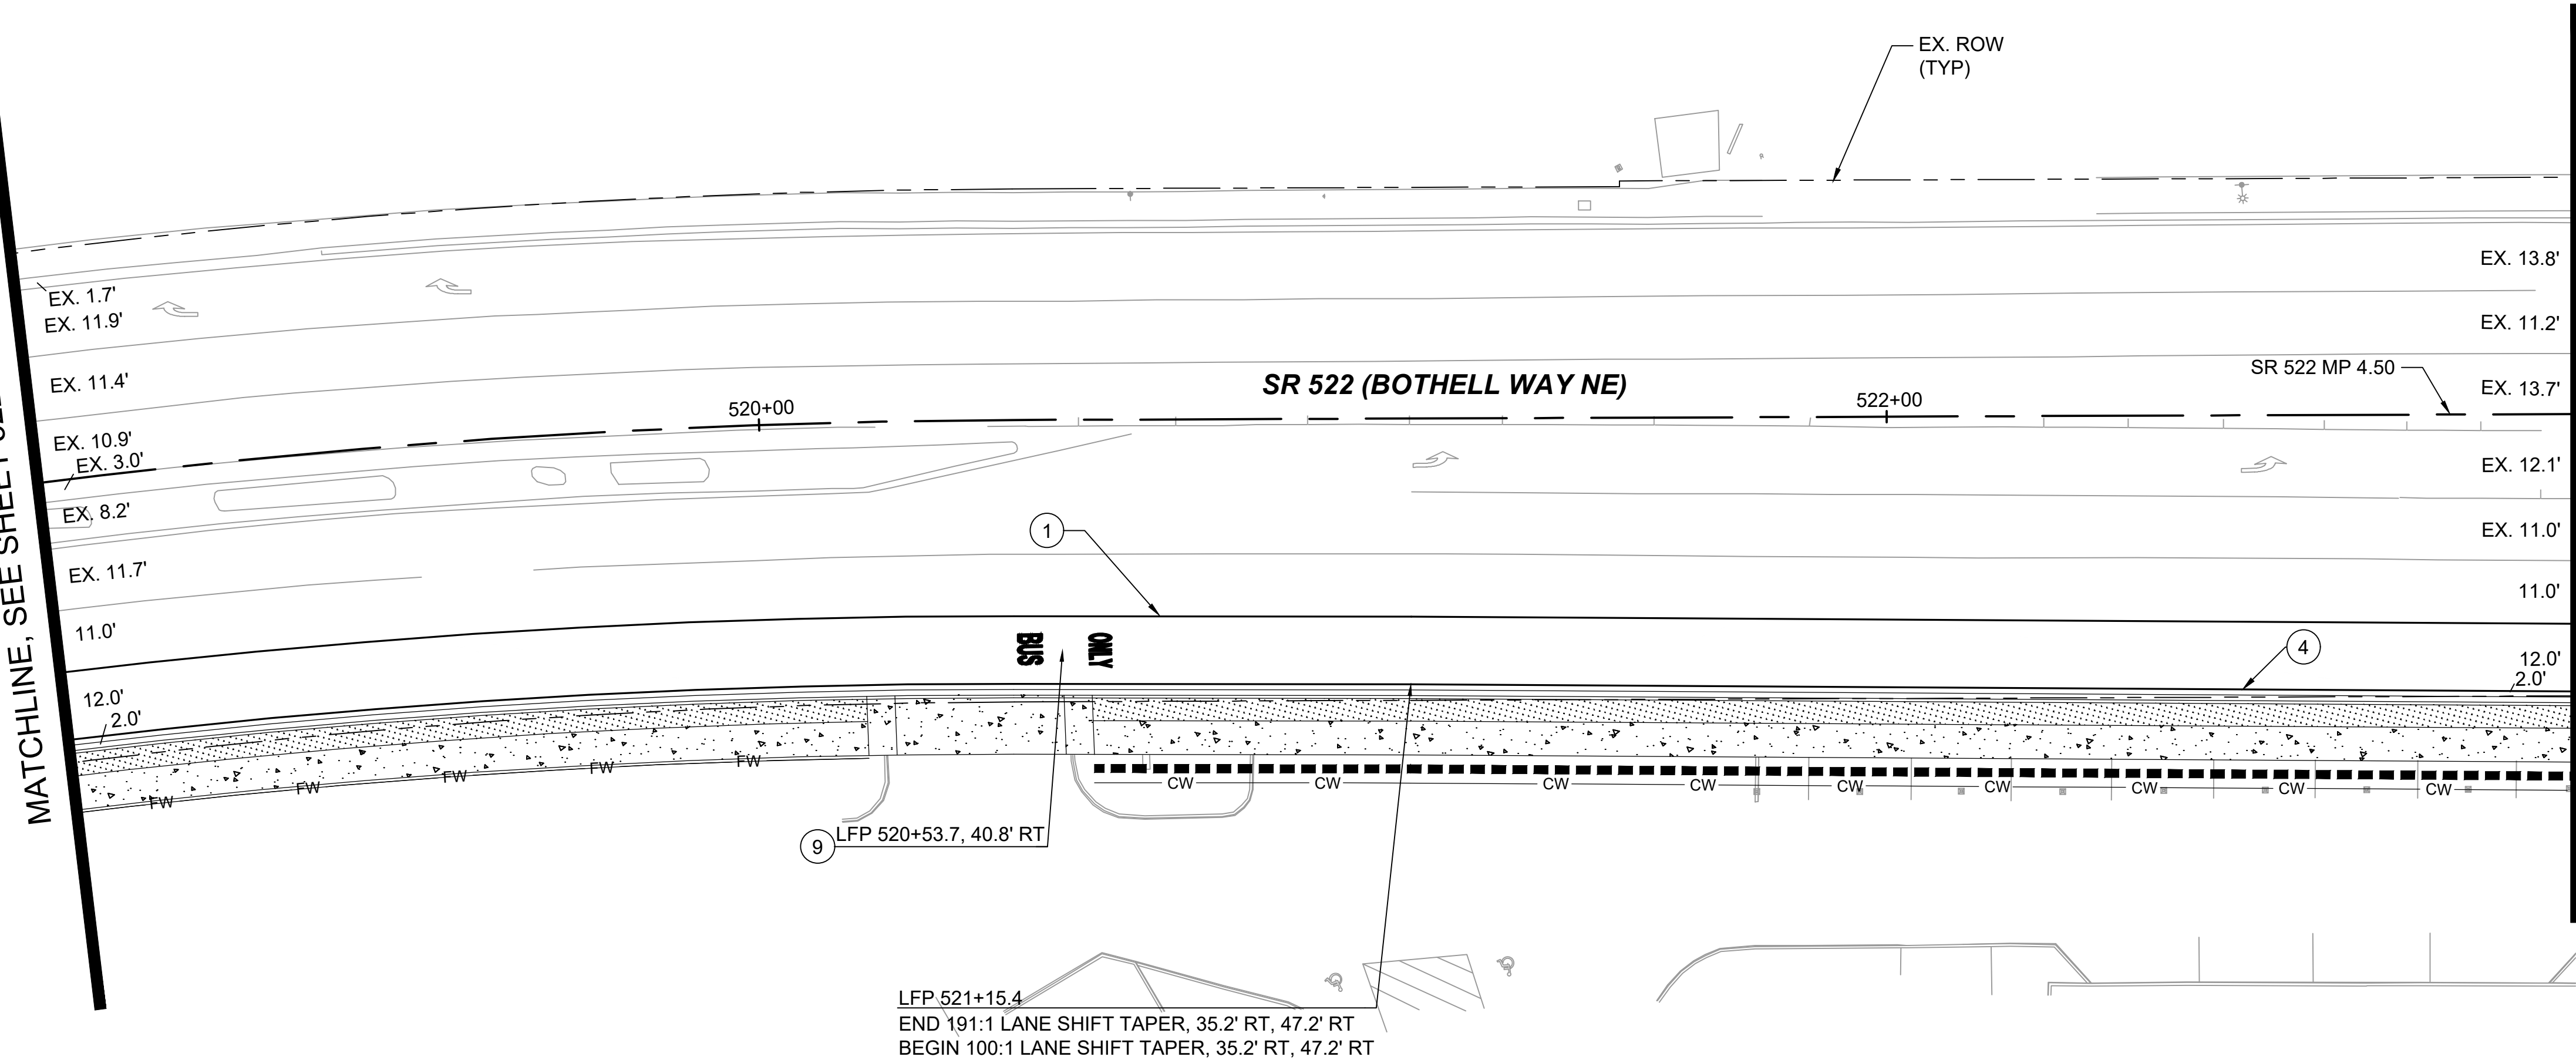

CHANNELIZATION NOTES:

- 1 WHITE WIDE LANE LINE PER WSDOT STD. PLAN M-20.10-02
- 2 WHITE LANE LINE PER WSDOT STD. PLAN M-20.10-02
- 3 YELLOW EDGE LINE PER WSDOT STD. PLAN M-20.10-02
- 4 WHITE EDGE LINE PER WSDOT STD. PLAN M-20.10-02
- 5 WHITE WIDE DOTTED EXTENSION LINE PER WSDOT STD. PLAN M-20.10-02
- 6 WHITE DOTTED EXTENSION LINE PER WSDOT STD. PLAN M-20.10-02
- 7 STOP LINE PER WSDOT STD. PLAN M-24.60-04
- 8 CROSSWALK LINE PER WSDOT STD. PLAN M-15.10-01
- 9 "BUS ONLY" HIGH SPEED TRAFFIC LETTERS PER WSDOT STD. PLAN M-80.10-01
- 10 TYPE 2SL TRAFFIC ARROW PER WSDOT STD. PLAN M-24.40-02
- 11 TYPE 2SR TRAFFIC ARROW PER WSDOT STD. PLAN M-24.40-02
- 12 WHITE DIAGONAL MARKING PER WSDOT STD. PLAN M-24.60-04, SPACED 3.5' ON CENTERS


GENERAL NOTES:

- 1. ONLY SIGNS THAT SHOW ACCESS CHANGES ARE INCLUDED IN THIS SET FOR INFORMATIONAL PURPOSES. FULL SIGNING PLANS WILL BE DEVELOPED POST 30% DESIGN.



DRAFT 30% SUBMITTAL						DESIGNED BY: C.MATYAS DRAWN BY: O.AHRENSFELD CHECKED BY: R.KOESTER APPROVED BY: M.FELIBERTI		 DAVID EVANS AND ASSOCIATES INC. 14432 SE Eastgate Way, Suite 400 Bellevue Washington 98007 Phone: 425.519.6500 LINE IS 1" AT FULL SCALE 			SCALE: 1"=20' FILENAME: BRT-522-CMP201-210 CONTRACT No.: AE 0055-17	SR 522 / NE 145TH BRT SR 522 (BOTHELL WAY NE) CIVIL CHANNELIZATION & SIGNING PLAN STA. 518+75 TO STA. 523+25			DRAWING No.: 522-CMP204 FACILITY ID: 522 SHEET No.: 166 OF 283 REV:
No.	DATE	DSN	CHK	APP	REVISION		SUBMITTED BY: D.SCHOCK	DATE: 09/11/2020	REVIEWED BY: B.KEMPER	DATE: 09/11/2020					

09/10/20 | 11:49 AM | APDC
C:\PW_WORK\DEA\APRIL COLEMAN\DWG\BRT-522-CMP201-210.DWG

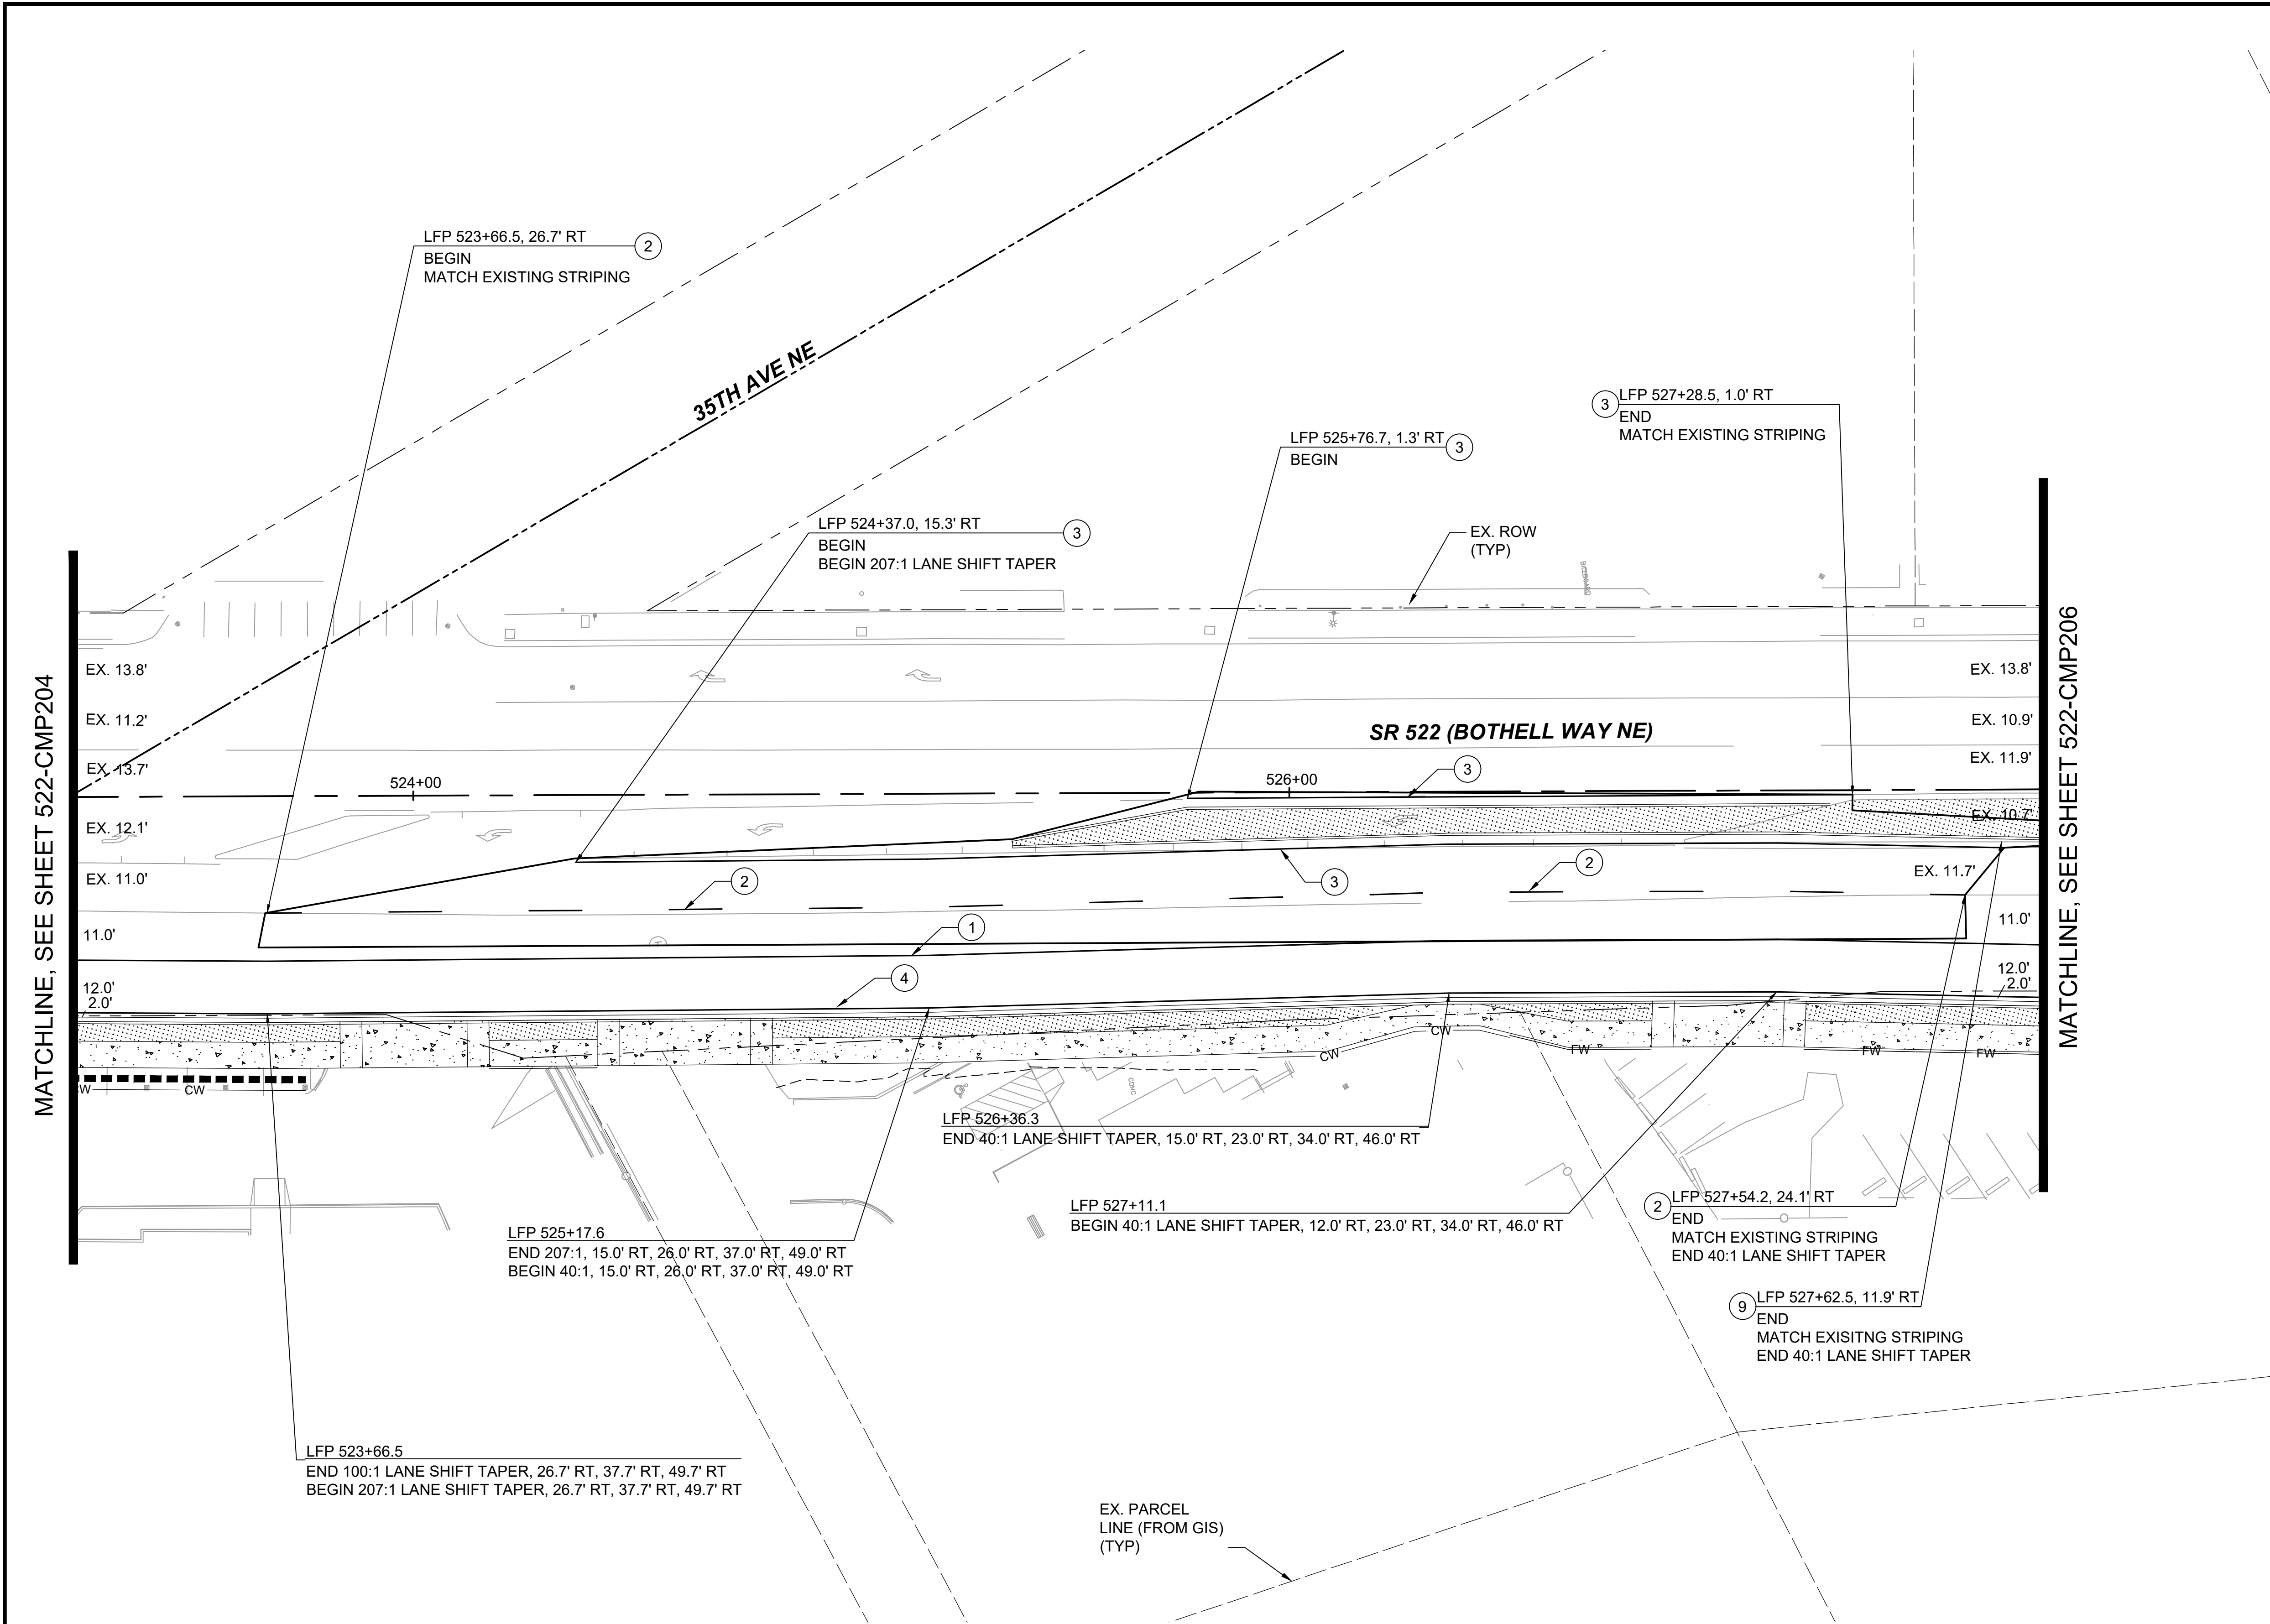


CHANNELIZATION NOTES:

- 1 WHITE WIDE LANE LINE PER WSDOT STD. PLAN M-20.10-02
- 2 WHITE LANE LINE PER WSDOT STD. PLAN M-20.10-02
- 3 YELLOW EDGE LINE PER WSDOT STD. PLAN M-20.10-02
- 4 WHITE EDGE LINE PER WSDOT STD. PLAN M-20.10-02
- 5 WHITE WIDE DOTTED EXTENSION LINE PER WSDOT STD. PLAN M-20.10-02
- 6 WHITE DOTTED EXTENSION LINE PER WSDOT STD. PLAN M-20.10-02
- 7 STOP LINE PER WSDOT STD. PLAN M-24.60-04
- 8 CROSSWALK LINE PER WSDOT STD. PLAN M-15.10-01
- 9 "BUS ONLY" HIGH SPEED TRAFFIC LETTERS PER WSDOT STD. PLAN M-80.10-01
- 10 TYPE 2SL TRAFFIC ARROW PER WSDOT STD. PLAN M-24.40-02
- 11 TYPE 2SR TRAFFIC ARROW PER WSDOT STD. PLAN M-24.40-02
- 12 WHITE DIAGONAL MARKING PER WSDOT STD. PLAN M-24.60-04, SPACED 3.5' ON CENTERS

GENERAL NOTES:

1. ONLY SIGNS THAT SHOW ACCESS CHANGES ARE INCLUDED IN THIS SET FOR INFORMATIONAL PURPOSES. FULL SIGNING PLANS WILL BE DEVELOPED POST 30% DESIGN.

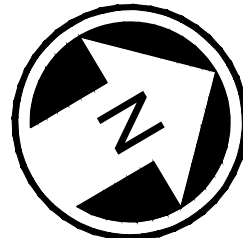


DRAFT 30% SUBMITTAL <table><tr><td>No.</td><td>DATE</td><td>DSN</td><td>CHK</td><td>APP</td><td>REVISION</td></tr><tr><td> </td><td> </td><td> </td><td> </td><td> </td><td> </td></tr><tr><td> </td><td> </td><td> </td><td> </td><td> </td><td> </td></tr><tr><td> </td><td> </td><td> </td><td> </td><td> </td><td> </td></tr><tr><td> </td><td> </td><td> </td><td> </td><td> </td><td> </td></tr></table>						No.	DATE	DSN	CHK	APP	REVISION																									DESIGNED BY: C.MATYAS		 DAVID EVANS AND ASSOCIATES INC. 14432 SE Eastgate Way, Suite 400 Bellevue Washington 98007 Phone: 425.519.6500				SCALE: 1"=20'	SR 522 / NE 145TH BRT		DRAWING No.: 522-CMP205
No.	DATE	DSN	CHK	APP	REVISION																																								
DRAWN BY: O.AHRENSFELD	FILENAME: BRT-522-CMP201-210	SR 522 (BOTHELL WAY NE)		FACILITY ID: 522																																									
CHECKED BY: R.KOESTER	CONTRACT No.: AE 0055-17	CIVIL CHANNELIZATION & SIGNING PLAN STA. 523+25 TO STA. 527+75		SHEET No.: 167 OF 283																																									
APPROVED BY: M.FELIBERTI	DATE: 09/11/2020	REVIEWED BY: B.KEMPER	DATE: 09/11/2020	REV:																																									
							SUBMITTED BY: D.SCHOCK	DATE: 09/11/2020																																					

09/10/20 | 10:39 AM | CLMA
C:\PW\WORK\DEA\CHERIE.MATYAS\DWG\BRT-522-CMP201-210.DWG

MATCHLINE, SEE SHEET 522-CMP205

MATCHLINE, SEE SHEET 522-CMP207

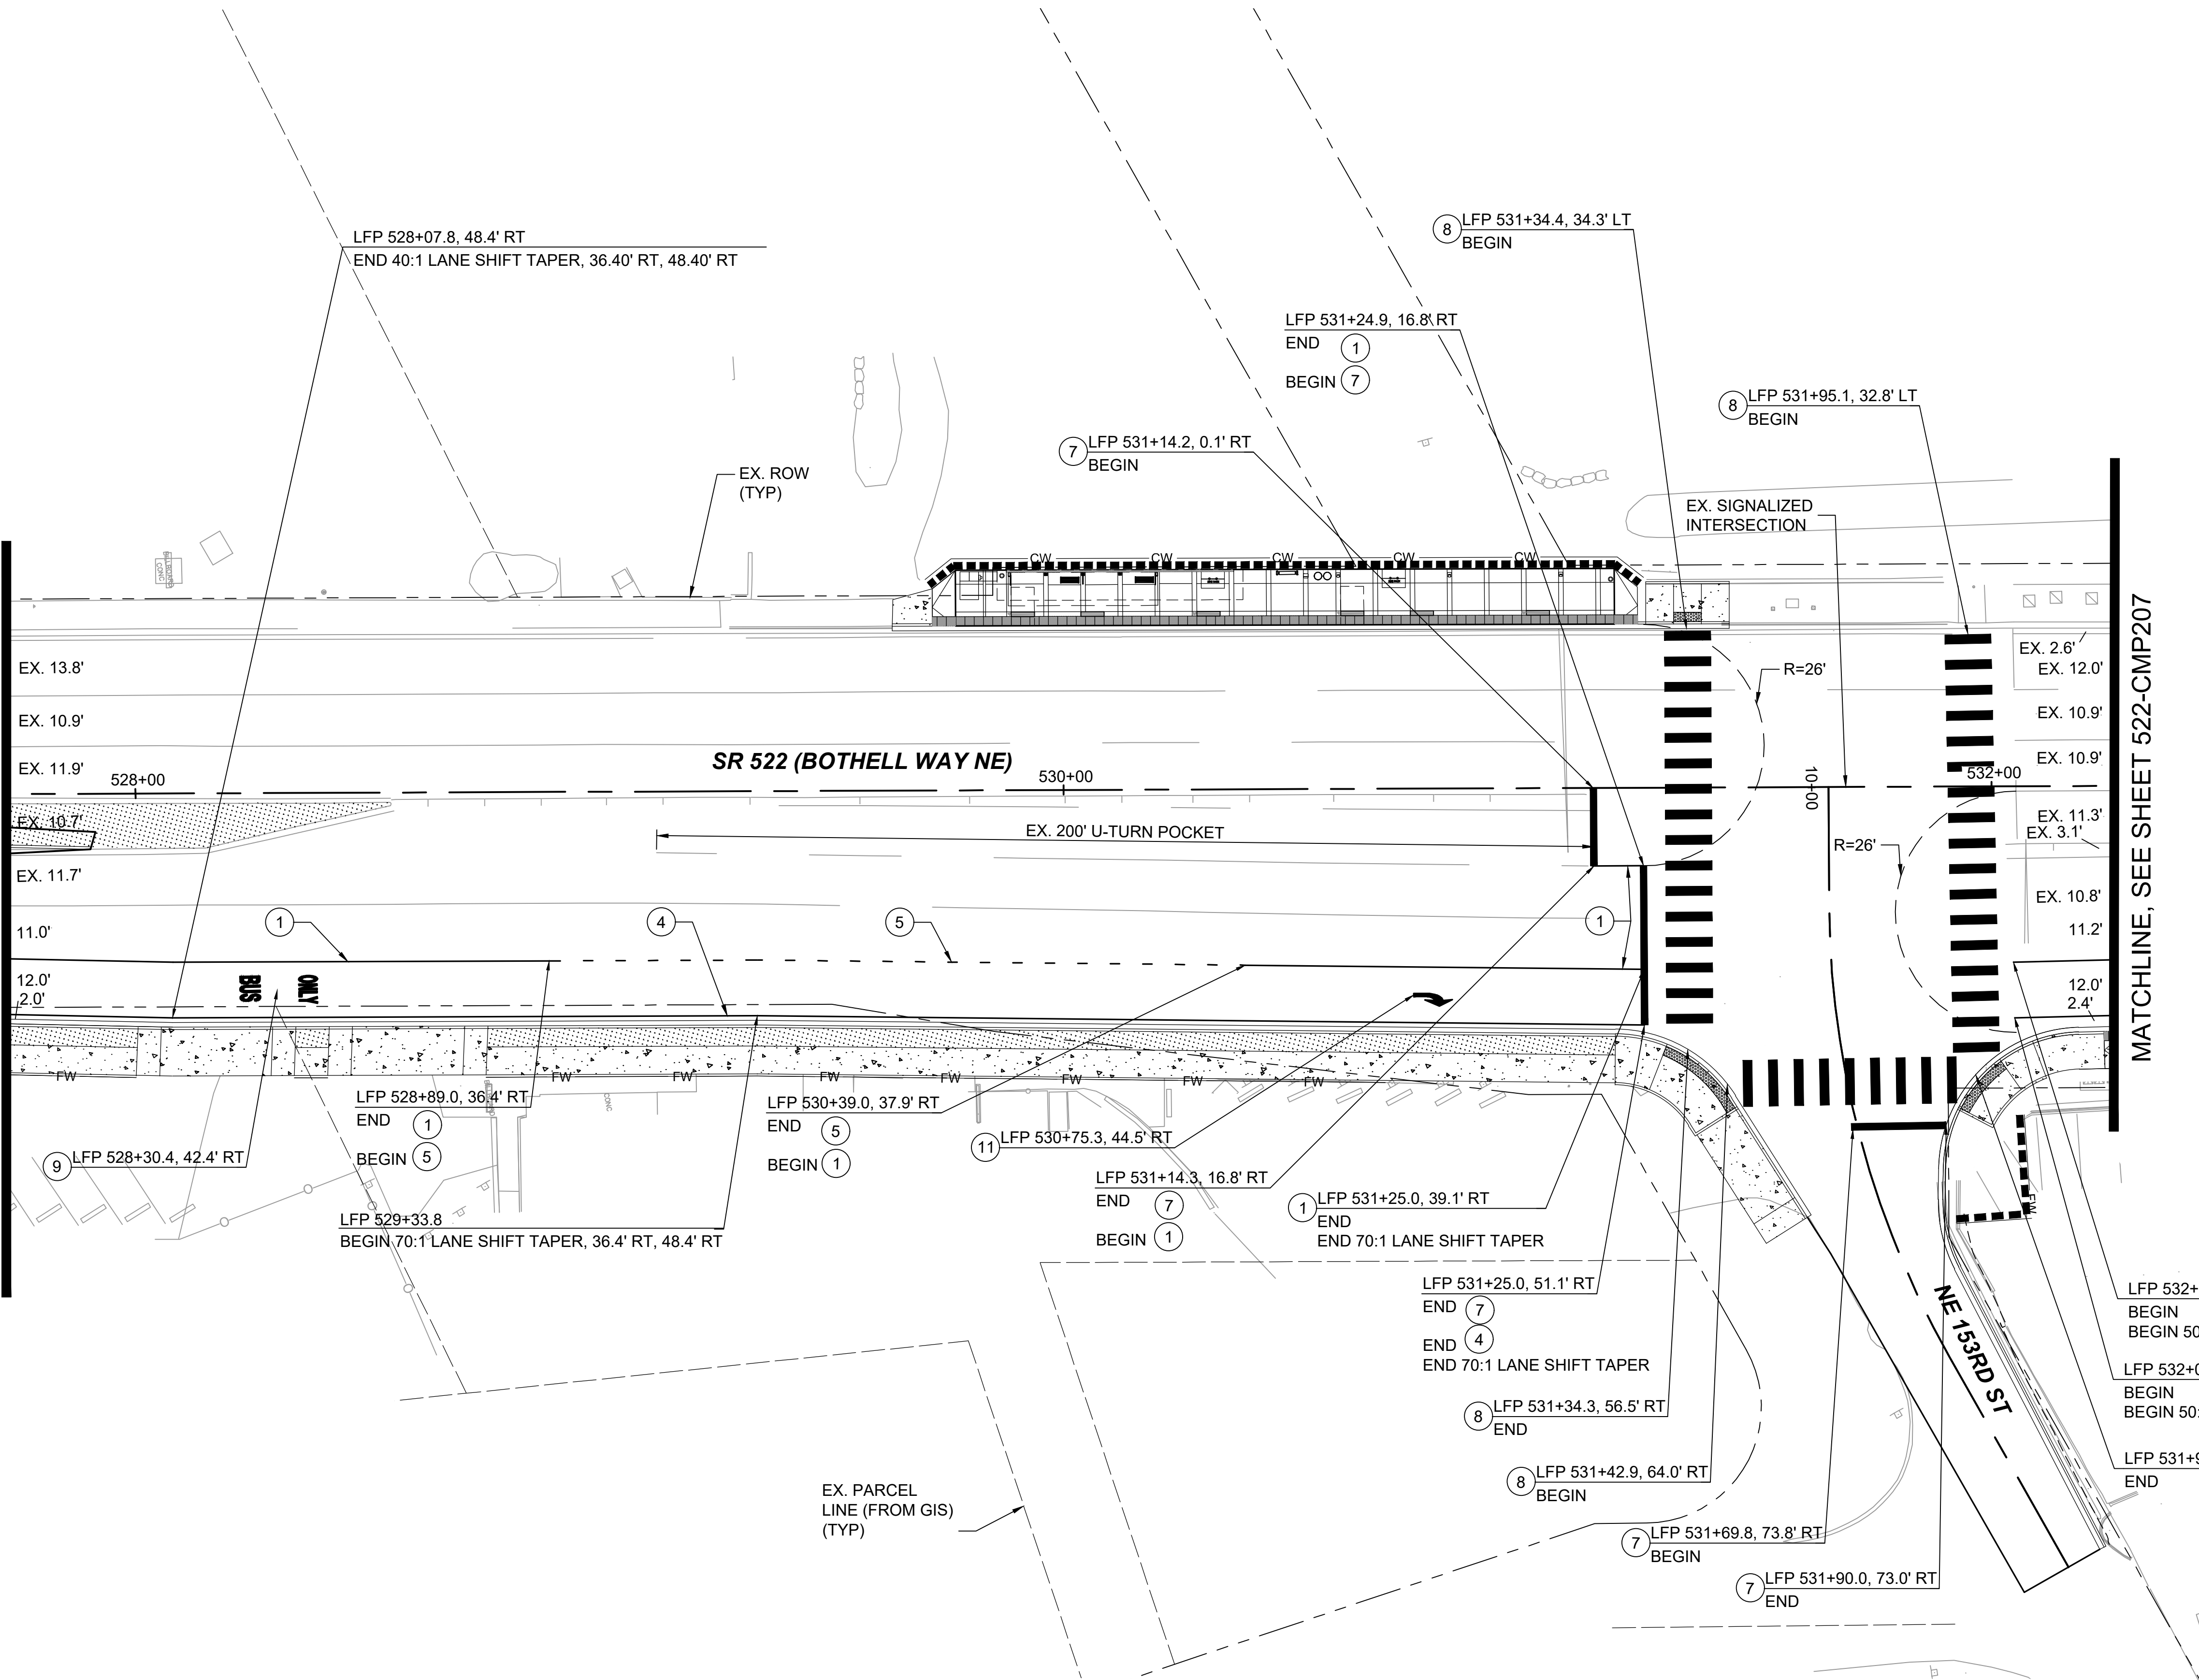


CHANNELIZATION NOTES:

- 1 WHITE WIDE LANE LINE PER WSDOT STD. PLAN M-20.10-02
- 2 WHITE LANE LINE PER WSDOT STD. PLAN M-20.10-02
- 3 YELLOW EDGE LINE PER WSDOT STD. PLAN M-20.10-02
- 4 WHITE EDGE LINE PER WSDOT STD. PLAN M-20.10-02
- 5 WHITE WIDE DOTTED EXTENSION LINE PER WSDOT STD. PLAN M-20.10-02
- 6 WHITE DOTTED EXTENSION LINE PER WSDOT STD. PLAN M-20.10-02
- 7 STOP LINE PER WSDOT STD. PLAN M-24.60-04
- 8 CROSSWALK LINE PER WSDOT STD. PLAN M-15.10-01
- 9 "BUS ONLY" HIGH SPEED TRAFFIC LETTERS PER WSDOT STD. PLAN M-80.10-01
- 10 TYPE 2SL TRAFFIC ARROW PER WSDOT STD. PLAN M-24.40-02
- 11 TYPE 2SR TRAFFIC ARROW PER WSDOT STD. PLAN M-24.40-02
- 12 WHITE DIAGONAL MARKING PER WSDOT STD. PLAN M-24.60-04, SPACED 3.5' ON CENTERS

GENERAL NOTES:

1. ONLY SIGNS THAT SHOW ACCESS CHANGES ARE INCLUDED IN THIS SET FOR INFORMATIONAL PURPOSES. FULL SIGNING PLANS WILL BE DEVELOPED POST 30% DESIGN.

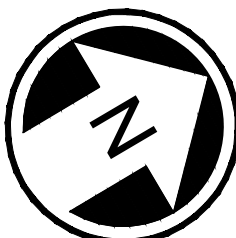

DRAFT 30% SUBMITTAL

DESIGNED BY:
C.MATYAS
DRAWN BY:
O.AHRENSFELD
CHECKED BY:
R.KOESTER
APPROVED BY:
M.FELIBERTI



DAVID EVANS
AND ASSOCIATES INC.
14432 SE Eastgate Way, Suite 400
Bellevue Washington 98007
Phone: 425.519.6500

SUBMITTED BY:
D.SCHOCK

DATE:
09/11/2020

REVIEWED BY:
B.KEMPER



DATE:
09/11/2020

SCALE:
1"=20'
FILENAME:
BRT-522-CMP201-210
CONTRACT No.:
AE 0055-17
DATE:
09/11/2020

SR 522 / NE 145TH BRT

SR 522 (BOTHELL WAY NE)

CIVIL
CHANNELIZATION & SIGNING PLAN
STA. 527+75 TO STA. 532+25

DRAWING No.:
522-CMP206
FACILITY ID:
522
SHEET No.:
168 OF 283
REV:

09/10/20 | 10:40 AM | CLMA
C:\PW\WORK\DEACHERIE\MATYAS\DWG\BRT-522-CMP201-210.DWG

MATCHLINE, SEE SHEET 522-CMP207

MATCHLINE, SEE SHEET 522-CMP209

CHANNELIZATION NOTES:

- 1 WHITE WIDE LANE LINE PER WSDOT STD. PLAN M-20.10-02
- 2 WHITE LANE LINE PER WSDOT STD. PLAN M-20.10-02
- 3 YELLOW EDGE LINE PER WSDOT STD. PLAN M-20.10-02
- 4 WHITE EDGE LINE PER WSDOT STD. PLAN M-20.10-02
- 5 WHITE WIDE DOTTED EXTENSION LINE PER WSDOT STD. PLAN M-20.10-02
- 6 WHITE DOTTED EXTENSION LINE PER WSDOT STD. PLAN M-20.10-02
- 7 STOP LINE PER WSDOT STD. PLAN M-24.60-04
- 8 CROSSWALK LINE PER WSDOT STD. PLAN M-15.10-01
- 9 "BUS ONLY" HIGH SPEED TRAFFIC LETTERS PER WSDOT STD. PLAN M-80.10-01
- 10 TYPE 2SL TRAFFIC ARROW PER WSDOT STD. PLAN M-24.40-02
- 11 TYPE 2SR TRAFFIC ARROW PER WSDOT STD. PLAN M-24.40-02
- 12 WHITE DIAGONAL MARKING PER WSDOT STD. PLAN M-24.60-04, SPACED 3.5' ON CENTERS


GENERAL NOTES:

1. ONLY SIGNS THAT SHOW ACCESS CHANGES ARE INCLUDED IN THIS SET FOR INFORMATIONAL PURPOSES. FULL SIGNING PLANS WILL BE DEVELOPED POST 30% DESIGN.

SIGNAGE LEGEND:



- R3-2 NO LEFT TURN
SIGN

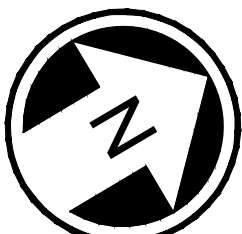

DRAFT 30% SUBMITTAL

No.	DATE	DSN	CHK	APP	REVISION

DESIGNED BY:
C.MATYAS
DRAWN BY:
O.AHRENSFELD
CHECKED BY:
R.KOESTER
APPROVED BY:
M.FELIBERTI



DAVID EVANS
AND ASSOCIATES INC.
14432 SE Eastgate Way, Suite 400
Bellevue Washington 98007
Phone: 425.519.6500

SUBMITTED BY:
D.SCHOCK

DATE:
09/11/2020

REVIEWED BY:
B.KEMPER



DATE:
09/11/2020

SCALE:
1"=20'
FILENAME:
BRT-522-CMP201-210
CONTRACT No.:
AE 0055-17
DATE:
09/11/2020

SR 522 / NE 145TH BRT

SR 522 (BOTHELL WAY NE)

CIVIL
CHANNELIZATION & SIGNING PLAN
STA. 536+75 TO STA. 541+25

DRAWING No.:

522-CMP208

FACILITY ID:


522

SHEET No.:

170 OF 283

REV:

09/10/20 | 10:40 AM | CLMA
C:\PW_WORK\DEACHERIE MATYAS\DWG\BRT-522-CMP201-210.DWG

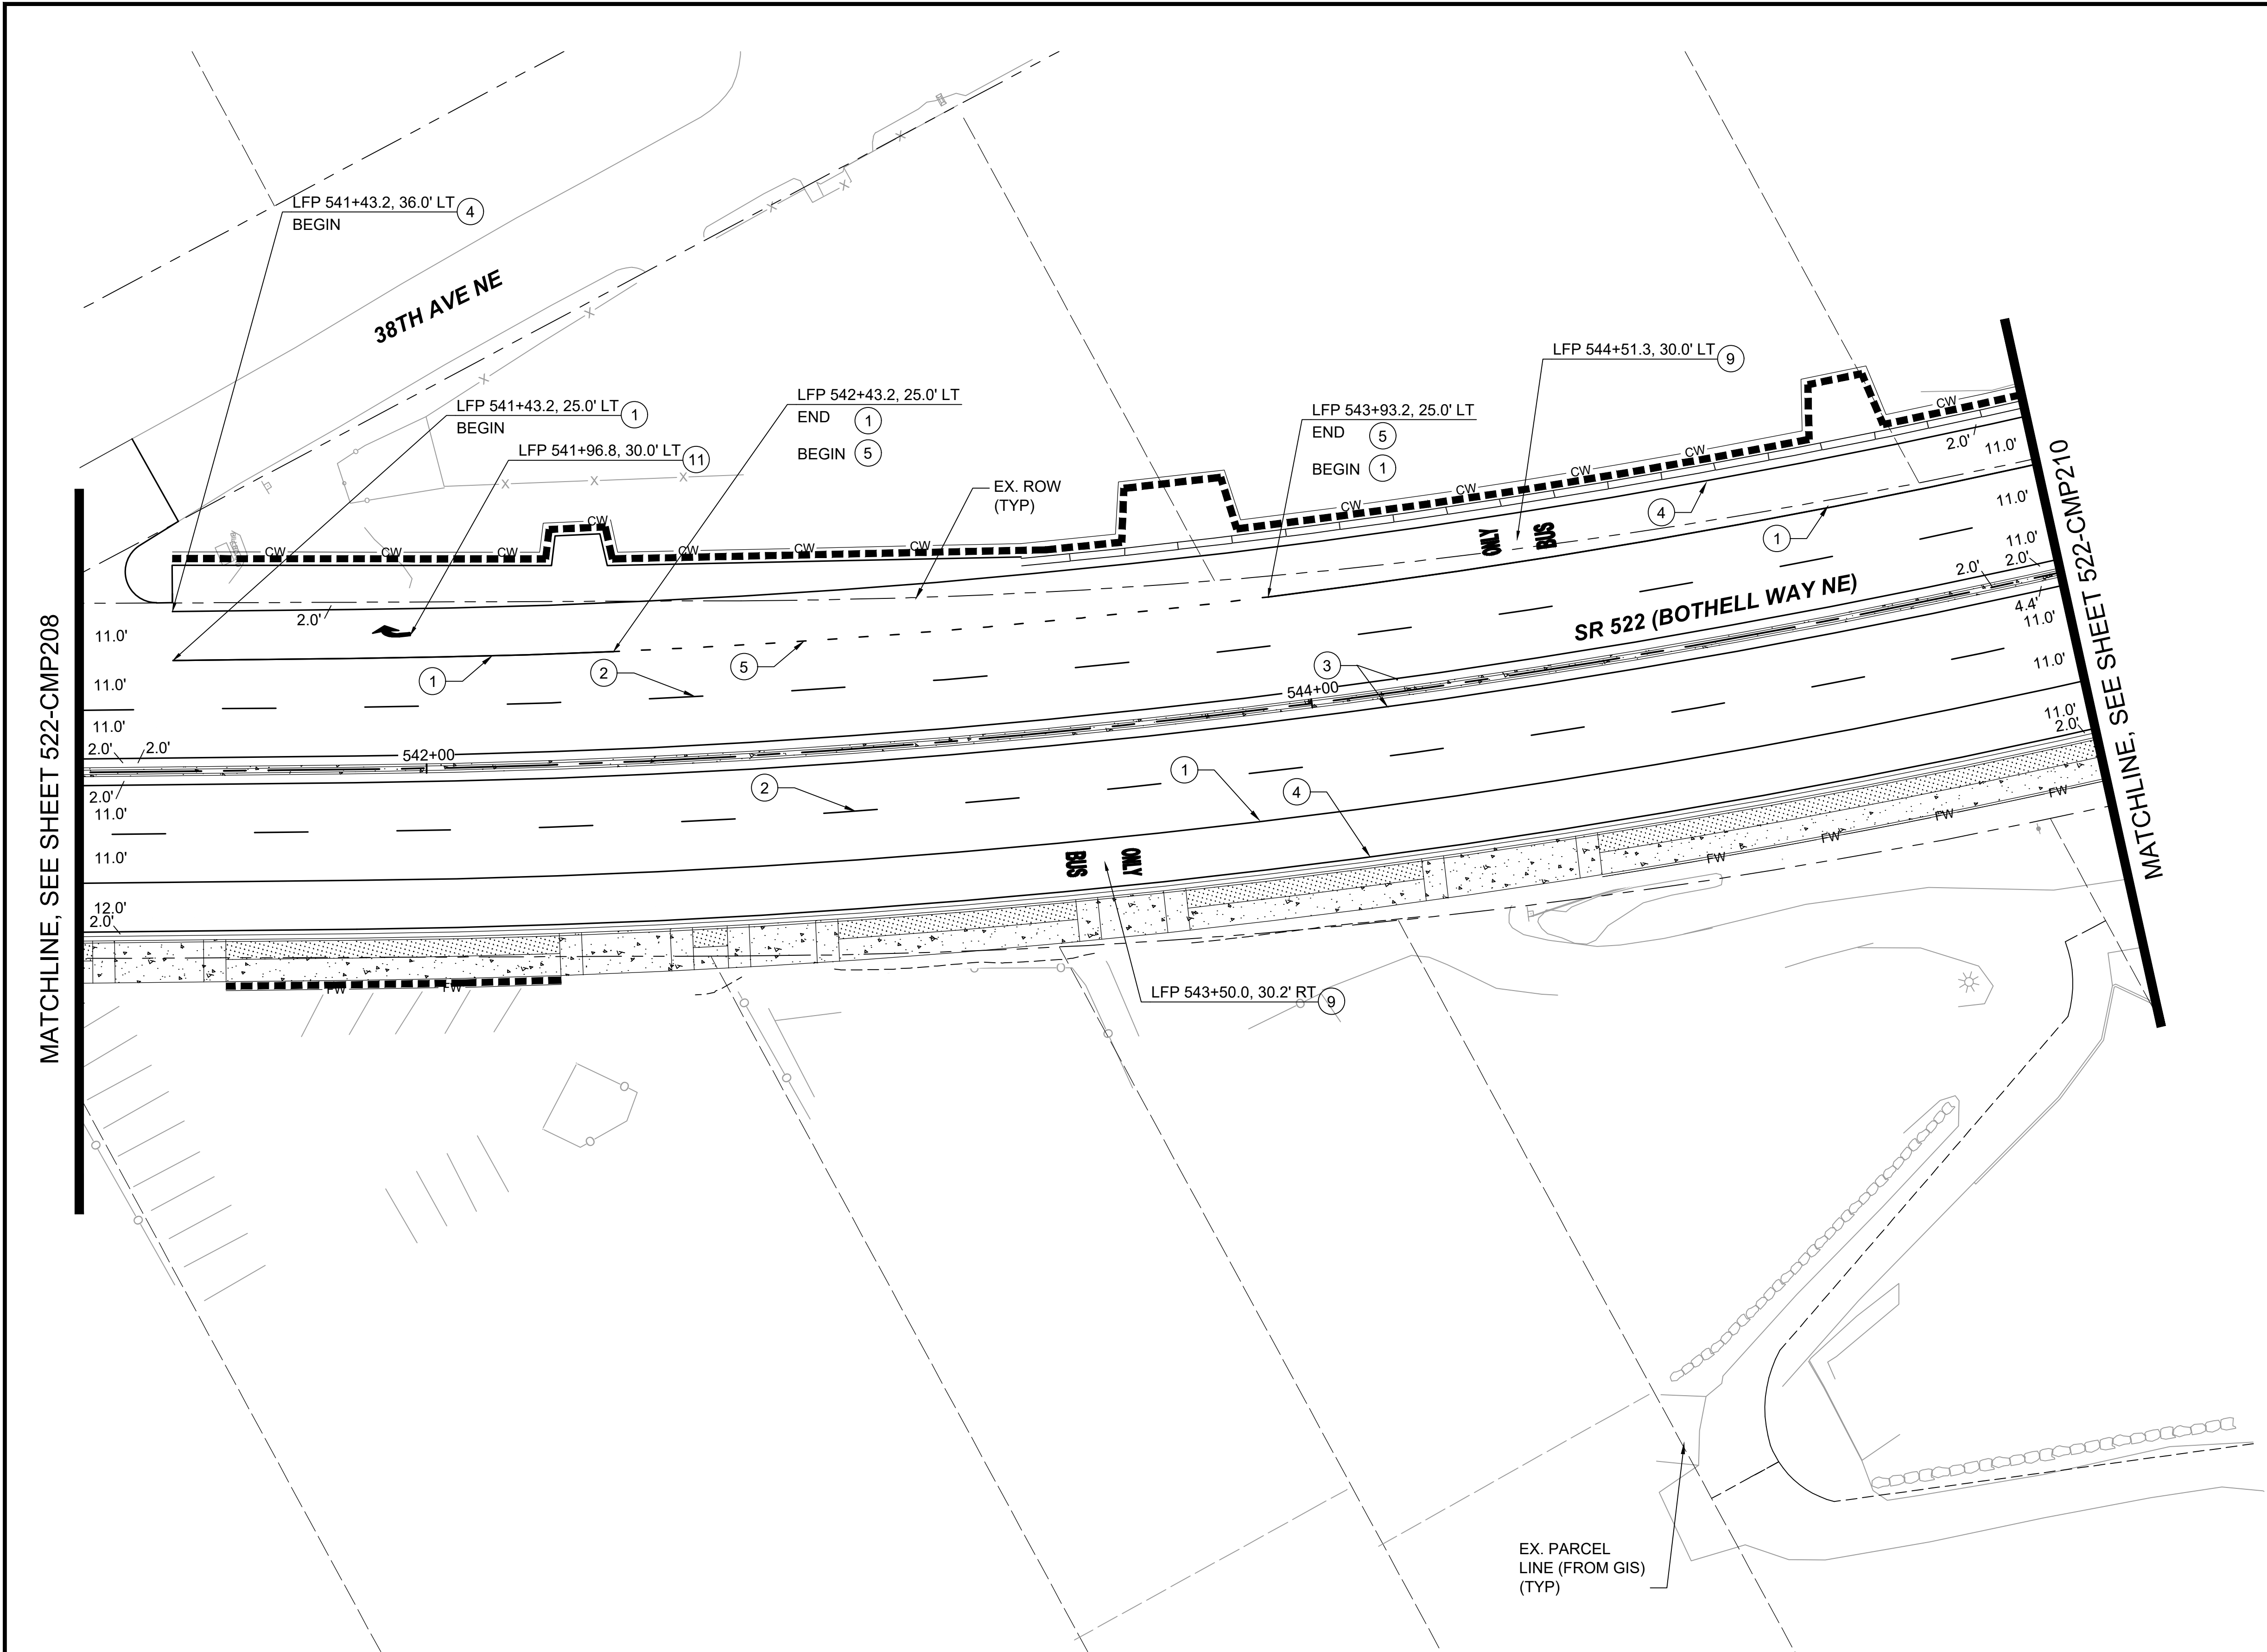

CHANNELIZATION NOTES:

- 1 WHITE WIDE LANE LINE PER WSDOT STD. PLAN M-20.10-02
- 2 WHITE LANE LINE PER WSDOT STD. PLAN M-20.10-02
- 3 YELLOW EDGE LINE PER WSDOT STD. PLAN M-20.10-02
- 4 WHITE EDGE LINE PER WSDOT STD. PLAN M-20.10-02
- 5 WHITE WIDE DOTTED EXTENSION LINE PER WSDOT STD. PLAN M-20.10-02
- 6 WHITE DOTTED EXTENSION LINE PER WSDOT STD. PLAN M-20.10-02
- 7 STOP LINE PER WSDOT STD. PLAN M-24.60-04
- 8 CROSSWALK LINE PER WSDOT STD. PLAN M-15.10-01
- 9 "BUS ONLY" HIGH SPEED TRAFFIC LETTERS PER WSDOT STD. PLAN M-80.10-01
- 10 TYPE 2SL TRAFFIC ARROW PER WSDOT STD. PLAN M-24.40-02
- 11 TYPE 2SR TRAFFIC ARROW PER WSDOT STD. PLAN M-24.40-02
- 12 WHITE DIAGONAL MARKING PER WSDOT STD. PLAN M-24.60-04, SPACED 3.5' ON CENTERS

GENERAL NOTES:

1. ONLY SIGNS THAT SHOW ACCESS CHANGES ARE INCLUDED IN THIS SET FOR INFORMATIONAL PURPOSES. FULL SIGNING PLANS WILL BE DEVELOPED POST 30% DESIGN.

DRAFT 30% SUBMITTAL


No.	DATE	DSN	CHK	APP	REVISION

DESIGNED BY:	C.MATYAS
DRAWN BY:	O.AHRENSFELD
CHECKED BY:	R.KOESTER
APPROVED BY:	M.FELIBERTI



**DAVID EVANS
AND ASSOCIATES INC.**
14432 SE Eastgate Way, Suite 400
Bellevue Washington 98007
Phone: 425.519.6500

SUBMITTED BY:	DATE:	REVIEWED BY:	DATE:
D.SCHOCK	09/11/2020	B.KEMPER	09/11/2020

 

SCALE:	1"=20'
FILENAME:	BRT-522-CMP201-210
CONTRACT No.:	AE 0055-17
DATE:	09/11/2020


SR 522 / NE 145TH BRT

SR 522 (BOTHELL WAY NE)

CIVIL
CHANNELIZATION & SIGNING PLAN
STA. 541+25 TO STA. 545+75

DRAWING No.:	522-CMP209
FACILITY ID:	522
SHEET No.:	171 OF 283

09/10/20 | 10:40 AM | CLMA
C:\PW_WORK\DEACHERIE\MATYAS\DWG\BRT-522-CMP201-210.DWG

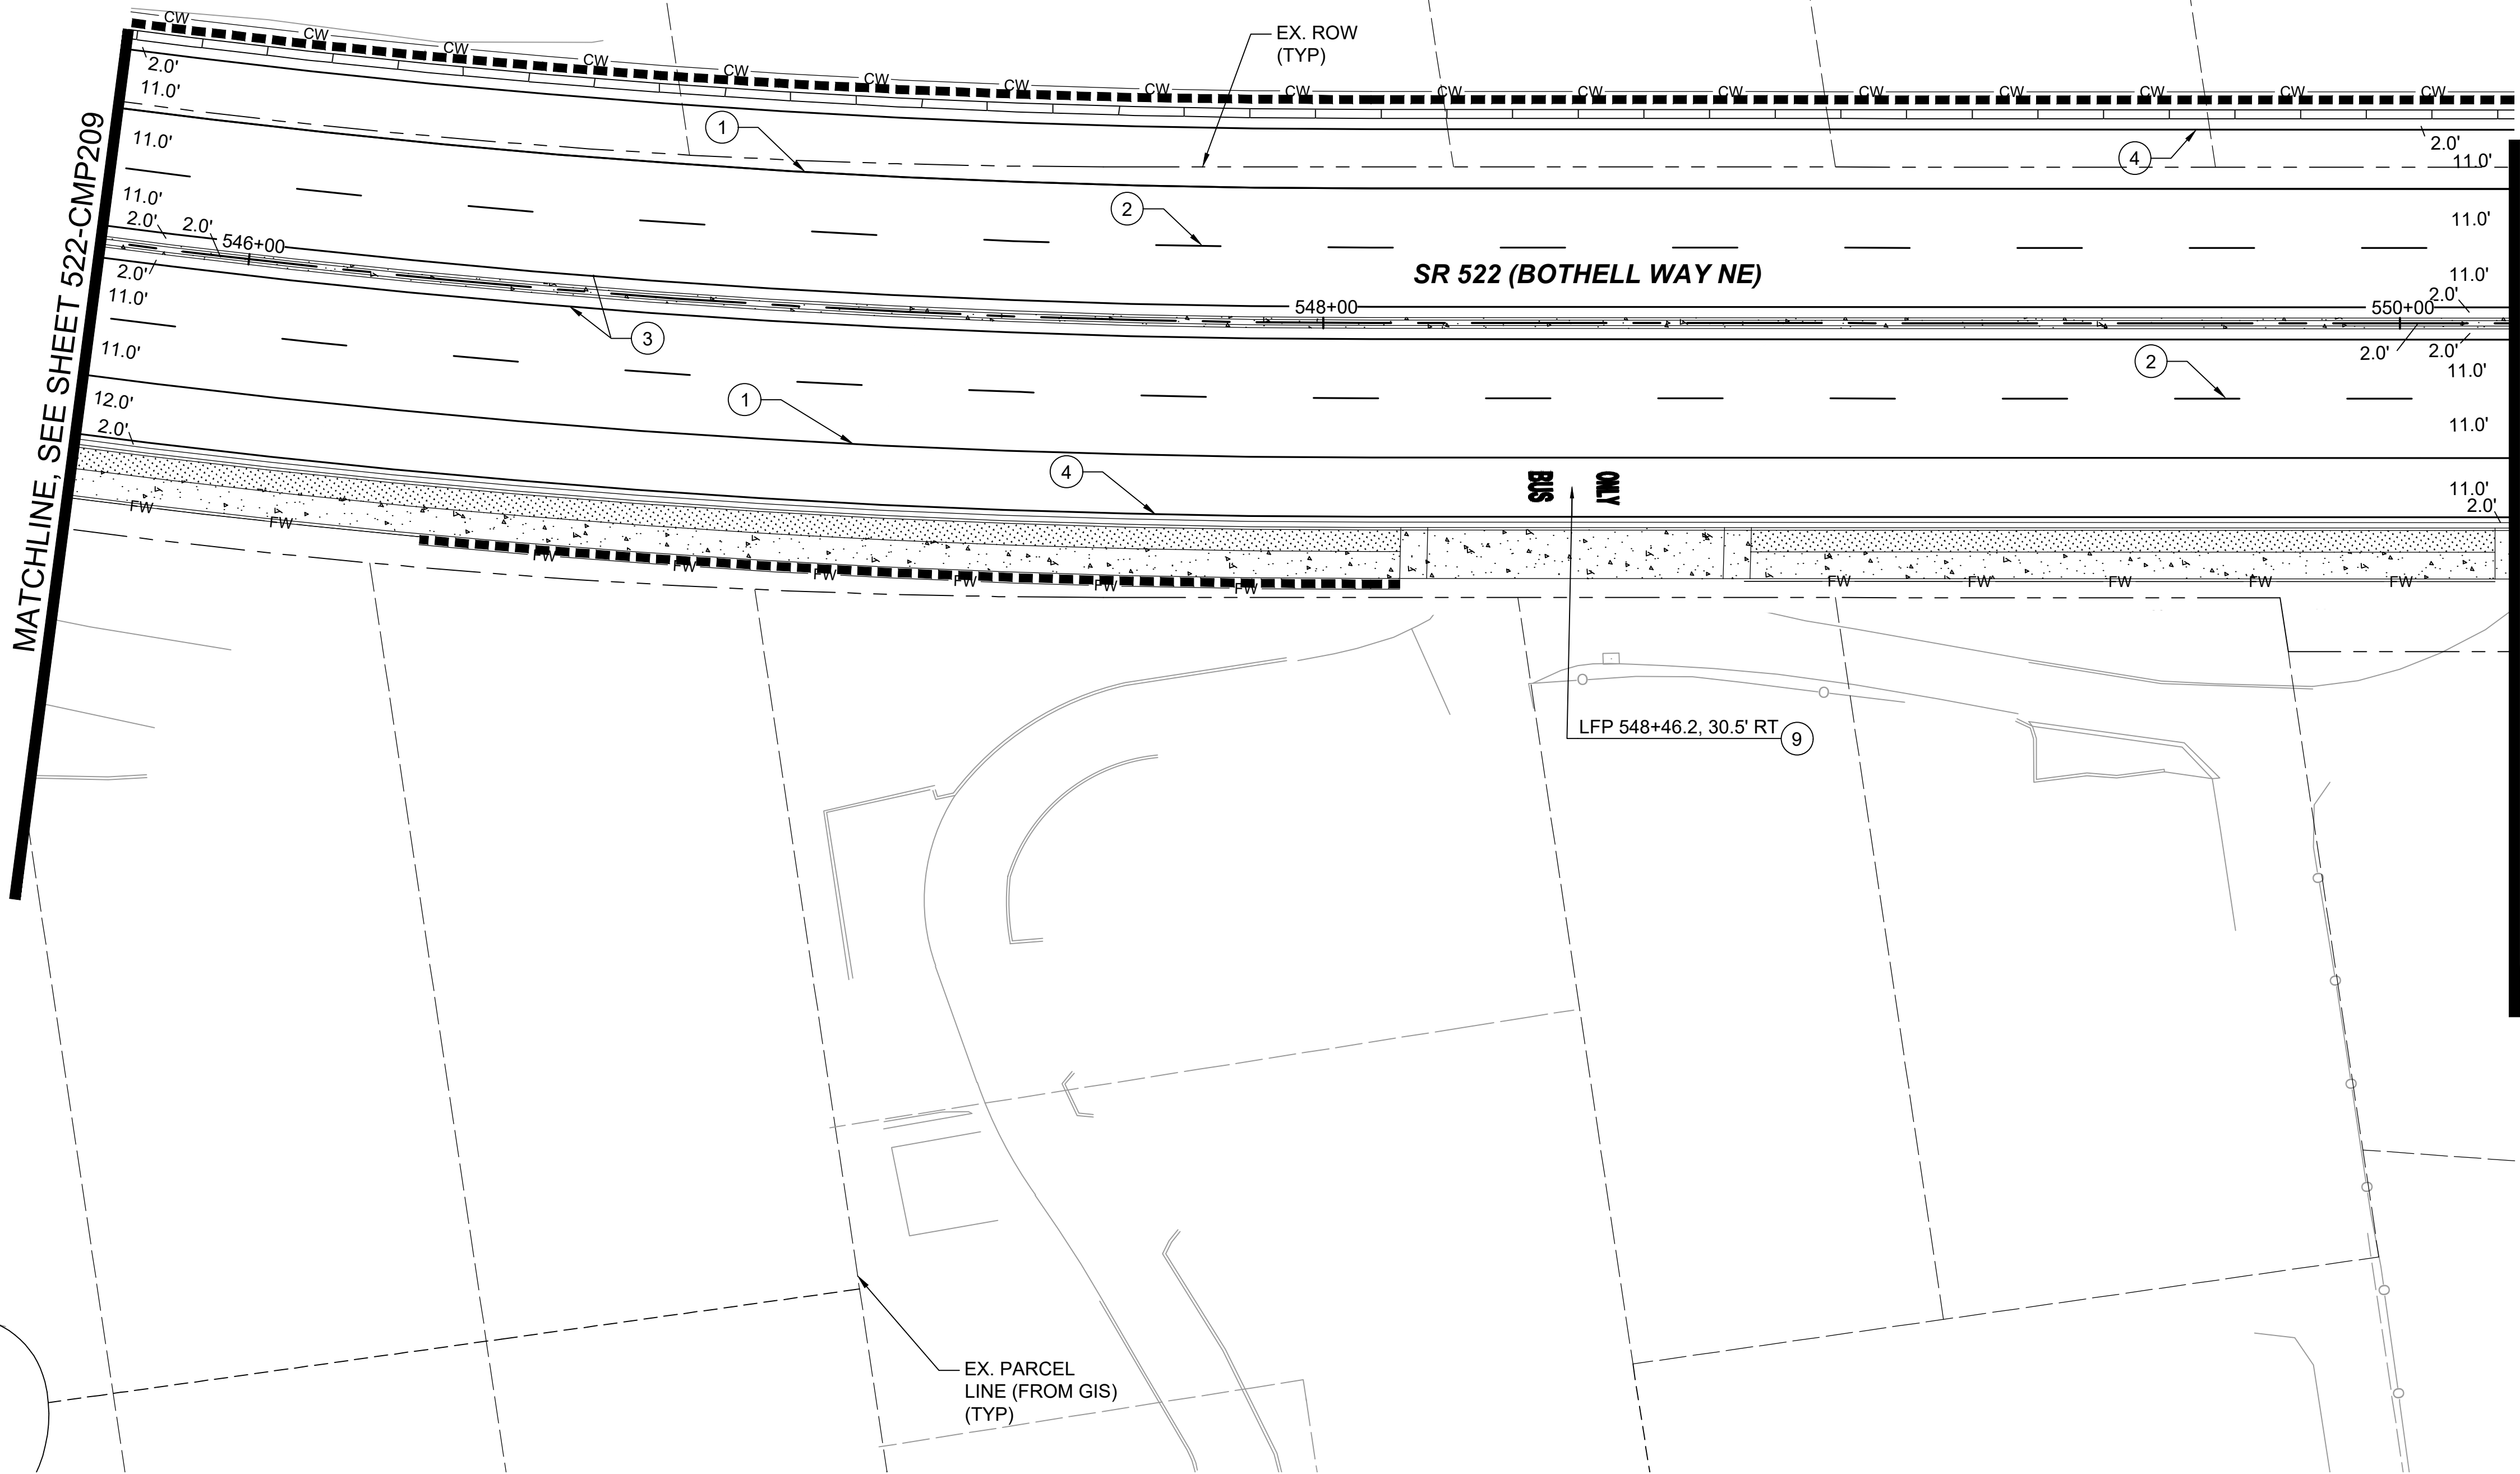

CHANNELIZATION NOTES:

- 1 WHITE WIDE LANE LINE PER WSDOT STD. PLAN M-20.10-02
- 2 WHITE LANE LINE PER WSDOT STD. PLAN M-20.10-02
- 3 YELLOW EDGE LINE PER WSDOT STD. PLAN M-20.10-02
- 4 WHITE EDGE LINE PER WSDOT STD. PLAN M-20.10-02
- 5 WHITE WIDE DOTTED EXTENSION LINE PER WSDOT STD. PLAN M-20.10-02
- 6 WHITE DOTTED EXTENSION LINE PER WSDOT STD. PLAN M-20.10-02
- 7 STOP LINE PER WSDOT STD. PLAN M-24.60-04
- 8 CROSSWALK LINE PER WSDOT STD. PLAN M-15.10-01
- 9 "BUS ONLY" HIGH SPEED TRAFFIC LETTERS PER WSDOT STD. PLAN M-80.10-01
- 10 TYPE 2SL TRAFFIC ARROW PER WSDOT STD. PLAN M-24.40-02
- 11 TYPE 2SR TRAFFIC ARROW PER WSDOT STD. PLAN M-24.40-02
- 12 WHITE DIAGONAL MARKING PER WSDOT STD. PLAN M-24.60-04, SPACED 3.5' ON CENTERS

GENERAL NOTES:

1. ONLY SIGNS THAT SHOW ACCESS CHANGES ARE INCLUDED IN THIS SET FOR INFORMATIONAL PURPOSES. FULL SIGNING PLANS WILL BE DEVELOPED POST 30% DESIGN.

DRAFT 30% SUBMITTAL

DESIGNED BY:
C.MATYAS
DRAWN BY:
O.AHRENSFELD
CHECKED BY:
R.KOESTER
APPROVED BY:
M.FELIBERTI



DAVID EVANS AND ASSOCIATES INC.
14432 SE Eastgate Way, Suite 400
Bellevue Washington 98007
Phone: 425.519.6500

SUBMITTED BY:
D.SCHOCK

DATE:
09/11/2020

REVIEWED BY:
B.KEMPER



DATE:
09/11/2020

SCALE:
1"=20'
FILENAME:
BRT-522-CMP201-210
CONTRACT No.:
AE 0055-17
DATE:
09/11/2020


SR 522 / NE 145TH BRT
SR 522 (BOTHELL WAY NE)
CIVIL
CHANNELIZATION & SIGNING PLAN
STA. 545+75 TO STA. 550+25

DRAWING No.:
522-CMP210
FACILITY ID:
522
SHEET No.:
172 OF 283

09/10/20 | 10:41 AM | CLMA
C:\PW\WORK\DEACHERIE\MATYAS\DWG\BRT-522-CMP211-220.DWG

MATCHLINE, SEE SHEET 522-CMP210

MATCHLINE, SEE SHEET 522-CMP212

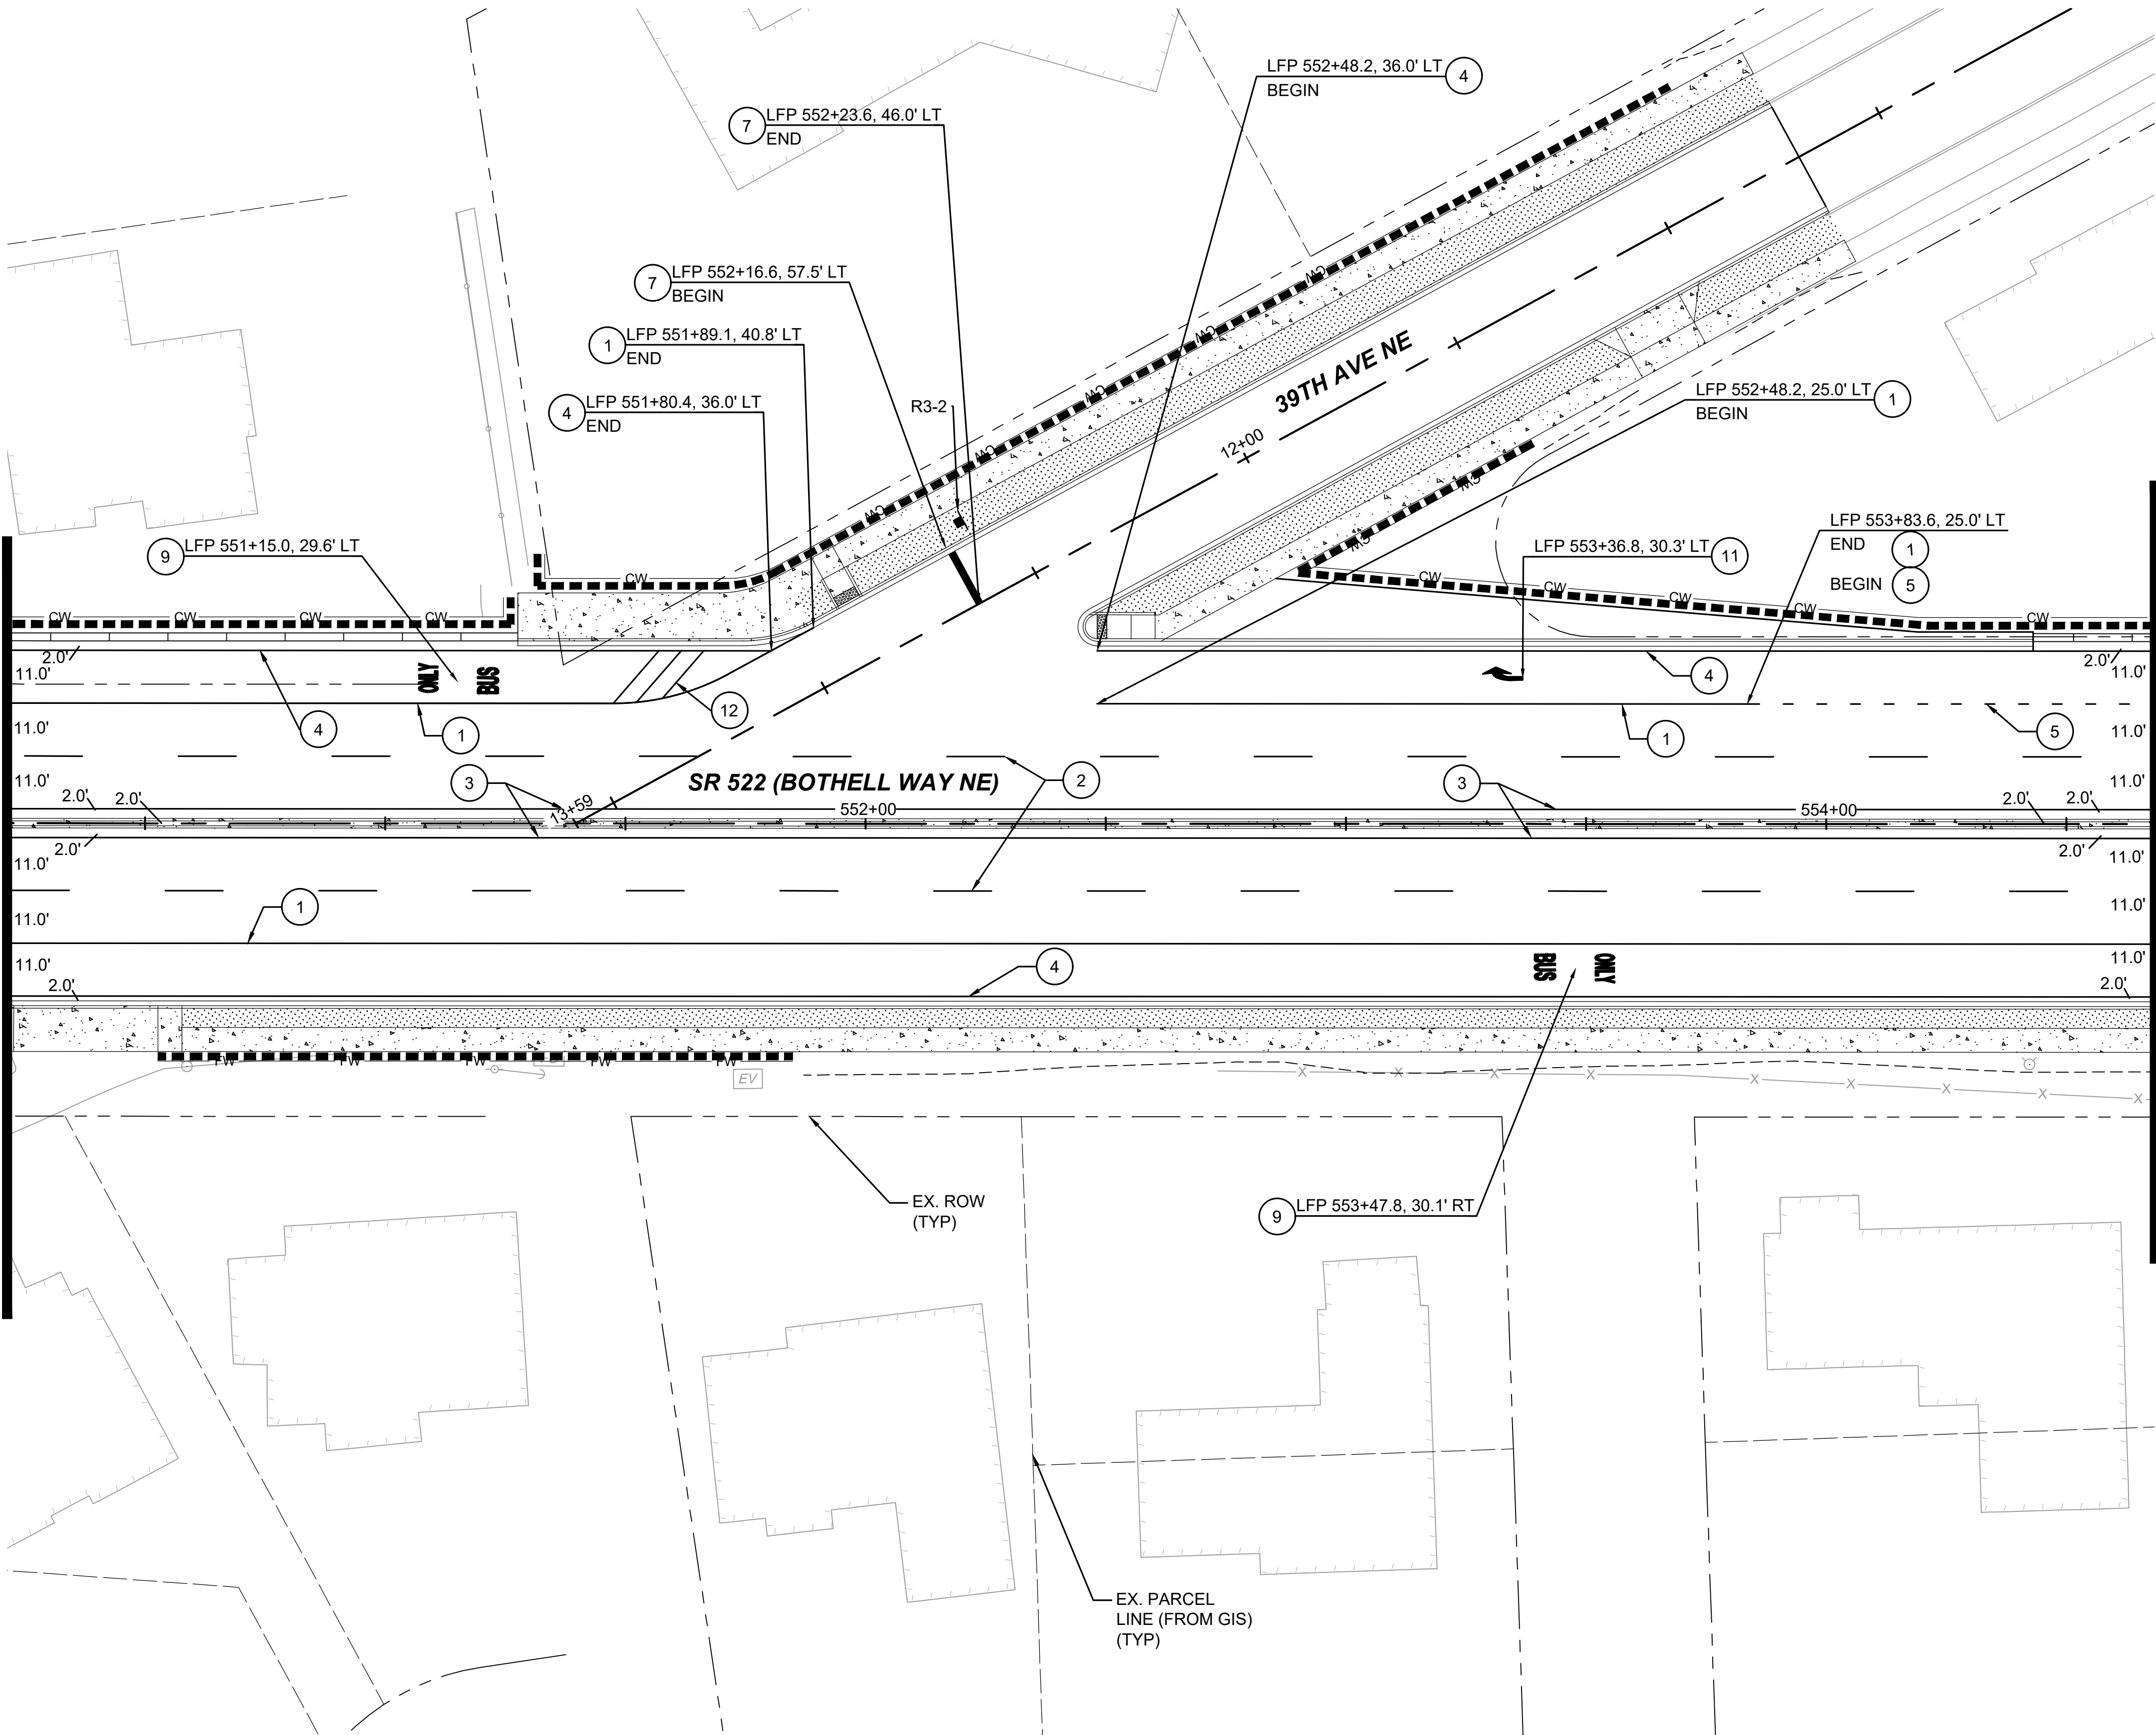

CHANNELIZATION NOTES:

- 1 WHITE WIDE LANE LINE PER WSDOT STD. PLAN M-20.10-02
- 2 WHITE LANE LINE PER WSDOT STD. PLAN M-20.10-02
- 3 YELLOW EDGE LINE PER WSDOT STD. PLAN M-20.10-02
- 4 WHITE EDGE LINE PER WSDOT STD. PLAN M-20.10-02
- 5 WHITE WIDE DOTTED EXTENSION LINE PER WSDOT STD. PLAN M-20.10-02
- 6 WHITE DOTTED EXTENSION LINE PER WSDOT STD. PLAN M-20.10-02
- 7 STOP LINE PER WSDOT STD. PLAN M-24.60-04
- 8 CROSSWALK LINE PER WSDOT STD. PLAN M-15.10-01
- 9 "BUS ONLY" HIGH SPEED TRAFFIC LETTERS PER WSDOT STD. PLAN M-80.10-01
- 10 TYPE 2SL TRAFFIC ARROW PER WSDOT STD. PLAN M-24.40-02
- 11 TYPE 2SR TRAFFIC ARROW PER WSDOT STD. PLAN M-24.40-02
- 12 WHITE DIAGONAL MARKING PER WSDOT STD. PLAN M-24.60-04, SPACED 3.5' ON CENTERS


GENERAL NOTES:

1. ONLY SIGNS THAT SHOW ACCESS CHANGES ARE INCLUDED IN THIS SET FOR INFORMATIONAL PURPOSES. FULL SIGNING PLANS WILL BE DEVELOPED POST 30% DESIGN.

SIGNAGE LEGEND:



- R3-2 NO LEFT TURN
- SIGN

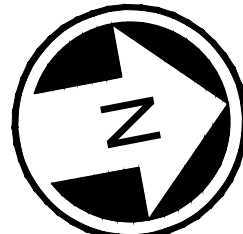

DRAFT 30% SUBMITTAL

No.	DATE	DSN	CHK	APP	REVISION

DESIGNED BY:
C.MATYAS
DRAWN BY:
O.AHRENSFELD
CHECKED BY:
R.KOESTER
APPROVED BY:
M.FELIBERTI



DAVID EVANS
AND ASSOCIATES INC.
14432 SE Eastgate Way, Suite 400
Bellevue Washington 98007
Phone: 425.519.6500

LINE IS 1" AT
FULL SCALE



SCALE:
1"=20'
FILENAME:
BRT-522-CMP211-220
CONTRACT No.:
AE 0055-17
DATE:
09/11/2020

SR 522 / NE 145TH BRT

SR 522 (BOTHELL WAY NE)

CIVIL
CHANNELIZATION & SIGNING PLAN
STA. 550+25 TO STA. 554+75

DRAWING No.:
522-CMP211
FACILITY ID:
522
SHEET No.:
173 OF 283
REV:

SUBMITTED BY:
D.SCHOCK


DATE:
09/11/2020

REVIEWED BY:
B.KEMPER

DATE:
09/11/2020

09/10/20 | 10:41 AM | CLMA
C:\PW_WORK\DEACHERIE\MATYAS\DWG\BRT-522-CMP211-220.DWG

MATCHLINE, SEE SHEET 522-CMP211

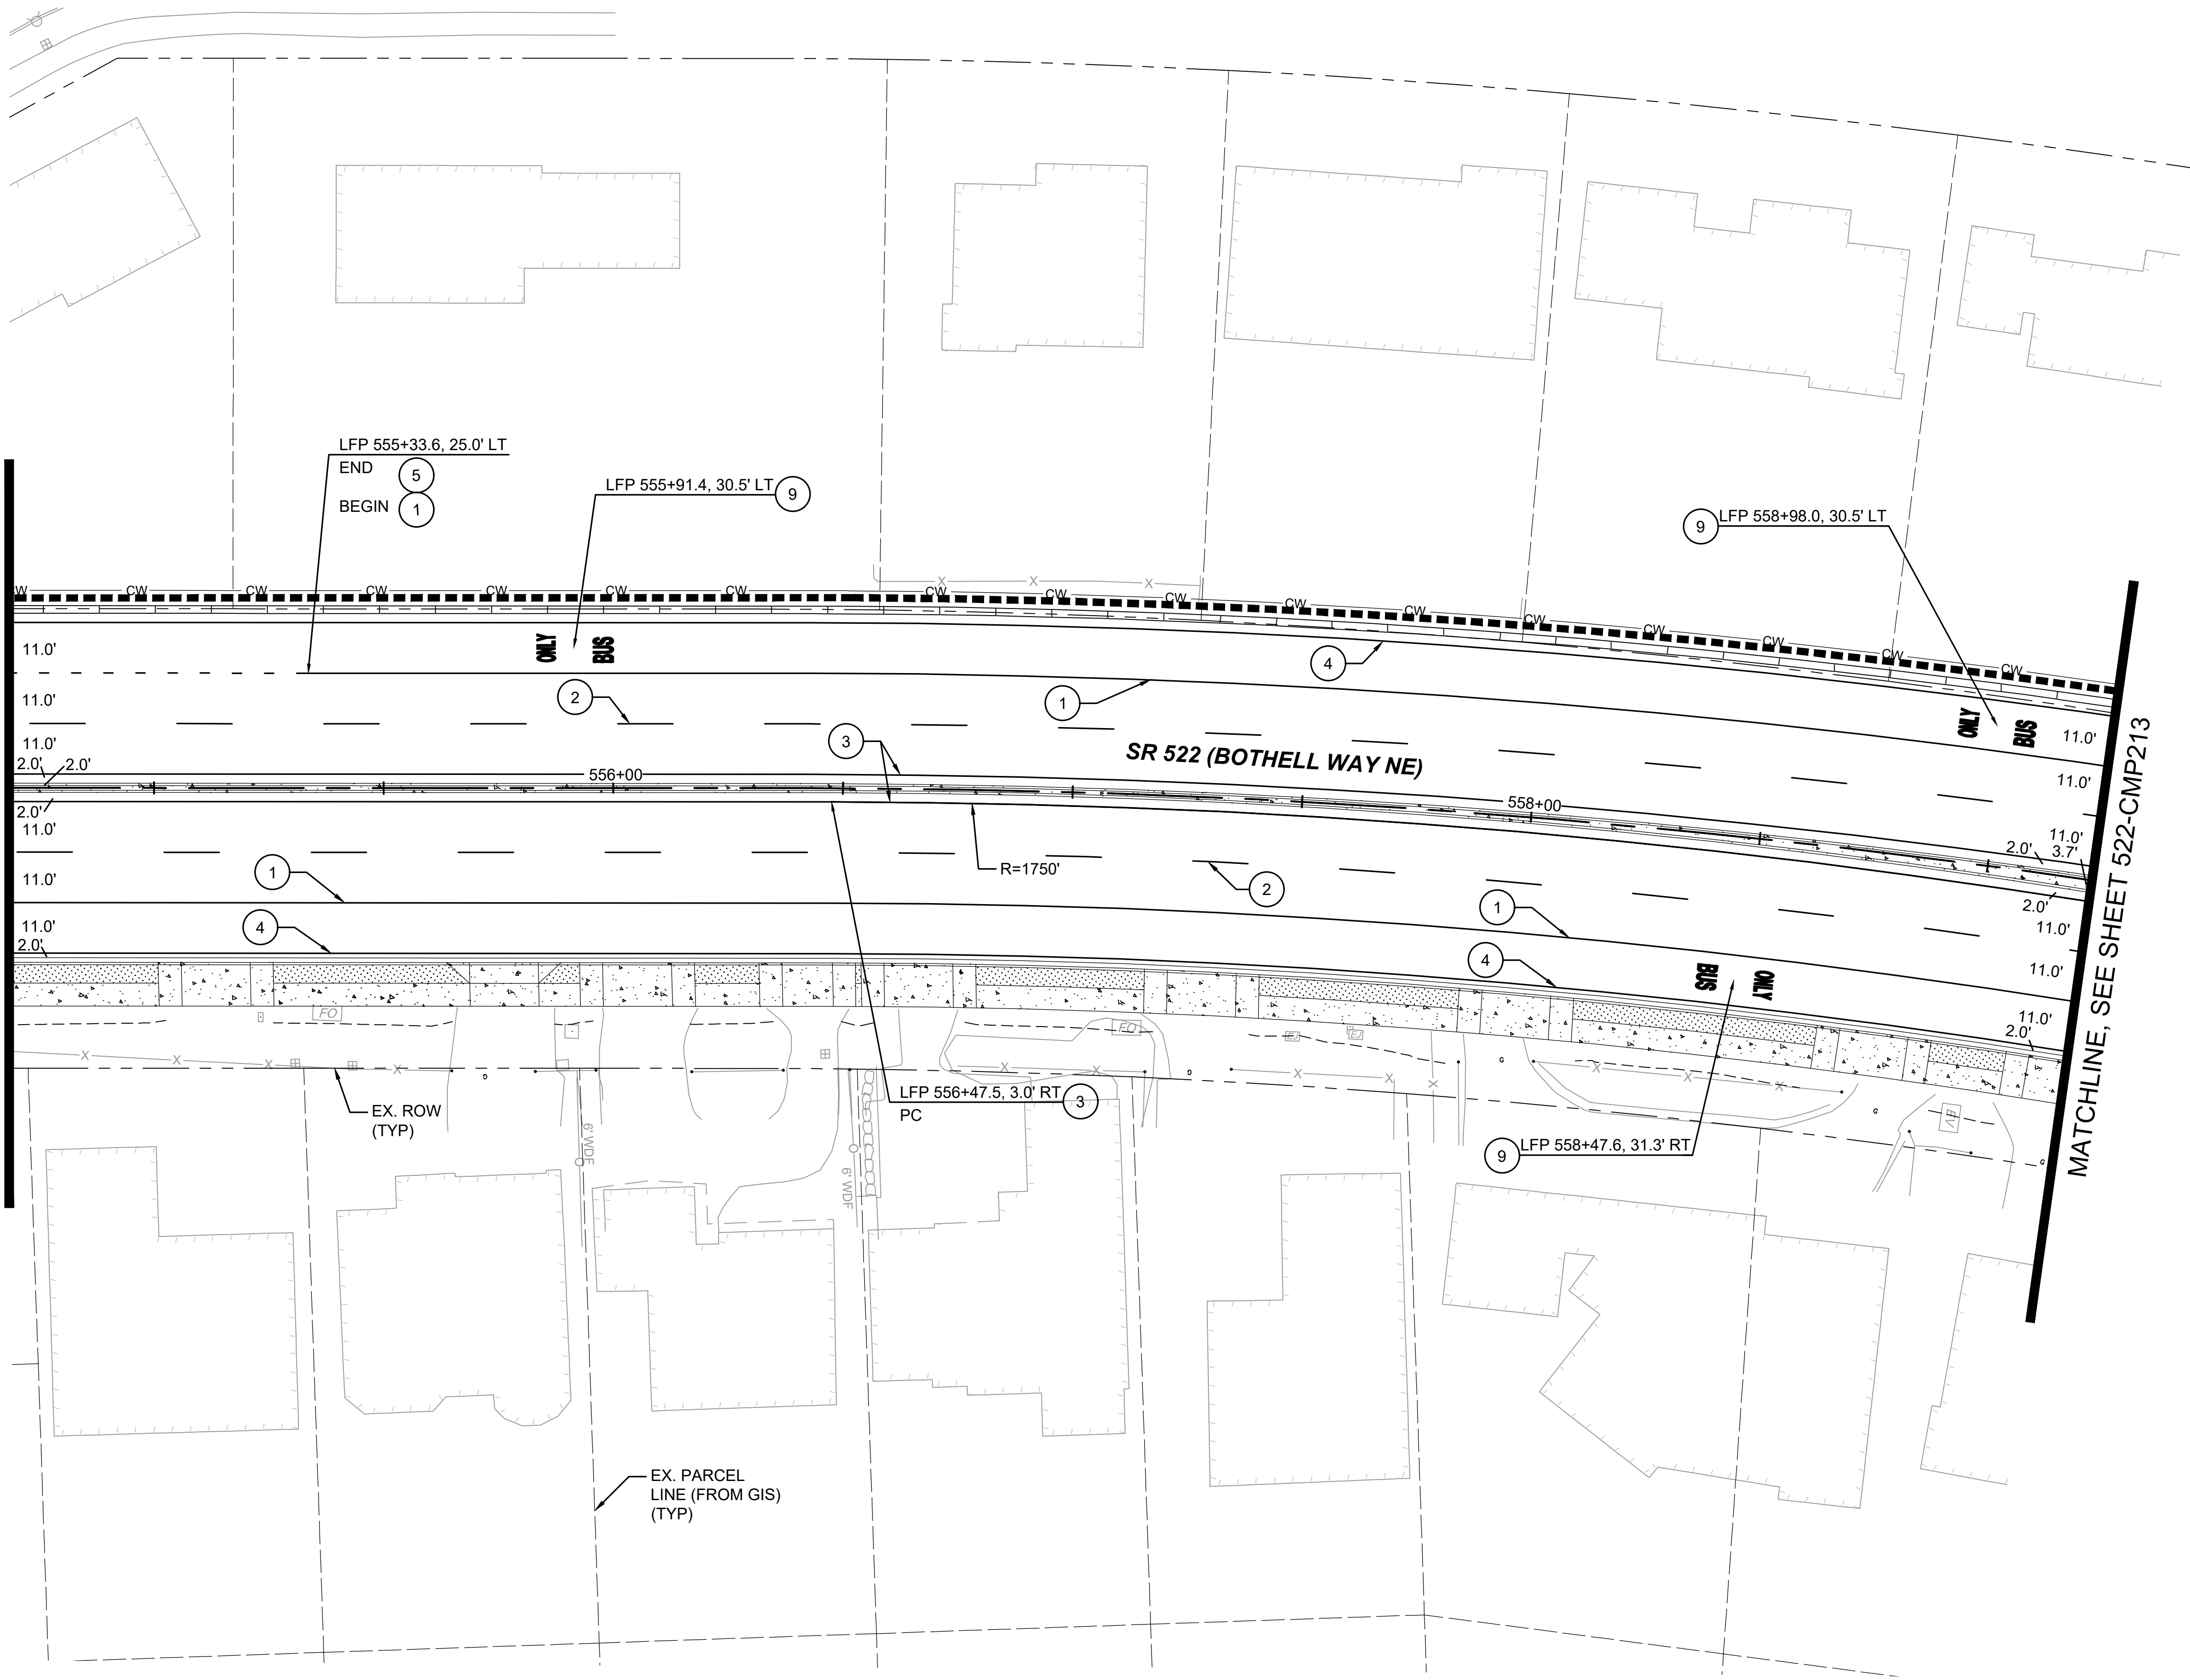

CHANNELIZATION NOTES:

- 1 WHITE WIDE LANE LINE PER WSDOT STD. PLAN M-20.10-02
- 2 WHITE LANE LINE PER WSDOT STD. PLAN M-20.10-02
- 3 YELLOW EDGE LINE PER WSDOT STD. PLAN M-20.10-02
- 4 WHITE EDGE LINE PER WSDOT STD. PLAN M-20.10-02
- 5 WHITE WIDE DOTTED EXTENSION LINE PER WSDOT STD. PLAN M-20.10-02
- 6 WHITE DOTTED EXTENSION LINE PER WSDOT STD. PLAN M-20.10-02
- 7 STOP LINE PER WSDOT STD. PLAN M-24.60-04
- 8 CROSSWALK LINE PER WSDOT STD. PLAN M-15.10-01
- 9 "BUS ONLY" HIGH SPEED TRAFFIC LETTERS PER WSDOT STD. PLAN M-80.10-01
- 10 TYPE 2SL TRAFFIC ARROW PER WSDOT STD. PLAN M-24.40-02
- 11 TYPE 2SR TRAFFIC ARROW PER WSDOT STD. PLAN M-24.40-02
- 12 WHITE DIAGONAL MARKING PER WSDOT STD. PLAN M-24.60-04, SPACED 3.5' ON CENTERS

GENERAL NOTES:

1. ONLY SIGNS THAT SHOW ACCESS CHANGES ARE INCLUDED IN THIS SET FOR INFORMATIONAL PURPOSES. FULL SIGNING PLANS WILL BE DEVELOPED POST 30% DESIGN.

DRAFT 30% SUBMITTAL

DESIGNED BY:
C.MATYAS
DRAWN BY:
O.AHRENSFELD
CHECKED BY:
R.KOESTER
APPROVED BY:
M.FELIBERTI



**DAVID EVANS
AND ASSOCIATES INC.**
14432 SE Eastgate Way, Suite 400
Bellevue Washington 98007
Phone: 425.519.6500

LINE IS 1" AT
FULL SCALE



SCALE:
1"=20'
FILENAME:
BRT-522-CMP211-220
CONTRACT No.:
AE 0055-17
DATE:
09/11/2020

SR 522 / NE 145TH BRT

SR 522 (BOTHELL WAY NE)

CIVIL
CHANNELIZATION & SIGNING PLAN
STA. 554+75 TO STA. 559+25

DRAWING No.:
522-CMP212
FACILITY ID:
522
SHEET No.: REV:
174 OF 283

SUBMITTED BY:
D.SCHOCK

DATE:
09/11/2020


REVIEWED BY:
B.KEMPER

DATE:
09/11/2020

09/10/20 | 10:41 AM | CLMA
C:\PW\WORK\DEACHERIE\MATYAS\DWG\BRT-522-CMP211-220.DWG

MATCHLINE, SEE SHEET 522-CMP212

MATCHLINE, SEE SHEET 522-CMP214

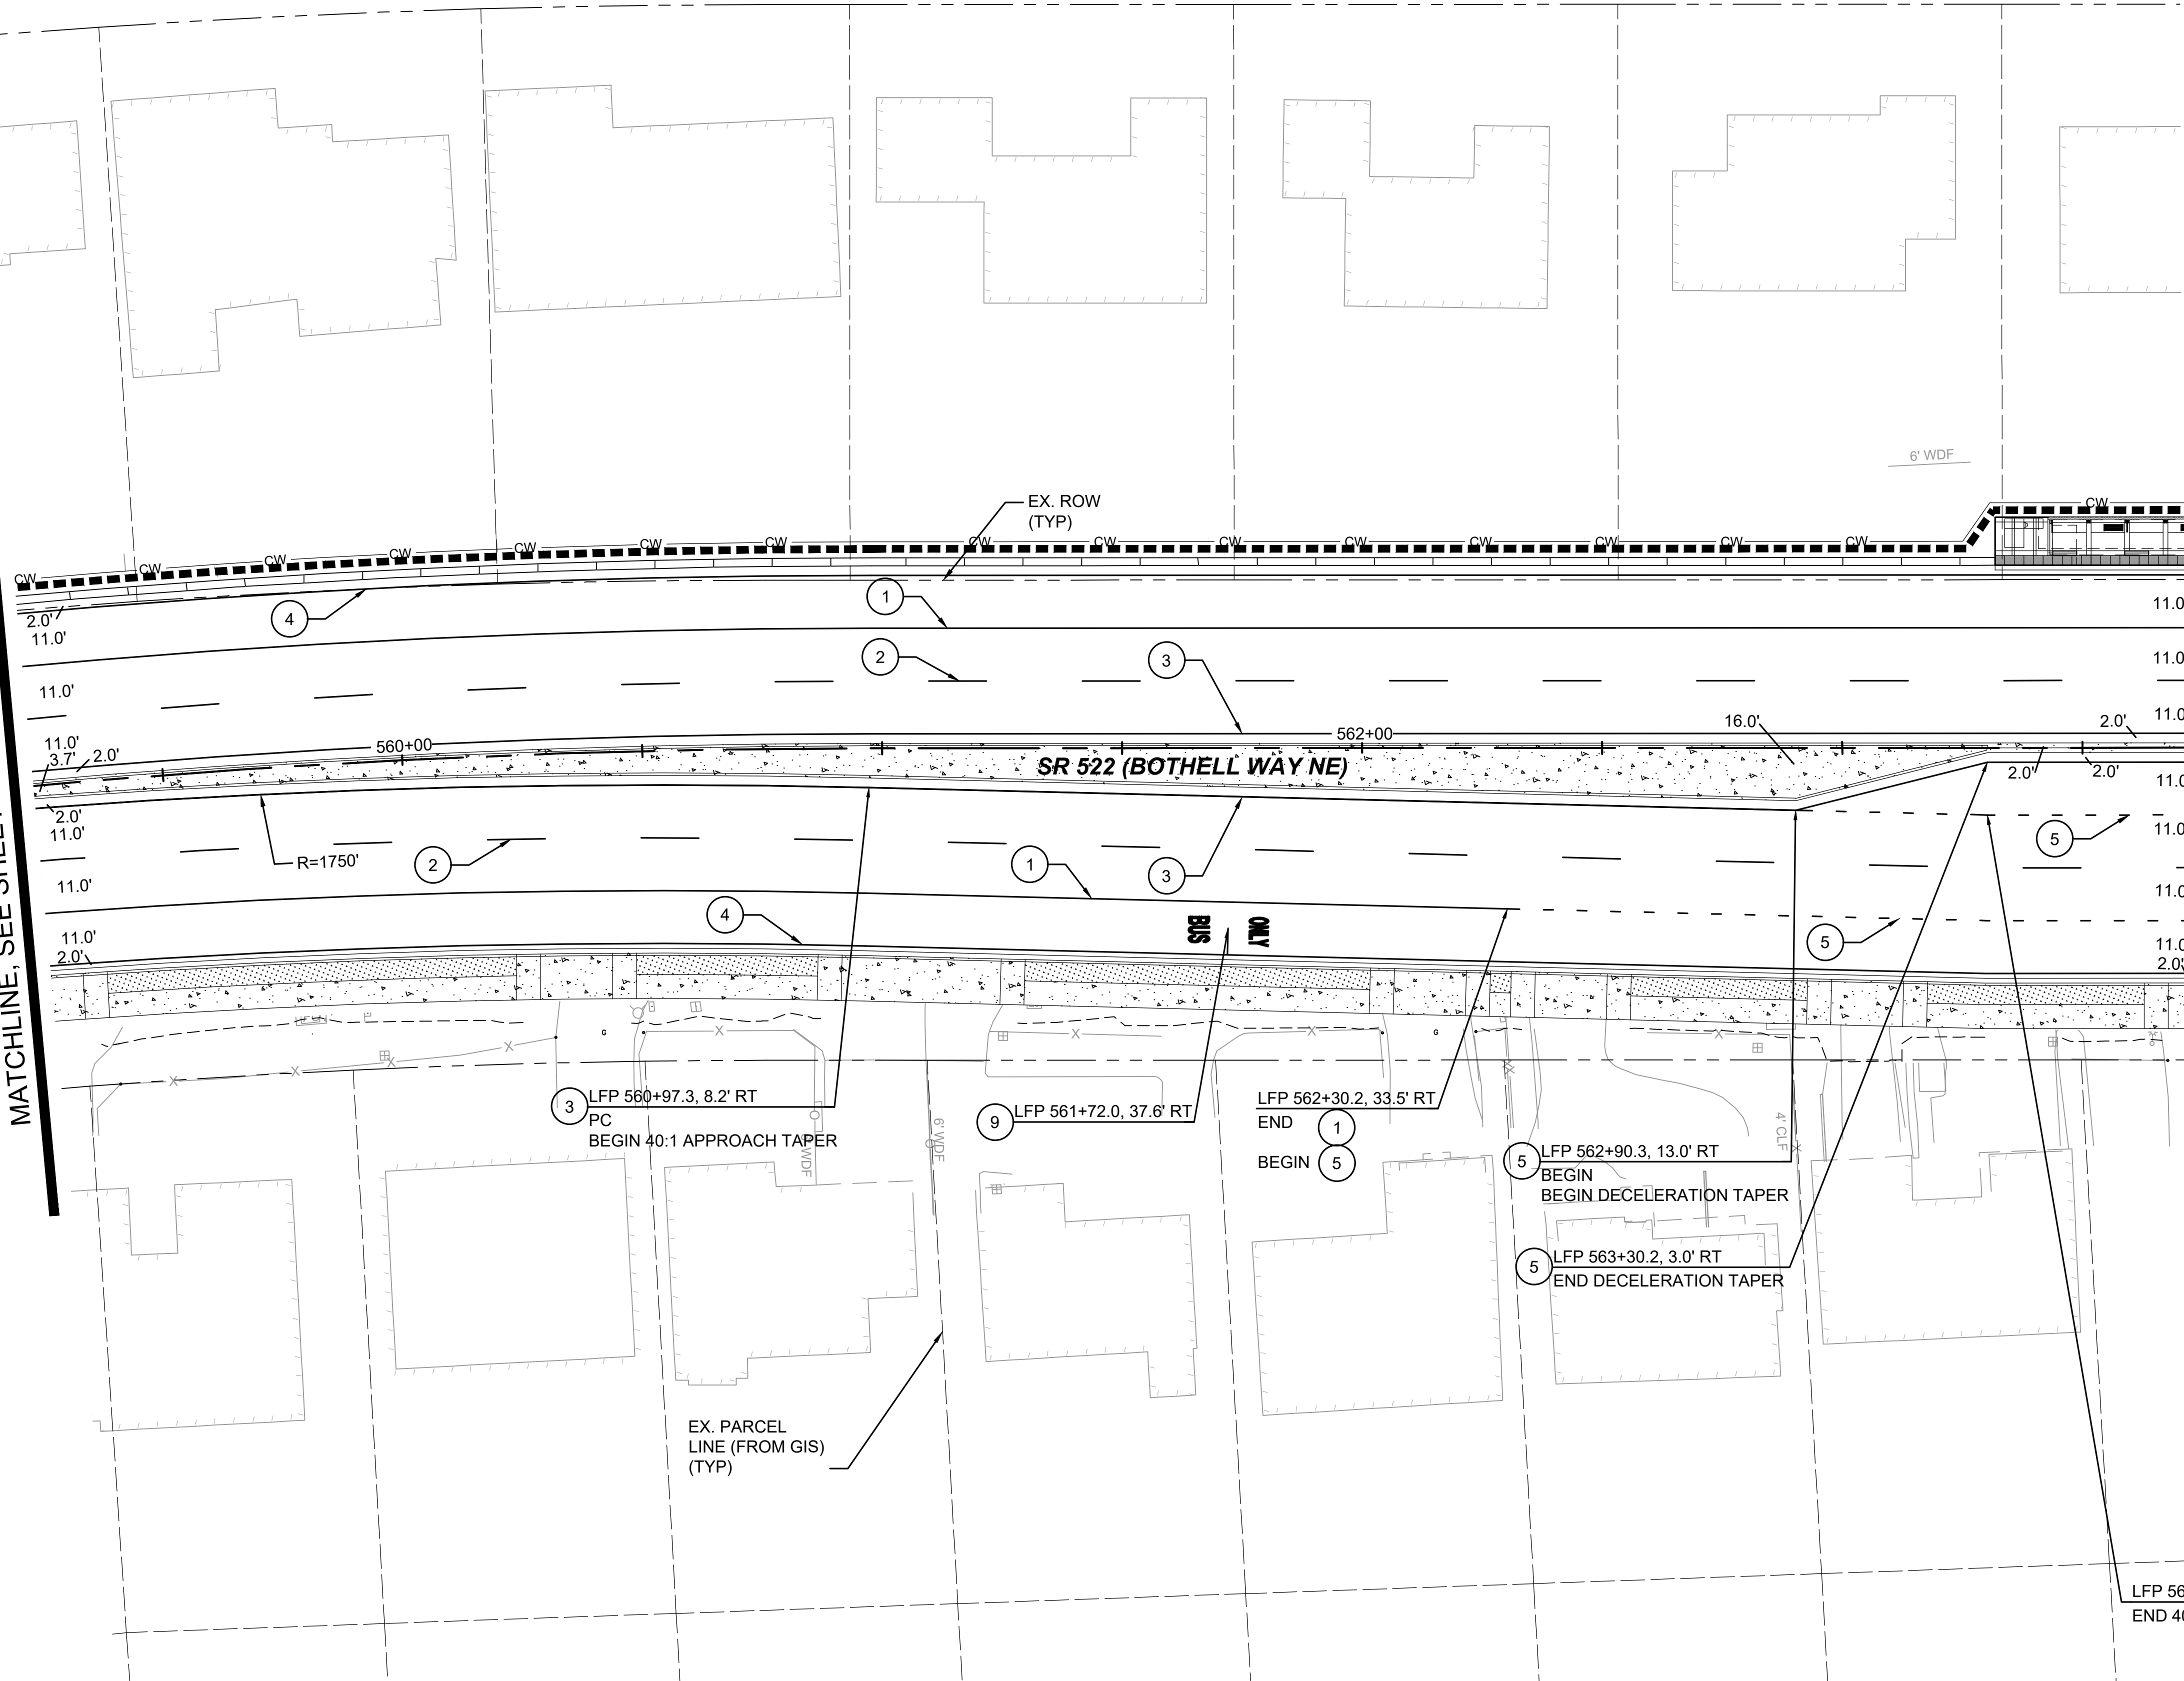


CHANNELIZATION NOTES:

- 1 WHITE WIDE LANE LINE PER WSDOT STD. PLAN M-20.10-02
- 2 WHITE LANE LINE PER WSDOT STD. PLAN M-20.10-02
- 3 YELLOW EDGE LINE PER WSDOT STD. PLAN M-20.10-02
- 4 WHITE EDGE LINE PER WSDOT STD. PLAN M-20.10-02
- 5 WHITE WIDE DOTTED EXTENSION LINE PER WSDOT STD. PLAN M-20.10-02
- 6 WHITE DOTTED EXTENSION LINE PER WSDOT STD. PLAN M-20.10-02
- 7 STOP LINE PER WSDOT STD. PLAN M-24.60-04
- 8 CROSSWALK LINE PER WSDOT STD. PLAN M-15.10-01
- 9 "BUS ONLY" HIGH SPEED TRAFFIC LETTERS PER WSDOT STD. PLAN M-80.10-01
- 10 TYPE 2SL TRAFFIC ARROW PER WSDOT STD. PLAN M-24.40-02
- 11 TYPE 2SR TRAFFIC ARROW PER WSDOT STD. PLAN M-24.40-02
- 12 WHITE DIAGONAL MARKING PER WSDOT STD. PLAN M-24.60-04, SPACED 3.5' ON CENTERS

GENERAL NOTES:

1. ONLY SIGNS THAT SHOW ACCESS CHANGES ARE INCLUDED IN THIS SET FOR INFORMATIONAL PURPOSES. FULL SIGNING PLANS WILL BE DEVELOPED POST 30% DESIGN.

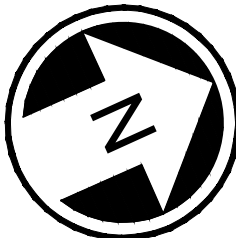


DRAFT 30% SUBMITTAL

DESIGNED BY:
C.MATYAS
DRAWN BY:
O.AHRENSFELD
CHECKED BY:
R.KOESTER
APPROVED BY:
M.FELIBERTI



 **DAVID EVANS
AND ASSOCIATES INC.**
14432 SE Eastgate Way, Suite 400
Bellevue Washington 98007
Phone: 425.519.6500



SOUND TRANSIT

SCALE:
1"=20'
FILENAME:
BRT-522-CMP211-220
CONTRACT No.:
AE 0055-17
DATE:
09/11/2020

SR 522 / NE 145TH BRT

SR 522 (BOTHELL WAY NE)

CIVIL
CHANNELIZATION & SIGNING PLAN
STA. 559+25 TO STA. 563+75

DRAWING No.:
522-CMP213
FACILITY ID:
522
SHEET No.:
175 OF 283
REV:

SUBMITTED BY:
D.SCHOCK

DATE:
09/11/2020

REVIEWED BY:
B.KEMPER

DATE:
09/11/2020

09/10/20 | 10:42 AM | CLMA
C:\PW_WORK\DEA\CHERIE.MATYAS\DWG\SR522-CMP211-220.DWG

DRAFT 30% SUBMITTAL

No.	DATE	DSN	CHK	APP	REVISION

DESIGNED BY: C.MATYAS
DRAWN BY: O.AHRENSFELD
CHECKED BY: R.KOESTER
APPROVED BY: M.FELIBERTI



**DAVID EVANS
AND ASSOCIATES INC.**
14432 SE Eastgate Way, Suite 400
Bellevue Washington 98007
Phone: 425.519.6500

SUBMITTED BY:
D.SCHOCK

DATE:
09/11/2020

REVIEWED BY:
B.KEMPER



SCALE: 1"=20'
FILENAME: BRT-522-CMP211-220
CONTRACT No.: AE 0055-17
DATE: 09/11/2020

SR 522 / NE 145TH BRT

SR 522 (BOTHELL WAY NE)

CIVIL
CHANNELIZATION & SIGNING PLAN
STA. 563+75 TO STA. 567+75

DRAWING No.: 522-CMP214
FACILITY ID: 522
SHEET No.: 176 OF 283
REV:

MATCHLINE, SEE SHEET 522-CMP213



MATCHLINE, SEE SHEET 522-CMP215

CHANNELIZATION NOTES:


- 1 WHITE WIDE LANE LINE PER WSDOT STD. PLAN M-20.10-02
- 2 WHITE LANE LINE PER WSDOT STD. PLAN M-20.10-02
- 3 YELLOW EDGE LINE PER WSDOT STD. PLAN M-20.10-02
- 4 WHITE EDGE LINE PER WSDOT STD. PLAN M-20.10-02
- 5 WHITE WIDE DOTTED EXTENSION LINE PER WSDOT STD. PLAN M-20.10-02
- 6 WHITE DOTTED EXTENSION LINE PER WSDOT STD. PLAN M-20.10-02
- 7 STOP LINE PER WSDOT STD. PLAN M-24.60-04
- 8 CROSSWALK LINE PER WSDOT STD. PLAN M-15.10-01
- 9 "BUS ONLY" HIGH SPEED TRAFFIC LETTERS PER WSDOT STD. PLAN M-80.10-01
- 10 TYPE 2SL TRAFFIC ARROW PER WSDOT STD. PLAN M-24.40-02
- 11 TYPE 2SR TRAFFIC ARROW PER WSDOT STD. PLAN M-24.40-02
- 12 WHITE DIAGONAL MARKING PER WSDOT STD. PLAN M-24.60-04, SPACED 3.5' ON CENTERS

GENERAL NOTES:

1. ONLY SIGNS THAT SHOW ACCESS CHANGES ARE INCLUDED IN THIS SET FOR INFORMATIONAL PURPOSES. FULL SIGNING PLANS WILL BE DEVELOPED POST 30% DESIGN.

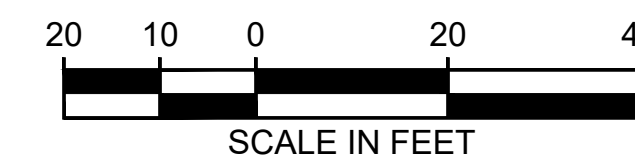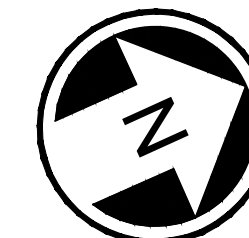

09/10/20 | 10:42 AM | CLMA
C:\PW_WORK\DEACHERIE\MATYAS\DWG\BRT-522-CMP211-220.DWG

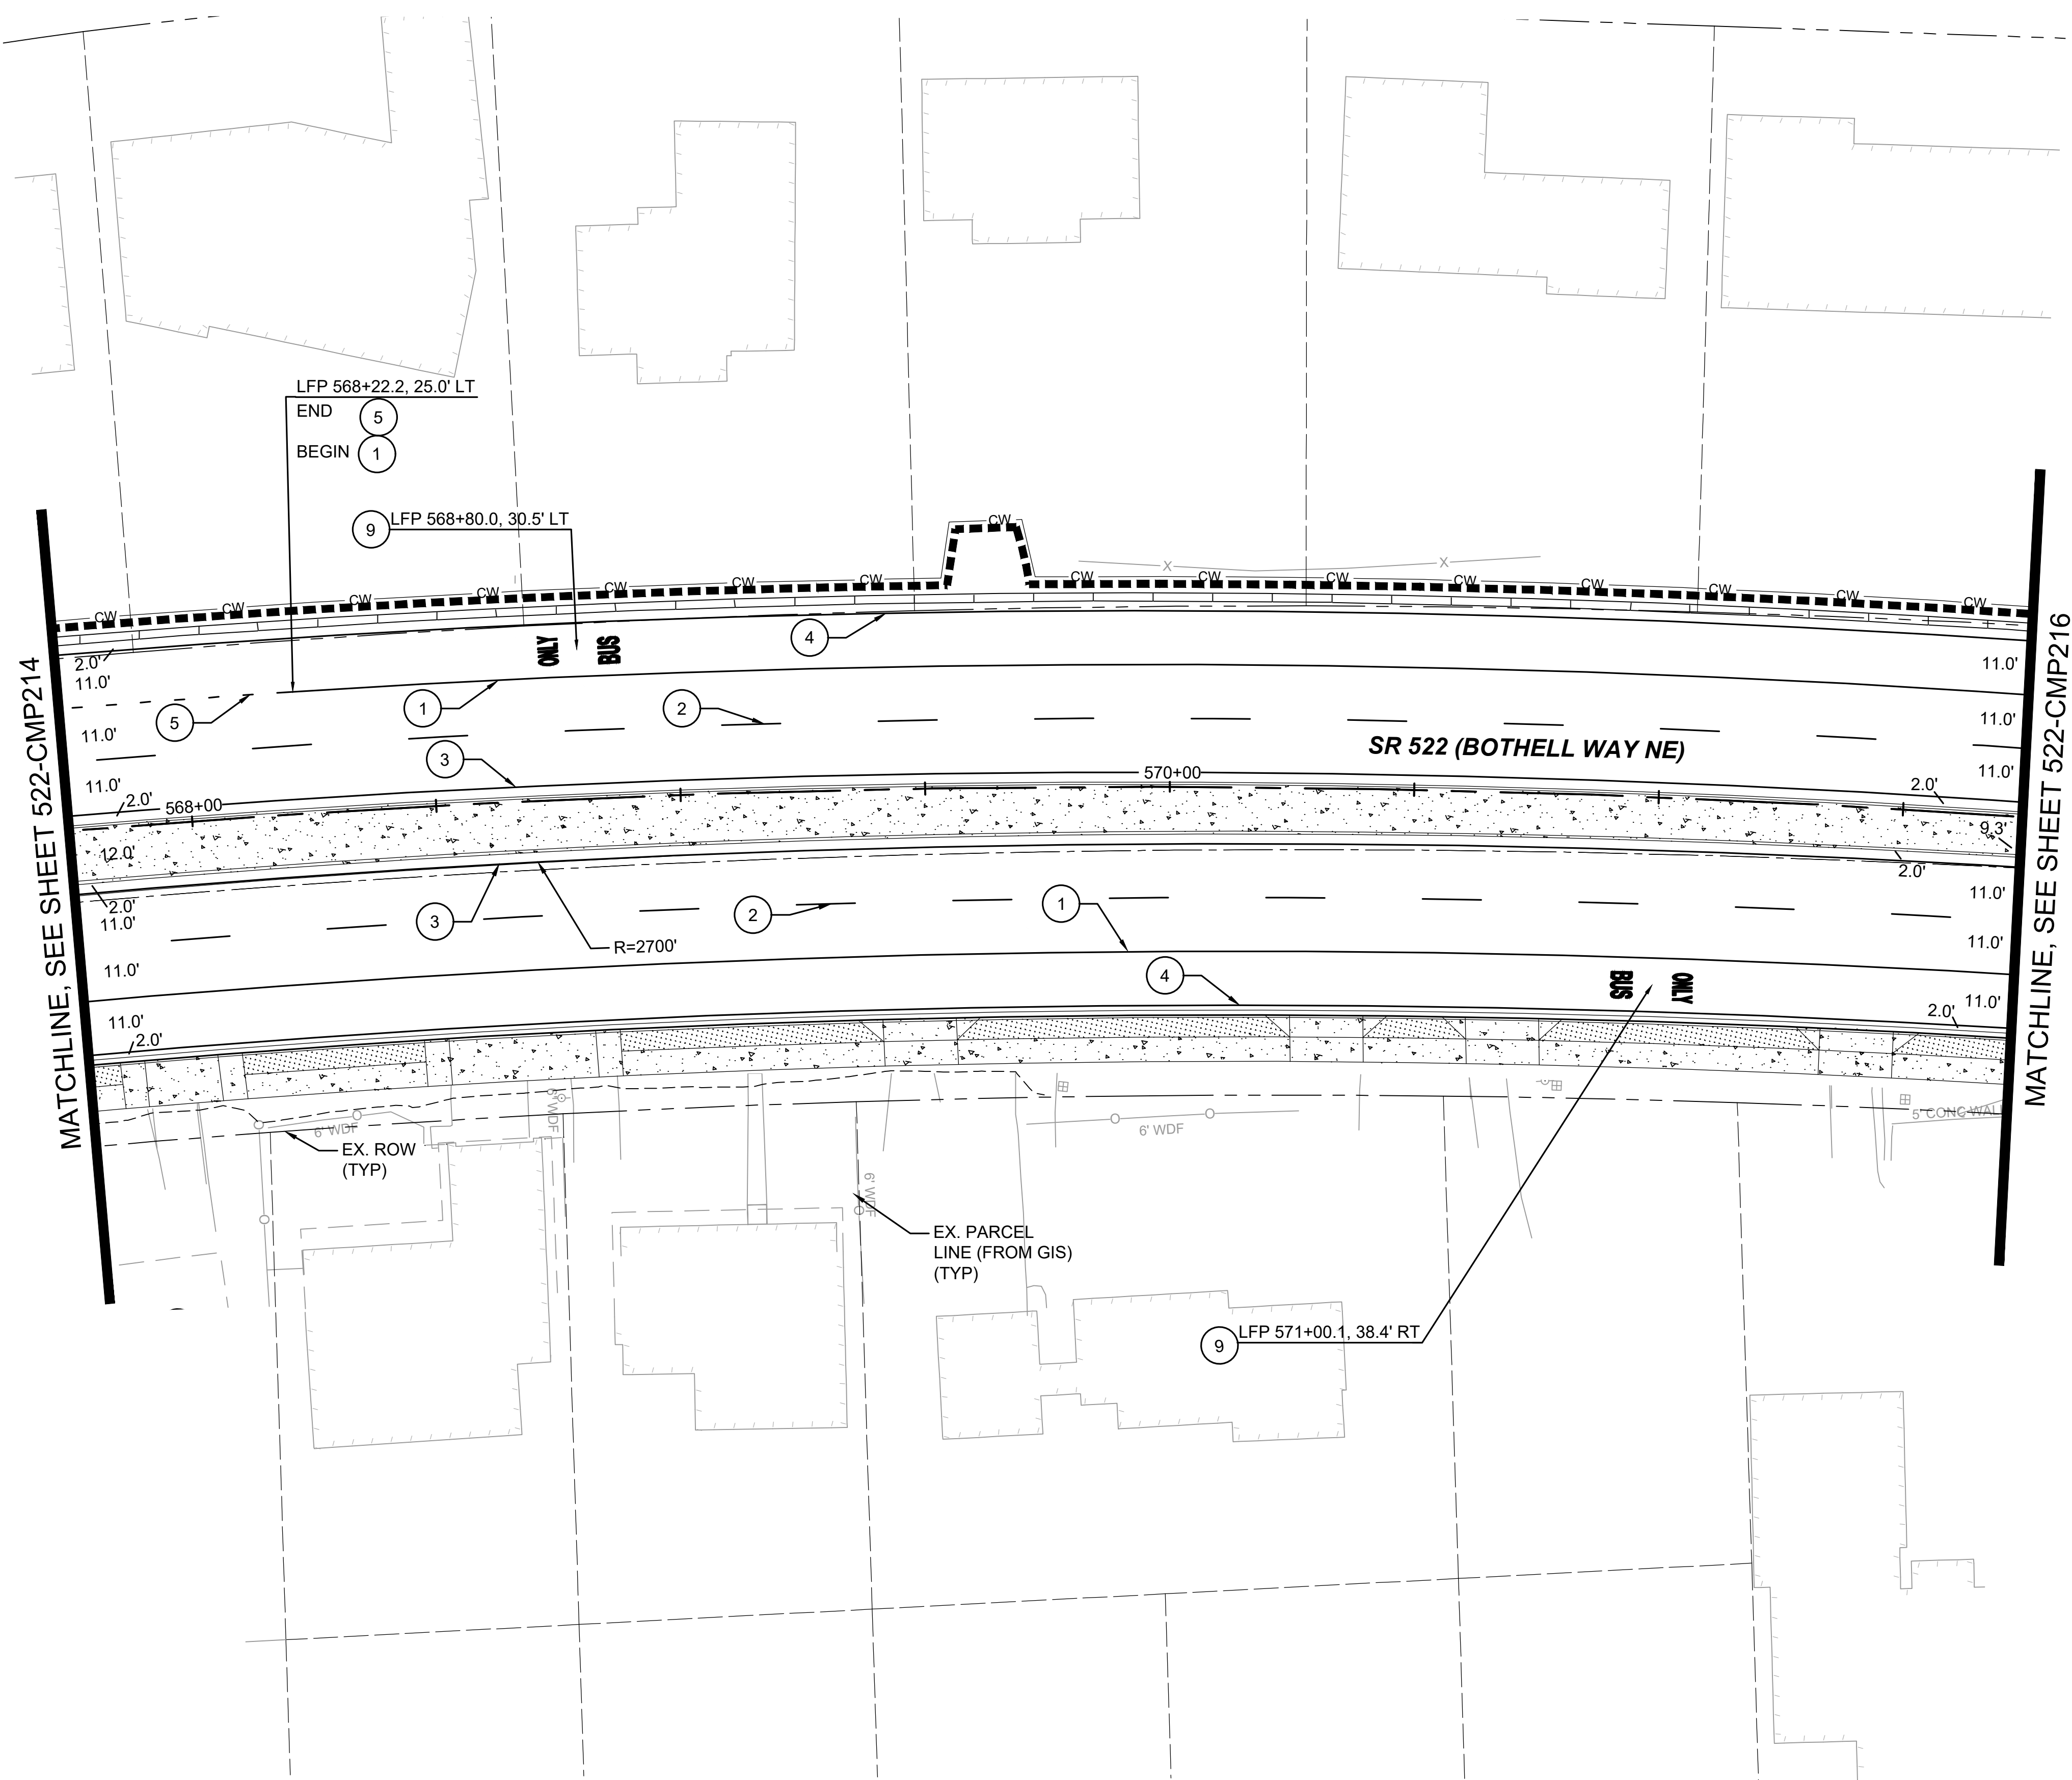

CHANNELIZATION NOTES:

- 1 WHITE WIDE LANE LINE PER WSDOT STD. PLAN M-20.10-02
- 2 WHITE LANE LINE PER WSDOT STD. PLAN M-20.10-02
- 3 YELLOW EDGE LINE PER WSDOT STD. PLAN M-20.10-02
- 4 WHITE EDGE LINE PER WSDOT STD. PLAN M-20.10-02
- 5 WHITE WIDE DOTTED EXTENSION LINE PER WSDOT STD. PLAN M-20.10-02
- 6 WHITE DOTTED EXTENSION LINE PER WSDOT STD. PLAN M-20.10-02
- 7 STOP LINE PER WSDOT STD. PLAN M-24.60-04
- 8 CROSSWALK LINE PER WSDOT STD. PLAN M-15.10-01
- 9 "BUS ONLY" HIGH SPEED TRAFFIC LETTERS PER WSDOT STD. PLAN M-80.10-01
- 10 TYPE 2SL TRAFFIC ARROW PER WSDOT STD. PLAN M-24.40-02
- 11 TYPE 2SR TRAFFIC ARROW PER WSDOT STD. PLAN M-24.40-02
- 12 WHITE DIAGONAL MARKING PER WSDOT STD. PLAN M-24.60-04, SPACED 3.5' ON CENTERS

GENERAL NOTES:

 
1. ONLY SIGNS THAT SHOW ACCESS CHANGES ARE INCLUDED IN THIS SET FOR INFORMATIONAL PURPOSES. FULL SIGNING PLANS WILL BE DEVELOPED POST 30% DESIGN.

DRAFT 30% SUBMITTAL

DESIGNED BY:
C.MATYAS
DRAWN BY:
O.AHRENSFELD
CHECKED BY:
R.KOESTER
APPROVED BY:
M.FELIBERTI



**DAVID EVANS
AND ASSOCIATES INC.**
14432 SE Eastgate Way, Suite 400
Bellevue Washington 98007
Phone: 425.519.6500



SOUNDTRANSIT

SCALE:
1"=20'
FILENAME:
BRT-522-CMP211-220
CONTRACT No.:
AE 0055-17
DATE:
09/11/2020

SR 522 / NE 145TH BRT

SR 522 (BOTHELL WAY NE)

CIVIL
CHANNELIZATION & SIGNING PLAN
STA. 567+75 TO STA. 571+75

DRAWING No.:
522-CMP215
FACILITY ID:
522
SHEET No.:
177 OF 283
REV:



EX. ROW
(TYP)

SR 522 (BOTHELL WAY NE)


41ST AVE NE

2 LFP 575+57.4, 14.0' LT
END
MATCH EXISTING STRIPING

3 LFP 575+12.7, 3.0' LT
PCC

1 LFP 575+33.37, 28.92' RT
END
MATCH EXISTING STRIPING

LINE IS 1" AT FULL SCALE

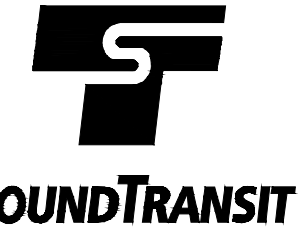

SCALE:	1"=20'
FILENAME:	BRT-522-CMP211-220
CONTRACT No.:	AE 0055-17
DATE:	09/11/2020

SR 522 / NE 145TH BRT

SR 522 (BOTHELL WAY NE)

CIVIL
CHANNELIZATION & SIGNING PLAN
STA. 571+75 TO STA. 575+75


DRAWING No.:	
522-CMP216	
FACILITY ID:	
522	
SHEET No.:	REV:
178 OF 283	

CHANNELIZATION NOTES:

- ① WHITE WIDE LANE LINE PER WSDOT STD. PLAN M-20.10-02
- ② WHITE LANE LINE PER WSDOT STD. PLAN M-20.10-02
- ③ YELLOW EDGE LINE PER WSDOT STD. PLAN M-20.10-02
- ④ WHITE EDGE LINE PER WSDOT STD. PLAN M-20.10-02
- ⑤ WHITE WIDE DOTTED EXTENSION LINE PER WSDOT STD. PLAN M-20.10-02
- ⑥ WHITE DOTTED EXTENSION LINE PER WSDOT STD. PLAN M-20.10-02
- ⑦ STOP LINE PER WSDOT STD. PLAN M-24.60-04
- ⑧ CROSSWALK LINE PER WSDOT STD. PLAN M-15.10-01
- ⑨ "BUS ONLY" HIGH SPEED TRAFFIC LETTERS PER WSDOT STD. PLAN M-80.10-01
- ⑩ TYPE 2SL TRAFFIC ARROW PER WSDOT STD. PLAN M-24.40-02
- ⑪ TYPE 2SR TRAFFIC ARROW PER WSDOT STD. PLAN M-24.40-02
- ⑫ WHITE DIAGONAL MARKING PER WSDOT STD. PLAN M-24.60-04, SPACED 3.5' ON CENTERS

GENERAL NOTES:

1. ONLY SIGNS THAT SHOW ACCESS CHANGES ARE INCLUDED IN THIS SET FOR INFORMATIONAL PURPOSES. FULL SIGNING PLANS WILL BE DEVELOPED POST 30% DESIGN.

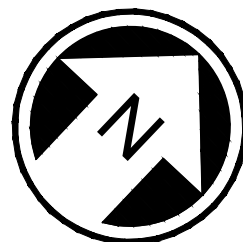

DRAFT 30% SUBMITTAL

No.	DATE	DSN	CHK	APP	REVISION

DESIGNED BY:	C.MATYAS
DRAWN BY:	O.AHRENSFELD
CHECKED BY:	R.KOESTER
APPROVED BY:	M.FELIBERTI



**DAVID EVANS
AND ASSOCIATES INC.**
14432 SE Eastgate Way, Suite 400
Bellevue Washington 98007
Phone: 425.519.6500

SUBMITTED BY
D.SCHOCK

DATE:	09/11/2020
-------	------------

REVIEWED BY:
B.KEMPER


DATE:
09/11/2020

DATE:	09/11/2020
-------	------------

09/10/20 | 10:43 AM | CLMA
C:\PW_WORK\DEACHERIE\MATYAS\DWG\BRT-522-CMP211-220.DWG

MATCHLINE, SEE SHEET 522-CMP216

MATCHLINE, SEE SHEET 522-CMP218

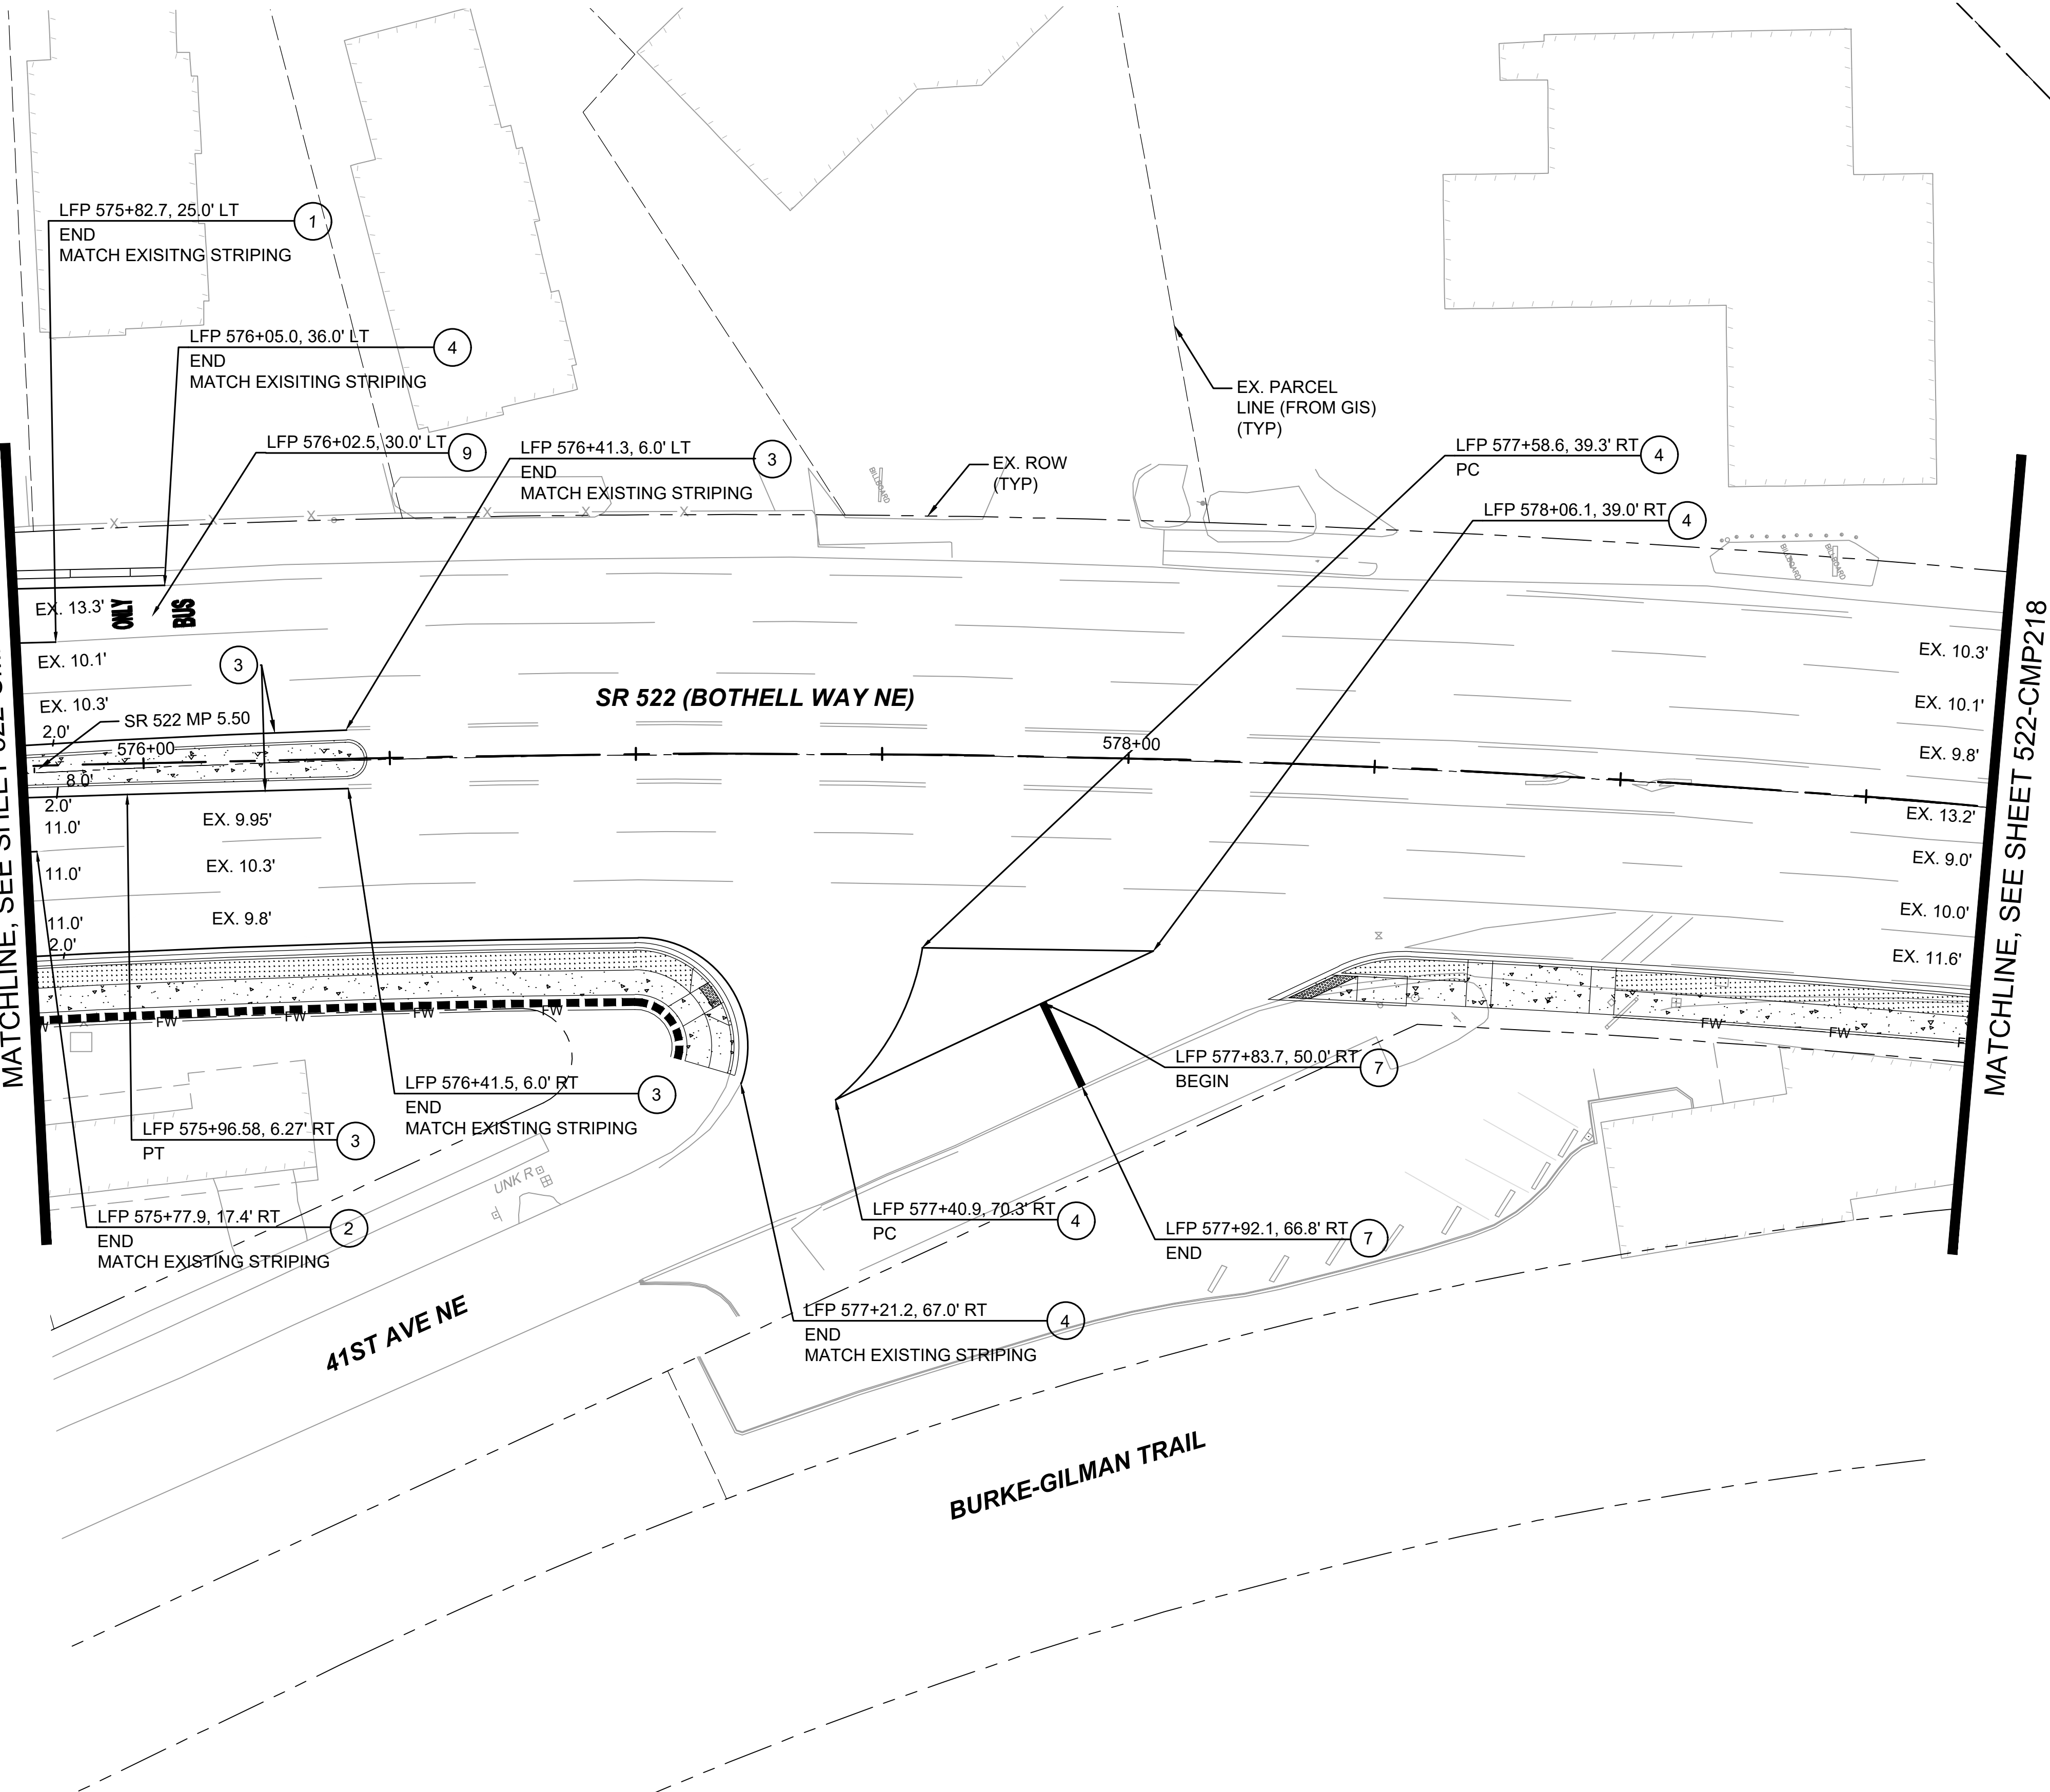


CHANNELIZATION NOTES:

- 1 WHITE WIDE LANE LINE PER WSDOT STD. PLAN M-20.10-02
- 2 WHITE LANE LINE PER WSDOT STD. PLAN M-20.10-02
- 3 YELLOW EDGE LINE PER WSDOT STD. PLAN M-20.10-02
- 4 WHITE EDGE LINE PER WSDOT STD. PLAN M-20.10-02
- 5 WHITE WIDE DOTTED EXTENSION LINE PER WSDOT STD. PLAN M-20.10-02
- 6 WHITE DOTTED EXTENSION LINE PER WSDOT STD. PLAN M-20.10-02
- 7 STOP LINE PER WSDOT STD. PLAN M-24.60-04
- 8 CROSSWALK LINE PER WSDOT STD. PLAN M-15.10-01
- 9 "BUS ONLY" HIGH SPEED TRAFFIC LETTERS PER WSDOT STD. PLAN M-80.10-01
- 10 TYPE 2SL TRAFFIC ARROW PER WSDOT STD. PLAN M-24.40-02
- 11 TYPE 2SR TRAFFIC ARROW PER WSDOT STD. PLAN M-24.40-02
- 12 WHITE DIAGONAL MARKING PER WSDOT STD. PLAN M-24.60-04, SPACED 3.5' ON CENTERS

GENERAL NOTES:

1. ONLY SIGNS THAT SHOW ACCESS CHANGES ARE INCLUDED IN THIS SET FOR INFORMATIONAL PURPOSES. FULL SIGNING PLANS WILL BE DEVELOPED POST 30% DESIGN.

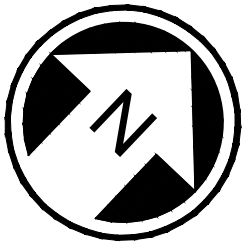

DRAFT 30% SUBMITTAL


No.	DATE	DSN	CHK	APP	REVISION

DESIGNED BY: C.MATYAS
DRAWN BY: O.AHRENSFELD
CHECKED BY: R.KOESTER
APPROVED BY: M.FELIBERTI



DAVID EVANS
AND ASSOCIATES INC.
14432 SE Eastgate Way, Suite 400
Bellevue Washington 98007
Phone: 425.519.6500

SUBMITTED BY: D.SCHOCK	DATE: 09/11/2020	REVIEWED BY: B.KEMPER	DATE: 09/11/2020
---------------------------	---------------------	--------------------------	---------------------

 


SOUNDTRANSIT

SCALE: 1"=20'
FILENAME: BRT-522-CMP211-220
CONTRACT No.: AE 0055-17
DATE: 09/11/2020

SR 522 / NE 145TH BRT
SR 522 (BOTHELL WAY NE)
CIVIL
CHANNELIZATION & SIGNING PLAN
STA. 575+75 TO STA. 579+75

DRAWING No.: 522-CMP217
FACILITY ID: 522
SHEET No.: 179 OF 283
REV:

09/10/20 | 10:43 AM | CLMA
C:\PW_WORK\DEACHERIE\MATYAS\DWG\BRT-522-CMP211-220.DWG

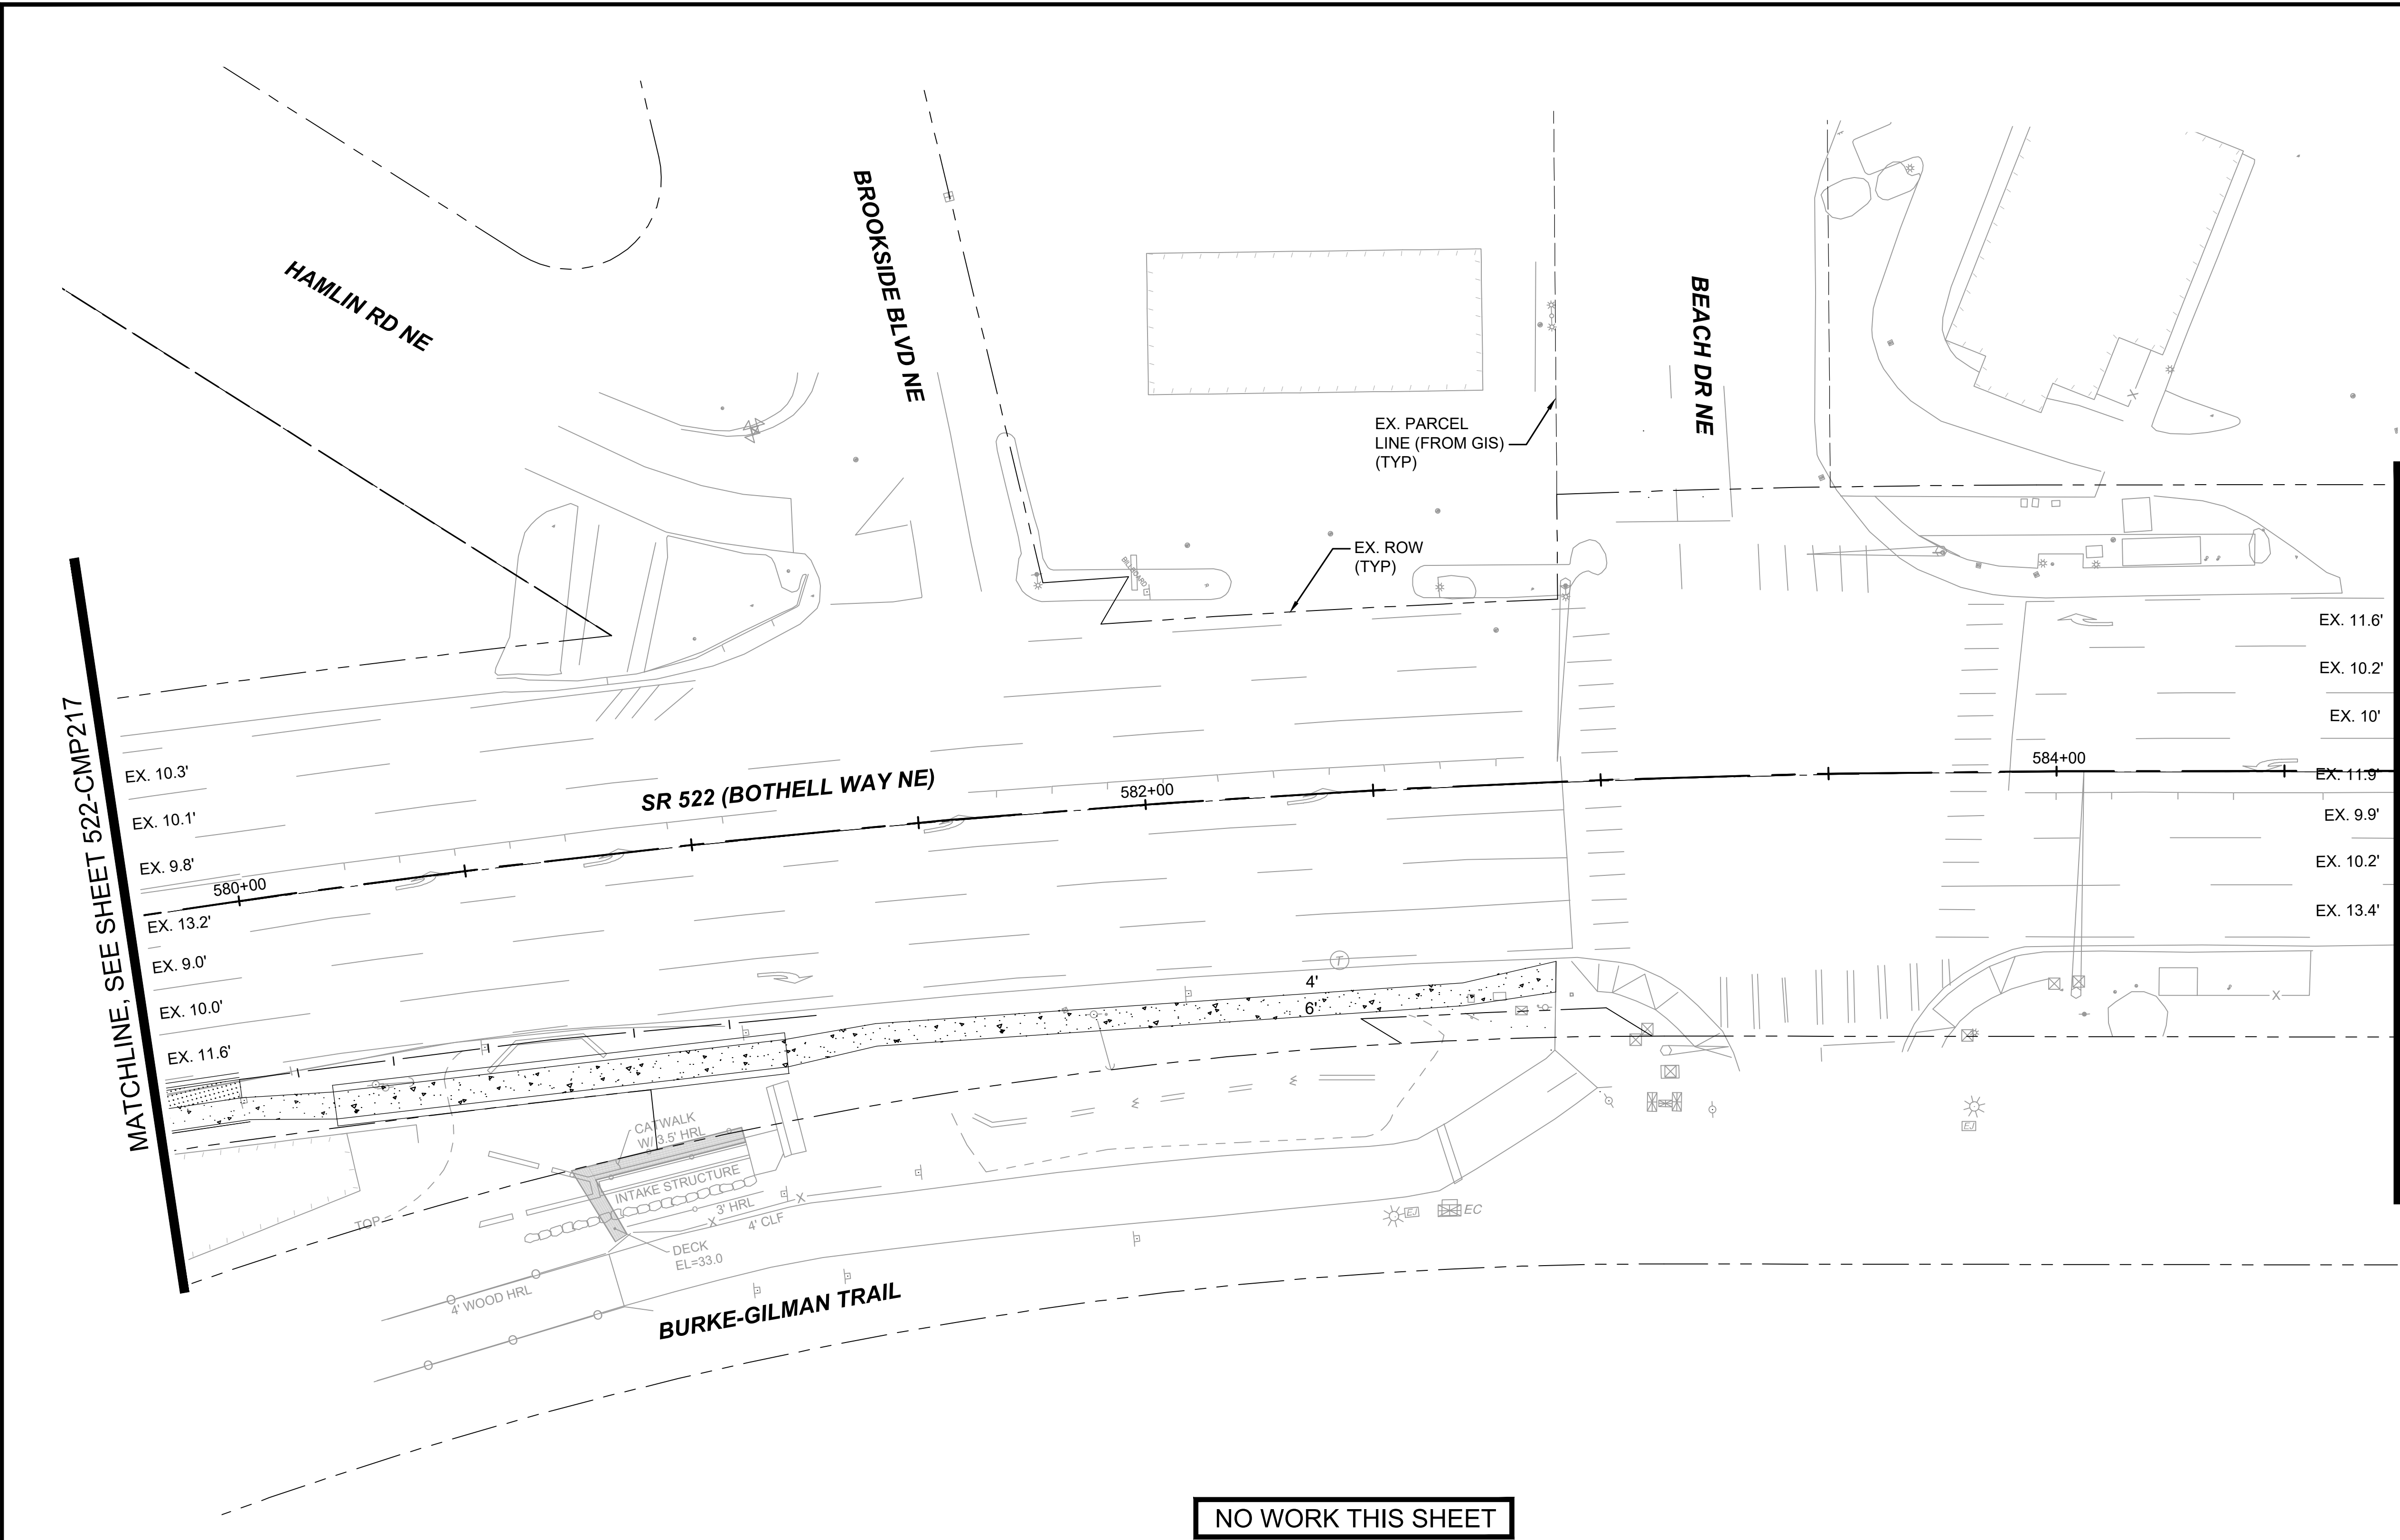


CHANNELIZATION NOTES:

- 1 WHITE WIDE LANE LINE PER WSDOT STD. PLAN M-20.10-02
- 2 WHITE LANE LINE PER WSDOT STD. PLAN M-20.10-02
- 3 YELLOW EDGE LINE PER WSDOT STD. PLAN M-20.10-02
- 4 WHITE EDGE LINE PER WSDOT STD. PLAN M-20.10-02
- 5 WHITE WIDE DOTTED EXTENSION LINE PER WSDOT STD. PLAN M-20.10-02
- 6 WHITE DOTTED EXTENSION LINE PER WSDOT STD. PLAN M-20.10-02
- 7 STOP LINE PER WSDOT STD. PLAN M-24.60-04
- 8 CROSSWALK LINE PER WSDOT STD. PLAN M-15.10-01
- 9 "BUS ONLY" HIGH SPEED TRAFFIC LETTERS PER WSDOT STD. PLAN M-80.10-01
- 10 TYPE 2SL TRAFFIC ARROW PER WSDOT STD. PLAN M-24.40-02
- 11 TYPE 2SR TRAFFIC ARROW PER WSDOT STD. PLAN M-24.40-02
- 12 WHITE DIAGONAL MARKING PER WSDOT STD. PLAN M-24.60-04, SPACED 3.5' ON CENTERS

GENERAL NOTES:

1. ONLY SIGNS THAT SHOW ACCESS CHANGES ARE INCLUDED IN THIS SET FOR INFORMATIONAL PURPOSES. FULL SIGNING PLANS WILL BE DEVELOPED POST 30% DESIGN.

MATCHLINE, SEE SHEET 522-CMP219

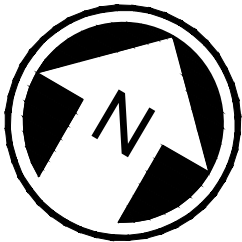


DRAFT 30% SUBMITTAL							DESIGNED BY: C.MATYAS		 DAVID EVANS AND ASSOCIATES INC. 14432 SE Eastgate Way, Suite 400 Bellevue Washington 98007 Phone: 425.519.6500				SCALE: 1"=20'	SR 522 / NE 145TH BRT		DRAWING No.: 522-CMP218
							DRAWN BY: O.AHRENSFELD						FILENAME: BRT-522-CMP211-220			FACILITY ID: 522
							CHECKED BY: R.KOESTER						CONTRACT No.: AE 0055-17			SHEET No.: 180 OF 283
							APPROVED BY: M.FELIBERTI						DATE: 09/11/2020			REV:
No.	DATE	DSN	CHK	APP	REVISION				SUBMITTED BY: D.SCHOCK	DATE: 09/11/2020	REVIEWED BY: B.KEMPER	DATE: 09/11/2020	DATE: 09/11/2020	SR 522 (BOTHELL WAY NE)		
							CIVIL CHANNELIZATION & SIGNING PLAN STA. 579+75 TO STA. 584+75									

09/10/20 | 10:43 AM | CLMA
C:\PW_WORK\DEACHERIE\MATYAS\DWG\BRT-522-CMP211-220.DWG

MATCHLINE, SEE SHEET 522-CMP218

MATCHLINE, SEE SHEET 522-CMP220

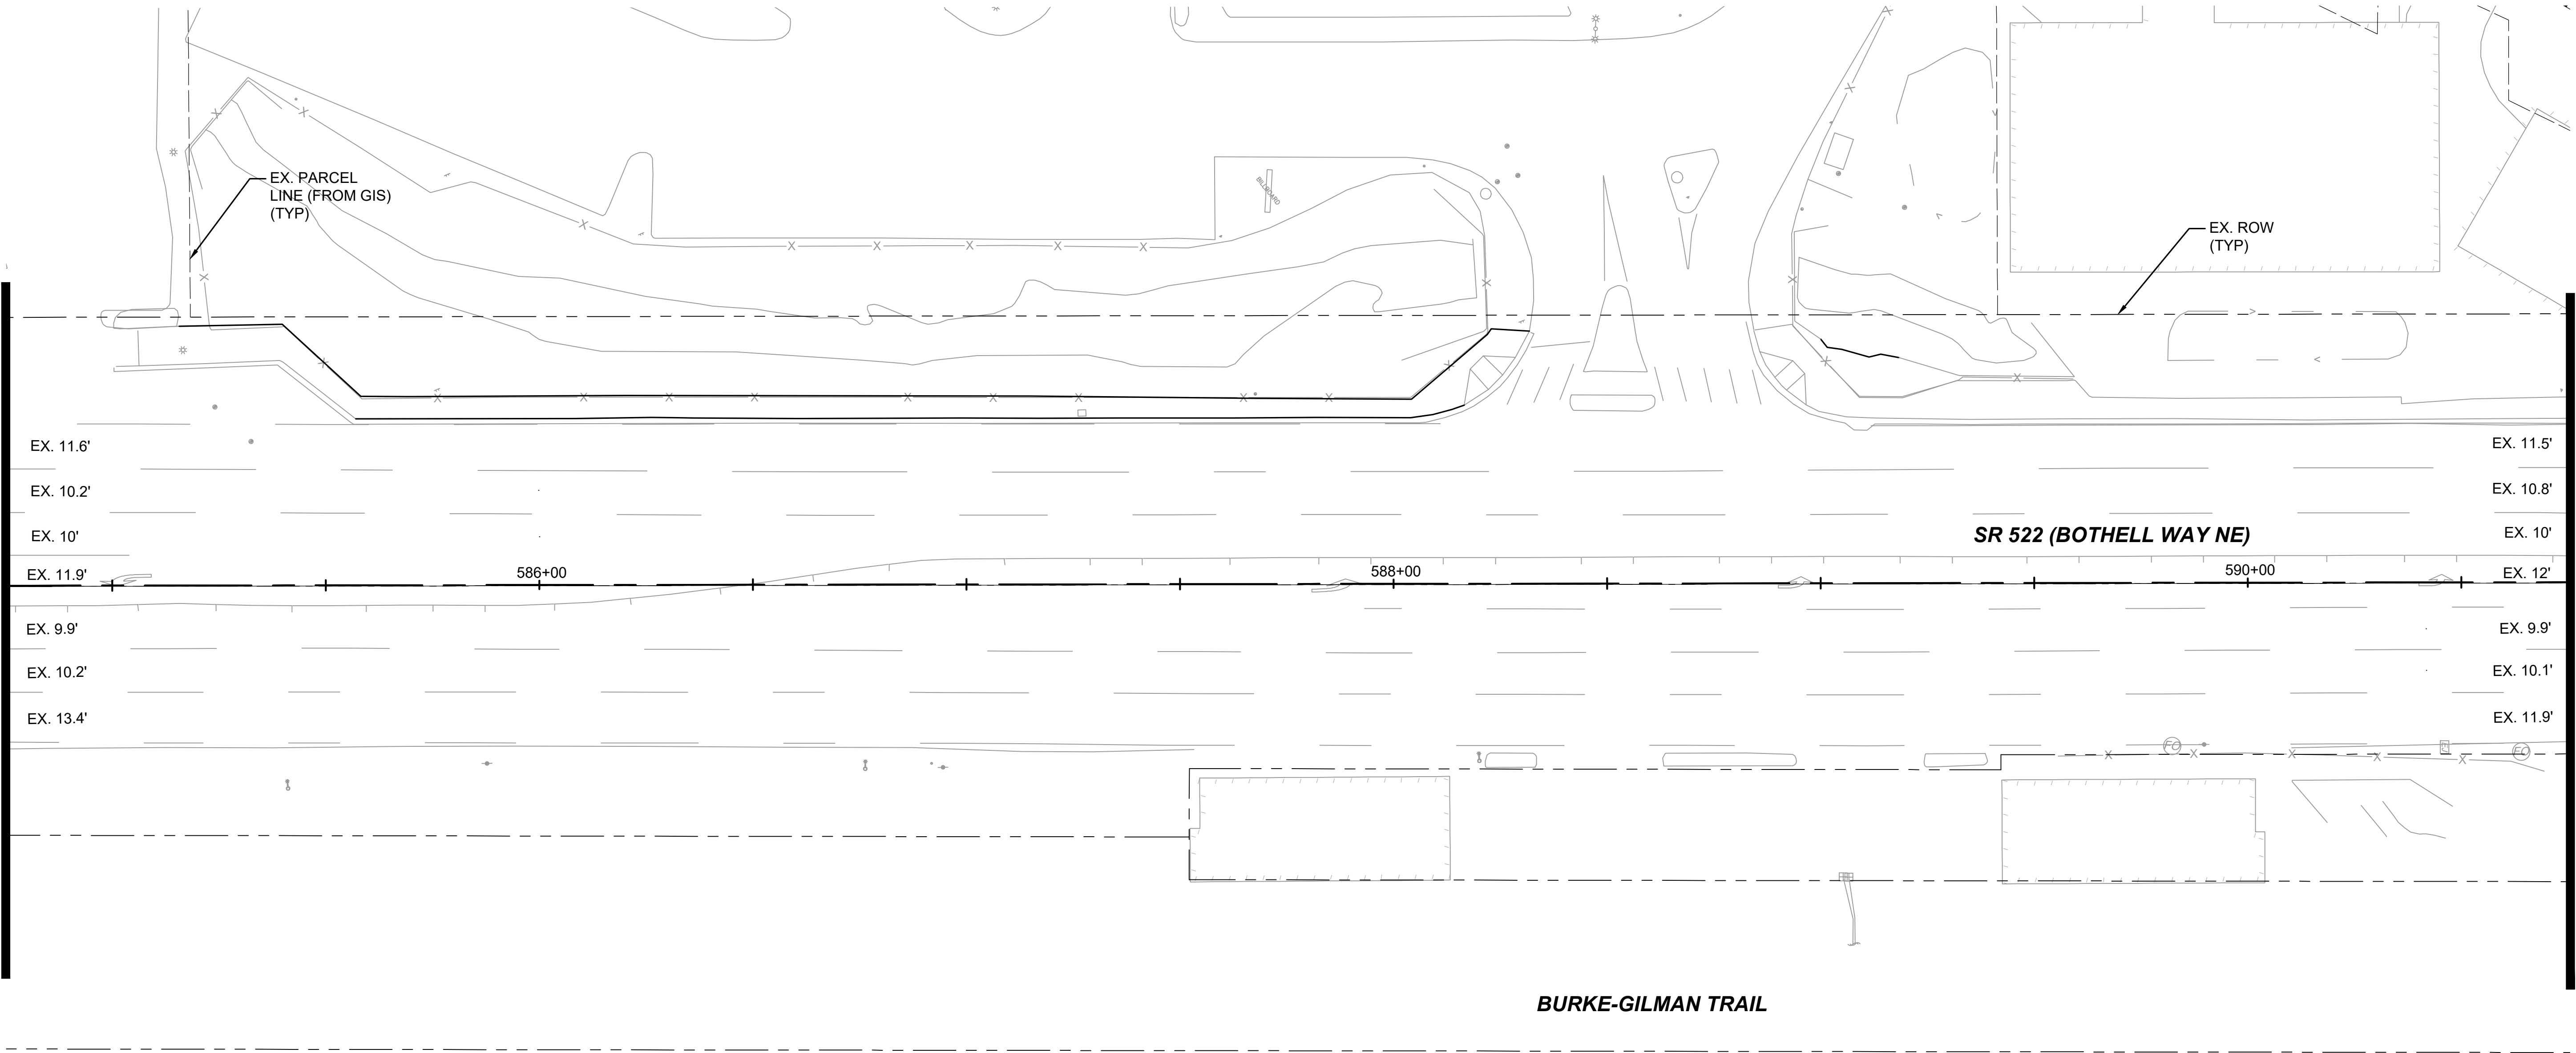

CHANNELIZATION NOTES:

- ① WHITE WIDE LANE LINE PER WSDOT STD. PLAN M-20.10-02

② WHITE LANE LINE PER WSDOT STD. PLAN M-20.10-02

③ YELLOW EDGE LINE PER WSDOT STD. PLAN M-20.10-02

④ WHITE EDGE LINE PER WSDOT STD. PLAN M-20.10-02

⑤ WHITE WIDE DOTTED EXTENSION LINE PER WSDOT STD. PLAN M-20.10-02

⑥ WHITE DOTTED EXTENSION LINE PER WSDOT STD. PLAN M-20.10-02

⑦ STOP LINE PER WSDOT STD. PLAN M-24.60-04
- ⑧ CROSSWALK LINE PER WSDOT STD. PLAN M-15.10-01

⑨ "BUS ONLY" HIGH SPEED TRAFFIC LETTERS PER WSDOT STD. PLAN M-80.10-01

⑩ TYPE 2SL TRAFFIC ARROW PER WSDOT STD. PLAN M-24.40-02


⑪ TYPE 2SR TRAFFIC ARROW PER WSDOT STD. PLAN M-24.40-02

⑫ WHITE DIAGONAL MARKING PER WSDOT STD. PLAN M-24.60-04, SPACED 3.5' ON CENTERS

GENERAL NOTES:


1. ONLY SIGNS THAT SHOW ACCESS CHANGES ARE INCLUDED IN THIS SET FOR INFORMATIONAL PURPOSES. FULL SIGNING PLANS WILL BE DEVELOPED POST 30% DESIGN.

NO WORK THIS SHEET

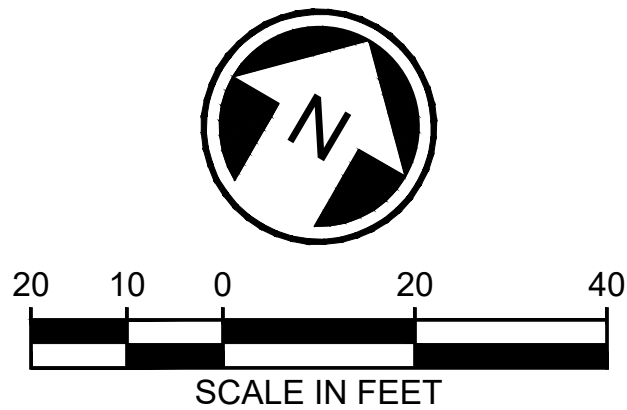

DRAFT 30% SUBMITTAL						DESIGNED BY: C.MATYAS		 DAVID EVANS AND ASSOCIATES INC. 14432 SE Eastgate Way, Suite 400 Bellevue Washington 98007 Phone: 425.519.6500			LINE IS 1" AT FULL SCALE  SOUNDTRANSIT	SCALE: 1"=20'	SR 522 / NE 145TH BRT			DRAWING No.: 522-CMP219	
						DRAWN BY: O.AHRENSFELD						FILENAME: BRT-522-CMP211-220	SR 522 (BOTHELL WAY NE)			FACILITY ID: 522	
						CHECKED BY: R.KOESTER						CONTRACT No.: AE 0055-17	CIVIL			SHEET No.: 181 OF 283	
						APPROVED BY: M.FELIBERTI						DATE: 09/11/2020	DATE: 09/11/2020	CHANNELIZATION & SIGNING PLAN			REV:
						SUBMITTED BY: D.SCHOCK		DATE: 09/11/2020	REVIEWED BY: B.KEMPER	DATE: 09/11/2020		DATE: 09/11/2020	STA. 584+75 TO STA. 590+75				
No.	DATE	DSN	CHK	APP	REVISION												

09/10/20 | 10:43 AM | CLMA
C:\PW\WORK\DEACHERIE\MATYAS\DWG\BRT-522-CMP211-220.DWG

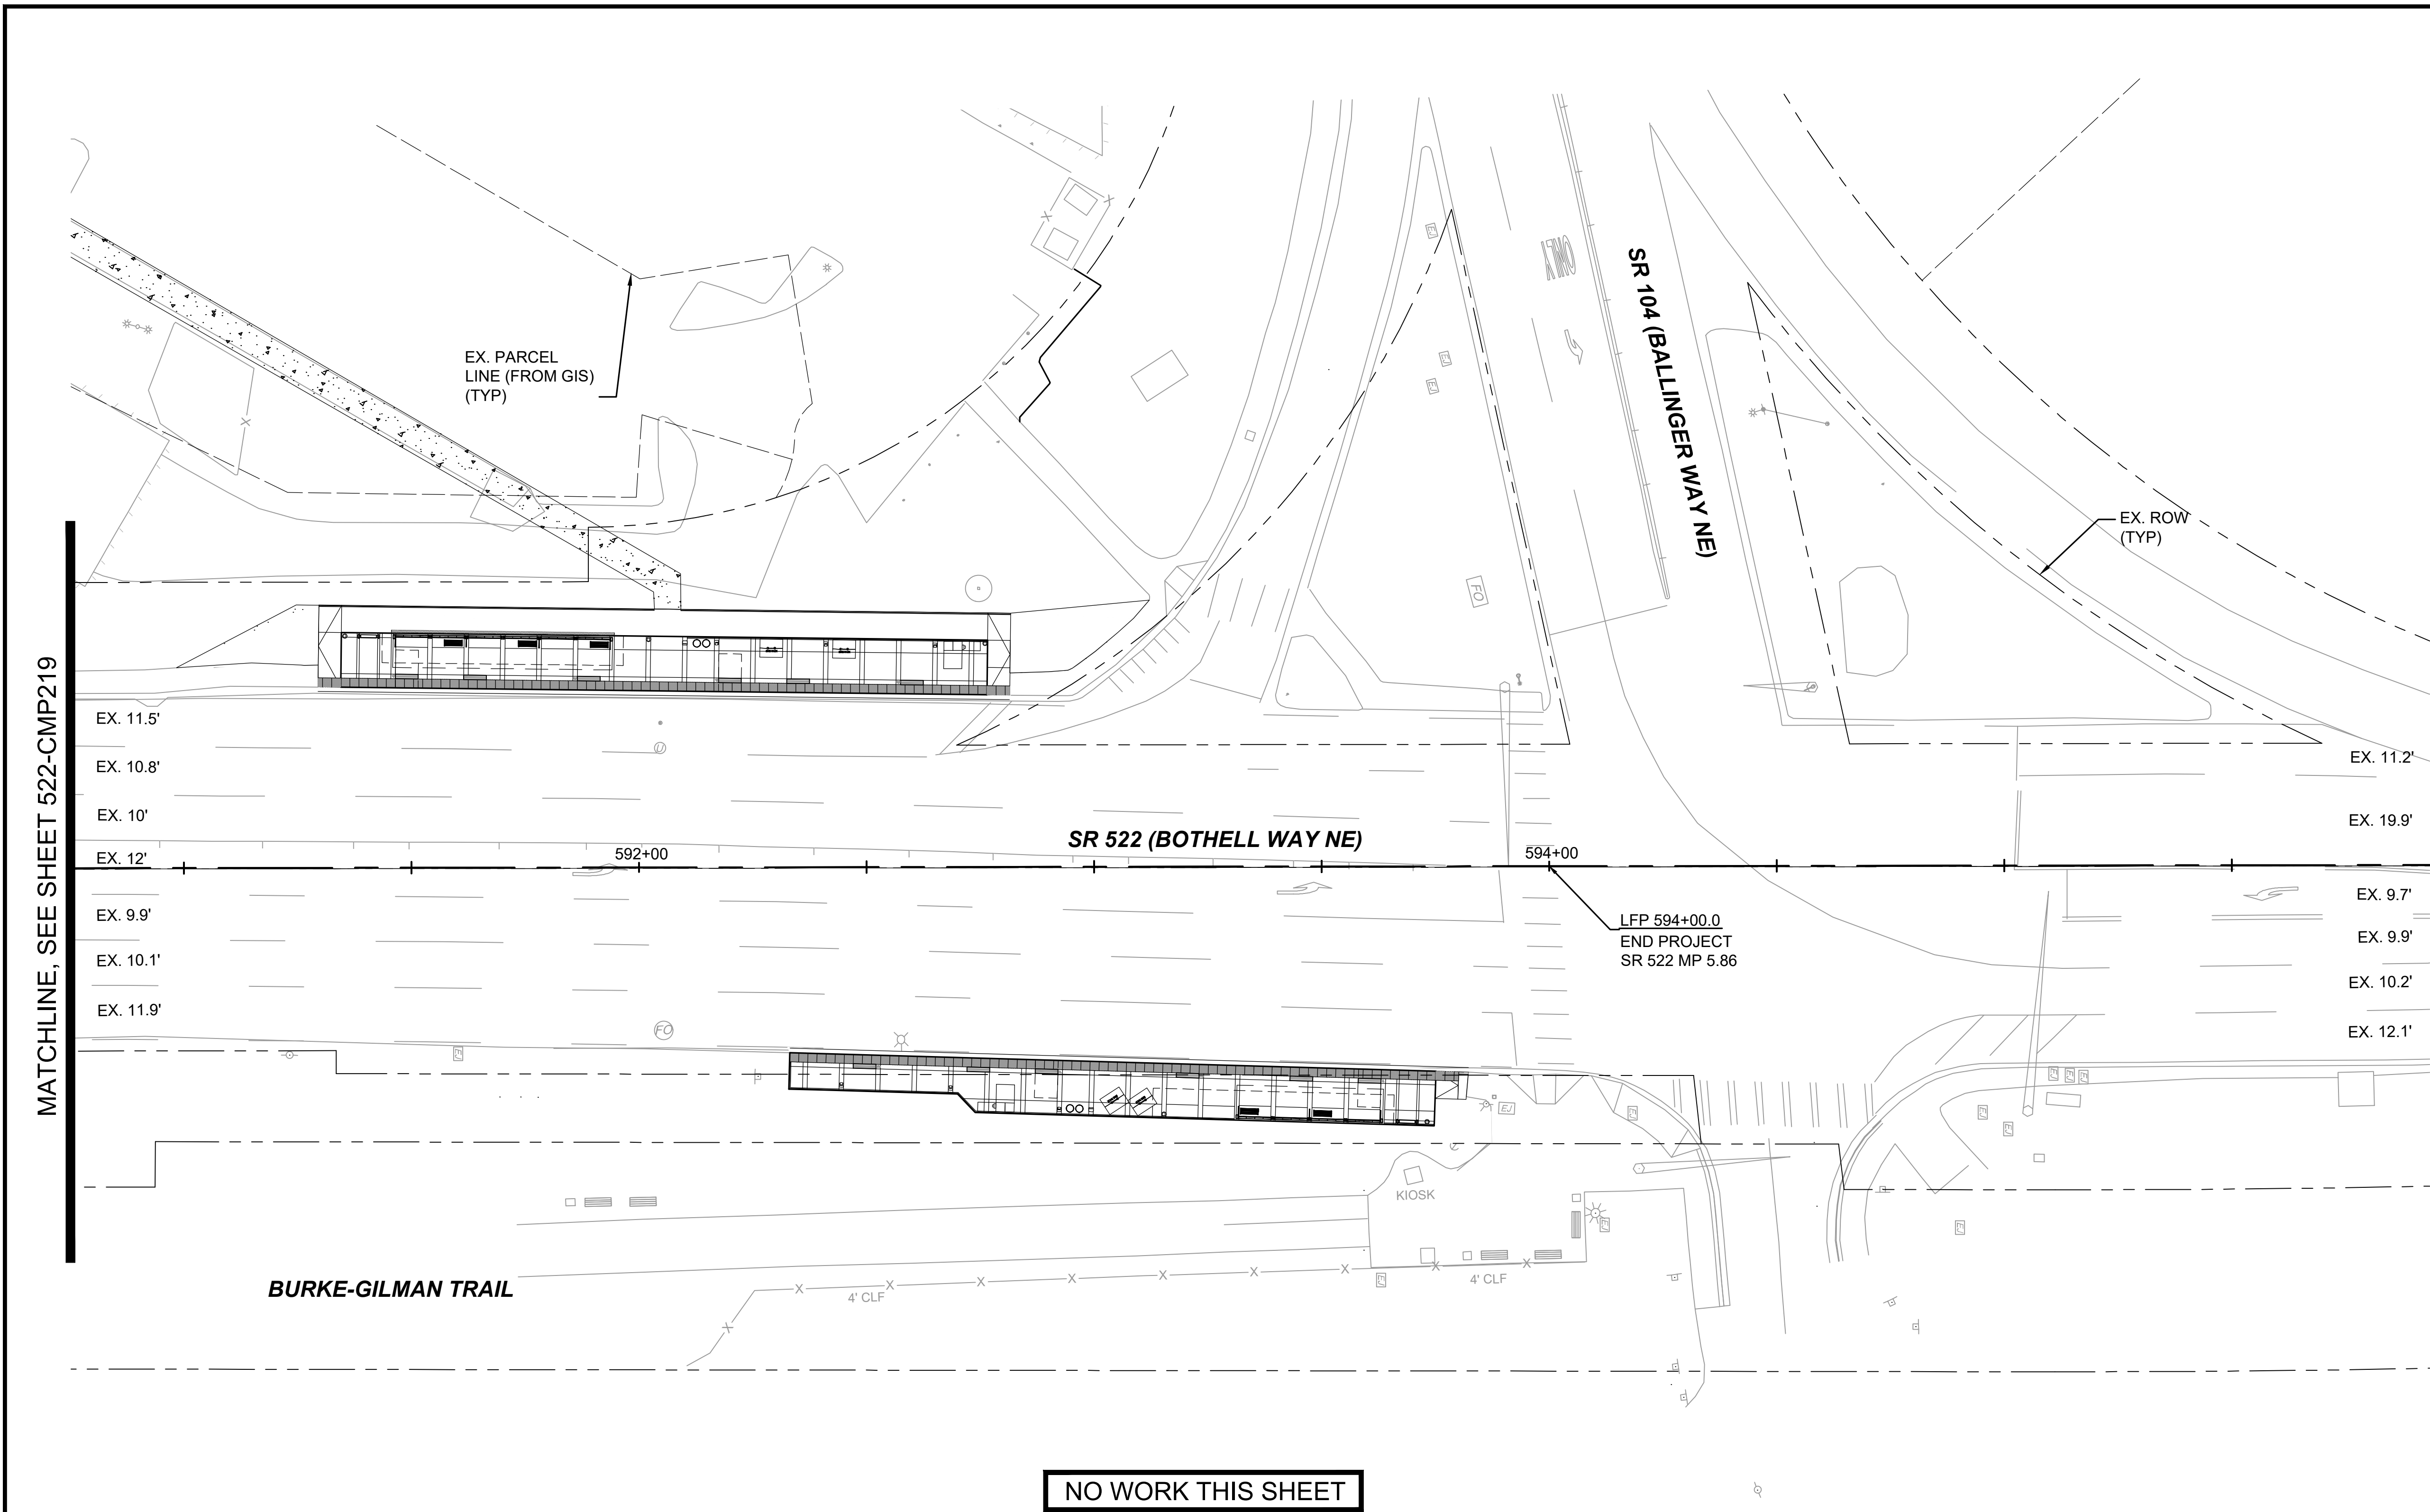


CHANNELIZATION NOTES:

- 1 WHITE WIDE LANE LINE PER WSDOT STD. PLAN M-20.10-02
- 2 WHITE LANE LINE PER WSDOT STD. PLAN M-20.10-02
- 3 YELLOW EDGE LINE PER WSDOT STD. PLAN M-20.10-02
- 4 WHITE EDGE LINE PER WSDOT STD. PLAN M-20.10-02
- 5 WHITE WIDE DOTTED EXTENSION LINE PER WSDOT STD. PLAN M-20.10-02
- 6 WHITE DOTTED EXTENSION LINE PER WSDOT STD. PLAN M-20.10-02
- 7 STOP LINE PER WSDOT STD. PLAN M-24.60-04
- 8 CROSSWALK LINE PER WSDOT STD. PLAN M-15.10-01
- 9 "BUS ONLY" HIGH SPEED TRAFFIC LETTERS PER WSDOT STD. PLAN M-80.10-01
- 10 TYPE 2SL TRAFFIC ARROW PER WSDOT STD. PLAN M-24.40-02
- 11 TYPE 2SR TRAFFIC ARROW PER WSDOT STD. PLAN M-24.40-02
- 12 WHITE DIAGONAL MARKING PER WSDOT STD. PLAN M-24.60-04, SPACED 3.5' ON CENTERS

GENERAL NOTES:

1. ONLY SIGNS THAT SHOW ACCESS CHANGES ARE INCLUDED IN THIS SET FOR INFORMATIONAL PURPOSES. FULL SIGNING PLANS WILL BE DEVELOPED POST 30% DESIGN.

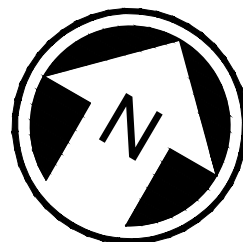

DRAFT 30% SUBMITTAL							DESIGNED BY: C.MATYAS		 DAVID EVANS AND ASSOCIATES INC. 14432 SE Eastgate Way, Suite 400 Bellevue Washington 98007 Phone: 425.519.6500				SCALE: 1"=20'	SR 522 / NE 145TH BRT SR 522 (BOTHELL WAY NE) CIVIL CHANNELIZATION & SIGNING PLAN STA. 590+75 TO STA. 595+75		DRAWING No.: 522-CMP220
							DRAWN BY: O.AHRENSFELD						FILENAME: BRT-522-CMP211-220			FACILITY ID: 522
							CHECKED BY: R.KOESTER						CONTRACT No.: AE 0055-17			SHEET No.: 182 OF 283
							APPROVED BY: M.FELIBERTI						DATE: 09/11/2020			REV:
No.	DATE	DSN	CHK	APP	REVISION				SUBMITTED BY: D.SCHOCK	DATE: 09/11/2020	REVIEWED BY: B.KEMPER	DATE: 09/11/2020	DATE: 09/11/2020			